

DESIGN DESIGNATION

I-435
 A.A.D.T. - 2025 = 24976
 A.A.D.T. - 2045 = 33639
 D.H.V. = 7%
 T = 26%
 V = 55 M.P.H.

FUNCTIONAL CLASSIFICATION- INTERSTATE

COOKINGHAM DRIVE
 A.A.D.T. - 2025 = 2443
 A.A.D.T. - 2045 = 3290
 D.H.V. = 16%
 T = 11%
 V = 55 M.P.H.
 D = 50%

FUNCTIONAL CLASSIFICATION- MINOR ARTERIAL

NO RIGHT OF WAY TO BE ACQUIRED


CONVENTIONAL SYMBOLS
(USED IN PLANS)

	EXISTING	NEW
BUILDINGS AND STRUCTURES		
GUARD RAIL		
GUARD CABLE		
CONCRETE RIGHT-OF-WAY MARKER		
STEEL RIGHT-OF-WAY MARKER		
LOCATION SURVEY MARKER		
UTILITIES		
FIBER OPTICS	-FO-	-FO-
OVERHEAD CABLE TV	-OTV-	-OTV-
UNDERGROUND CABLE TV	-UTV-	-UTV-
OVERHEAD TELEPHONE	-OT-	-OT-
UNDERGROUND TELEPHONE	-UT-	-UT-
OVERHEAD POWER	-OE-	-OE-
UNDERGROUND POWER	-UE-	-UE-
SANITARY SEWER	-S-	-S-
STORM SEWER	-SS-	-SS-
GAS	-G-	-G-
WATER	-W-	-W-
MANHOLE		
FIRE HYDRANT		
WATER VALVE		
WATER METER		
DROP INLET		
DITCH BLOCK		
GROUND MOUNTED SIGN		
LIGHT POLE		
H-FRAME POWER POLE		
TELEPHONE PEDESTAL		
FENCE		
CHAIN LINK		
WOVEN WIRE		
GATE POST		
BENCHMARK		

NOTE: DASHED OR OPEN SYMBOLS INDICATE EXISTING FEATURES

MISSOURI HIGHWAYS AND TRANSPORTATION COMMISSION

**PLANS FOR PROPOSED
STATE HIGHWAY
PLATTE COUNTY
PRELIMINARY PLANS**

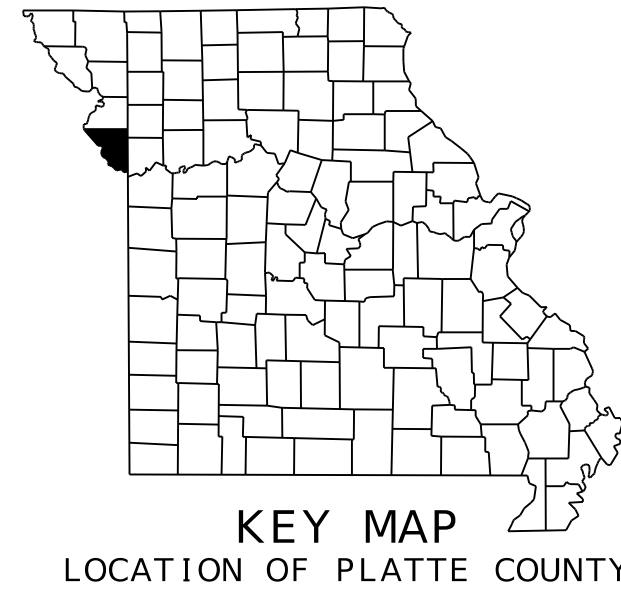

NOT TO SCALE

THE EXISTENCE AND APPROXIMATE LOCATION OF UTILITY FACILITIES KNOWN TO EXIST, AS SHOWN ON THE PLANS, ARE BASED ON THE BEST INFORMATION AVAILABLE TO THE COMMISSION AT THIS TIME. THIS INFORMATION IS PROVIDED BY THE COMMISSION "AS-IS" AND THE COMMISSION EXPRESSLY DISCLAIMS ANY REPRESENTATION OR WARRANTY AS TO THE COMPLETENESS, ACCURACY, OR SUITABILITY OF THE INFORMATION FOR ANY USE. RELIANCE UPON THIS INFORMATION IS DONE AT THE RISK AND PERIL OF THE USER, AND THE COMMISSION SHALL NOT BE LIABLE FOR ANY DAMAGES THAT MAY ARISE FROM ANY ERROR IN THE INFORMATION. IT IS, THEREFORE, THE RESPONSIBILITY OF THE CONTRACTOR TO VERIFY THE EXISTENCE, LOCATION AND STATUS OF ANY FACILITY. SUCH VERIFICATION INCLUDES DIRECT CONTACT WITH THE LISTED UTILITIES.

INDEX OF SHEETS

DESCRIPTION	SHEET NUMBER
TITLE SHEET	1
TYPICAL SECTIONS (TS) (4 SHEETS)	2
PLAN-PROFILE (PP)	4-11
COORDINATE POINTS (CP)	12
TRAFFIC CONTROL SHEETS (TC)	13-20
BRIDGE DRAWINGS (B)	
A9700	1-3
WALL A9701	1-2
WALL A9702	1-2
CROSS SECTIONS (XS)	1-37

PRELIMINARY
PLANS
NOT FOR
CONSTRUCTION

DATE PREPARED
4/30/2025
ROUTE 1435 STATE MO
DISTRICT KC SHEET NO. 1
COUNTY PLATTE
JOB NO. J4S3489
CONTRACT ID.


PROJECT NO.
BRIDGE NO. A9700

DATE	DESCRIPTION

LENGTH OF PROJECT

ROUTE 1435	
BEGINNING OF PROJECT	STA. 941+26.54
END OF PROJECT	STA. 948+33.15
APPARENT LENGTH	706.61 FEET
NET LENGTH OF PROJECT	706.61 FEET
STATE LENGTH	0.134 MILES
COOKINGHAM DRIVE	
BEGINNING OF PROJECT	STA. 630+75.00
END OF PROJECT	STA. 640+20.00
APPARENT LENGTH	945.00 FEET
NET LENGTH OF PROJECT	945.00 FEET
STATE LENGTH	0.179 MILES
EQUATIONS AND EXCEPTIONS	0.000 FEET

FOR INFORMATION ONLY
ESTIMATED DISTURBED ACRES 1.0 ACRES

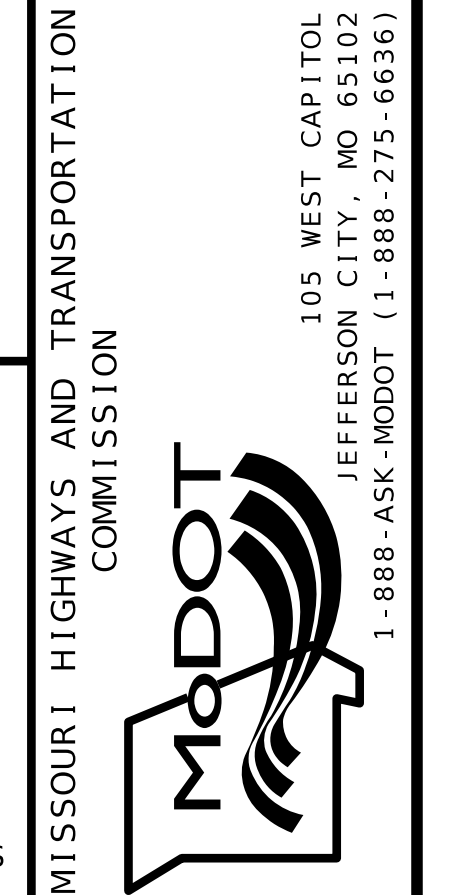

olsson
 1301 BURLINGTON STREET, STE. 100
 NORTH KANSAS CITY, MO 64116
 PHONE: 816.361.1177
 CERTIFICATE OF AUTHORITY NO. 001592

IF A SEAL IS PRESENT ON THIS SHEET IT HAS BEEN ELECTRONICALLY SEALED AND DATED.

PRELIMINARY
PLANS
NOT FOR
CONSTRUCTION

DATE PREPARED
4/30/2025
ROUTE 1435 STATE MO
DISTRICT KC SHEET NO. 2
COUNTY PLATTE
JOB NO. J4S3489
CONTRACT ID.


PROJECT NO.
BRIDGE NO. A9700

DATE	DESCRIPTION


MISSOURI HIGHWAYS AND TRANSPORTATION
COMMISSION
MoDOT
105 WEST CAPITOL
JEFFERSON CITY, MO 65102
1-888-ASK-MODOT (1-888-275-6636)

Olsson
1301 BURLINGTON STREET, STE. 100
NORTH KANSAS CITY, MO 64116
PHONE: 816.361.1177
CERTIFICATE OF AUTHORITY NO. 001592


IF A SEAL IS PRESENT ON THIS SHEET IT HAS BEEN ELECTRONICALLY SEALED AND DATED.

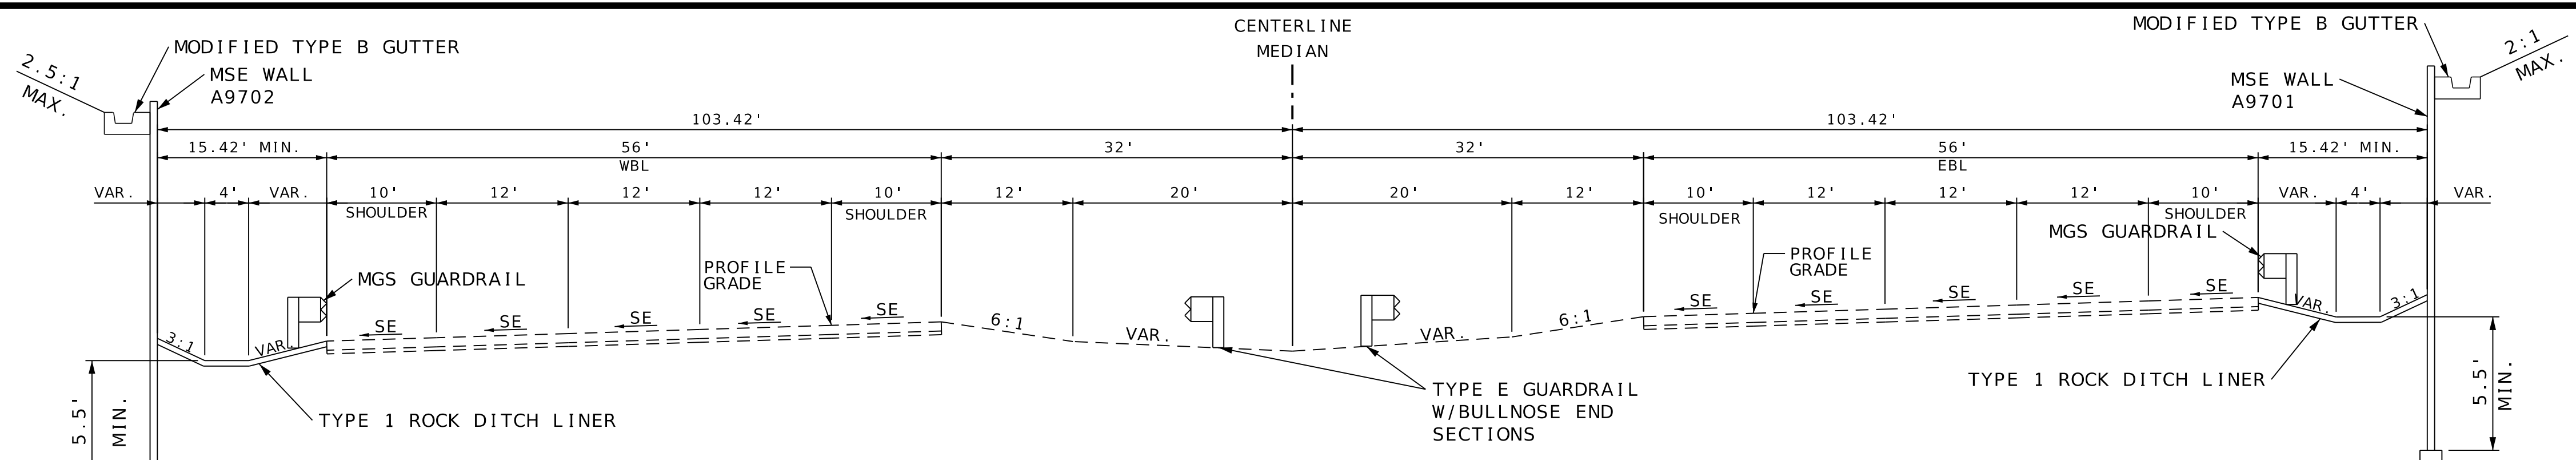


SECTION ON SUPERELEVATED CURVE
TYPICAL SECTION RTE. 1435
STA. 944+39.92 TO STA. 945+38.92

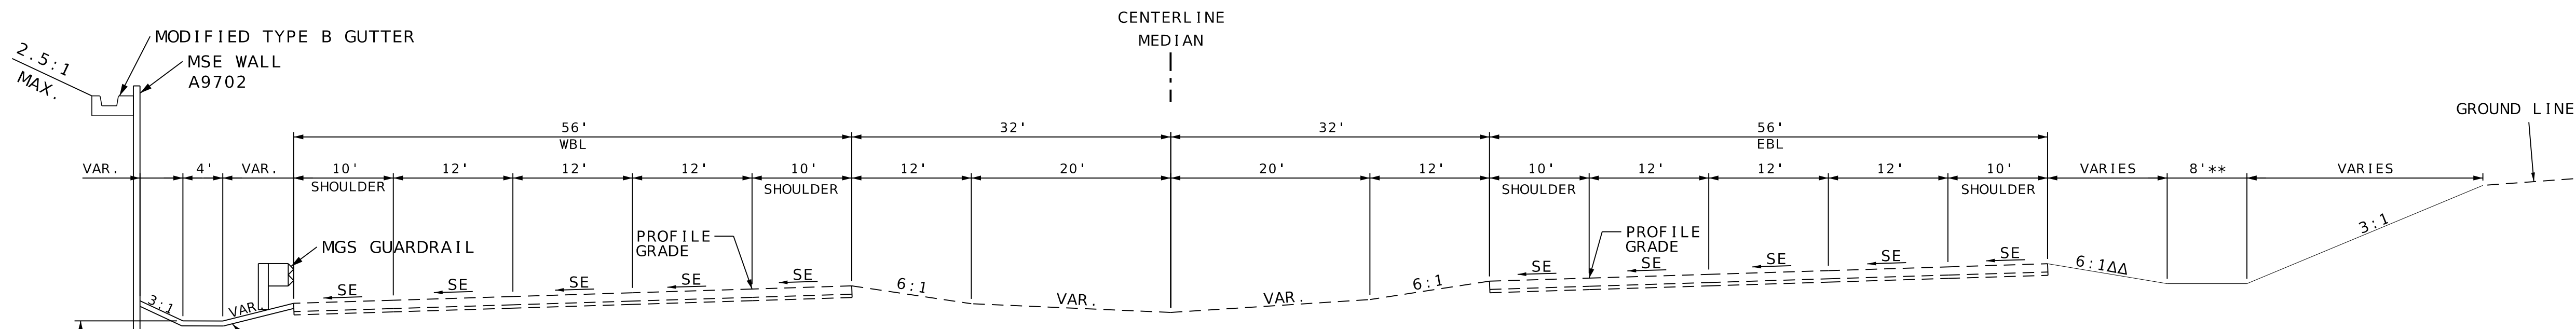

SECTION ON SUPERELEVATED CURVE
TYPICAL SECTION RTE. 1435
STA. 942+59.01 TO STA. 944+39.92
** TRANSITION 8.00' TO 4.00' FROM STA. 942+59.01 TO STA. 944+39.92
ΔΔ TRANSITION 6:1 TO VAR. FROM STA. 942+59.01 TO STA. 944+39.92

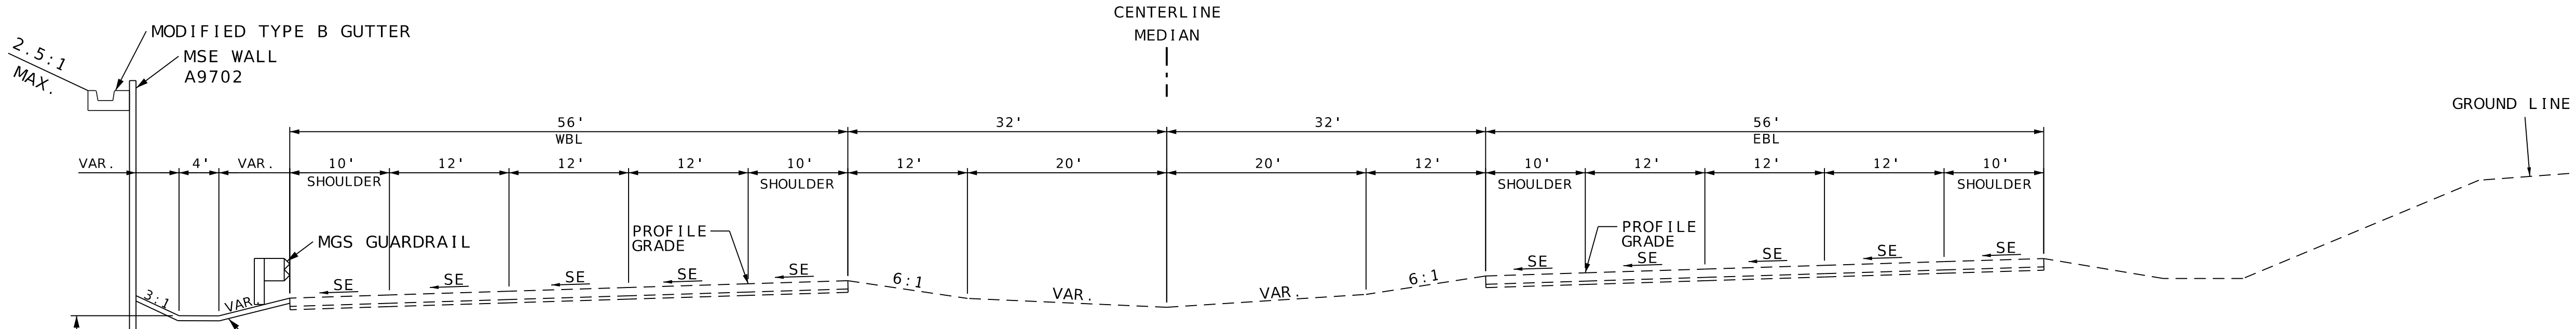

SECTION ON SUPERELEVATED CURVE
TYPICAL SECTION RTE. 1435
STA. 942+44.03 TO STA. 942+59.01

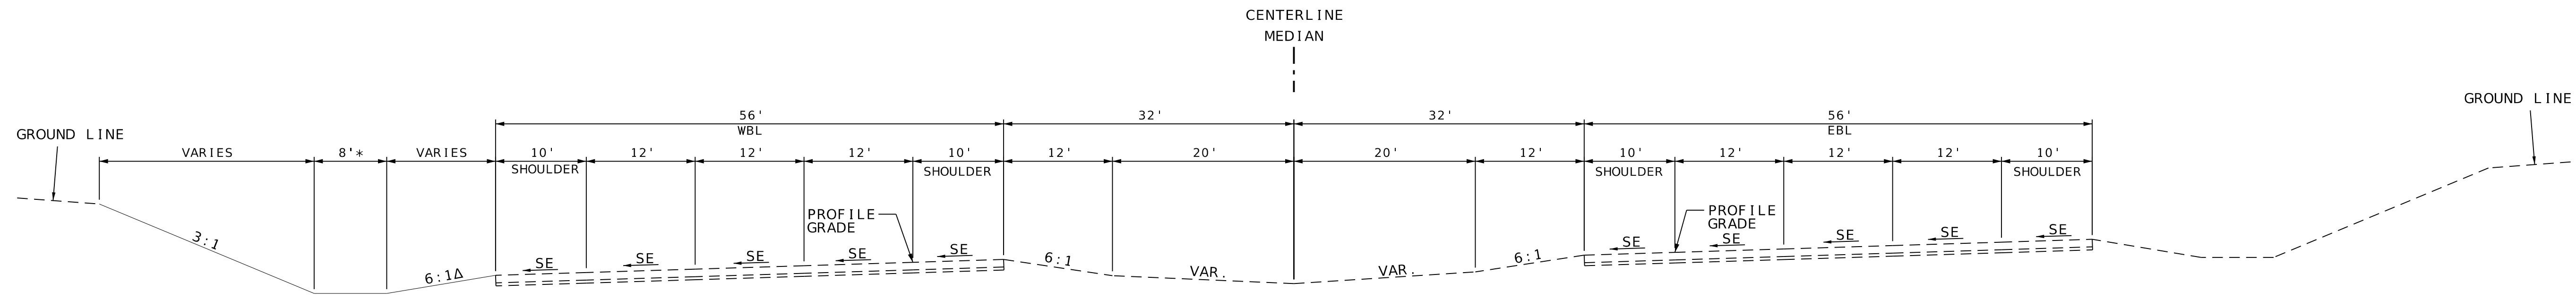

SECTION ON SUPERELEVATED CURVE
TYPICAL SECTION RTE. 1435
STA. 941+26.54 TO STA. 942+44.03
* TRANSITION 8.00' TO 4.00' FROM STA. 941+26.54 TO STA. 942+44.03
Δ TRANSITION 6:1 TO VAR. FROM STA. 941+26.54 TO STA. 942+44.03

NOT TO SCALE

TYPICAL SHEET
1 OF 4

PRELIMINARY
PLANS
NOT FOR
CONSTRUCTION

DATE PREPARED
4/30/2025
ROUTE 1435 STATE MO
DISTRICT KC SHEET NO. 2
COUNTY PLATTE
JOB NO. J4S3489
CONTRACT ID.


PROJECT NO.
BRIDGE NO. A9700

DATE	DESCRIPTION

MISSOURI HIGHWAYS AND TRANSPORTATION COMMISSION
105 WEST CAPITOL JEFFERSON CITY, MO 65102
1-888-ASK-MODOT (1-888-275-6636)


olsson
1301 BURLINGTON STREET, STE. 100
NORTH KANSAS CITY, MO 64116
PHONE: 816.361.1177
CERTIFICATE OF AUTHORITY NO. 001592

IF A SEAL IS PRESENT ON THIS SHEET IT HAS BEEN ELECTRONICALLY SEALED AND DATED.

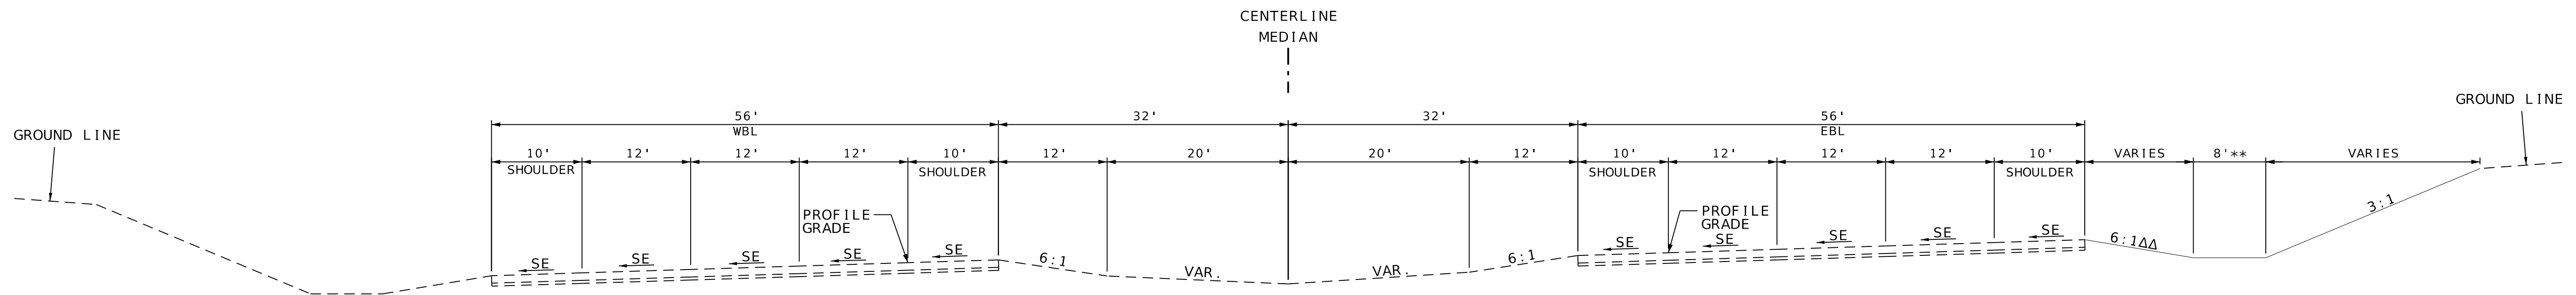


SECTION ON SUPERELEVATED CURVE
TYPICAL SECTION RTE. 1435
STA. 947+78.36 TO STA. 948+33.15

** TRANSITION 4.00' TO 8.00' FROM STA. 947+09.52 TO STA. 948+33.15
ΔΔ TRANSITION VAR. TO 6:1 FROM STA. 947+09.52 TO STA. 948+33.15

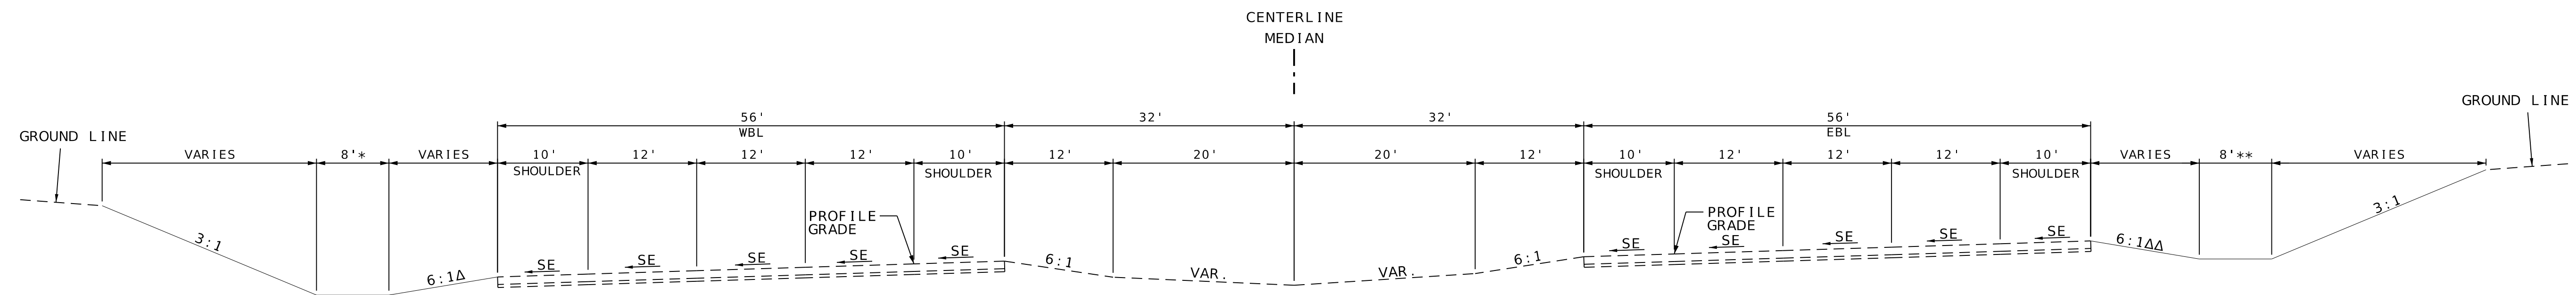

SECTION ON SUPERELEVATED CURVE
TYPICAL SECTION RTE. 1435
STA. 947+09.52 TO STA. 947+78.36

* TRANSITION 4.00' TO 8.00' FROM STA. 945+38.92 TO STA. 947+78.36
** TRANSITION 4.00' TO 8.00' FROM STA. 947+09.52 TO STA. 948+33.15
Δ TRANSITION VAR. TO 6:1 FROM STA. 945+38.92 TO STA. 947+78.36
ΔΔ TRANSITION VAR. TO 6:1 FROM STA. 947+09.52 TO STA. 948+33.15

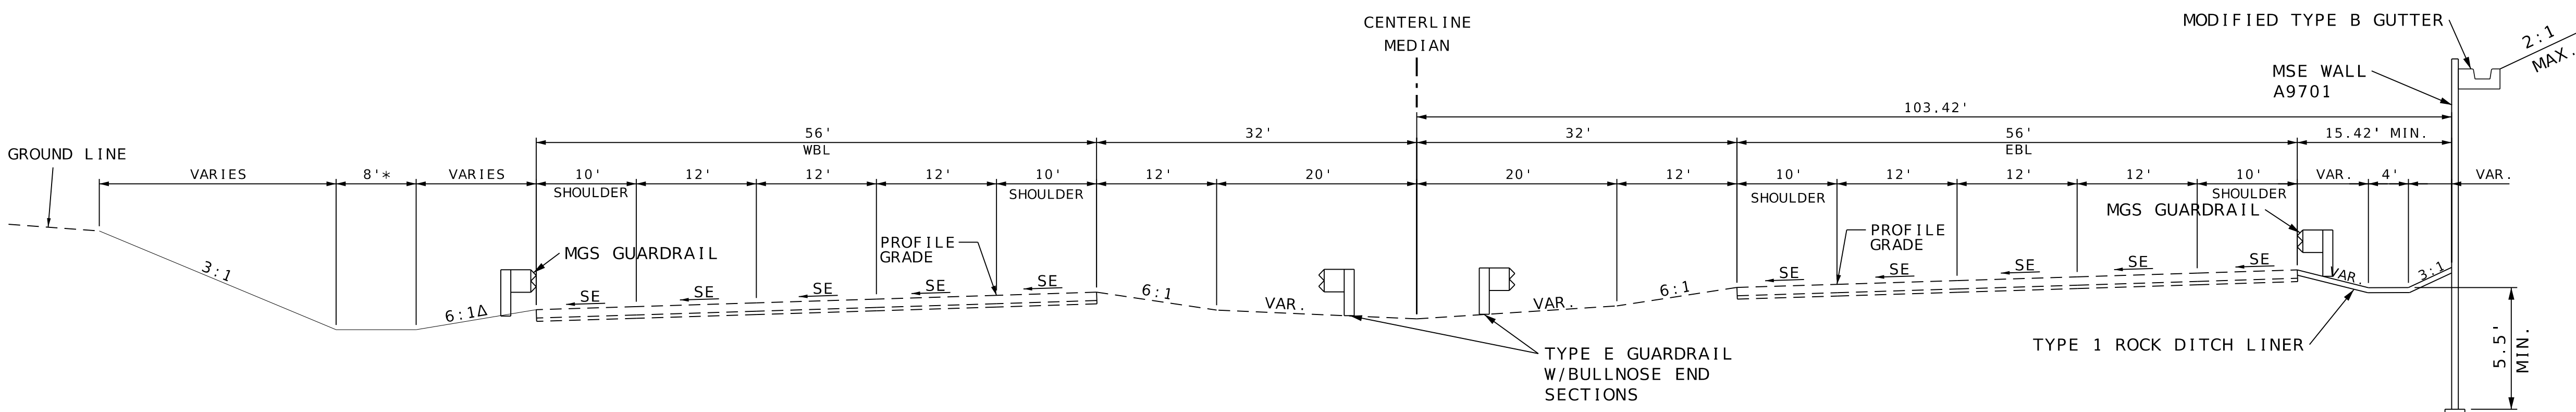

SECTION ON SUPERELEVATED CURVE
TYPICAL SECTION RTE. 1435
STA. 945+38.92 TO STA. 947+09.52

* TRANSITION 4.00' TO 8.00' FROM STA. 945+38.92 TO STA. 947+78.36
Δ TRANSITION VAR. TO 6:1 FROM STA. 945+38.92 TO STA. 947+78.36

NOT TO SCALE

TYPICAL SHEET
2 OF 4

PRELIMINARY
PLANS
NOT FOR
CONSTRUCTION

DATE PREPARED
4/30/2025

ROUTE STATE
1435 MO

DISTRICT SHEET NO.
KC 5

COUNTY
PLATTE

JOB NO.
J4S3489

CONTRACT ID.

PROJECT NO.

BRIDGE NO.
A9700

DESCRIPTION

DATE

DATE


DATE

DATE


DATE

DATE

PI 944+92.61
PC 940+77.71
PT 949+06.69
Δ 6°13'2.3" (LT)
D 0°45'0.0"
L 828.97' (ARC)
T 414.89'
R 7,639.44'

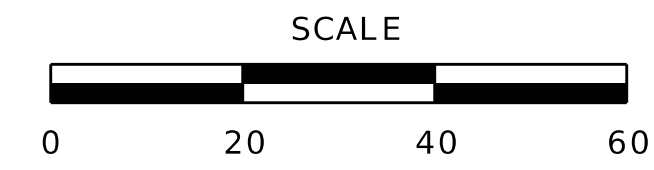


LEGEND

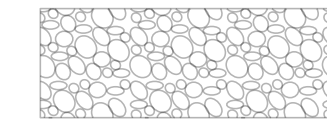

TYPE 1 ROCK DITCH LINER



CONCRETE SLOPE PROTECTION

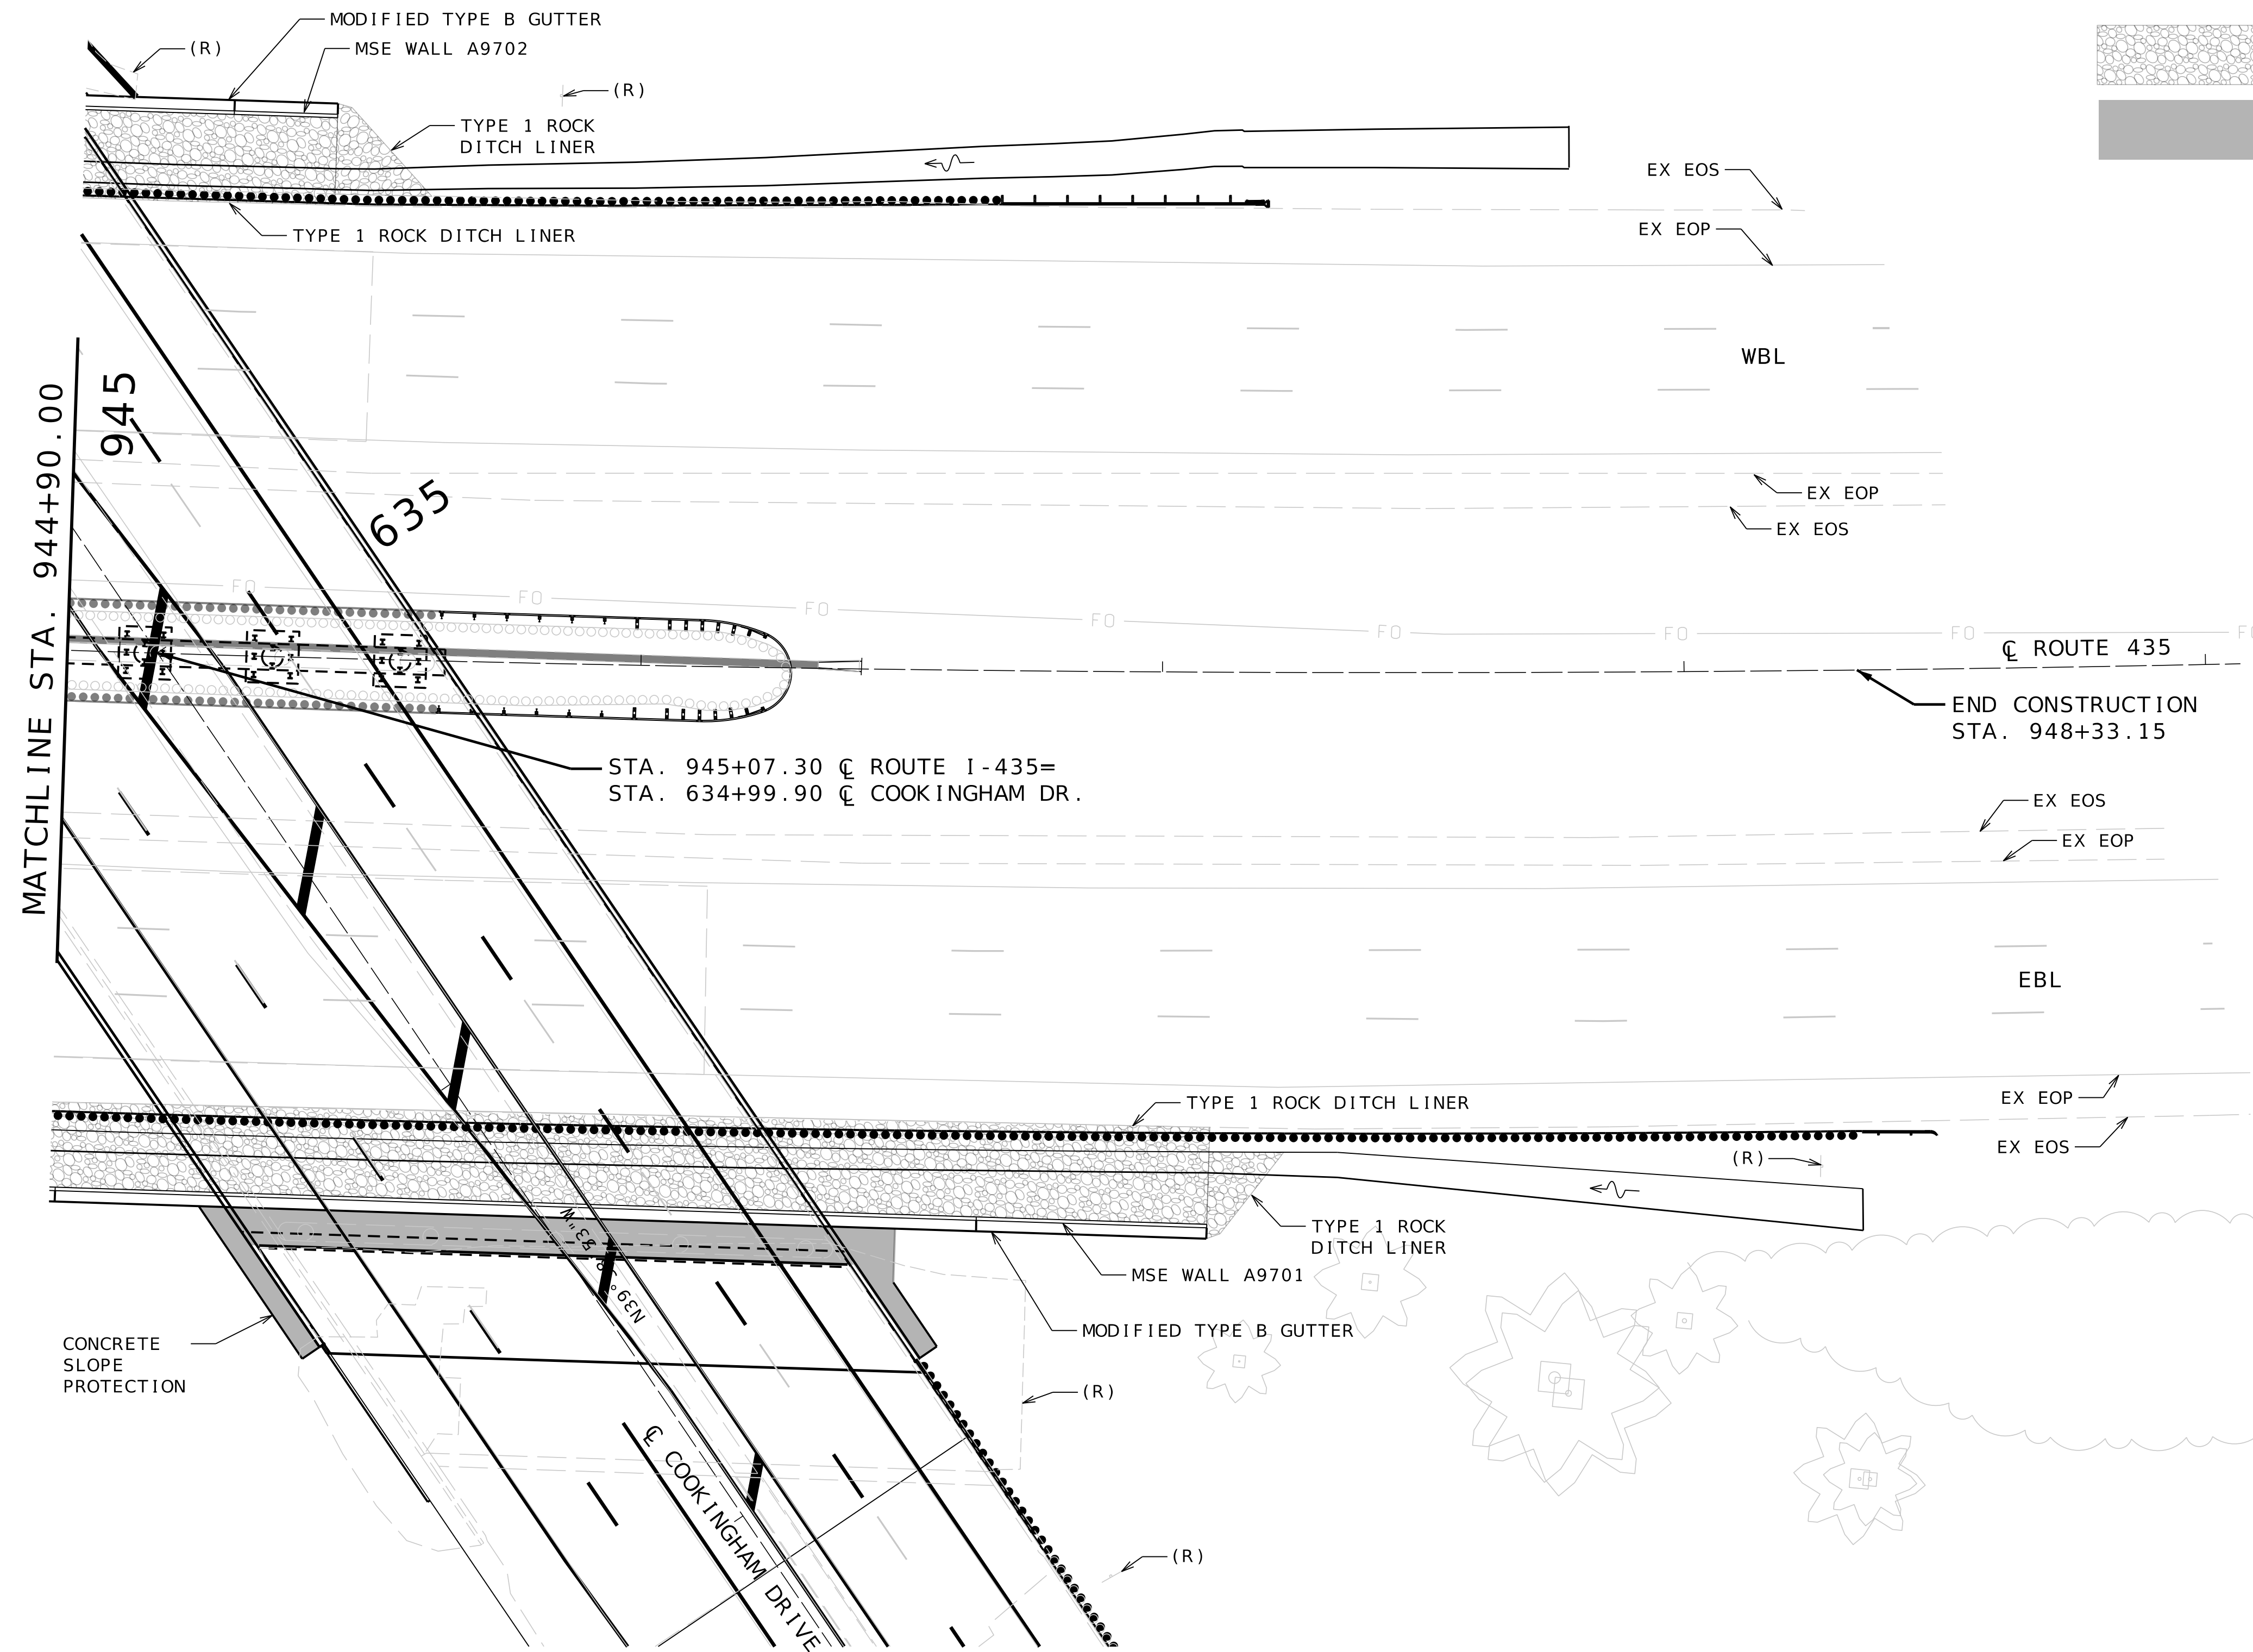



PLAN & PROFILE
SHEET 2 OF 8

olsson
1301 BURLINGTON STREET, STE. 100
NORTH KANSAS CITY, MO 64116
PHONE: 816.361.1177
CERTIFICATE OF AUTHORITY NO. 001592

MISSOURI HIGHWAYS AND TRANSPORTATION
COMMISSION

105 WEST CAPITOL
JEFFERSON CITY, MO 65102
1-888-ASK-MODOT (1-888-275-6636)

IF A SEAL IS PRESENT ON THIS SHEET IT HAS BEEN ELECTRONICALLY SEALED AND DATED.

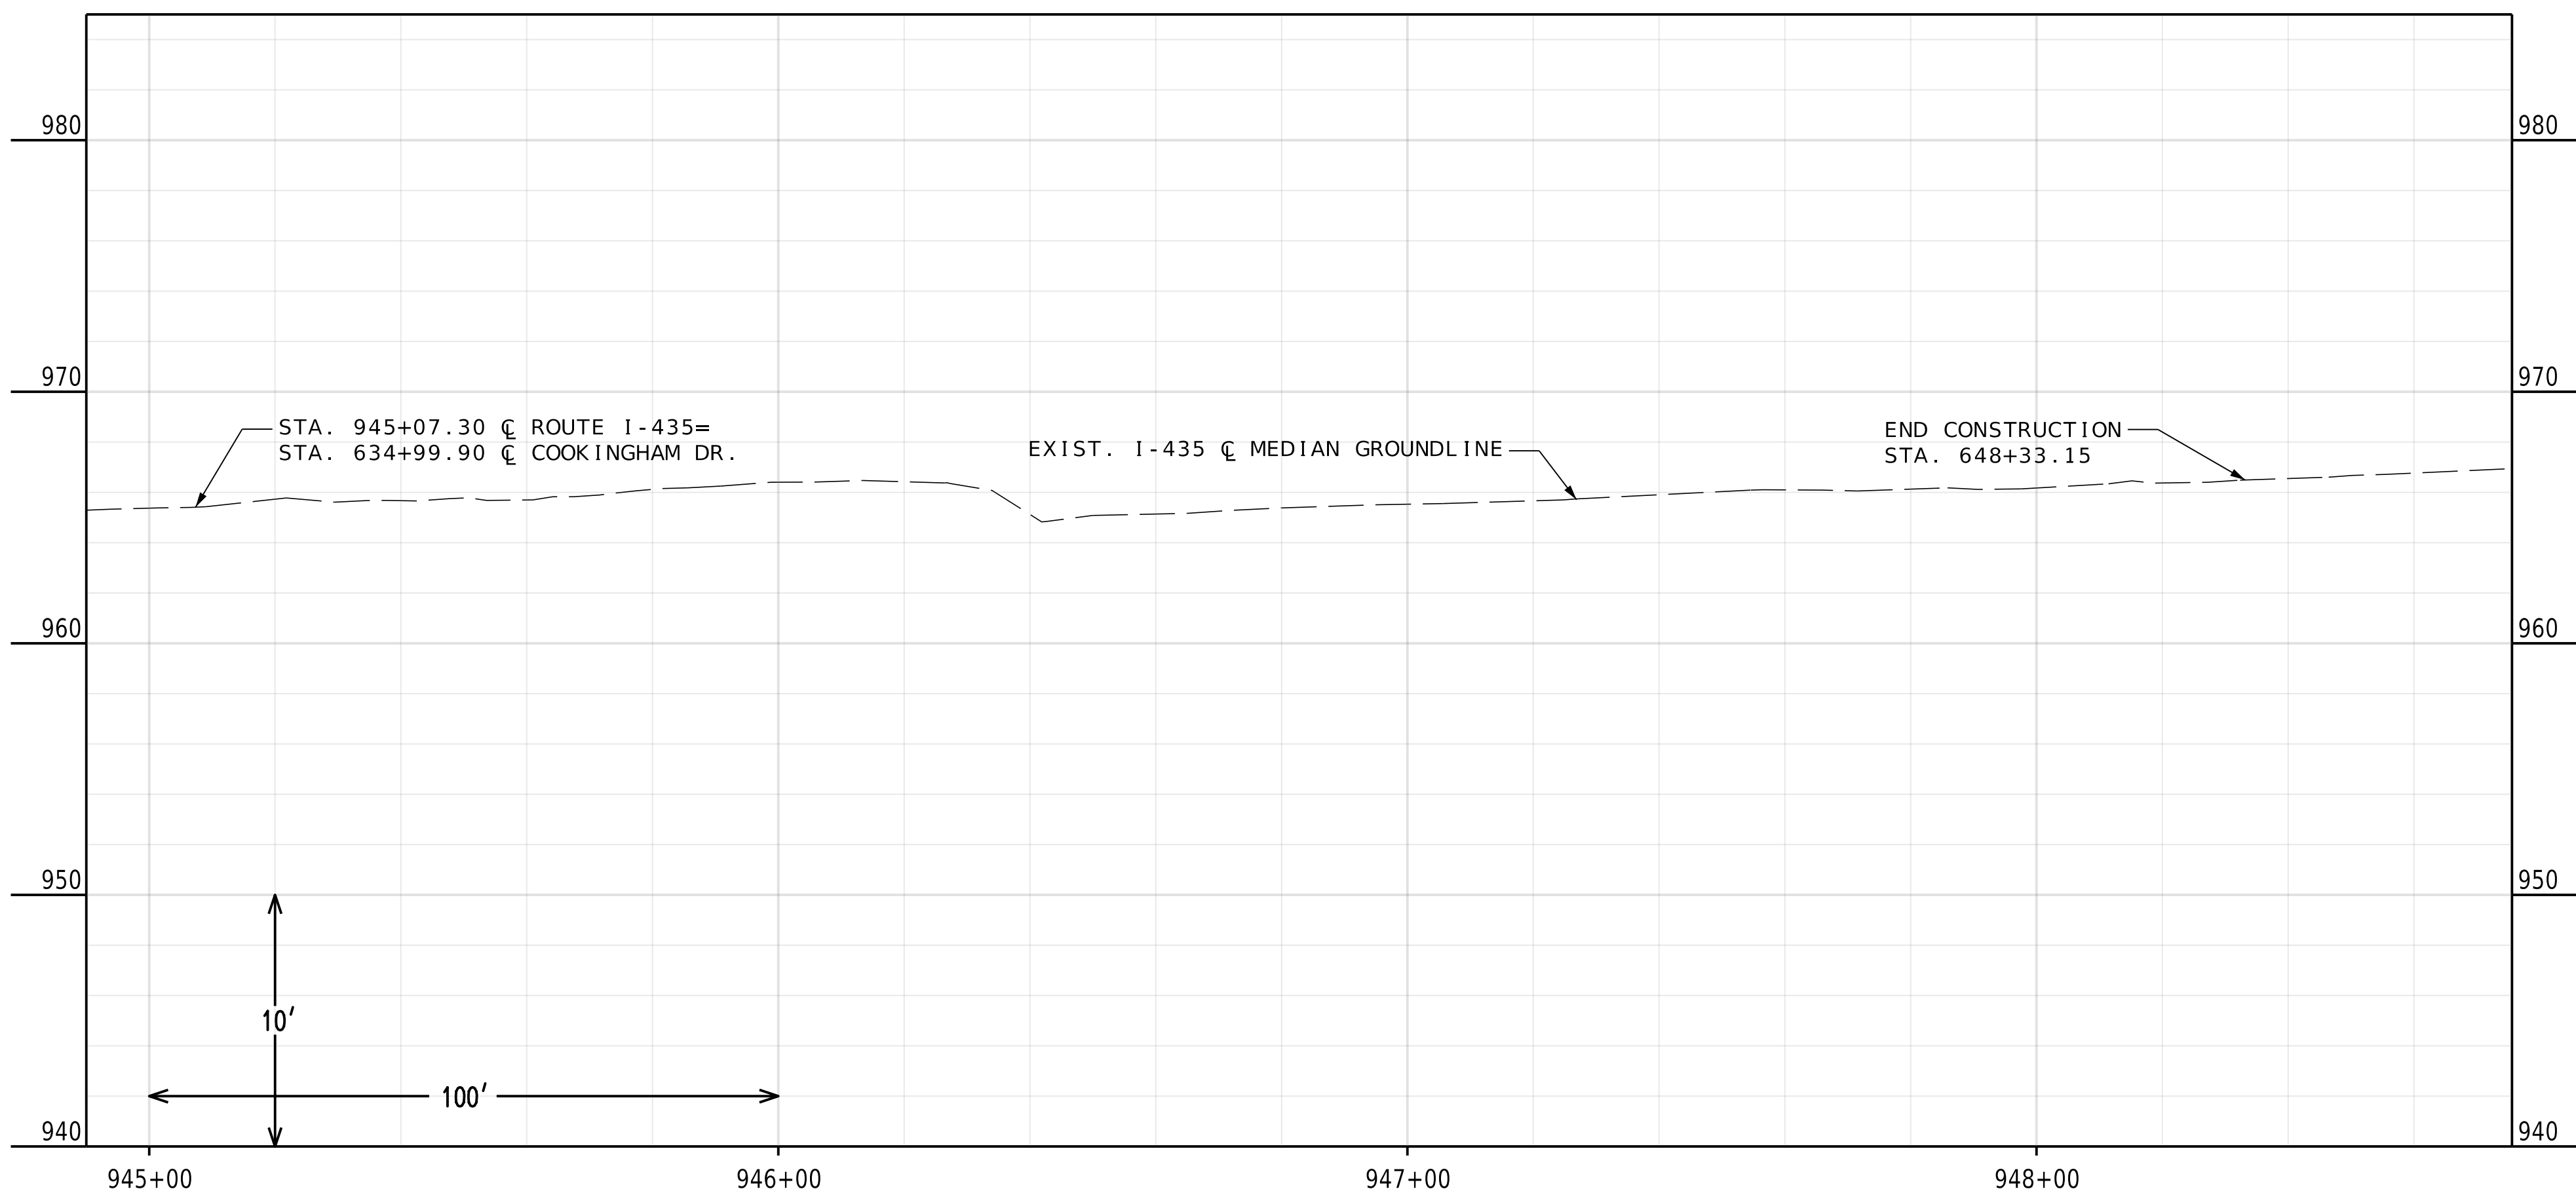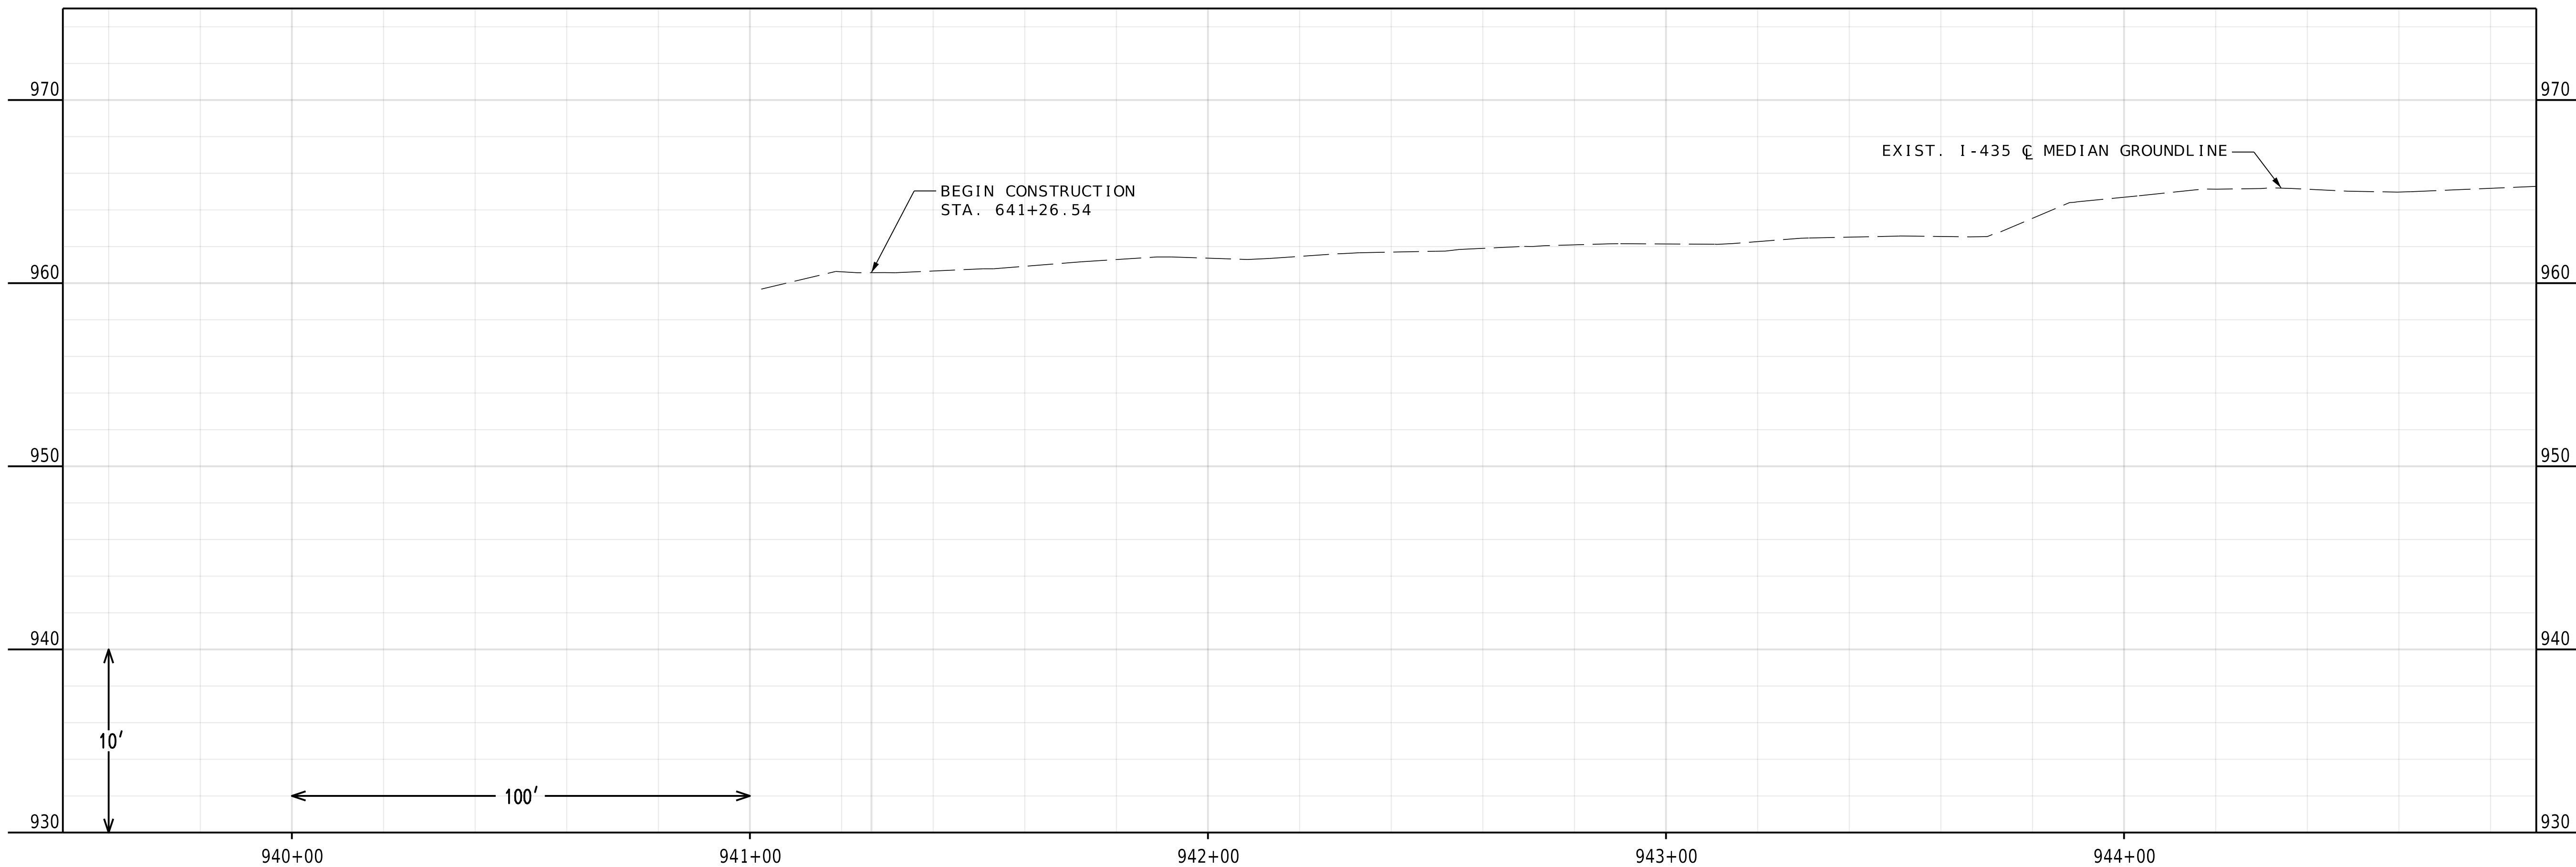

PRELIMINARY
PLANS
NOT FOR
CONSTRUCTION


DATE PREPARED 4/30/2025	
ROUTE 1435	STATE MO
DISTRICT KC	SHEET NO. 6
COUNTY PLATTE	
JOB NO. J4S3489	
CONTRACT ID.	
PROJECT NO.	
BRIDGE NO. A9700	

DATE	DESCRIPTION

MISSOURI HIGHWAYS AND TRANSPORTATION
COMMISSION




105 WEST CAPITOL
JEFFERSON CITY, MO 65102
1-888-ASK-MODOT (1-888-275-6636)

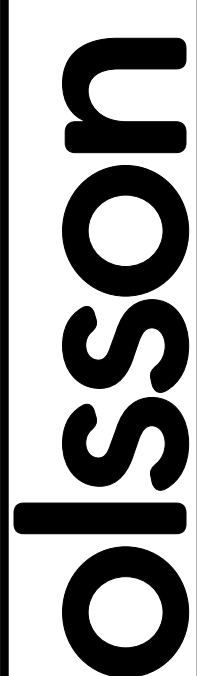

1301 BURLINGTON STREET, STE. 100
NORTH KANSAS CITY, MO 64116
PHONE: 816.361.1177
CERTIFICATE OF AUTHORITY NO. 001592

PLAN & PROFILE
SHEET 3 OF 8


IF A SEAL IS PRESENT ON THIS SHEET IT HAS BEEN ELECTRONICALLY SEALED AND DATED.

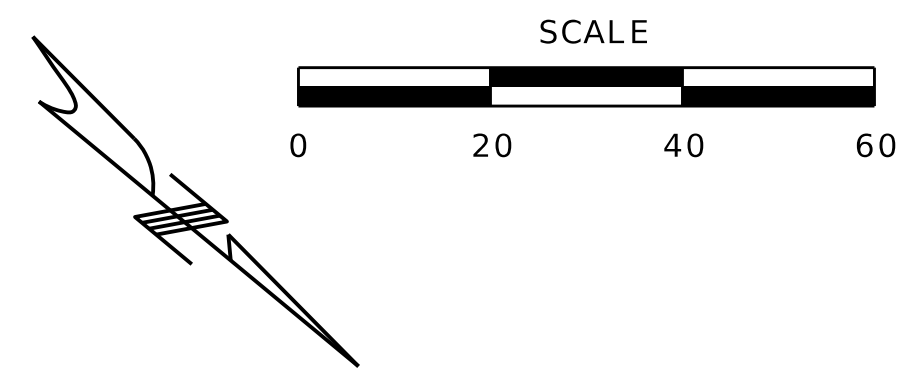

PI 944+92.61
 PC 940+77.71
 PT 949+06.69
 Δ 6°13'2.3" (LT)
 D 0°45'0.0"
 L 828.97' (ARC)
 T 414.89'
 R 7,639.44'

LEGEND

- TYPE 1 ROCK DITCH LINER
- CONCRETE SLOPE PROTECTION

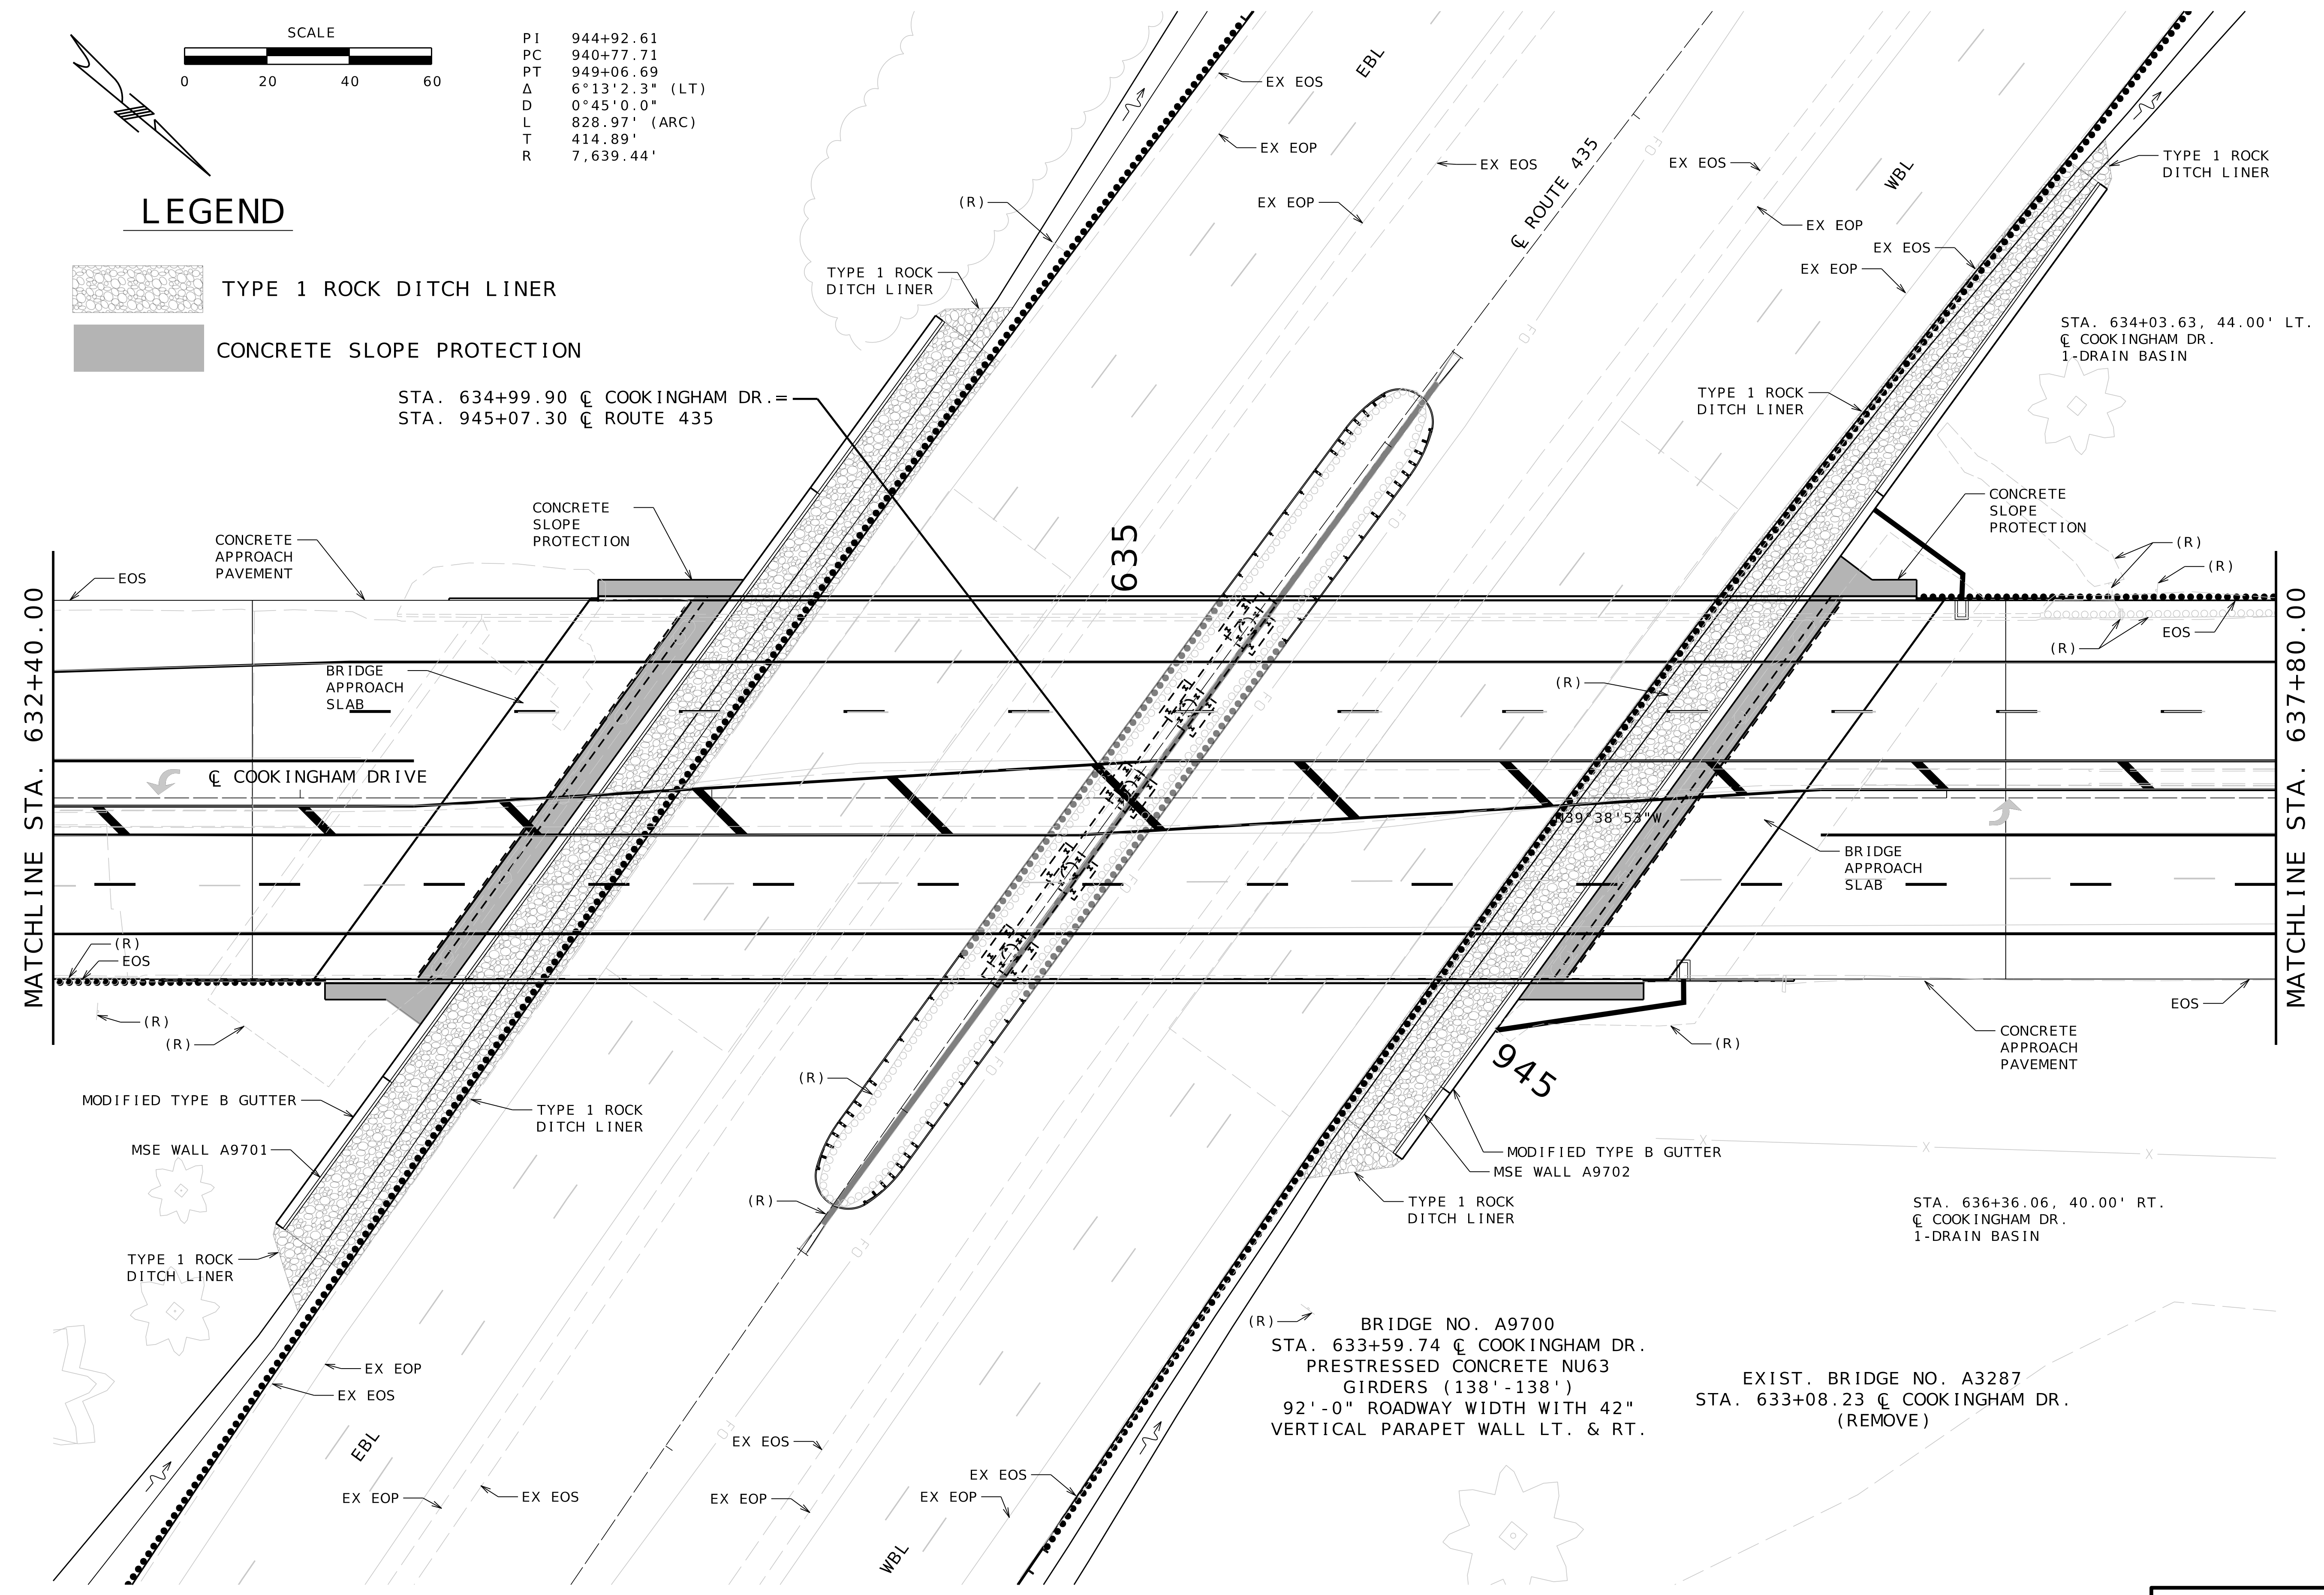

STA. 634+99.90 C COOKINGHAM DR.
 STA. 945+07.30 C ROUTE 435

STA. 634+03.63, 44.00' LT.
 C COOKINGHAM DR.
 1-DRAIN BASIN

STA. 636+36.06, 40.00' RT.
 C COOKINGHAM DR.
 1-DRAIN BASIN

(R) BRIDGE NO. A9700
 STA. 633+59.74 C COOKINGHAM DR.
 PRESTRESSED CONCRETE NU63
 GIRDERS (138'-138')
 92'-0" ROADWAY WIDTH WITH 42"
 VERTICAL PARAPET WALL LT. & RT.

EXIST. BRIDGE NO. A3287
 STA. 633+08.23 C COOKINGHAM DR.
 (REMOVE)

PRELIMINARY
 PLANS
 NOT FOR
 CONSTRUCTION

DATE PREPARED
 4/30/2025
 ROUTE 1435 STATE MO
 DISTRICT KC SHEET NO. 8

COUNTY PLATTE
 JOB NO. J4S3489
 CONTRACT ID.

PROJECT NO.
 BRIDGE NO. A9700

DATE	DESCRIPTION



MISSOURI HIGHWAYS AND TRANSPORTATION
 COMMISSION

 105 WEST CAPITOL
 JEFFERSON CITY, MO 65102
 1-888-ASK-MODOT (1-888-275-6636)

1301 BURLINGTON STREET, STE. 100
 NORTH KANSAS CITY, MO 64116
 PHONE: 816.361.1177
 CERTIFICATE OF AUTHORITY NO. 001592

PLAN & PROFILE
 SHEET 5 OF 8

IF A SEAL IS PRESENT ON THIS SHEET IT HAS BEEN ELECTRONICALLY SEALED AND DATED.

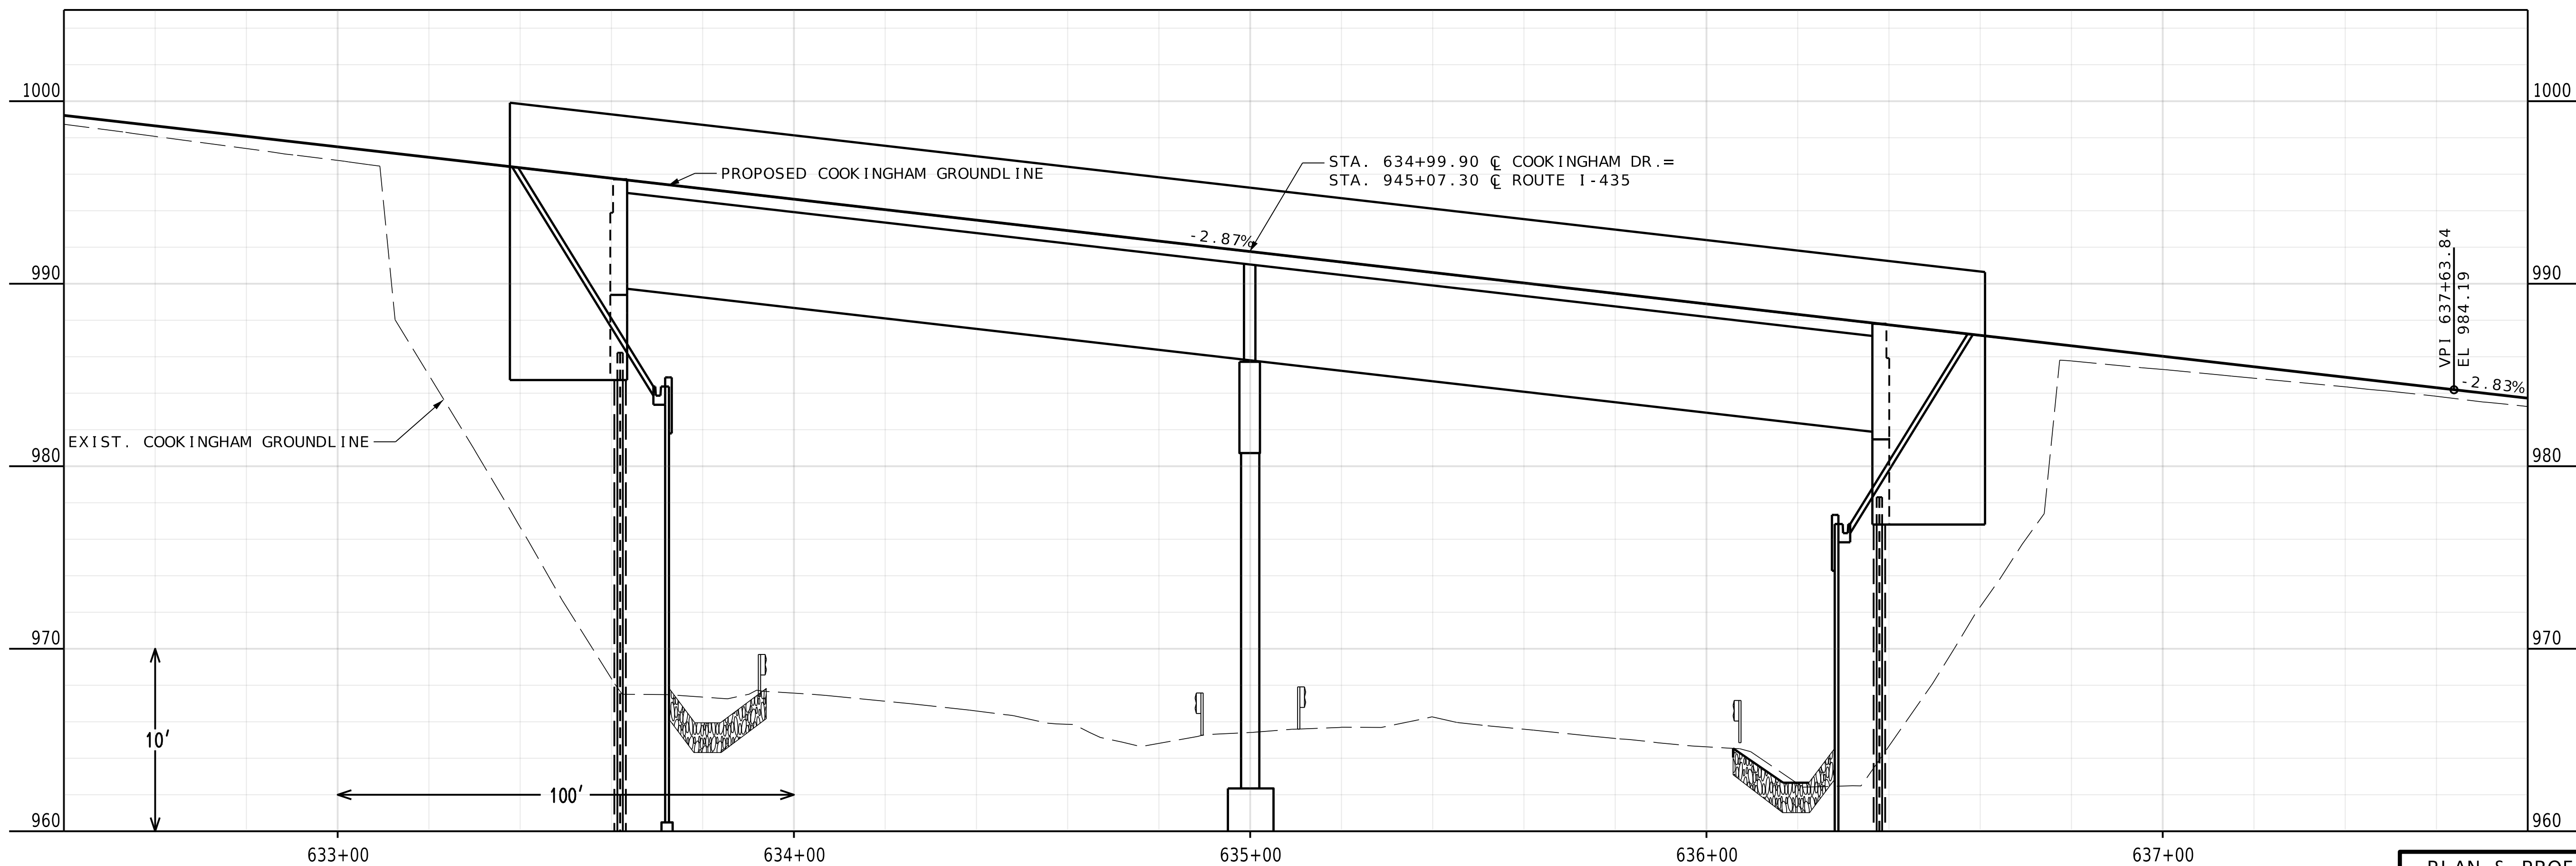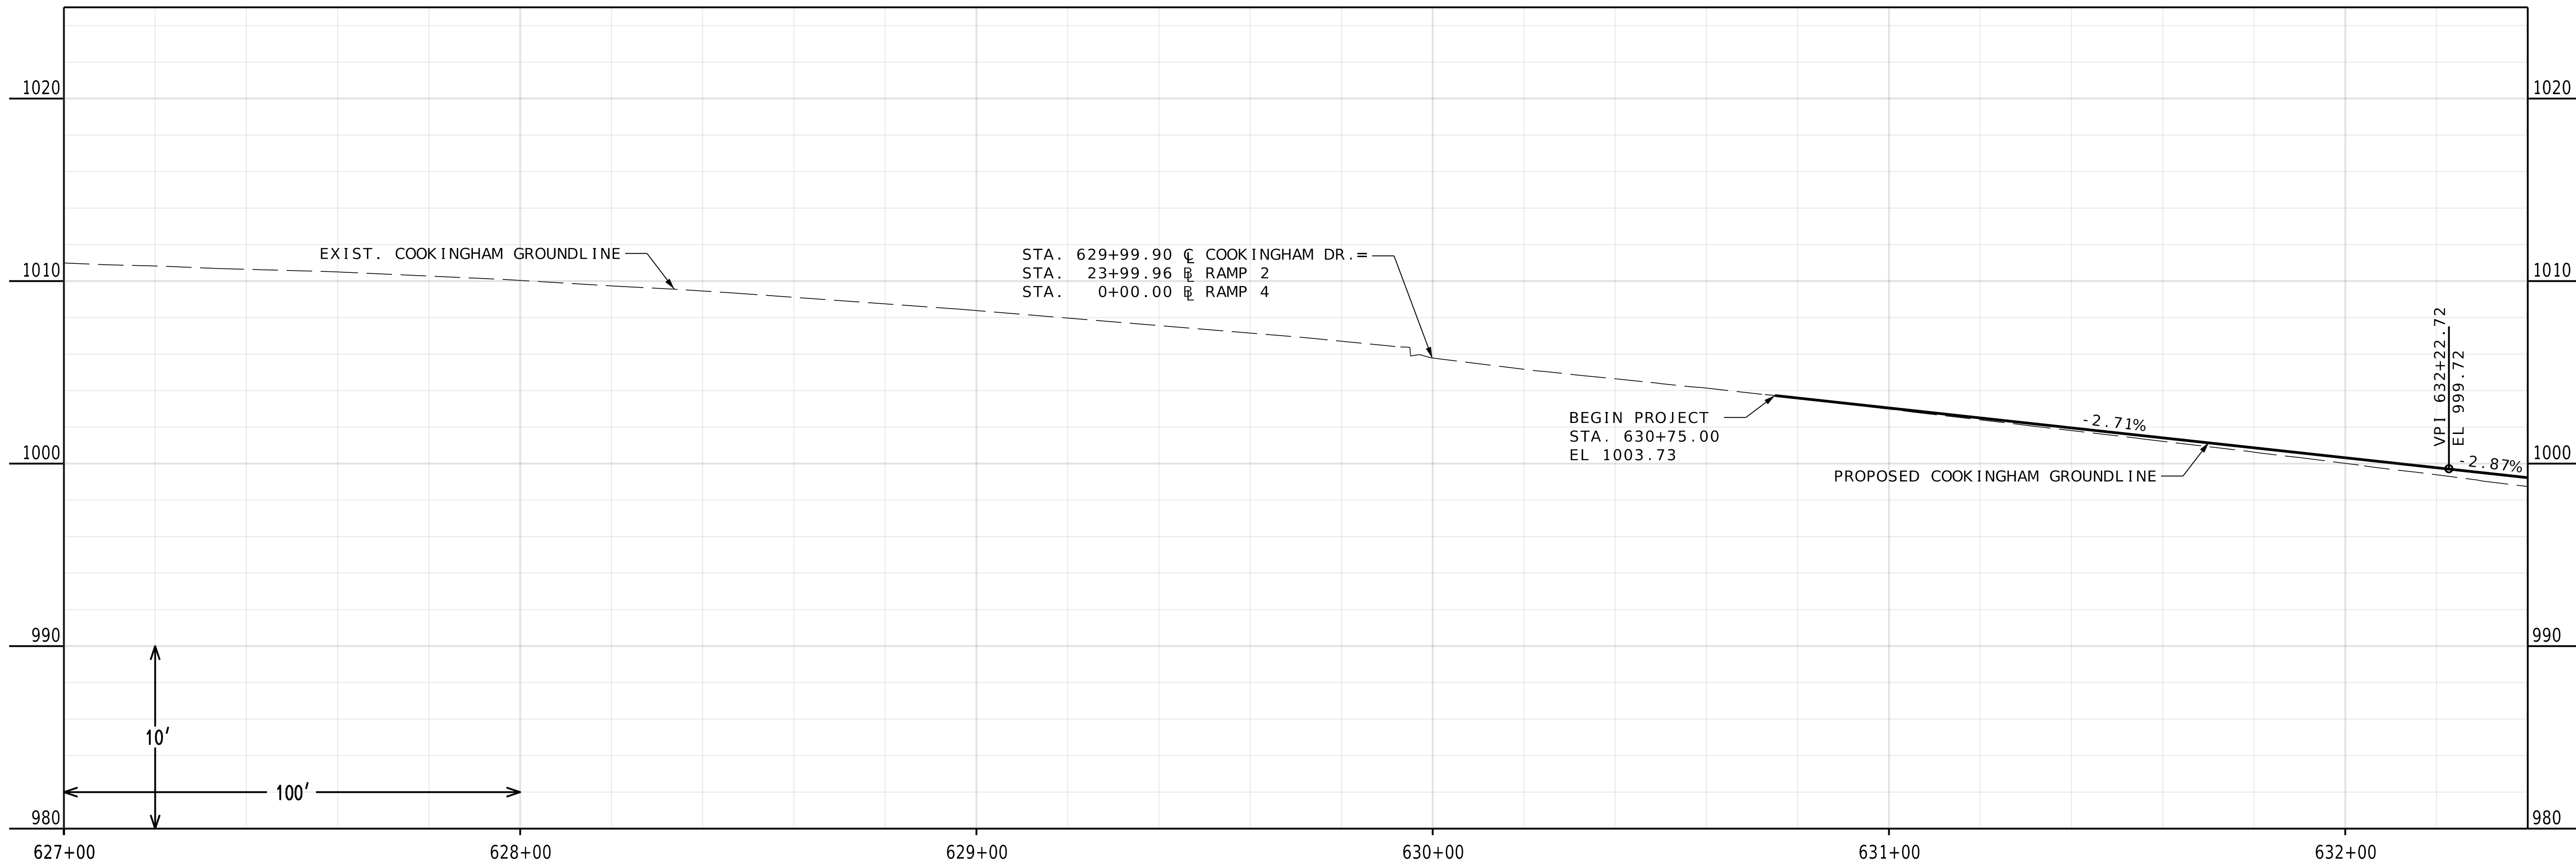

PLAN & PROFILE
SHEET 7 OF 8

PRELIMINARY
PLANS
NOT FOR
CONSTRUCTION

DATE PREPARED
4/30/2025

ROUTE 1435	STATE MO
DISTRICT KC	SHEET NO. 10

COUNTY
PLATTE

JOB NO.
J4S3489


CONTRACT ID.

PROJECT NO.

BRIDGE NO.
A9700

DATE	DESCRIPTION

MISSOURI HIGHWAYS AND TRANSPORTATION
COMMISSION

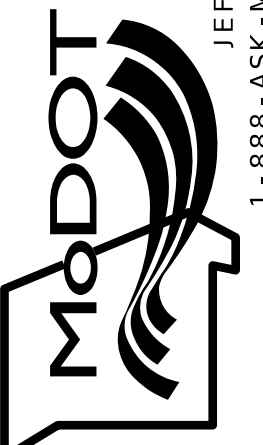


105 WEST CAPITOL
JEFFERSON CITY, MO 65102
1-888-ASK-MODOT (1-888-275-6636)

olsson

1301 BURLINGTON STREET, STE. 100
NORTH KANSAS CITY, MO 64116
PHONE: 816.361.1177
CERTIFICATE OF AUTHORITY NO. 001592

IF A SEAL IS PRESENT ON THIS SHEET IT HAS BEEN ELECTRONICALLY SEALED AND DATED.

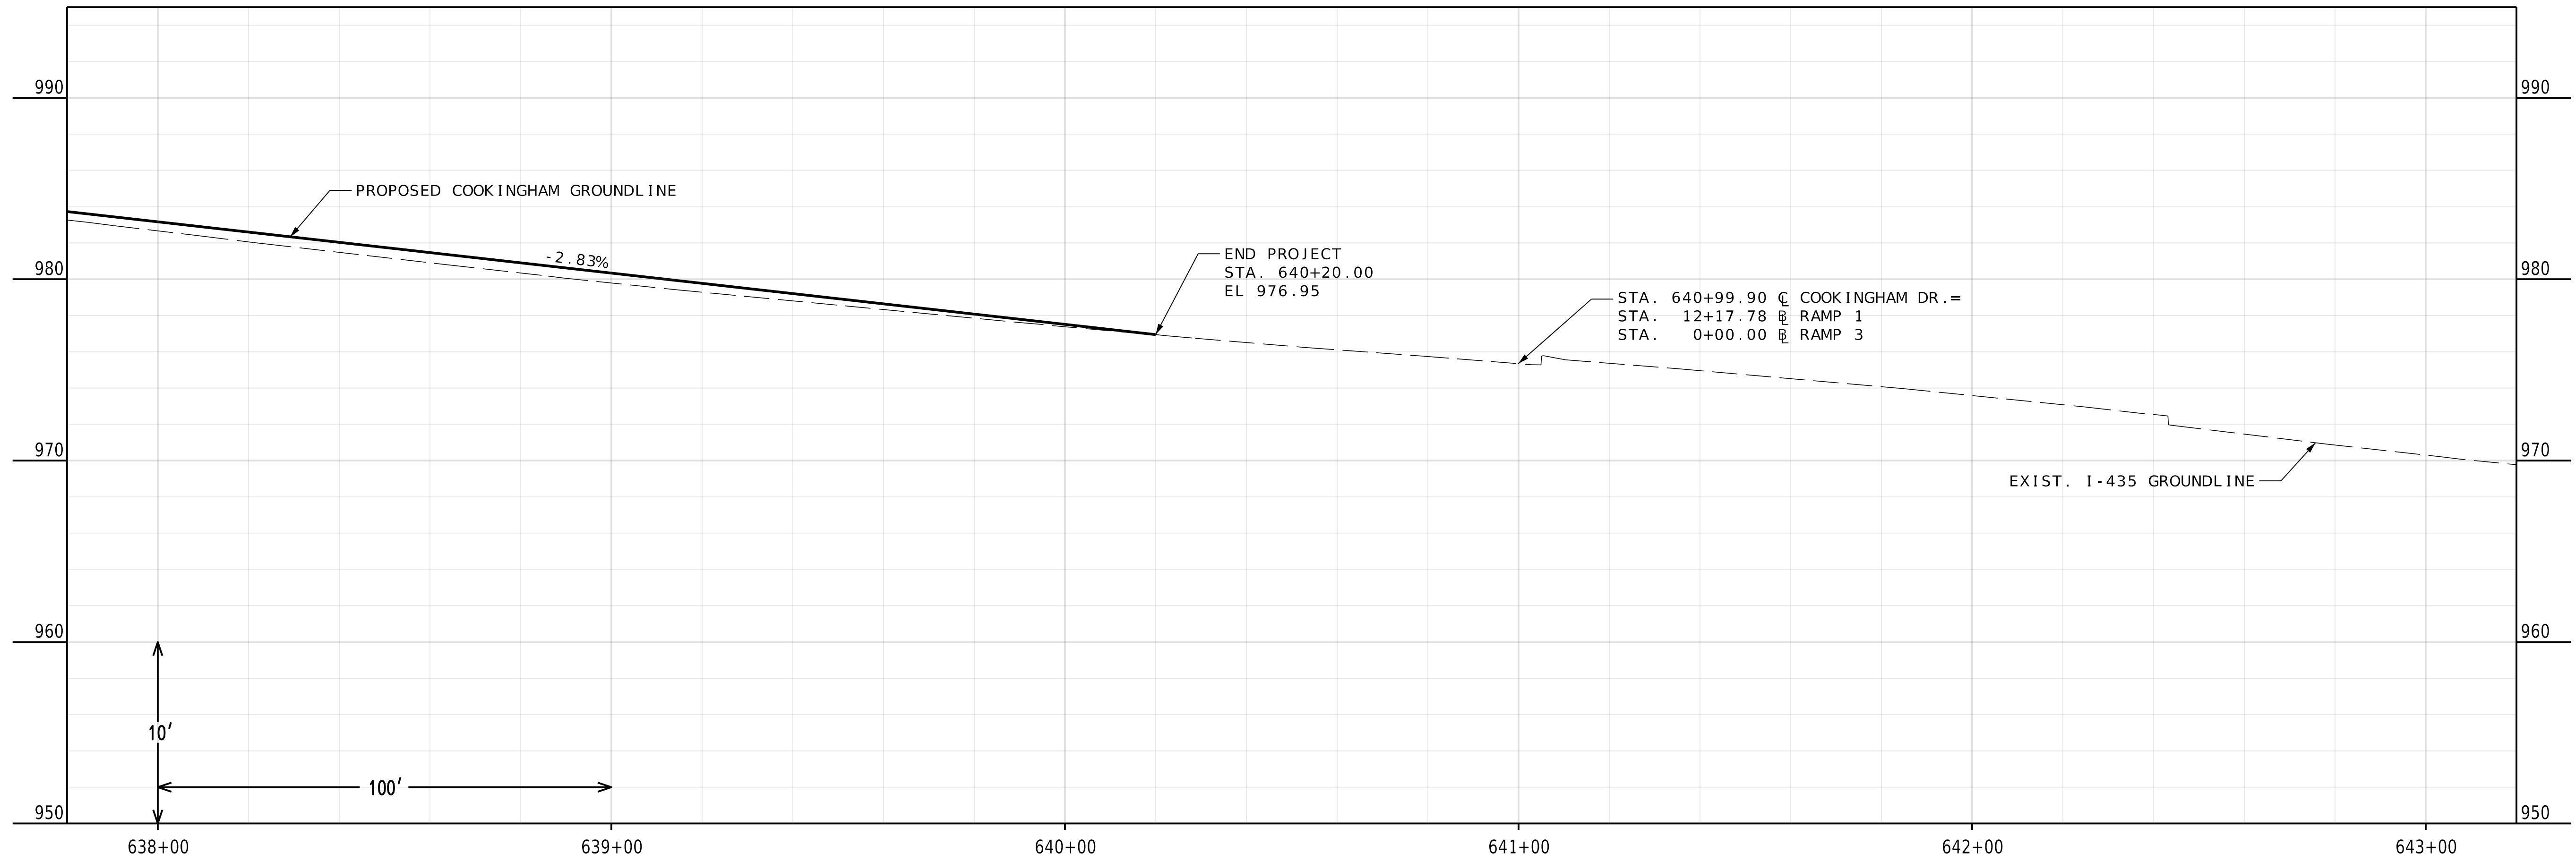

PRELIMINARY
PLANS
NOT FOR
CONSTRUCTION

DATE PREPARED
4/30/2025

ROUTE	STATE
1435	MO
DISTRICT	SHEET NO.
KC	11

COUNTY
PLATTE

JOB NO.
J4S3489

CONTRACT ID.

PROJECT NO.

BRIDGE NO.
A9700

DATE	DESCRIPTION

MISSOURI HIGHWAYS AND TRANSPORTATION
COMMISSION

105 WEST CAPITOL
JEFFERSON CITY, MO 65102
1-888-ASK-MODOT (1-888-275-6636)

1301 BURLINGTON STREET, STE. 100
NORTH KANSAS CITY, MO 64116
PHONE: 816.361.1177
CERTIFICATE OF AUTHORITY NO. 001592

PLAN & PROFILE
SHEET 8 OF 8

IF A SEAL IS PRESENT ON THIS SHEET IT HAS BEEN ELECTRONICALLY SEALED AND DATED.

ALL PROJECT COORDINATES HAVE BEEN PROJECTED FROM THE MISSOURI STATE PLANE COORDINATE (SPC) SYSTEM OF 1983 USING AN AVERAGE PROJECT PROJECTION (GRID TO GROUND) FACTOR. TO GET BACK TO STATE PLANE COORDINATES MULTIPLY THE PROJECT COORDINATES BY THE AVERAGE GRID FACTOR AS SHOWN IN THE "REFERENCE CONTROL INFORMATION" PORTION OF THIS TABLE.

PROJECT COORDINATE INFORMATION	
COORDINATE SYSTEM	STATE PLANE, MISSOURI WEST
HORIZONTAL DATUM	NAD 1983
VERTICAL DATUM	NAVD 1988
GEOID MODEL	PLATTE COUNTY
ELEVATIONS DETERMINED BY	GPS OBSERVATIONS
PROJECT PROJECTION FACTOR	1.00010131

REFERENCE CONTROL INFORMATION	
COORDINATE SYSTEM	NAD 1983
CONTROL STATION	PL-06
DESIGNATION	PL-06
CORS_ID	
PID	165006
LATITUDE	39°18'24.53538"
LONGITUDE	94°37'08.25323"
NORTHING (M)	348516.2920
EASTING (M)	839740.2450
ZONE	WEST
PROJECT AVERAGE GRID FACTOR	0.99989870

EXAMPLE OF PROJECT COORDINATE TO S.P.C.

PROJECT NORTHING X AVERAGE GRID FACTOR = STATE PLANE NORTHING
 PROJECT EASTING X AVERAGE GRID FACTOR = STATE PLANE EASTING
 EXAMPLE: CONTROL POINT #5027
 N 1142683.91 X 0.99989870 = N 1142568.156
 E 2760693.65 X 0.99989870 = E 2760413.992

LINEAR UNIT CONVERSION	
1 METER =	3.280833333 US SURVEY FEET (USFT)

COORDINATE POINT LISTING

SHEET NO	STATION	LOCATION	OFFSET (USFT)	MODIFIED STATE PLANE (GROUND)			DESCRIPTION	GPK POINT ID
				NORTHING (US SURVEY FT)	EASTING (US SURVEY FT)	ELEVATION (US SURVEY FT)		
PROJECT CONTROL POINTS								
	949+06.69	ROUTE 435	1027.15'	1142683.91	2760693.65	1017.48	CONTROL -GPS #5027	
	635+66.49	COOKINGHAM	190.01'	1143811.35	2760130.29	985.35	CONTROL -GPS #5030	
				1144937.34	2758563.05	973.83	CONTROL -GPS #5056	
ALIGNMENTS								
	COOKINGHAM							
	627+00.00	☉		1143022.936	2760536.869		BEGIN ALIGNMENT	
	645+35.46	☉		1144436.196	2759365.717		END ALIGNMENT	
	RTE I435							
	940+77.71	☉		1143623.126	2759597.233		BEGIN ALIGNMENT/PC CURVE	
	944+92.61	RT	11.258	1143626.643	2760012.113		PI CURVE	
				1151262.291	2759532.464		CC CURVE	
	949+06.69	☉		1143675.072	2760424.171		END ALIGNMENT/PT CURVE	
	RAMP 1							
	8+88.79	☉		1143963.624	2759344.619		BEGIN ALIGNMENT	
	12+17.78	☉		1144100.827	2759643.633		END ALIGNMENT	
	RAMP 2							
	18+30.61	☉		1143176.867	2759797.158		BEGIN ALIGNMENT/PC CURVE	
	20+70.85	RT	43.82	1143107.823	2760027.264		PI CURVE	
				1143786.630	2759980.117		CC CURVE	
	22+90.05	☉		1143208.015	2760245.616		PT CURVE	
	23+99.96	☉		1143253.852	2760345.512		END ALIGNMENT	
	RAMP 3							
	0+00.00	☉		1144100.827	2759643.633		BEGIN ALIGNMENT	
	1+29.57	☉		1144154.864	2759761.398		END ALIGNMENT	
	RAMP 4							
	0+00.00	☉		1143253.852	2760345.512		BEGIN ALIGNMENT	
	3+26.26	☉		1143389.919	2760642.048		END ALIGNMENT	

PRELIMINARY PLANS NOT FOR CONSTRUCTION

DATE PREPARED: 4/30/2025

ROUTE: I435 STATE: MO

DISTRICT: KC SHEET NO.: 12

COUNTY: PLATTE

JOB NO.: J4S3489


CONTRACT ID:

PROJECT NO.:

BRIDGE NO.: A9700

DATE	DESCRIPTION

MISSOURI HIGHWAYS AND TRANSPORTATION COMMISSION

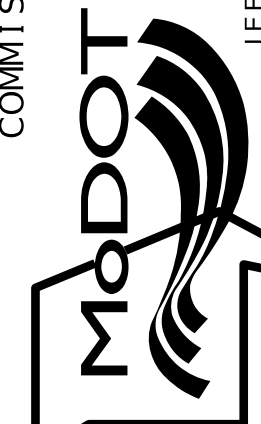

105 WEST CAPITOL JEFFERSON CITY, MO 65102
1-888-ASK-MODOT (1-888-275-6636)

Olsson
 1301 BURLINGTON STREET, STE. 100
 NORTH KANSAS CITY, MO 64116
 PHONE: 816.361.1177
 CERTIFICATE OF AUTHORITY NO. 001592

IF A SEAL IS PRESENT ON THIS SHEET IT HAS BEEN ELECTRONICALLY SEALED AND DATED.

DATE PREPARED
5/2/2025

ROUTE STATE
1435 MO

DISTRICT SHEET NO.
KC 15

COUNTY
PLATTE

JOB NO.
J4S3489

CONTRACT ID.

PROJECT NO.

BRIDGE NO.
A9700

SIGN SPACING FOR ADVANCE SIGN SERIES (1) (2)		
PERMANENT POSTED SPEED MPH	^s UNDIVIDED HIGHWAYS	^s DIVIDED HIGHWAYS
0-35	200'	200'
40-45	350'	500'
50-55	500'	1000'
60-70	1000'	SA - 1000' SB - 1500' SC - 2640'

SHOULDER WORK NOTES:
PROVIDE SIGNS ON LEFT AND RIGHT SIDES OF DIVIDED HIGHWAYS.

ROAD WORK AHEAD SIGN NOT NEEDED IF SHOULDER WORK IS LOCATED WITHIN THE LIMITS OF AN ACTIVITY AREA WHERE ANOTHER ROAD WORK AHEAD SIGN IS ALREADY USED.

SEE EPG 616.12 WORK ZONE SPEED LIMITS FOR SPEED LIMIT GUIDELINES.

(3) NEXT XX MILES SIGN NOT REQUIRED FOR NARROW LANE SECTIONS LESS THAN ONE MILE.


THE PROTECTIVE VEHICLE MAY BE OMITTED IF A TAPER AND CHANNELIZING DEVICES ARE USED.

VEHICLE-MOUNTED SIGNS SHALL BE MOUNTED IN A MANNER SUCH THAT THEY ARE NOT OBSCURED BY EQUIPMENT OR SUPPLIES. SIGN LEGENDS ON VEHICLE-MOUNTED SIGNS SHALL BE COVERED OR TURNED FROM VIEW WHEN WORK IS NOT IN PROGRESS.

VEHICLE HAZARD WARNING SIGNALS SHALL NOT BE USED INSTEAD OF VEHICLES ROTATING LIGHTS OR STROBE LIGHTS.

SHADOW AND WORK VEHICLES SHALL DISPLAY HIGH-DENSITY ROTATING, FLASHING, OSCILLATING, OR STROBE LIGHTS.

SEE SHEET 13 FOR TAPER LENGTHS AND CHANNELIZER SPACING.

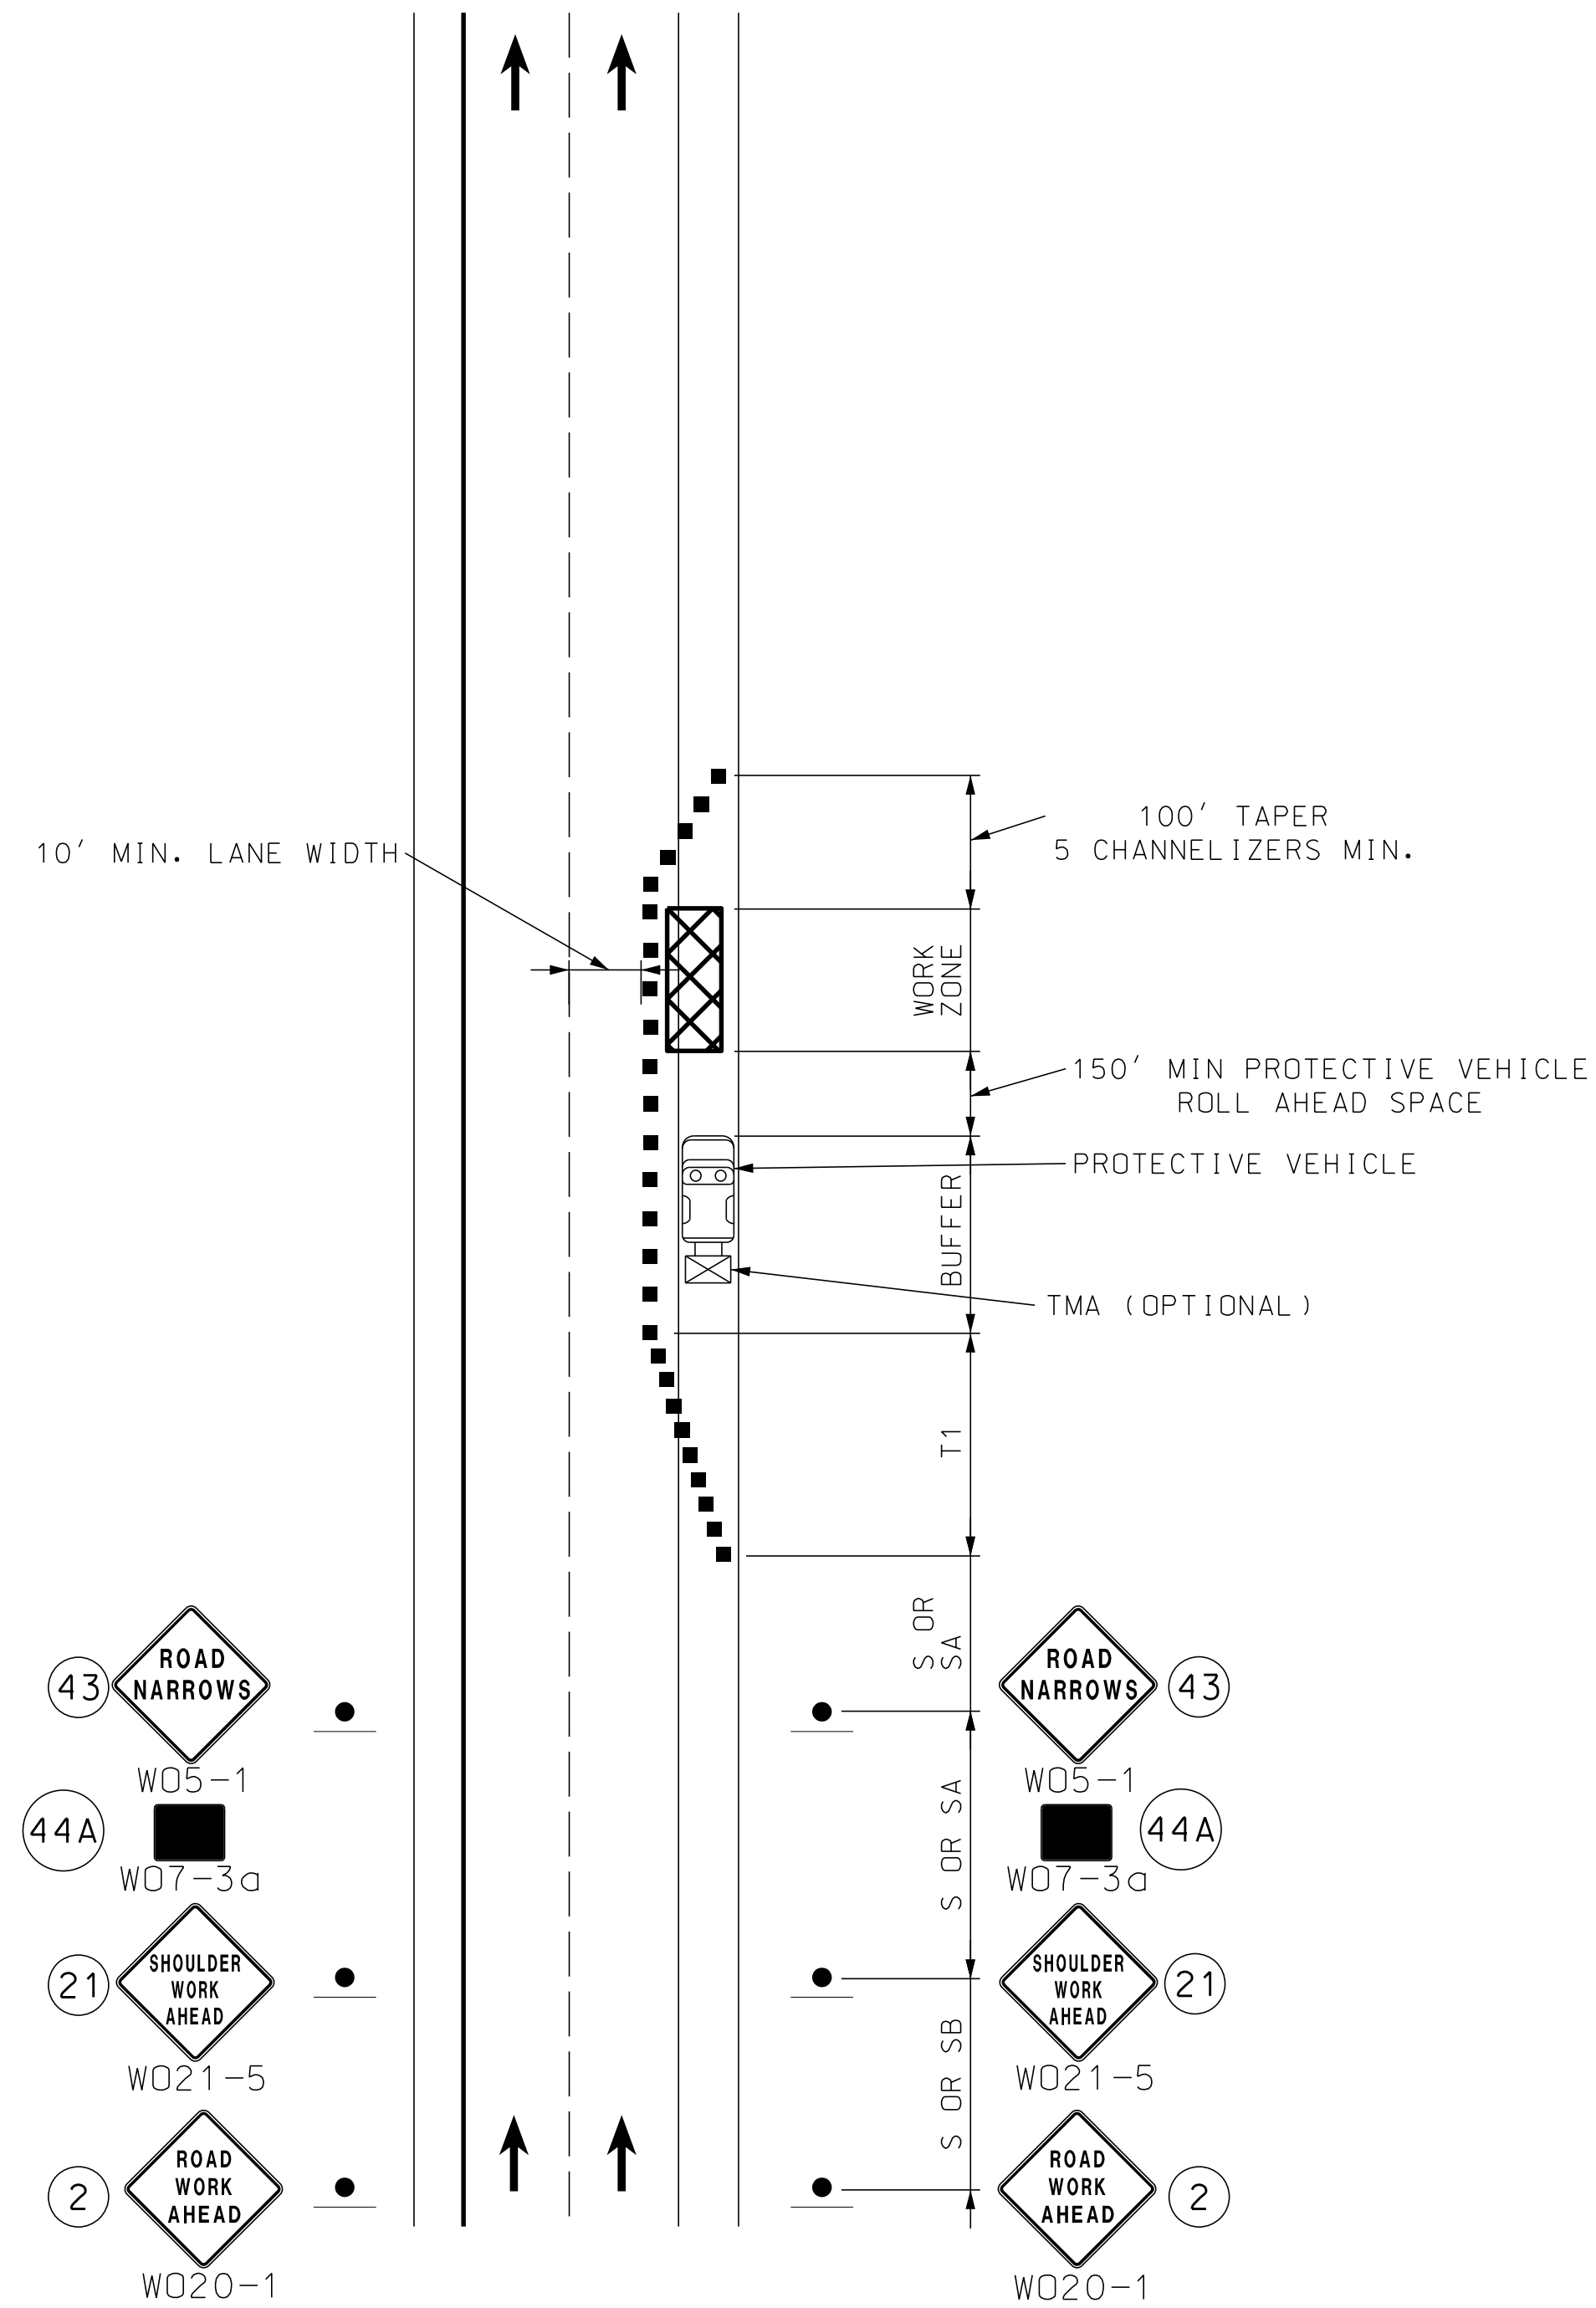

I-435
SHOULDER WORK WITH MINOR ENCROACHMENT
ON DIVIDED AND UNDIVIDED HIGHWAYS

DATE	DESCRIPTION


MISSOURI HIGHWAYS AND TRANSPORTATION COMMISSION

105 WEST CAPITOL
JEFFERSON CITY, MO 65102
1-888-ASK-MODOT (1-888-275-6636)

olsson
1301 BURLINGTON STREET, STE. 100
NORTH KANSAS CITY, MO 64116
PHONE: 816.361.1177
CERTIFICATE OF AUTHORITY NO. 001592


IF A SEAL IS PRESENT ON THIS SHEET IT HAS BEEN ELECTRONICALLY SEALED AND DATED.

STAGE
ROUTE I-435
BRIDGE REHABS

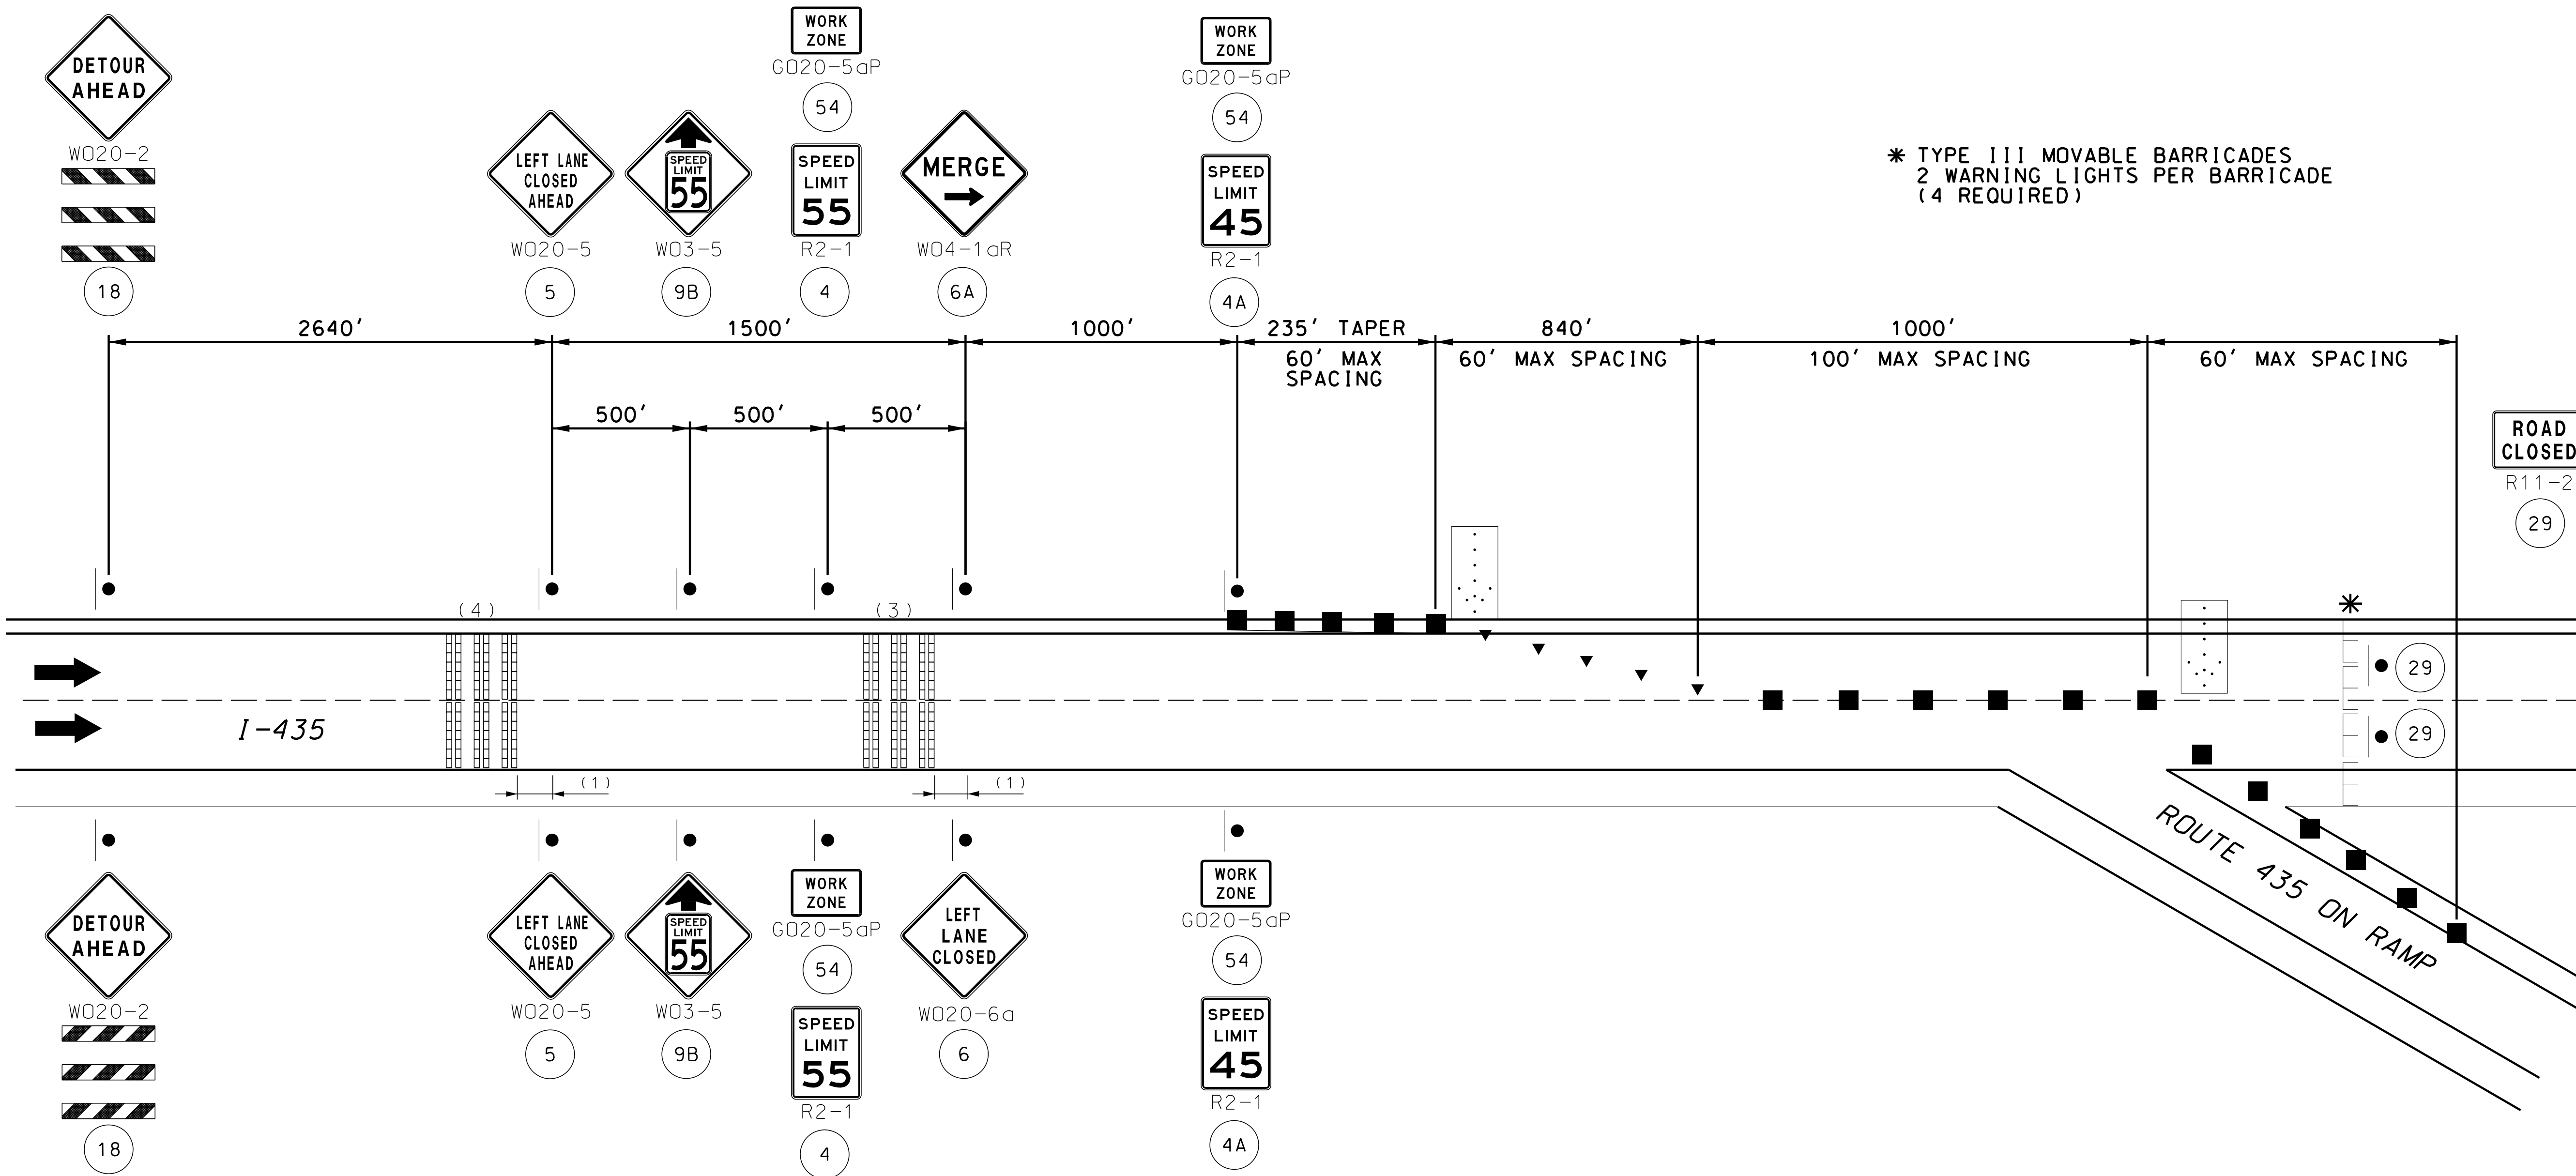


* TYPE III MOVABLE BARRICADES
2 WARNING LIGHTS PER BARRICADE
(4 REQUIRED)

ROAD
CLOSED
R11-2
29

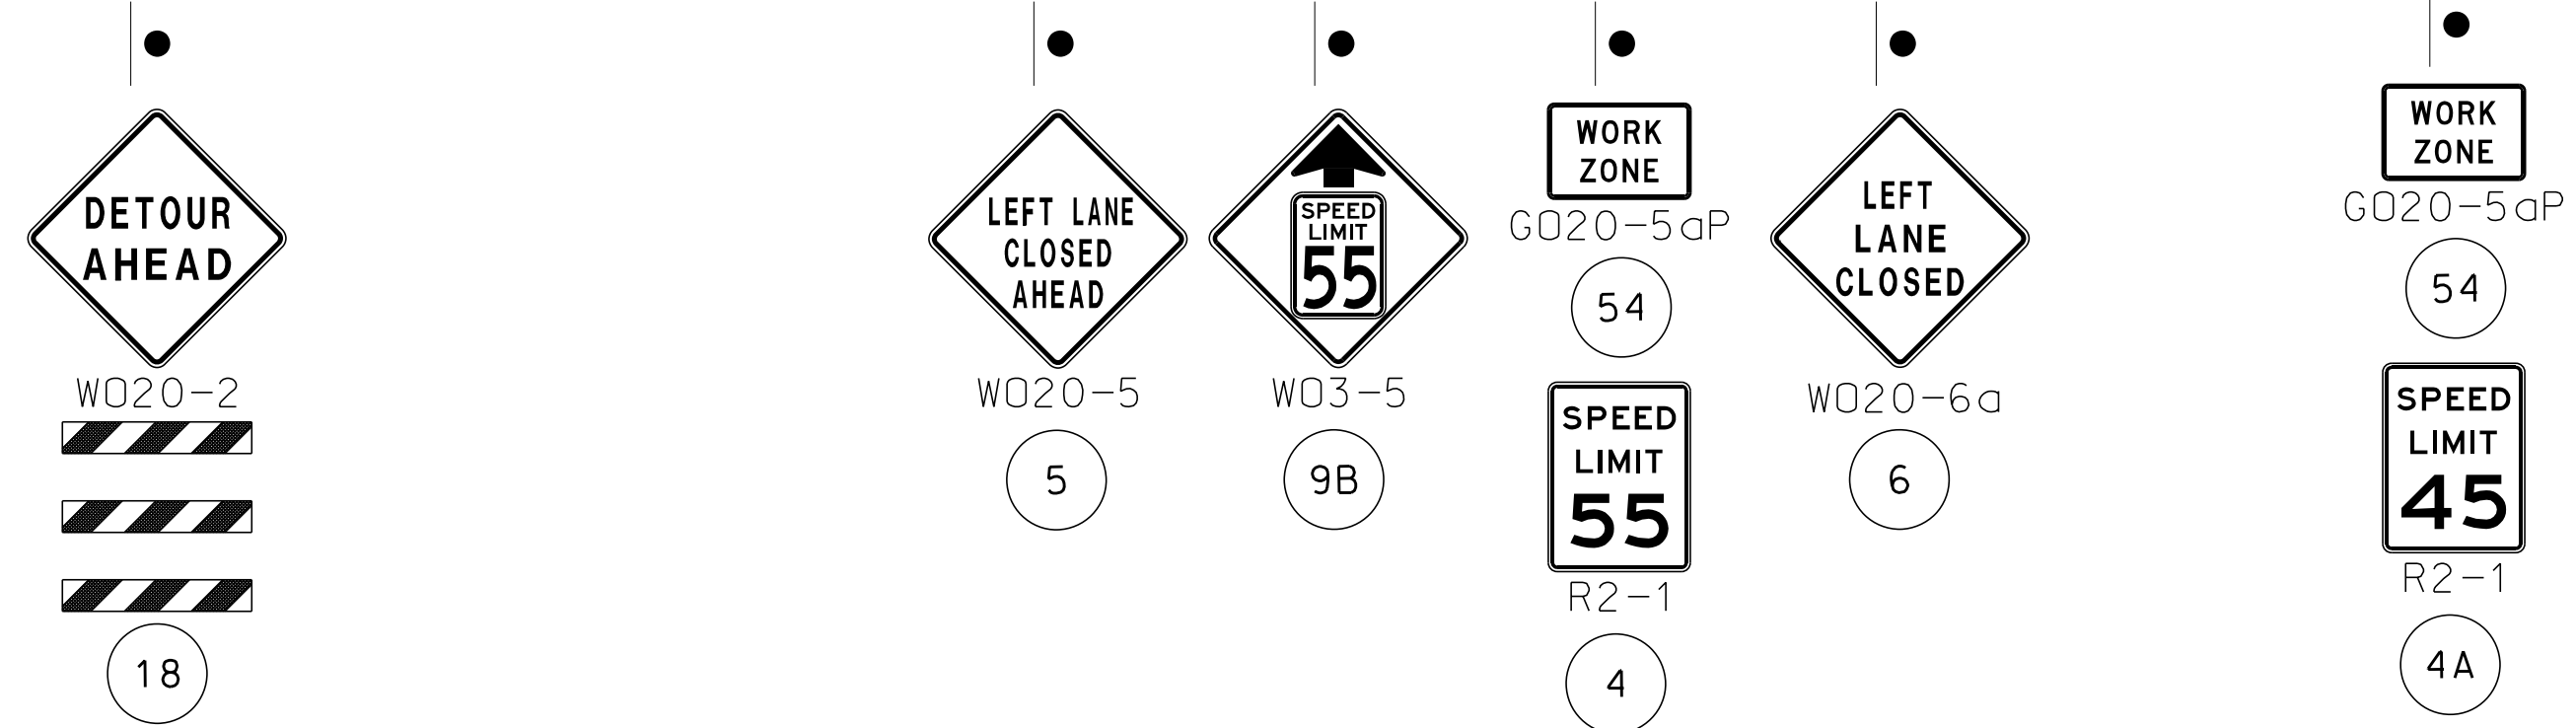

NOTES:
NO DIRECT PAY WILL BE MADE FOR RELOCATING, COVERING, UNCOVERING, OR REMOVING SIGNS.
ANY EXISTING SIGNING THAT CONFLICTS WITH THE TRAFFIC CONTROL SIGNING SHALL BE COMPLETELY COVERED OR REMOVED.
LOCATE FLASHING ARROW PANEL AT BEGINNING OF TAPER WHEN FEASIBLE. ARROW PANELS ARE ALWAYS LOCATED BEHIND CHANNELIZERS.
SPACING OF SIGNS SHOWN ON THE PLANS ARE MINIMUM AND MAY BE ADJUSTED BY THE ENGINEER TO MEET FIELD CONDITIONS.
SEE SPECIAL PROVISIONS FOR I-29 CLOSURE RESTRICTIONS.
DIMENSIONS IN FEET UNLESS OTHERWISE NOTED.
(1) SPACINGS MAY BE ADJUSTED AS NECESSARY TO MEET FIELD CONDITIONS.

SHORT-TERM RUMBLE STRIPS		
SPEED (1) MPH	DISTANCE (1)	SPACING (2)
0 - 45 OPTIONAL	120 FT	10 FT
50 - 55	160 FT	15 FT
60 - 70	200 FT	20 FT

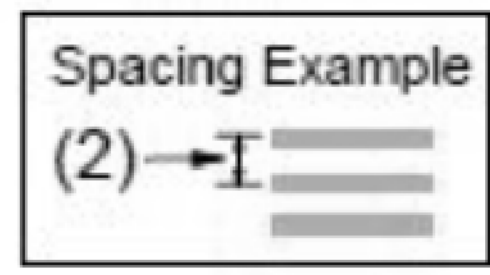

Spacing (2) may need to be adjusted if temporary rumble strips are sliding or moving.

NORTH I-29 DETOUR (EXIT 92)
SOUTH I-29 DETOUR (EXIT 92)

SEE EPG 616.6.87 TEMPORARY RUMBLE STRIPS FOR RUMBLE STRIP GUIDANCE AND LOCATIONS.
TEMPORARY RUMBLE STRIPS SHALL BE ORANGE, IN COLOR.

LONG-TERM RUMBLE STRIPS SHALL CONSIST OF 5 STRIPS SEPARATE AT 10-12 FT. CENTERS OR MANUFACTURE'S RECOMMENDATION.

TWO OR FOUR SETS OF RUMBLE STRIPS MAY BE USED SIMULTANEOUSLY COVERING LOCATIONS (3) AND (4). IF ONLY TWO SETS ARE USED, THE PREFERRED PLACEMENT IS AT LOCATION (3)

TRAFFIC CONTROL LEGEND

- SIGN (SINGLE SIDED)
- CHANNELIZER
- ▼ DIRECTIONAL INDICATOR
- E TYPE 3 MOVABLE BARRICADE
- DIRECTION OF TRAFFIC
- FLASHING ARROW PANEL
- ||| LONG-TERM RUMBLE STRIPS

TRAFFIC CONTROL
SHEET 5 OF 8

NOT TO SCALE

PRELIMINARY
PLANS
NOT FOR
CONSTRUCTION

DATE PREPARED
5/2/2025

ROUTE
1435

STATE
MO

DISTRICT
KC

SHEET NO.
17

COUNTY
PLATTE

JOB NO.
J4S3489

CONTRACT ID.

PROJECT NO.

BRIDGE NO.
A9700

DESCRIPTION

DATE

MISSOURI HIGHWAYS AND TRANSPORTATION
COMMISSION

MoDOT
105 WEST CAPITOL
JEFFERSON CITY, MO 65102
1-888-ASK-MODOT (1-888-275-6636)


1301 BURLINGTON STREET, STE. 100
NORTH KANSAS CITY, MO 64116
PHONE: 816.361.1177
CERTIFICATE OF AUTHORITY NO. 001592

IF A SEAL IS PRESENT ON THIS SHEET IT HAS BEEN ELECTRONICALLY SEALED AND DATED.

ROUTE I-435
BRIDGE REHAB
AND COOKINGHAM DRIVE PAVEMENT REHAB

TRAFFIC CONTROL LEGEND

- SIGN (SINGLE SIDED)
- CHANNELIZER
- ⌈ BARRICADE
- DIRECTION OF TRAFFIC

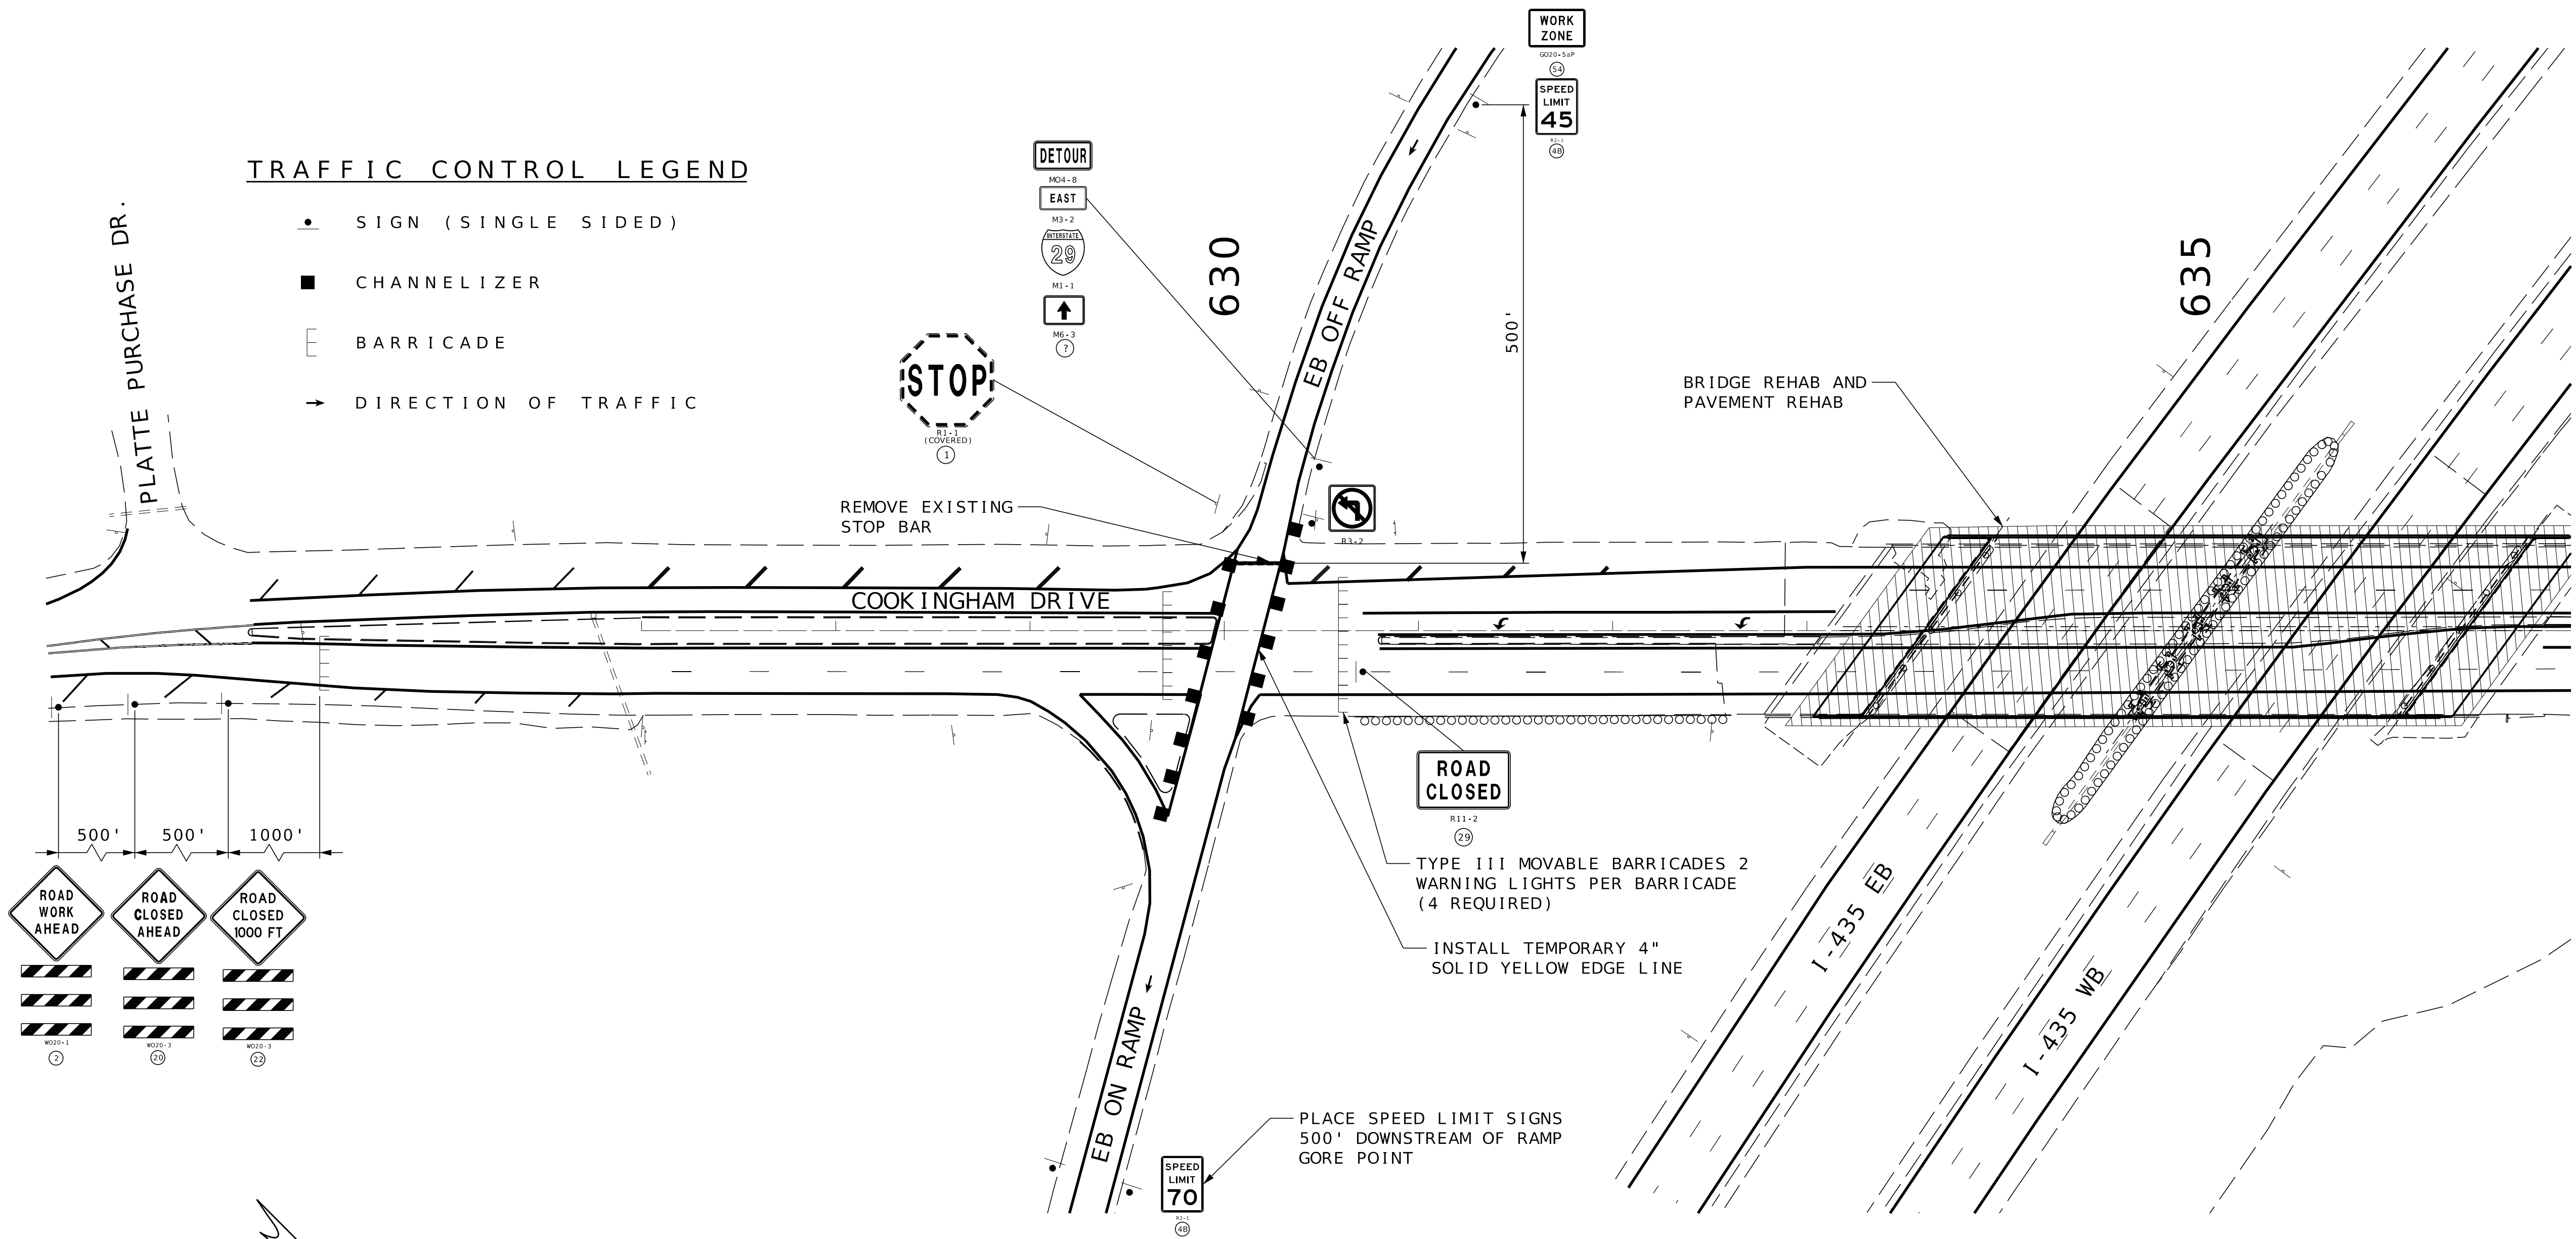

PRELIMINARY
PLANS
NOT FOR
CONSTRUCTION

DATE PREPARED 5/2/2025	
ROUTE I 435	STATE MO
DISTRICT KC	SHEET NO. 18
COUNTY PLATTE	
JOB NO. J4S3489	
CONTRACT ID.	
PROJECT NO.	
BRIDGE NO. A9700	

DATE	DESCRIPTION

MISSOURI HIGHWAYS AND TRANSPORTATION
COMMISSION

105 WEST CAPITOL
JEFFERSON CITY, MO 65102
1-888-ASK-MODOT (1-888-275-6636)

olsson
1301 BURLINGTON STREET, STE. 100
NORTH KANSAS CITY, MO 64116
PHONE: 816.361.1177
CERTIFICATE OF AUTHORITY NO. 001592



TRAFFIC CONTROL
SHEET 6 OF 8

IF A SEAL IS PRESENT ON THIS SHEET IT HAS BEEN ELECTRONICALLY SEALED AND DATED.

TRAFFIC CONTROL LEGEND

- SIGN (SINGLE SIDED)
- CHANNELIZER
- ⌈ BARRICADE
- DIRECTION OF TRAFFIC

**ROUTE 1-435
BRIDGE REHAB
AND COOKINGHAM DRIVE PAVEMENT REHAB**

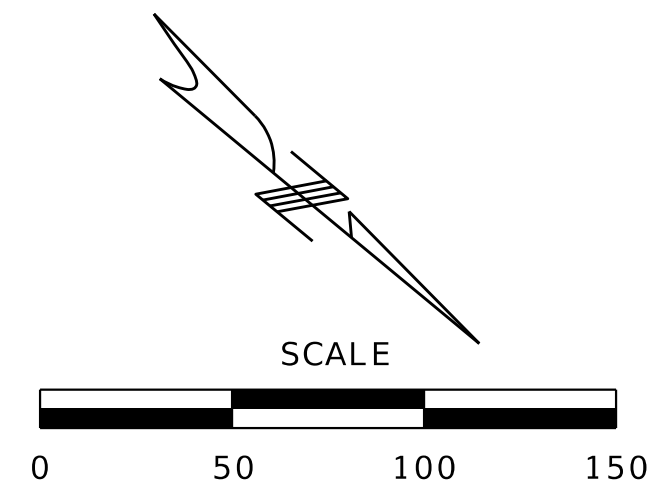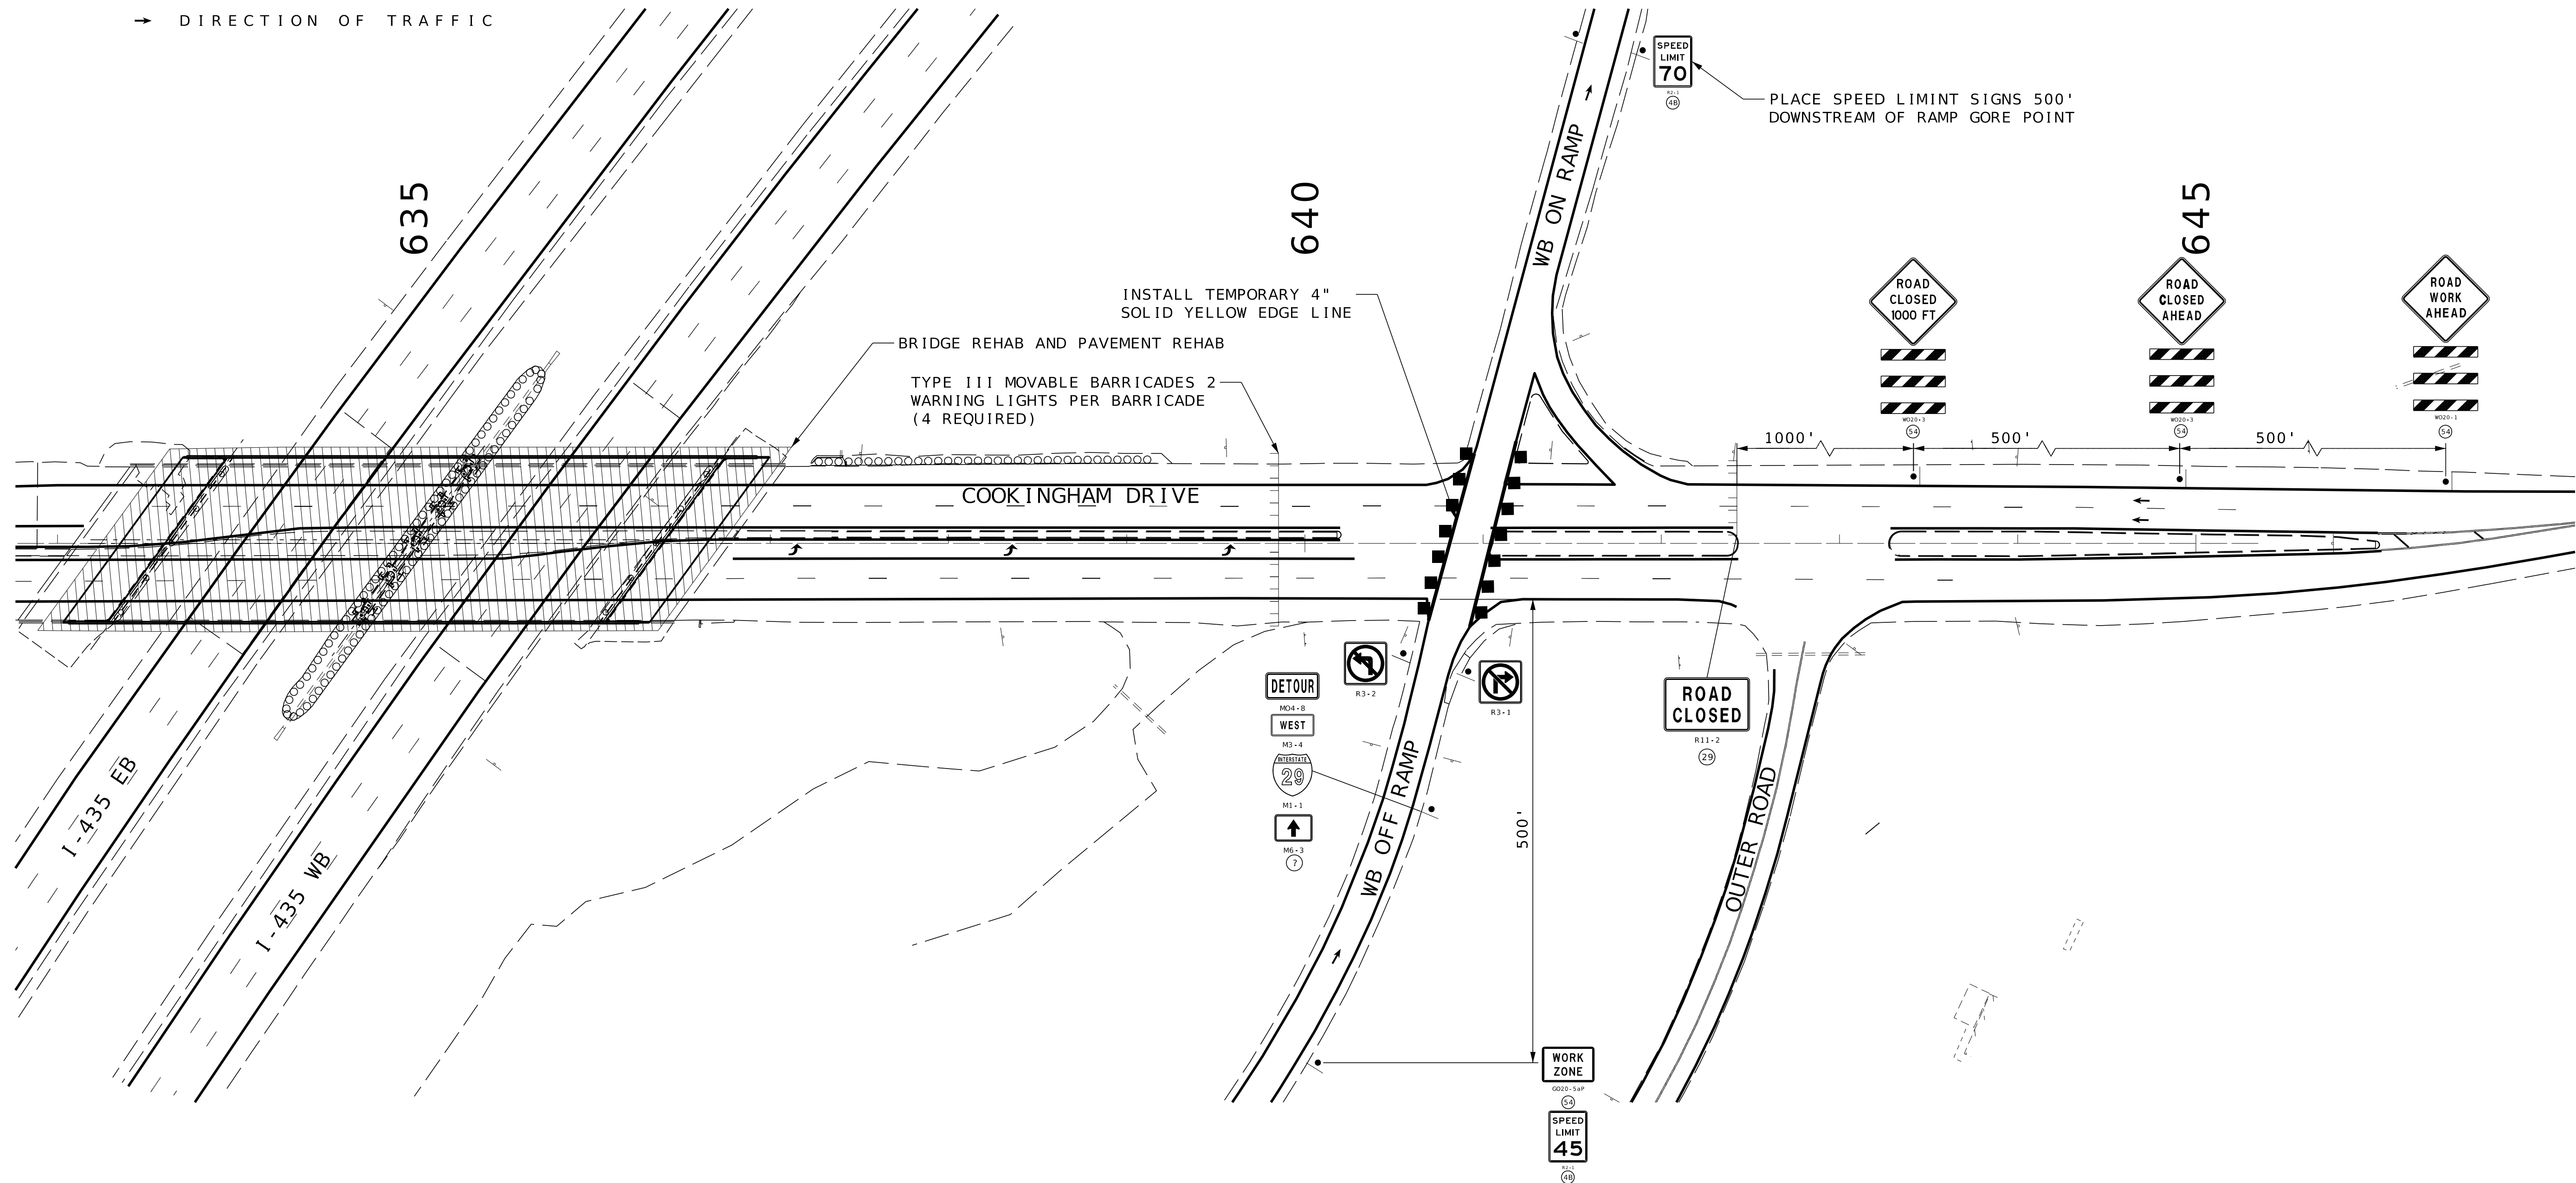

PRELIMINARY
PLANS
NOT FOR
CONSTRUCTION

DATE PREPARED 5/2/2025	
ROUTE 1435	STATE MO
DISTRICT KC	SHEET NO. 19
COUNTY PLATTE	
JOB NO. J4S3489	
CONTRACT ID.	
PROJECT NO.	
BRIDGE NO. A9700	

DATE	DESCRIPTION

MISSOURI HIGHWAYS AND TRANSPORTATION
COMMISSION

105 WEST CAPITOL
JEFFERSON CITY, MO 65102
1-888-ASK-MODOT (1-888-275-6636)


olsson

1301 BURLINGTON STREET, STE. 100
NORTH KANSAS CITY, MO 64116
PHONE: 816.361.1177
CERTIFICATE OF AUTHORITY NO. 001592



TRAFFIC CONTROL
SHEET 7 OF 8

IF A SEAL IS PRESENT ON THIS SHEET IT HAS BEEN ELECTRONICALLY SEALED AND DATED.

GENERAL NOTES:
 (1) ROAD CLOSED SIGN MAY BE PLACED 7-10 FEET BEHIND THE BARRICADES AND AT A SIGN HEIGHT APPROPRIATE TO THE TYPE OF ROADWAY. ONE BARRICADE SHOULD BE REQUIRED TO COMPLETELY CLOSE EVERY 8- FEET OF PAVEMENT. PAVED SHOULDERS SHOULD BE INCLUDED IN THE AREA TO BE CLOSED.

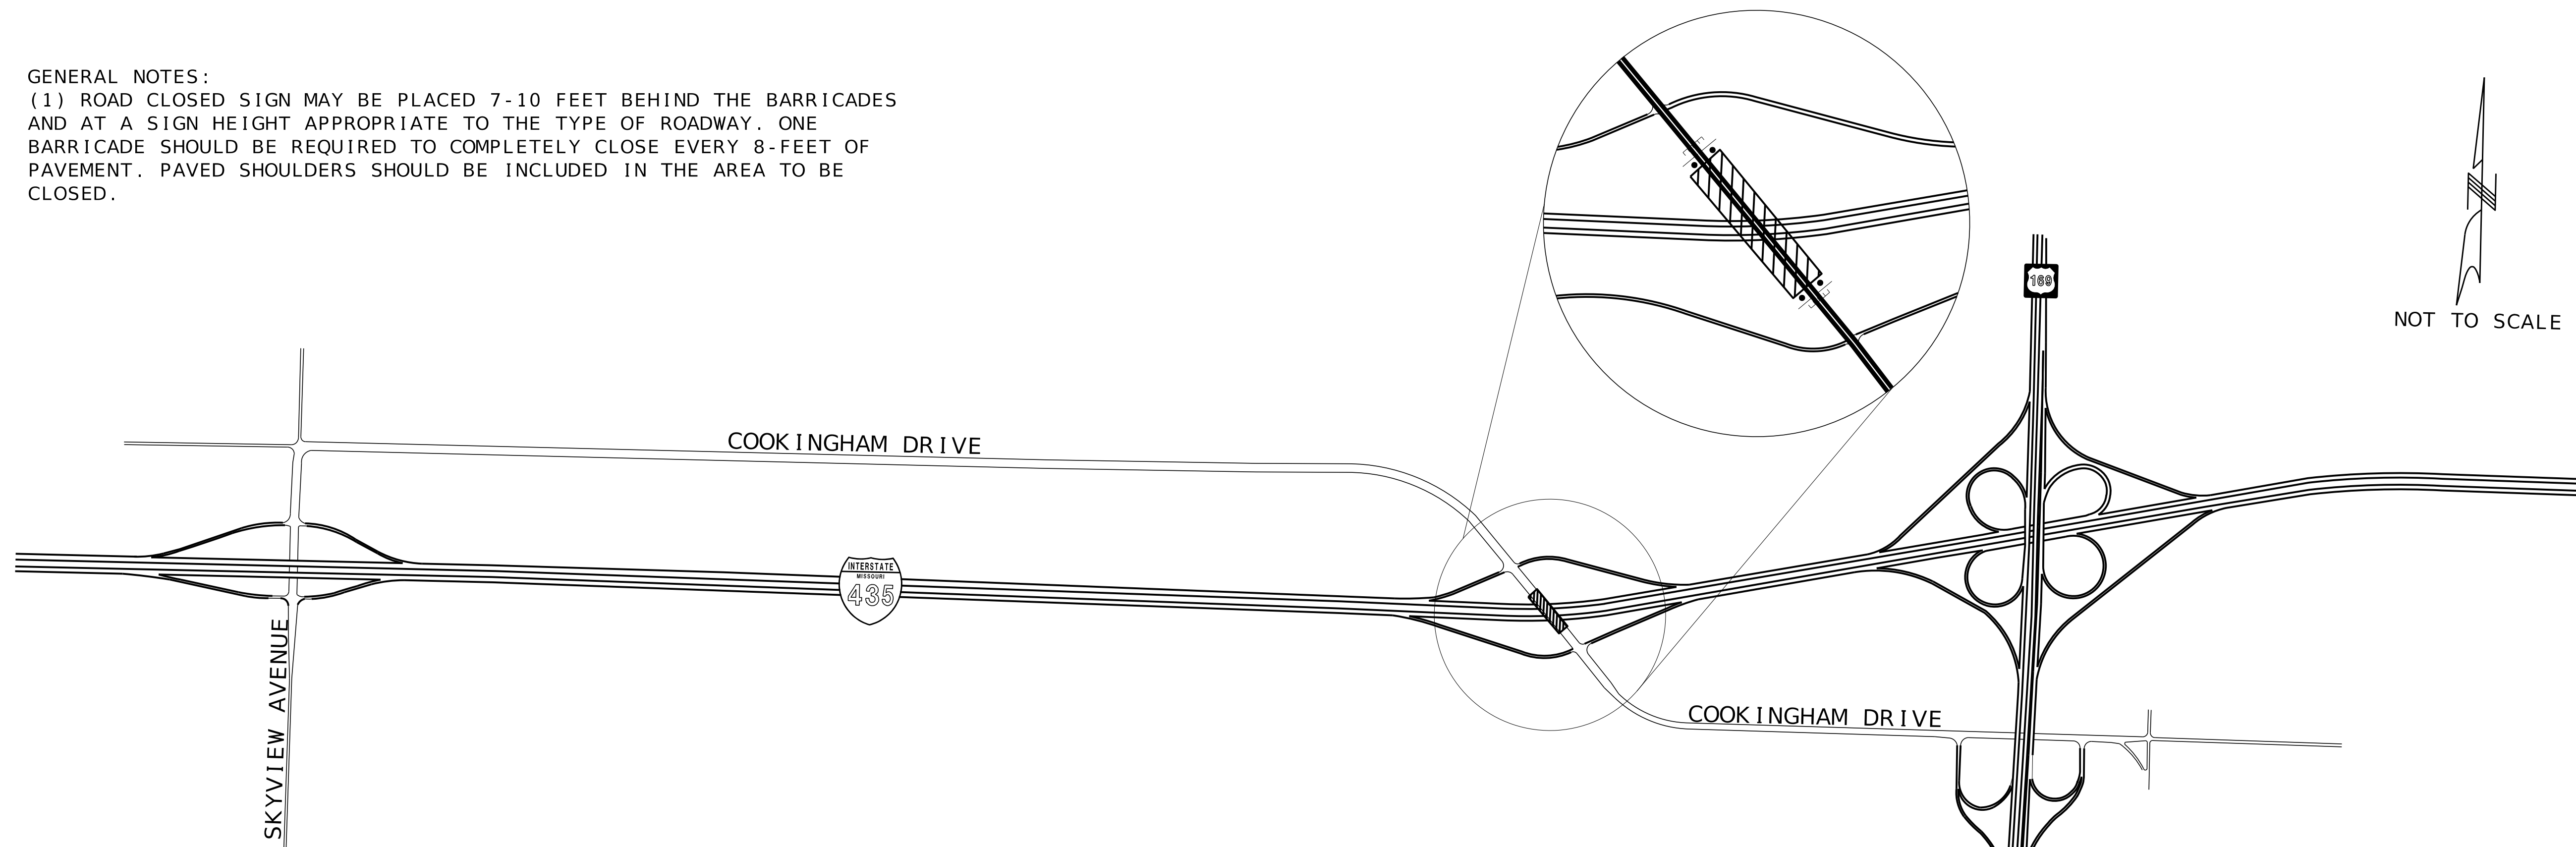

NOT TO SCALE

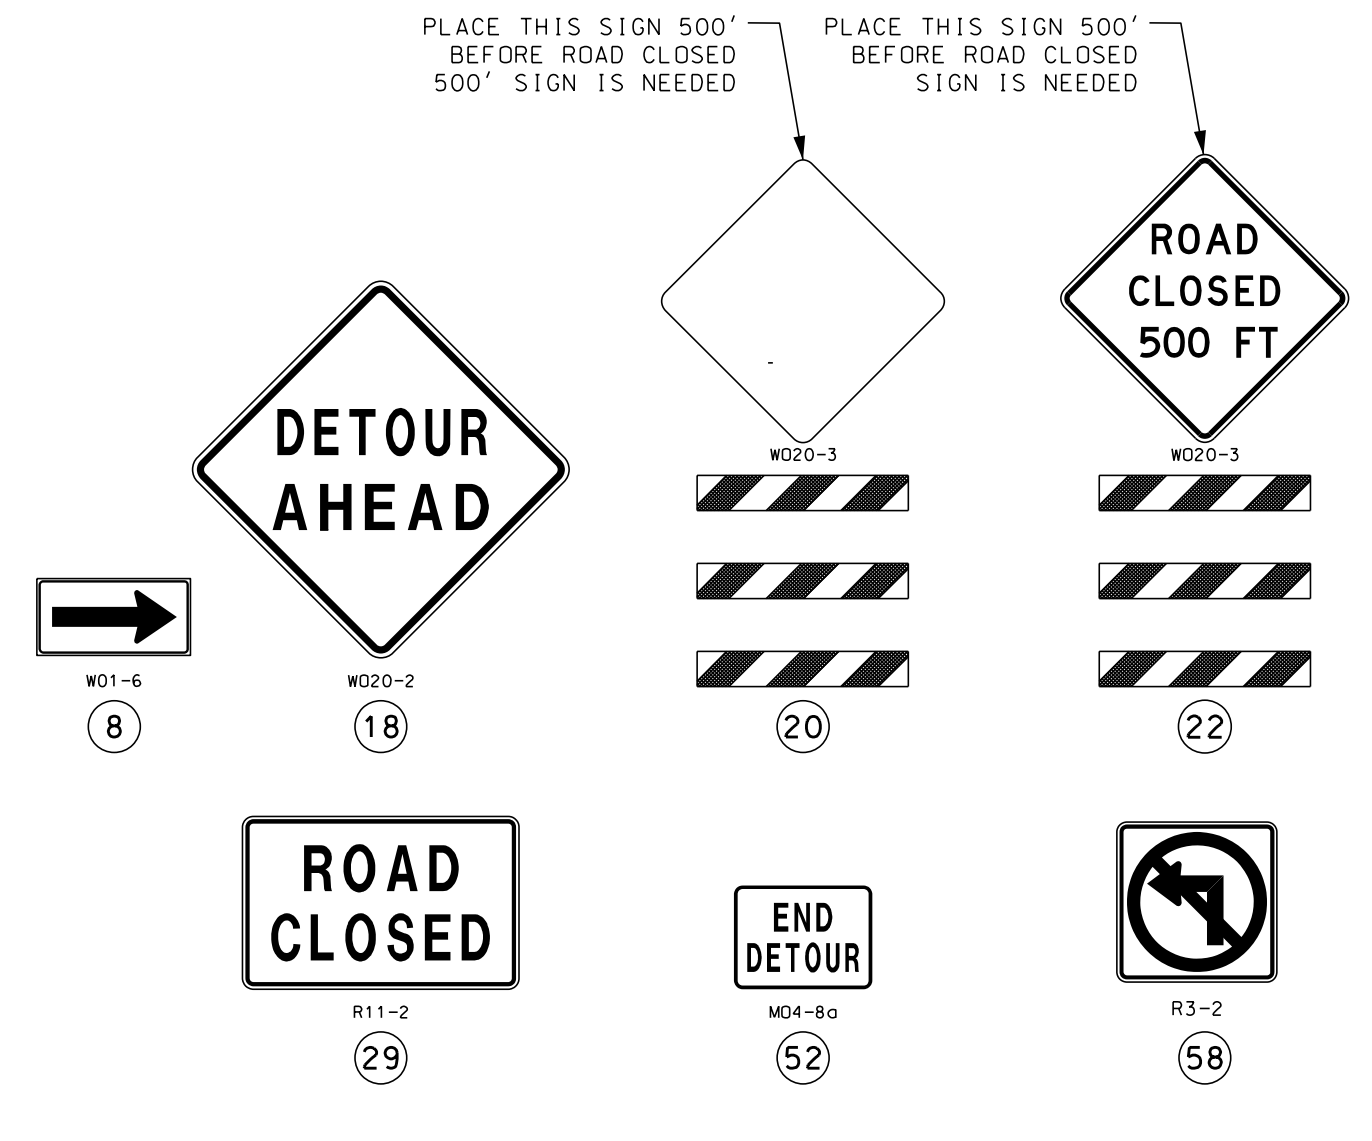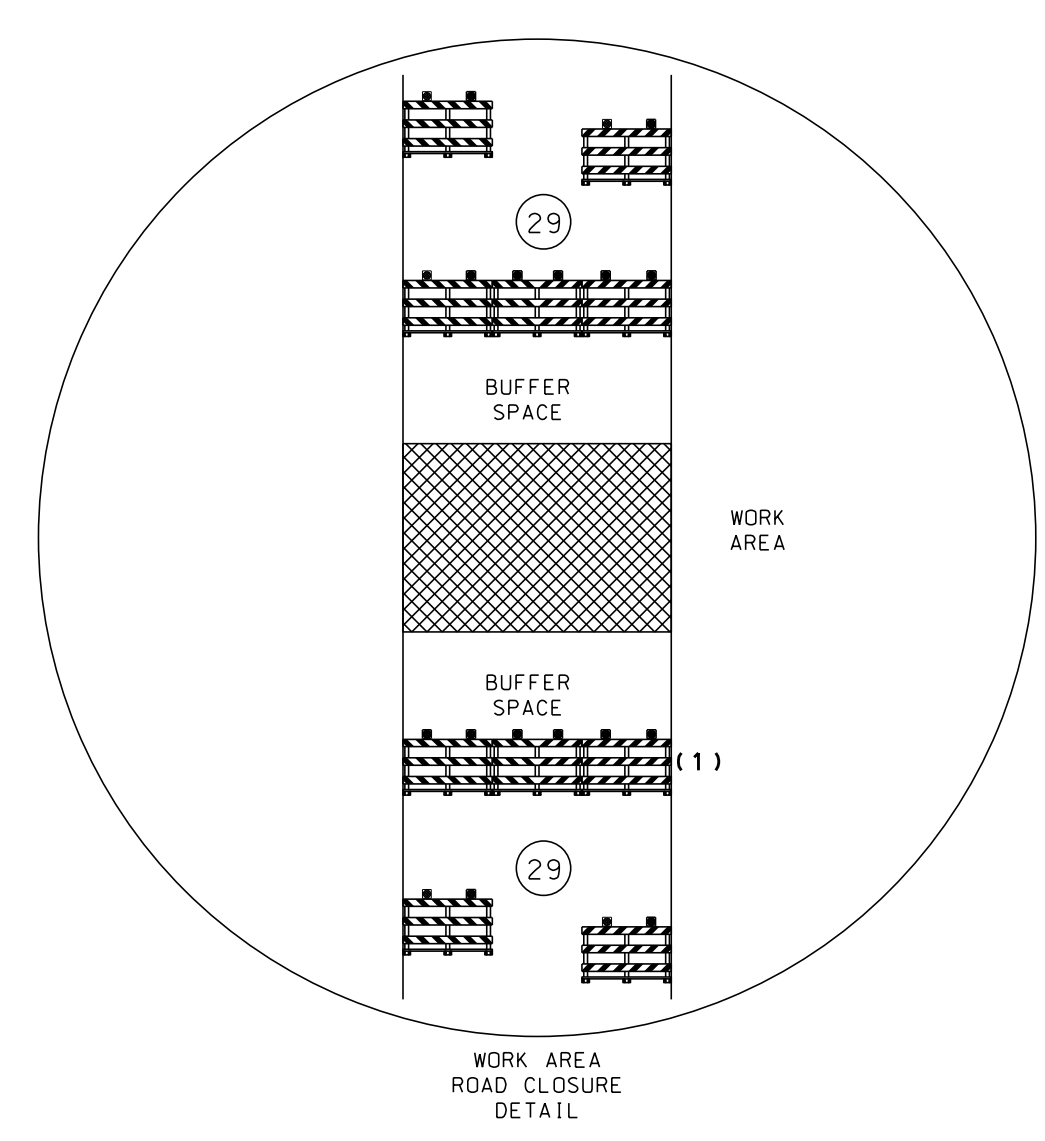

PRELIMINARY
 PLANS
 NOT FOR
 CONSTRUCTION

DATE PREPARED 5/2/2025	
ROUTE 1435	STATE MO
DISTRICT KC	SHEET NO. 20
COUNTY PLATTE	
JOB NO. J4S3489	
CONTRACT ID.	
PROJECT NO.	
BRIDGE NO. A9700	

DATE	DESCRIPTION

MISSOURI HIGHWAYS AND TRANSPORTATION COMMISSION


105 WEST CAPITOL
 JEFFERSON CITY, MO 65102
 1-888-ASK-MODOT (1-888-275-6636)

olsson

1301 BURLINGTON STREET, STE. 100
 NORTH KANSAS CITY, MO 64116
 PHONE: 816.361.1177
 CERTIFICATE OF AUTHORITY NO. 001592

TRAFFIC CONTROL
 SHEET 8 OF 8

IF A SEAL IS PRESENT ON THIS SHEET IT HAS BEEN ELECTRONICALLY SEALED AND DATED.

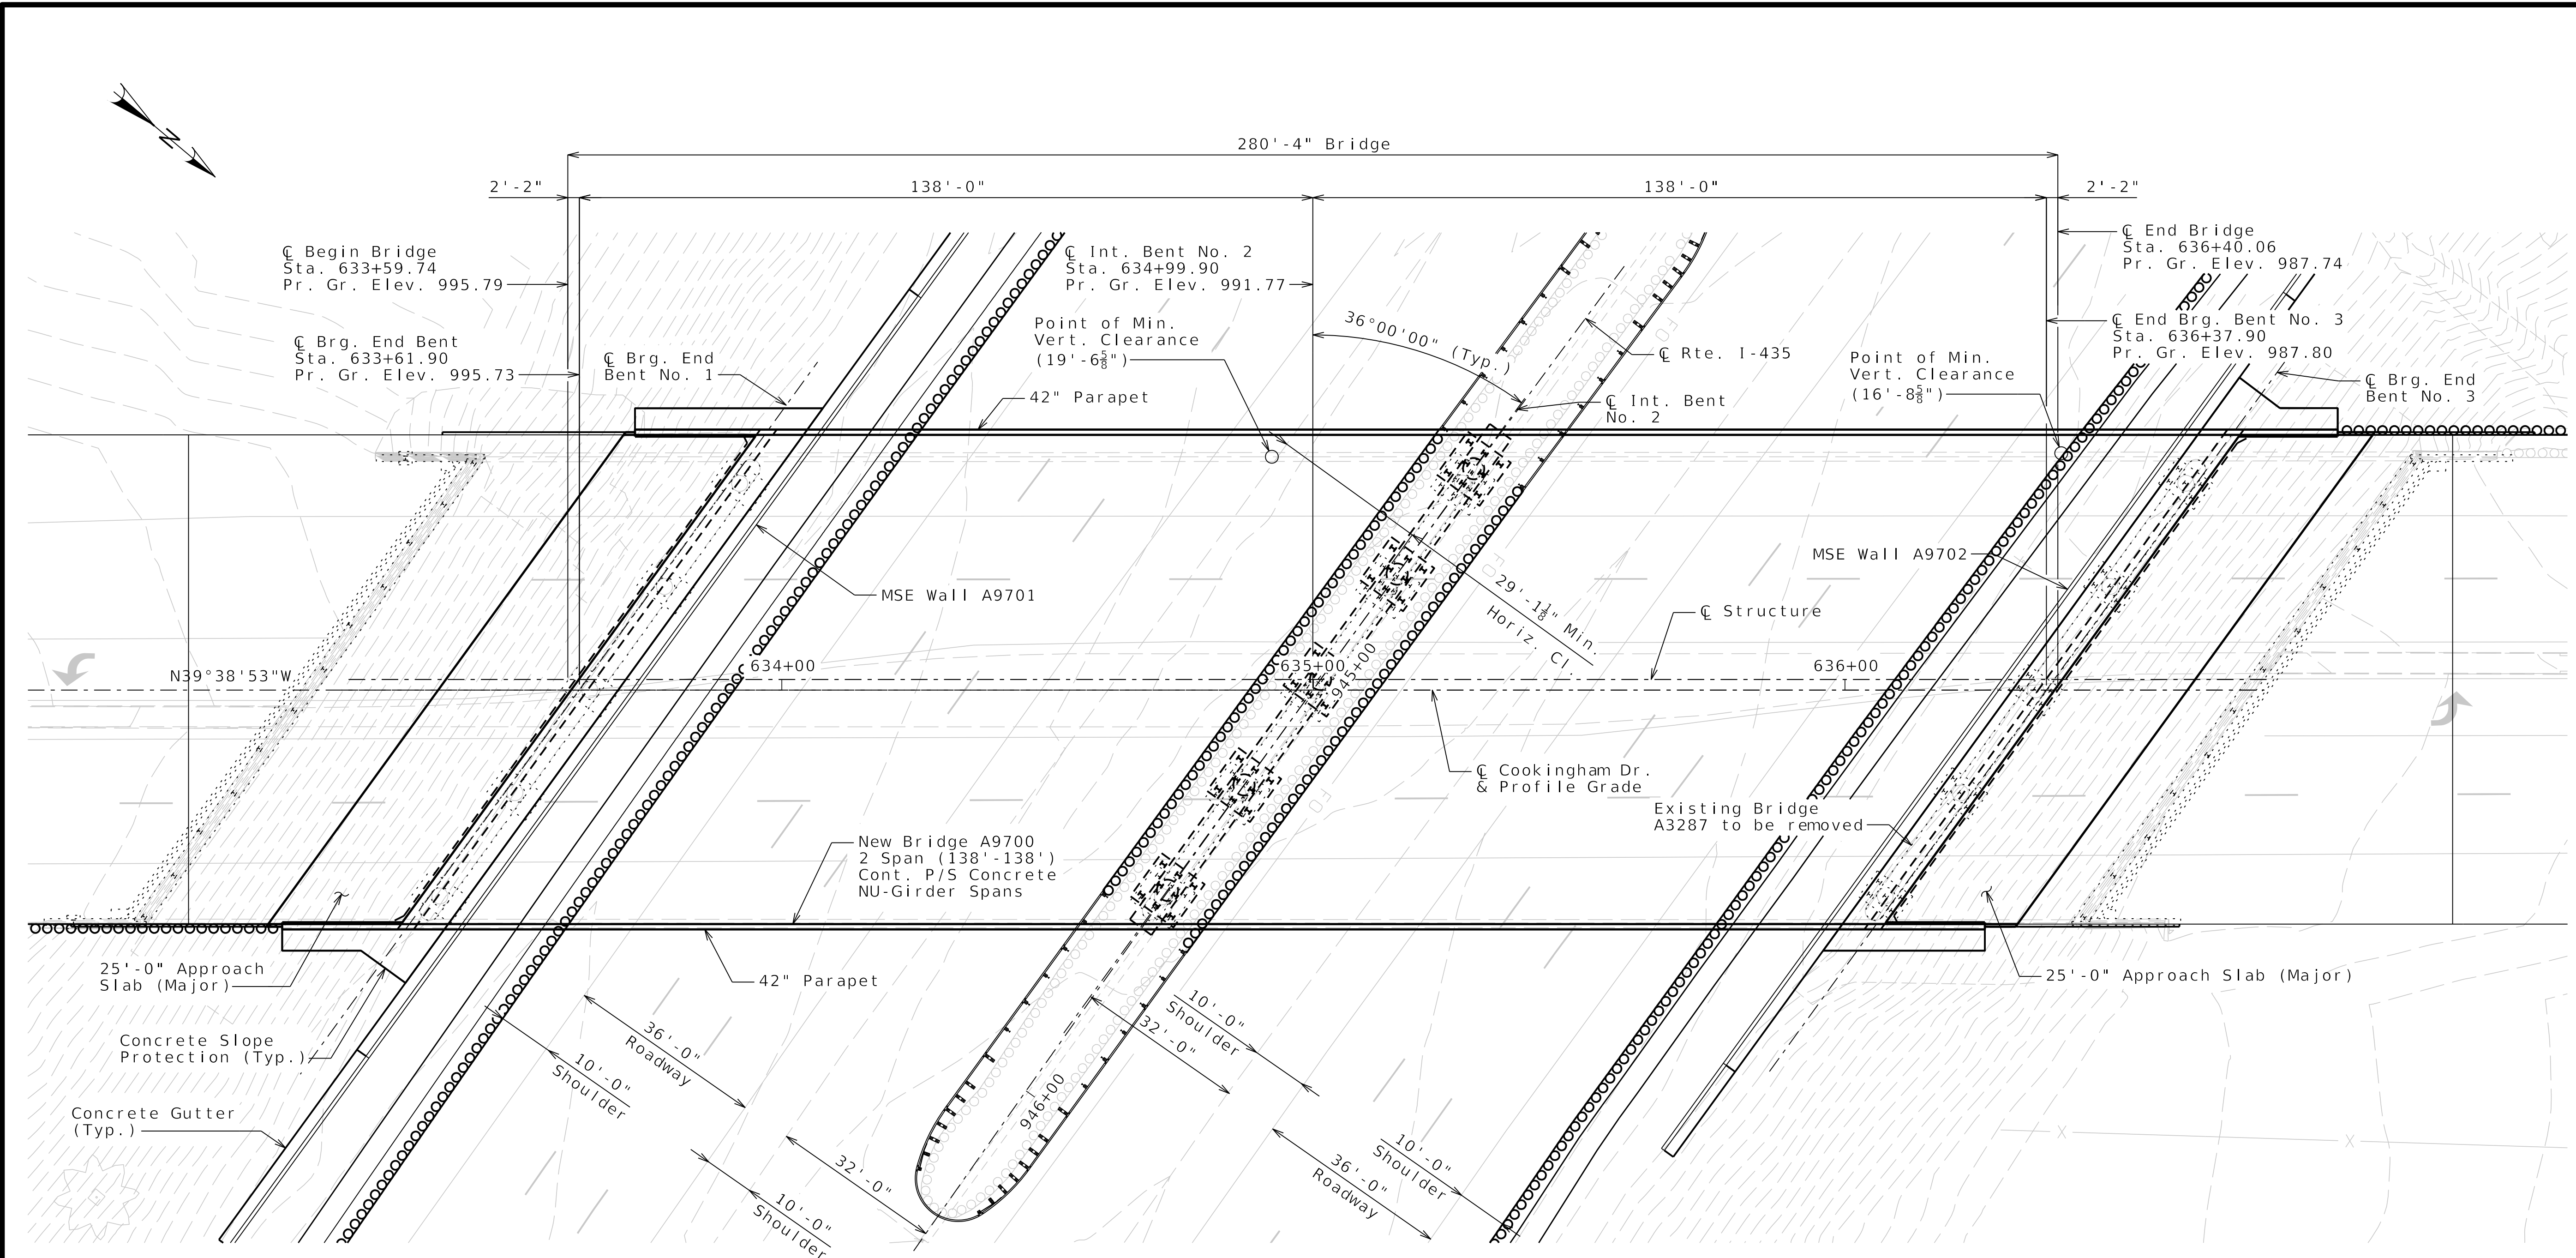

PLAN


PRELIMINARY
PLANS NOT
FOR
CONSTRUCTION

DATE PREPARED 4/28/2025	
ROUTE COOKINGHAM DRIVE	STATE MO
DISTRICT BR	SHEET NO. 1
COUNTY PLATTE	
JOB NO. J4S3489	
CONTRACT ID.	


PROJECT NO.
BRIDGE NO. A9700

DATE	DESCRIPTION

MISSOURI HIGHWAYS AND TRANSPORTATION
COMMISSION

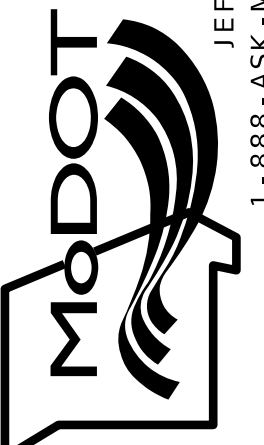


105 WEST CAPITOL
JEFFERSON CITY, MO 65102
1-888-ASK-MODOT (1-888-275-6636)

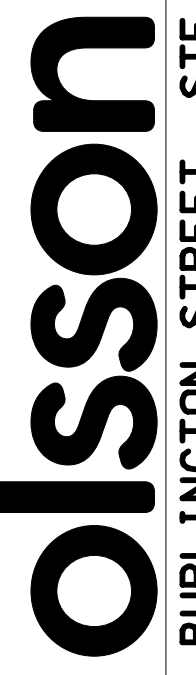


1301 BURLINGTON STREET, STE. 100
NORTH KANSAS CITY, MO 64116
PHONE: 816.361.1177
CERTIFICATE OF AUTHORITY NO. 001592


IF A SEAL IS PRESENT ON THIS SHEET IT HAS BEEN ELECTRONICALLY SEALED AND DATED.

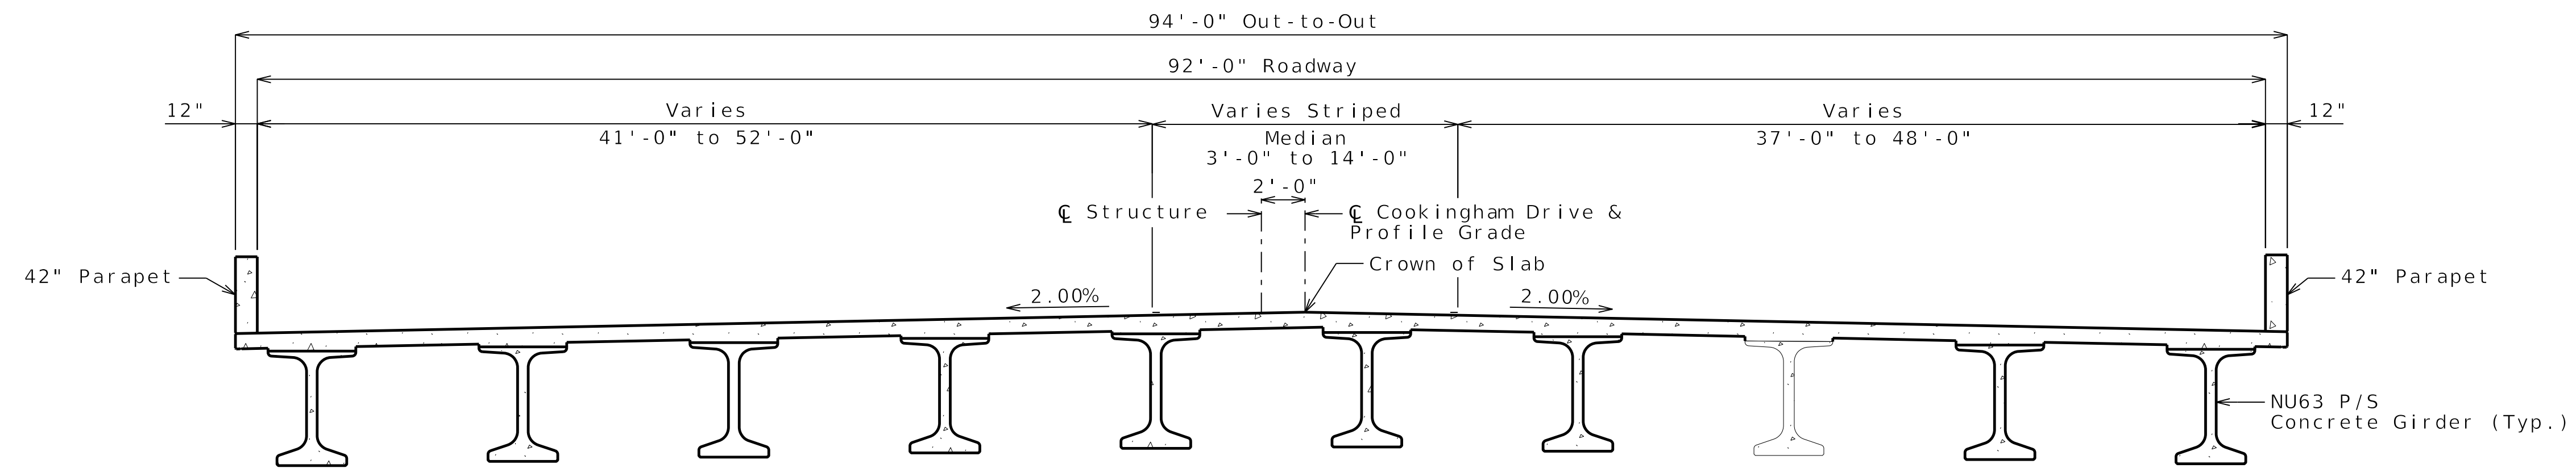


PROPOSED TYPICAL SECTION

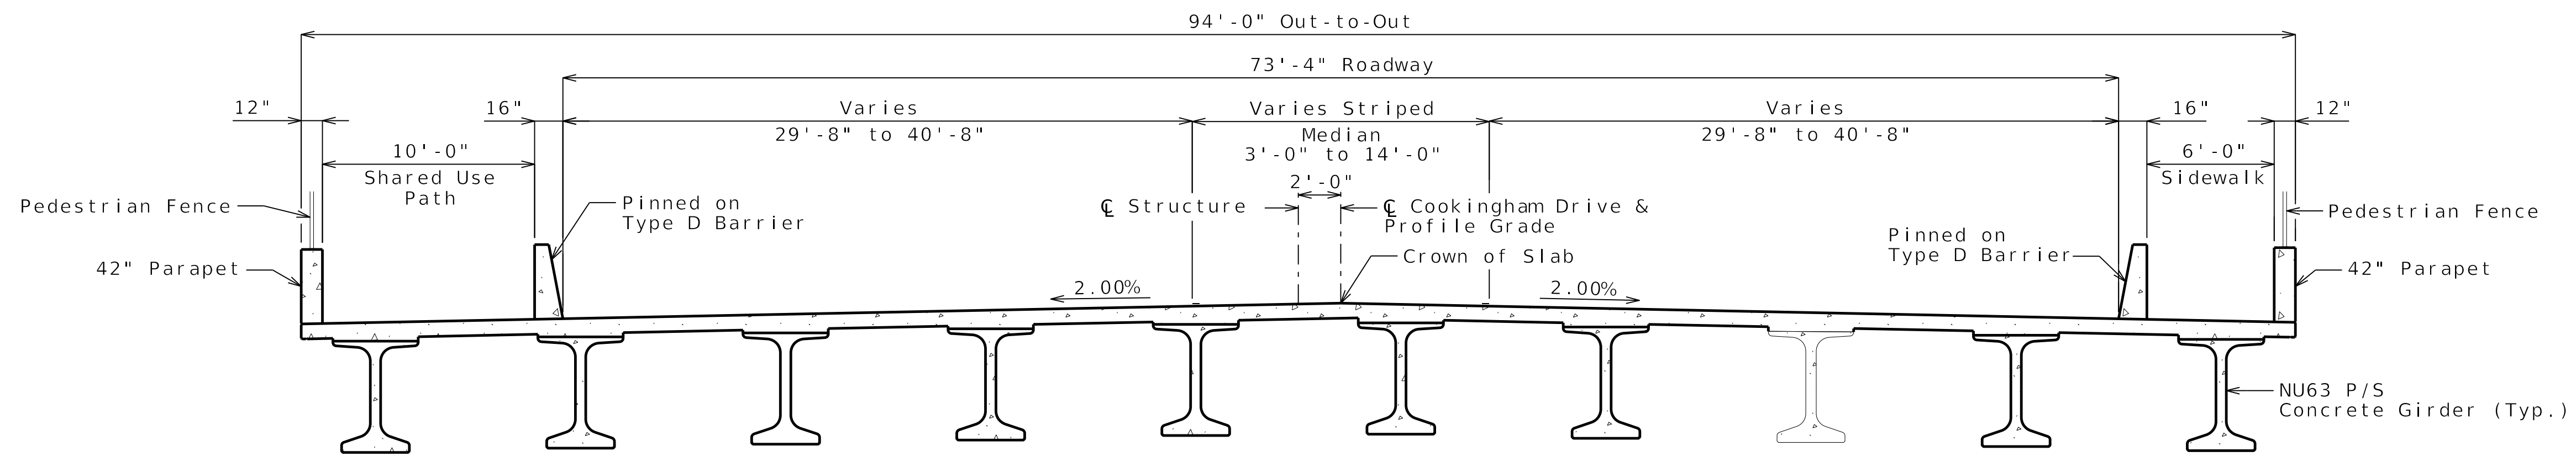

FUTURE TYPICAL SECTION

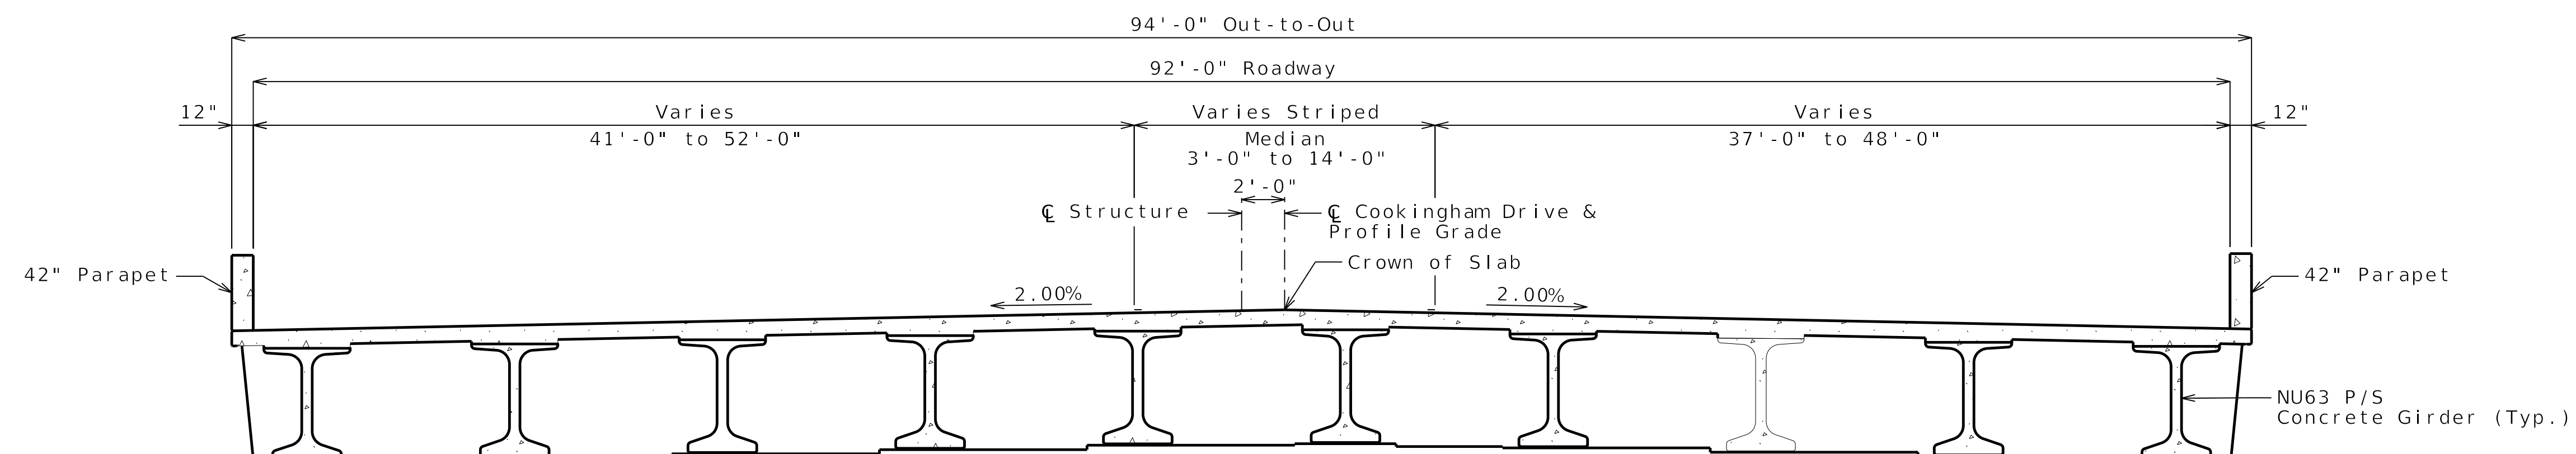

PROPOSED TYPICAL SECTION AT INTERMEDIATE BENT

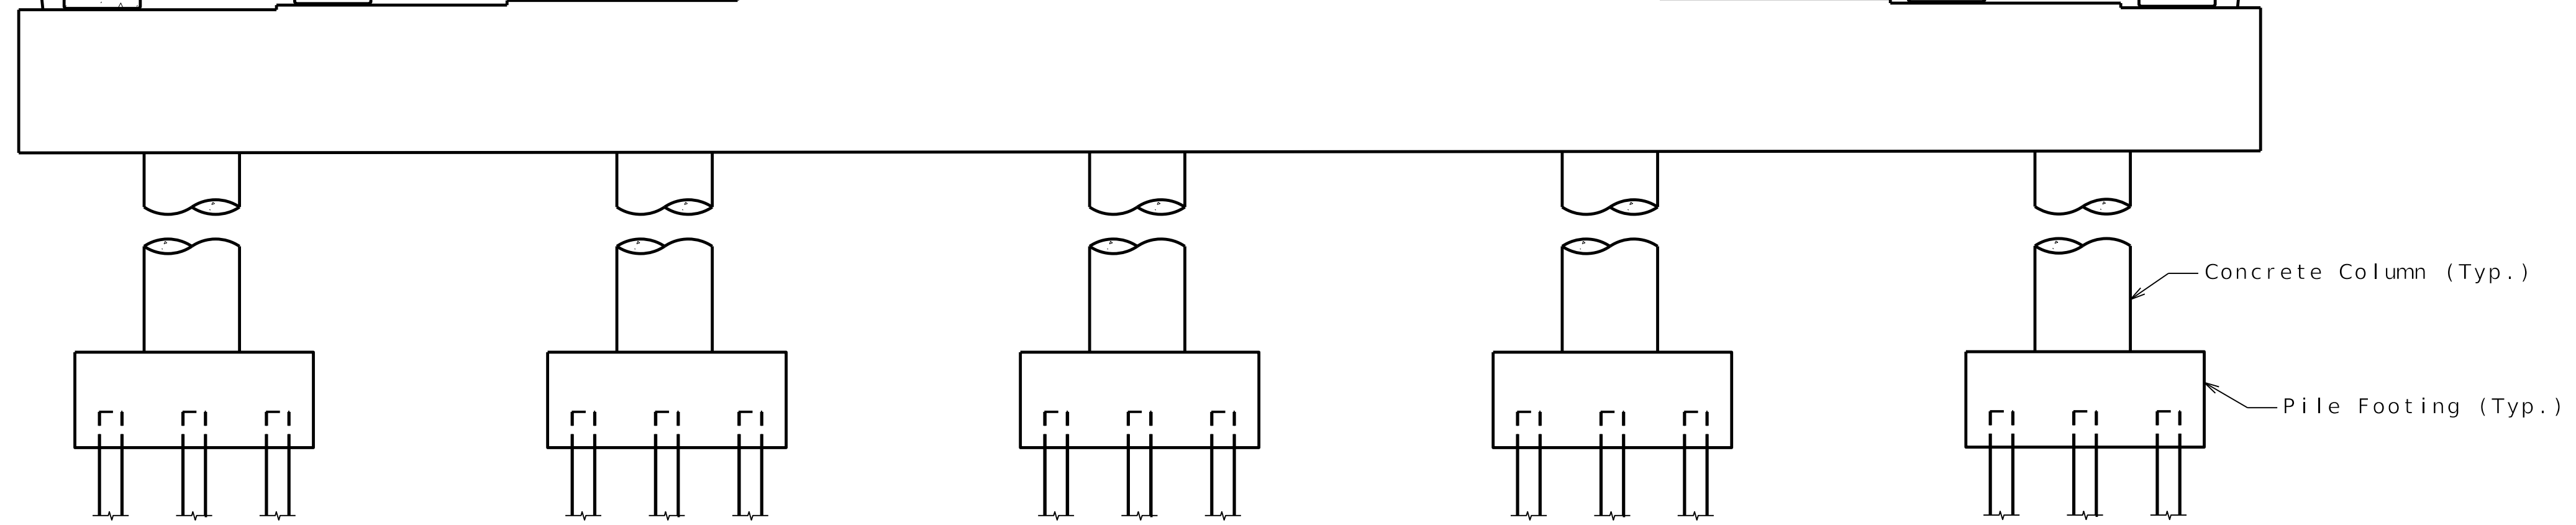

PRELIMINARY
PLANS NOT
FOR
CONSTRUCTION

DATE PREPARED
4/28/2025

ROUTE STATE
COOKINGHAM MO
DRIVE
DISTRICT SHEET NO.
BR 3

COUNTY
PLATTE
JOB NO.
J4S3489
CONTRACT ID.

PROJECT NO.

BRIDGE NO.
A9700

DATE	DESCRIPTION

MISSOURI HIGHWAYS AND TRANSPORTATION
COMMISSION

105 WEST CAPITOL
JEFFERSON CITY, MO 65102
1-888-ASK-MODOT (1-888-275-6636)

1301 BURLINGTON STREET, STE. 100
NORTH KANSAS CITY, MO 64116
PHONE: 816.361.1177
CERTIFICATE OF AUTHORITY NO. 001592

IF A SEAL IS PRESENT ON THIS SHEET IT HAS BEEN ELECTRONICALLY SEALED AND DATED.


273' MECHANICALLY STABILIZED EARTH (MSE) RETAINING WALL SYSTEM

PRELIMINARY
PLANS NOT
FOR
CONSTRUCTION


DATE PREPARED 4/28/2025	
ROUTE I-435	STATE MO
DISTRICT BR	SHEET NO. 1
COUNTY PLATTE	
JOB NO. J4S3489	
CONTRACT ID.	
PROJECT NO.	
BRIDGE NO. A9701	

DATE	DESCRIPTION


MISSOURI HIGHWAYS AND TRANSPORTATION
COMMISSION

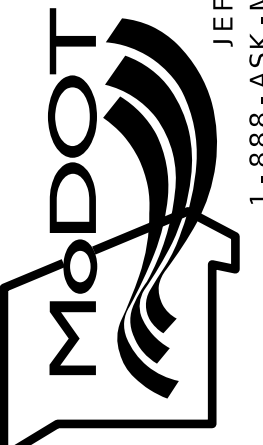


105 WEST CAPITOL
JEFFERSON CITY, MO 65102
1-888-ASK-MODOT (1-888-275-6636)

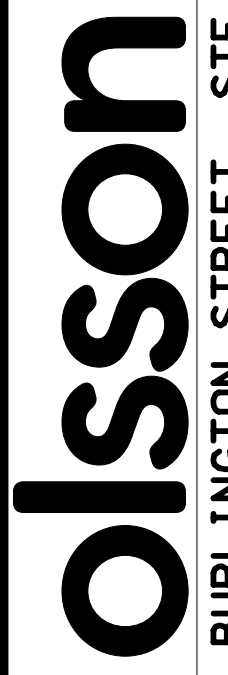

1301 BURLINGTON STREET, STE. 100
NORTH KANSAS CITY, MO 64116
PHONE: 816.361.1177
CERTIFICATE OF AUTHORITY NO. 001592

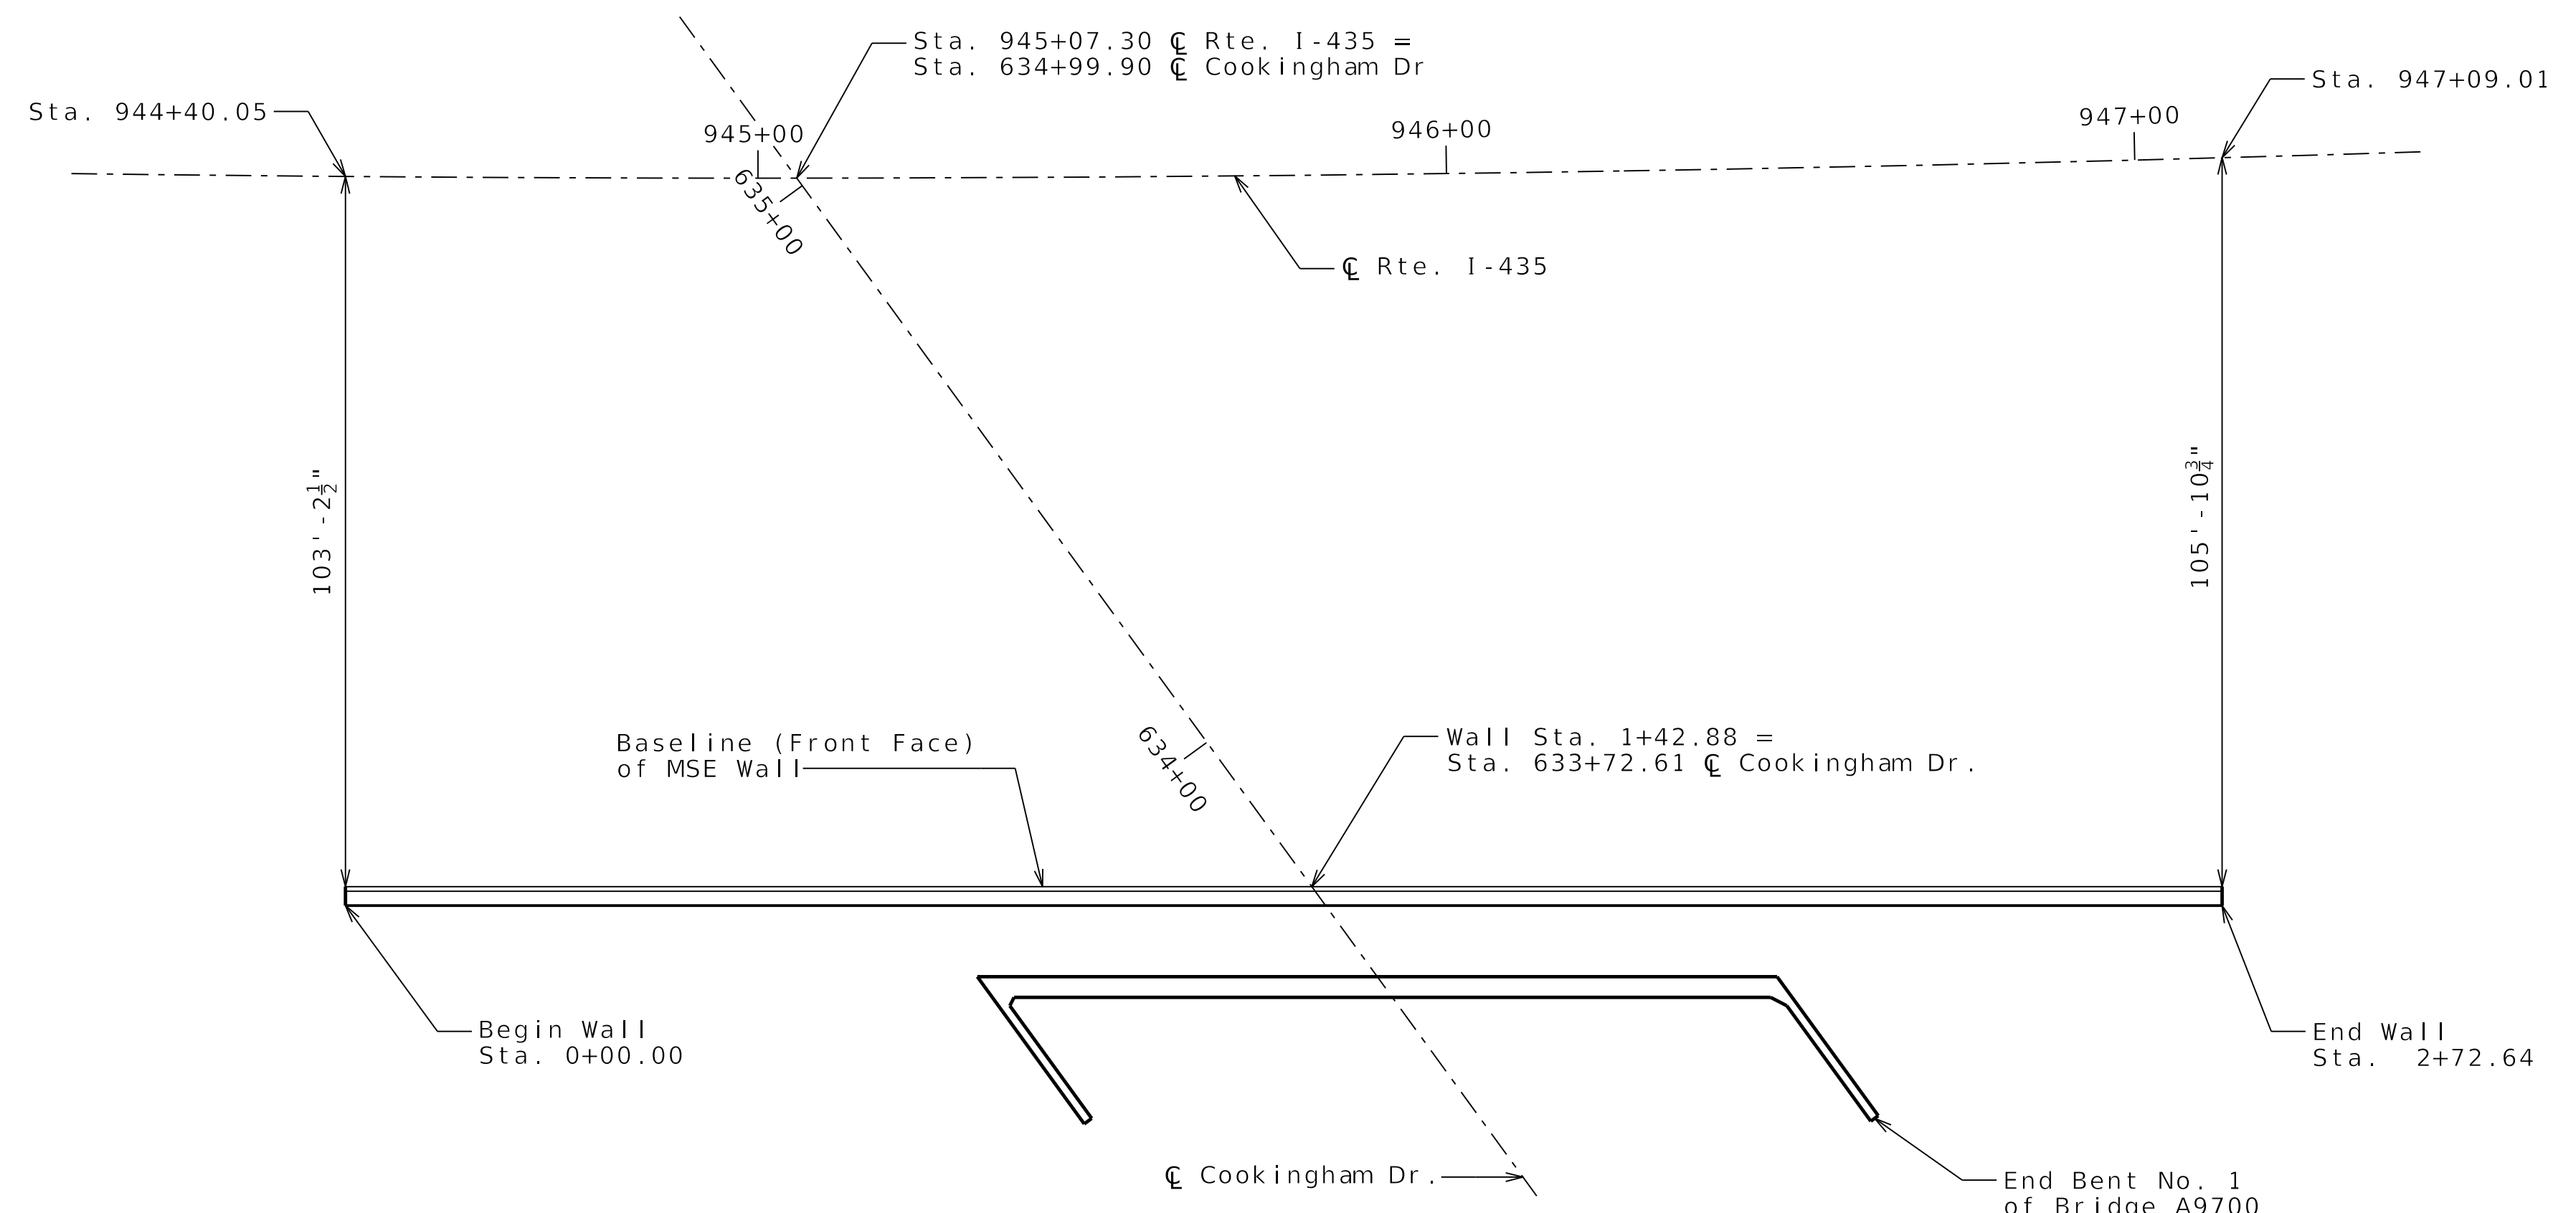


PLAN
Concrete Leveling pad and Coping not shown for clarity.

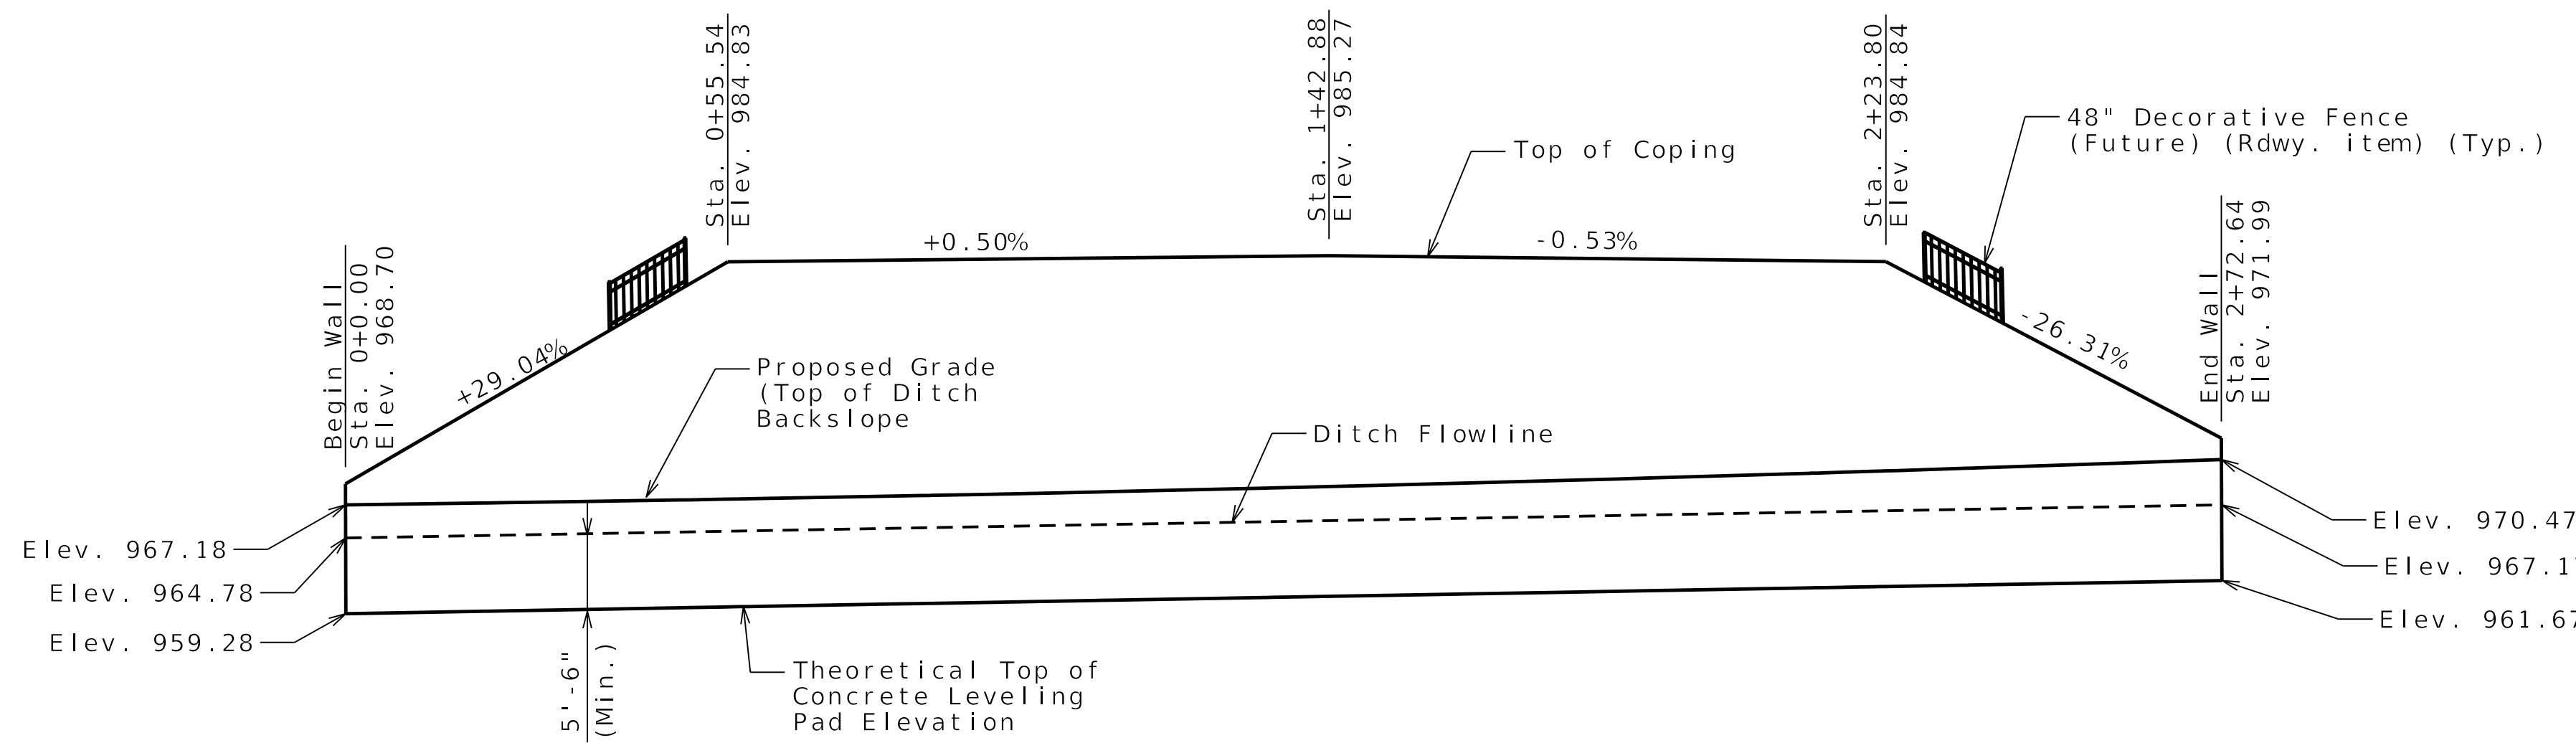


DEVELOPED ELEVATION
Concrete Leveling pad and Coping not shown for clarity.

RETAINING WALL ALONG RIGHT SIDE OF ROUTE I-435
COOKINGHAM DRIVE FROM ROUTE 169 TO ROUTE I-435
ABOUT 1.1 MILES WEST OF ROUTE 169
TIE STATION 633+72.61

IF A SEAL IS PRESENT ON THIS SHEET IT HAS BEEN ELECTRONICALLY SEALED AND DATED.

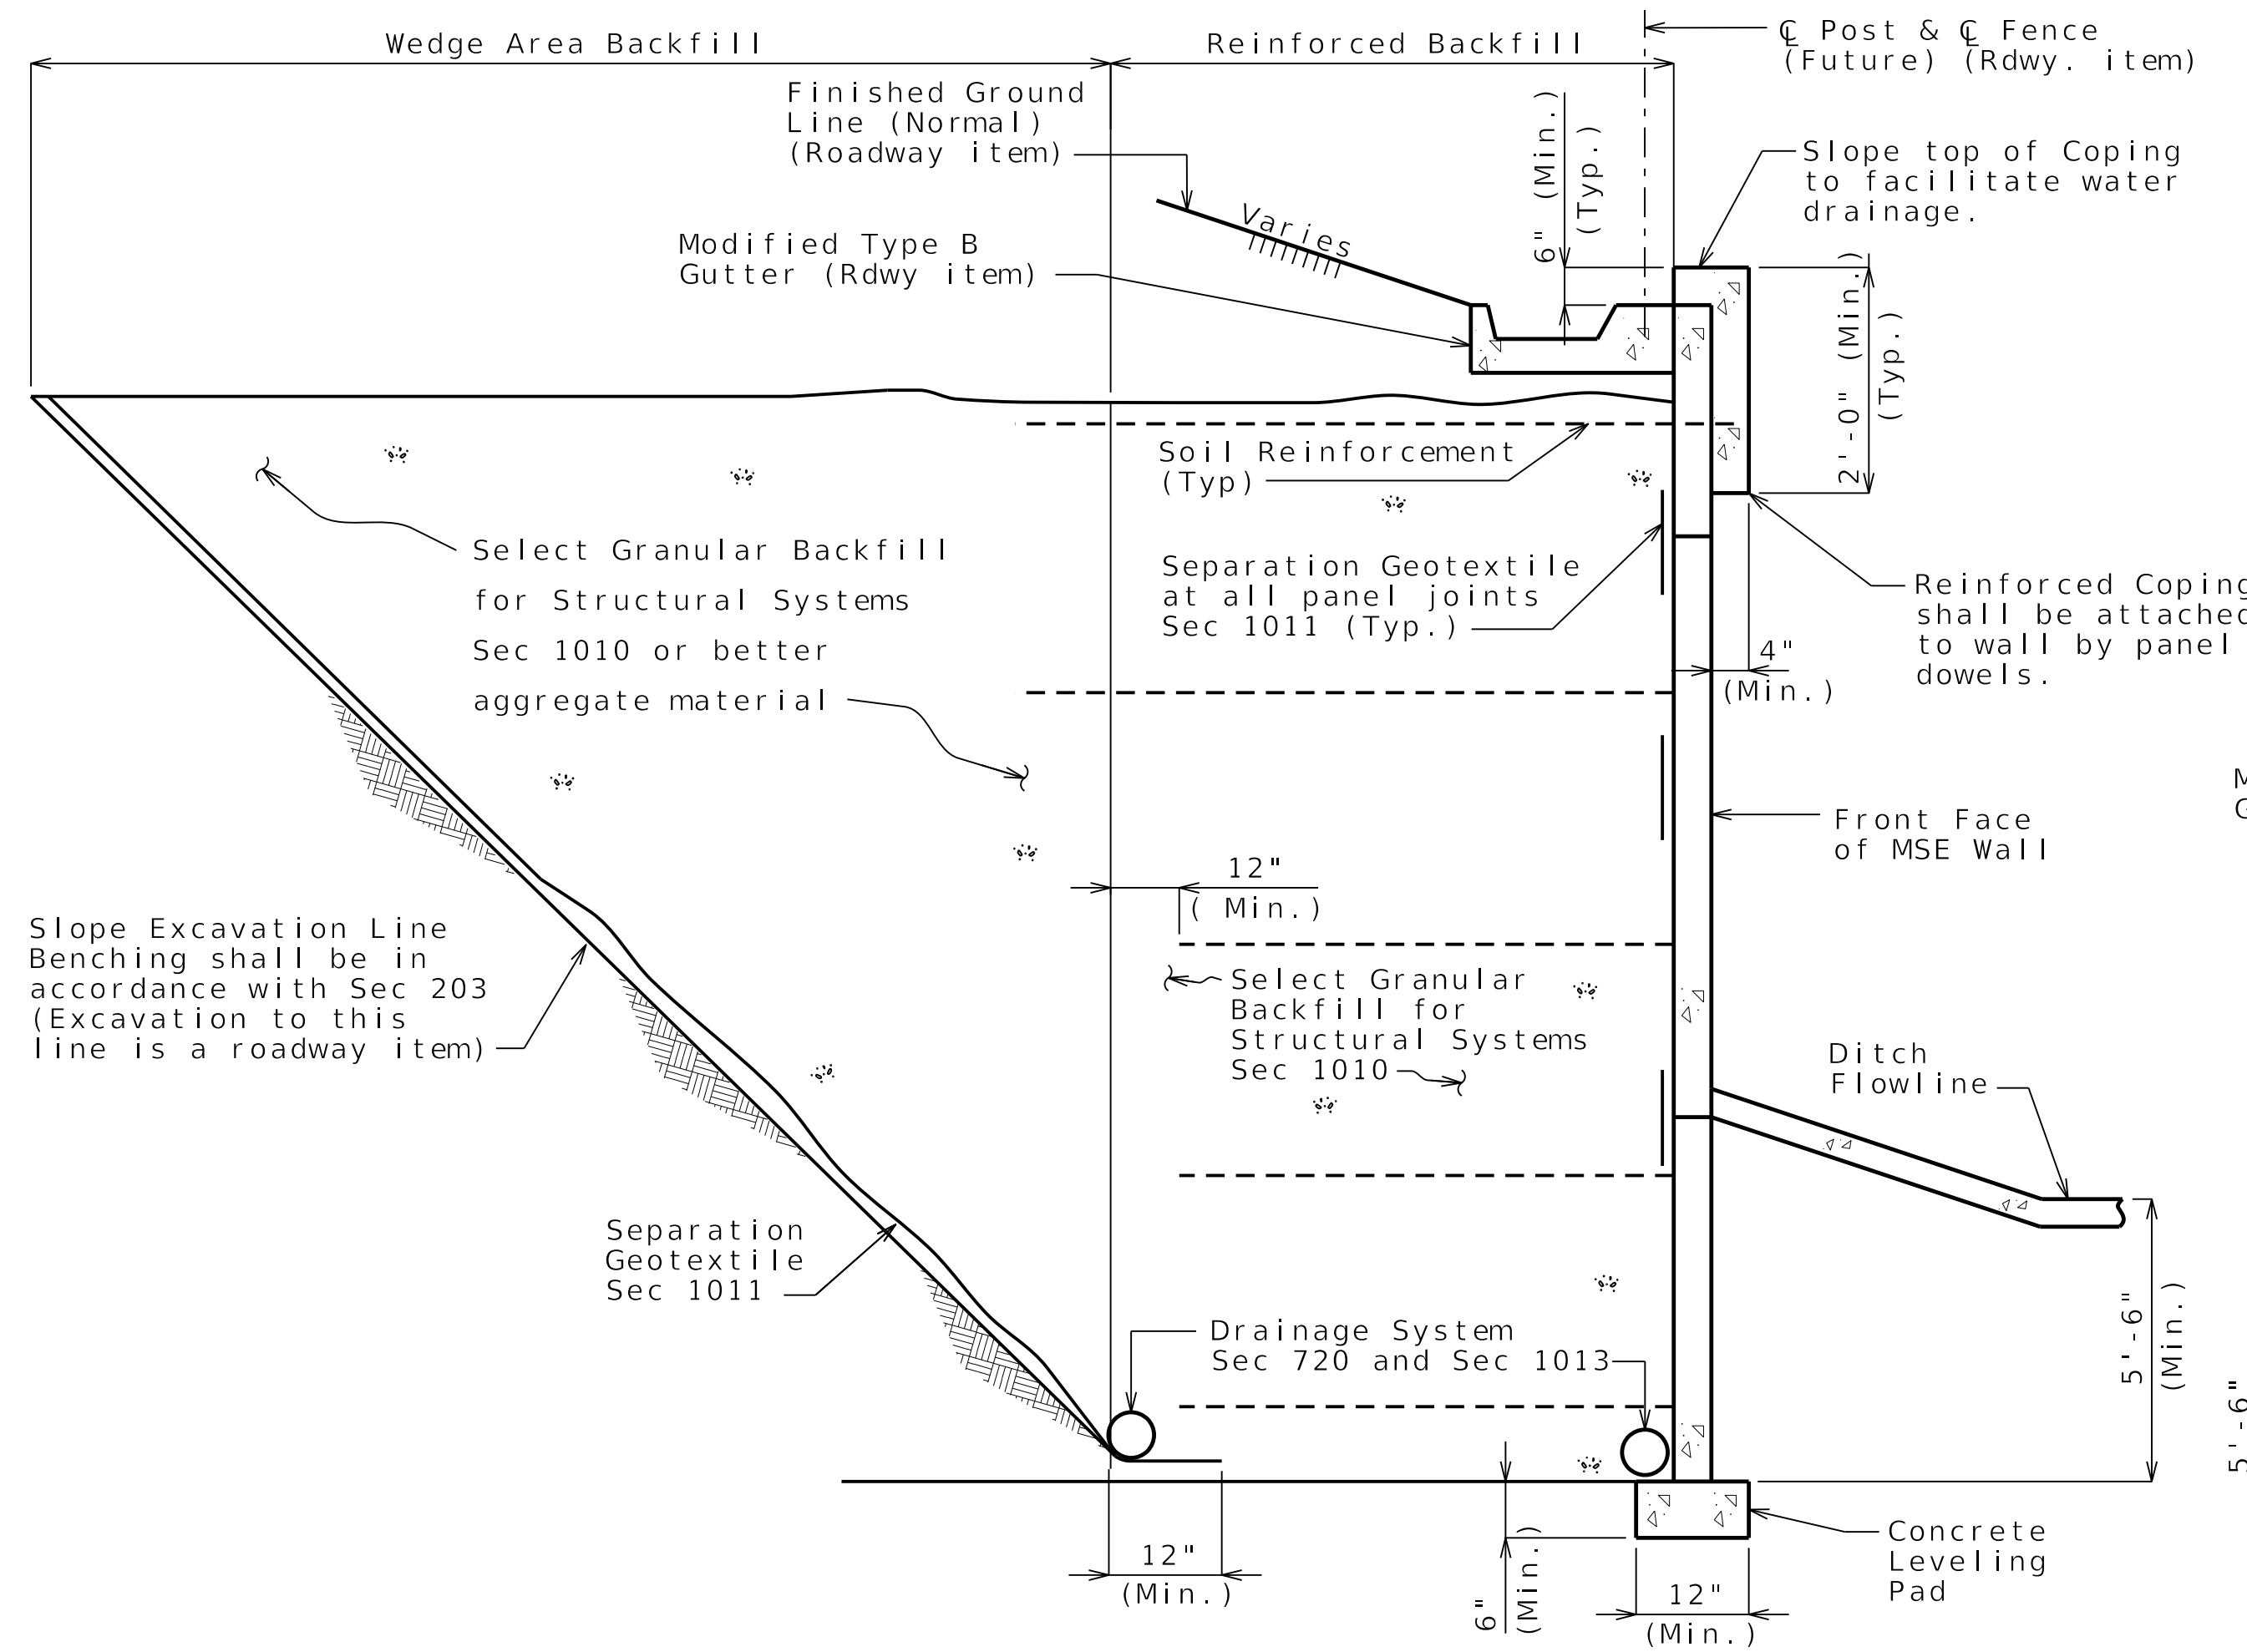


TYPICAL SECTION THRU PRECAST MODULAR PANEL WALL (GENERAL)

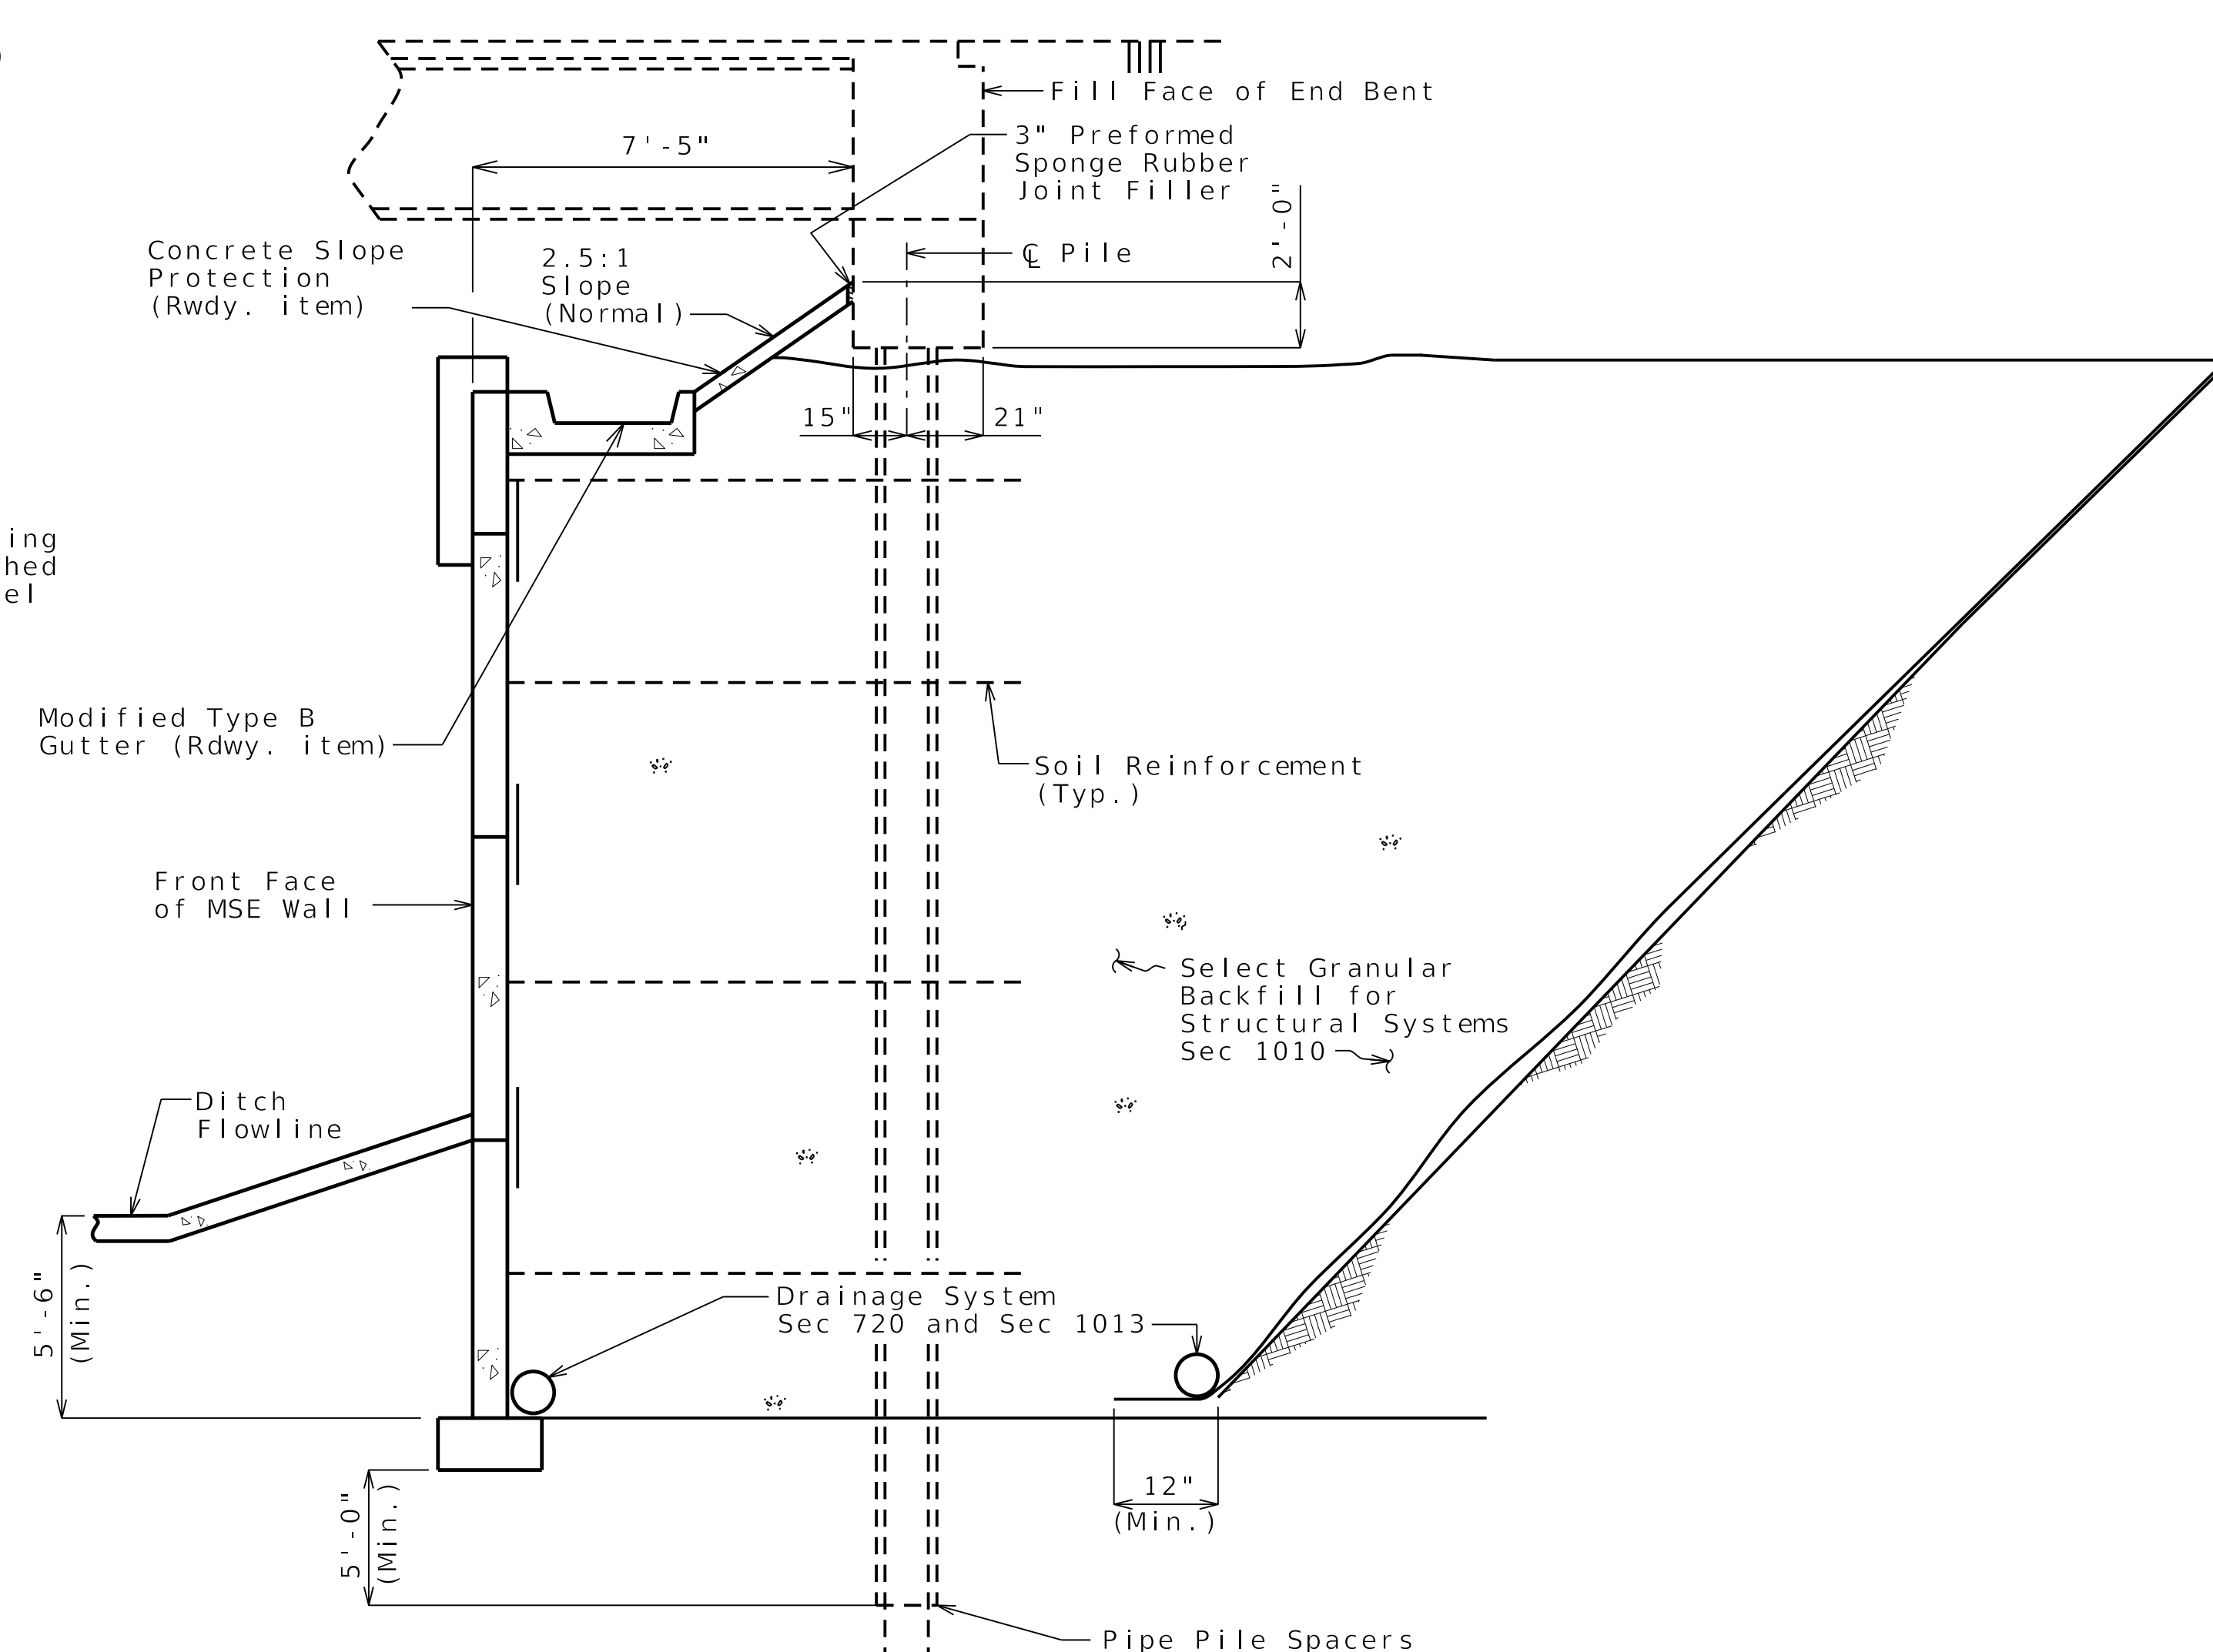

TYPICAL SECTION THRU PRECAST MODULAR PANEL WALL UNDER BRIDGE

Note: For additional information, see Typical Section Thru Precast Modular Panel Wall (General).

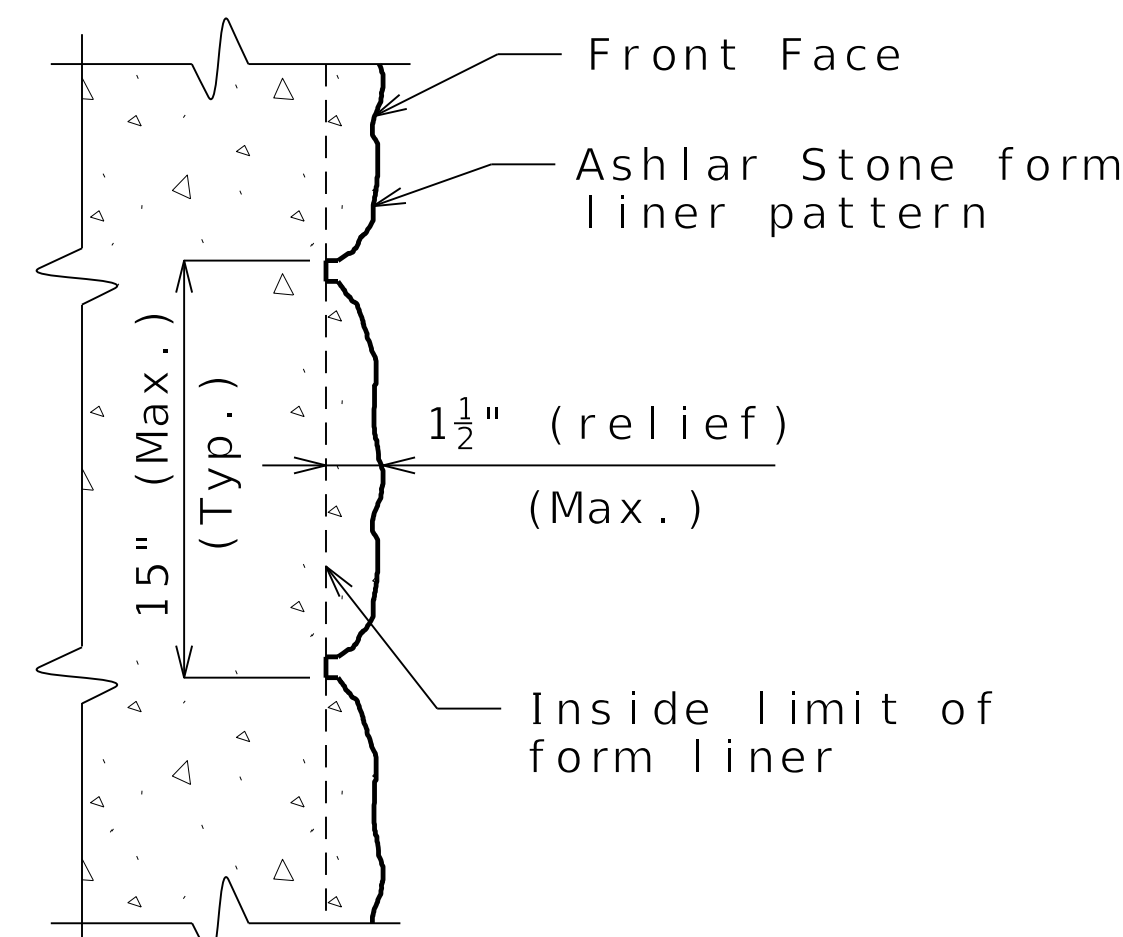

FORM LINER DETAIL (PRECAST MODULAR PANEL WALL)


DETAILS FOR GENERIC MSE WALL

PRELIMINARY
PLANS NOT
FOR
CONSTRUCTION

DATE PREPARED
4/28/2025
ROUTE I-435 STATE MO
DISTRICT BR SHEET NO. 2
COUNTY PLATTE
JOB NO. J4S3489
CONTRACT ID.

PROJECT NO.
BRIDGE NO. A9701


DATE	DESCRIPTION

MISSOURI HIGHWAYS AND TRANSPORTATION COMMISSION

 105 WEST CAPITOL
 JEFFERSON CITY, MO 65102
 1-888-ASK-MODOT (1-888-275-6636)

olsson
 1301 BURLINGTON STREET, STE. 100
 NORTH KANSAS CITY, MO 64116
 PHONE: 816.361.1177
 CERTIFICATE OF AUTHORITY NO. 001592


IF A SEAL IS PRESENT ON THIS SHEET IT HAS BEEN ELECTRONICALLY SEALED AND DATED.

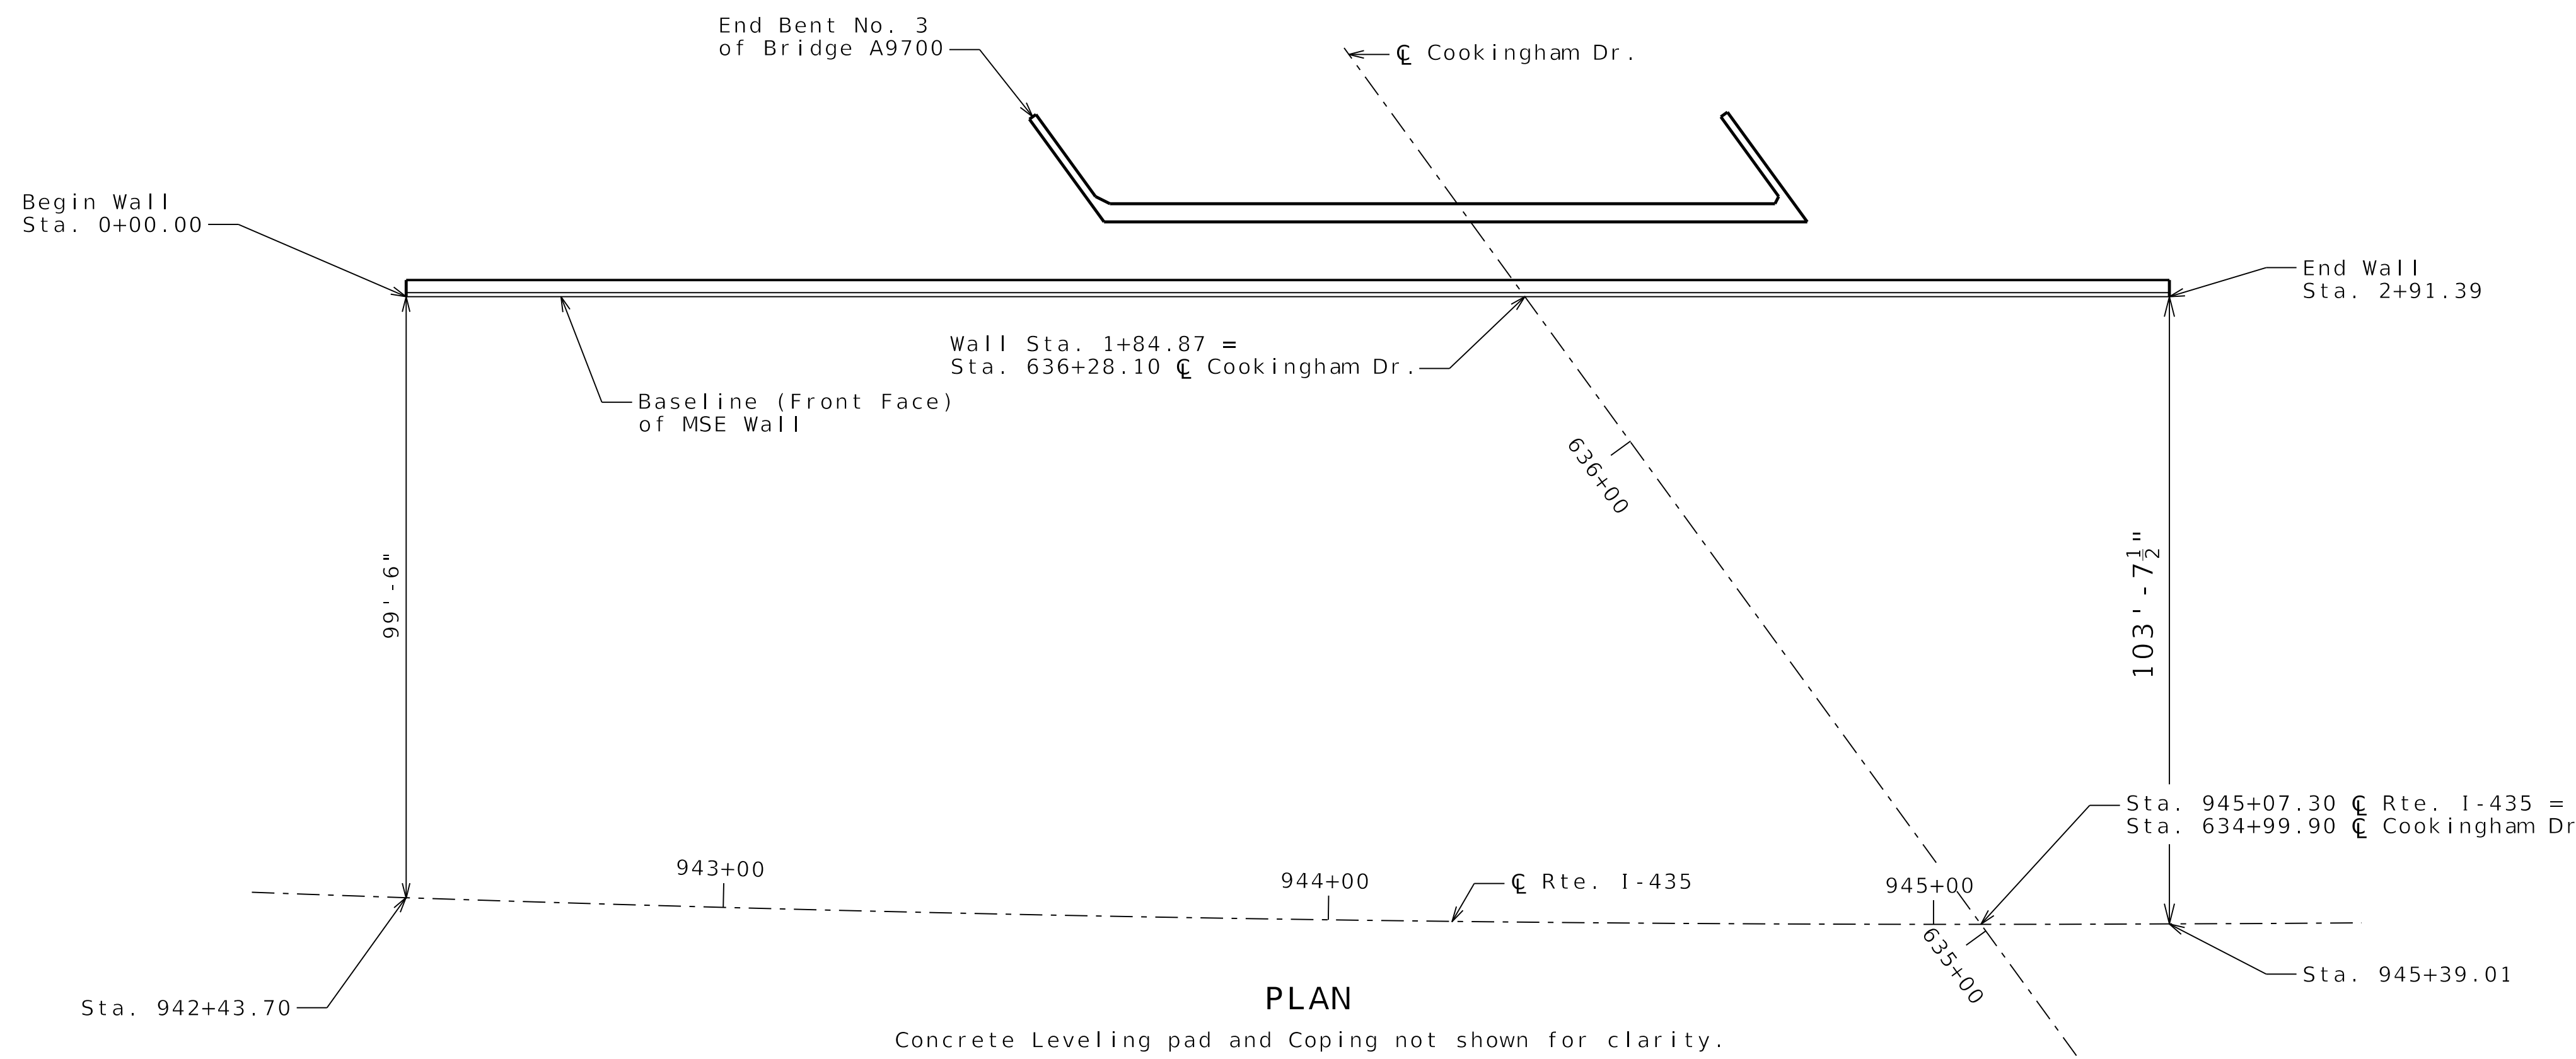291' MECHANICALLY STABILIZED EARTH (MSE) RETAINING WALL SYSTEM



PLAN

Concrete Leveling pad and Coping not shown for clarity.

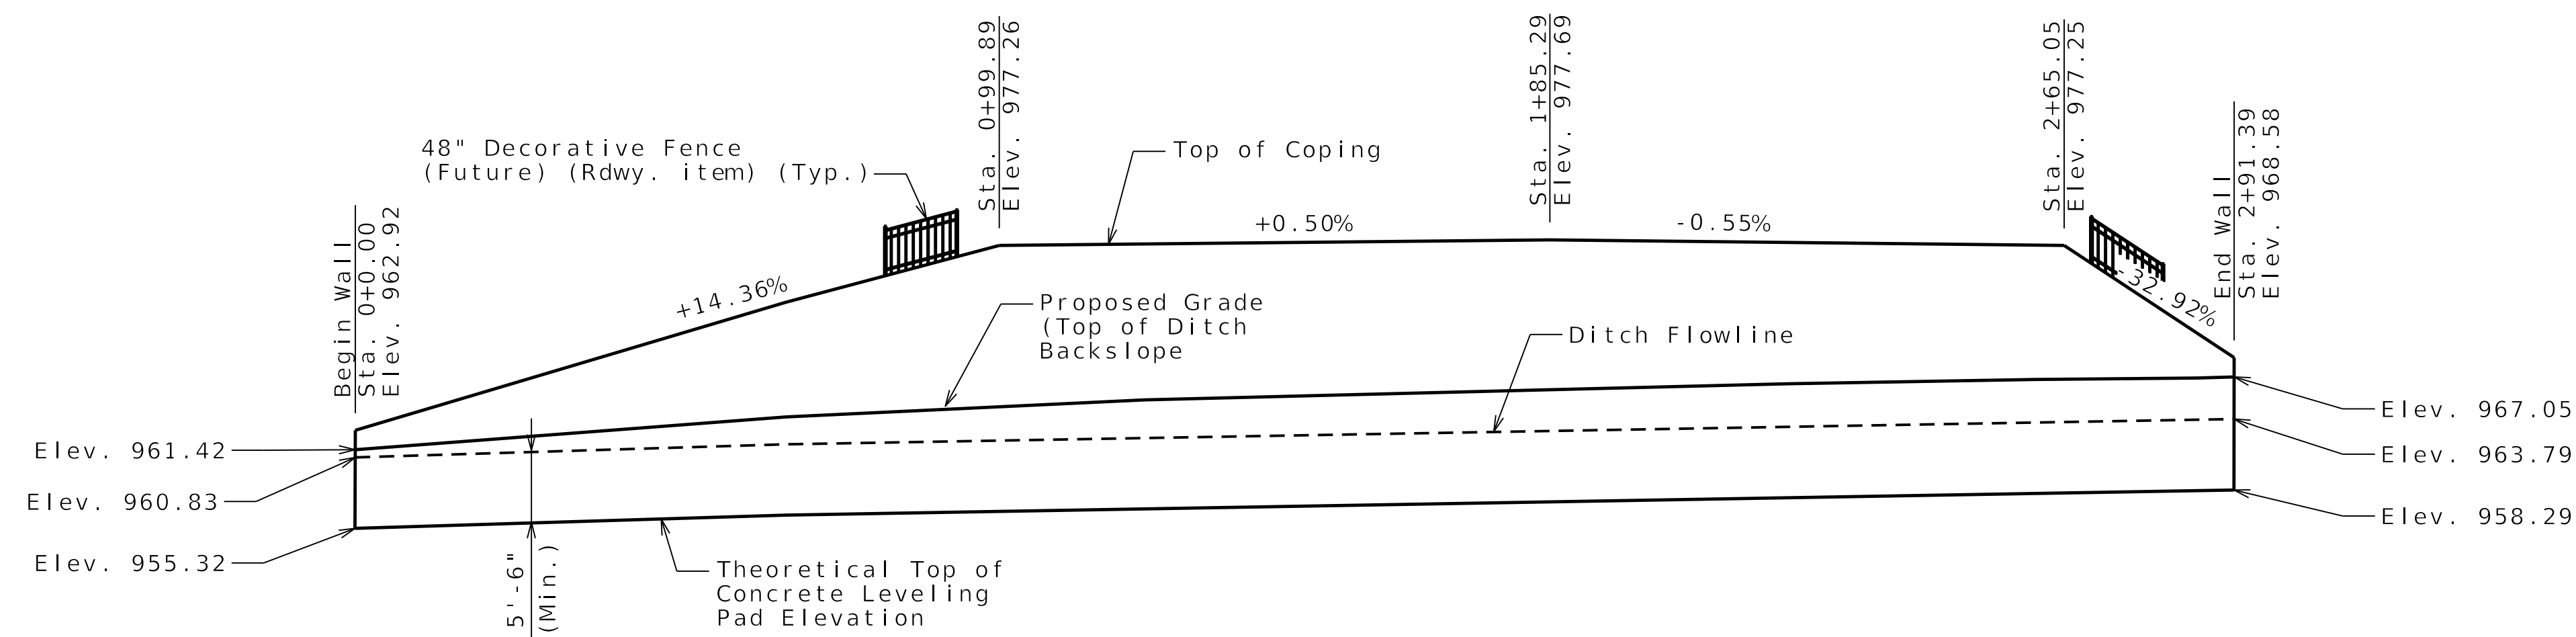

DEVELOPED ELEVATION

Concrete Leveling pad and Coping not shown for clarity.

RETAINING WALL ALONG LEFT SIDE OF ROUTE I-435

COOKINGHAM DRIVE FROM ROUTE 169 TO ROUTE I-435
 ABOUT 1.1 MILES WEST OF ROUTE 169
 TIE STATION 636+28.10


PRELIMINARY
 PLANS NOT
 FOR
 CONSTRUCTION

DATE PREPARED 4/28/2025	
ROUTE I-435	STATE MO
DISTRICT BR	SHEET NO. 1
COUNTY PLATTE	
JOB NO. J4S3489	
CONTRACT ID.	

PROJECT NO.
BRIDGE NO. A9702

DATE	DESCRIPTION




MISSOURI HIGHWAYS AND TRANSPORTATION
 COMMISSION

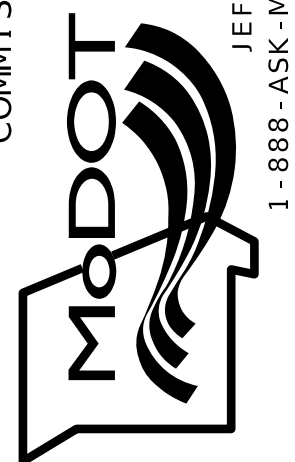

105 WEST CAPITOL
 JEFFERSON CITY, MO 65102
 1-888-ASK-MODOT (1-888-275-6636)

Olsson
 1301 BURLINGTON STREET, STE. 100
 NORTH KANSAS CITY, MO 64116
 PHONE: 816.361.1177
 CERTIFICATE OF AUTHORITY NO. 001592

IF A SEAL IS PRESENT ON THIS SHEET IT HAS BEEN ELECTRONICALLY SEALED AND DATED.

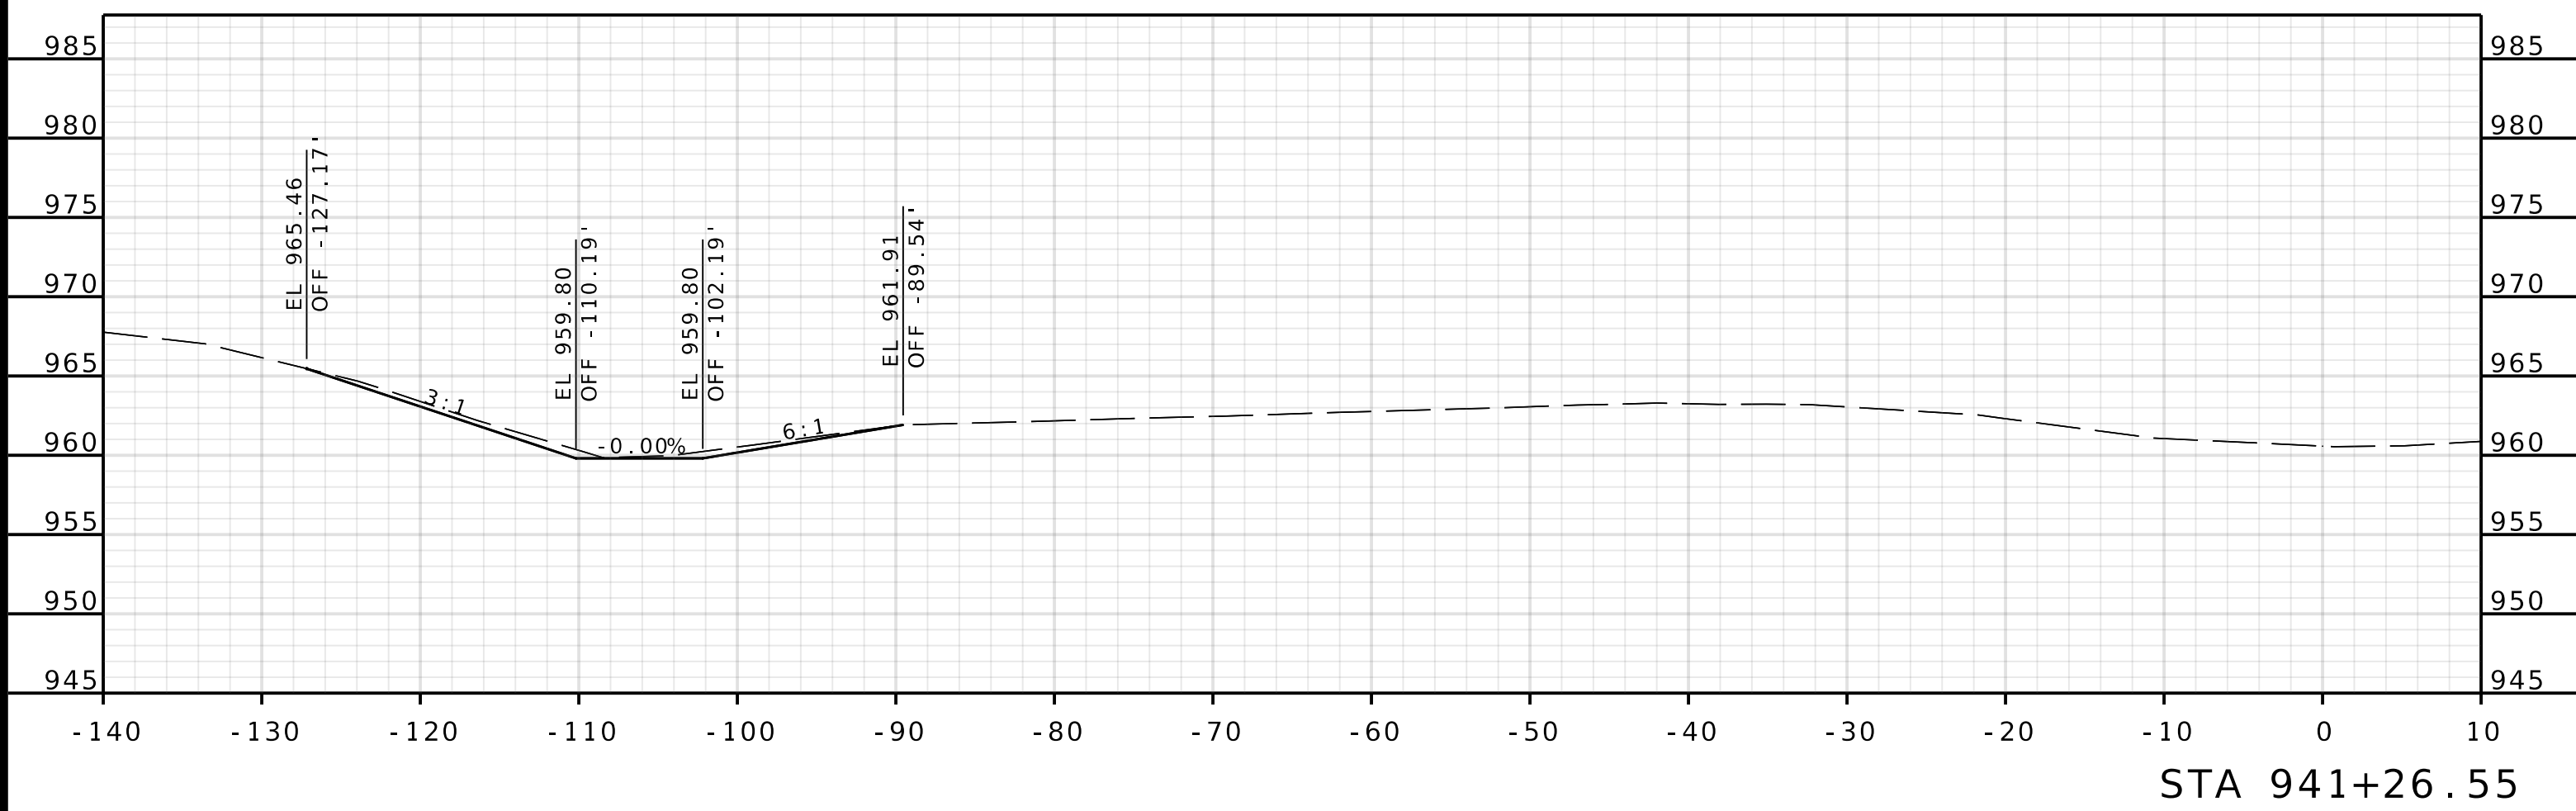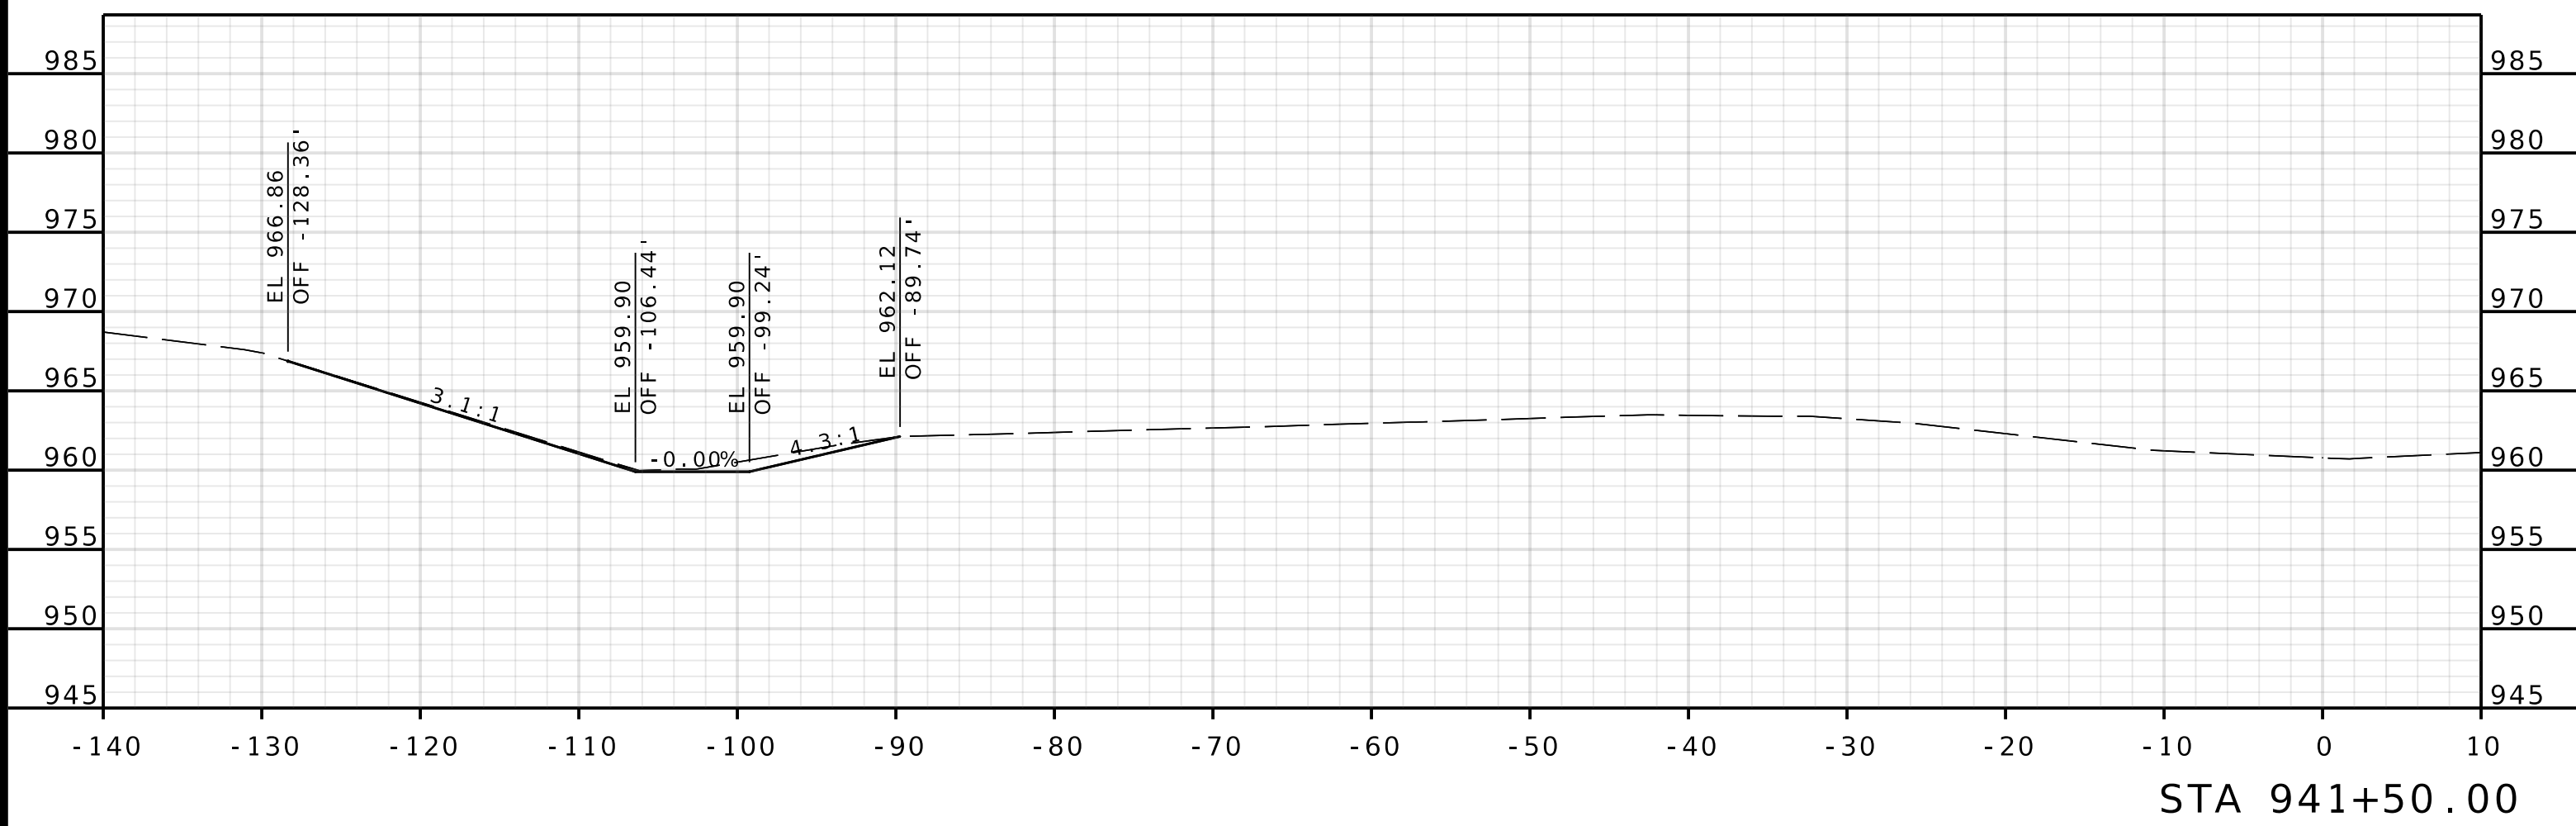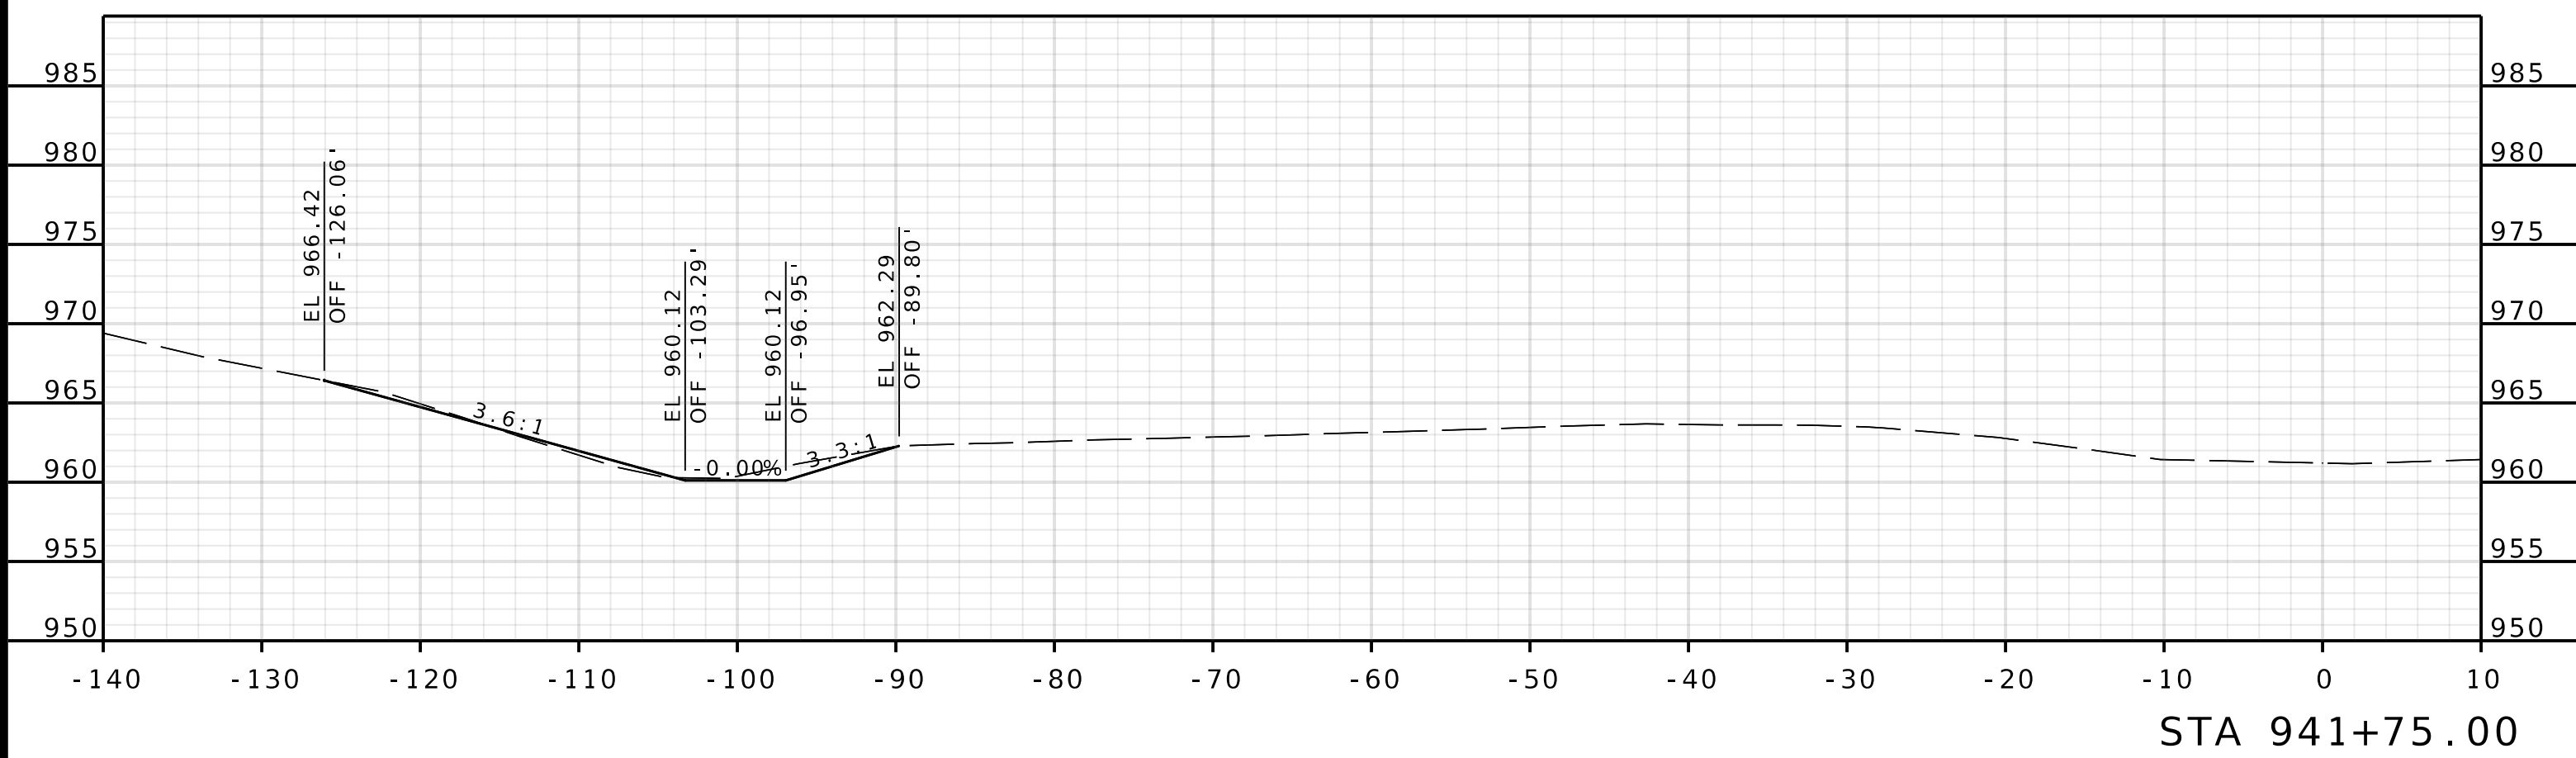


ROUTE I-435
WBL

DATE PREPARED 4/30/2025	
ROUTE 1435	STATE MO
DISTRICT KC	SHEET NO. 1
COUNTY PLATTE	
JOB NO. J4S3489	
CONTRACT ID.	
PROJECT NO.	
BRIDGE NO. A9700	

DATE	DESCRIPTION




MISSOURI HIGHWAYS AND TRANSPORTATION COMMISSION

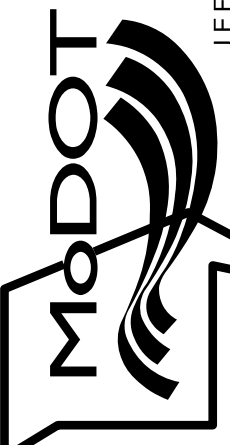

105 WEST CAPITOL
JEFFERSON CITY, MO 65102
1-888-ASK-MODOT (1-888-275-6636)

Olsson
1301 BURLINGTON STREET, STE. 100
NORTH KANSAS CITY, MO 64116
PHONE: 816.361.1177
CERTIFICATE OF AUTHORITY NO. 001592

IF A SEAL IS PRESENT ON THIS SHEET IT HAS BEEN ELECTRONICALLY SEALED AND DATED.

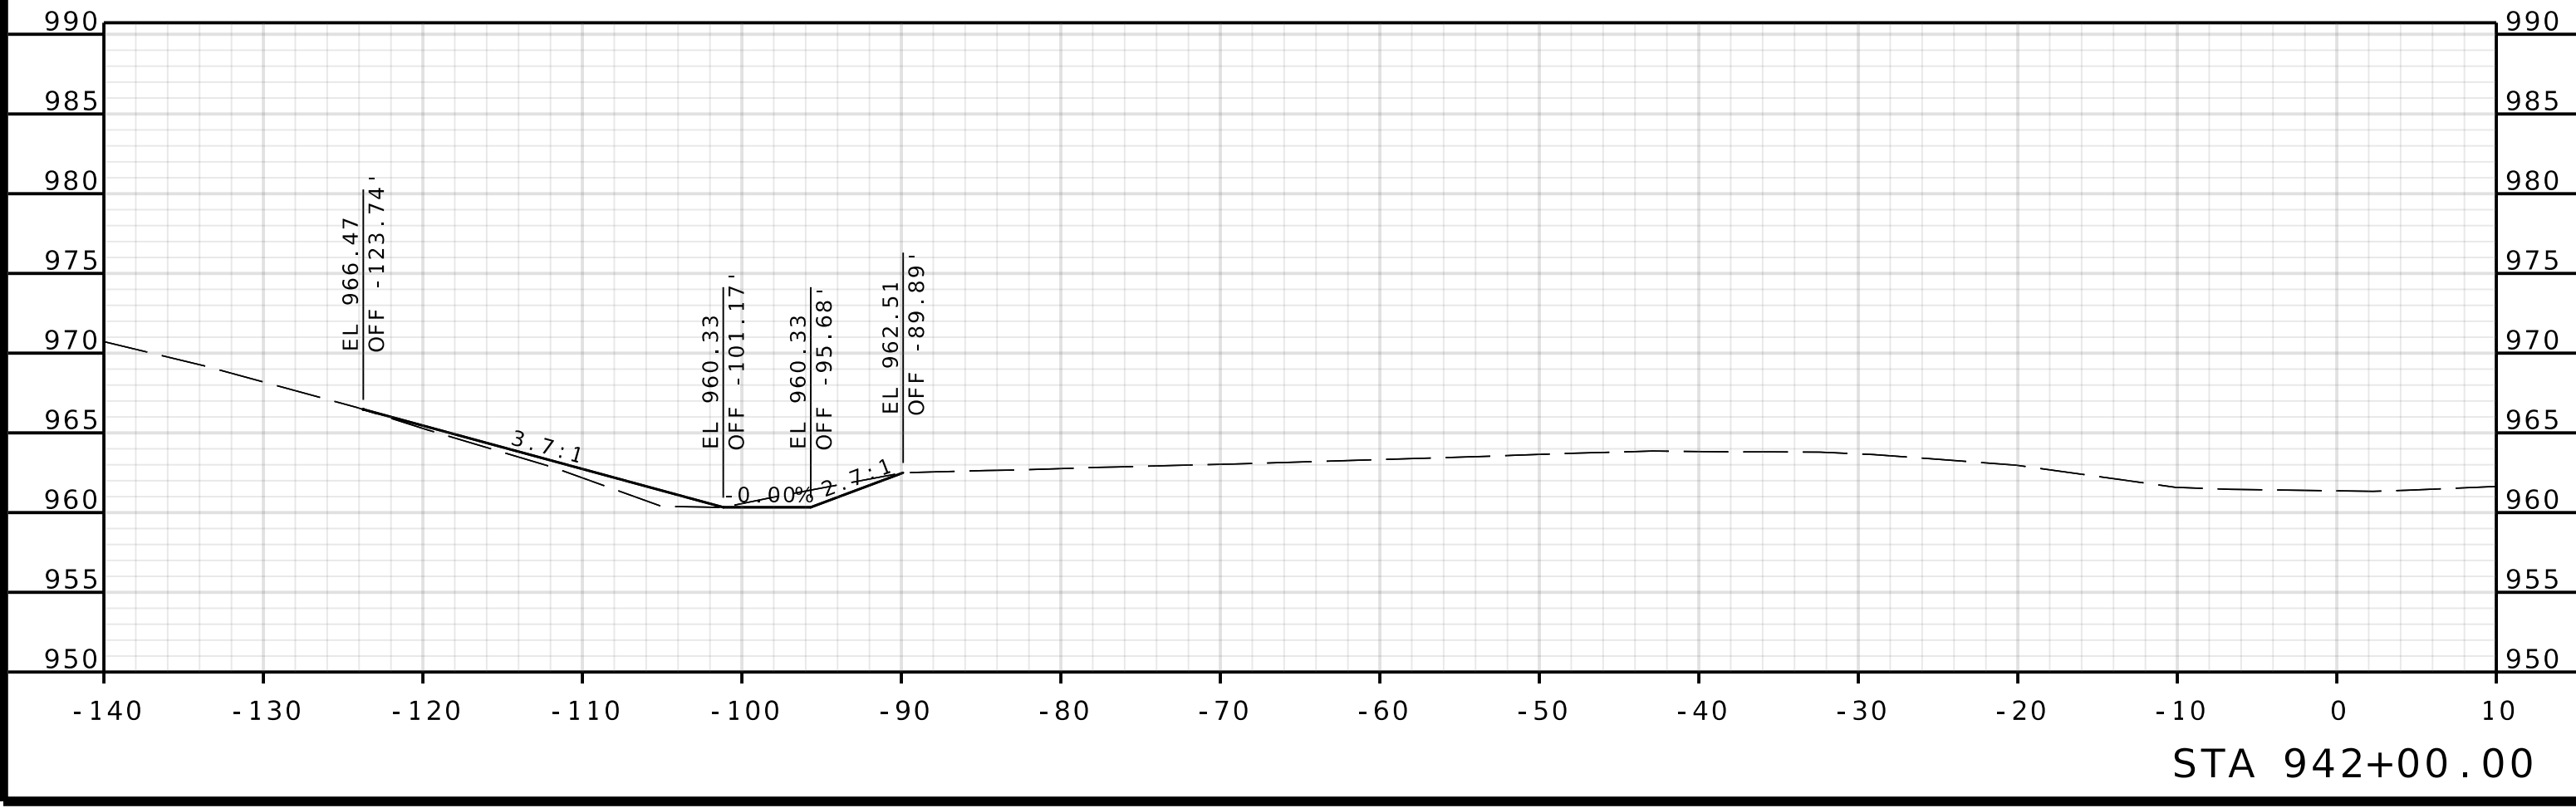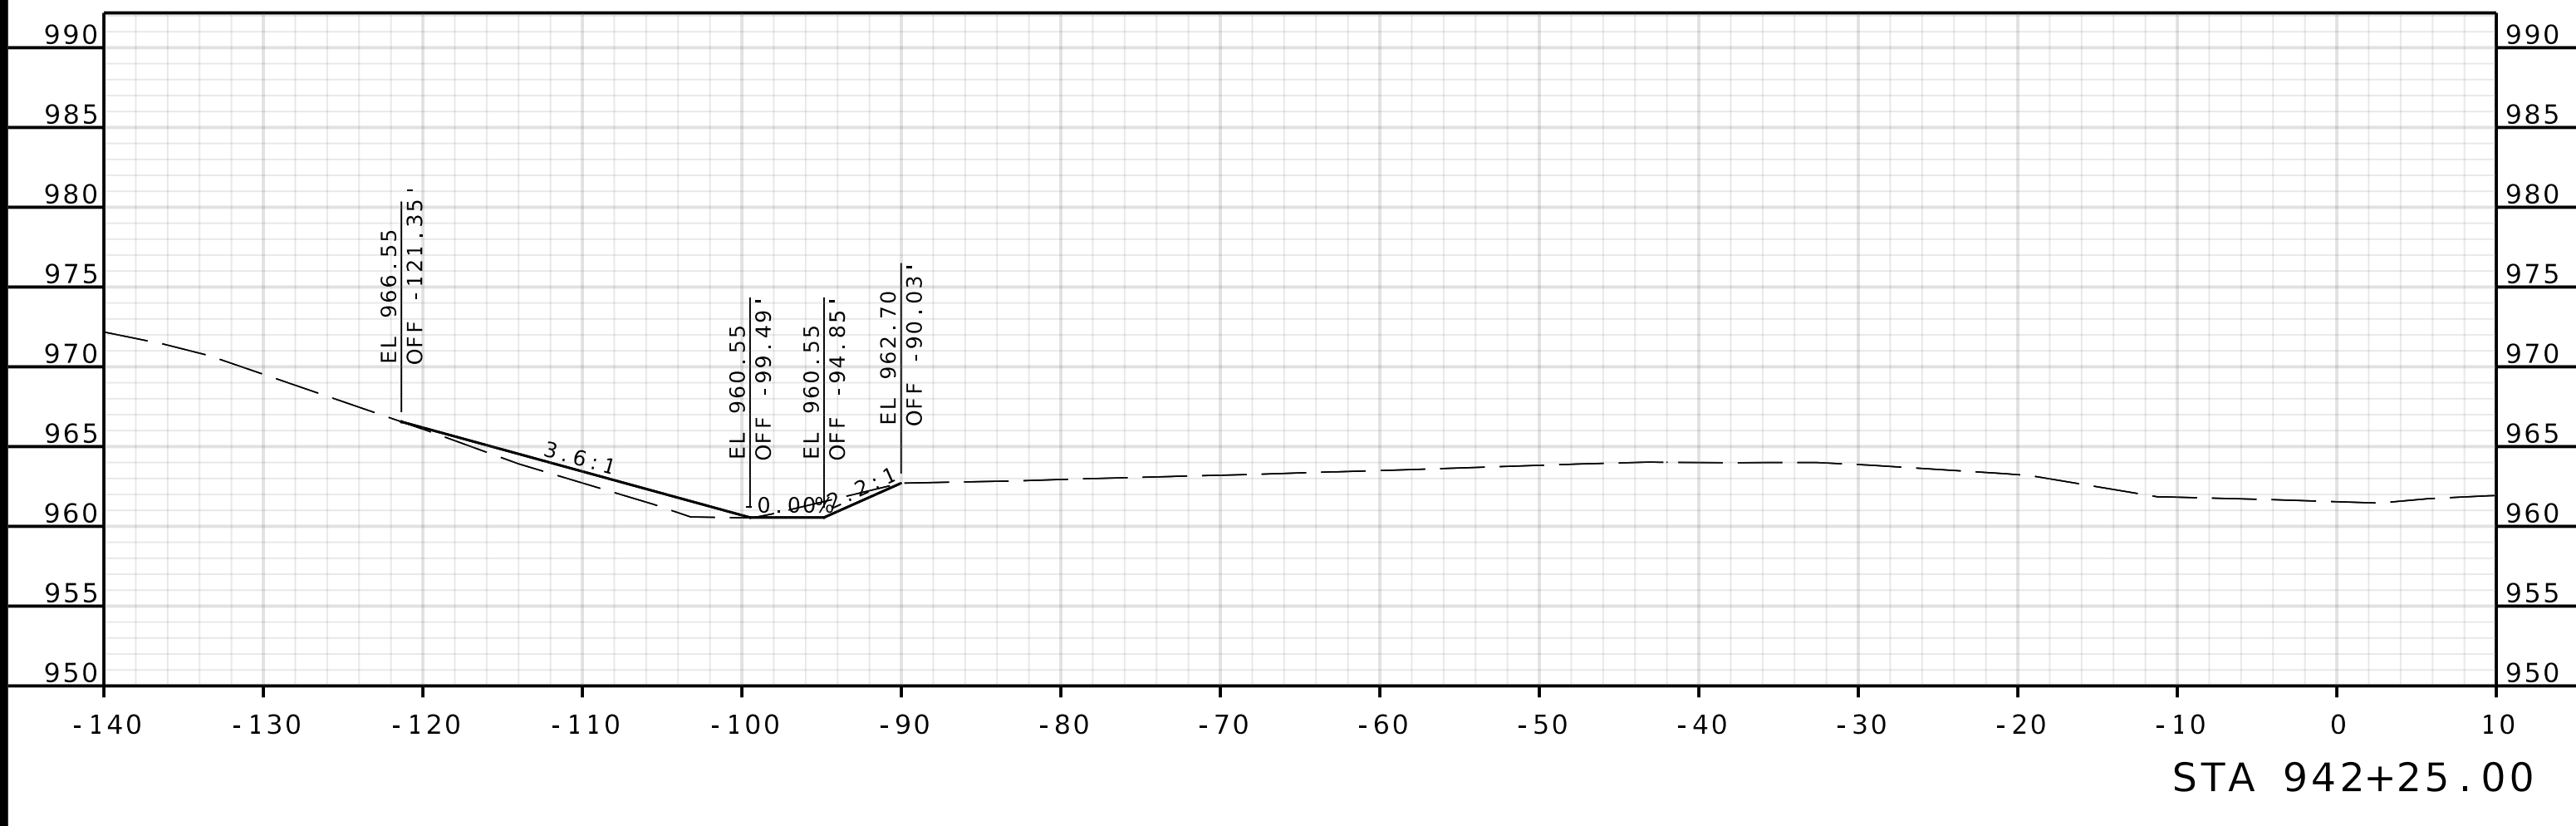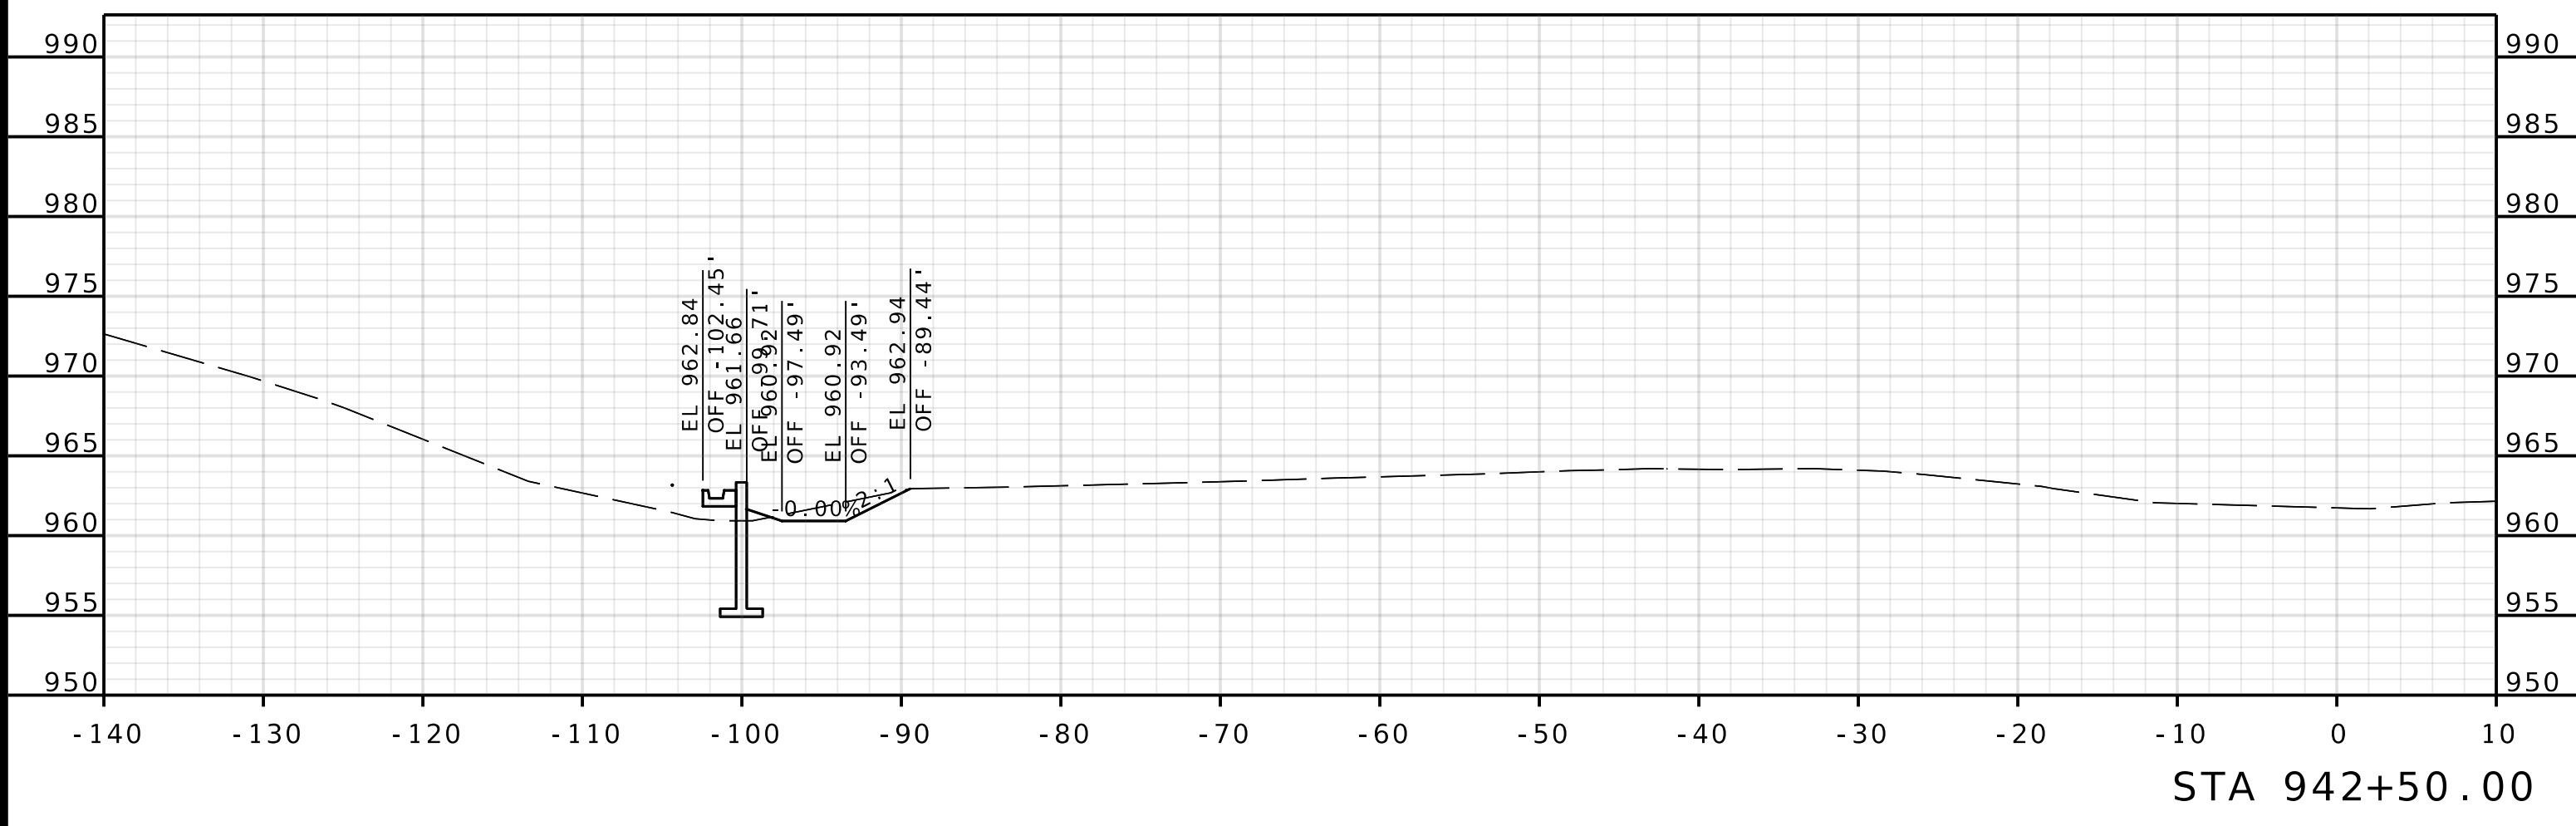


ROUTE I-435
WBL

DATE PREPARED 4/30/2025	
ROUTE 1435	STATE MO
DISTRICT KC	SHEET NO. 2
COUNTY PLATTE	
JOB NO. J4S3489	
CONTRACT ID.	
PROJECT NO.	
BRIDGE NO. A9700	

DATE	DESCRIPTION


MISSOURI HIGHWAYS AND TRANSPORTATION
COMMISSION

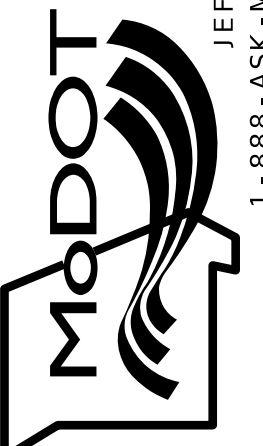


105 WEST CAPITOL
JEFFERSON CITY, MO 65102
1-888-ASK-MODOT (1-888-275-6636)

Olsson
1301 BURLINGTON STREET, STE. 100
NORTH KANSAS CITY, MO 64116
PHONE: 816.361.1177
CERTIFICATE OF AUTHORITY NO. 001592


IF A SEAL IS PRESENT ON THIS SHEET IT HAS BEEN ELECTRONICALLY SEALED AND DATED.

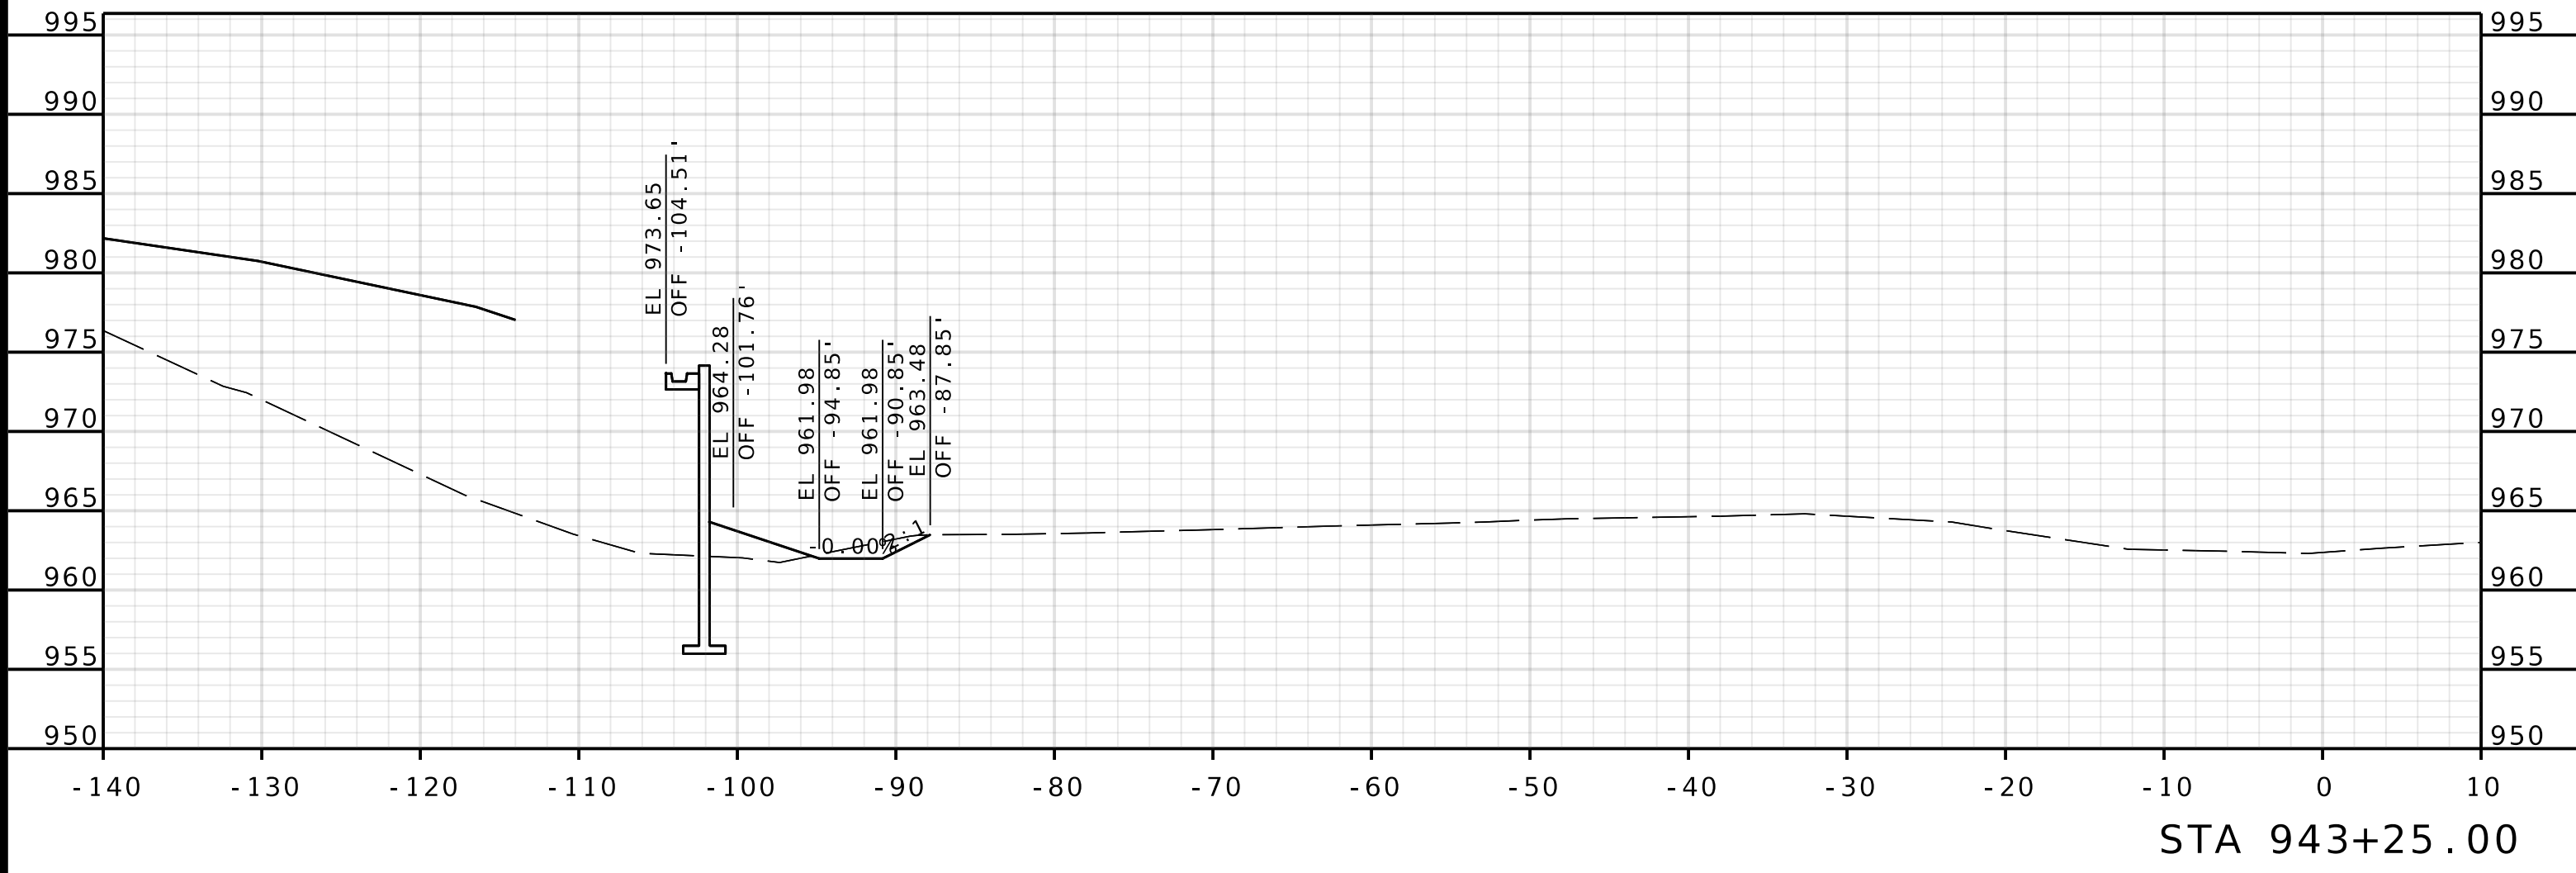

STA 943+25.00

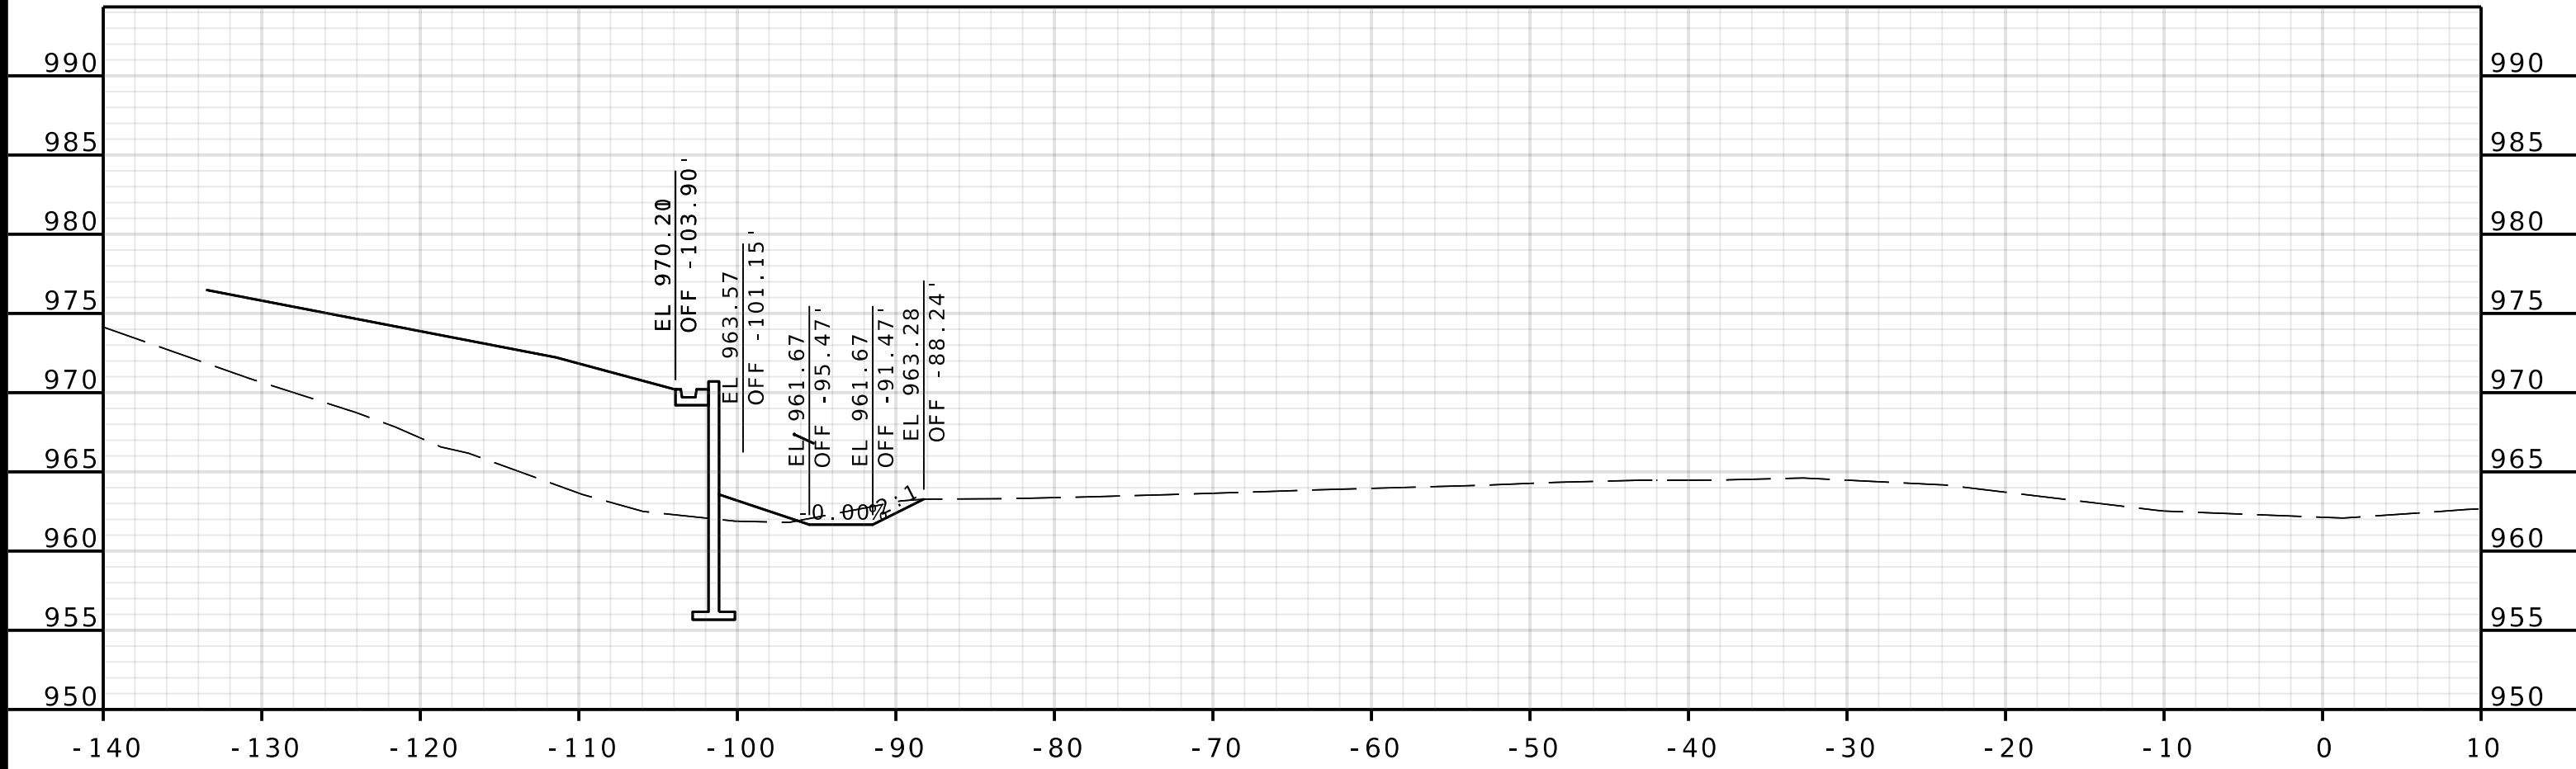

STA 943+00.00

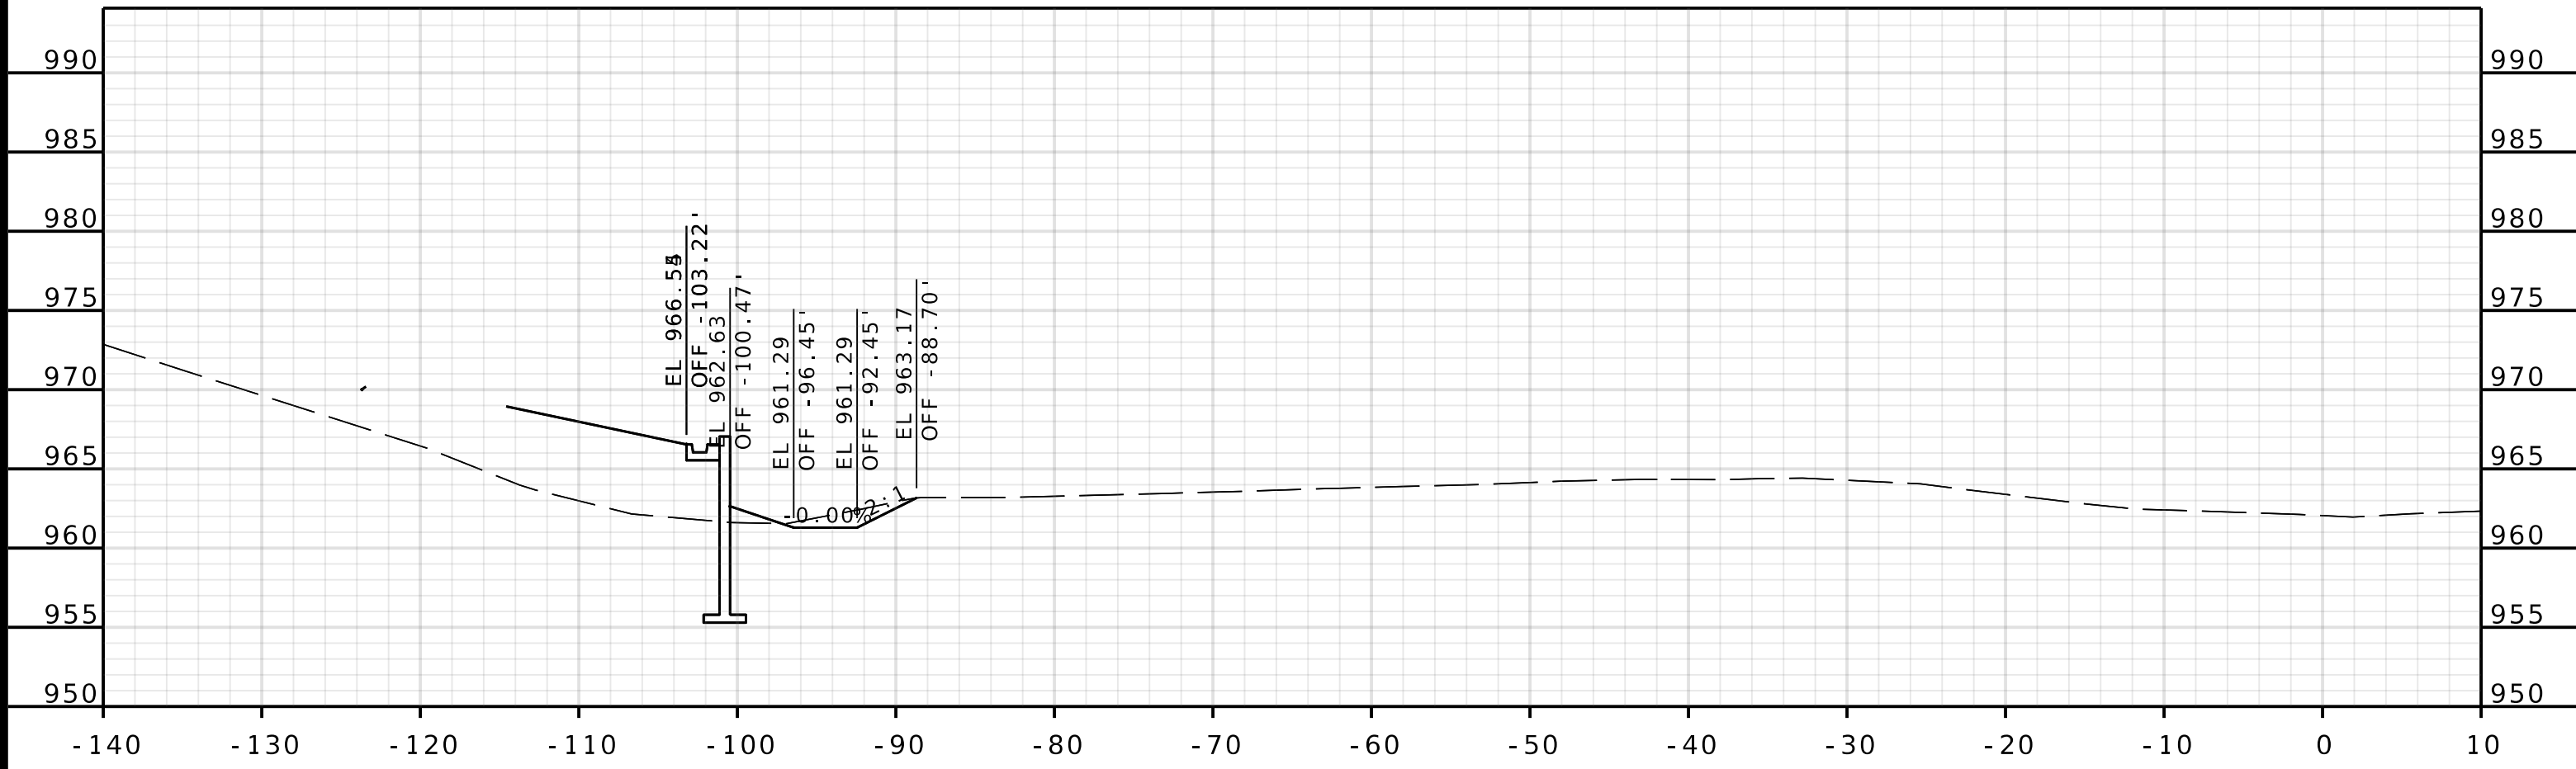


STA 942+75.00

ROUTE I-435
WBL

DATE PREPARED 4/30/2025	
ROUTE 1435	STATE MO
DISTRICT KC	SHEET NO. 3
COUNTY PLATTE	
JOB NO. J4S3489	
CONTRACT ID.	
PROJECT NO.	
BRIDGE NO. A9700	

DATE	DESCRIPTION



MISSOURI HIGHWAYS AND TRANSPORTATION COMMISSION

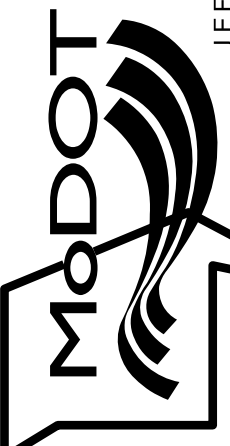

105 WEST CAPITOL
JEFFERSON CITY, MO 65102
1-888-ASK-MODOT (1-888-275-6636)

Olsson
1301 BURLINGTON STREET, STE. 100
NORTH KANSAS CITY, MO 64116
PHONE: 816.361.1177
CERTIFICATE OF AUTHORITY NO. 001592


IF A SEAL IS PRESENT ON THIS SHEET IT HAS BEEN ELECTRONICALLY SEALED AND DATED.

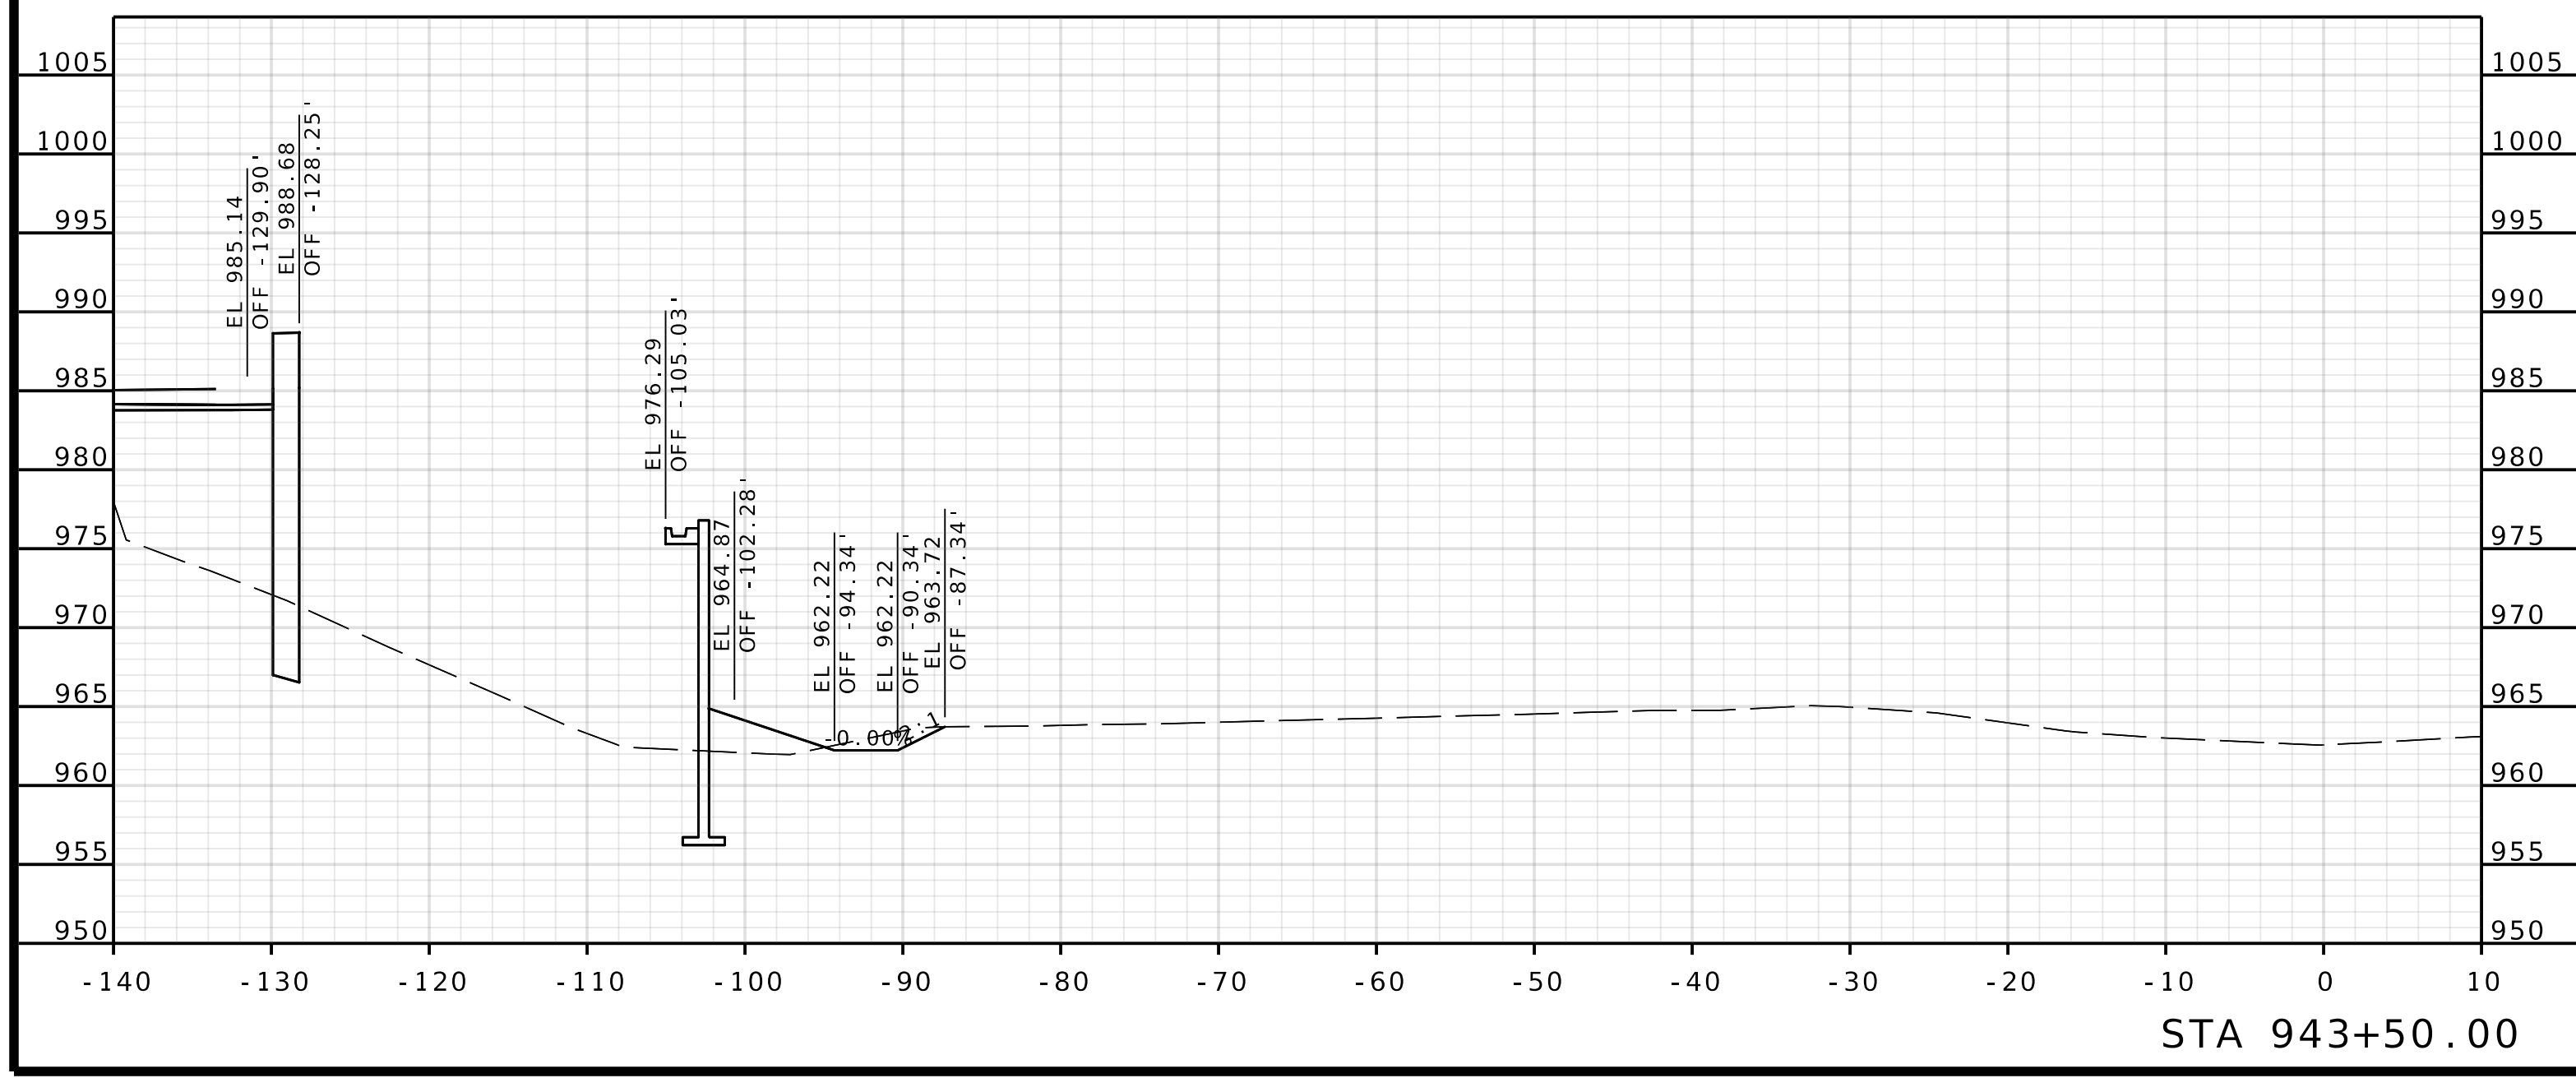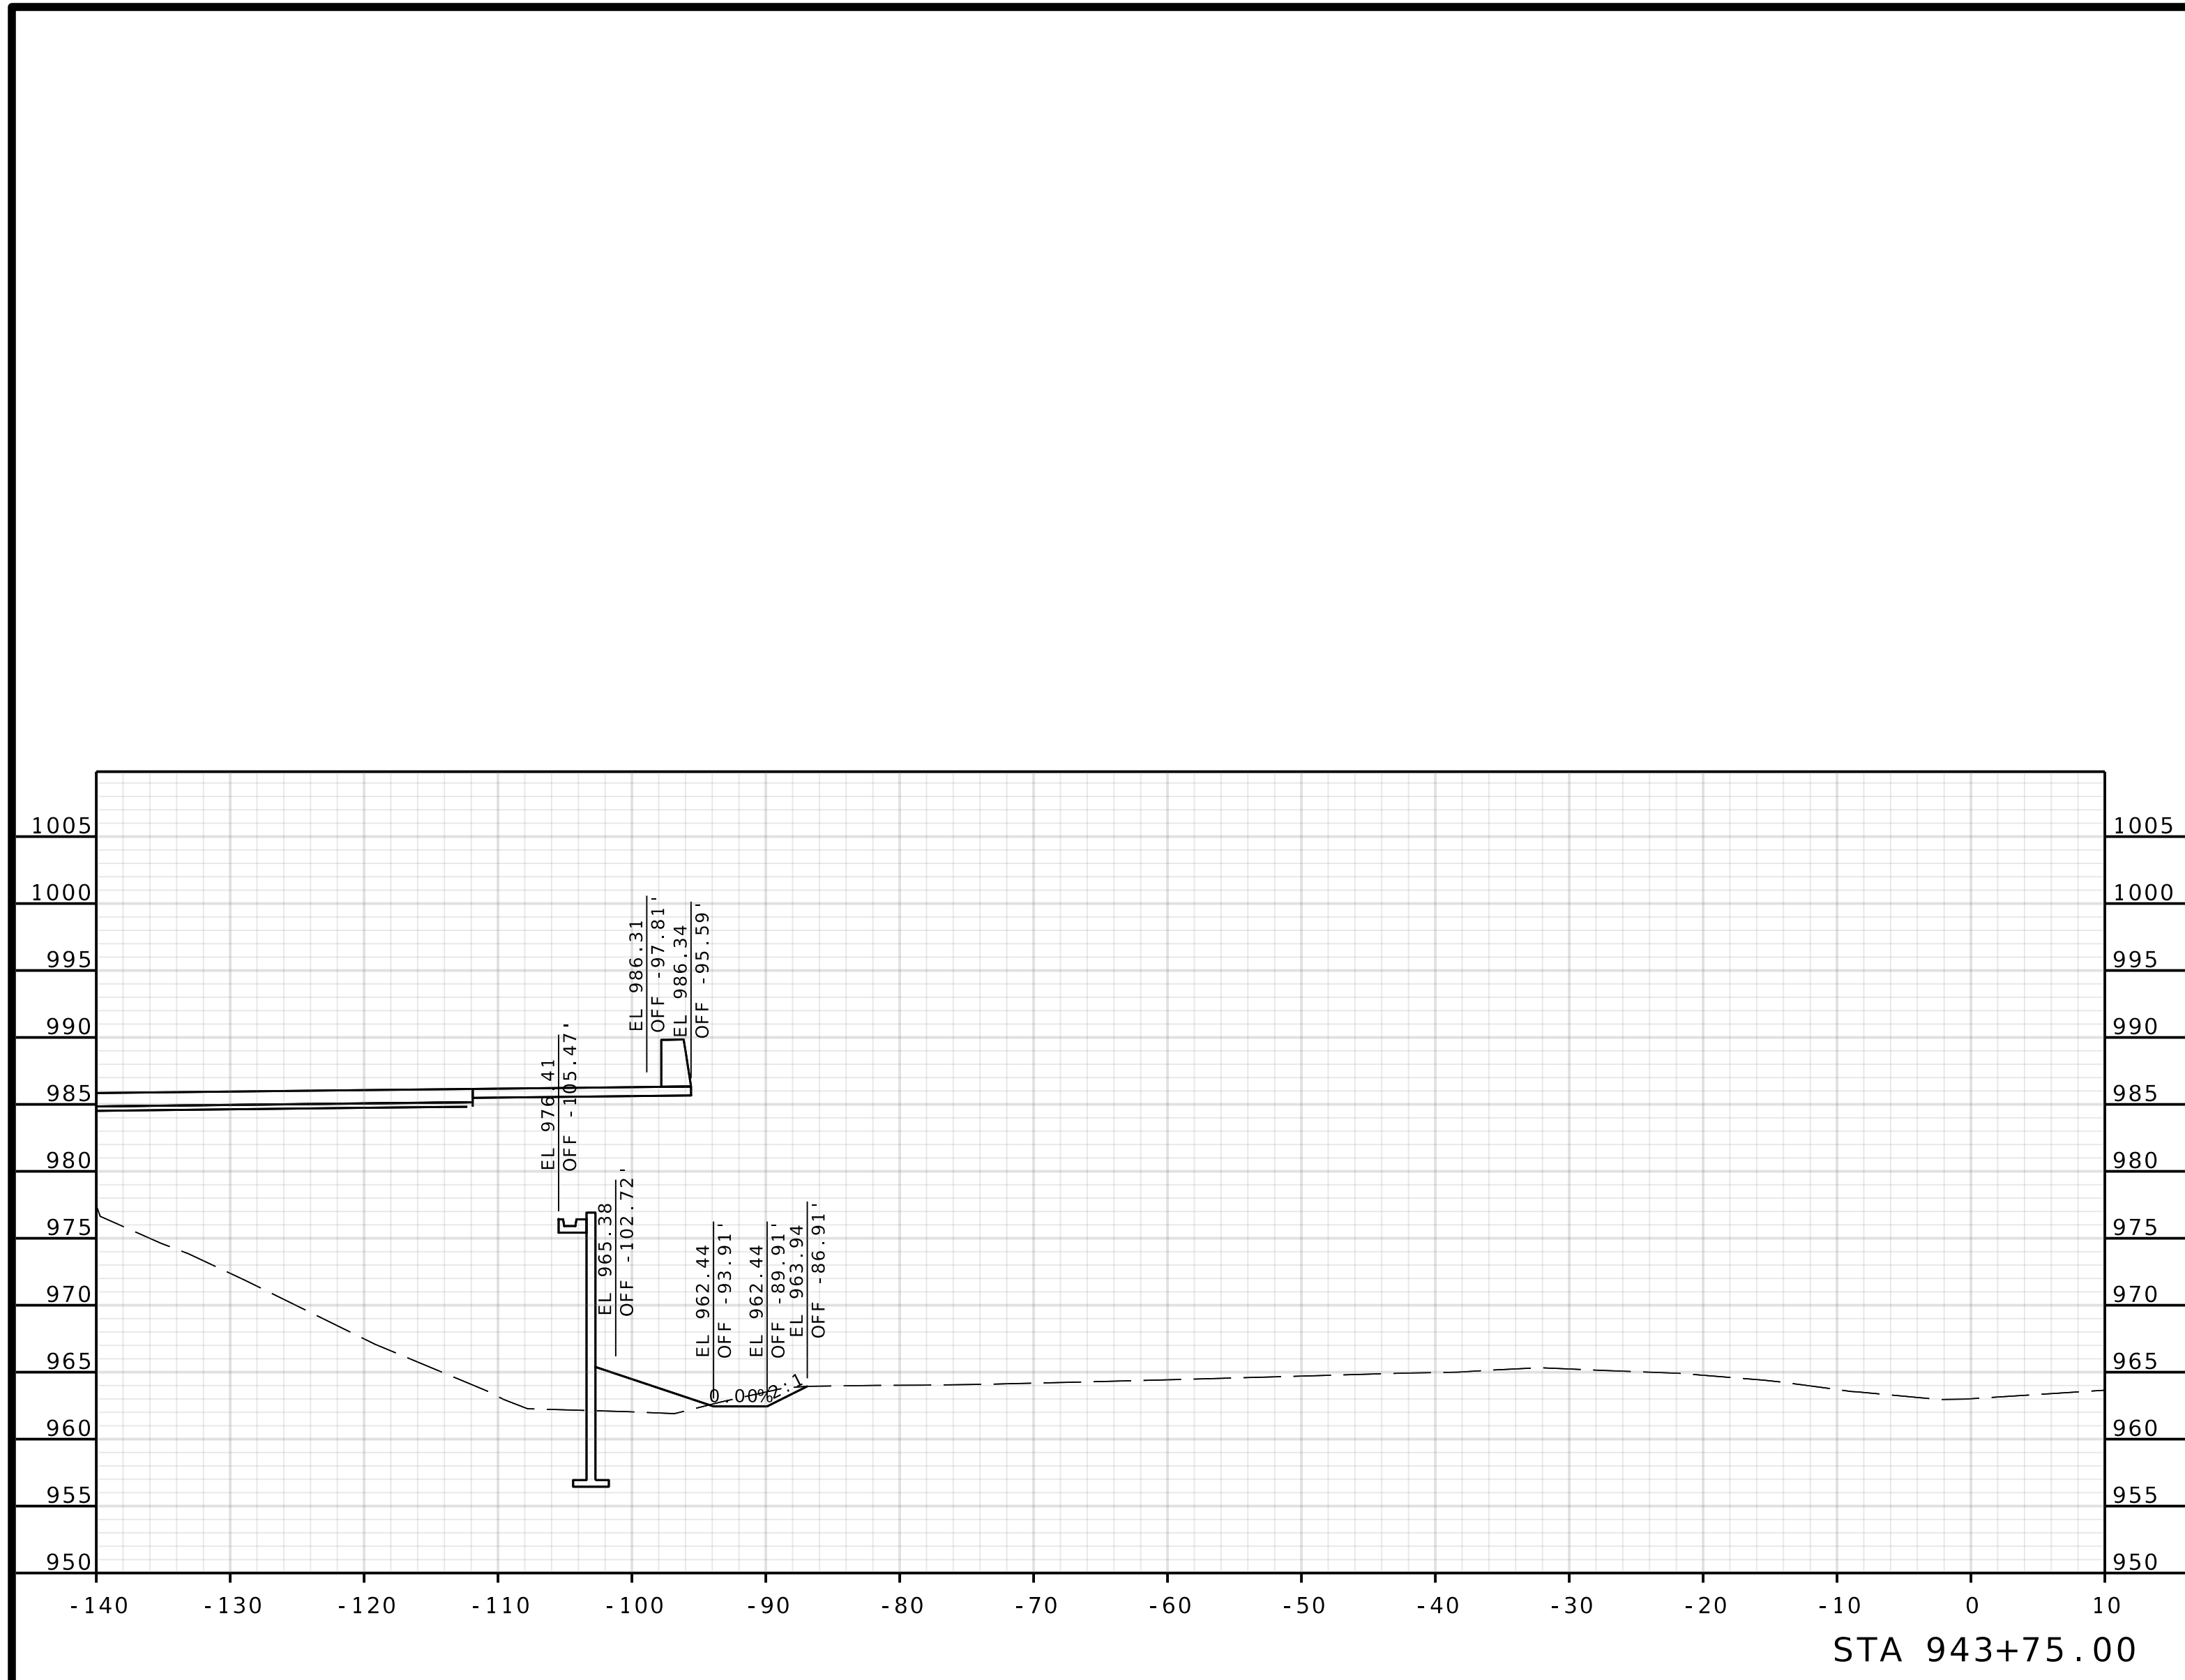

DATE PREPARED 4/30/2025	
ROUTE 1435	STATE MO
DISTRICT KC	SHEET NO. 4
COUNTY PLATTE	
JOB NO. J4S3489	
CONTRACT ID.	
PROJECT NO.	
BRIDGE NO. A9700	

DATE	DESCRIPTION

MISSOURI HIGHWAYS AND TRANSPORTATION COMMISSION

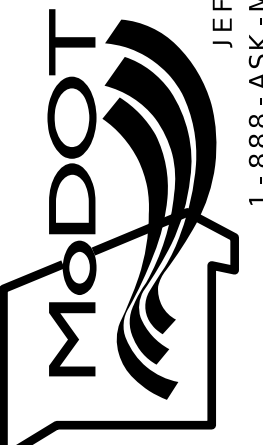



105 WEST CAPITOL
JEFFERSON CITY, MO 65102
1-888-ASK-MODOT (1-888-275-6636)

Olsson

1301 BURLINGTON STREET, STE. 100
NORTH KANSAS CITY, MO 64116
PHONE: 816.361.1177
CERTIFICATE OF AUTHORITY NO. 001592

ROUTE I-435
WBL

IF A SEAL IS PRESENT ON THIS SHEET IT HAS BEEN ELECTRONICALLY SEALED AND DATED.

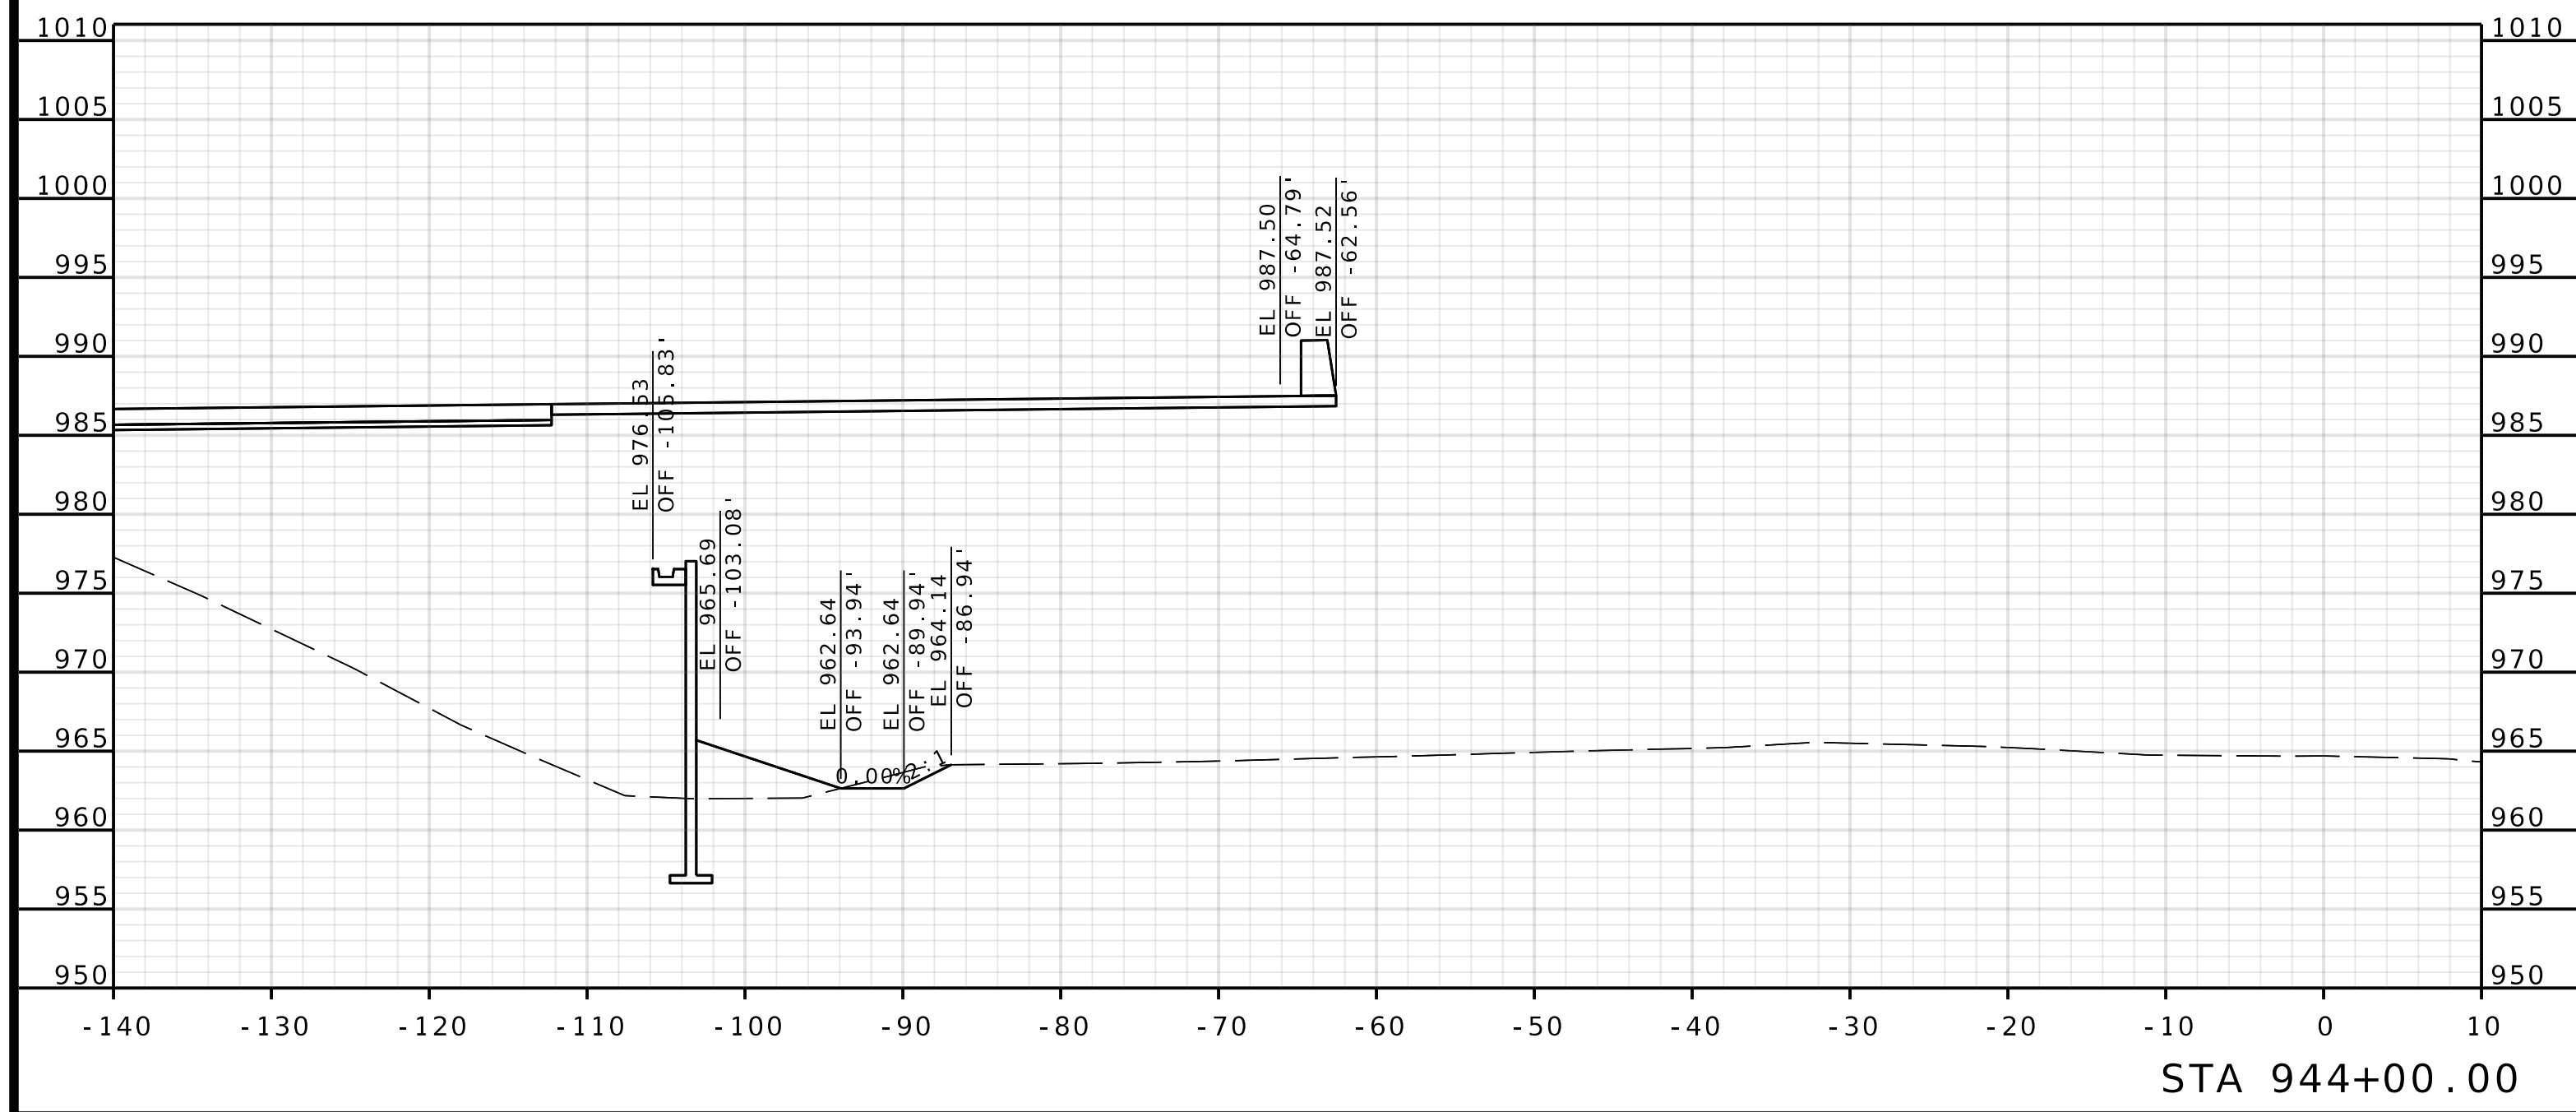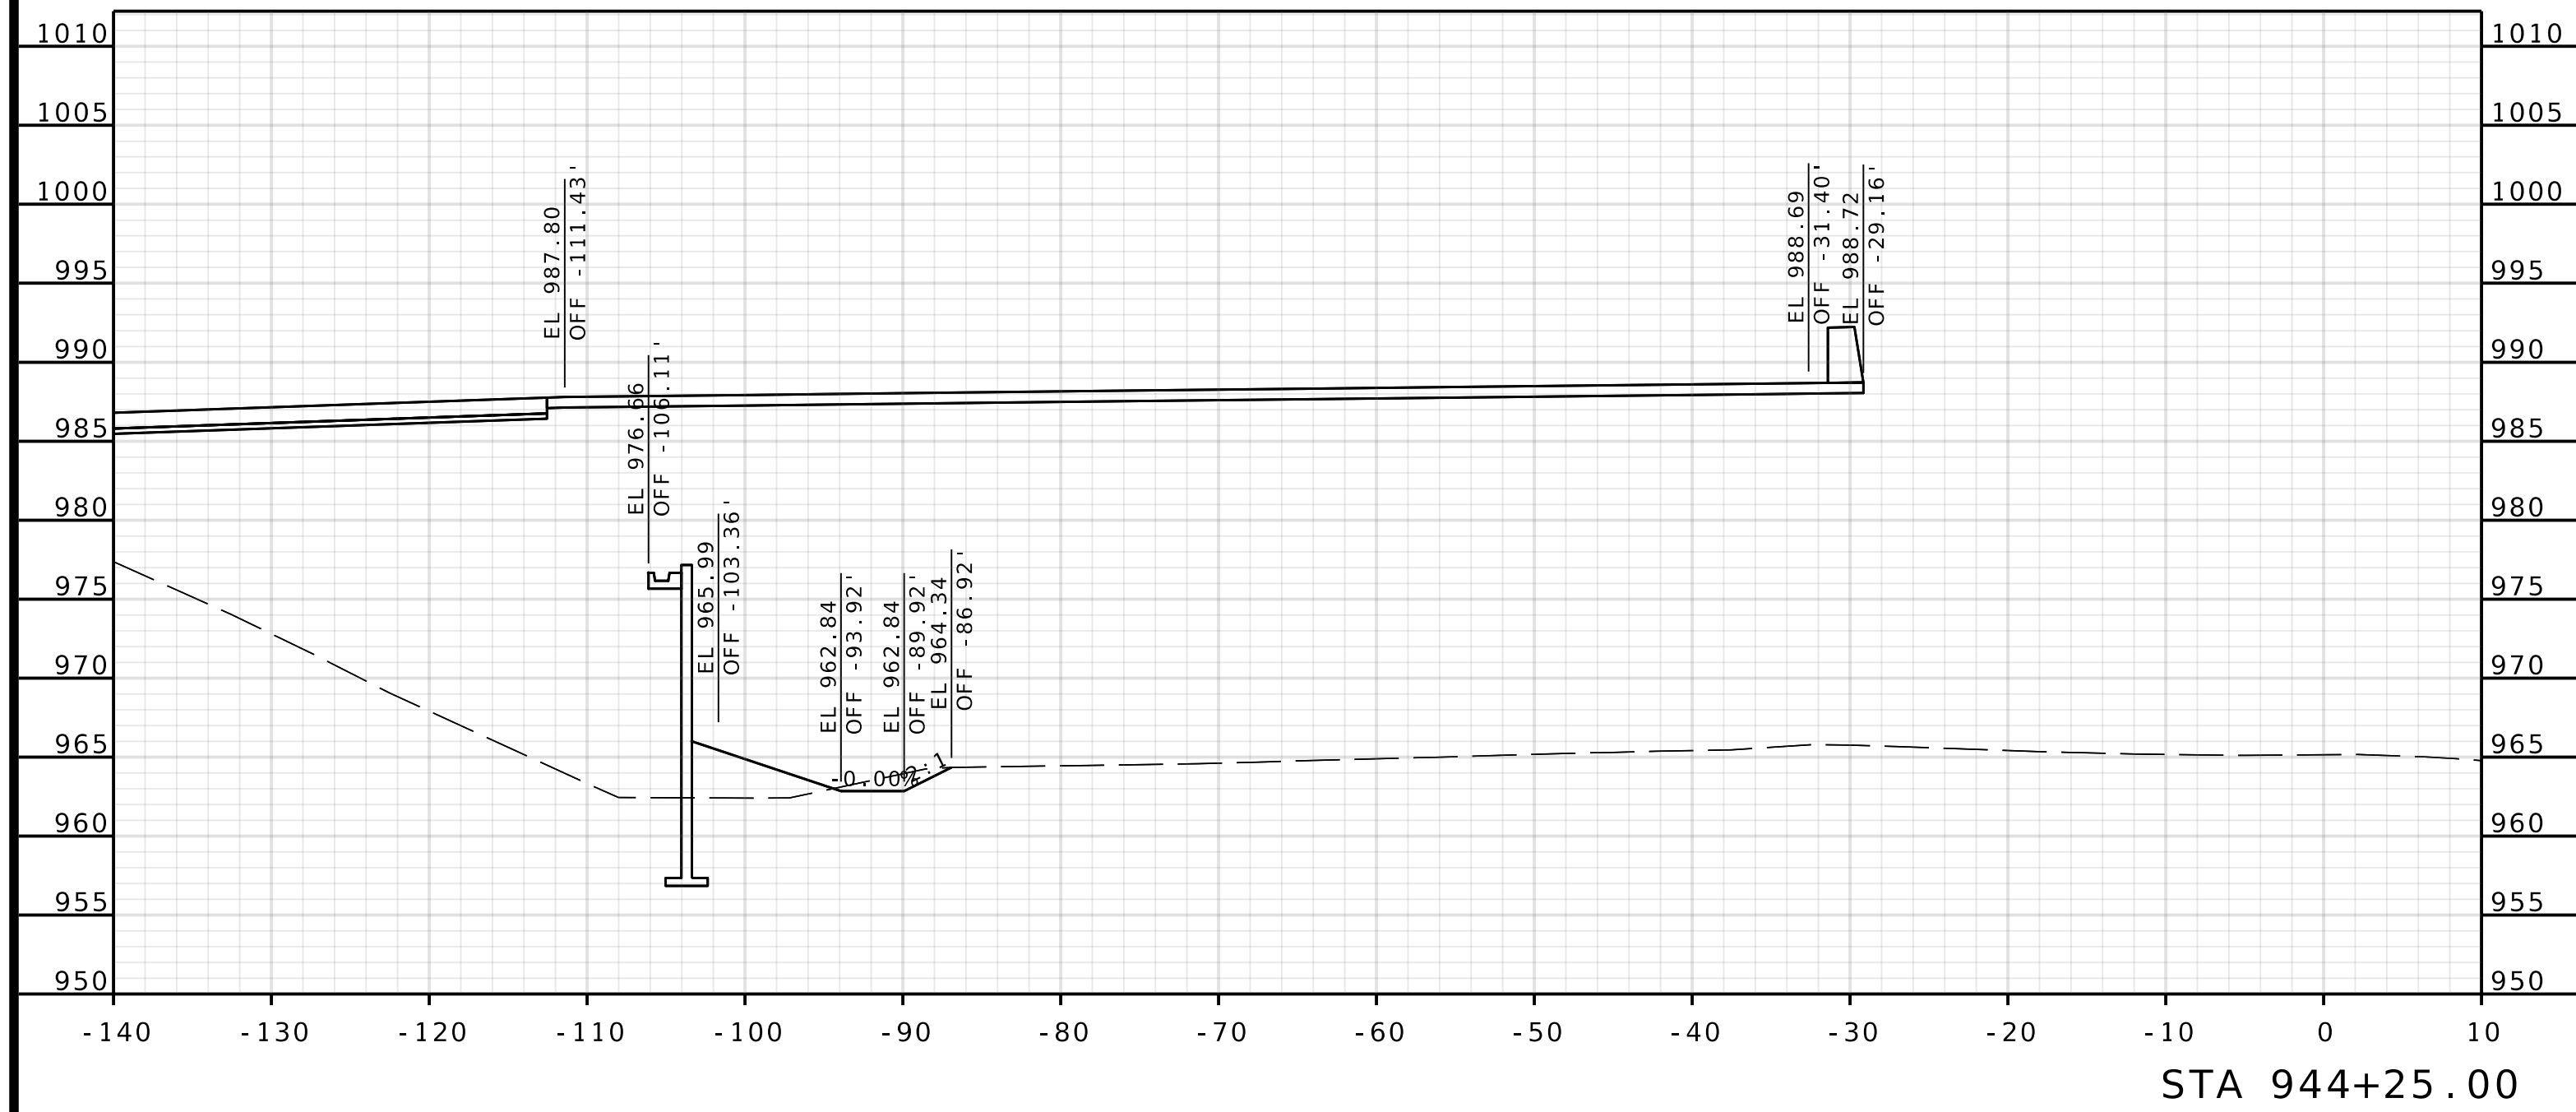

DATE PREPARED 4/30/2025	
ROUTE 1435	STATE MO
DISTRICT KC	SHEET NO. 5
COUNTY PLATTE	
JOB NO. J4S3489	
CONTRACT ID.	

PROJECT NO.
BRIDGE NO. A9700

DATE	DESCRIPTION

MISSOURI HIGHWAYS AND TRANSPORTATION COMMISSION





105 WEST CAPITOL
JEFFERSON CITY, MO 65102
1-888-ASK-MODOT (1-888-275-6636)

Olsson

1301 BURLINGTON STREET, STE. 100
NORTH KANSAS CITY, MO 64116
PHONE: 816.361.1177
CERTIFICATE OF AUTHORITY NO. 001592

IF A SEAL IS PRESENT ON THIS SHEET IT HAS BEEN ELECTRONICALLY SEALED AND DATED.

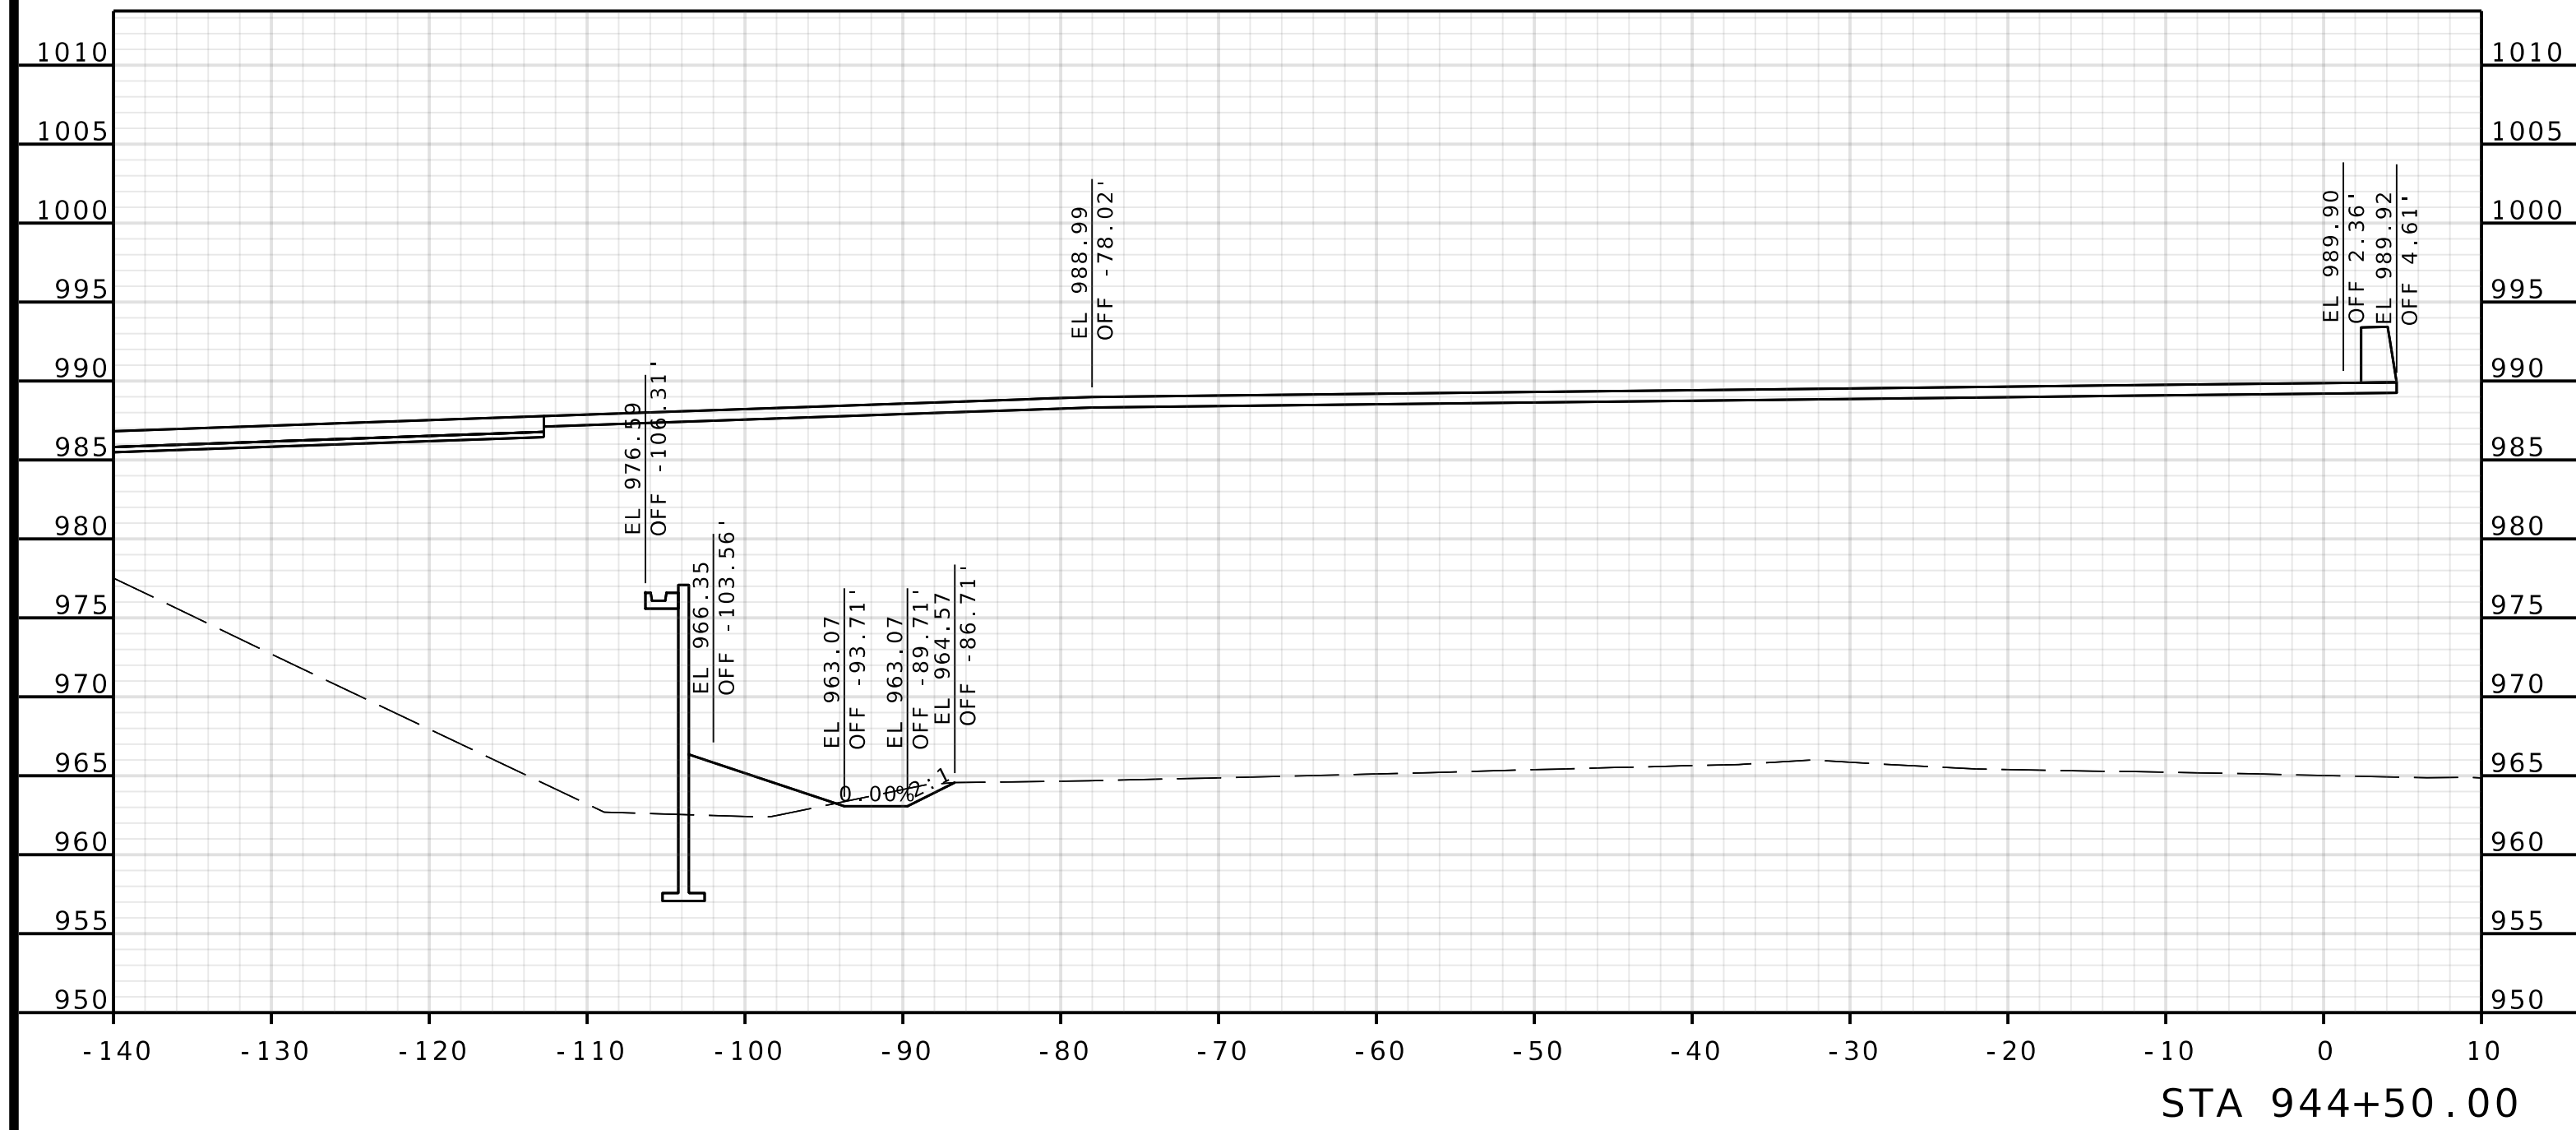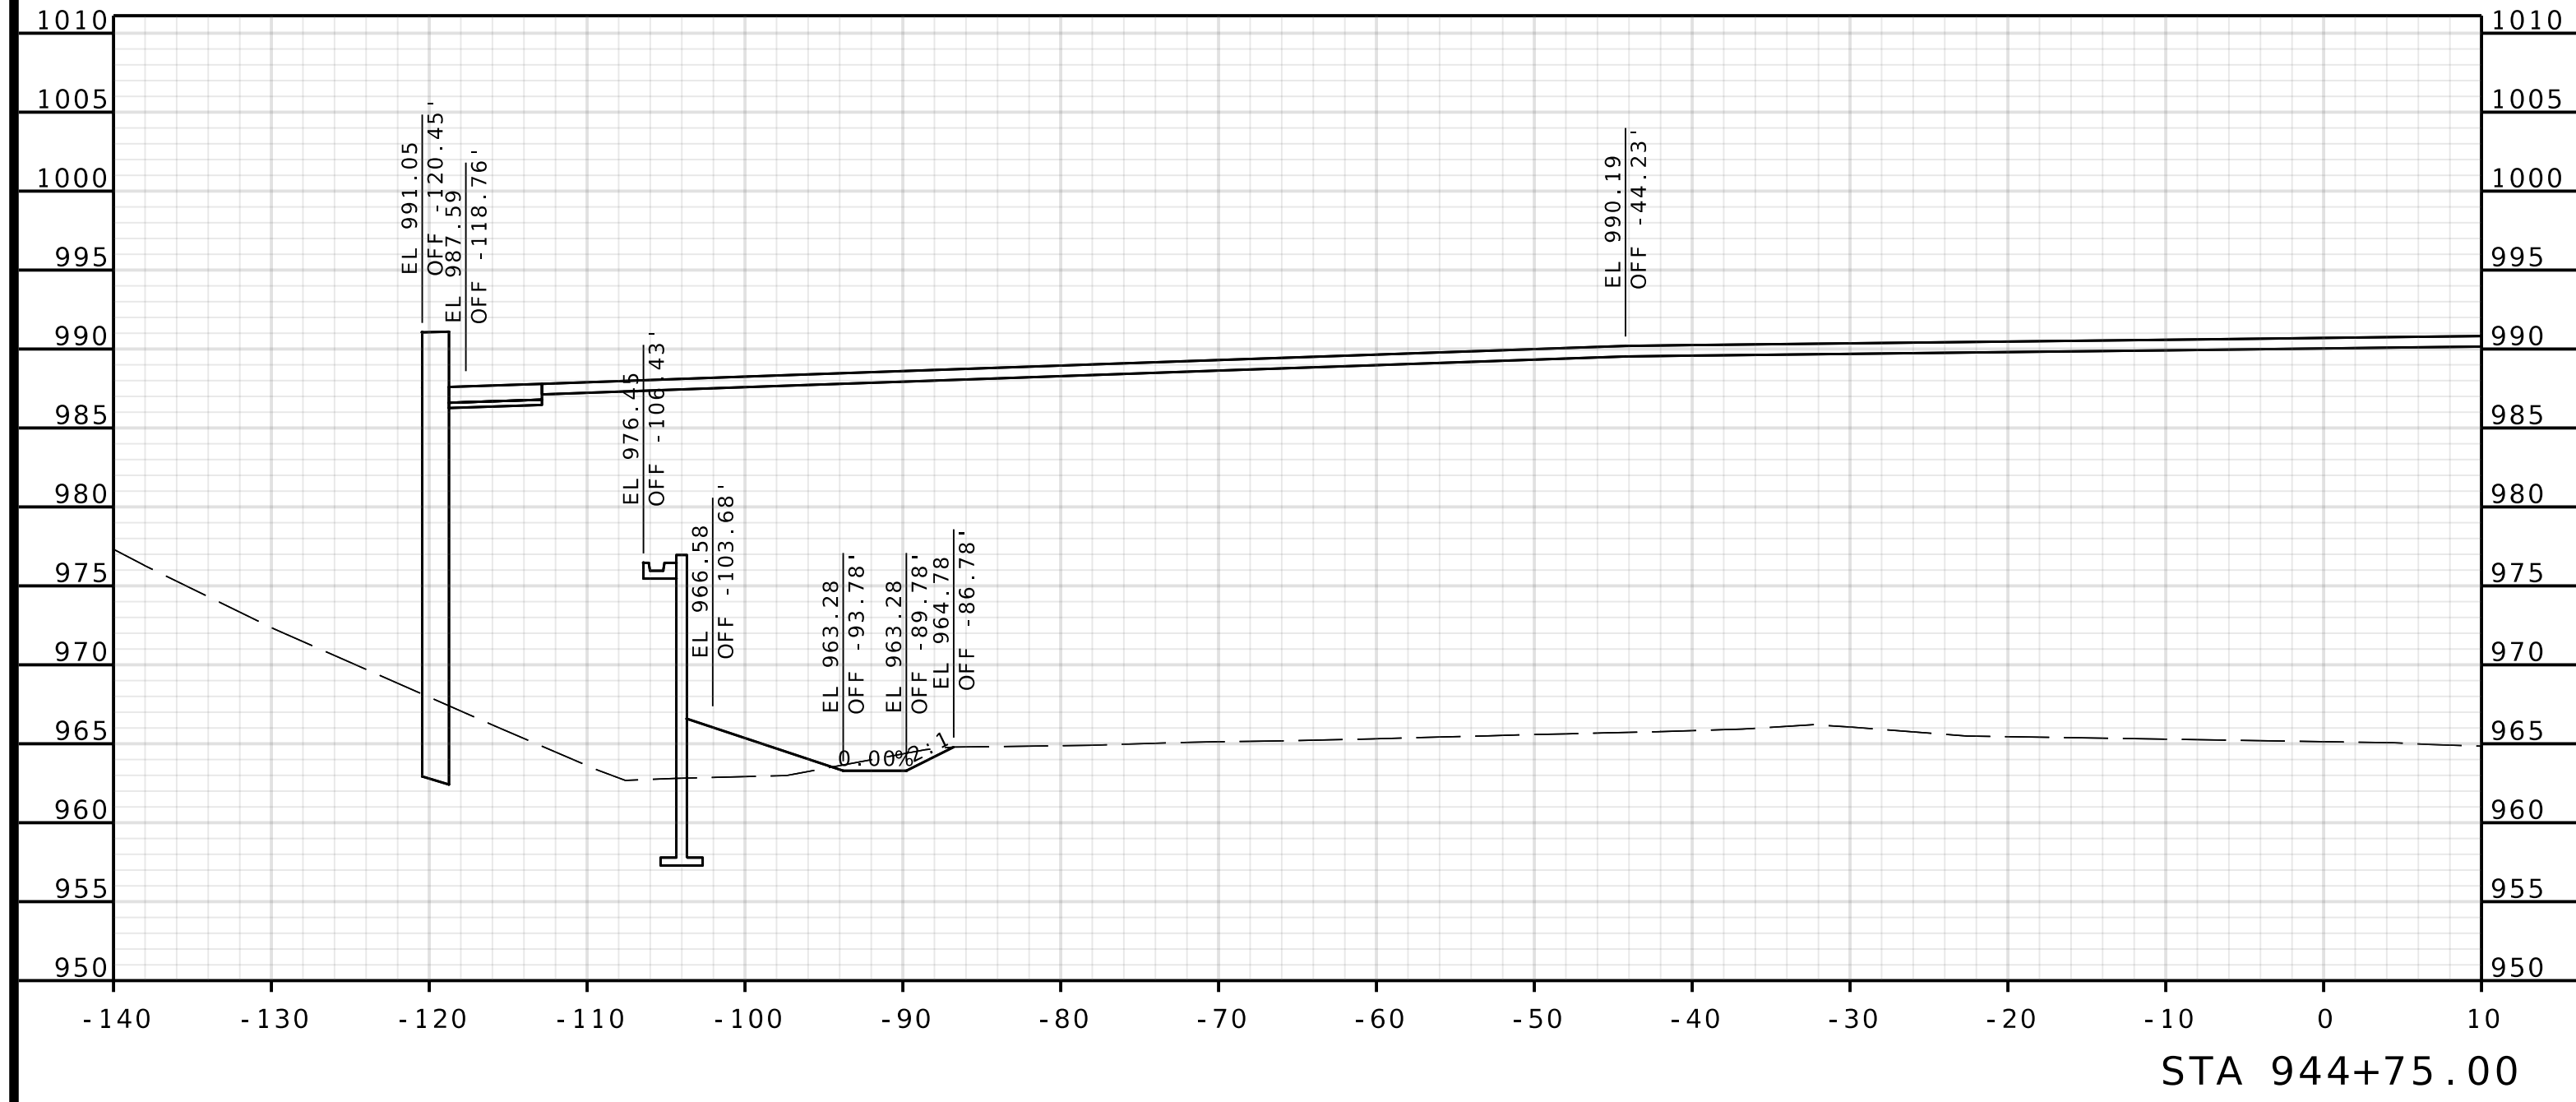


ROUTE I-435
WBL

DATE PREPARED 4/30/2025	
ROUTE 1435	STATE MO
DISTRICT KC	SHEET NO. 6
COUNTY PLATTE	
JOB NO. J4S3489	
CONTRACT ID.	

PROJECT NO.
BRIDGE NO.
A9700

DATE	DESCRIPTION



MISSOURI HIGHWAYS AND TRANSPORTATION
COMMISSION

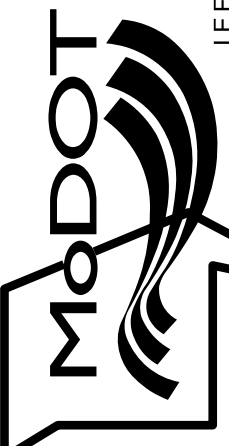

105 WEST CAPITOL
JEFFERSON CITY, MO 65102
1-888-ASK-MODOT (1-888-275-6636)

Olsson
1301 BURLINGTON STREET, STE. 100
NORTH KANSAS CITY, MO 64116
PHONE: 816.361.1177
CERTIFICATE OF AUTHORITY NO. 001592

IF A SEAL IS PRESENT ON THIS SHEET IT HAS BEEN ELECTRONICALLY SEALED AND DATED.

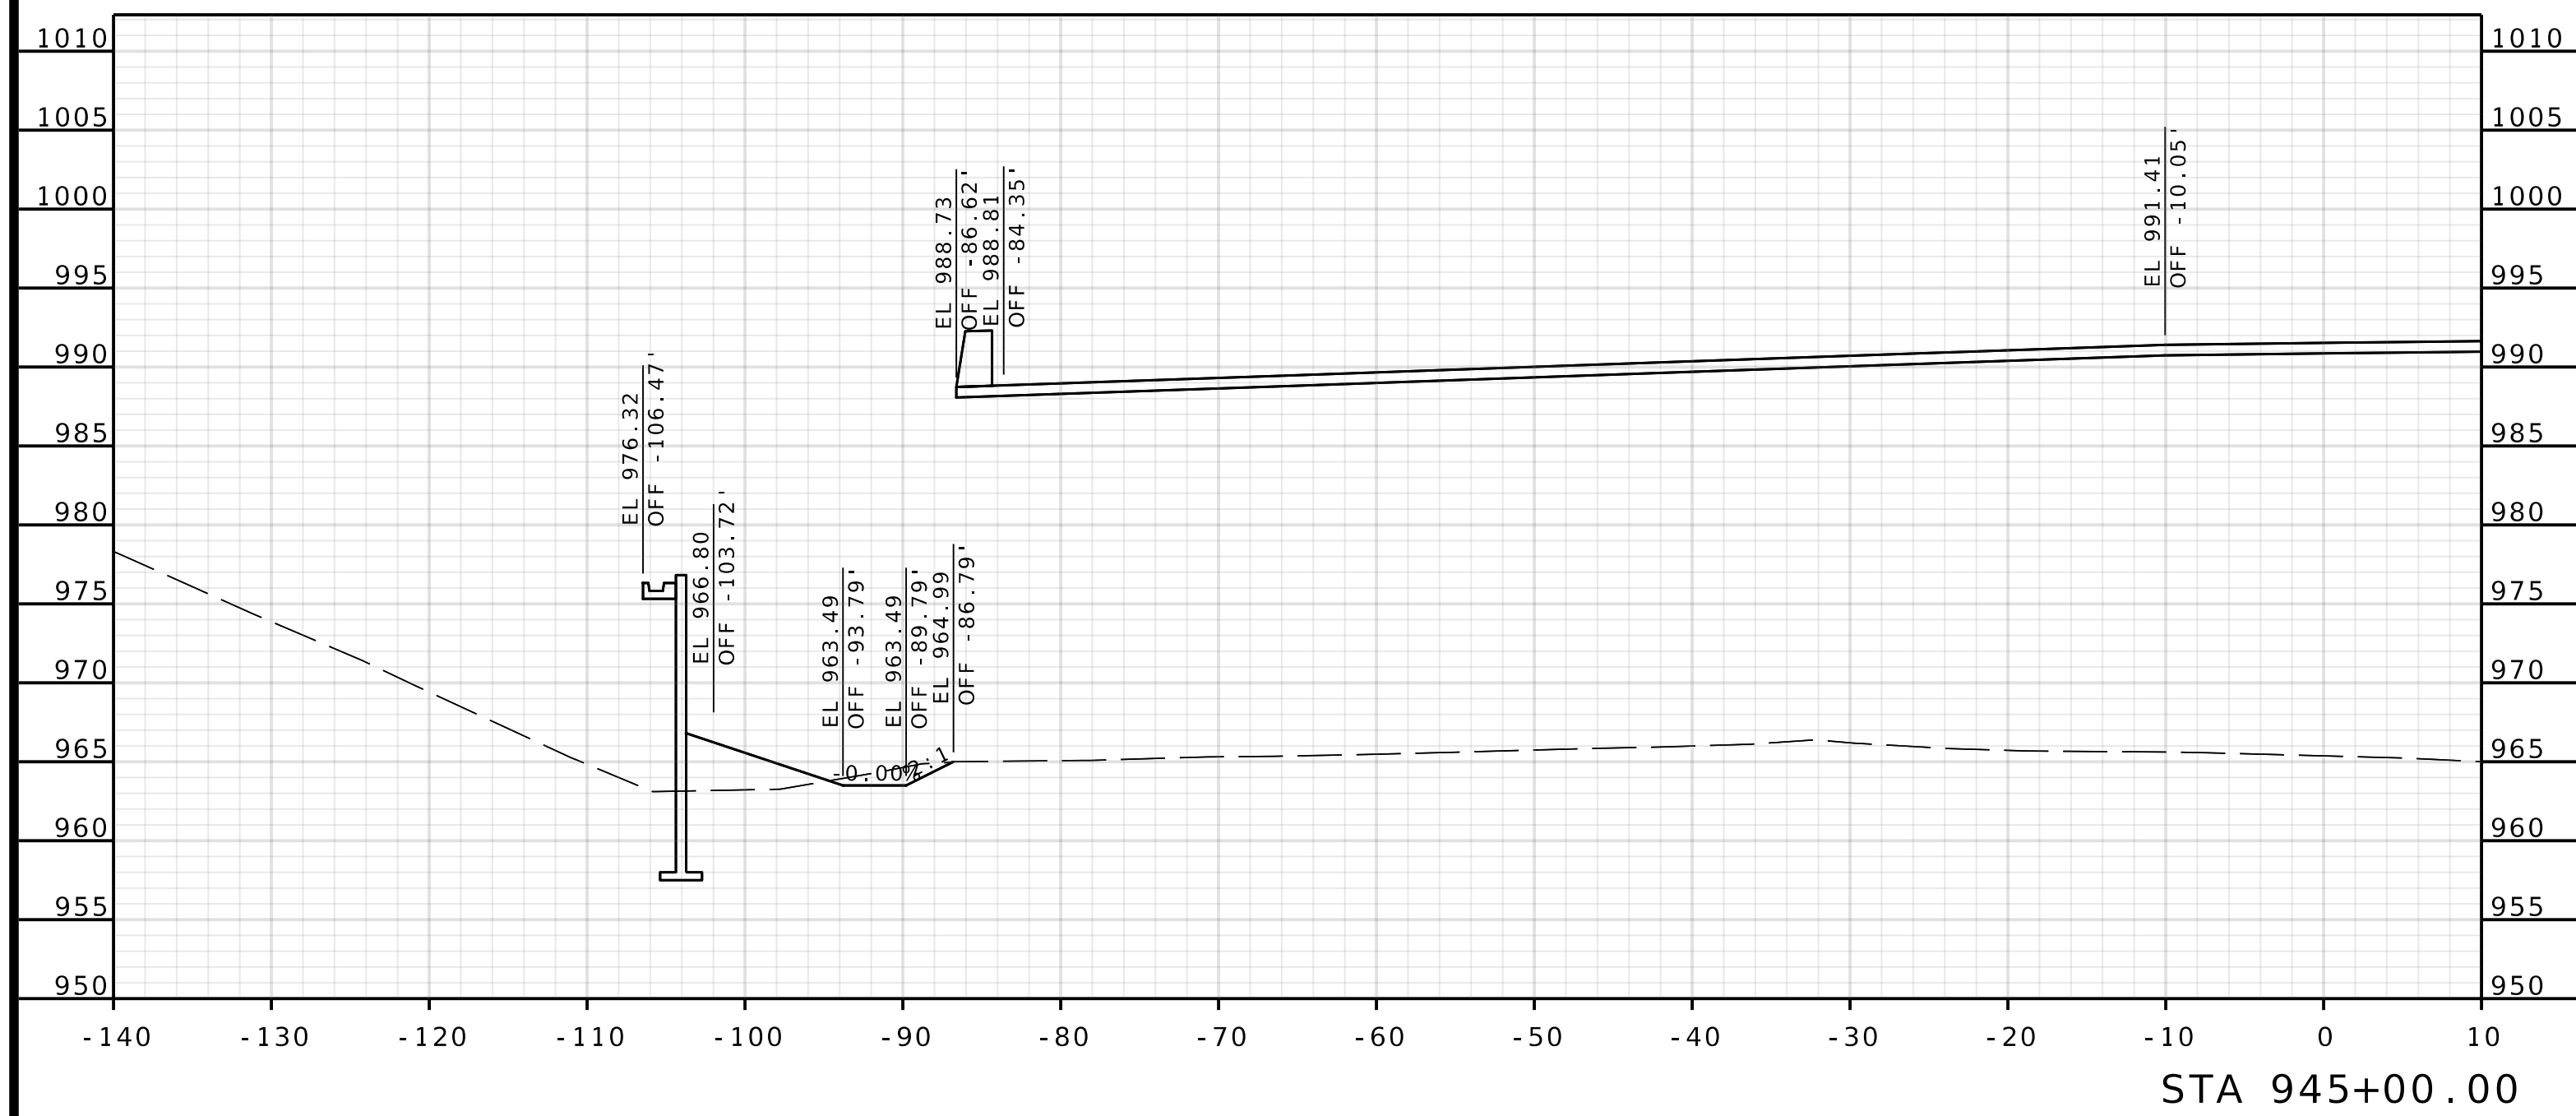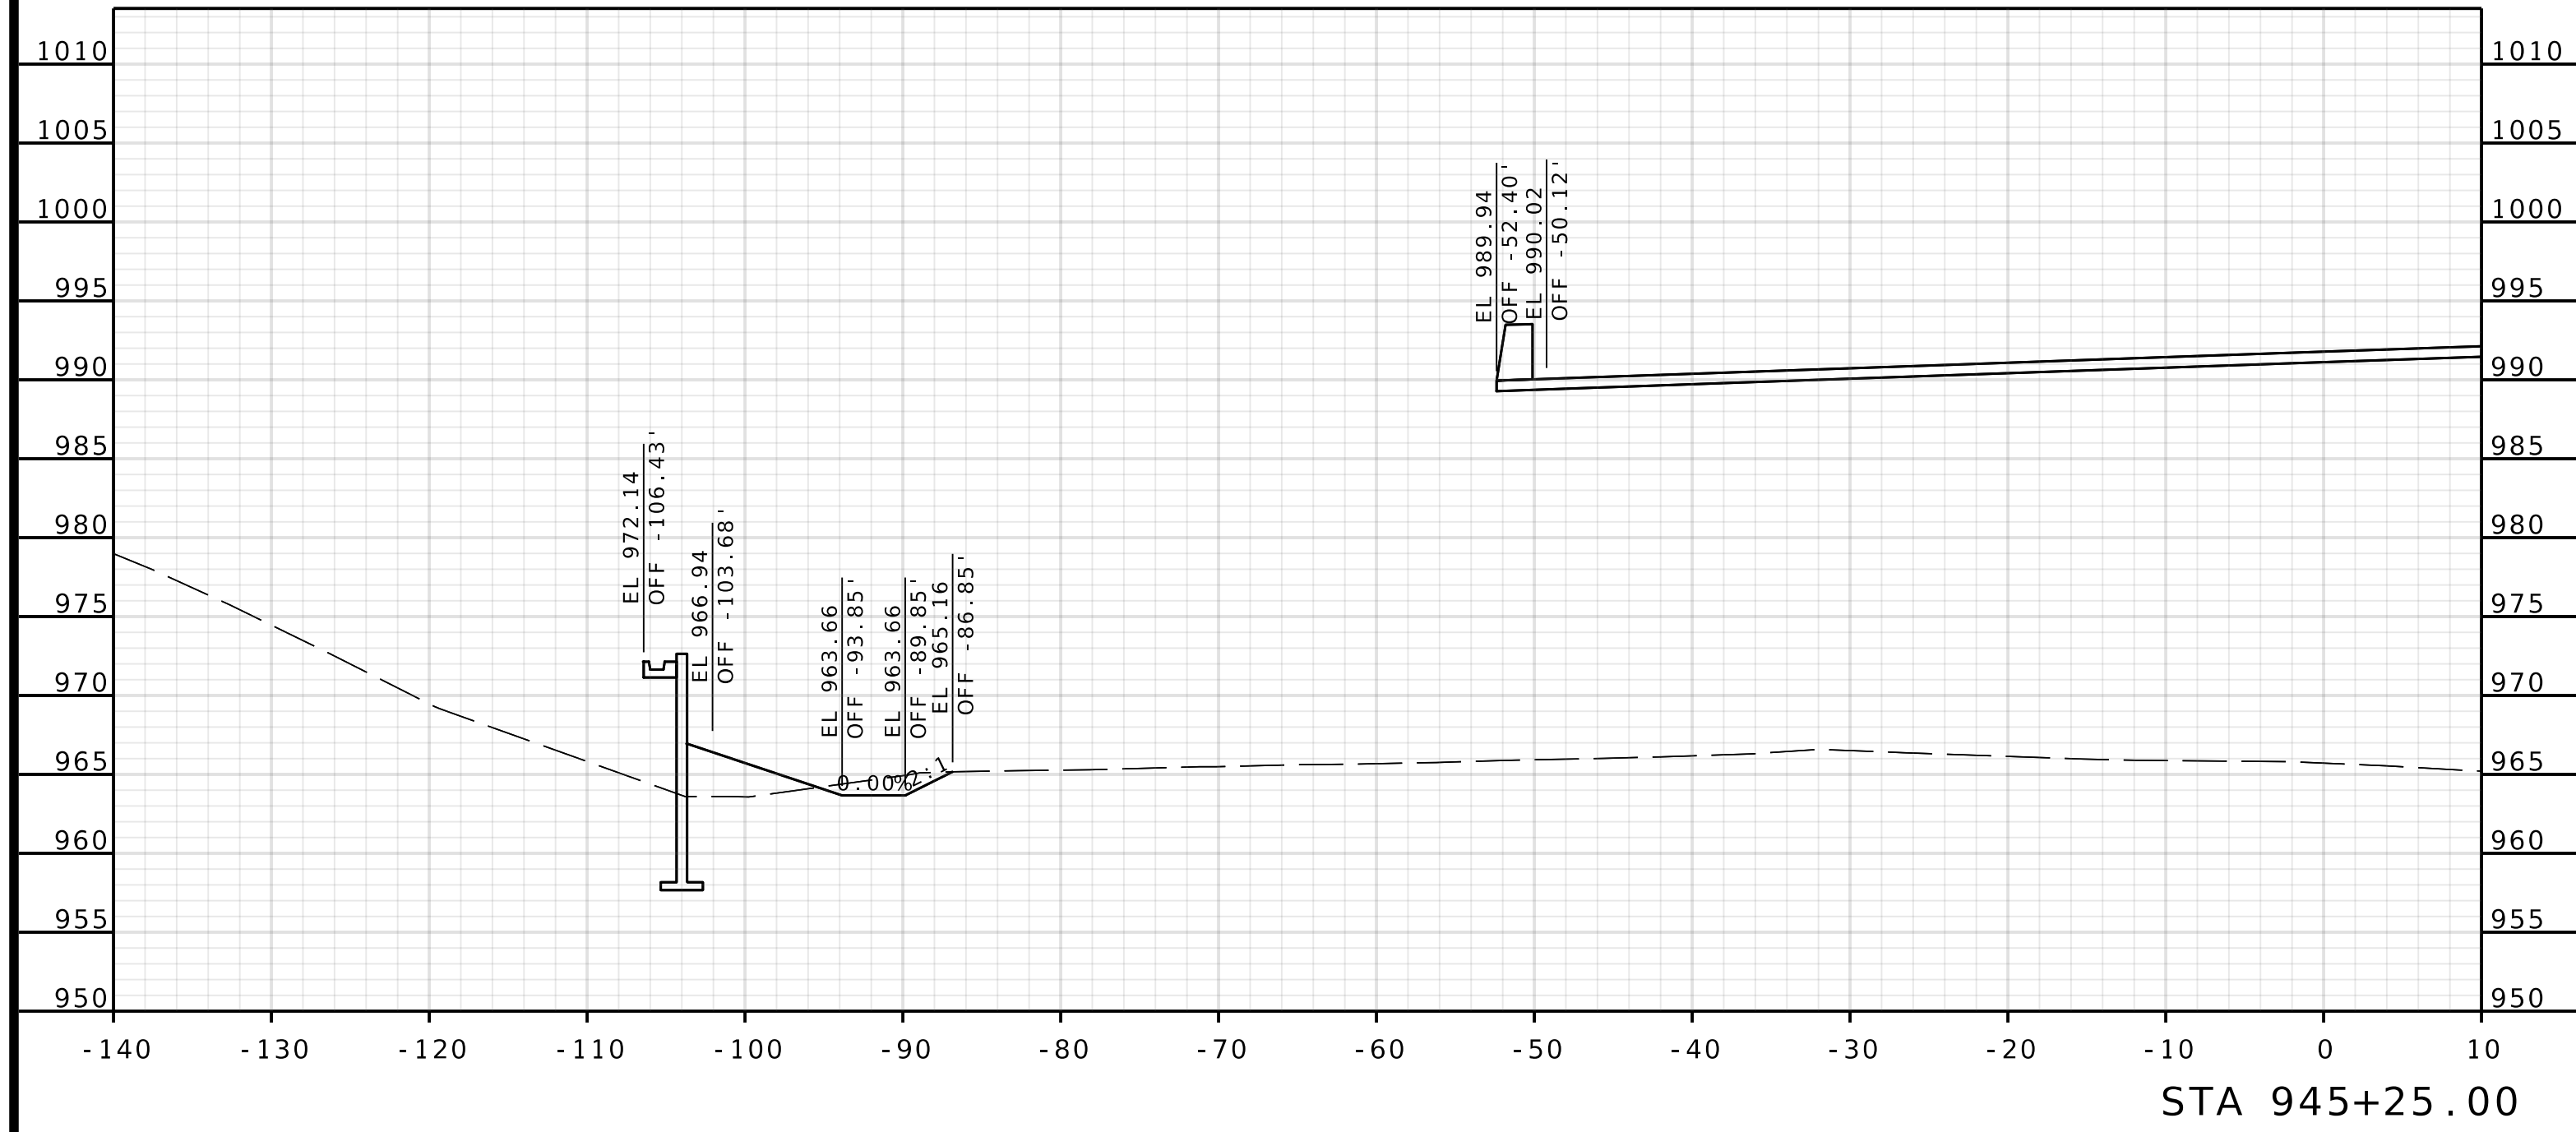

ROUTE I-435
WBL

DATE PREPARED 4/30/2025	
ROUTE 1435	STATE MO
DISTRICT KC	SHEET NO. 7
COUNTY PLATTE	
JOB NO. J4S3489	
CONTRACT ID.	

PROJECT NO.
BRIDGE NO.
A9700

DATE	DESCRIPTION



MISSOURI HIGHWAYS AND TRANSPORTATION
COMMISSION





105 WEST CAPITOL
JEFFERSON CITY, MO 65102
1-888-ASK-MODOT (1-888-275-6636)

Olsson
1301 BURLINGTON STREET, STE. 100
NORTH KANSAS CITY, MO 64116
PHONE: 816.361.1177
CERTIFICATE OF AUTHORITY NO. 001592



IF A SEAL IS PRESENT ON THIS SHEET IT HAS BEEN ELECTRONICALLY SEALED AND DATED.

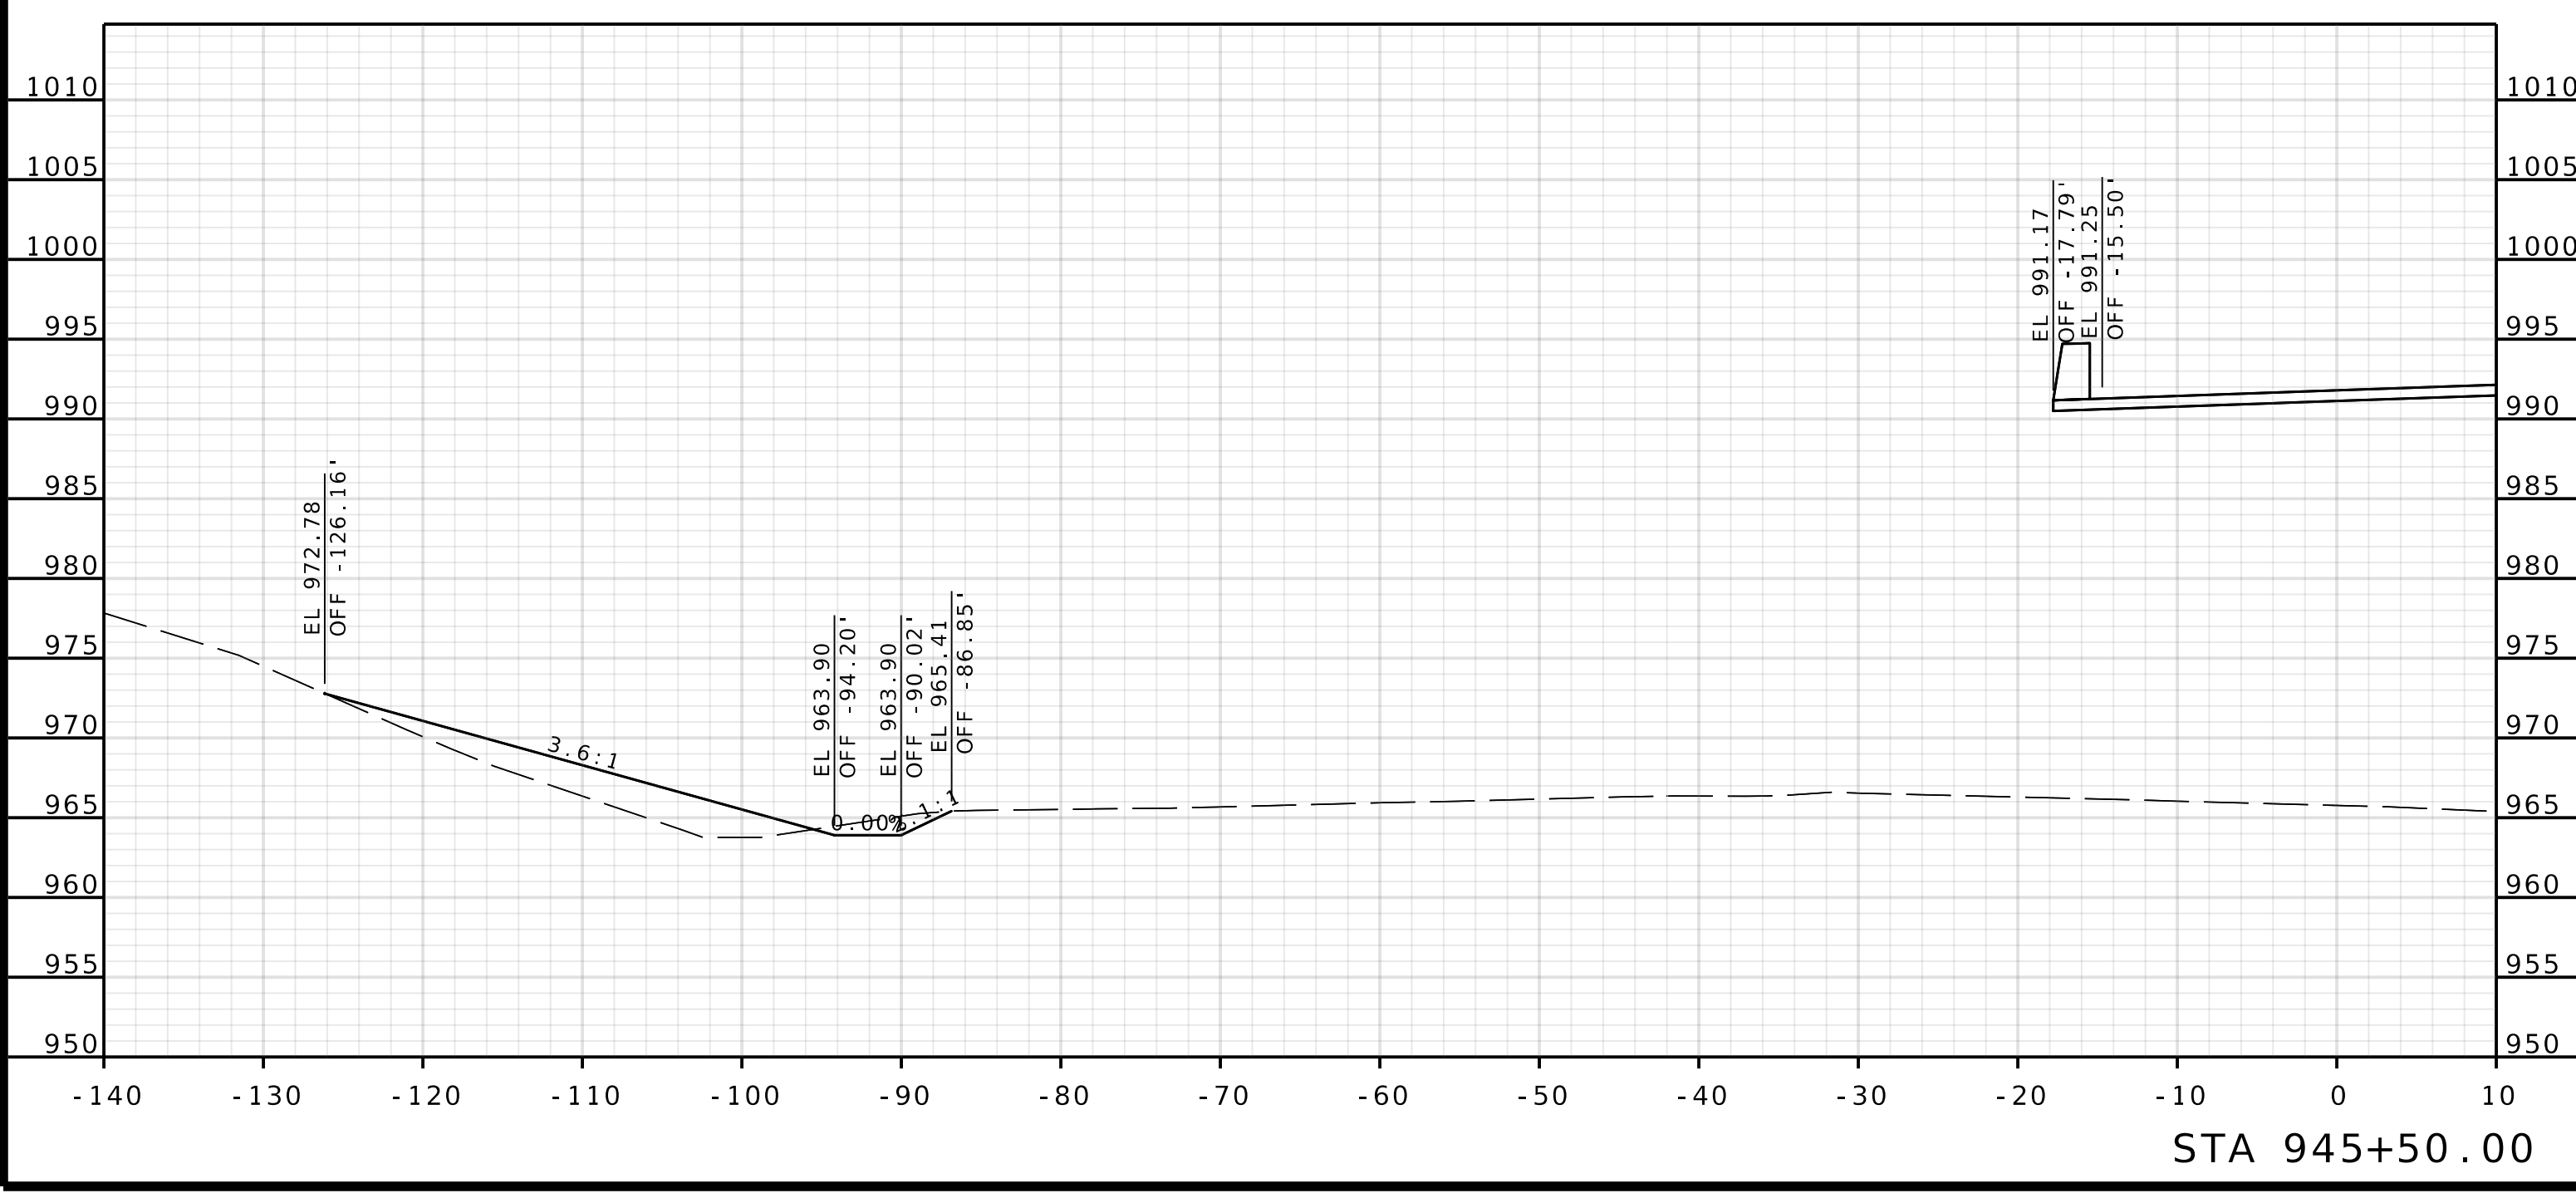
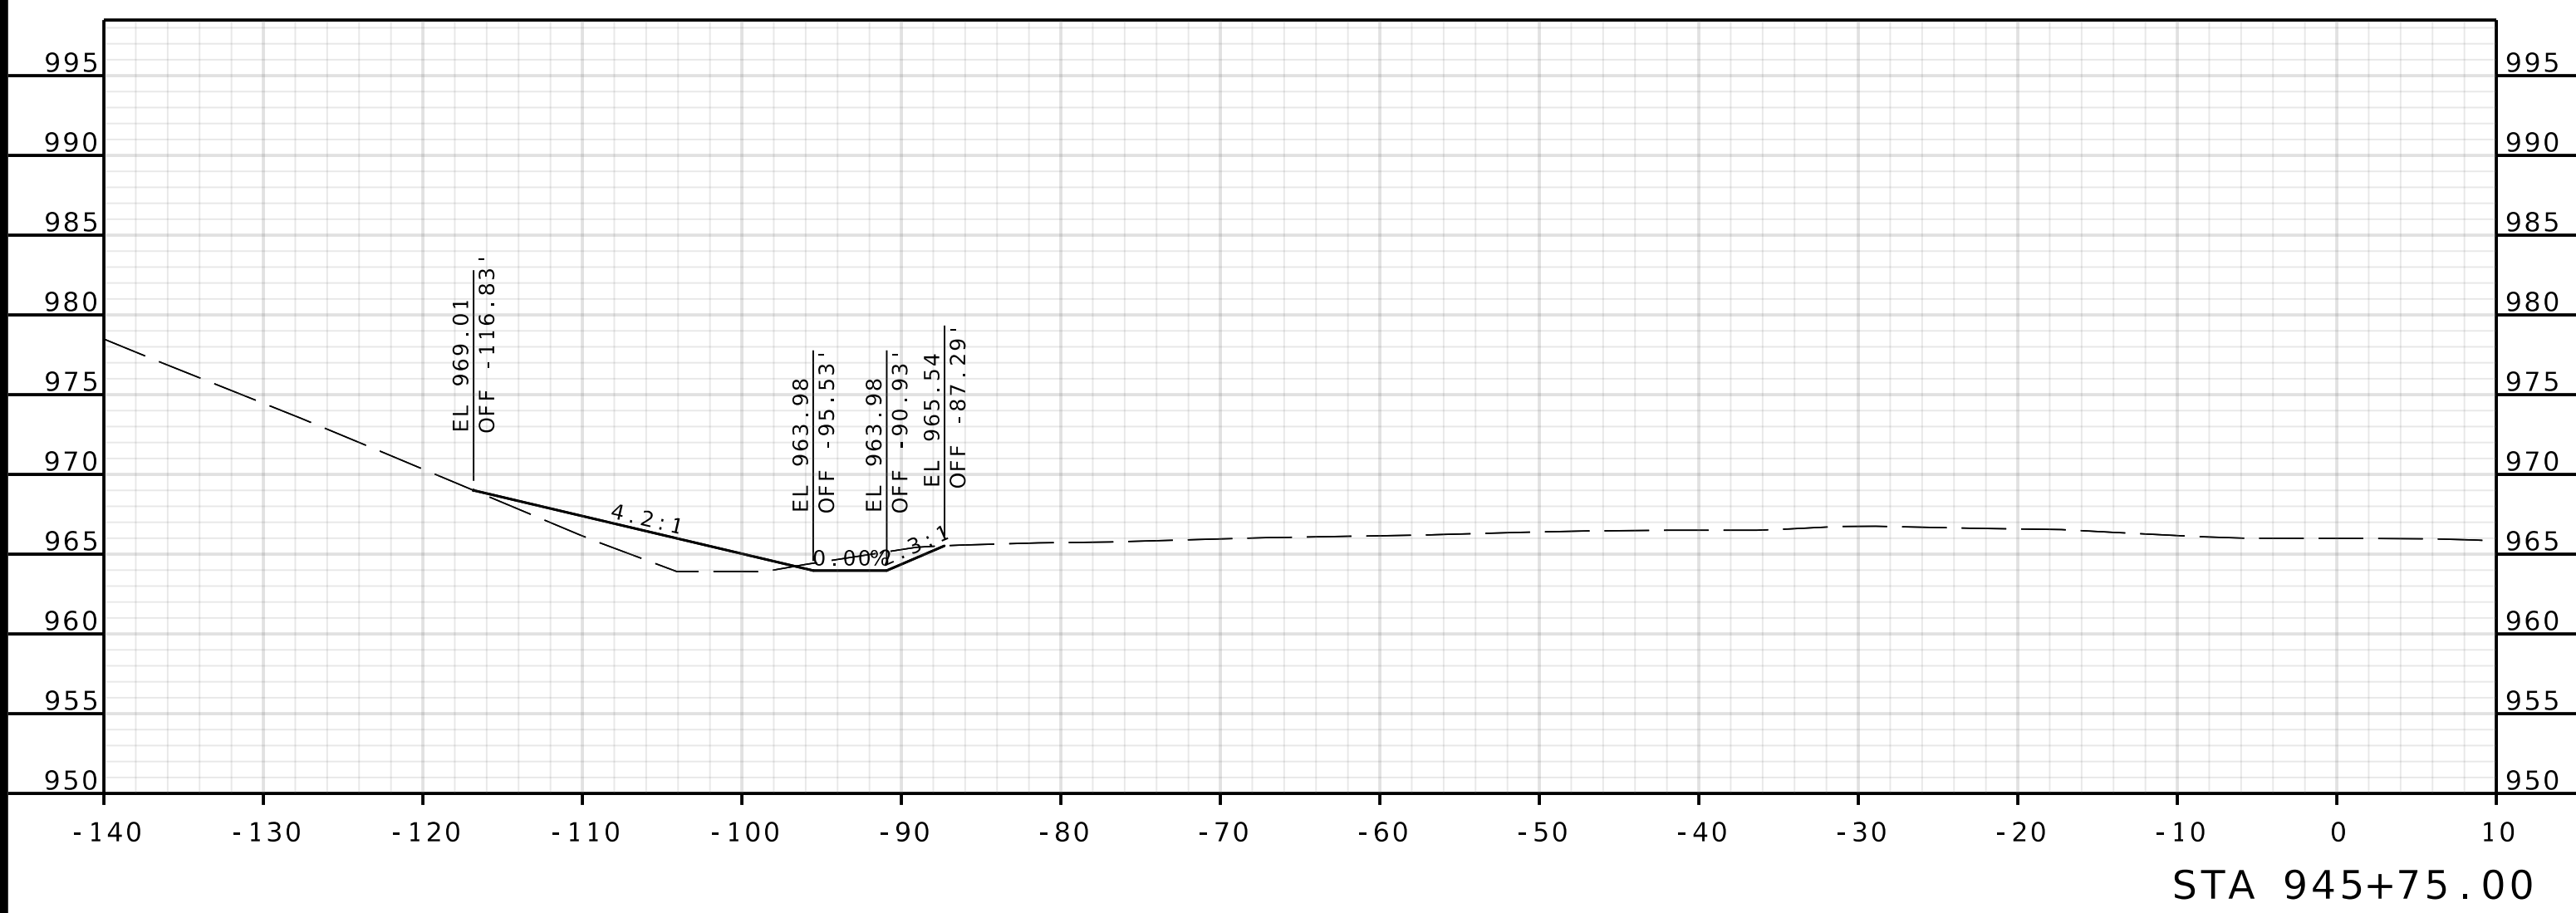


ROUTE I - 435
WBL


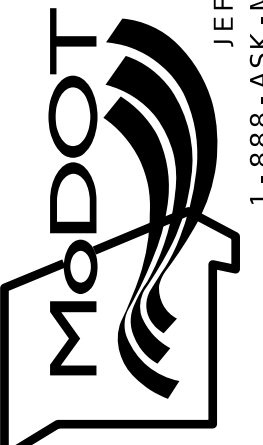
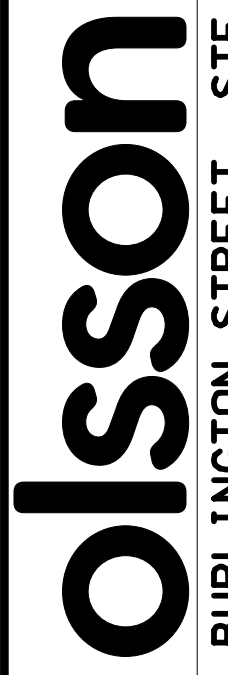
DATE PREPARED 4/30/2025	
ROUTE 1435	STATE MO
DISTRICT KC	SHEET NO. 8
COUNTY PLATTE	
JOB NO. J4S3489	
CONTRACT ID.	
PROJECT NO.	
BRIDGE NO. A9700	
DATE	DESCRIPTION
MISSOURI HIGHWAYS AND TRANSPORTATION COMMISSION	
	
105 WEST CAPITOL JEFFERSON CITY, MO 65102 1-888-ASK-MODOT (1-888-275-6636)	
	
1301 BURLINGTON STREET, STE. 100 NORTH KANSAS CITY, MO 64116 PHONE: 816.361.1177 CERTIFICATE OF AUTHORITY NO. 001592	

IF A SEAL IS PRESENT ON THIS SHEET IT HAS BEEN ELECTRONICALLY SEALED AND DATED.

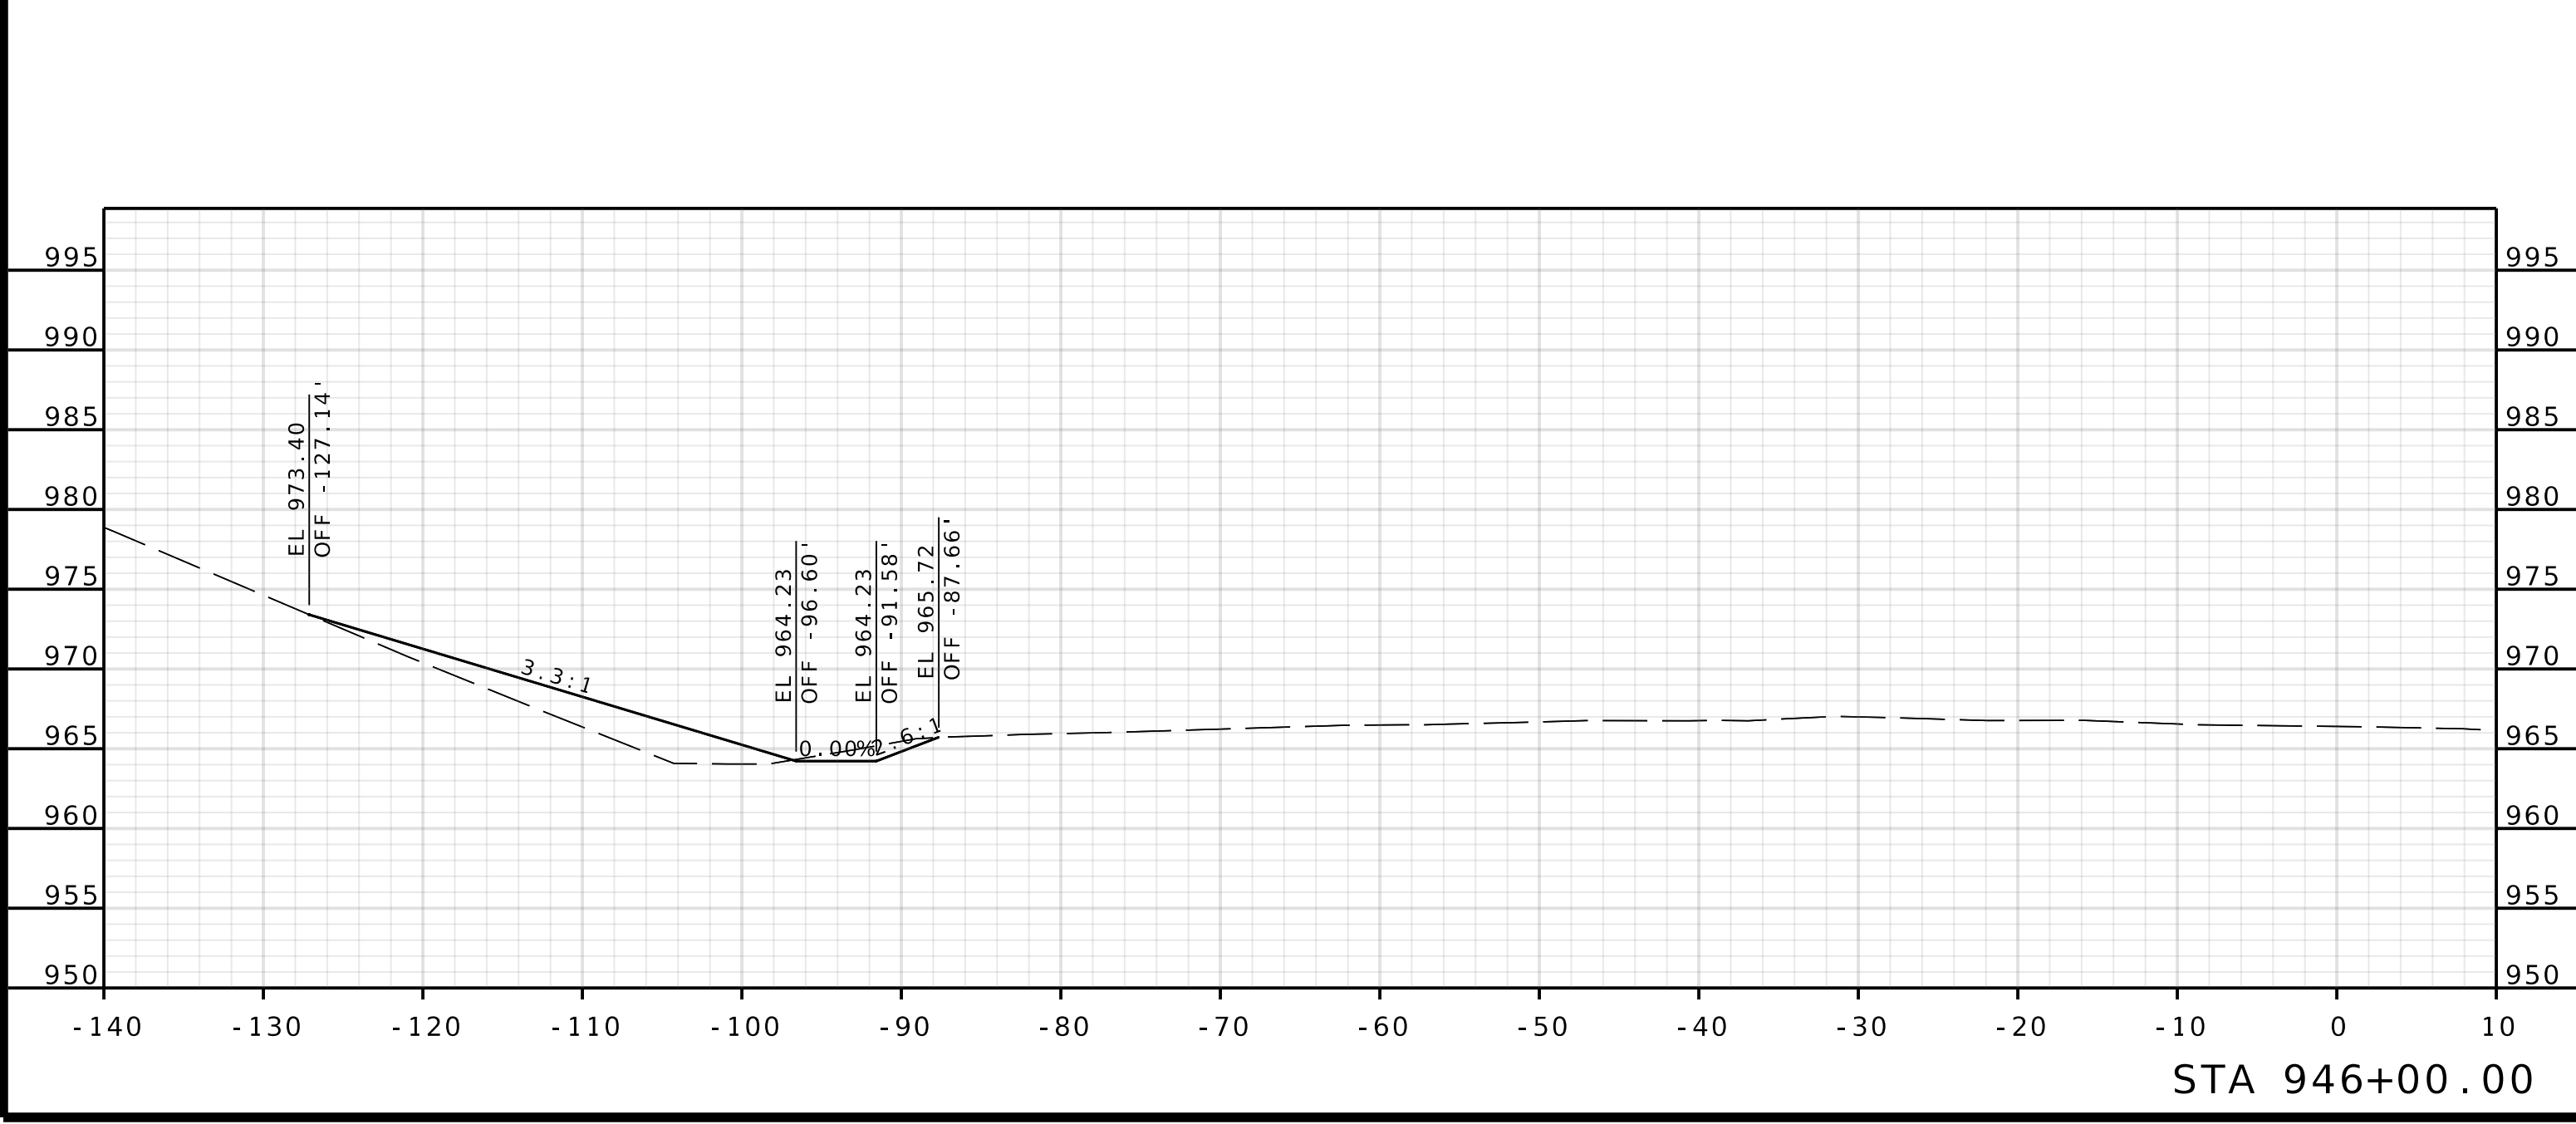
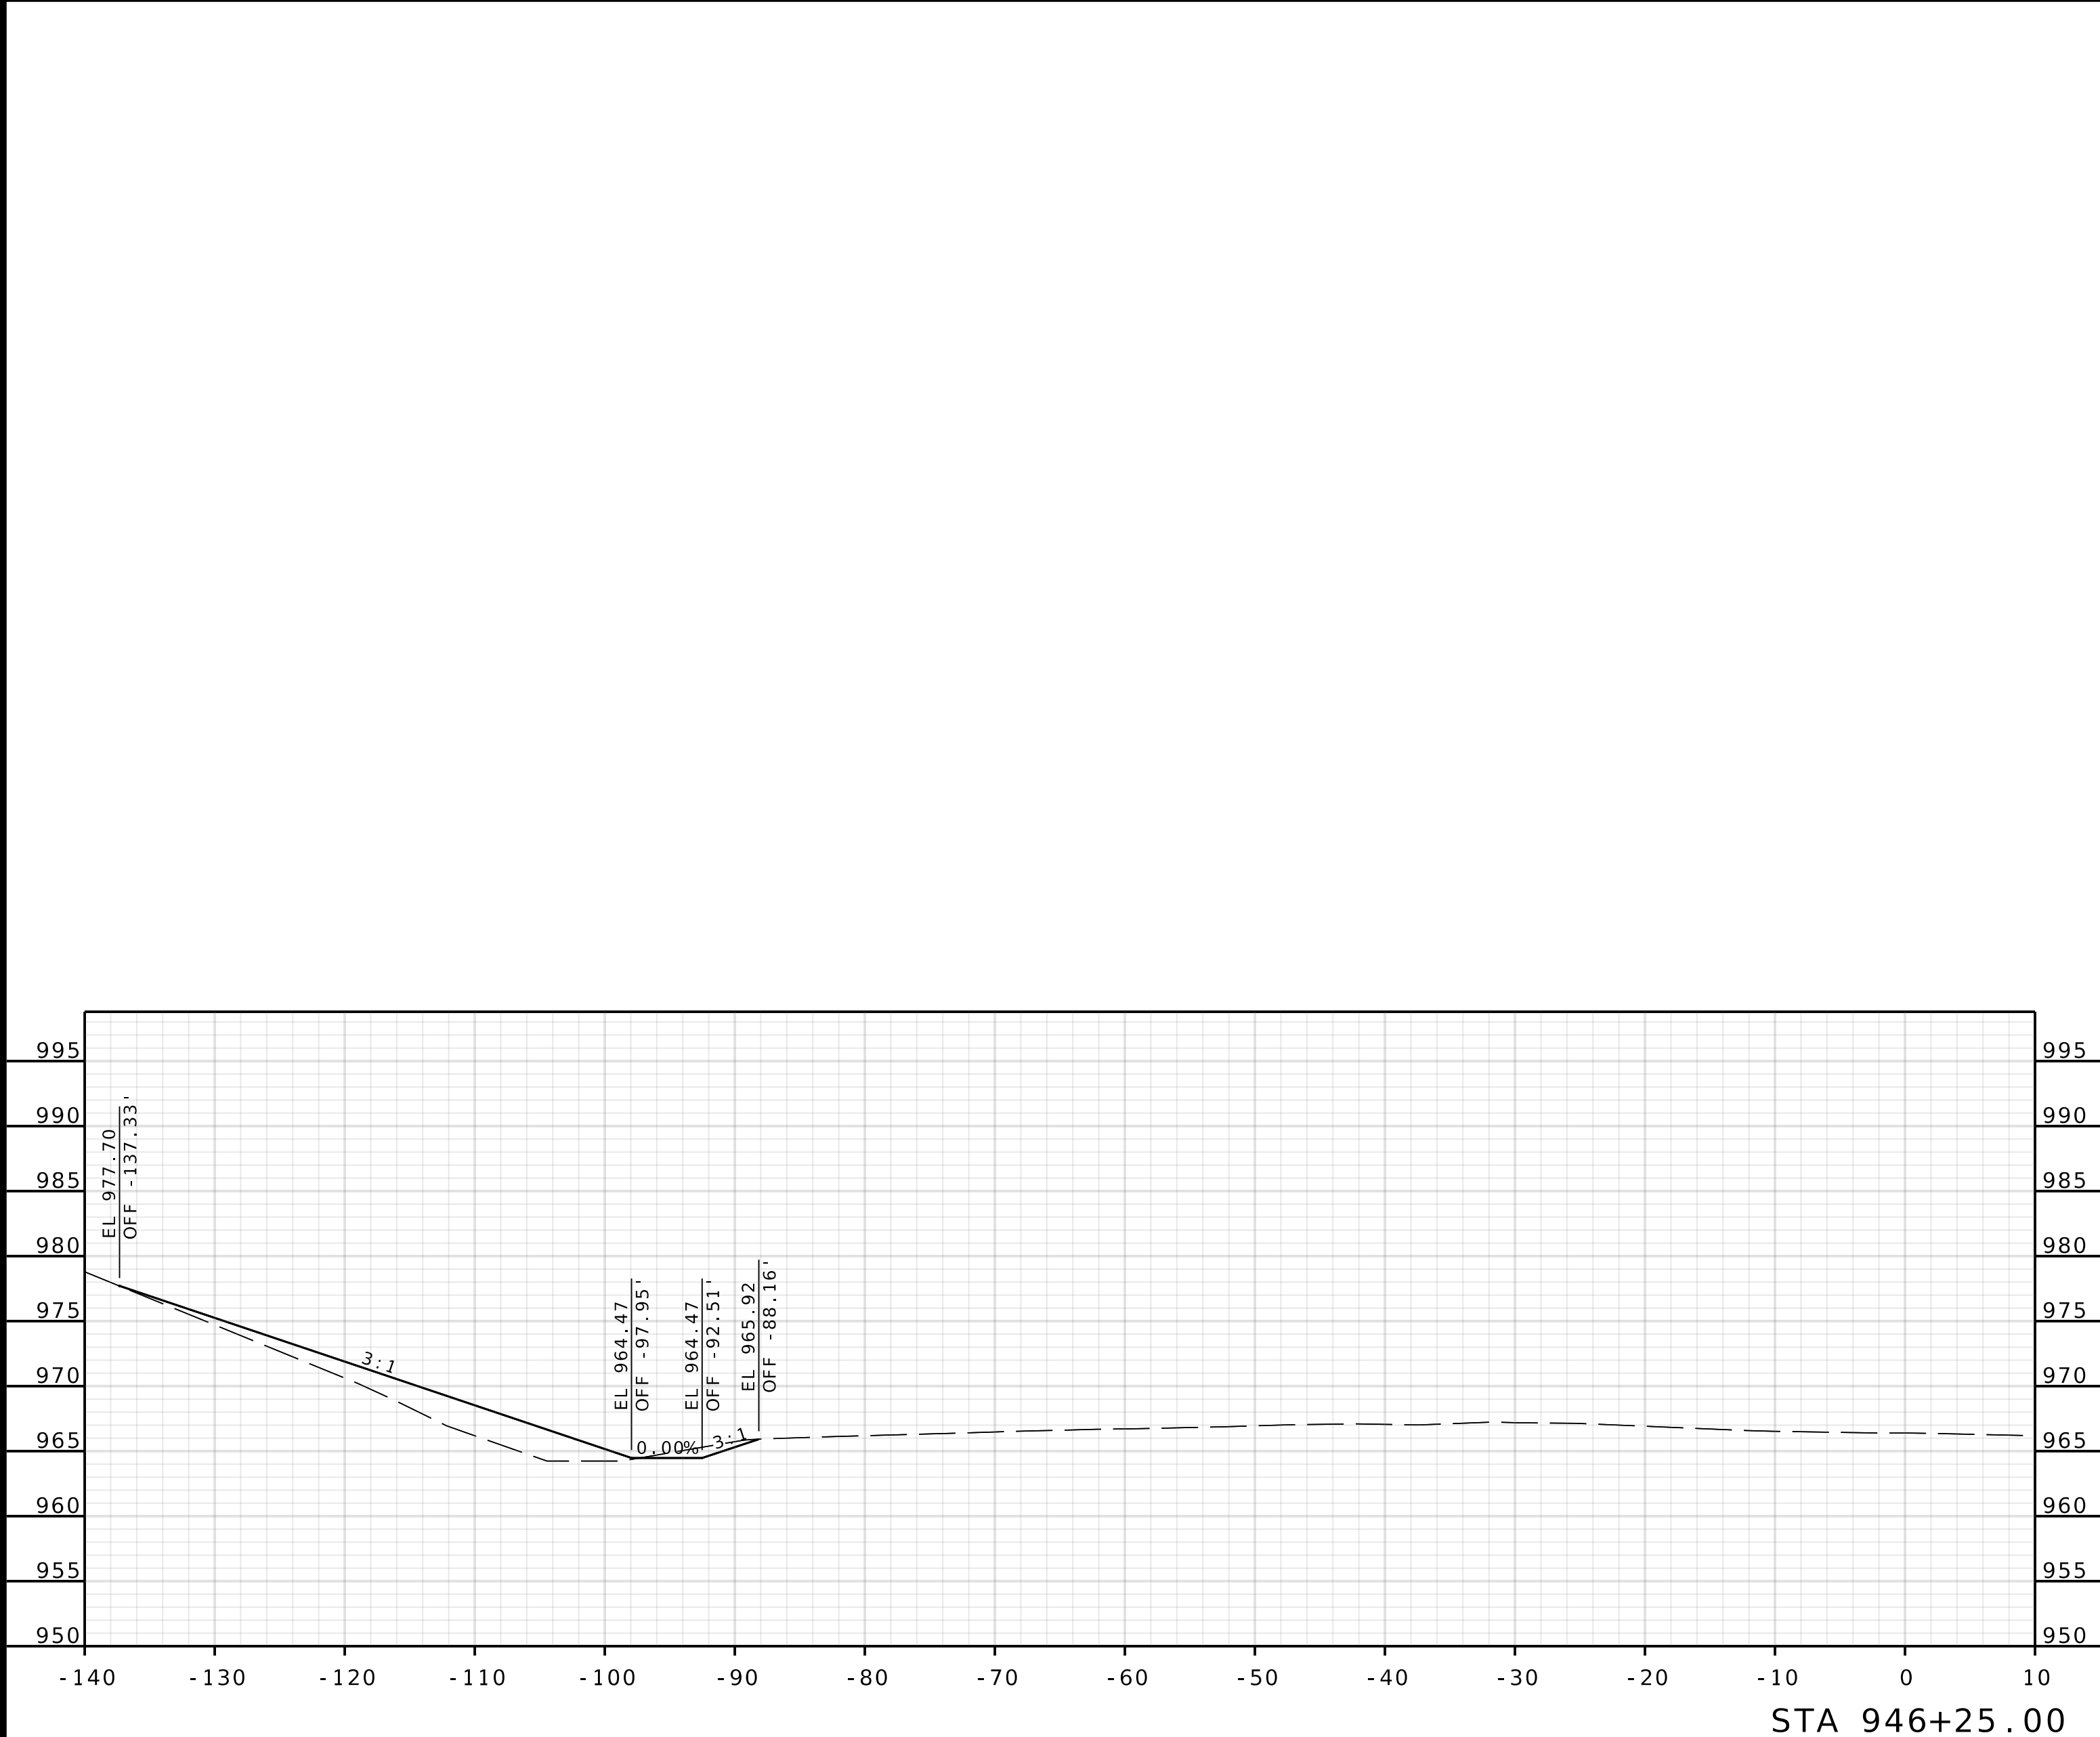


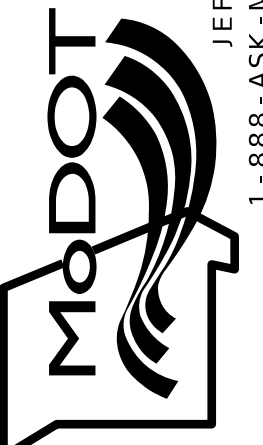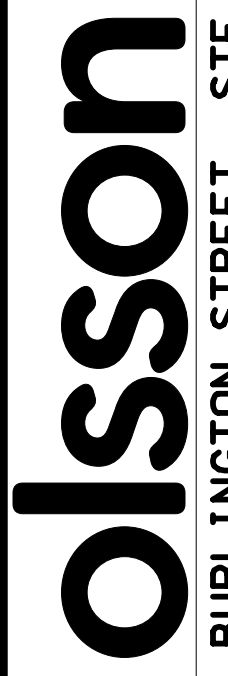DATE PREPARED 4/30/2025	
ROUTE 1435	STATE MO
DISTRICT KC	SHEET NO. 9
COUNTY PLATTE	
JOB NO. J4S3489	
CONTRACT ID.	
PROJECT NO.	
BRIDGE NO. A9700	
DATE	DESCRIPTION
MISSOURI HIGHWAYS AND TRANSPORTATION COMMISSION	
	
105 WEST CAPITOL JEFFERSON CITY, MO 65102 1-888-ASK-MODOT (1-888-275-6636)	
	
1301 BURLINGTON STREET, STE. 100 NORTH KANSAS CITY, MO 64116 PHONE: 816.361.1177 CERTIFICATE OF AUTHORITY NO. 001592	
ROUTE I - 435 WBL	




IF A SEAL IS PRESENT ON THIS SHEET IT HAS BEEN ELECTRONICALLY SEALED AND DATED.

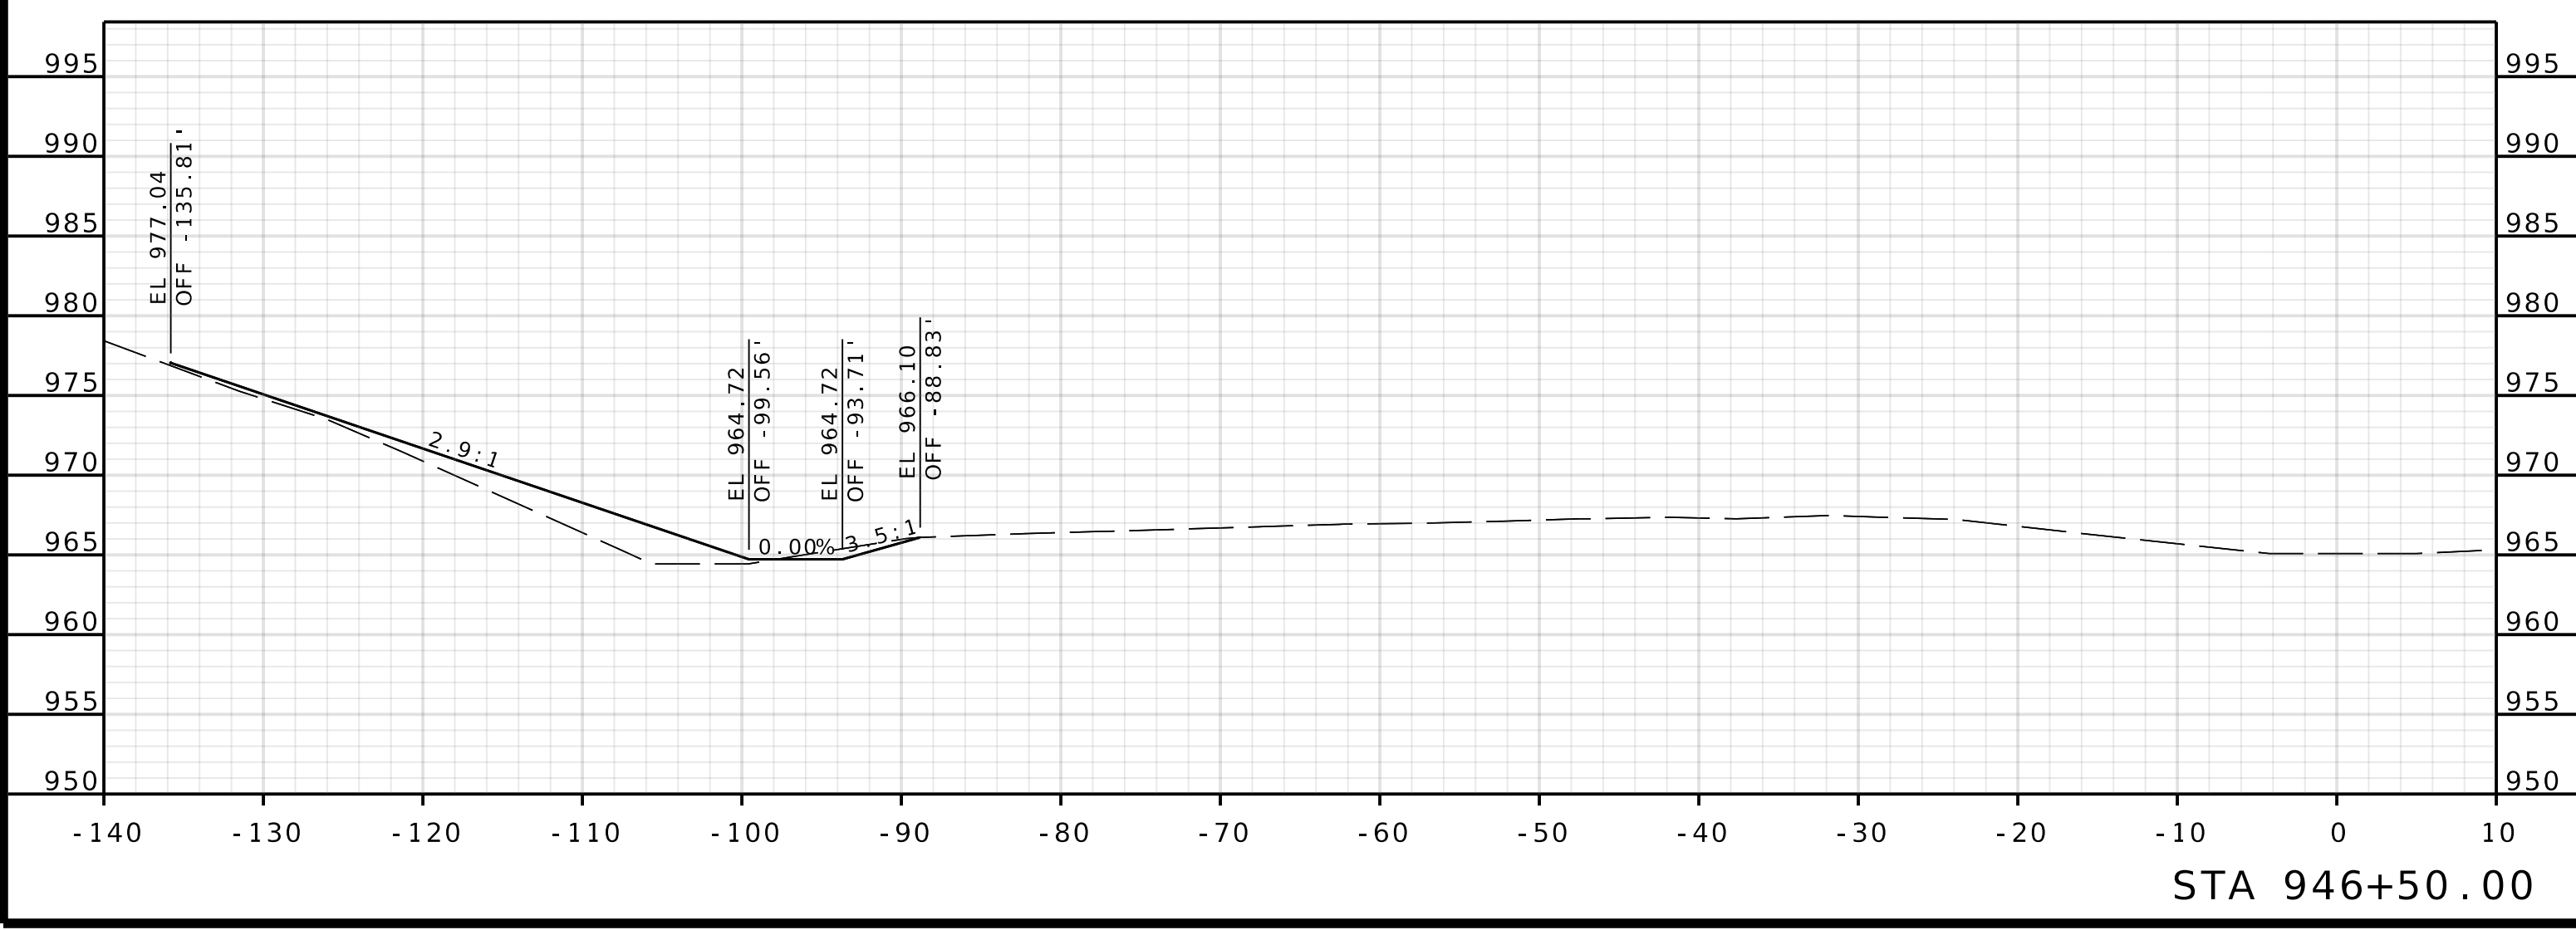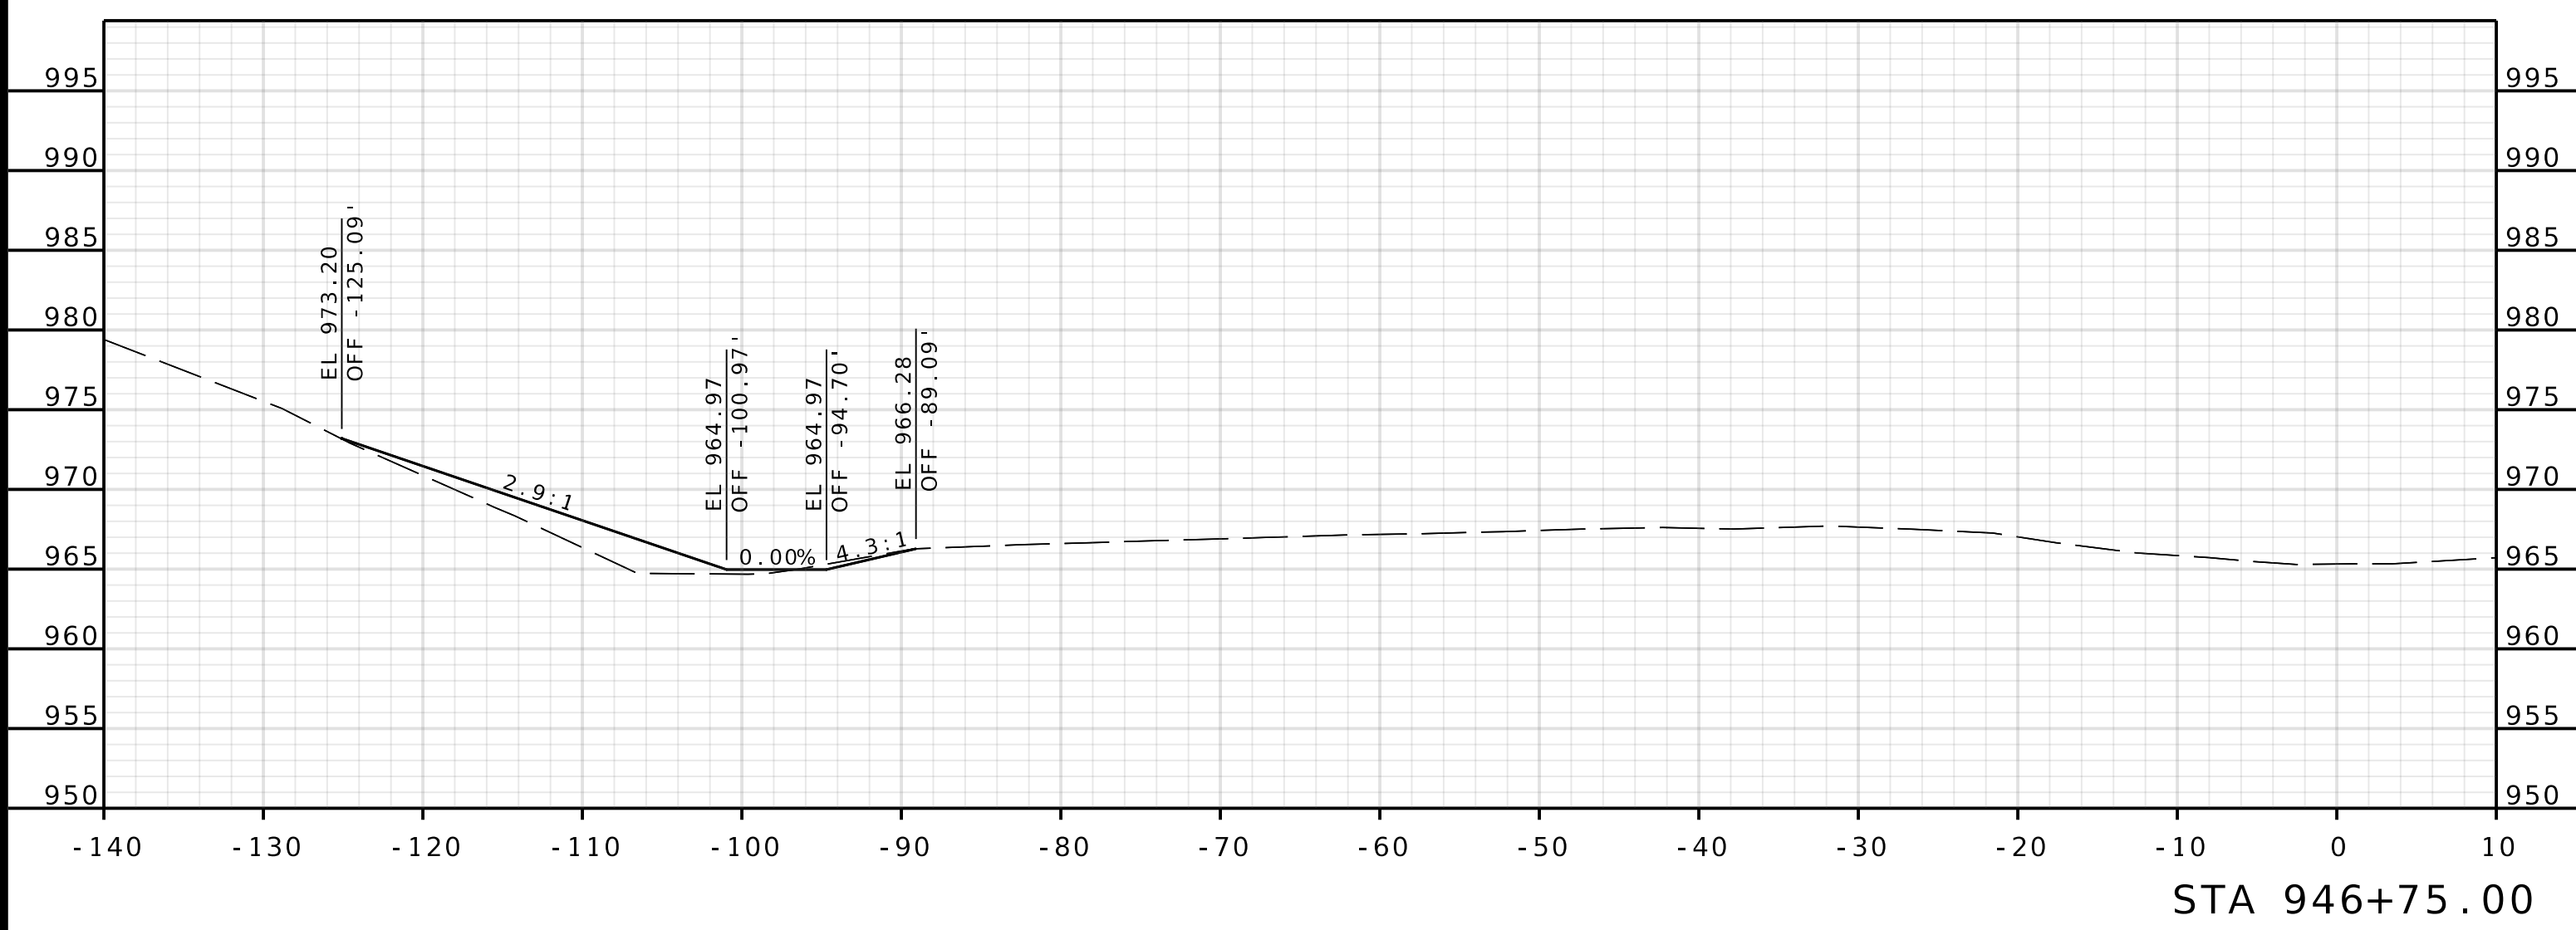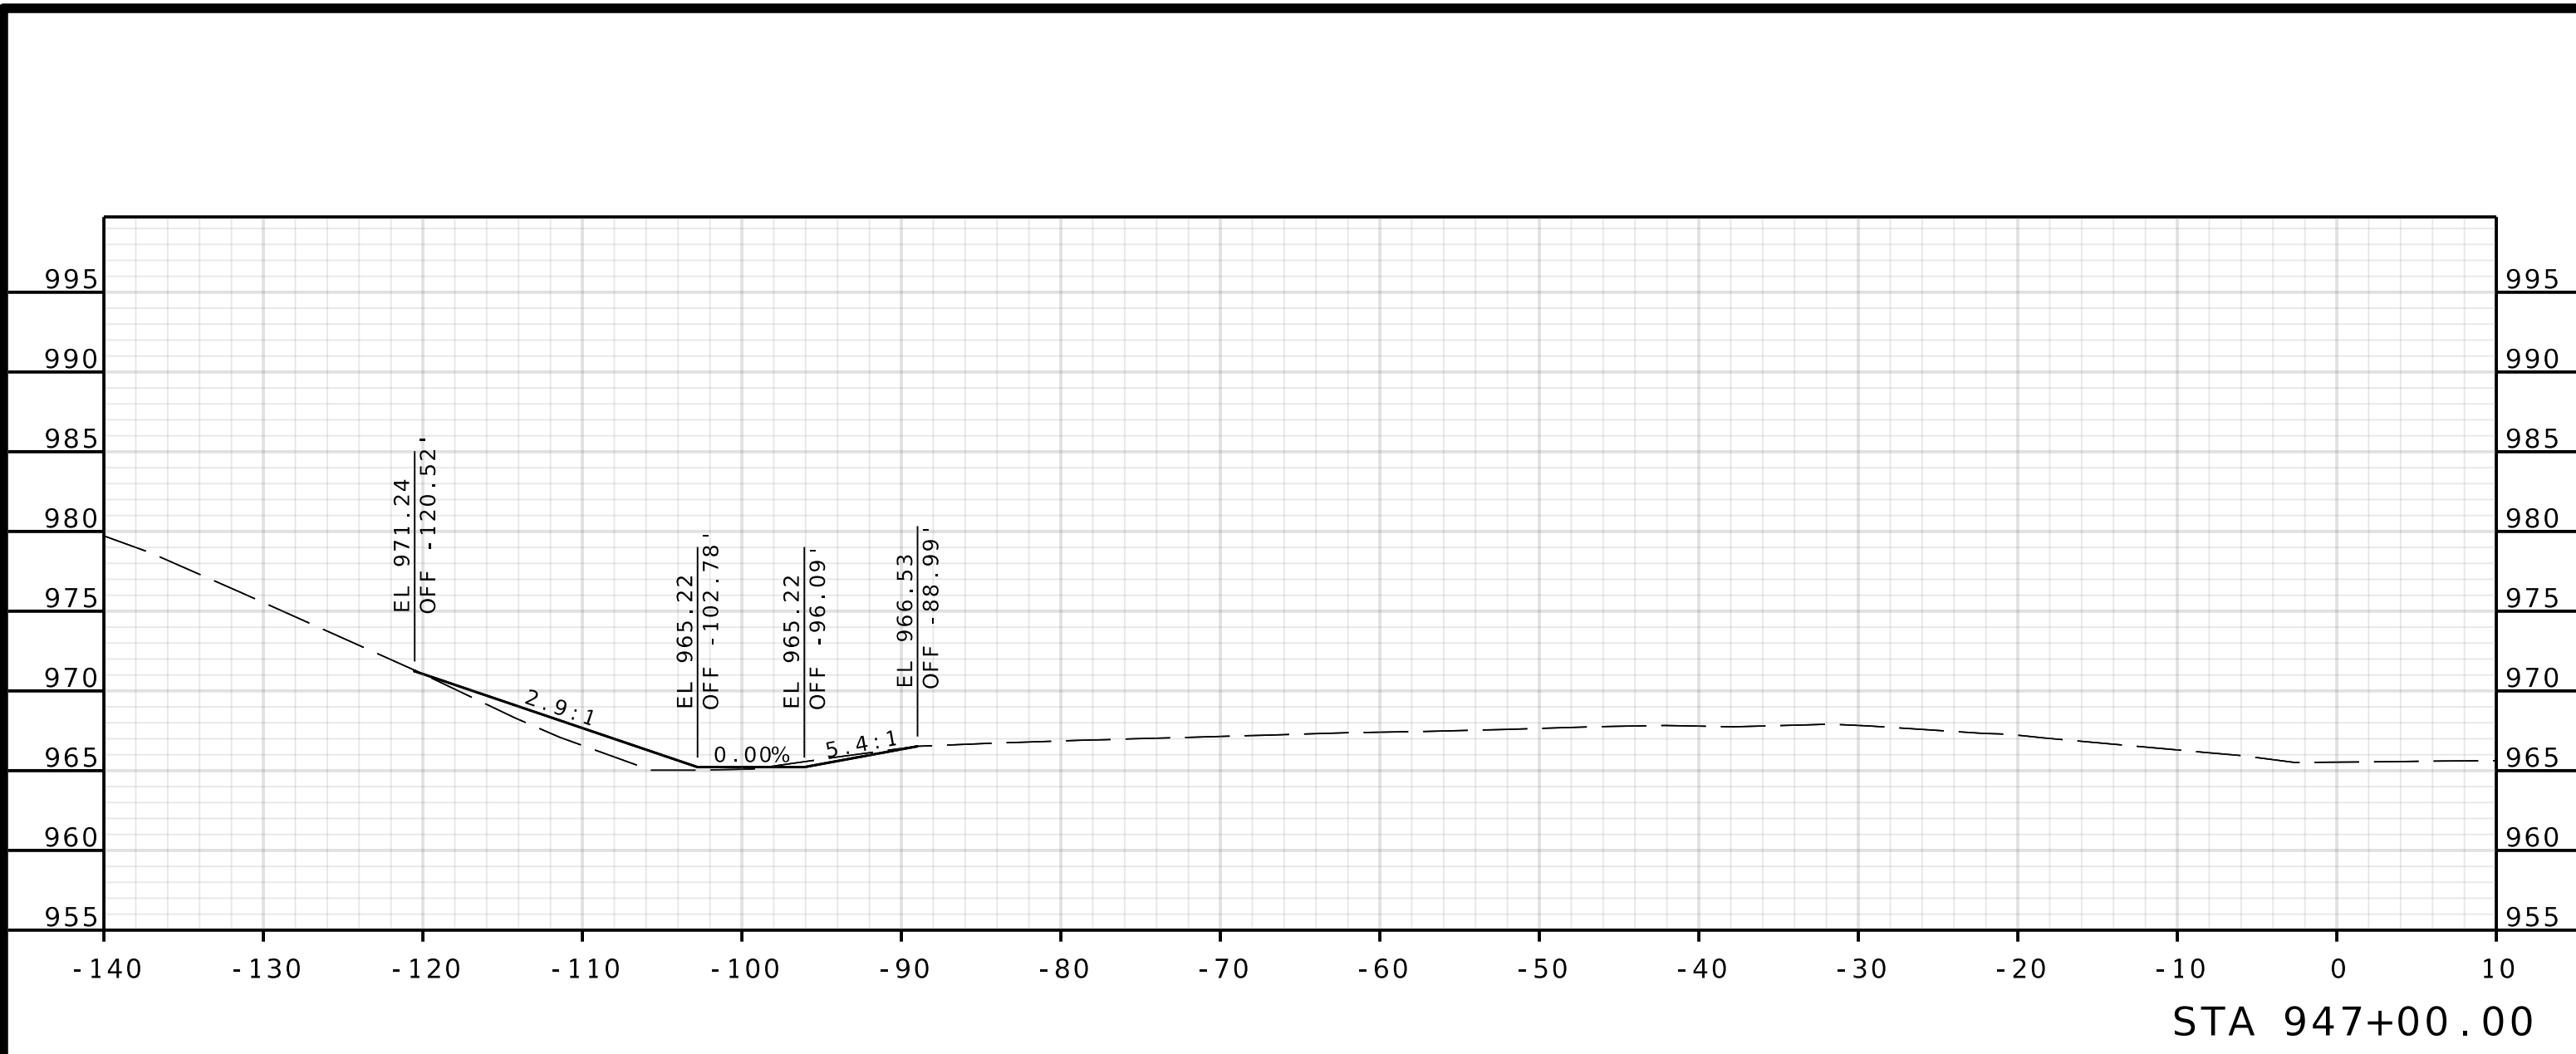



ROUTE I-435
WBL

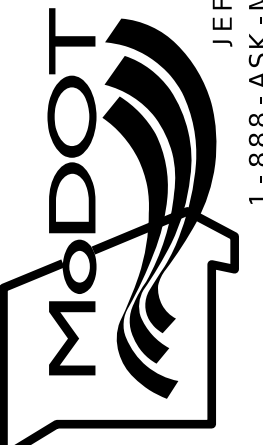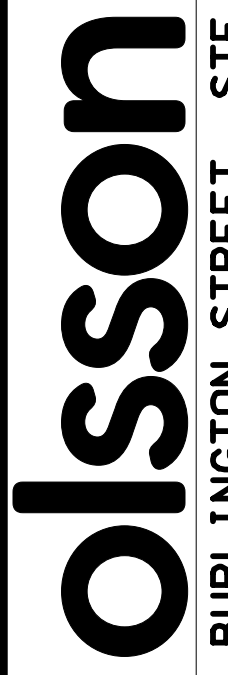DATE PREPARED 4/30/2025	
ROUTE 1435	STATE MO
DISTRICT KC	SHEET NO. 10
COUNTY PLATTE	
JOB NO. J4S3489	
CONTRACT ID.	
PROJECT NO.	
BRIDGE NO. A9700	
DATE	DESCRIPTION
MISSOURI HIGHWAYS AND TRANSPORTATION COMMISSION	
 105 WEST CAPITOL JEFFERSON CITY, MO 65102 1-888-ASK-MODOT (1-888-275-6636)	
 1301 BURLINGTON STREET, STE. 100 NORTH KANSAS CITY, MO 64116 PHONE: 816.361.1177 CERTIFICATE OF AUTHORITY NO. 001592	


IF A SEAL IS PRESENT ON THIS SHEET IT HAS BEEN ELECTRONICALLY SEALED AND DATED.

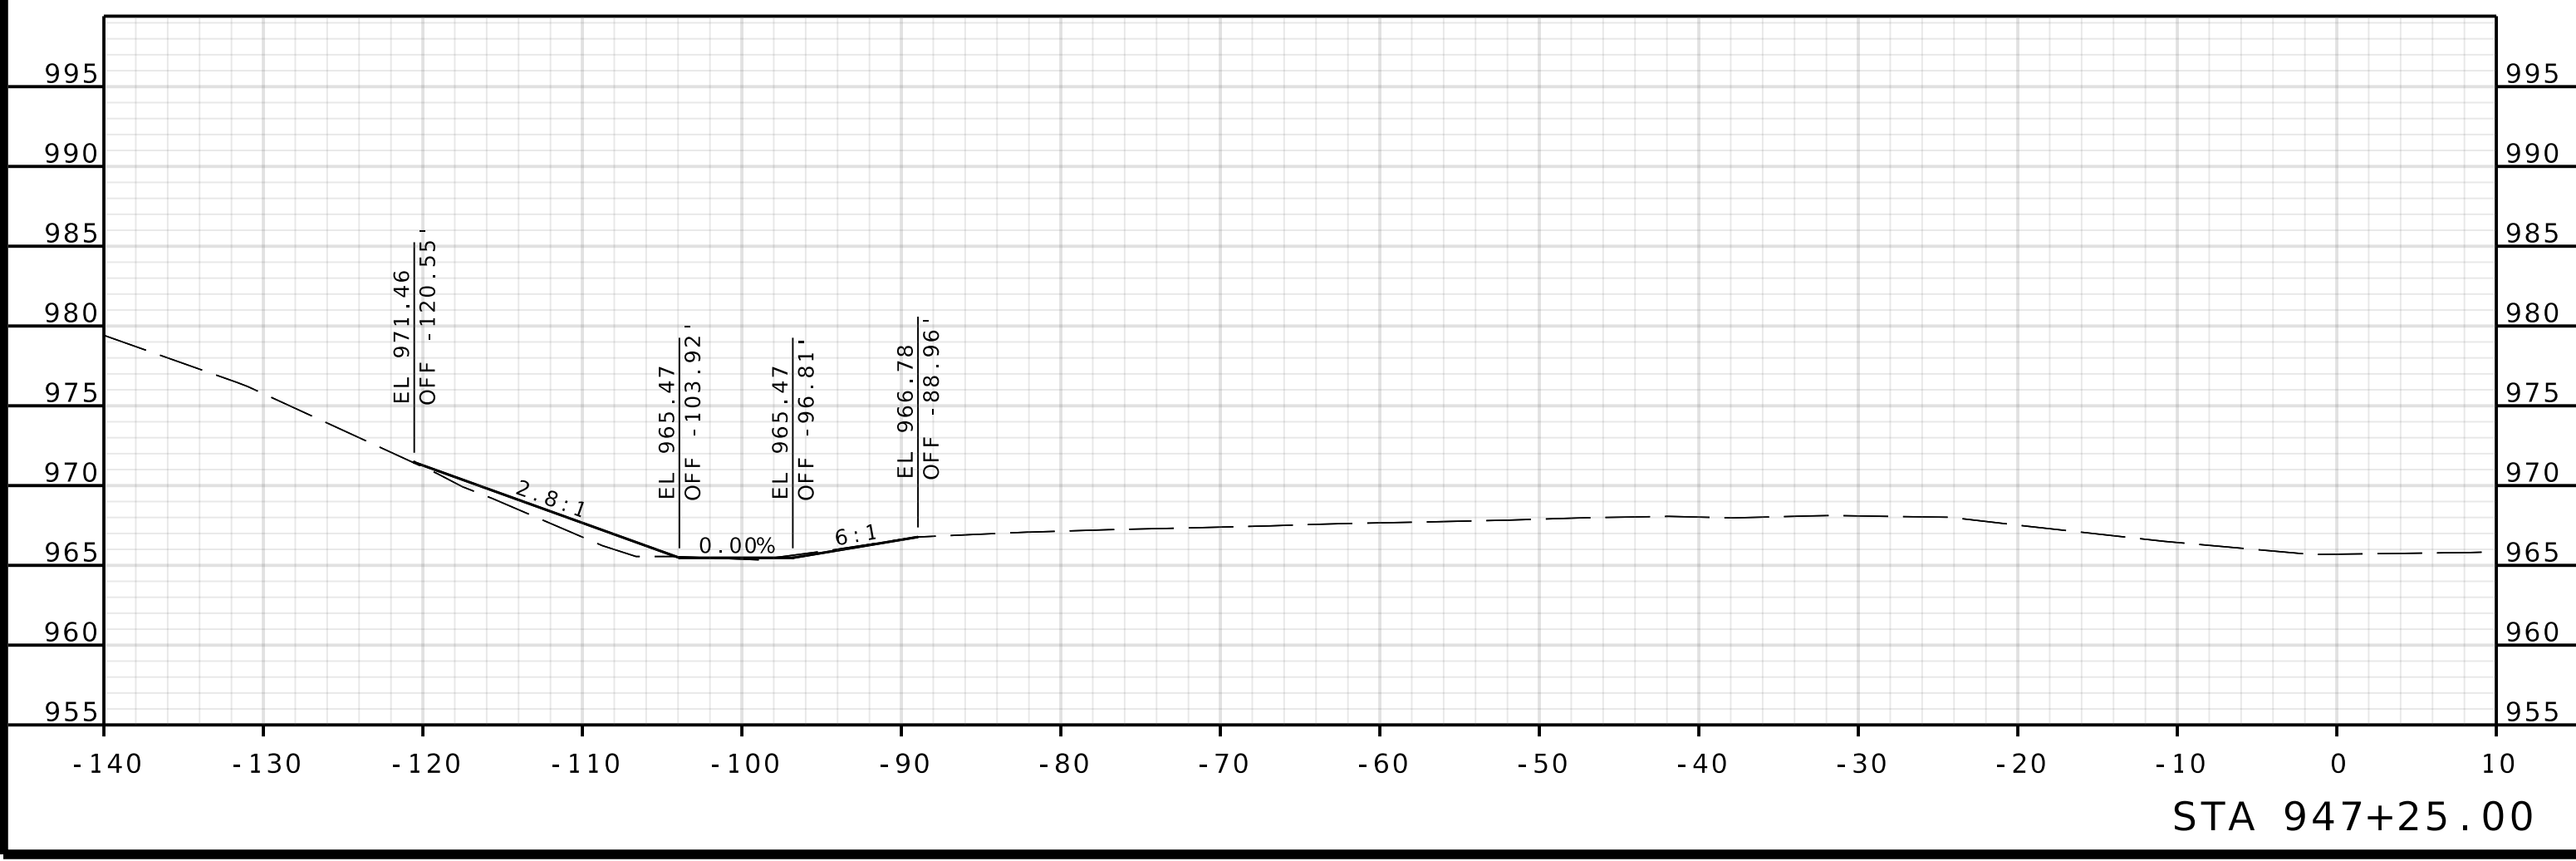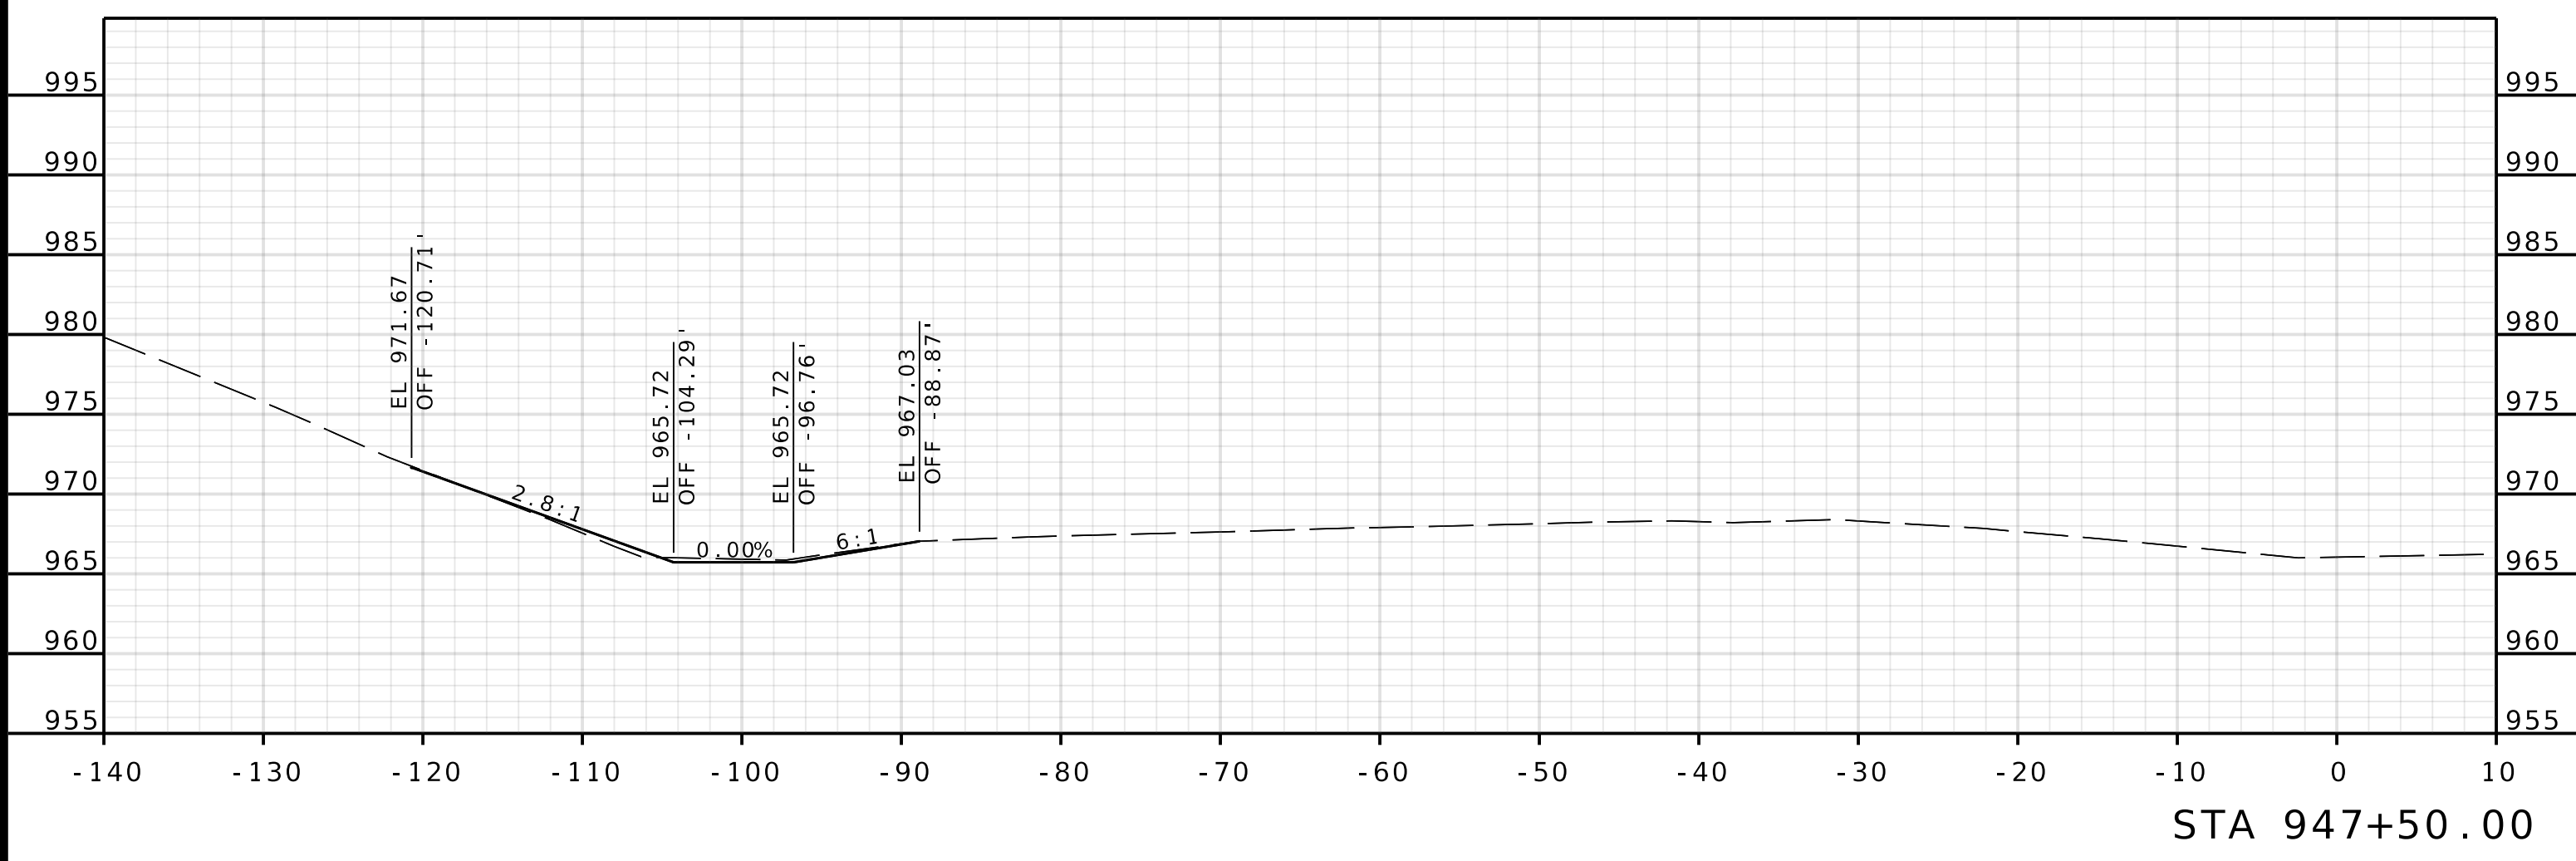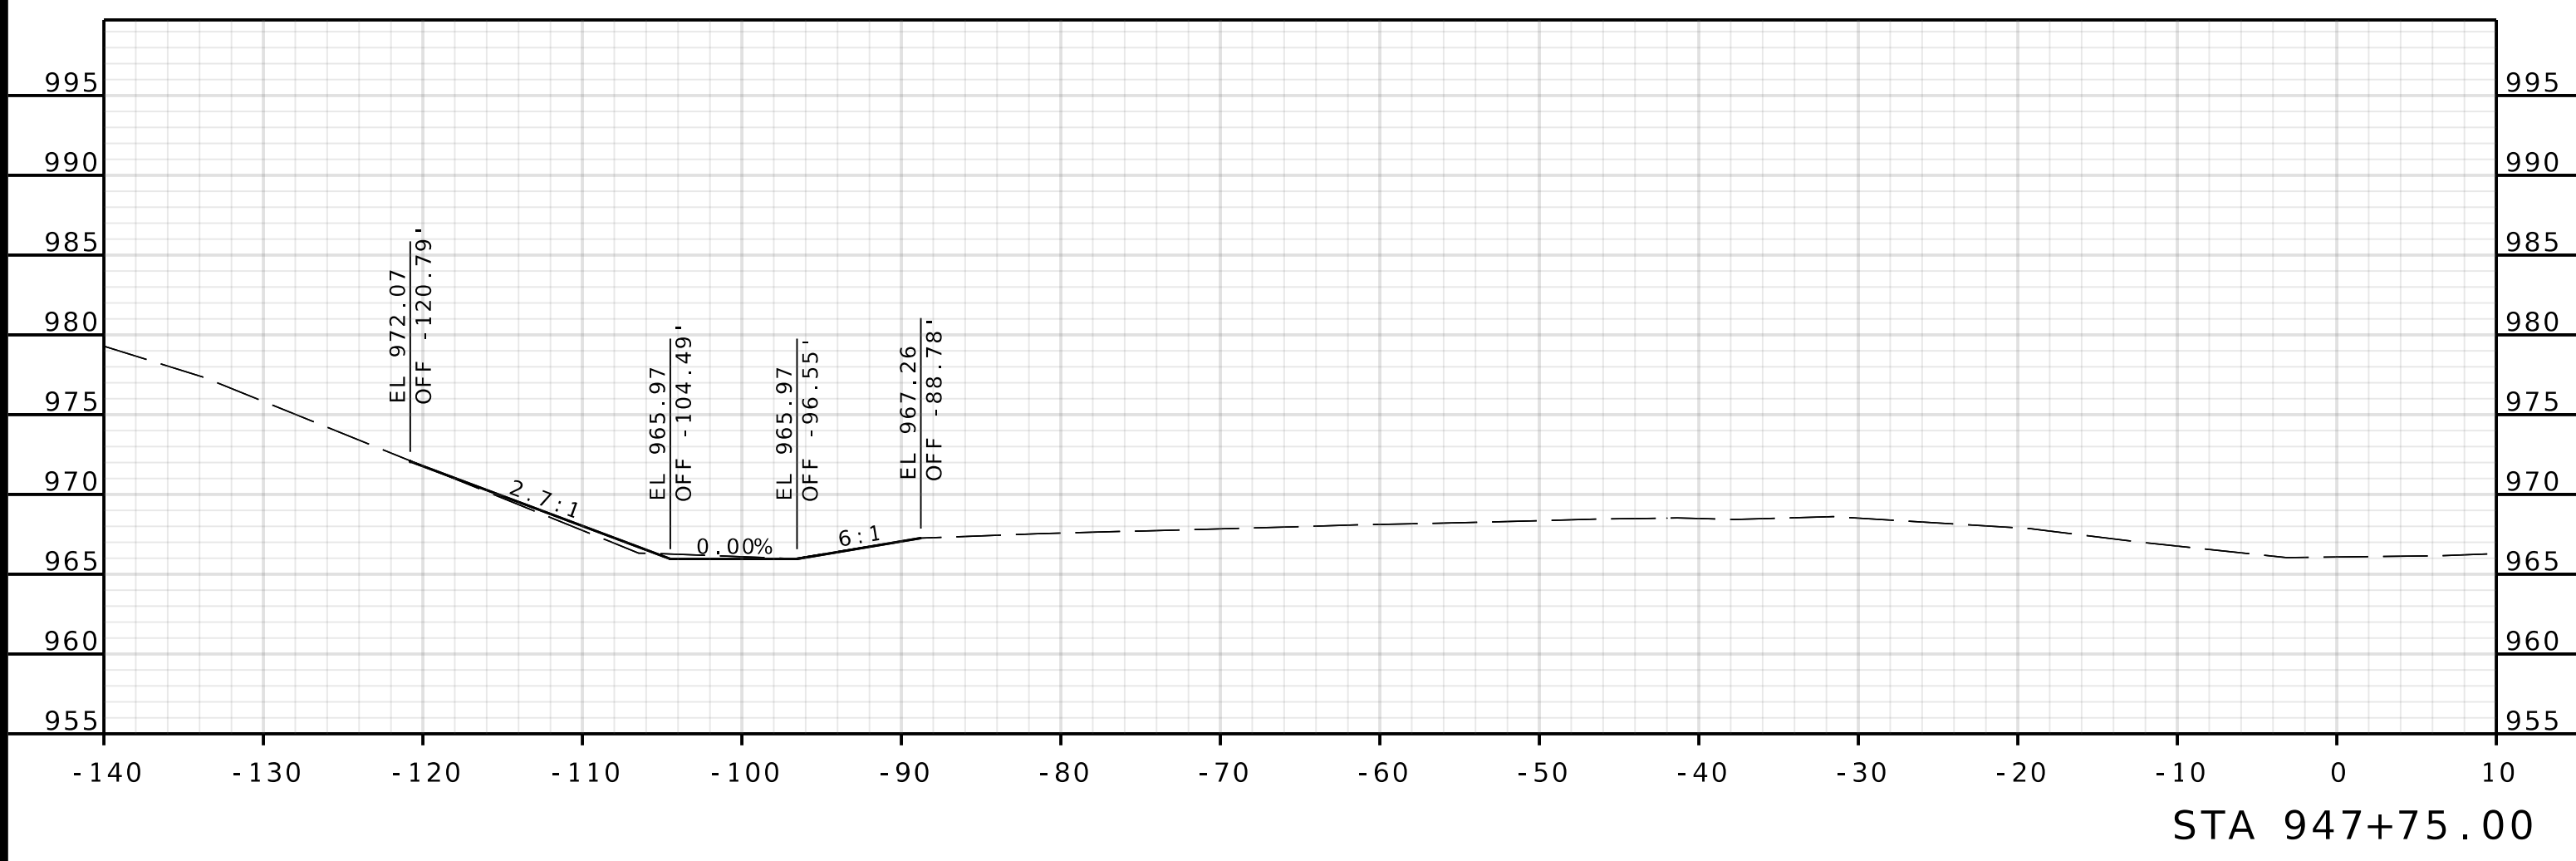

ROUTE I - 435
WBL

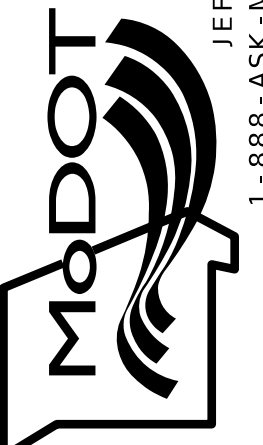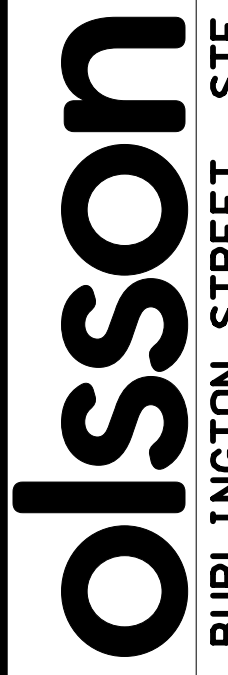DATE PREPARED 4/30/2025	
ROUTE 1435	STATE MO
DISTRICT KC	SHEET NO. 11
COUNTY PLATTE	
JOB NO. J4S3489	
CONTRACT ID.	
PROJECT NO.	
BRIDGE NO. A9700	
DATE	DESCRIPTION
MISSOURI HIGHWAYS AND TRANSPORTATION COMMISSION	
 105 WEST CAPITOL JEFFERSON CITY, MO 65102 1-888-ASK-MODOT (1-888-275-6636)	
 1301 BURLINGTON STREET, STE. 100 NORTH KANSAS CITY, MO 64116 PHONE: 816.361.1177 CERTIFICATE OF AUTHORITY NO. 001592	

IF A SEAL IS PRESENT ON THIS SHEET IT HAS BEEN ELECTRONICALLY SEALED AND DATED.

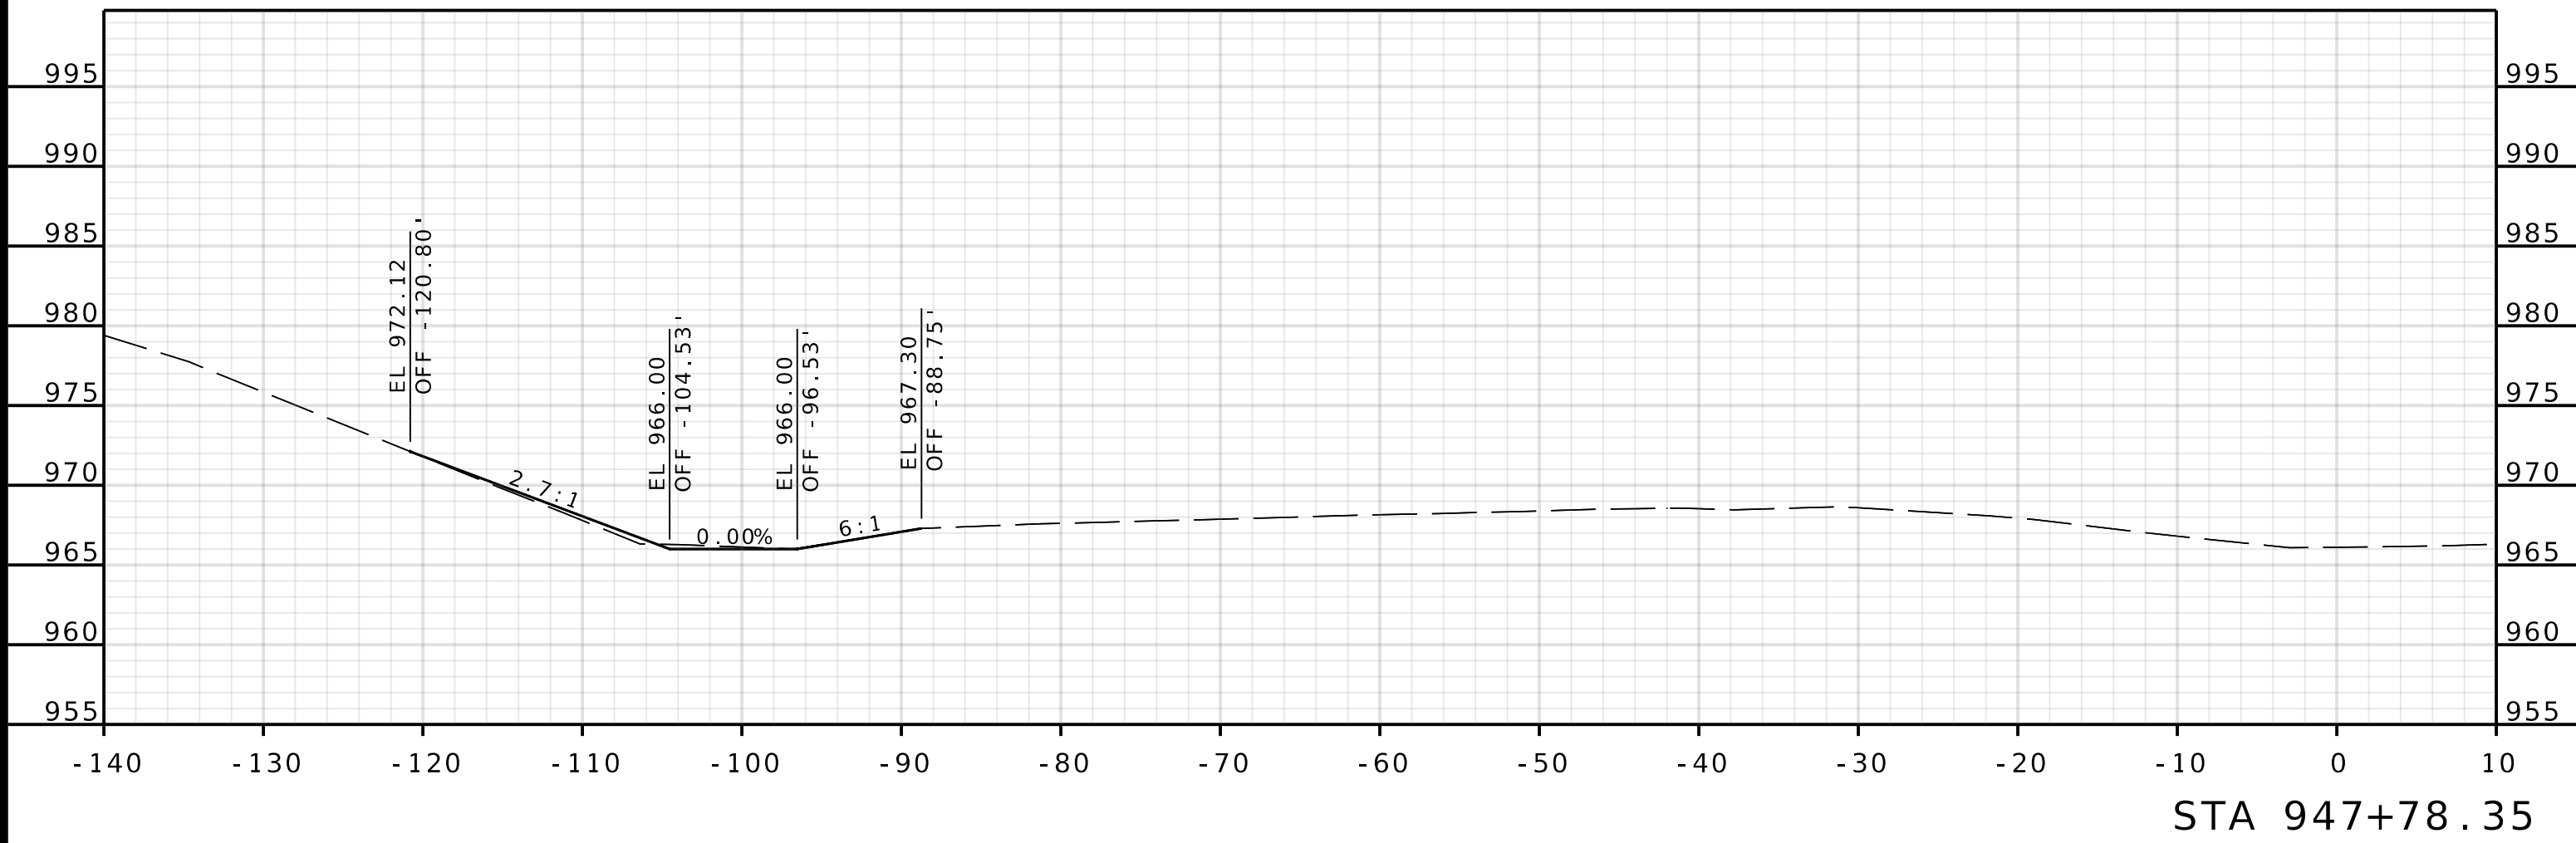


STA 947+78.35

ROUTE I - 435
WBL

DATE PREPARED 4/30/2025	
ROUTE I 435	STATE MO
DISTRICT KC	SHEET NO. 12
COUNTY PLATTE	
JOB NO. J4S3489	
CONTRACT ID.	
PROJECT NO.	
BRIDGE NO. A9700	
DATE	DESCRIPTION




MISSOURI HIGHWAYS AND TRANSPORTATION COMMISSION

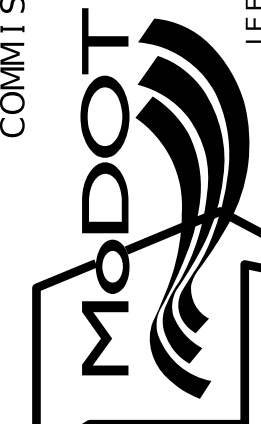

105 WEST CAPITOL
JEFFERSON CITY, MO 65102
1-888-ASK-MODOT (1-888-275-6636)

Olsson
1301 BURLINGTON STREET, STE. 100
NORTH KANSAS CITY, MO 64116
PHONE: 816.361.1177
CERTIFICATE OF AUTHORITY NO. 001592

IF A SEAL IS PRESENT ON THIS SHEET IT HAS BEEN ELECTRONICALLY SEALED AND DATED.

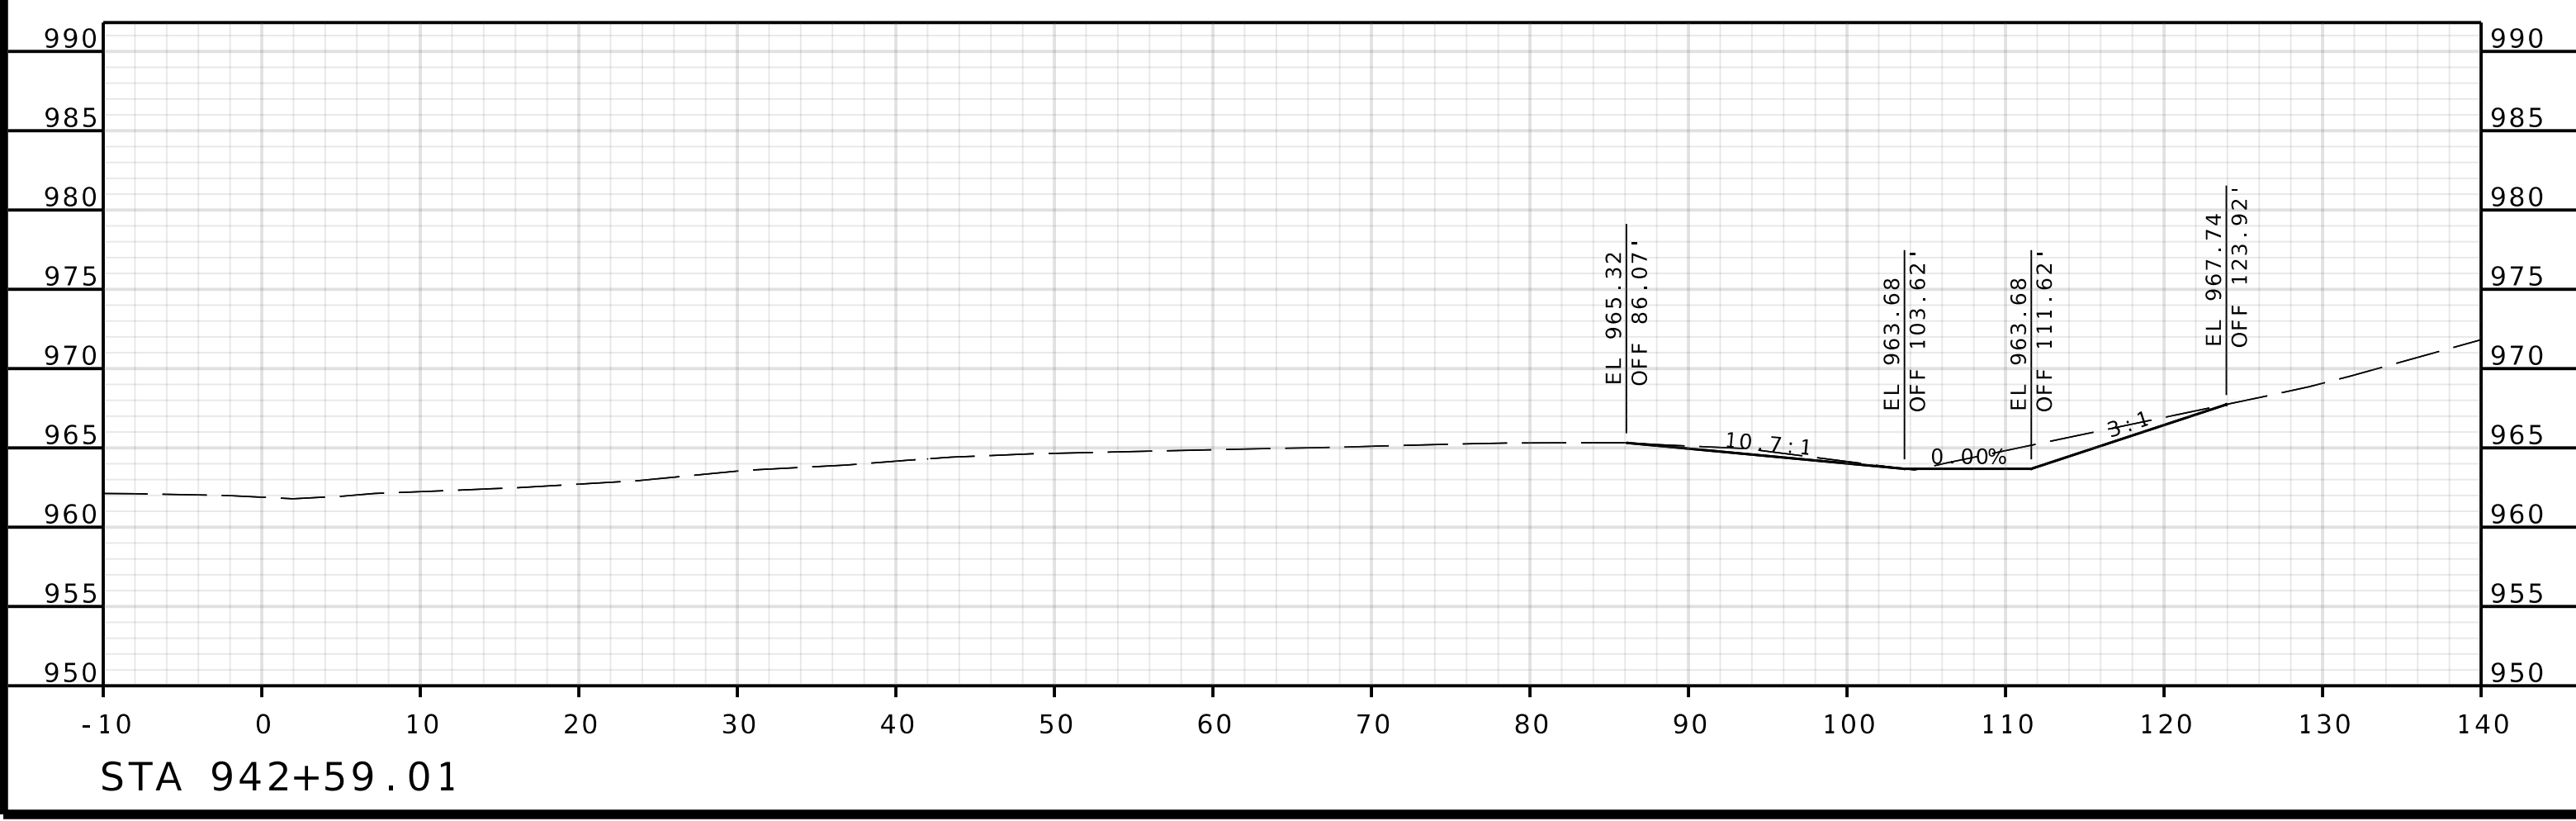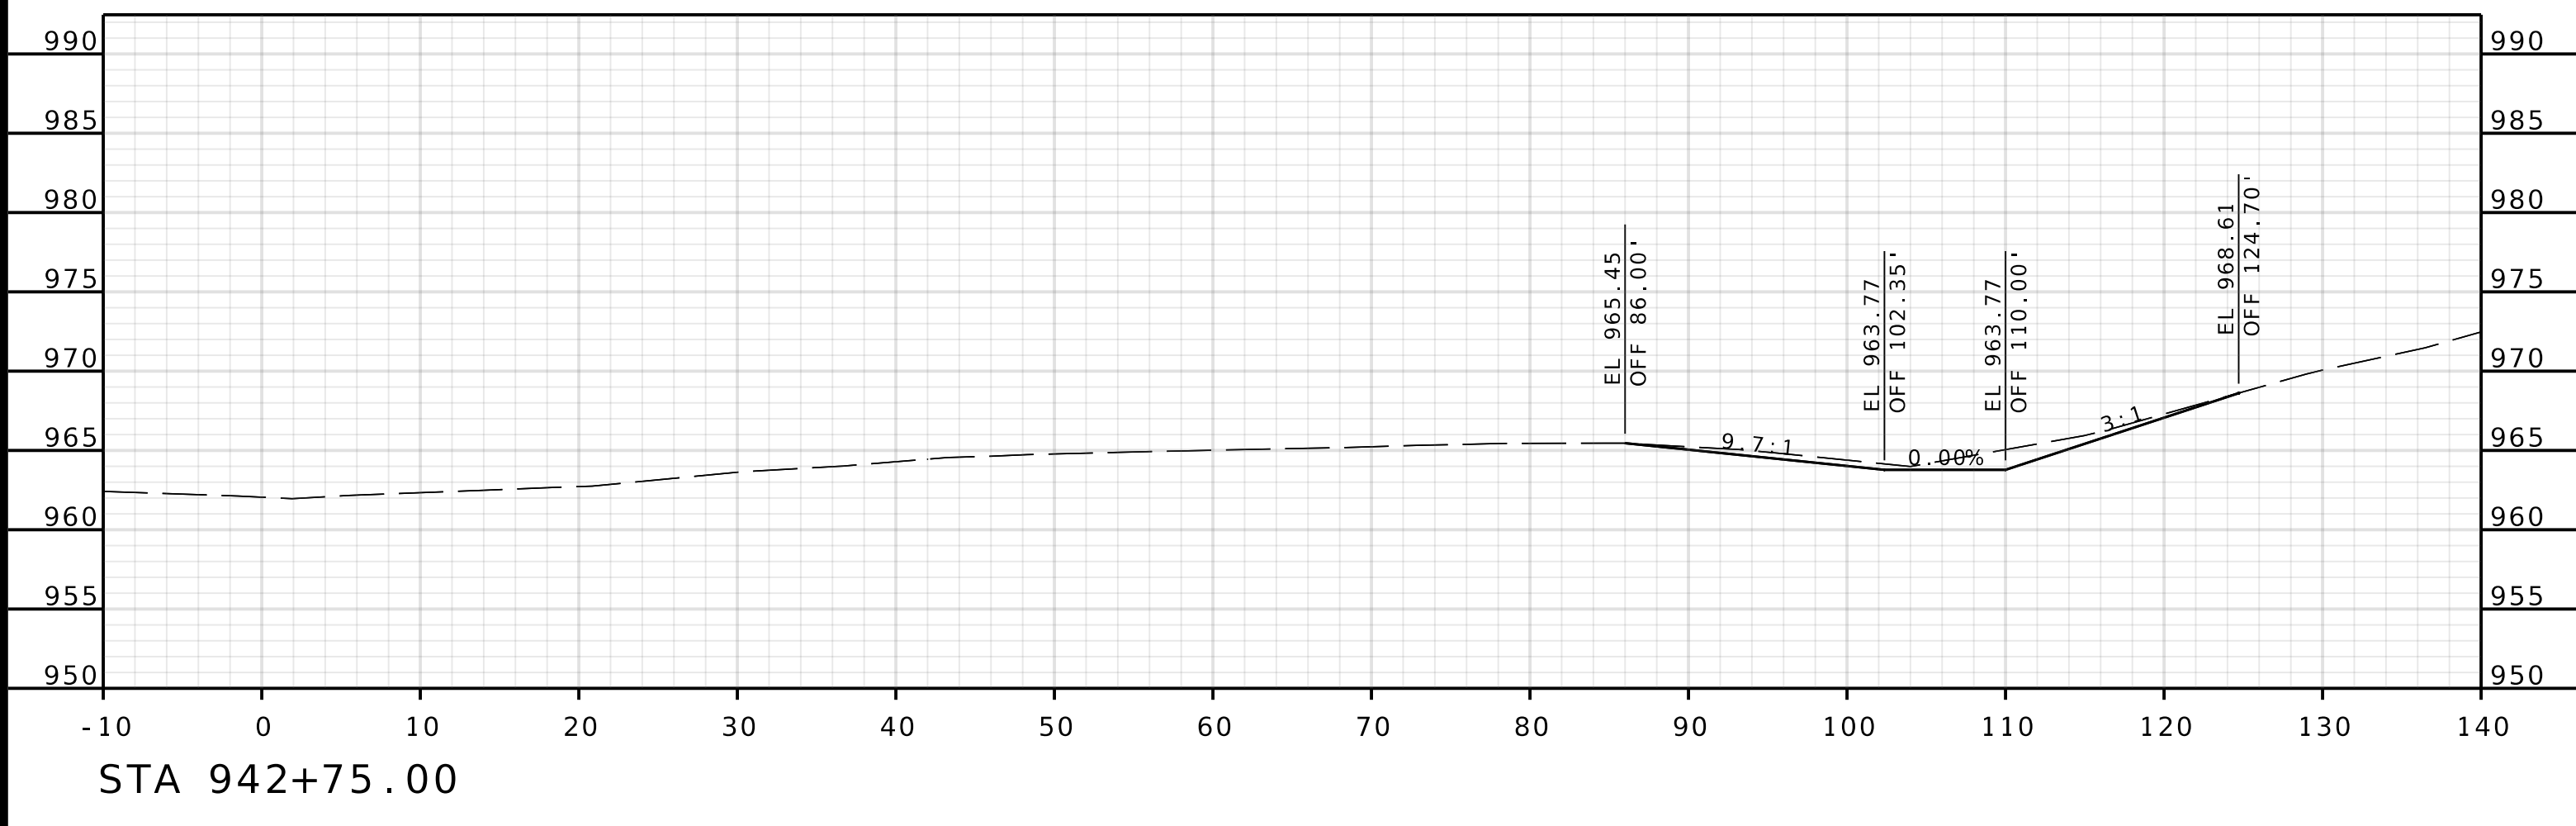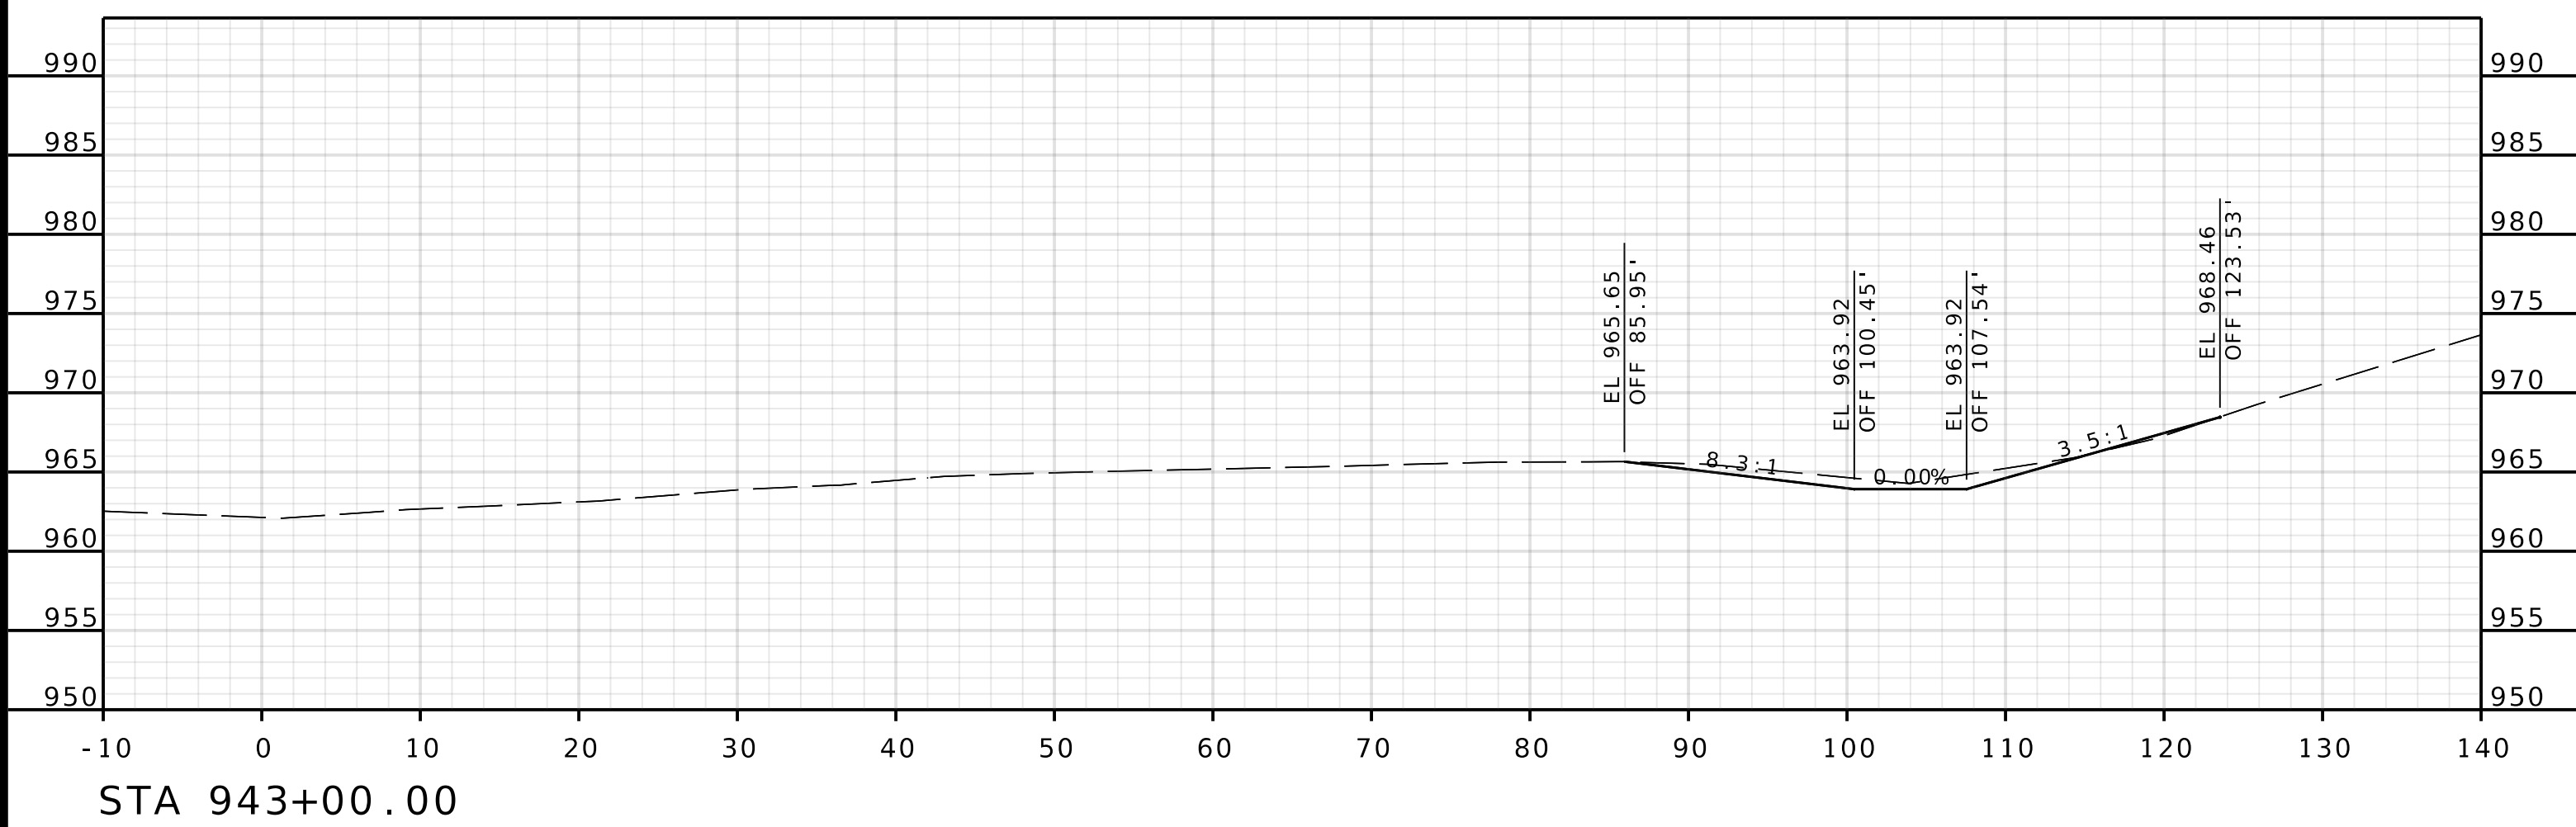

DATE PREPARED 4/30/2025	
ROUTE 1435	STATE MO
DISTRICT KC	SHEET NO. 13
COUNTY PLATTE	
JOB NO. J4S3489	
CONTRACT ID.	
PROJECT NO.	
BRIDGE NO. A9700	

DATE	DESCRIPTION

MISSOURI HIGHWAYS AND TRANSPORTATION COMMISSION






105 WEST CAPITOL
JEFFERSON CITY, MO 65102
1-888-ASK-MODOT (1-888-275-6636)

Olsson
1301 BURLINGTON STREET, STE. 100
NORTH KANSAS CITY, MO 64116
PHONE: 816.361.1177
CERTIFICATE OF AUTHORITY NO. 001592

ROUTE I-435
EBL


IF A SEAL IS PRESENT ON THIS SHEET IT HAS BEEN ELECTRONICALLY SEALED AND DATED.

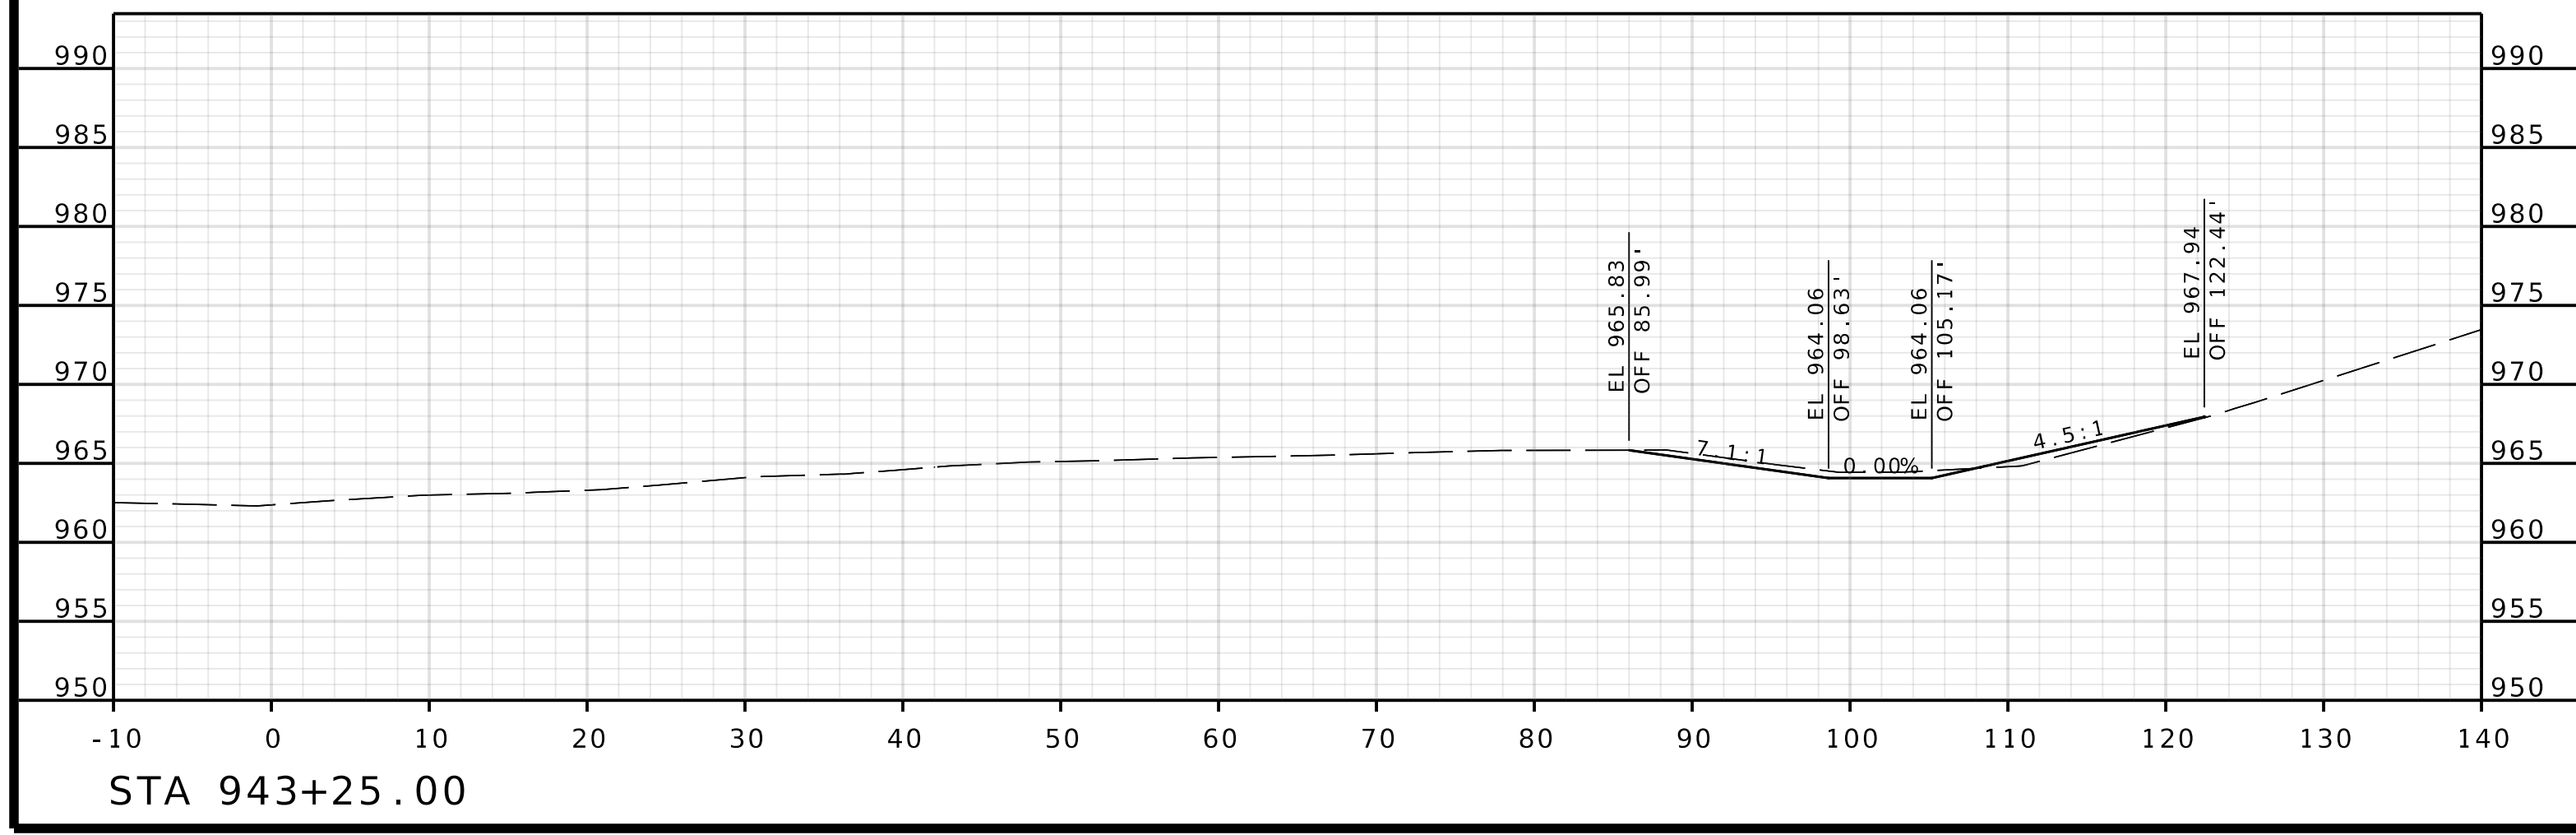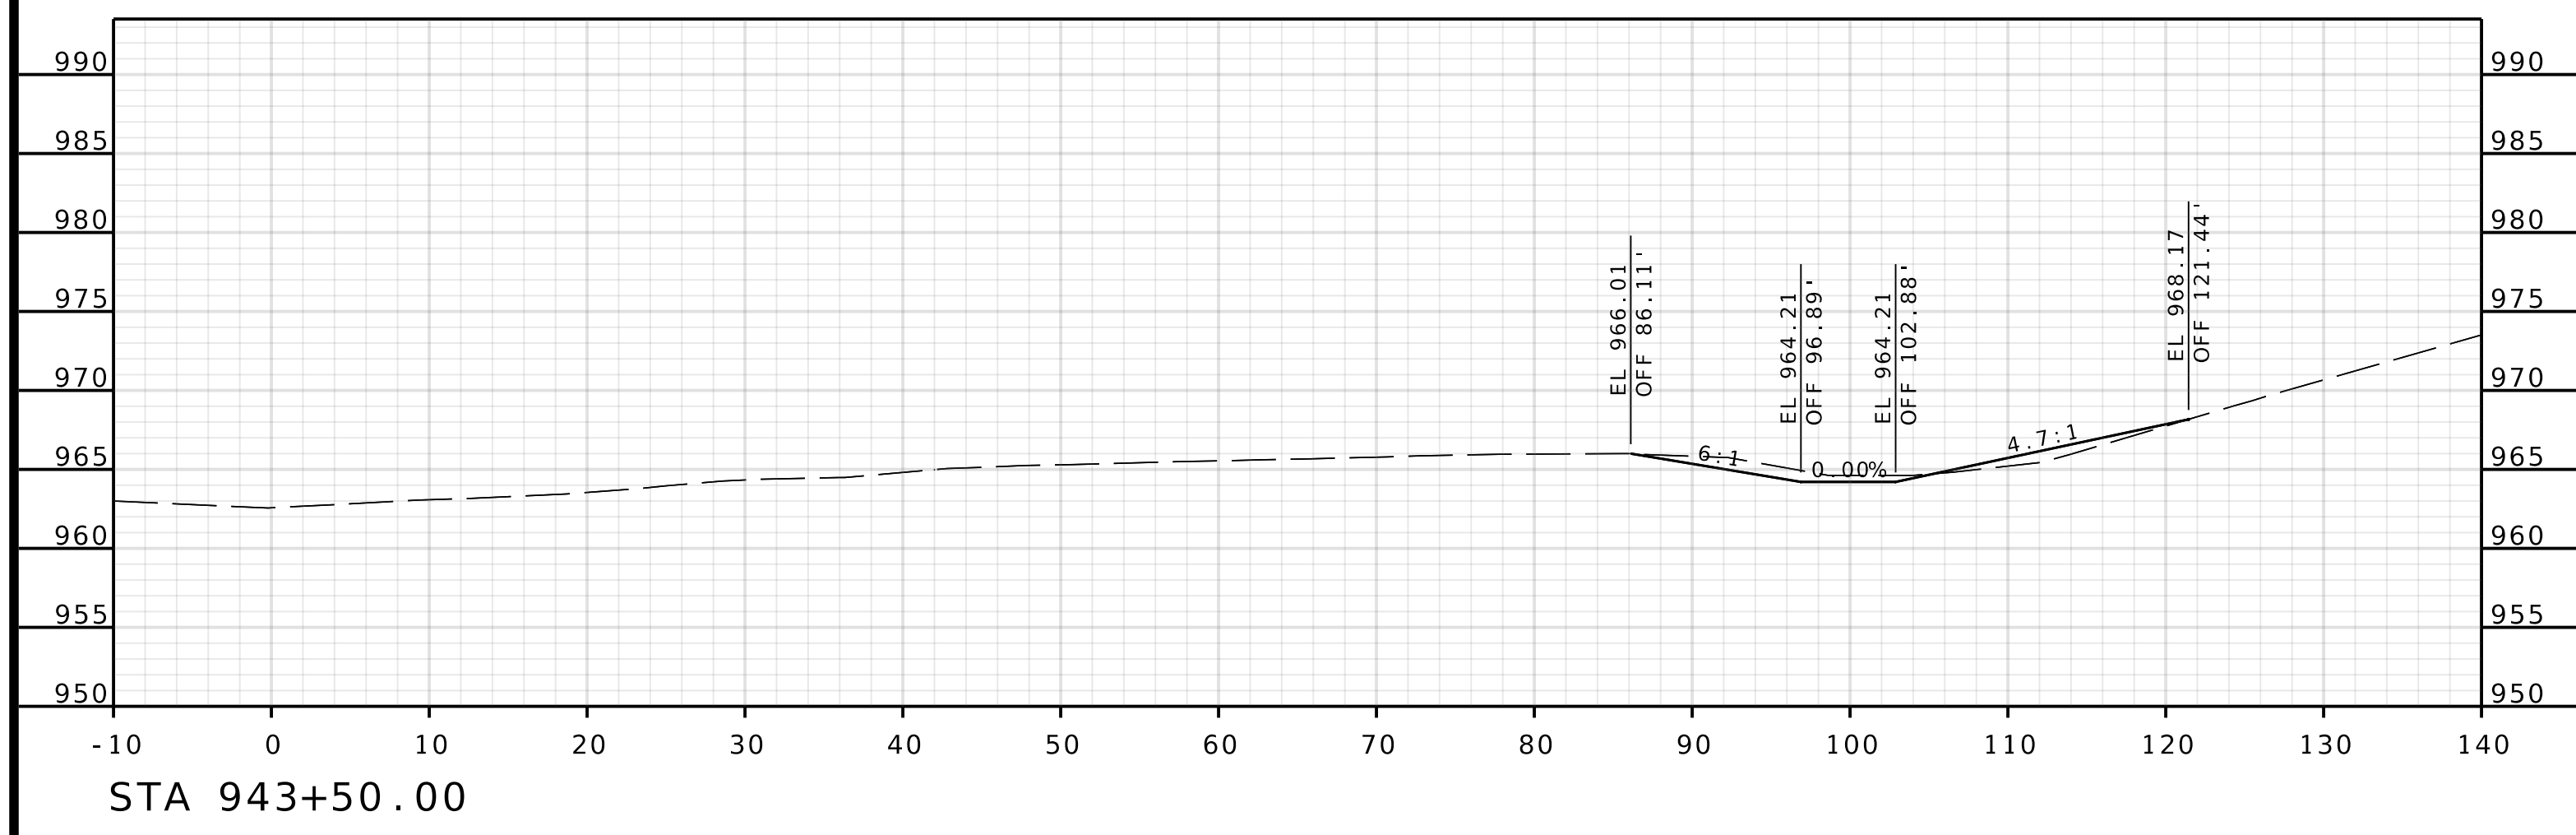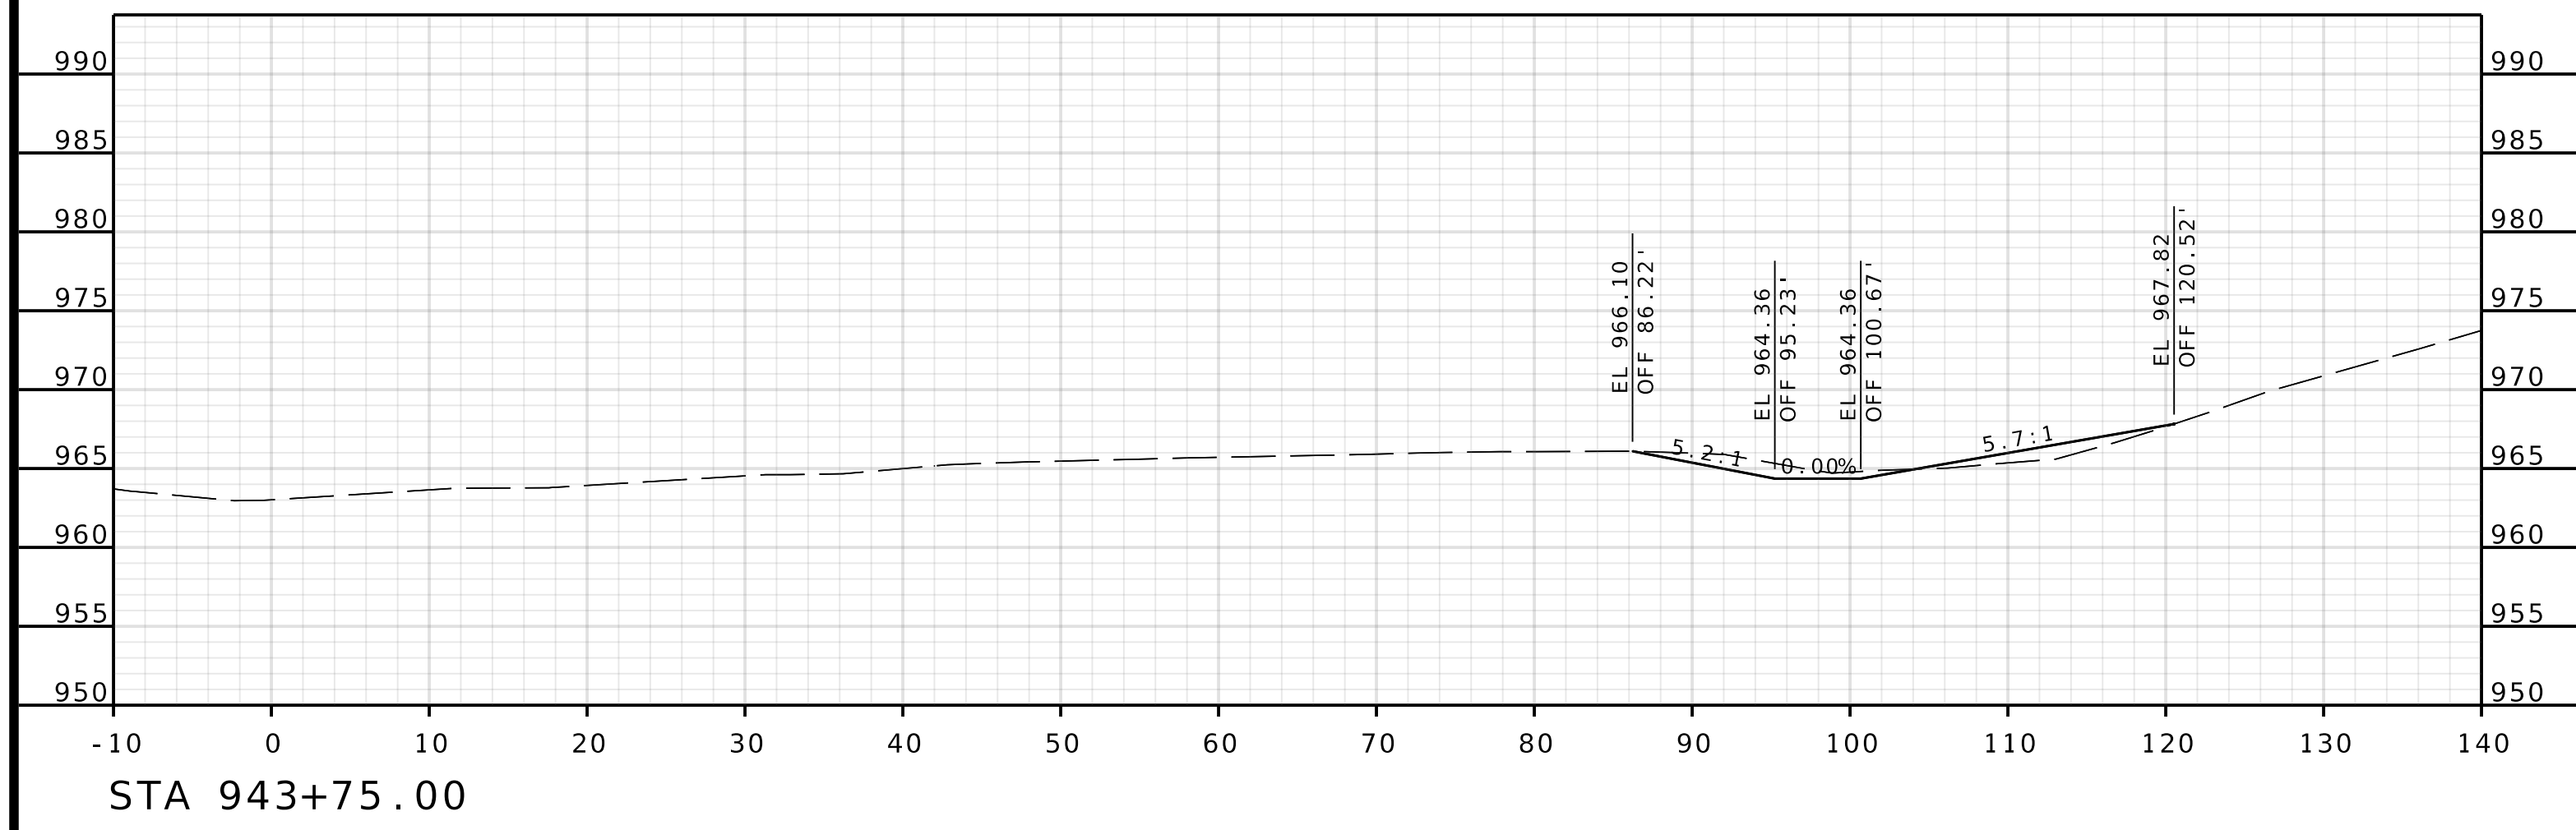

DATE PREPARED 4/30/2025	
ROUTE 1435	STATE MO
DISTRICT KC	SHEET NO. 14
COUNTY PLATTE	
JOB NO. J4S3489	
CONTRACT ID.	
PROJECT NO.	
BRIDGE NO. A9700	

DATE	DESCRIPTION

MISSOURI HIGHWAYS AND TRANSPORTATION COMMISSION


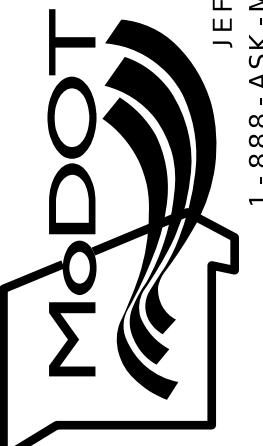




105 WEST CAPITOL
JEFFERSON CITY, MO 65102
1-888-ASK-MODOT (1-888-275-6636)

Olsson
1301 BURLINGTON STREET, STE. 100
NORTH KANSAS CITY, MO 64116
PHONE: 816.361.1177
CERTIFICATE OF AUTHORITY NO. 001592



ROUTE I-435
EBL

IF A SEAL IS PRESENT ON THIS SHEET IT HAS BEEN ELECTRONICALLY SEALED AND DATED.

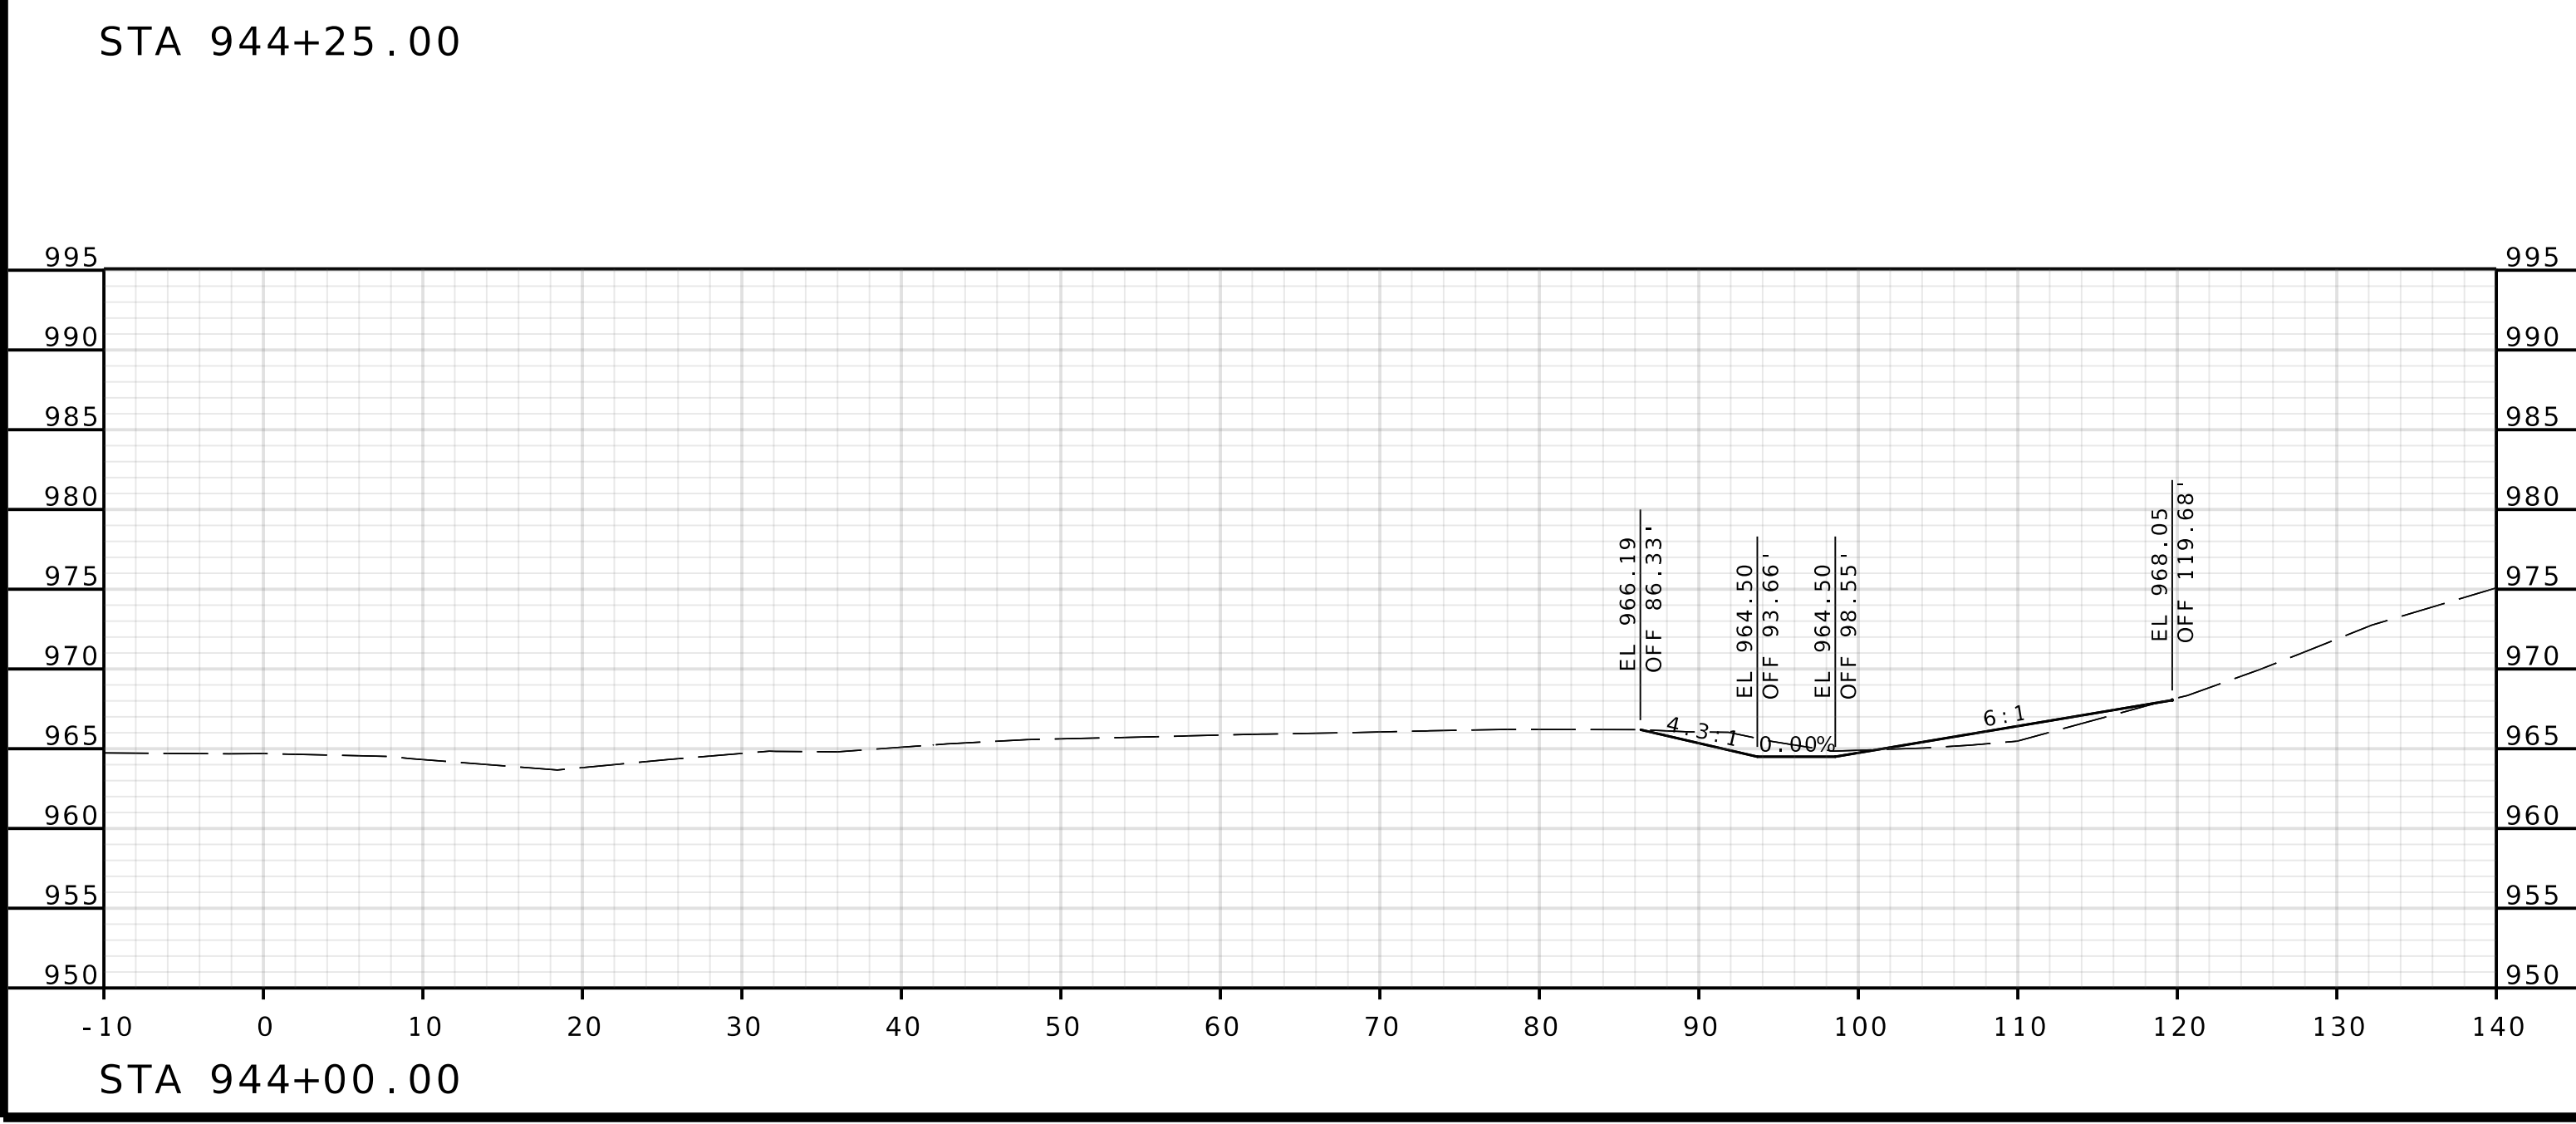
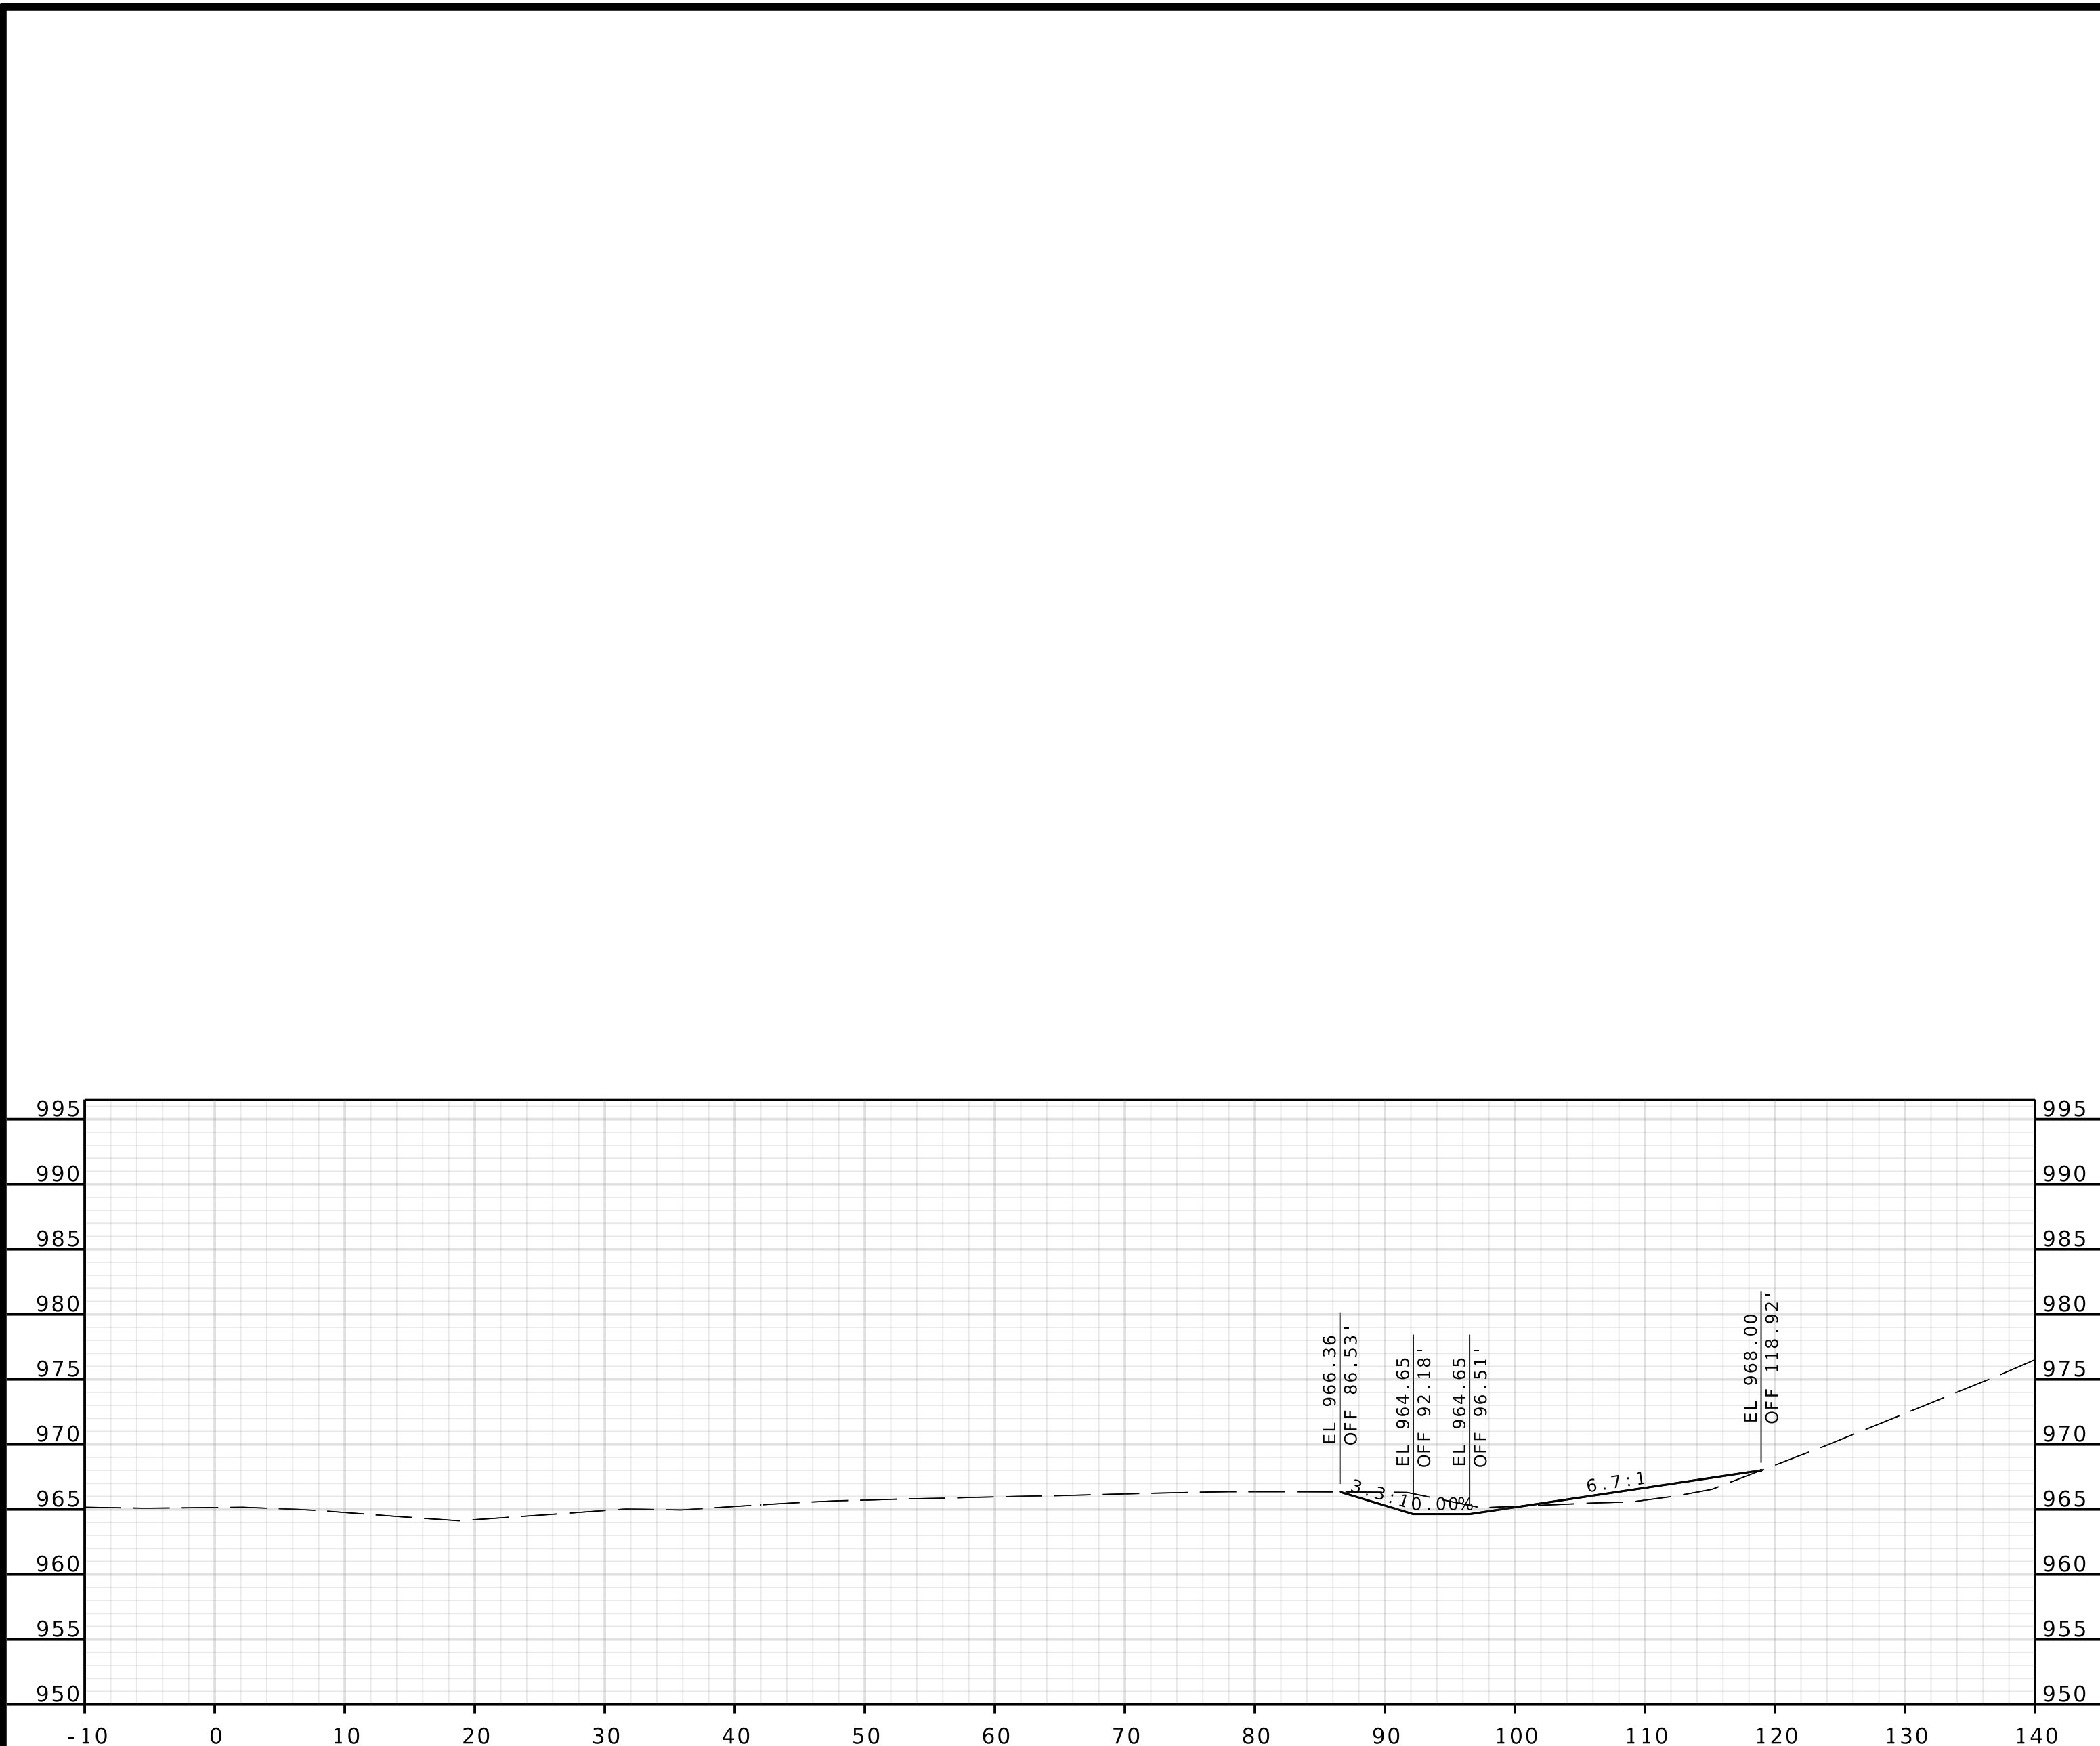


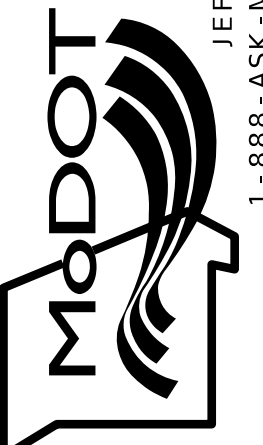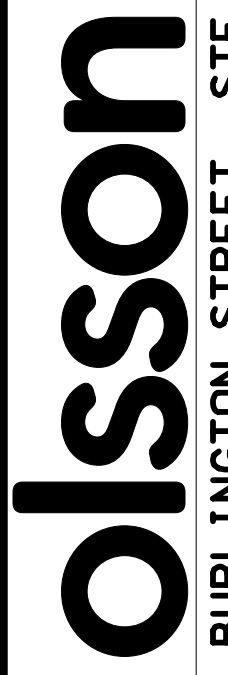DATE PREPARED 4/30/2025	
ROUTE 1435	STATE MO
DISTRICT KC	SHEET NO. 15
COUNTY PLATTE	
JOB NO. J4S3489	
CONTRACT ID.	
PROJECT NO.	
BRIDGE NO. A9700	
DATE	DESCRIPTION
MISSOURI HIGHWAYS AND TRANSPORTATION COMMISSION  105 WEST CAPITOL JEFFERSON CITY, MO 65102 1-888-ASK-MODOT (1-888-275-6636)	
 1301 BURLINGTON STREET, STE. 100 NORTH KANSAS CITY, MO 64116 PHONE: 816.361.1177 CERTIFICATE OF AUTHORITY NO. 001592	
ROUTE I-435 EBL	



IF A SEAL IS PRESENT ON THIS SHEET IT HAS BEEN ELECTRONICALLY SEALED AND DATED.

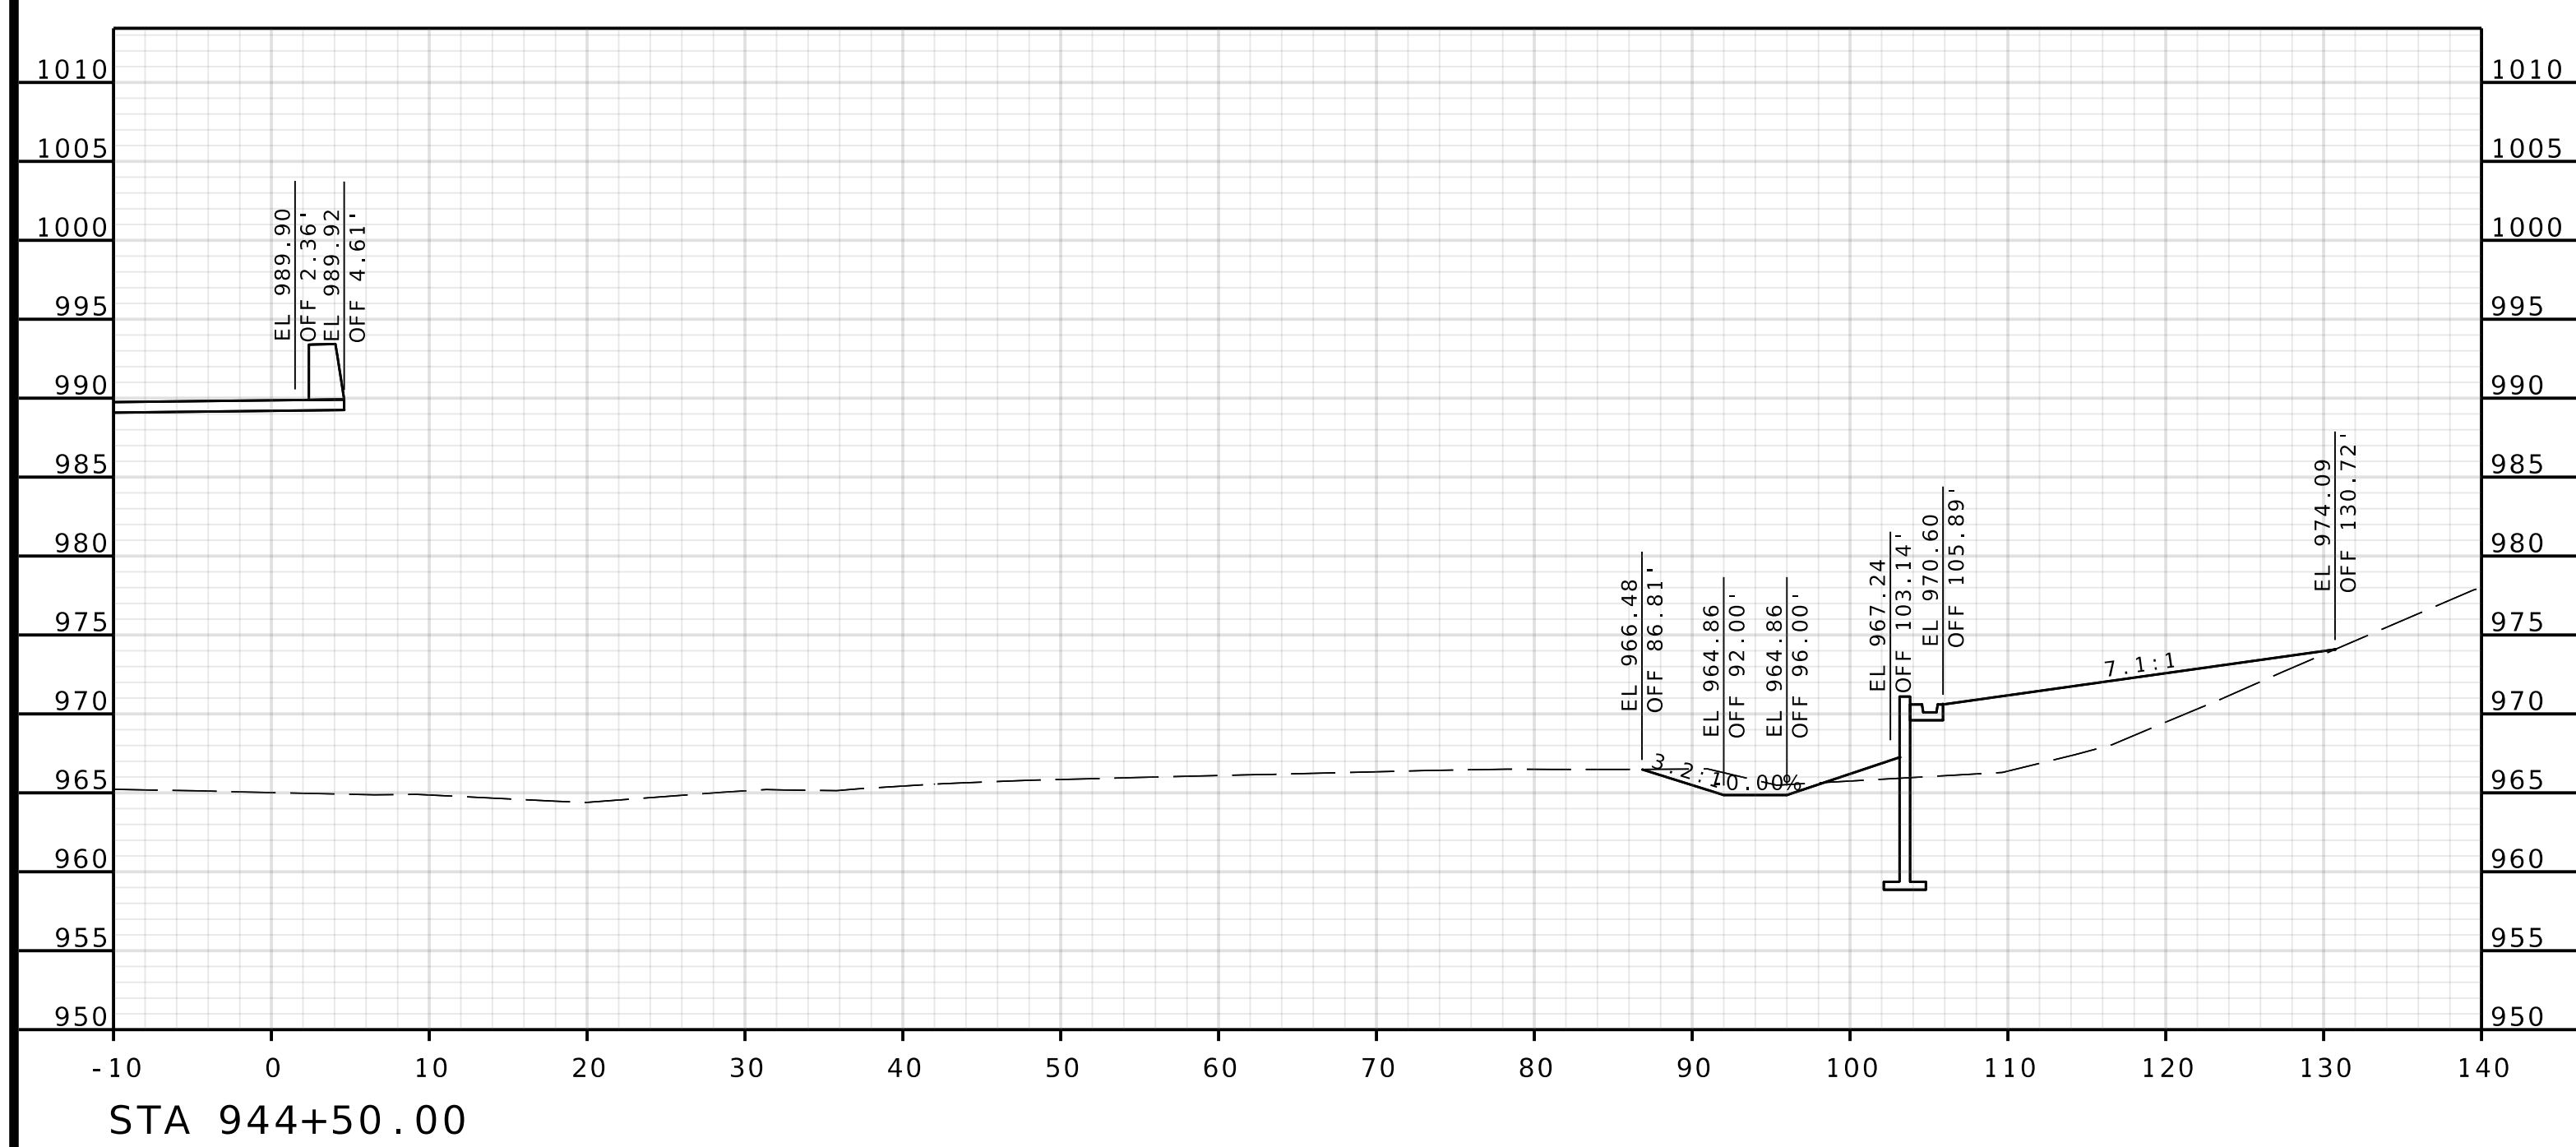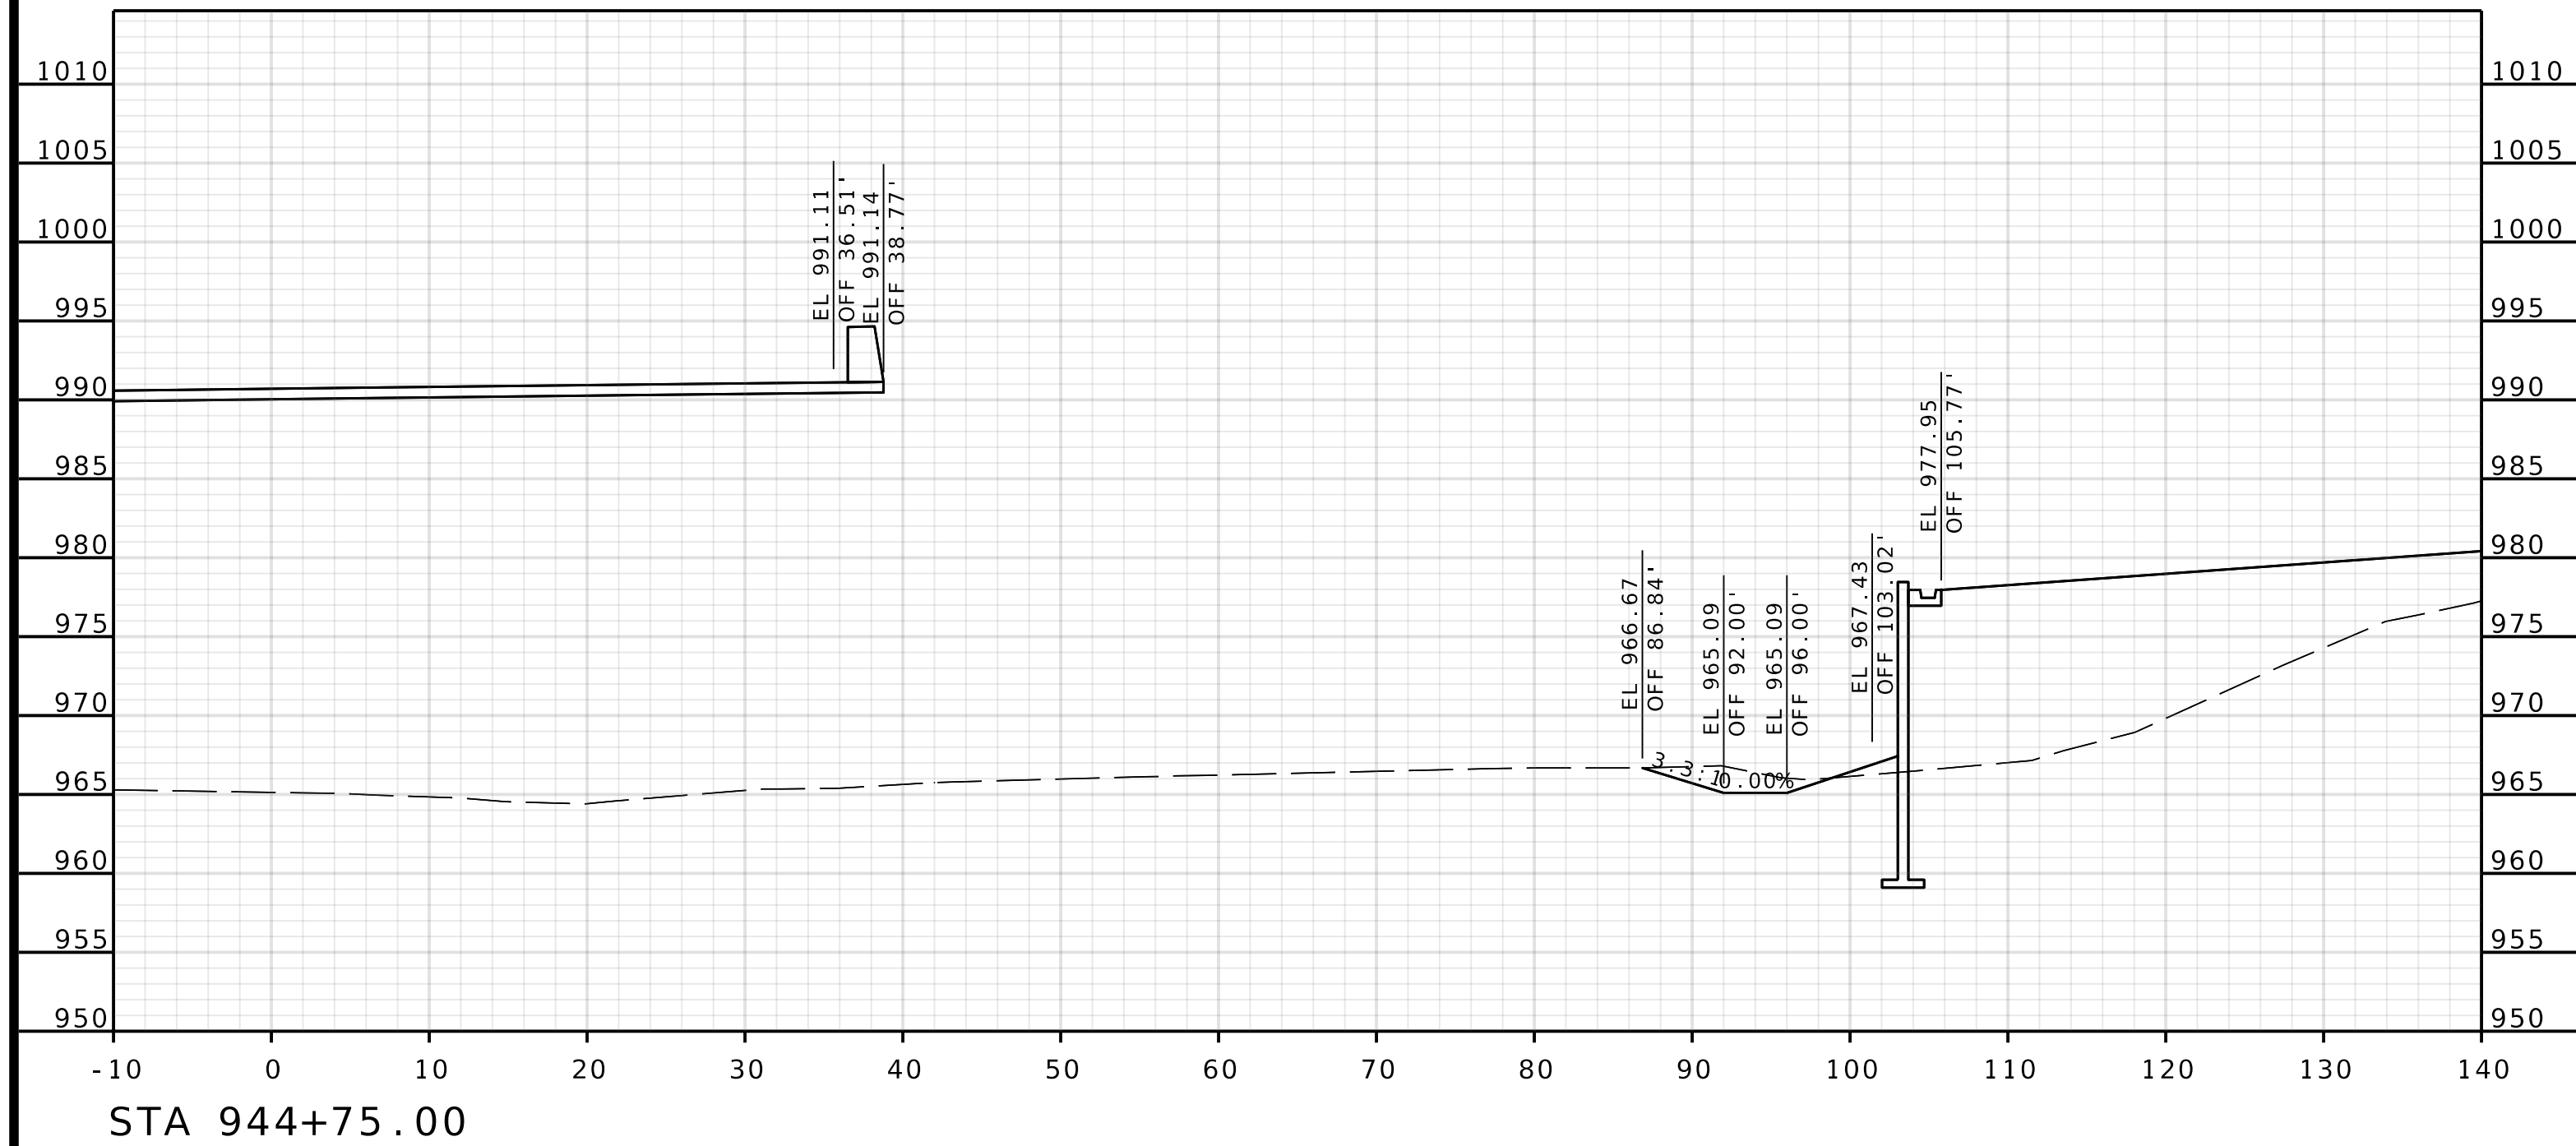

ROUTE I-435
EBL

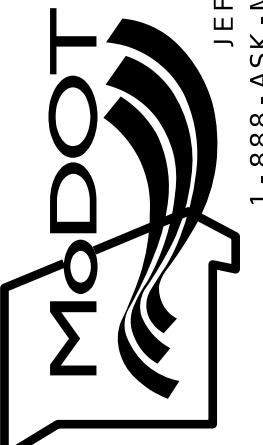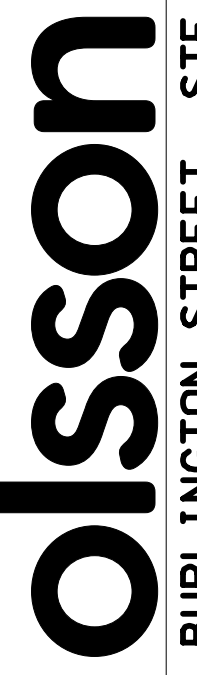DATE PREPARED 4/30/2025	
ROUTE 1435	STATE MO
DISTRICT KC	SHEET NO. 16
COUNTY PLATTE	
JOB NO. J4S3489	
CONTRACT ID.	
PROJECT NO.	
BRIDGE NO. A9700	
DATE	DESCRIPTION
MISSOURI HIGHWAYS AND TRANSPORTATION COMMISSION	
 105 WEST CAPITOL JEFFERSON CITY, MO 65102 1-888-ASK-MODOT (1-888-275-6636)	
 1301 BURLINGTON STREET, STE. 100 NORTH KANSAS CITY, MO 64116 PHONE: 816.361.1177 CERTIFICATE OF AUTHORITY NO. 001592	

IF A SEAL IS PRESENT ON THIS SHEET IT HAS BEEN ELECTRONICALLY SEALED AND DATED.

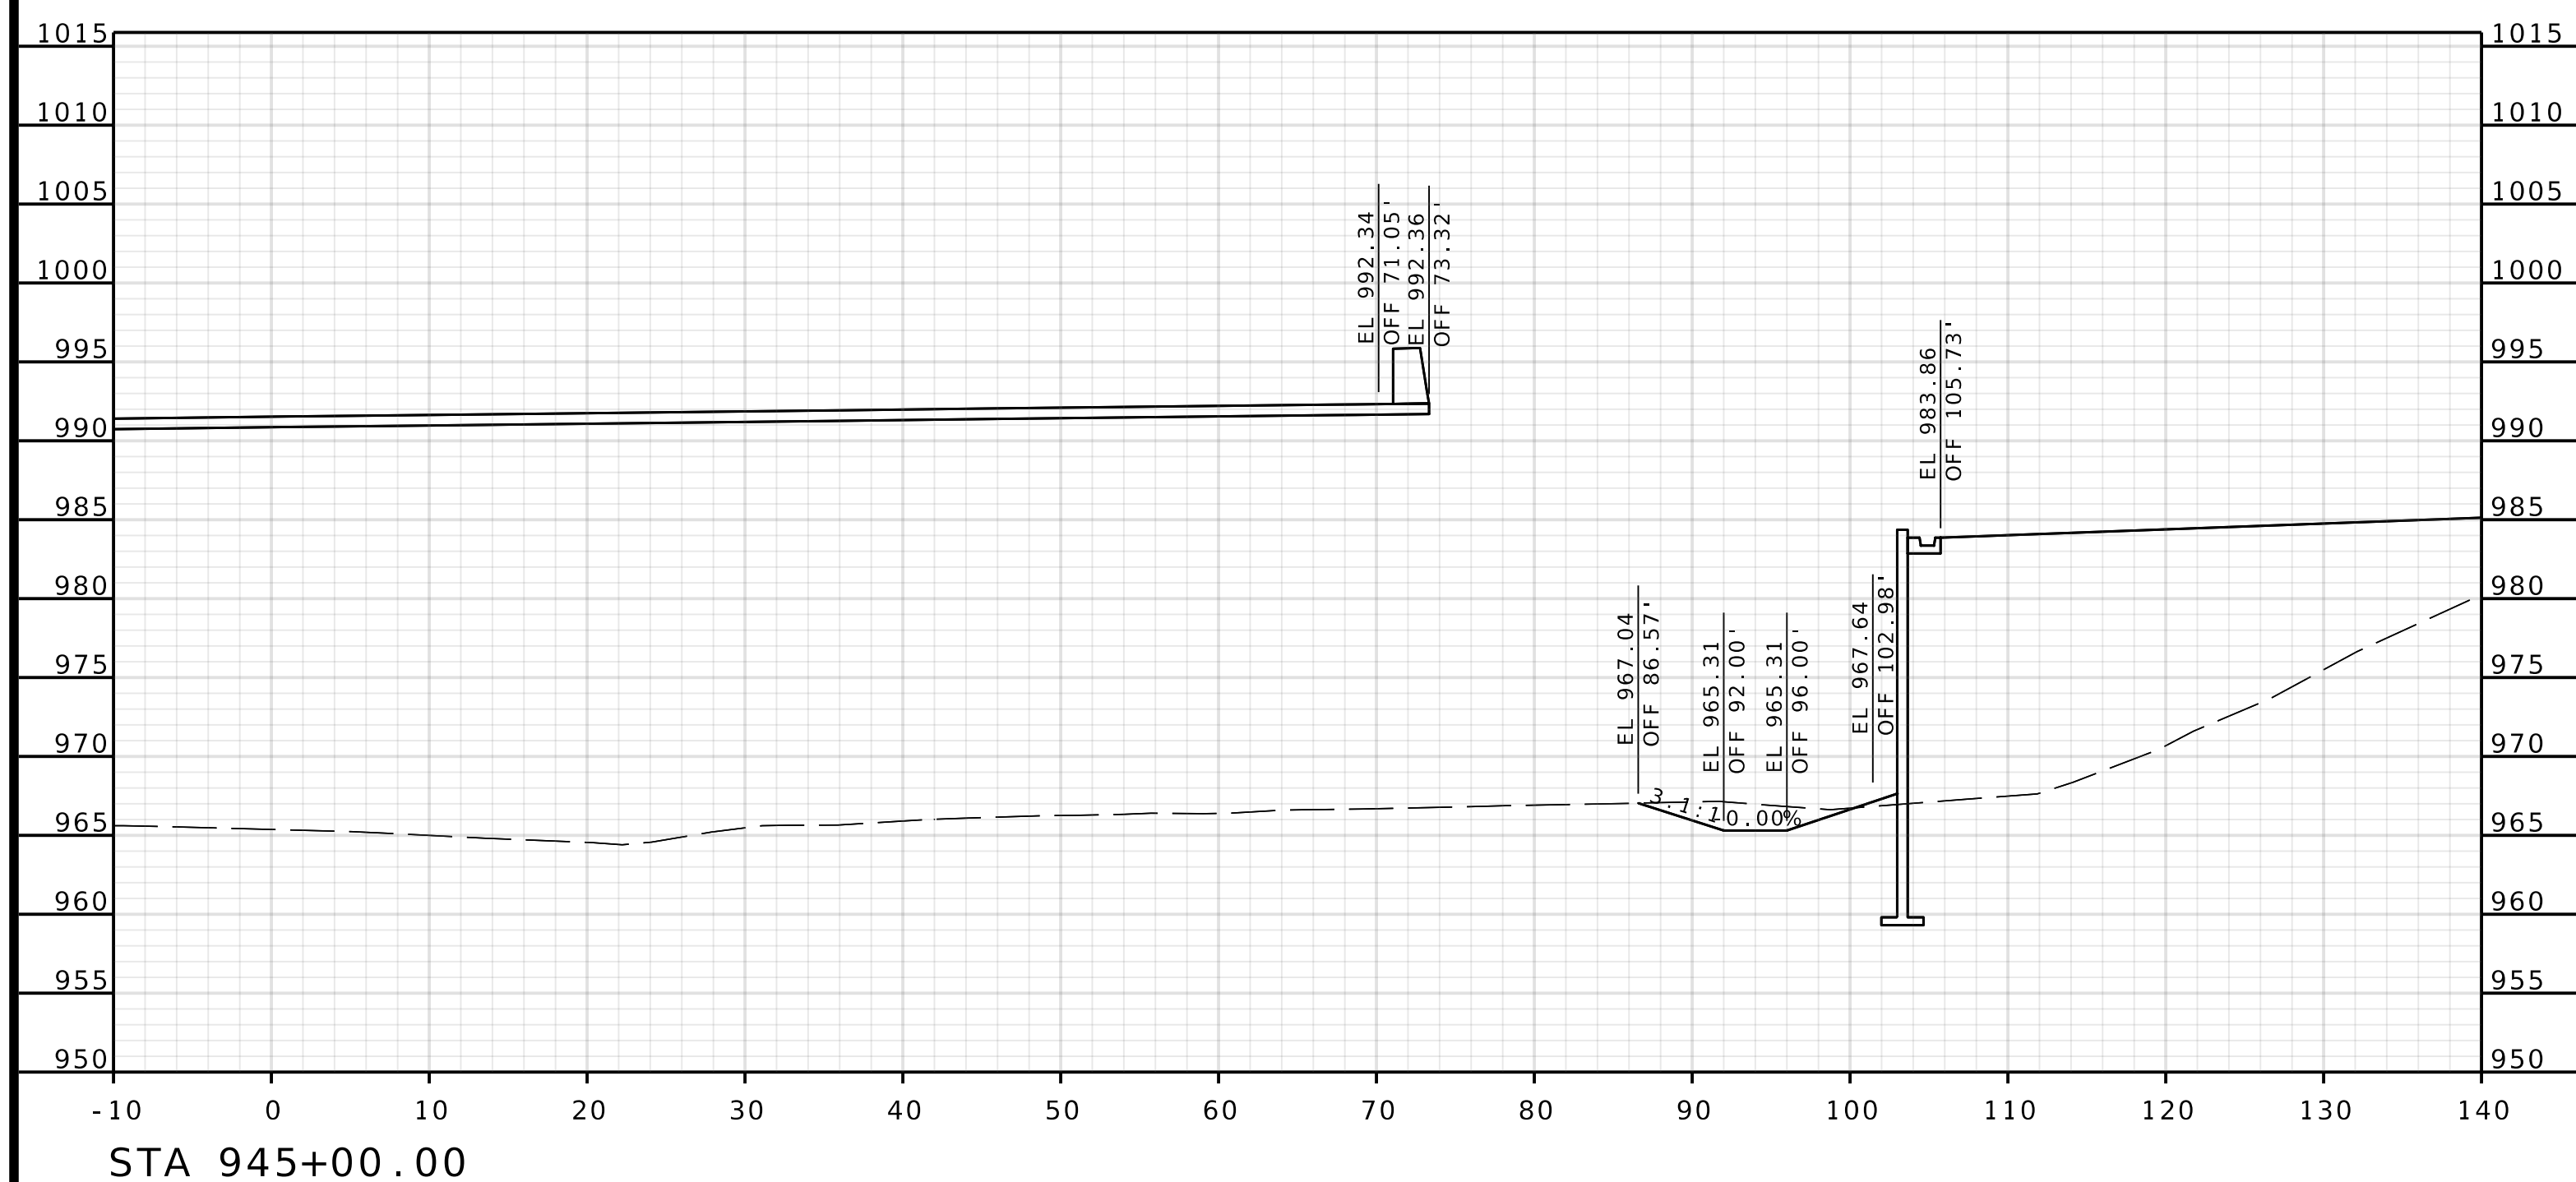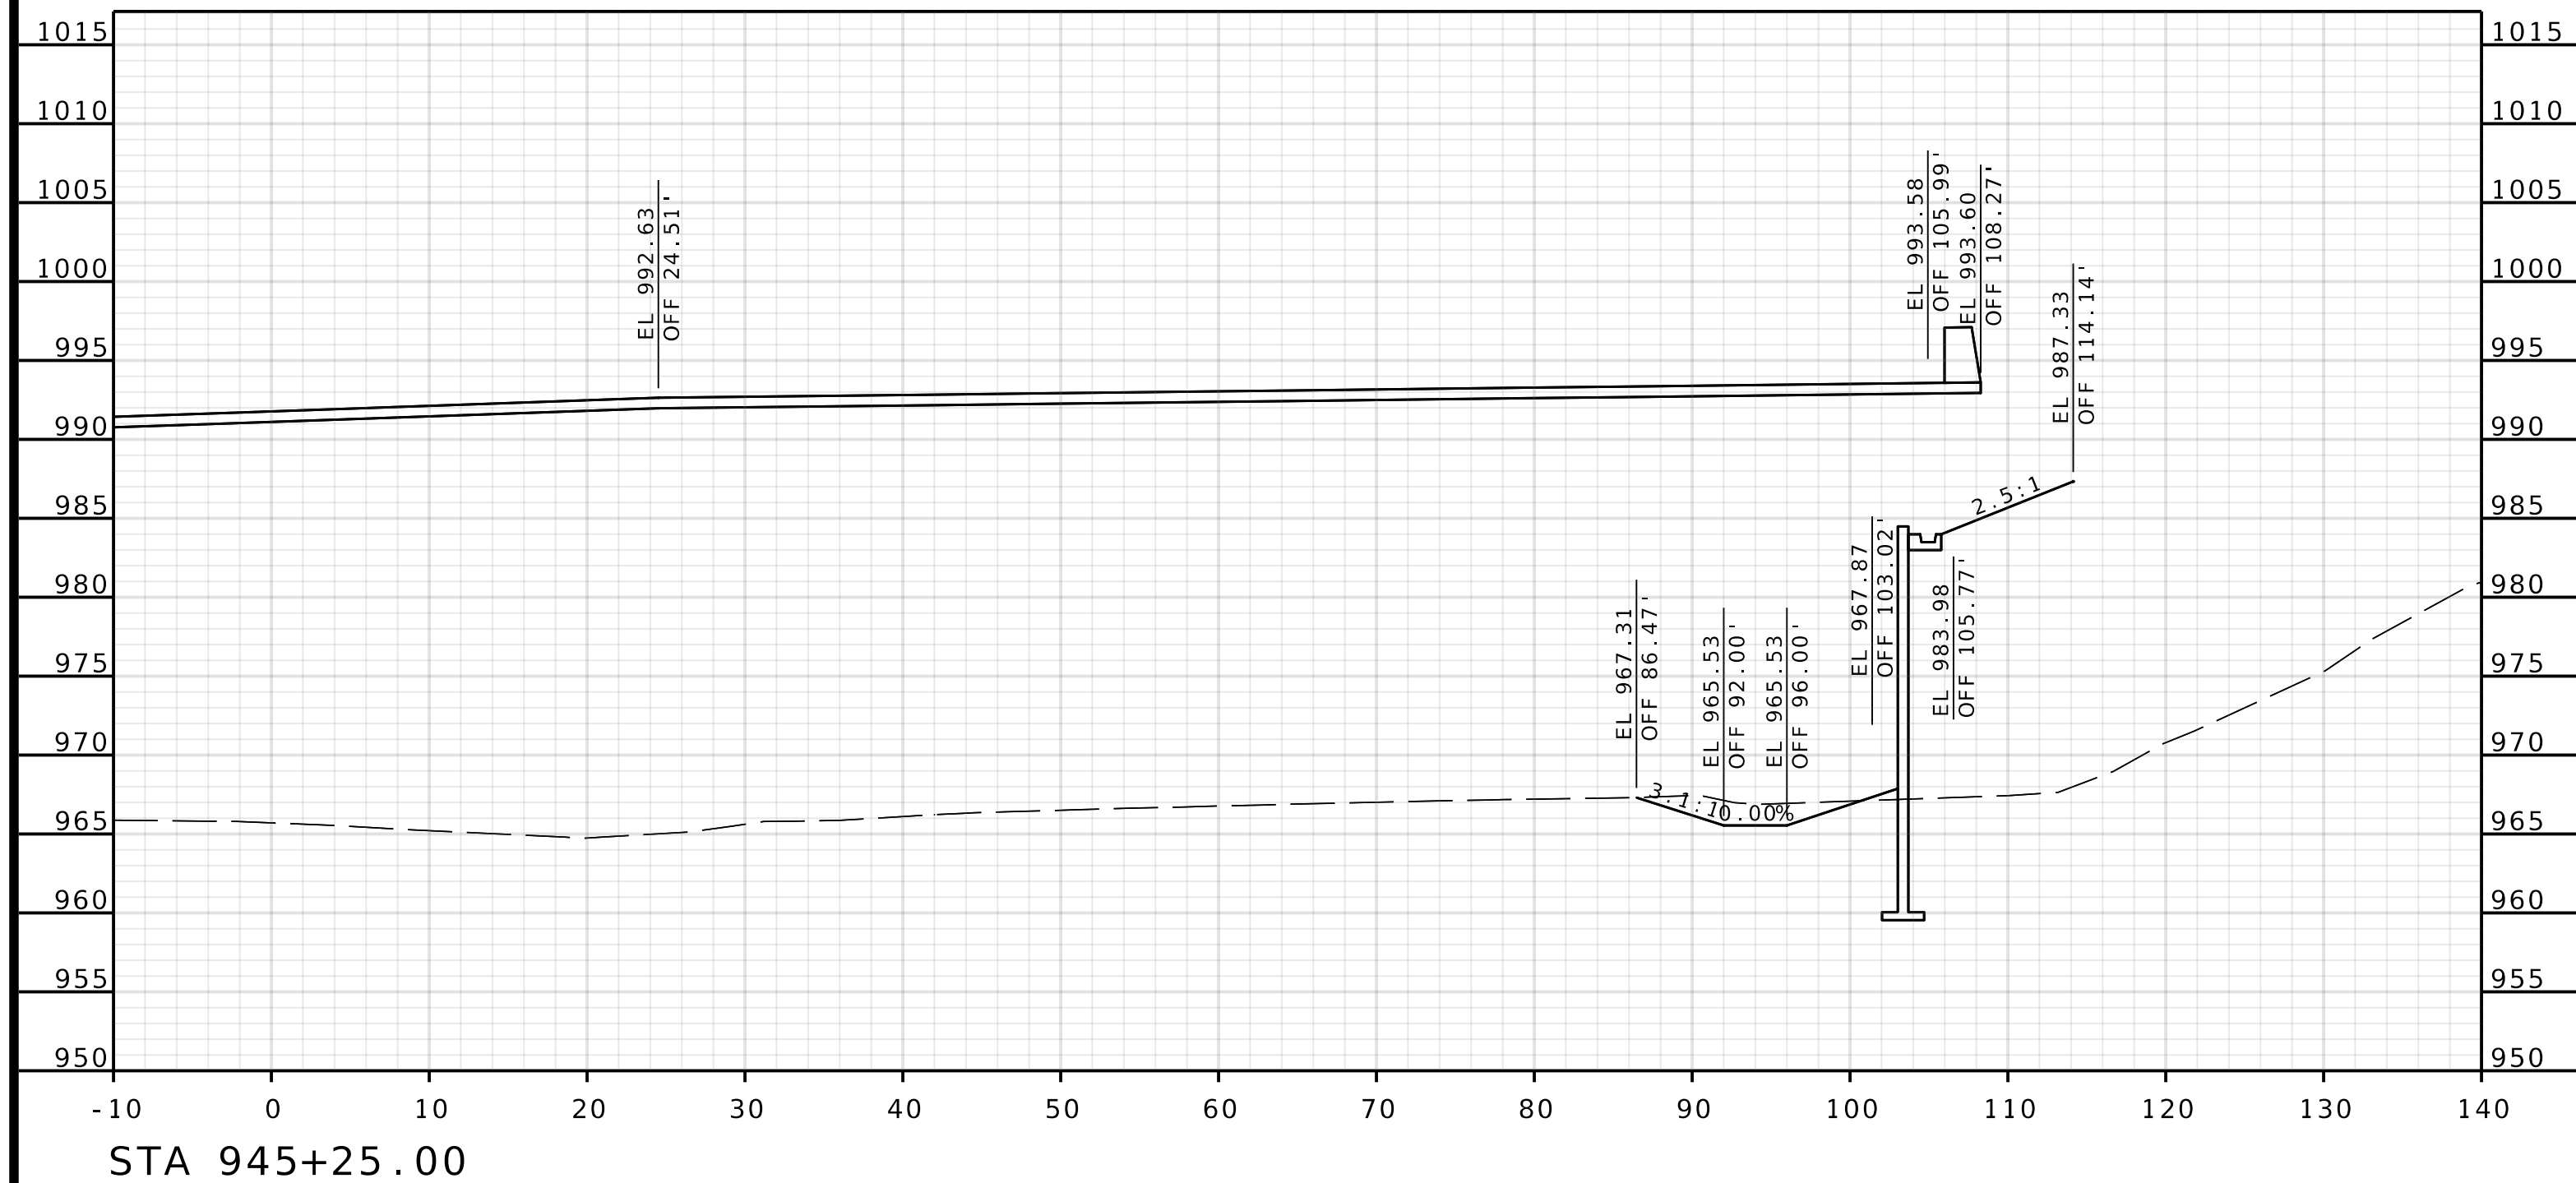

ROUTE I-435
EBL

DATE PREPARED 4/30/2025	
ROUTE 1435	STATE MO
DISTRICT KC	SHEET NO. 17
COUNTY PLATTE	
JOB NO. J4S3489	
CONTRACT ID.	
PROJECT NO.	
BRIDGE NO. A9700	

DATE	DESCRIPTION



MISSOURI HIGHWAYS AND TRANSPORTATION
COMMISSION





105 WEST CAPITOL
JEFFERSON CITY, MO 65102
1-888-ASK-MODOT (1-888-275-6636)

Olsson
1301 BURLINGTON STREET, STE. 100
NORTH KANSAS CITY, MO 64116
PHONE: 816.361.1177
CERTIFICATE OF AUTHORITY NO. 001592


IF A SEAL IS PRESENT ON THIS SHEET IT HAS BEEN ELECTRONICALLY SEALED AND DATED.

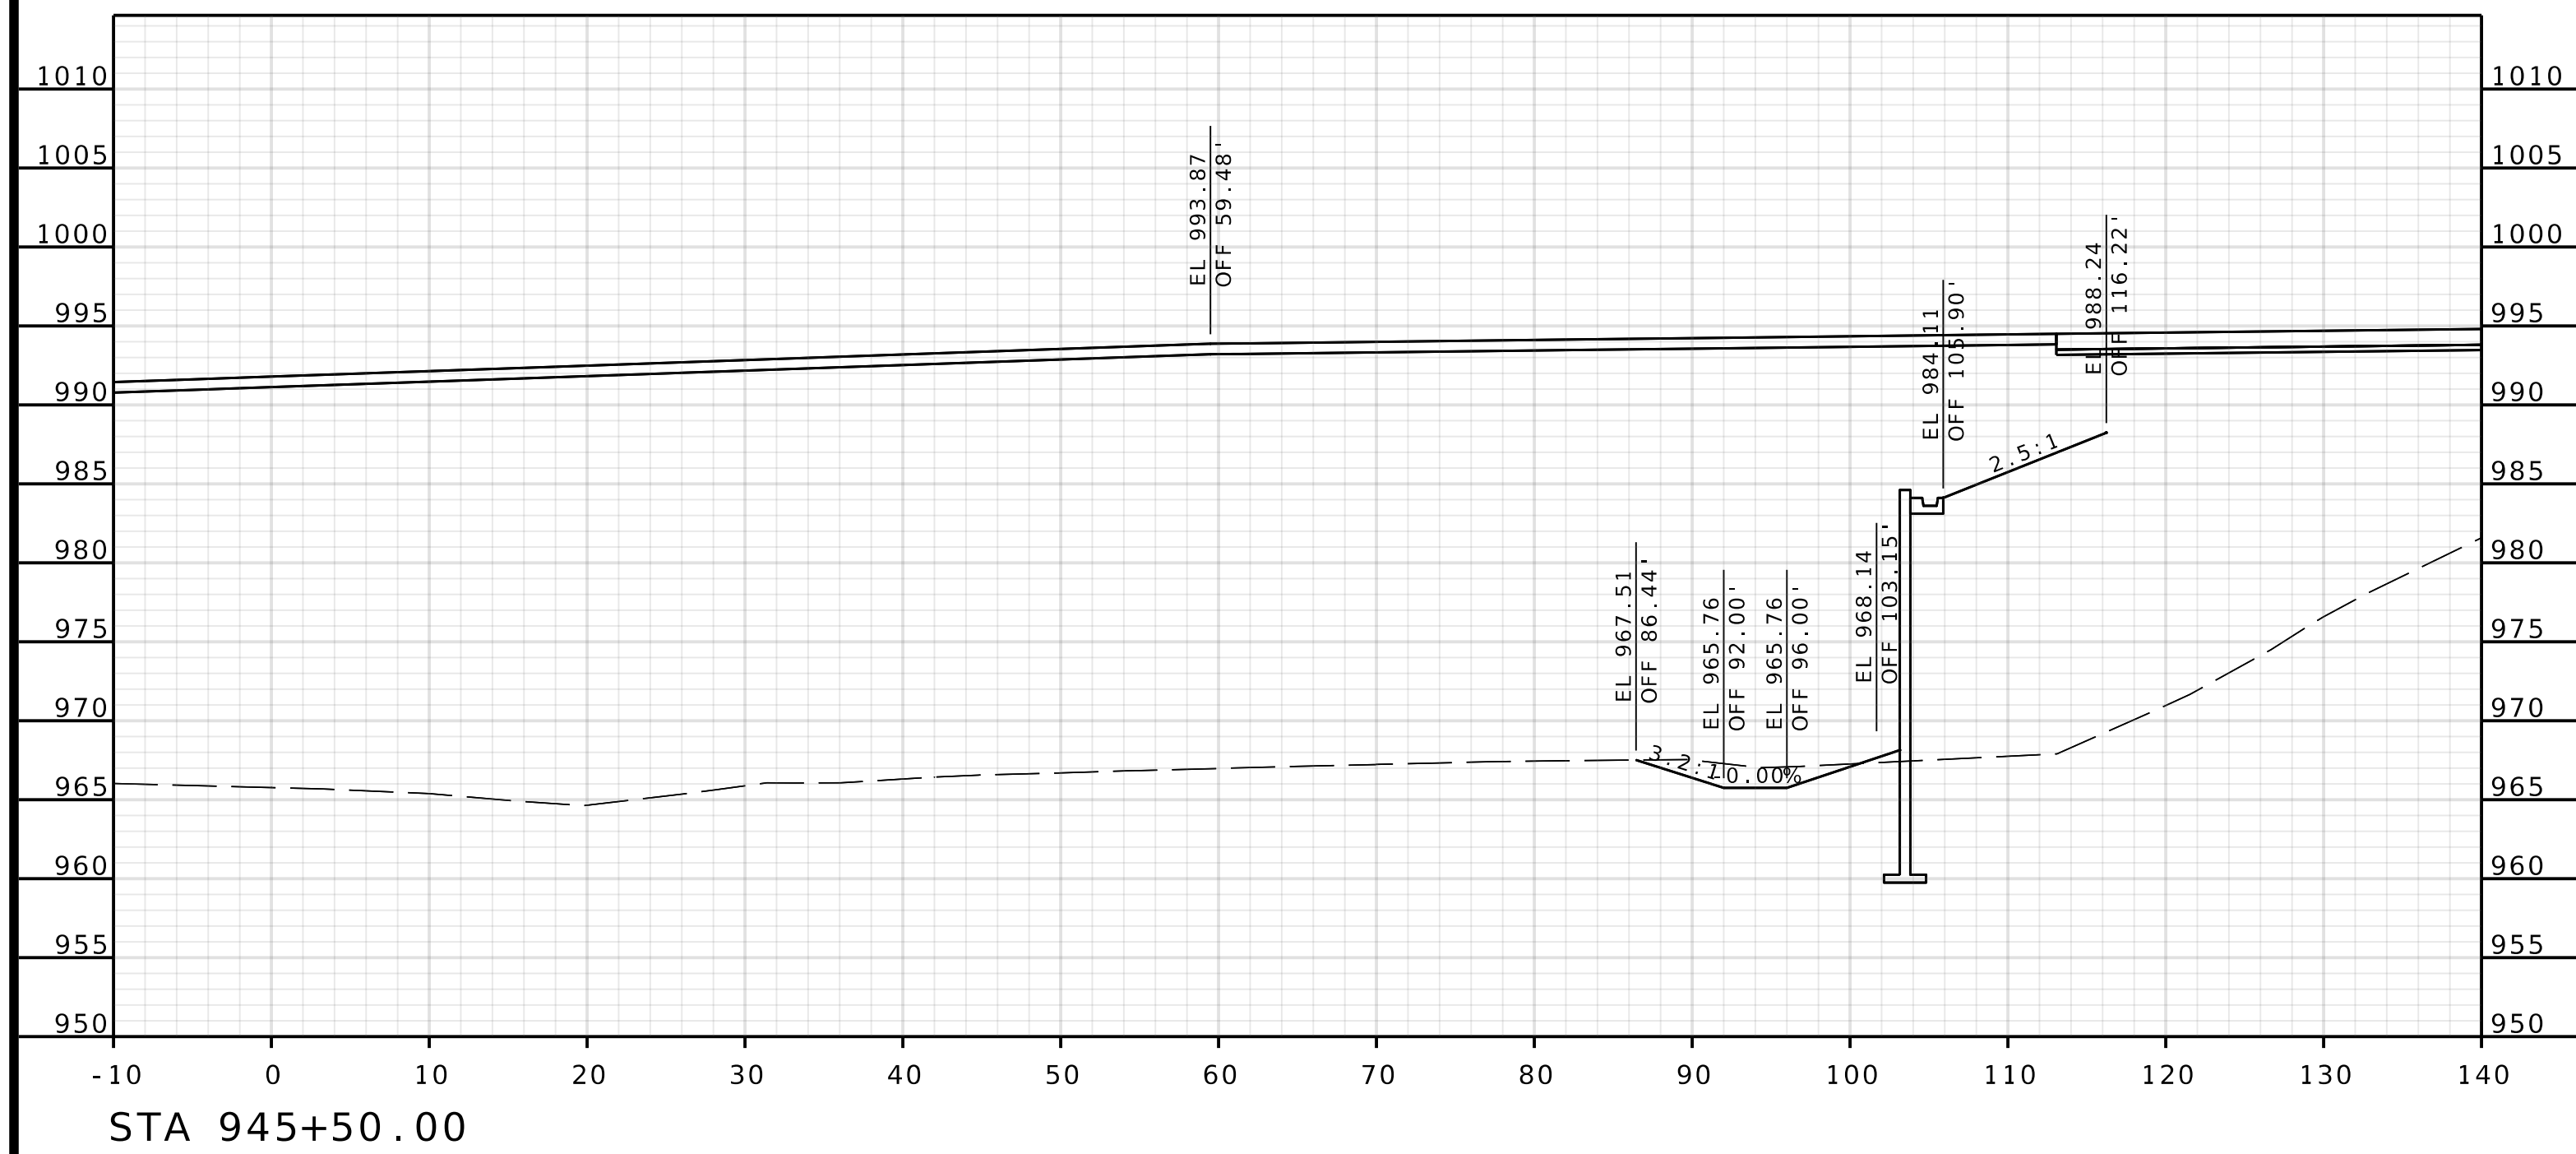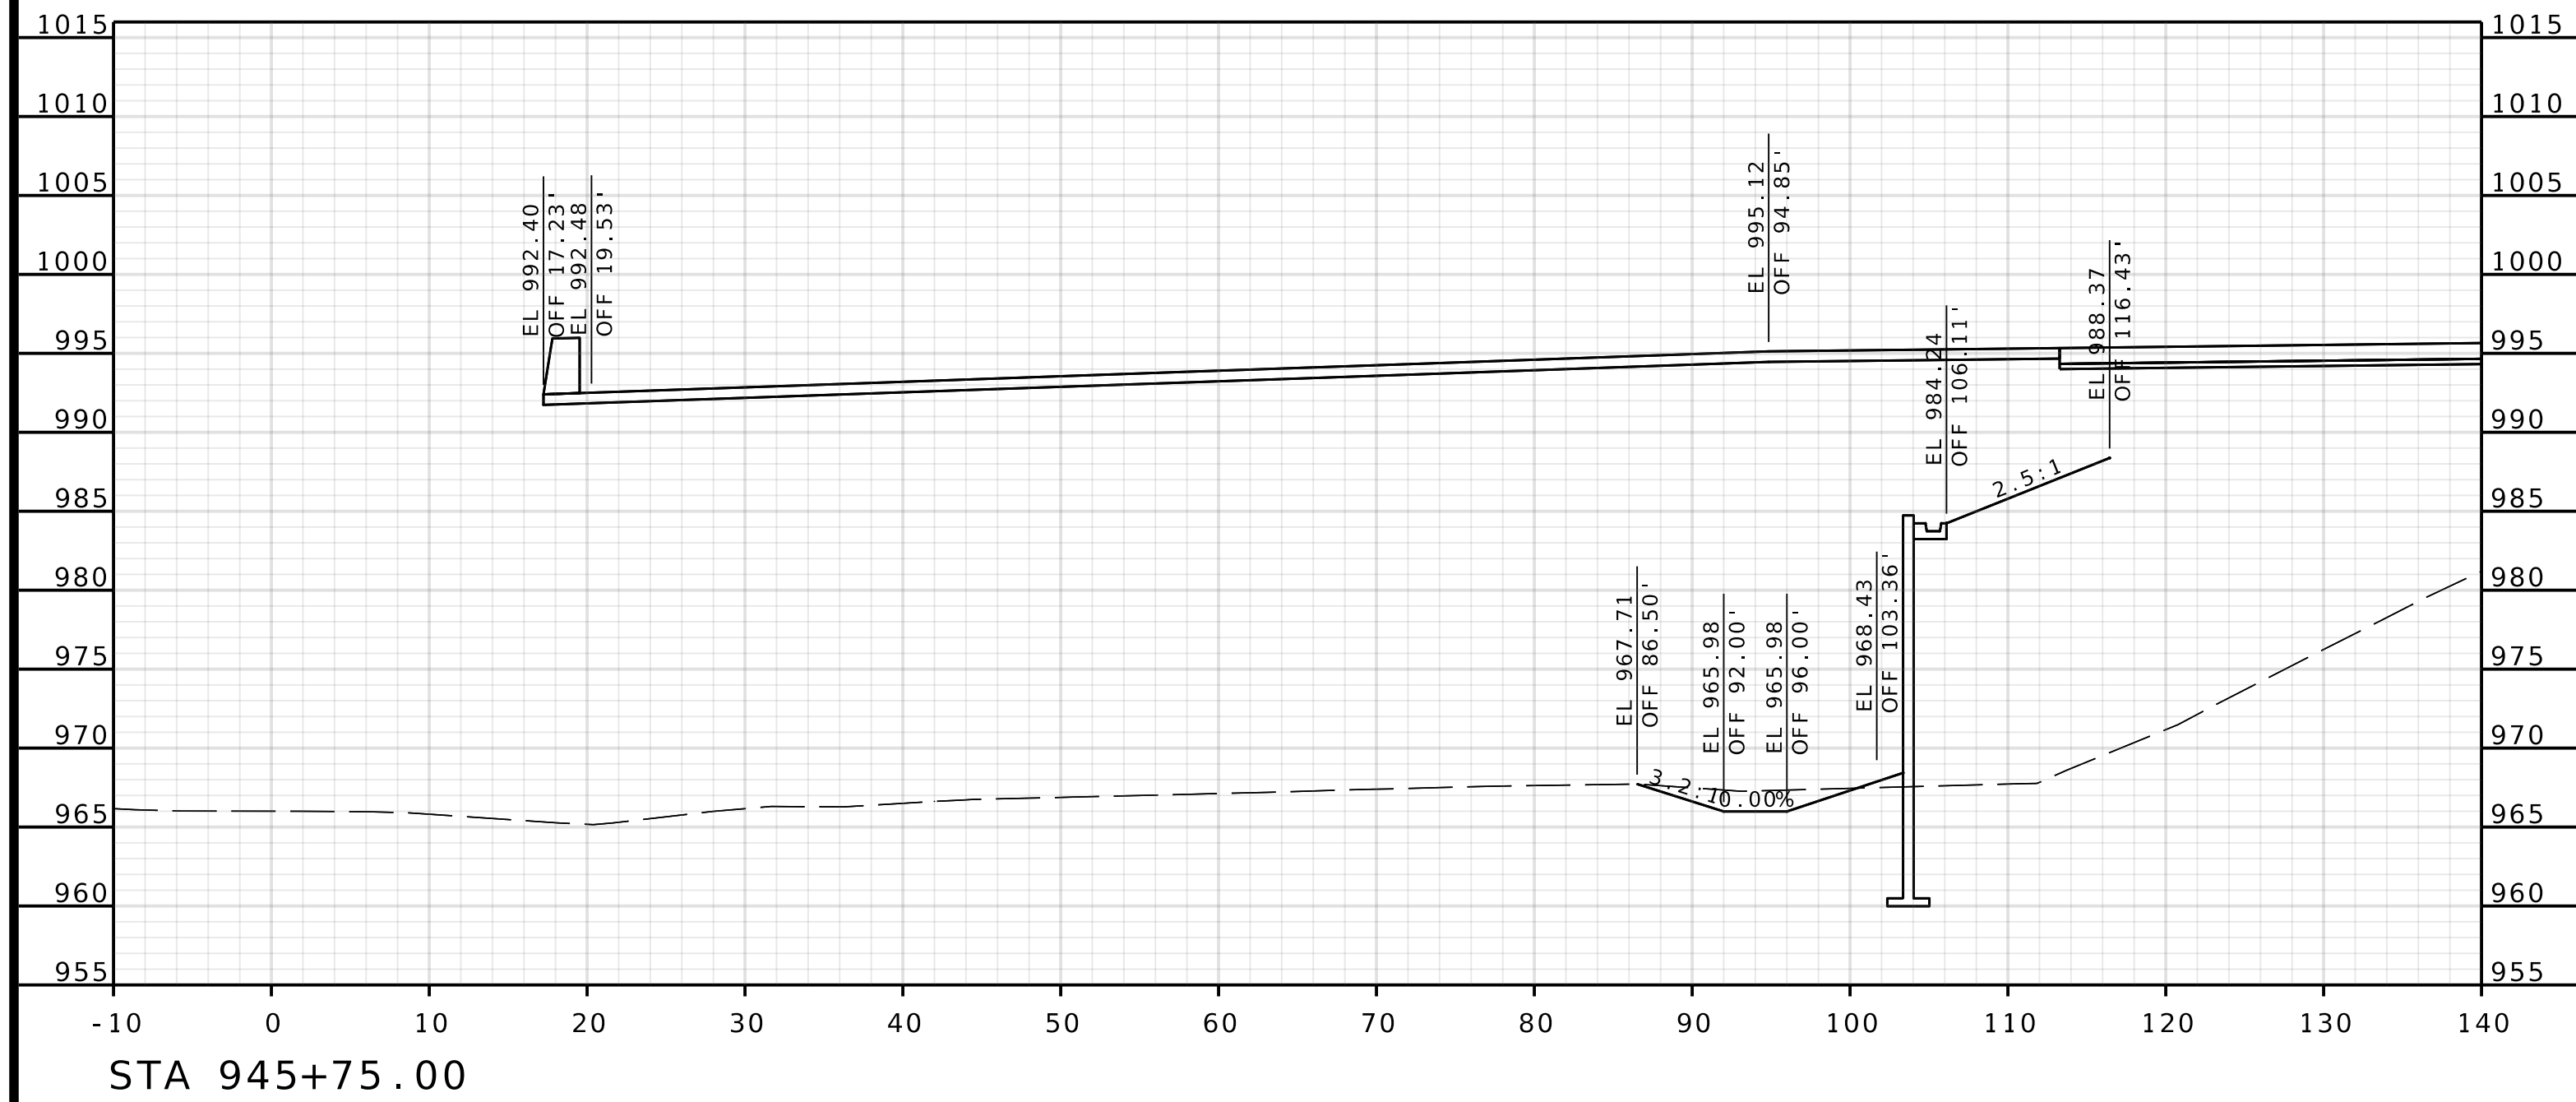


ROUTE I-435
EBL

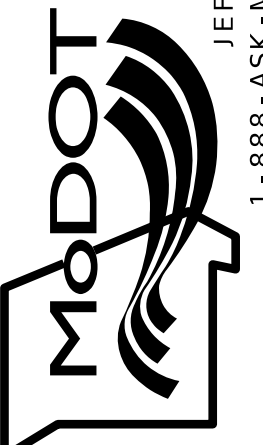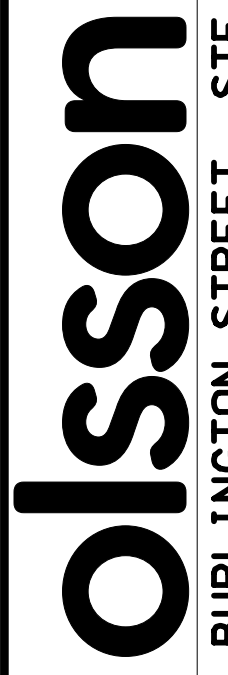DATE PREPARED 4/30/2025	
ROUTE 1435	STATE MO
DISTRICT KC	SHEET NO. 18
COUNTY PLATTE	
JOB NO. J4S3489	
CONTRACT ID.	
PROJECT NO.	
BRIDGE NO. A9700	
DATE	DESCRIPTION
MISSOURI HIGHWAYS AND TRANSPORTATION COMMISSION	
 105 WEST CAPITOL JEFFERSON CITY, MO 65102 1-888-ASK-MODOT (1-888-275-6636)	
 1301 BURLINGTON STREET, STE. 100 NORTH KANSAS CITY, MO 64116 PHONE: 816.361.1177 CERTIFICATE OF AUTHORITY NO. 001592	

IF A SEAL IS PRESENT ON THIS SHEET IT HAS BEEN ELECTRONICALLY SEALED AND DATED.

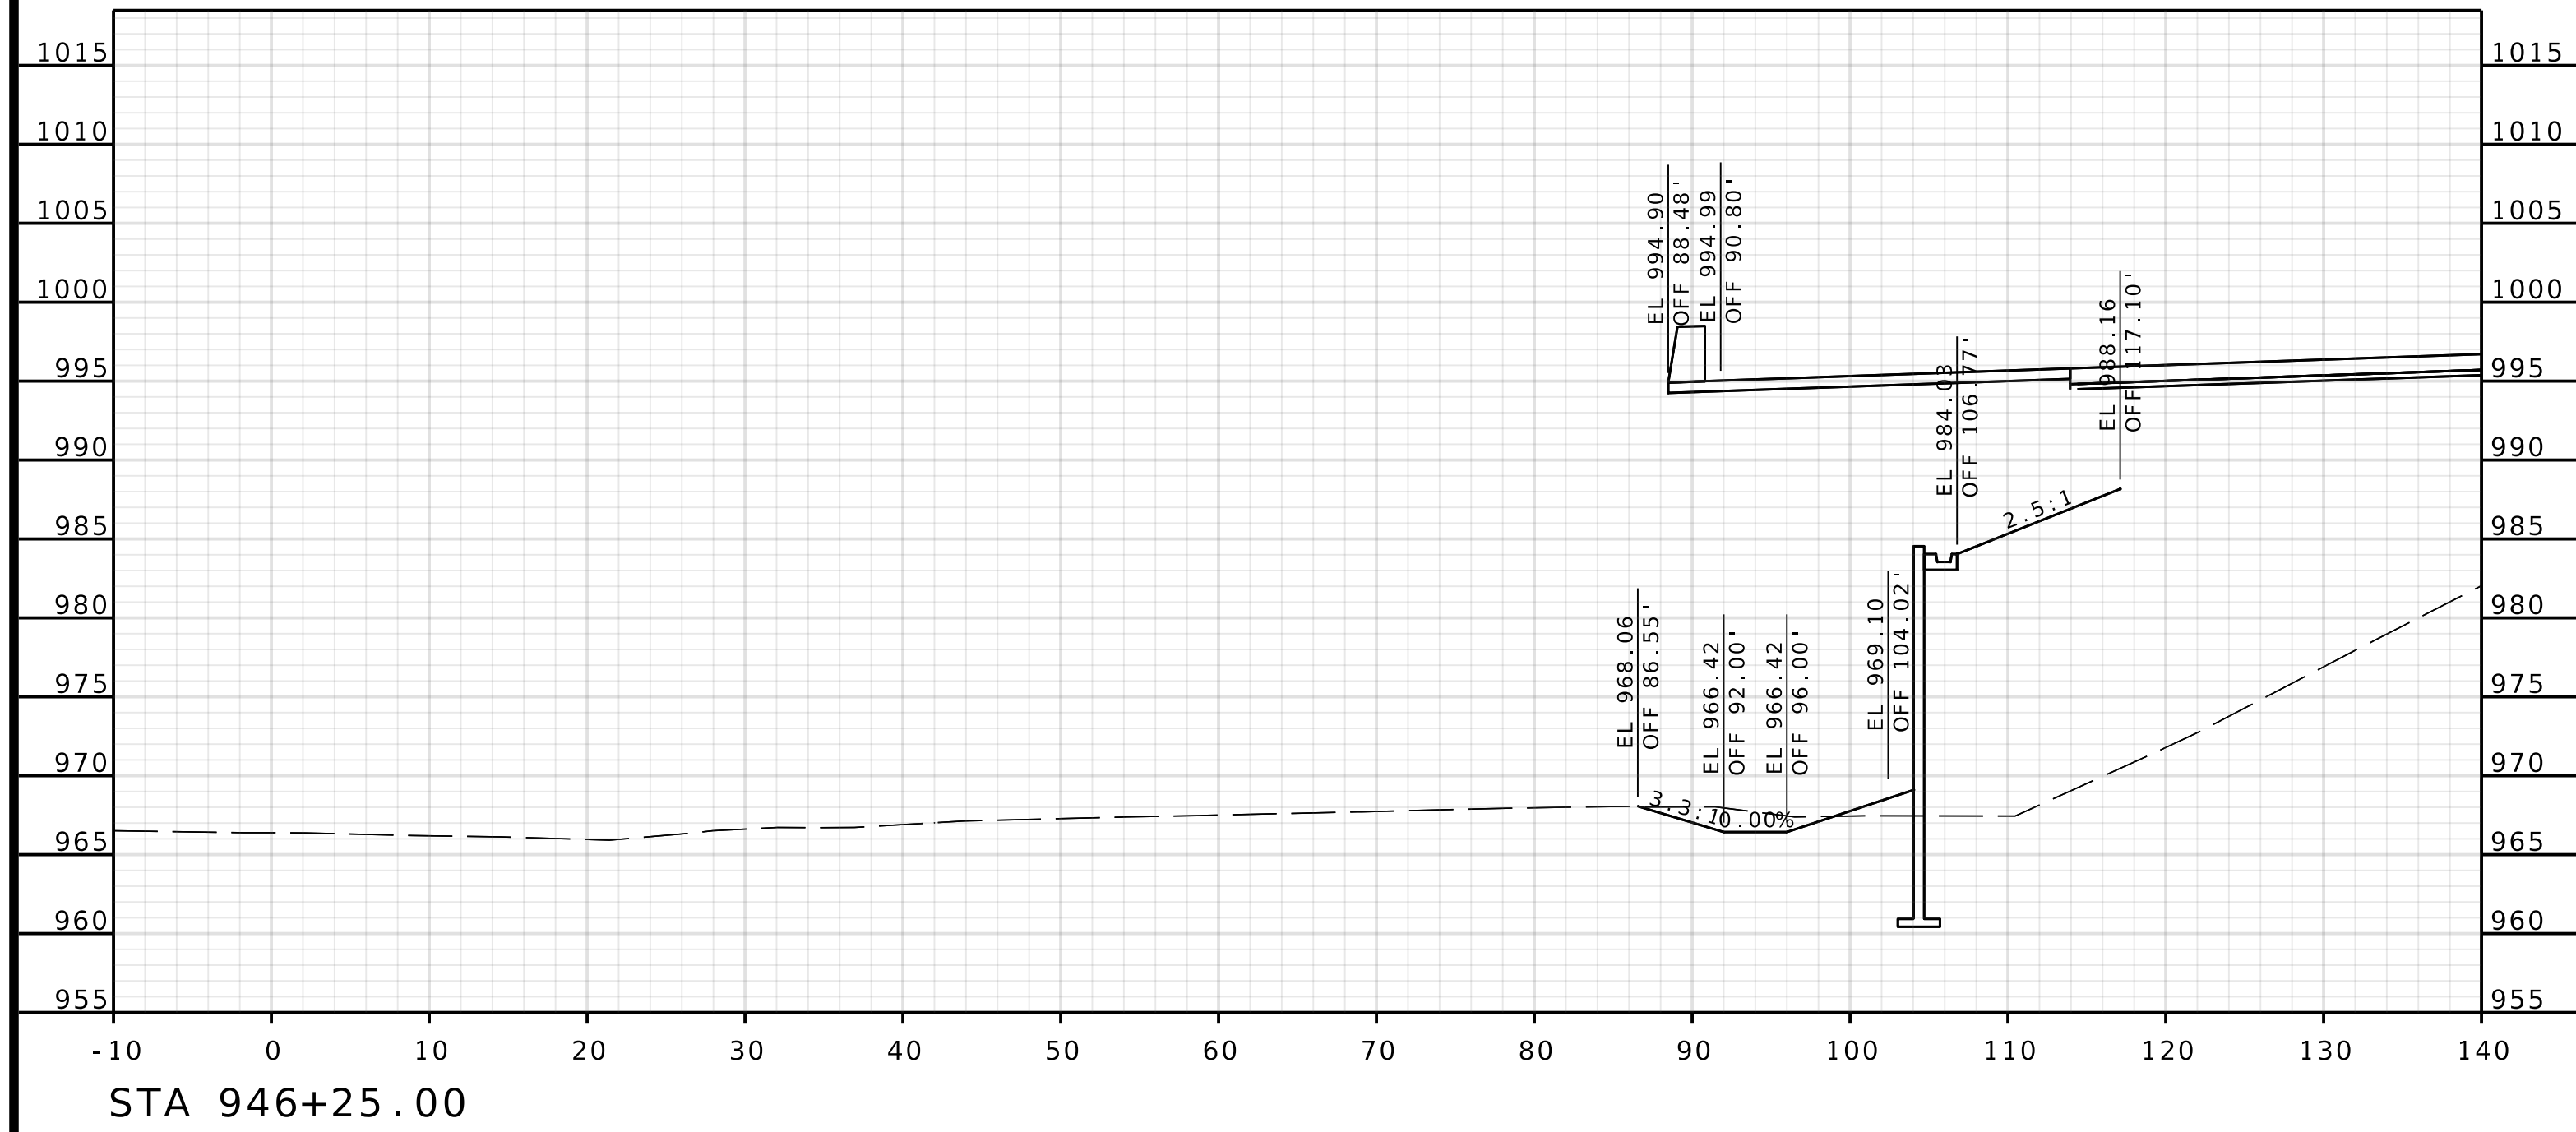

STA 946+25.00

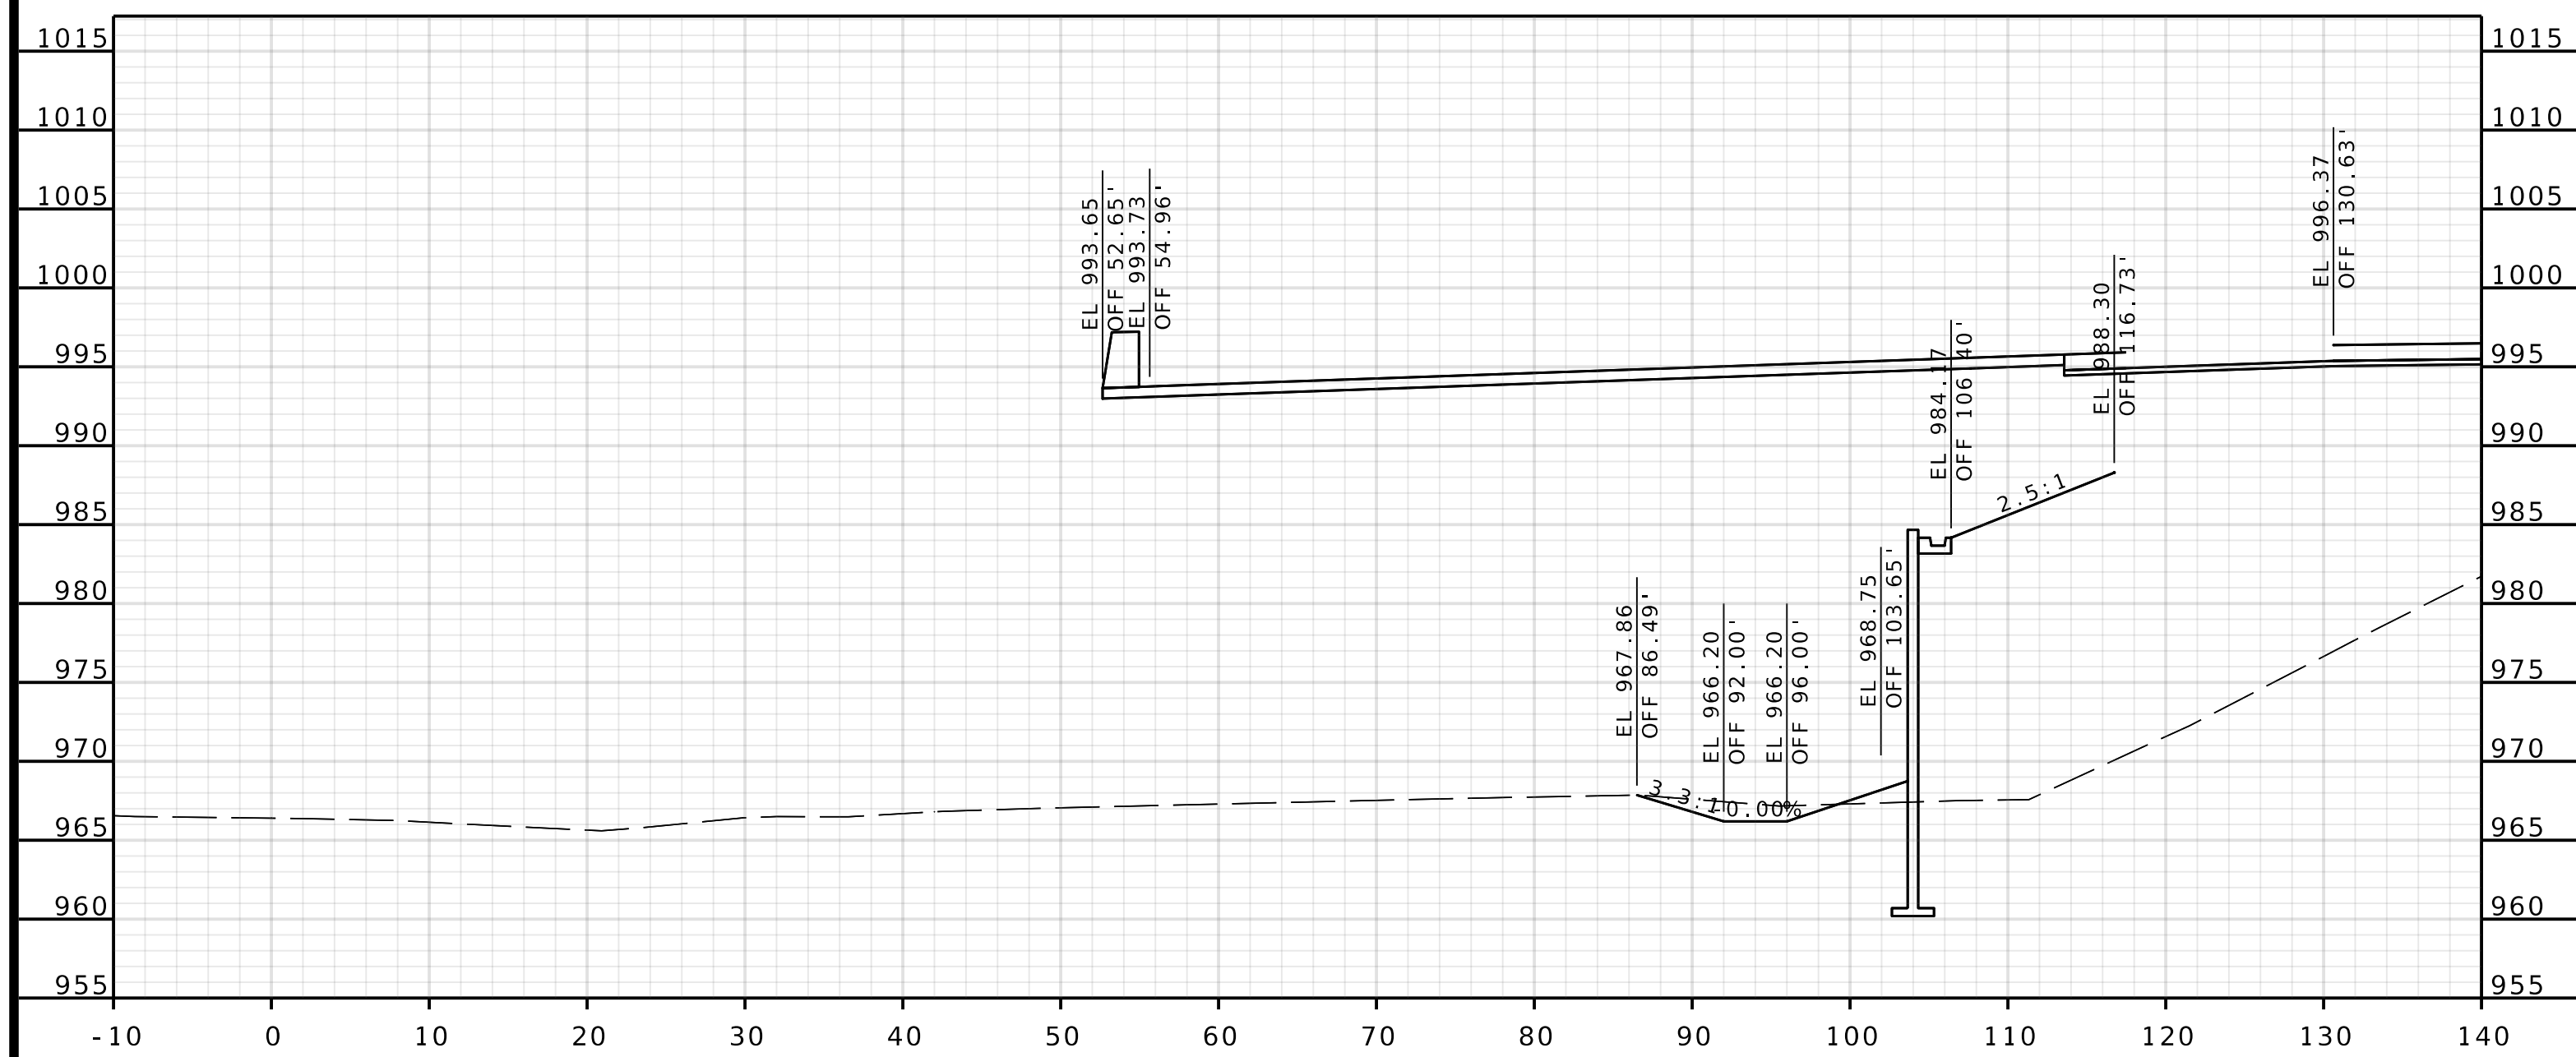


STA 946+00.00

DATE PREPARED 4/30/2025	
ROUTE 1435	STATE MO
DISTRICT KC	SHEET NO. 19
COUNTY PLATTE	
JOB NO. J4S3489	
CONTRACT ID.	
PROJECT NO.	
BRIDGE NO. A9700	

DATE	DESCRIPTION

MISSOURI HIGHWAYS AND TRANSPORTATION COMMISSION


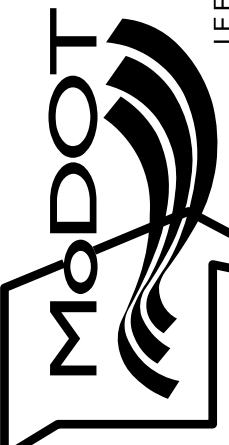


105 WEST CAPITOL
JEFFERSON CITY, MO 65102
1-888-ASK-MODOT (1-888-275-6636)



Olsson
1301 BURLINGTON STREET, STE. 100
NORTH KANSAS CITY, MO 64116
PHONE: 816.361.1177
CERTIFICATE OF AUTHORITY NO. 001592

ROUTE I-435
EBL




IF A SEAL IS PRESENT ON THIS SHEET IT HAS BEEN ELECTRONICALLY SEALED AND DATED.

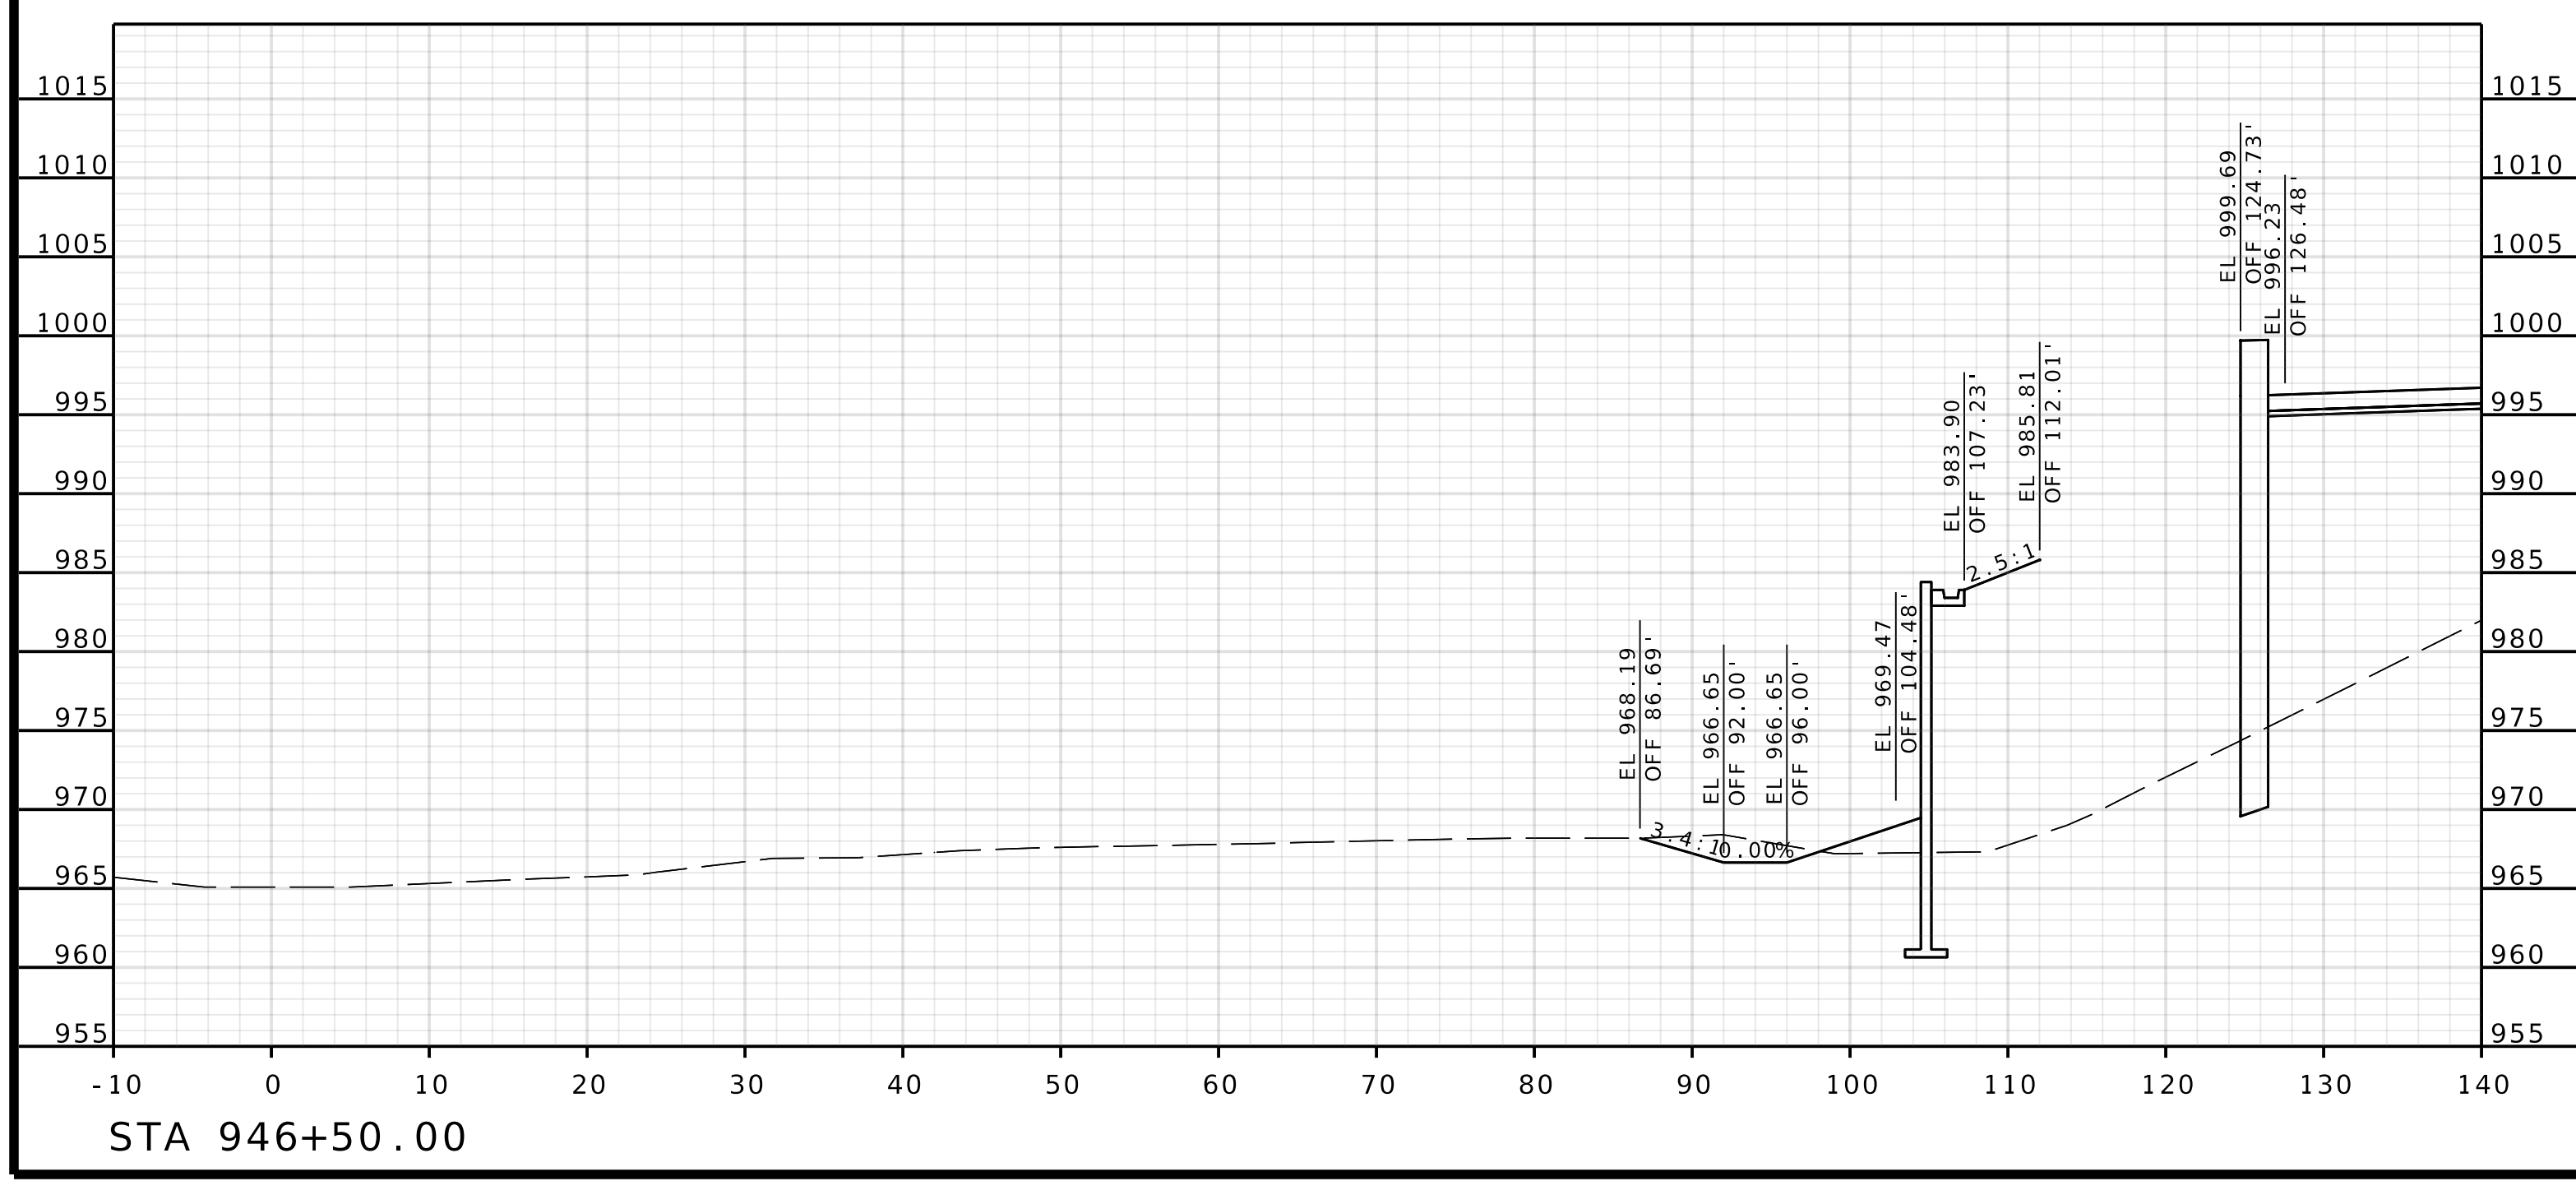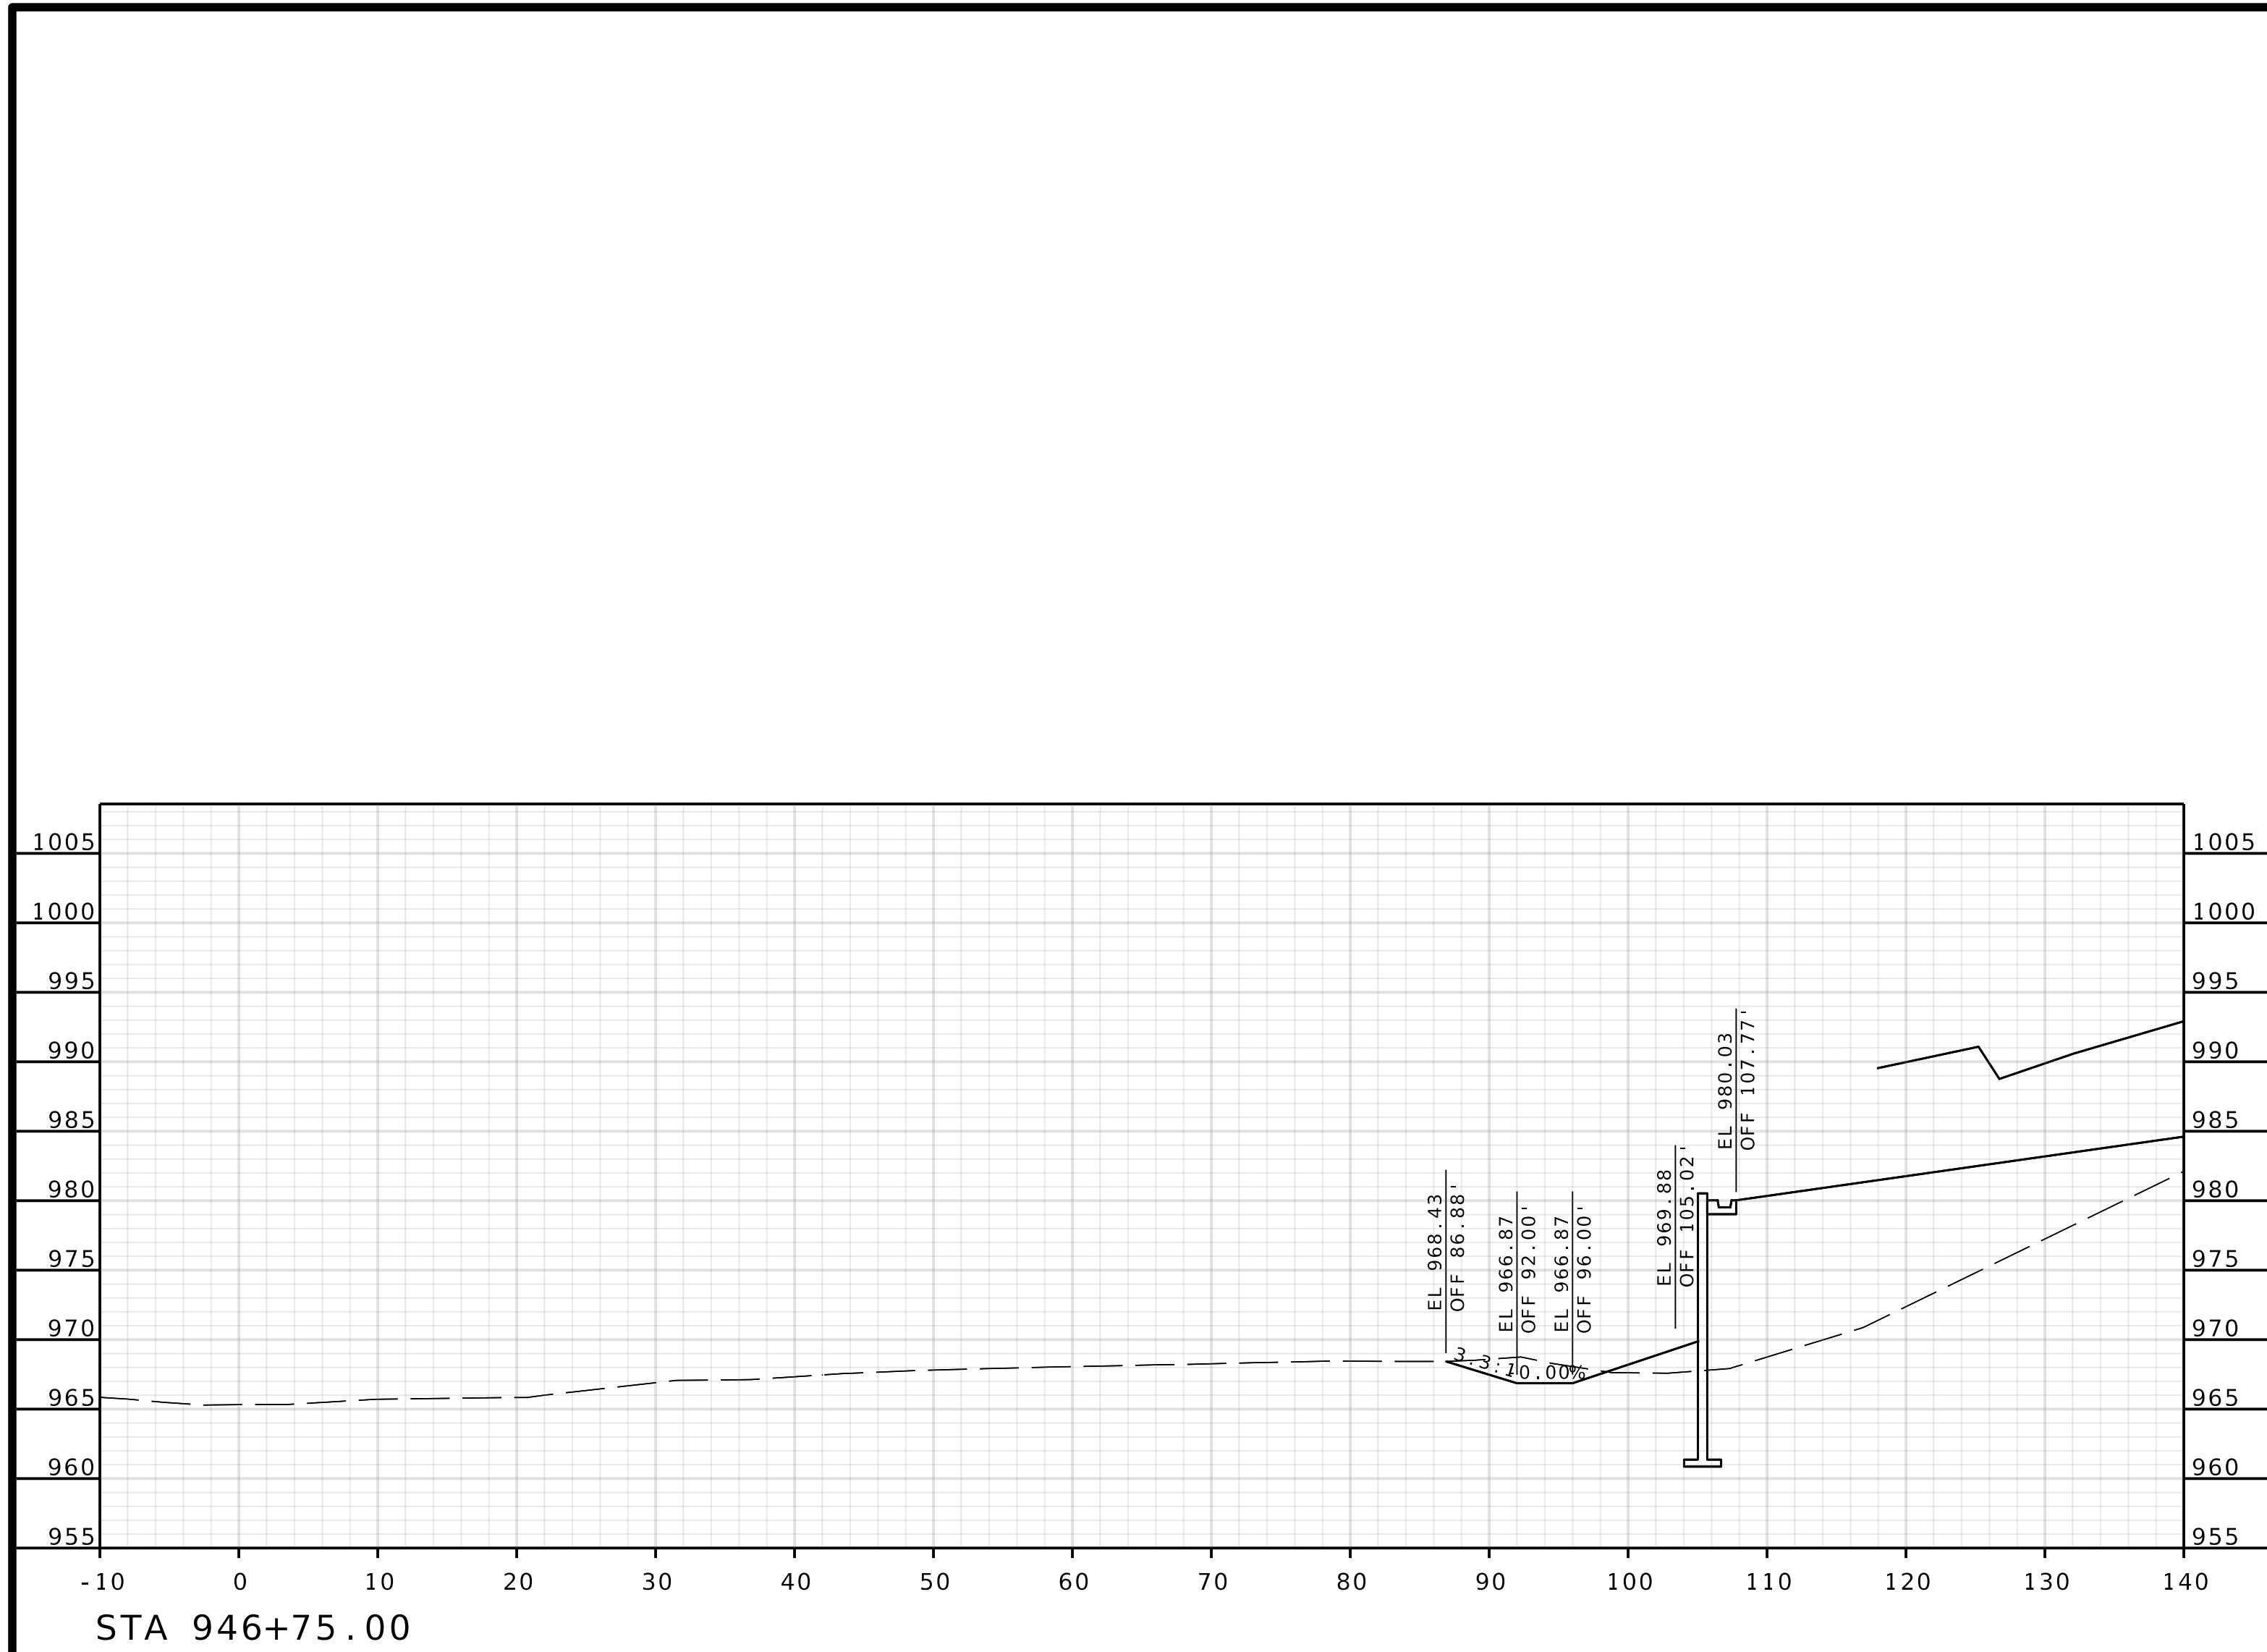

ROUTE I-435
EBL

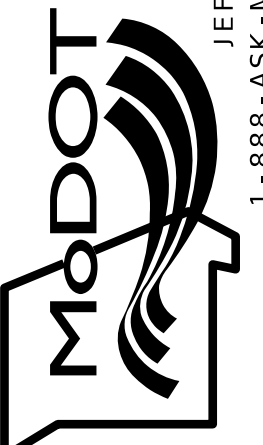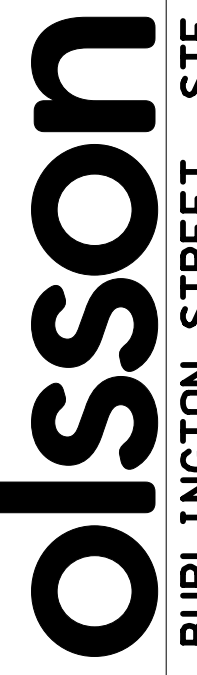DATE PREPARED 4/30/2025	
ROUTE 1435	STATE MO
DISTRICT KC	SHEET NO. 20
COUNTY PLATTE	
JOB NO. J4S3489	
CONTRACT ID.	
PROJECT NO.	
BRIDGE NO. A9700	
DATE	DESCRIPTION
MISSOURI HIGHWAYS AND TRANSPORTATION COMMISSION	
 105 WEST CAPITOL JEFFERSON CITY, MO 65102 1-888-ASK-MODOT (1-888-275-6636)	
 1301 BURLINGTON STREET, STE. 100 NORTH KANSAS CITY, MO 64116 PHONE: 816.361.1177 CERTIFICATE OF AUTHORITY NO. 001592	




IF A SEAL IS PRESENT ON THIS SHEET IT HAS BEEN ELECTRONICALLY SEALED AND DATED.

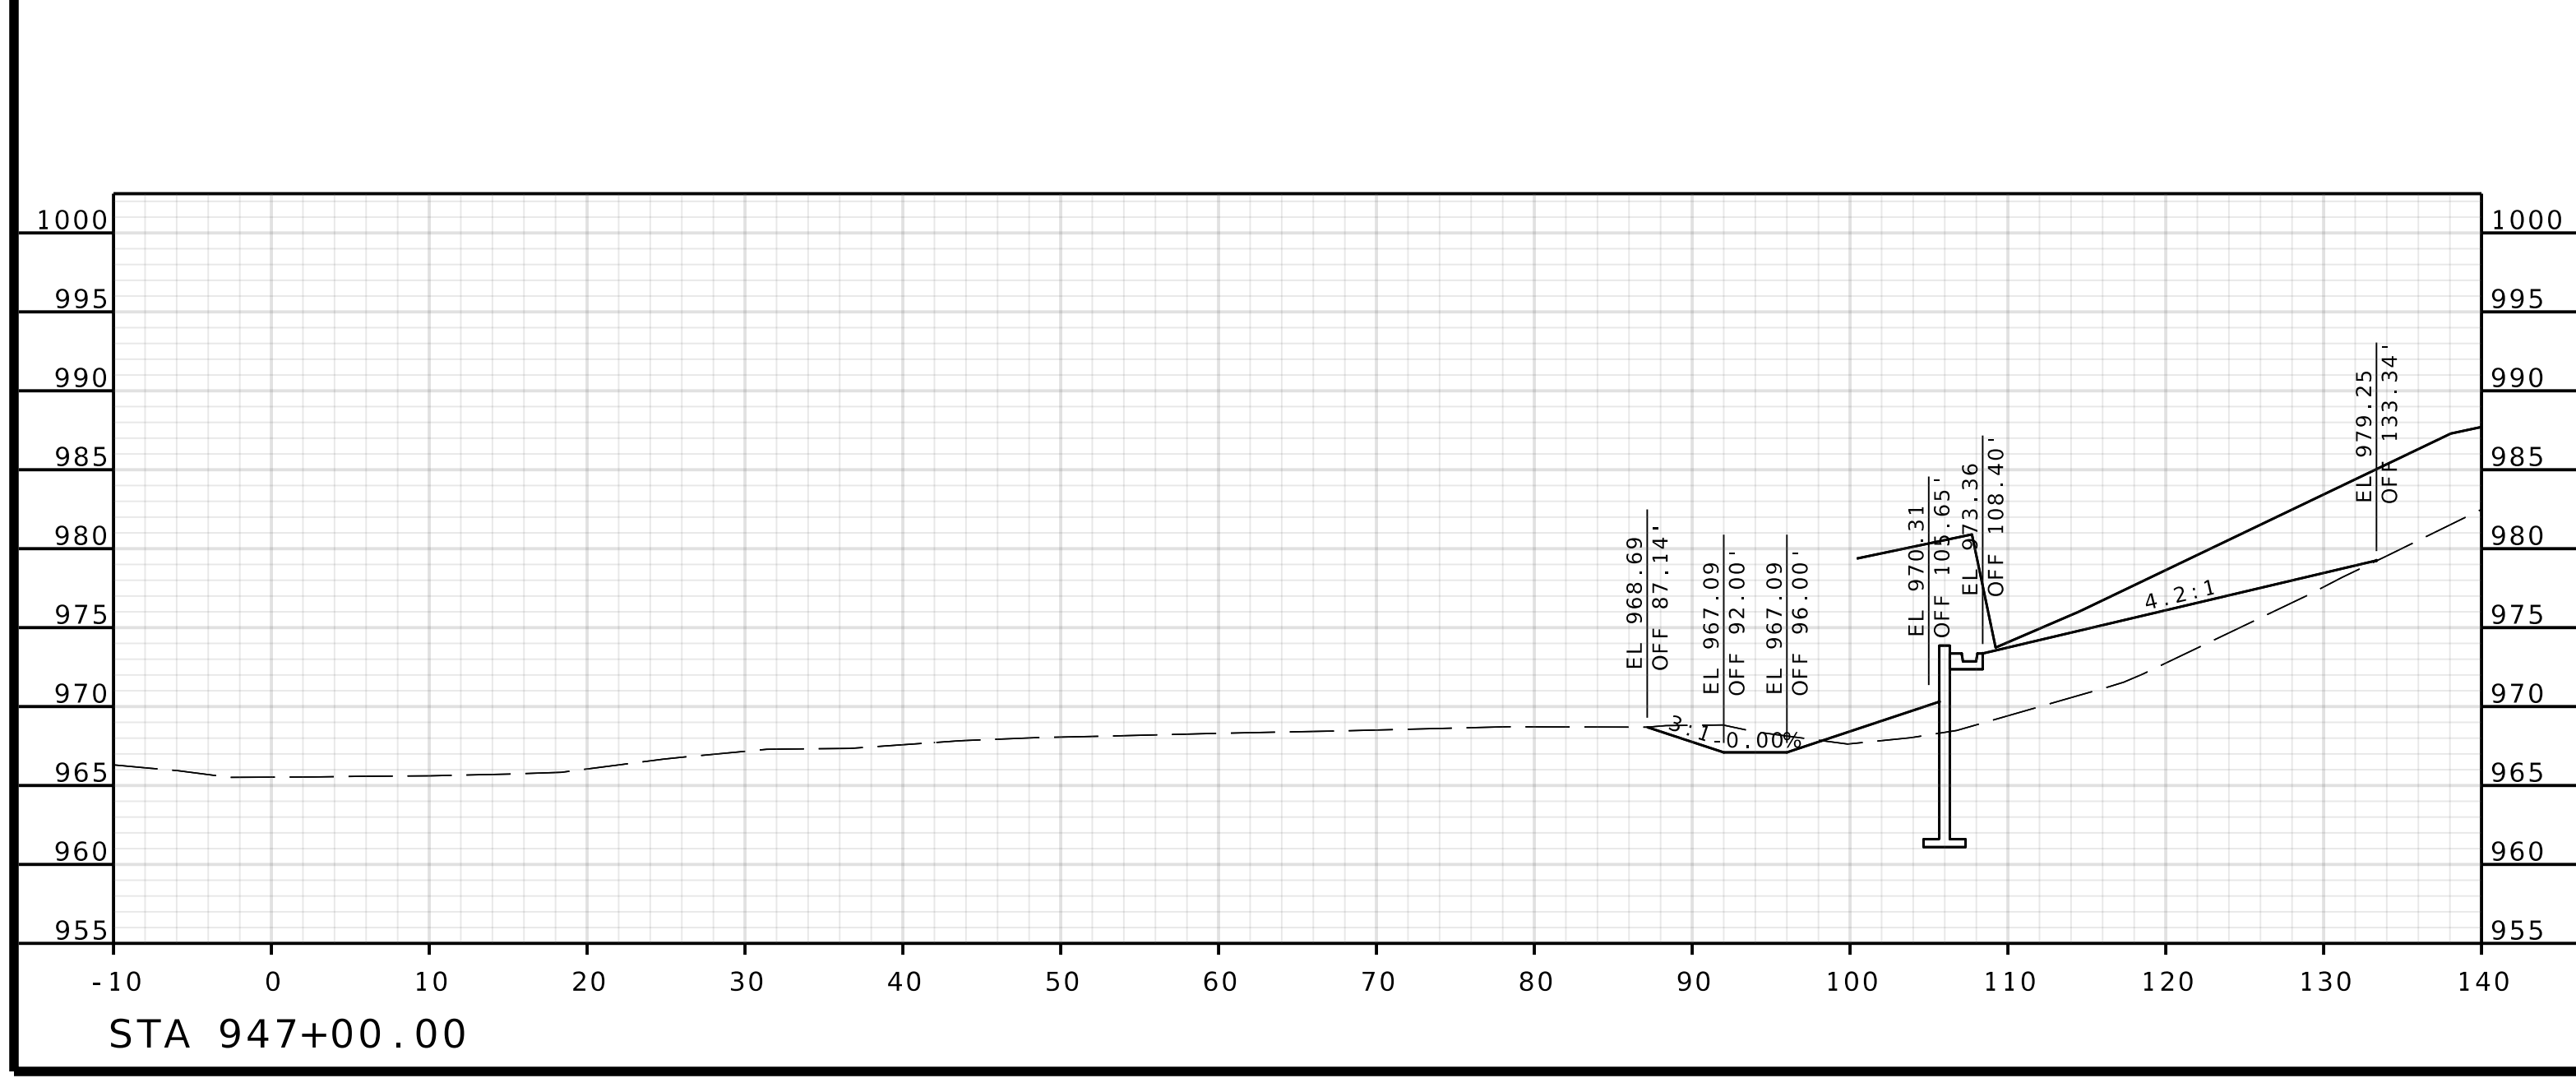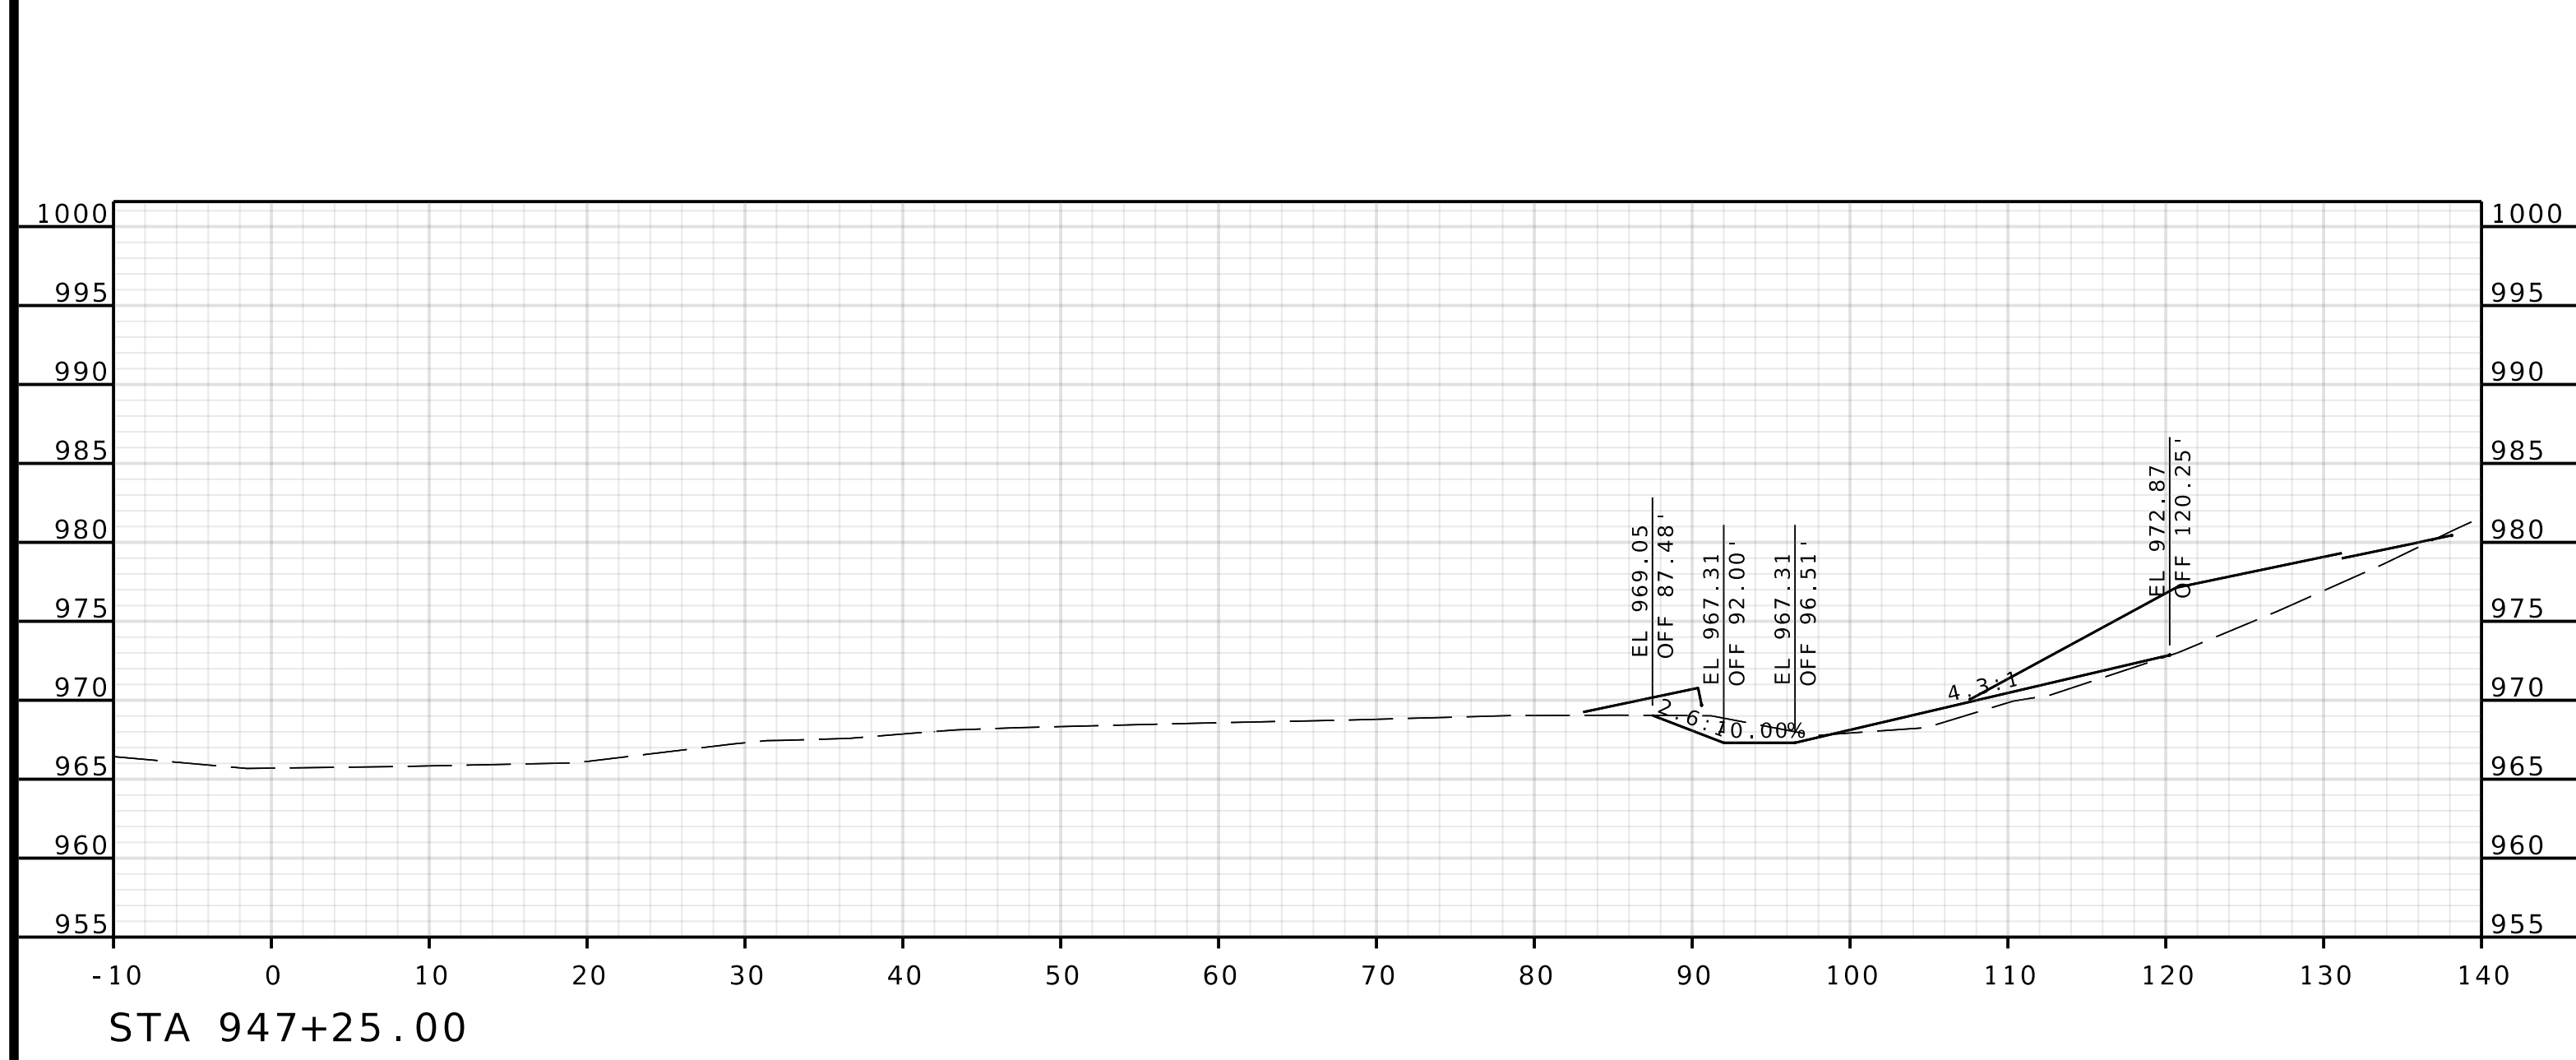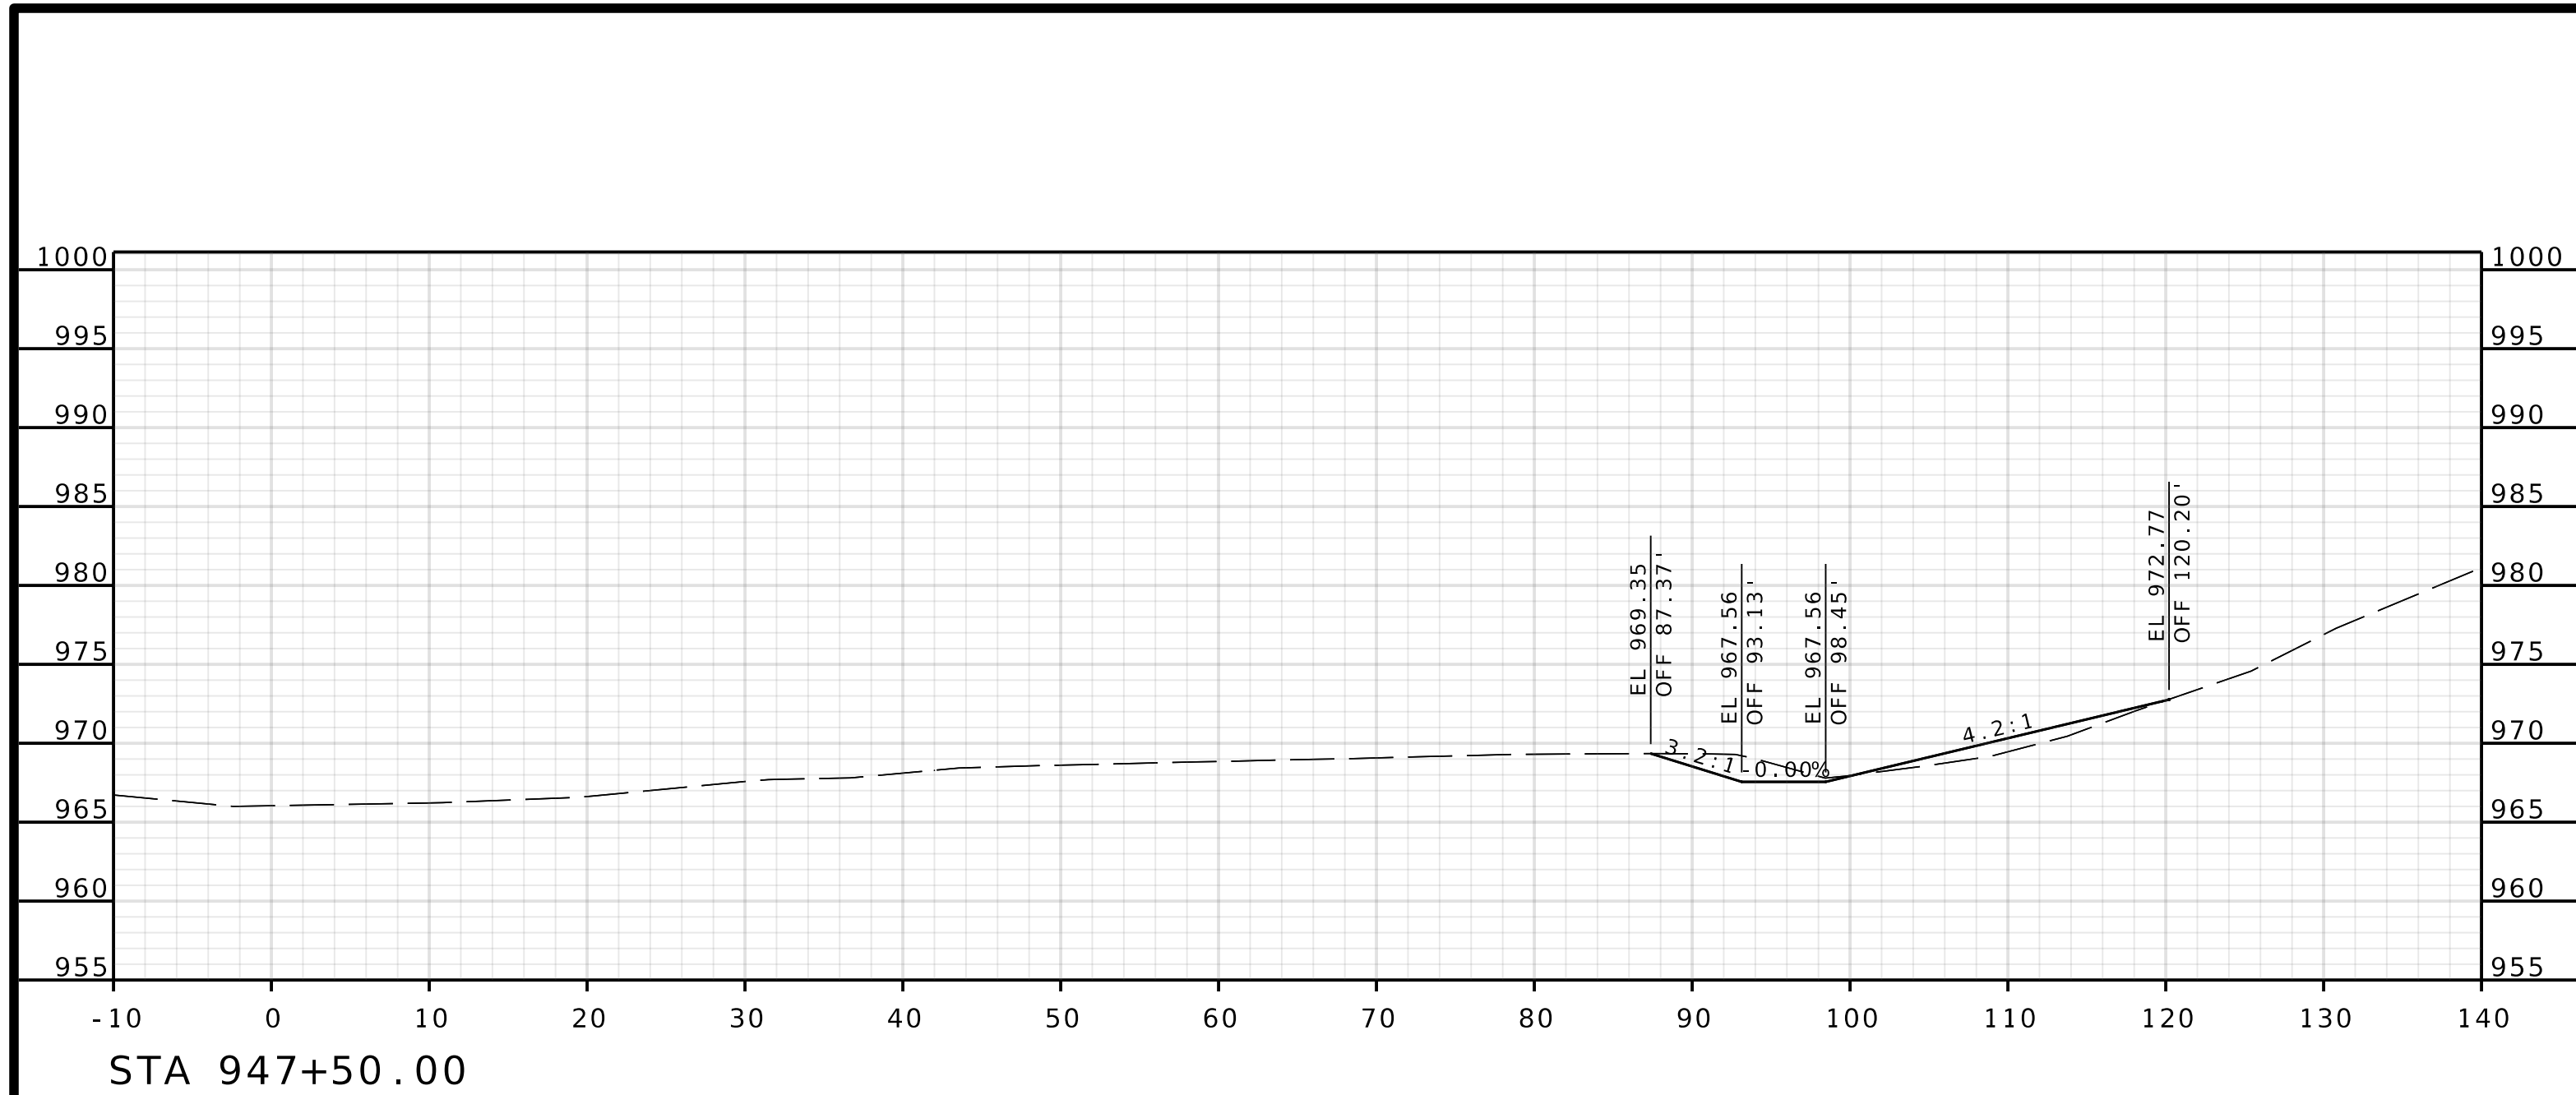

DATE PREPARED 4/30/2025	
ROUTE 1435	STATE MO
DISTRICT KC	SHEET NO. 21
COUNTY PLATTE	
JOB NO. J4S3489	
CONTRACT ID.	
PROJECT NO.	
BRIDGE NO. A9700	
DATE	DESCRIPTION
MISSOURI HIGHWAYS AND TRANSPORTATION COMMISSION 105 WEST CAPITOL JEFFERSON CITY, MO 65102 1-888-ASK-MODOT (1-888-275-6636)	
1301 BURLINGTON STREET, STE. 100 NORTH KANSAS CITY, MO 64116 PHONE: 816.361.1177 CERTIFICATE OF AUTHORITY NO. 001592	

ROUTE I-435
EBL

IF A SEAL IS PRESENT ON THIS SHEET IT HAS BEEN ELECTRONICALLY SEALED AND DATED.

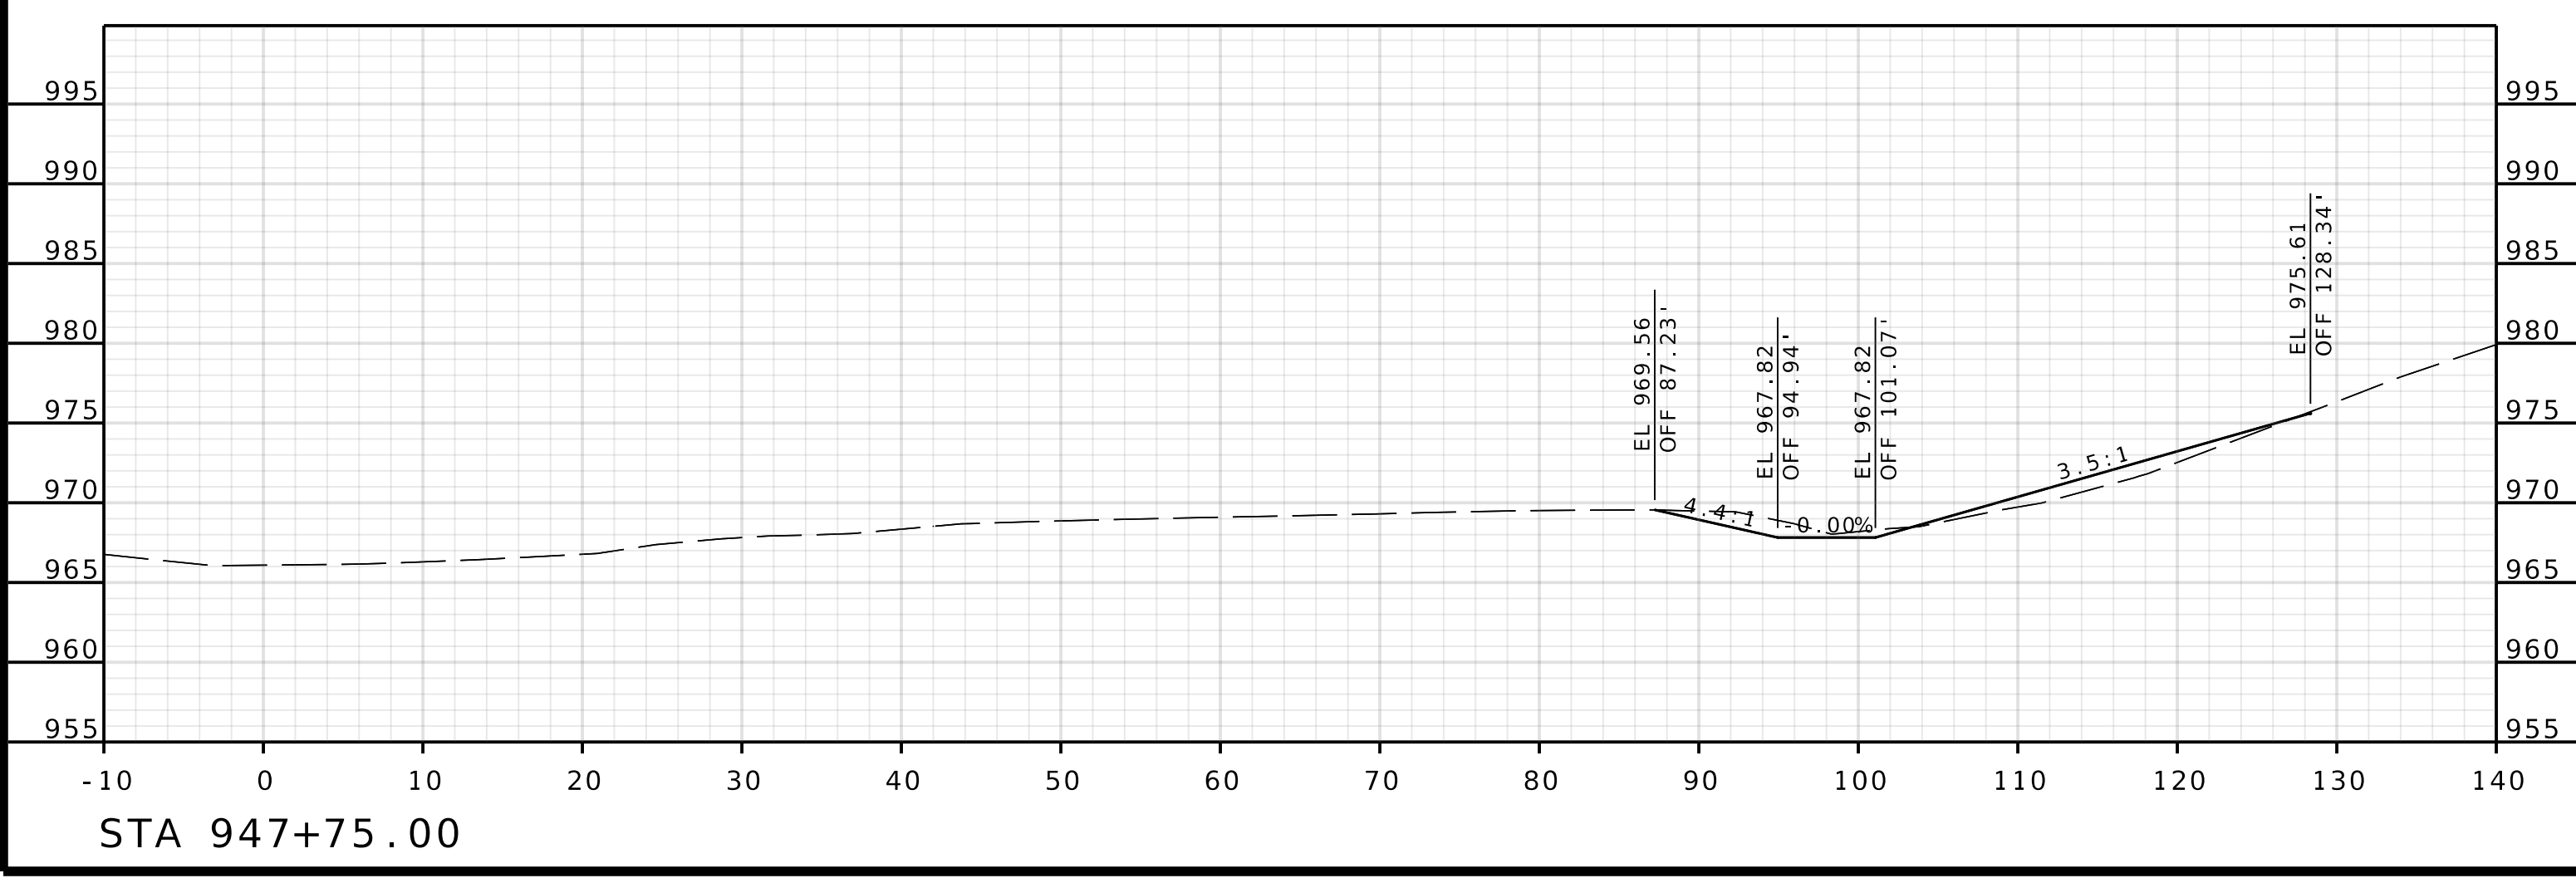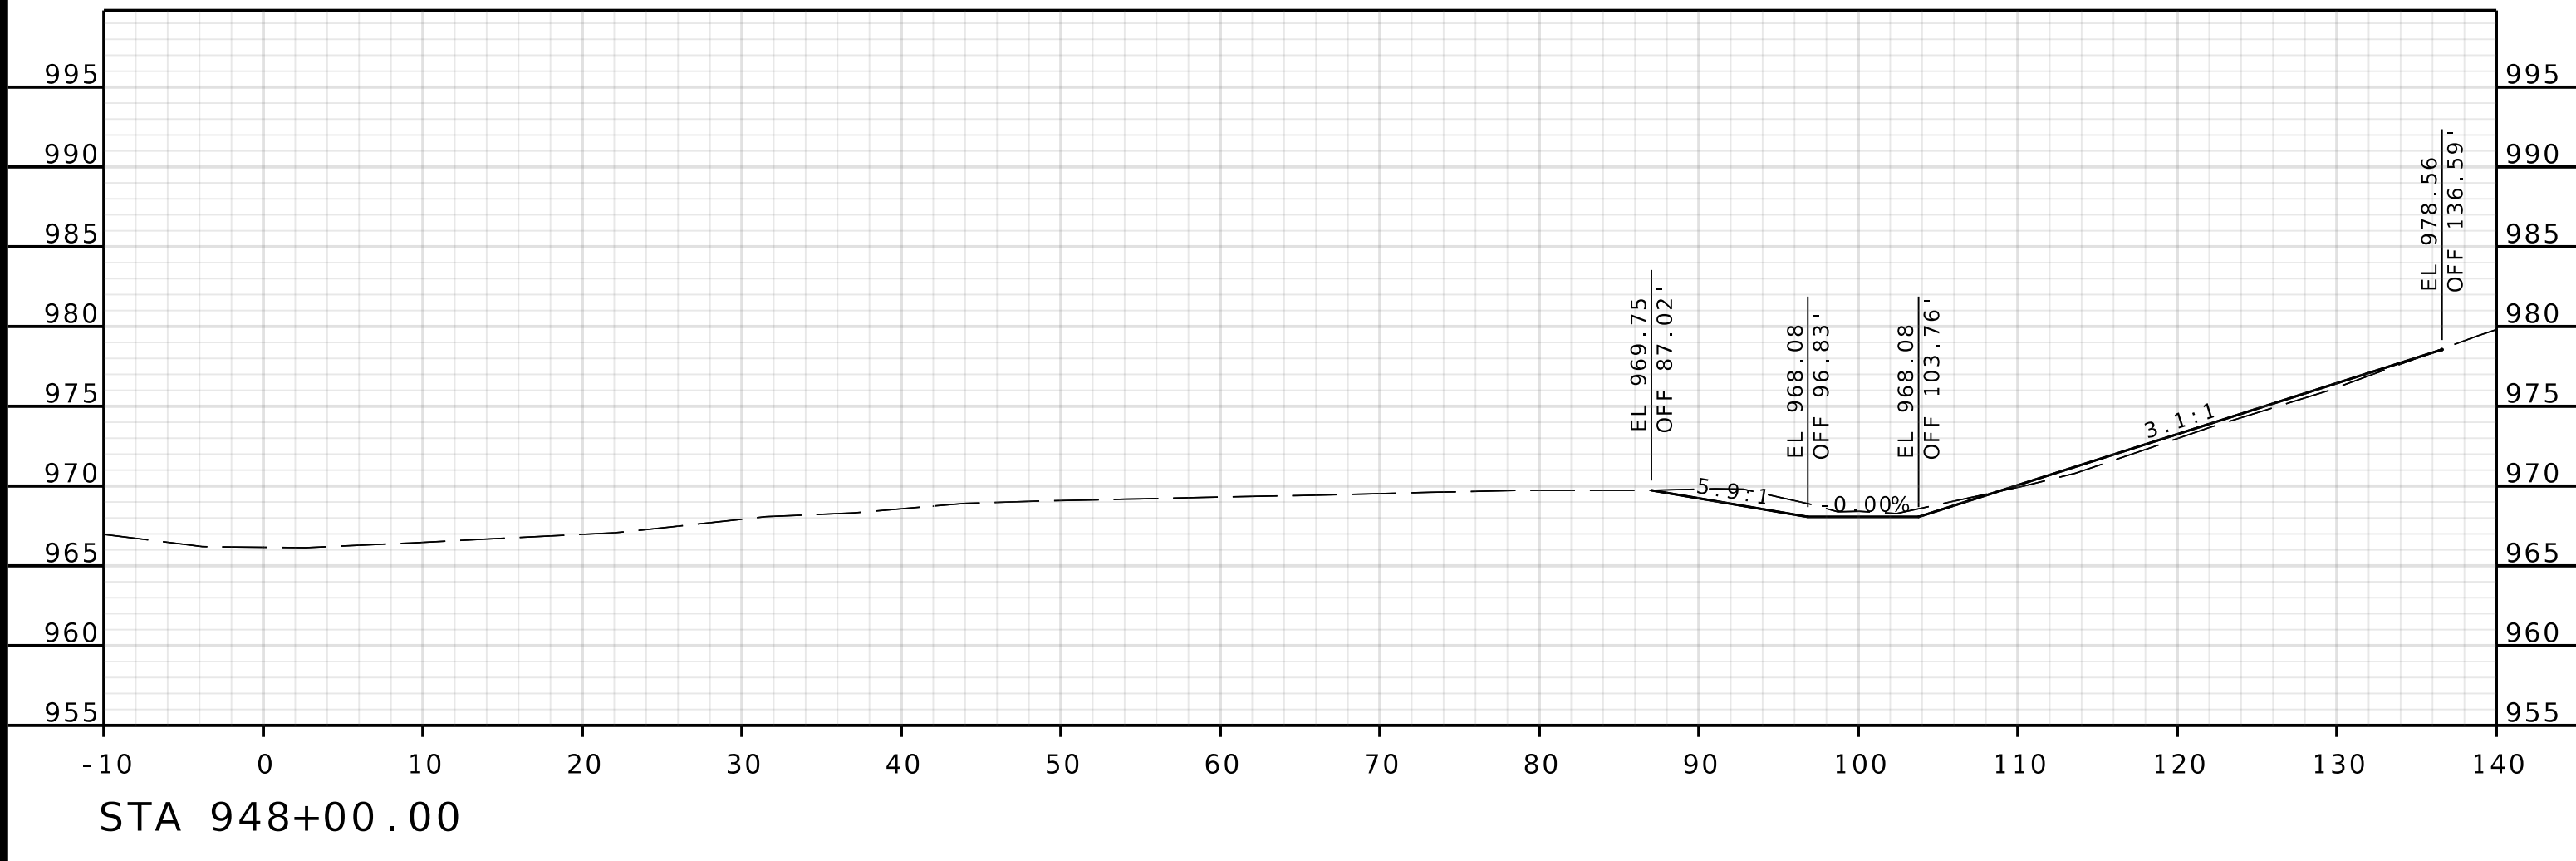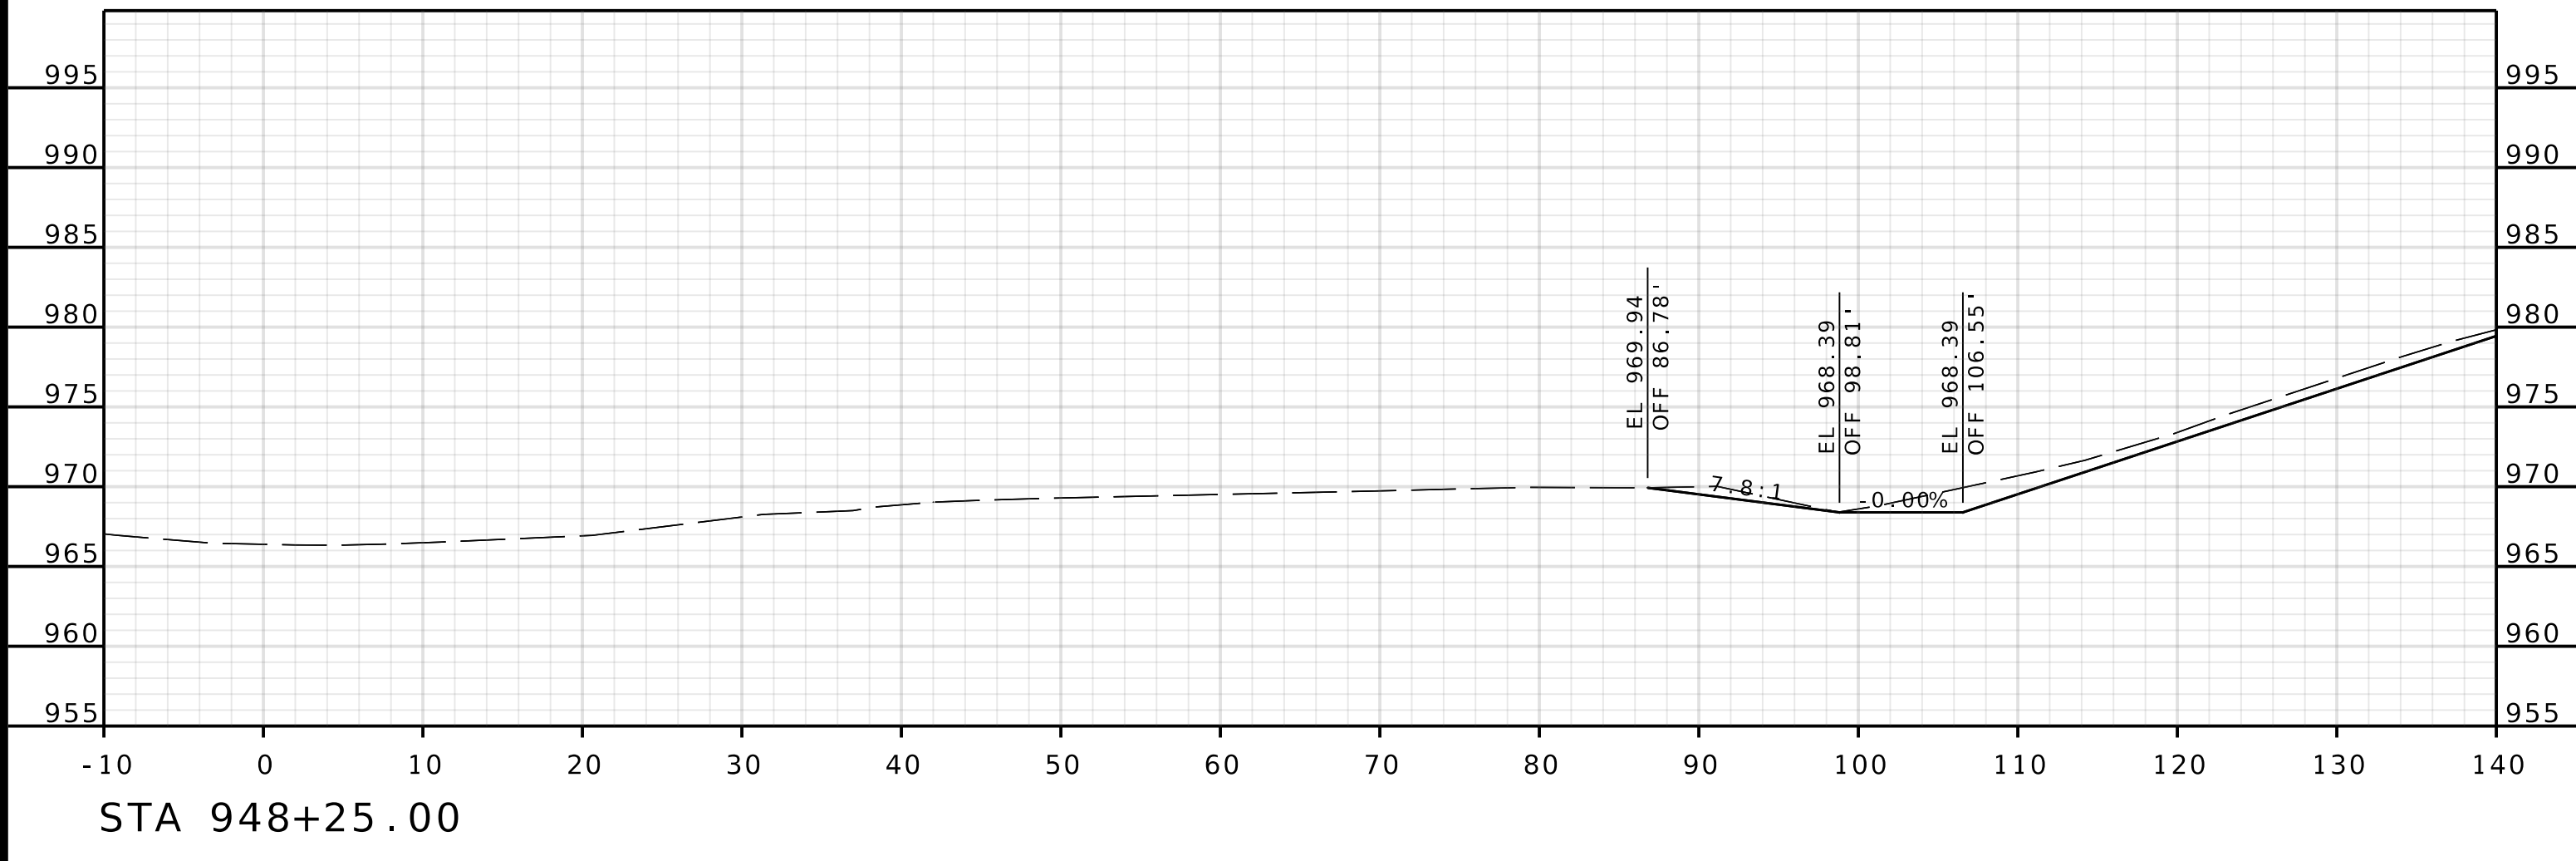

DATE PREPARED 4/30/2025	
ROUTE 1435	STATE MO
DISTRICT KC	SHEET NO. 22
COUNTY PLATTE	
JOB NO. J4S3489	
CONTRACT ID.	
PROJECT NO.	
BRIDGE NO. A9700	

DATE	DESCRIPTION


MISSOURI HIGHWAYS AND TRANSPORTATION COMMISSION

105 WEST CAPITOL
JEFFERSON CITY, MO 65102
1-888-ASK-MODOT (1-888-275-6636)

Olsson
1301 BURLINGTON STREET, STE. 100
NORTH KANSAS CITY, MO 64116
PHONE: 816.361.1177
CERTIFICATE OF AUTHORITY NO. 001592

ROUTE I-435
EBL

IF A SEAL IS PRESENT ON THIS SHEET IT HAS BEEN ELECTRONICALLY SEALED AND DATED.

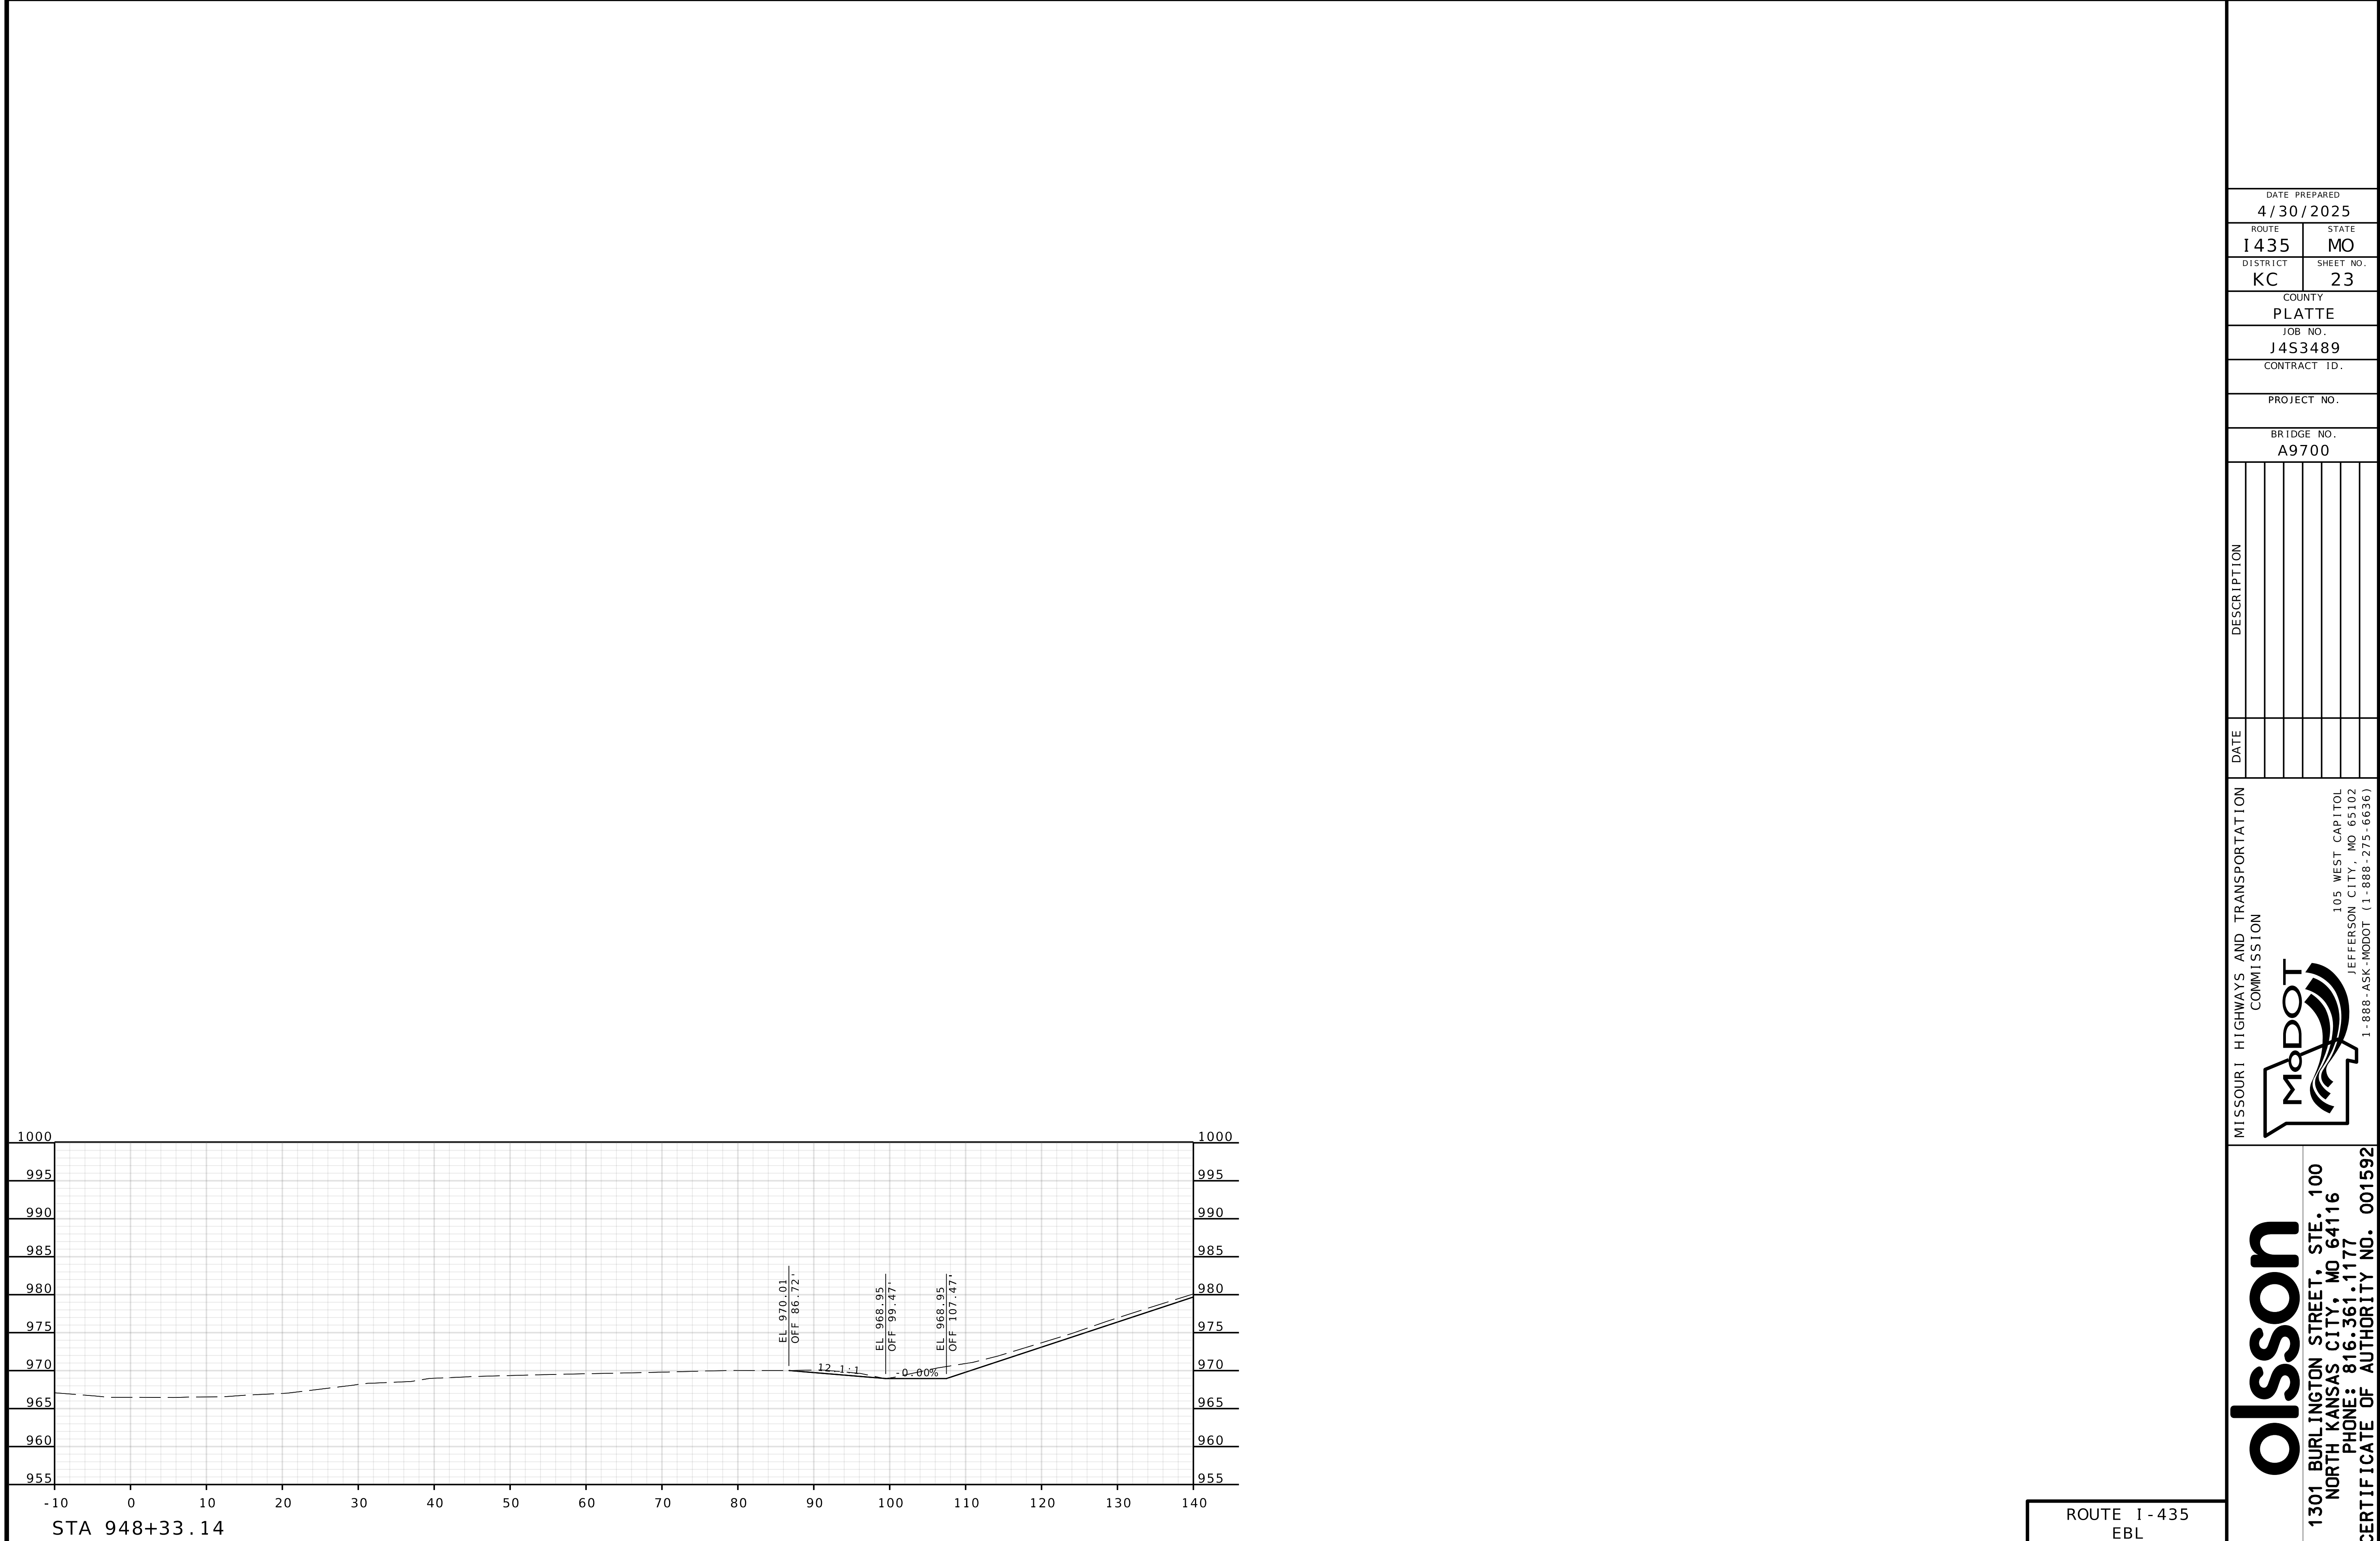


STA 948+33.14

ROUTE I - 435
EBL

DATE PREPARED 4/30/2025	
ROUTE 1435	STATE MO
DISTRICT KC	SHEET NO. 23
COUNTY PLATTE	
JOB NO. J4S3489	
CONTRACT ID.	
PROJECT NO.	
BRIDGE NO. A9700	
DATE	DESCRIPTION


MISSOURI HIGHWAYS AND TRANSPORTATION COMMISSION

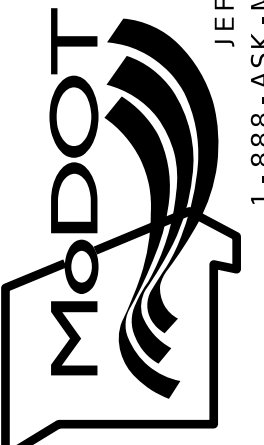


105 WEST CAPITOL
JEFFERSON CITY, MO 65102
1-888-ASK-MODOT (1-888-275-6636)

Olsson
1301 BURLINGTON STREET, STE. 100
NORTH KANSAS CITY, MO 64116
PHONE: 816.361.1177
CERTIFICATE OF AUTHORITY NO. 001592


IF A SEAL IS PRESENT ON THIS SHEET IT HAS BEEN ELECTRONICALLY SEALED AND DATED.

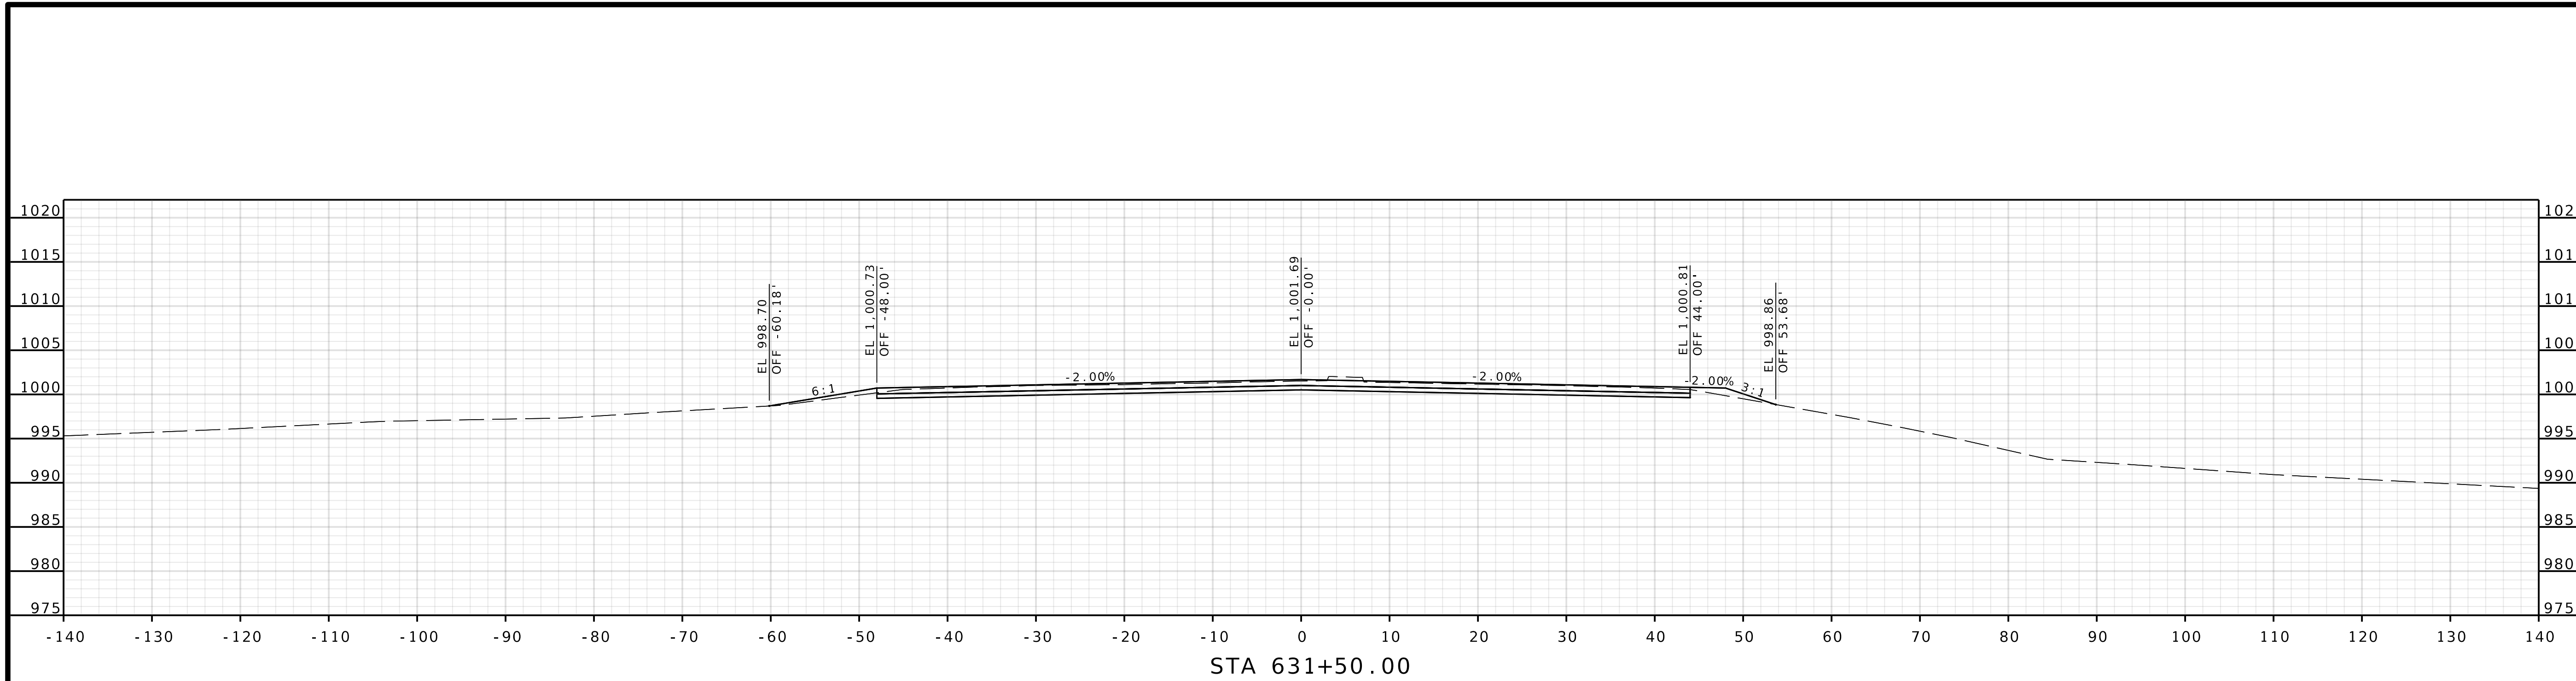

STA 631+50.00


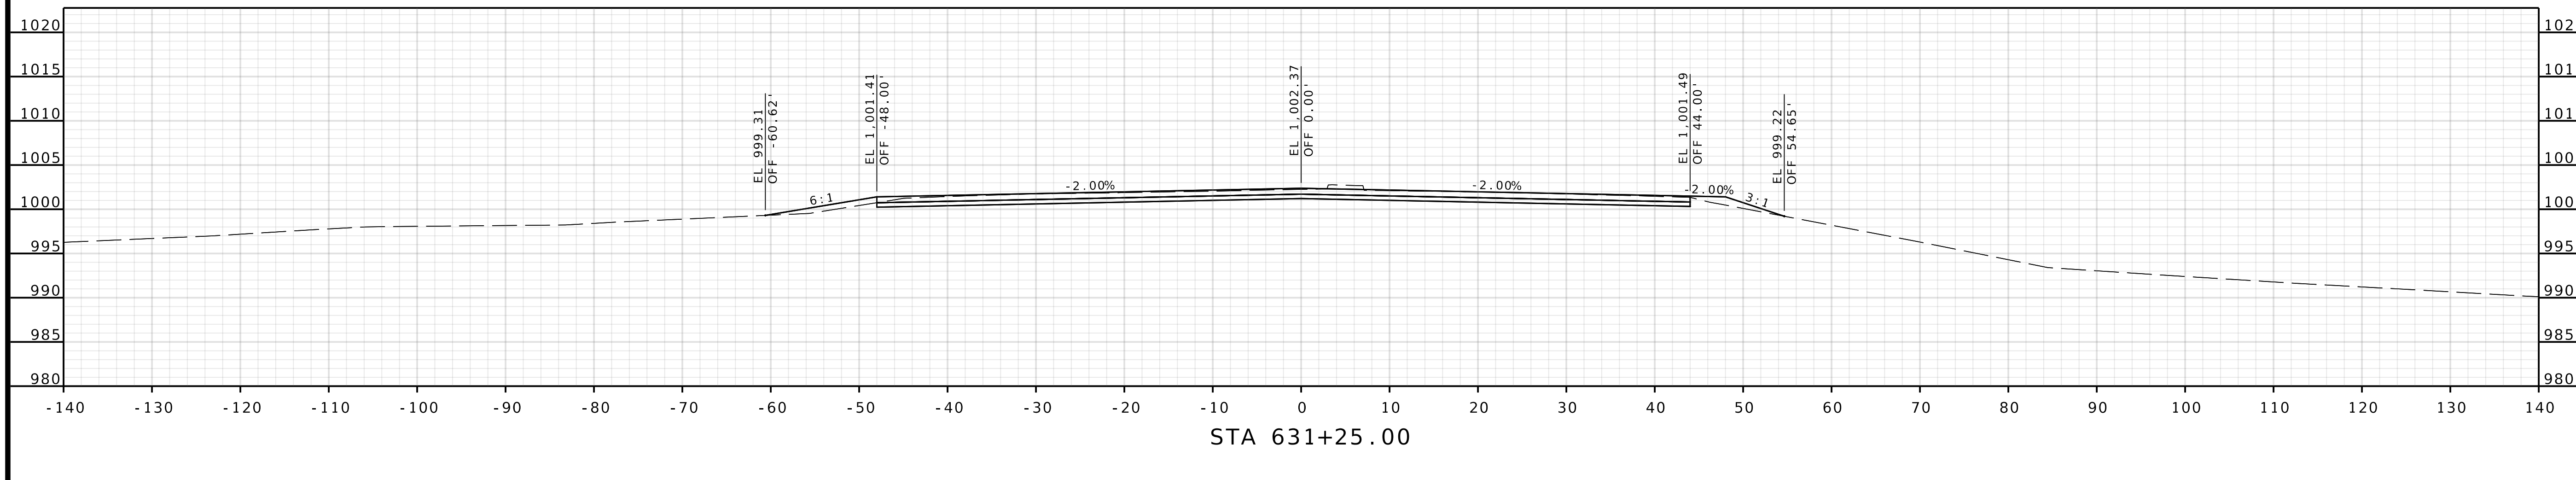


STA 631+25.00

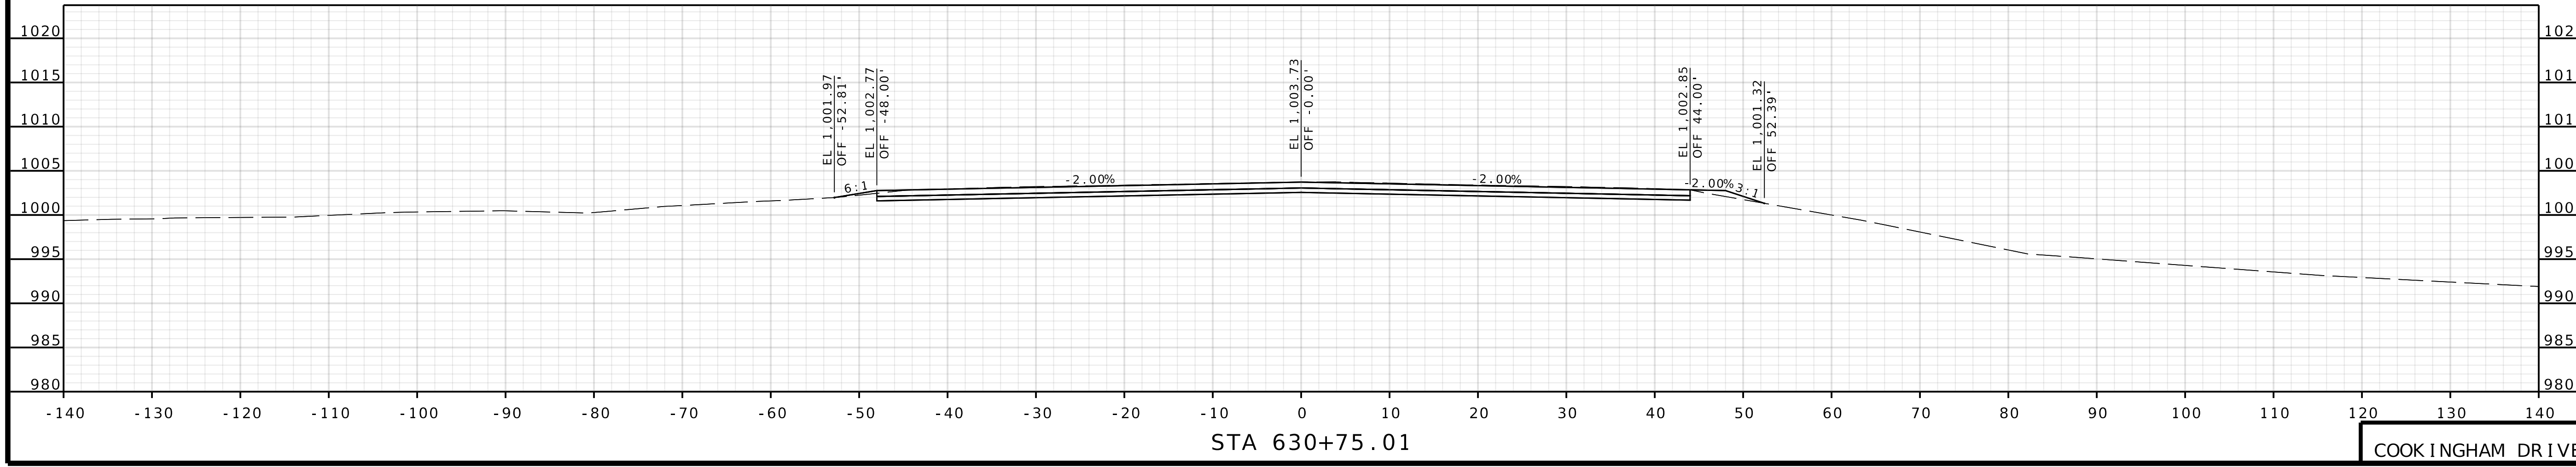


STA 630+75.01


COOKINGHAM DRIVE

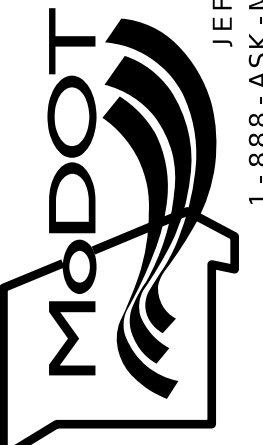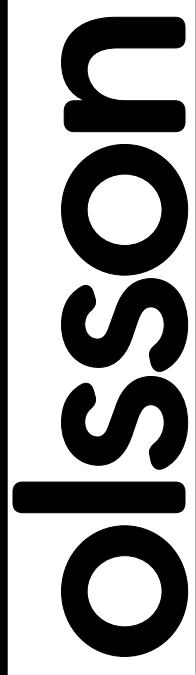DATE PREPARED 4/30/2025	
ROUTE 1435	STATE MO
DISTRICT KC	SHEET NO. 24
COUNTY PLATTE	
JOB NO. J4S3489	
CONTRACT ID.	
PROJECT NO.	
BRIDGE NO. A9700	
DESCRIPTION	
DATE	
MISSOURI HIGHWAYS AND TRANSPORTATION COMMISSION	
 105 WEST CAPITOL JEFFERSON CITY, MO 65102 1-888-ASK-MODOT (1-888-275-6636)	
 1301 BURLINGTON STREET, STE. 100 NORTH KANSAS CITY, MO 64116 PHONE: 816.361.1177 CERTIFICATE OF AUTHORITY NO. 001592	


IF A SEAL IS PRESENT ON THIS SHEET IT HAS BEEN ELECTRONICALLY SEALED AND DATED.

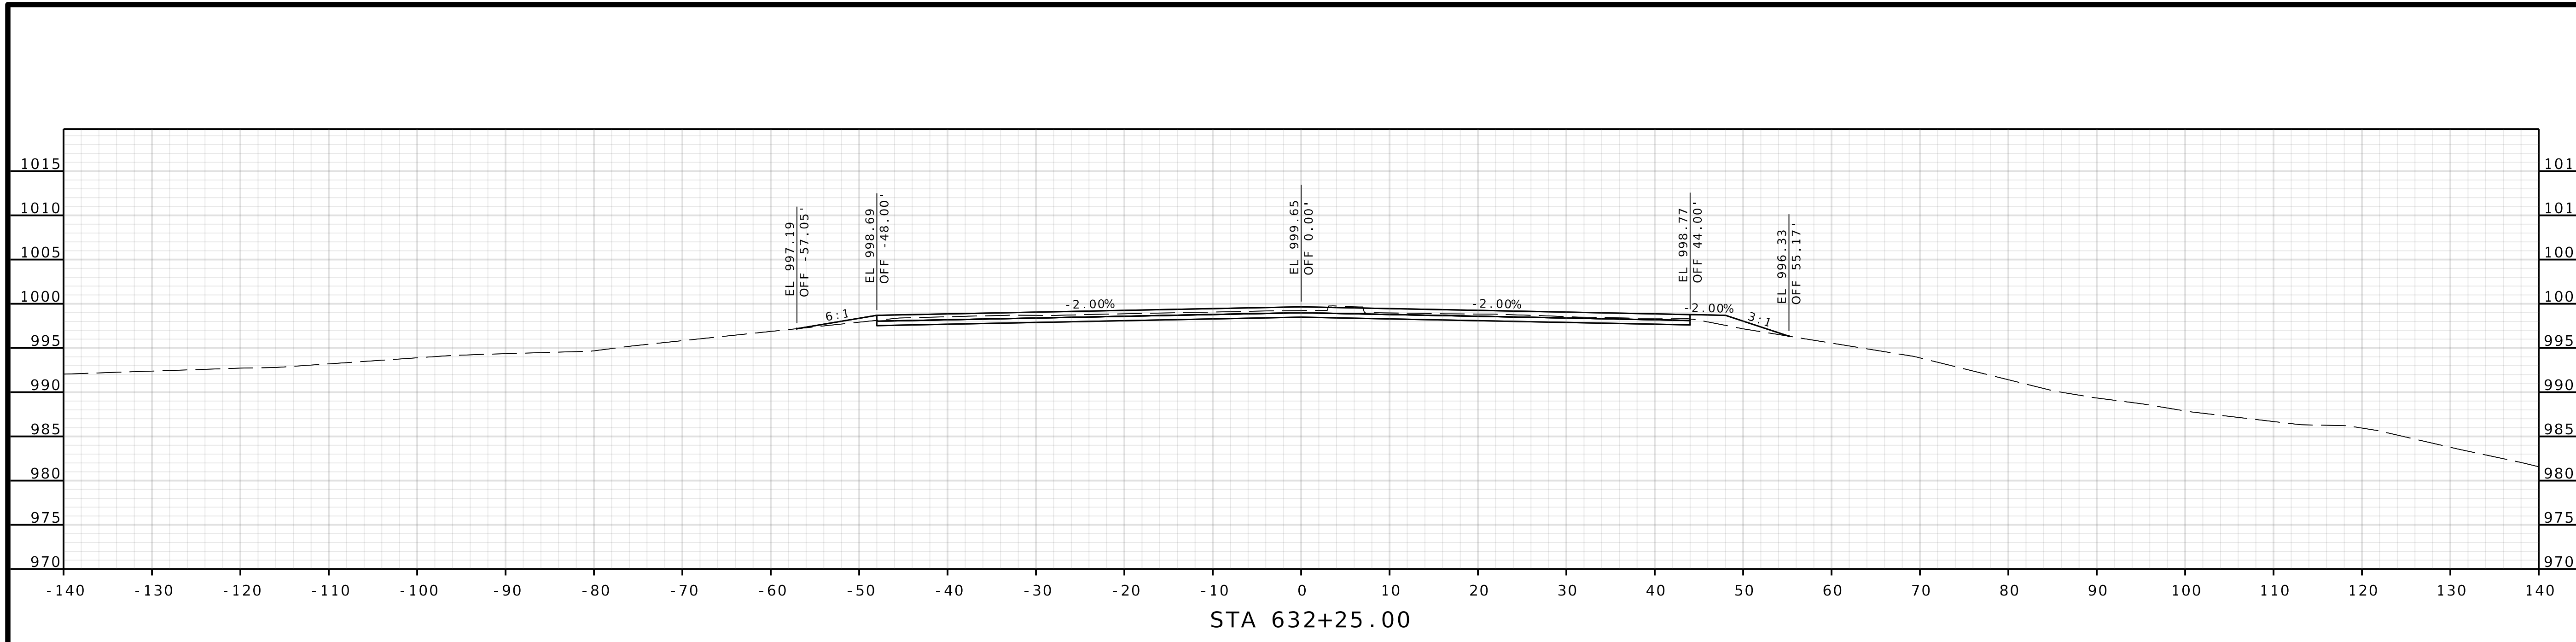

STA 632+25.00


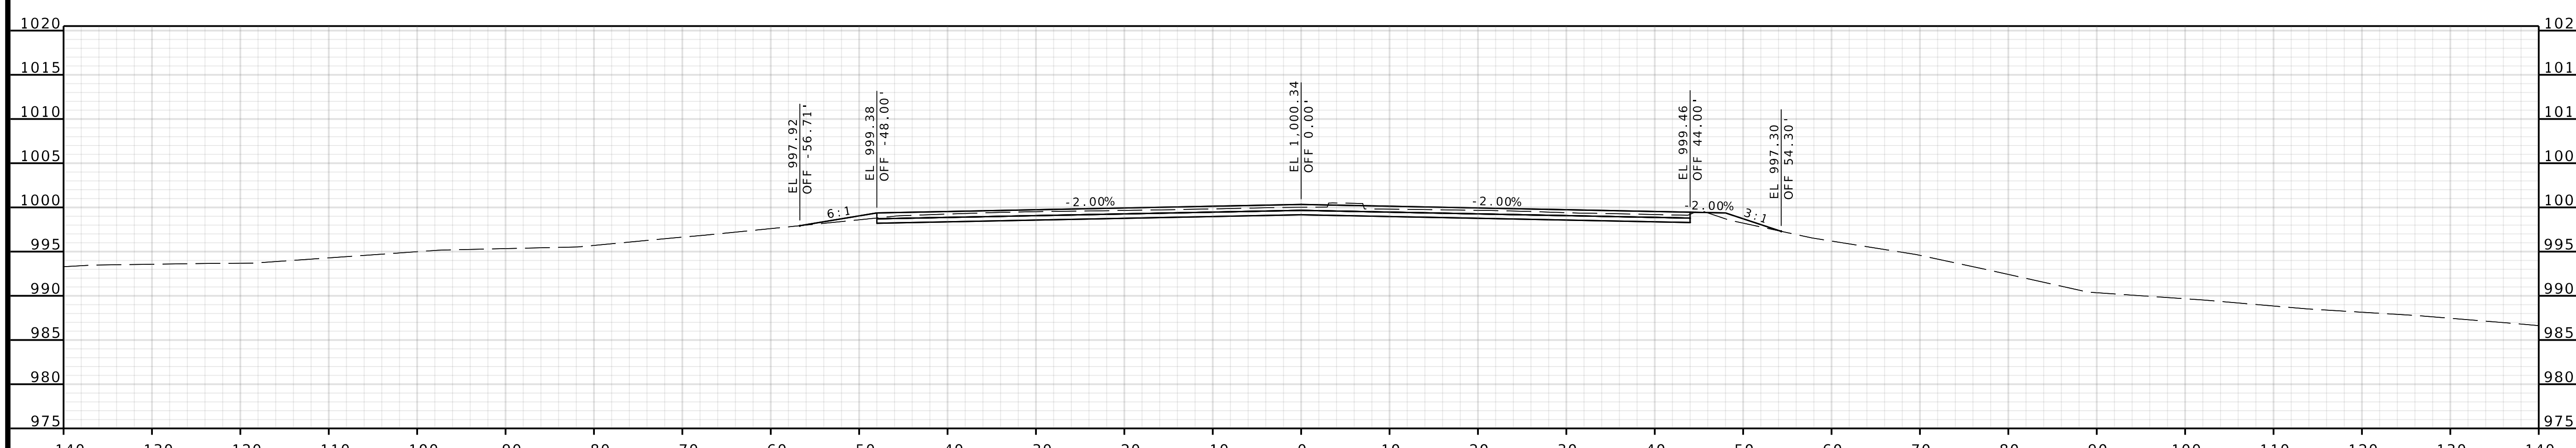


STA 632+00.00

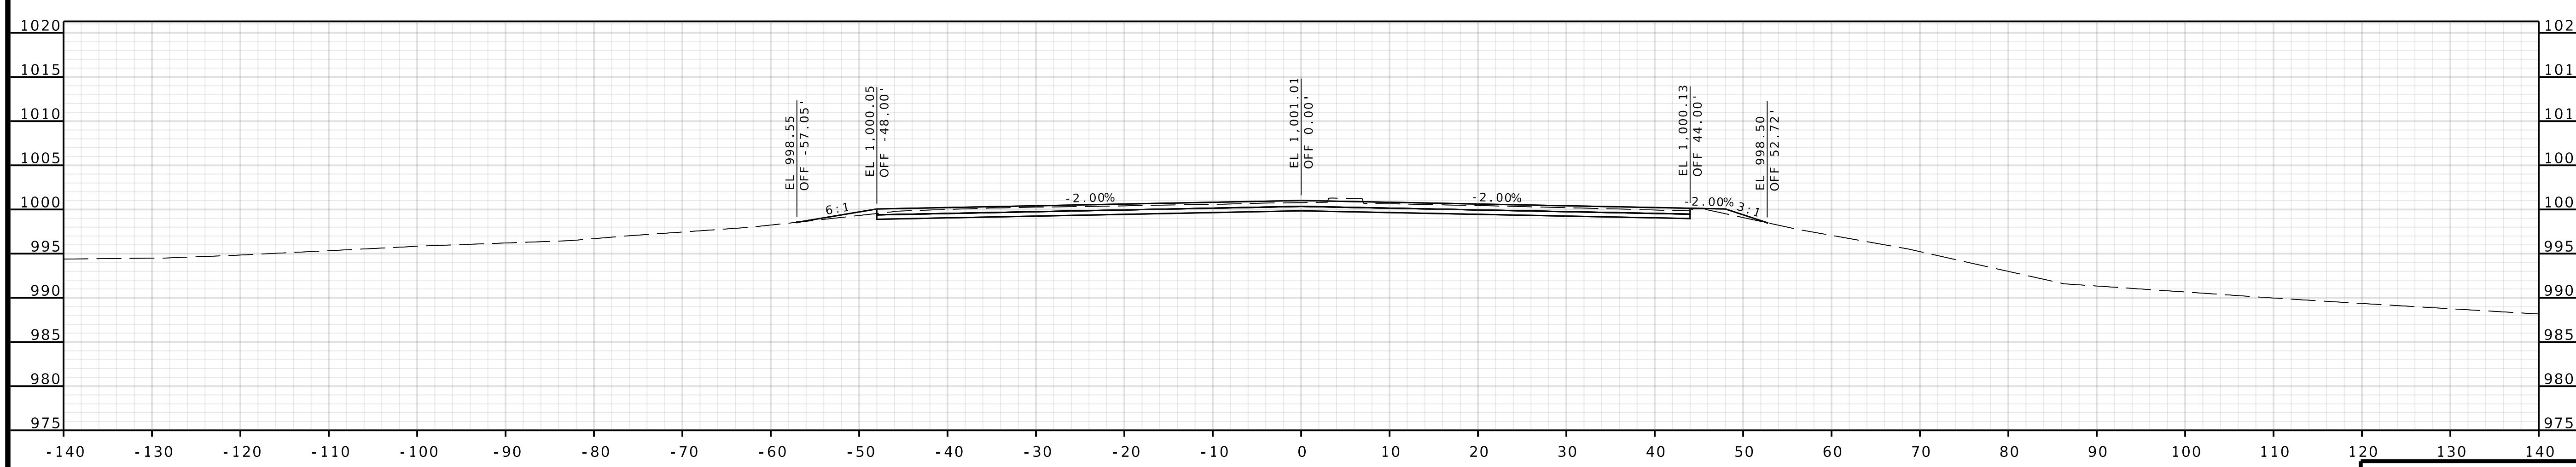


STA 631+75.00



COOKINGHAM DRIVE

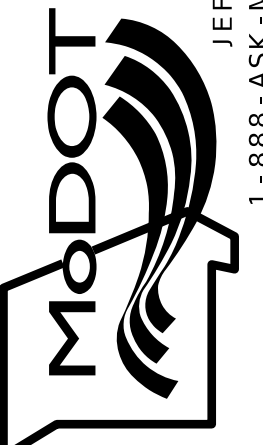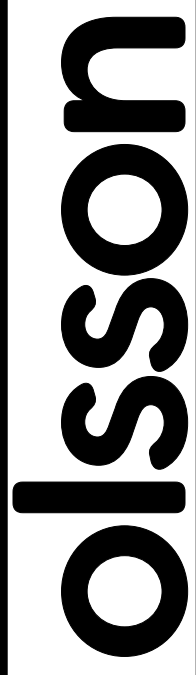DATE PREPARED 4/30/2025	
ROUTE 1435	STATE MO
DISTRICT KC	SHEET NO. 25
COUNTY PLATTE	
JOB NO. J4S3489	
CONTRACT ID.	
PROJECT NO.	
BRIDGE NO. A9700	
DESCRIPTION	
DATE	
MISSOURI HIGHWAYS AND TRANSPORTATION COMMISSION	
 105 WEST CAPITOL JEFFERSON CITY, MO 65102 1-888-ASK-MODOT (1-888-275-6636)	
 1301 BURLINGTON STREET, STE. 100 NORTH KANSAS CITY, MO 64116 PHONE: 816.361.1177 CERTIFICATE OF AUTHORITY NO. 001592	



IF A SEAL IS PRESENT ON THIS SHEET IT HAS BEEN ELECTRONICALLY SEALED AND DATED.


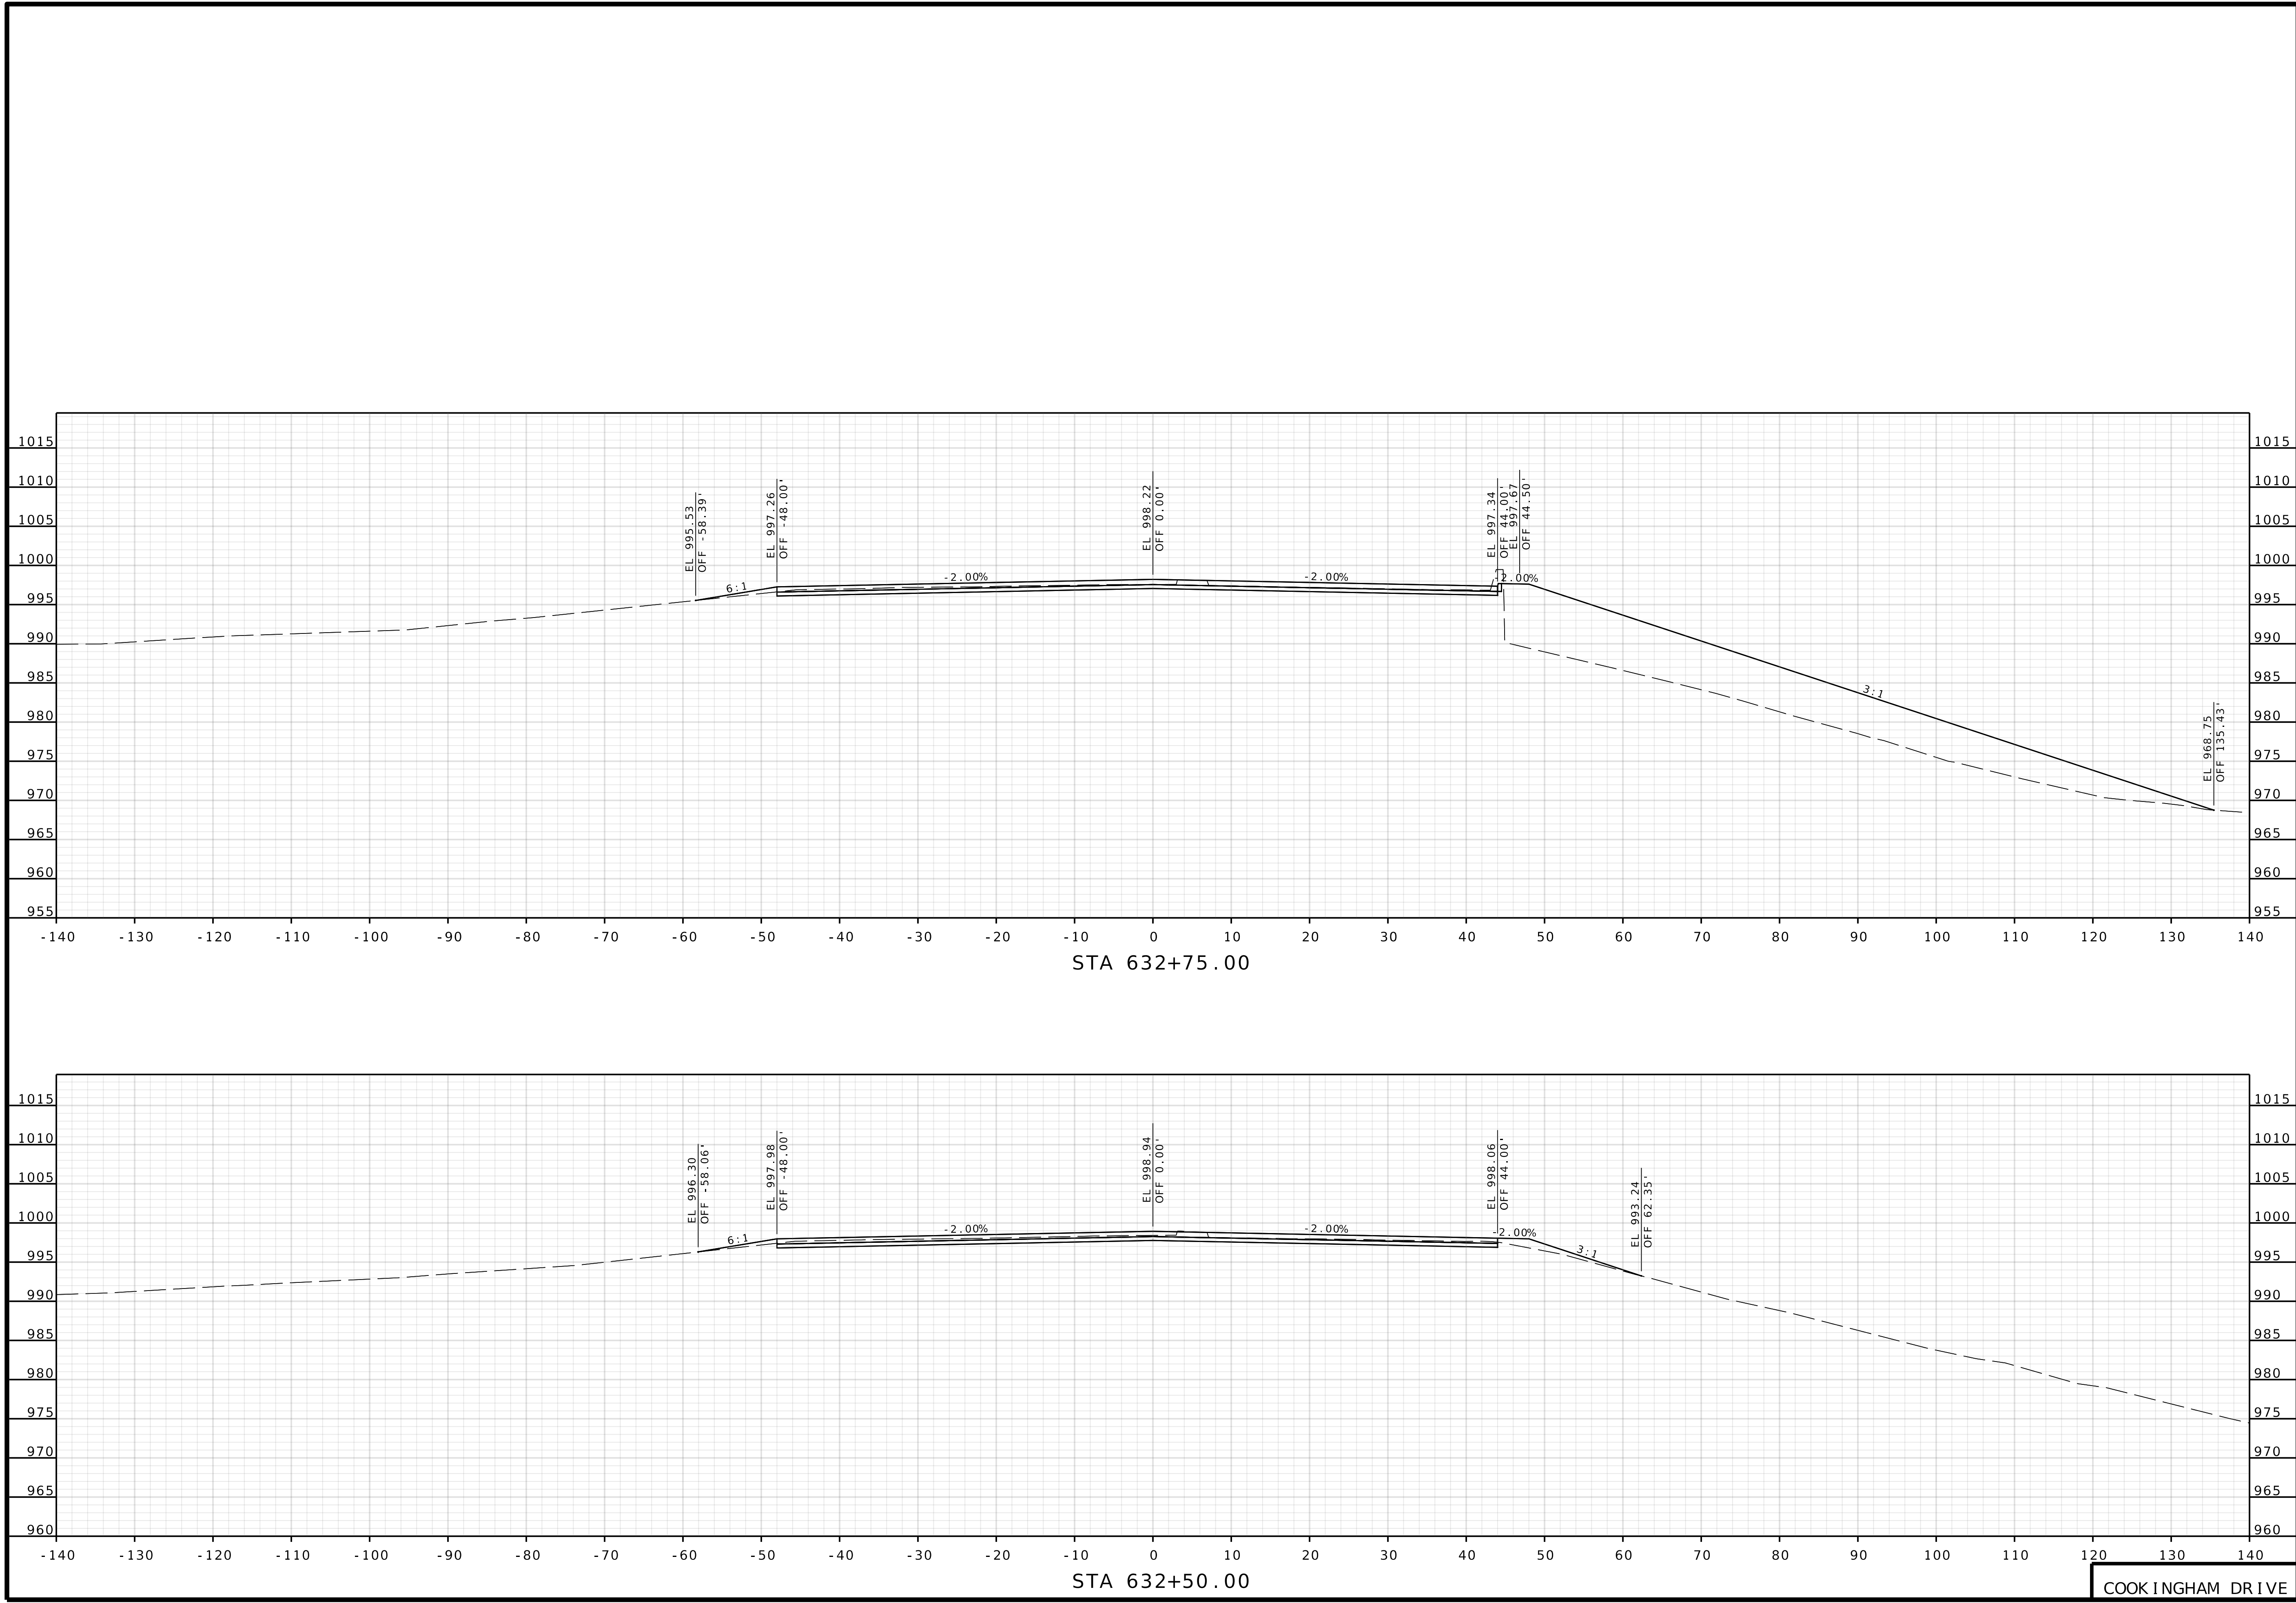


COOK INGHAM DRIVE

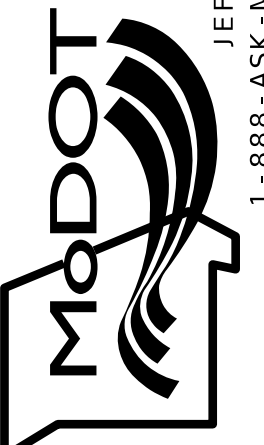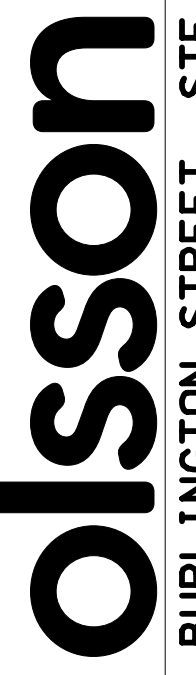
DATE PREPARED 4/30/2025	
ROUTE 1435	STATE MO
DISTRICT KC	SHEET NO. 26
COUNTY PLATTE	
JOB NO. J4S3489	
CONTRACT ID.	
PROJECT NO.	
BRIDGE NO. A9700	
DESCRIPTION	DATE
MISSOURI HIGHWAYS AND TRANSPORTATION COMMISSION	
	
105 WEST CAPITOL JEFFERSON CITY, MO 65102 1-888-ASK-MODOT (1-888-275-6636)	
	
1301 BURLINGTON STREET, STE. 100 NORTH KANSAS CITY, MO 64116 PHONE: 816.361.1177 CERTIFICATE OF AUTHORITY NO. 001592	

IF A SEAL IS PRESENT ON THIS SHEET IT HAS BEEN ELECTRONICALLY SEALED AND DATED.

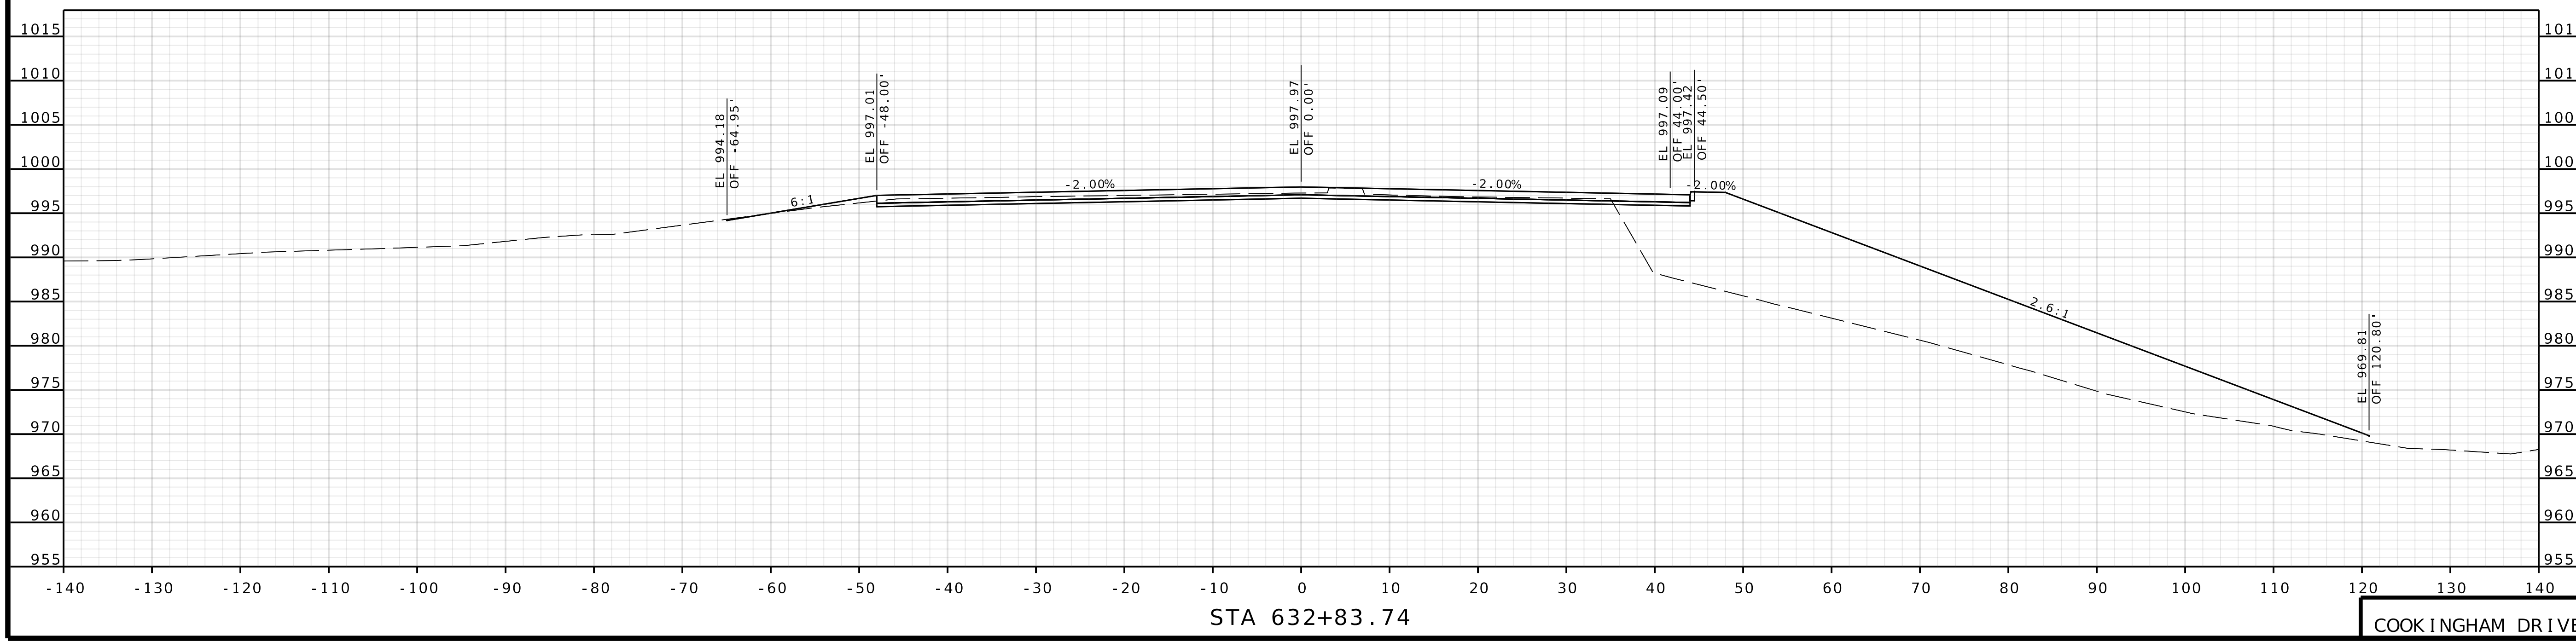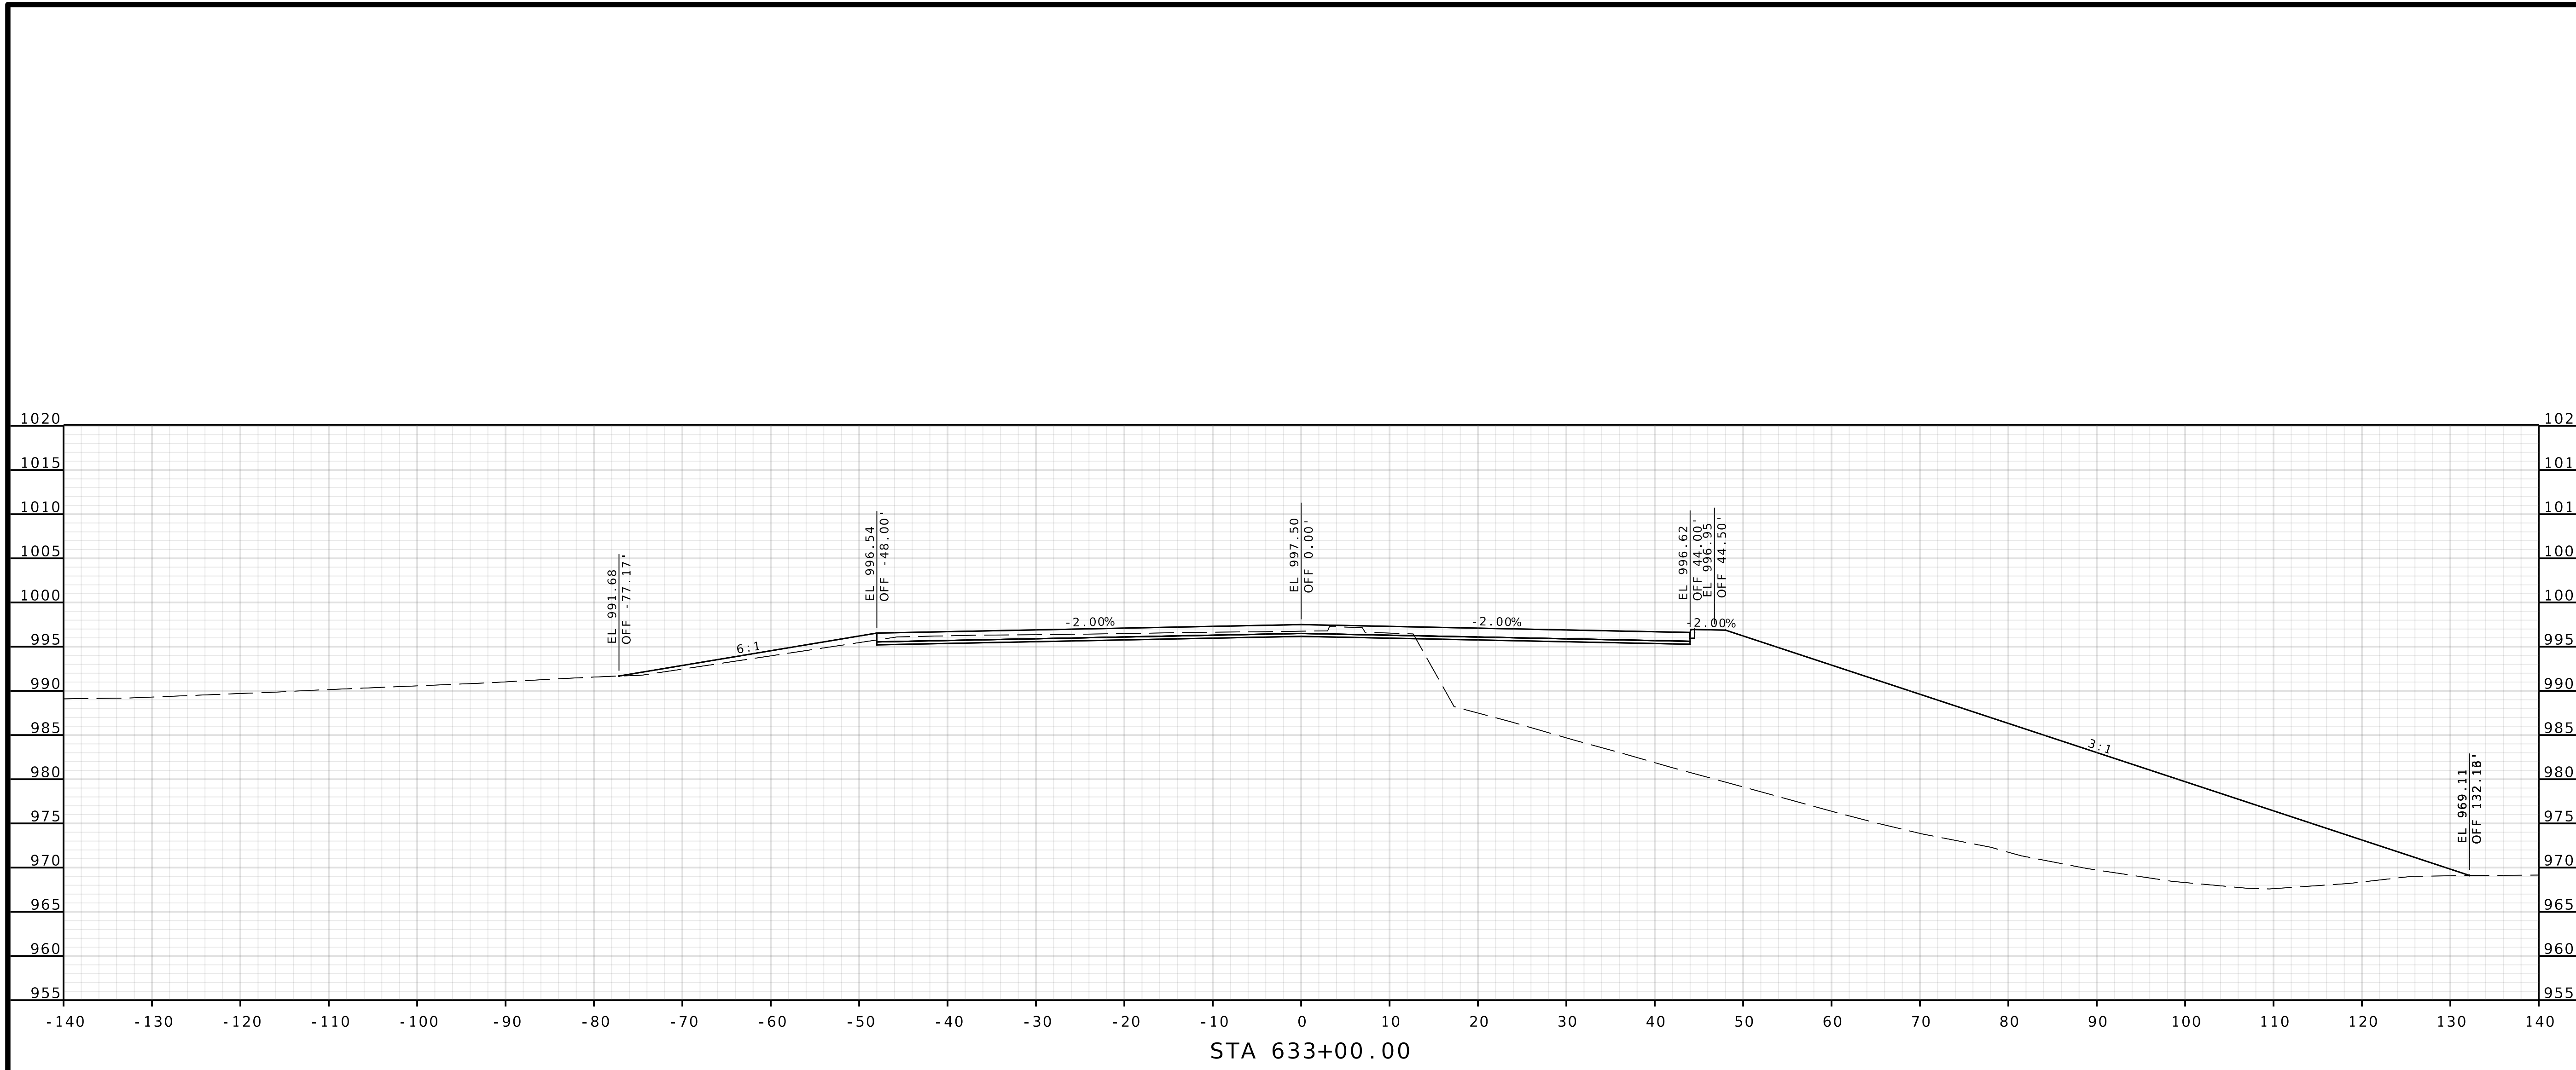


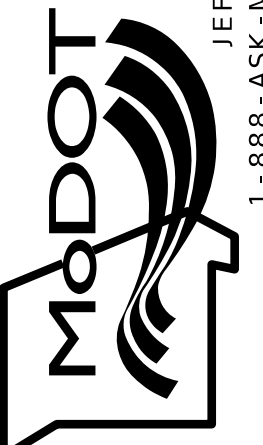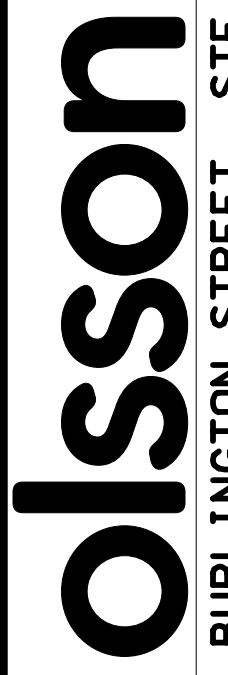DATE PREPARED 4/30/2025	
ROUTE 1435	STATE MO
DISTRICT KC	SHEET NO. 27
COUNTY PLATTE	
JOB NO. J4S3489	
CONTRACT ID.	
PROJECT NO.	
BRIDGE NO. A9700	
DESCRIPTION	DATE
MISSOURI HIGHWAYS AND TRANSPORTATION COMMISSION	
 105 WEST CAPITOL JEFFERSON CITY, MO 65102 1-888-ASK-MODOT (1-888-275-6636)	
 1301 BURLINGTON STREET, STE. 100 NORTH KANSAS CITY, MO 64116 PHONE: 816.361.1177 CERTIFICATE OF AUTHORITY NO. 001592	

IF A SEAL IS PRESENT ON THIS SHEET IT HAS BEEN ELECTRONICALLY SEALED AND DATED.


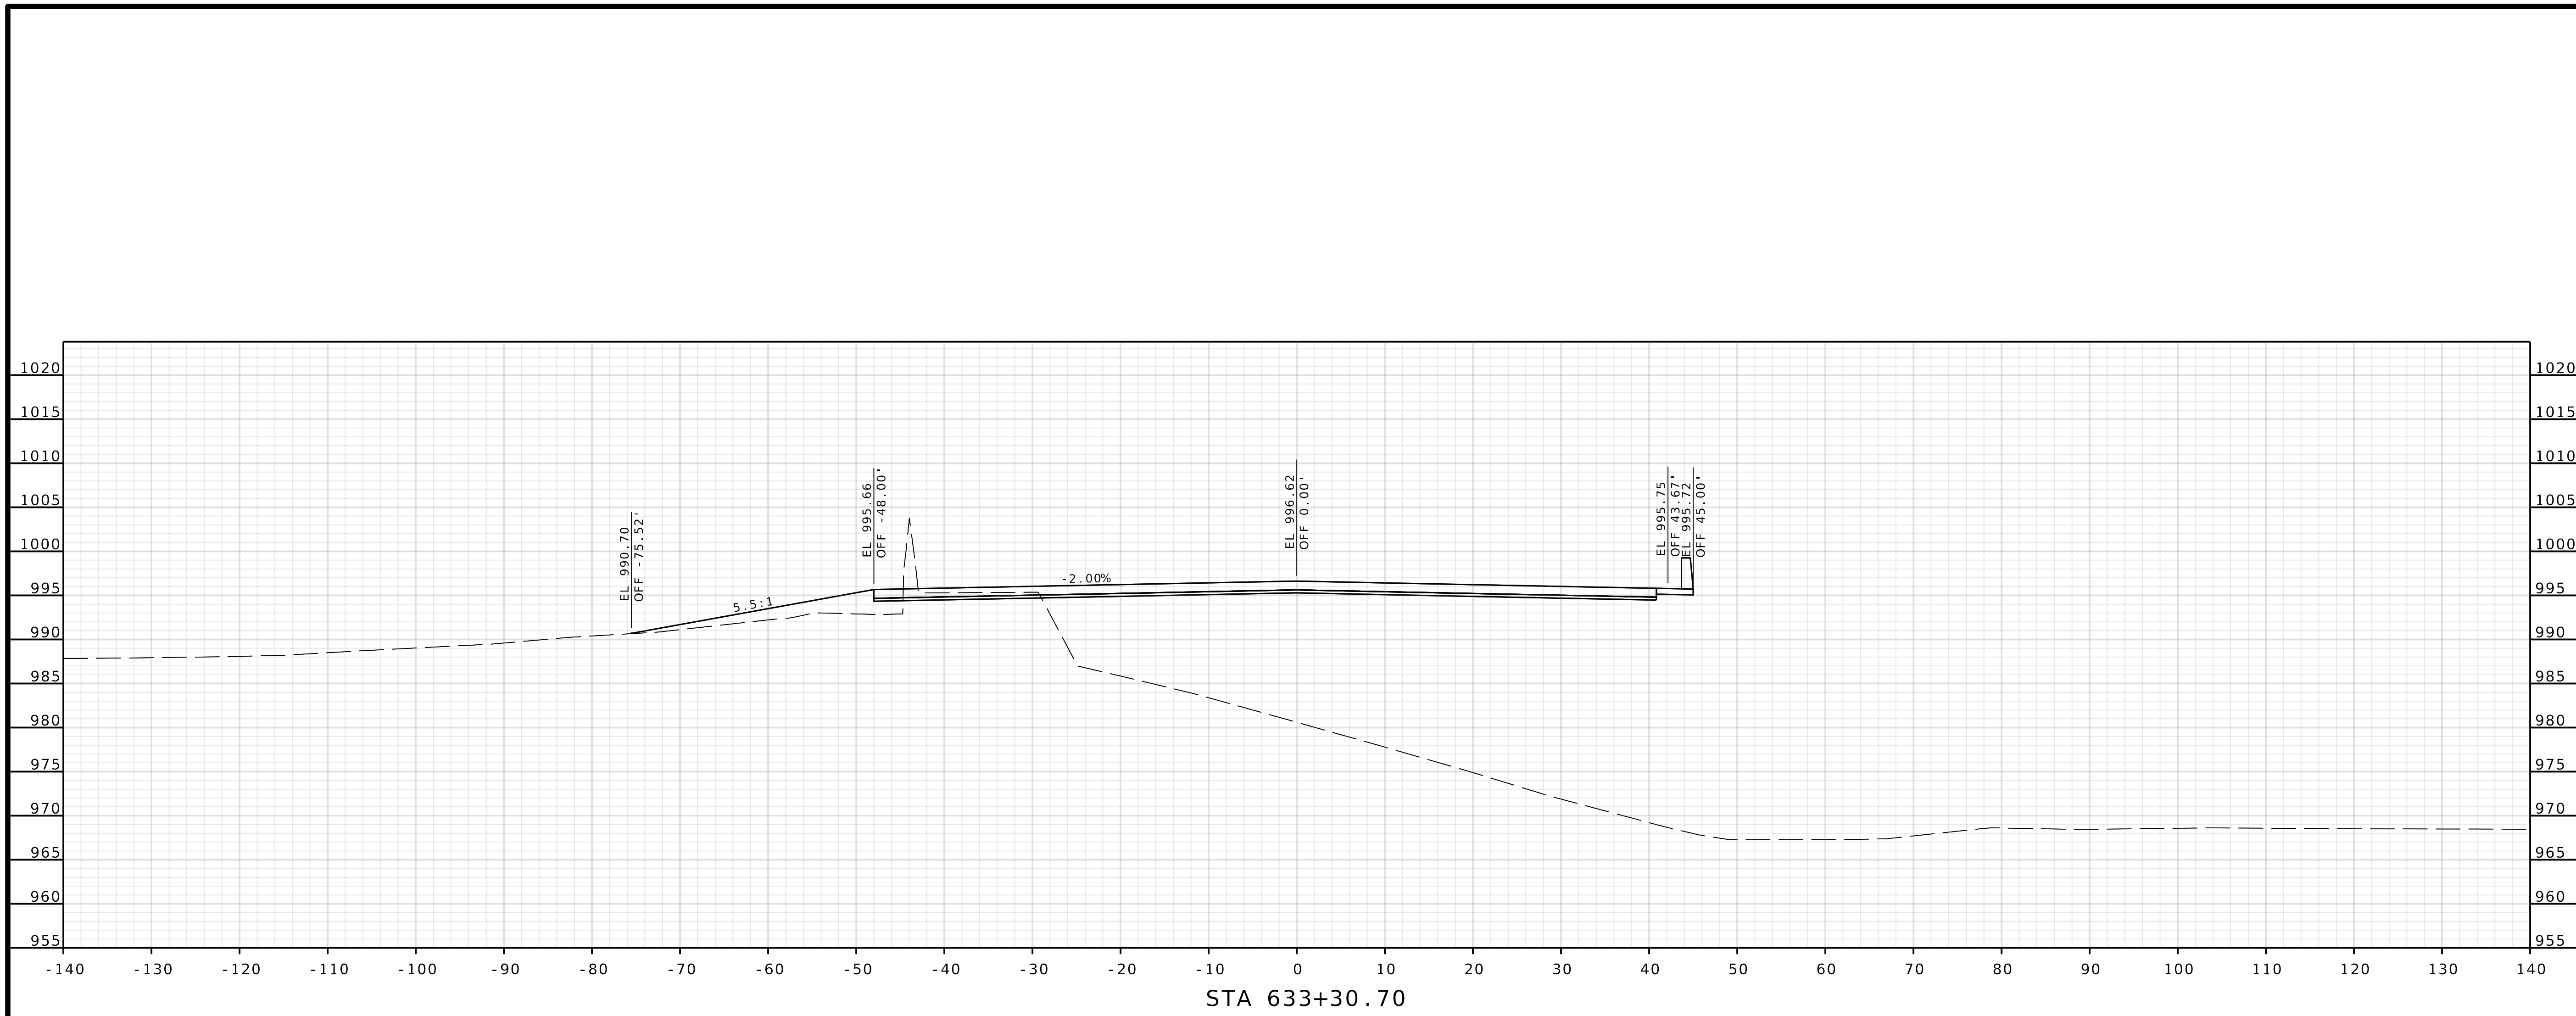


STA 633+30.70


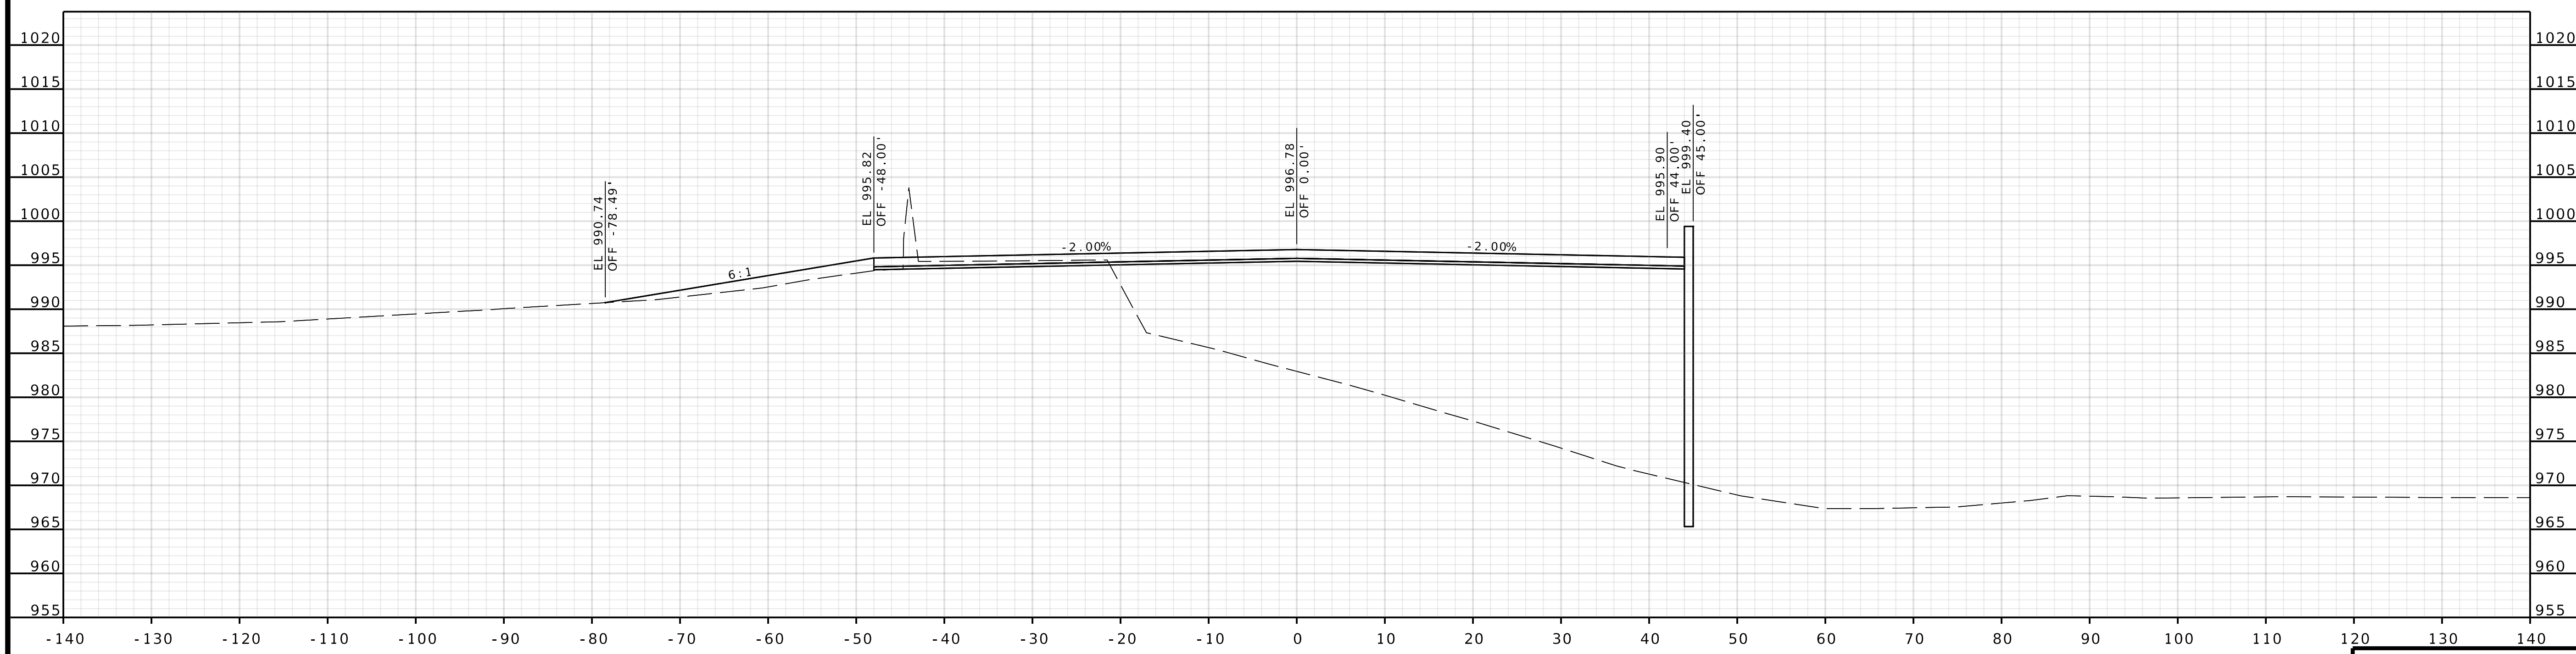




STA 633+25.00

COOK INGHAM DRIVE

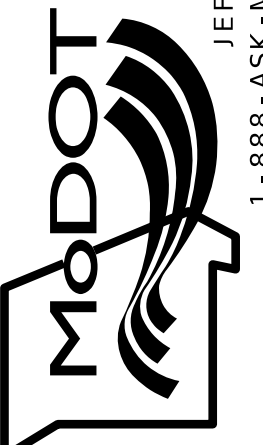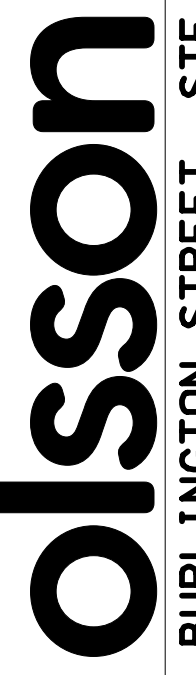DATE PREPARED 4/30/2025	
ROUTE 1435	STATE MO
DISTRICT KC	SHEET NO. 28
COUNTY PLATTE	
JOB NO. J4S3489	
CONTRACT ID.	
PROJECT NO.	
BRIDGE NO. A9700	
DESCRIPTION	DATE
MISSOURI HIGHWAYS AND TRANSPORTATION COMMISSION	
 105 WEST CAPITOL JEFFERSON CITY, MO 65102 1-888-ASK-MODOT (1-888-275-6636)	
 1301 BURLINGTON STREET, STE. 100 NORTH KANSAS CITY, MO 64116 PHONE: 816.361.1177 CERTIFICATE OF AUTHORITY NO. 001592	



IF A SEAL IS PRESENT ON THIS SHEET IT HAS BEEN ELECTRONICALLY SEALED AND DATED.

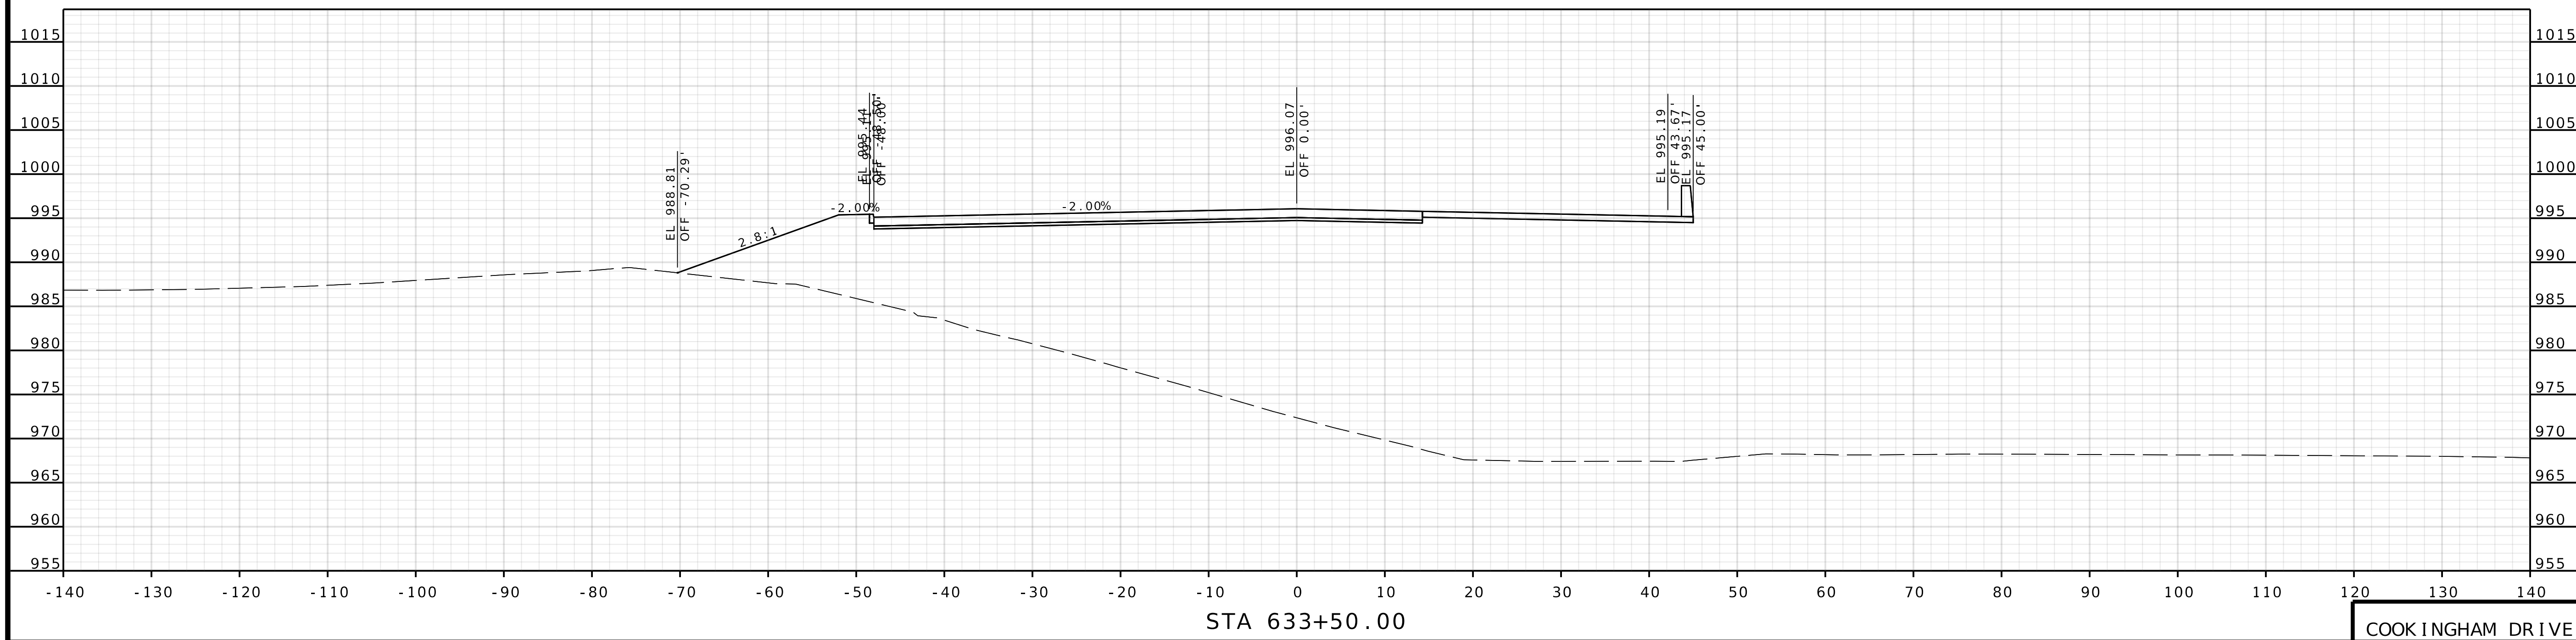
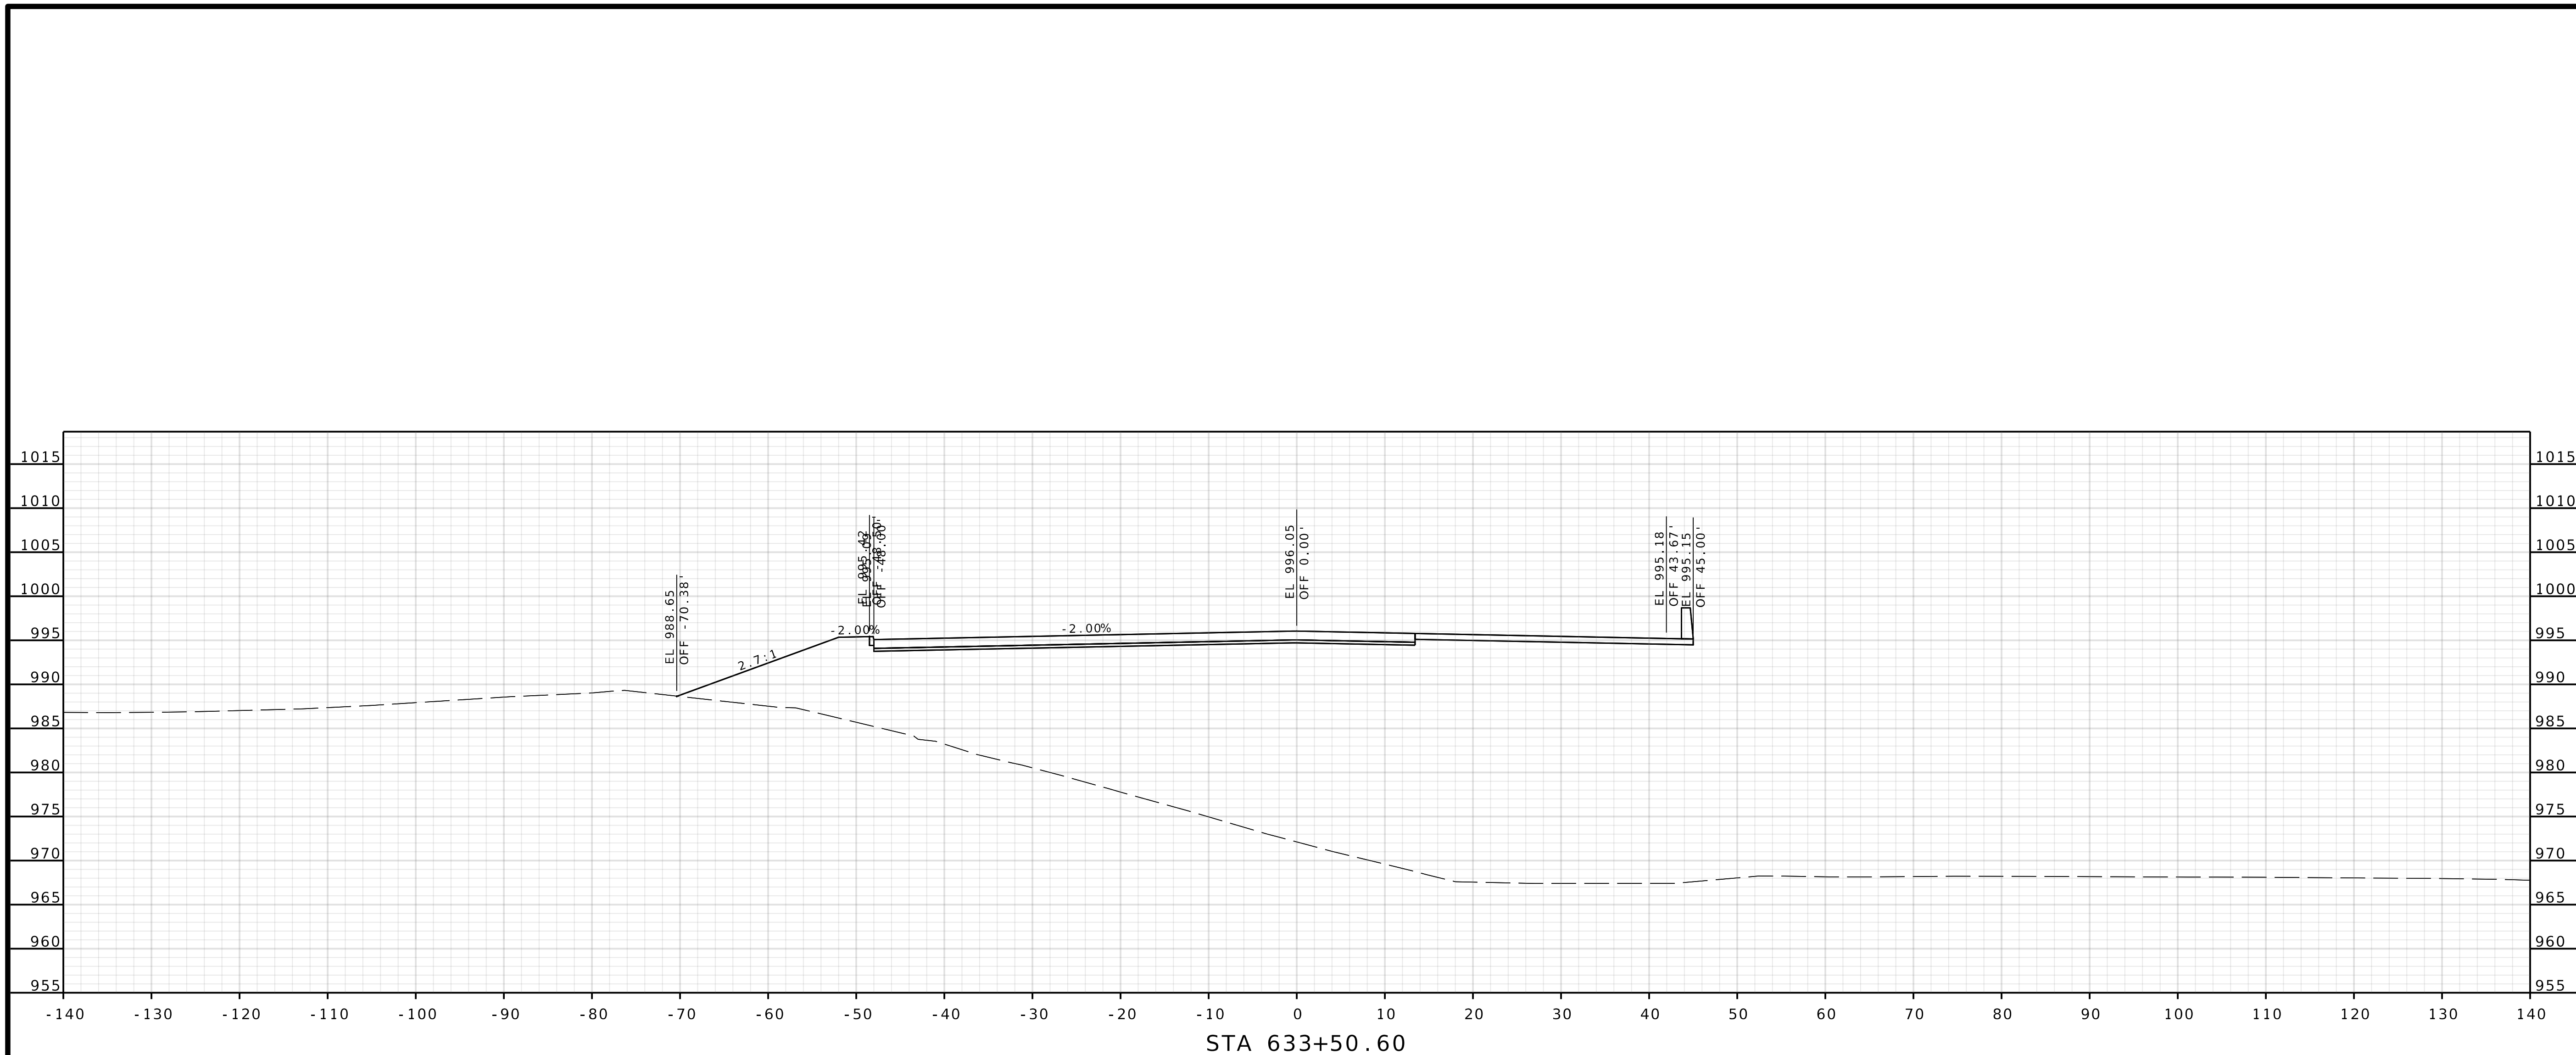


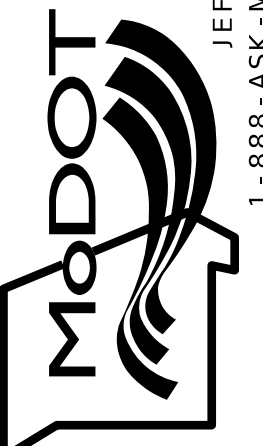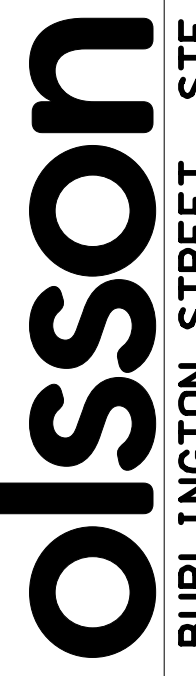DATE PREPARED 4/30/2025	
ROUTE 1435	STATE MO
DISTRICT KC	SHEET NO. 29
COUNTY PLATTE	
JOB NO. J4S3489	
CONTRACT ID.	
PROJECT NO.	
BRIDGE NO. A9700	
DESCRIPTION	DATE
MISSOURI HIGHWAYS AND TRANSPORTATION COMMISSION	
 105 WEST CAPITOL JEFFERSON CITY, MO 65102 1-888-ASK-MODOT (1-888-275-6636)	
 1301 BURLINGTON STREET, STE. 100 NORTH KANSAS CITY, MO 64116 PHONE: 816.361.1177 CERTIFICATE OF AUTHORITY NO. 001592	


COOK INGHAM DRIVE

IF A SEAL IS PRESENT ON THIS SHEET IT HAS BEEN ELECTRONICALLY SEALED AND DATED.

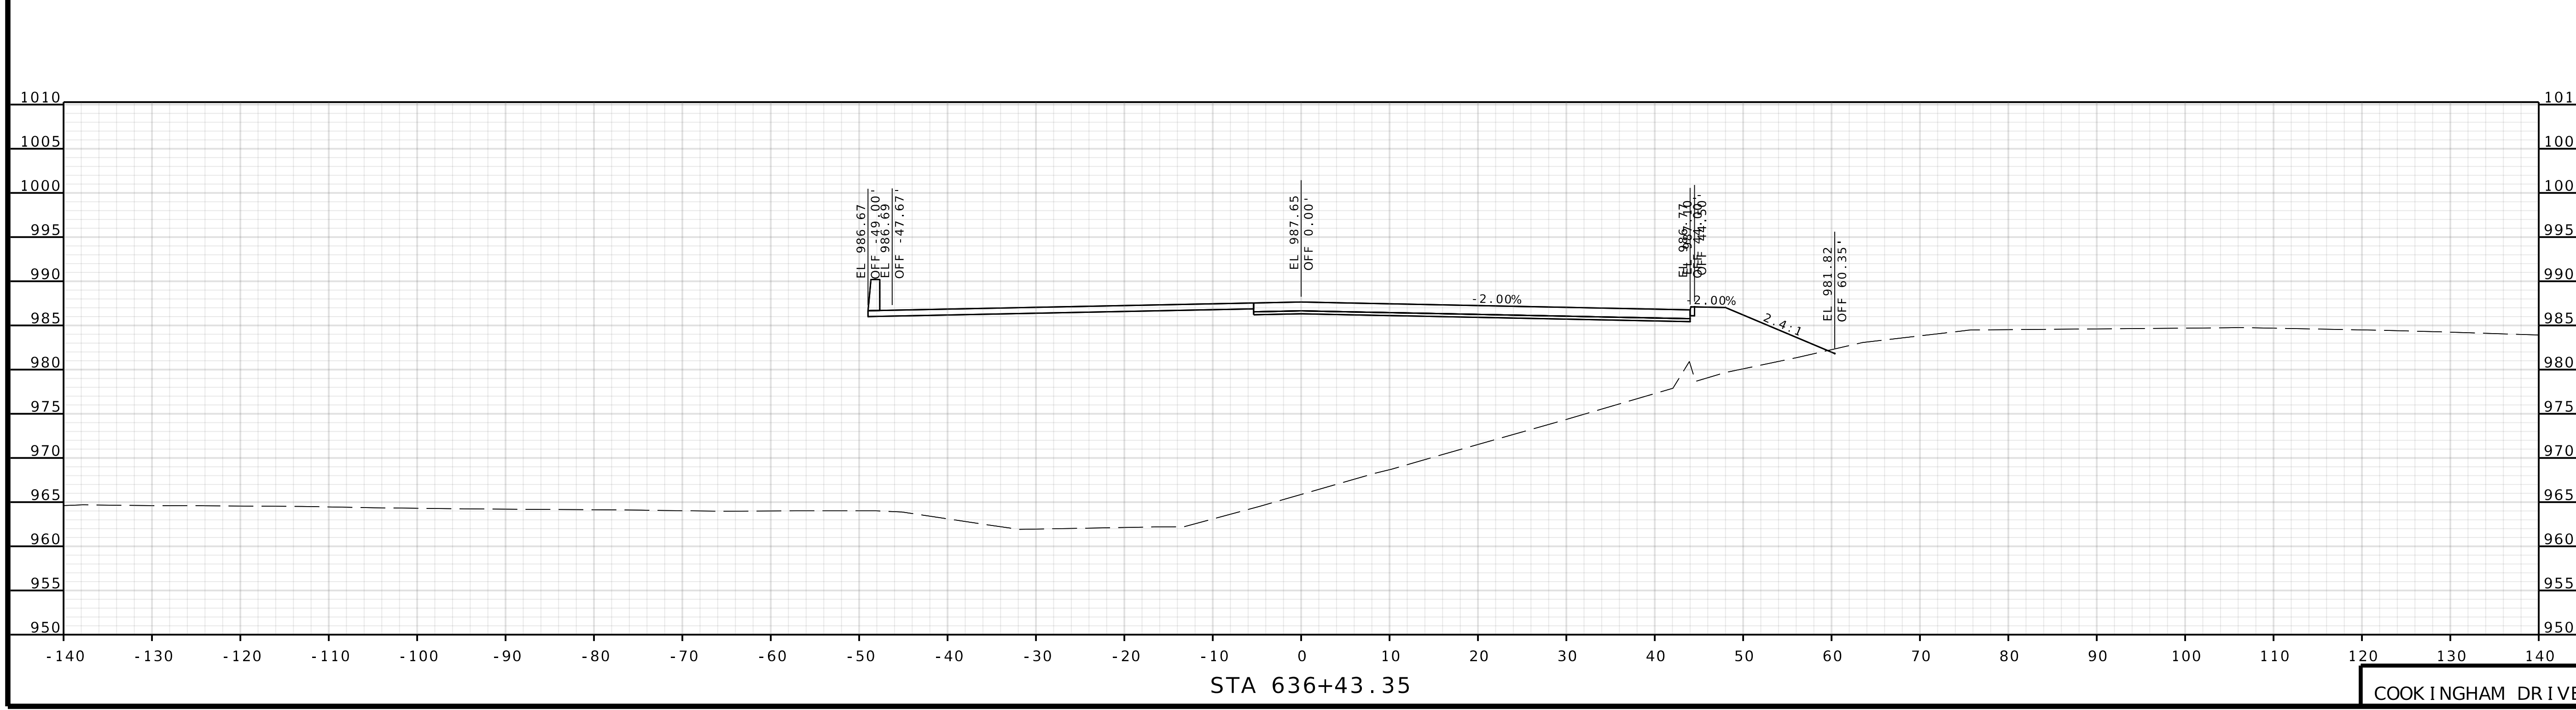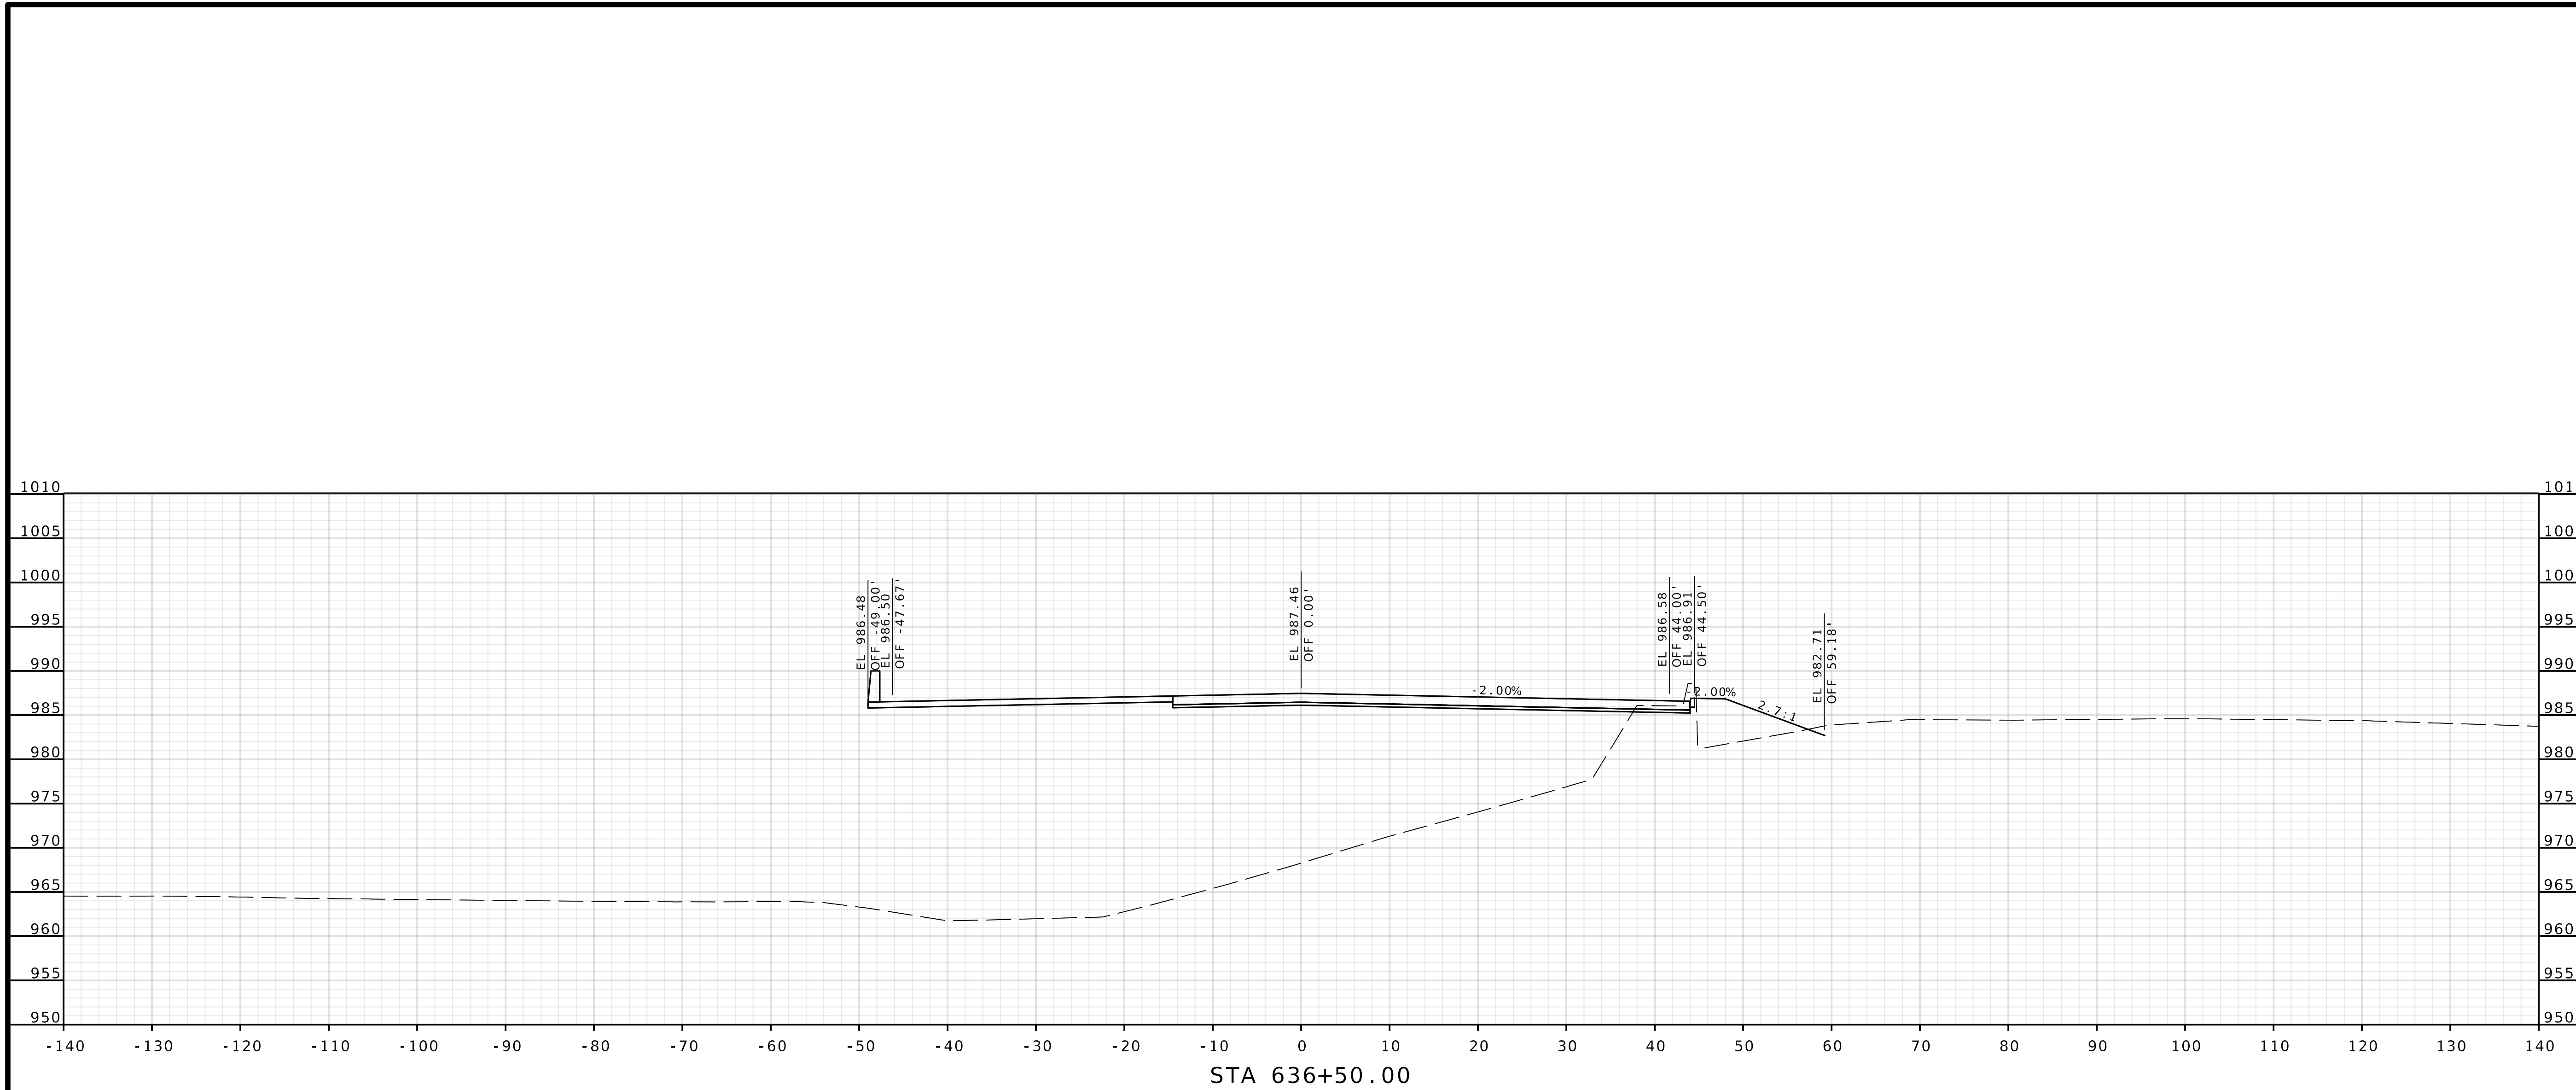


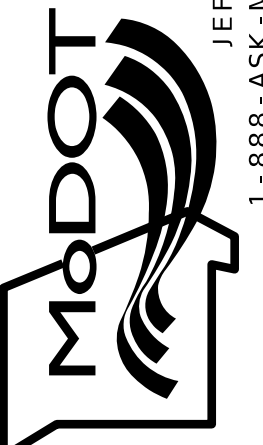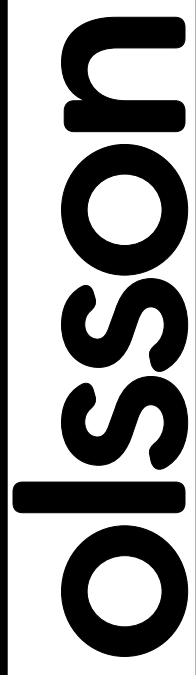DATE PREPARED 4/30/2025	
ROUTE 1435	STATE MO
DISTRICT KC	SHEET NO. 30
COUNTY PLATTE	
JOB NO. J4S3489	
CONTRACT ID.	
PROJECT NO.	
BRIDGE NO. A9700	
DESCRIPTION	DATE
MISSOURI HIGHWAYS AND TRANSPORTATION COMMISSION	
	
105 WEST CAPITOL JEFFERSON CITY, MO 65102 1-888-ASK-MODOT (1-888-275-6636)	
	
1301 BURLINGTON STREET, STE. 100 NORTH KANSAS CITY, MO 64116 PHONE: 816.361.1177 CERTIFICATE OF AUTHORITY NO. 001592	

IF A SEAL IS PRESENT ON THIS SHEET IT HAS BEEN ELECTRONICALLY SEALED AND DATED.


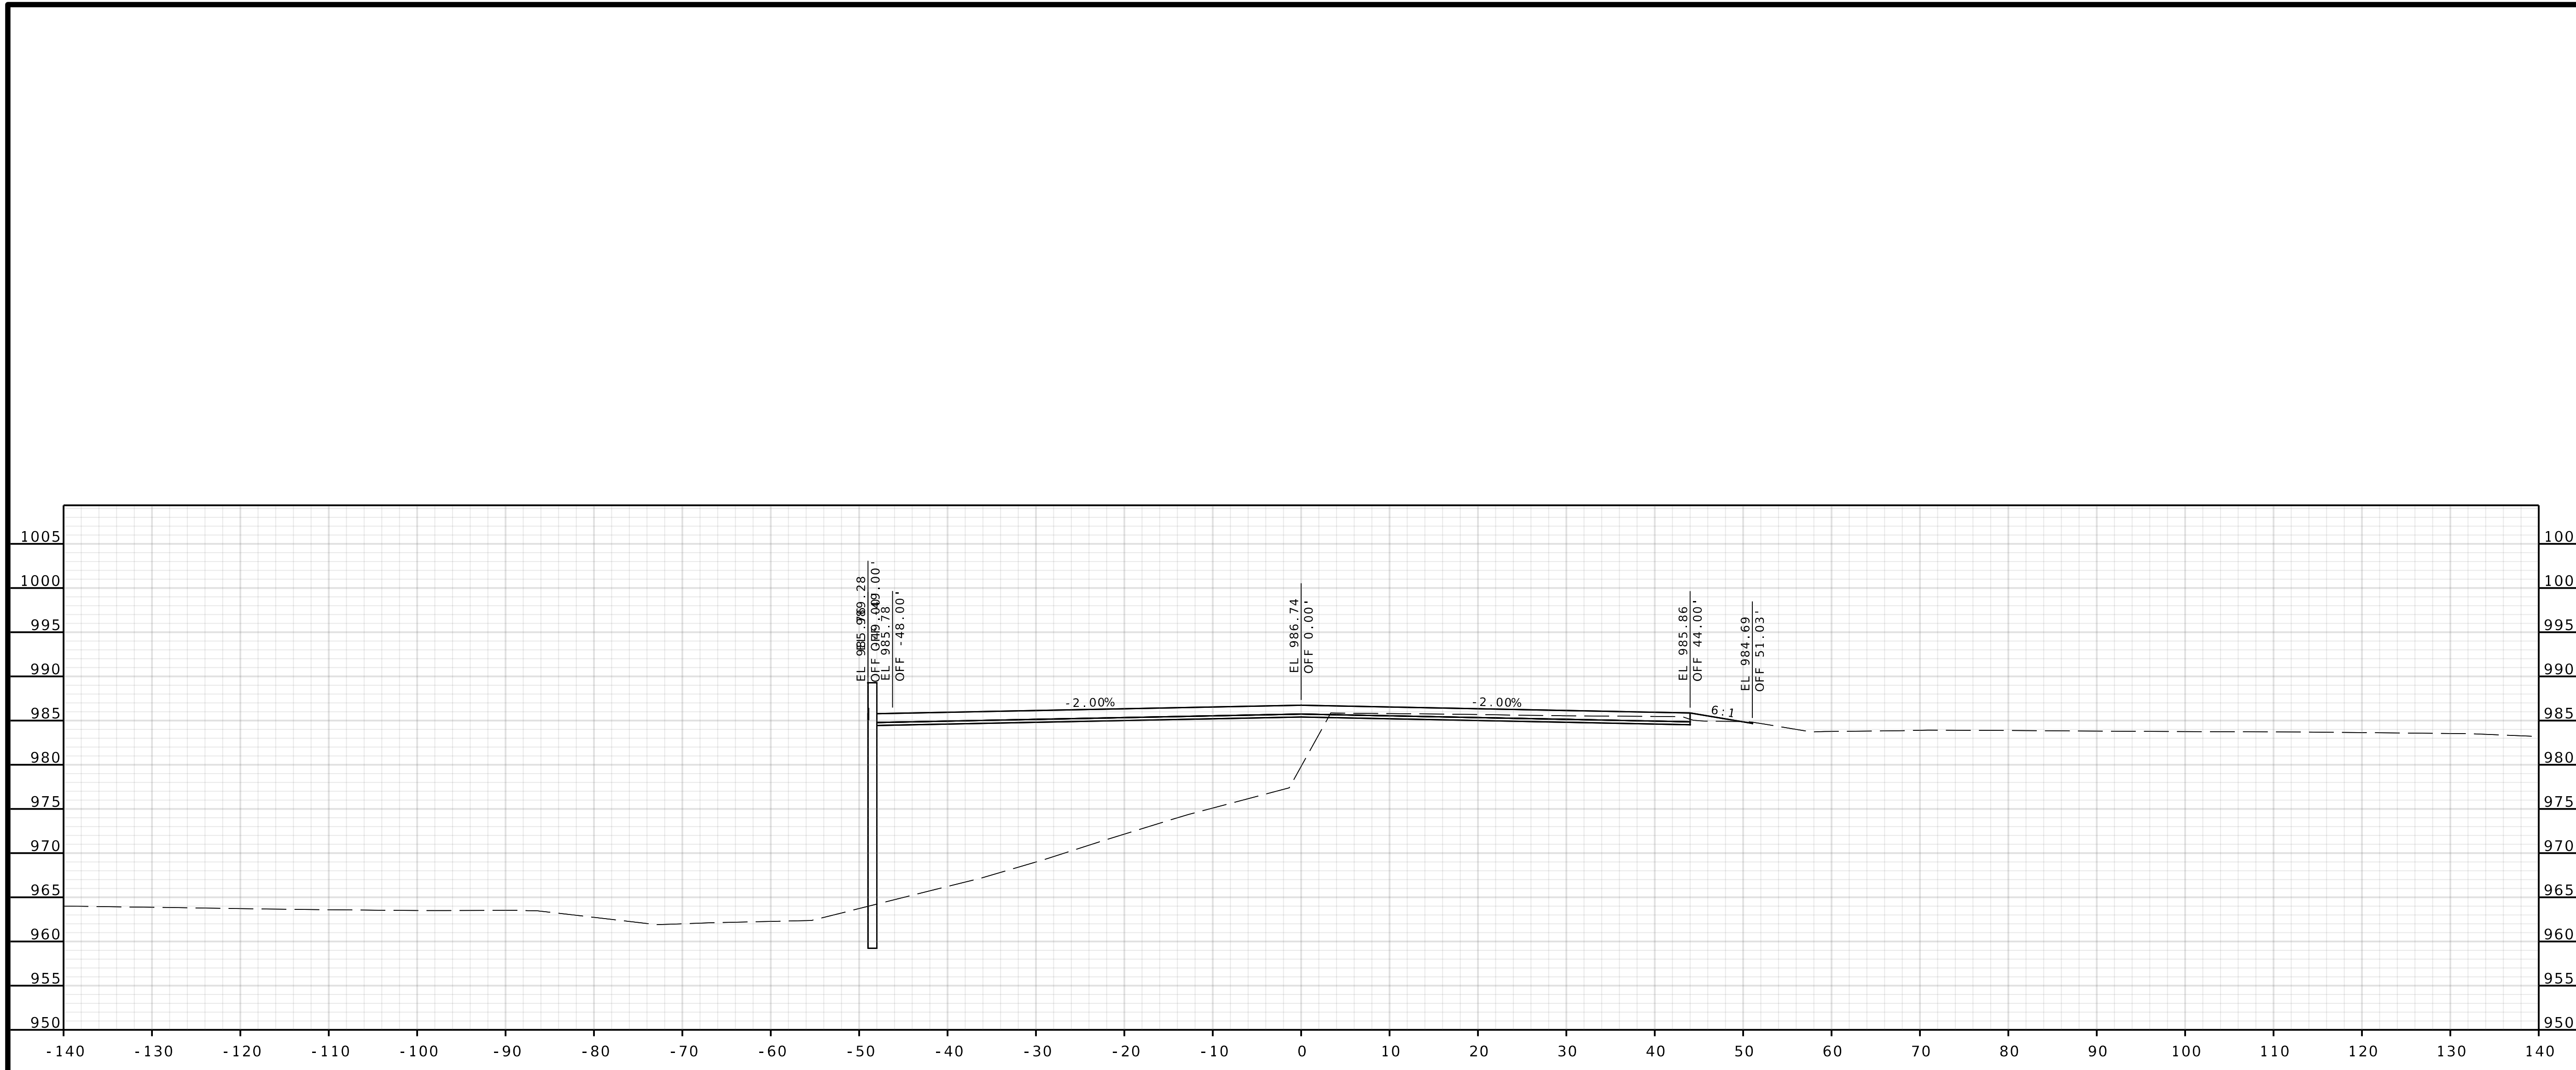


STA 636+75.00

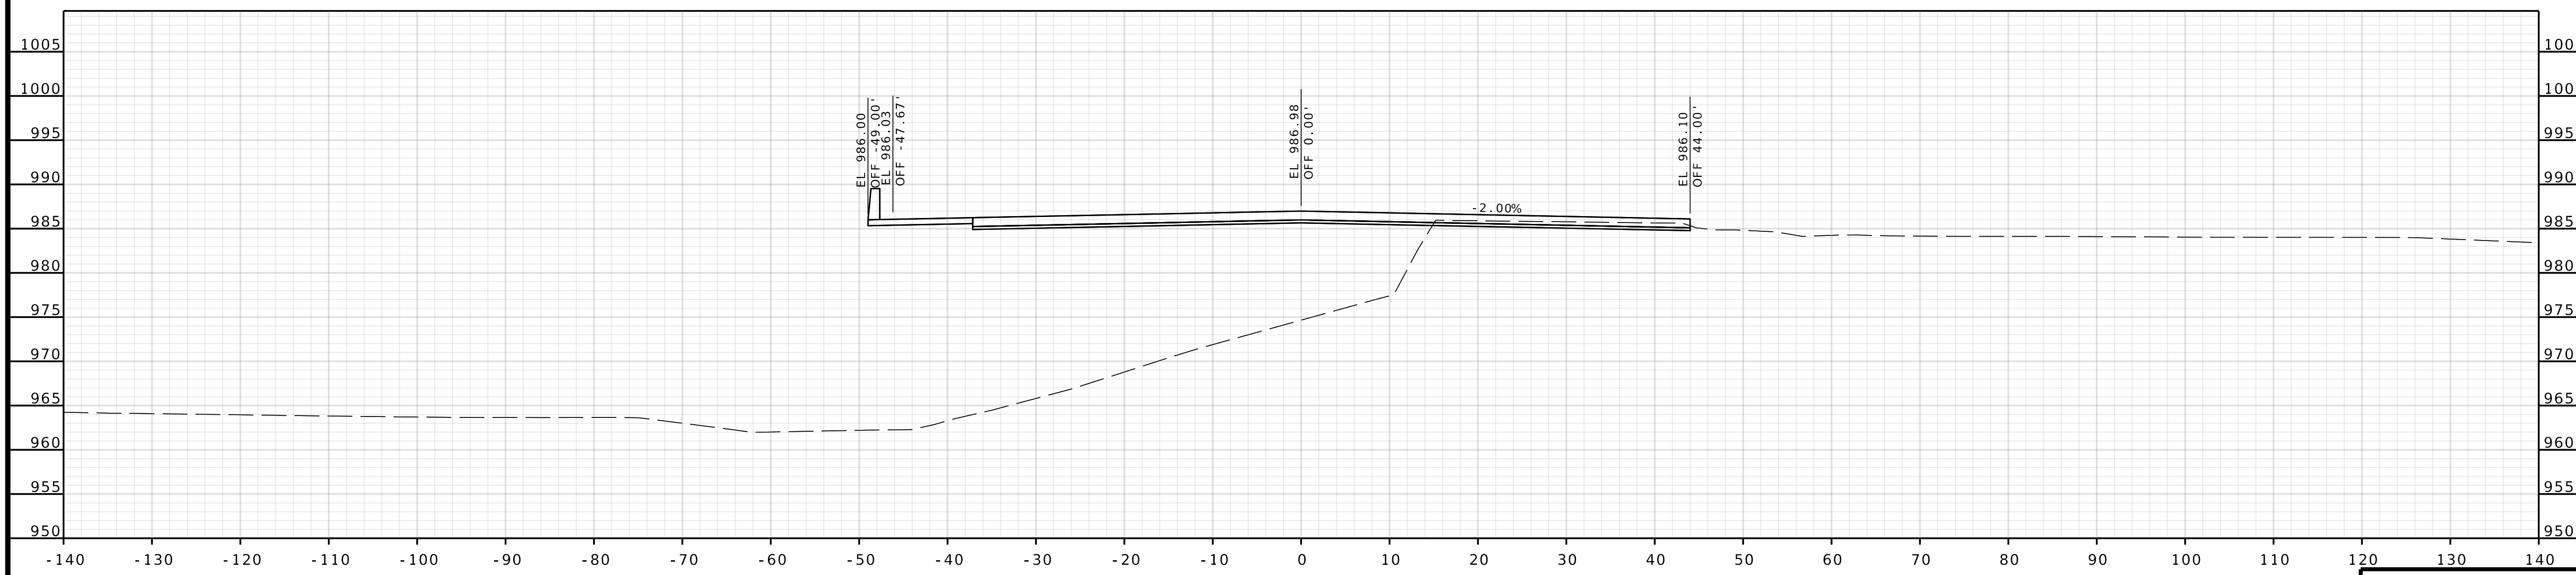


STA 636+66.45


COOK INGHAM DRIVE

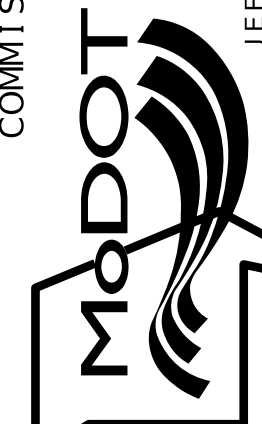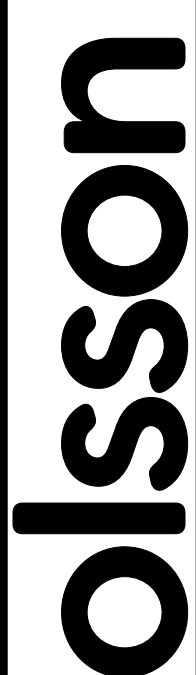DATE PREPARED 4/30/2025	
ROUTE 1435	STATE MO
DISTRICT KC	SHEET NO. 31
COUNTY PLATTE	
JOB NO. J4S3489	
CONTRACT ID.	
PROJECT NO.	
BRIDGE NO. A9700	
DESCRIPTION	DATE
MISSOURI HIGHWAYS AND TRANSPORTATION COMMISSION	
 105 WEST CAPITOL JEFFERSON CITY, MO 65102 1-888-ASK-MODOT (1-888-275-6636)	
 1301 BURLINGTON STREET, STE. 100 NORTH KANSAS CITY, MO 64116 PHONE: 816.361.1177 CERTIFICATE OF AUTHORITY NO. 001592	

IF A SEAL IS PRESENT ON THIS SHEET IT HAS BEEN ELECTRONICALLY SEALED AND DATED.

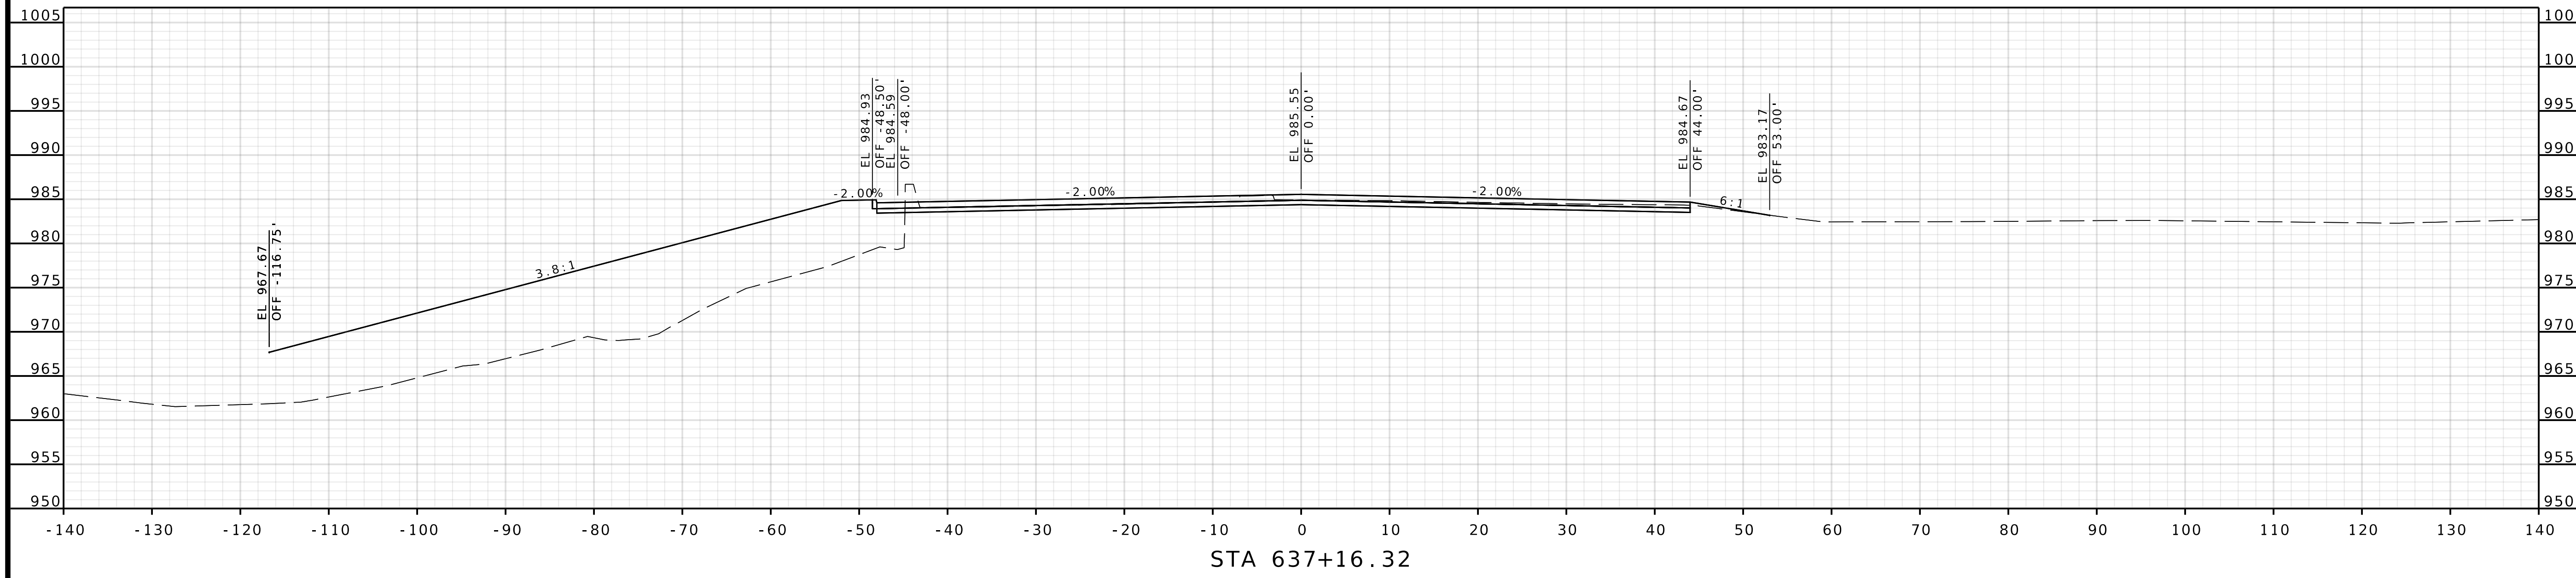

STA 637+16.32

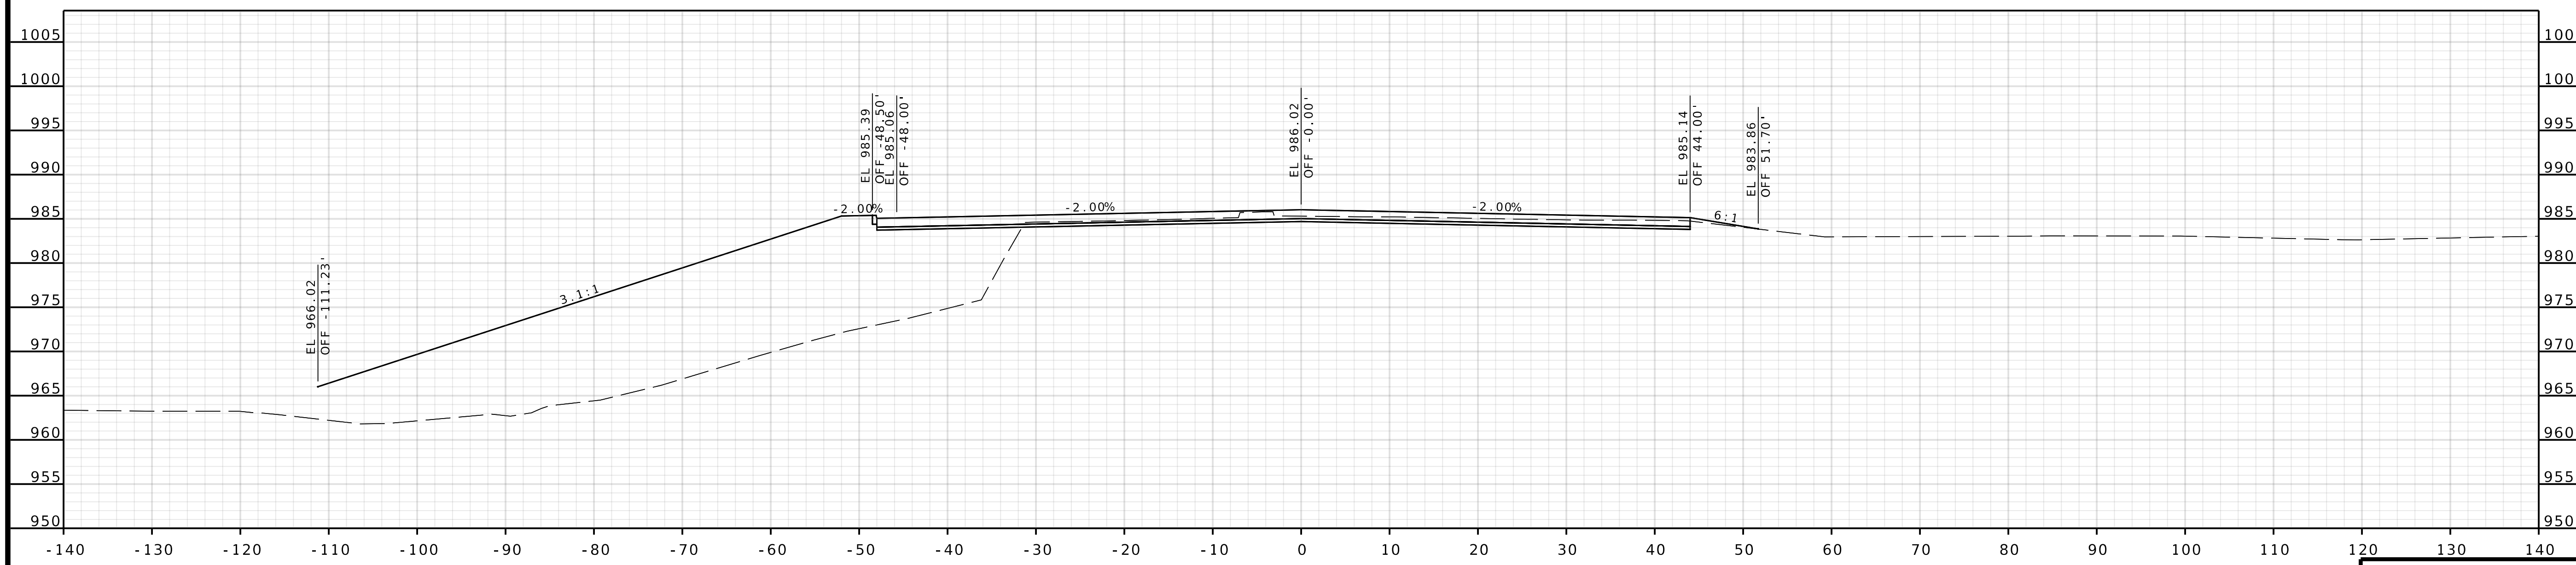


STA 637+00.00

COOKINGHAM DRIVE

DATE PREPARED 4/30/2025	
ROUTE 1435	STATE MO
DISTRICT KC	SHEET NO. 32
COUNTY PLATTE	
JOB NO. J4S3489	
CONTRACT ID.	
PROJECT NO.	
BRIDGE NO. A9700	

DESCRIPTION	DATE

MISSOURI HIGHWAYS AND TRANSPORTATION COMMISSION

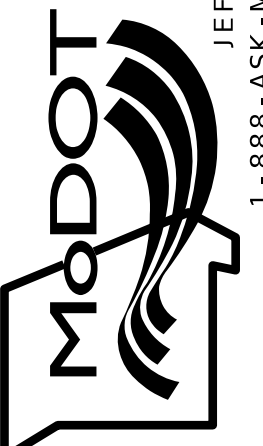




105 WEST CAPITOL
JEFFERSON CITY, MO 65102
1-888-ASK-MODOT (1-888-275-6636)

Olsson

1301 BURLINGTON STREET, STE. 100
NORTH KANSAS CITY, MO 64116
PHONE: 816.361.1177
CERTIFICATE OF AUTHORITY NO. 001592


IF A SEAL IS PRESENT ON THIS SHEET IT HAS BEEN ELECTRONICALLY SEALED AND DATED.

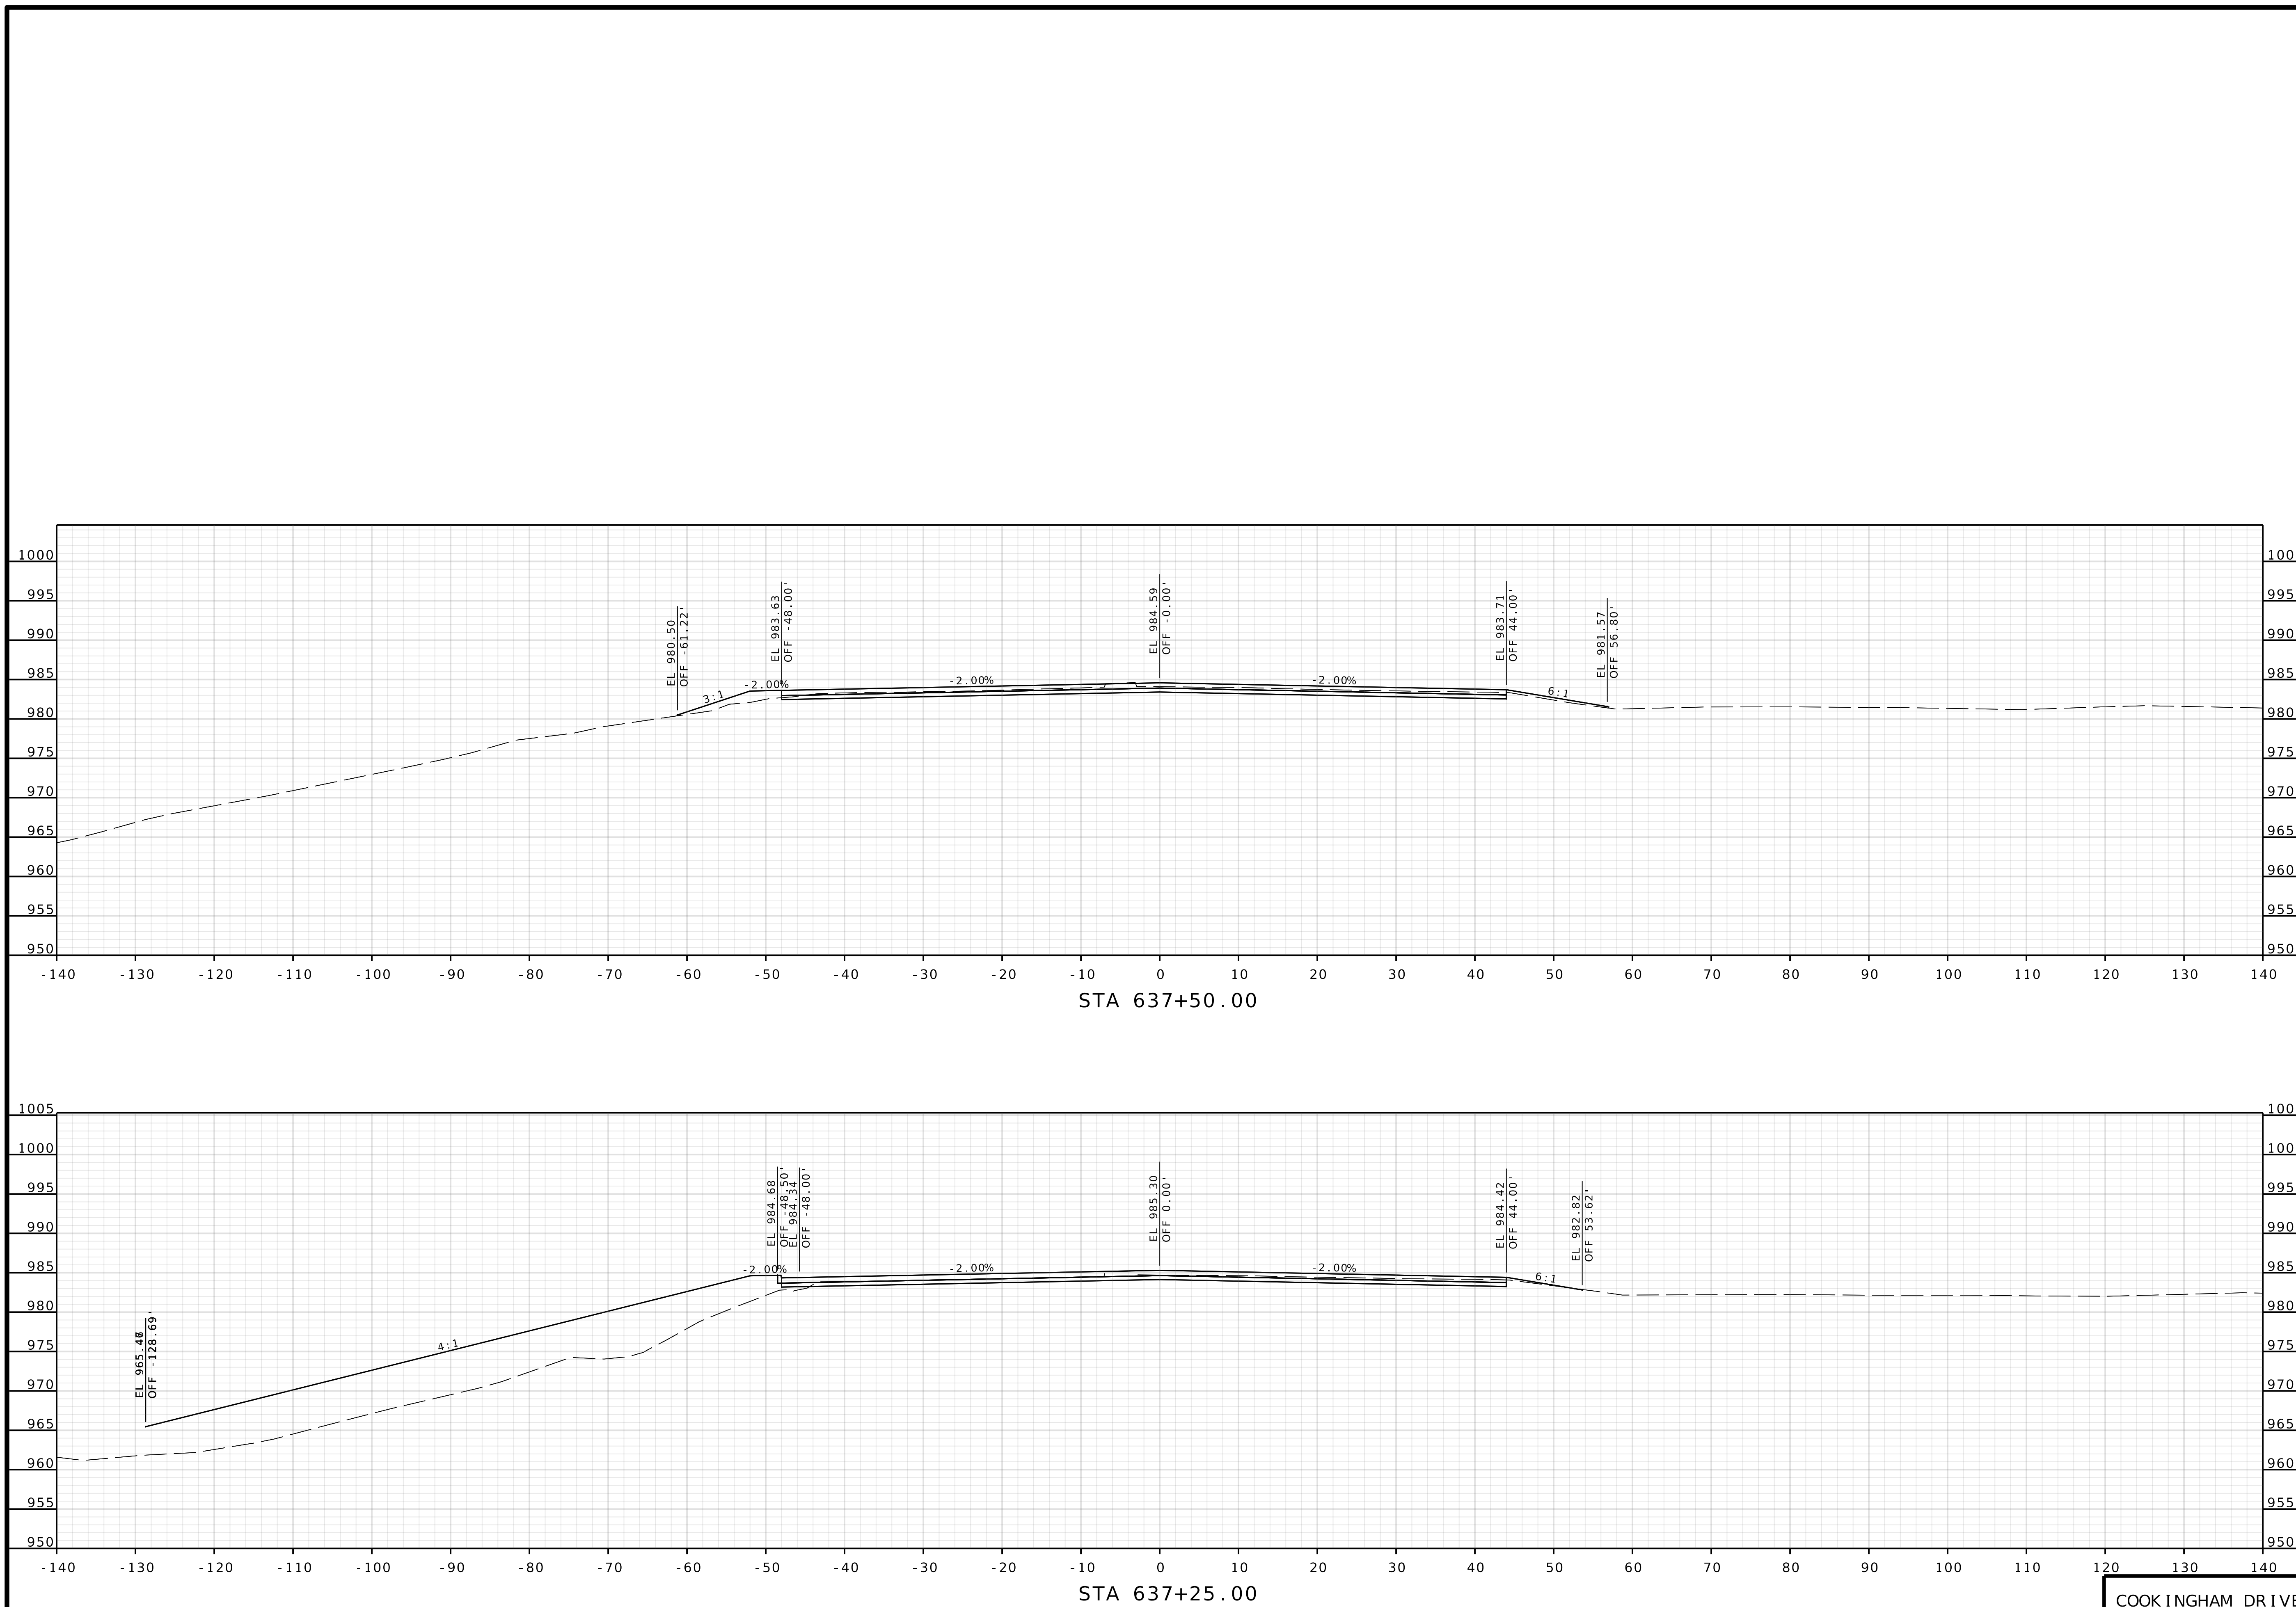

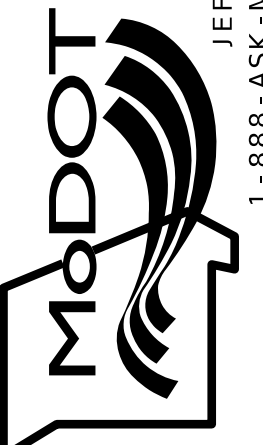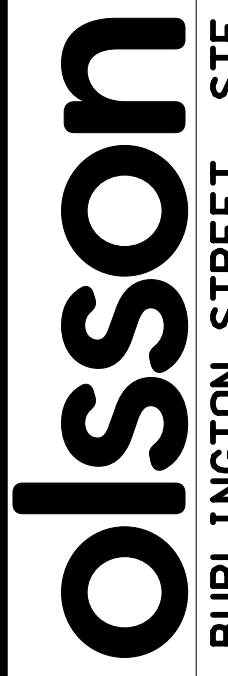
DATE PREPARED 4/30/2025	
ROUTE 1435	STATE MO
DISTRICT KC	SHEET NO. 33
COUNTY PLATTE	
JOB NO. J4S3489	
CONTRACT ID.	
PROJECT NO.	
BRIDGE NO. A9700	
DESCRIPTION	DATE
MISSOURI HIGHWAYS AND TRANSPORTATION COMMISSION	
 105 WEST CAPITOL JEFFERSON CITY, MO 65102 1-888-ASK-MODOT (1-888-275-6636)	
 olsson 1301 BURLINGTON STREET, STE. 100 NORTH KANSAS CITY, MO 64116 PHONE: 816.361.1177 CERTIFICATE OF AUTHORITY NO. 001592	

COOKINGHAM DRIVE


IF A SEAL IS PRESENT ON THIS SHEET IT HAS BEEN ELECTRONICALLY SEALED AND DATED.

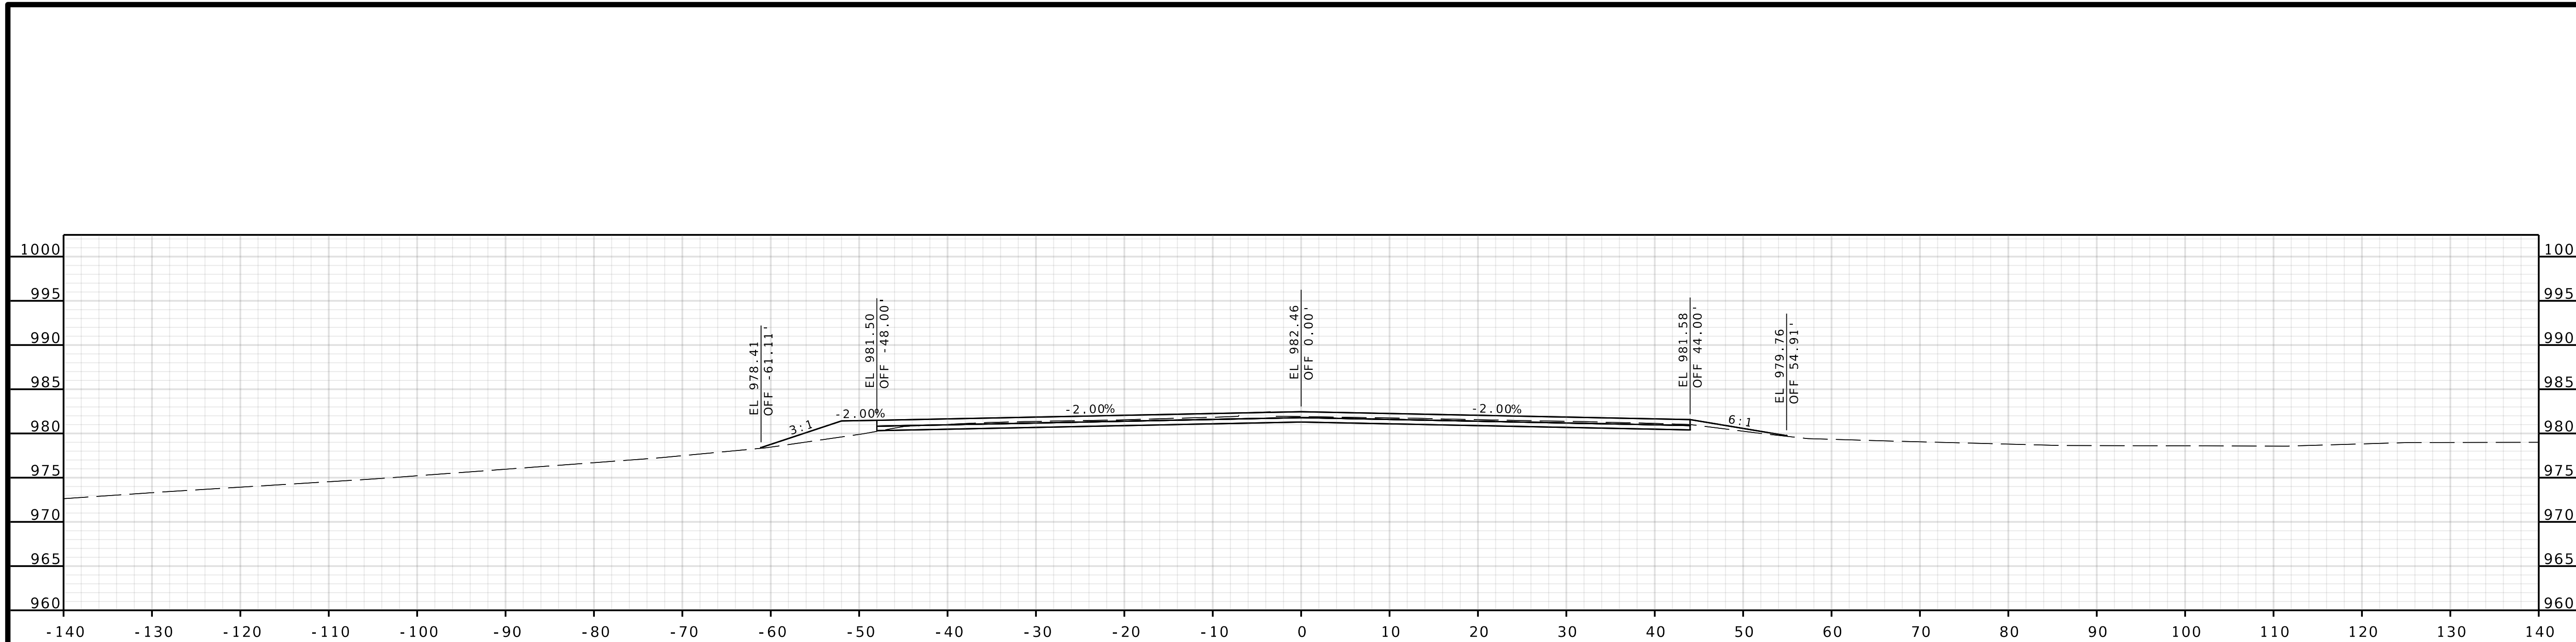



STA 638+25.00

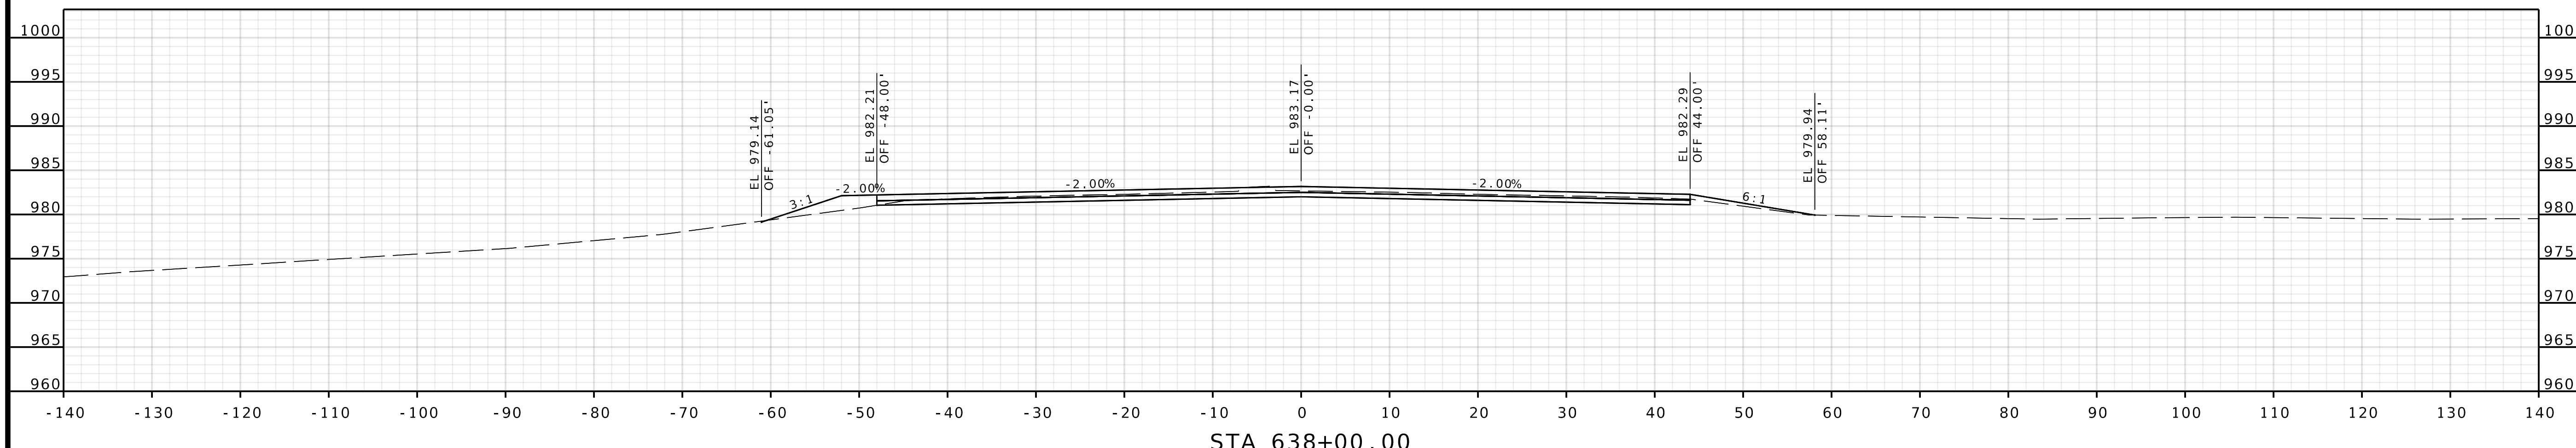


STA 638+00.00

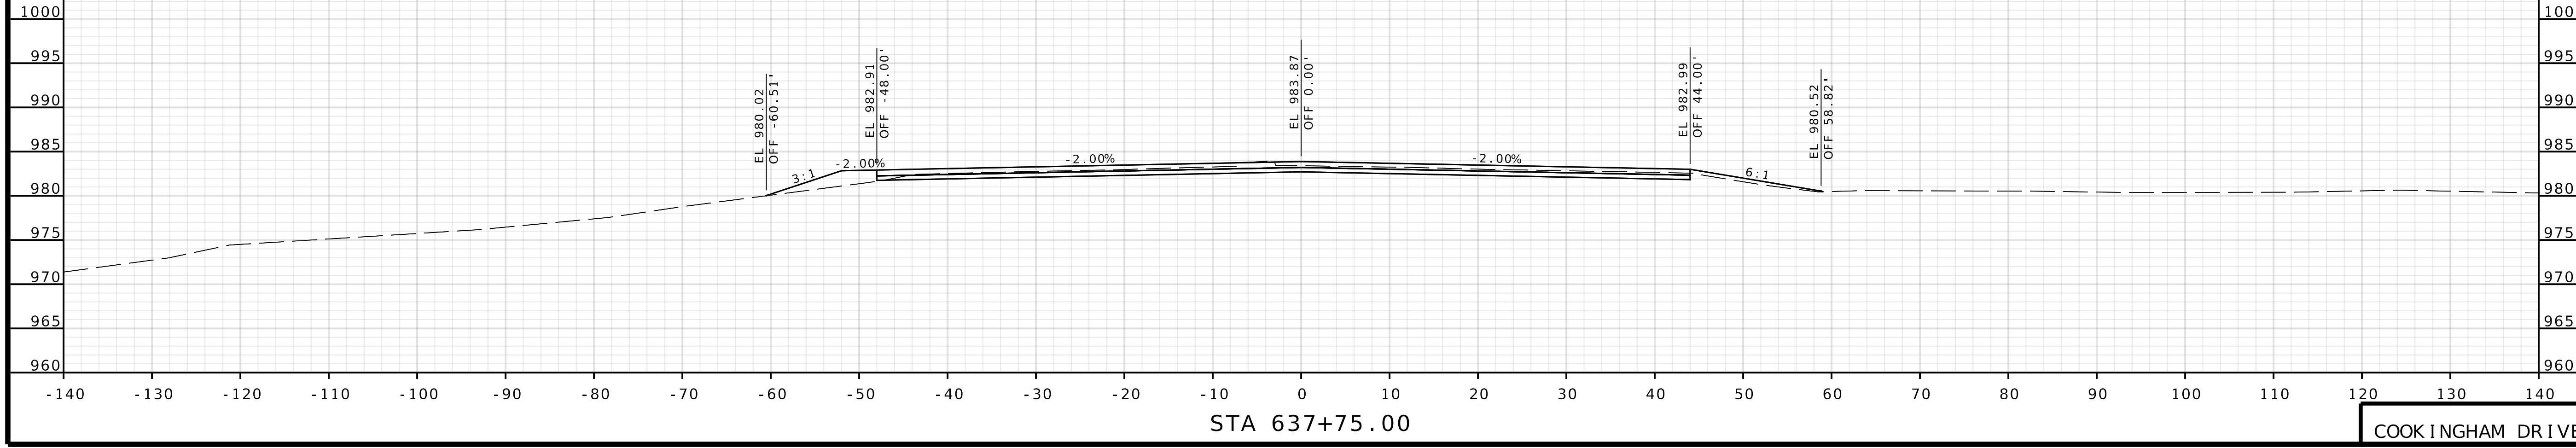


STA 637+75.00

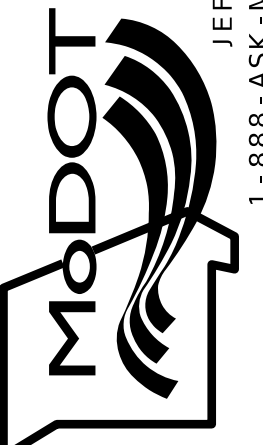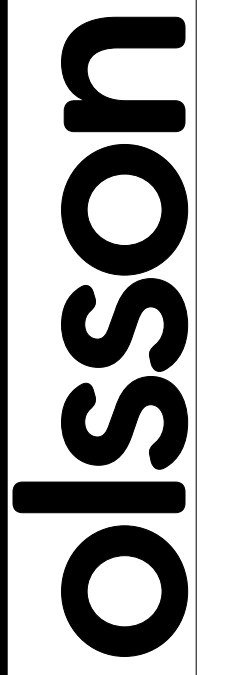DATE PREPARED 4/30/2025	
ROUTE 1435	STATE MO
DISTRICT KC	SHEET NO. 34
COUNTY PLATTE	
JOB NO. J4S3489	
CONTRACT ID.	
PROJECT NO.	
BRIDGE NO. A9700	
DESCRIPTION	DATE
MISSOURI HIGHWAYS AND TRANSPORTATION COMMISSION	
 105 WEST CAPITOL JEFFERSON CITY, MO 65102 1-888-ASK-MODOT (1-888-275-6636)	
	
COOK INGHAM DRIVE	


IF A SEAL IS PRESENT ON THIS SHEET IT HAS BEEN ELECTRONICALLY SEALED AND DATED.

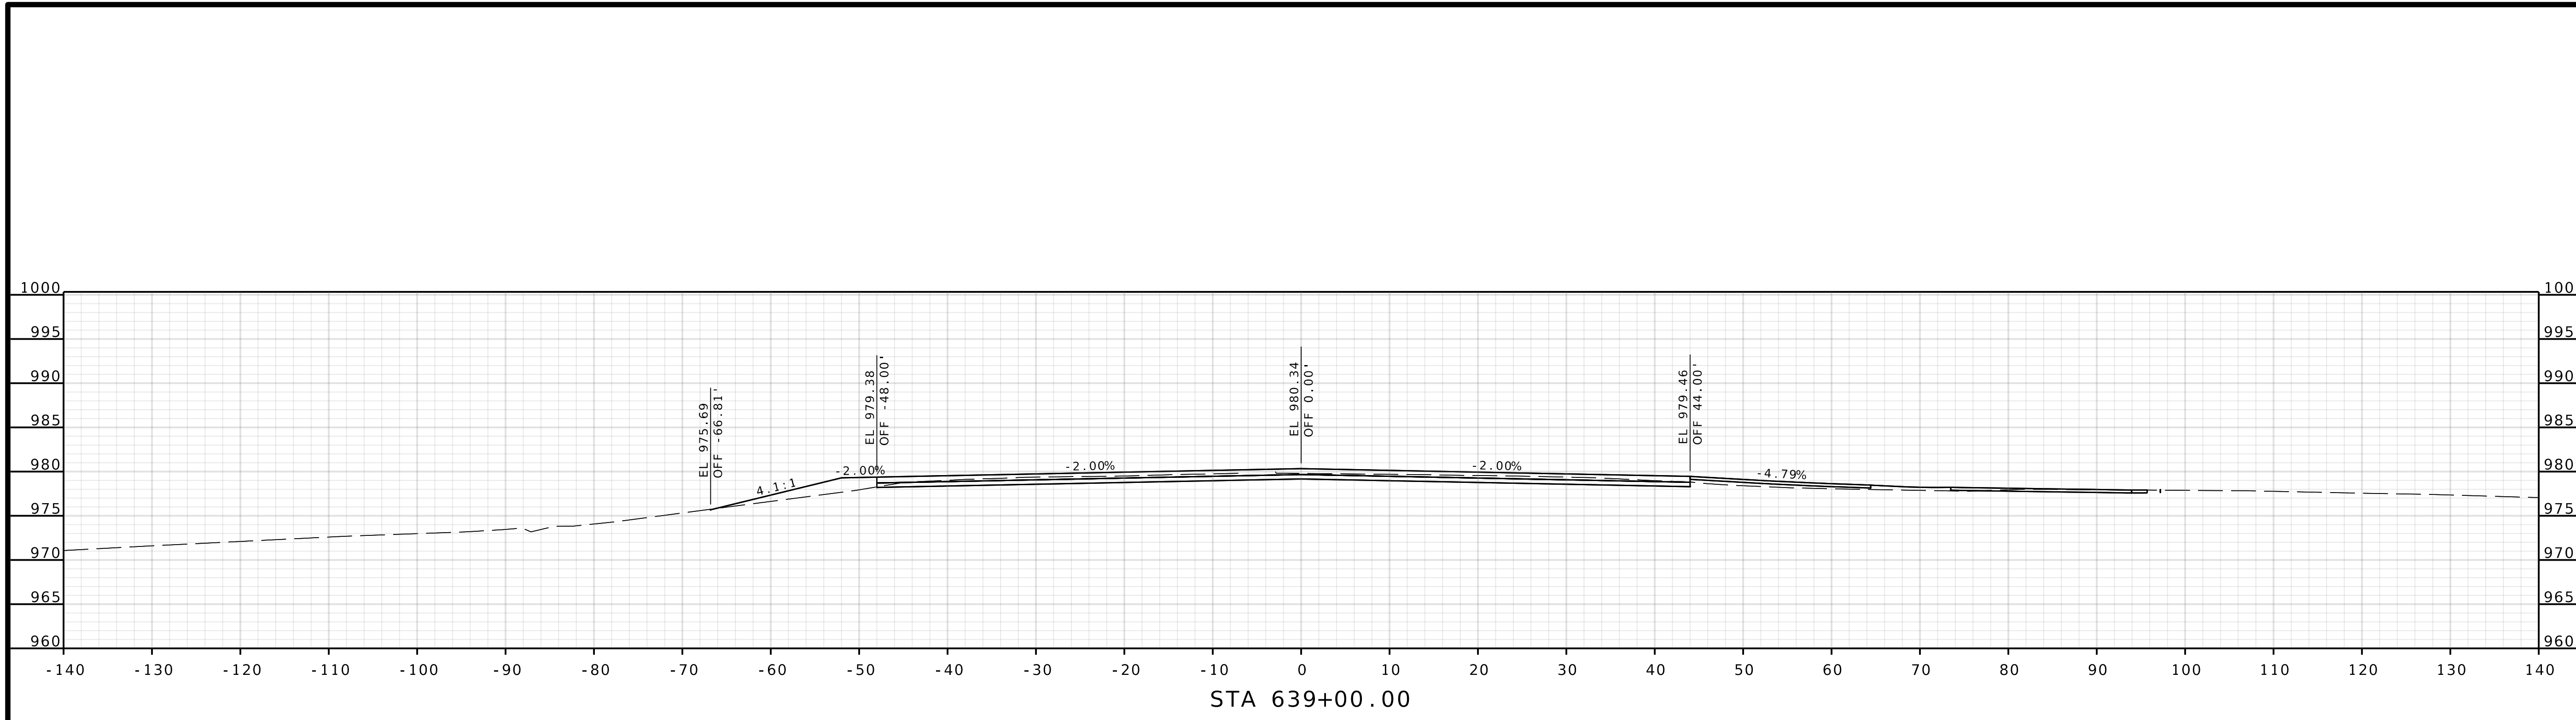

STA 639+00.00


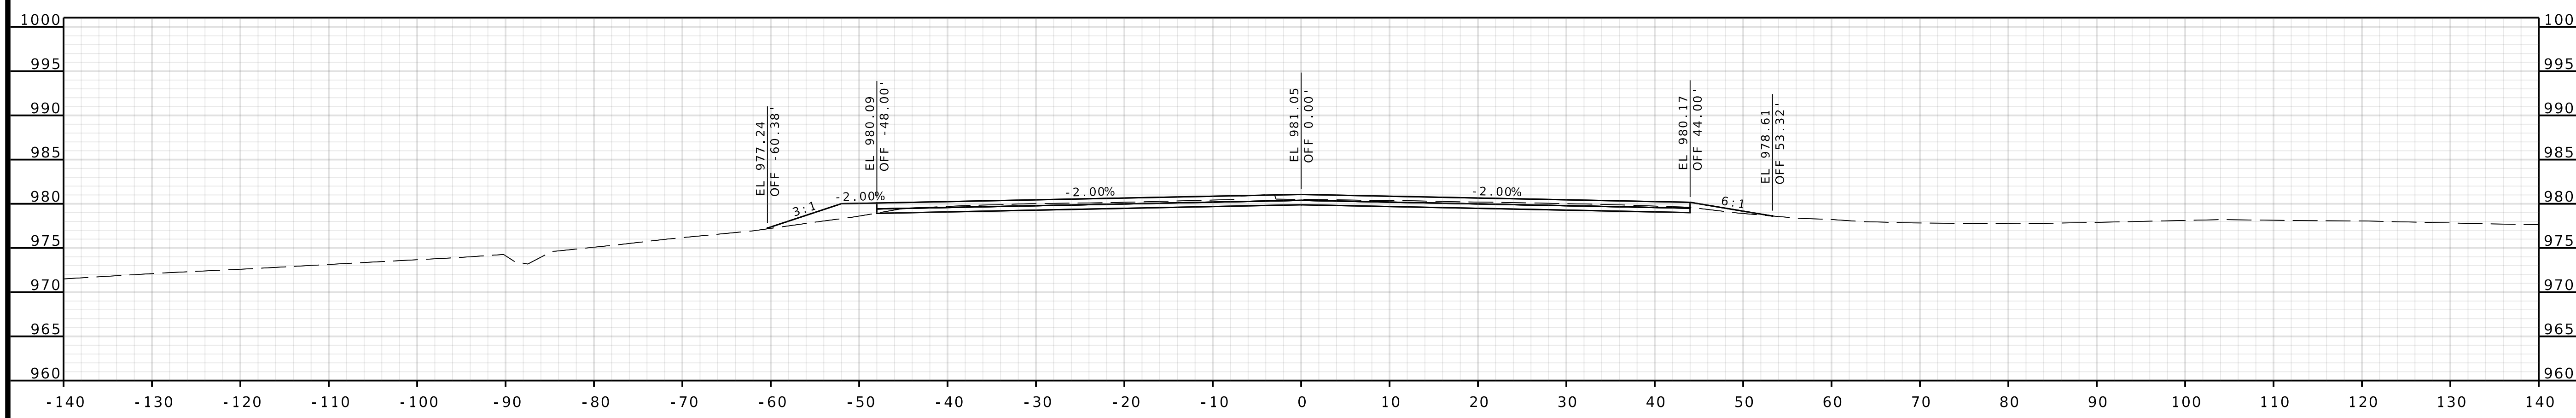


STA 638+75.00



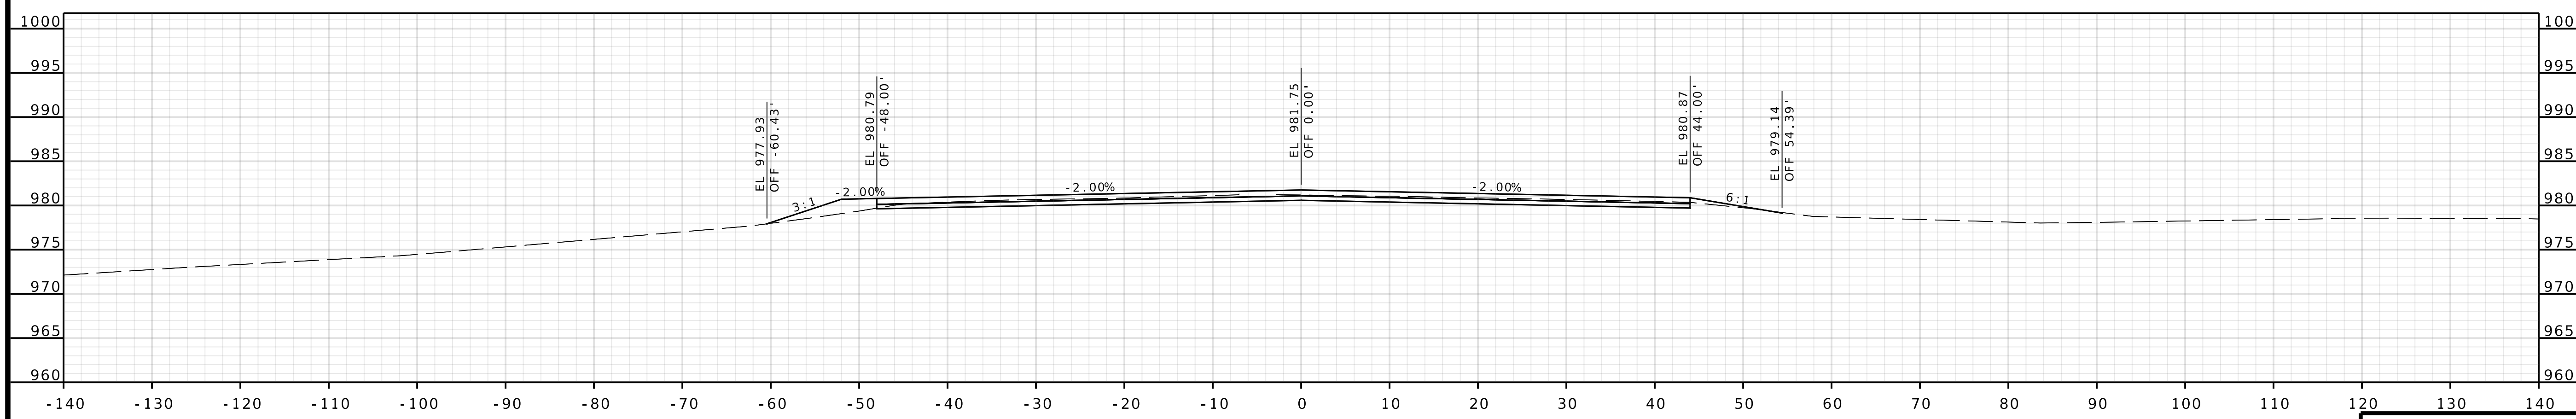




STA 638+50.00

COOK INGHAM DRIVE

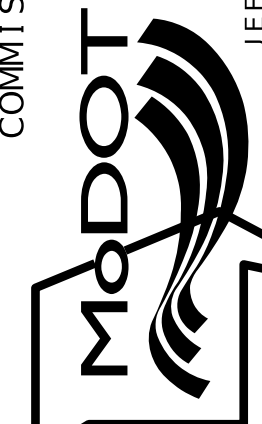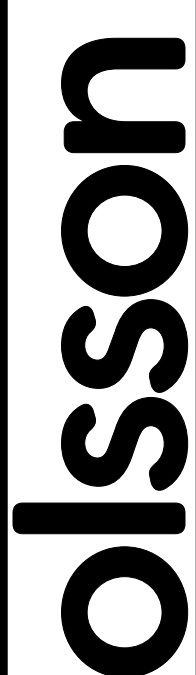
DATE PREPARED 4/30/2025	
ROUTE 1435	STATE MO
DISTRICT KC	SHEET NO. 35
COUNTY PLATTE	
JOB NO. J4S3489	
CONTRACT ID.	
PROJECT NO.	
BRIDGE NO. A9700	
DESCRIPTION	DATE
MISSOURI HIGHWAYS AND TRANSPORTATION COMMISSION	
	
105 WEST CAPITOL JEFFERSON CITY, MO 65102 1-888-ASK-MODOT (1-888-275-6636)	
	
1301 BURLINGTON STREET, STE. 100 NORTH KANSAS CITY, MO 64116 PHONE: 816.361.1177 CERTIFICATE OF AUTHORITY NO. 001592	

IF A SEAL IS PRESENT ON THIS SHEET IT HAS BEEN ELECTRONICALLY SEALED AND DATED.

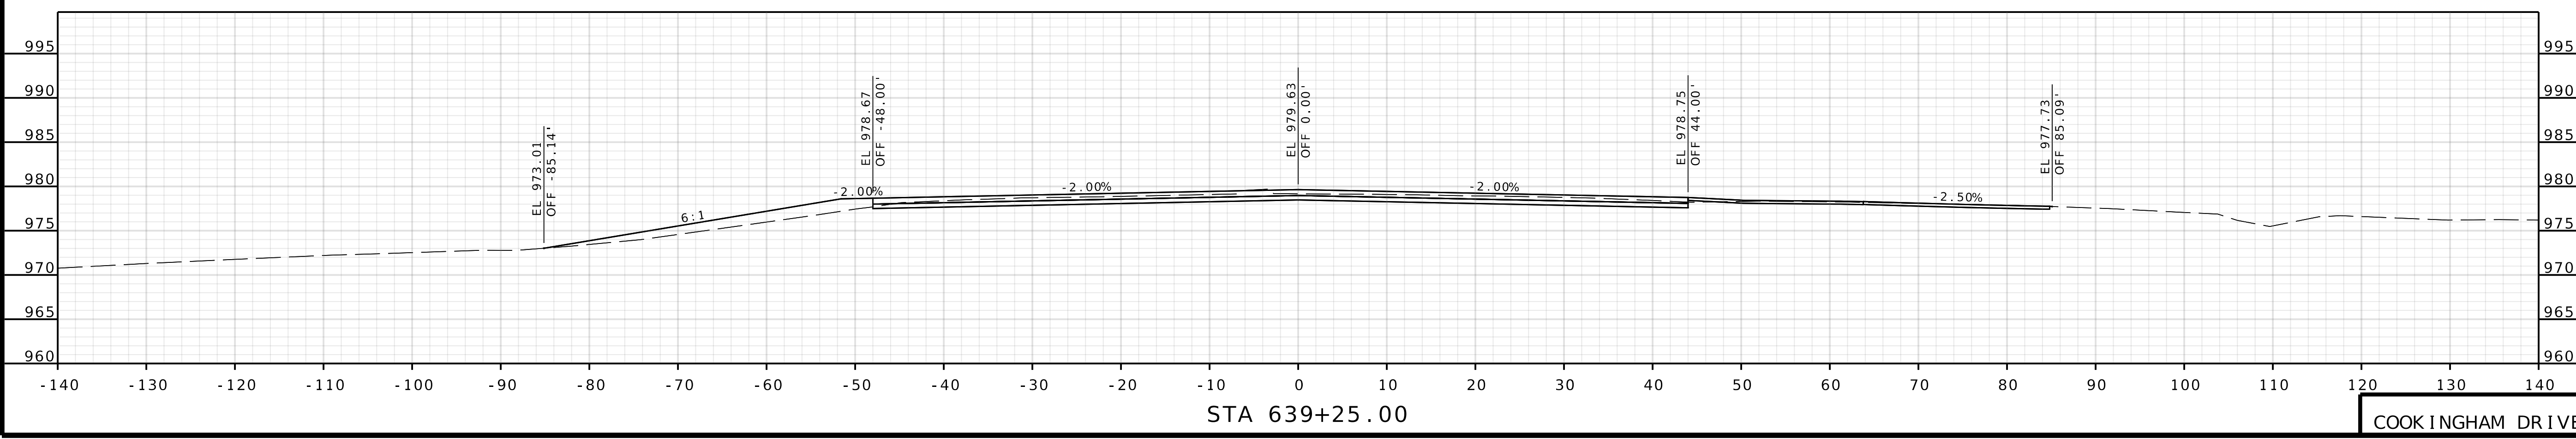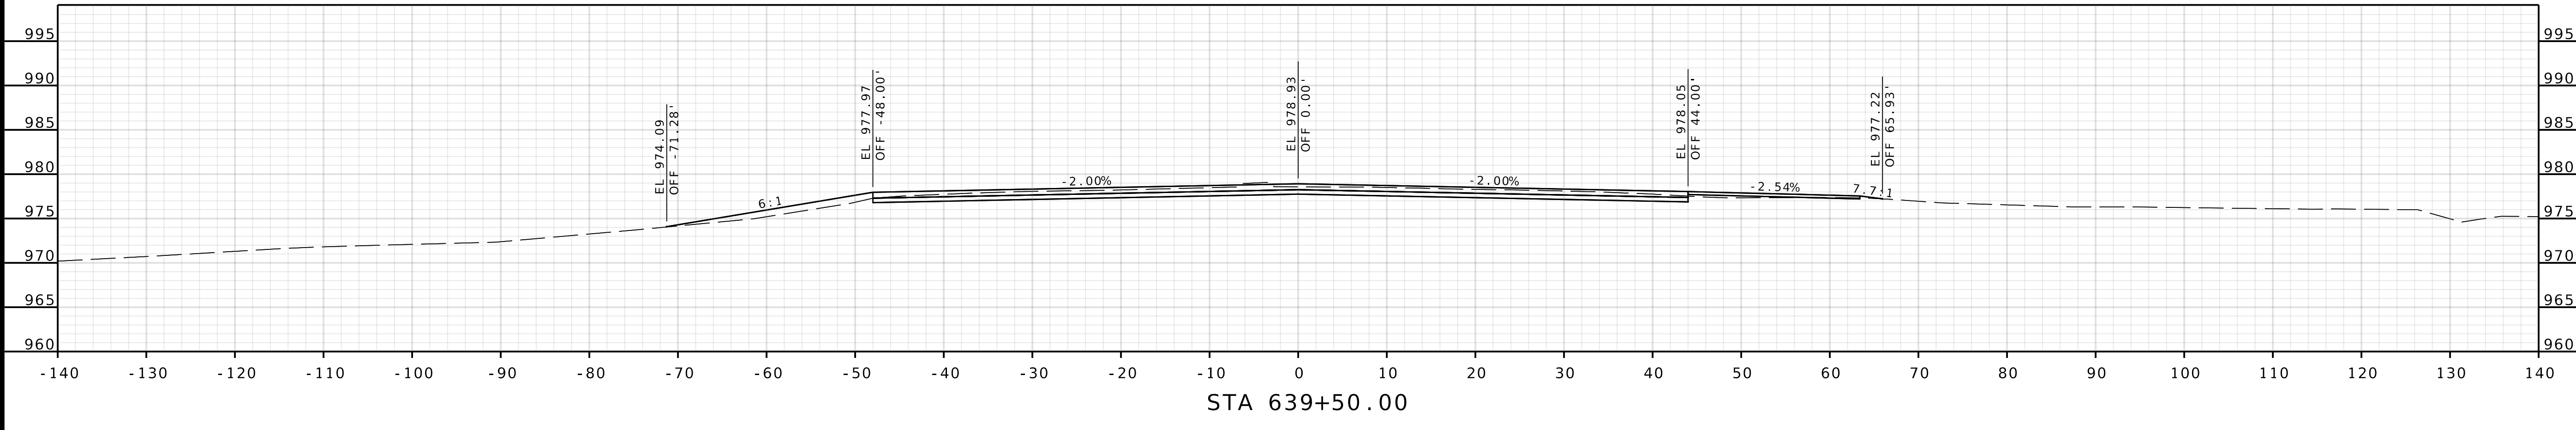
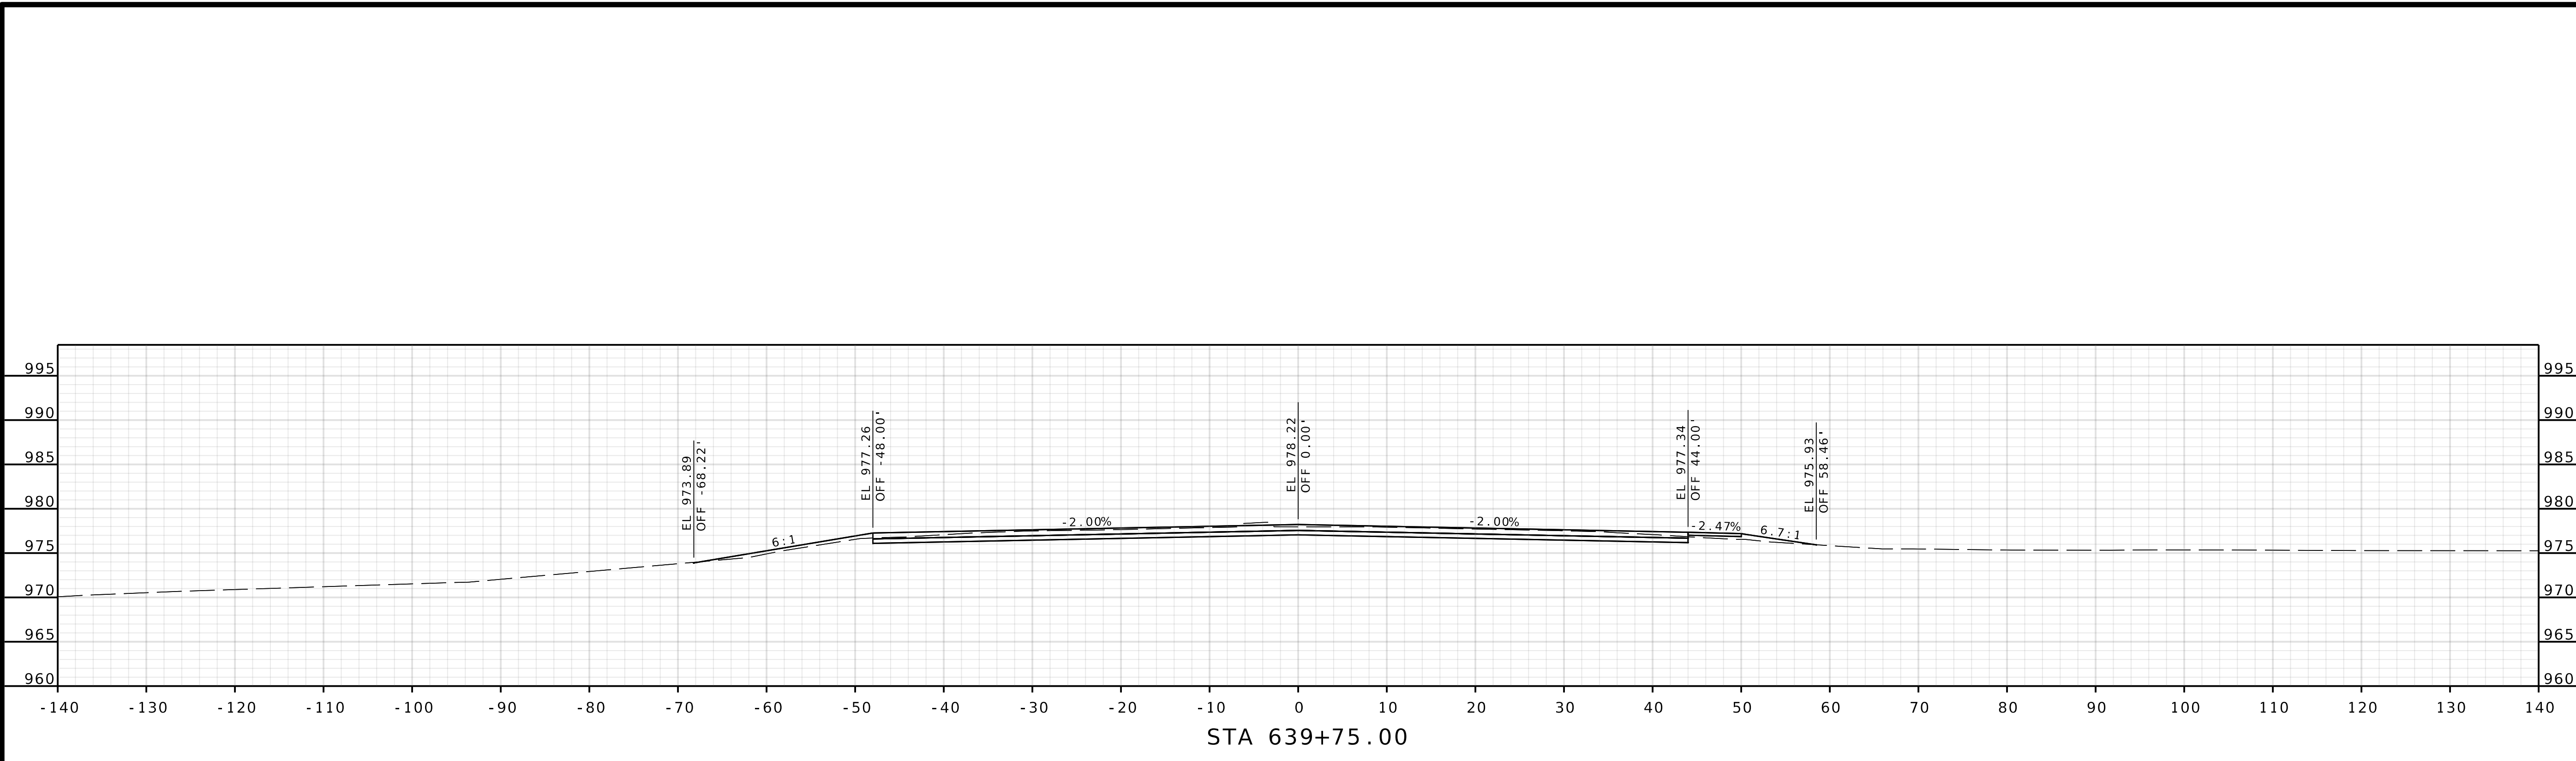


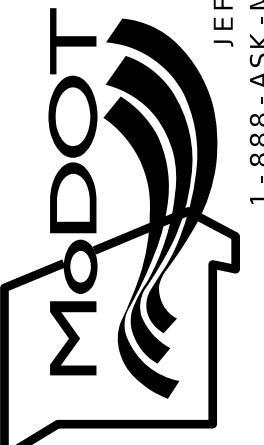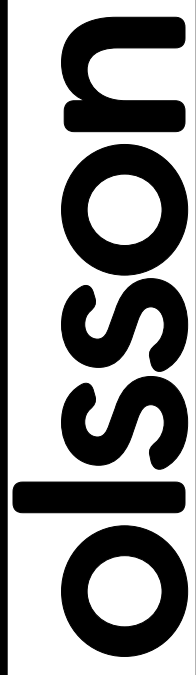DATE PREPARED 4/30/2025	
ROUTE 1435	STATE MO
DISTRICT KC	SHEET NO. 36
COUNTY PLATTE	
JOB NO. J4S3489	
CONTRACT ID.	
PROJECT NO.	
BRIDGE NO. A9700	
DESCRIPTION	DATE
MISSOURI HIGHWAYS AND TRANSPORTATION COMMISSION	
 105 WEST CAPITOL JEFFERSON CITY, MO 65102 1-888-ASK-MODOT (1-888-275-6636)	
 olsson 1301 BURLINGTON STREET, STE. 100 NORTH KANSAS CITY, MO 64116 PHONE: 816.361.1177 CERTIFICATE OF AUTHORITY NO. 001592	

IF A SEAL IS PRESENT ON THIS SHEET IT HAS BEEN ELECTRONICALLY SEALED AND DATED.

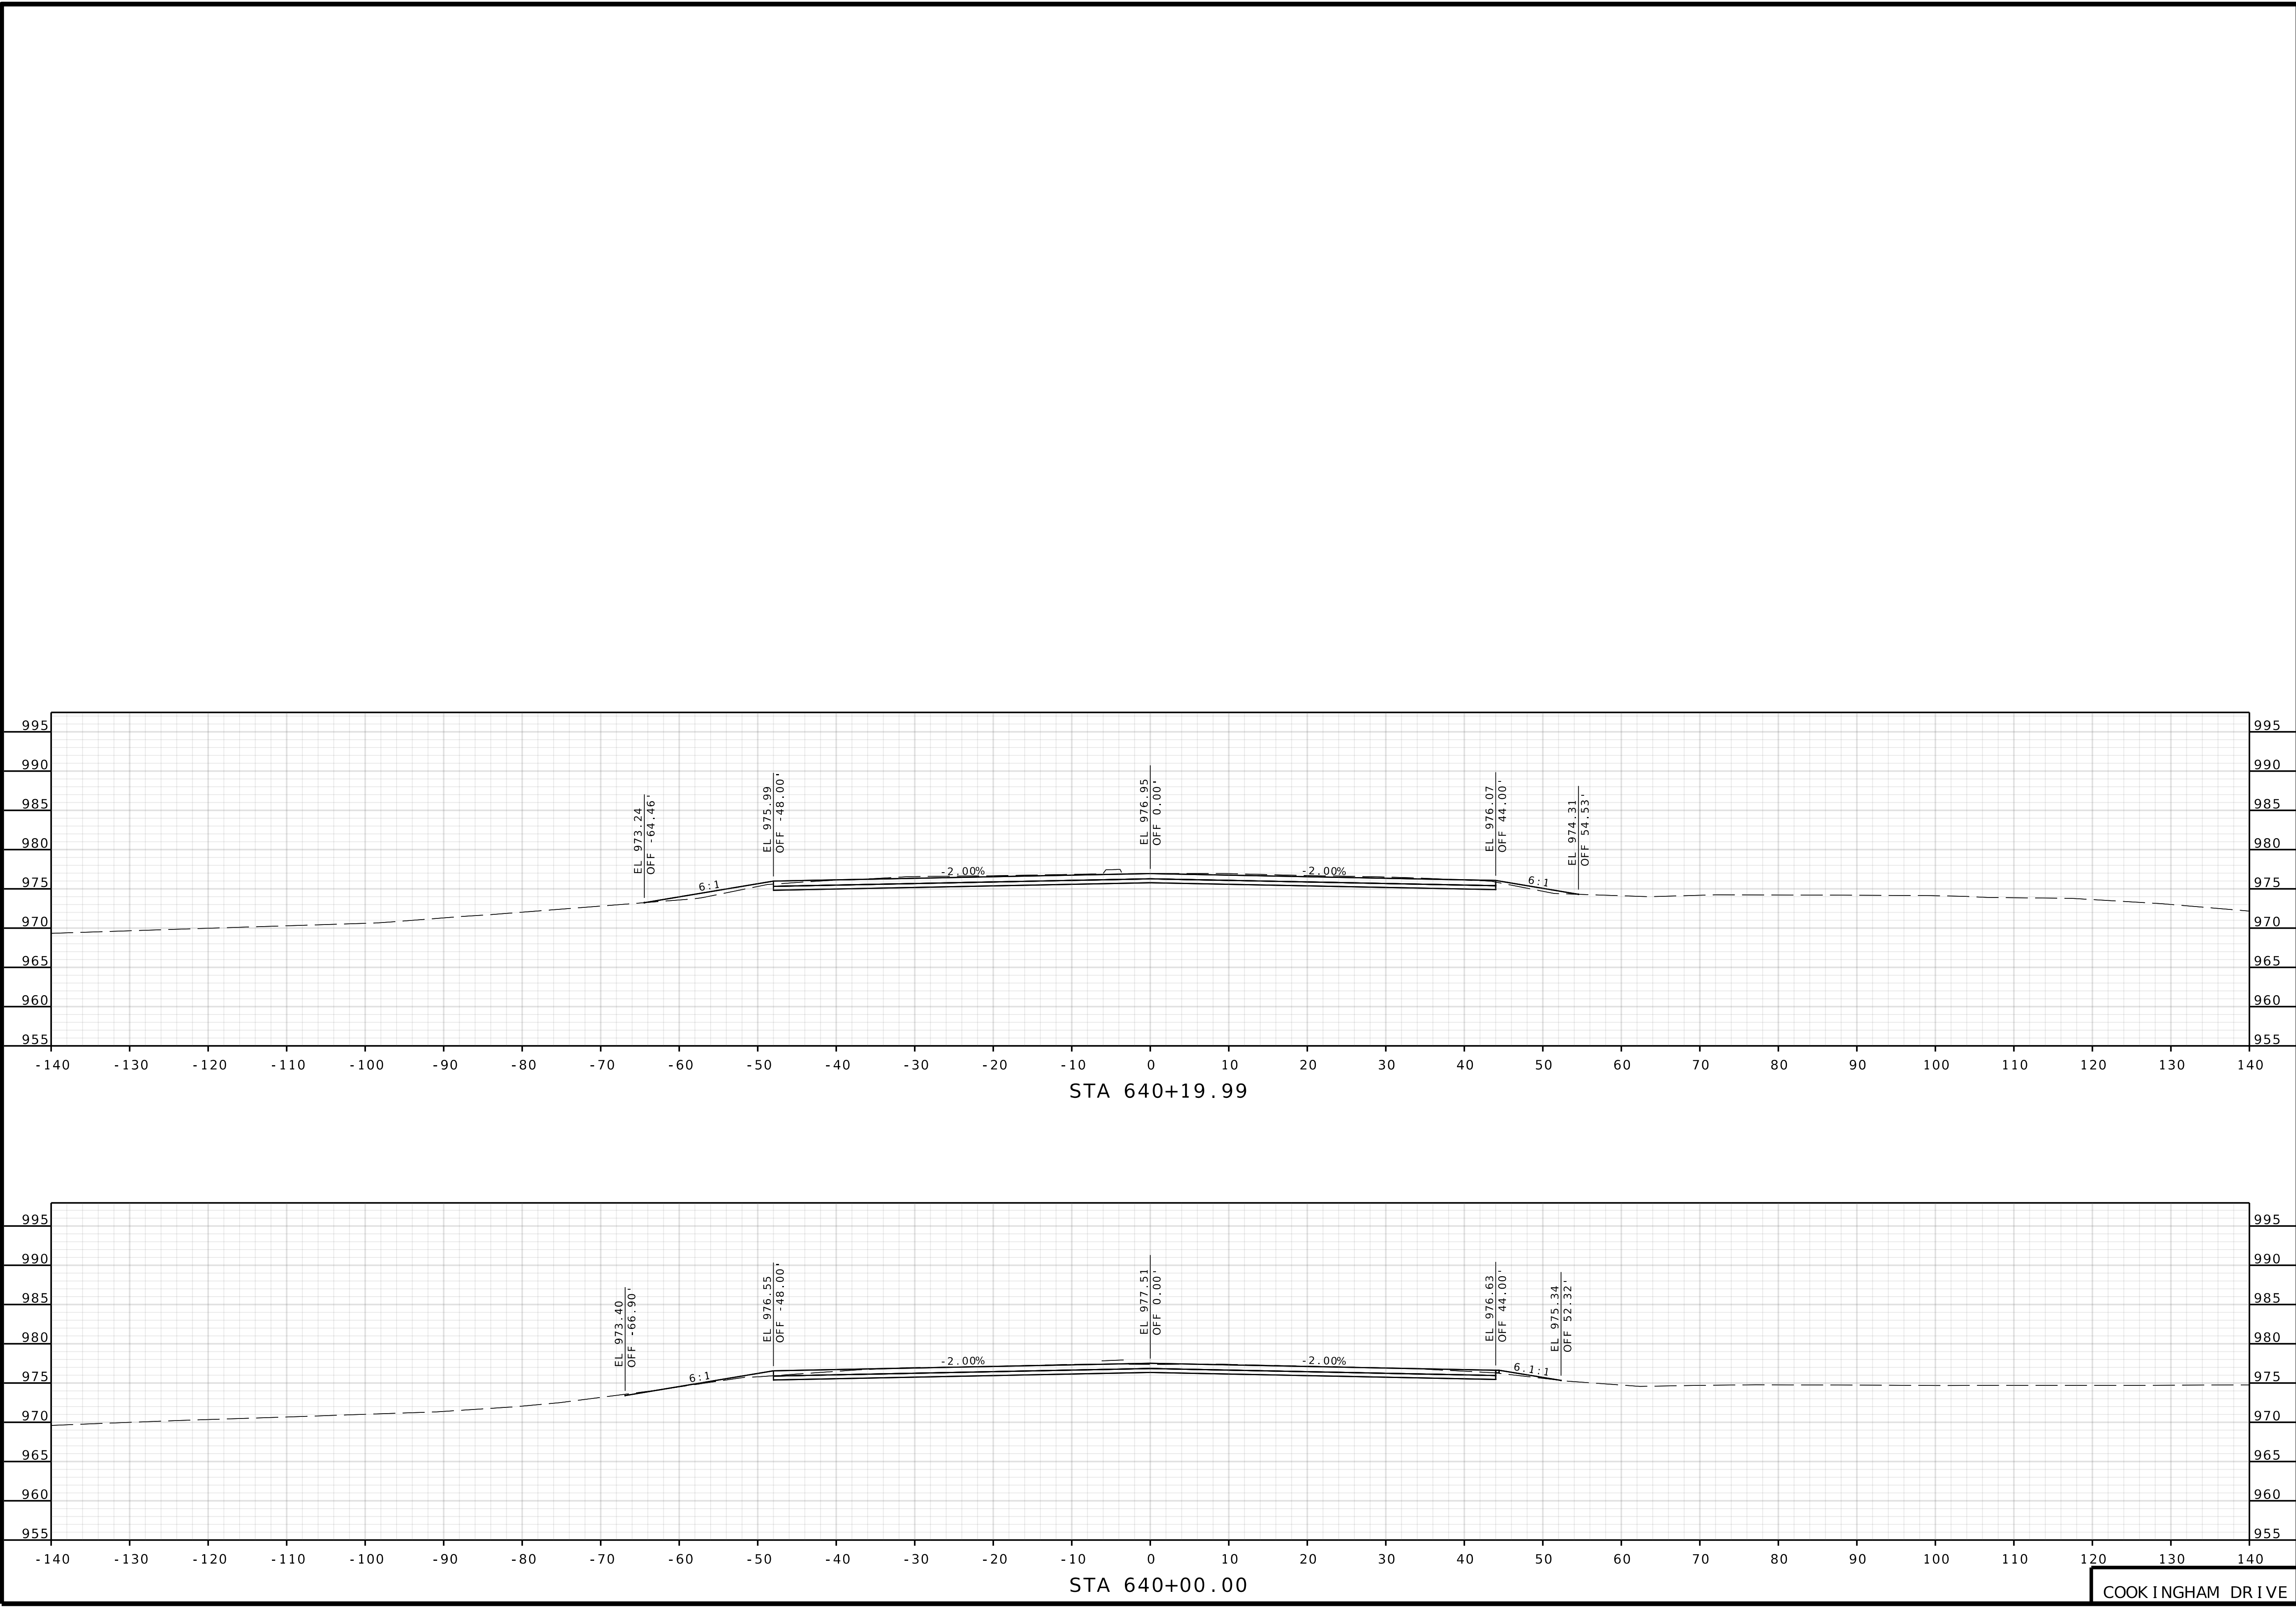

COOK INGHAM DRIVE

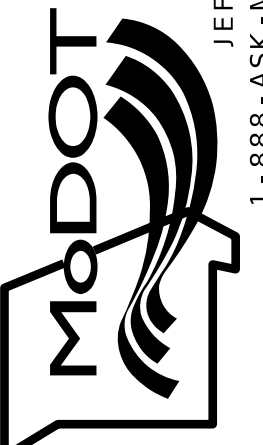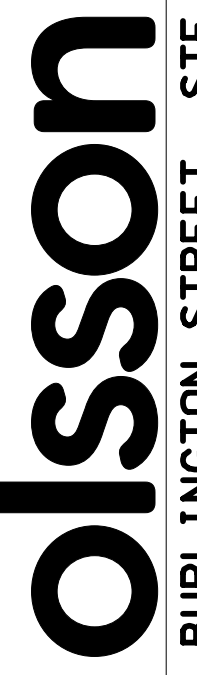DATE PREPARED 4/30/2025	
ROUTE 1435	STATE MO
DISTRICT KC	SHEET NO. 37
COUNTY PLATTE	
JOB NO. J4S3489	
CONTRACT ID.	
PROJECT NO.	
BRIDGE NO. A9700	
DESCRIPTION	DATE
MISSOURI HIGHWAYS AND TRANSPORTATION COMMISSION	
 105 WEST CAPITOL JEFFERSON CITY, MO 65102 1-888-ASK-MODOT (1-888-275-6636)	
 1301 BURLINGTON STREET, STE. 100 NORTH KANSAS CITY, MO 64116 PHONE: 816.361.1177 CERTIFICATE OF AUTHORITY NO. 001592	

IF A SEAL IS PRESENT ON THIS SHEET IT HAS BEEN ELECTRONICALLY SEALED AND DATED.