


OPTIONAL PAVEMENT

1.75" BP-1 (PG64-22)
8.25" BB (PG64-22)

OR


8" PCCP W/ 15' JOINT
SPACING & 1.25" DOWELS

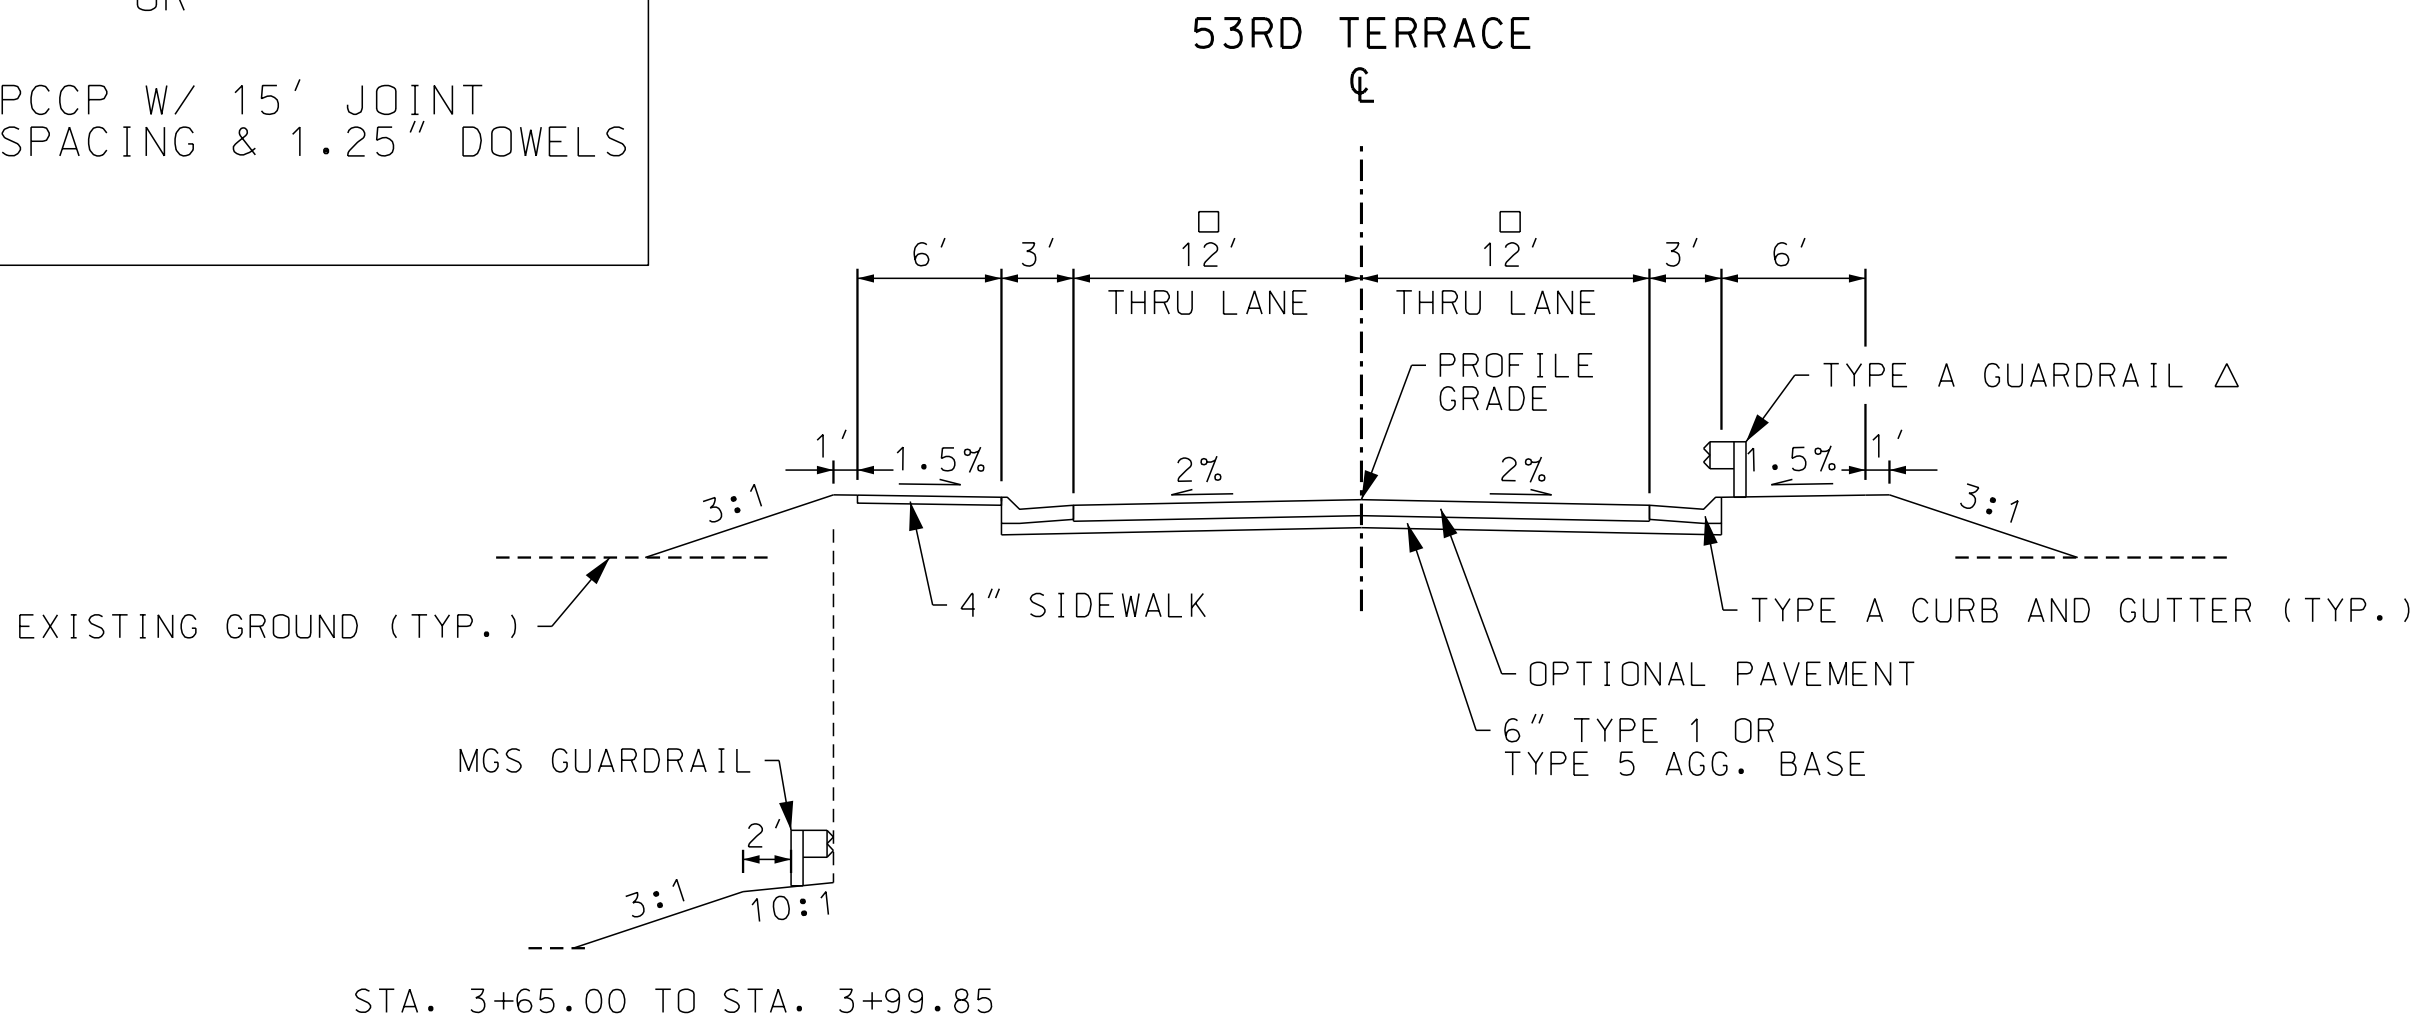

SECTION ON TANGENT


TYPICAL SECTION 53RD TERRACE
STA. 3+65.00 TO STA. 4+06.25
STA. 5+93.75 TO STA. 7+00.00
BRIDGE A8931 EXCEPTION STA. 4+06.25 TO STA. 5+93.75

- TRANS. 12' TO 13'
STA. 3+65.00 TO STA. 3+86.75
- WIDTH = 13'
STA. 3+86.75 TO STA. 4+06.25
STA. 5+93.75 TO STA. 6+13.25
- TRANS. 13' TO 12'
STA. 6+13.25 TO STA. 6+33.25
- Δ STA. 3+65.00 TO STA. 3+99.85

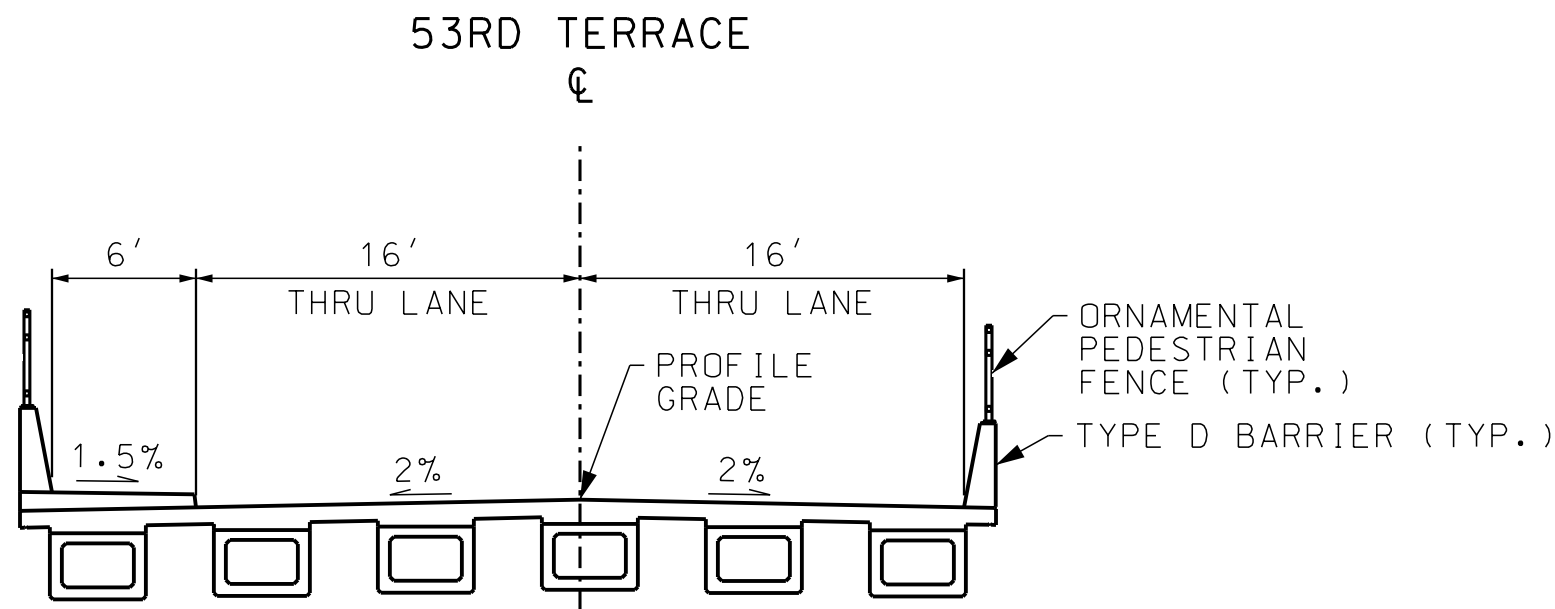

SECTION - BRIDGE A8931

TYPICAL SECTION 53RD TERRACE
STA. 4+06.25 TO STA. 5+93.75

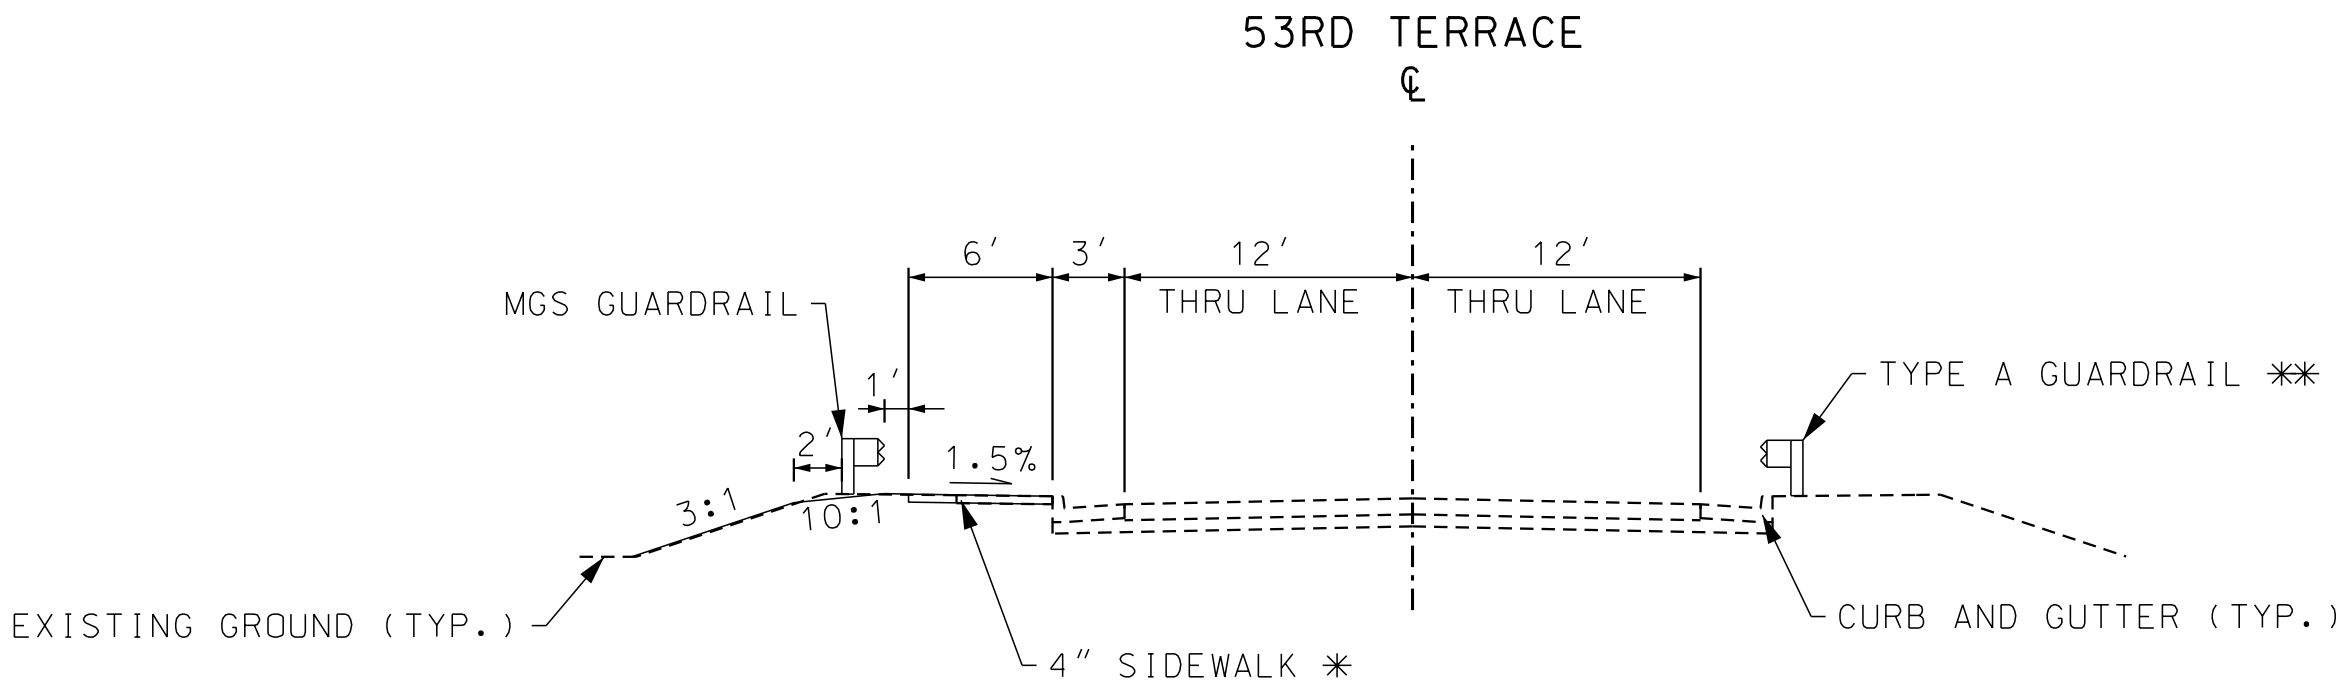

SECTION ON TANGENT

TYPICAL SECTION 53RD TERRACE
STA. 3+12.35 TO STA. 3+65.00

* STA. 3+24.45 TO 3+65.00

** STA. 3+31.11 TO 3+65.00

"THIS MEDIA SHOULD NOT BE CONSIDERED A CERTIFIED DOCUMENT."

DATE PREPARED
6/12/2020

ROUTE 53RD	STATE MO
DISTRICT KC	SHEET NO. 2

COUNTY
CLAY

JOB NO.
J4S3386

CONTRACT ID.

PROJECT NO.

BRIDGE NO.
A8931

DESCRIPTION	DATE

MISSOURI HIGHWAYS AND TRANSPORTATION COMMISSION

MoDOT

105 WEST CAPITOL
JEFFERSON CITY, MO 65102
1-888-ASK-MODOT (1-888-275-6636)


GARVER, LLC.
7410 NW TIFFANY SPRINGS
PARKWAY, SUITE 200
KANSAS CITY, MO 64153
PHONE: (816) 298-6465
CERTIFICATE OF AUTHORITY
NO. 2008013090

OPTIONAL PAVEMENT

1.75" BP-1 (PG64-22)
8.25" BB (PG64-22)


OR

8" PCCP W/ 15' JOINT
SPACING & 1.25" DOWELS

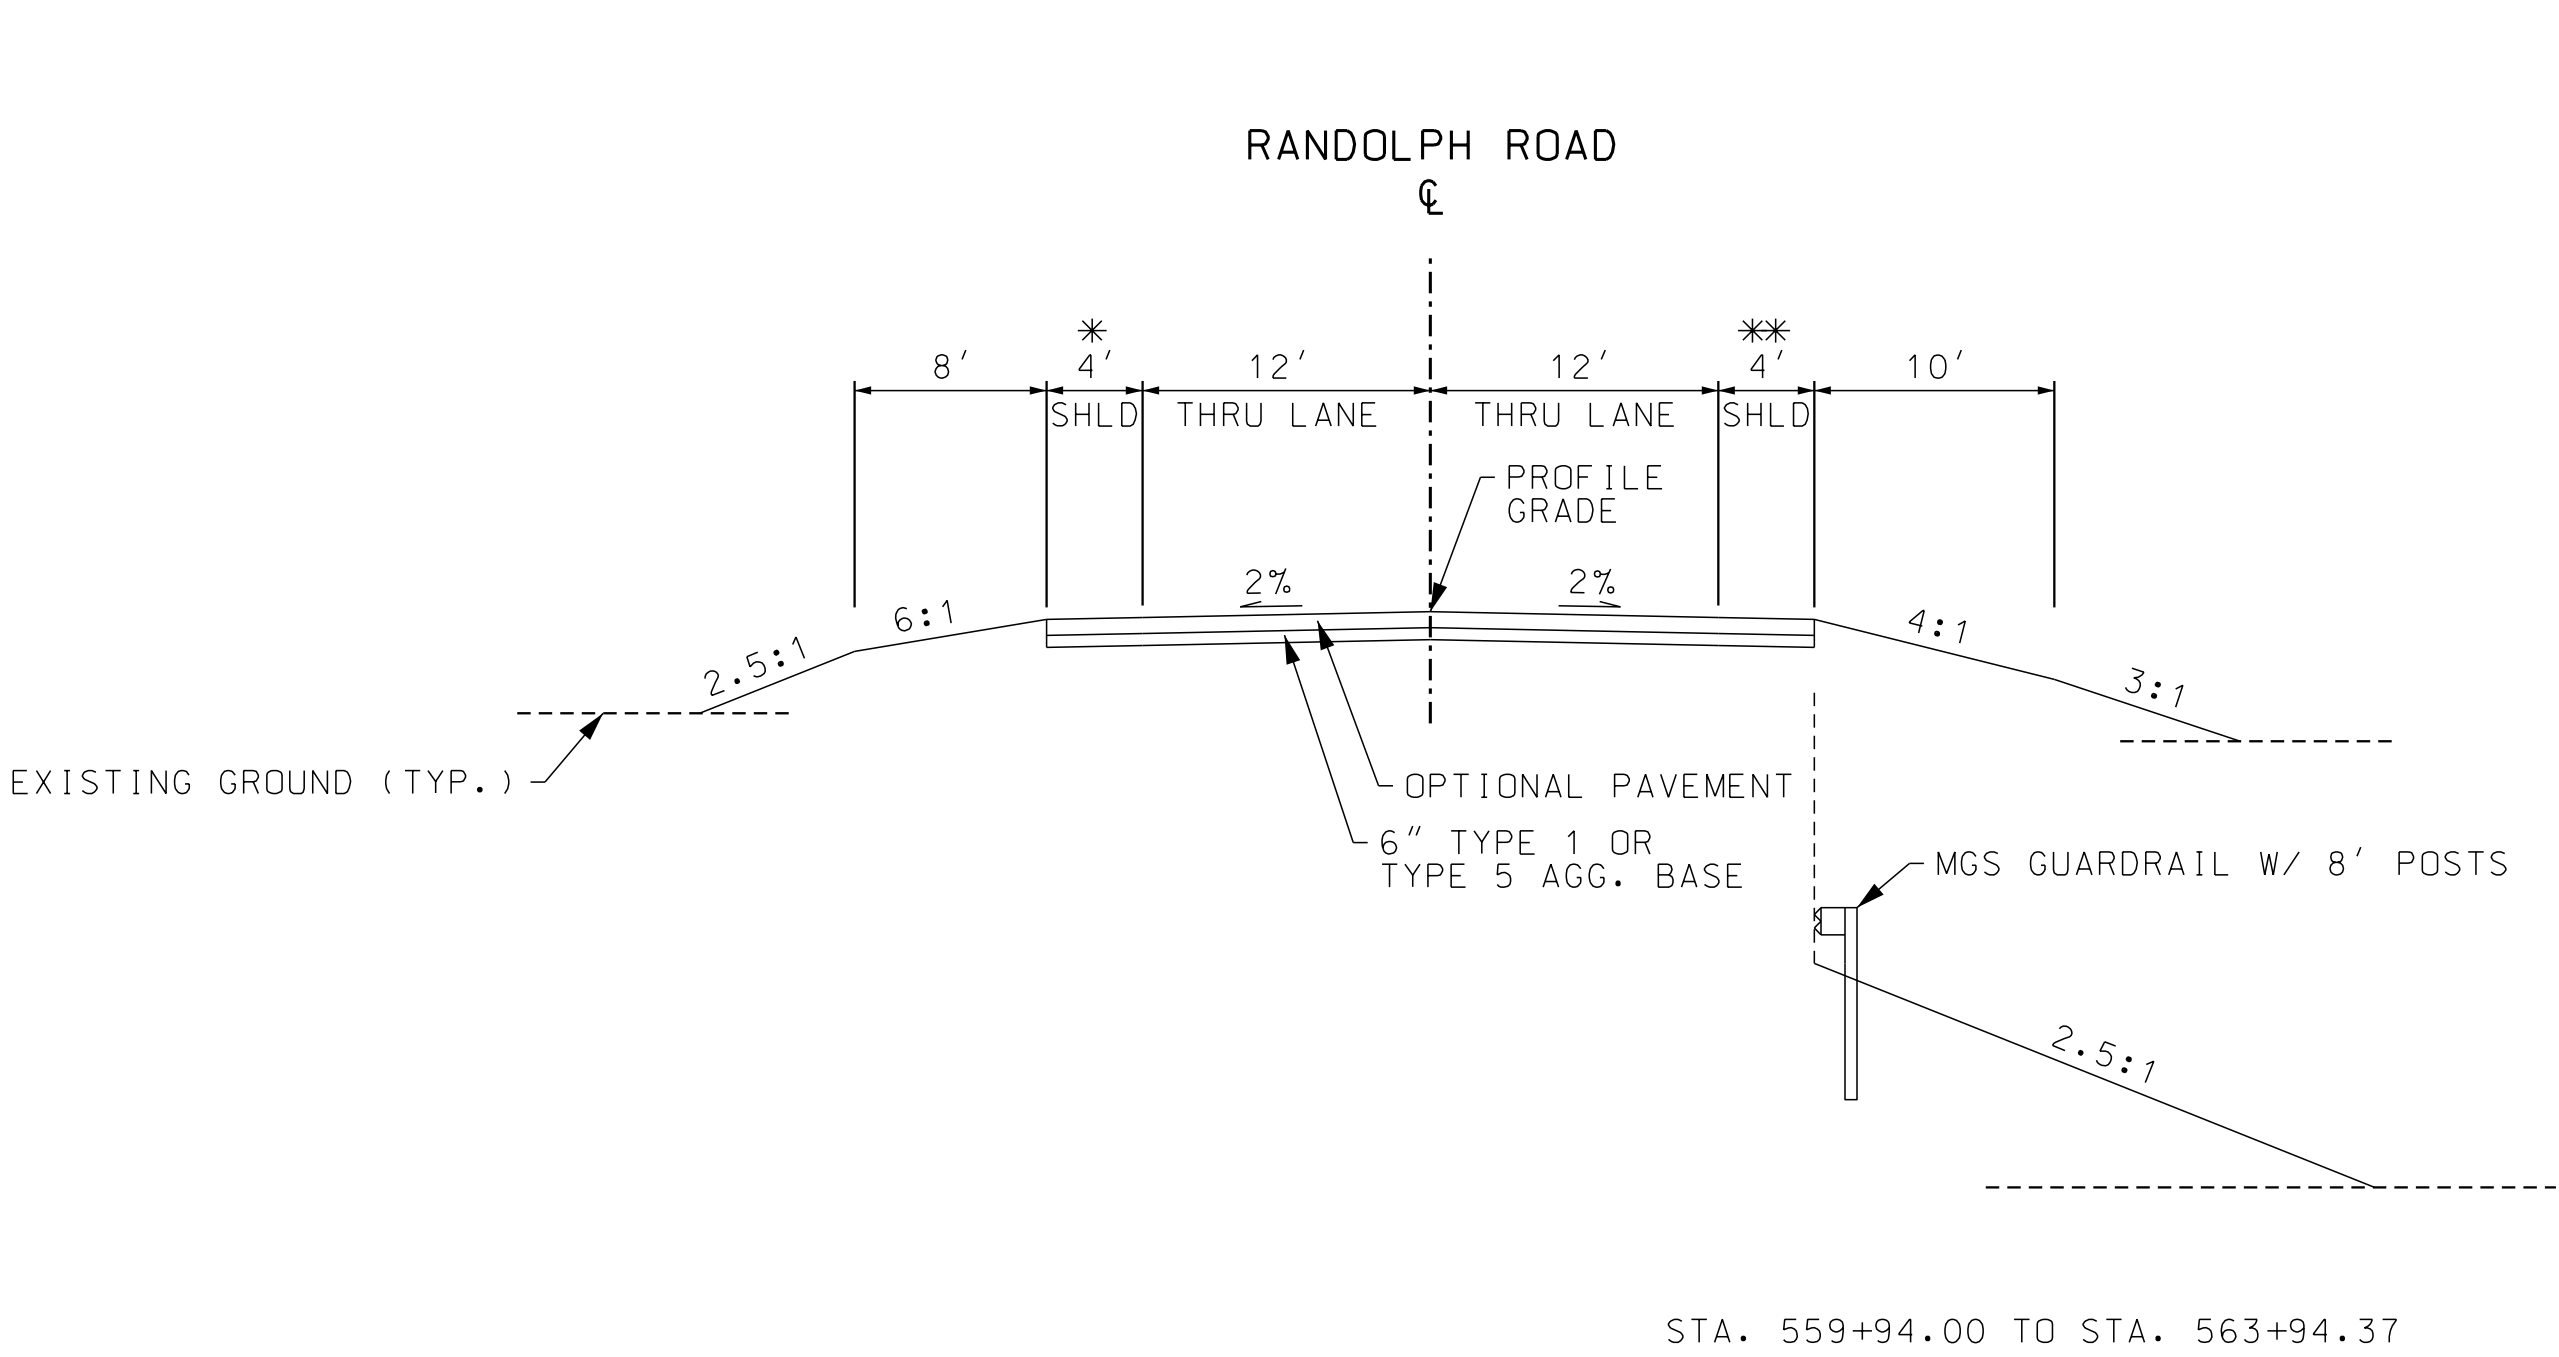

SECTION ON TANGENT

TYPICAL SECTION RANDOLPH RD
STA. 559+94.00 TO STA. 565+20.00

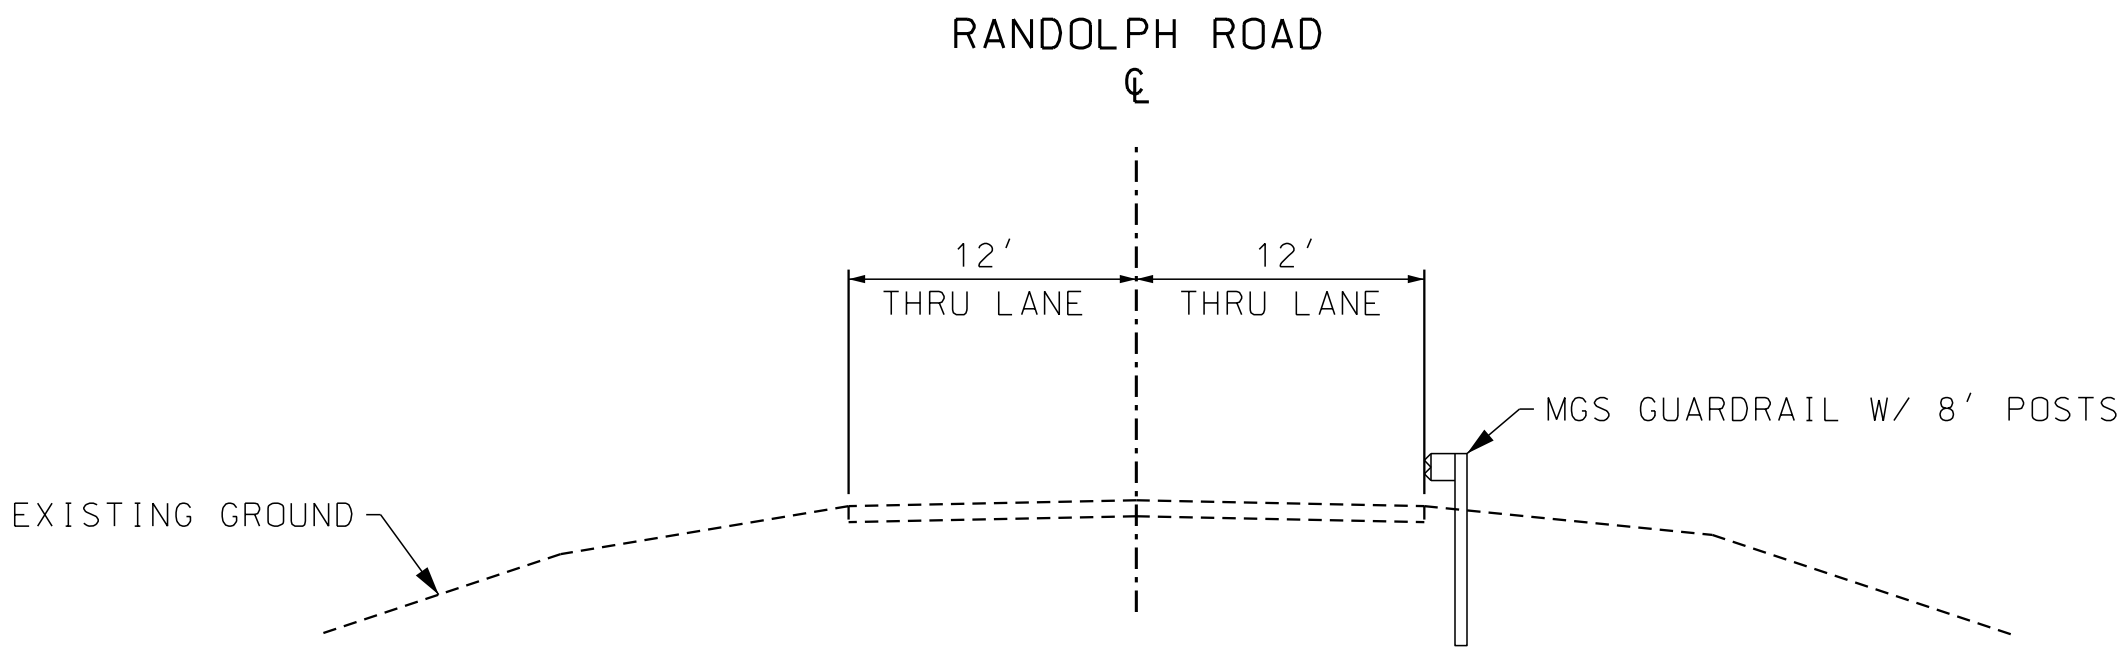

SECTION ON TANGENT

TYPICAL SECTION RANDOLPH RD
STA. 558+97.67 TO STA. 559+94.00

- * WIDTH = 0'
STA. 559+94.00 TO STA. 561+82.77
- WIDTH = 4'
STA. 561+82.77 TO STA. 564+80.00
- TRANS. FROM 4' TO 2'
STA. 564+80.00 TO STA. 565+00.00
- WIDTH = 0'
STA. 565+00.00 TO STA. 565+20.00
- ** TRANS. FROM 2' TO 4'
STA. 559+94.00 TO STA. 560+14.00
- WIDTH = 4'
STA. 560+14.00 TO STA. 564+82.84
- WIDTH = 0'
STA. 564+82.84 TO 565+20.00

"THIS MEDIA SHOULD NOT BE CONSIDERED A CERTIFIED DOCUMENT."

DATE PREPARED
6/12/2020

ROUTE 53RD	STATE MO
DISTRICT KC	SHEET NO. 2

COUNTY
CLAY

JOB NO.
J4S3386

CONTRACT ID.

PROJECT NO.

BRIDGE NO.
A8931


DESCRIPTION	DATE

MISSOURI HIGHWAYS AND TRANSPORTATION COMMISSION


MoDOT

105 WEST CAPITOL
JEFFERSON CITY, MO 65102
1-888-ASK-MODOT (1-888-275-6636)

GARVER, LLC.
7410 NW TIFFANY SPRINGS
PARKWAY, SUITE 200
KANSAS CITY, MO 64153
PHONE: (816) 298-6465
CERTIFICATE OF AUTHORITY
NO. 2008013090

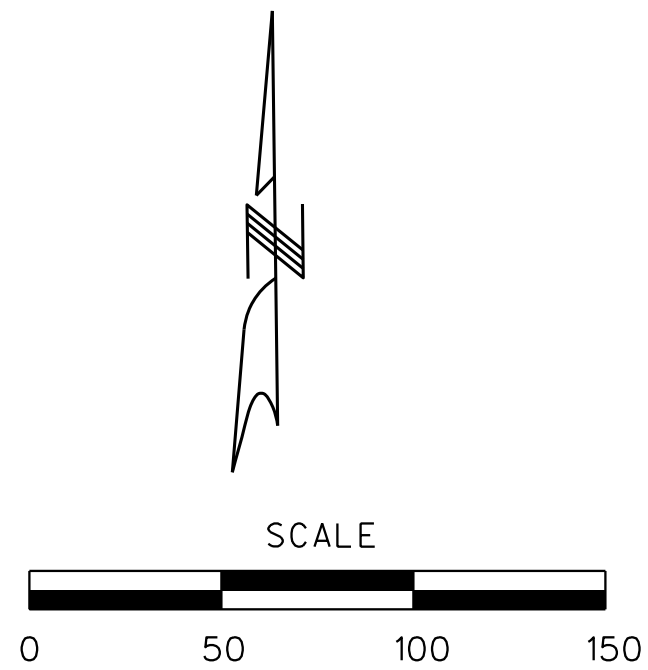

THE APPROXIMATE LOCATION OF PROPERTY LINES AS SHOWN ON THE PLANS ARE BASED ON THE BEST INFORMATION AVAILABLE TO THE COMMISSION AT THIS TIME. THIS INFORMATION IS PROVIDED BY THE COMMISSION "AS-IS" AND THE COMMISSION EXPRESSLY DISCLAIMS ANY REPRESENTATION OR WARRANTY AS TO THE COMPLETENESS, ACCURACY, OR SUITABILITY OF THE INFORMATION FOR ANY USE.

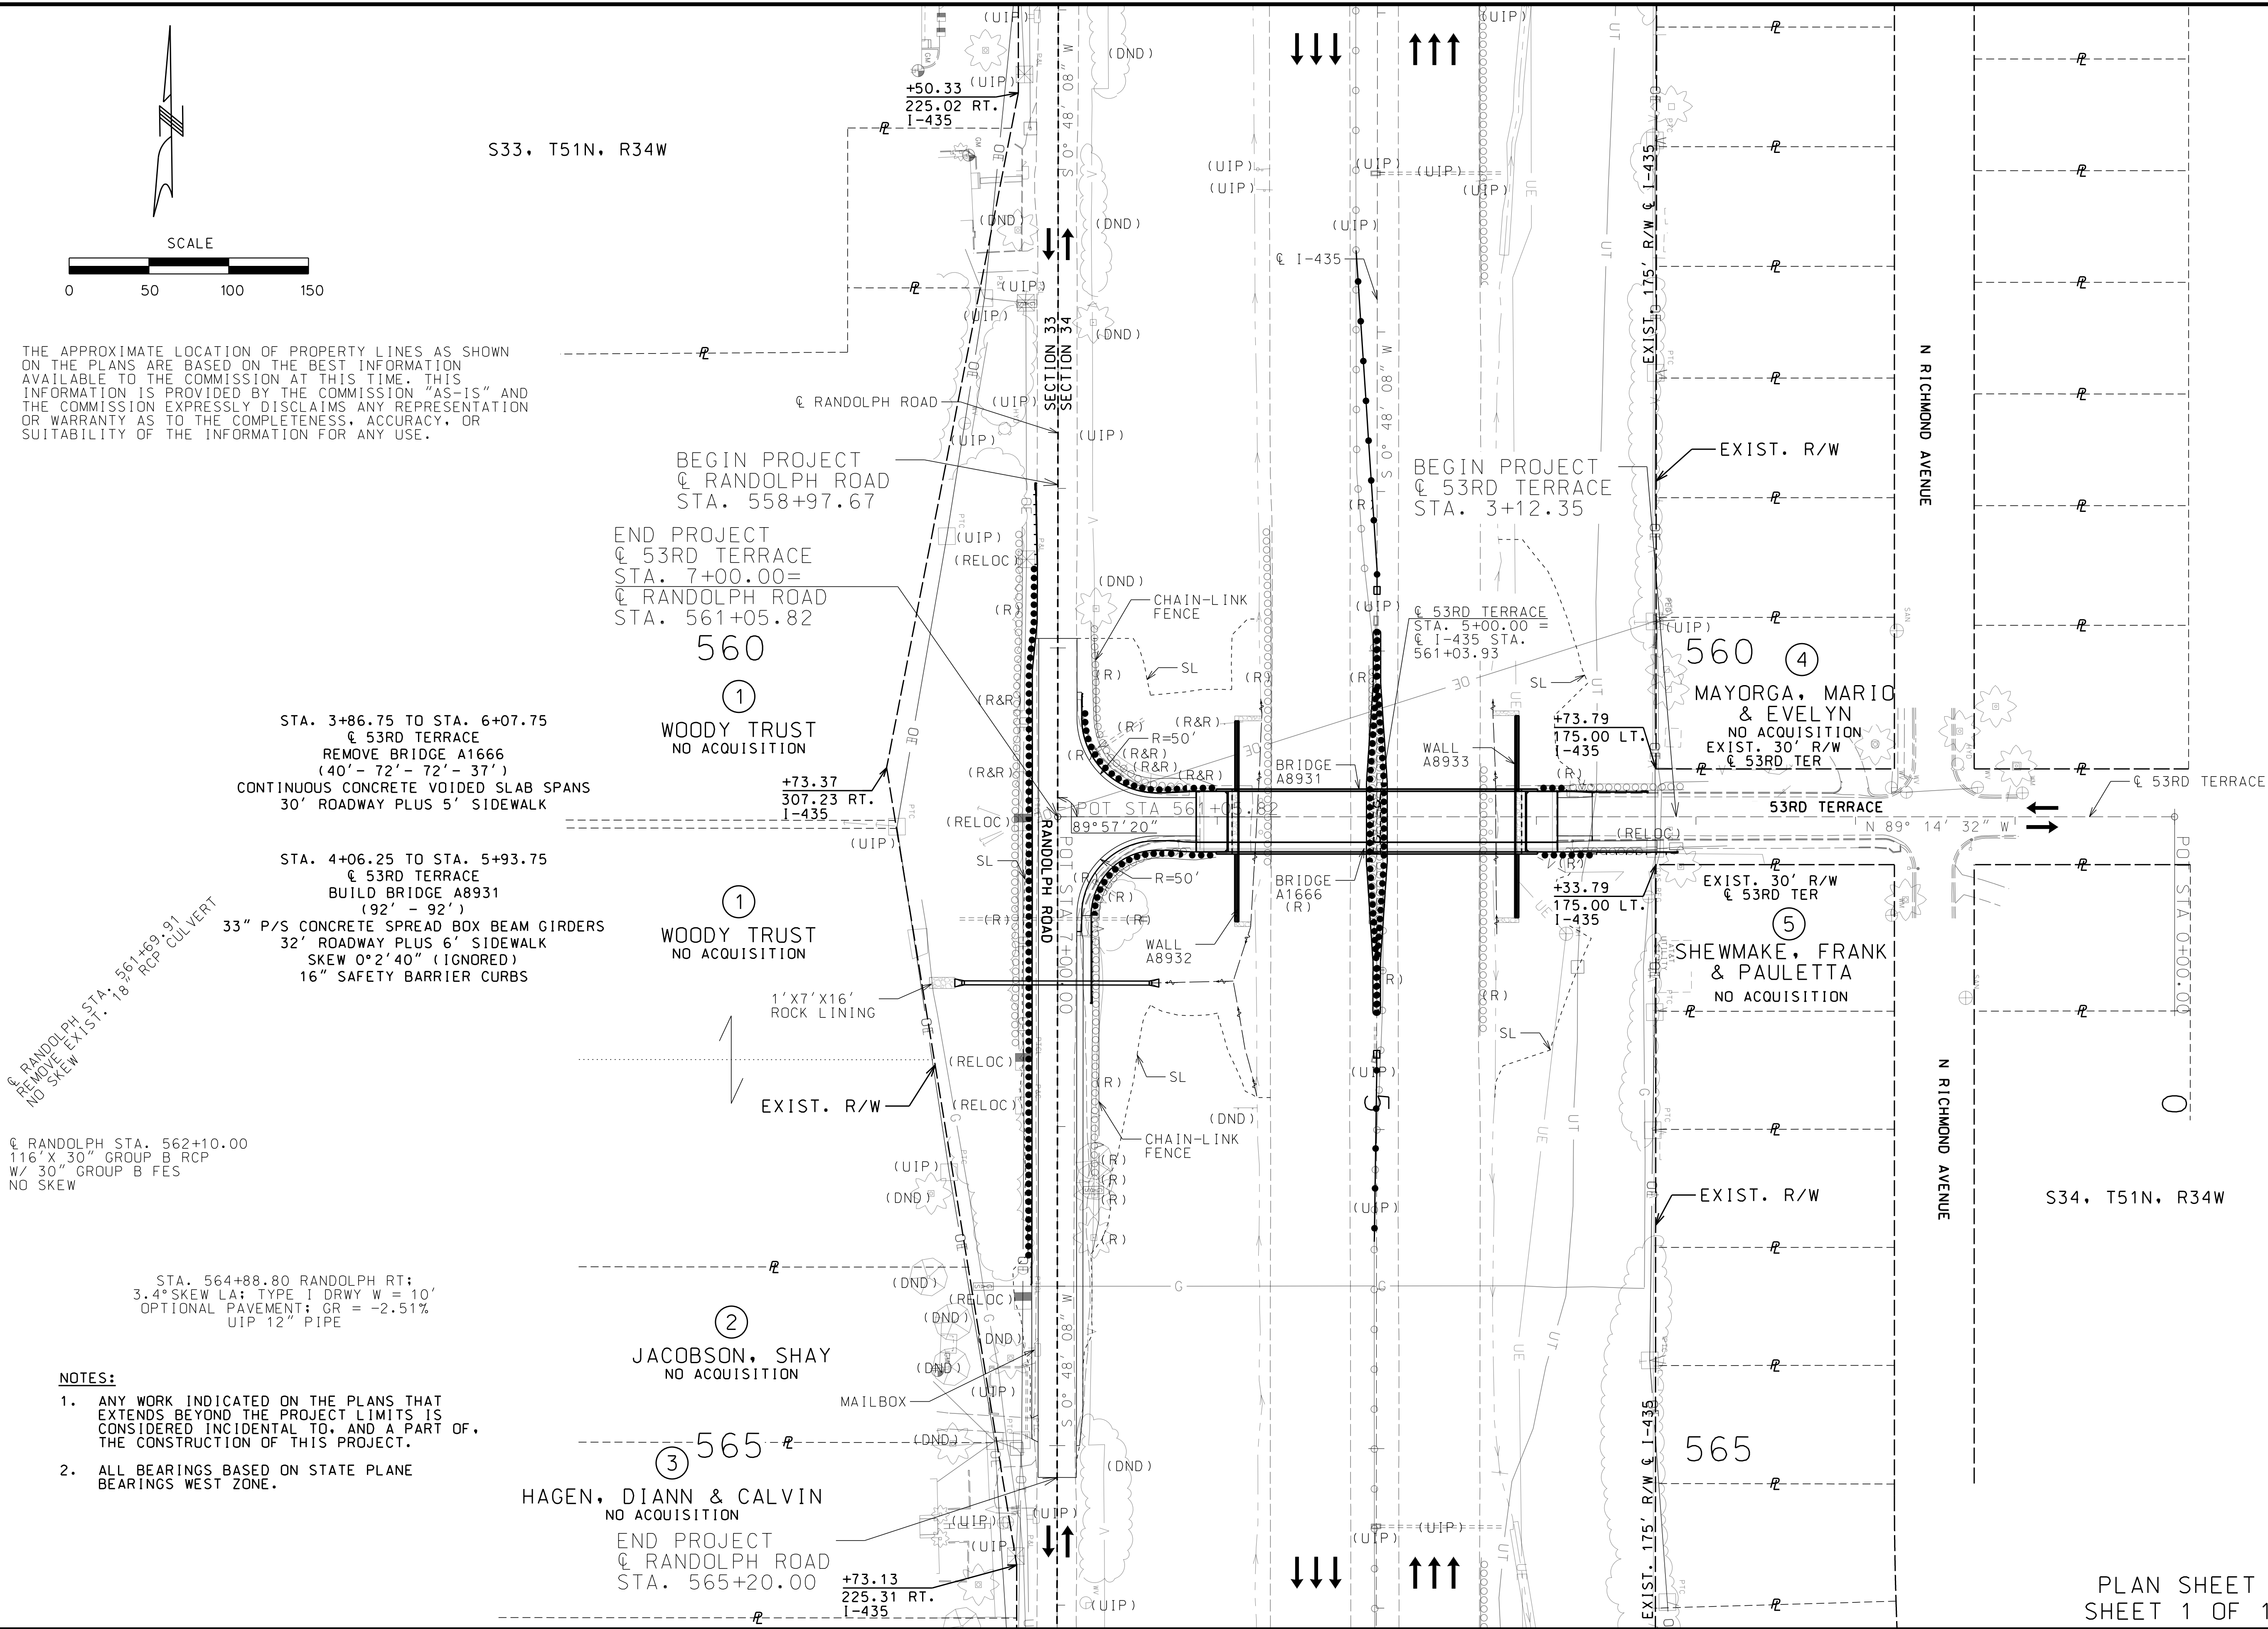

NOTES:

1. ANY WORK INDICATED ON THE PLANS THAT EXTENDS BEYOND THE PROJECT LIMITS IS CONSIDERED INCIDENTAL TO, AND A PART OF, THE CONSTRUCTION OF THIS PROJECT.
2. ALL BEARINGS BASED ON STATE PLANE BEARINGS WEST ZONE.

"THIS MEDIA SHOULD NOT BE CONSIDERED A CERTIFIED DOCUMENT."

DATE PREPARED

6/12/2020

ROUTE

53RD

STATE

MO

DISTRICT

KC

SHEET NO.

4

COUNTY

CLAY

JOB NO.

J453386

CONTRACT ID.

PROJECT NO.

BRIDGE NO.

A8931

DESCRIPTION

DATE

MISSOURI HIGHWAYS AND TRANSPORTATION COMMISSION

105 WEST CAPITAL

JEFFERSON CITY, MO 65102

1-888-ASK-MODOT (1-888-275-6636)

ModOT

GARVER, LLC.

7410 NW TIFFANY SPRINGS


PARKWAY, SUITE 200

KANSAS CITY, MO 64153

PHONE: (816) 298-6465

CERTIFICATE OF AUTHORITY

NO. 2008013090

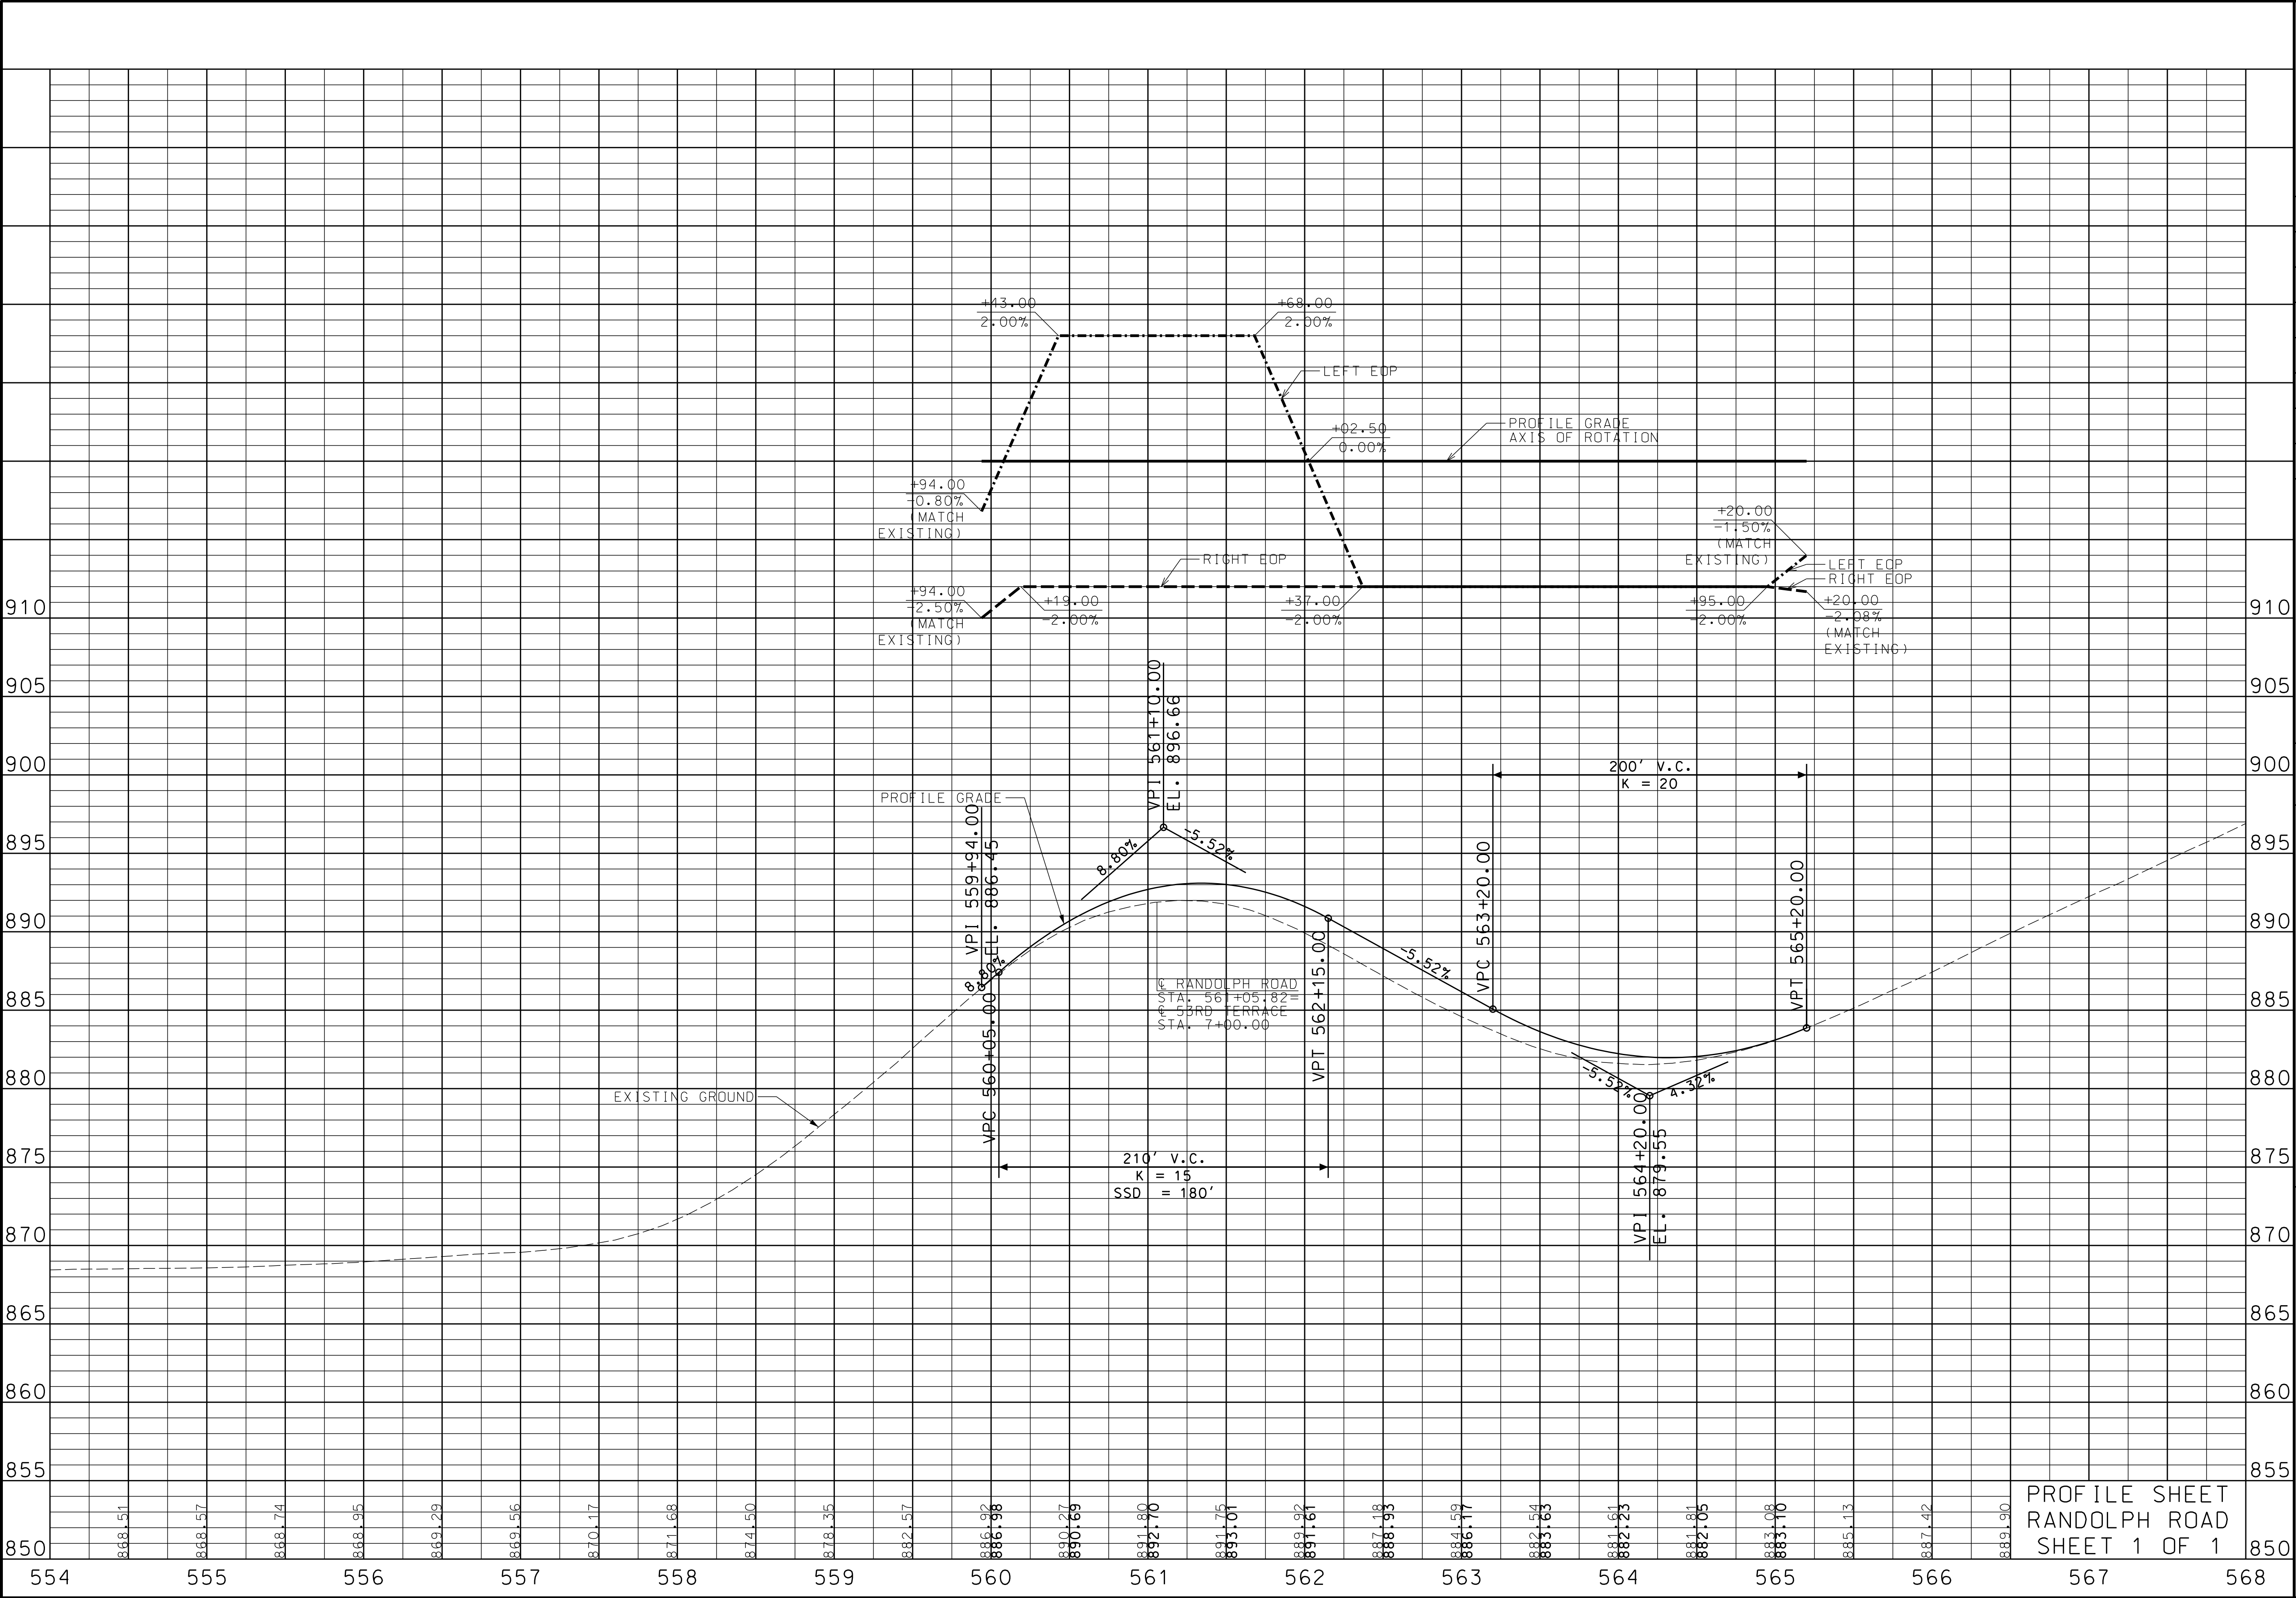

THIS MEDIA SHOULD NOT BE CONSIDERED A CERTIFIED DOCUMENT.

DATE PREPARED
6/12/2020

ROUTE 53RD	STATE MO
DISTRICT KC	SHEET NO. 6

COUNTY
CLAY

JOB NO.
J4S3386

CONTRACT ID.

PROJECT NO.

BRIDGE NO.
A8931

DESCRIPTION	DATE


MISSOURI HIGHWAYS AND TRANSPORTATION COMMISSION

MoDOT

105 WEST CAPITAL
JEFFERSON CITY, MO 65102
1-888-ASK-MODOT (1-888-275-6636)

GARVER, LLC.
7410 NW TIFFANY SPRINGS
PARKWAY, SUITE 200
KANSAS CITY, MO 64153
PHONE: (816) 298-6465
CERTIFICATE OF AUTHORITY
NO. 2008013090

PROFILE SHEET
RANDOLPH ROAD
SHEET 1 OF 1

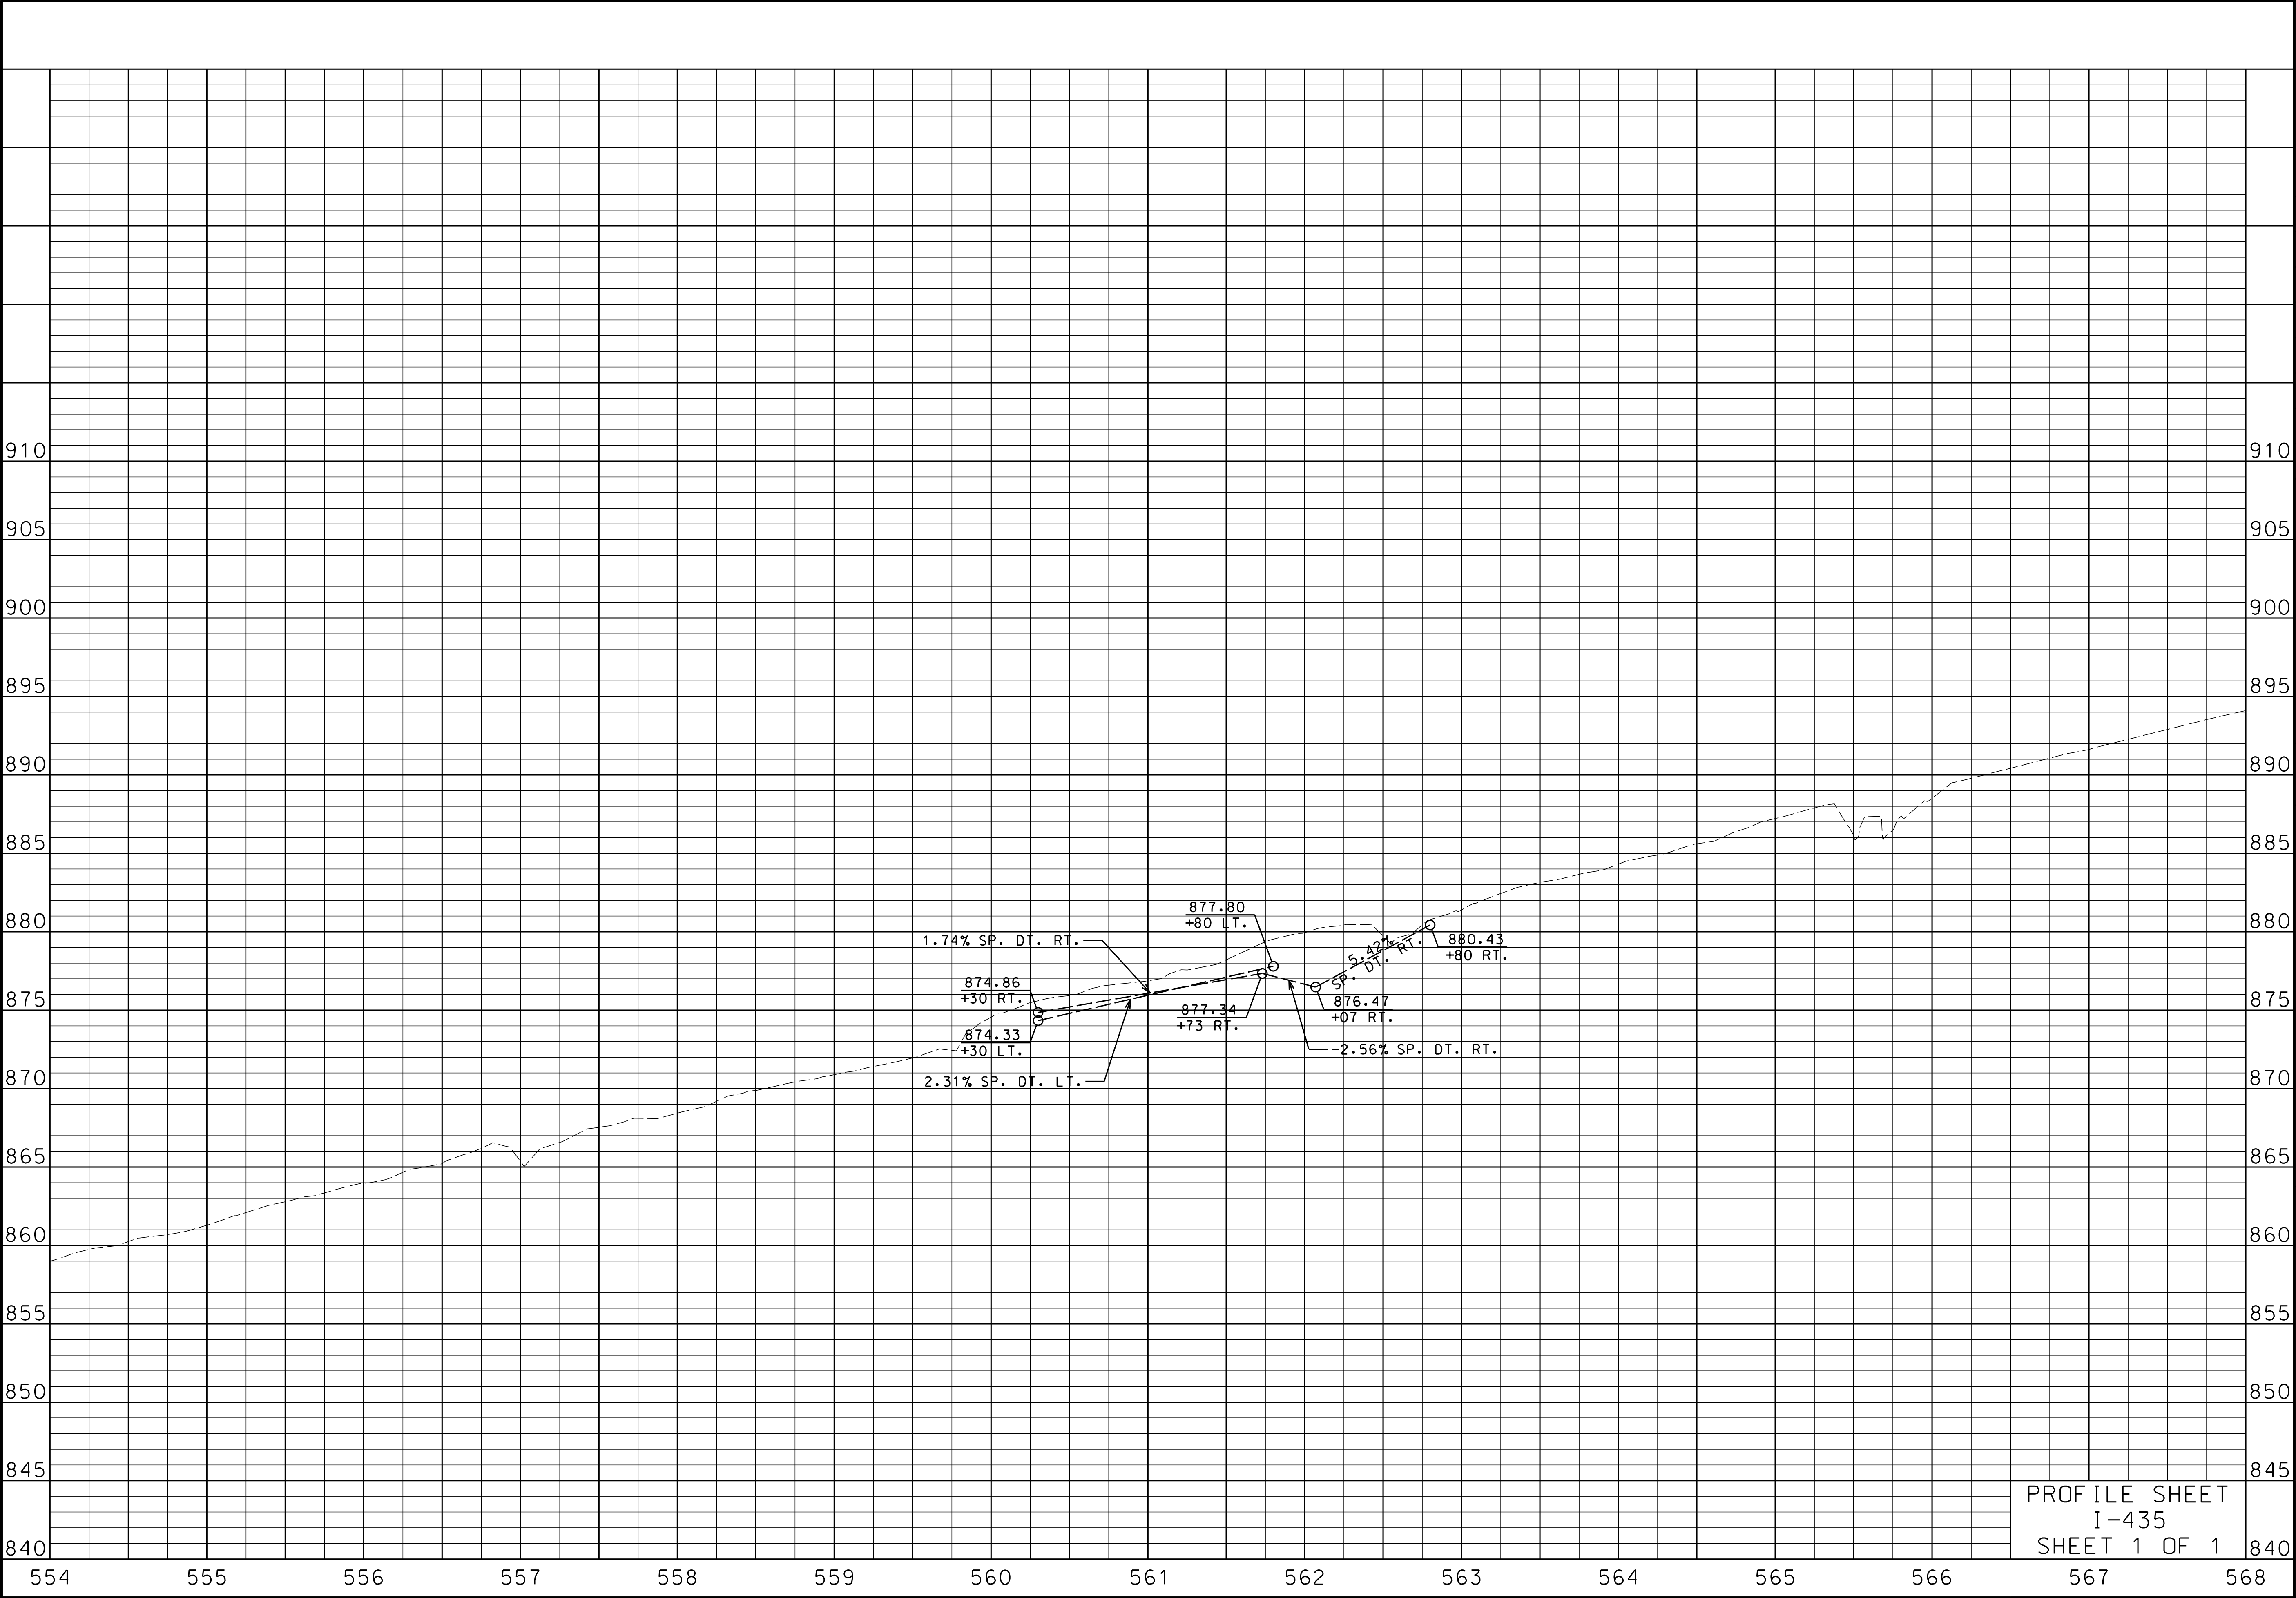

"THIS MEDIA SHOULD NOT BE CONSIDERED A CERTIFIED DOCUMENT."

DATE PREPARED
6/12/2020

ROUTE 53RD	STATE MO
DISTRICT KC	SHEET NO. 7

COUNTY
CLAY

JOB NO.
J4S3386

CONTRACT ID.

PROJECT NO.

BRIDGE NO.
A8931


DESCRIPTION	DATE

MISSOURI HIGHWAYS AND TRANSPORTATION COMMISSION

GARVER, LLC.
7410 NW TIFFANY SPRINGS
PARKWAY, SUITE 200
KANSAS CITY, MO 64153
PHONE: (816) 298-6465
CERTIFICATE OF AUTHORITY
NO. 2008013090

105 WEST CAPITAL
JEFFERSON CITY, MO 65102
1-888-ASK-MODOT (1-888-275-6636)

PROFILE SHEET
I-435
SHEET 1 OF 1

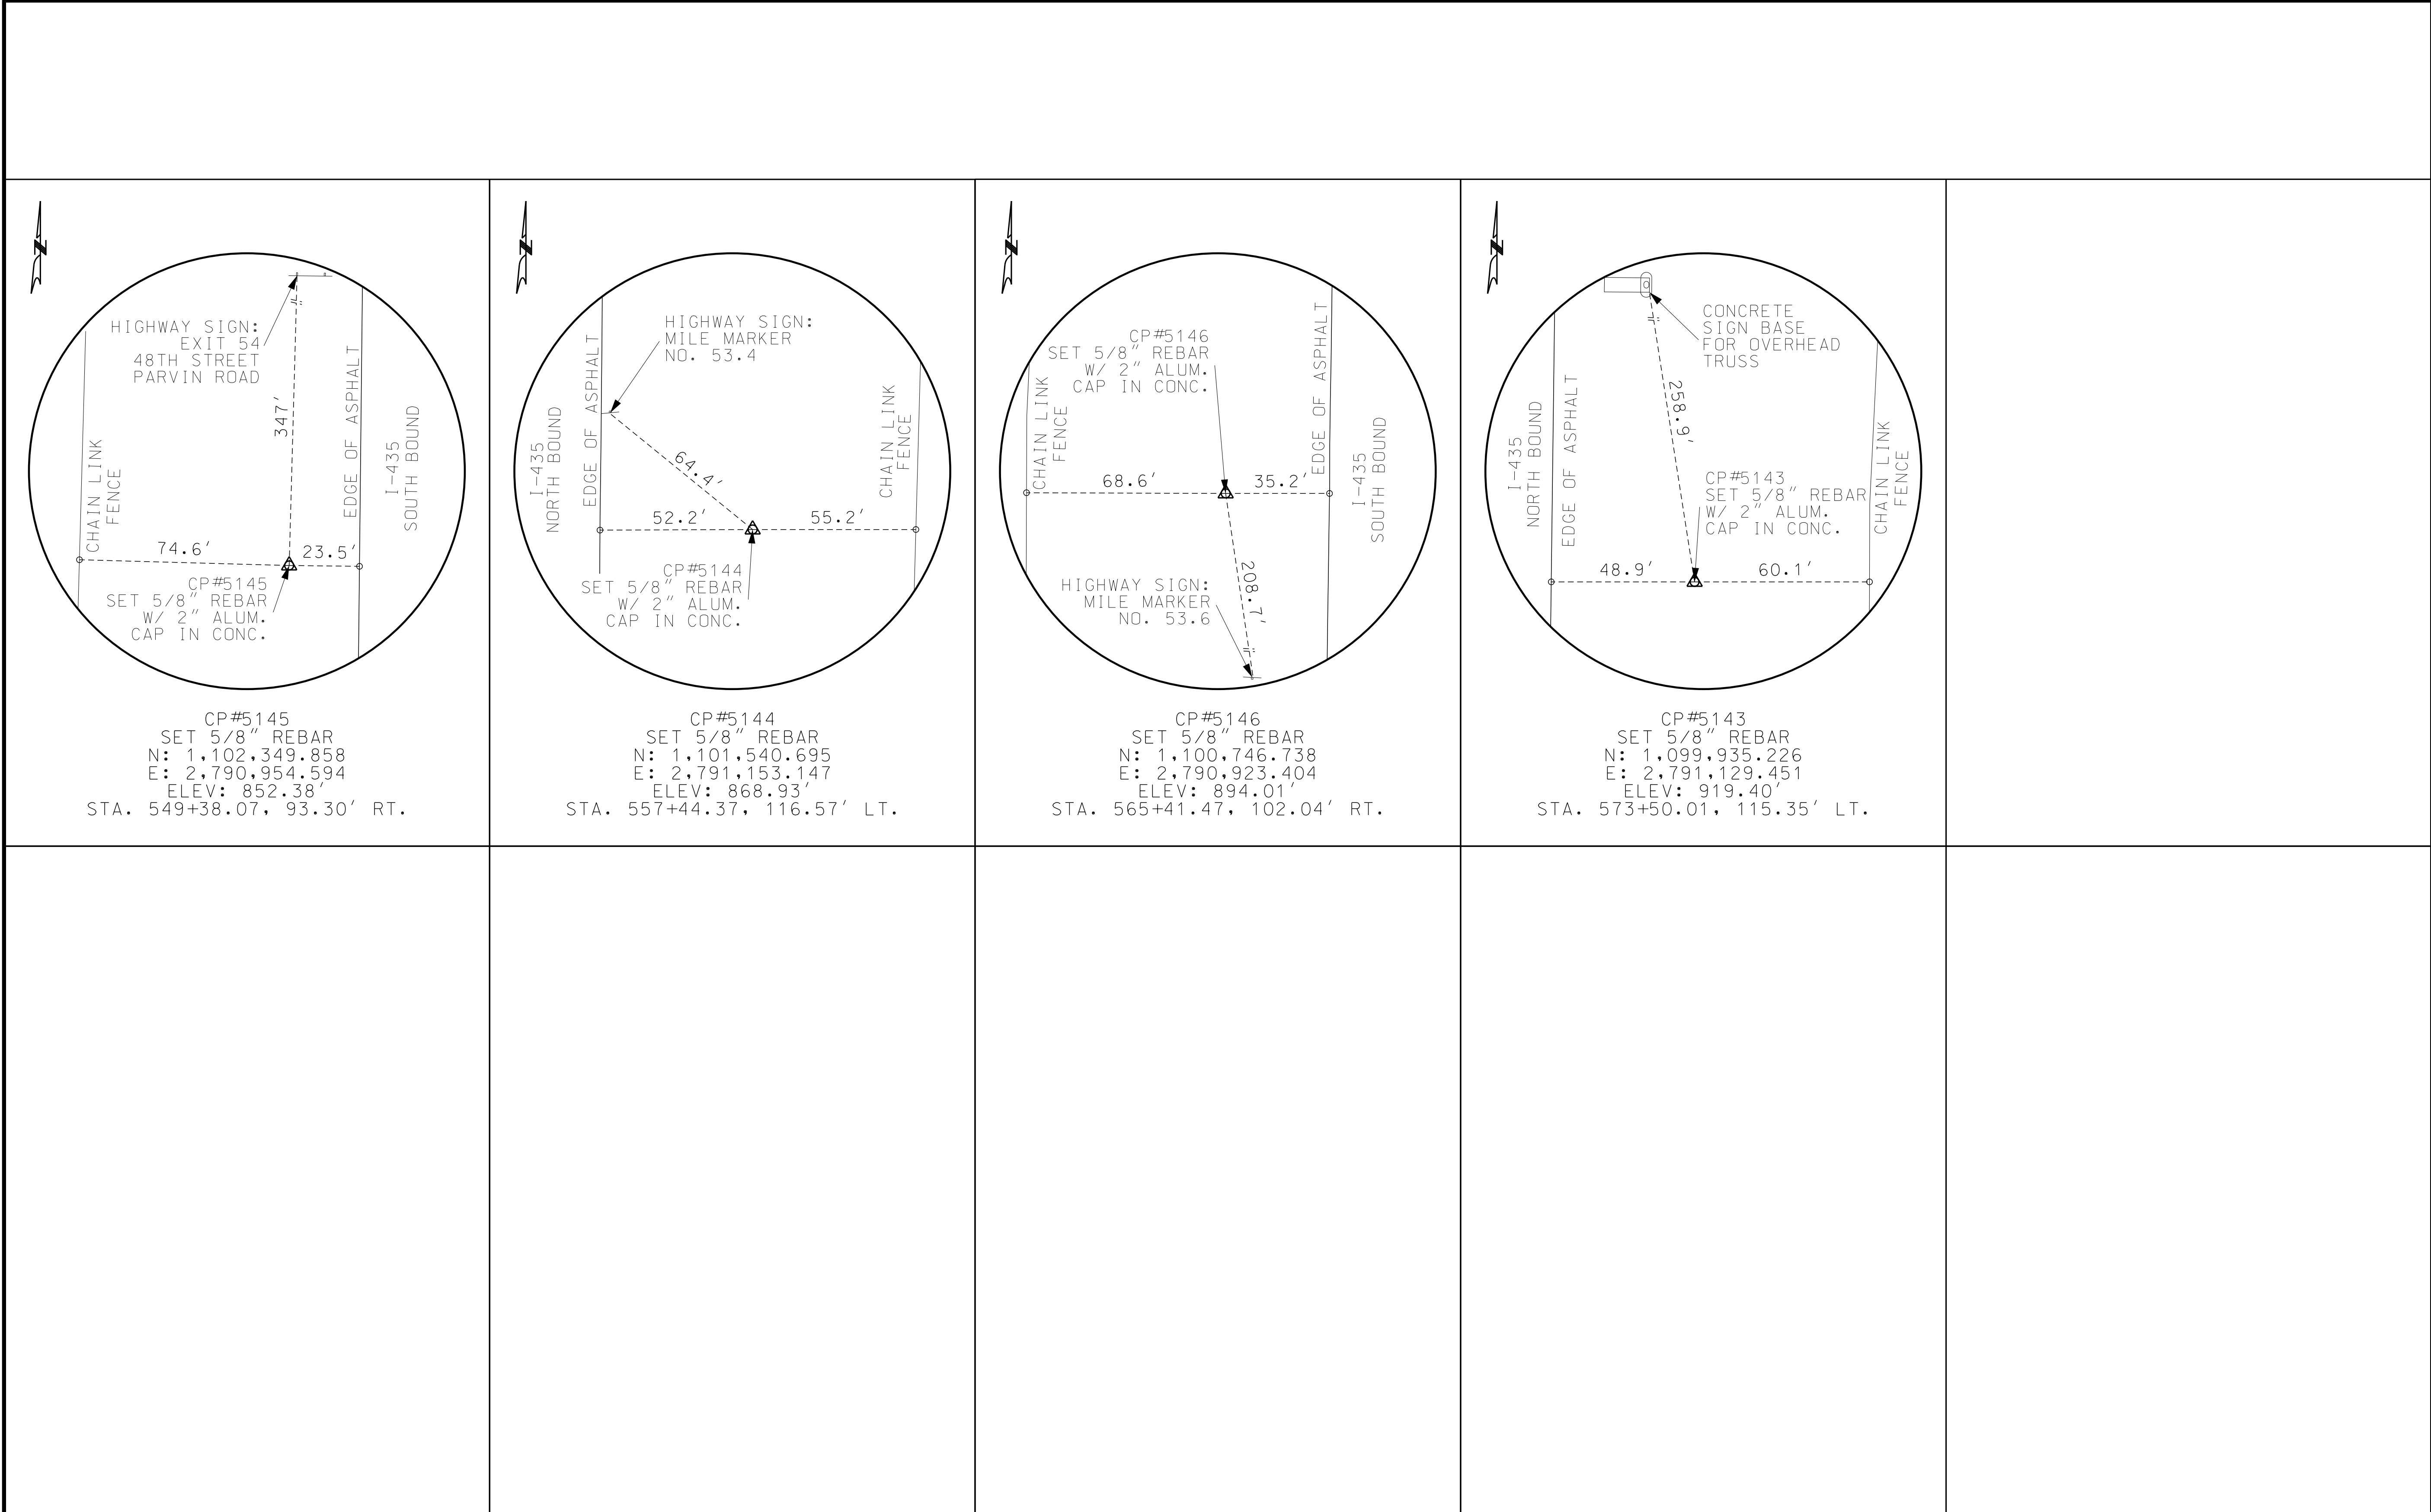

COORDINATES LISTED ARE MODIFIED STATE PLANE COORDINATES

REFERENCE POINTS
SHEET 1 OF 1

"THIS MEDIA SHOULD NOT BE CONSIDERED A CERTIFIED DOCUMENT."

DATE PREPARED
6/12/2020

ROUTE 53RD	STATE MO
DISTRICT KC	SHEET NO. 8
COUNTY CLAY	
JOB NO. J4S3386	
CONTRACT ID.	
PROJECT NO.	
BRIDGE NO. A8931	

DATE	DESCRIPTION

MISSOURI HIGHWAYS AND TRANSPORTATION COMMISSION



105 WEST CAPITOL
JEFFERSON CITY, MO 65102
1-888-ASK-MODOT (1-888-275-6636)

GARVER, LLC.
7410 NW TIFFANY SPRINGS
PARKWAY, SUITE 200
KANSAS CITY, MO 64153
PHONE: (816) 298-6465
CERTIFICATE OF AUTHORITY
NO. 2008013090

COORDINATE POINT LISTING
MISSOURI COORDINATE SYSTEM OF 1983 (2011 ZONE WEST)

RECIPROCAL OF AVERAGE GRID FACTOR : 1.0000995

		MODIFIED STATE PLANE COORDINATES		STATE PLANE COORDINATES		DESCRIPTION
STATION	OFFSET	NORTHING (US FEET)	EASTING (US FEET)	NORTHING (US FEET)	EASTING (US FEET)	
53RD TERRACE						
0+00.00	—	1,101,176.1928	2,791,531.5147	1,101,066.6258	2,791,253.7573	POT
7+00.00	—	1,101,185.4522	2,790,831.5759	1,101,075.8842	2,790,553.8882	POT
RANDOLPH ROAD						
552+20.31	—	1,102,070.8754	2,790,843.9755	1,101,961.2193	2,790,566.2865	POT
561+05.82	—	1,101,185.4522	2,790,831.5759	1,101,075.8842	2,790,553.8882	POT
571+29.38	—	1,100,161.9880	2,790,817.2431	1,100,052.5219	2,790,539.5568	POT
1-435						
517+48.33	—	1,105,537.9770	2,791,092.5491	1,105,427.9760	2,790,814.8354	POT
586+00.00	—	1,098,686.9788	2,790,996.6063	1,098,577.6594	2,790,718.9021	POT

NOTE: THE RECIPROCAL OF THE AVERAGE GRID FACTOR IS USED AS A
MULTIPLIER FROM STATE PLANE DISTANCE TO GROUND DISTANCE

THIS MEDIA SHOULD NOT BE CONSIDERED A CERTIFIED DOCUMENT.

DATE PREPARED
6/12/2020

ROUTE
53RD

DISTRICT
KC

STATE
MO

SHEET NO.
9

COUNTY
CLAY

JOB NO.
J4S3386

CONTRACT ID.

PROJECT NO.

BRIDGE NO.
A8931

DESCRIPTION

DATE


MISSOURI HIGHWAYS AND TRANSPORTATION COMMISSION

MoDOT

105 WEST CAPITOL
JEFFERSON CITY, MO 65102
1-888-ASK-MODOT (1-888-275-6636)

GARVER, LLC.
7410 NW TIFFANY SPRINGS
PARKWAY, SUITE 200
KANSAS CITY, MO 64153
PHONE: (816) 298-6465
CERTIFICATE OF AUTHORITY
NO. 2008013090

L:\2019\19T04060 - MoDOT KC 53rd Terrace Bridge Replacement\Drawings\009_CP_01_J4S3386_i1_53rd.dgn 12:38:18 AM 6/12/2020

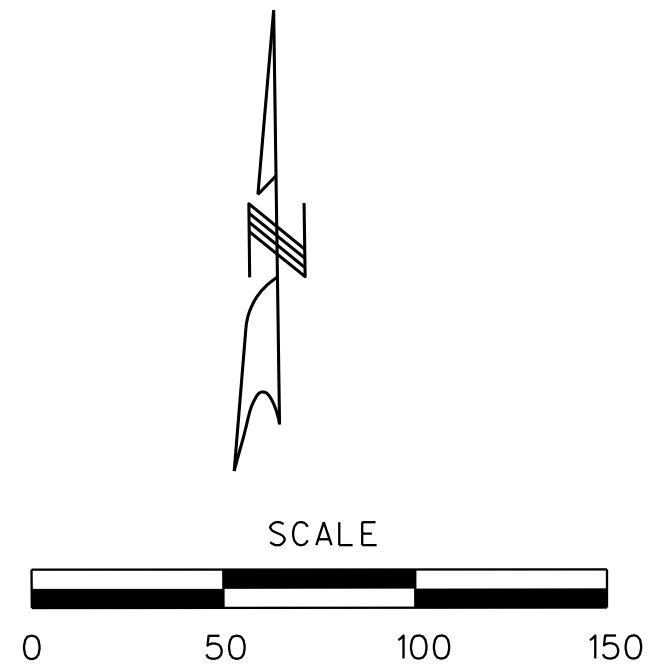


- ① $\text{CL RANDOLPH STA. } 560+30.47, \text{ LT. TO CL } 53\text{RD TERRACE STA. } 6+00.15, \text{ RT.}$
INSTALL BRIDGE ANCHOR SECTION, TRANSITION SECTION, 100' TYPE A GUARDRAIL, AND END ANCHOR
- ② $\text{CL } 53\text{RD TERRACE STA. } 6+00.15, \text{ LT. TO CL RANDOLPH STA. } 562+22.85, \text{ LT.}$
INSTALL BRIDGE ANCHOR SECTION, TRANSITION SECTION, 87.5' TYPE A GUARDRAIL, AND TYPE A CRASHWORTHY END TERMINAL
- ③ $\text{CL RANDOLPH STA. } 558+97.67 \text{ TO STA. } 563+94.37, \text{ RT.}$
INSTALL MGS END ANCHOR, 437.5' MGS GUARDRAIL W/ 8' POSTS, AND TYPE A CRASHWORTHY END TERMINAL (MASH)
- ④ $\text{CL } 53\text{RD TERRACE STA. } 3+31.11 \text{ TO STA. } 3+99.85, \text{ RT.}$
INSTALL BRIDGE ANCHOR SECTION, TRANSITION SECTION, AND TYPE A CRASHWORTHY END TERMINAL
- ⑤ $\text{CL } 53\text{RD TERRACE STA. } 3+12.35 \text{ TO STA. } 3+99.85, \text{ LT.}$
INSTALL MGS BRIDGE APPROACH TRANSITION SECTION AND TYPE A CRASHWORTHY END TERMINAL (MASH)
- ⑥ $\text{CL } 1-435 \text{ STA. } 560+20.06 \text{ TO STA. } 561+94.78$
INSTALL 350' MGS GUARDRAIL FOR MEDIAN PIER PROTECTION AND 2 TYPE B CRASHWORTHY END TERMINALS
- ⑦ $\text{CL } 1-435 \text{ STA. } 557+49.01 \text{ TO STA. } 559+64.47$
INSTALL ANCHOR ASSEMBLY, GUARD CABLE 3-STRAND AND 192' MEDIAN GUARD CABLE 3-STRAND
- ⑧ $\text{CL } 1-435 \text{ STA. } 562+50.39 \text{ TO STA. } 563+70.38$
INSTALL ANCHOR ASSEMBLY, GUARD CABLE 3-STRAND AND 96' MEDIAN GUARD CABLE 3-STRAND

560


565

CL RANDOLPH ROAD

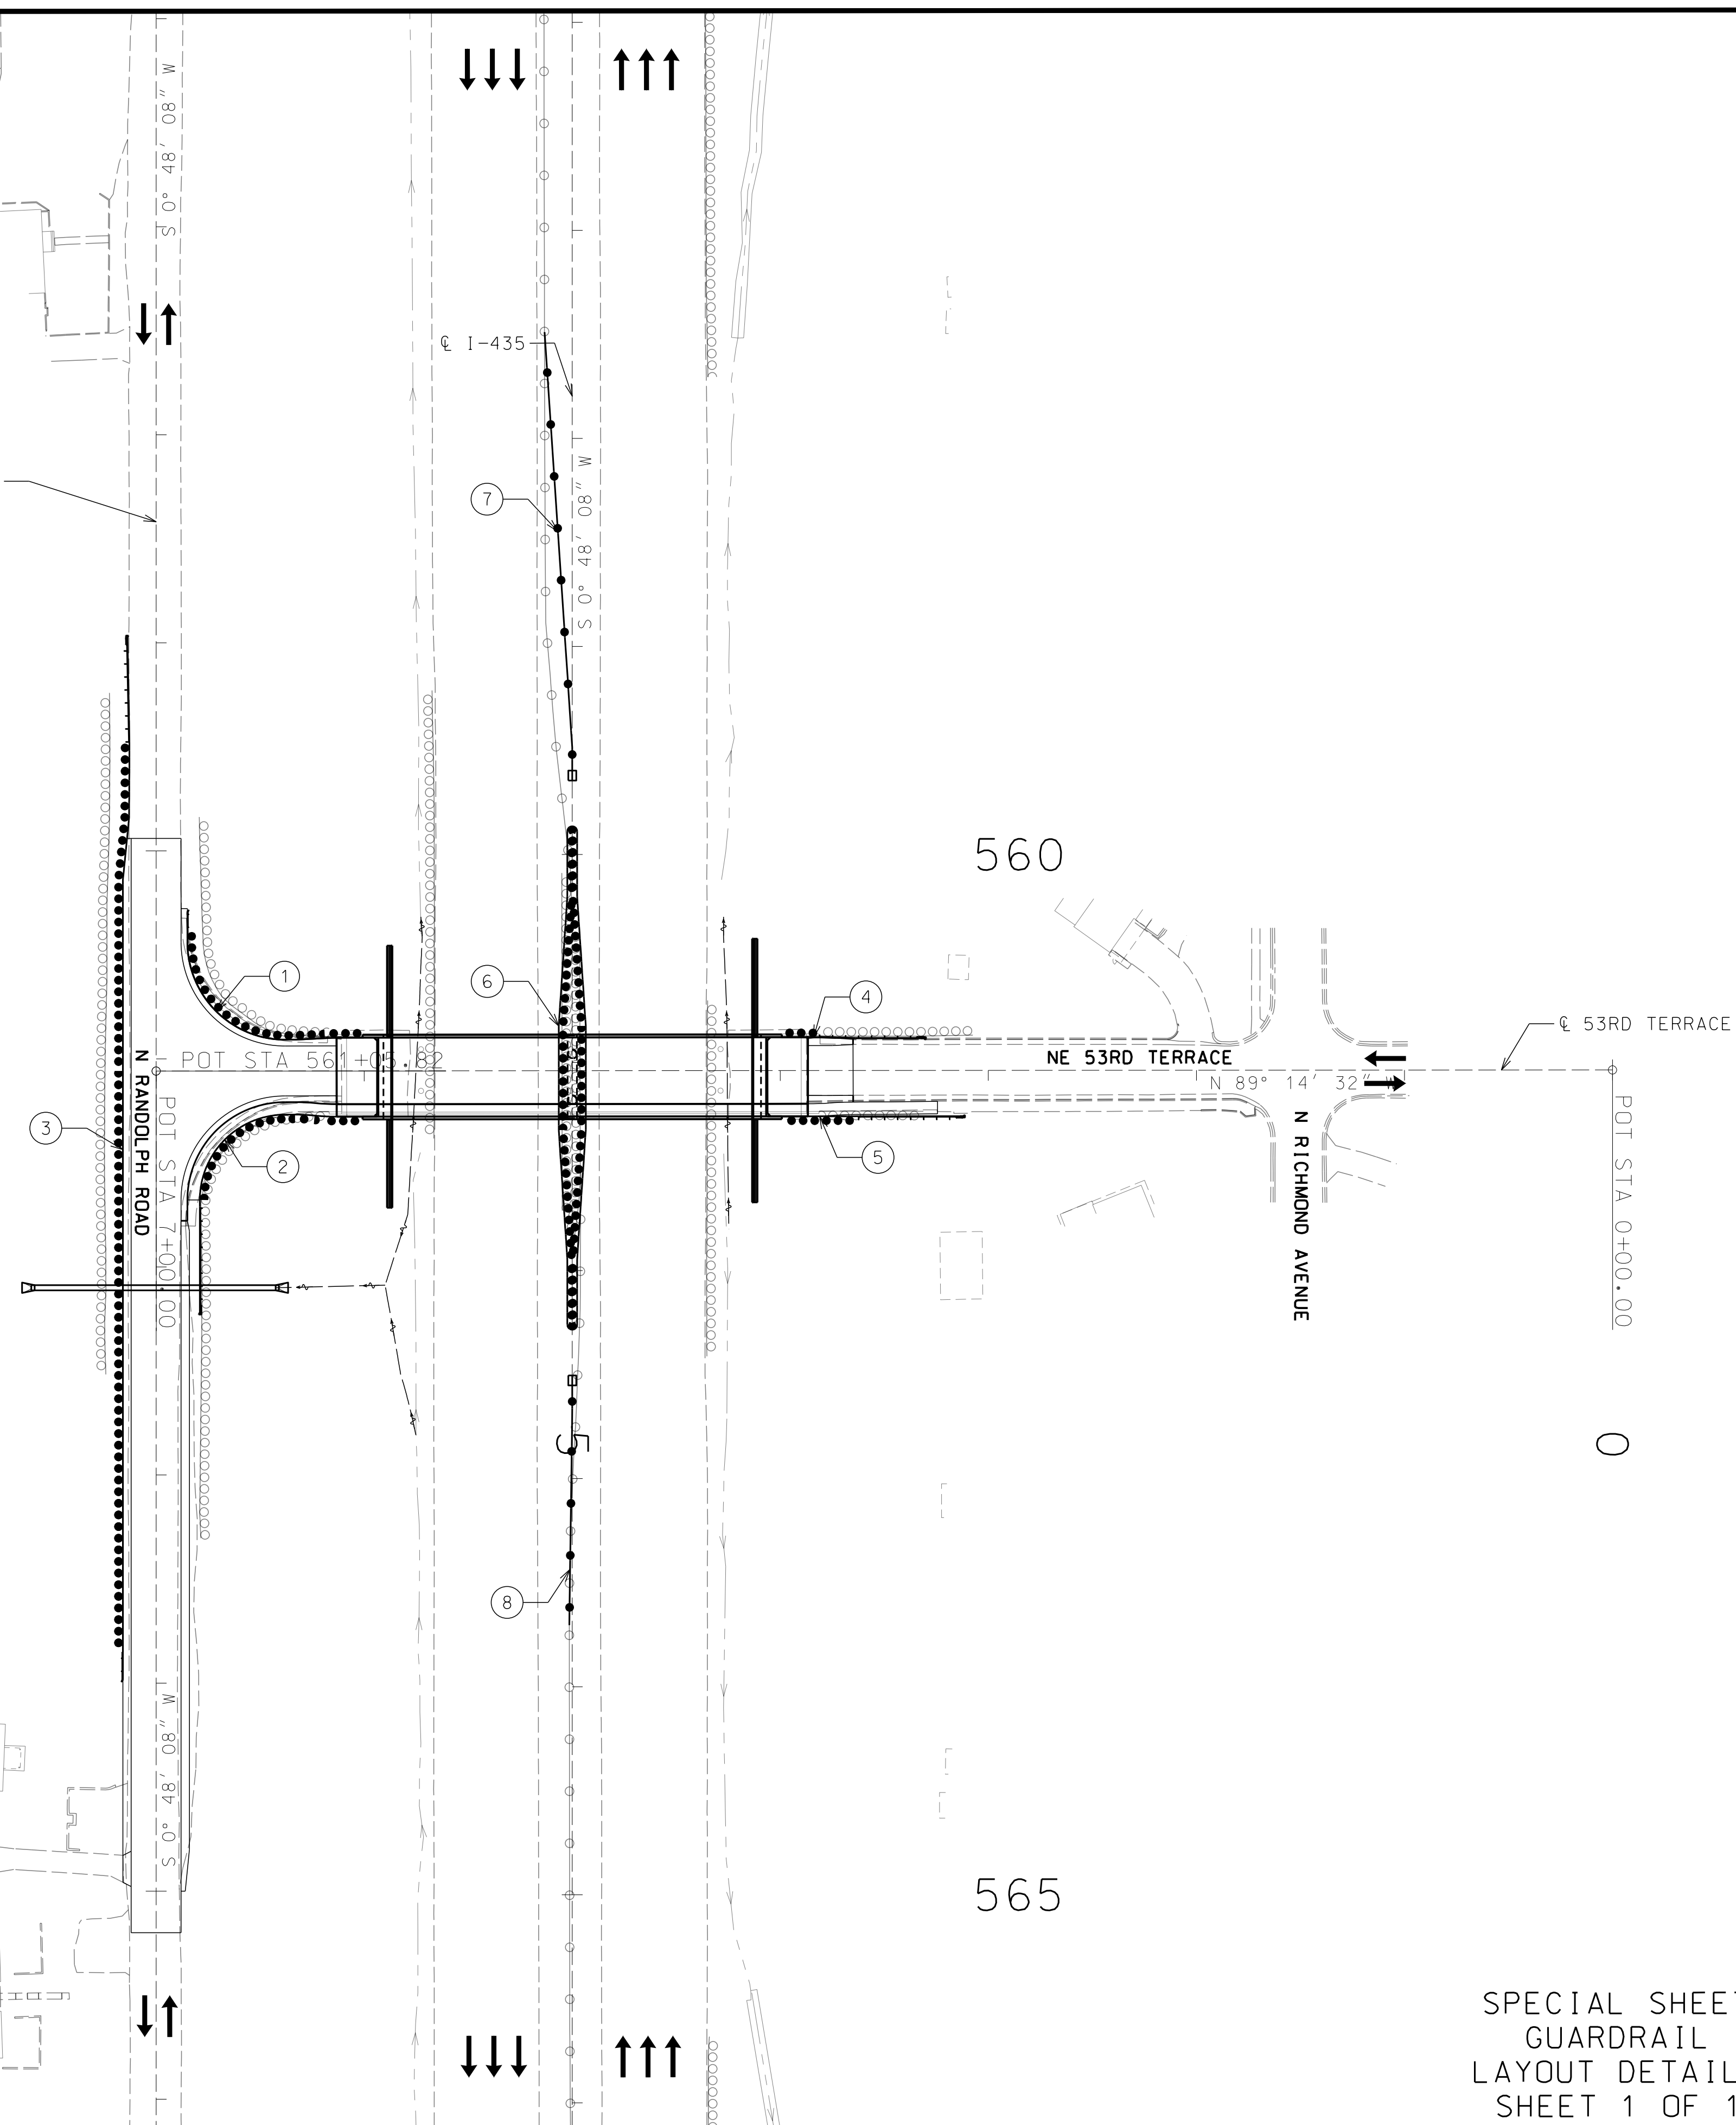

SPECIAL SHEET
GUARDRAIL
LAYOUT DETAILS
SHEET 1 OF 1

GARVER, LLC.
7410 NW TIFFANY SPRINGS
PARKWAY, SUITE 200
KANSAS CITY, MO 64153
PHONE: (816) 298-6465
CERTIFICATE OF AUTHORITY
NO. 2008013090

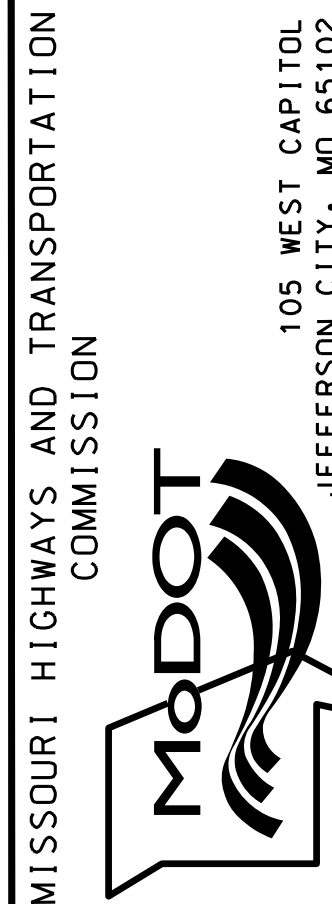

MISSOURI HIGHWAYS AND TRANSPORTATION
COMMISSION

DATE	DESCRIPTION

BRIDGE NO.
A8931

PROJECT NO.

CONTRACT ID.

J4S3386

CLAY

DISTRICT
KC

STATE
MO

ROUTE
53RD

DATE PREPARED
6/12/2020

"THIS MEDIA SHOULD
NOT BE CONSIDERED
A CERTIFIED
DOCUMENT."

PHASE 1 CONSTRUCTION

REMOVE 53RD TERRACE BRIDGE OVER I-435
SHOULDER STRENGTHENING ON I-435 NB/SB OUTSIDE SHOULDERS

PHASE 1 TRAFFIC CONTROL

CLOSE 53RD TERRACE. DETOUR VIA RANDOLPH ROAD, 48TH STREET, MANCHESTER AVENUE, 51ST STREET, AND RICHMOND AVENUE
WEEKEND CLOUSRE OF I-435 FOR BRIDGE REMOVAL. DETOUR I-435 VIA I-35 TO I-70. CLOSE I-435 BETWEEN I-35/US-69 AND 48TH STREET/PARVIN ROAD
UTILIZE SINGLE LANE CLOSURES WITH CHANNELIZERS DURING OFF-PEAK HOURS ON I-435 FOR SHOULDER STRENGTHENING

PHASE 2 CONSTRUCTION

CONSTRUCT 53RD TERRACE MEDIAN PIERS

PHASE 2 TRAFFIC CONTROL

SHIFT I-435 TO OUTSIDE SHOULDERS. MAINTAIN THREE LANES IN EACH DIRECTION
53RD TERRACE REMAINS CLOSED AND DETOURED

PHASE 3 CONSTRUCTION

CONSTRUCT 53RD TERRACE BRIDGE END BENTS

PHASE 3 TRAFFIC CONTROL

SHIFT I-435 TO INSIDE. MAINTAIN THREE LANES IN EACH DIRECTION
53RD TERRACE REMAINS CLOSED AND DETOURED

PHASE 4 CONSTRUCTION

PLACE 53RD TERRACE BRIDGE GIRDERS

PHASE 4 TRAFFIC CONTROL

WEEKEND CLOUSRE OF I-435 FOR BRIDGE REMOVAL. DETOUR I-435 VIA I-35 TO I-70. CLOSE I-435 BETWEEN I-35/US-69 AND 48TH STREET/PARVIN ROAD
53RD TERRACE REMAINS CLOSED AND DETOURED

PHASE 5 CONSTRUCTION

FINISH 53RD TERRACE BRIDGE CONSTRUCTION

PHASE 5 TRAFFIC CONTROL

I-435 TRAFFIC SHIFTED BACK TO EXISTING TRAFFIC PATTERN
53RD TERRACE REMAINS CLOSED AND DETOURED

THIS MEDIA SHOULD NOT BE CONSIDERED A CERTIFIED DOCUMENT.

DATE PREPARED
6/12/2020

ROUTE
53RD

STATE
MO

DISTRICT
KC

SHEET NO.
11

COUNTY
CLAY

JOB NO.
J4S3386

CONTRACT ID.

PROJECT NO.

BRIDGE NO.

DESCRIPTION

DATE

MISSOURI HIGHWAYS AND TRANSPORTATION COMMISSION

MoDOT

105 WEST CAPITOL
JEFFERSON CITY, MO 65102
1-888-ASK-MODOT (1-888-275-6636)


Consult
engineers
Inc
planners

Hg CONSULT, INC.
PRO. ENGINEER 2010005873

EARL HARRISON, JR.
PROFESSIONAL
ENGINEER
E-2003019813

TRAFFIC CONTROL PLAN
STAGE WRITEUP
SHEET 1 OF 3

G:\My Drive\Hg Projects\2019\19.072 53rd Terrace Bridge over I-435 (Garver)\Civil\Sheet_Files\J4S3386_TCon_SH1.dgn 2:30:50 PM 4/1/2020

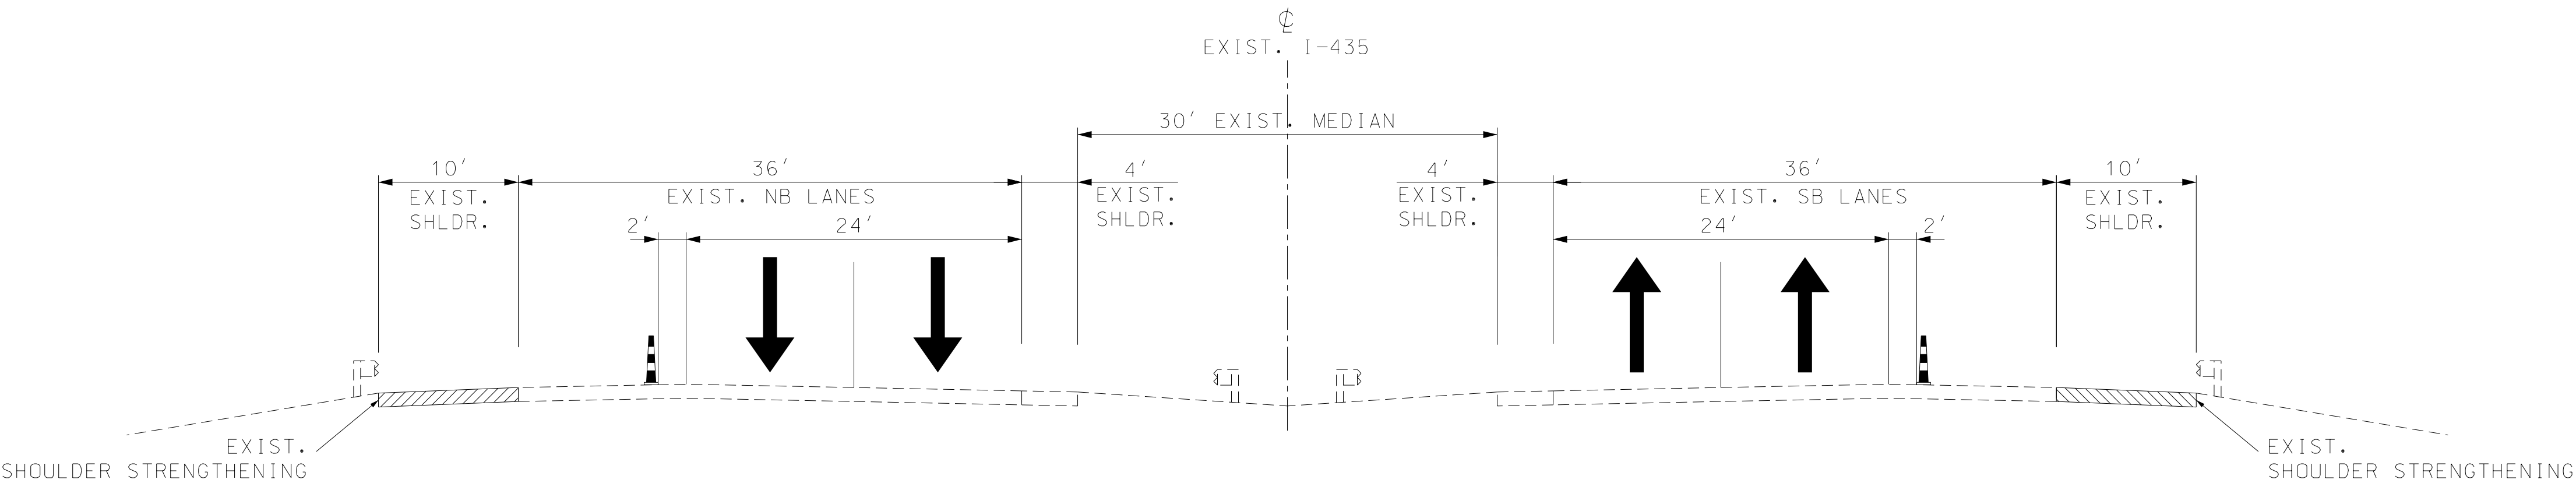


TRAFFIC CONTROL – PHASE 1
TYPICAL SECTION
SHEET 2 OF 3

"THIS MEDIA SHOULD NOT BE CONSIDERED A CERTIFIED DOCUMENT."	
DATE PREPARED 6/12/2020	
ROUTE 53RD	STATE MO
DISTRICT KC	SHEET NO. 12
COUNTY CLAY	
JOB NO. J4S3386	
CONTRACT ID.	
PROJECT NO.	
BRIDGE NO.	

DESCRIPTION	DATE



MISSOURI HIGHWAYS AND TRANSPORTATION COMMISSION

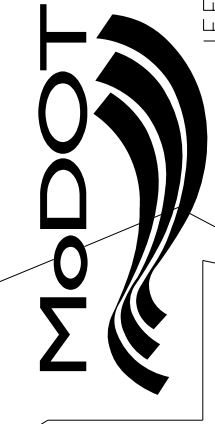

105 WEST CAPITOL
JEFFERSON CITY, MO 65102
1-888-ASK-MODOT (1-888-275-6636)



Hg CONSULT, INC.
PRO. ENGINEER 2010005873
EARL HARRISON, JR.
PROFESSIONAL ENGINEER
E-2003019813

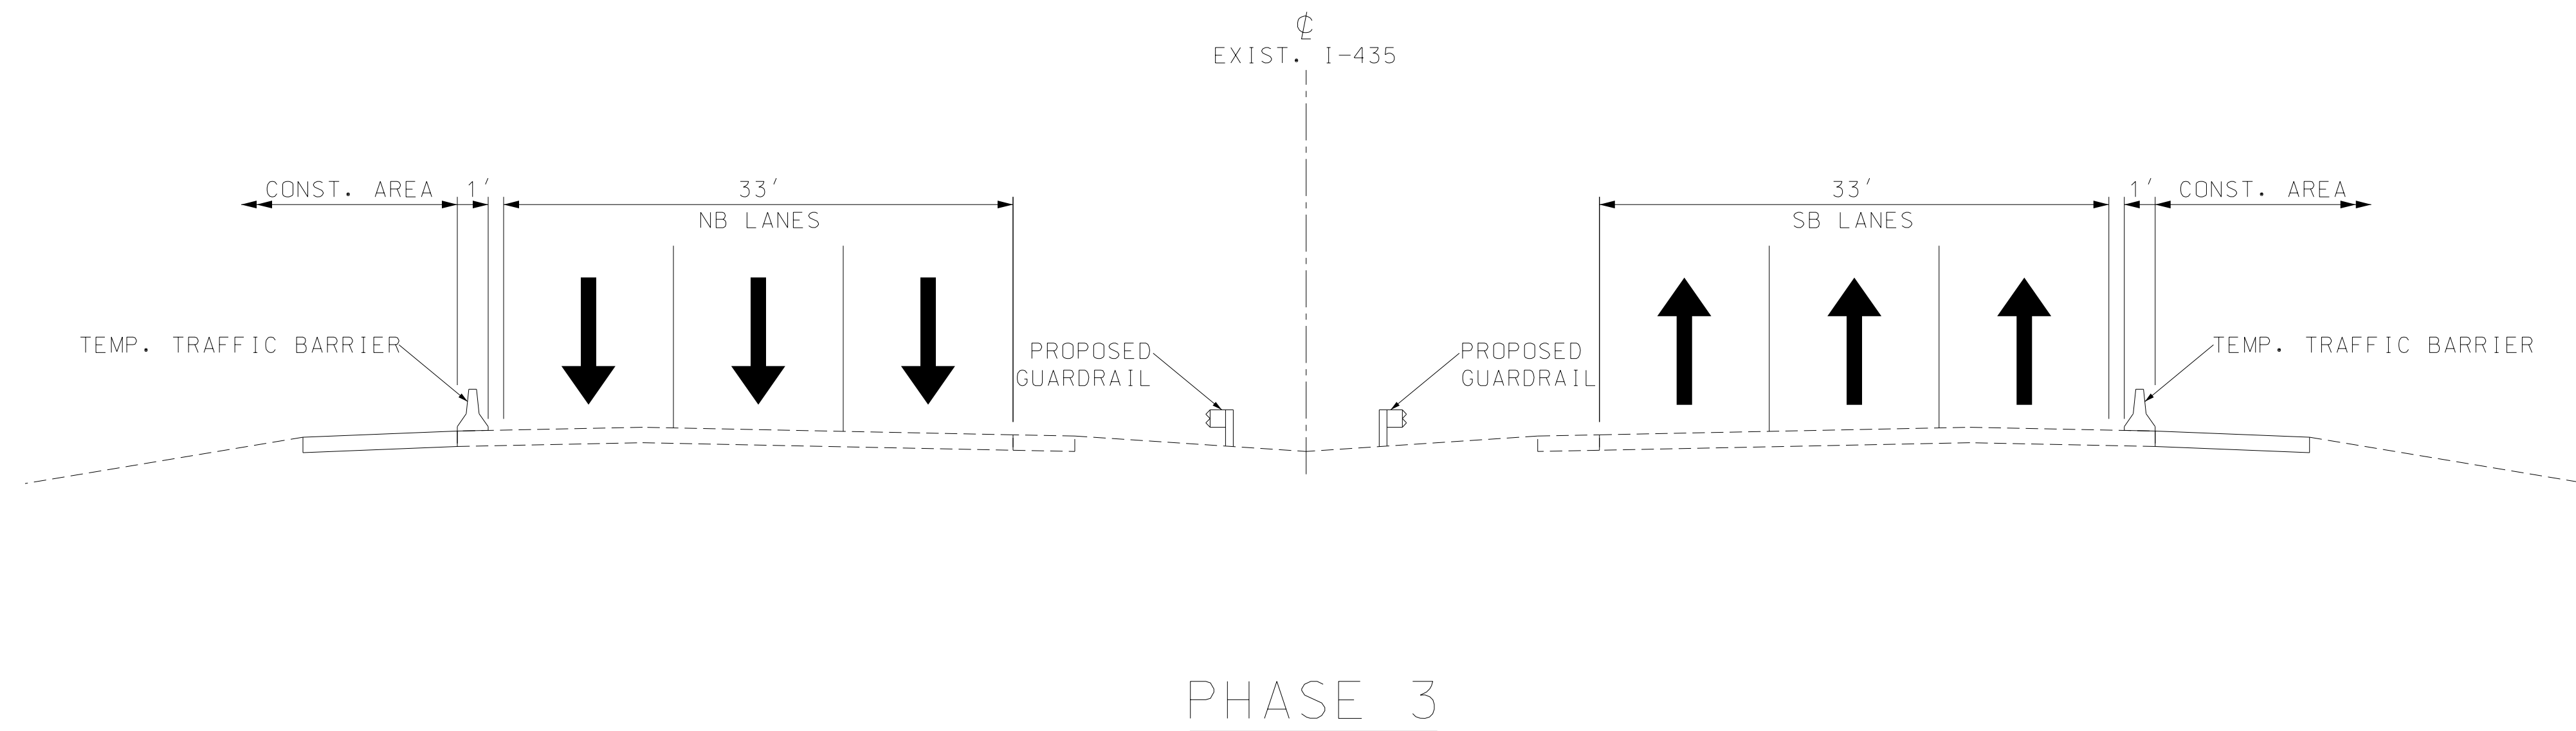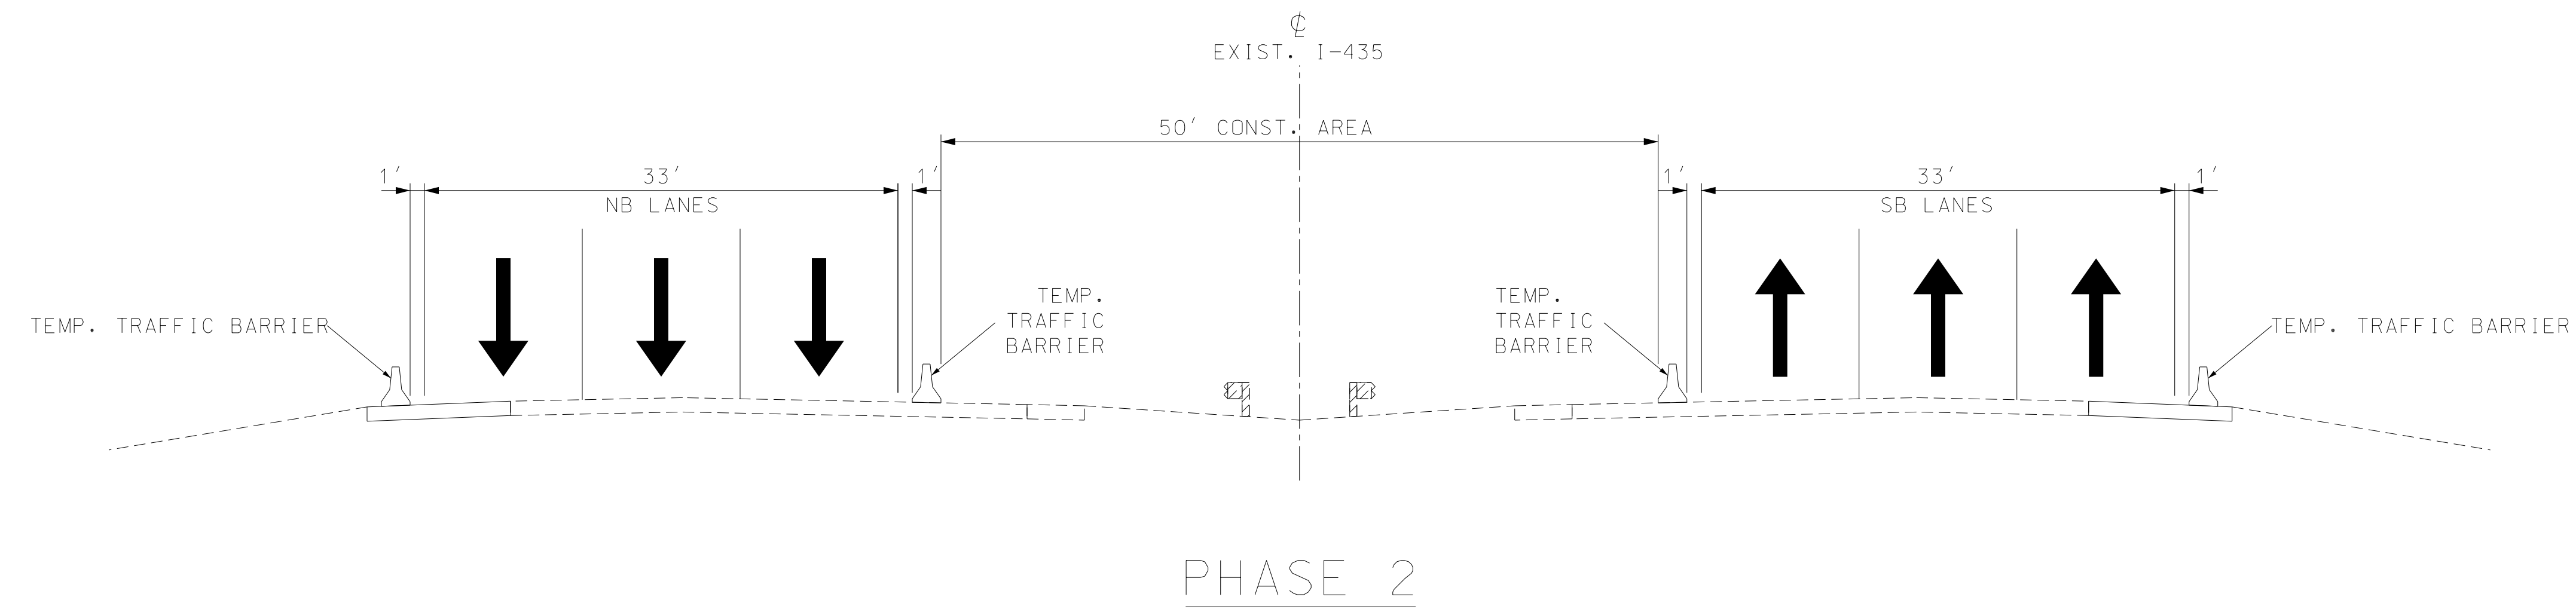

TRAFFIC CONTROL – PHASE 2 AND 3
TYPICAL SECTION
SHEET 3 OF 3

"THIS MEDIA SHOULD NOT BE CONSIDERED A CERTIFIED DOCUMENT."

DATE PREPARED
6/12/2020

ROUTE 53RD	STATE MO
DISTRICT KC	SHEET NO. 13

COUNTY
CLAY

JOB NO.
J4S3386

CONTRACT ID.

PROJECT NO.

BRIDGE NO.

DESCRIPTION	DATE

MISSOURI HIGHWAYS AND TRANSPORTATION COMMISSION

MoDOT


105 WEST CAPITOL
JEFFERSON CITY, MO 65102
1-888-ASK-MODOT (1-888-275-6636)

Consult
engineers
Inc
planners

Hg

Hg CONSULT, INC.
PRO. ENGINEER 2010005873

EARL HARRISON, JR.
PROFESSIONAL
ENGINEER
E-2003019813

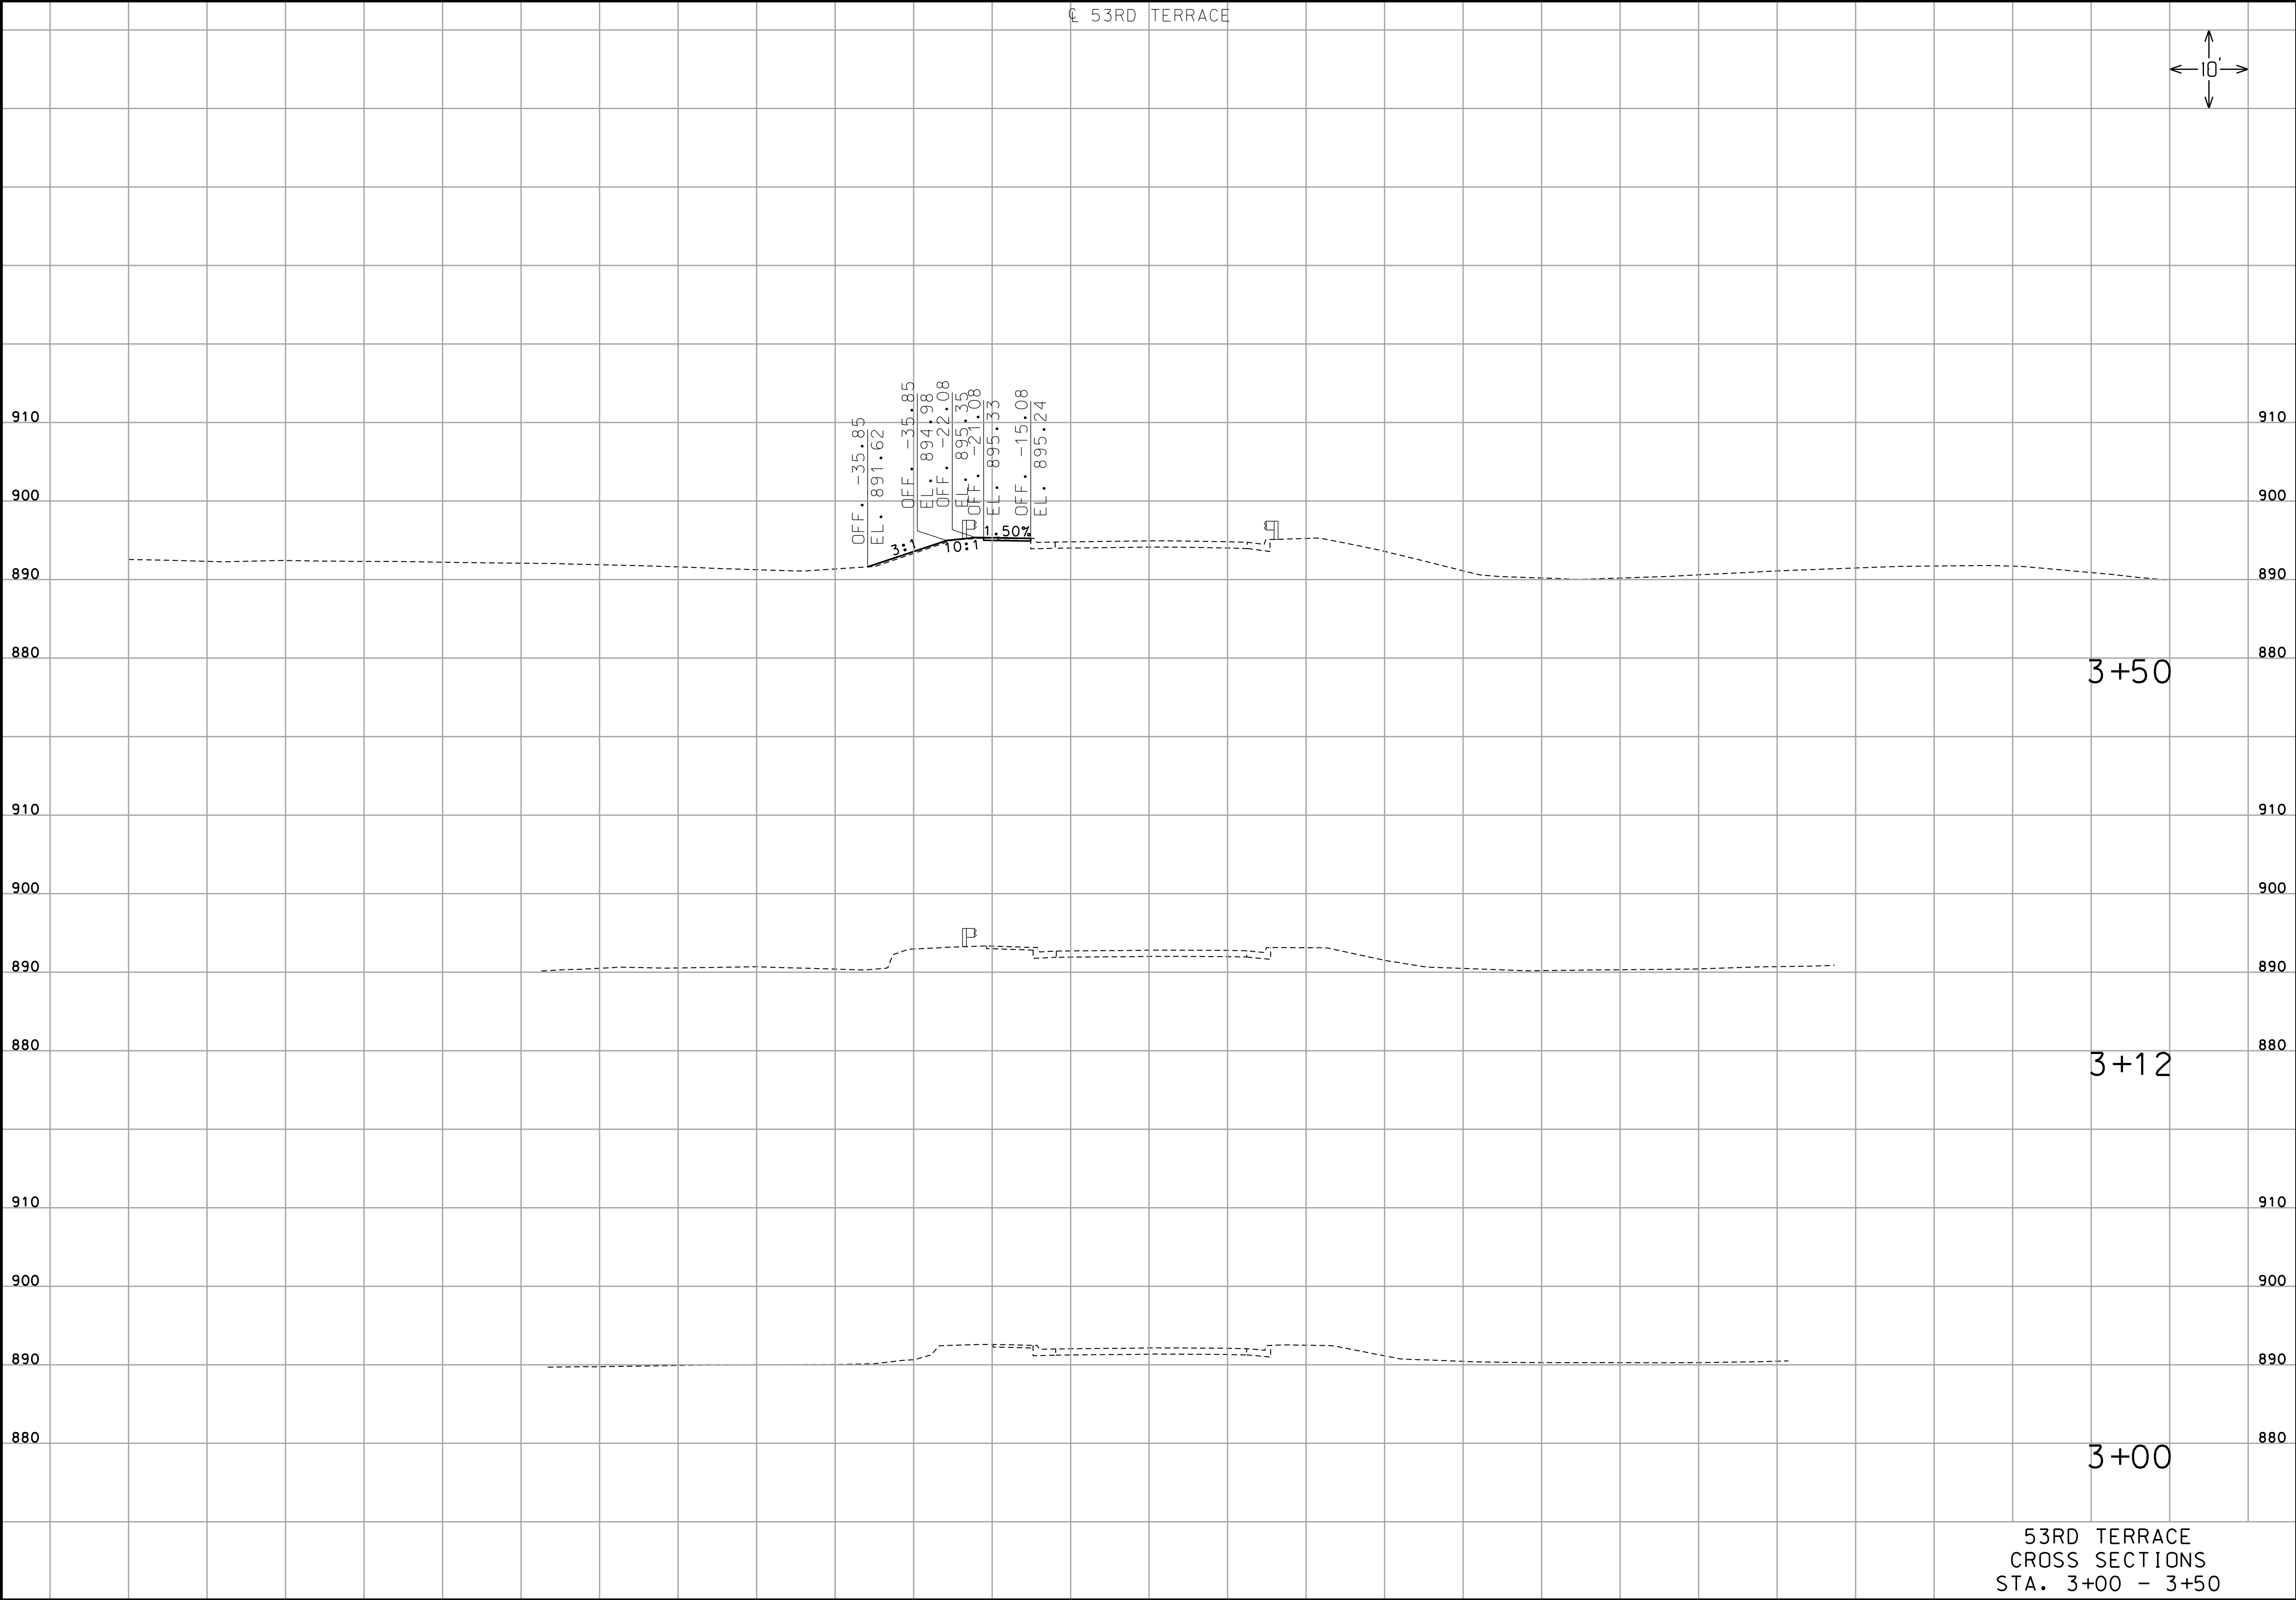

53RD TERRACE
CROSS SECTIONS
STA. 3+00 - 3+50

"THIS MEDIA SHOULD NOT BE CONSIDERED A CERTIFIED DOCUMENT."

DATE PREPARED 6/12/2020	
ROUTE 53RD	STATE MO
DISTRICT KC	SHEET NO. 1
COUNTY CLAY	
JOB NO. J453386	
CONTRACT ID.	
PROJECT NO.	
BRIDGE NO. A8931	

DATE	DESCRIPTION


MISSOURI HIGHWAYS AND TRANSPORTATION COMMISSION



105 WEST CAPITAL
JEFFERSON CITY, MO 65102
1-888-ASK-MODOT (1-888-275-6636)

GARVER, LLC.
7410 NW TIFFANY SPRINGS
PARKWAY, SUITE 200
KANSAS CITY, MO 64153
PHONE: (816) 298-6465
CERTIFICATE OF AUTHORITY
NO. 2008013090

IF A SEAL IS PRESENT ON THIS SHEET IT HAS BEEN ELECTRONICALLY SEALED AND DATED.

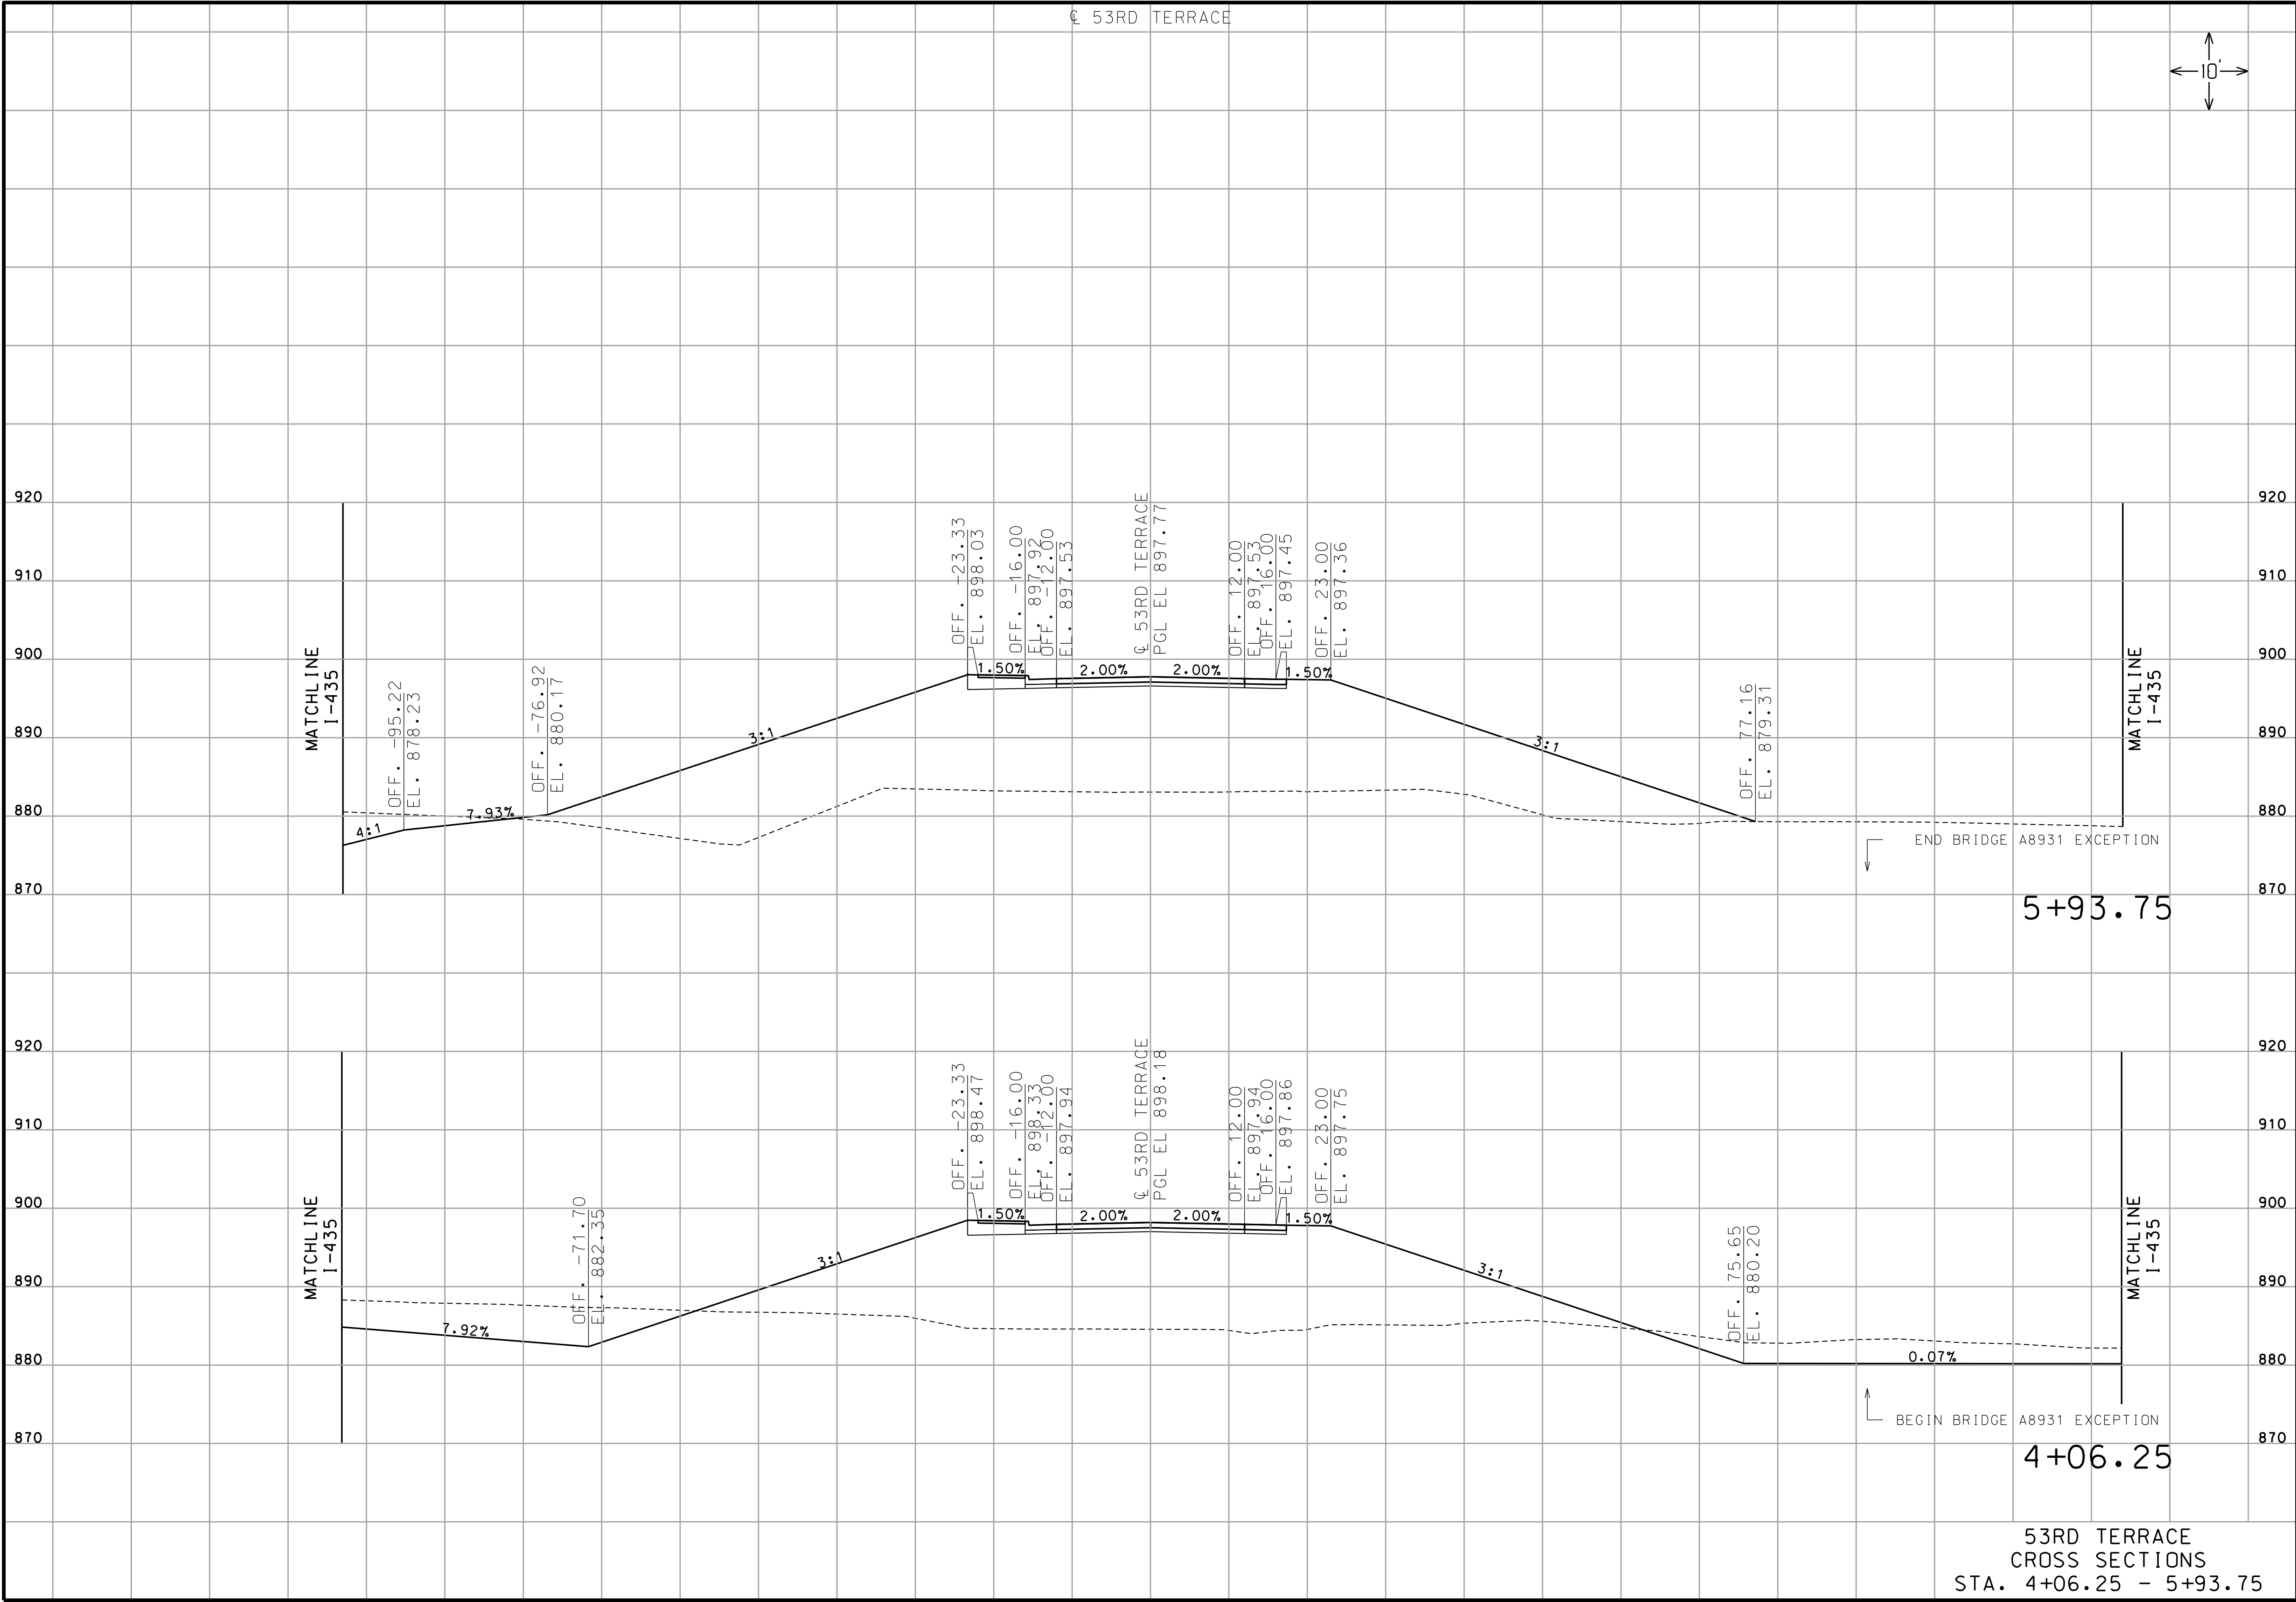

"THIS MEDIA SHOULD NOT BE CONSIDERED A CERTIFIED DOCUMENT."

DATE PREPARED 6/12/2020	
ROUTE 53RD	STATE MO
DISTRICT KC	SHEET NO. 3
COUNTY CLAY	
JOB NO. J453386	
CONTRACT ID.	
PROJECT NO.	
BRIDGE NO. A8931	

DATE	DESCRIPTION

MISSOURI HIGHWAYS AND TRANSPORTATION COMMISSION




105 WEST CAPITAL
JEFFERSON CITY, MO 65102
1-888-ASK-MODOT (1-888-275-6636)

GARVER, LLC.
7410 NW TIFFANY SPRINGS
PARKWAY, SUITE 200
KANSAS CITY, MO 64153
PHONE: (816) 298-6465
CERTIFICATE OF AUTHORITY
NO. 2008013090

53RD TERRACE
CROSS SECTIONS
STA. 4+06.25 - 5+93.75

IF A SEAL IS PRESENT ON THIS SHEET IT HAS BEEN ELECTRONICALLY SEALED AND DATED.

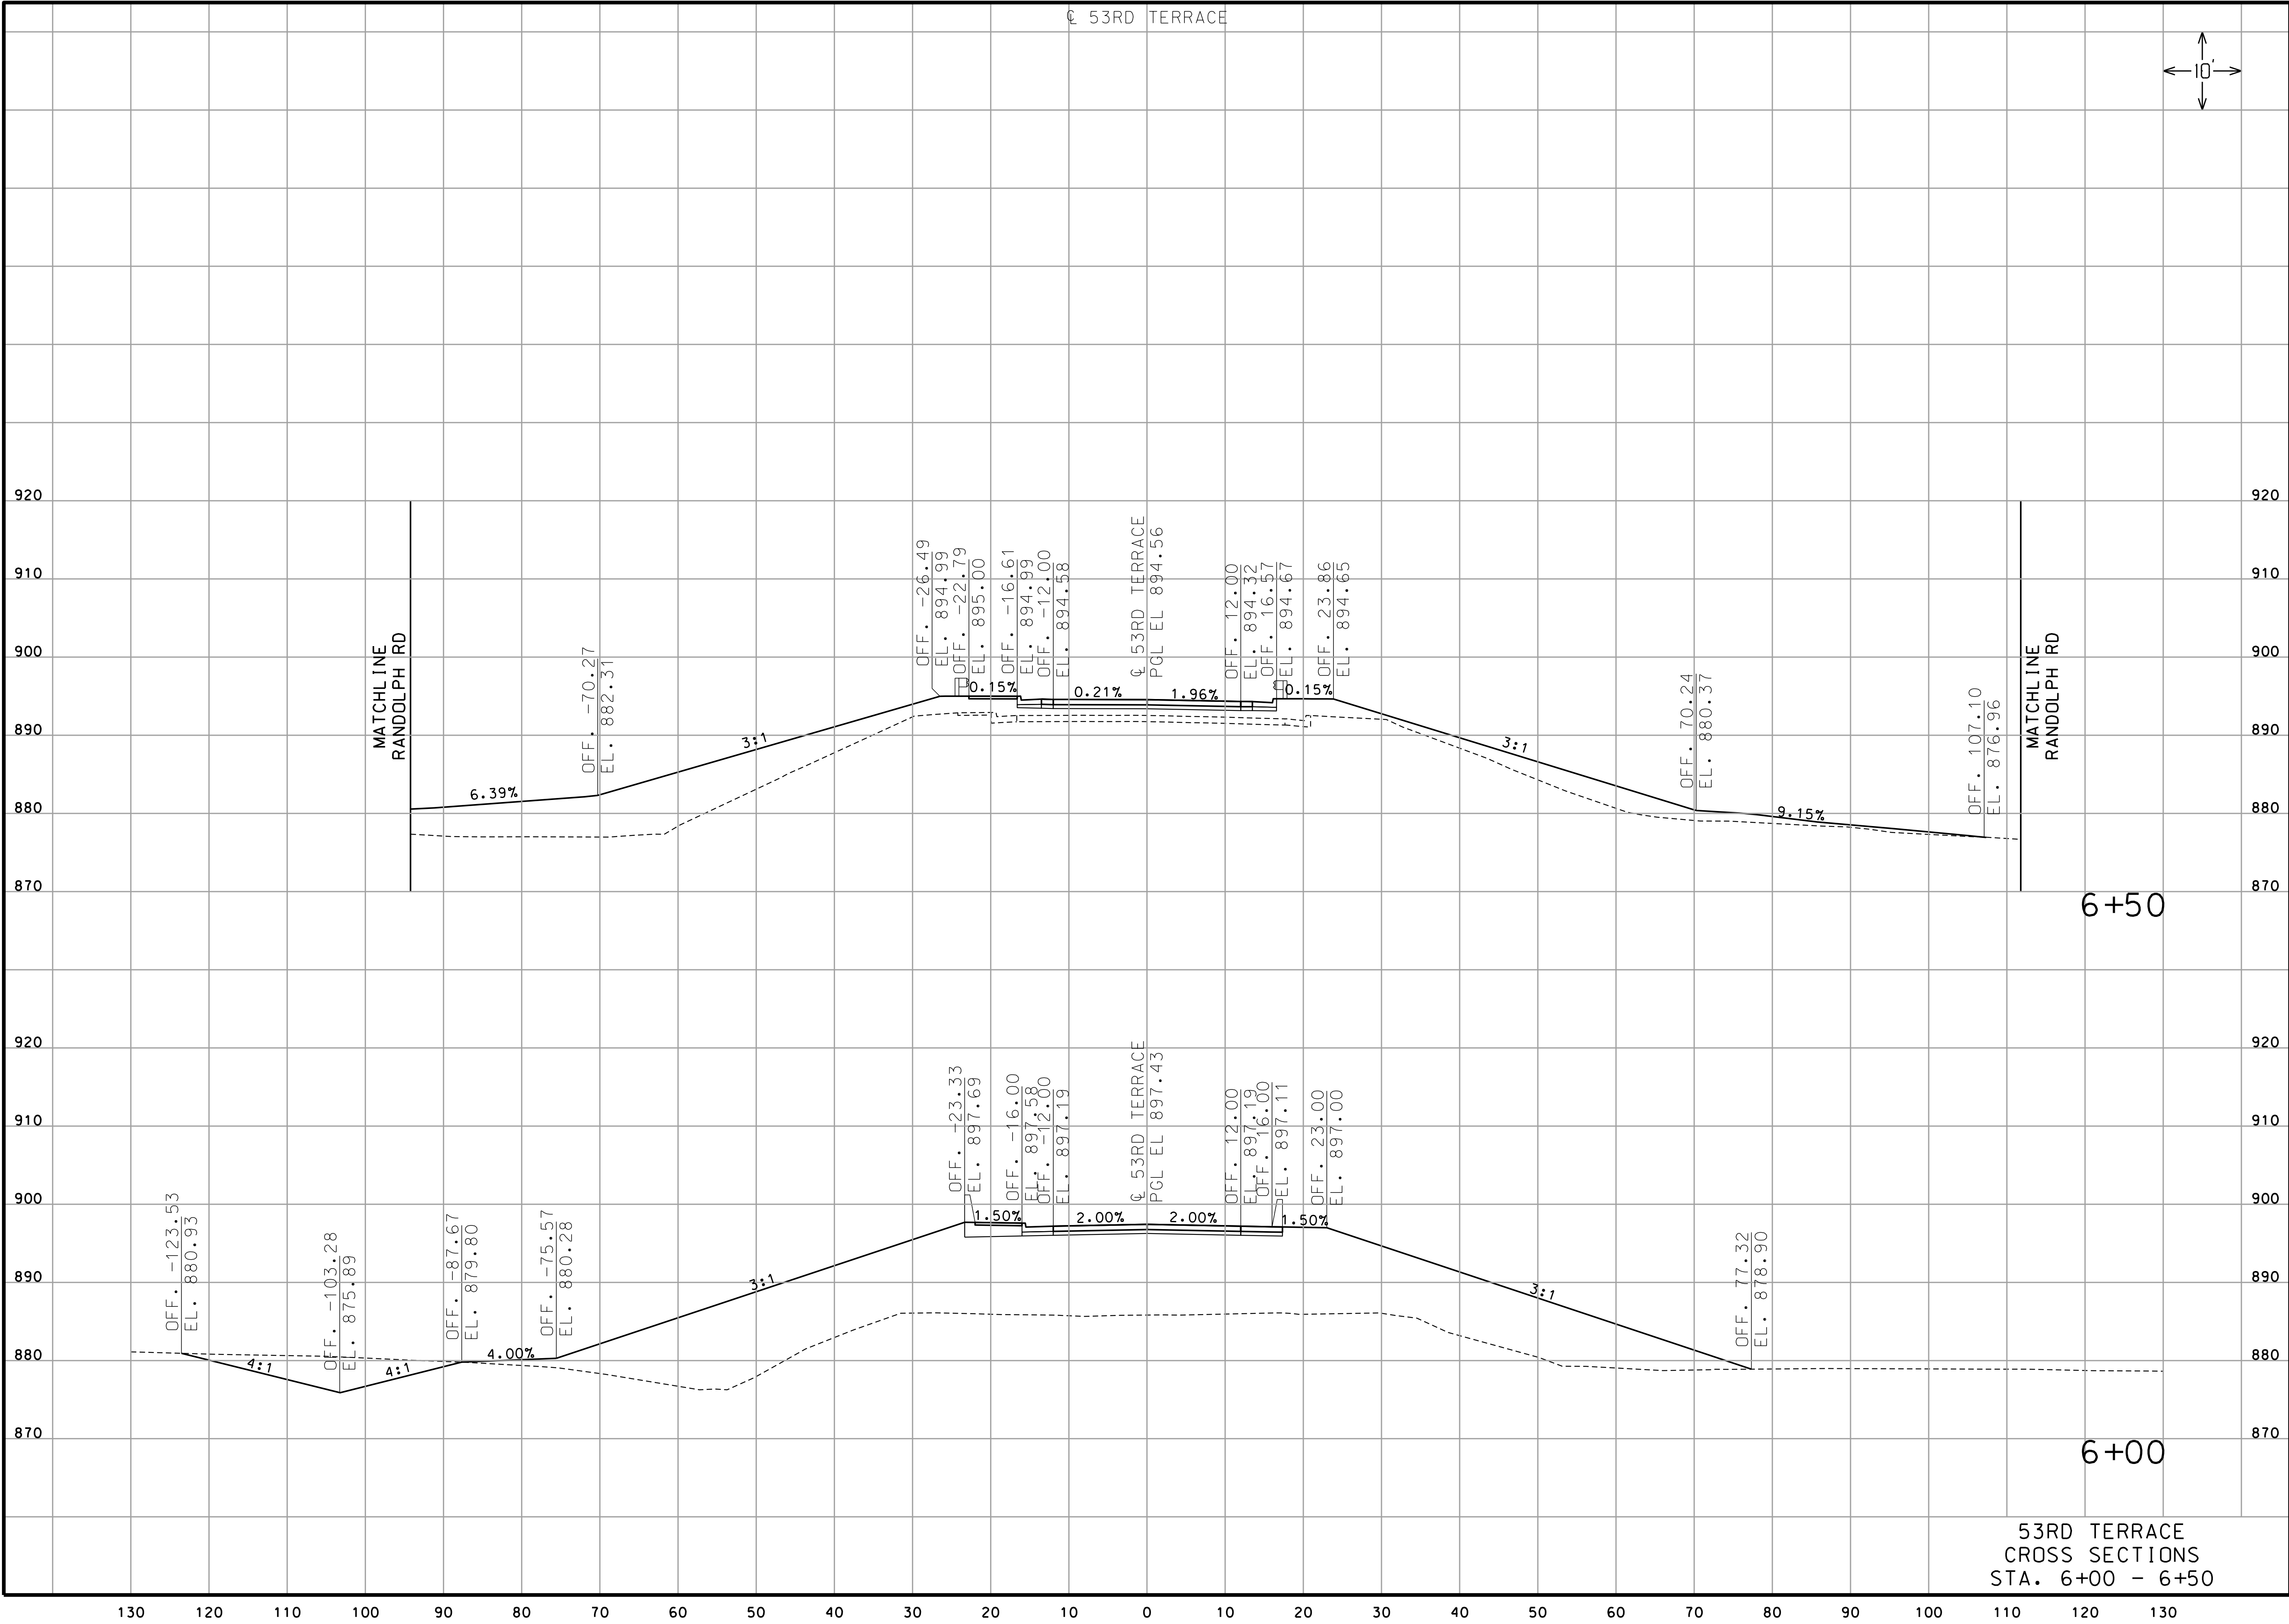

THIS MEDIA SHOULD NOT BE CONSIDERED A CERTIFIED DOCUMENT.

DATE PREPARED 6/12/2020	
ROUTE 53RD	STATE MO
DISTRICT KC	SHEET NO. 4
COUNTY CLAY	
JOB NO. J453386	
CONTRACT ID.	
PROJECT NO.	
BRIDGE NO. A8931	


DATE	DESCRIPTION


MISSOURI HIGHWAYS AND TRANSPORTATION COMMISSION

MoDOT

105 WEST CAPITAL
JEFFERSON CITY, MO 65102
1-888-ASK-MODOT (1-888-275-6636)

GARVER, LLC.
7410 NW TIFFANY SPRINGS
PARKWAY, SUITE 200
KANSAS CITY, MO 64153
PHONE: (816) 298-6465
CERTIFICATE OF AUTHORITY
NO. 2008013090

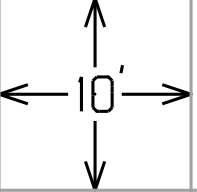

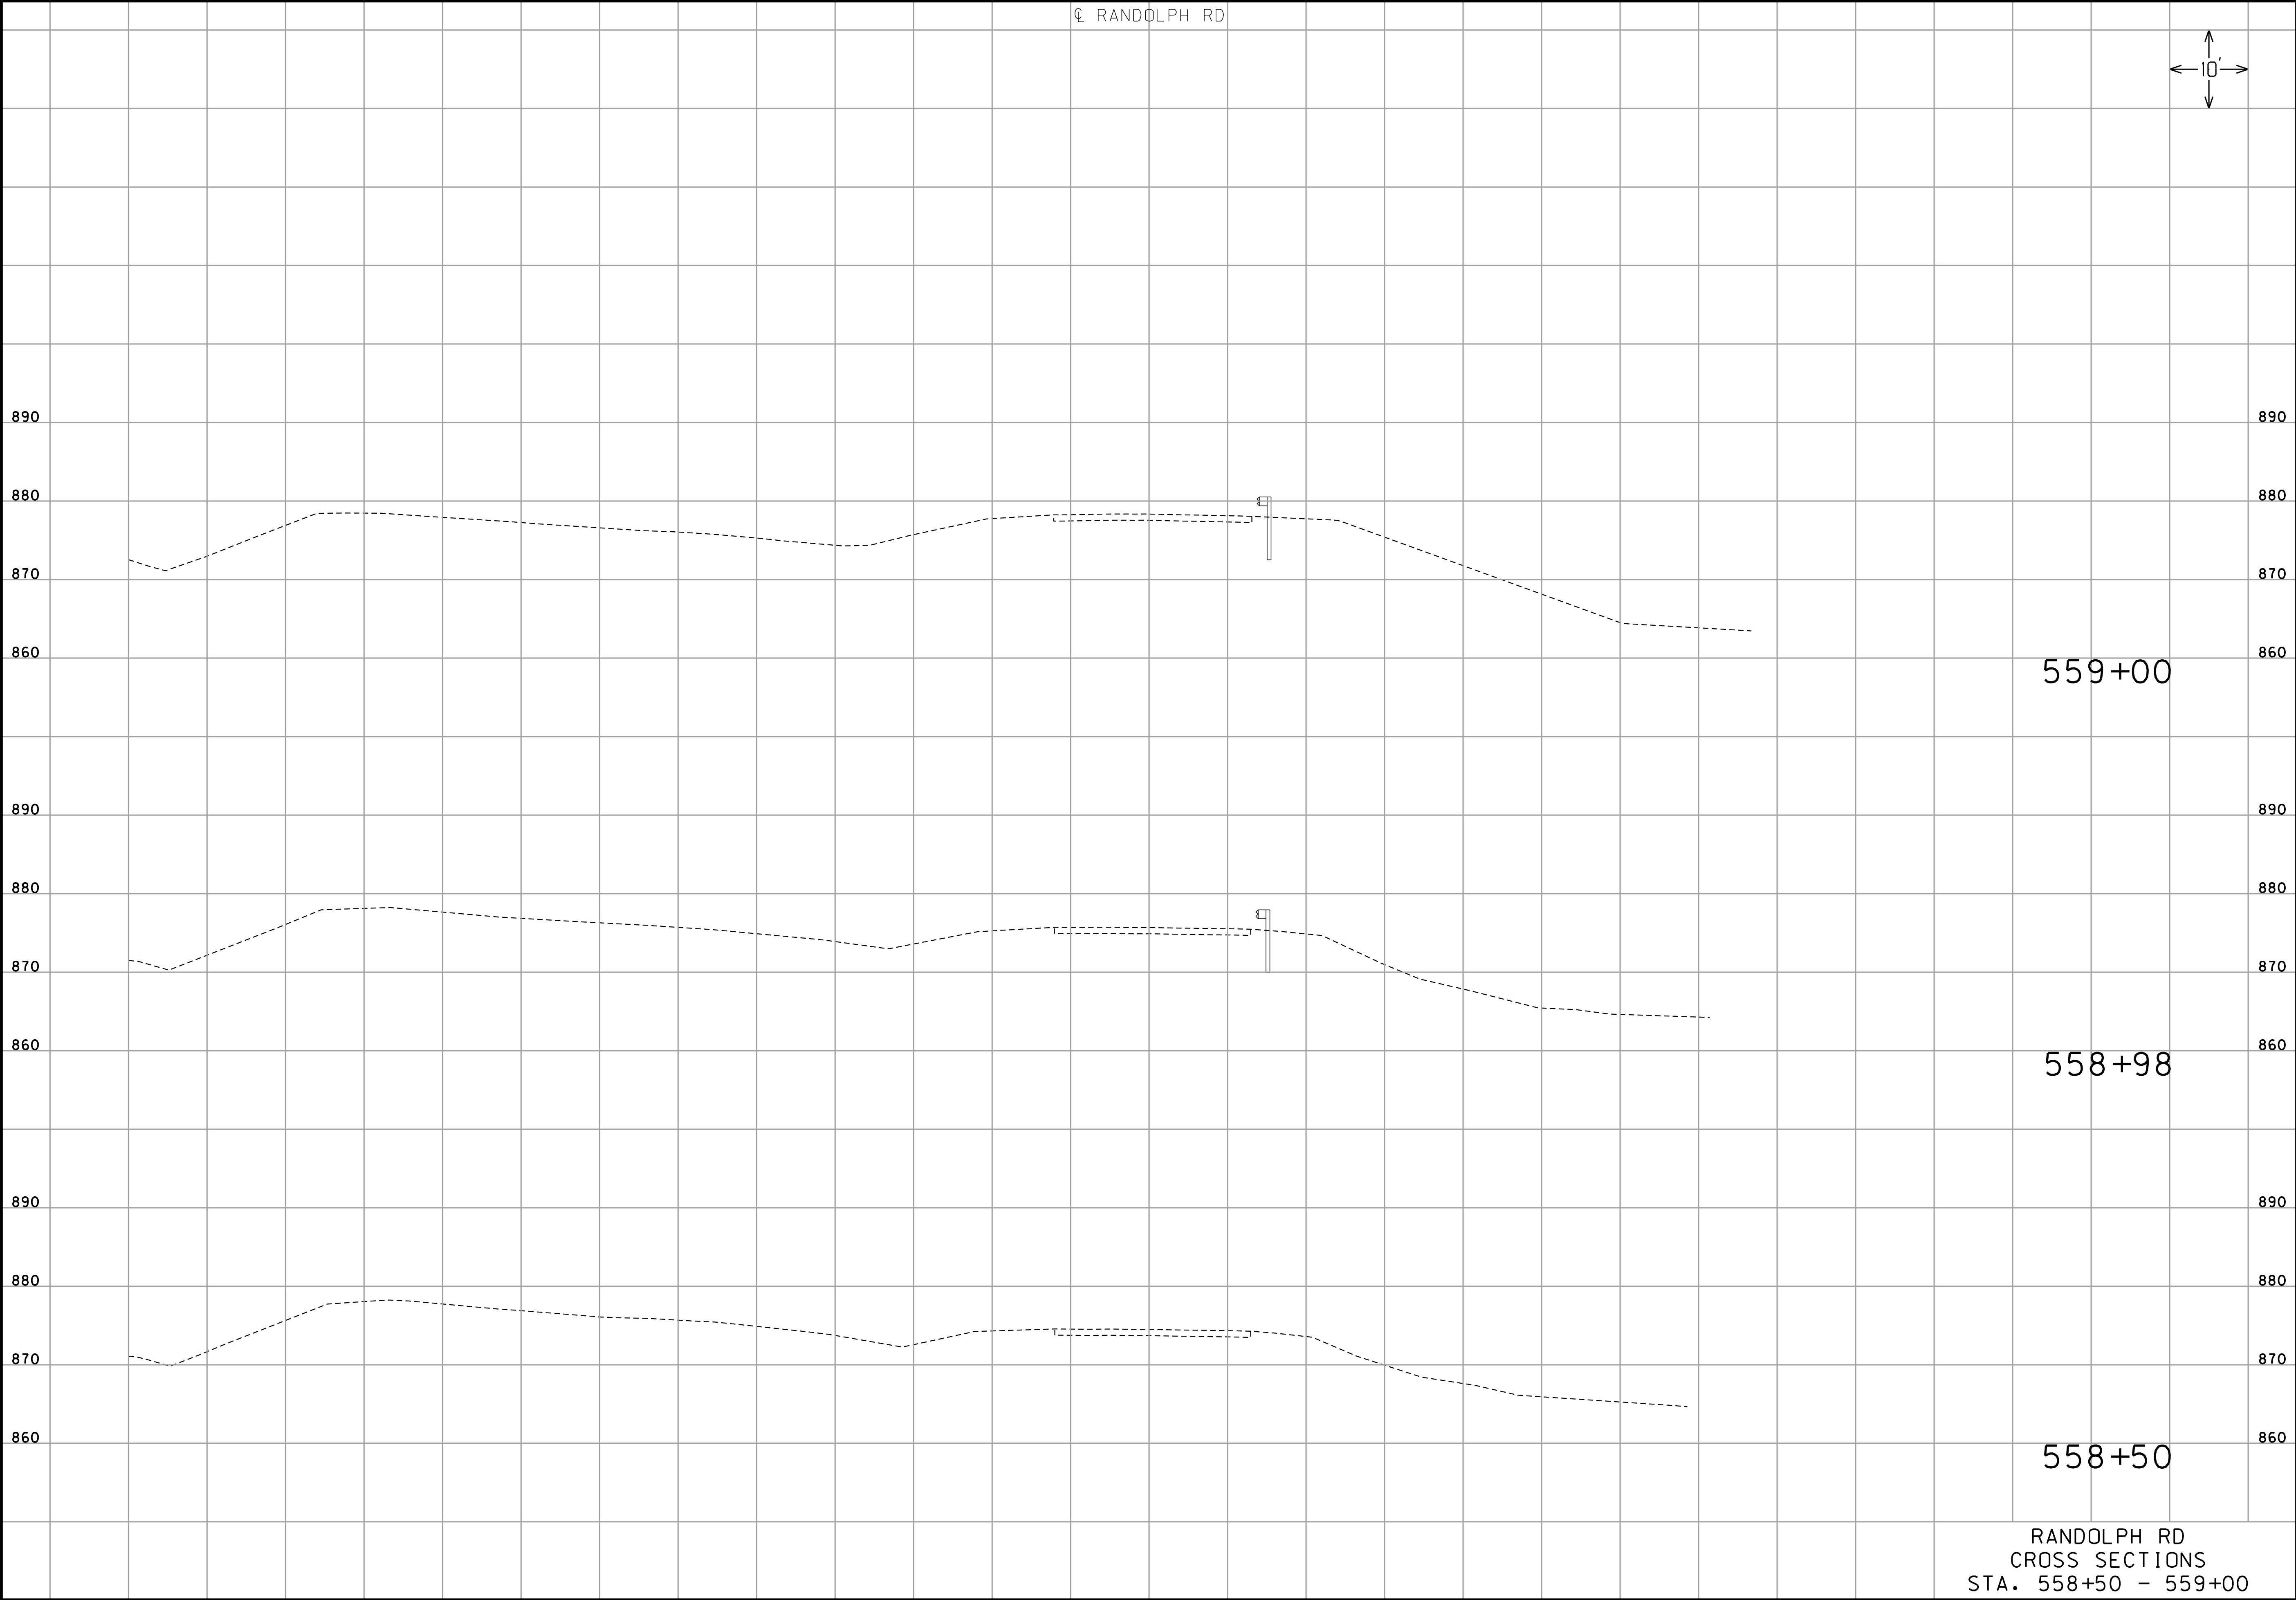

"THIS MEDIA SHOULD NOT BE CONSIDERED A CERTIFIED DOCUMENT."

DATE PREPARED
6/12/2020

ROUTE 53RD	STATE MO
DISTRICT KC	SHEET NO. 5
COUNTY CLAY	
JOB NO. J453386	
CONTRACT ID.	
PROJECT NO.	
BRIDGE NO. A8931	


DATE	DESCRIPTION

MISSOURI HIGHWAYS AND TRANSPORTATION COMMISSION

MoDOT

105 WEST CAPITOL
JEFFERSON CITY, MO 65102
1-888-ASK-MODOT (1-888-275-6636)

GARVER, LLC.
7410 NW TIFFANY SPRINGS
PARKWAY, SUITE 200
KANSAS CITY, MO 64153
PHONE: (816) 298-6465
CERTIFICATE OF AUTHORITY
NO. 2008013090

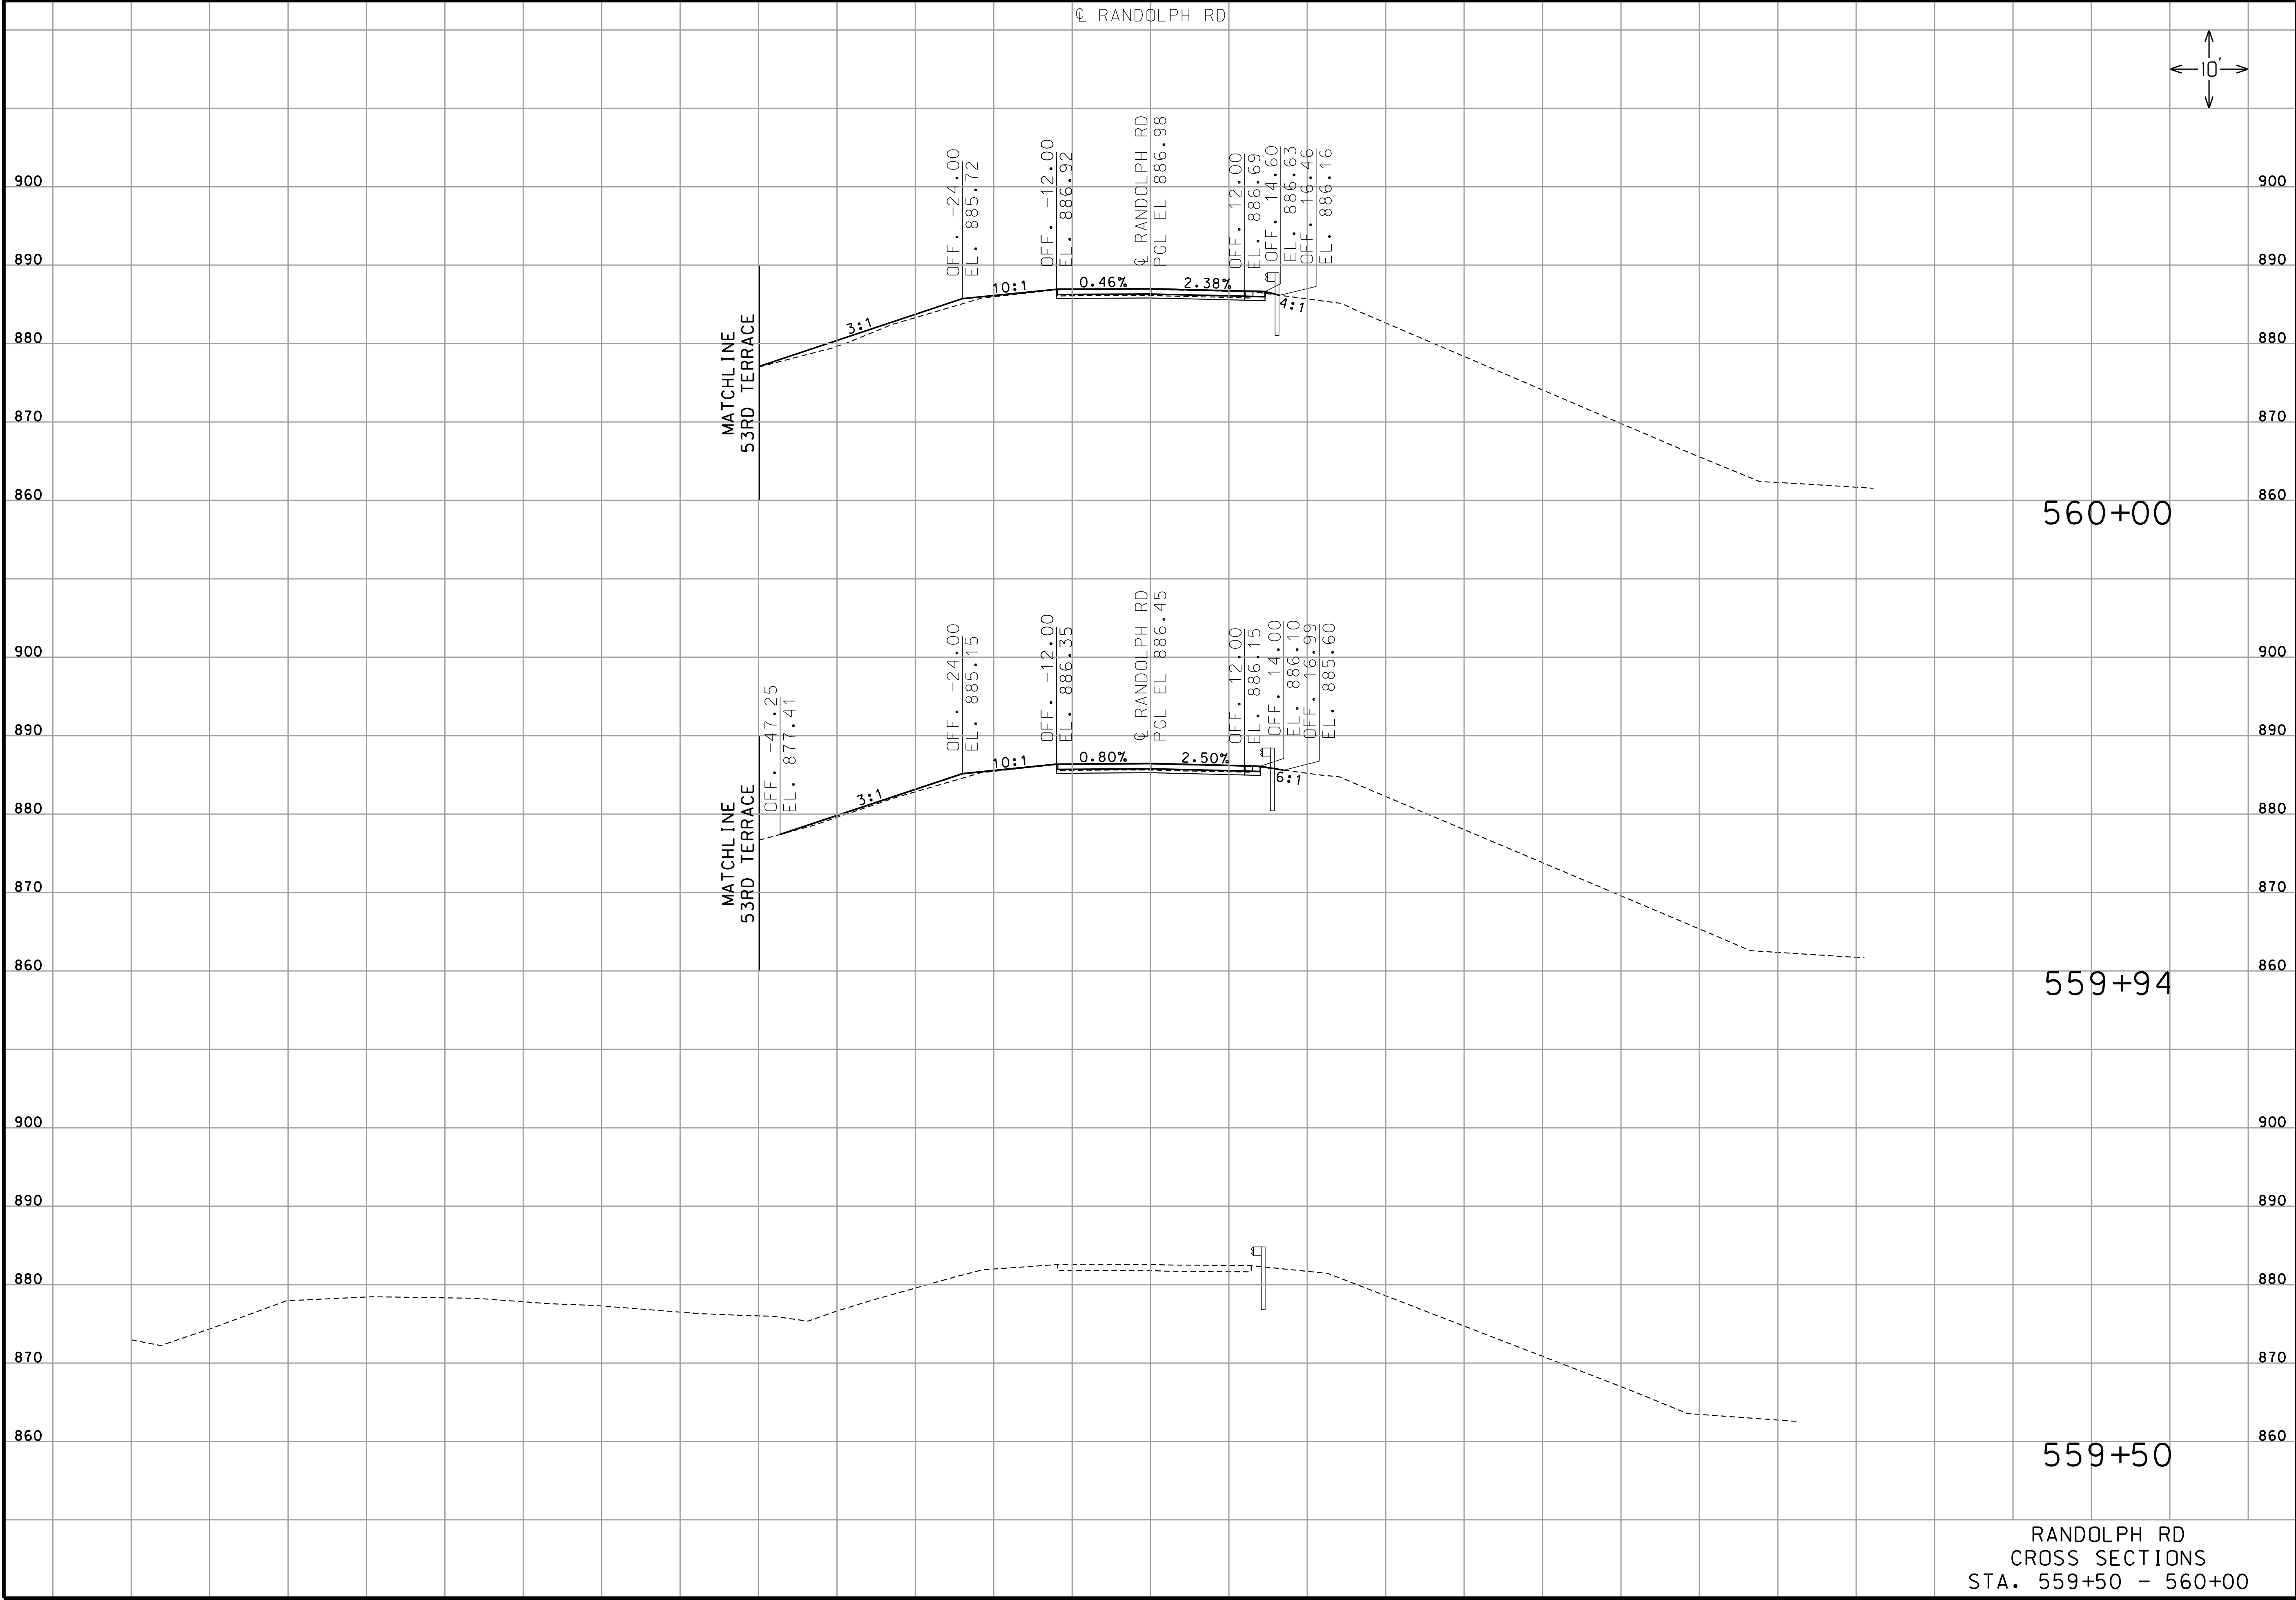

RANDOLPH RD
CROSS SECTIONS
STA. 559+50 - 560+00

"THIS MEDIA SHOULD NOT BE CONSIDERED A CERTIFIED DOCUMENT."

DATE PREPARED
6/12/2020

ROUTE 53RD	STATE MO
DISTRICT KC	SHEET NO. 6

COUNTY
CLAY

JOB NO.
J453386

CONTRACT ID.

PROJECT NO.

BRIDGE NO.
A8931

DATE	DESCRIPTION


MISSOURI HIGHWAYS AND TRANSPORTATION COMMISSION



105 WEST CAPITAL
JEFFERSON CITY, MO 65102
1-888-ASK-MODOT (1-888-275-6636)

GARVER, LLC.
7410 NW TIFFANY SPRINGS
PARKWAY, SUITE 200
KANSAS CITY, MO 64153
PHONE: (816) 298-6465
CERTIFICATE OF AUTHORITY
NO. 2008013090

IF A SEAL IS PRESENT ON THIS SHEET IT HAS BEEN ELECTRONICALLY SEALED AND DATED.

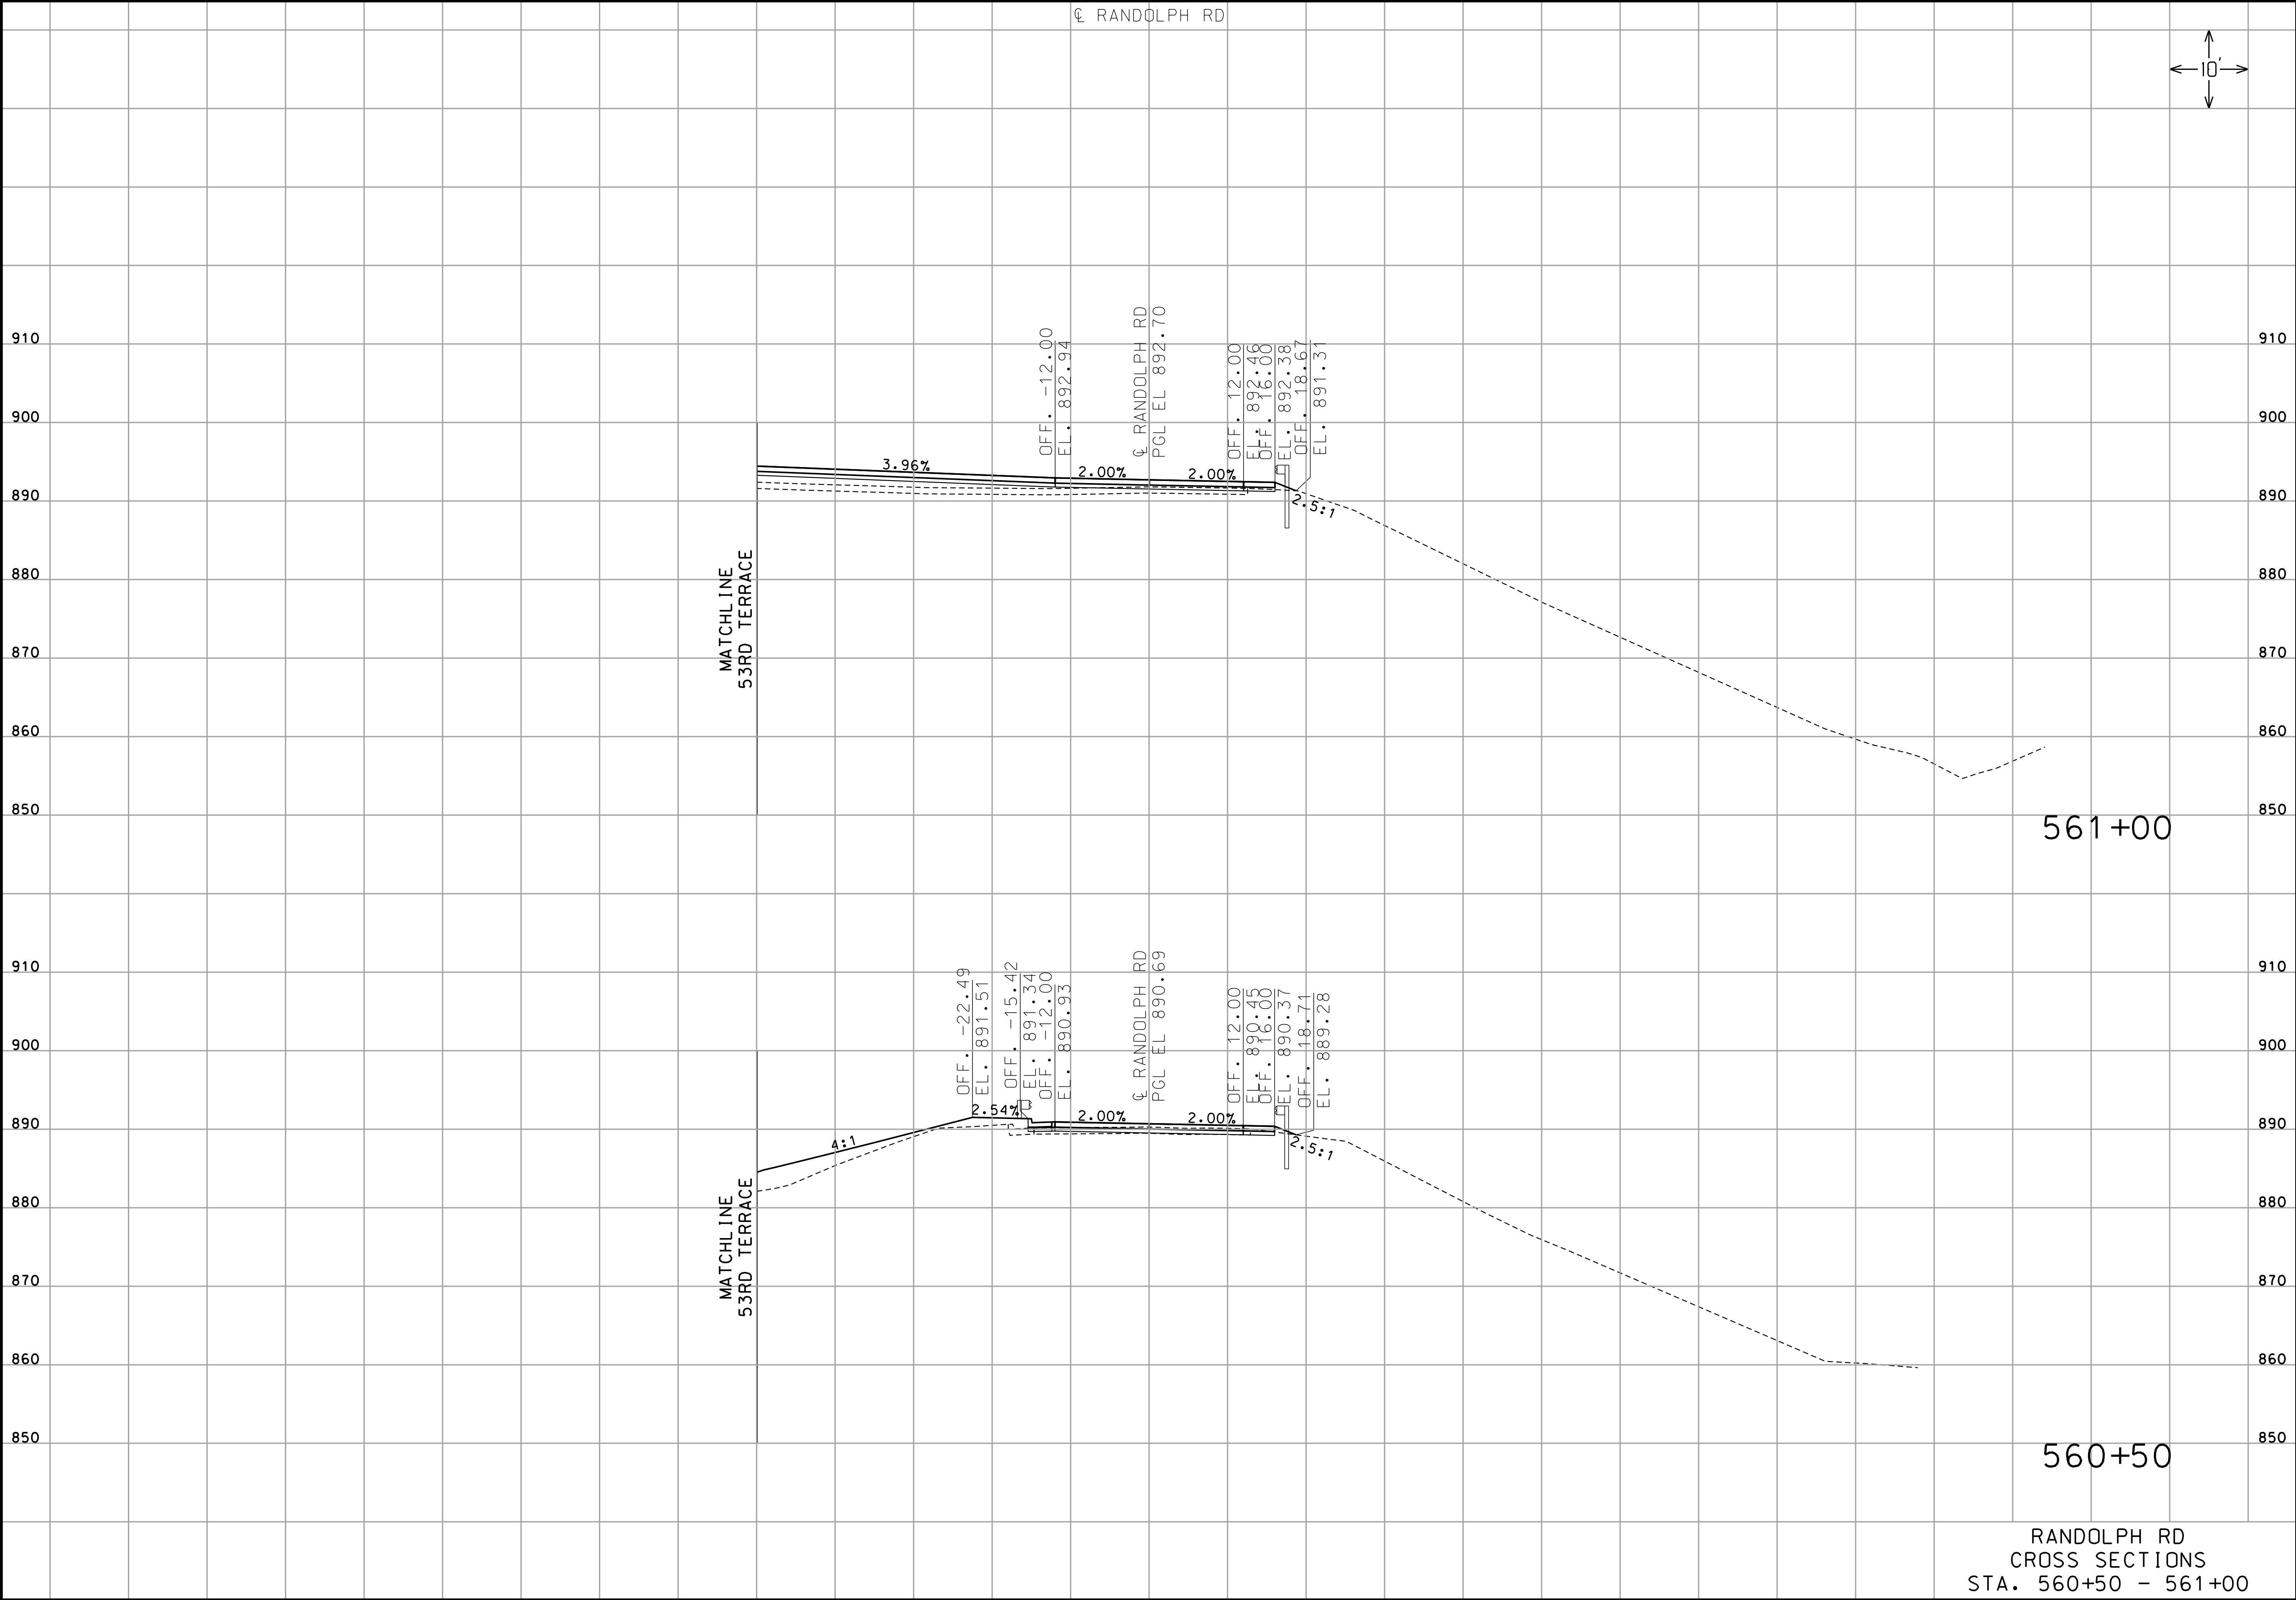

"THIS MEDIA SHOULD NOT BE CONSIDERED A CERTIFIED DOCUMENT."

DATE PREPARED 6/12/2020	
ROUTE 53RD	STATE MO
DISTRICT KC	SHEET NO. 7
COUNTY CLAY	
JOB NO. J453386	
CONTRACT ID.	
PROJECT NO.	
BRIDGE NO. A8931	

DATE	DESCRIPTION

MISSOURI HIGHWAYS AND TRANSPORTATION COMMISSION




105 WEST CAPITAL
JEFFERSON CITY, MO 65102
1-888-ASK-MODOT (1-888-275-6636)

GARVER, LLC.
7410 NW TIFFANY SPRINGS
PARKWAY, SUITE 200
KANSAS CITY, MO 64153
PHONE: (816) 298-6465
CERTIFICATE OF AUTHORITY
NO. 2008013090

RANDOLPH RD
CROSS SECTIONS
STA. 560+50 - 561+00

IF A SEAL IS PRESENT ON THIS SHEET IT HAS BEEN ELECTRONICALLY SEALED AND DATED.

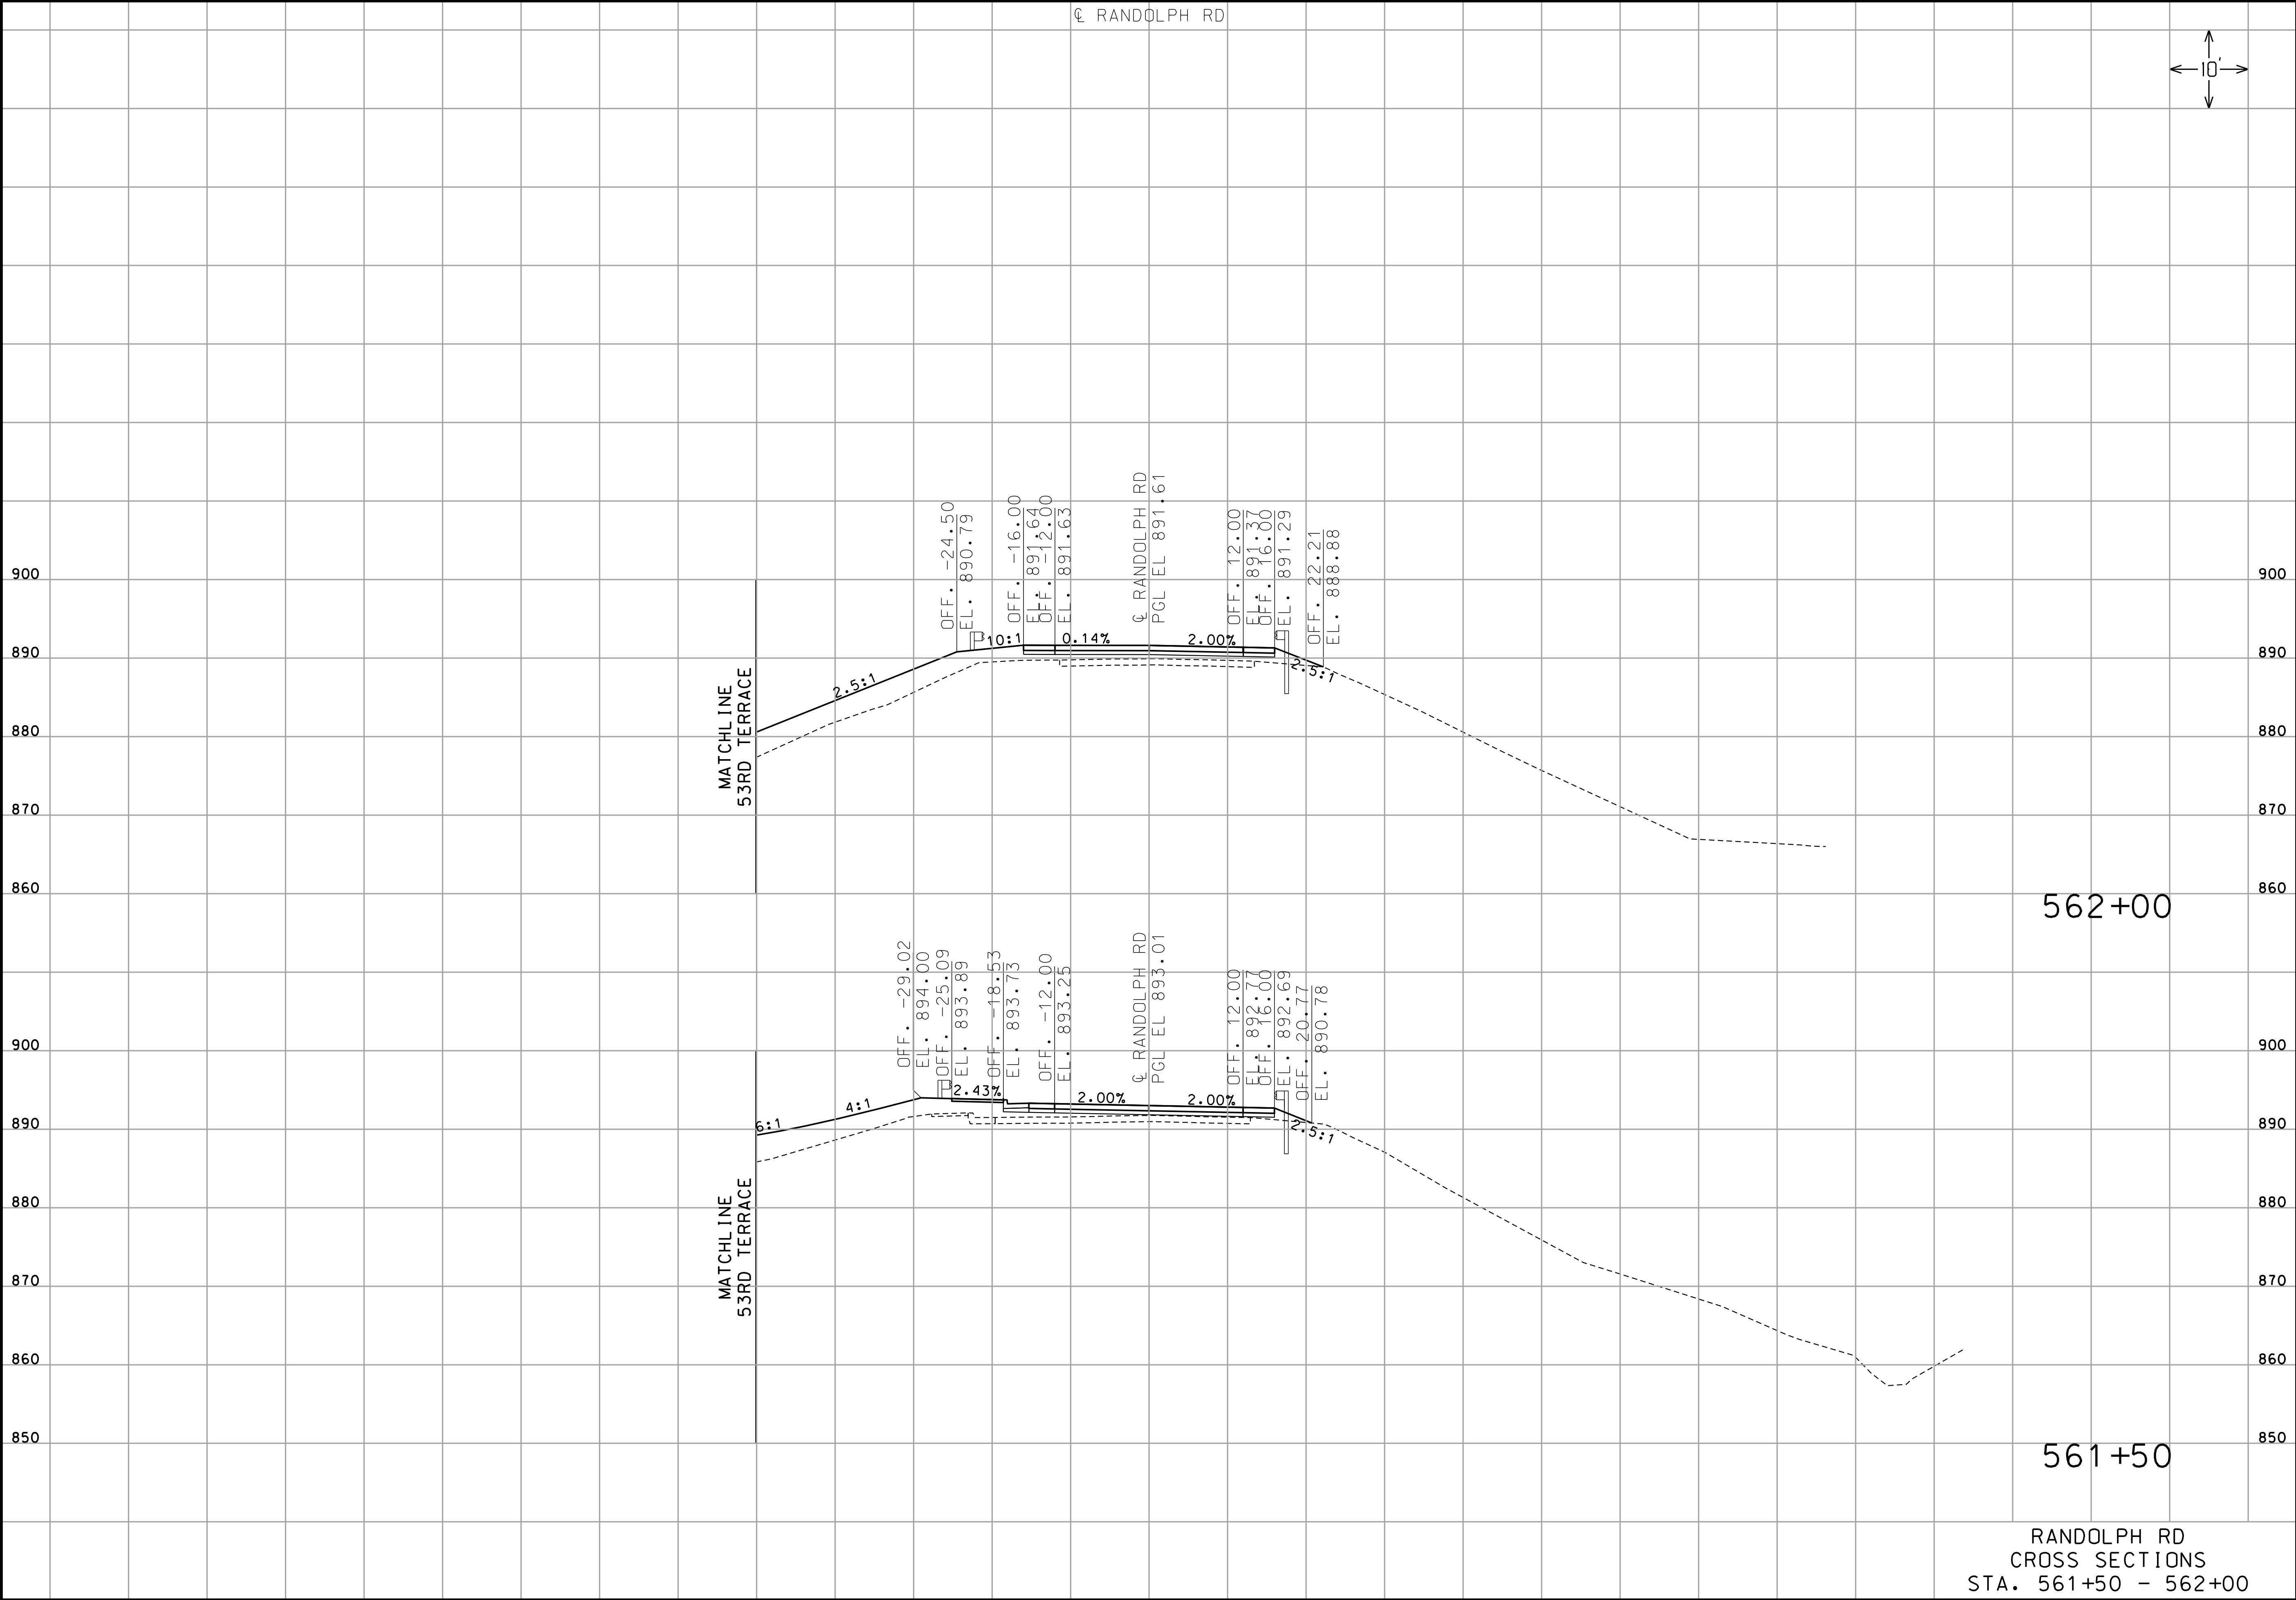

THIS MEDIA SHOULD NOT BE CONSIDERED A CERTIFIED DOCUMENT.

DATE PREPARED
6/12/2020

ROUTE 53RD	STATE MO
DISTRICT KC	SHEET NO. 8

COUNTY
CLAY

JOB NO.
J453386

CONTRACT ID.

PROJECT NO.

BRIDGE NO.
A8931

DATE	DESCRIPTION

MISSOURI HIGHWAYS AND TRANSPORTATION COMMISSION



MoDOT

105 WEST CAPITAL
JEFFERSON CITY, MO 65102
1-888-ASK-MODOT (1-888-275-6636)

GARVER, LLC.
7410 NW TIFFANY SPRINGS
PARKWAY, SUITE 200
KANSAS CITY, MO 64153
PHONE: (816) 298-6465
CERTIFICATE OF AUTHORITY
NO. 2008013090

RANDOLPH RD
CROSS SECTIONS
STA. 561+50 - 562+00

IF A SEAL IS PRESENT ON THIS SHEET IT HAS BEEN ELECTRONICALLY SEALED AND DATED.

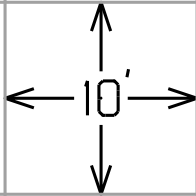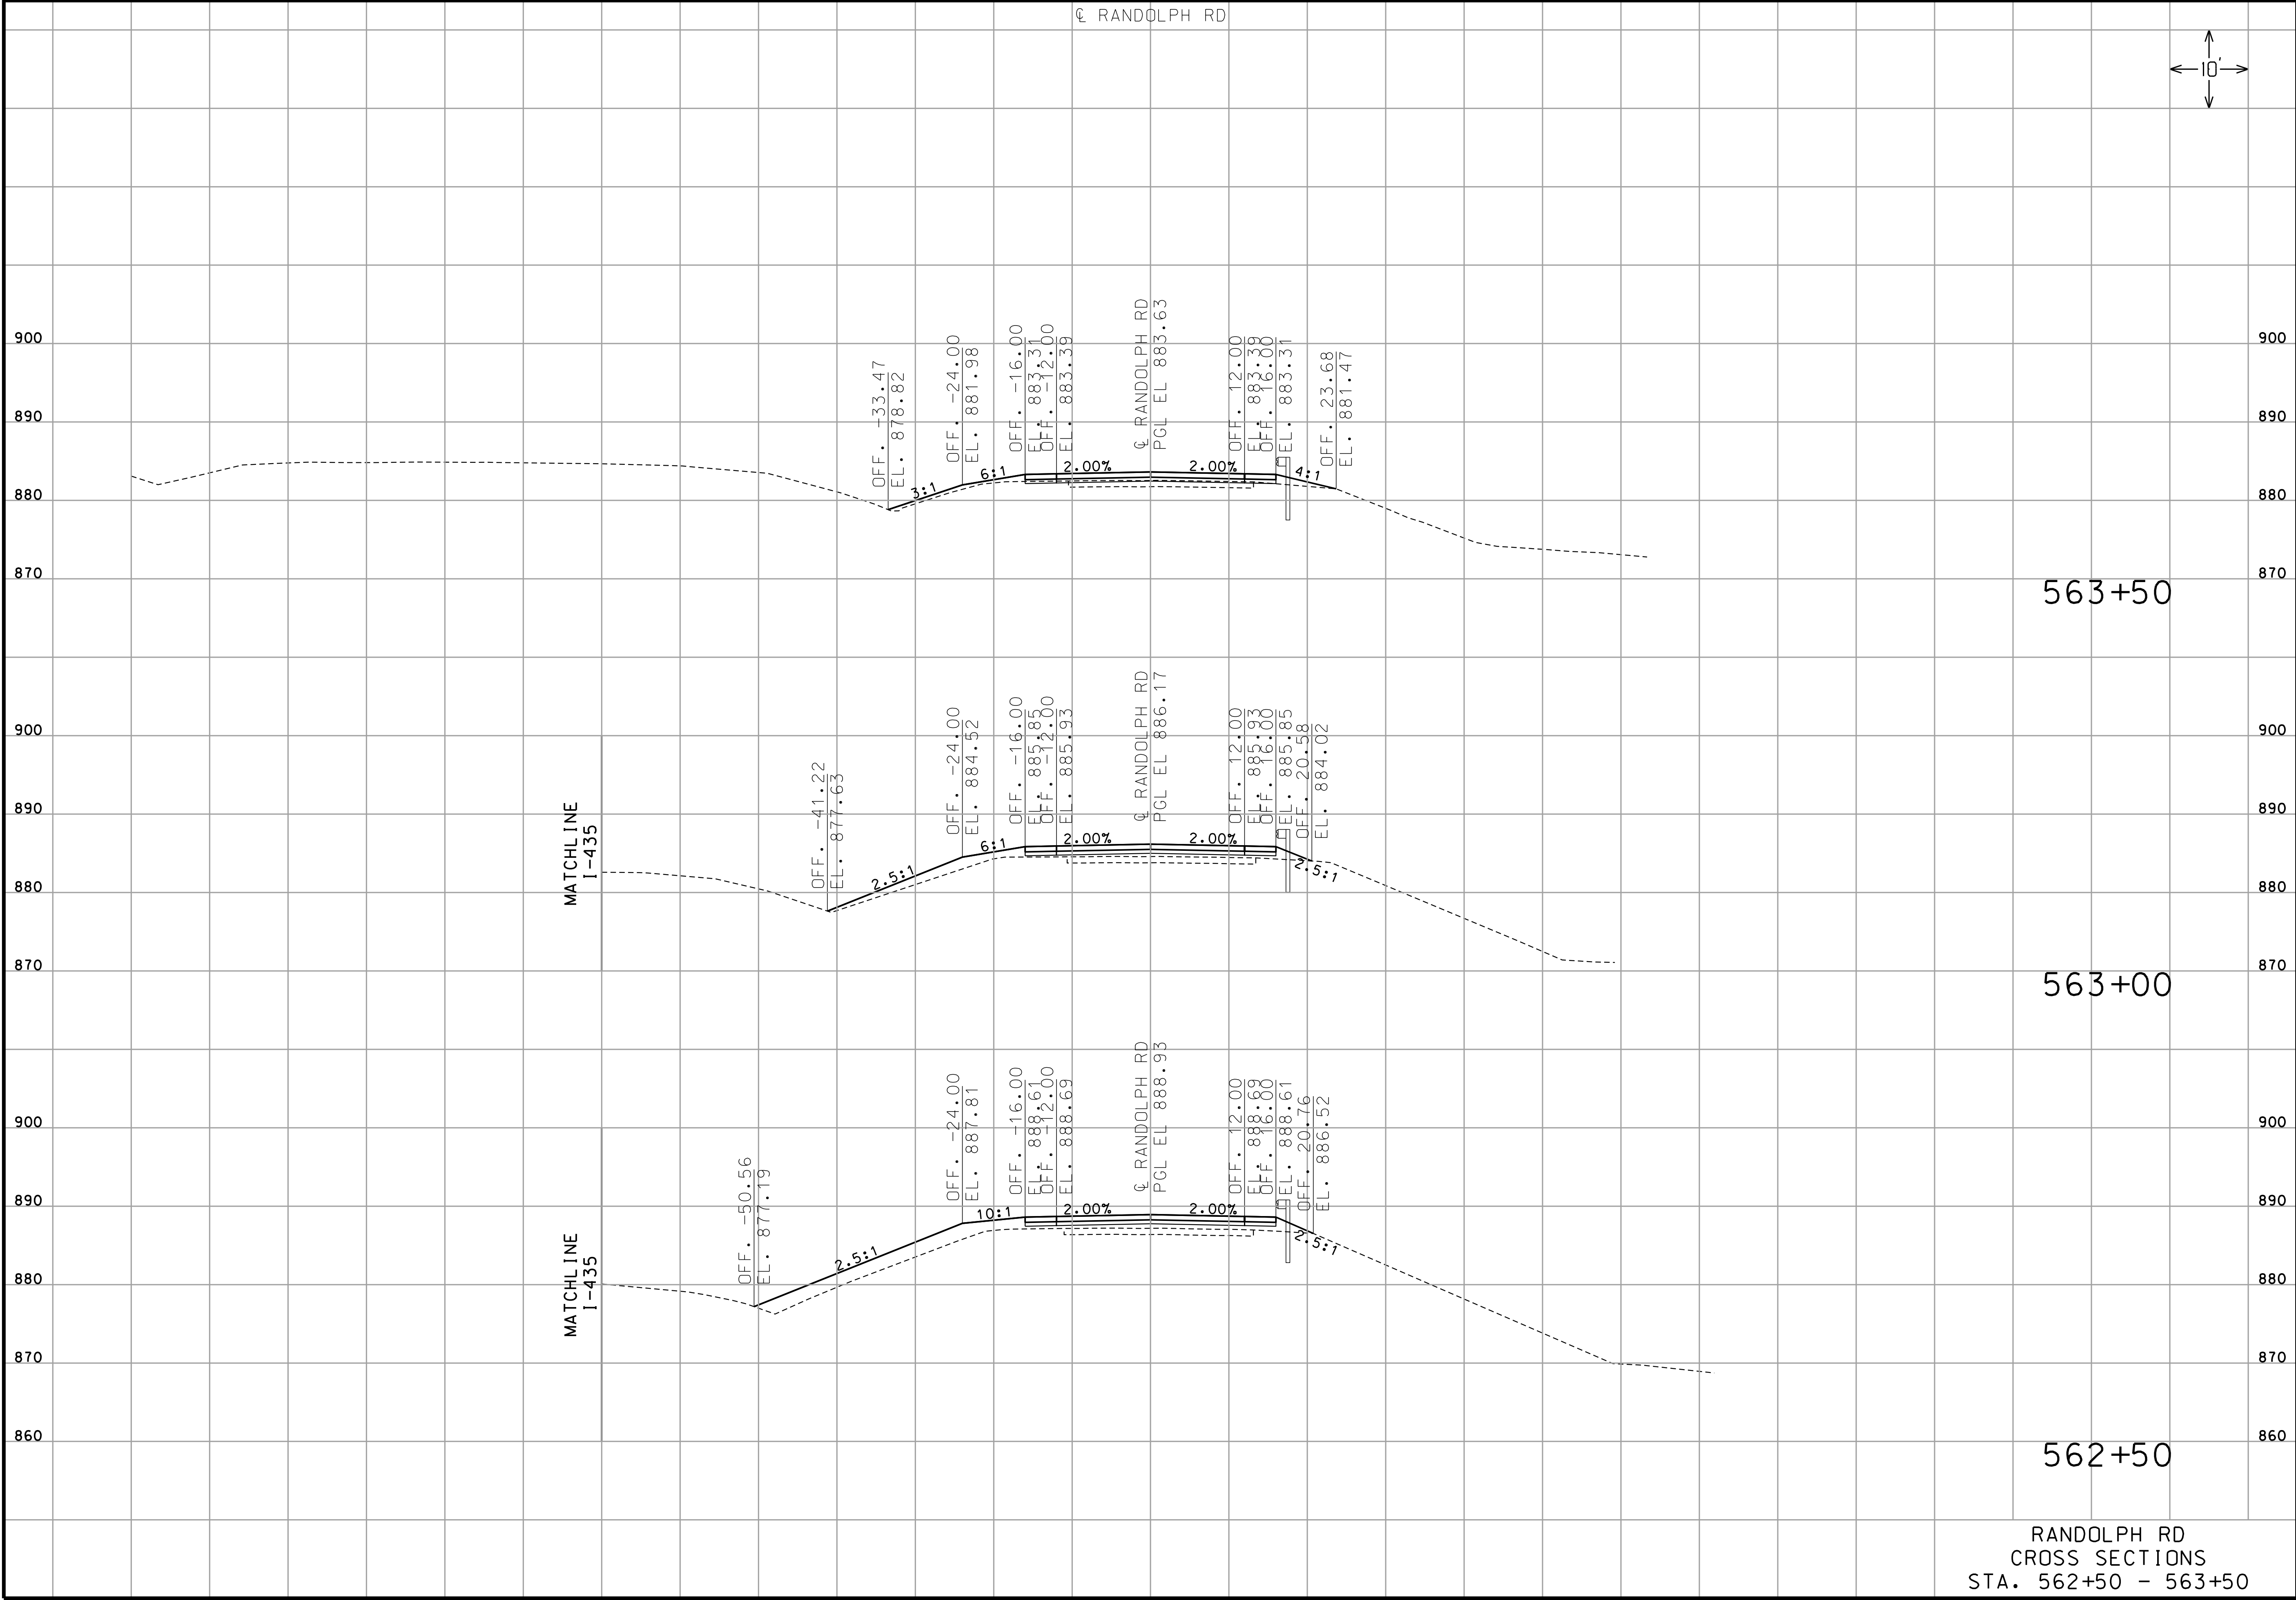

"THIS MEDIA SHOULD NOT BE CONSIDERED A CERTIFIED DOCUMENT."

DATE PREPARED 6/12/2020	
ROUTE 53RD	STATE MO
DISTRICT KC	SHEET NO. 9
COUNTY CLAY	
JOB NO. J453386	
CONTRACT ID.	
PROJECT NO.	
BRIDGE NO. A8931	

DATE	DESCRIPTION



MISSOURI HIGHWAYS AND TRANSPORTATION COMMISSION

105 WEST CAPITAL
JEFFERSON CITY, MO 65102
1-888-ASK-MODOT (1-888-275-6636)

GARVER, LLC.
7410 NW TIFFANY SPRINGS
PARKWAY, SUITE 200
KANSAS CITY, MO 64153
PHONE: (816) 298-6465
CERTIFICATE OF AUTHORITY
NO. 2008013090

RANDOLPH RD
CROSS SECTIONS
STA. 562+50 - 563+50

IF A SEAL IS PRESENT ON THIS SHEET IT HAS BEEN ELECTRONICALLY SEALED AND DATED.

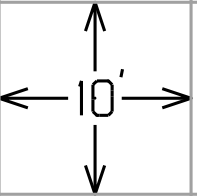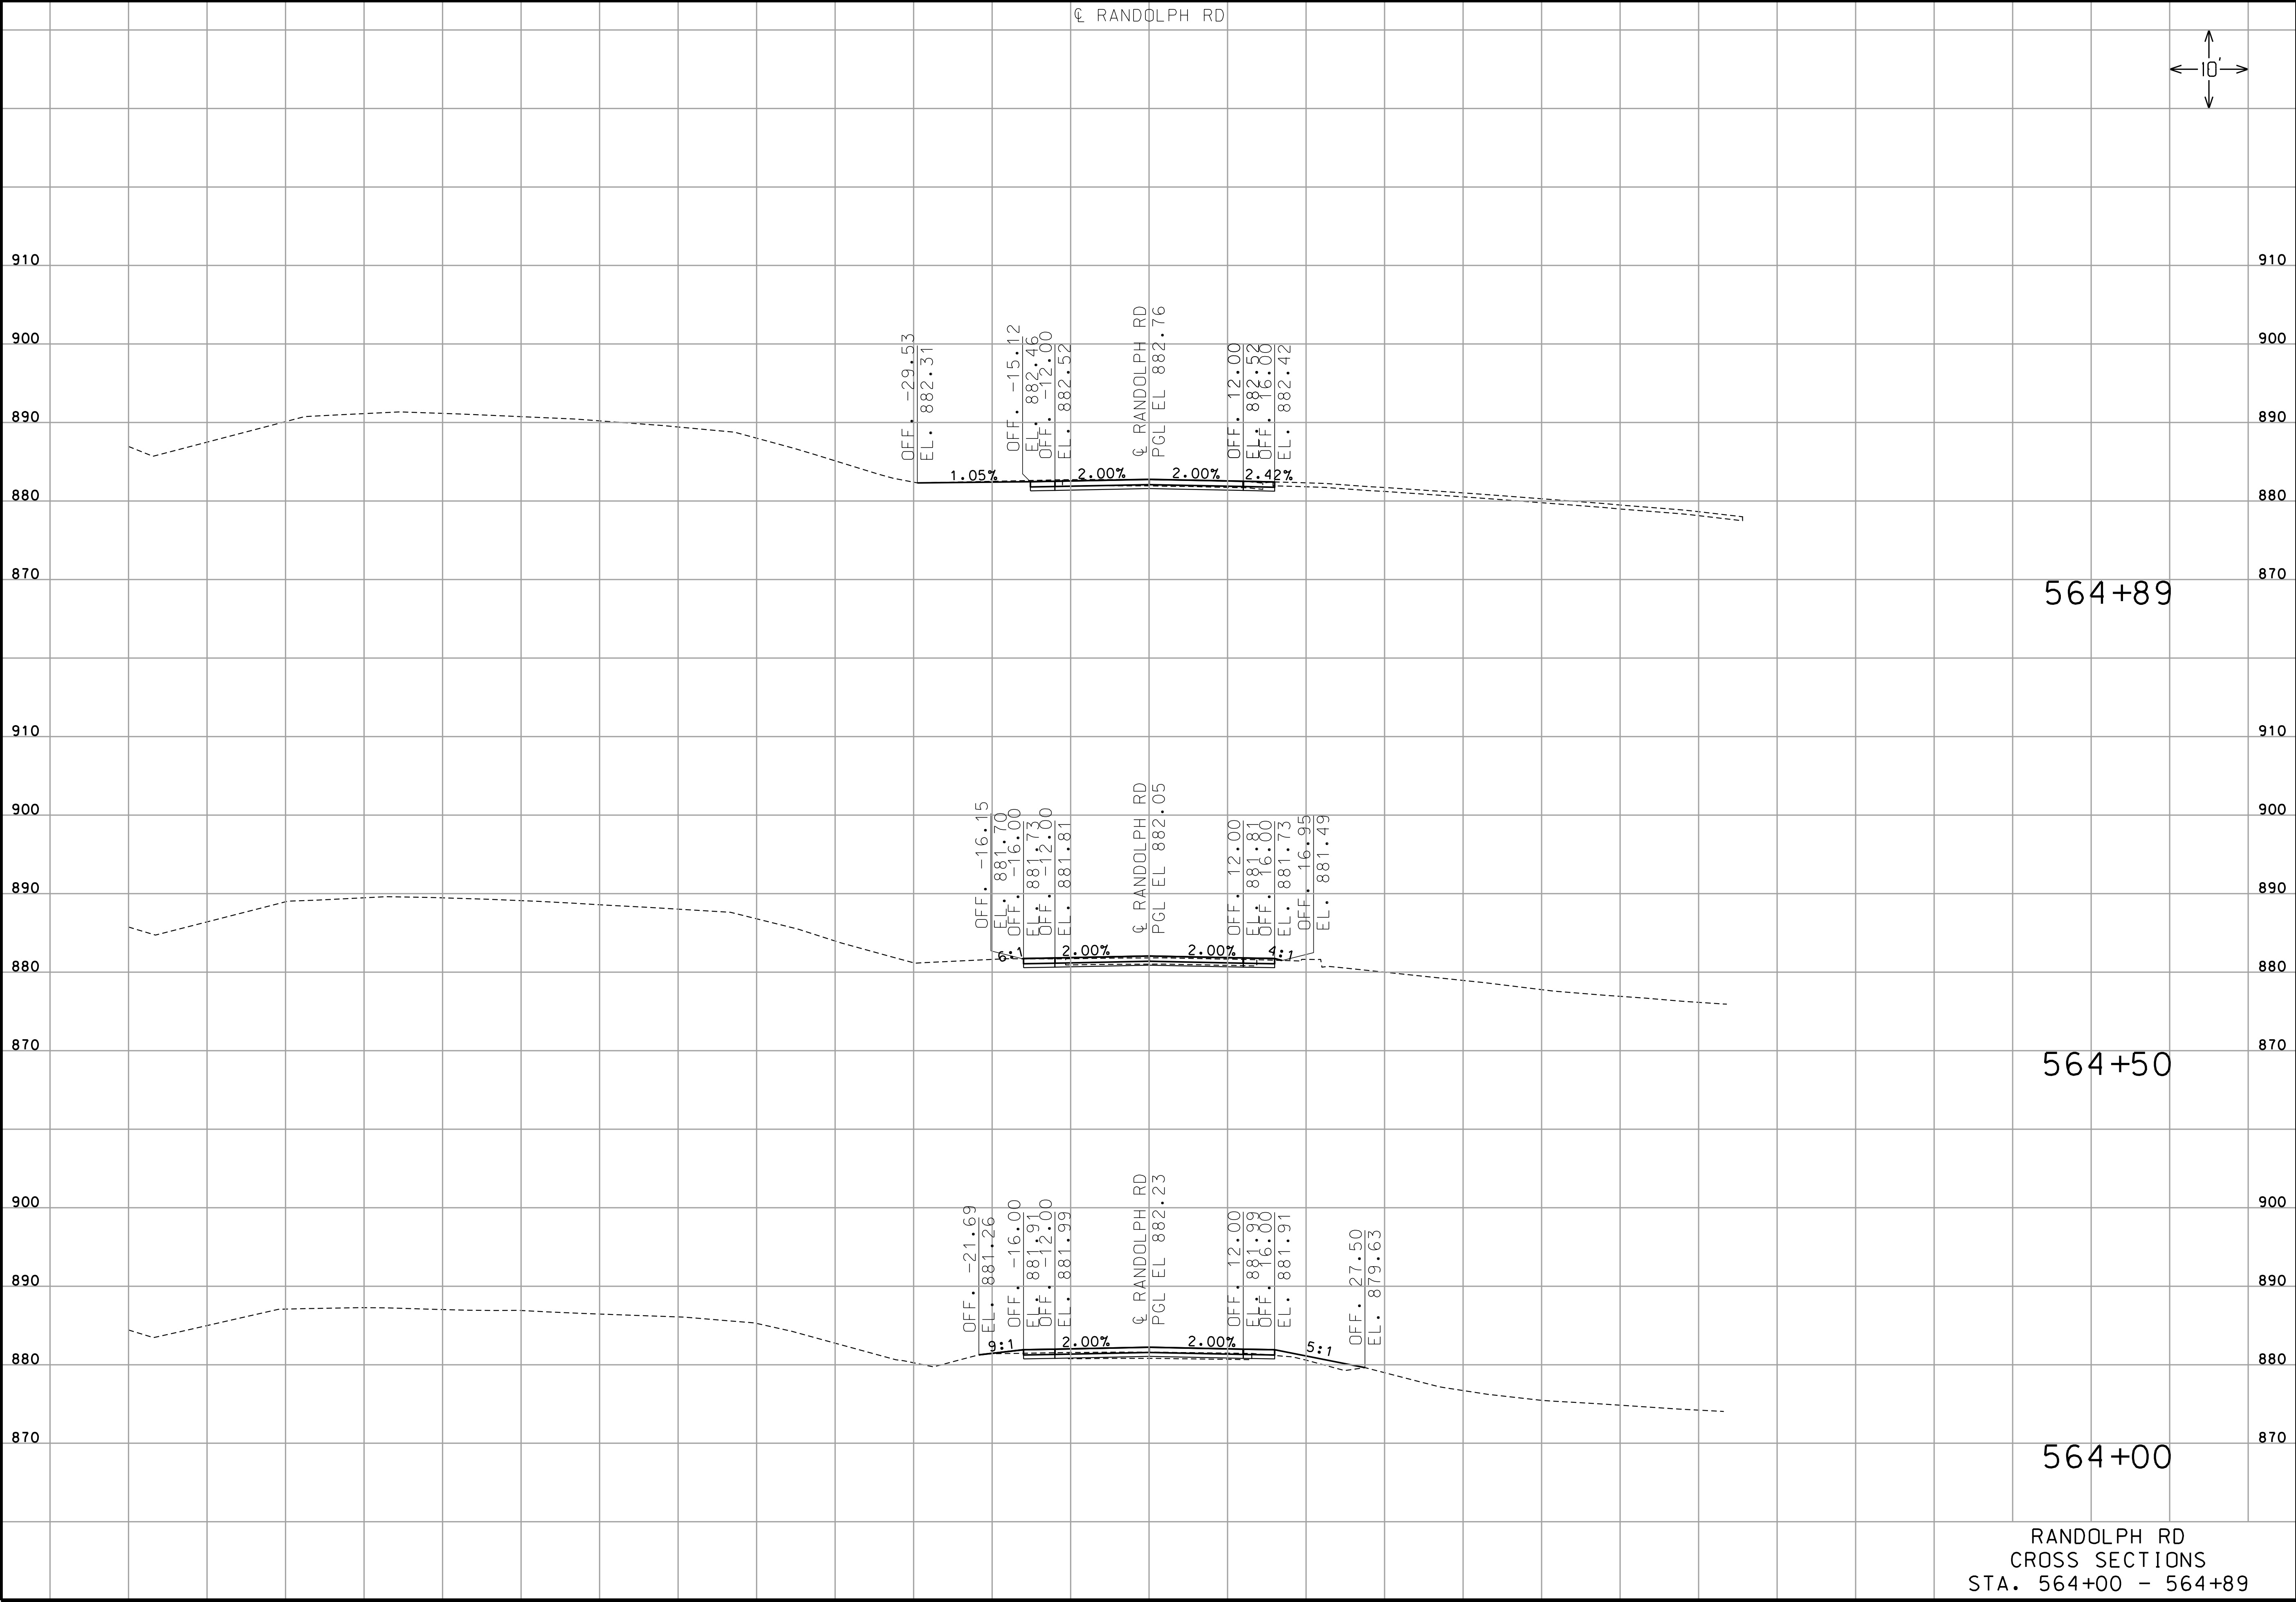

"THIS MEDIA SHOULD NOT BE CONSIDERED A CERTIFIED DOCUMENT."

DATE PREPARED 6/12/2020	
ROUTE 53RD	STATE MO
DISTRICT KC	SHEET NO. 10
COUNTY CLAY	
JOB NO. J453386	
CONTRACT ID.	
PROJECT NO.	
BRIDGE NO. A8931	

DATE	DESCRIPTION

MISSOURI HIGHWAYS AND TRANSPORTATION COMMISSION




105 WEST CAPITAL
JEFFERSON CITY, MO 65102
1-888-ASK-MODOT (1-888-275-6636)

GARVER, LLC.
7410 NW TIFFANY SPRINGS
PARKWAY, SUITE 200
KANSAS CITY, MO 64153
PHONE: (816) 298-6465
CERTIFICATE OF AUTHORITY
NO. 2008013090

RANDOLPH RD
CROSS SECTIONS
STA. 564+00 - 564+89

IF A SEAL IS PRESENT ON THIS SHEET IT HAS BEEN ELECTRONICALLY SEALED AND DATED.

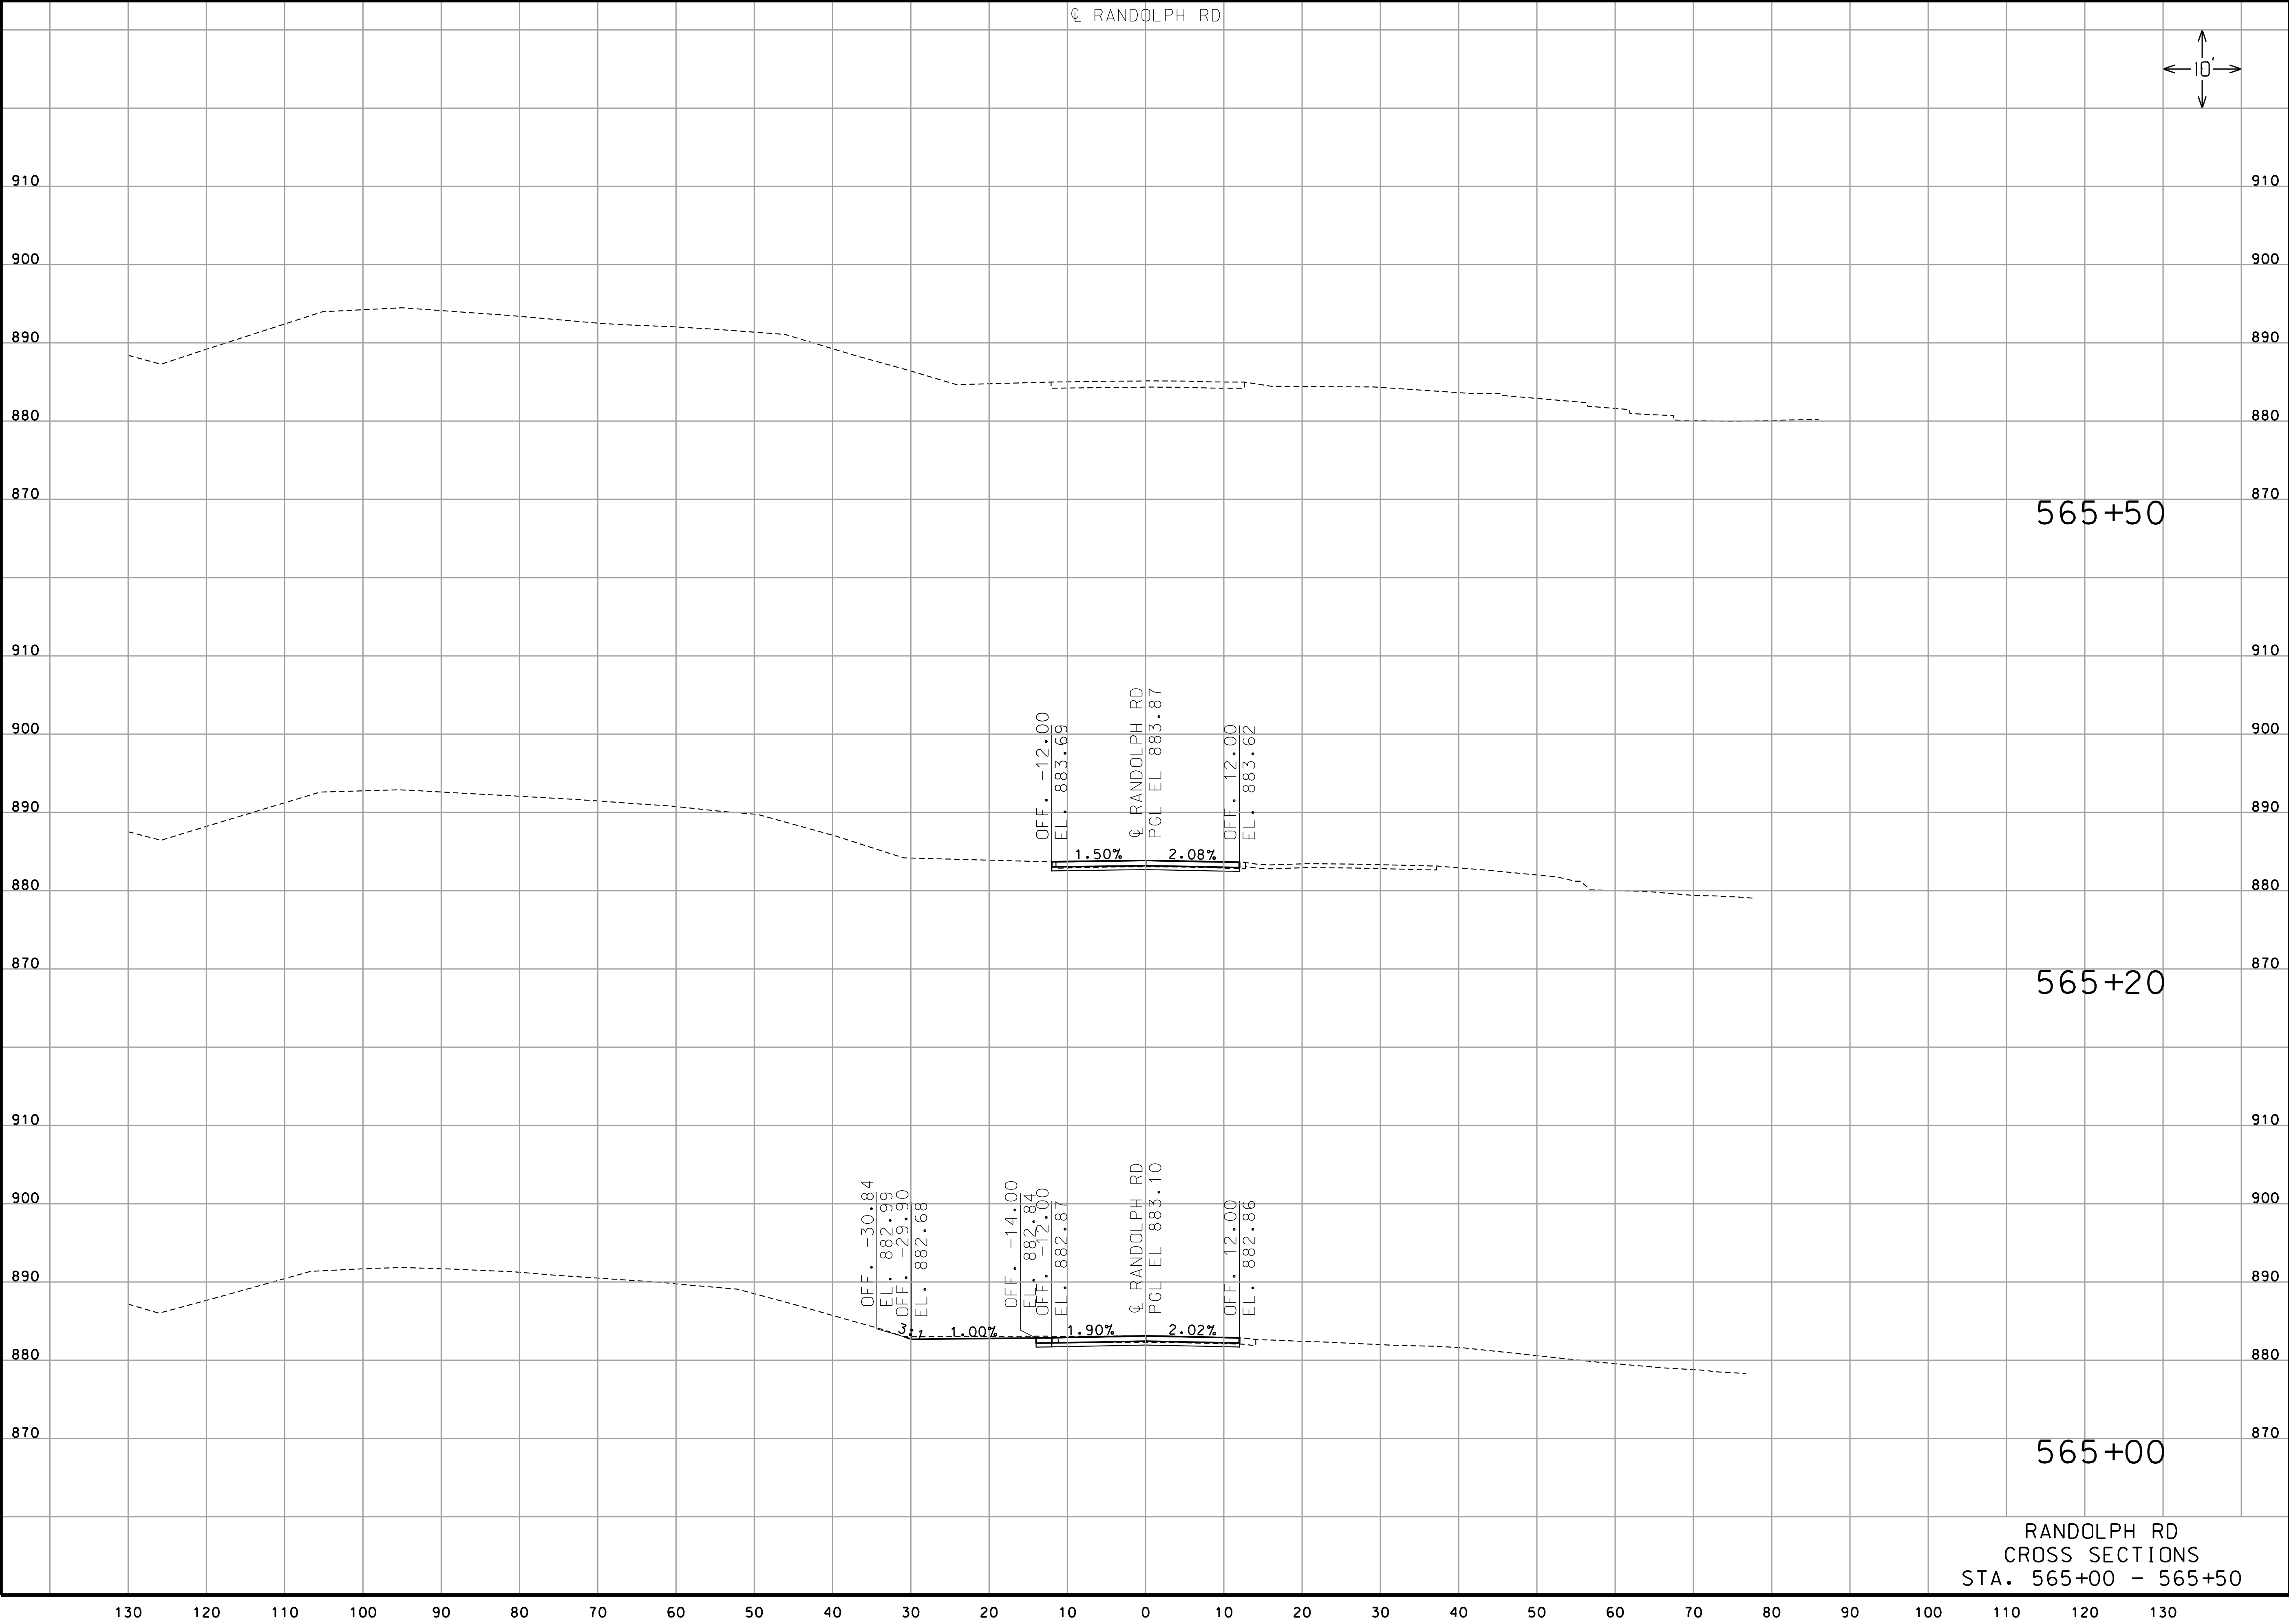

"THIS MEDIA SHOULD NOT BE CONSIDERED A CERTIFIED DOCUMENT."

DATE PREPARED 6/12/2020	
ROUTE 53RD	STATE MO
DISTRICT KC	SHEET NO. 11
COUNTY CLAY	
JOB NO. J453386	
CONTRACT ID.	
PROJECT NO.	
BRIDGE NO. A8931	

DESCRIPTION	DATE

MISSOURI HIGHWAYS AND TRANSPORTATION COMMISSION





105 WEST CAPITAL
JEFFERSON CITY, MO 65102
1-888-ASK-MODOT (1-888-275-6636)

GARVER, LLC.
7410 NW TIFFANY SPRINGS
PARKWAY, SUITE 200
KANSAS CITY, MO 64153
PHONE: (816) 298-6465
CERTIFICATE OF AUTHORITY
NO. 2008013090

RANDOLPH RD
CROSS SECTIONS
STA. 565+00 - 565+50

IF A SEAL IS PRESENT ON THIS SHEET IT HAS BEEN ELECTRONICALLY SEALED AND DATED.

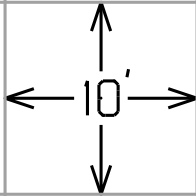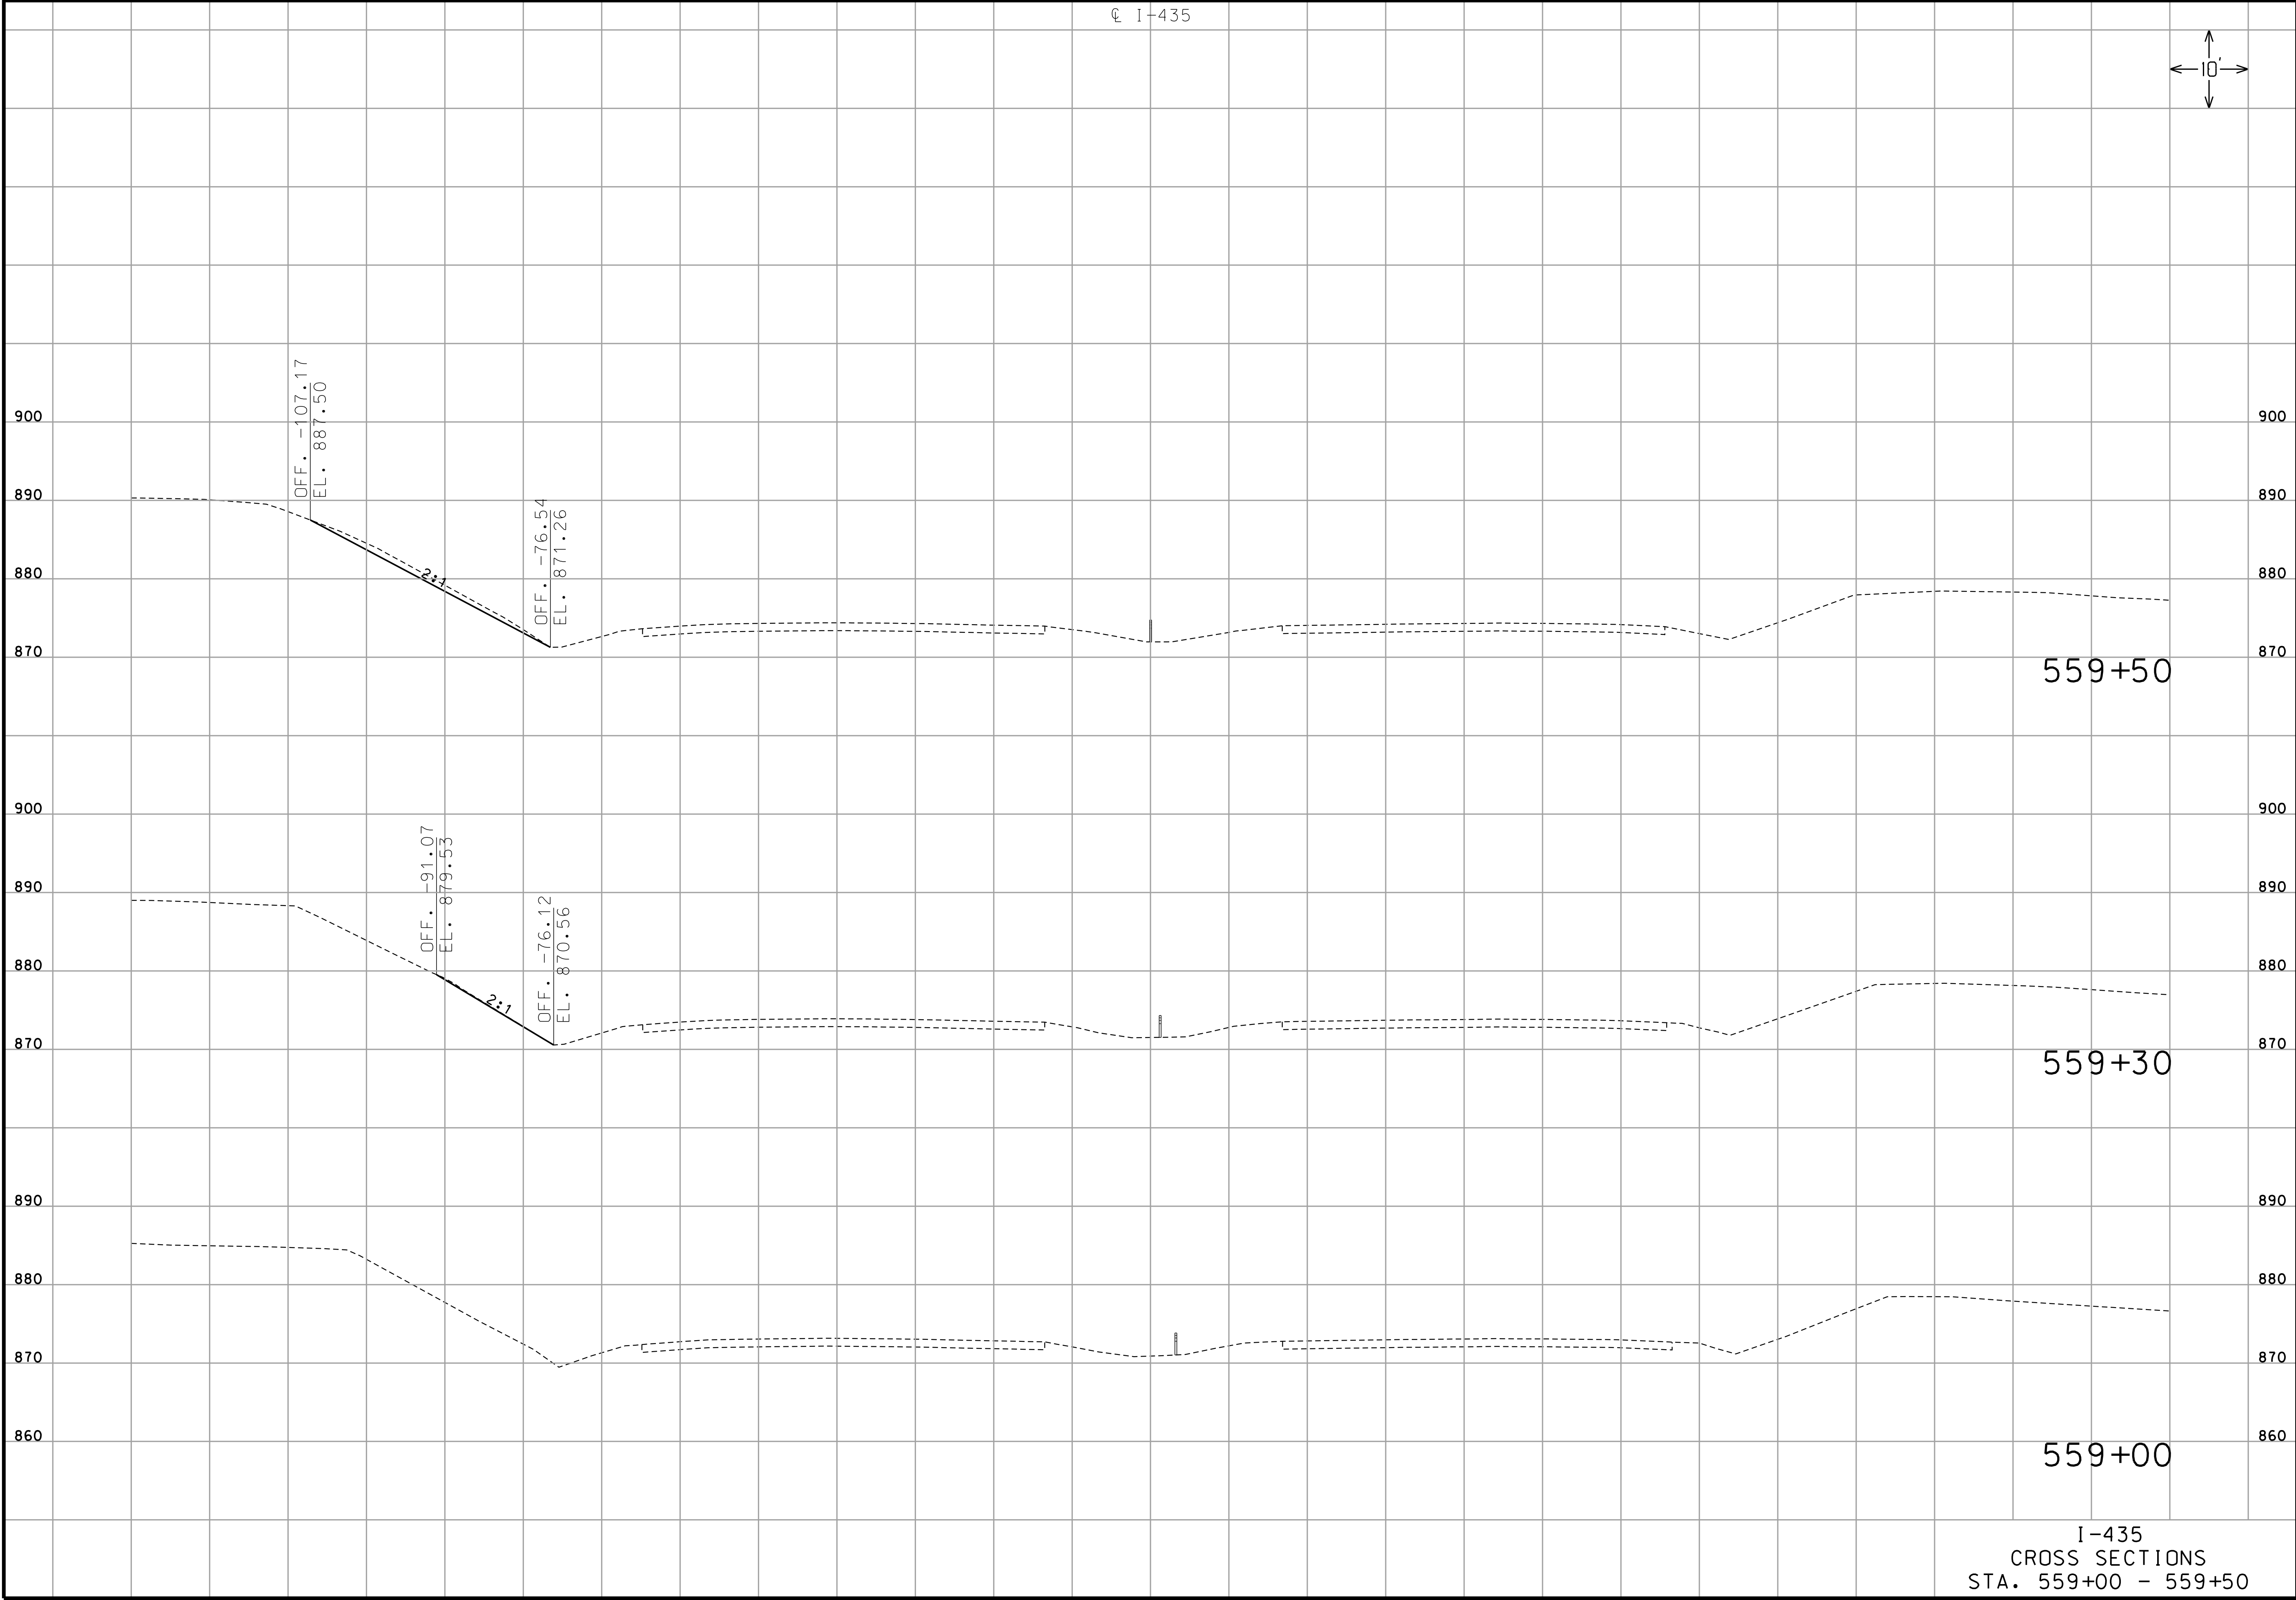

"THIS MEDIA SHOULD NOT BE CONSIDERED A CERTIFIED DOCUMENT."


DATE PREPARED 6/12/2020	
ROUTE 53RD	STATE MO
DISTRICT KC	SHEET NO. 12
COUNTY CLAY	
JOB NO. J453386	
CONTRACT ID.	
PROJECT NO.	
BRIDGE NO. A8931	

DESCRIPTION	DATE


MISSOURI HIGHWAYS AND TRANSPORTATION COMMISSION

105 WEST CAPITOL
JEFFERSON CITY, MO 65102
1-888-ASK-MODOT (1-888-275-6636)

GARVER, LLC.
7410 NW TIFFANY SPRINGS
PARKWAY, SUITE 200
KANSAS CITY, MO 64153
PHONE: (816) 298-6465
CERTIFICATE OF AUTHORITY
NO. 2008013090

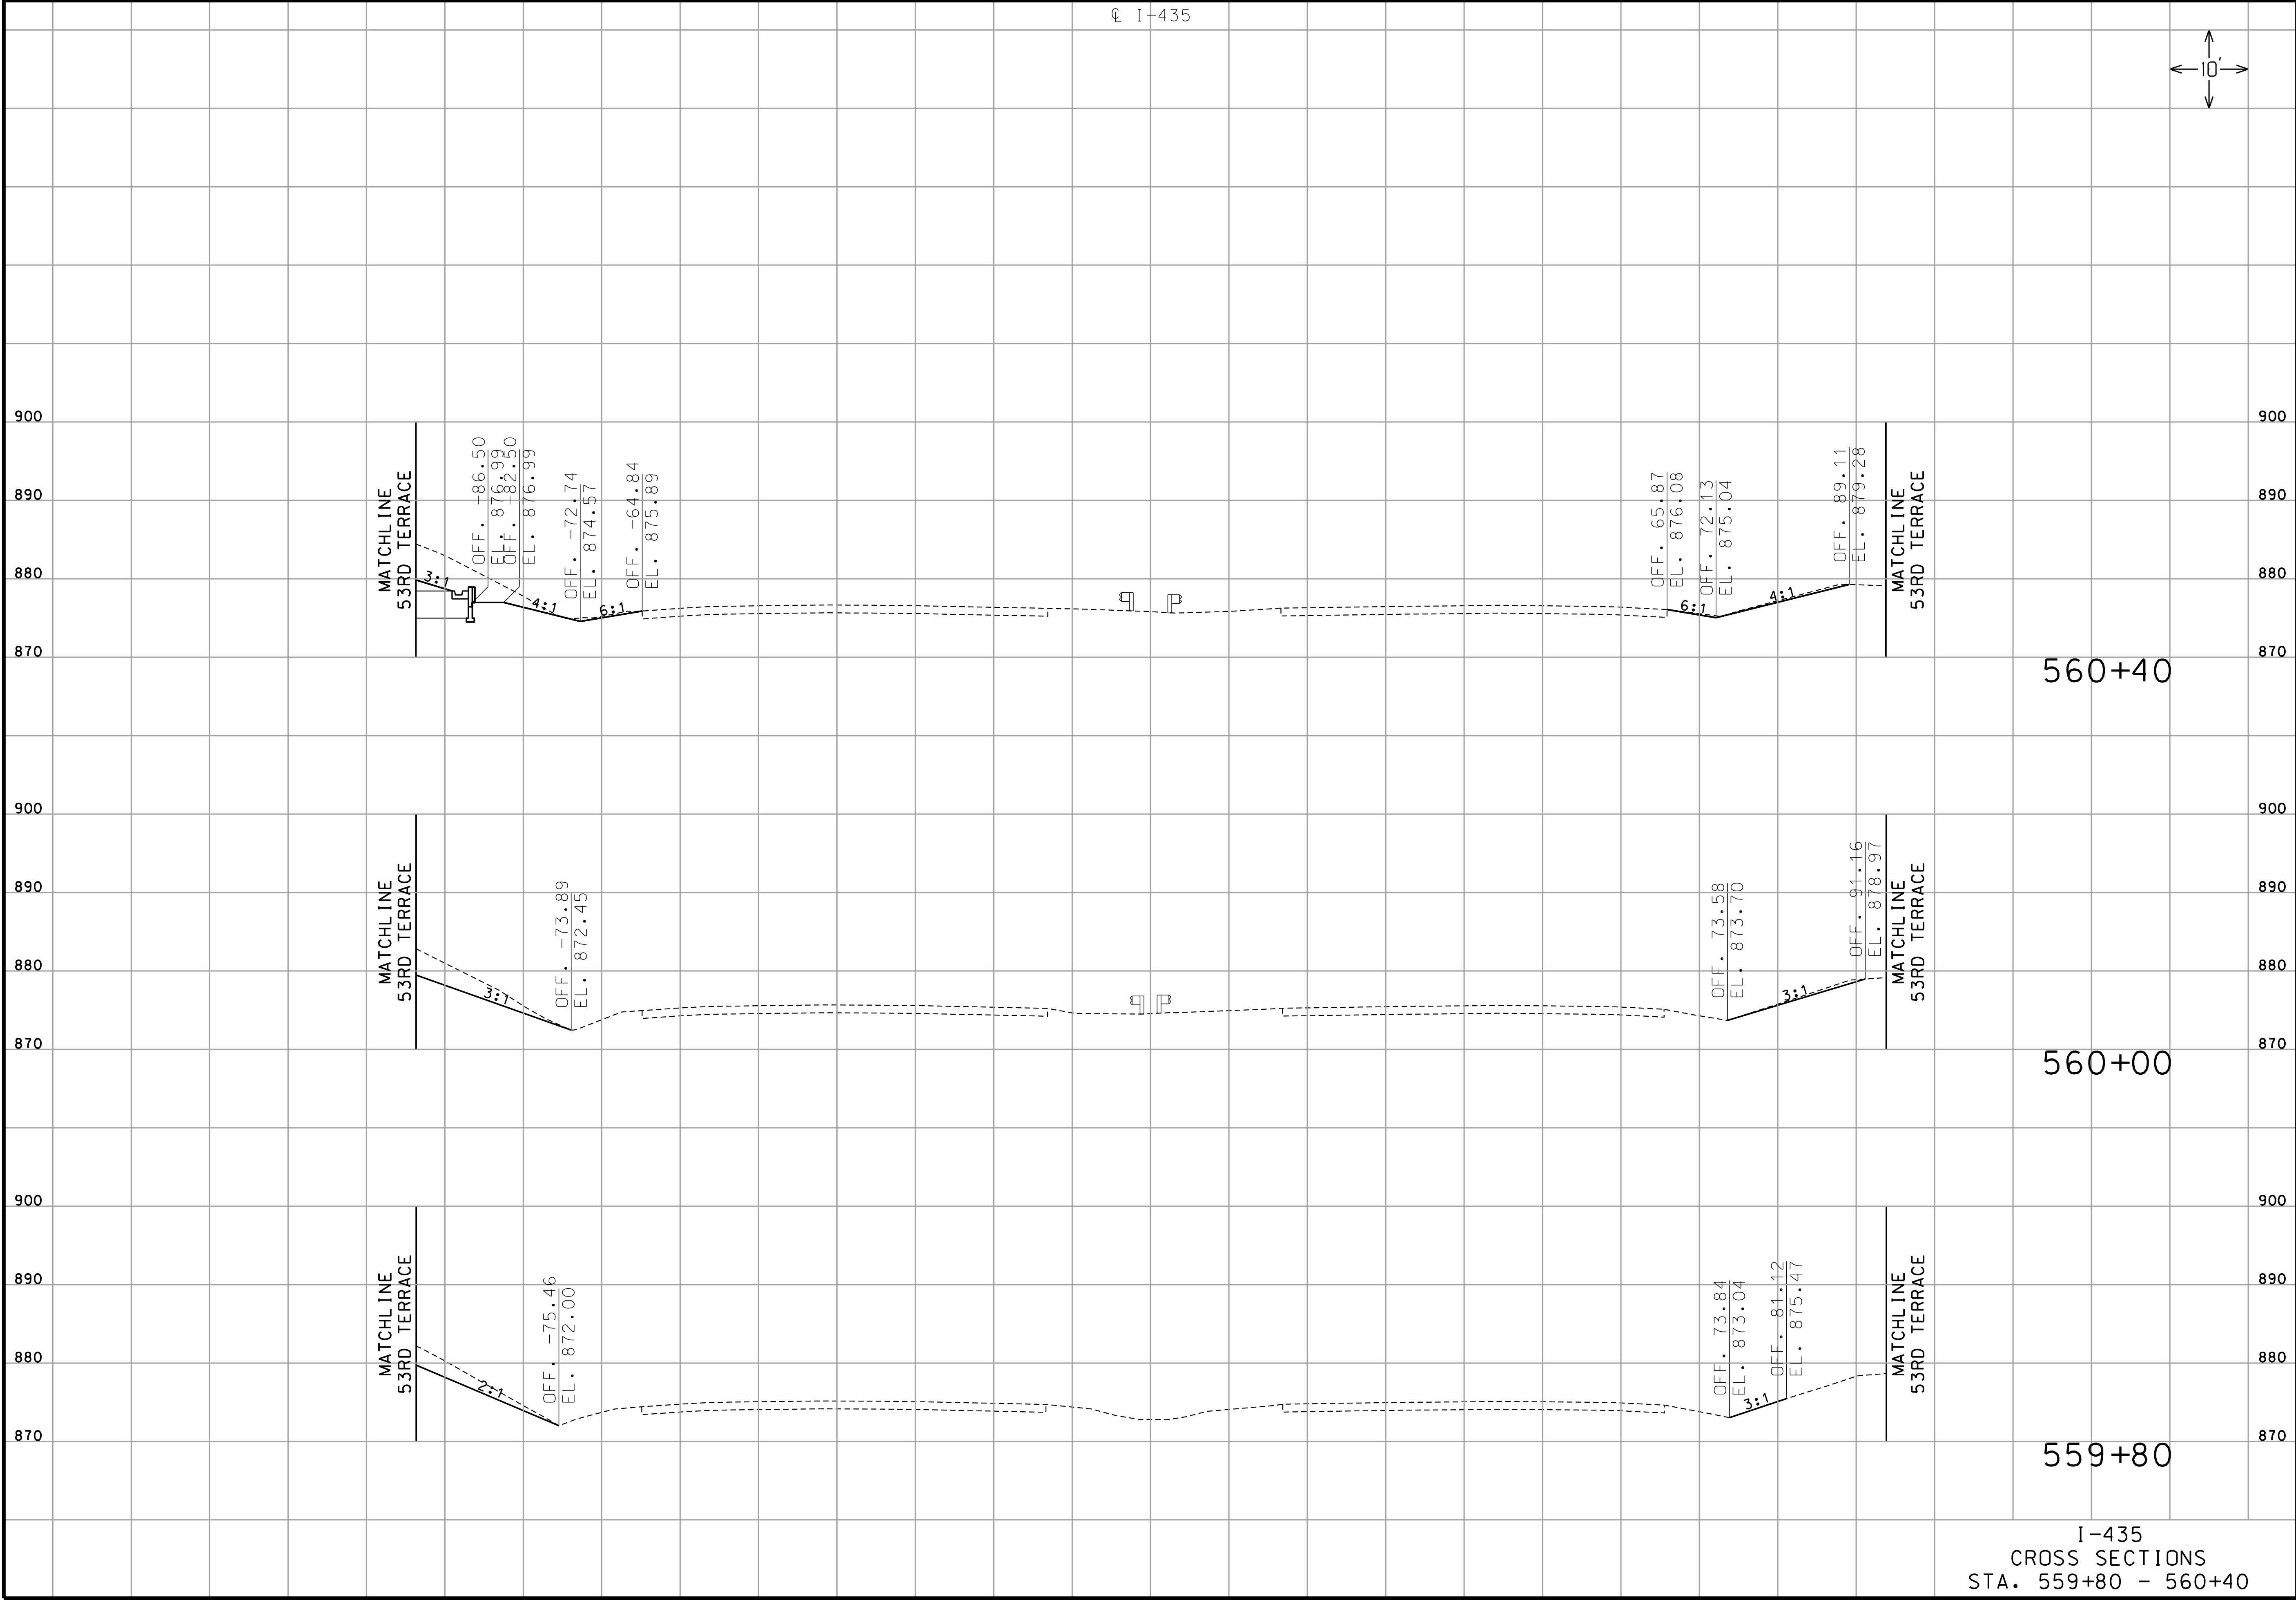

CL I-435

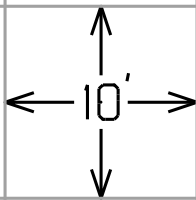

"THIS MEDIA SHOULD NOT BE CONSIDERED A CERTIFIED DOCUMENT."

DATE PREPARED 6/12/2020	
ROUTE 53RD	STATE MO
DISTRICT KC	SHEET NO. 13
COUNTY CLAY	
JOB NO. J453386	
CONTRACT ID.	
PROJECT NO.	
BRIDGE NO. A8931	


DATE	DESCRIPTION

MISSOURI HIGHWAYS AND TRANSPORTATION COMMISSION

105 WEST CAPITAL
JEFFERSON CITY, MO 65102
1-888-ASK-MODOT (1-888-275-6636)

GARVER, LLC.
7410 NW TIFFANY SPRINGS
PARKWAY, SUITE 200
KANSAS CITY, MO 64153
PHONE: (816) 298-6465
CERTIFICATE OF AUTHORITY
NO. 2008013090

I-435
CROSS SECTIONS
STA. 559+80 - 560+40

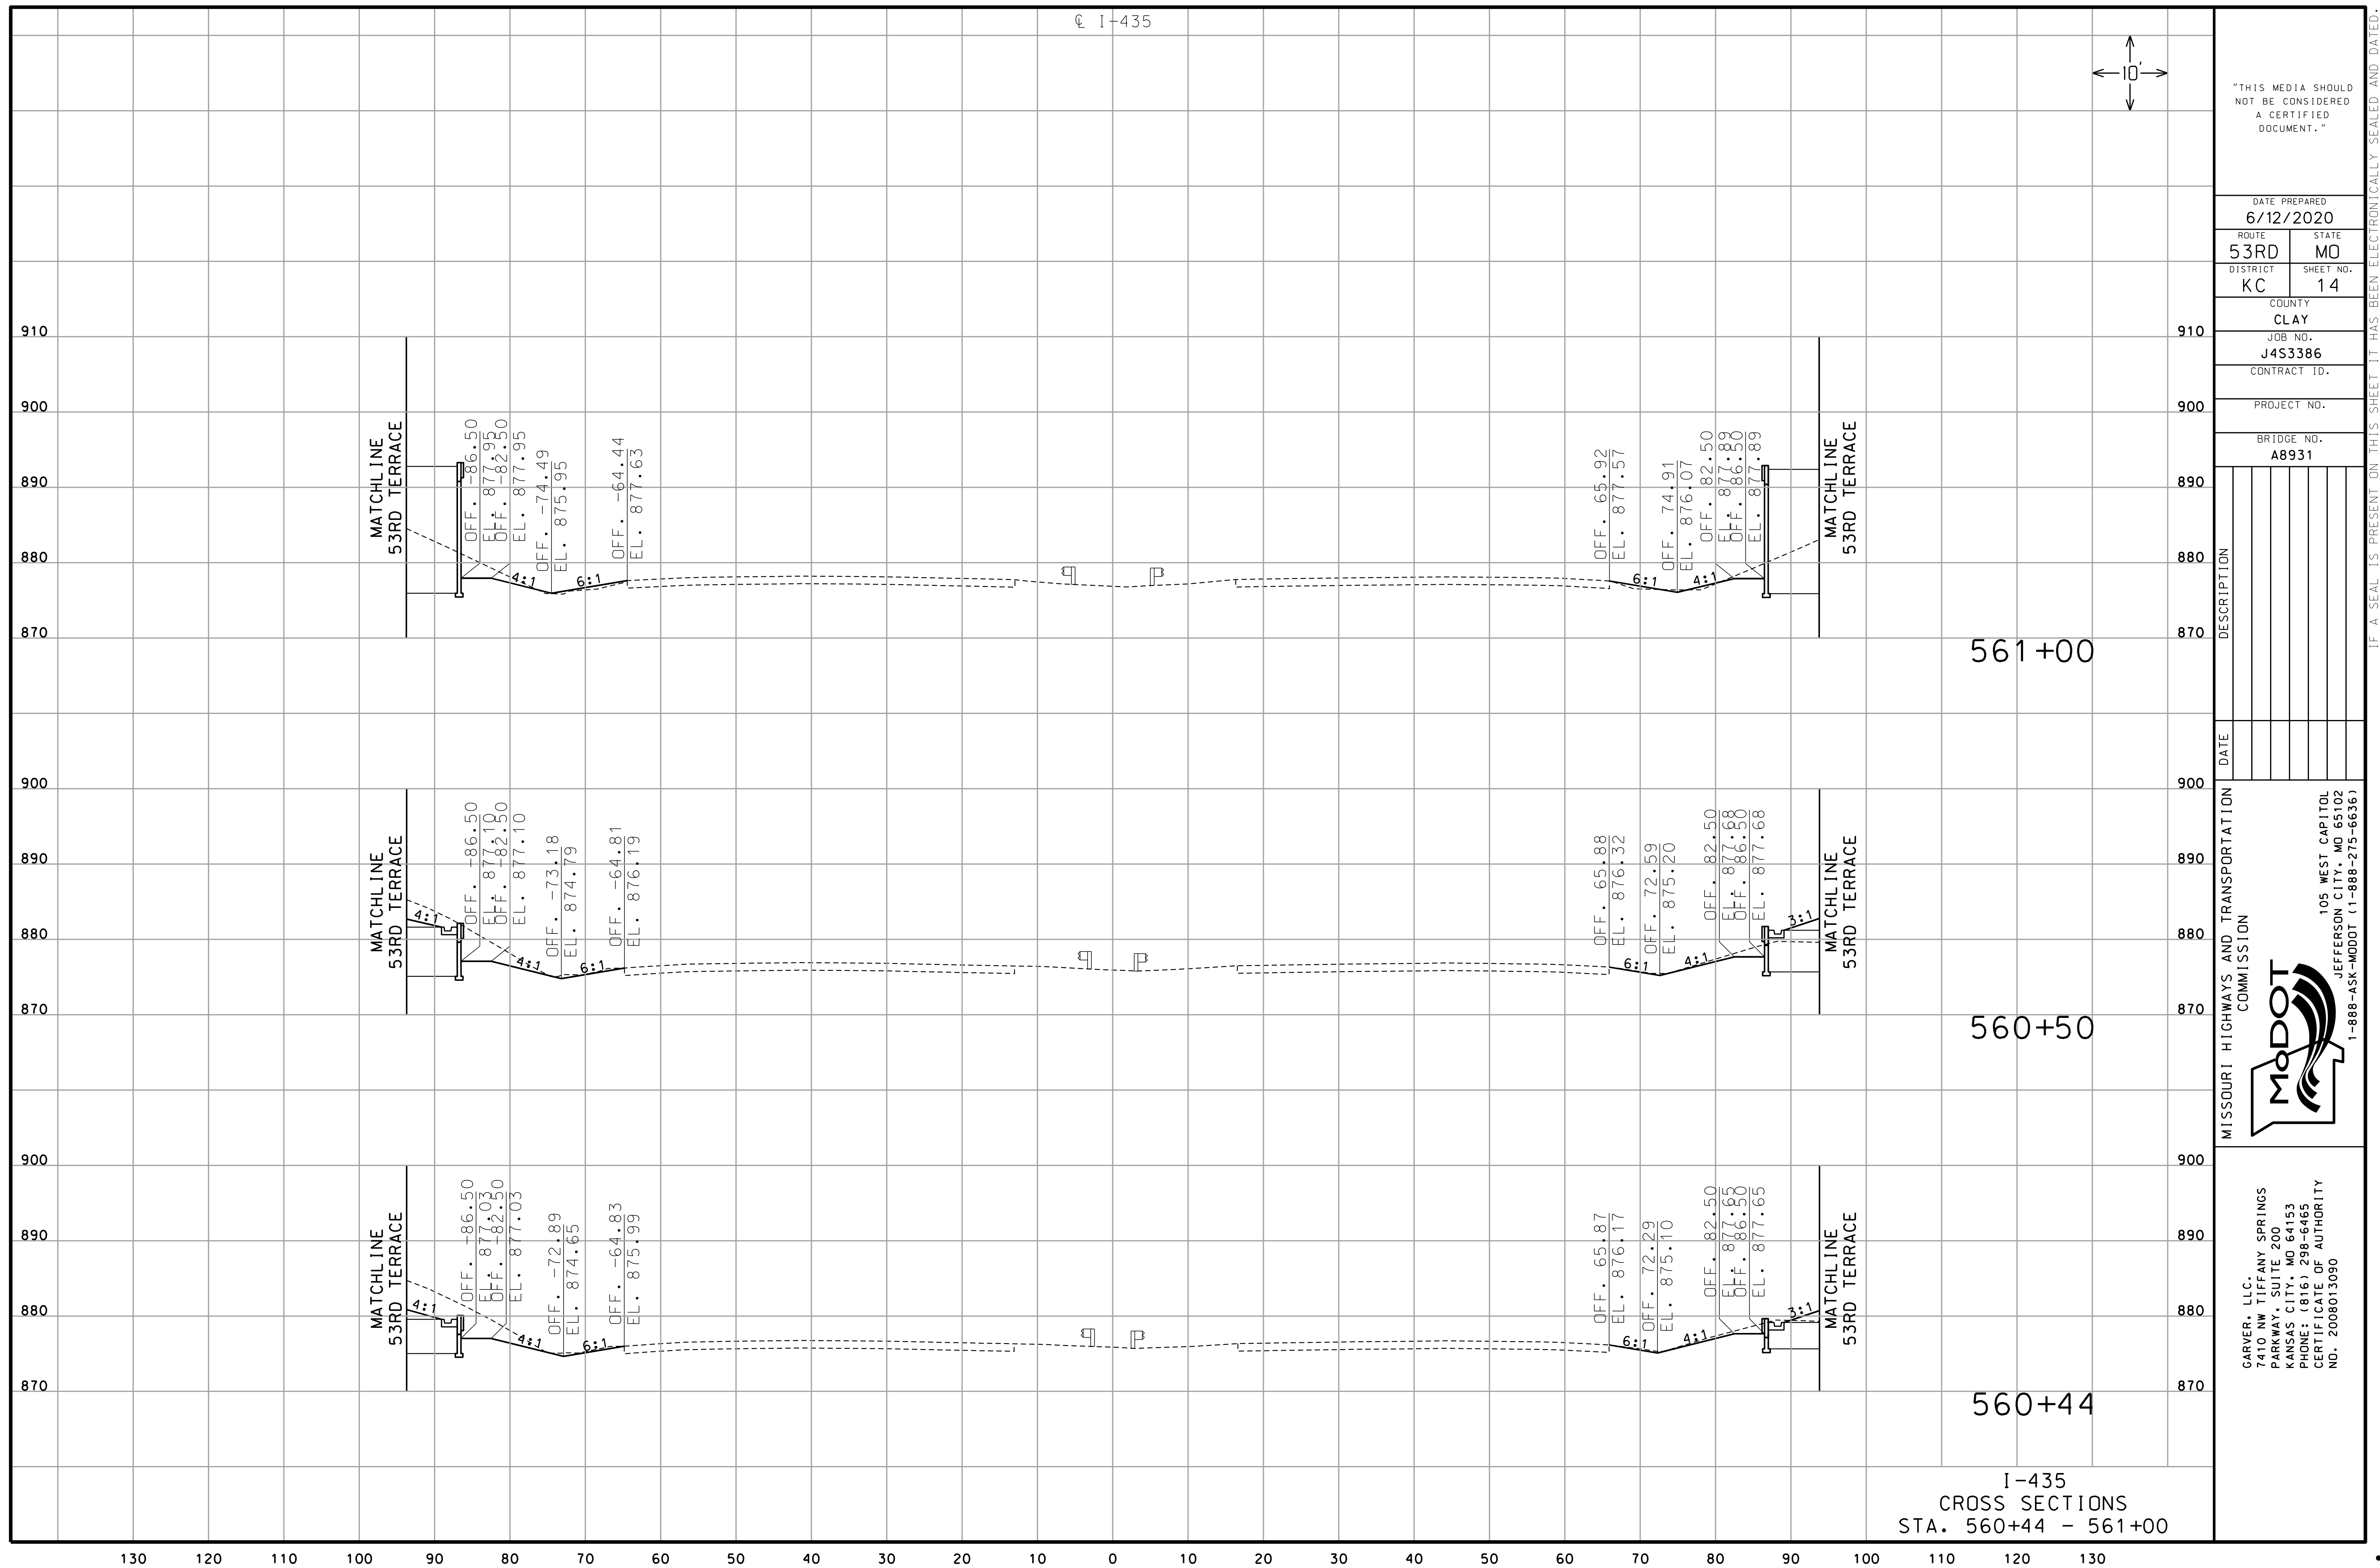

"THIS MEDIA SHOULD
NOT BE CONSIDERED
A CERTIFIED
DOCUMENT."

DATE PREPARED
0-1-78-000000

ROUTE	STATE
-------	-------

RICT	SHEET NO.
------	-----------

COUNTY


CLAT
LOB_NO

J4S3386

A8931


11

COMMISSION

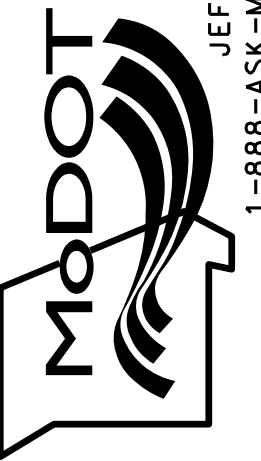

7410 NW TIFFANY SPRINGS
PARKWAY, SUITE 200
KANSAS CITY, MO 64153
PHONE: (816) 298-6465
CERTIFICATE OF AUTHORITY
NO. 2008013090

[illegible]

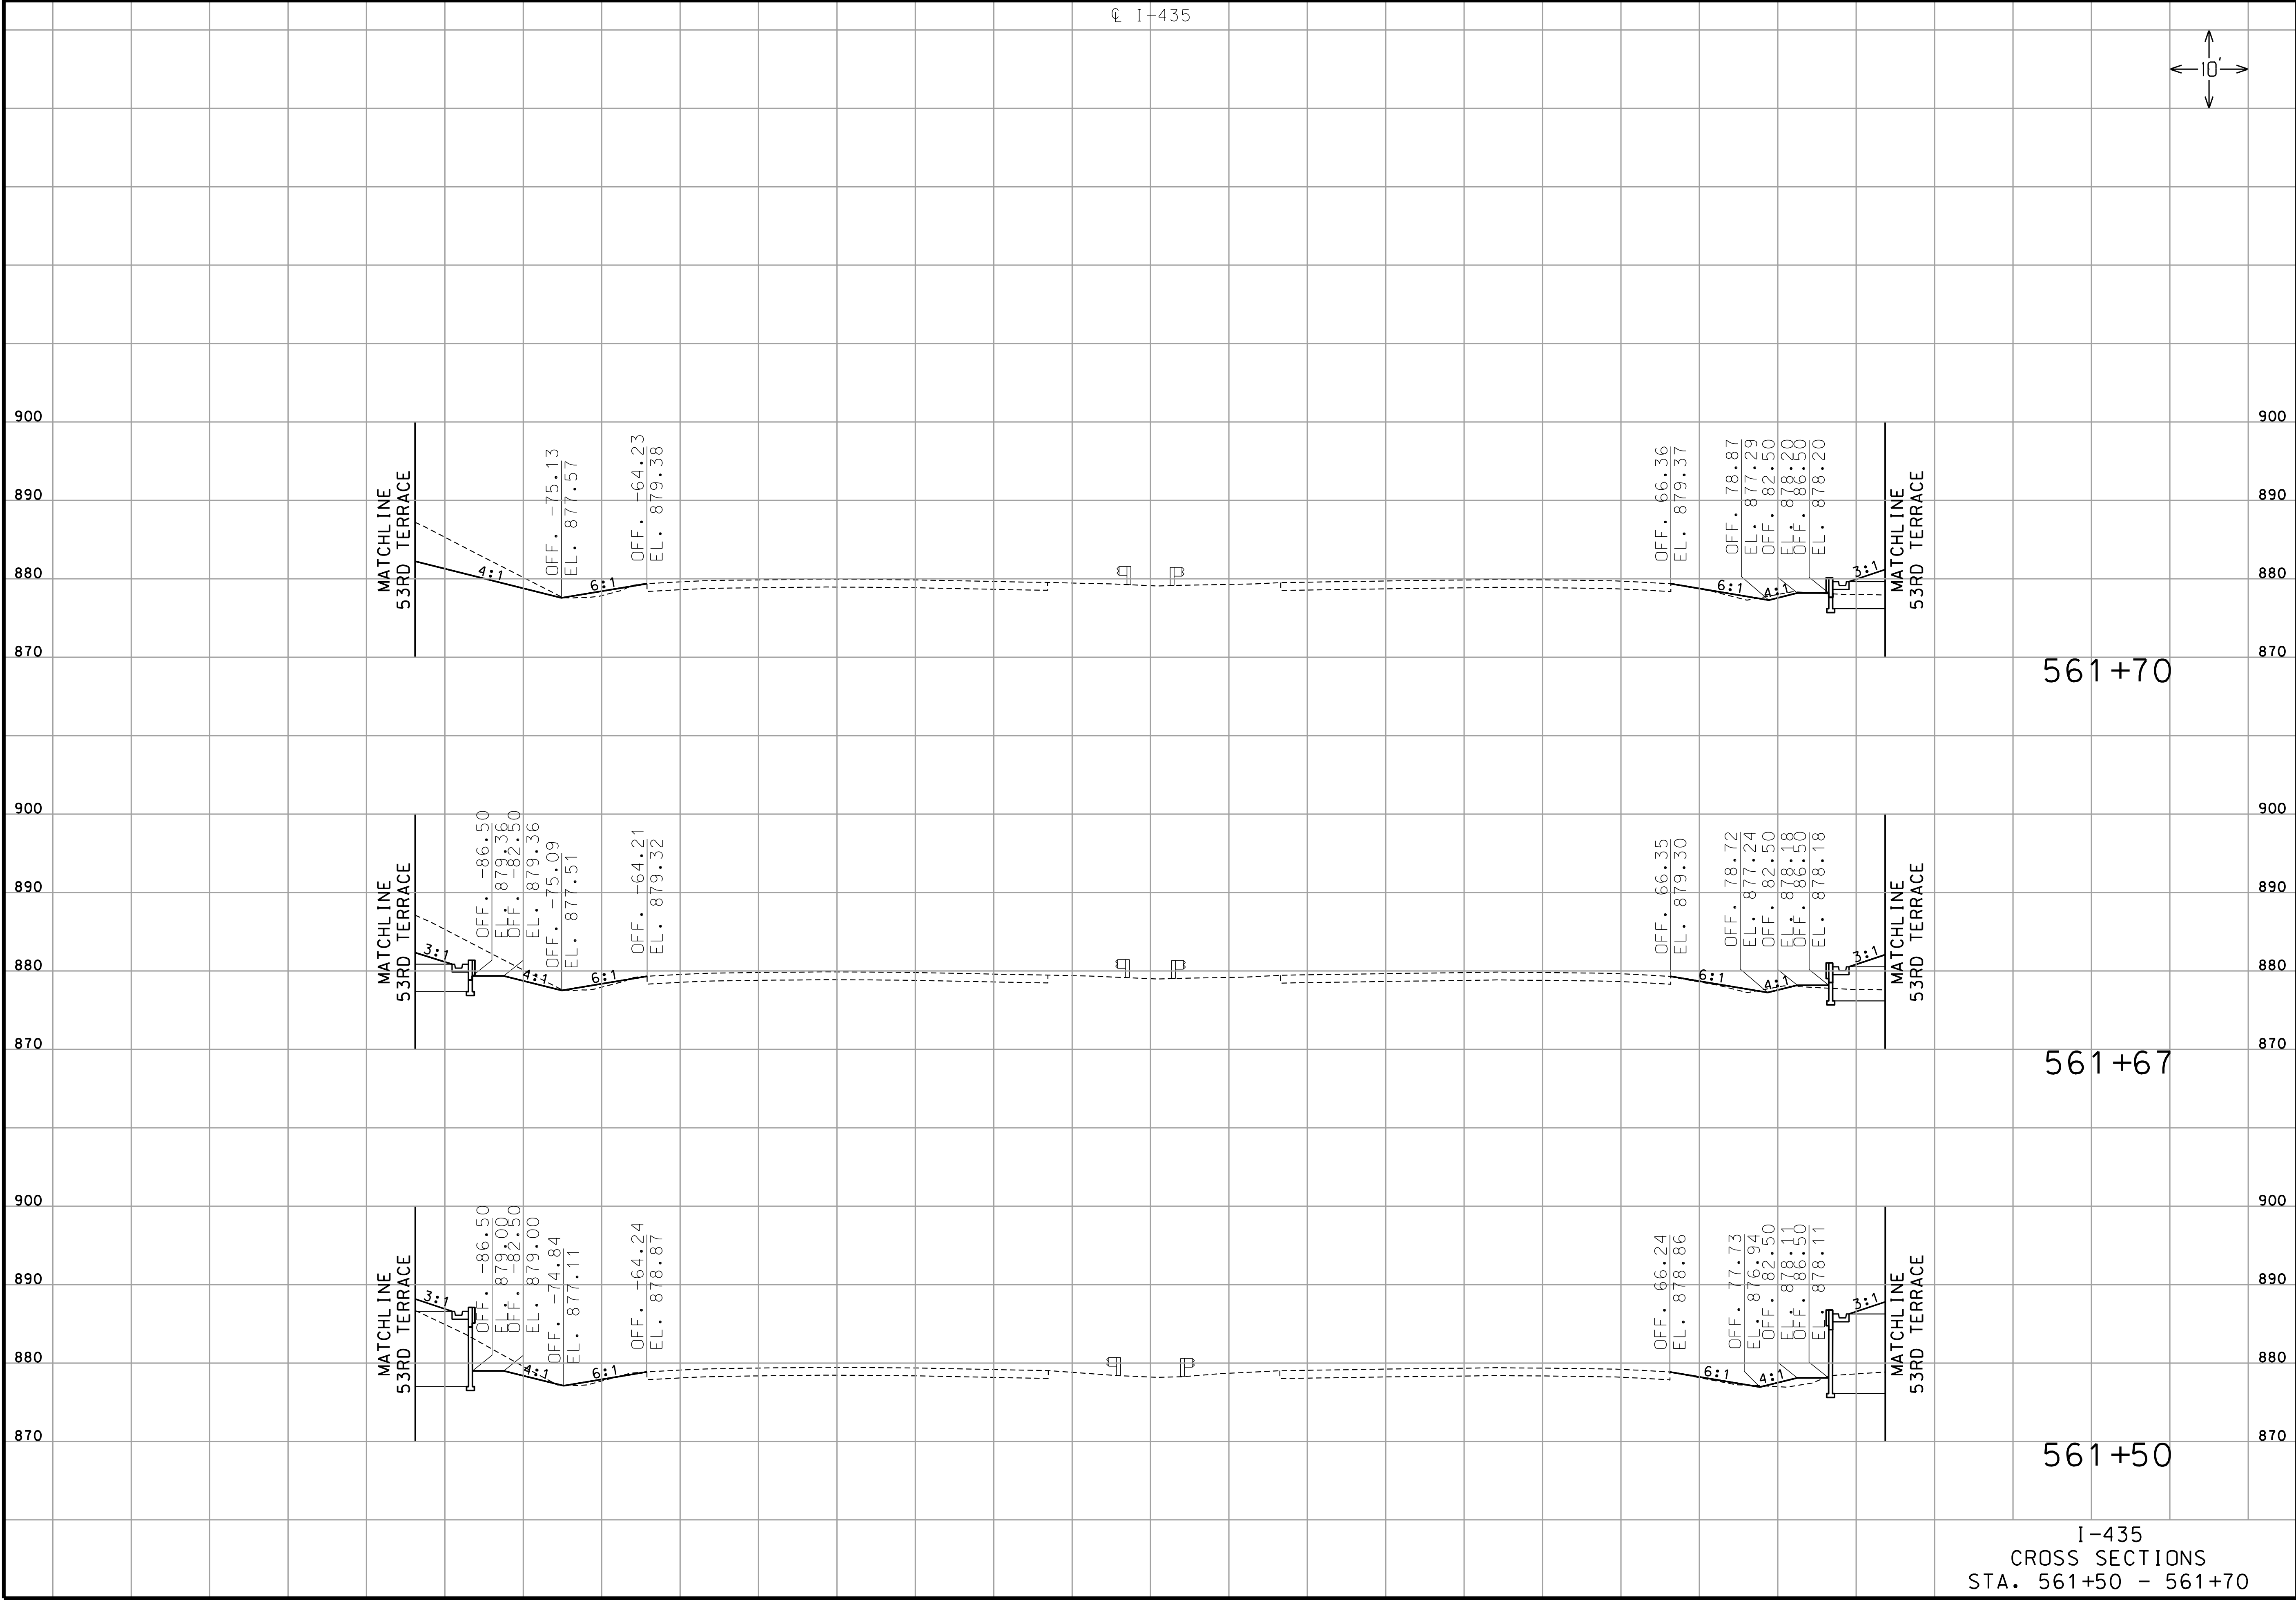

"THIS MEDIA SHOULD NOT BE CONSIDERED A CERTIFIED DOCUMENT."

DATE PREPARED 6/12/2020	
ROUTE 53RD	STATE MO
DISTRICT KC	SHEET NO. 15
COUNTY CLAY	
JOB NO. J453386	
CONTRACT ID.	
PROJECT NO.	
BRIDGE NO. A8931	

DATE	DESCRIPTION


MISSOURI HIGHWAYS AND TRANSPORTATION COMMISSION

105 WEST CAPITAL
JEFFERSON CITY, MO 65102
1-888-ASK-MODOT (1-888-275-6636)

GARVER, LLC.
7410 NW TIFFANY SPRINGS
PARKWAY, SUITE 200
KANSAS CITY, MO 64153
PHONE: (816) 298-6465
CERTIFICATE OF AUTHORITY
NO. 2008013090

I-435
CROSS SECTIONS
STA. 561+50 - 561+70

IF A SEAL IS PRESENT ON THIS SHEET IT HAS BEEN ELECTRONICALLY SEALED AND DATED.

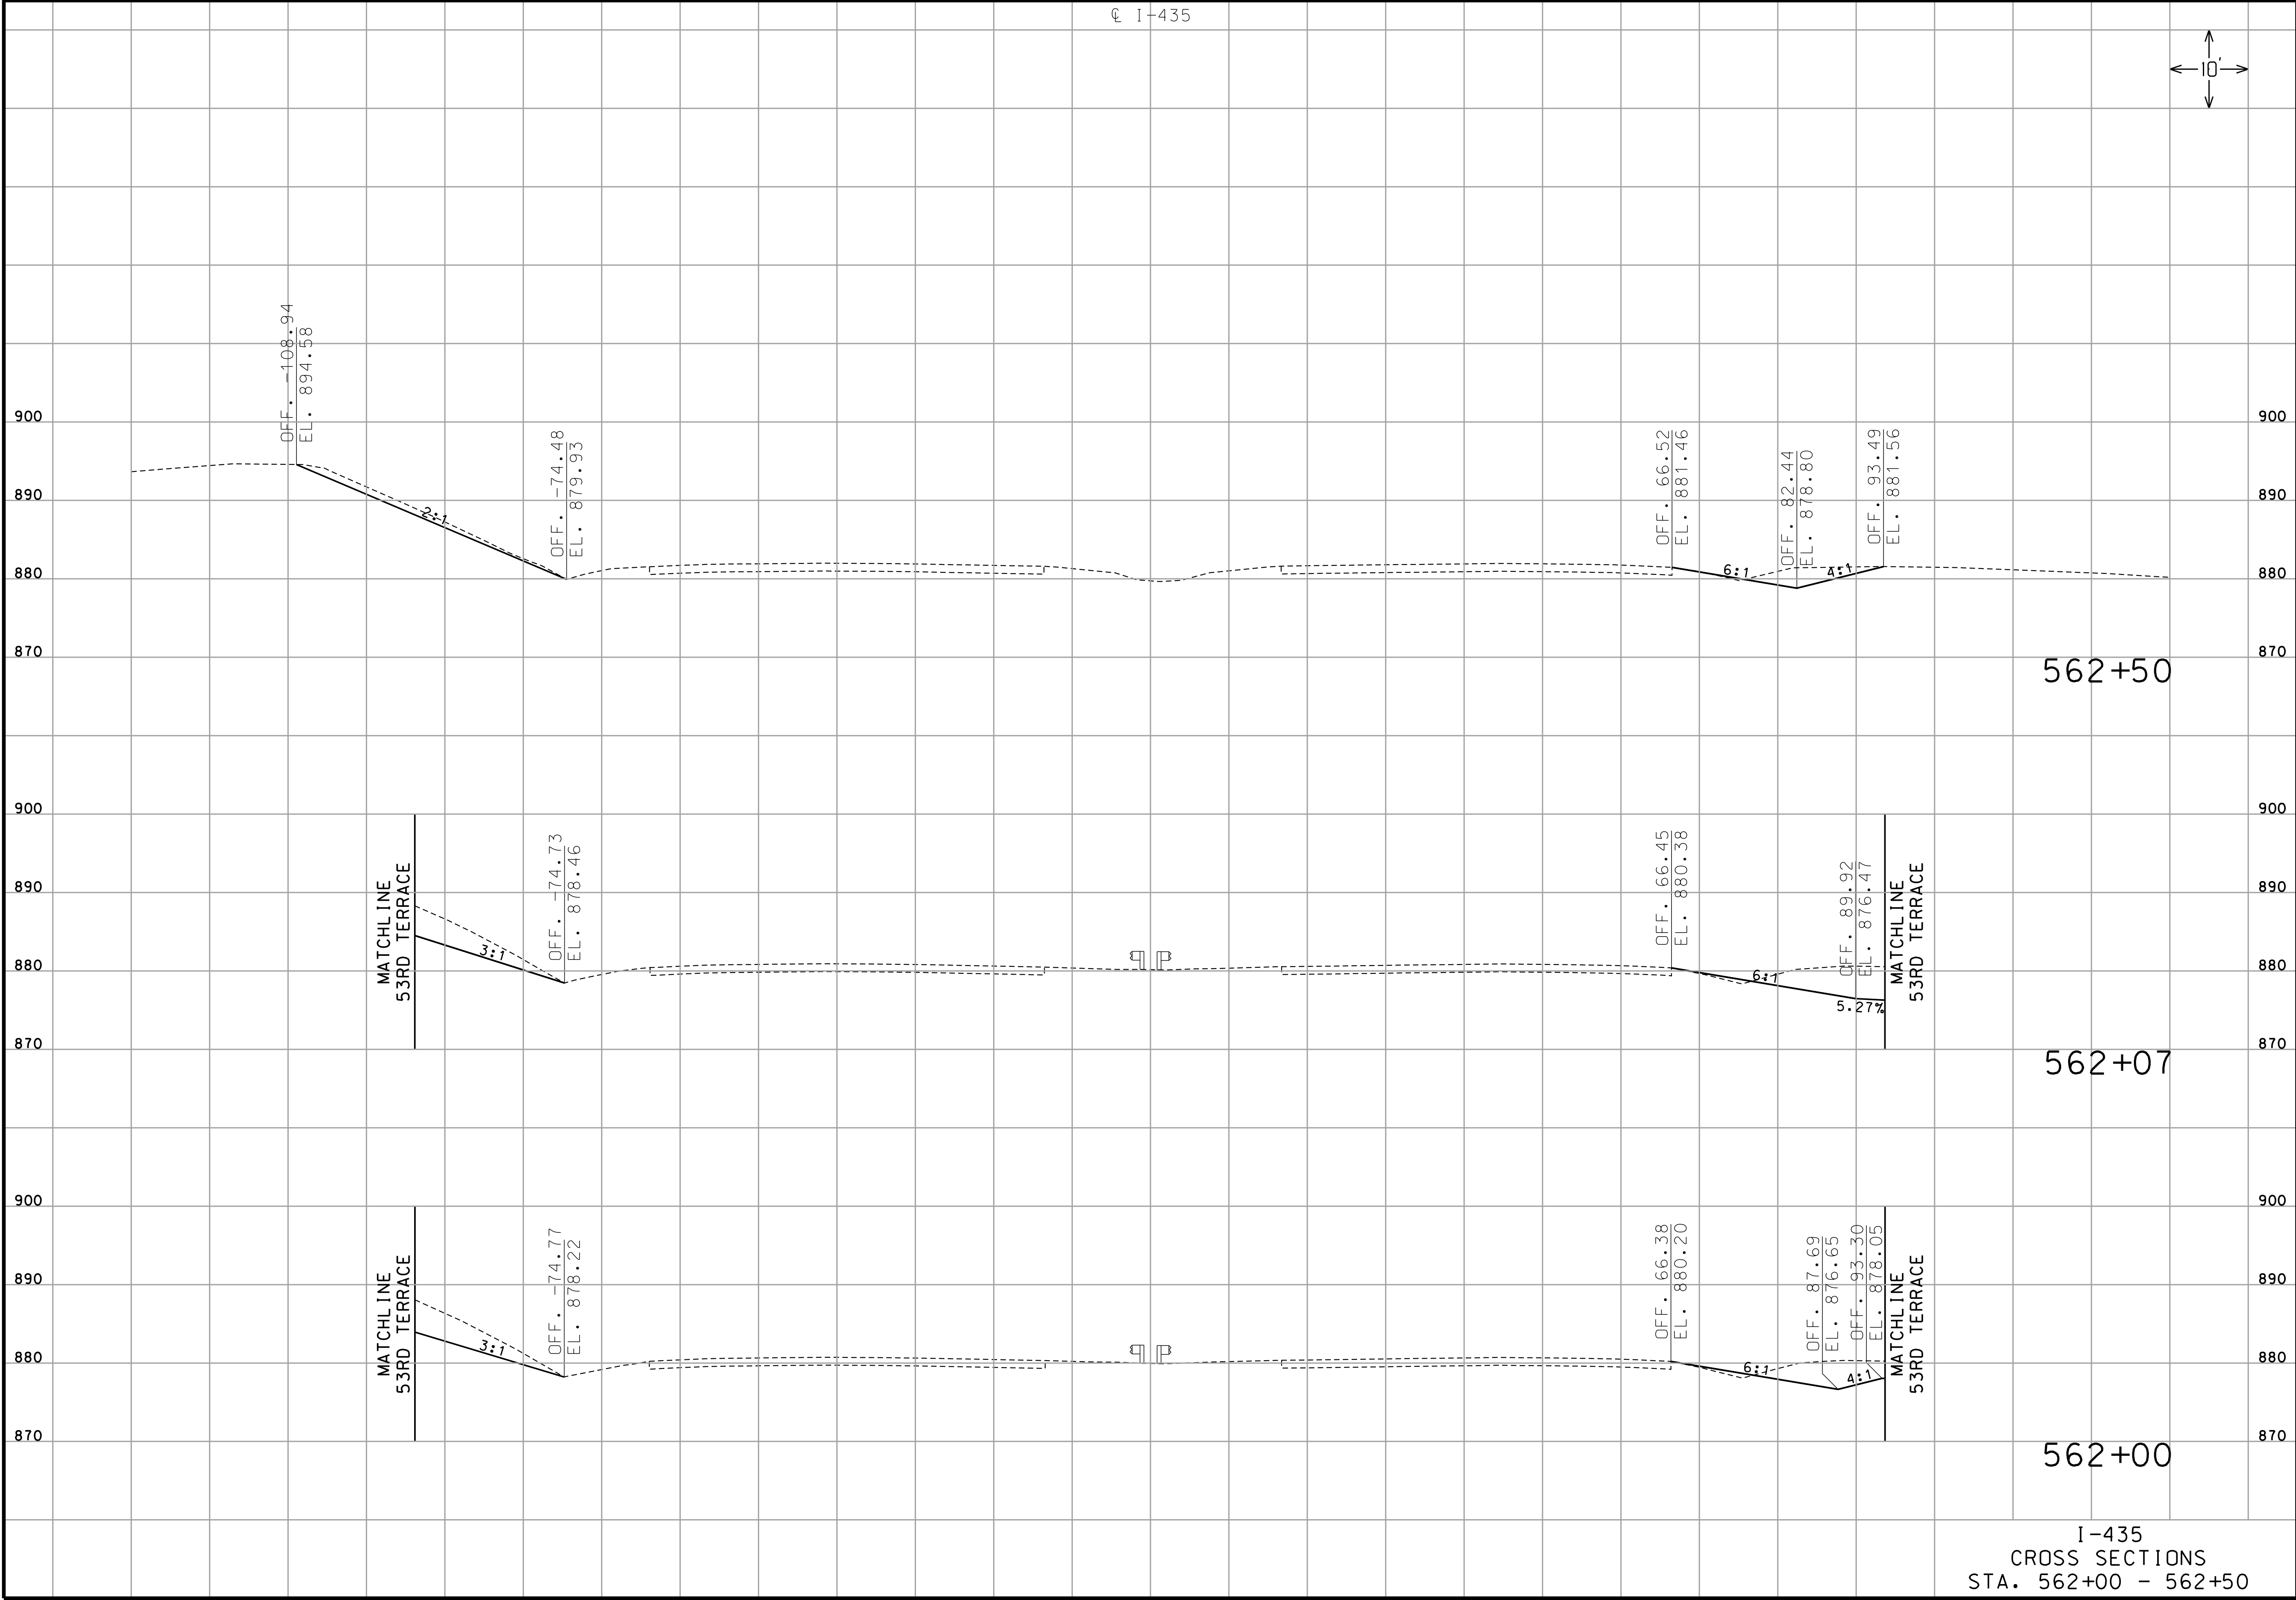

"THIS MEDIA SHOULD NOT BE CONSIDERED A CERTIFIED DOCUMENT."

DATE PREPARED 6/12/2020	
ROUTE 53RD	STATE MO
DISTRICT KC	SHEET NO. 16
COUNTY CLAY	
JOB NO. J453386	
CONTRACT ID.	
PROJECT NO.	
BRIDGE NO. A8931	

DATE	DESCRIPTION

MISSOURI HIGHWAYS AND TRANSPORTATION COMMISSION




105 WEST CAPITOL
JEFFERSON CITY, MO 65102
1-888-ASK-MODOT (1-888-275-6636)

GARVER, LLC.
7410 NW TIFFANY SPRINGS
PARKWAY, SUITE 200
KANSAS CITY, MO 64153
PHONE: (816) 298-6465
CERTIFICATE OF AUTHORITY
NO. 2008013090

I-435
CROSS SECTIONS
STA. 562+00 - 562+50

IF A SEAL IS PRESENT ON THIS SHEET IT HAS BEEN ELECTRONICALLY SEALED AND DATED.

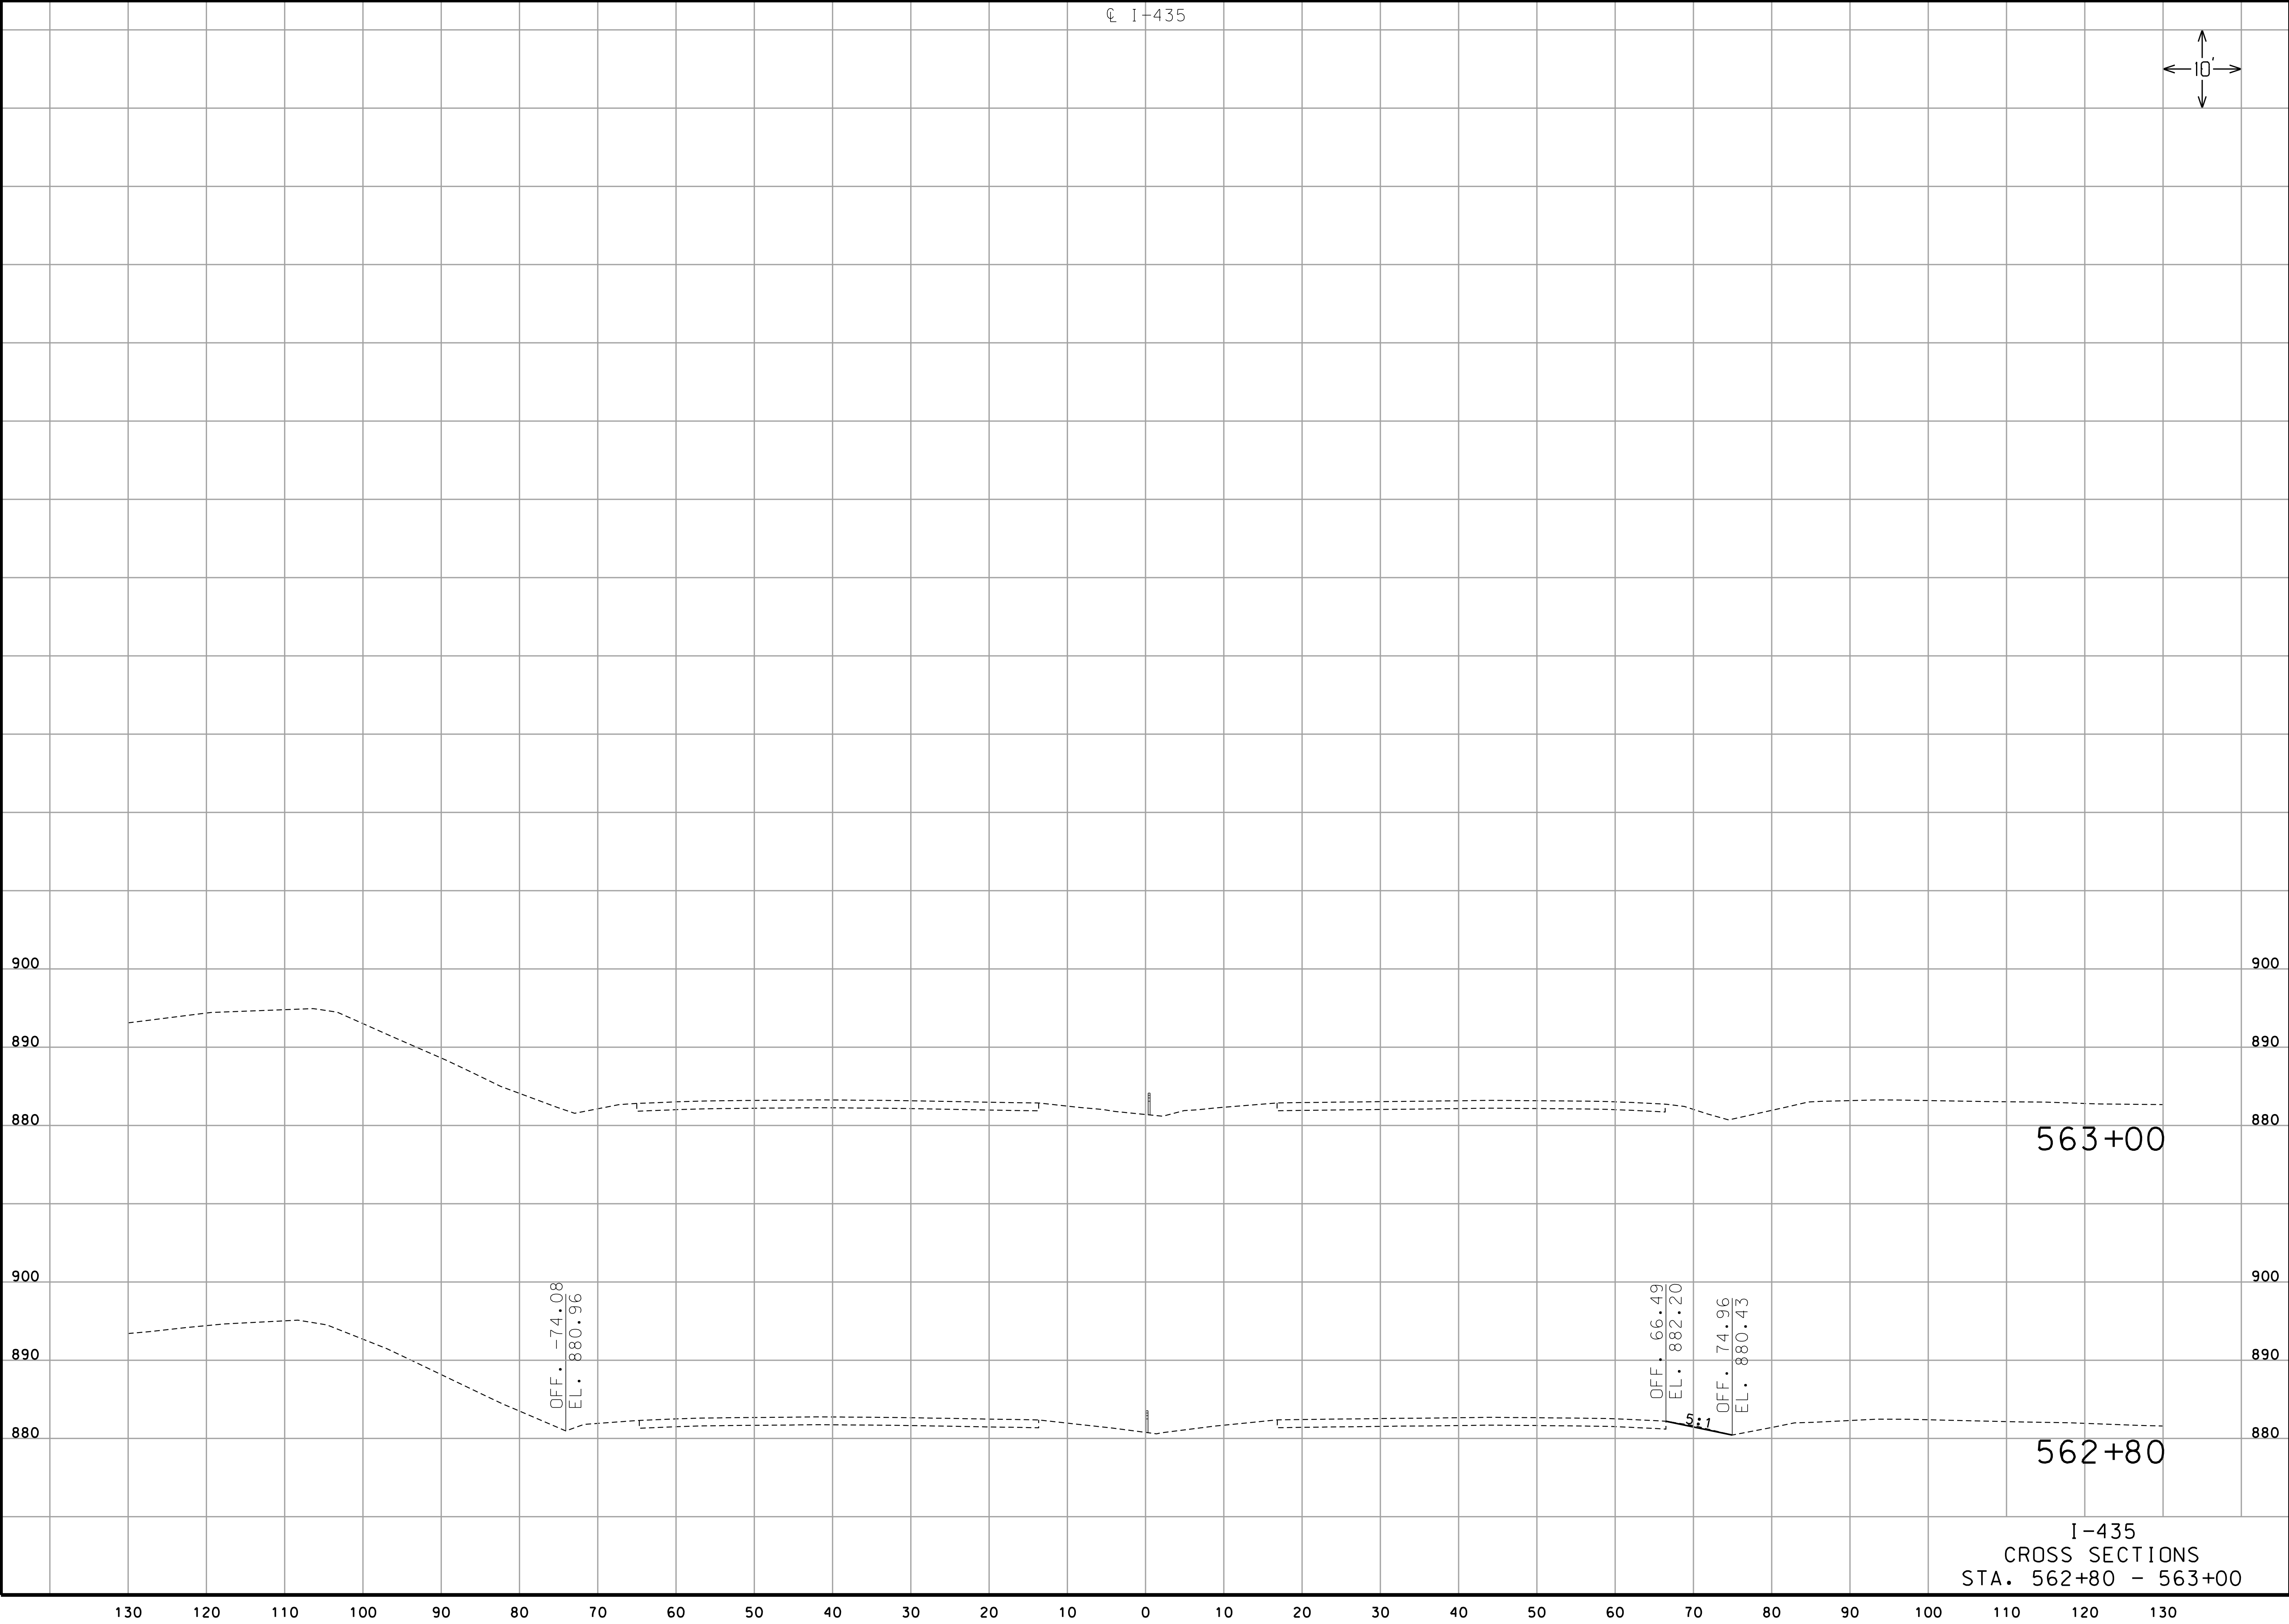

THIS MEDIA SHOULD NOT BE CONSIDERED A CERTIFIED DOCUMENT.

DATE PREPARED 6/12/2020	
ROUTE 53RD	STATE MO
DISTRICT KC	SHEET NO. 17
COUNTY CLAY	
JOB NO. J453386	
CONTRACT ID.	
PROJECT NO.	
BRIDGE NO. A8931	

DATE	DESCRIPTION

MISSOURI HIGHWAYS AND TRANSPORTATION COMMISSION



105 WEST CAPITOL
JEFFERSON CITY, MO 65102
1-888-ASK-MODOT (1-888-275-6636)

GARVER, LLC.
7410 NW TIFFANY SPRINGS
PARKWAY, SUITE 200
KANSAS CITY, MO 64153
PHONE: (816) 298-6465
CERTIFICATE OF AUTHORITY
NO. 2008013090

I-435
CROSS SECTIONS
STA. 562+80 - 563+00

IF A SEAL IS PRESENT ON THIS SHEET IT HAS BEEN ELECTRONICALLY SEALED AND DATED.