



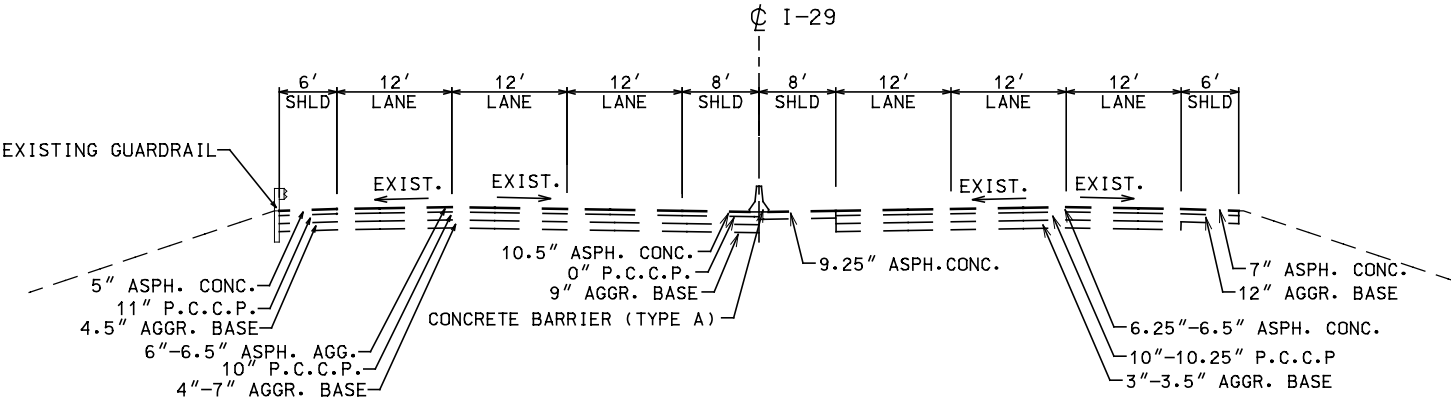

TYPICAL SECTION - I-29
NORTH OF 56TH ST.
EXISTING

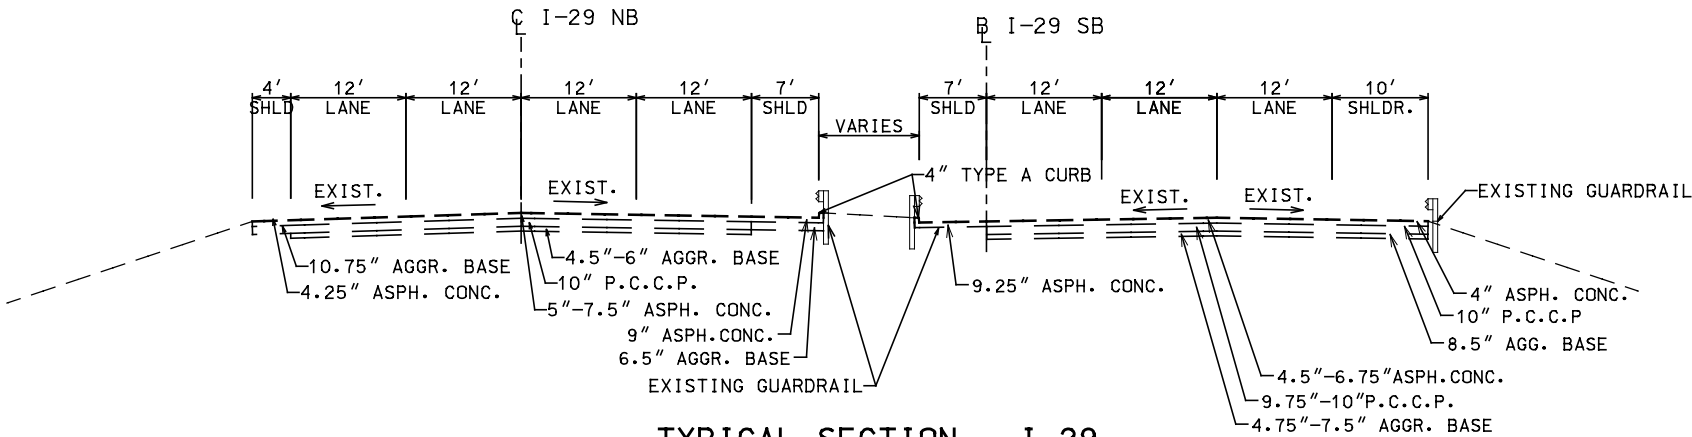

TYPICAL SECTION - I-29
SOUTH OF 56TH ST.
EXISTING

EXISTING TYPICAL SECTIONS
I-29 & 56TH ST.
SHEET 1 OF 4

"THIS MEDIA SHOULD
NOT BE CONSIDERED
A CERTIFIED
DOCUMENT."

DATE PREPARED
7/19/2020

ROUTE I-29 STATE MO
DISTRICT K-C SHEET NO. 2

COUNTY
PLATTE

JOB NO.
J413291

CONTRACT ID.

PROJECT NO.

BRIDGE NO.

DATE	DESCRIPTION
.	.
.	.
.	.
.	.
.	.
.	.







MISSOURI HIGHWAYS AND TRANSPORTATION
COMMISSION



105 WEST CAPITOL
JEFFERSON CITY, MO 65102
1-888-ASK-MODOT (1-888-275-6636)

Burns & McDonnell Engineering Co., Inc.
9400 Ward Parkway
Kansas City, Missouri 64114
816-333-9400
Certificate of Authority
No. : 000165
BMOB Project No. 109387



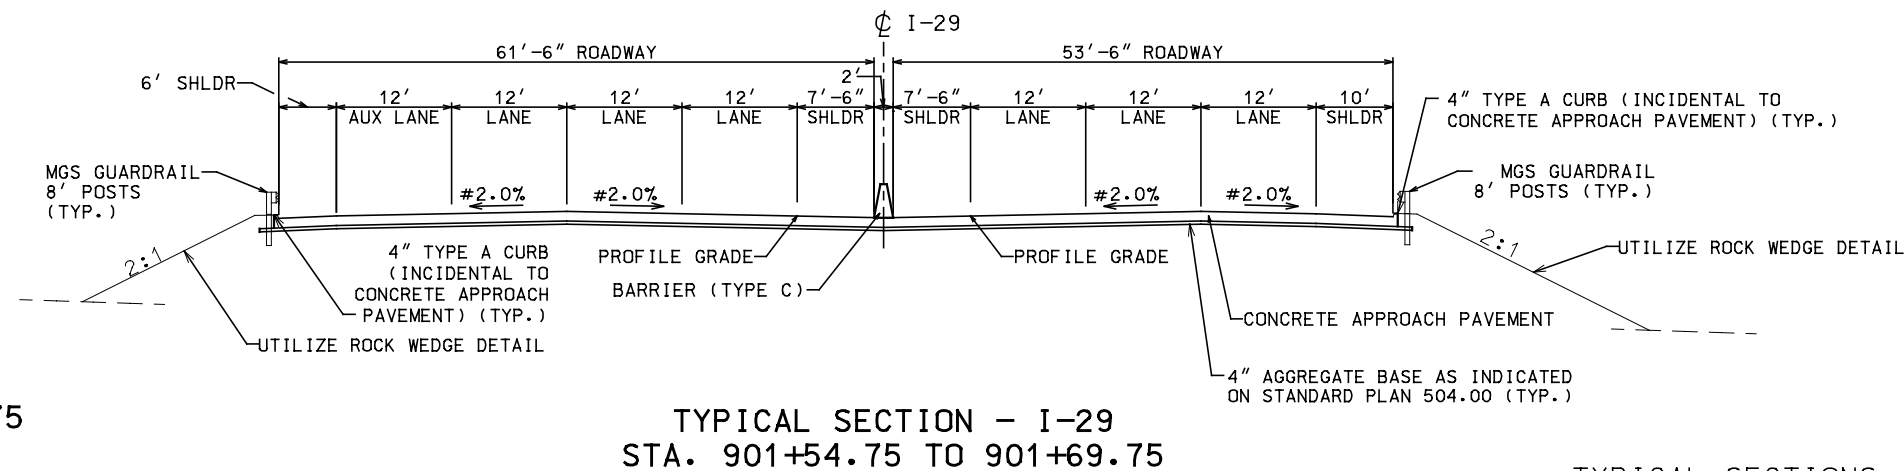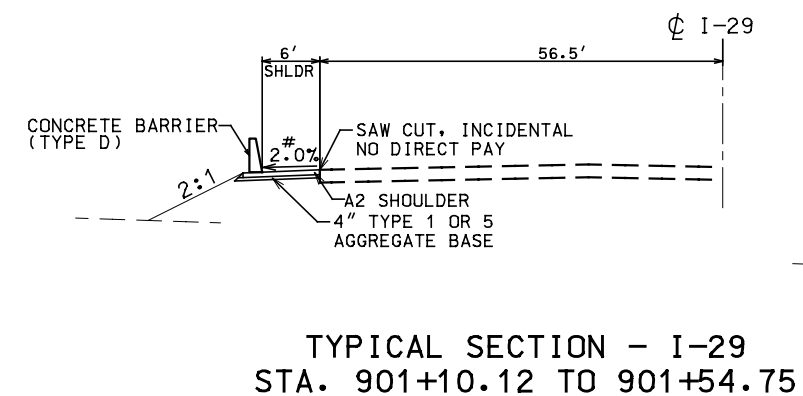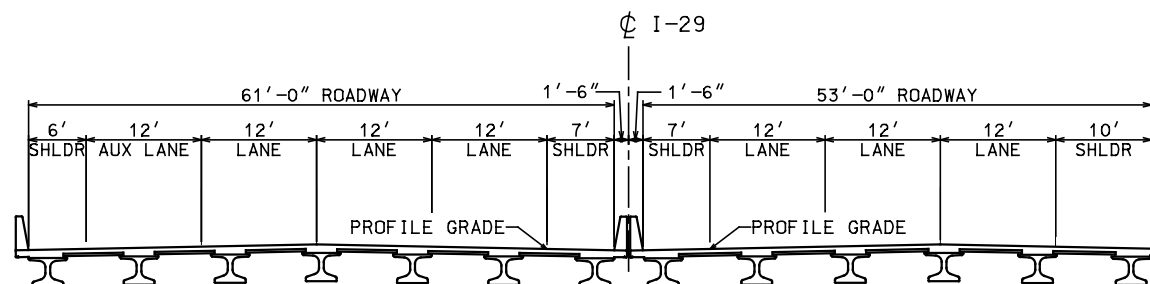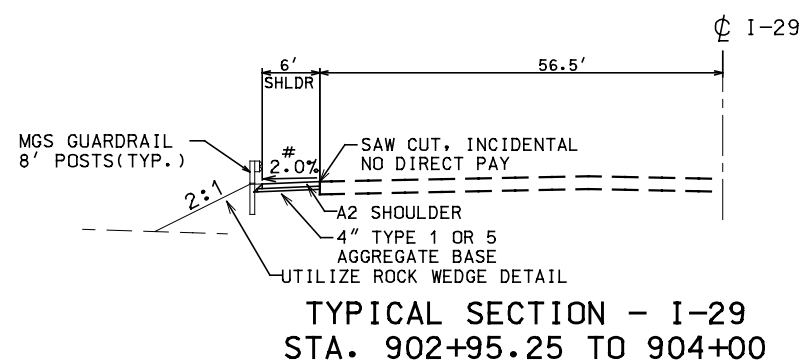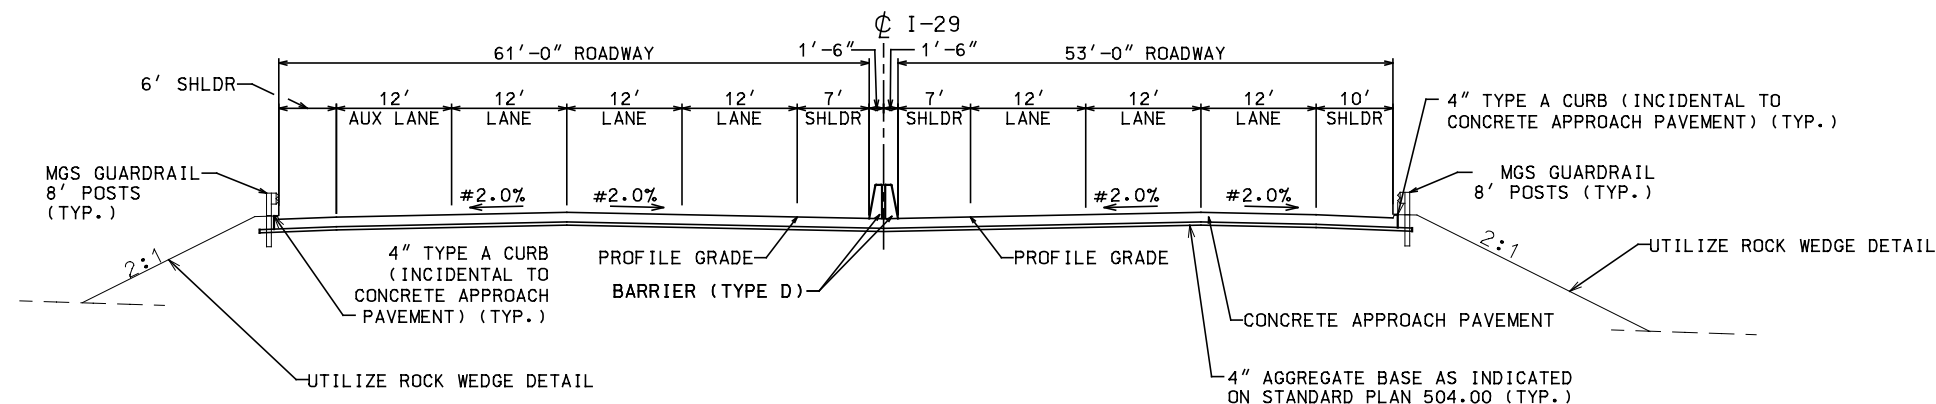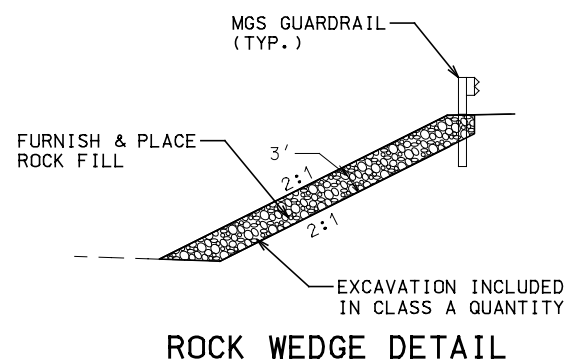

TYPICAL SECTIONS
I-29 & 56TH ST.
SHEET 2 OF 4

"THIS MEDIA SHOULD
NOT BE CONSIDERED
A CERTIFIED
DOCUMENT."

DATE PREPARED
7/19/2020

ROUTE
I-29
DISTRICT
K-C

STATE
MO
SHEET NO.
2

COUNTY
PLATTE

JOB NO.
J413291


CONTRACT ID.

PROJECT NO.

BRIDGE NO.


DATE	DESCRIPTION

MISSOURI HIGHWAYS AND TRANSPORTATION
COMMISSION

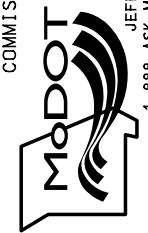


Burns & McDonnell Engineering Co., Inc.
9400 Ward Parkway
Kansas City, Missouri 64114
816-333-9400
Certificate of Authority
No. 1-000165
BMD Project No. 109387




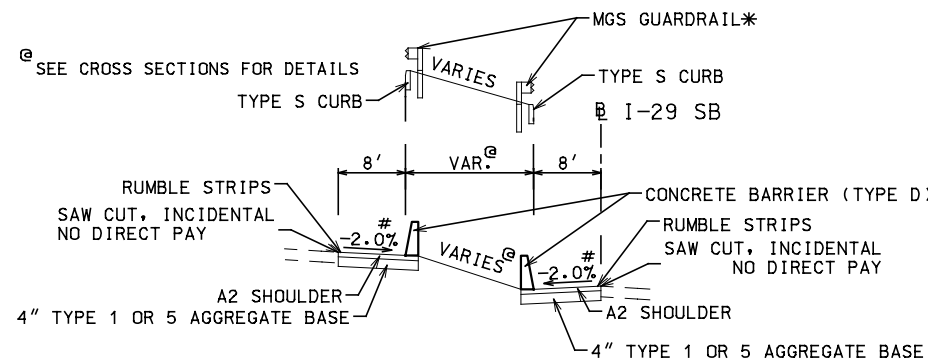


TYPICAL SECTION - I-29
STA. 904+65.07 TO 907+75.00 I-29 SB

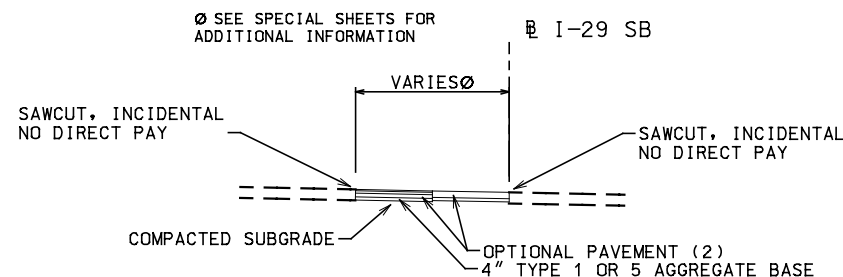


TYPICAL SECTION - I-29
STA. 904+65.07 TO 907+75.00 I-29 SB

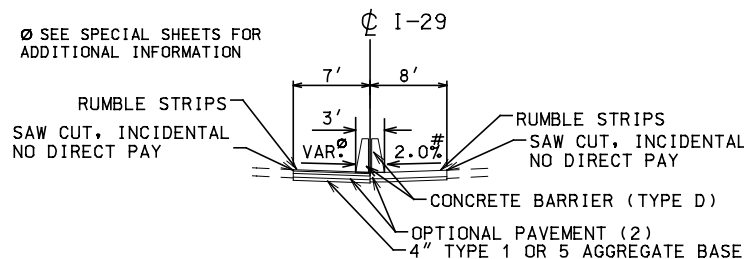


TYPICAL SECTION - I-29
STA. 902+95.25 TO 904+73.95 I-29

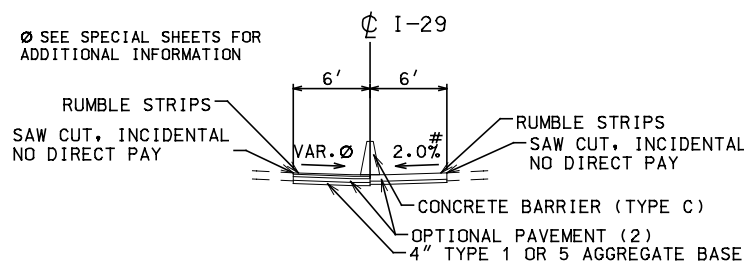


TYPICAL SECTION - I-29
STA. 896+50 TO 889+97.53
STA. 900+04.31 TO 901+54.75

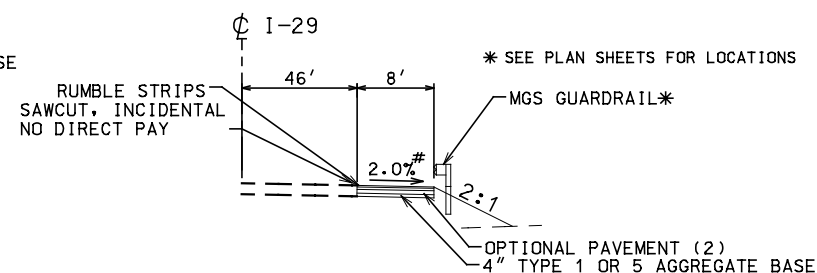

TYPICAL SECTION - I-29
STA. 897+20 TO 901+54.75
STA. 902+95.25 TO 904+73.95

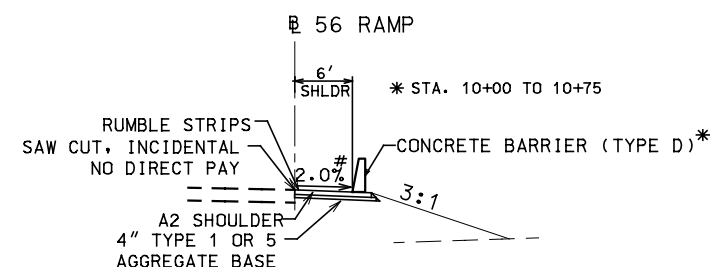


TYPICAL SECTION - 56TH RAMP
STA. 10+00 TO 11+00

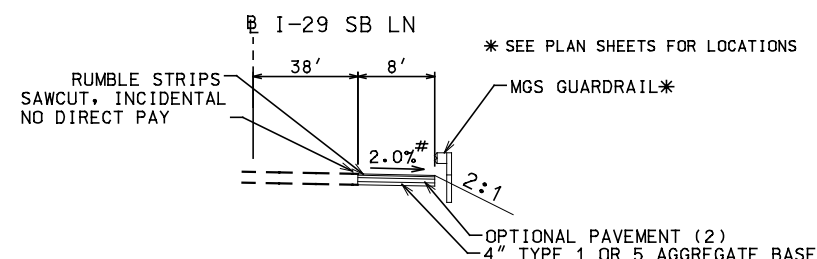

TYPICAL SECTION - I-29 SB LN
STA. 904+65.07 TO 905+80.00

TYPICAL SECTIONS
SHOULDER RESTORATIONS
I-29 & 56TH ST.
SHEET 3 OF 4

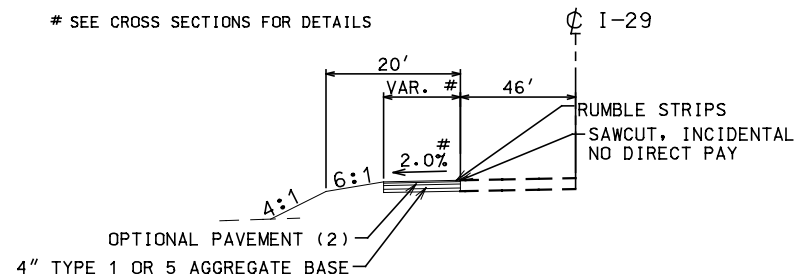

TYPICAL SECTION - I-29
STA. 897+00.00 TO 900+19.37

(2) OPTIONAL PAVEMENT:
1.75" SP125C w/PG 70-22
3" SP250C w/PG 70-22
4.75" SP250C w/PG 64-22

OR

8" PCCP PAVEMENT W/15' JOINTS
& 1.25" DOWELS

"THIS MEDIA SHOULD
NOT BE CONSIDERED
A CERTIFIED
DOCUMENT."

DATE PREPARED
7/19/2020

ROUTE I-29 STATE MO
DISTRICT K-C SHEET NO. 2

COUNTY
PLATTE

JOB NO.
J413291

CONTRACT ID.

PROJECT NO.


BRIDGE NO.

DESCRIPTION	DATE

MISSOURI HIGHWAYS AND TRANSPORTATION
COMMISSION
105 WEST CAPITAL
JEFFERSON CITY, MO 65102
1-888-ASK-MODOT (1-888-278-6636)

Burns & McDonnell Engineering Co., Inc.
9400 Ward Parkway
Kansas City, Missouri 64114
816-333-9400
Certificate of Authority
No. : 000165
BMD Project No. 109387

REV.

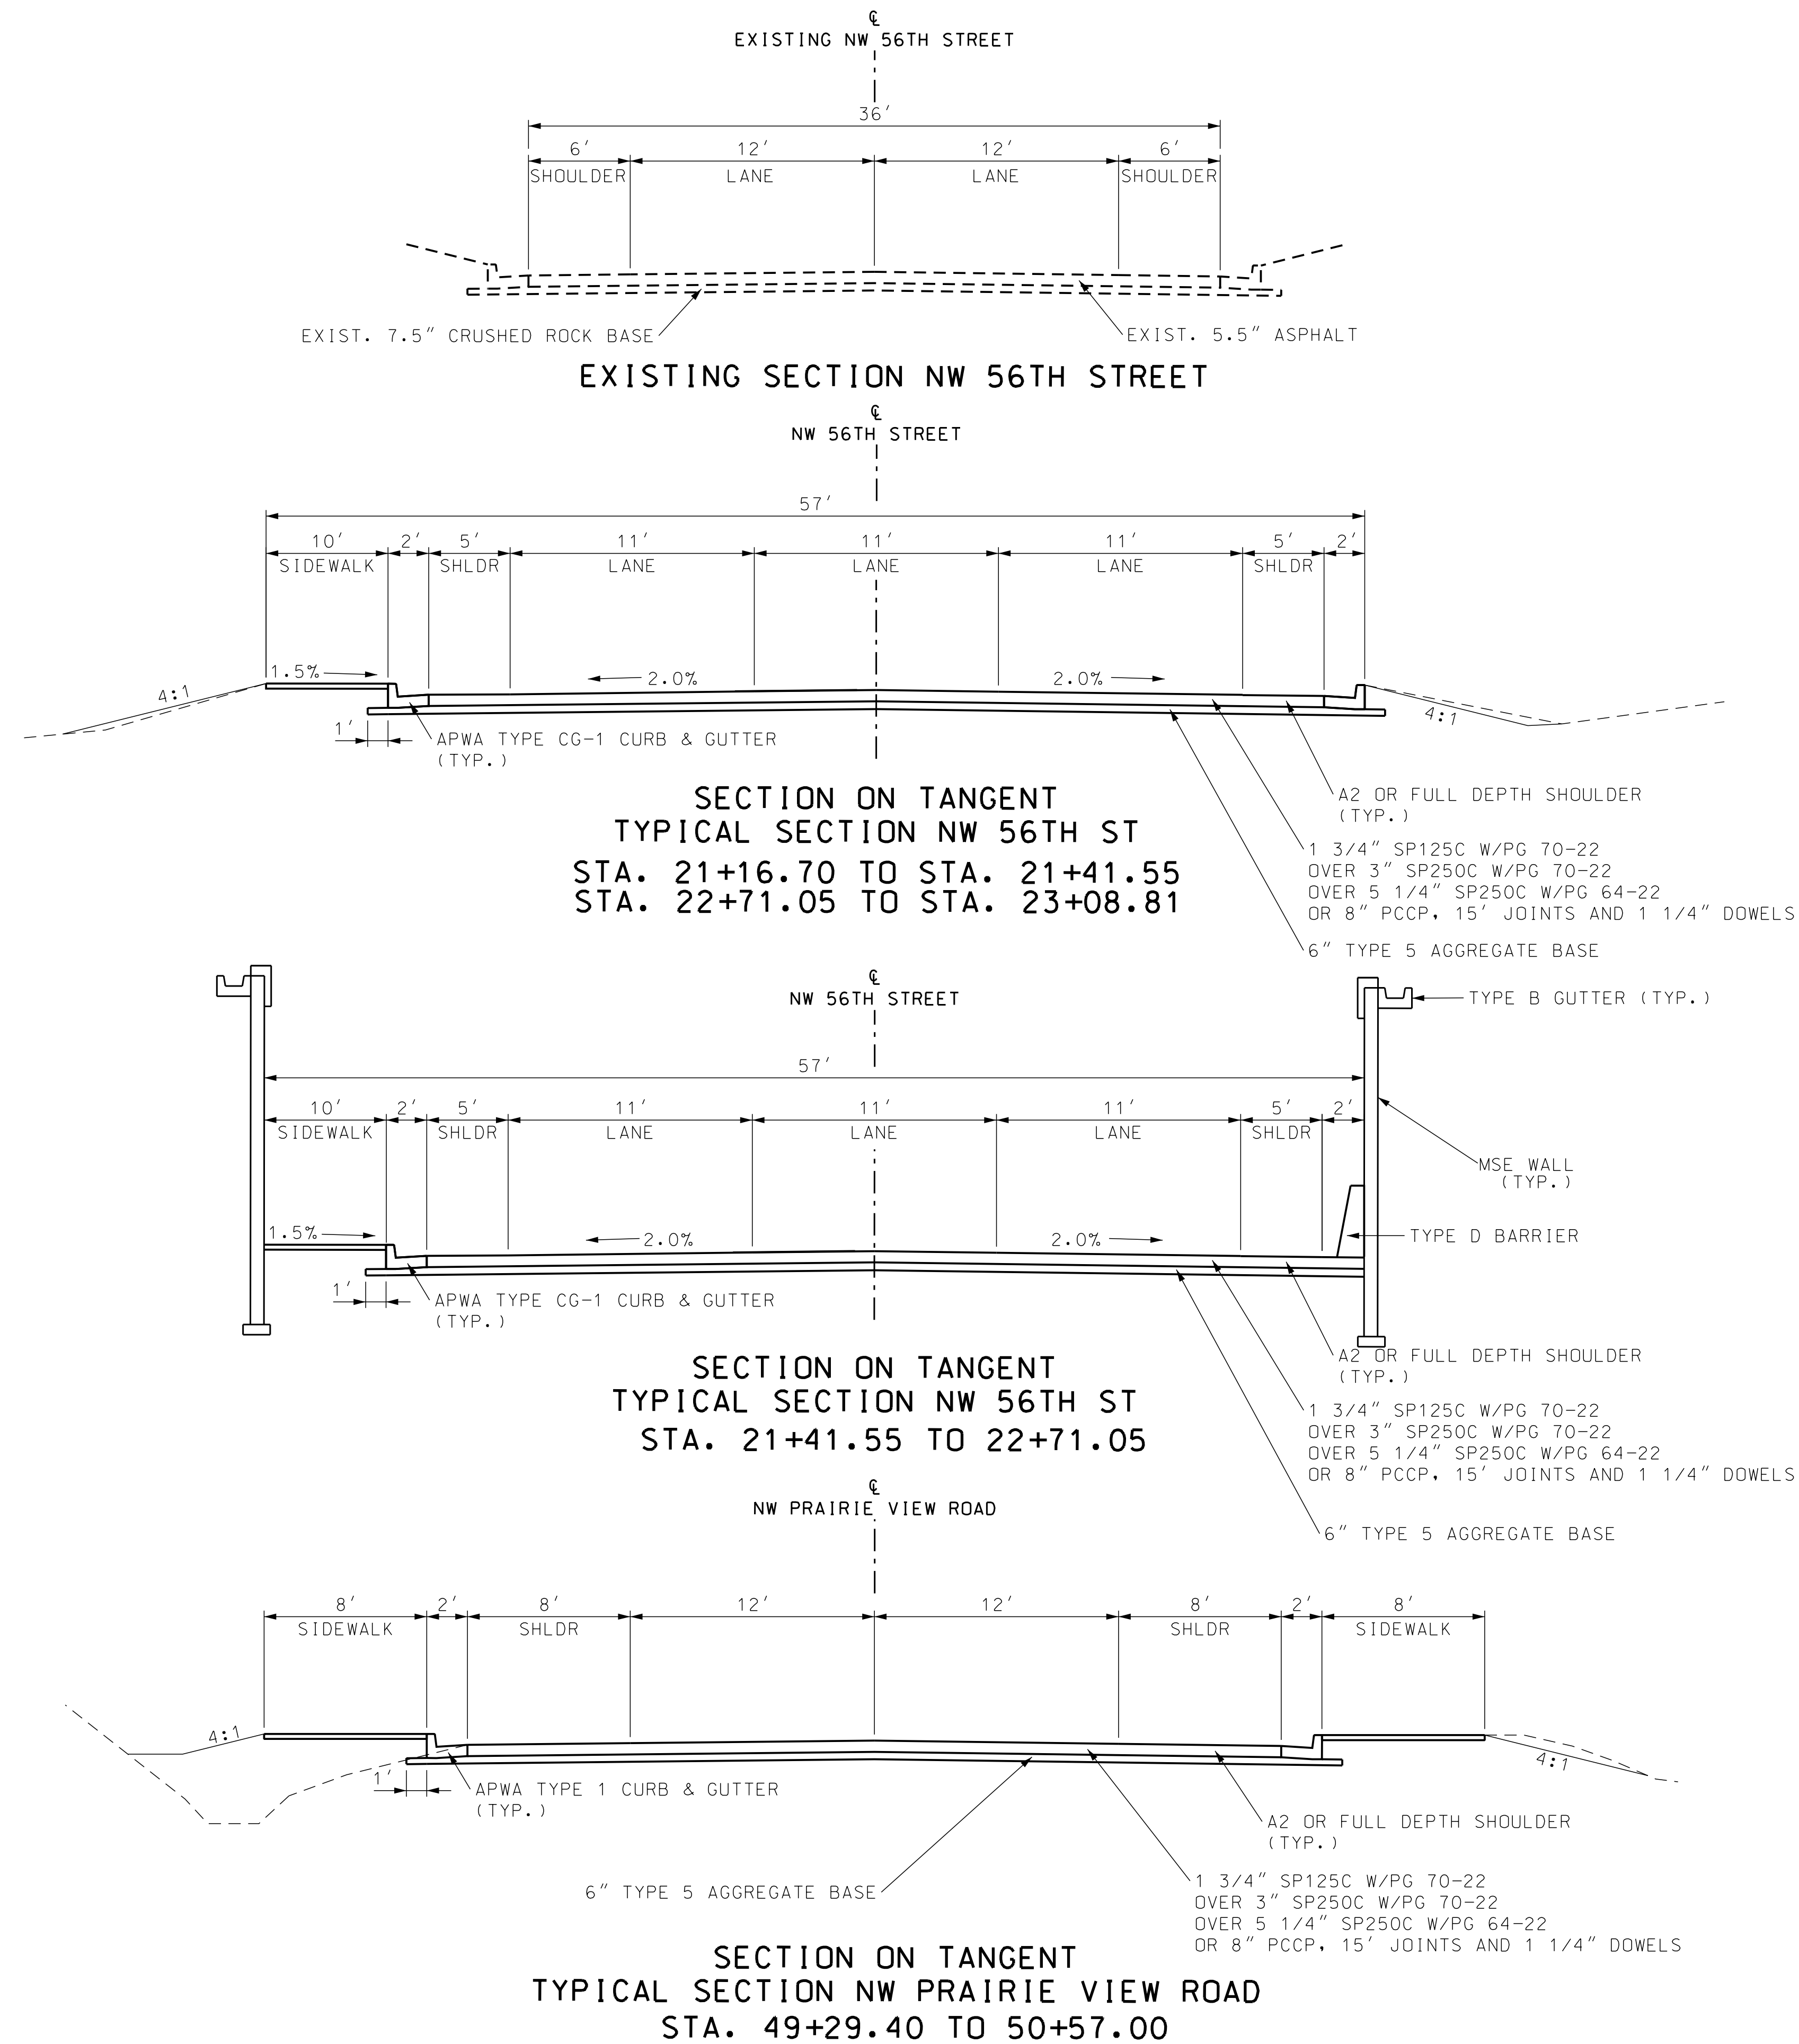

TYPICAL SECTION
56TH STREET
SHEET 4 OF 4

DATE PREPARED 6/26/2020	
ROUTE I-29	STATE MO
DISTRICT KC	SHEET NO. 2
COUNTY PLATTE	
JOB NO. J413291	
CONTRACT ID.	
PROJECT NO.	
BRIDGE NO.	
DESCRIPTION	
DATE	

MISSOURI HIGHWAYS AND TRANSPORTATION COMMISSION

MoDOT

105 WEST CAPITOL
JEFFERSON CITY, MO 65102
1-888-ASK-MODOT (1-888-275-6636)

TREKK

1411 East 104th St.
Kansas City, MO 64131
Tel (816) 974-4655
Fax (816) 974-4675
www.trekdesigngroup.com

Missouri Cert. of
Authority 202010300

CONTRACTOR FURNISHED SURVEYING & STAKING	
LOCATION	QUANTITY (L.S.)
PROJECT	1
PAY TOTAL:	1

MOBILIZATION	
LOCATION	QUANTITY (L.S.)
PROJECT	1
PAY TOTAL:	1

REMOVAL OF IMPROVEMENTS									
SHEET	STATION	TO	STATION	LOCATION	ROUTE	DESCRIPTION	UNIT	RMOVAL OF IMPROVEMENTS	REMARKS
50	896+50.00	TO	901+54.75	INSIDE SHLD. N.B.L	I-29 NB	ASPHALT PAVEMENT	SY	332	
50	896+50.00	TO	901+54.75	INSIDE SHLD. S.B.L	I-29 SB	ASPHALT PAVEMENT	SY	332	
50	897+00.00	TO	900+19.37	OUTSIDE SHLD. N.B.L	I-29 NB	ASPHALT PAVEMENT	SY	503	
50	897+20.00	TO	901+54.75	OUTSIDE SHOULDER	I-29 SB	ASPHALT PAVEMENT	SY	386	
50	896+50.00	TO	901+69.75	CL I-29	I-29	EXISTING TRAFFIC BARRIER	LF	505	
50	896+95.35	TO	901+82.85	OUTSIDE SHOULDER	I-29	EXISTING GUARDRAIL	LF	488	
50	900+11.75	TO	901+69.75	56TH RAMP SHOULDER	I-29	ASPHALT PAVEMENT	SY	102	
50	900+73.38	TO	901+55.99	R/O I-29 N.B.L	I-29	EXISTING GUARDRAIL	LF	83	
50	902+67.15	TO	904+54.65	R/O I-29 N.B.L	I-29	EXISTING GUARDRAIL	LF	188	
50	902+67.15	TO	904+73.95	R/O I-29 S.B.L	I-29	EXISTING GUARDRAIL	LF	207	
50	901+54.75	TO	901+69.75	I-29 N.B.L	I-29	ASPHALT PAVEMENT	SY	104	
50	901+54.75	TO	901+69.75	I-29 S.B.L	I-29	ASPHALT PAVEMENT	SY	91	
50	902+80.25	TO	902+95.25	I-29 N.B.L	I-29	ASPHALT PAVEMENT	SY	104	
50	902+80.25	TO	902+95.25	I-29 S.B.L	I-29	ASPHALT PAVEMENT	SY	91	
50	902+95.25	TO	904+00.00	OUTSIDE SHLD. N.B.L	I-29	ASPHALT PAVEMENT	SY	70	
50	902+95.25	TO	904+73.95	OUTSIDE SHLD. S.B.L	I-29	ASPHALT PAVEMENT	SY	159	
50	904+73.95	TO	905+80.00	OUTSIDE SHLD. S.B.L	I-29	ASPHALT PAVEMENT	SY	100	
50	902+95.25	TO	904+73.95	INSIDES SHLD. N.B.L.	I-29	ASPHALT PAVEMENT	SY	149	
50	902+95.25	TO	904+73.95	INSIDES SHLD. S.B.L.	I-29	ASPHALT PAVEMENT	SY	149	
50	902+80.25	TO	907+87.26	INSIDES SHLD. N.B.L.	I-29	EXISTING TRAFFIC BARRIER	LF	507	
50	902+80.25	TO	907+50.00	INSIDES SHLD. S.B.L.	I-29	EXISTING TRAFFIC BARRIER	LF	470	
50	904+73.95	TO	905+97.91	R/O I-29 S.B.L	I-29	EXISTING GUARDRAIL	LF	130	
50	904+73.95	TO	908+61.63	INSIDES SHLD. S.B.L.	I-29	EXISTING GUARDRAIL	LF	113	
50	904+73.95	TO	908+86.92	INSIDES SHLD. N.B.L.	I-29	EXISTING GUARDRAIL	LF	113	
50	904+73.95	TO	907+75.00	CL I-29	I-29	ASPHALT PAVEMENT	SY	604	
7	19+87			NW 56TH ST		INLET TOP AND GRATE	EA	1	
7	20+14			NW 56TH ST		SIGN	EA	1	
7	20+44			NW 56TH ST		SIGN	EA	1	
7	23+08			NW 56TH ST		SIGNS	EA	3	
7	23+16			NW 56TH ST		HEADWALL	EA	1	
7	902+78			NW ROANRIDGE RD		SAWCUT	LF	28	
7	23+02			NW 56TH ST		BUS STOP	SY	6.4	
7	49+19		49+73	NW PRAIRIE VIEW		PAVED DITCH	SY	69.3	
7	49+24		49+50	NW PRAIRIE VIEW		CURB AND GUTTER	LF	27	
7	49+26			NW PRAIRIE VIEW		SIGN	EA	1	
7	49+32			NW PRAIRIE VIEW		SIGN	EA	1	
7	49+41			NW PRAIRIE VIEW		SIGN	EA	1	
7	50+27			NW PRAIRIE VIEW		SIGN	EA	1	
7	49+50		50+19	NW PRAIRIE VIEW		SAWCUT	LF	68	
7	50+36			NW PRAIRIE VIEW		SIGN	EA	1	
7	50+56			NW PRAIRIE VIEW		SAWCUT	LF	30	
					PAY TOTAL	1	LUMP SUM		

CLEARING & GRUBBING					
SHEET NO	STATION	TO	STATION	LOCATION	CLEARING & GRUBBING (ACRES)
4-5	902+95.25	TO	9029+25.00	L/O CL I-29	0.11
				56TH ST	0.20
				TOTAL:	0.31
				PAY TOTAL:	1.0
					Round up to nearest acre

SUMMARY OF QUANTITIES
SHEET 1 OF 6

"THIS MEDIA SHOULD NOT BE CONSIDERED A CERTIFIED DOCUMENT."

DATE PREPARED 7/19/2020	
ROUTE I-29	STATE MO
DISTRICT K-C	SHEET NO. 3
COUNTY PLATTE	
JOB NO. J413291	
CONTRACT ID. .	
PROJECT NO. .	
BRIDGE NO. .	

DATE	DESCRIPTION
.	.
.	.
.	.
.	.
.	.
.	.

MISSOURI HIGHWAYS AND TRANSPORTATION COMMISSION



105 WEST CAPITOL
JEFFERSON CITY, MO 65102
1-888-ASK-MODOT (1-888-278-6636)

Burns & McDonnell Engineering Co., Inc.



9400 Ward Parkway
Kansas City, Missouri 64114
816-333-9400
Certificate of Authority
No. : 000165
BMOB Project No. 109387

EARTHWORK SUMMARY										
SHEET	STATION	TO	STATION	LOCATION	CLASS A EXC. (C.Y.)	EMBANKMENT IN PLACE (C.Y.)	COMPACTING EMBANKMENT (C.Y.)	REMARKS		
4-5	896+50.00	TO	907+75.00	CL I-29/BL I-29 SB	742.9	9.5		STAGE 1		
4-5	897+20.00	TO	908+80.00	CL I-29	2726.1		509.0	STAGE 2, INCLUDES PARTIAL EXCAVATION OF WALL A8881 (CLASS A 972 CY) & A8882 (CLASS A 1378 CY)		
4-5	900+11.75	TO	904+00.00	CL I-29	2776.5		571.4	STAGE 3, INCLUDES PARTIAL EXCAVATION OF WALL A8881 (CLASS A 914 CY) AND A8882 (CLASS A 1281 CY)		
4-5	904+65.07	TO	907+75.00	BL I-29 SB	164.9			STAGE 4		
7	19+84.00	TO	23+00.00	NW 56TH ST	1238.0		14.0	STAGE 5		
7	49+29.40	TO	50+54.30	NW PRAIRIE VIEW RD	363.0		68.0	STAGE 5		
VAR.	VAR.		VAR.		100.0			ROUNDING & MISCELLANEOUS GRADING		
PAY TOTAL:					8,112	10	1,163			

CONCRETE APPROACH PAVEMENT											
					AVERAGE SHDR. LT. WIDTH	AVERAGE PAVEMENT WIDTH	AVERAGE SHDR. RT. WIDTH	CONCRETE APPROACH PAVEMENT	TYPE 5 AGGREGATE BASE (4 IN.)	COMPACTING IN CUT	
SHEET	STATION	TO	STATION	LOCATION	(FT.)	(FT.)	(FT.)	(S.Y.)	(S.Y.)	(STA.)	REMARKS
4	901+54.7	TO	901+69.75	I-29 LT	0.0	63.8	0.0	106.38	106.38	0.15	NB BRIDGE
4	901+54.7	TO	901+69.75	I-29 RT	0.0	54.5	0.0	90.83	90.83	0.15	SB BRIDGE
4	902+80.2	TO	902+95.25	I-29 LT	0.0	63.8	0.0	106.38	106.38	0.15	NB BRIDGE
4	902+80.2	TO	902+95.25	I-29 RT	0.0	54.5	0.0	90.83	90.83	0.15	SB BRIDGE
TOTAL								394.4	394.4	0.60	
PAY TOTAL:								395.0	395.0	0.60	

ROCK FILL							
SHEET	STATION	TO	STATION	LOCATION	FURNISH ROCK FILL (C.Y.)	PLACE ROCK FILL (C.Y.)	GEOTEXTILE FABRIC (S.Y.)
4	901+50.00	TO	901+89.25	L/O CL I-29	102.6	102.6	134.3
4	902+95.25	TO	904+00.00	L/O CL I-29	613.4	613.4	749.8
4	902+95.25	TO	904+00.00	R/O CL I-29	88.5	88.5	115.9
4	902+95.25	TO	904+00.00	R/O CL I-29	55.2	55.2	73.3
PAY TOTAL:					860.0	860.0	1074.0

TEMPORARY SURFACING					
SHEET	STATION	TO	STATION	LOCATION	TEMPORARY (CY.)
40	20+36		20+58	NW 56TH ST	10
41	902+41		902+78	NW ROANRIDGE RD	10
TOTAL					20.0

PAVEMENT														
SHEET	STATION	TO	STATION	LOCATION	AVERAGE SHDR. LT. WIDTH	AVERAGE PAVEMENT WIDTH	AVERAGE SHDR. RT. WIDTH	AREA	A2 SHOULDER	TYPE 5 AGGREGATE BASE (4 IN.)	TYPE 5 AGGREGATE BASE (6 IN.)	OPTIONAL PAVEMENT (SHOULDER/CROSSOVER)	OPTIONAL PAVEMENT (56TH ST.)	COMPACTING IN CUT
					(FT.)	(FT.)	(FT.)		(S.Y.)	(S.Y.)	(S.Y.)	(S.Y.)	(S.Y.)	(STA.)
4	897+00.00	TO	900+19.37	I-29 C.L.				4525.6		502.84		502.84		3.19
4	896+50.00	TO	899+97.54	I-29 INSIDE SHLD.	6.0		6.0			463.39		463.39		3.48
4	900+04.25	TO	901+54.75	I-29 INSIDE SHLD.	6.0		6.0			200.67		200.67		1.51
4	902+95.25	TO	904+73.95	I-29 INSIDE SHLD.	7.0		8.0			297.83		297.83		1.79
5	904+65.07	TO	907+75.00	I-29 SB				5440.0		604.45		604.45		3.10
5	904+65.07	TO	907+75.00	I-29 SB				4735.9	526.21	526.21				3.10
4	897+20.00	TO	901+54.75	I-29 OUTSIDE SHLD.	0.0		8.0			386.44		386.44		4.35
4	902+95.25	TO	904+73.95	I-29 OUTSIDE SHLD.	0.0		8.0			158.84		158.84		1.79
5	904+65.07	TO	905+80.00	I-29 OUTSIDE SHLD.	0.0		8.0			102.16		102.16		1.15
4	10+00.00	TO	11+00.00	56TH RAMP	0.0		6.0		66.67	66.67				1.00
4	901+10.12	TO	901+54.75	I-29 OUTSIDE SHLD.	0.0		6.0		29.75	29.75				0.45
4	902+95.25	TO	904+00.00	I-29 OUTSIDE SHLD.	6.0		0.0		69.83	69.83				1.05
7	19+84.00	TO	23+31.13	NW 56TH ST					81.90		1799.00		1717.20	3.47
7	902+42.25	TO	902+78.25	NW ROADRIDGE RD					45.50		191.00		708.00	0.36
7	49+29.40	TO	50+55.93	NW PRAIRIE VIEW RD							708.00		708.00	1.27
TOTAL:									819.864	3409.09	2698.00	2716.63	3133.20	31.03
PAY TOTAL									820.00	3410.00	2698.00	2717.00	3134.00	31.03

PAVEMENT EDGE TREATMENT						
SHEET	STATION	TO	STATION	LOCATION	PAVEMENT EDGE TREATMENT (S.Y.)	REMARKS
7	19+84		20+72	NW 56TH ST	88	
7	902+23		902+78	NW ROANRIDGE RD	55	
7	19+84		20+72	NW 56TH ST	88	
7	902+23		902+78	NW ROANRIDGE RD	55	
TOTAL					286	

CLASS 1 LINEAR GRADING						
SHEET	STATION	TO	STATION	LOCATION	CLASS 1 LINEAR GRADING (STA.)	REMARKS
4	896+65.00	TO	897+20.00	R/O CL I-29	0.6	FOR TYPE A END TERMINAL
PAY TOTAL					0.6	

CURB AND GUTTER							
SHEET	STATION	TO	STATION	LOCATION	CURB AND GUTTER APWA TYPE CG-1 (L.F.)	MODOT TYPE A GUTTER (L.F.)	REMARKS
7	20+75.63		21+11.55	NW 56TH ST		37	
7	21+16.70		23+08.81	NW 56TH ST	192		
7	22+71.05		23+29.35	NW 56TH ST	94		
7	49+23.71		494+48.67	NW PRAIRIE VIEW RD	28		
TOTAL					313.3	36.9	
PAY TOTAL:					314.0	37.0	

SUMMARY OF QUANTITIES
SHEET 2 OF 6

THIS MEDIA SHOULD NOT BE CONSIDERED A CERTIFIED DOCUMENT.

DATE PREPARED
7/19/2020

ROUTE
I-29

STATE
MO

DISTRICT
K-C

SHEET NO.
3

COUNTY
PLATTE

JOB NO.
J413291

CONTRACT ID.
.

PROJECT NO.
.

BRIDGE NO.
.

DESCRIPTION

DATE

MISSOURI HIGHWAYS AND TRANSPORTATION COMMISSION

MoDOT

105 WEST CAPITOL
JEFFERSON CITY, MO 65102
1-888-ASK-MODOT (1-888-275-6636)

BURNS & MCDONNELL

9400 Ward Parkway
Kansas City, Missouri 64114
816-333-9400

Certification of Authority
No. : 000165
BMD Project No. 109387

\\bmd\dfs\Clients\TRN\MODOT\109387_129Bridges\Design\CADD\Road_Sheets\J413291_56th St\003_QU_01_J413291_11.dgn 5:31:56 PM 7/19/2020

GUARDRAIL											
SHEET	STATION	TO	STATION	LOCATION	MGS GUARDRAIL	MGS GUARDRAIL, 8 FT POSTS	VERTICAL CONCRETE BARRIER	VERTICAL CONCRETE BARRIER TRANS. SECTION	MGS HEIGHT AND BLOCK TRANSITION	END TERMINAL TYPE A MASH	NOTES
					(LF)	(LF)	(EACH)	(EACH)	(EACH)	(EACH)	
4	896+95.35	TO	900+45.35	R/O CL I-29	300					1	SB outside shoulder
4	900+45.35	TO	901+82.85	R/O CL I-29		100	1				SB outside shoulder
4	902+67.15	TO	904+54.65	L/O CL I-29		125	1		1		NB outside shoulder
4	902+67.15	TO	904+73.95	R/O BL I-29 SB		169.30	1				SB outside shoulder 1/2
5	904+64.07	TO	905+97.91	R/O BL I-29 SB		105.70			1		SB outside shoulder 2/2
4	907+73.79	TO	908+86.92	R/O CL I-29 NB	50.00			1	1		Inside shoulder
4	907+49.40	TO	908+61.63	L/O BL I-29 S.B.L	50.00			1	1		Inside shoulder
PAY TOTAL:					400	500	3	2	4	1	

CONCRETE TRAFFIC BARRIER								
SHEET	STATION	TO	STATION	LOCATION	CONCRETE TRAFFIC BARRIER,	CONCRETE TRAFFIC BARRIER,	CONCRETE CURB TYPE S	NOTES
					(LF)	(LF)	(LF)	
4	896+50.00	TO	899+98.00	CL I-29	348.00			
4	900+04.31	TO	901+69.75	CL I-29	165.44			
4	901+10.11	TO	901+69.75	L/O CL I-29		59.64		
4	902+80.25	TO	904+73.95	R/O CL I-29		193.70		
4	902+80.25	TO	904+73.95	L/O CL I-29		193.70		
5	904+65.07	TO	907+50.00	L/O BL I-29 SB		284.93		
5	904+73.95	TO	907+74.40	R/O CL I-29 NB		300.45		
5	10+00.00	TO	10+75.00	R/O 56TH RAMP		75.00		
5	907+50.00	TO	907+75.00	L/O BL I-29 SB			25.00	
5	907+62.60	TO	907+75.00	R/O CL I-29 NB			12.40	
7	21+11.55	TO	22+71.05	NW 56TH ST		160		Includes 30' Height Transition
PAY TOTAL:					513.00	1267.00	37.00	

CONCRETE TRAFFIC BARRIER TRANSITION						
SHEET	STATION	TO	STATION	LOCATION	CONCRETE TRAFFIC BARRIER,	NOTES
					(EA)	
13	896+27.35	TO	896+47.35	CL-I-29	1.00	TYPE A TO TYPE C
13	899+77.56	TO	899+97.56	CL-I-29	1.00	FLUSH WITH SIGN TRUSS
13	900+04.25	TO	900+24.25	CL-I-29	1.00	FLUSH WITH SIGN TRUSS
13	900+91.85	TO	901+11.85	CL-I-29	1.00	FLUSH WITH SIGN TRUSS
13	901+15.72	TO	901+35.72	CL-I-29	1.00	FLUSH WITH SIGN TRUSS
13	901+49.80	TO	901+69.80	CL-I-29	1.00	TYPE C TO TYPE D
PAY TOTAL:					6.00	

DRAINAGE											
SHEET	ID	STATION	OFFSET (FT)	LOCATION	UPSTREAM STRUCTURE	DOWNSTREAM STRUCTURE	PIPE COLLAR	MANHOLE FRAME & COVER TYPE	18 IN PIPE GROUPE B	18 IN FES GROUPE B	CLASS 3 EXCAVATION
							(EA)	(EA)	(LT)	(EA)	(CY)
7	F1	23+14.96	78.09'	RTE 56							
7	C1	23+15.82	25.19'	RTE 56			1.0			1.0	
	P-F1				F1	C1			53.0		2.0
7		20+76.16	33.72'	RTE 56							4.0
7	M1	19+86.80	13.43'	RTE 56				1.0			
TOTAL & PAY:							1.0	1.0	53.0	1.0	4.0

TYPE 2 ROCK BLANKET							
SHEET	STATION	TO	STATION	LOCATION	FURNISH TYPE 2 ROCK BLANKET	PLACE TYPE 2 ROCK BLANKET	REMARKS
4	21+46.50	TO	22+66.13	L/O 56TH ST	14.8	14.8	ON TOP OF MSE WALL A8882
4	21+46.50	TO	22+66.13	R/O 56TH ST	14.8	14.8	ON TOP OF MSE WALL A8881
PAY TOTAL:					29.5	29.5	

RUMBLE STRIPS						
SHEET	STATION	TO	STATION	LOCATION	RUMBLE STRIPS (STA)	REMARKS
4	897+00.00	TO	900+19.37	L/O CL I-29	3.19	NB OUTSIDE SHOULDER
4	10+00.00	TO	11+00.00	L/O BL 56 RAMP	1.00	NB 56 OFF RAMP
4	901+10.12	TO	901+69.75	L/O CL I-29	0.60	NB OUTSIDE SHOULDER
4	902+80.25	TO	904+00.00	L/O CL I-29	1.20	NB OUTSIDE SHOULDER
4	896+50.00	TO	901+69.75	L/O & R/O CL I-29	10.40	NB & SB INSIDE SHOULDERS
4	902+80.25	TO	904+73.95	L/O & R/O CL I-29	3.87	NB & SB INSIDE SHOULDERS
5	904+73.95	TO	907+87.26	R/O CL I-29 NB	3.13	NB INSIDE SHOULDER
5	904+65.07	TO	907+75.00	L/O BL I-29 SB	3.10	SB INSIDE SHOULDER
4	897+20.00	TO	901+69.75	R/O CL I-29	4.50	SB OUTSIDE SHOULDER
5	904+65.07	TO	905+80.00	R/O BL I-29 SB	1.15	SB OUTSIDE SHOULDER
TOTAL					32.14	
PAY					32.20	

MODIFIED TYPE B GUTTER						
SHEET	STATION	TO	STATION	LOCATION	MODIFIED TYPE B	REMARKS
4	21+11.55	TO	23+01.00	L/O 56TH ST	214	ON TOP OF MSE WALL A8882
4	21+11.55	TO	23+01.00	R/O 56TH ST	214	ON TOP OF MSE WALL A8881
PAY TOTAL:					428	

CHAIN LINK FENCE (48")						
SHEET	STATION	TO	STATION	LOCATION	48" FENCE (L.F.)	REMARKS
4	21+11.55	TO	21+46.46	L/O 56TH ST	57.3	ON TOP OF MSE WALL A8882
4	22+66.13	TO	23+01.00	L/O 56TH ST	47.34	ON TOP OF MSE WALL A8882
4	21+11.55	TO	21+46.46	R/O 56TH ST	47.34	ON TOP OF MSE WALL A8881
4	22+66.13	TO	23+01.00	R/O 56TH ST	47.34	ON TOP OF MSE WALL A8881
PAY TOTAL:					200	

SIDEWALK						
SHEET	STATION	TO	STATION	LOCATION	CONCRETE CURB RAMP	TRUNCADED DOMES
					(SY.)	(SF.)
7	21+16.7	TO	23+08.81	NW 56TH ST	7.0	12
7	49+29.0	TO	49+76.32	NW PRAIRIE VIEW	13.7	24
7	49+23.7	TO	49+36.22	NW PRAIRIE VIEW	5.6	12
TOTAL					26.3	48
						251.0

SUMMARY OF QUANTITIES
SHEET 3 OF 6

"THIS MEDIA SHOULD NOT BE CONSIDERED A CERTIFIED DOCUMENT."

DATE PREPARED
7/19/2020

ROUTE
I-29
STATE
MO
DISTRICT
K-C
SHEET NO.
3

COUNTY
PLATTE

JOB NO.
J413291

CONTRACT ID.
.

PROJECT NO.
.

BRIDGE NO.
.

DESCRIPTION	DATE										
	.	.	.	.	.	.	.	.	.	.	.

MISSOURI HIGHWAYS AND TRANSPORTATION COMMISSION

105 WEST CAPITOL
JEFFERSON CITY, MO 65102
1-888-ASK-MODOT (1-888-278-6636)

Burns & McDonnell Engineering Co., Inc.
9400 Ward Parkway
Kansas City, Missouri 64114
816-333-9400
Certificate of Authority
No. : 000165
BMOB Project No. 109387


REV.

IF A SEAL IS PRESENT ON THIS SHEET IT HAS BEEN ELECTRONICALLY SEALED AND DATED.

SEEDING						
SHEET	STATION	TO	STATION	LOCATION	COOL SEASON MIXTURE	REMARKS
					(ACRE)	
4	901+39.4	TO	902+95.75	R/O & L/O ML I-29	0.21	
7	19+84	TO	21+42	NW 56TH ST	0.03	RT
7	19+84	TO	20+58	NW 56TH ST	0.03	LT
7	20+91	TO	21+42	NW 56TH ST	0.01	LT
7	22+71	TO	23+29	NW 56TH ST	0.03	RT
7	22+71	TO	23+31	NW 56TH ST	0.02	LT
7	49+24	TO	49+50	NW PRAIRIE VIEW RD	0.01	RT
7	50+19	TO	50+57	NW PRAIRIE VIEW RD	0.01	RT
				TOTAL:	0.40	
				PAY TOTAL:	0.4	

EROSION CONTROL DEVICES									
SHEET	STATION	TO	STATION	LOCATION	ROCK DITCH CHECK	SILT FENCE	SEDIMENT REMOVAL	ECB, TYPE 2	REMARKS
					(LF)	(LF)	(CY)	(SY)	
50	896+79.06	TO	899+35.74	R/O I-29		258.0	2.58		
50	900+04.43	TO	901+61.14	R/O I-29		185.0	1.85		
50	902+98.98	TO	904+73.95	L/O I-29		310.0	3.10	554.9	
50	896+81.56	TO	902+94.24	R/O I-29	100.00		10.00		
51	19+81	TO	19+93	NW 56TH ST	24		2		RT
51	19+81	TO	20+37	NW 56TH ST		86	1		LT
51	902+66	TO	903+56	NW ROANRIDGE RD	36		3		RT
51	48+98	TO	49+17	NW PRAIRIE VIEW RD	36		2		LT
51	70+45	TO	71+27	RAMP 7	48		4		LT
TOTAL:					244.00	839.00	29.50	554.90	
PAY TOTAL:					244.0	839.0	29.5	554.9	

"THIS MEDIA SHOULD NOT BE CONSIDERED A CERTIFIED DOCUMENT."

DATE PREPARED 7/19/2020	
ROUTE I-29	STATE MO
DISTRICT K-C	SHEET NO. 3
COUNTY	

PLATTE
J413291
CONTRACT ID.
PROJECT NO.
BRIDGE NO.

DATE	DESCRIPTION
.	.
.	.
.	.
.	.
.	.
.	.

MISSOURI HIGHWAYS AND TRANSPORTATION COMMISSION



105 WEST CAPITOL
JEFFERSON CITY, MO 65102
1-888-ASK-MODOT (1-888-275-6636)

BURNS & McDONNELL

9400 Ward Parkway
Kansas City, Missouri 64114
816-333-9400

Certificate of Authority
No. : 000165

BMCD Project No. 109387

IF A SEAL IS PRESENT ON THIS SHEET IT HAS BEEN ELECTRONICALLY SEALED AND DATED. REV.

PERMANENT PAVEMENT MARKINGS										
SHEET	STATION	TO	STATION	LOCATION	ACRYLIC WATERBORNE PAVEMENT MARKING PAINT					REMARKS
					6" SOLID YELLOW EDGE LINE	6" WHITE INTERMITTENT LANE LINE	6" DOTTED WHITE LANE LINE	6" SOLID WHITE EDGE LINE (L.F.)	12" SOLID WHITE GORE LINE (L.F.)	
57	893+00.00	TO	912+61.00	I-29 NB	2072.0	4044	1222	1863.00		
57	899+50.00	TO	900+58.00	I-29 NB					132.00	
58	912+61.00	TO	END	I-29 NB		1416				EDGE LINES WILL REMAIN
57	893+00.00	TO	910+28.00	I-29 SB	1812.0	3524.0		1812.00		
TOTAL & PAY:					3884	2246	306	3675	132	

PERMANENT PAVEMENT MARKING							
LOCATION	STATION	STATION	4" WHITE STANDARD WATERBORNE PVMT MARKING PAINT WITH TYPE P BEADS (LF)	4" YELLOW STANDARD WATERBORNE PVMT MARKING PAINT WITH TYPE P BEADS (LF)	PREFORMED THERMOPLASTIC PAVEMENT MARKING		
					6" SOLID WHITE (LF)	24" WHITE STOP BAR (LF)	LEFT/RIGHT ARROW (EA)
56TH ST	16+97	21+11	620	472		14	
56TH ST	21+11	23+02	557	374		22	2
56TH ST	23+02	23+90	285	52	167	12	
TOTAL			1462	898	167	48	2

56th St - LIGHTING QUANTITIES			
Item	Unit	Totals	
CABLE, 8 AWG 1 CONDUCTOR	LF	1118	
CABLE, 4 AWG 1 CONDUCTOR	LF	140	
WIRE, 8 AWG, BARE NEUTRAL	LF	559	
WIRE, 4 AWG, BARE NEUTRAL	LF	70	
POWER SUPPLY ASSEMBLY, TYPE 1, 240/120 VOLT SERVICE, LIGHTING ONLY	EA	1	
BASE MOUNTED CONTROL STATION 240 VOLT - 4 CIRCUIT	EA	1	
LUMINAIRE, 150 WATT HIGH PRESSURE SODIUM (UNDERPASS)	EA	4	
CONDUIT, 2 IN. RIGID, IN TRENCH	LF	65	
CONDUIT, 2 IN. RIGID, EXTERNAL ON STRUCTURE	LF	268	
CONDUIT, 3 IN. RIGID, PUSHED	LF	197	
CONDUIT, 3 IN. RIGID, IN TRENCH	LF	60	
MISC. - CONDUIT, 1" FLEXIBLE	LF	8	
PULL BOX, PREFORMED CLASS 1	EA	4	
MISC. JUNCTION BOX, NEMA	EA	4	

ADJUST PULL BOX					
SHEET	STATION	OFFSET (FT)	LOCATION	ADJUST PULL BOX (EA)	REMARKS
7	21+14	27	NW 56TH ST	1.0	ADJUST FLUSH W/ SHOULDER
TOTAL & PAY:				1	

"THIS MEDIA SHOULD NOT BE CONSIDERED A CERTIFIED DOCUMENT."

DATE PREPARED
7/19/2020

ROUTE
I-29

STATE
MO

DISTRICT
K-C

SHEET NO.
3

COUNTY
PLATTE

JOB NO.
J413291

CONTRACT ID.
.

PROJECT NO.
.

BRIDGE NO.
.

DESCRIPTION	DATE
.	.
.	.
.	.
.	.
.	.
.	.

MISSOURI HIGHWAYS AND TRANSPORTATION COMMISSION



105 WEST CAPITOL
JEFFERSON CITY, MO 65102
1-888-ASK-MODOT (1-888-278-6636)

BURNS & McDONNELL

9400 Ward Parkway
Kansas City, Missouri 64114
816-333-9400
Certificate of Authority
No. : 000165
BMOB Project No. 109387

REV.

IF A SEAL IS PRESENT ON THIS SHEET IT HAS BEEN ELECTRONICALLY SEALED AND DATED.

 

ANY WORK INDICATED ON THE PLANS THAT EXTENDS BEYOND THE PROJECT LIMITS IS CONSIDERED INCIDENTAL TO AND A PART OF THE CONSTRUCTION OF THIS PROJECT.

THE EXISTENCE AND APPROXIMATE LOCATION OF UTILITY FACILITIES KNOWN TO EXIST, AS SHOWN ON THE PLANS, ARE BASED ON THE BEST INFORMATION AVAILABLE TO THE COMMISSION AT THIS TIME. THIS INFORMATION IS PROVIDED BY THE COMMISSION "AS-IS" AND THE COMMISSION EXPRESSLY DISCLAIMS ANY REPRESENTATION OR WARRANTY AS TO THE COMPLETENESS, ACCURACY, OR SUITABILITY OF THE INFORMATION FOR ANY USE. RELIANCE UPON THIS INFORMATION IS DONE AT THE RISK AND PERIL OF THE USER, AND THE COMMISSION SHALL NOT BE LIABLE FOR ANY DAMAGES THAT MAY ARISE FROM ANY ERROR IN THE INFORMATION.

BEGIN PROJECT AT STA. 896+50.00 (C I-29)
A DISTANCE OF 498.02, N36°28'57"W OF THE
NW COR 33-51-33

STA. 896+50.00 TO STA 899+98.00 C I-29
INSTALL 348' TYPE C CONCRETE TRAFFIC BARRIER
ADJUST TO ALIGN WITH OVERHEAD SIGN FOUNDATION

STA. 10+00 TO 10+75, E 56TH RAMP
75' TYPE D CONCRETE TRAFFIC BARRIER

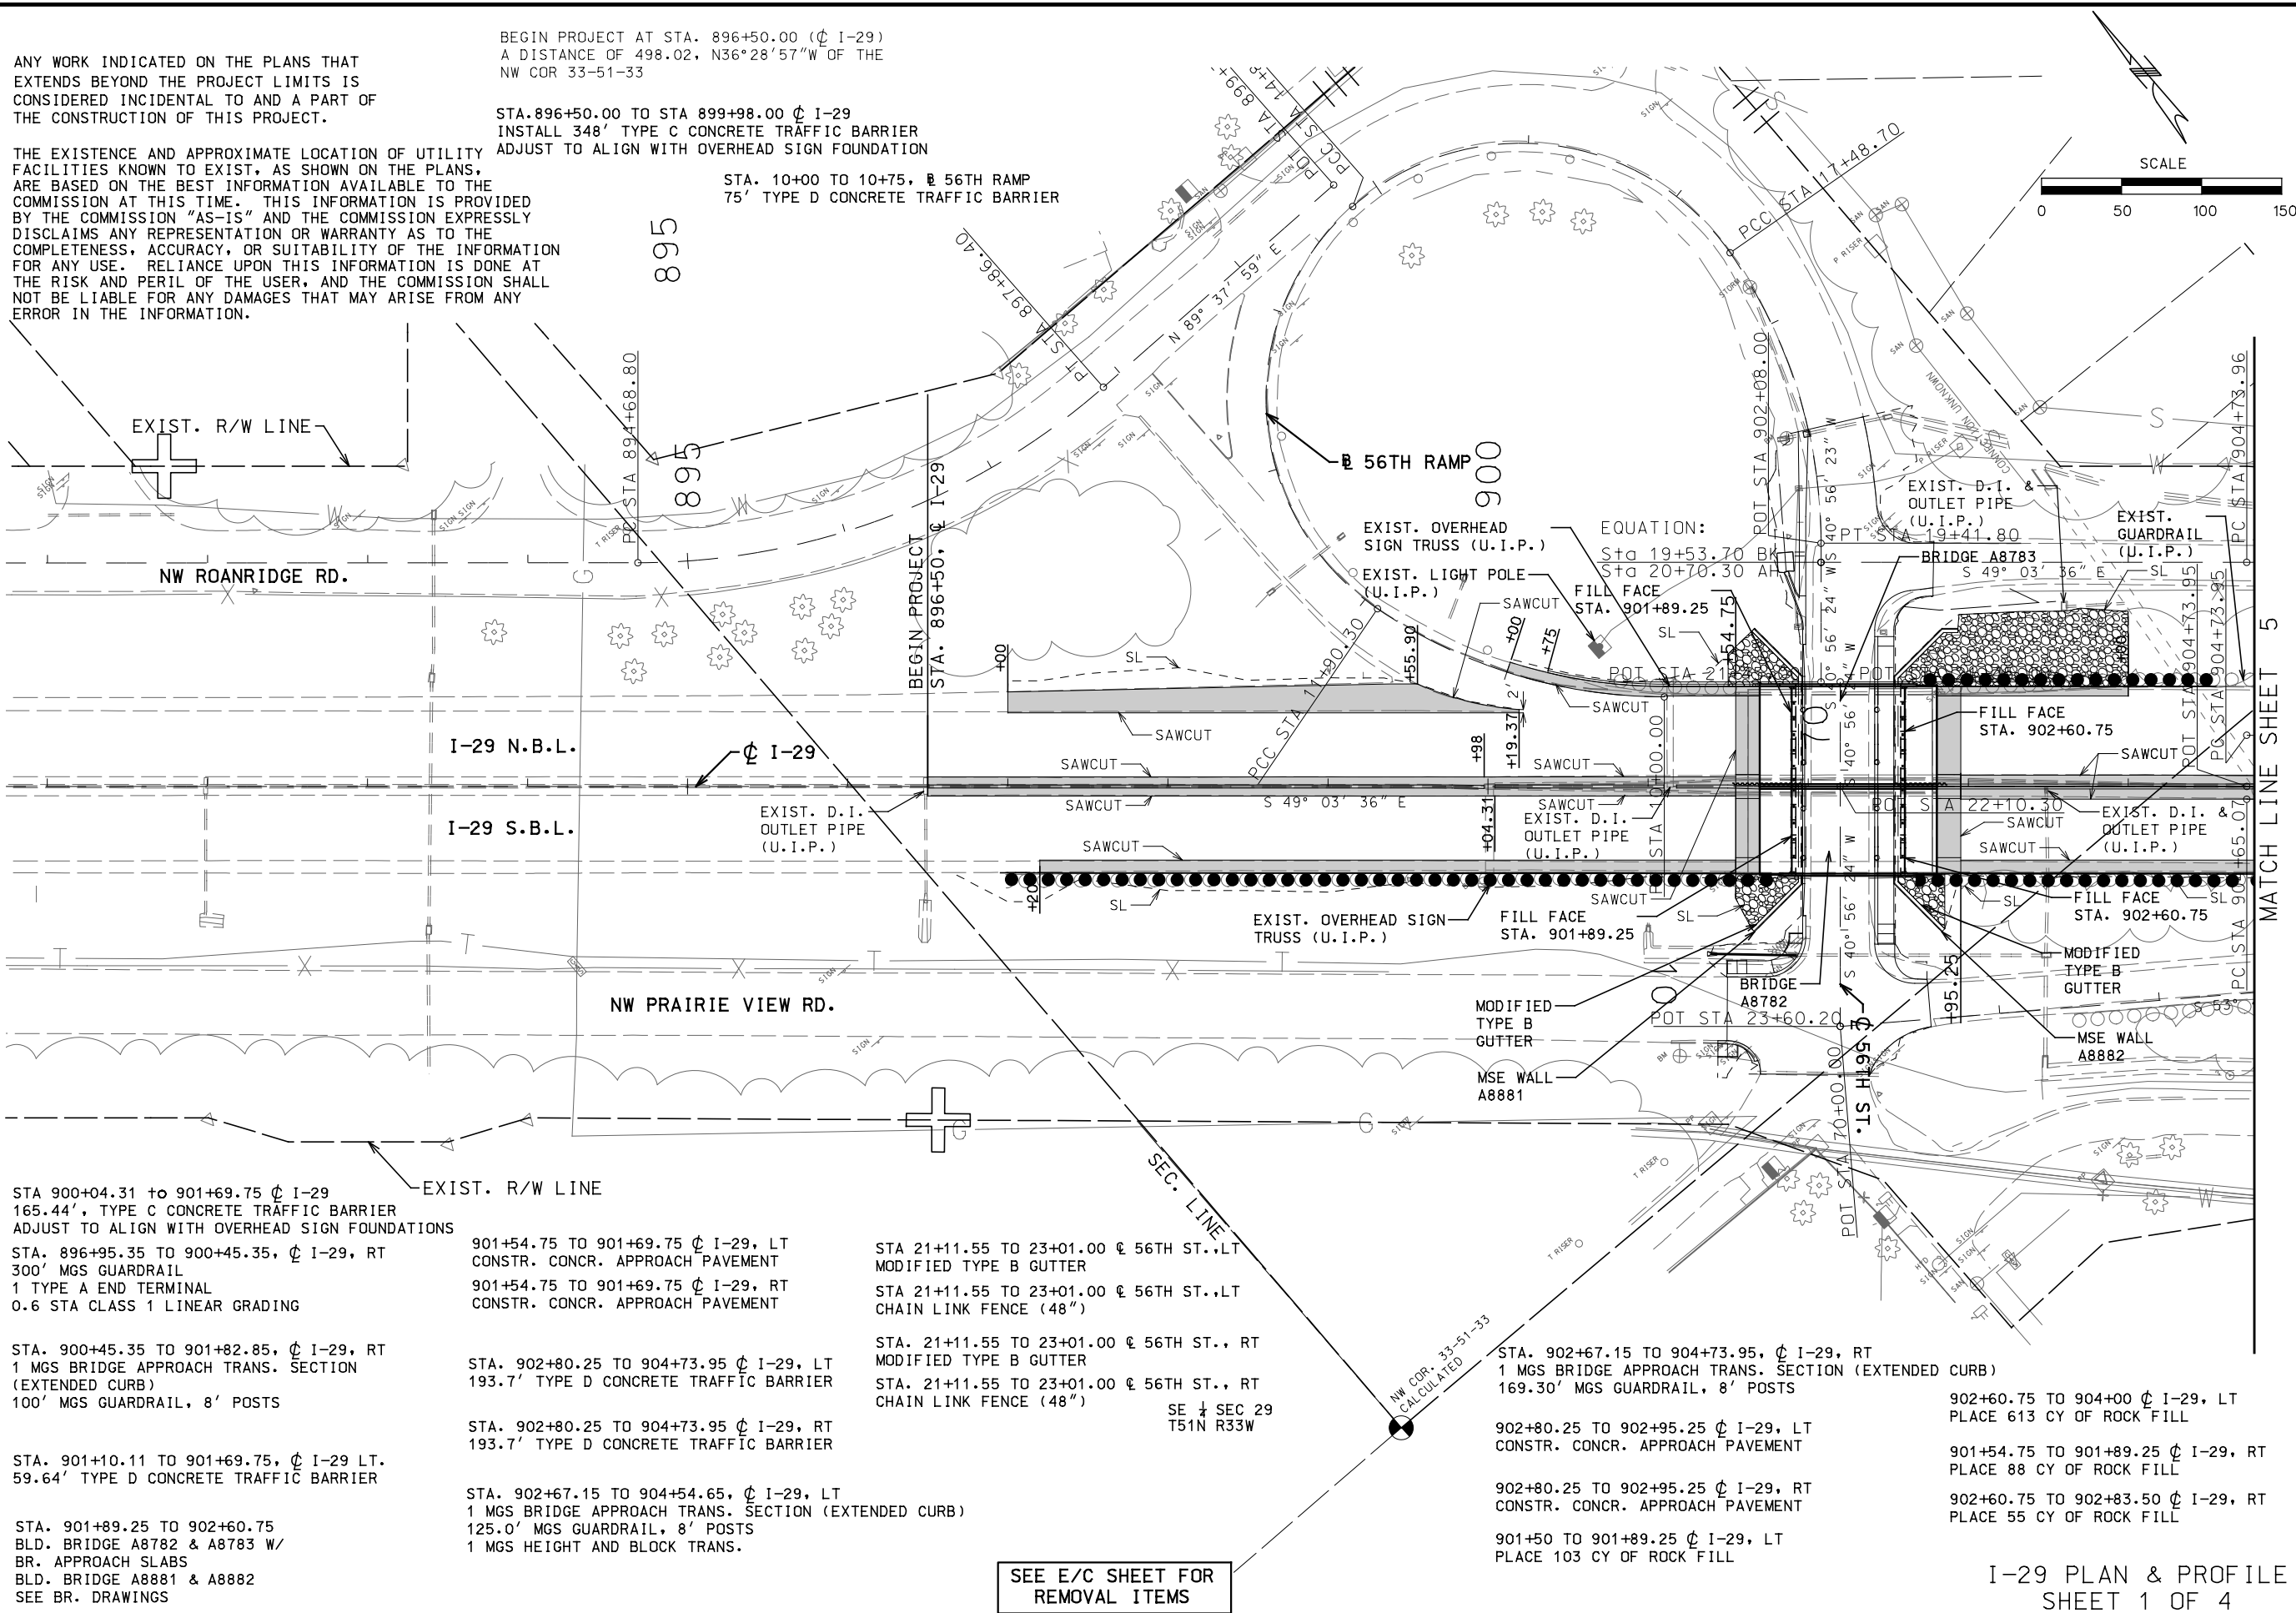

MATCH LINE SHEET 5

STA 900+04.31 to 901+69.75 C I-29
165.44', TYPE C CONCRETE TRAFFIC BARRIER
ADJUST TO ALIGN WITH OVERHEAD SIGN FOUNDATIONS

STA. 896+95.35 TO 900+45.35, C I-29, RT
300' MGS GUARDRAIL
1 TYPE A END TERMINAL
0.6 STA CLASS 1 LINEAR GRADING

STA. 900+45.35 TO 901+82.85, C I-29, RT
1 MGS BRIDGE APPROACH TRANS. SECTION
(EXTENDED CURB)
100' MGS GUARDRAIL, 8' POSTS

STA. 901+10.11 TO 901+69.75, C I-29 LT.
59.64' TYPE D CONCRETE TRAFFIC BARRIER

STA. 901+89.25 TO 902+60.75
BLD. BRIDGE A8782 & A8783 W/
BR. APPROACH SLABS
BLD. BRIDGE A8881 & A8882
SEE BR. DRAWINGS

901+54.75 TO 901+69.75 C I-29, LT
CONSTR. CONCR. APPROACH PAVEMENT
901+54.75 TO 901+69.75 C I-29, RT
CONSTR. CONCR. APPROACH PAVEMENT

STA. 902+80.25 TO 904+73.95 C I-29, LT
193.7' TYPE D CONCRETE TRAFFIC BARRIER

STA. 902+80.25 TO 904+73.95 C I-29, RT
193.7' TYPE D CONCRETE TRAFFIC BARRIER

STA. 902+67.15 TO 904+54.65, C I-29, LT
1 MGS BRIDGE APPROACH TRANS. SECTION (EXTENDED CURB)
125.0' MGS GUARDRAIL, 8' POSTS
1 MGS HEIGHT AND BLOCK TRANS.

STA 21+11.55 TO 23+01.00 E 56TH ST.,LT
MODIFIED TYPE B GUTTER
STA 21+11.55 TO 23+01.00 E 56TH ST.,LT
CHAIN LINK FENCE (48")

STA. 21+11.55 TO 23+01.00 E 56TH ST., RT
MODIFIED TYPE B GUTTER
STA. 21+11.55 TO 23+01.00 E 56TH ST., RT
CHAIN LINK FENCE (48")

SE 1/4 SEC 29
T51N R33W

SEE E/C SHEET FOR
REMOVAL ITEMS

NW COR. 33-51-33
CALCULATED

STA. 902+67.15 TO 904+73.95, C I-29, RT
1 MGS BRIDGE APPROACH TRANS. SECTION (EXTENDED CURB)
169.30' MGS GUARDRAIL, 8' POSTS

902+80.25 TO 902+95.25 C I-29, LT
CONSTR. CONCR. APPROACH PAVEMENT

902+80.25 TO 902+95.25 C I-29, RT
CONSTR. CONCR. APPROACH PAVEMENT

901+50 TO 901+89.25 C I-29, LT
PLACE 103 CY OF ROCK FILL

902+60.75 TO 904+00 C I-29, LT
PLACE 613 CY OF ROCK FILL

901+54.75 TO 901+89.25 C I-29, RT
PLACE 88 CY OF ROCK FILL

902+60.75 TO 902+83.50 C I-29, RT
PLACE 55 CY OF ROCK FILL

I-29 PLAN & PROFILE
SHEET 1 OF 4

"THIS MEDIA SHOULD
NOT BE CONSIDERED
A CERTIFIED
DOCUMENT."

DATE PREPARED
7/19/2020

ROUTE
I-29

DISTRICT
K-C

COUNTY
PLATTE

JOB NO.
J413291

CONTRACT ID.

PROJECT NO.

BRIDGE NO.

DESCRIPTION

DATE

DATE


DATE

DATE

DATE

DATE

MISSOURI HIGHWAYS AND TRANSPORTATION
COMMISSION

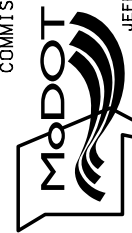

Burns & McDonnell Engineering Co., Inc.

9400 Ward Parkway
Kansas City, Missouri 64114
816-333-9400

Certification of Authority
No. : 000165

BMD Project No. 109387



105 WEST CAPITOL
JEFFERSON CITY, MO 65102
1-888-ASK-MODOT (1-888-275-6636)

REV.

IF A SEAL IS PRESENT ON THIS SHEET IT HAS BEEN ELECTRONICALLY SEALED AND DATED.

END PROJECT AT STA. 907+75.00 (E I-29 SB)
A DISTANCE OF 919.92', S65°34'30"E OF THE
NW COR 33-51-33

STA. 904+65.07 TO 907+50 E I-29 SB
284.93' CONCRETE BARRIER TYPE D


STA. 904+73.95 TO 907+74.40 C I-29 NB
300.45' CONCRETE BARRIER TYPE D

SW 1/4 SEC 28 T51N R33W

NW 1/4 SEC 33 T51N R33W

SCALE

0 50 100 150

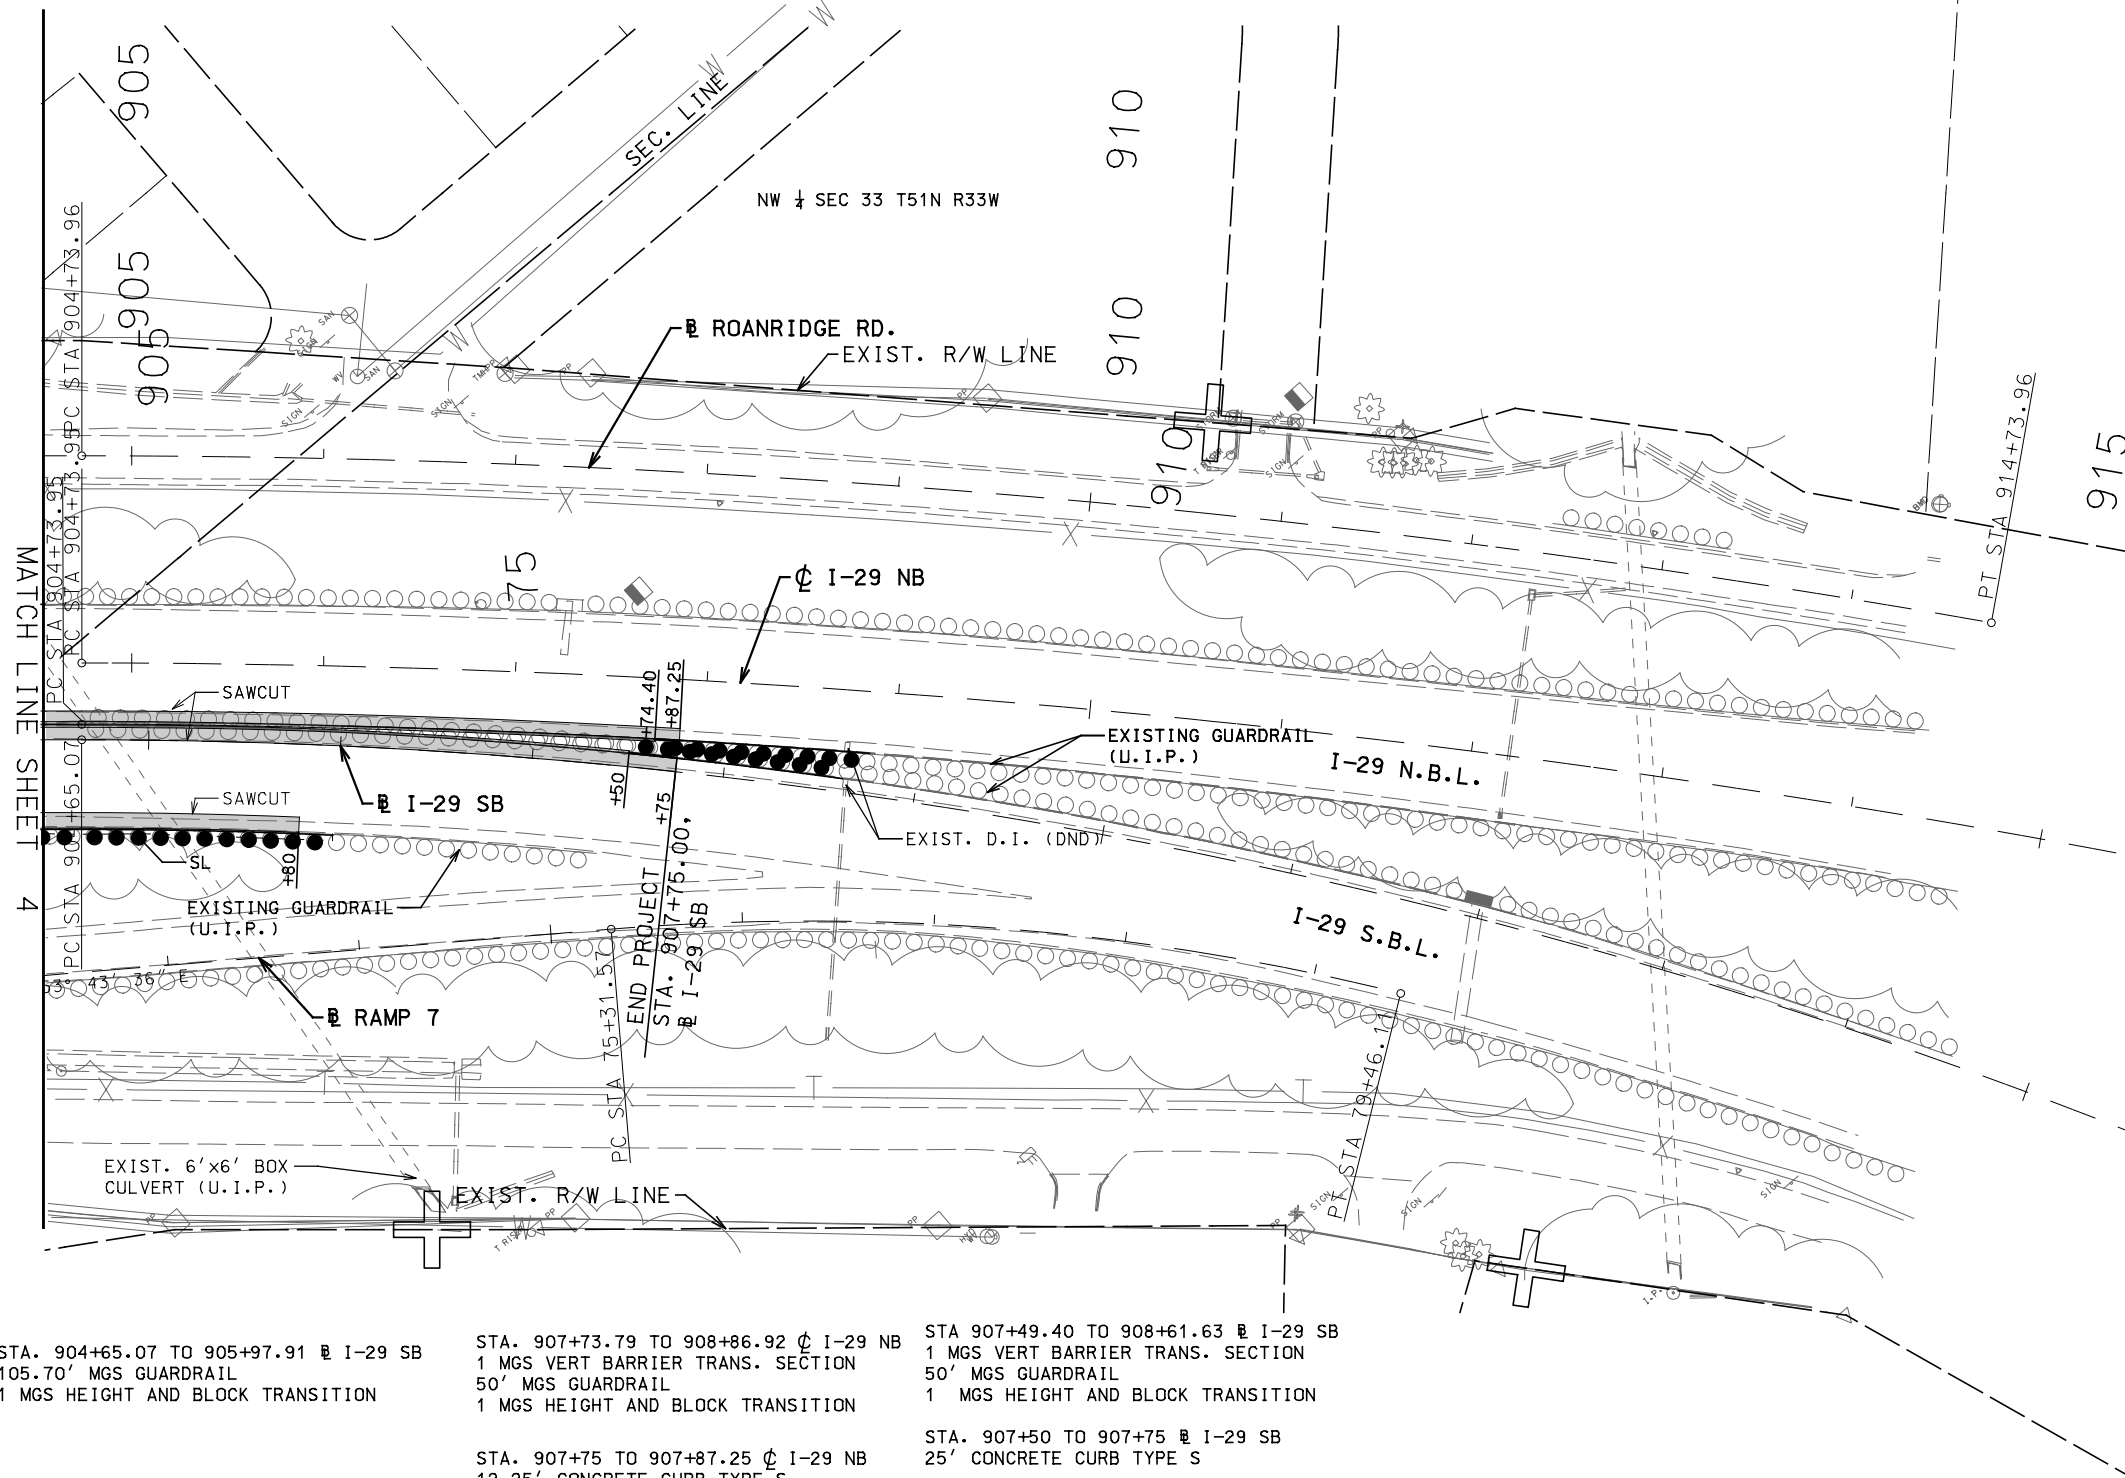

STA. 904+65.07 TO 905+97.91 E I-29 SB
105.70' MGS GUARDRAIL
1 MGS HEIGHT AND BLOCK TRANSITION

STA. 907+73.79 TO 908+86.92 C I-29 NB
1 MGS VERT BARRIER TRANS. SECTION
50' MGS GUARDRAIL
1 MGS HEIGHT AND BLOCK TRANSITION

STA 907+49.40 TO 908+61.63 E I-29 SB
1 MGS VERT BARRIER TRANS. SECTION
50' MGS GUARDRAIL
1 MGS HEIGHT AND BLOCK TRANSITION

STA. 907+75 TO 907+87.25 C I-29 NB
12.25' CONCRETE CURB TYPE S

STA. 907+50 TO 907+75 E I-29 SB
25' CONCRETE CURB TYPE S

SEE E/C SHEET FOR
REMOVAL ITEMS

I-29 PLAN AND PROFILE
SHEET 2 OF 4

"THIS MEDIA SHOULD
NOT BE CONSIDERED
A CERTIFIED
DOCUMENT."

DATE PREPARED
7/19/2020

ROUTE I-29 STATE MO
DISTRICT K-C SHEET NO. 5

COUNTY

PLATTE

JOB NO.

J413291

CONTRACT ID.

PROJECT NO.

BRIDGE NO.

DESCRIPTION

DATE

MISSOURI HIGHWAYS AND TRANSPORTATION
COMMISSION

105 WEST CAPITOL
JEFFERSON CITY, MO 65102
1-888-ASK-MODOT (1-888-275-6636)




Burns & McDonnell Engineering Co., Inc.

9400 Ward Parkway
Kansas City, Missouri 64114
816-333-9400

Certificate of Authority
No. : 000165

BMD Project No. 109387



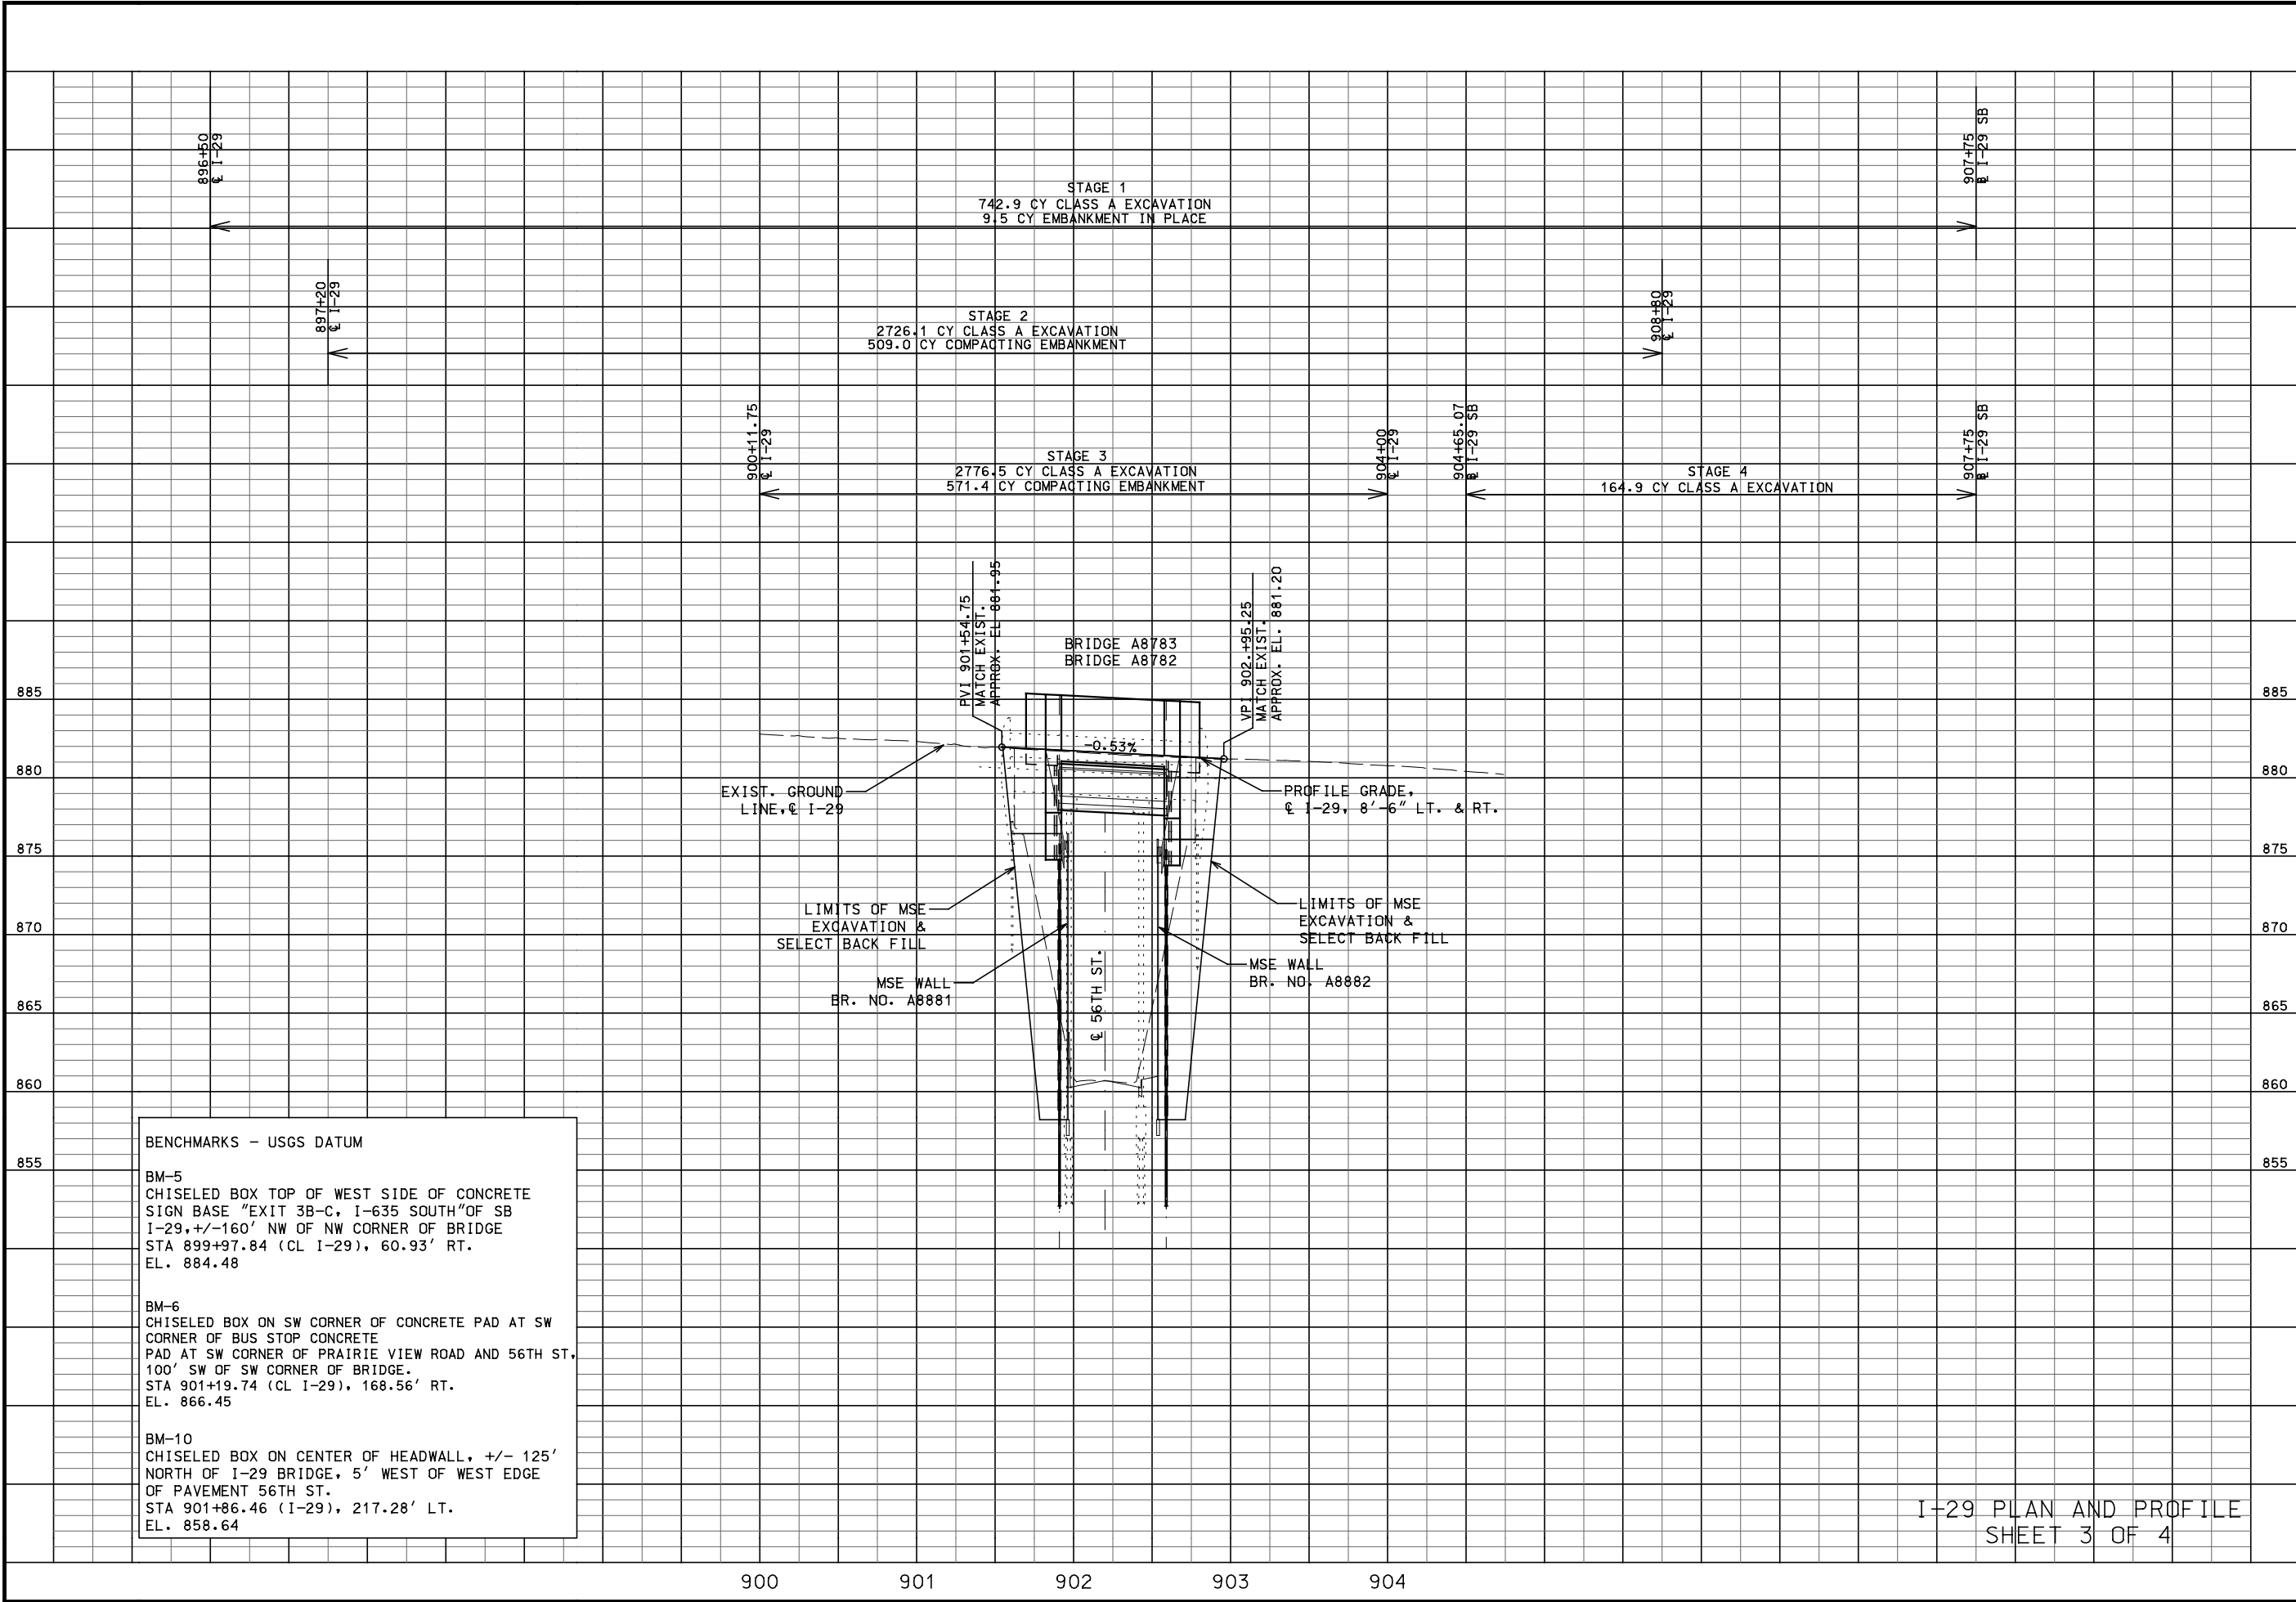

"THIS MEDIA SHOULD NOT BE CONSIDERED A CERTIFIED DOCUMENT."

DATE PREPARED
7/19/2020

ROUTE
I-29

STATE
MO

DISTRICT
K-C

SHEET NO.
6

COUNTY
PLATTE

JOB NO.
J413291

CONTRACT ID.
.

PROJECT NO.
.

BRIDGE NO.
.

DATE	DESCRIPTION
.	.
.	.
.	.
.	.
.	.
.	.

MISSOURI HIGHWAYS AND TRANSPORTATION COMMISSION

MoDOT

105 WEST CAPITOL
JEFFERSON CITY, MO 65102
1-888-ASK-MODOT (1-888-275-6636)

Burns & McDonnell Engineering Co., Inc.



9400 Ward Parkway
Kansas City, Missouri 64114
816-333-9400

Certificate of Authority
No. : 000165

BMd Project No. 109387

BURNS MEDONNELL

I-29 PLAN AND PROFILE
SHEET 3 OF 4

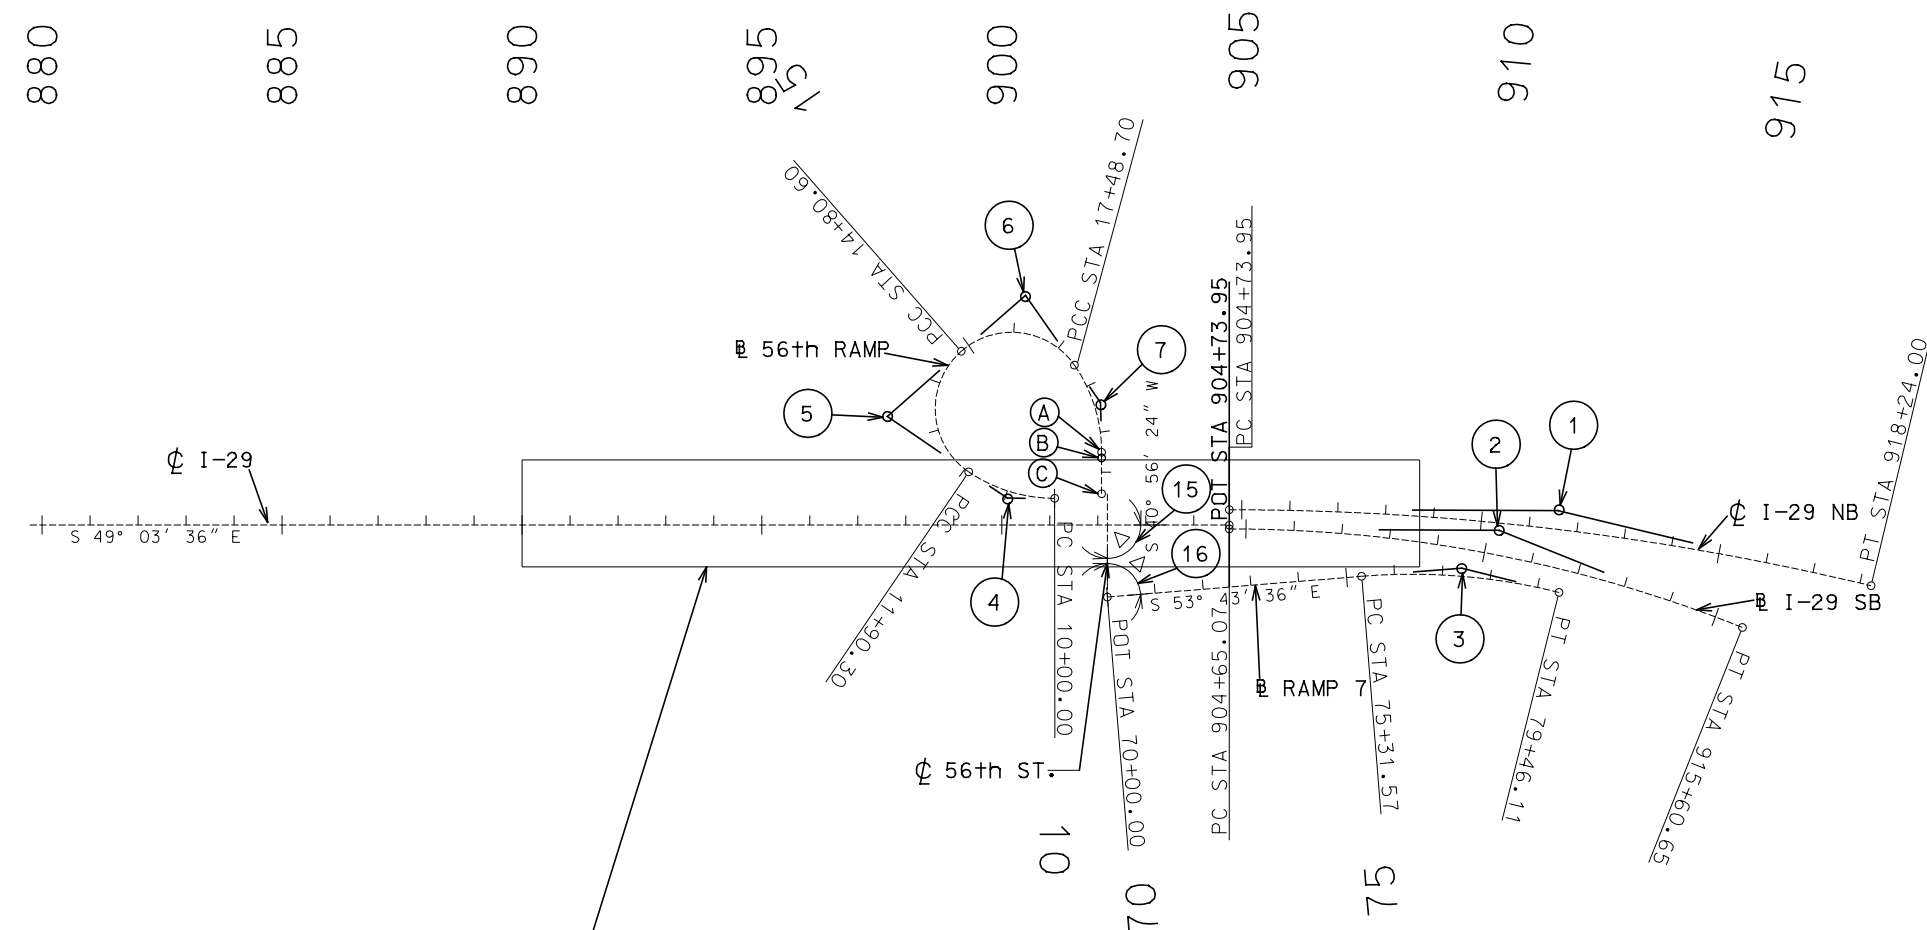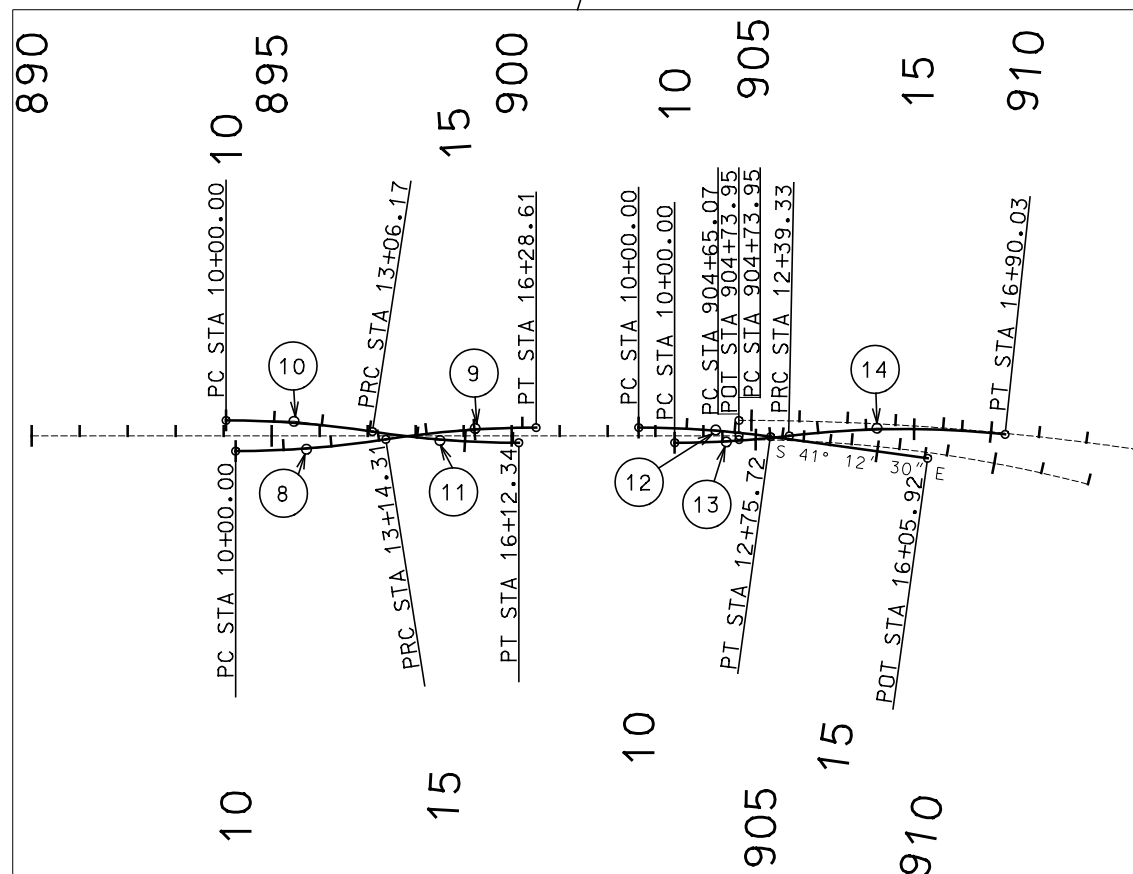

	LOCATION	STATION	
A	Ø 56th RAMP		19+41.80
B	Ø 56th RAMP	19+53.70 BK	20+70.30 AH
C	Ø 56th RAMP		21+45.00


CURVE DATA									
NO	LOCATION	P. I STATION	Δ	D	T	L	R	S.E	
1	☺ I29 NB C NB	911+52.12	13°30'01.19"	0°59'59.95"	678.17'	1,350.05'	5,729.65'	EXIST.	5.0%
2	☺ I29 C SB	910+19.52	21°43'42.59"	1°58'59.83"	554.45'	1,095.58'	2,888.93'	EXIST.	4.0%
3	☺ Ramp 7	77+40.69	18°39'15.46"	4°29.59.99"	209.12'	414.54'	1,273.24'	EXIST.	8.0%
4	☺ 56th RAMP C1	10+98.09	34°15'14.36"	17°59'59.98"	98.09'	190.30'	318.31'		
5	☺ 56th RAMP C2	13+95.88	104°30'16.85"	35°59'55.88"	205.58'	290.30'	159.16'		
6	☺ 56th RAMP C3	16+58.96	96°30'46.56"	35°59'55.88"	178.36'	268.10'	159.16'		
7	☺ 56th RAMP C4	18+48.32	34°45'28.76"	17°59'59.98"	99.62'	193.10'	318.31'		
8	I-29 TEMPCONN.2-1	11+57.47	8°57'01.9" (LT)	2°50'51.7"	157.47'	314.31'	2,012.00'		
9	I-29 TEMPCONN.2-2	14+71.78	8°57'01.9" (RT)	2°50'51.7"	157.47'	314.31'	2,012.00'		
10	I-29 TEMPCONN.1-1	11+53.38	8°43'07.5" (RT)	2°50'51.7"	153.38'	306.17'	2,012.00'		
11	I-29 TEMPCONN.1-2	14+59.55	8°43'07.5" (LT)	2°50'51.7"	153.38'	306.17'	2,012.00'		
12	I-29 TEMPCONN.3-1	11+38.08	7°51'06.0" (RT)	2°50'51.7"	138.08'	275.72'	2,012.00'		
13	I-29 TEMPCONN.4-1	11+19.81	6°48'55.8" (LT)	2°50'51.7"	119.81'	239.33'	2,012.00'		
14	I-29 TEMPCONN.4-2	14+65.63	12°50'04.8" (RT)	2°50'51.7"	226.30'	450.70'	2,012.00'		

INTERSECTION POINT					
NO	MAIN	CROSSROAD	MAIN STATION	CROSSROAD STATION	Δ
8	56th ST.	I-29 SB	22+10.30	901+20.00	90°00'00"
9	56th ST.	RAMP 7	23+60.20	70+00.00	85°20'00"

ALIGNMENT LAYOUT SHEET
SHEET 1 OF 1


REFERENCE POINTS

RM-1: NNW 47.50' TO SOUTH FACE OF METAL SIGN BASE
RM-2: NORTH 1.75' TO CHAIN LINK FENCE
RM-3: SW 67.87' TO NORTH FACE OF METAL SIGN BASE

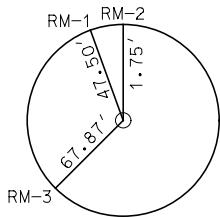


CP 3 - SET 1/2" IRON BAR OFF NORTH EDGE
OF PAVEMENT OF NW PRAIRIE VIEW RD,
+/-70' SE OF CL OF N. ADRIAN AVE.
N: 1104585.279
E: 2753108.497
ELEVATION: 889.65
Ø SURVEY STA. 881+20.23
OFFSET 110.38' RT.

RM-1: NE 2.8' TO CHAIN LINK FENCE
RM-2: SE 27.9' TO NW FACE OF 20MPH SIGN
RM-3: SOUTH 39.4' TO NORTH FACE OF METAL
SIGN POST "CITY LIMIT"
RM-4: WNW 59.5' TO SE FACE OF METAL SIGN POST

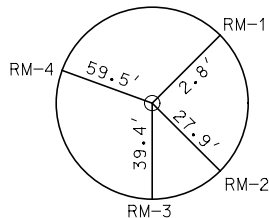


CP 7 - SET 1/2" IRON BAR OFF NORTH EDGE
OF PAVEMENT OF NW PRAIRIE VIEW RD,
+/-180' SE OF N. VENETIAN AVE.
N: 1102385.126
E: 2755458.456
ELEVATION: 841.21
Ø SURVEY STA. 913+70.10
OFFSET 88.21' RT.

RM-1: NORTH 44.95' TO SOUTH FACE OF METAL STOP SIGN POST
RM-2: NE 46.72' TO SOUTH FACE OF METAL "DO NOT ENTER" SIGN POST
RM-3: SW 58.76' TO NORTH FACE OF METAL SIGN POST

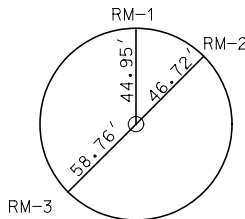


CP 11 - SET COTTON SPINDLE AT SOUTH END OF
ASPHALT ISLAND AT INTERSECTION OF ROANRIDGE RD
AND NB I-29 OFF RAMP TO 56TH STREET
N: 1103711.786
E: 2754616.783
ELEVATION: 879.18
Ø SURVEY STA. 898+32.47
OFFSET 218.11' LT.

RM-1: NORTH 59.37' TO EDGE OF PAVEMENT OF SB I-29
RM-2: NW 7.2' TO SOUTH FACE OF CHAIN LINK FENCE
RM-3: NE 12.80' TO SOUTH FACE OF CHAIN LINK FENCE
RM-4: SOUTH 0.7' TO NORTH EDGE OF PAVEMENT

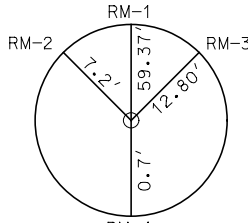


CP 4 - SET 1/2" IRON BAR OFF NORTH EDGE
OF PAVEMENT OF NW PRAIRIE VIEW RD, +/-800'
SE OF CL OF N. ADIRAN AVE.
N: 1104102.367
E: 2753661.345
ELEVATION: 892.39
Ø SURVEY STA. 888+54.28
OFFSET 112.91' RT.

RM-1: SW 6.3' TO NORTH EDGE OF PAVEMENT ROANRIDGE RD.
RM-2: NW 55.3' TO END OF GUARD RAIL
RM-3: SE 47.2' TO END OF GUARD RAIL

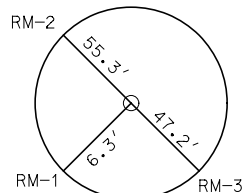


CP 8 - SET 1/2" IRON BAR OFF NORTH
SHOULDER OF ROANRIDGE RD, +/-210'
SE OF CL N. MAYVIEW AVE.
N: 1102664.519
E: 2755643.234
ELEVATION: 848.76
Ø SURVEY STA. 912+78.68
OFFSET 125.26' LT.

RM-1: SW 0.75' TO EDGE OF PAVEMENT
RM-2: WEST 16.20' TO NORTH FACE OF METAL FENCE POSTS
RM-3: SW 6.3' TO NORTH FACE OF METAL FENCE POST
RM-4: SE 4.5' TO NORTH FACE OF METAL FENCE POST
RM-5: EAST 13.55' TO NORTH FACE OF METAL FENCE POST

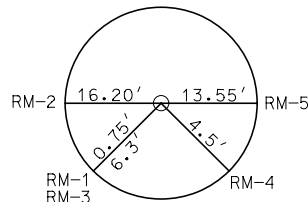


CP 12 - SET COTTON SPINDLE IN
SB LANE OF ROANRIDGE RD, +/-75'
SE OF CL OF N. LENOX AVE.
N: 1104034.046
E: 2754098.884
ELEVATION: 901.94
Ø SURVEY STA. 892+29.57
OFFSET 122.19' LT.

RM-1: NORTH 4.0' TO SOUTH FACE OF GUARD RAIL
RM-2: WEST 45.60' TO EAST FACE OF METAL SIGN BASE
RM-3: EAST 46.60' TO WEST FACE OF METAL SIGN BASE

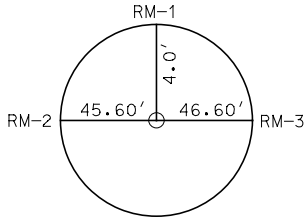


CP 5 - SET 1/2" IRON BAR OFF
SOUTH SHOULDER OF SB I-29, +/-200' NW OF NW
CORNER OF I-29 BRIDGE OVER NW 56TH ST.
N: 1103425.148
E: 2754525.471
ELEVATION: 883.09
Ø SURVEY STA. 899+50.8
OFFSET 58.25' RT.

RM-1: WEST 9.0' TO NORTH FACE OF METAL FENCE POST
RM-2: EAST 12.0' TO NORTH FACE OF METAL FENCE POST
RM-3: NORTH 4.5' TO SOUTH EDGE OF PAVEMENT

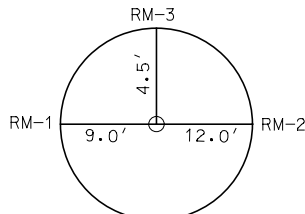


CP 9 - SET 1/2" IRON BAR OFF NORTH
SHOULDER OF ROANRIDGE RD, +/-275'
NW OF CL N. MAYVIEW AVE.
N: 1102995.441
E: 2755285.405
ELEVATION: 870.52
Ø SURVEY STA. 908+1.32
OFFSET 92.61' LT.

RM-1: SW 1.6' TO EDGE OF PAVEMENT
RM-2: WEST 13.6' TO NORTH FACE OF METAL FENCE POST
RM-3: SW 5.44' TO NORTH FACE OF METAL FENCE POST
RM-4: SE 7.45' TO NORTH FACE OF METAL FENCE POST
RM-5: EAST 16.85' TO NORTH FACE OF METAL FENCE POST

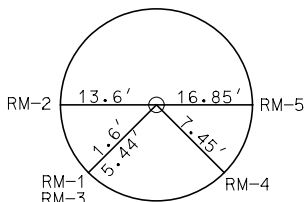


CP 13 - SET COTTON SPINDLE IN
SB LANE OF ROANRIDGE RD, +/-500'
NE OF CL OF N. AVA TERRACE.
N: 1104683.165
E: 2753351.842
ELEVATION: 910.01
Ø SURVEY STA. 882+39.91
OFFSET 123.02' LT.

RM-1: NE 18.70' TO SOUTH FACE OF METAL STOP SIGN BASE
RM-2: SE 56.05' TO NORTH FACE OF METAL SIGN POST "HOUSTON LAKE"
RM-3: WEST 46.15' TO EAST FACE OF METAL STOP SIGN BASE

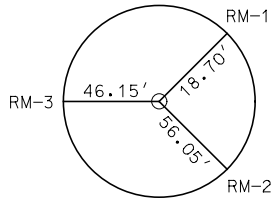

CP 6 - SET 1/2" IRON BAR WEST SIDE OF
INTERSECTION OF NW PRAIRIE VIEW RD AND
N 56TH STREET
N: 1103131.473
E: 2754659.430
ELEVATION: 858.69
Ø SURVEY STA. 902+44.43
OFFSET 192.31' RT.

RM-1: EAST 20.15' TO WEST EDGE OF PAVEMENT OF 56TH ST.
RM-2: NNE 28.6' TO SW CORNER OF CONCRETE VAULT
RM-3: NE 73.85' TO SOUTH FACE OF METAL SIGN BASE
RM-4: ENE 63.6' TO WEST FACE OF METAL STOP SIGN BASE

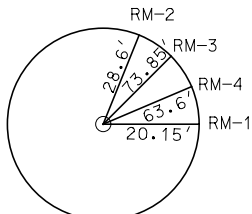

CP 10 - SET 1/2" IRON BAR EAST OF INTERSECTION
OF N 56TH ST. AND ROANRIDGE RD
N: 1103431.721
E: 2754844.799
ELEVATION: 858.41
Ø SURVEY STA. 901+87.71
OFFSET 155.96' LT.

"THIS MEDIA SHOULD
NOT BE CONSIDERED
A CERTIFIED
DOCUMENT."

DATE PREPARED
7/19/2020

ROUTE I-29 STATE MO
DISTRICT K-C SHEET NO. 9

COUNTY
PLATTE

JOB NO.
J413291

CONTRACT ID.
.

PROJECT NO.
.

BRIDGE NO.
.

DATE	DESCRIPTION
.	.
.	.
.	.
.	.
.	.
.	.

MISSOURI HIGHWAYS AND TRANSPORTATION
COMMISSION
MoDOT
105 WEST CAPITOL
JEFFERSON CITY, MO 65102
1-888-ASK-MODOT (1-888-275-6636)

Burns & McDonnell Engineering Co., Inc.
9400 Ward Parkway
Kansas City, Missouri 64114
816-333-9400
Certificate of Authority
No. : 000165
BMD Project No. 109387

BURNS
& MCDONNELL

REFERENCE POINTS
SHEET 1 OF 1

COORDINATE POINT LISTING
MISSOURI COORDINATE SYSTEM OF 1983 (WEST ZONE)

SURVEYOR NOTES

1) PROJECT "GROUND" COORDINATES SHOWN HEREON ARE BASED ON THE MISSOURI STATE PLANE COORDINATE SYSTEM OF 1983, NAVD 88, WEST ZONE, USING THE MISSOURI HIGHWAY AND TRANSPORTATION COMMISSION GLOBAL NAVIGATION SATELLITE REAL TIME NETWORK FOR BASE STATION. ALL COORDINATES ARE SHOWN IN U.S. SURVEY FEET UNLESS OTHERWISE NOTED. PROJECT INITIAL START DATE WAS JULY OF 2018.

CHECKED HORIZONTAL AND VERTICAL CONTROL STATIONS

PL-19 GRID METERS FROM MGRS DATA SHEET, DATE OF REPORT 2001
NORTHING 335873.535(m) / EASTING 840026.812(m) / ELEVATION 269.7(m)

PL-19 PROJECT COORDINATES CALCULATED FROM MGRS DATA SHEET
NORTHING 1102049.5626 / EASTING 2756249.2553 / ELEVATION 884.84

PL-19 MEASURED WITH TRIMBLE R8 RECIEVER
NORTHING 1102049.5359 / EASTING 2756249.3048 / ELEVATION 884.85

CL-14 GRID METERS FROM MGRS DATA SHEET, DATE OF REPORT 2003
NORTHING 337007.919(m) / EASTING 842215.255(m) / ELEVATION 280.9(m)

CL-14 PROJECT COORDINATES CALCULATED FROM MGRS DATA SHEET
NORTHING 1105771.6403 / EASTING 2763429.8528 / ELEVATION 921.57

CL-14 MEASURED WITH TRIMBLE R8 RECIEVER
NORTHING 1105771.6403 / EASTING 2763429.8833 / ELEVATION 921.60

PROJECTION FACTOR = 1.000094809
GRID FACTOR = 0.9999052
1 METER = 3.28083333 U.S. FEET
MGRS = MISSOURI GEOGRAPHIC REFERENCE STATION

			PROJECT (GROUND) COORDINATES		STATE PLANE COORDINATES		
SHEET NO.	POINT ID	STATION	NORTH	EAST	NORTH	EAST	DESCRIPTION
			CL I-29 MEDIAN				
	Point 2	860+00.00	1106057.98	2751579.21	1106162.84	2751840.09	
	Point 3	904+73.95	1103126.35	2754958.82	1103230.93	2755220.02	
			CL I-29 LT LN				
		904+73.95	1103150.52	2754979.79	1103255.12	2755240.99	P.C.
		911+52.12	1102706.14	2755492.08	1102810.69	2755753.32	P.I.
		918+24.00	1102154.45	2755886.47	1102258.94	2756147.75	P.T.
			BL I-29 SB				
		904+65.07	1103120.30	2754953.58	1103224.89	2755214.78	P.C.
		910+19.52	1102756.99	2755372.41	1102861.54	2755633.65	P.I.
		915+60.65	1102264.44	2755626.98	1102368.94	2755888.24	P.T.
			CL SURVEY 56TH				
	Point 7	21+45.00	1103342.08	2754809.78	1103446.69	2755070.96	
	Point 8	22+10.30	1103292.75	2754766.99	1103397.35	2755028.17	
	Point 9	23+60.20	1103179.52	2754668.77	1103284.11	2754929.93	
			RAMP 7				
	Point 1	70.00.00	1103179.52	2754668.77	1103284.11	2754929.93	Point 1
		75+31.57	1102865.02	2755097.32	1102969.58	2755358.53	P.C.
		77+40.69	1102741.30	2755265.91	1102845.85	2755527.14	P.I.
		79+46.11	1102570.15	2755386.08	1102674.68	2755647.31	P.T.
			1101838.53	2754344.02	1101943.00	2754605.16	C.C.
			BL 56 Ramp				
		10+00.00	1103407.00	2754720.62	1103511.60	2754981.80	P.C.
		10+98.09	1103471.23	2754646.50	1103575.85	2754907.66	P.I.
		11+90.30	1103566.05	2754621.38	1103670.67	2754882.54	P.T.
			1103647.55	2754929.08	1103752.19	2755190.27	C.C.
		11+90.30	1103566.05	2754621.38	1103670.67	2754882.54	P.C.
		13+95.88	1103764.77	2754568.74	1103869.42	2754829.90	P.I.
		14+80.60	1103765.96	2754774.31	1103870.60	2755035.49	P.T.
			1103606.80	2754775.23	1103711.43	2755036.41	C.C.
		14+80.60	1103765.96	2754774.31	1103870.60	2755035.49	P.C.
		16+58.96	1103766.99	2754952.68	1103871.63	2755213.87	P.I.
		17+48.70	1103589.66	2754933.47	1103694.29	2755194.66	P.T.
			1103606.80	2754775.23	1103711.43	2755036.41	C.C.
		17+48.70	1103589.66	2754933.47	1103694.29	2755194.66	P.C.
		18+48.32	1103490.62	2754922.74	1103595.24	2755183.93	P.I.
		19+41.80	1103415.36	2754857.46	1103519.97	2755118.65	P.T.
			1103623.94	2754617.01	1103728.57	2754878.17	C.C.
			REGION 2				
	Point 66	20+70.30	1103406.37	2754849.66	1103510.98	2755110.85	Point 66
	Point 11	21+45.00	1103349.94	2754800.71	1103454.55	2755061.89	Point 11
		896+50.00	1103666.25	2754336.41	1103770.89	2754597.55	BEGIN POINT
		907+75.00	1102905.06	2755176.37	1103009.63	2755437.59	END POINT

			PROJECT (GROUND) COORDINATES		STATE PLANE COORDINATES		
SHEET NO.	POINT ID	STATION	NORTH	EAST	NORTH	EAST	DESCRIPTION
TEMPORARY CONNECT 1							
		10+00.00	1103789.51	2754145.48	1103894.16	2754406.63	P.C.
		11+57.47	1103686.33	2754264.43	1103790.97	2754525.56	P.I.
		13+14.31	1103602.90	2754398.00	1103707.53	2754659.14	P.T.
		14+71.78	1103519.48	2754531.56	1103624.10	2754792.71	P.I.
		16+28.61	1103416.29	2754650.51	1103520.90	2754911.68	P.T.
TEMPORARY CONNECT 2							
		10+00.00	1103850.97	2754172.31	1103955.63	2754433.43	P.C.
		11+53.38	1103750.46	2754288.17	1103855.11	2754549.30	P.I.
		13+06.17	1103633.55	2754387.46	1103738.18	2754648.60	P.T.
		14+59.55	1103516.65	2754486.75	1103621.27	2754747.90	P.I.
		16+12.34	1103416.14	2754602.61	1103520.75	2754863.77	P.T.
TEMPORARY CONNECT 3							
		10+00.00	1103276.11	2754812.12	1103380.71	2755073.30	P.C.
		11+38.08	1103185.63	2754916.42	1103290.22	2755177.61	P.I.
		12+75.72	1103081.75	2755007.39	1103186.33	2755268.59	P.T.
	POINT B1001	16+05.92	1102833.33	2755224.93	1102937.89	2755486.15	POINT B1001
TEMPORARY CONNECT 4							
		10+00.00	1103203.17	2754848.14	1103307.76	2755109.32	P.C.
		11+19.81	1103124.66	2754938.64	1103229.25	2755199.83	P.I.
		12+39.33	1103057.45	2755037.82	1103162.03	2755299.02	P.T.
		14+65.63	1102930.50	2755225.15	1103035.07	2755486.37	P.I.
		16+90.03	1102765.10	2755379.61	1102869.65	2755640.85	P.T.

COORDINATE POINTS SHEET
SHEET 1 OF 1

"THIS MEDIA SHOULD
NOT BE CONSIDERED
A CERTIFIED
DOCUMENT."

DATE PREPARED
7/19/2020

ROUTE I-29 STATE MO
DISTRICT K-C SHEET NO. 10

COUNTY
PLATTE

JOB NO.
J413291

CONTRACT ID.
.

PROJECT NO.
.

BRIDGE NO.
.

DESCRIPTION	DATE						
	.	.	.	.	.	.	.




MISSOURI HIGHWAYS AND TRANSPORTATION COMMISSION




105 WEST CAPITOL
JEFFERSON CITY, MO 65102
1-888-ASK-MODOT (1-888-275-6636)

Burns & McDonnell Engineering Co., Inc.
9400 Ward Parkway
Kansas City, Missouri 64114
816-333-9400
Certificate of Authority
No. : 000165
BMD Project No. 109387




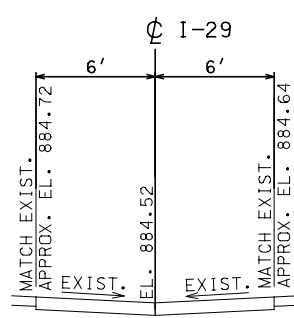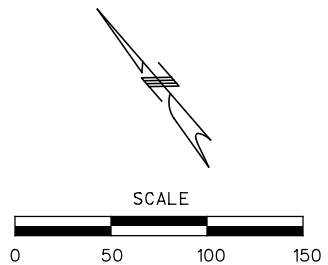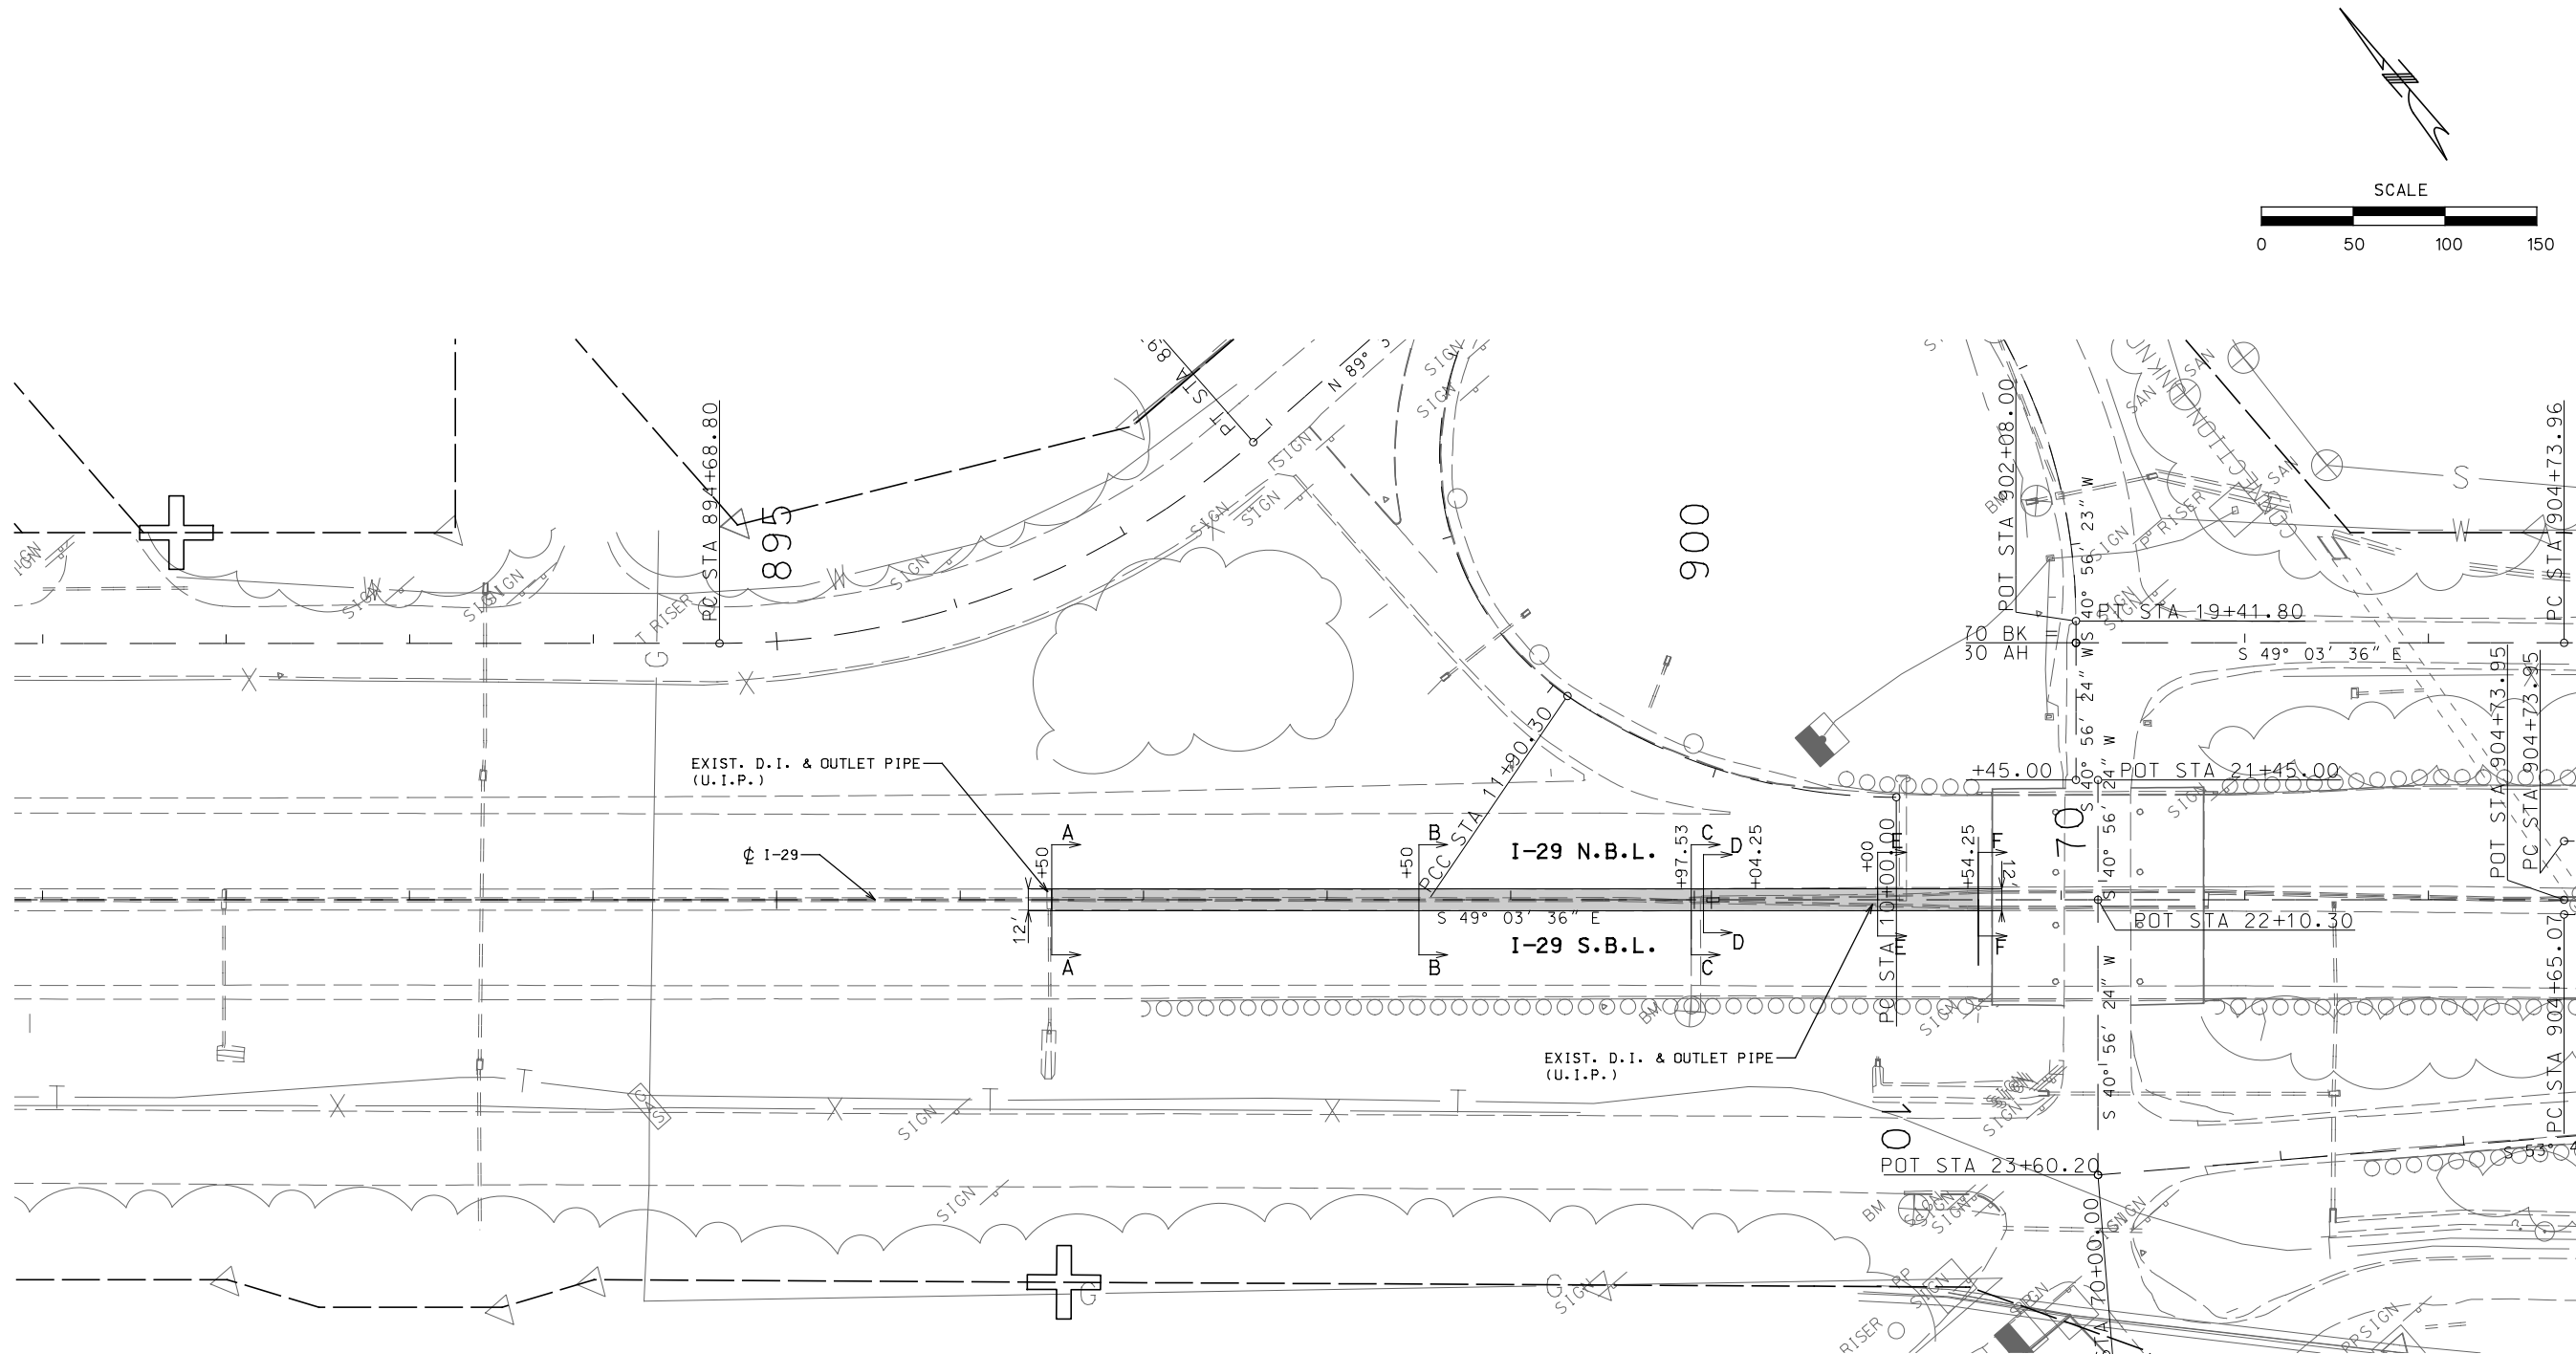


SEC. A-A
896+50 (I-29)

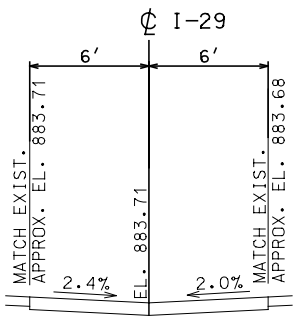


SEC. B-B
898+50 (I-29)

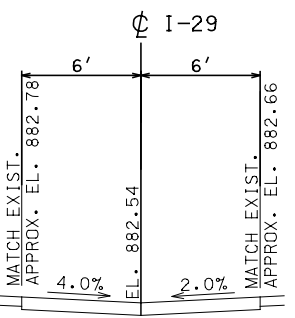


SEC. C-C
899+97.53 (I-29)

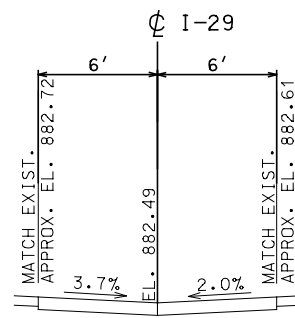

SEC. D-D
900+04.25 (I-29)

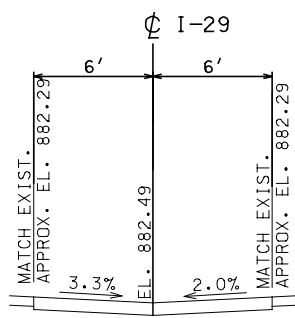

SEC. E-E
901+00.00 (I-29)

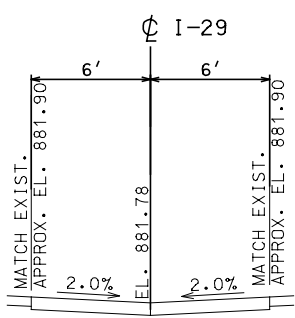

SEC. F-F
901+54.25 (I-29)

SPECIAL SHEETS
NORTH CROSSOVER
SHEET 1 OF 6

"THIS MEDIA SHOULD
NOT BE CONSIDERED
A CERTIFIED
DOCUMENT."

DATE PREPARED
7/19/2020

ROUTE
I-29
STATE
MO
DISTRICT
K-C
SHEET NO.
1-1

COUNTY
PLATTE

JOB NO.
J413291

CONTRACT ID.







PROJECT NO.

BRIDGE NO.


DATE	DESCRIPTION
.	.
.	.
.	.
.	.
.	.

MISSOURI HIGHWAYS AND TRANSPORTATION
COMMISSION
105 WEST CAPITOL
JEFFERSON CITY, MO 65102
1-888-ASK-MODOT (1-888-275-6636)

Burns & McDonnell Engineering Co., Inc.
9400 Ward Parkway
Kansas City, Missouri 64114
816-333-9400
Certificate of Authority
No. : 000165
BMD Project No. 109387

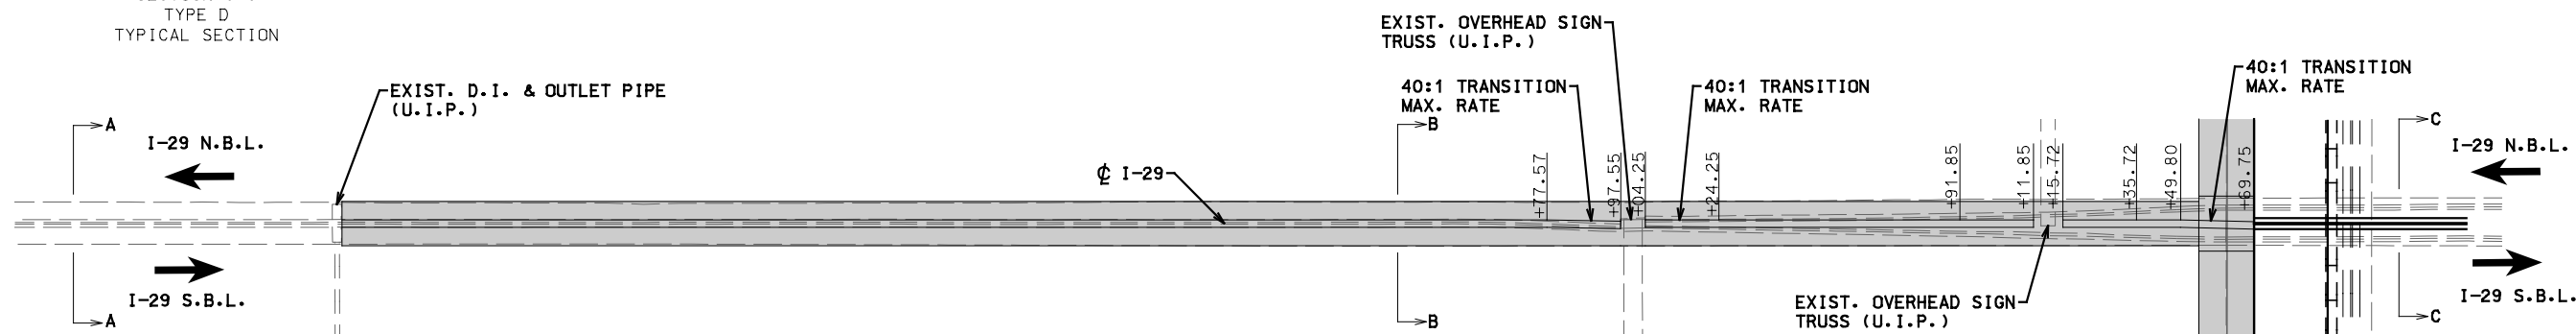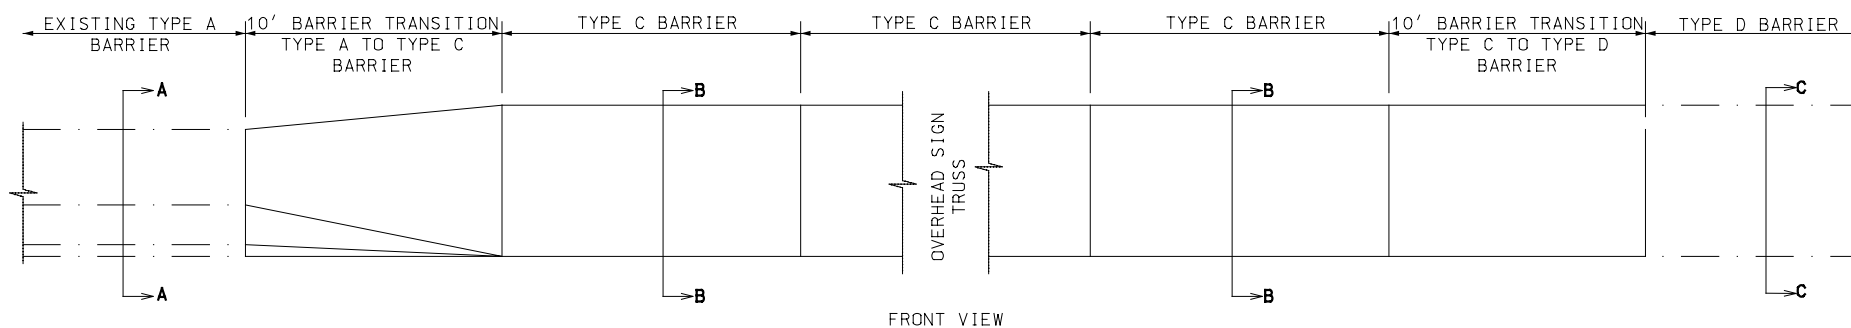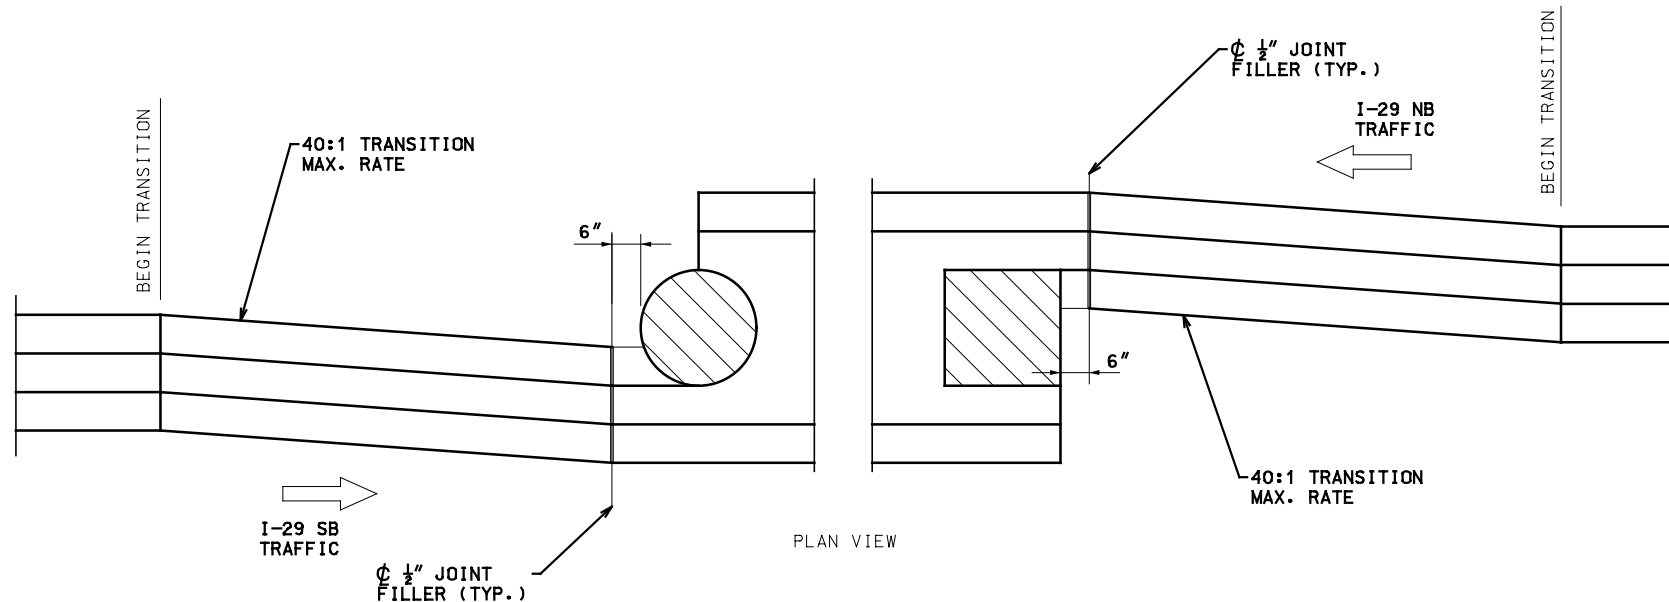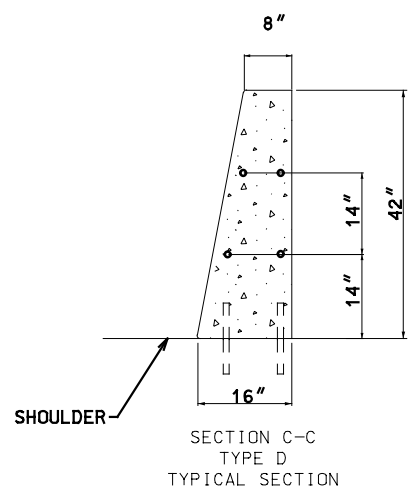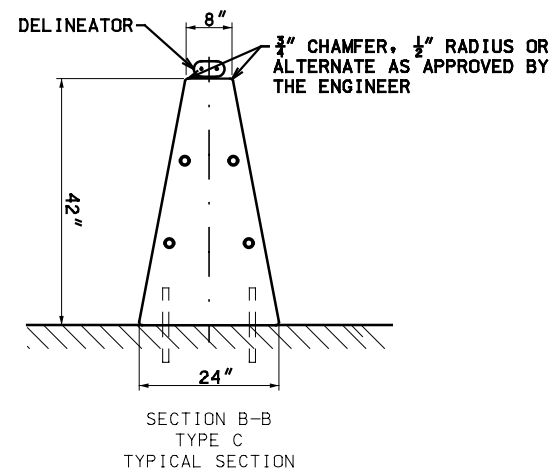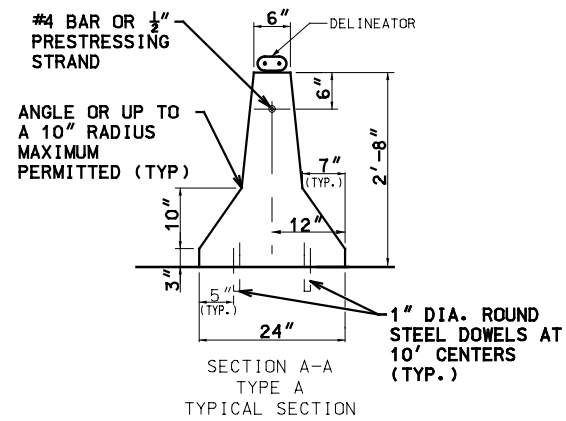

NOTE: WITH APPROVAL OF THE ENGINEER, THE CONTRACTOR SHALL ADJUST THE TAPER OF THE CONCRETE BARRIER TO ALIGN FLUSH WITH OVERHEAD SIGN TRUSS.

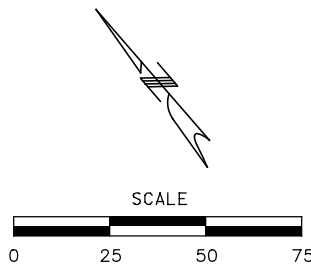

"THIS MEDIA SHOULD NOT BE CONSIDERED A CERTIFIED DOCUMENT."

DATE PREPARED 7/19/2020

ROUTE I-29 MO
DISTRICT K-C SHEET NO. 13

COUNTY PLATTE

JOB NO. J413291

CONTRACT ID.

PROJECT NO.

BRIDGE NO.

DATE	DESCRIPTION
.	.
.	.
.	.
.	.
.	.
.	.

MISSOURI HIGHWAYS AND TRANSPORTATION COMMISSION

105 WEST CAPITOL
JEFFERSON CITY, MO 65102
1-888-ASK-MODOT (1-888-275-6636)

Burns & McDonnell Engineering Co., Inc.
9400 Ward Parkway
Kansas City, Missouri 64114
816-333-9400

Certificate of Authority
No. : 000165

BMD Project No. 109387

SPECIAL SHEETS
BARRIER TRANSITION DETAIL
SHEET 3 OF 6


EXIST. R/W

ROADWAY	LOCATION	STATION	OFFSET	ELEVATION
€ 56TH ST	PC1	20+36.78	23.62' LT	860.57
L = 38.4'	¼ PT.	20+45.46	25.63' LT	860.63
R = 25.0'	½ PT.	20+52.61	31.17' LT	860.65
Δ = 87°59'16"	¾ PT.	20+57.11	39.31' LT	860.62
	PT1	20+58.42	48.73' LT	860.60

ROADWAY	LOCATION	STATION	OFFSET	ELEVATION
€ 56TH ST	PC2	20+91.48	53.56' LT	860.27
L = 32.1'	¼ PT.	20+93.34	45.82' LT	860.24
R = 21.0'	½ PT.	20+97.95	39.33' LT	860.16
Δ = 87°26'49"	¾ PT.	21+04.64	35.01' LT	860.14
	PT2	21+12.46	33.56' LT	860.37

I-29
NORTHBOUND

I-29
SOUTHBOUND

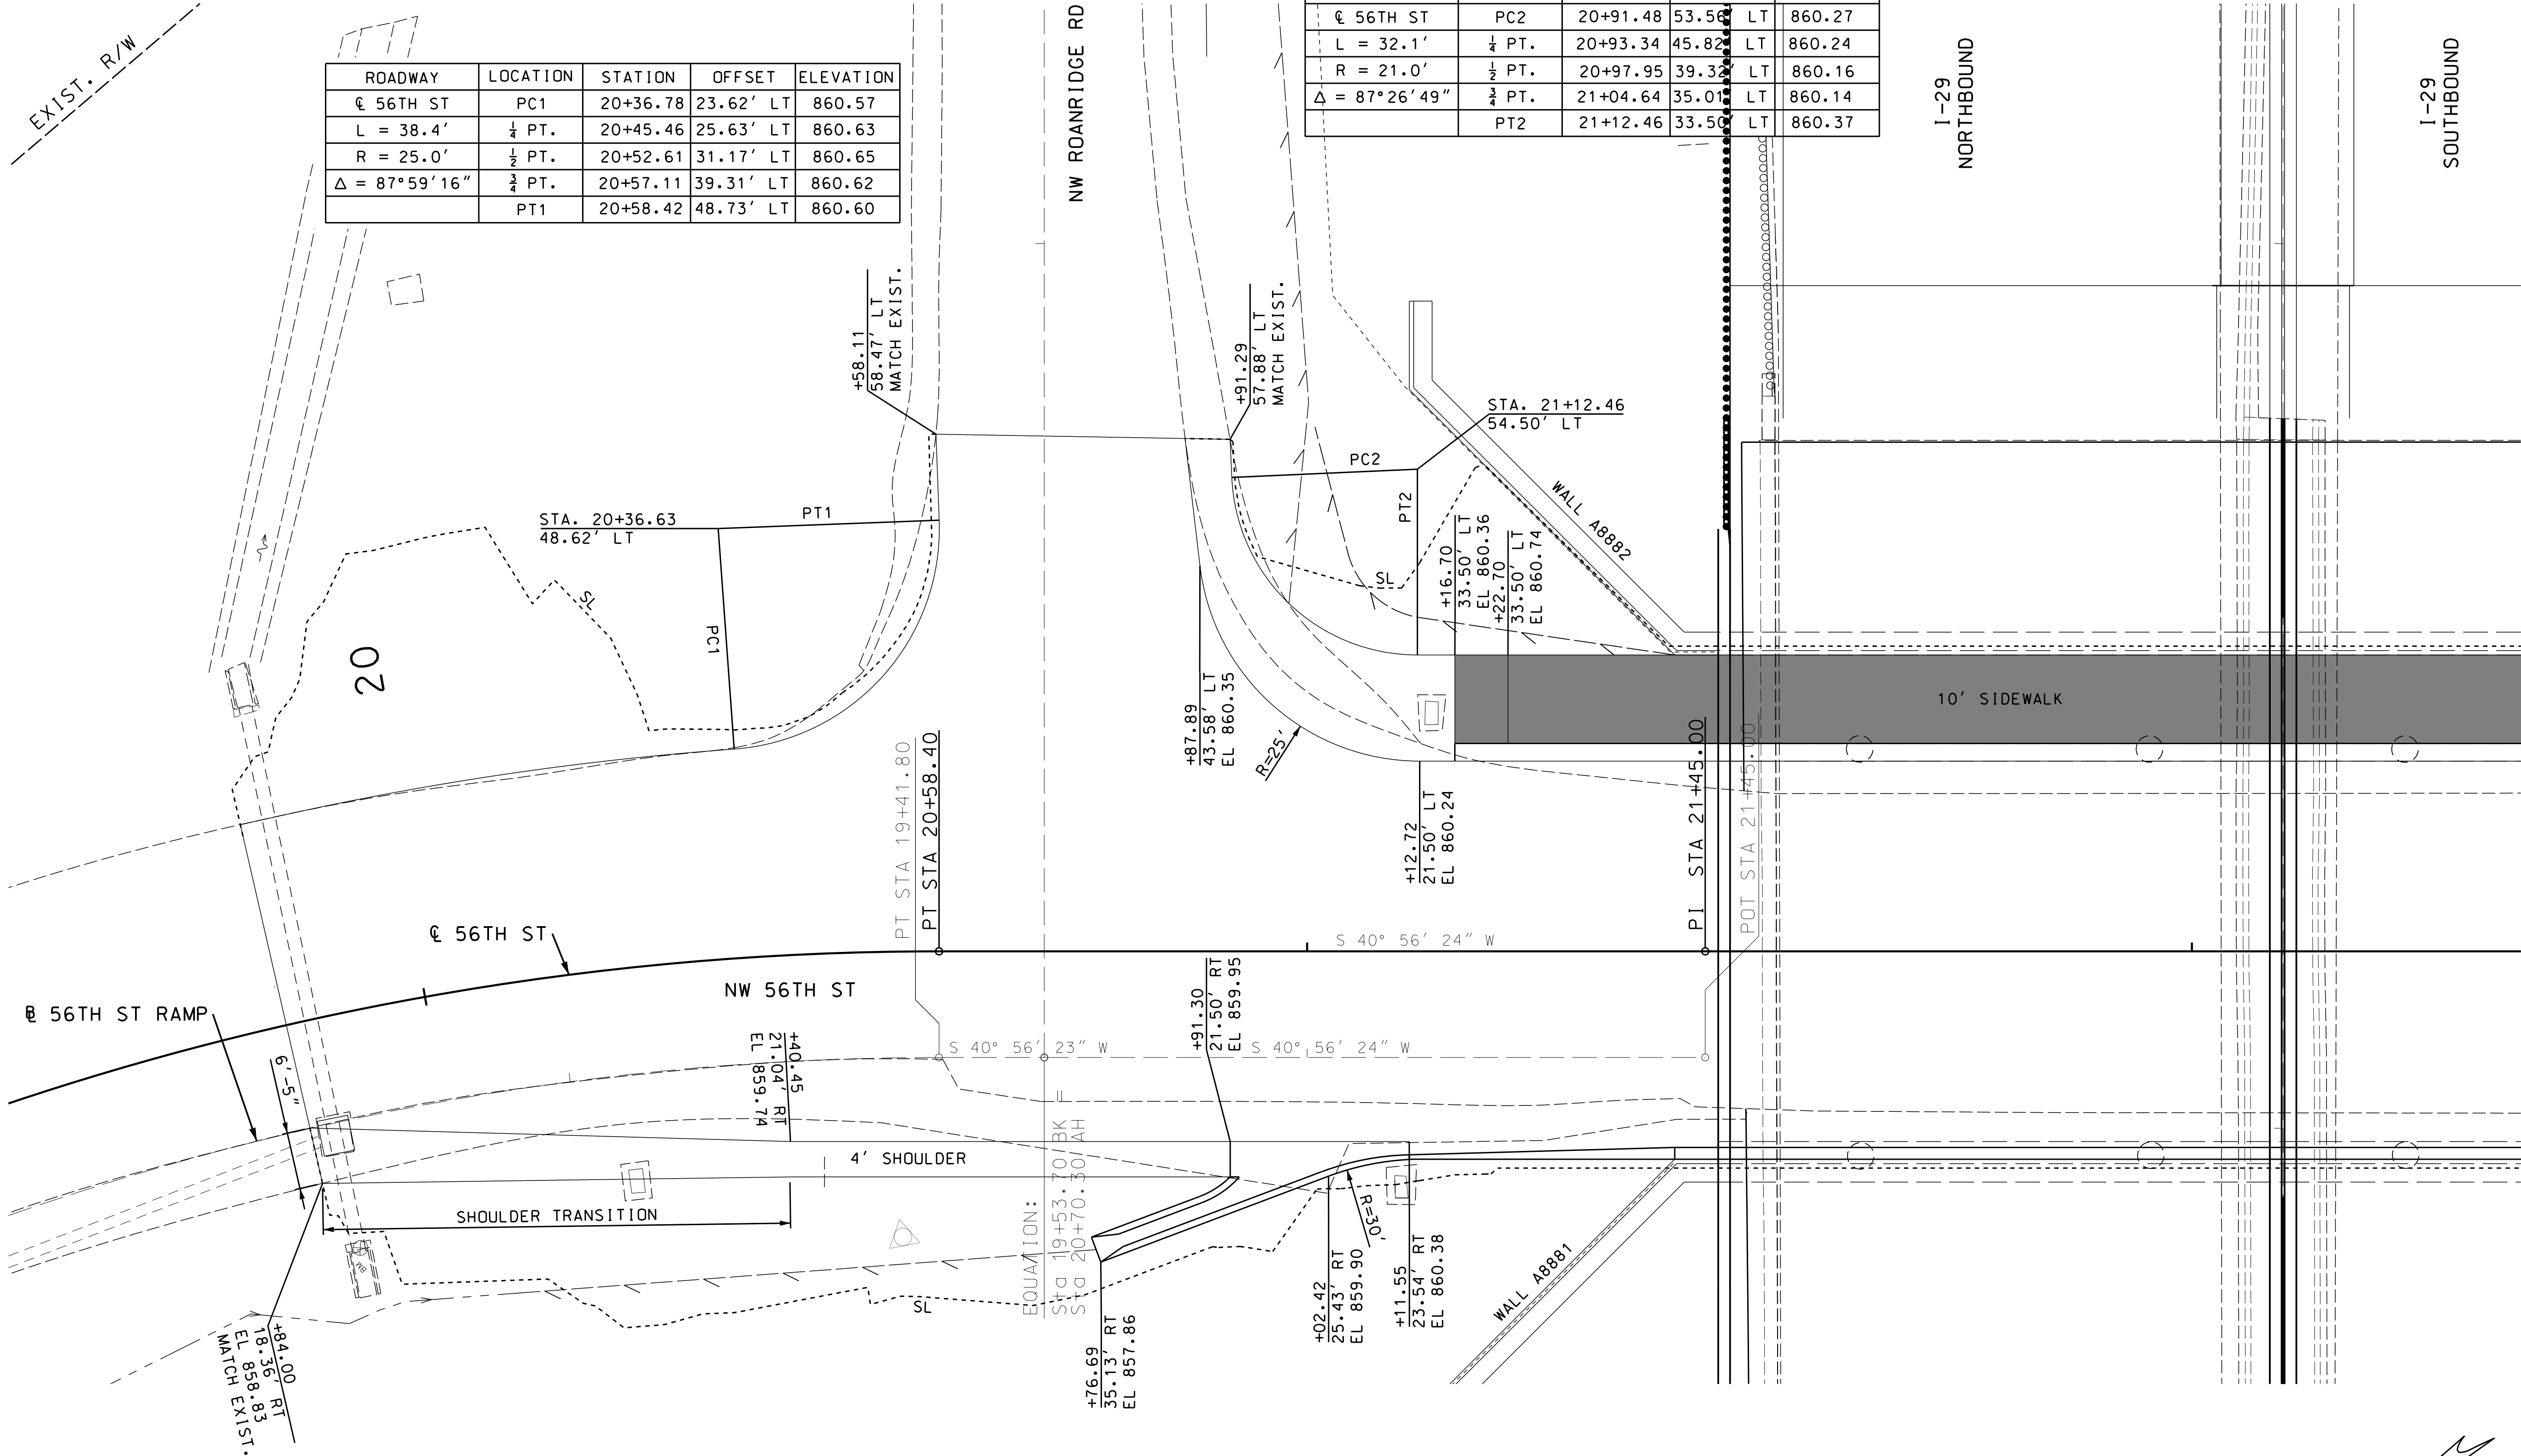

LEGEND

■ SIDEWALK

■ RAMPS

SCALE

0 10 20 30

SPECIAL SHEET
GEOMETRIC DETAILS
56TH STREET
SHEET 4 OF 6

MISSOURI HIGHWAYS AND TRANSPORTATION COMMISSION

1411 East 104th St.
Kansas City, MO 64131
Tel (816) 974-4655
Fax (816) 974-4675
www.trekdesigngroup.com

Missouri Cert. of
Authority 202010300

DATE PREPARED
6/26/2020

ROUTE
I-29

DISTRICT
KC

STATE
MO

SHEET NO.
14

COUNTY
PLATTE

JOB NO.
J413291

CONTRACT ID.

PROJECT NO.

BRIDGE NO.

DESCRIPTION

DATE

MISSOURI HIGHWAYS AND TRANSPORTATION COMMISSION

105 WEST CAPITAL
JEFFERSON CITY, MO 65102
1-888-ASK-MODOT (1-888-275-6636)

- LEGEND
- SIDEWALK
 - RAMPS
 - TRUNCATED DOMES

I-29
SOUTHBOUND

ROADWAY	LOCATION	STATION	OFFSET	ELEVATION
NW 56TH ST	PC3	23+15.70	34.00' LT	860.19
L = 23.1'	1/4 PT.	23+21.33	35.10' LT	860.04
R = 15.0'	1/2 PT.	23+26.14	38.23' LT	859.89
Δ = 88°16'18"	3/4 PT.	23+29.42	42.95' LT	859.75
	PT4	23+30.69	48.55' LT	859.54

ROADWAY	LOCATION	STATION	OFFSET	ELEVATION
PRAIRIE VIEW RD	PC4	50+56.88	10.94' LT	859.35
L = 44.8'	1/4 PT.	50+46.08	13.77' LT	859.60
R = 50.0'	1/2 PT.	50+36.16	18.93' LT	859.70
Δ = 51°18'49"	3/4 PT.	50+27.65	26.15' LT	859.80
	PT4	50+20.94	35.09' LT	859.89

ROADWAY	LOCATION	STATION	OFFSET	ELEVATION
PRAIRIE VIEW RD	PC5	49+76.33	44.90' LT	861.58
L = 36.1'	PT.	49+74.61	36.09' LT	862.16
R = 23.0'	1/2 PT.	49+69.65	28.61' LT	862.74
Δ = 90°00'00"	3/4 PT.	49+62.21	23.59' LT	863.33
	PT5	49+53.41	21.81' LT	863.89

ROADWAY	LOCATION	STATION	OFFSET	ELEVATION
PRAIRIE VIEW RD	PC6	49+30.35	22.18' LT	865.02
L = 20.9'	1/4 PT.	49+35.50	22.95' LT	864.73
R = 18.0'	1/2 PT.	49+40.21	25.16' LT	864.37
Δ = 66°31'41"	3/4 PT.	49+44.10	28.63' LT	864.01
	PT6	49+46.83	33.06' LT	863.65

SPECIAL SHEET
GEOMETRIC DETAILS
56TH STREET
SHEET 5 OF 6

DATE PREPARED
6/26/2020

ROUTE
I-29

DISTRICT
KC

COUNTY
PLATTE

JOB NO.
J413291

CONTRACT ID.

PROJECT NO.

BRIDGE NO.

DESCRIPTION	DATE

MISSOURI HIGHWAYS AND TRANSPORTATION COMMISSION

1411 East 104th St.
Kansas City, MO 64131
Tel (816) 974-4655
Fax (816) 974-4675
www.trekkdesigngroup.com

Missouri Dept. of
Transportation
Authority 2020/10/30


105 WEST CAPITAL
JEFFERSON CITY, MO 65102
1-888-ASK-MODOT (1-888-275-6636)

TREKK


DESIGN GROUP, LLC

IF A SEAL IS PRESENT ON THIS SHEET IT HAS BEEN ELECTRONICALLY SEALED AND DATED.

014_SS_02_J413291_I20_56THST.dgn 1:56:32 PM 6/26/2020

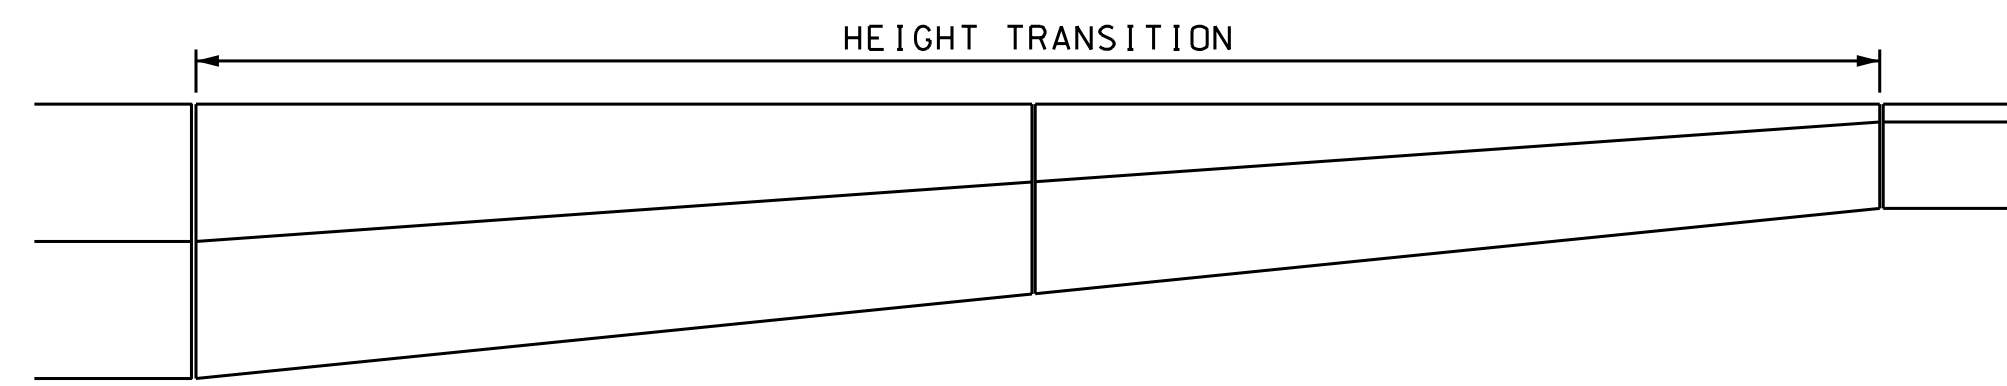

PLAN

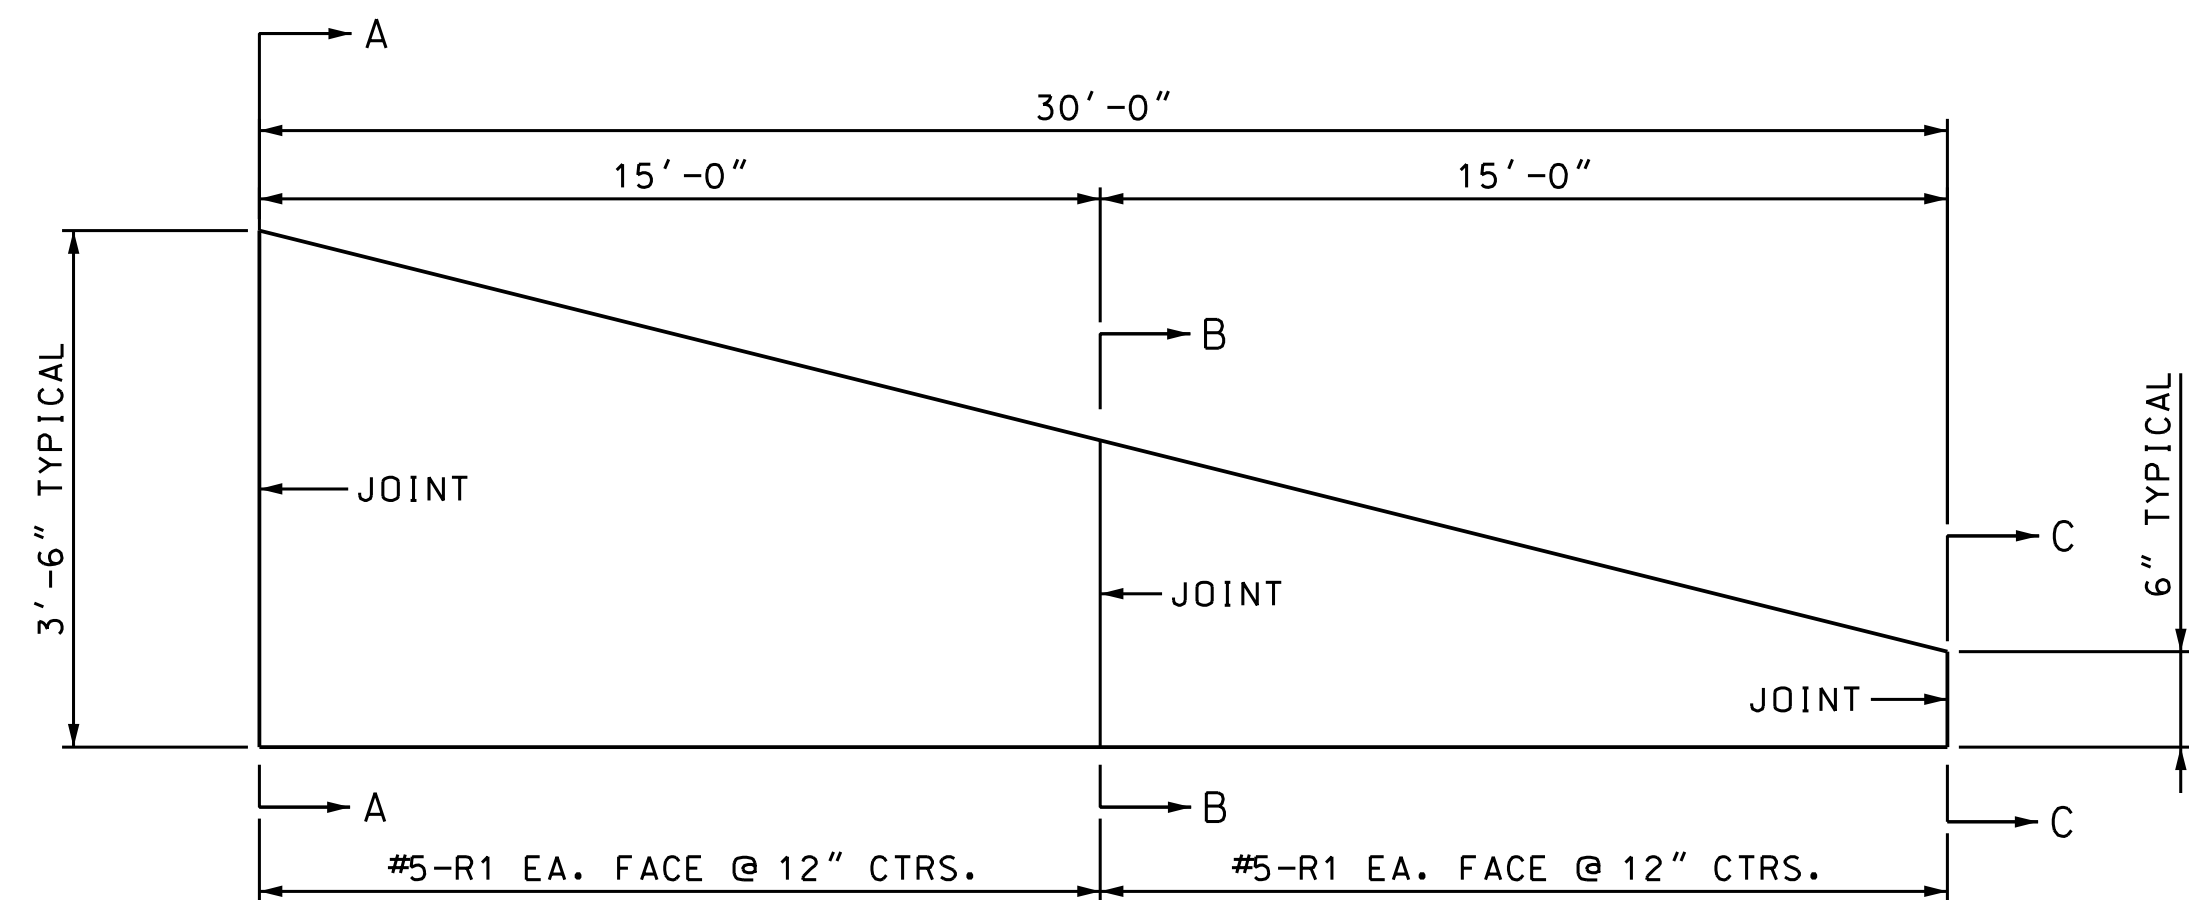

ELEVATION
BARRIER HEIGHT TRANSITION


NOTES:

ALL TOP AND END EDGES SHALL BE CHAMFERED $\frac{3}{4}$ INCH.


EXPANSION JOINTS SHALL BE PROVIDED IN THE BARRIER TO MATCH EXPANSION JOINTS IN PAVEMENT.

FOR DELINEATOR DETAILS, SEE SHEET NUMBER 1 OF MISSOURI STANDARD PLAN 903.03. DELINEATORS SHALL BE PLACED AS DEFINED IN THE JOB SPECIAL PROVISIONS.


MINIMUM CLEARANCE TO REINFORCING STEEL SHALL BE 1 $\frac{1}{2}$ ", UNLESS OTHERWISE SHOWN.

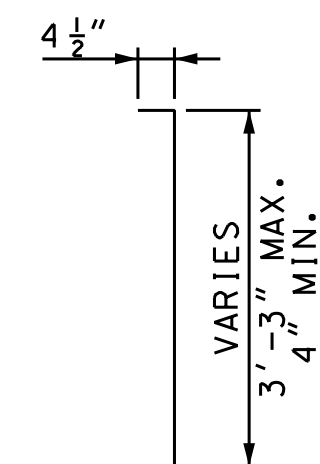


#5 R1

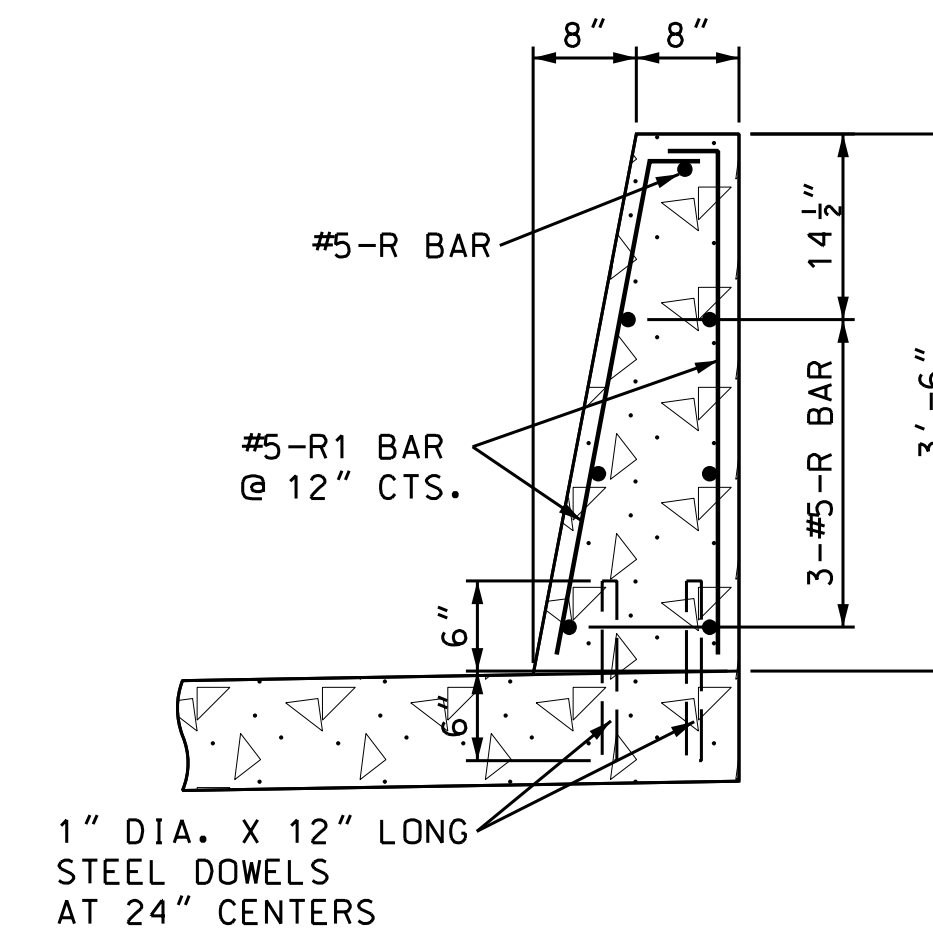

SECTION A-A

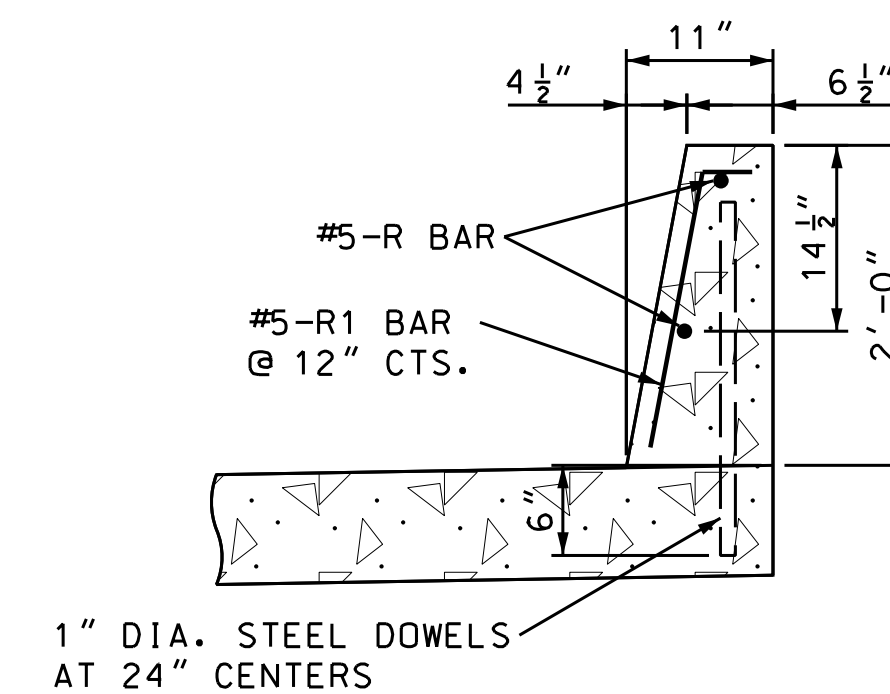


SECTION B-B

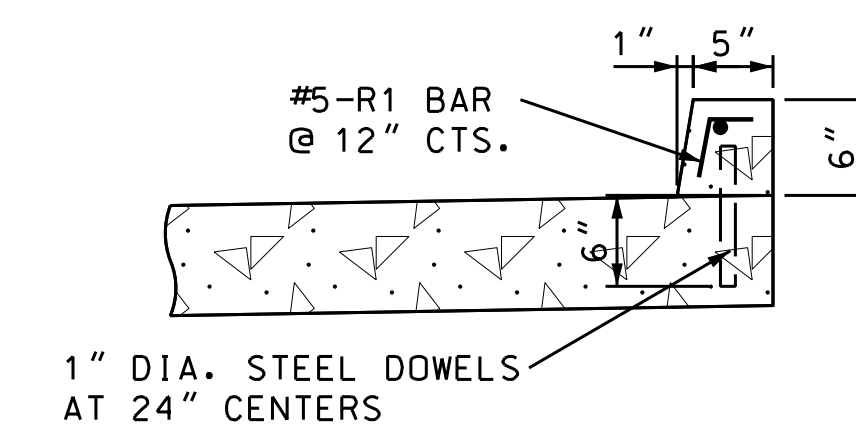

SECTION C-C

SPECIAL SHEET
PERMANENT BARRIER
HEIGHT TRANSITION
56TH STREET
SHEET 6 OF 6

DATE PREPARED 6/26/2020	
ROUTE I-29	STATE MO
DISTRICT KC	SHEET NO. 16
COUNTY PLATTE	
JOB NO. J413291	
CONTRACT ID.	
PROJECT NO.	
BRIDGE NO.	
DESCRIPTION	
DATE	
MISSOURI HIGHWAYS AND TRANSPORTATION COMMISSION	
105 WEST CAPITAL JEFFERSON CITY, MO 65102 1-888-ASK-MODOT (1-888-275-6636)	
1411 East 104th St. Kansas City, MO 64131 Tel (816) 974-4655 Fax (816) 974-4675 www.trekdesigngroup.com	
Missouri Cert. of Authority 202010300	
TREK DESIGN GROUP, LLC	

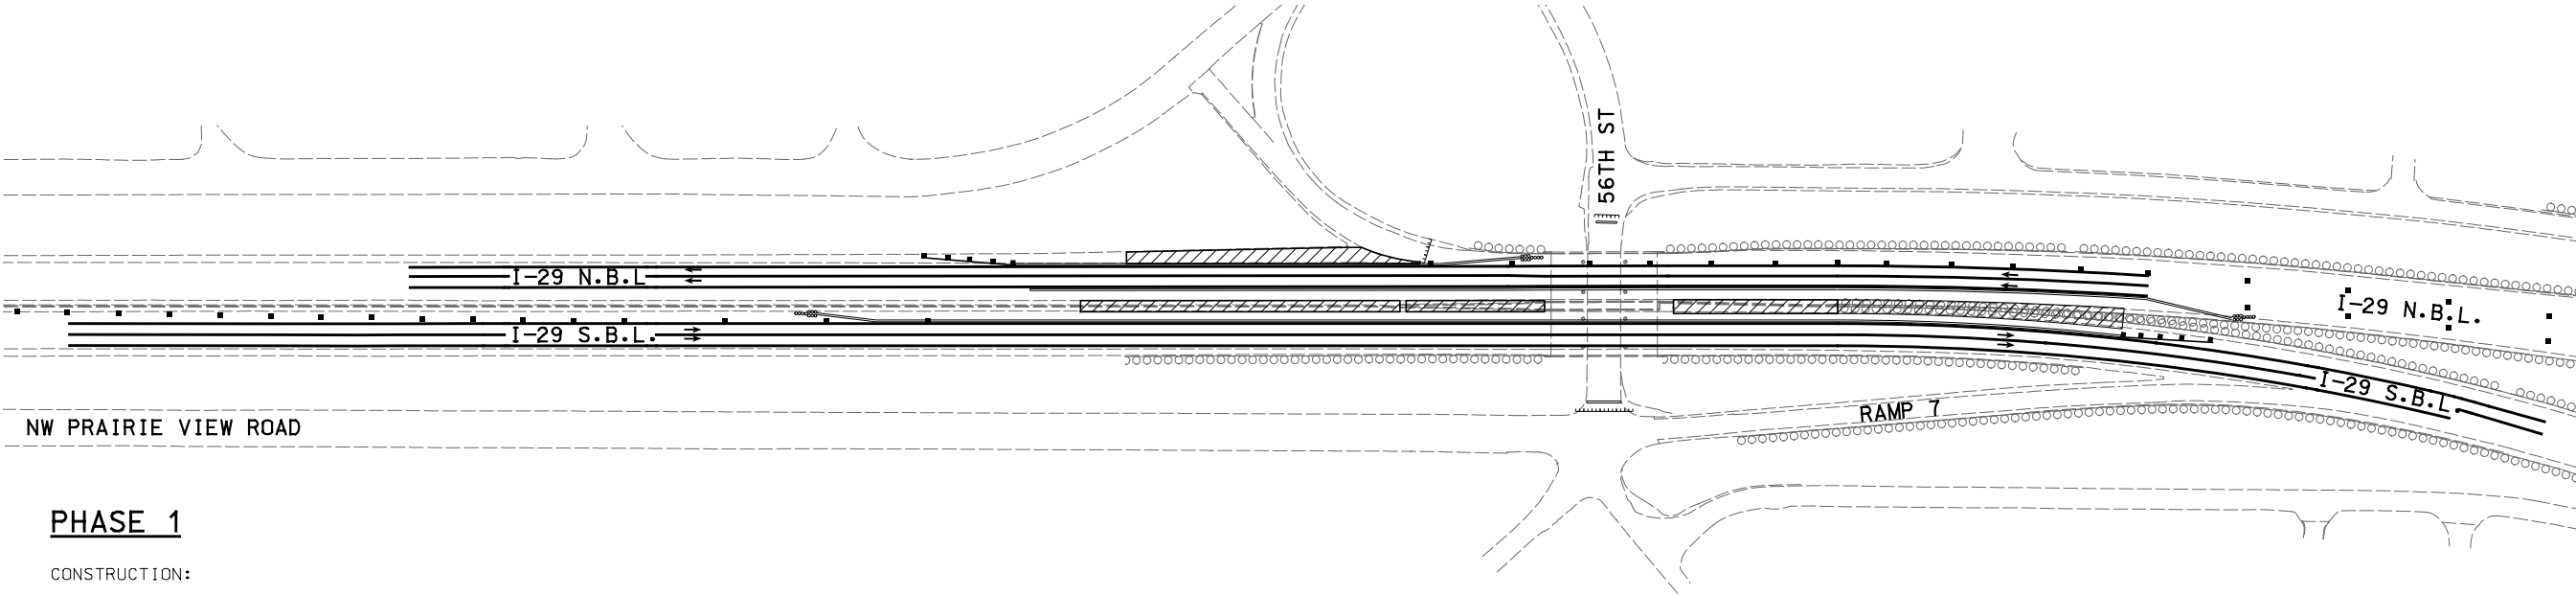


PHASE 1

CONSTRUCTION:

- 1. CONSTRUCT NORTH & SOUTH MEDIAN CROSSOVER
- 2. CONSTRUCT IMPROVEMENTS ALONG NB OUTSIDE SHOULDER

TRAFFIC:

- 1. CLOSE INSIDE LANES AND SHOULDER & MAINTAIN TRAFFIC ON THE TWO OUTSIDE NB & SB LANES
- 2. CLOSE RTE A TO I-29 NB RAMP
- 3. CLOSE I-635 NB TO I-29 NB RAMP
- 4. CLOSE 56TH RAMP & 56TH ST UNDER BRIDGE

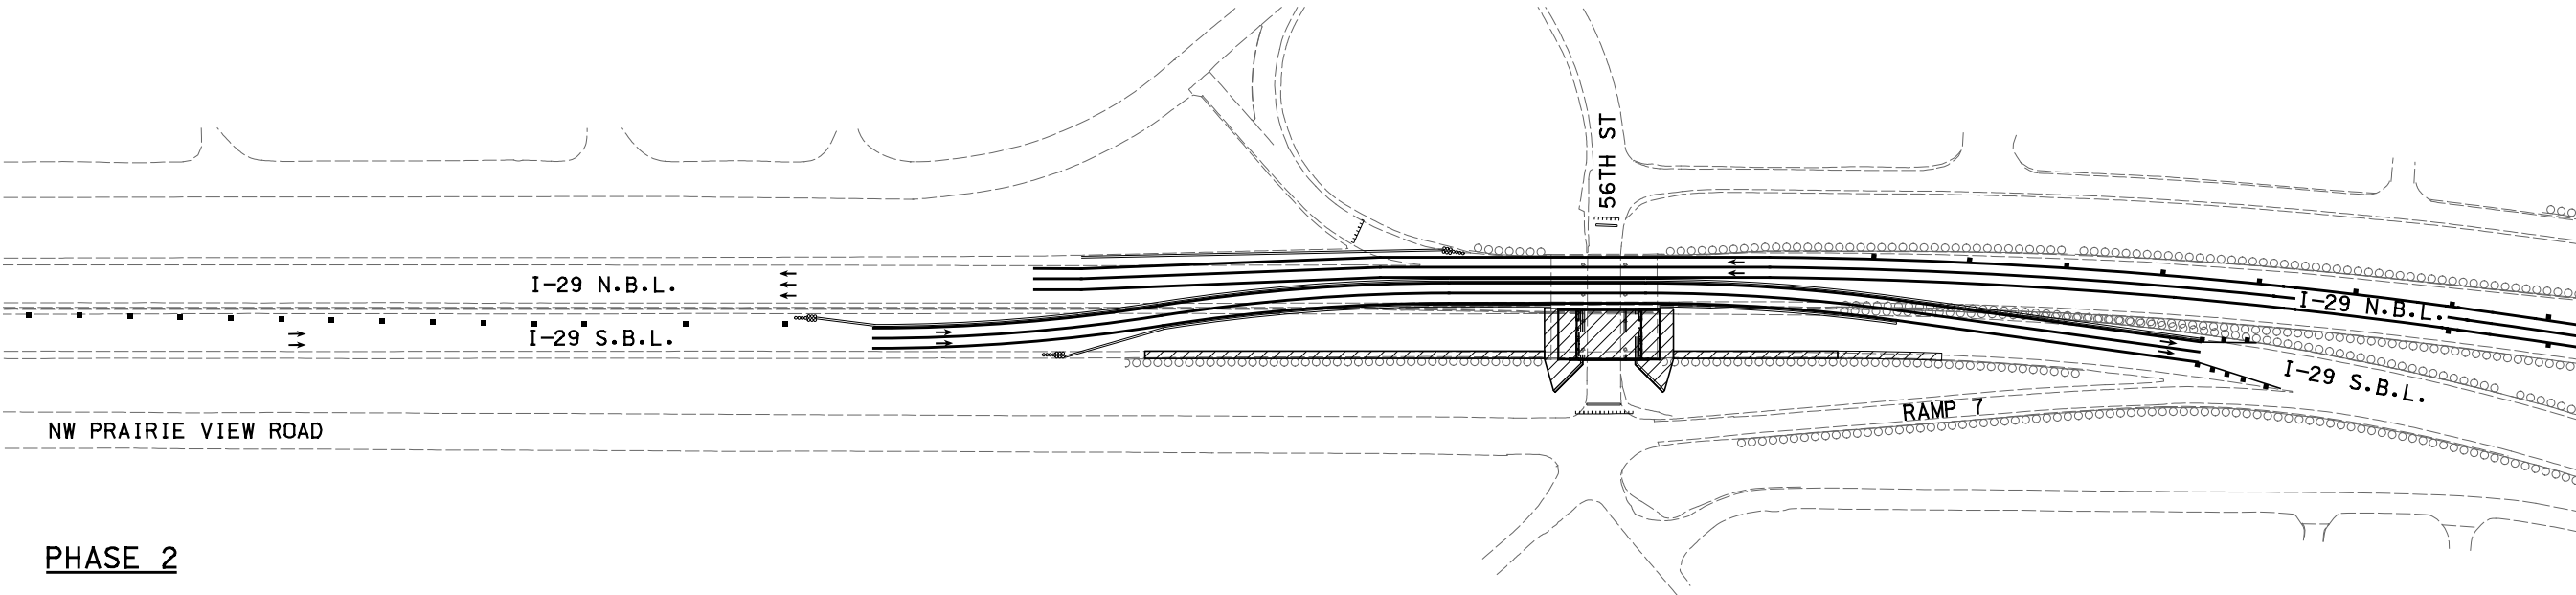

PHASE 2

CONSTRUCTION:

 
- 1. CONSTRUCT SB BRIDGE
- 2. CONSTRUCT SB SHOULDER IMPROVEMENTS

TRAFFIC:

- 1. MAINTAIN TRAFFIC ON NB LANES
- 2. LANES OF NB & SB TRAFFIC ON NB LANES
- 3. MAINTAIL CLOSURE FROM PHASE 1

LEGEND

CONSTRUCTION AREA



SCALE

I-29 OVER 56TH STREET
TRAFFIC CONTROL SHEET
PHASING PLAN
SHEET 1 OF 3

"THIS MEDIA SHOULD NOT BE CONSIDERED A CERTIFIED DOCUMENT."

DATE PREPARED 7/19/2020	
ROUTE I-29	STATE MO
DISTRICT K-C	SHEET NO. 1-7
COUNTY PLATTE	
JOB NO. J413291	
CONTRACT ID.	
PROJECT NO.	
BRIDGE NO.	

DATE	DESCRIPTION
.	.
.	.
.	.
.	.
.	.

MISSOURI HIGHWAYS AND TRANSPORTATION COMMISSION

MoDOT

105 WEST CAPITAL
JEFFERSON CITY, MO 65102
1-888-ASK-MODOT (1-888-275-6636)


Burns & McDonnell Engineering Co., Inc.

9400 Ward Parkway
Kansas City, Missouri 64114
816-333-9400

Certificate of Authority
No. : 000165

BMOB Project No. 109387

BURNS & McDONNELL

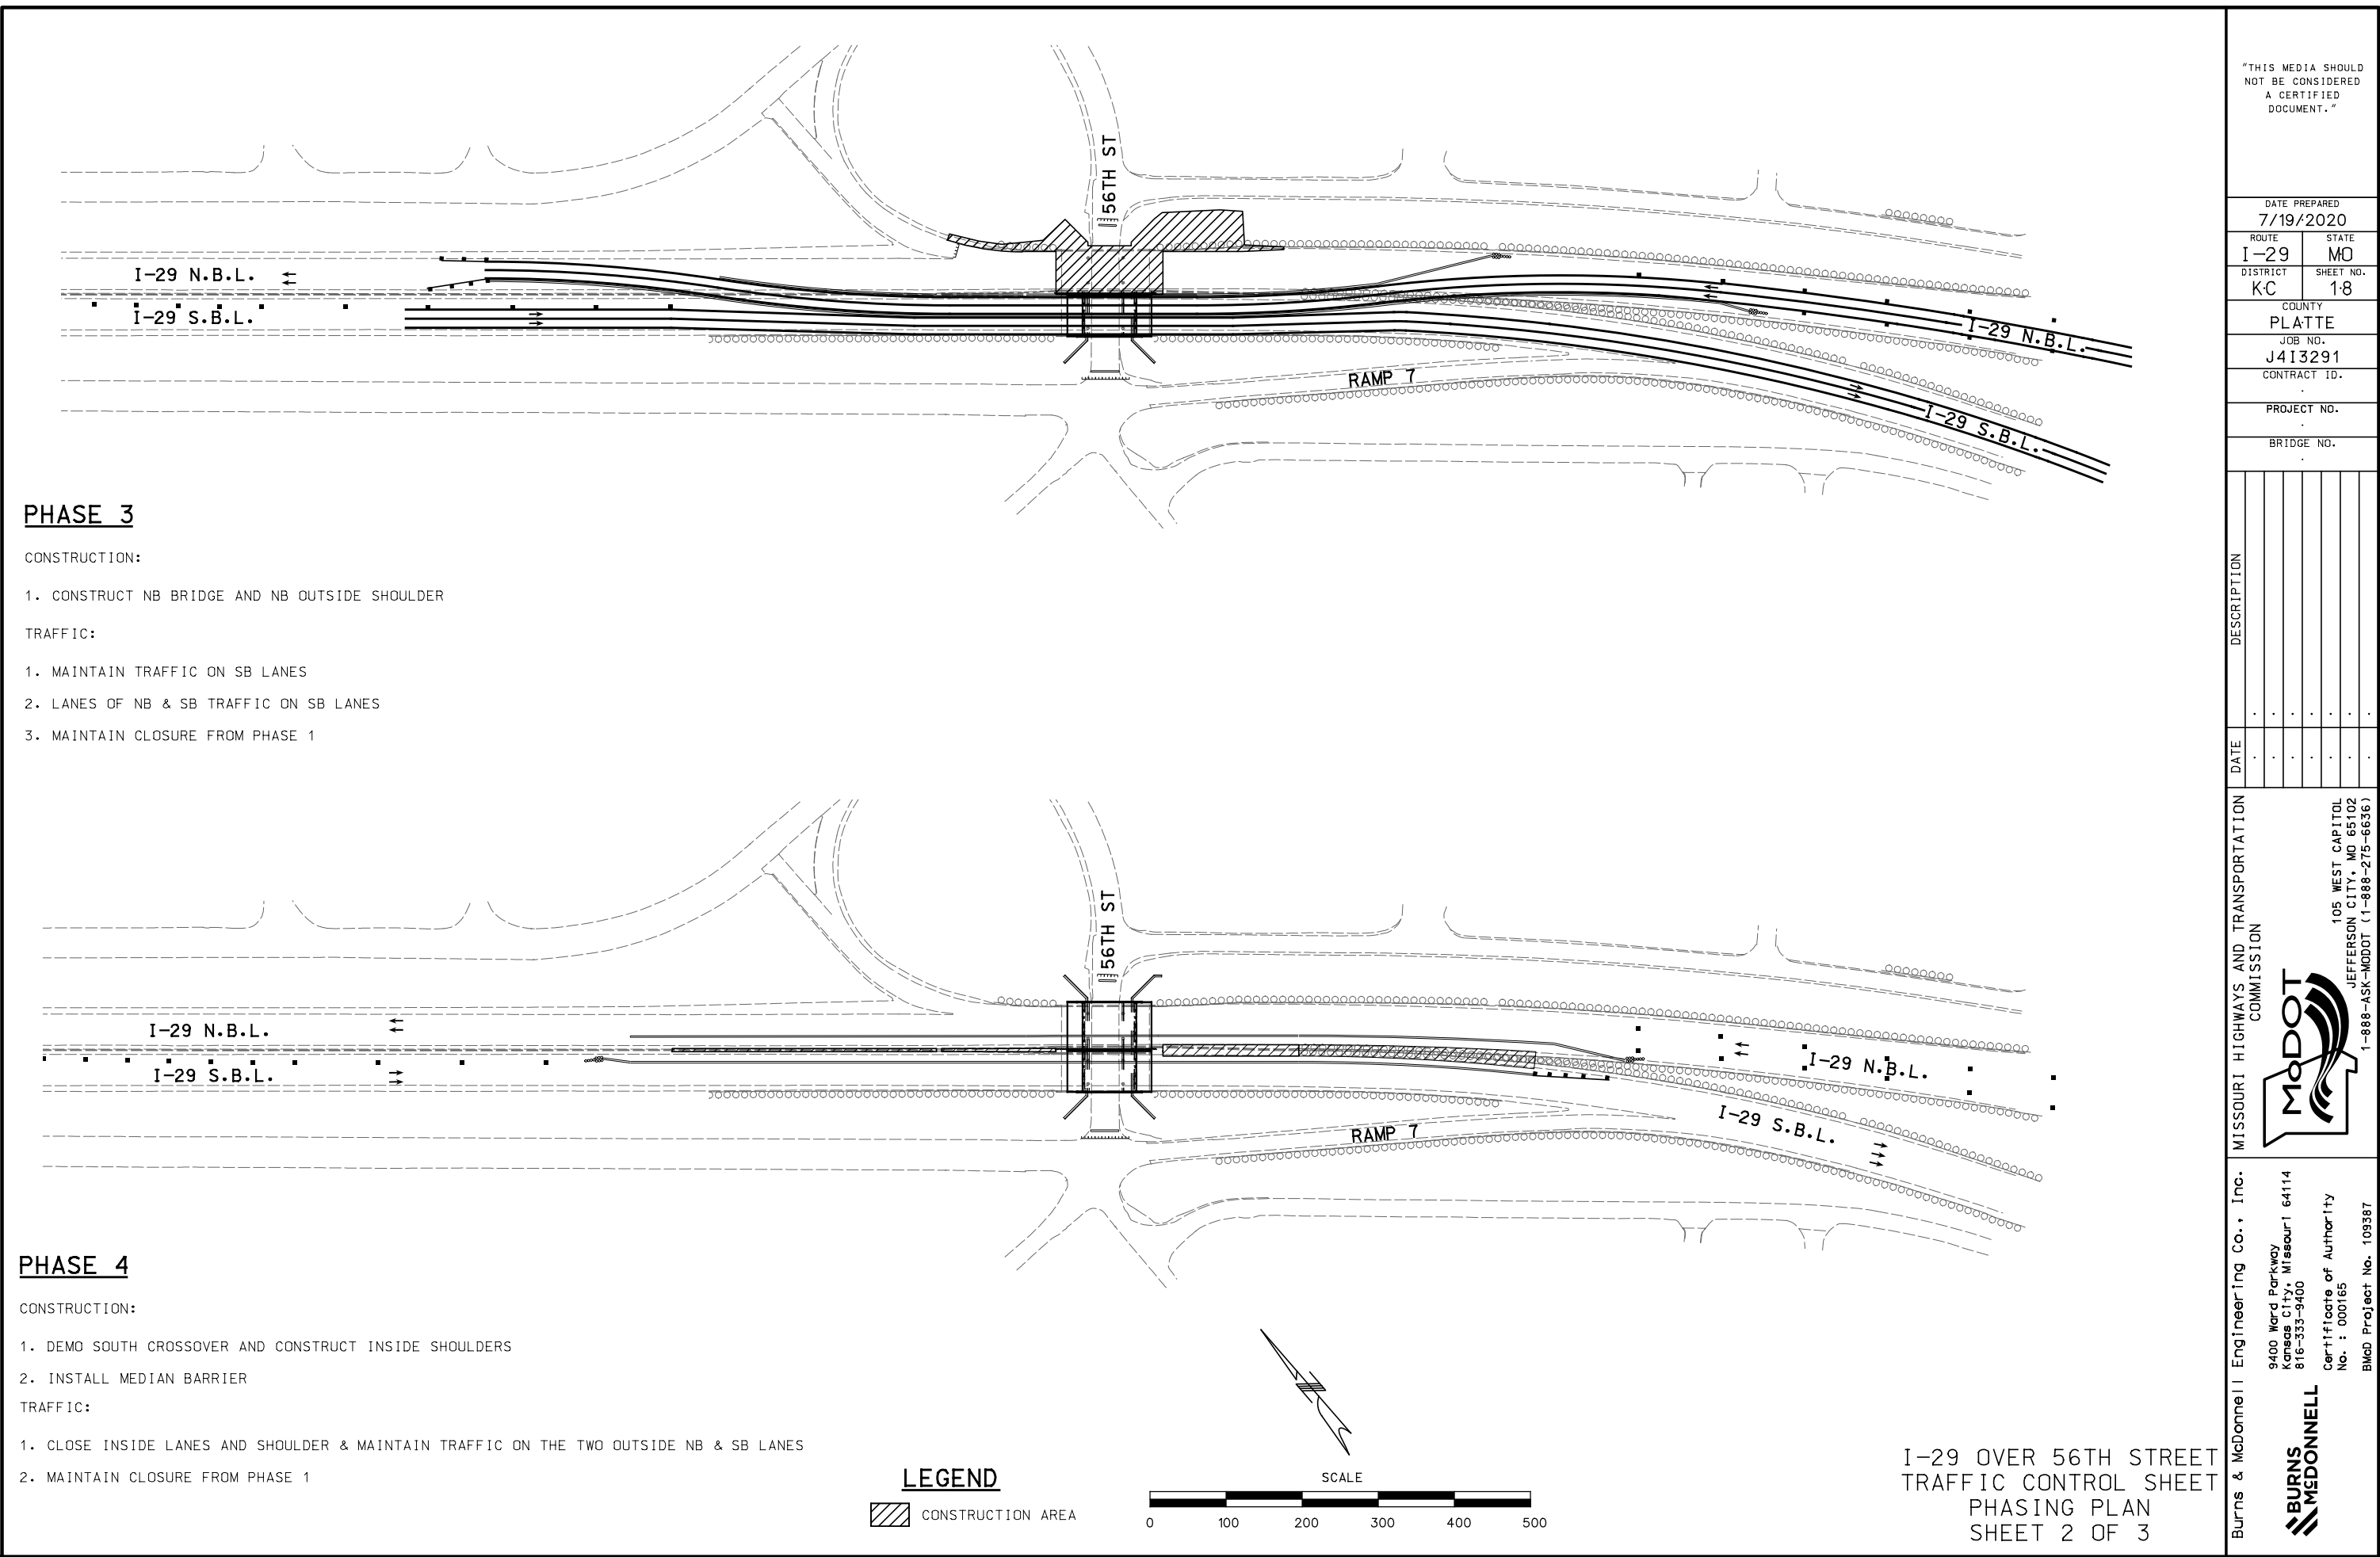

PHASE 3		CONSTRUCTION:		1. CONSTRUCT NB BRIDGE AND NB OUTSIDE SHOULDER	
TRAFFIC:		1. MAINTAIN TRAFFIC ON SB LANES		2. LANES OF NB & SB TRAFFIC ON SB LANES	
		3. MAINTAIN CLOSURE FROM PHASE 1			
PHASE 4		CONSTRUCTION:		1. DEMO SOUTH CROSSOVER AND CONSTRUCT INSIDE SHOULDERS	
TRAFFIC:		1. CLOSE INSIDE LANES AND SHOULDER & MAINTAIN TRAFFIC ON THE TWO OUTSIDE NB & SB LANES		2. MAINTAIN CLOSURE FROM PHASE 1	

"THIS MEDIA SHOULD NOT BE CONSIDERED A CERTIFIED DOCUMENT."

DATE PREPARED		7/19/2020	
ROUTE	I-29	STATE	MO
DISTRICT	K-C	SHEET NO.	18
COUNTY		PLATTE	
JOB NO.		J413291	
CONTRACT ID.			
PROJECT NO.			
BRIDGE NO.			

DATE	DESCRIPTION
.	.
.	.
.	.
.	.
.	.
.	.

MISSOURI HIGHWAYS AND TRANSPORTATION COMMISSION



105 WEST CAPITAL
JEFFERSON CITY, MO 65102
1-888-ASK-MODOT (1-888-275-6636)

Burns & McDonnell Engineering Co., Inc.


9400 Ward Parkway
Kansas City, Missouri 64114
816-333-9400

Certification of Authority
No. : 000165

BMd Project No. 109387




IF A SEAL IS PRESENT ON THIS SHEET IT HAS BEEN ELECTRONICALLY SEALED AND DATED.

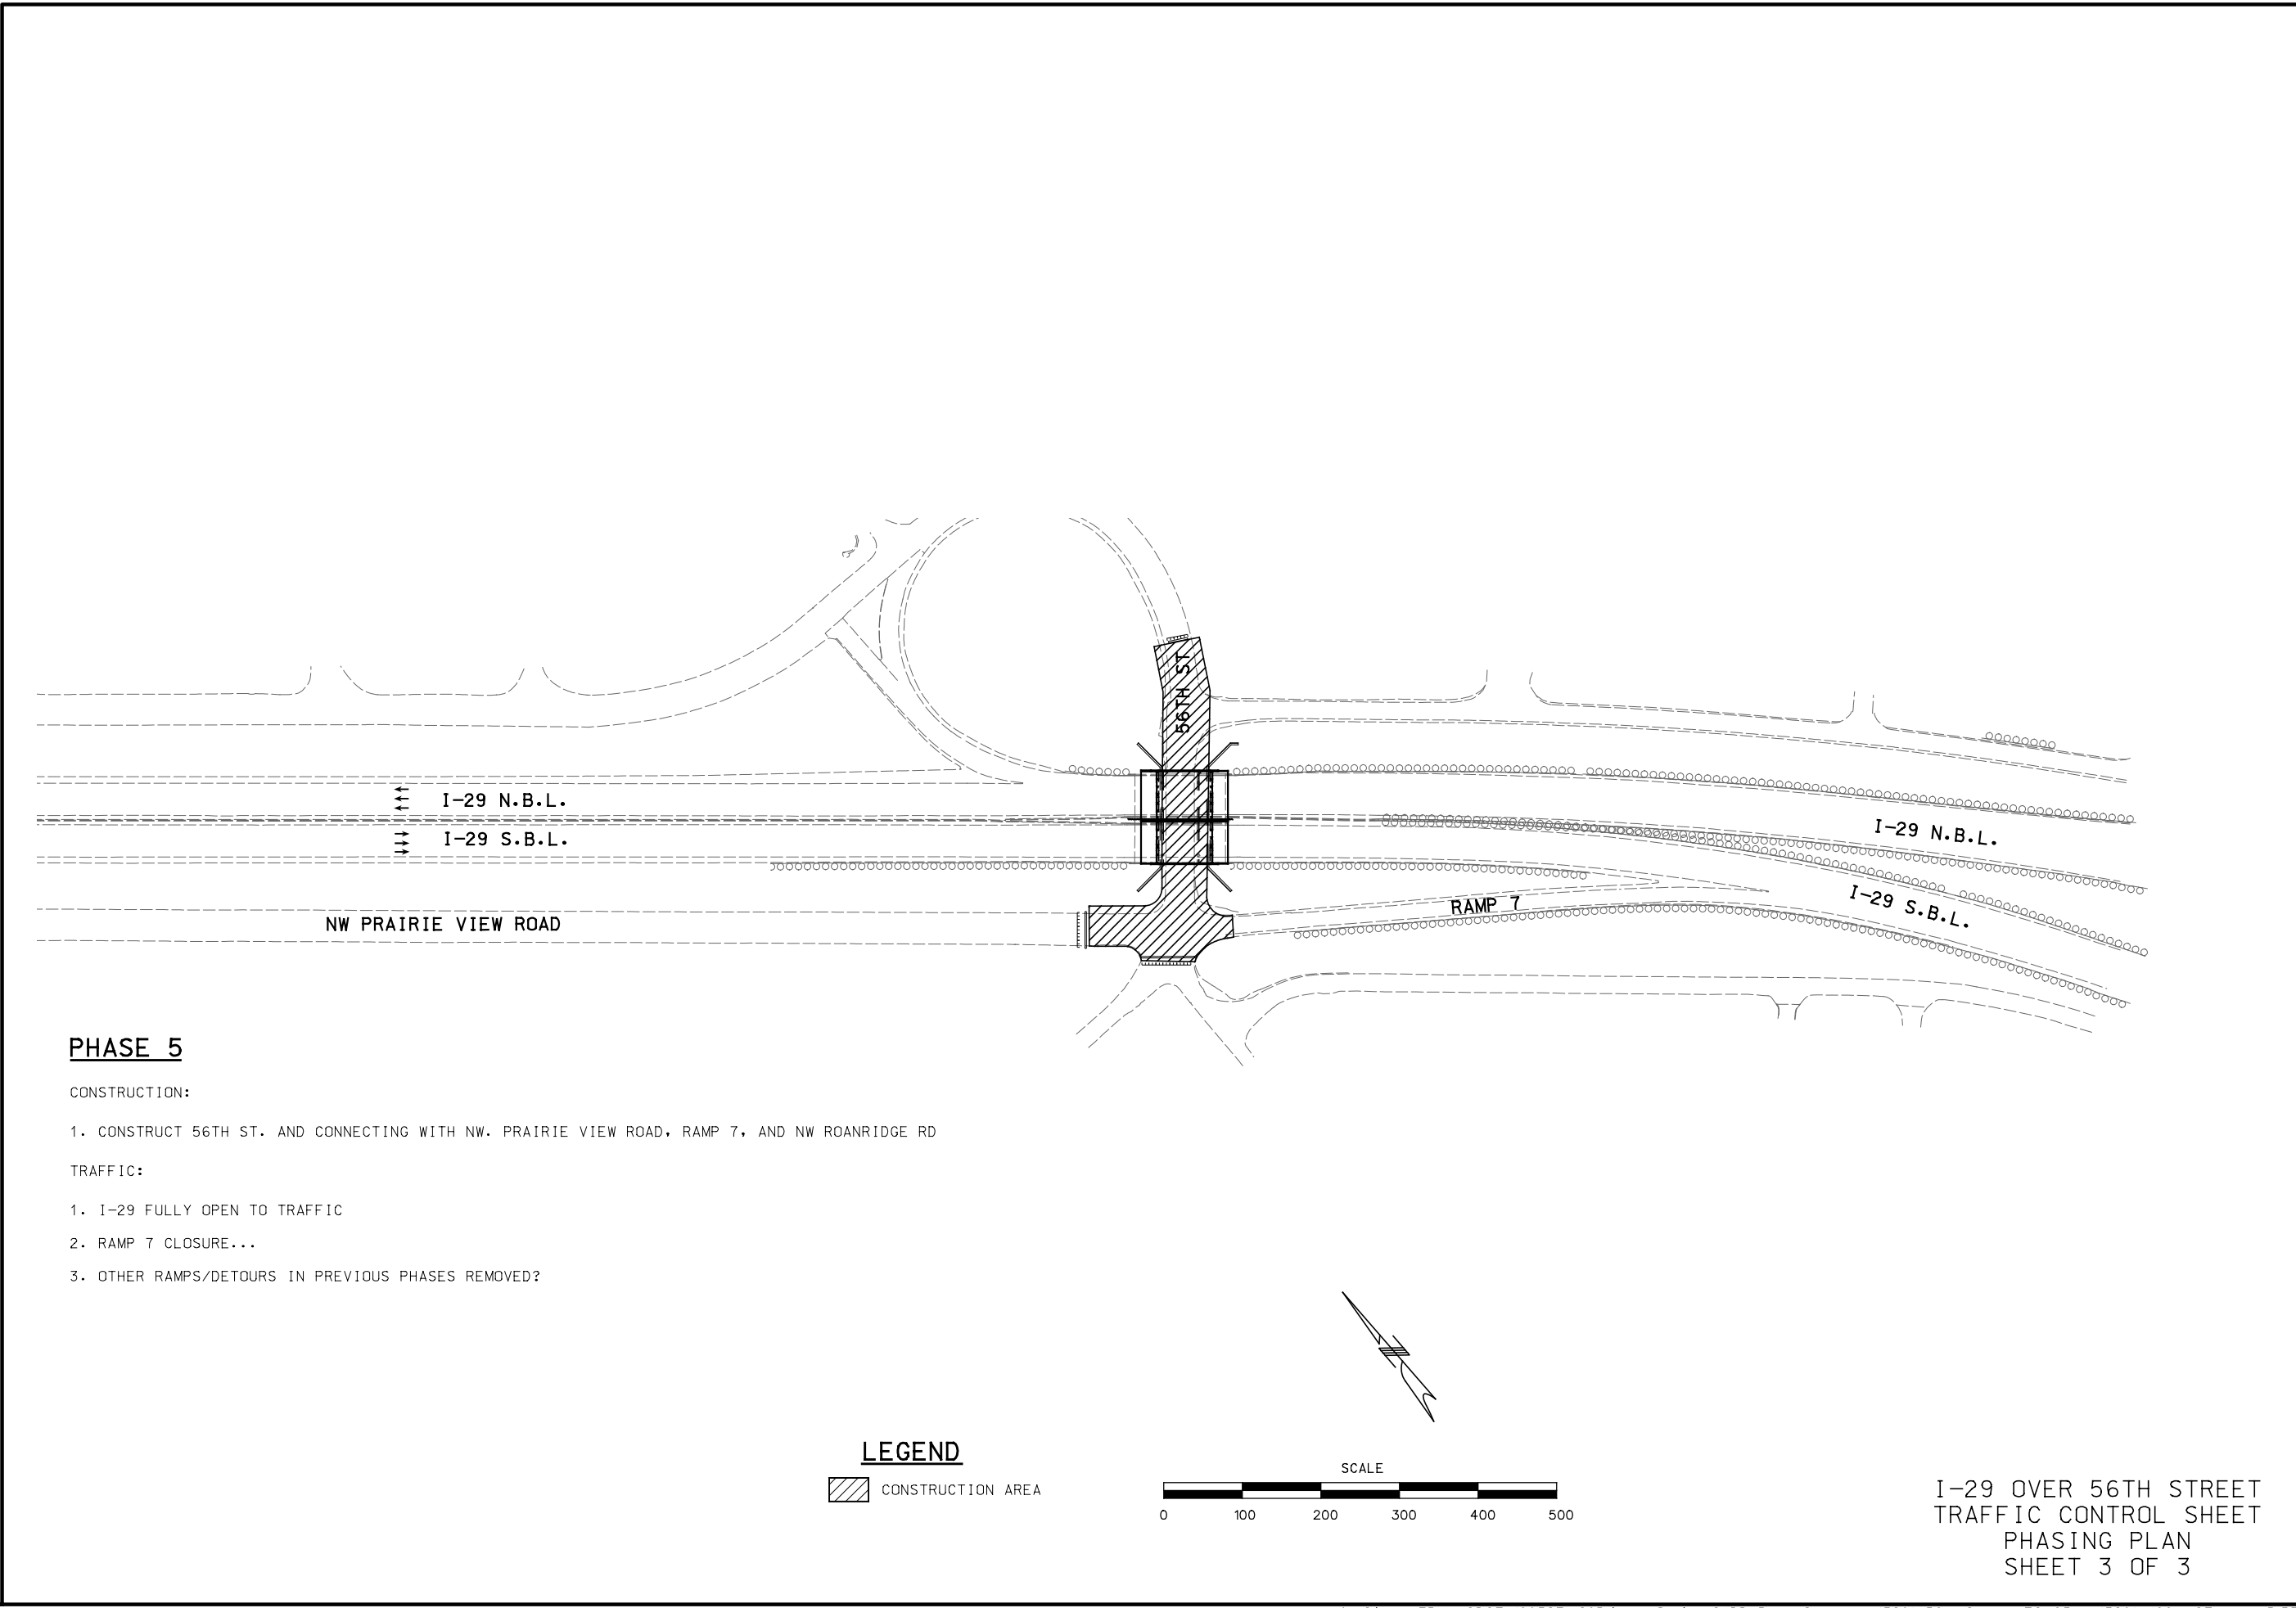

"THIS MEDIA SHOULD NOT BE CONSIDERED A CERTIFIED DOCUMENT."	
DATE PREPARED 7/19/2020	
ROUTE I-29	STATE MO
DISTRICT K-C	SHEET NO. 1-9
COUNTY PLATTE	
JOB NO. J413291	
CONTRACT ID. .	
PROJECT NO. .	
BRIDGE NO. .	
DATE	DESCRIPTION
.	.
.	.
.	.
.	.
.	.
.	.
MISSOURI HIGHWAYS AND TRANSPORTATION COMMISSION	
	
105 WEST CAPITAL JEFFERSON CITY, MO 65102 1-888-ASK-MODOT (1-888-275-6636)	
Burns & McDonnell Engineering Co., Inc. 9400 Ward Parkway Kansas City, Missouri 64114 816-333-9400	Certificate of Authority No. : 000165 BMOB Project No. 109387

NOTES:
1. SUGGESTED MESSAGE FOR CHANGEABLE MESSAGE BOARD:
"RTE A CLOSED AT I-29 - FOLLOW DETOUR"
2. DETOUR SHALL BE IN PLACE DURING PHASES 1 THRU 4.
3. ALL CHANGABLE MESSABLE SIGNS SHALL BE CONTRACTOR
FURNISHED AND CONTRACTOR RETAINED.

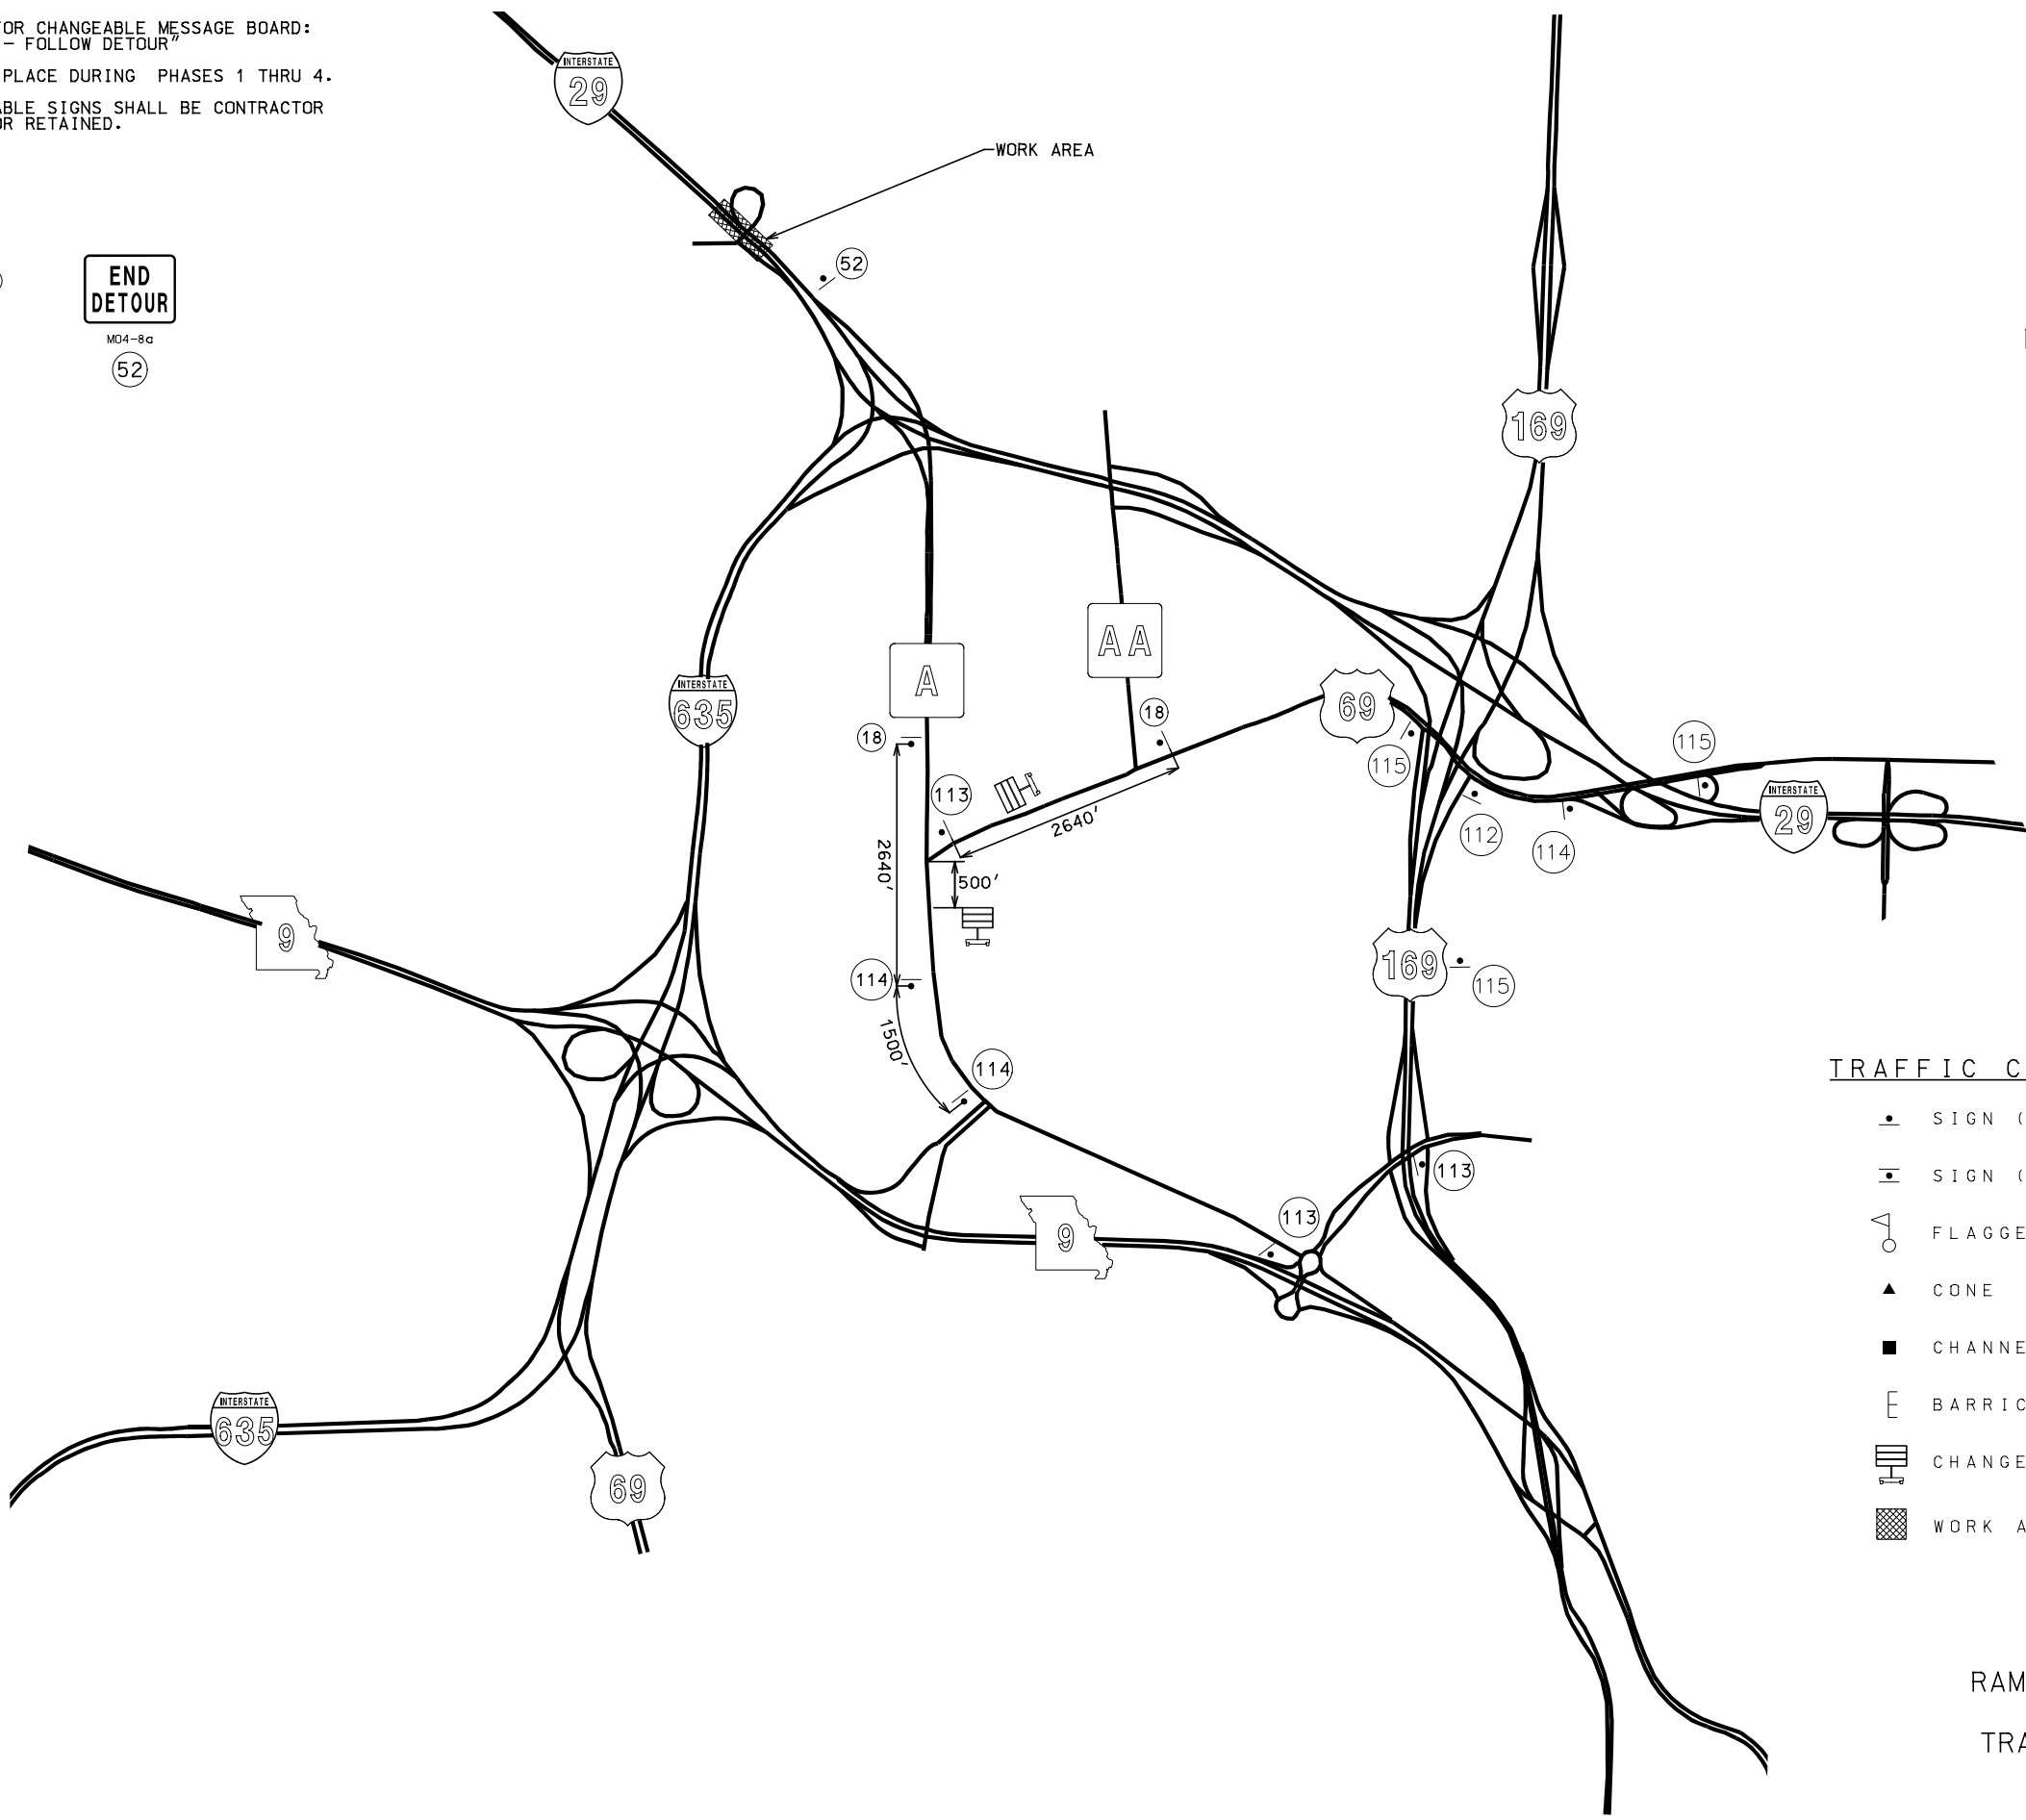

NOT TO SCALE

TRAFFIC CONTROL LEGEND

- SIGN (SINGLE SIDED)
- SIGN (DOUBLE SIDED)
- ◁ FLAGGER
- ▲ CONE
- CHANNELIZER
- ⌌ BARRICADE
- ▮ CHANGEABLE MESSAGE BOARD
- ▨ WORK AREA

RAMP RTE. A TO I-29 NB
OVER RAMP I-29
TRAFFIC CONTROL SHEET
DETOUR
SHEET 1 OF 7

"THIS MEDIA SHOULD
NOT BE CONSIDERED
A CERTIFIED
DOCUMENT."

DATE PREPARED 7/19/2020	
ROUTE I-29	STATE MO
DISTRICT K-C	SHEET NO. 20
COUNTY PLATTE	
JOB NO. J413291	
CONTRACT ID.	
PROJECT NO.	
BRIDGE NO.	

DATE	DESCRIPTION
•	•
•	•
•	•
•	•
•	•
•	•

MISSOURI HIGHWAYS AND TRANSPORTATION
COMMISSION

105 WEST CAPITAL
JEFFERSON CITY, MO 65102
1-888-ASK-MODOT (1-888-278-6636)


Burns & McDonnell Engineering Co., Inc.
9400 Ward Parkway
Kansas City, Missouri 64114
816-333-9400
Certificate of Authority
No. : 000165
BMD Project No. 109387



NOTES:
1. UTILIZE DETOUR PLAN DURING
PHASES 1 THRU 4 OF CONSTRUCTION.



NOT TO SCALE

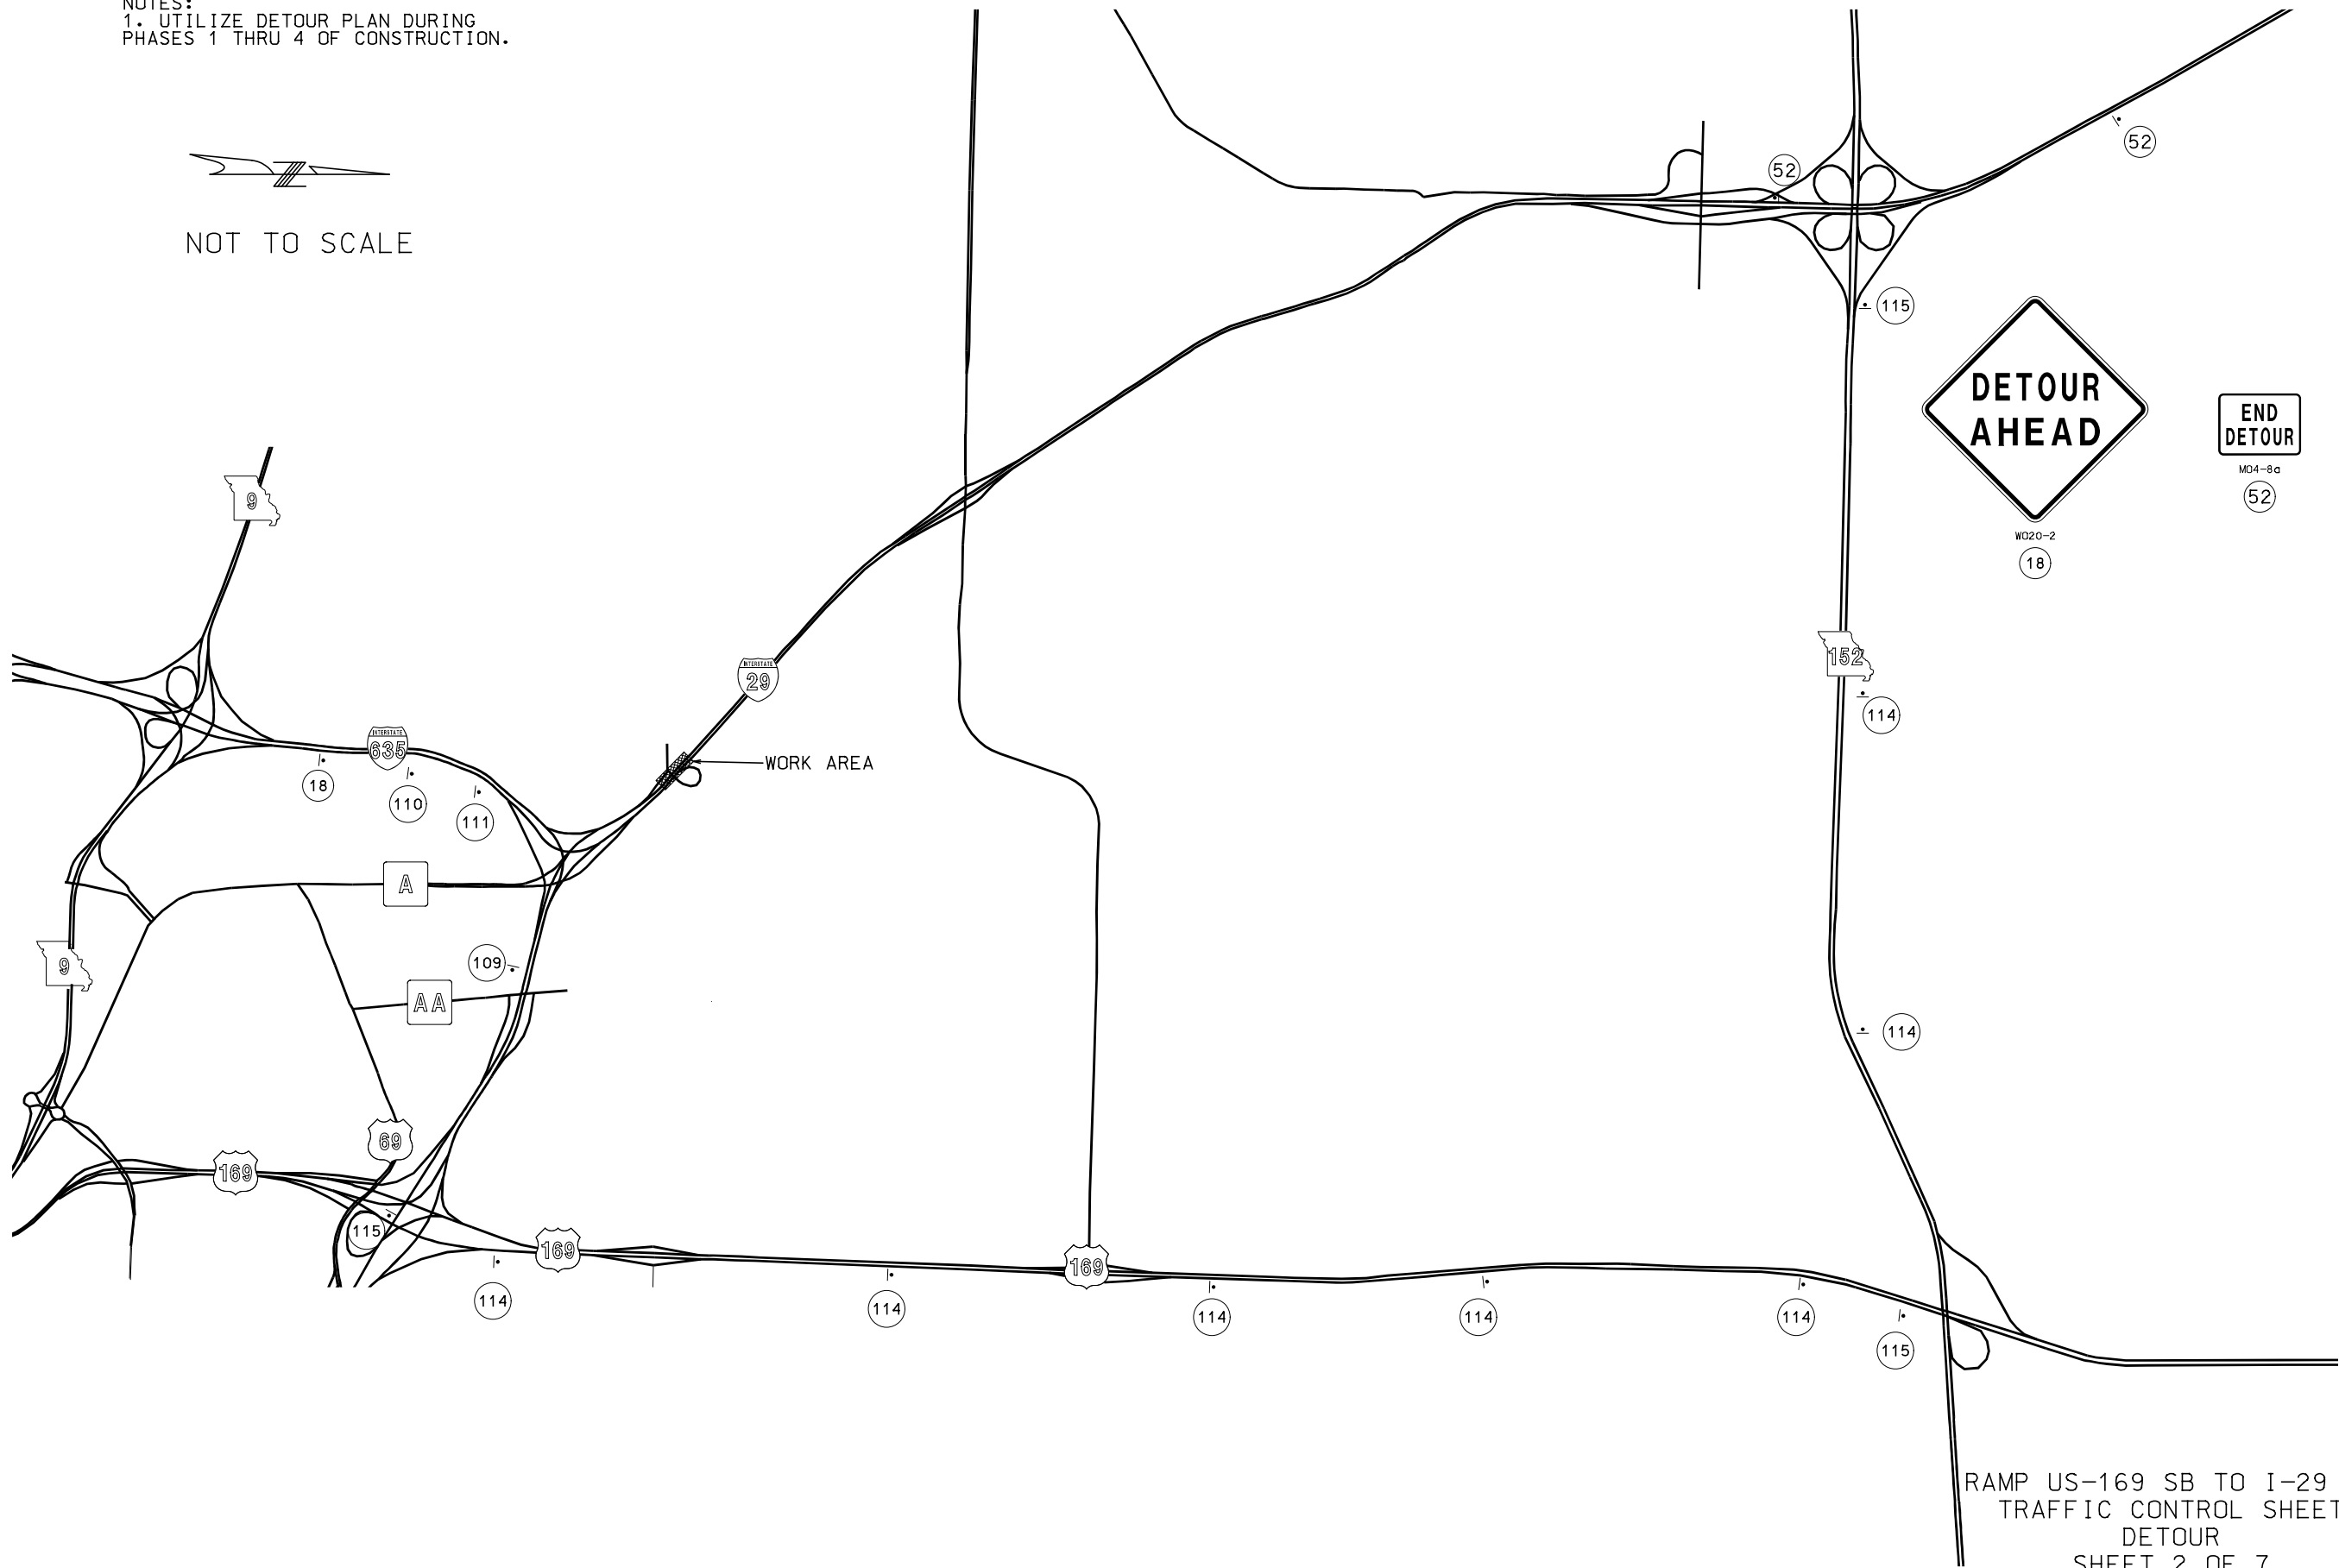

RAMP US-169 SB TO I-29 NB
TRAFFIC CONTROL SHEET
DETOUR
SHEET 2 OF 7

Professional Engineer
Michael W. Carroll
E-27823

DATE PREPARED
7/19/2020

ROUTE STATE
MO

DISTRICT SHEET NO.
KC 21

COUNTY
PLATTE

JOB NO.
J413291

CONTRACT ID.

PROJECT NO.


BRIDGE NO.

DATE	DESCRIPTION

MISSOURI HIGHWAYS AND TRANSPORTATION
COMMISSION

105 WEST CAPITOL
JEFFERSON CITY, MO 65102
1-888-ASK-MODOT (1-888-275-6636)

 Burns & McDonnell Engineering Co., Inc.
9400 Ward Parkway
Kansas City, Missouri 64114
816-333-9400
Certificate of Authority
No. : 000165
BMOB Project No. 91750


[illegible]MISSOURI HIGHWAYS AND TRANSPORTATION
COMMISSION

BMCD Project No. 109387

\\bmc\dfs\Clients\TRN\MODOT\109387_129Bridges\Design\CADD\Road_Sheets\J413291_56th St\xxx_TC_06_J413291_I100_DETOUR.dgn 5:33:12 PM 7/19/2020

5:15 PM 7/7/1972

1

[illegible]

Engineering Co., Inc.
9400 Ward Parkway
Kansas City, Missouri 64114
816-333-9400

Certificate of Authority
No. : 000165


BMed Project No. 109387



MISSOURI HIGHWAYS AND TRANSPORTATION
COMMISSION

105 WEST CAPITOL
JEFFERSON CITY, MO 65102
1-888-ASK-MODOT (1-888-275-6636)

1:40

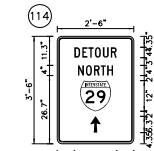

BORDER
R=1.5"
TH=0.63"
IN=0.47"

Panel Style: construction_guide.ssi
M.U.T.C.D.: 2009 Edition

Panel Style: construction_guide.ssi
Dimensions are in Inches,tenths


Letter locations are panel edge to lower left corner

[illegible]

SIGN NUMBER	name
WIDTH x HGHT.	2'-6" x 3'-6"
BORDER WIDTH	0.63"
CORNER RADIUS	1.5"
MOUNTING	Overhead
BACKGROUND	TYPE: Reflective
	COLOR: Orange
LEGEND/BORDER	TYPE: Reflective
	COLOR: Black/Black

SYMBOL	ROT	X	Y	WID	HT
M1_1	0	9	12.7	12	12
AR_Type A	0	13	4.3	4	6.3

1:40

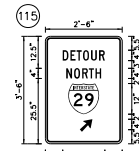

BORDER
R=1.5"
TH=0.63"
IN=0.47"

Panel Style: construction_guide.ssi
M.U.T.C.D.: 2009 Edition

Panel Style: construction_guide.ssi
Dimensions are in Inches,tenths

Letter locations are panel edge to lower left corner

[illegible]

SIGN NUMBER	name
WIDTH x HIGHT.	2'-6" x 3'-6"
BORDER WIDTH	0.63"
CORNER RADIUS	1.5"
MOUNTING	Overhead
BACKGROUND	TYPE: Reflective
	COLOR: Orange
LEGEND/BORDER	TYPE: Reflective
	COLOR: Black/Black

SYMBOL	ROT	X	Y	WID	HT
MT_1	0	9	11.5	12	12
AR_Type A	90	11.8	5.5	4	6.3

DATE PREPARED
7/19/2020

ROUTE I-29	STATE MO
DISTRICT K.C.	SHEET NO. 2-6

COUNTY
PLATTE

JOB NO.
J4I3291

CONTRACT ID.

PROJECT NO.

BRIDGE NO.

[illegible]

MISSOURI HIGHWAYS AND TRANSPORTATION
COMMISSION



JEFFERSON CITY, MO 65102
1-888-ASK-MODOT (1-888-275-6636)

BURNS & MCDONNELL Engineering Co., Inc.

9400 Ward Parkway
Kansas City, Missouri 64114
816-333-9400


No. : 000165

BMCD Project No. 109387




**BURNS
MCDONNELL**

I-29 OVER 56TH ST.
DETOUR
SIGN DETAILS
SHEET 7 OF 7

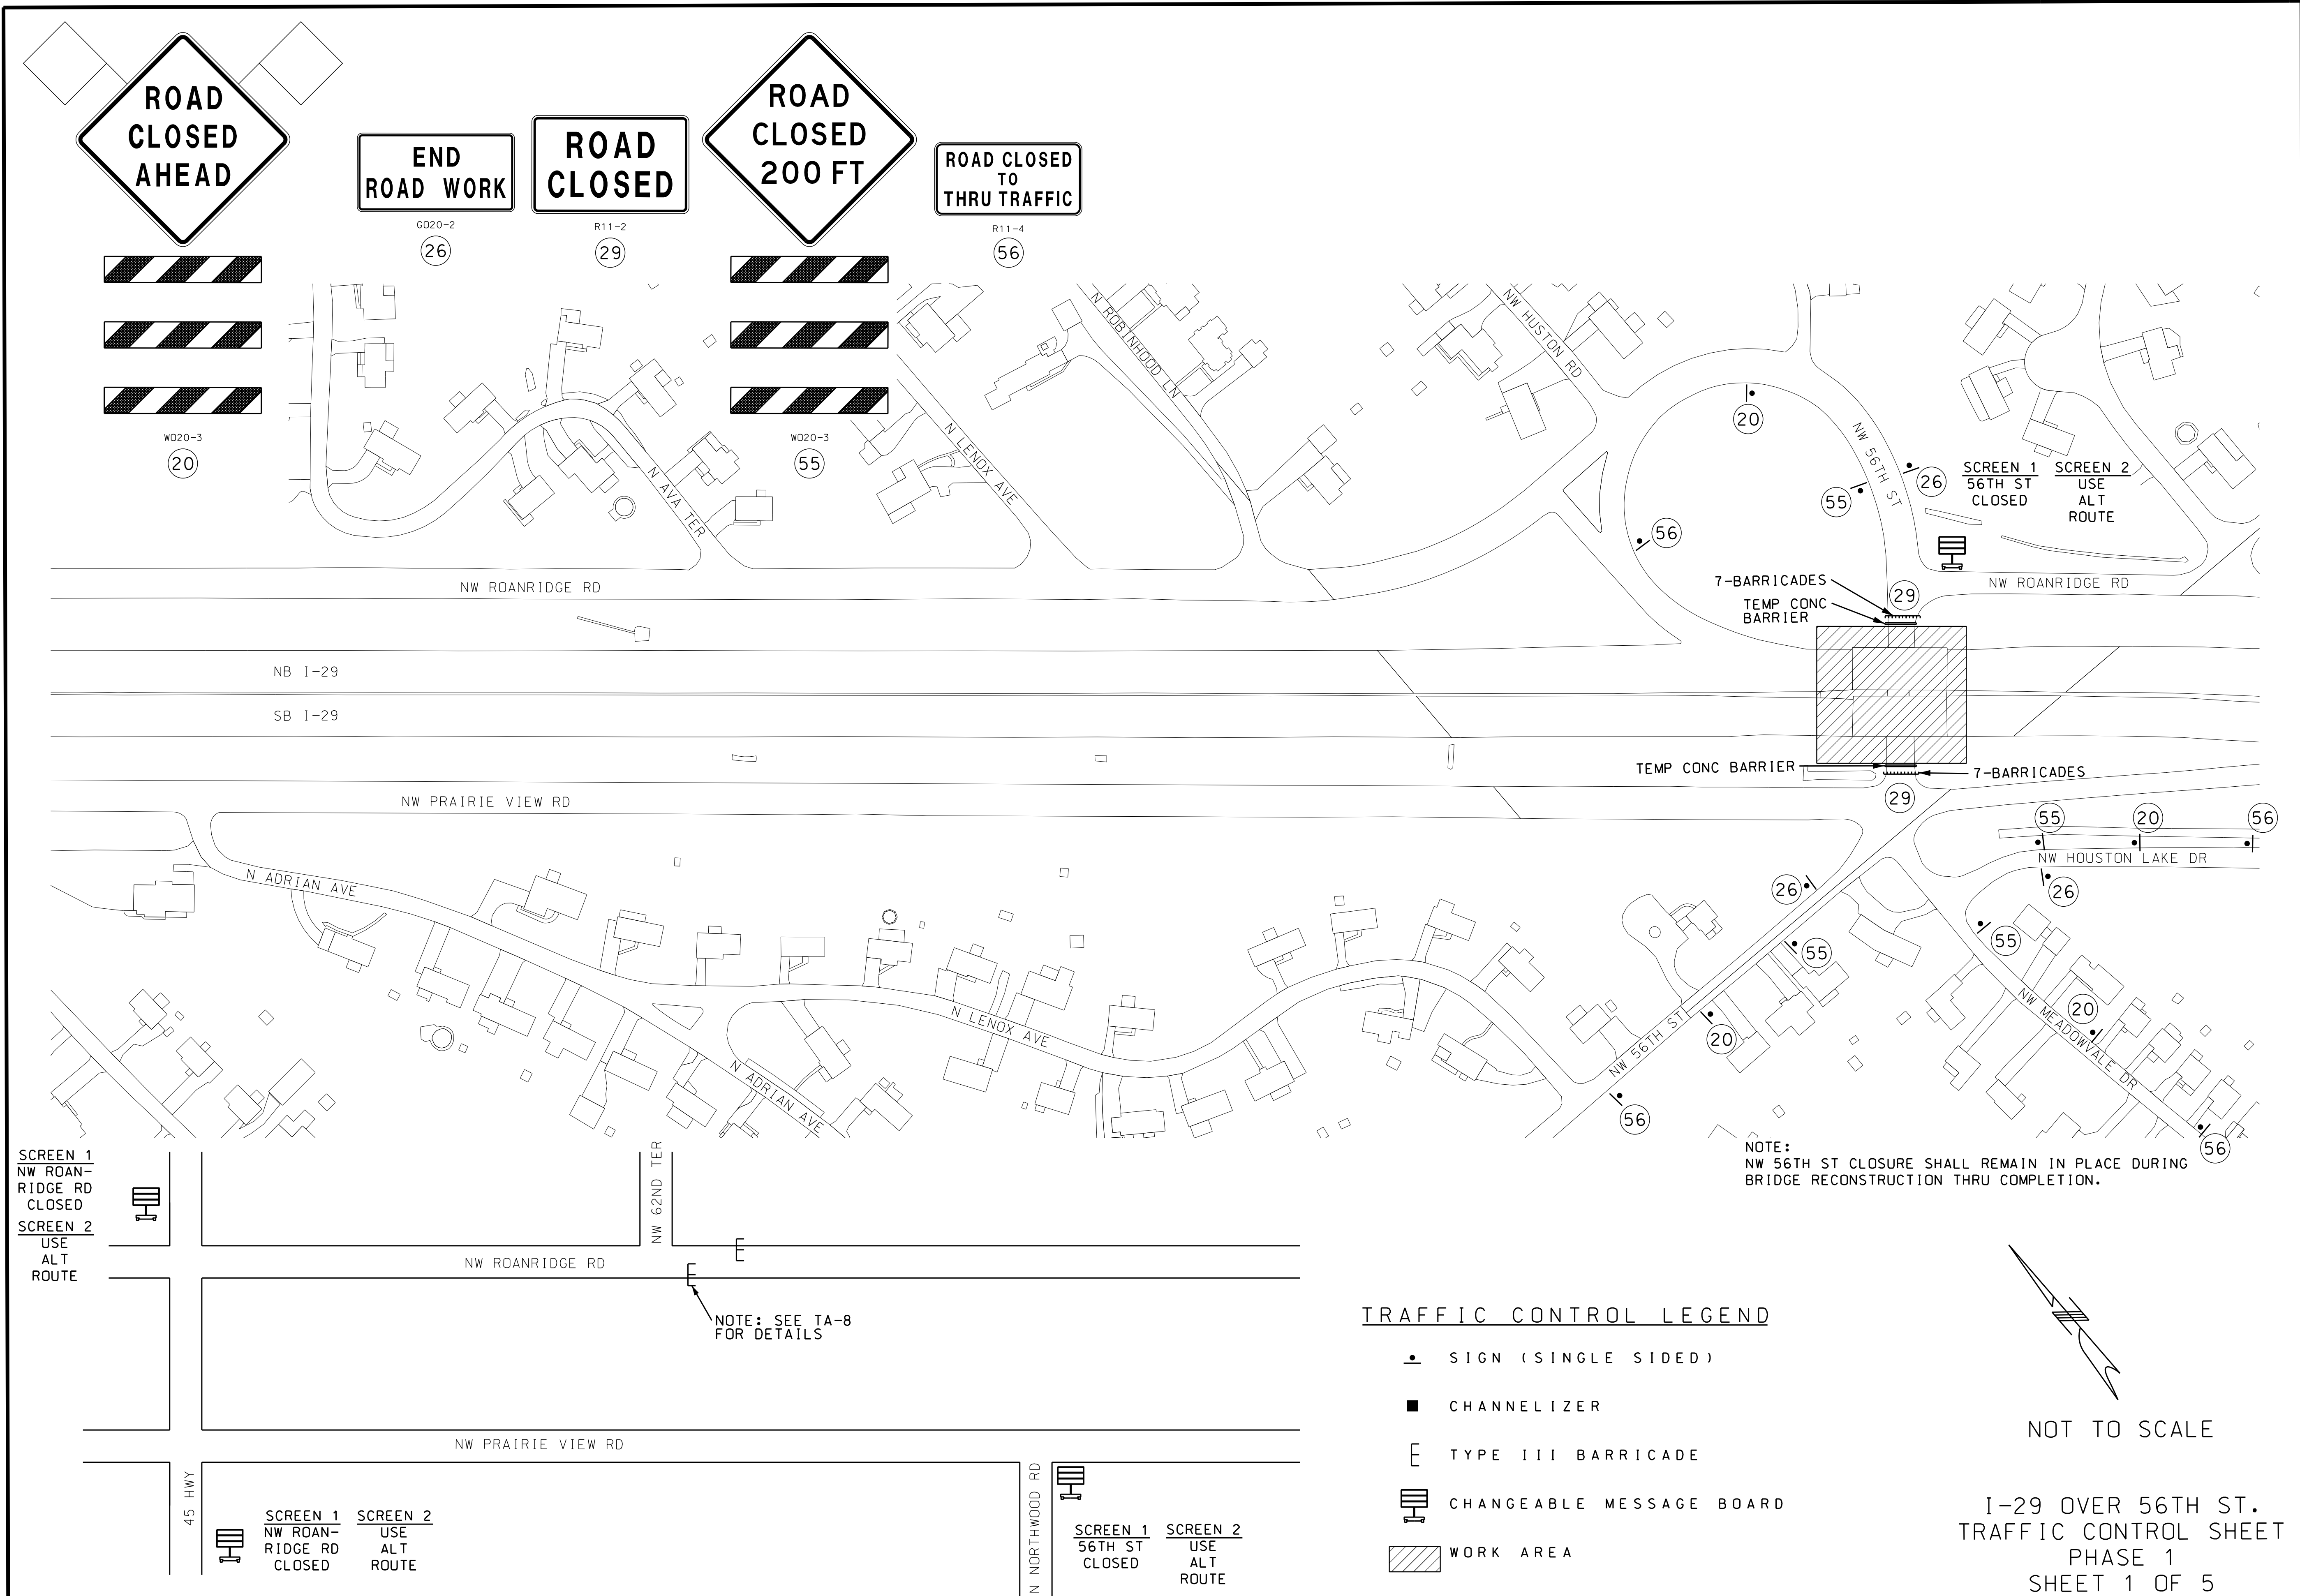

TREK DESIGN GROUP, LLC 1411 East 104th St. Kansas City, MO 64131 Tel (816) 874-4655 Fax (816) 874-4675 www.trekdesigngroup.com Missouri Cert. of Authority 2002010300	MISSOURI HIGHWAYS AND TRANSPORTATION COMMISSION			 105 WEST CAPITAL JEFFERSON CITY, MO 65102 1-888-ASK-MDOT (1-888-275-6636)
DATE PREPARED 6/26/2020				
ROUTE I-29		STATE MO		
DISTRICT KC		SHEET NO. 27		
COUNTY PLATTE				
JOB NO. J413291				
CONTRACT ID.				
PROJECT NO.				
BRIDGE NO.				

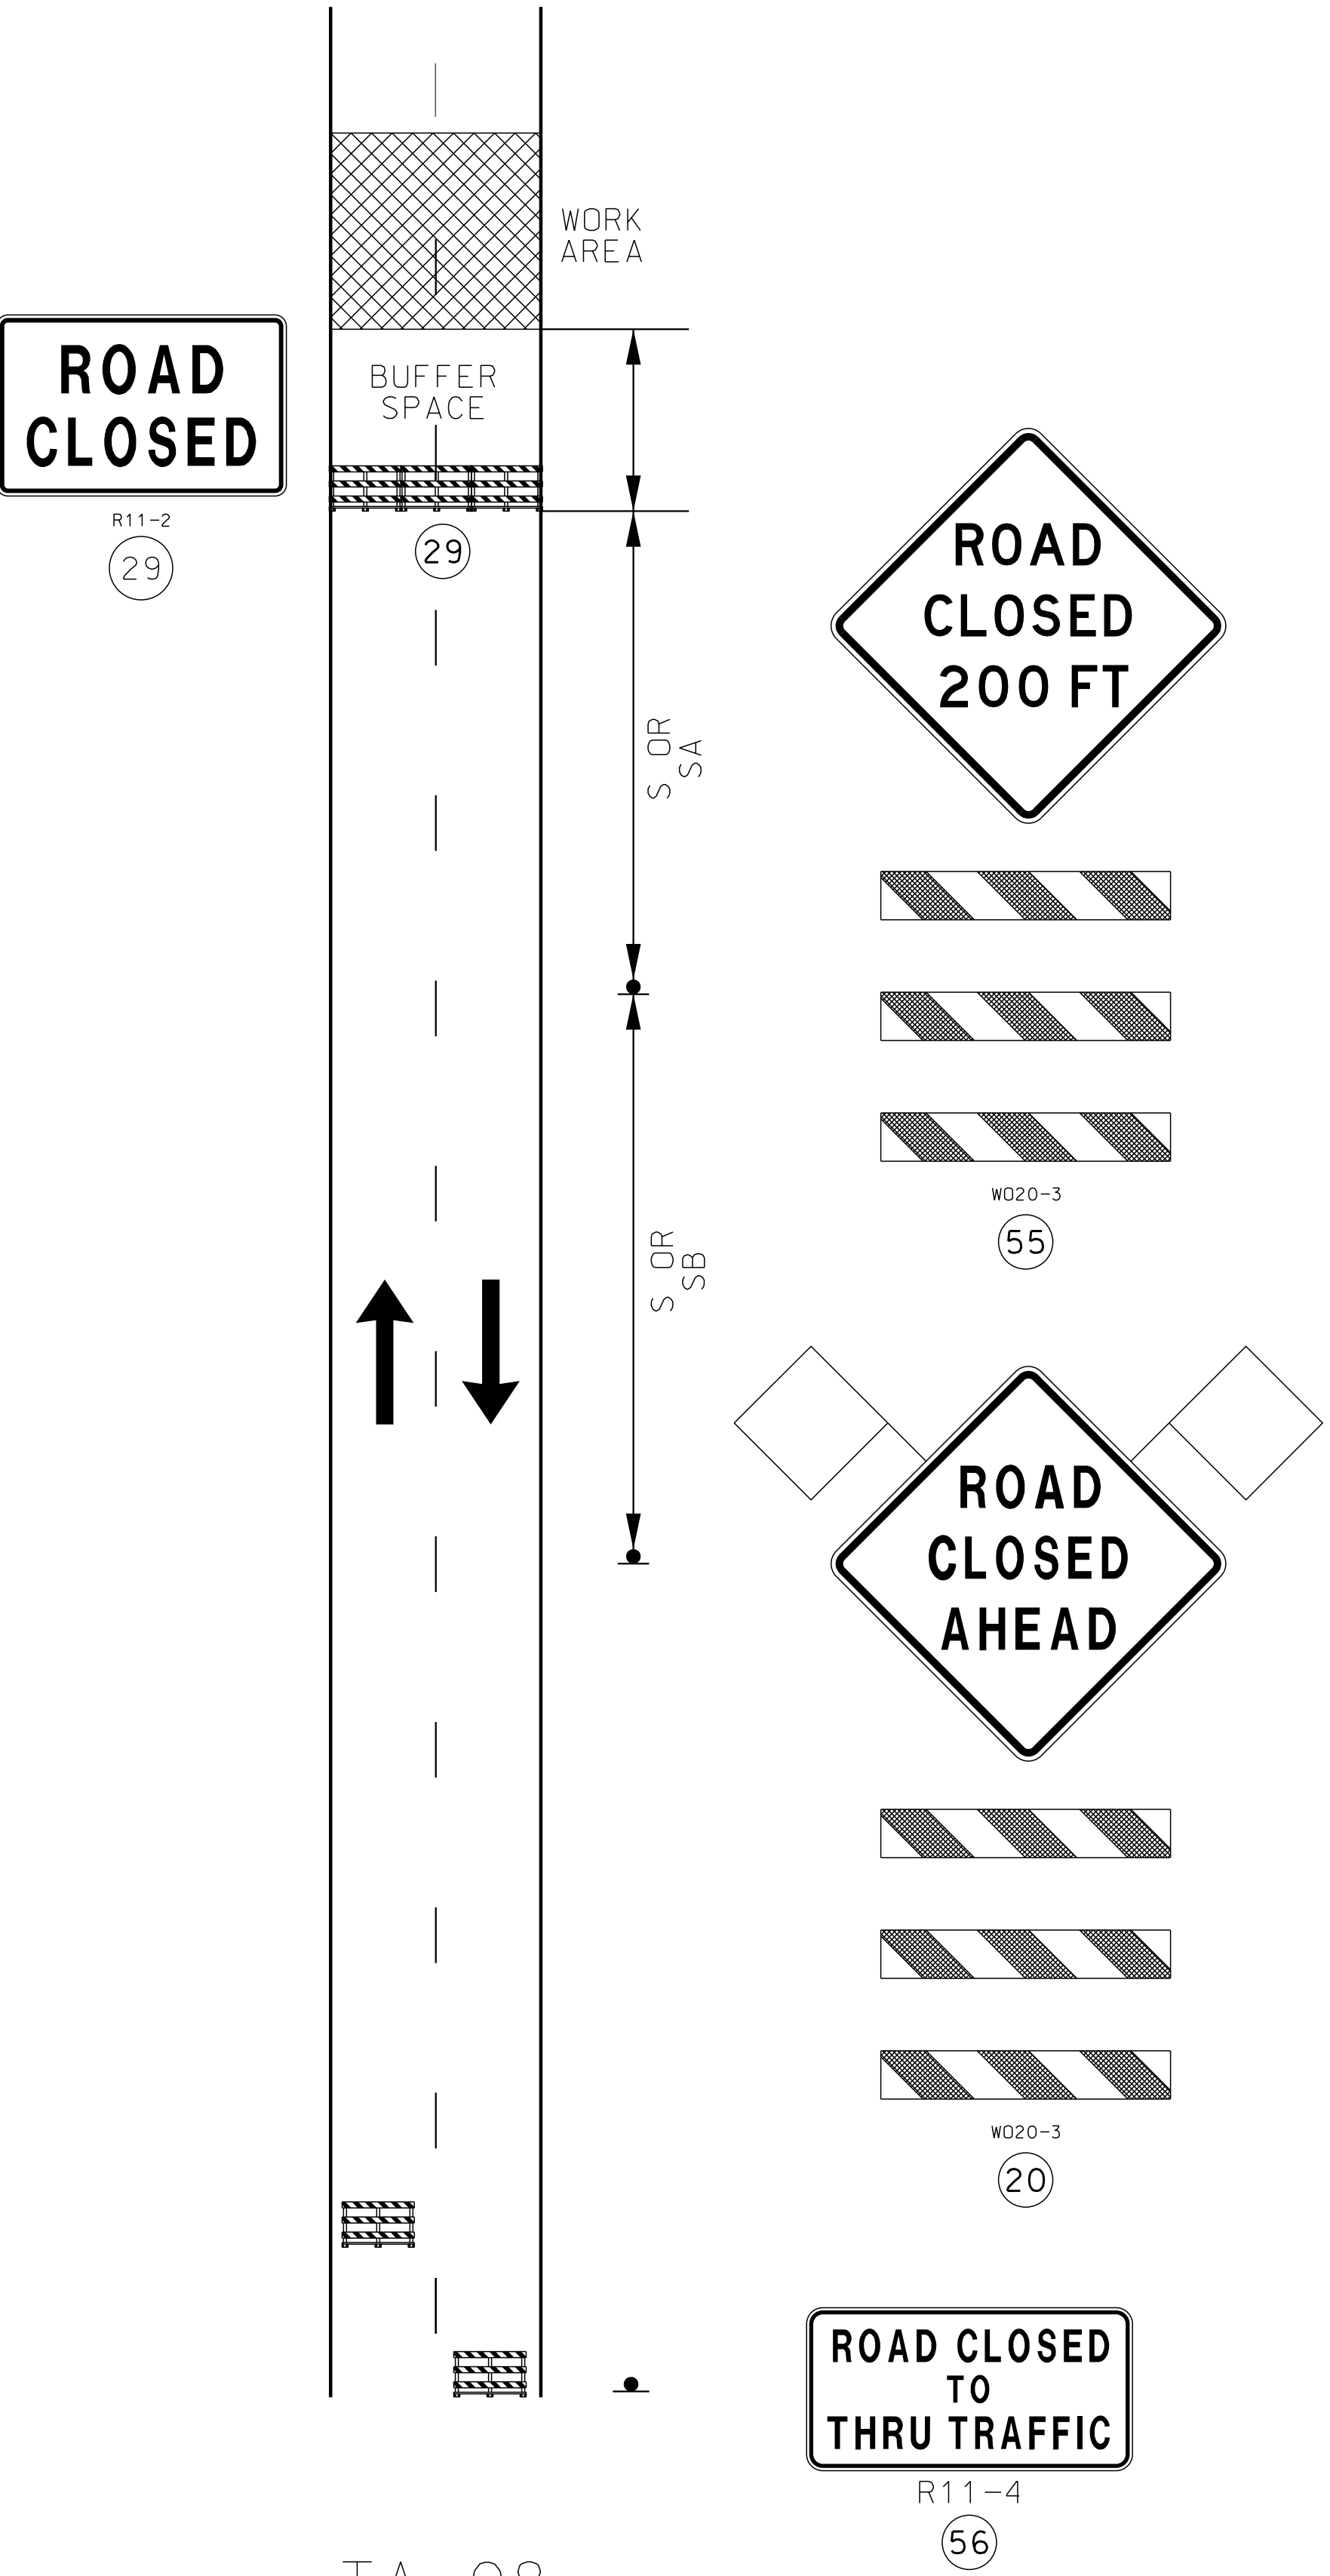

NOTES:


SEE TRAFFIC CONTROL SHEET 43 FOR WORK ZONE SPEED LIMIT GUIDELINES.

SEE TRAFFIC CONTROL SHEET 43 FOR SIGN SPACING, DEVICE SPACING AND CHANNELIZING TAPER LENGTHS.

WHEN A SIDE ROAD INTERSECTS THE HIGHWAY WITHIN THE TTC ZONE ADDITIONAL TTC DEVICES SHALL BE PLACED AS NEEDED.

“ROAD CLOSED” SIGN MAY BE PLACED 7-10 FEET BEHIND THE BARRICADES AND AT A SIGN HEIGHT APPROPRIATE TO THE TYPE OF ROADWAY. ONE BARRICADE SHOULD BE REQUIRED TO COMPLETELY CLOSE EACH 8-FEET OF PAVEMENT. PAVED SHOULDERS SHALL BE INCLUDED IN THE AREA TO BE CLOSED.


IF USED, THE “ROAD CLOSED XX MILES AHEAD LOCAL TRAFFIC ONLY” OR “ROAD CLOSED TO THRU TRAFFIC” SIGN SHOULD BE LOCATED AT THE FIRST STATE ROUTE OR, UPON THE DISCRETION OF THE ENGINEER, ANY OTHER INTERSECTION IN ADVANCE OF THE CLOSURE. ADDITIONAL BARRICADES MAY BE USED AND OFFSETTED TO FACILITATE ACCESS FOR WORK VEHICLES, LOCAL TRAFFIC, ETC.

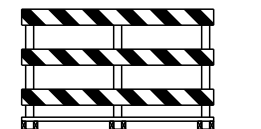

BARRICADE



 FOR FLAGS AND ADVANCE WARNING RAIL SYSTEMS,



REFER TO EPG 616.6.2.2



FLAGS AND ADVANCED WARNING RAIL SYSTEM

DATE PREPARED
6/26/2020

ROUTE
I-29

DISTRICT
KC

STATE
MO

SHEET NO.
28

COUNTY
PLATTE

JOB NO.
J413291


CONTRACT ID.

PROJECT NO.

BRIDGE NO.

DESCRIPTION	DATE


MISSOURI HIGHWAYS AND TRANSPORTATION COMMISSION

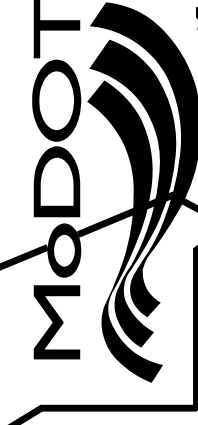

105 WEST CAPITOL
JEFFERSON CITY, MO 65102
1-888-ASK-MODOT (1-888-275-6636)

1411 East 104th St.
Kansas City, MO 64131
Tel (816) 974-4655
Fax (816) 974-4675
www.trekdesigngroup.com

Missouri Cert. of
Authority 202010300

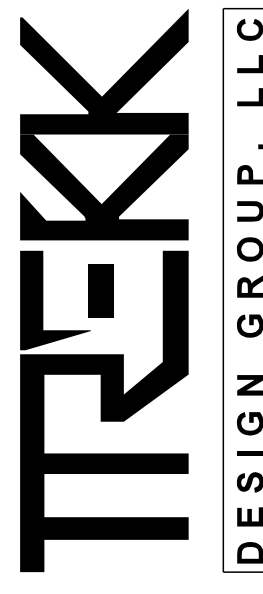


024_TC_02_J413291_I1-56THST_TA-08.dgn 1:56:33 PM 6/26/2020

TRAFFIC CONTROL LEGEND

- SIGN (SINGLE SIDED)
- ◐ SIGN (DOUBLE SIDED)
- ◁ FLAGGER
- ▲ CONE
- CHANNELIZER
- [BARRICADE
- ▮ CHANGEABLE MESSAGE BOARD
- ▨ WORK AREA



CONST-7-48
91

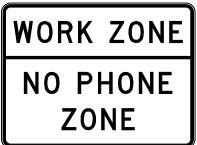

SPECIAL
90




G020-1
1



W020-5
58



W020-1
2

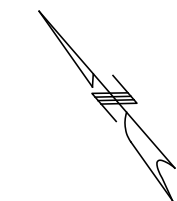

NOT TO SCALE



W04-1aR
59



 
W020-6a
57





R2-1
4



G020-5aP
54



G020-2
26

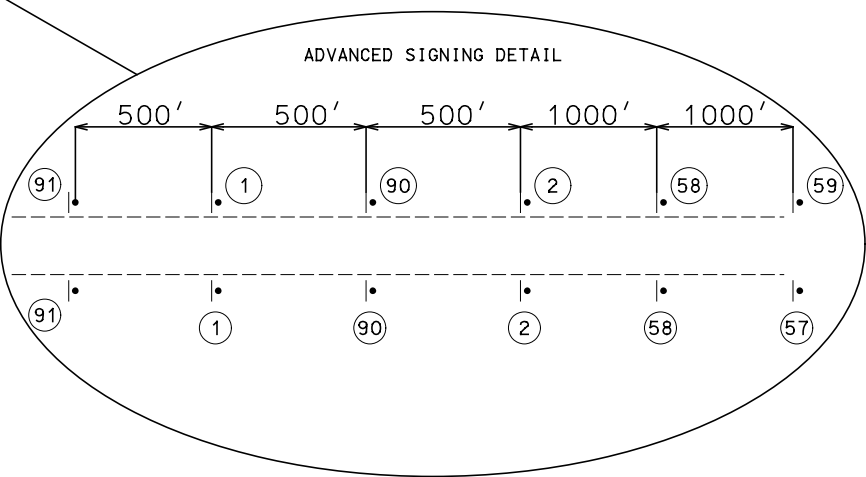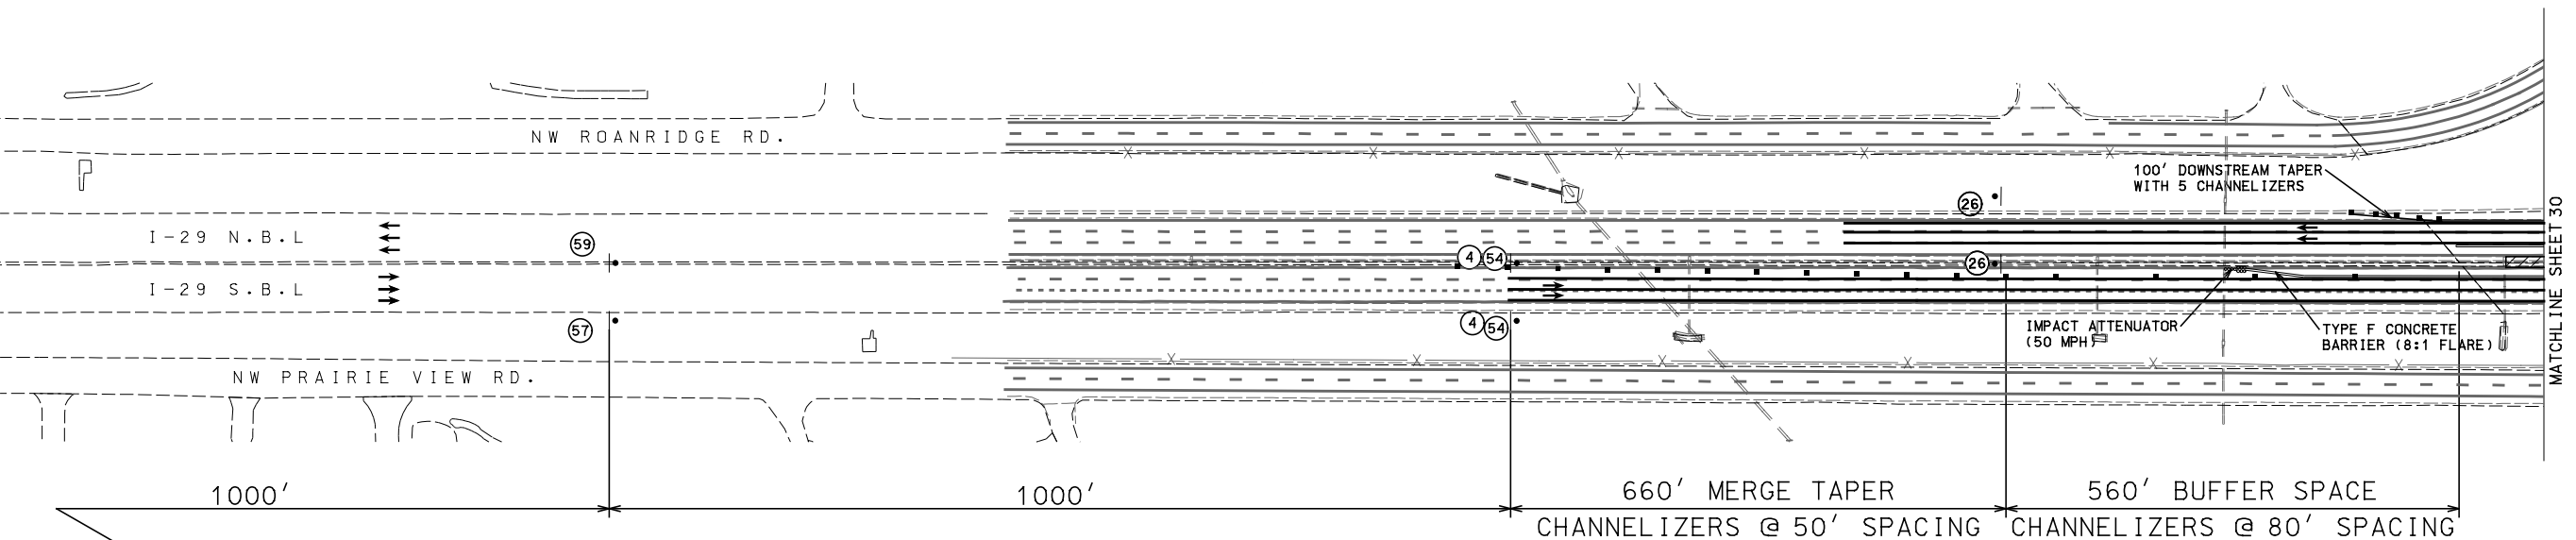

- NOTES:
1. CONTRACTOR IS RESPONSIBLE FOR ENSURING THAT ALL SIGNS AND INSTALLATIONS COMPLY WITH THE FULL INTENT OF THE LATEST EDITION OF THE M.U.T.C.D.
 2. CONTRACTOR SHALL MASK OR REMOVE ALL CONFLICTING PAVEMENT MARKING OR SIGNING.
 3. CONTRACTOR MAY FIELD ADJUST INSTALLATIONS. COORDINATE WITH ENGINEER.
 4. NO SURVEY INFORMATION HAS BEEN USED TO DEVELOP THESE PLANS. CONTRACTOR SHALL FIELD VERIFY PRIOR TO STARTING WORK.
 5. REMOVE AND/OR MODIFY EXISTING PAVEMENT MARKINGS.
 6. ALL EXISTING SIGNS THAT CONFLICT WITH THE PROPOSED TCP SHALL BE COVERED. NO DIRECT PAY.
 7. NO DIRECT PAYMENT FOR RELOCATION OF TCP SIGNS. ALL WARNING SIGNS SHALL HAVE FLORESCENT SHEETING.

I-29 OVER 56TH ST.
TRAFFIC CONTROL SHEET
PHASE 1
SHEET 3 OF 5

"THIS MEDIA SHOULD NOT BE CONSIDERED A CERTIFIED DOCUMENT."

DATE PREPARED
7/19/2020

ROUTE
I-29
STATE
MO
DISTRICT
K-C
SHEET NO.
29

COUNTY
PLATTE

JOB NO.
J413291

CONTRACT ID.

PROJECT NO.

BRIDGE NO.

DESCRIPTION	DATE

MISSOURI HIGHWAYS AND TRANSPORTATION COMMISSION




Burns & McDonnell Engineering Co., Inc.

9400 Ward Parkway
Kansas City, Missouri 64114
816-333-9400

Certificate of Authority
No. : 000165
BMOB Project No. 109387



IF A SEAL IS PRESENT ON THIS SHEET IT HAS BEEN ELECTRONICALLY SEALED AND DATED.

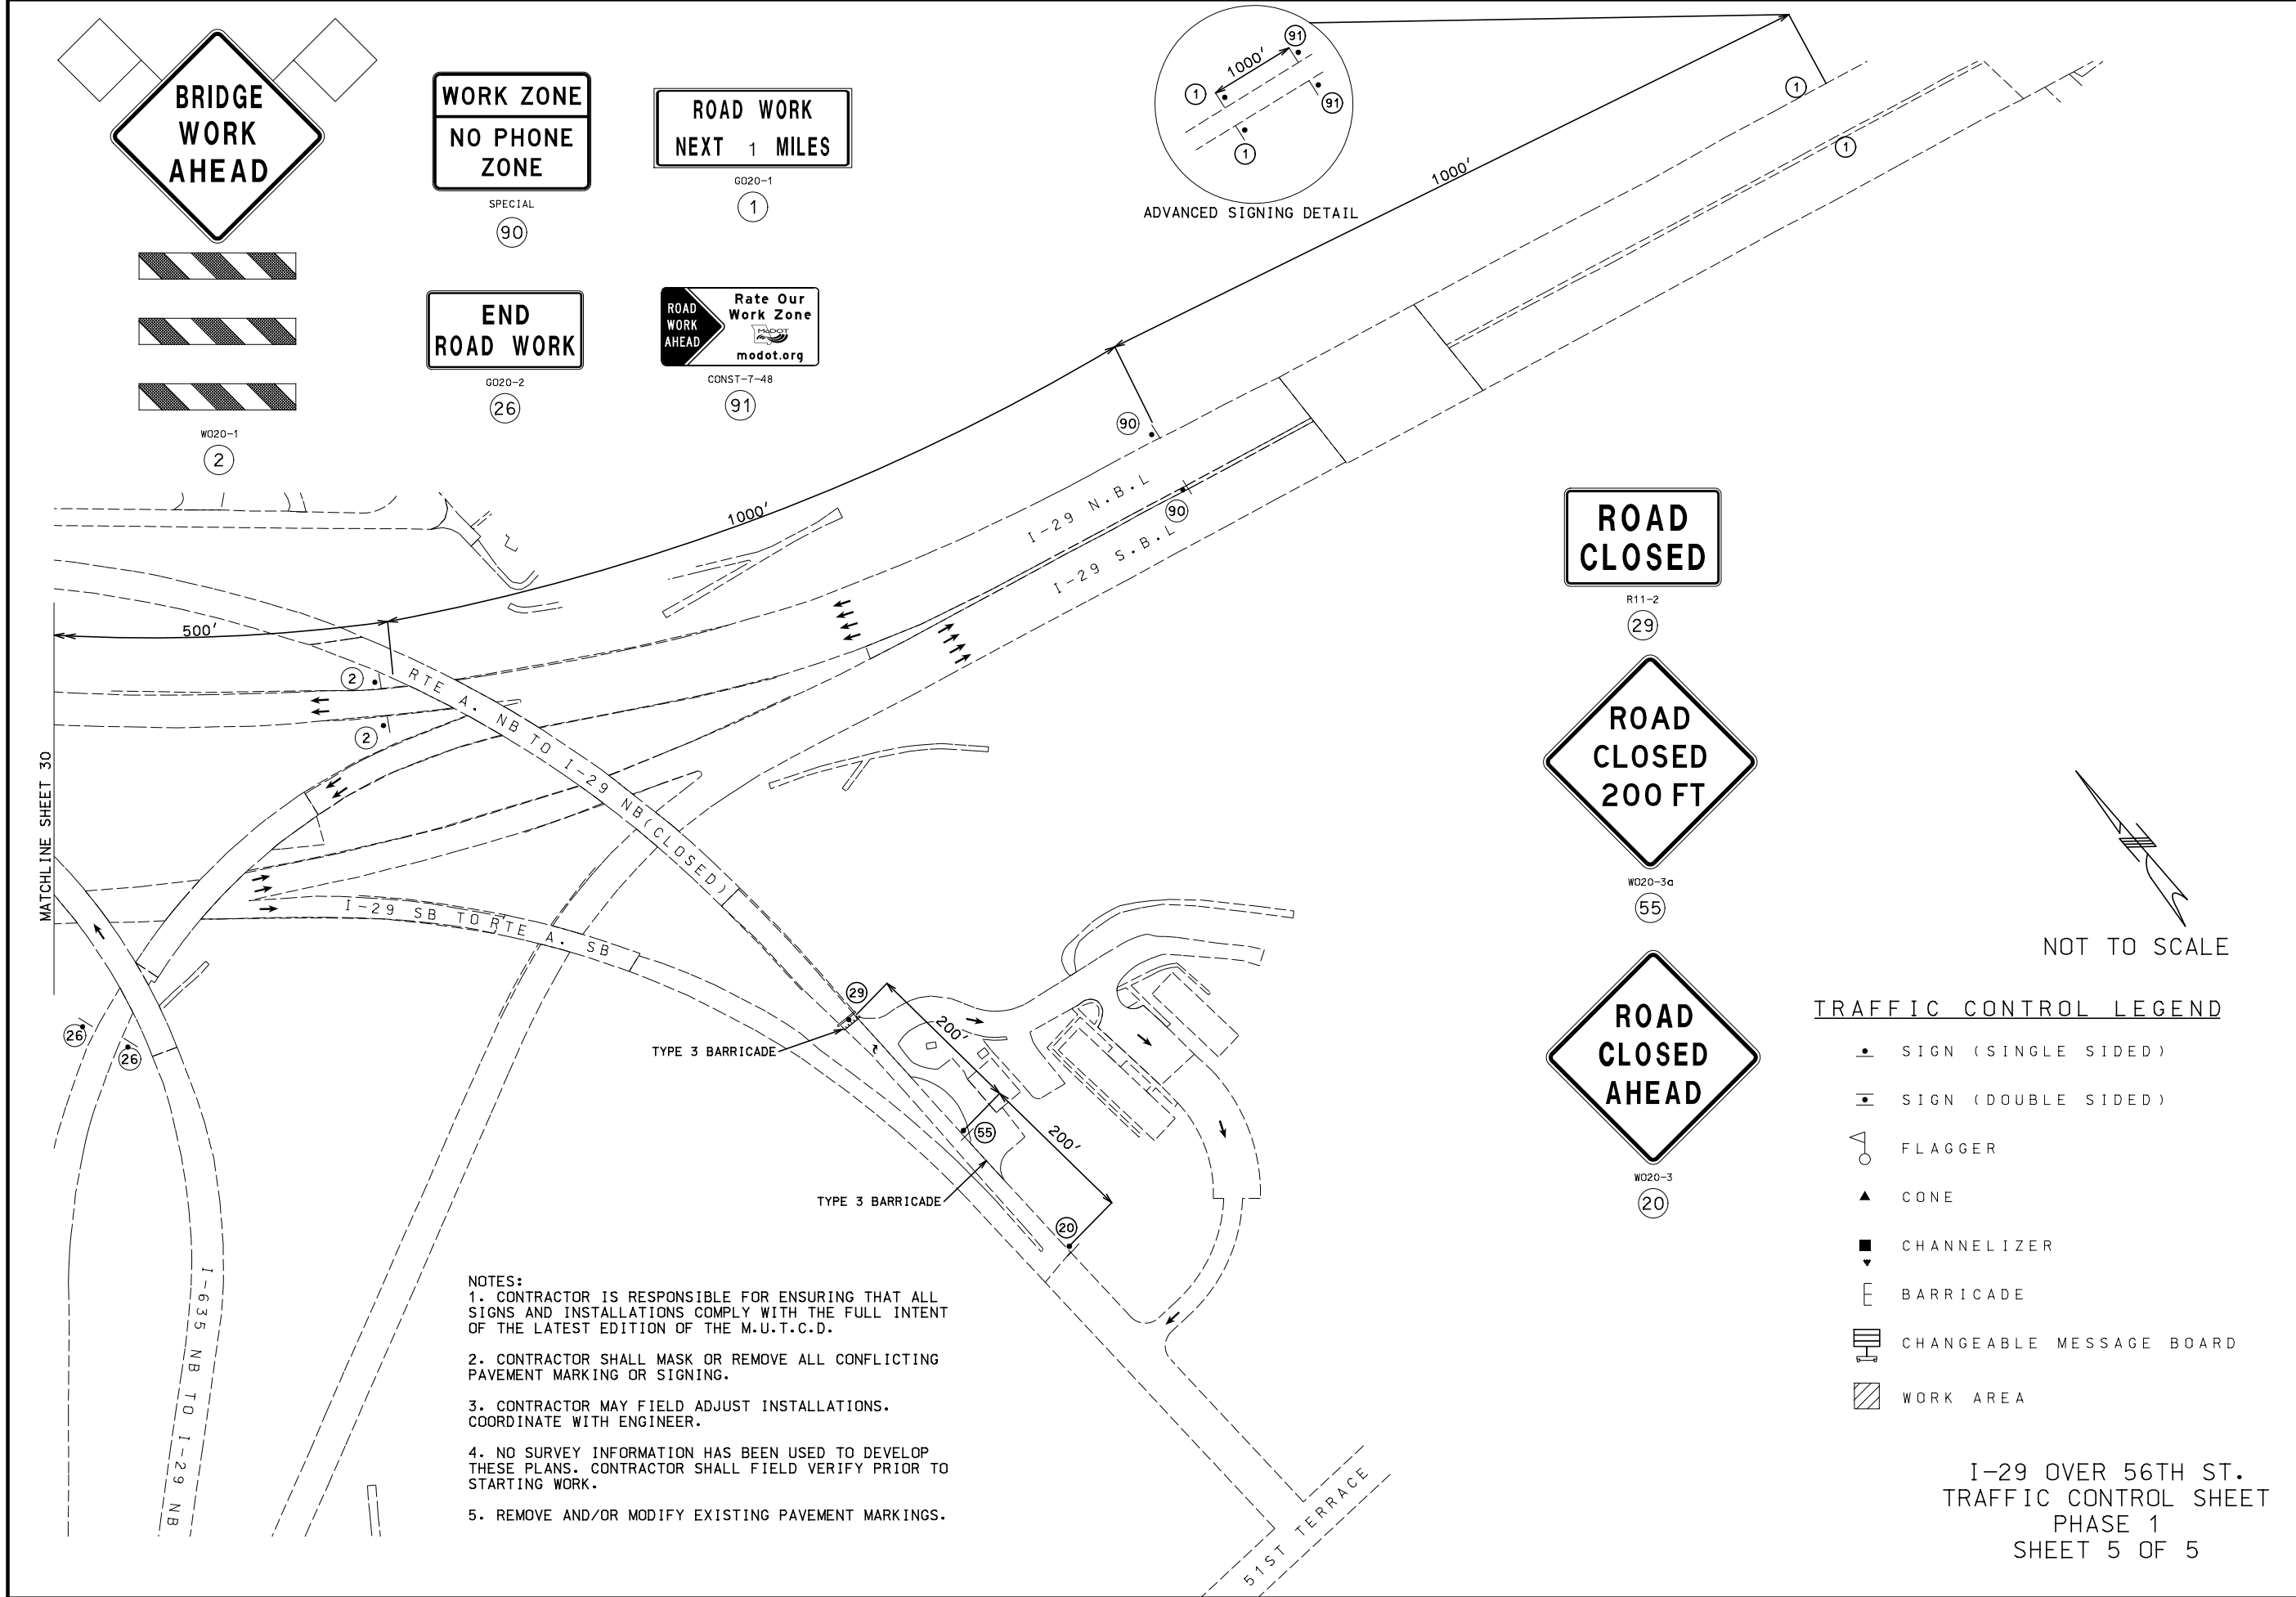

- NOTES:
1. CONTRACTOR IS RESPONSIBLE FOR ENSURING THAT ALL SIGNS AND INSTALLATIONS COMPLY WITH THE FULL INTENT OF THE LATEST EDITION OF THE M.U.T.C.D.
 2. CONTRACTOR SHALL MASK OR REMOVE ALL CONFLICTING PAVEMENT MARKING OR SIGNING.
 3. CONTRACTOR MAY FIELD ADJUST INSTALLATIONS. COORDINATE WITH ENGINEER.
 4. NO SURVEY INFORMATION HAS BEEN USED TO DEVELOP THESE PLANS. CONTRACTOR SHALL FIELD VERIFY PRIOR TO STARTING WORK.
 5. REMOVE AND/OR MODIFY EXISTING PAVEMENT MARKINGS.

- TRAFFIC CONTROL LEGEND
- SIGN (SINGLE SIDED)
 - SIGN (DOUBLE SIDED)
 - ◁ FLAGGER
 - ▲ CONE
 - CHANNELIZER
 - ⌄ BARRICADE
 - ⌄ CHANGEABLE MESSAGE BOARD
 - ▨ WORK AREA

I-29 OVER 56TH ST.
TRAFFIC CONTROL SHEET
PHASE 1
SHEET 5 OF 5

"THIS MEDIA SHOULD NOT BE CONSIDERED A CERTIFIED DOCUMENT."

DATE PREPARED
7/19/2020

ROUTE I-29	STATE MO
DISTRICT K-C	SHEET NO. 31

COUNTY
PLATTE

JOB NO.
J413291

CONTRACT ID.
.

PROJECT NO.
.

BRIDGE NO.
.

DESCRIPTION	DATE
.	.
.	.
.	.
.	.
.	.
.	.

MISSOURI HIGHWAYS AND TRANSPORTATION COMMISSION

MoDOT

105 WEST CAPITOL
JEFFERSON CITY, MO 65102
1-888-ASK-MODOT (1-888-275-6636)



Burns & McDonnell Engineering Co., Inc.

9400 Ward Parkway
Kansas City, Missouri 64114
816-333-9400





Certificate of Authority
No. : 000165

BMd Project No. 109387

NOTES:
1. CONTRACTOR IS RESPONSIBLE FOR ENSURING THAT ALL SIGNS AND INSTALLATIONS COMPLY WITH THE FULL INTENT OF THE LATEST EDITION OF THE M.U.T.C.D.
2. CONTRACTOR SHALL MASK OR REMOVE ALL CONFLICTING PAVEMENT MARKING OR SIGNING.
3. CONTRACTOR MAY FIELD ADJUST INSTALLATIONS. COORDINATE WITH ENGINEER.
4. NO SURVEY INFORMATION HAS BEEN USED TO DEVELOP THESE PLANS. CONTRACTOR SHALL FIELD VERIFY PRIOR TO STARTING WORK.
5. REMOVE AND/OR MODIFY EXISTING PAVEMENT MARKINGS

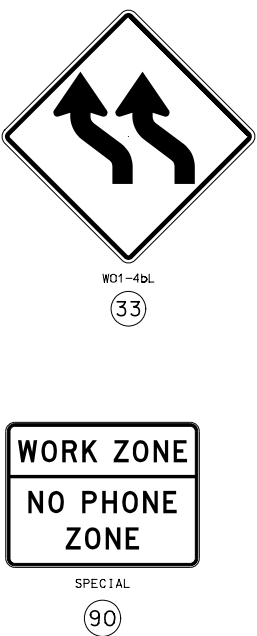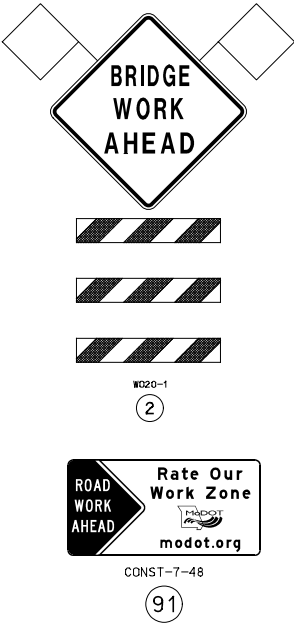

- TRAFFIC CONTROL LEGEND
- SIGN (SINGLE SIDED)
 - ▬ SIGN (DOUBLE SIDED)
 - ◁ FLAGGER
 - ▲ CONE
 - CHANNELIZER
 - ⌈ BARRICADE
 - ▨ CHANGEABLE MESSAGE BOARD
 - ▨ WORK AREA

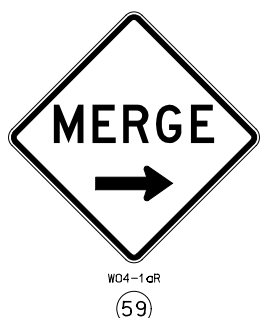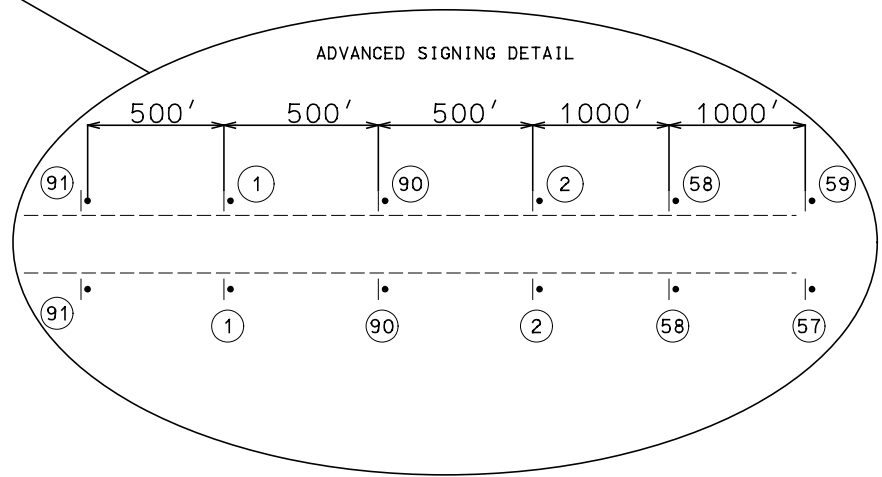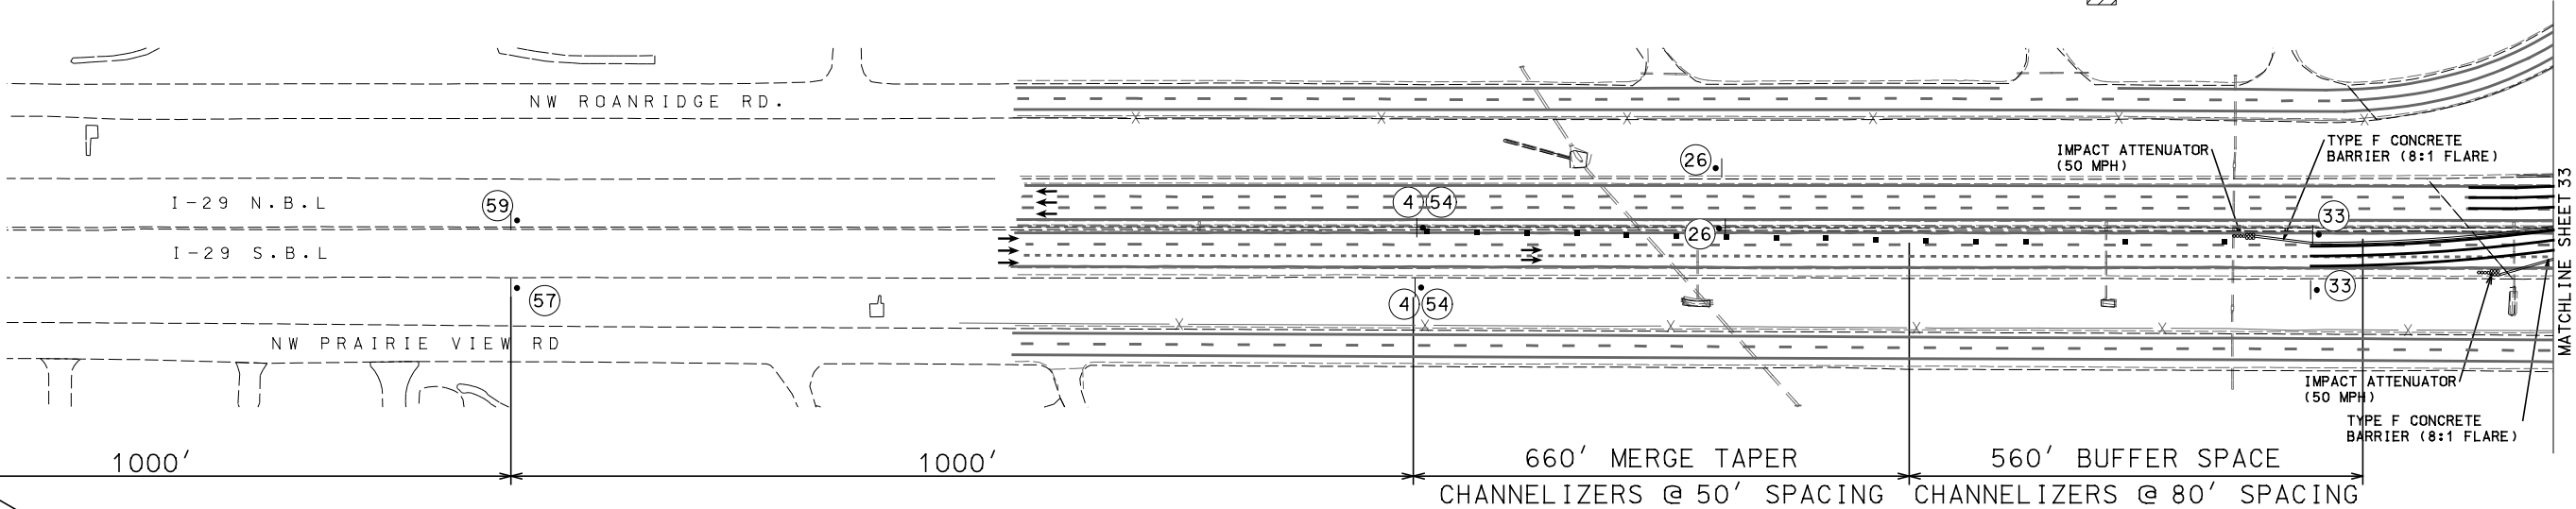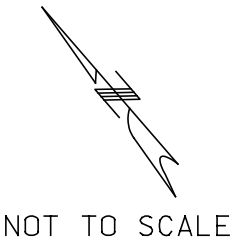

I-29 OVER 56TH ST.
TRAFFIC CONTROL SHEET
PHASE 2
SHEET 1 OF 4

"THIS MEDIA SHOULD NOT BE CONSIDERED A CERTIFIED DOCUMENT."


DATE PREPARED 7/19/2020

ROUTE I-29	STATE MO
DISTRICT K-C	SHEET NO. 32
COUNTY PLATTE	
JOB NO. J413291	
CONTRACT ID.	
PROJECT NO.	
BRIDGE NO.	

MISSOURI HIGHWAYS AND TRANSPORTATION COMMISSION

105 WEST CAPITAL
JEFFERSON CITY, MO 65102
1-888-ASK-MODOT (1-888-275-6636)

Burns & McDonnell Engineering Co., Inc.
9400 Ward Parkway
Kansas City, Missouri 64114
816-333-9400
Certificate of Authority
No. : 000165
BMOB Project No. 109387

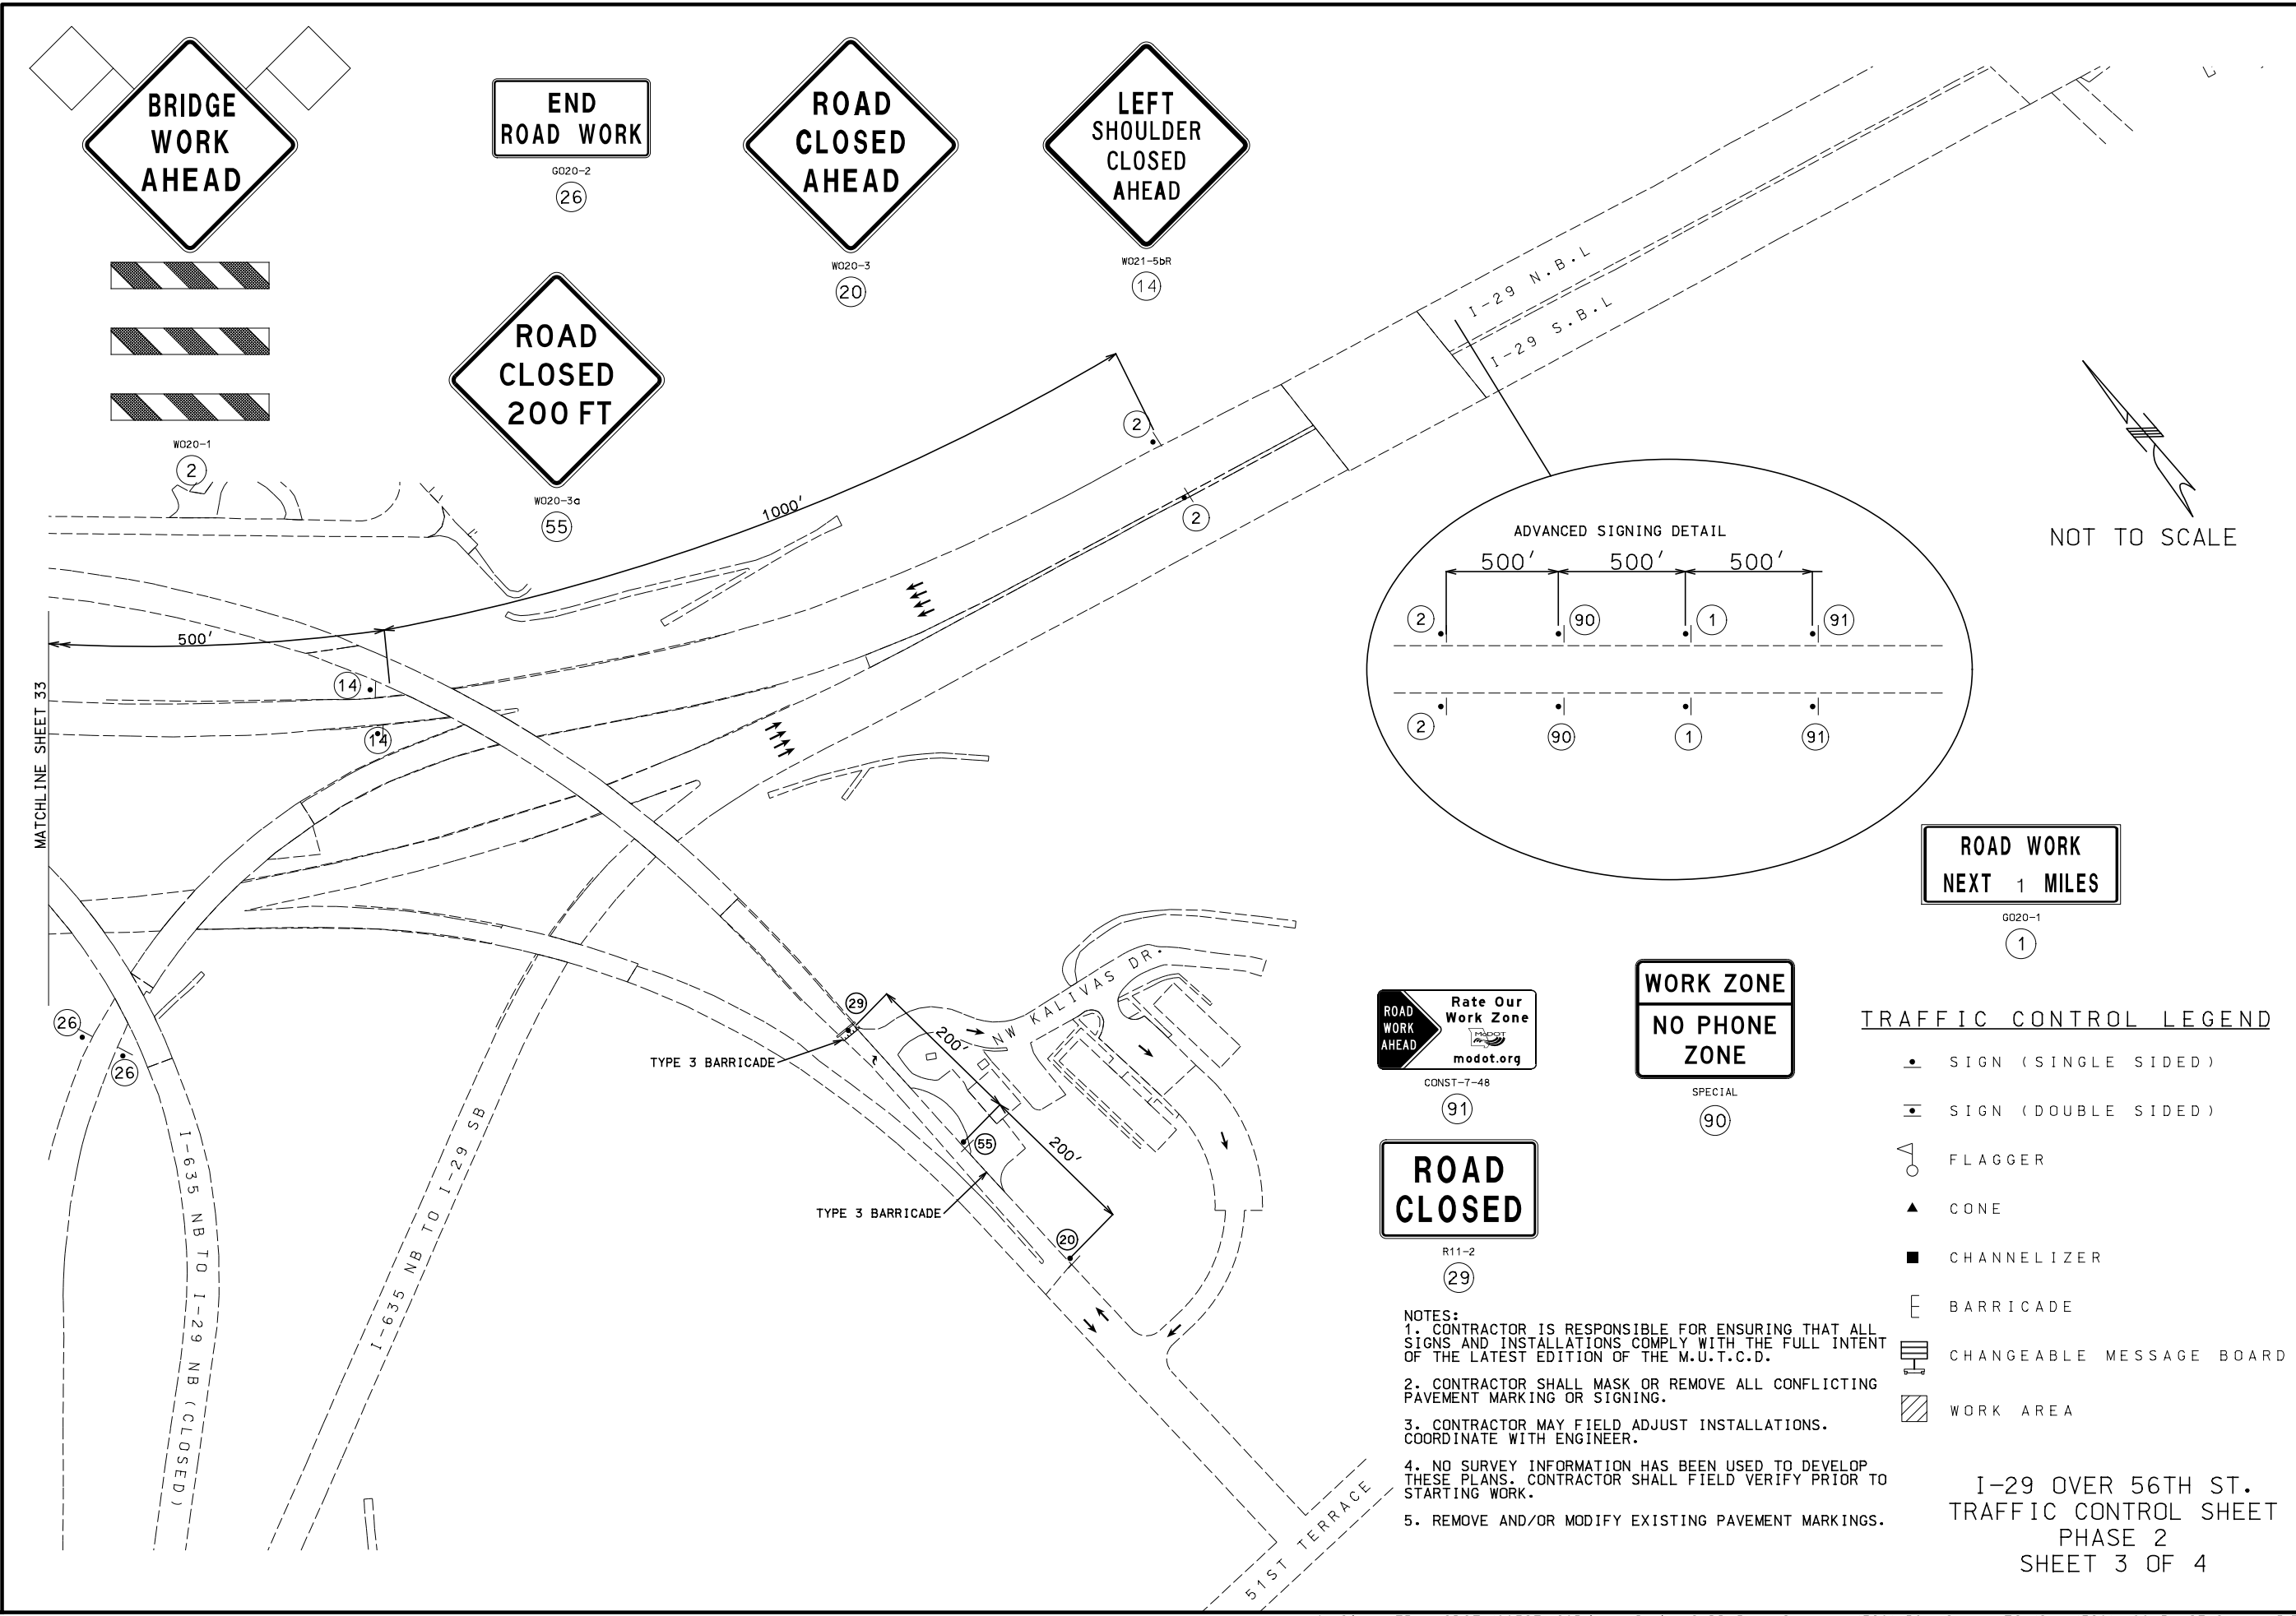

"THIS MEDIA SHOULD NOT BE CONSIDERED A CERTIFIED DOCUMENT."

DATE PREPARED
7/19/2020

ROUTE I-29	STATE MO
DISTRICT K-C	SHEET NO. 34

COUNTY
PLATTE

JOB NO.
J413291

CONTRACT ID.
.

PROJECT NO.
.

BRIDGE NO.
.

DESCRIPTION	DATE
.	.
.	.
.	.
.	.
.	.
.	.

MISSOURI HIGHWAYS AND TRANSPORTATION COMMISSION

MoDOT

105 WEST CAPITAL
JEFFERSON CITY, MO 65102
1-888-ASK-MODOT (1-888-278-6636)

Burns & McDonnell Engineering Co., Inc.

9400 Ward Parkway
Kansas City, Missouri 64114
816-333-9400








Certificate of Authority
No. : 000165

BMOB Project No. 109387

BURNS & McDONNELL

TRAFFIC CONTROL LEGEND

- SIGN (SINGLE SIDED)
- ▬ SIGN (DOUBLE SIDED)
- ◁ FLAGGER
- ▲ CONE
- CHANNELIZER
- ⌈ BARRICADE
- ▮ CHANGEABLE MESSAGE BOARD
- ▨ WORK AREA

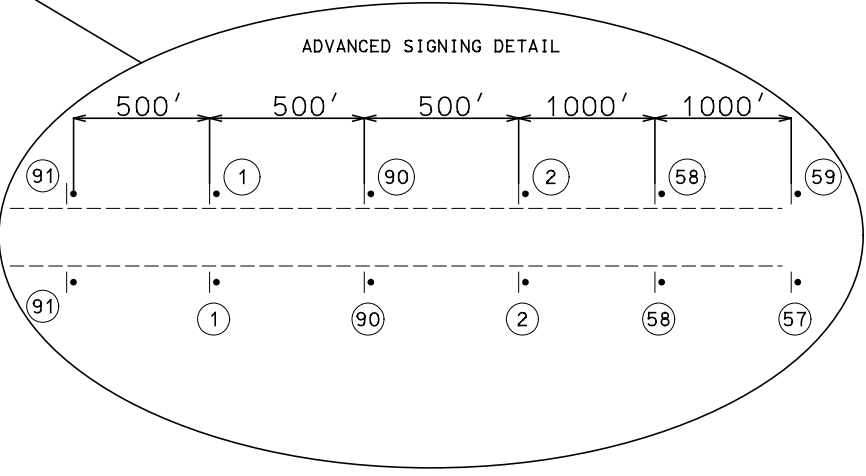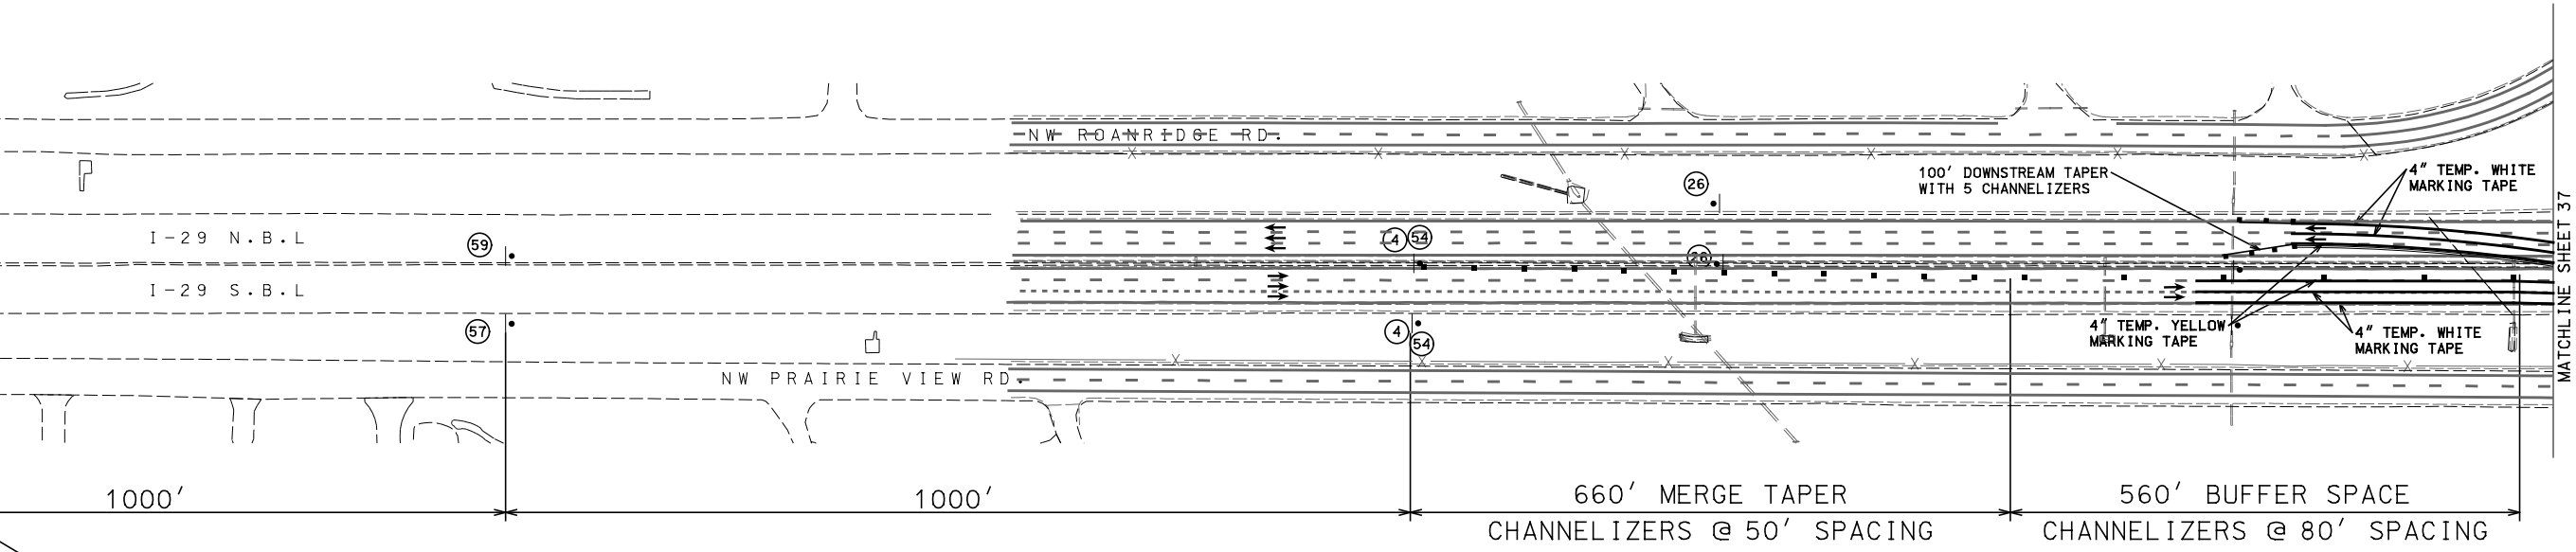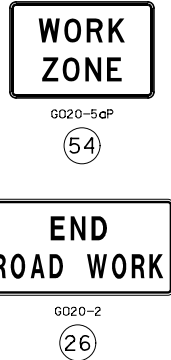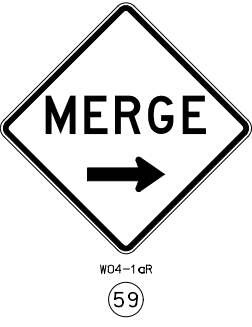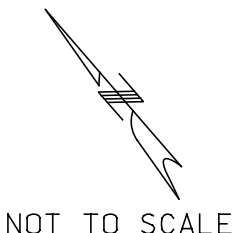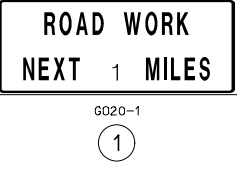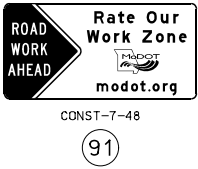

- NOTES:
1. CONTRACTOR IS RESPONSIBLE FOR ENSURING THAT ALL SIGNS AND INSTALLATIONS COMPLY WITH THE FULL INTENT OF THE LATEST EDITION OF THE M.U.T.C.D.
 2. CONTRACTOR SHALL MASK OR REMOVE ALL CONFLICTING PAVEMENT MARKING OR SIGNING.
 3. CONTRACTOR MAY FIELD ADJUST INSTALLATIONS. COORDINATE WITH ENGINEER.
 4. NO SURVEY INFORMATION HAS BEEN USED TO DEVELOP THESE PLANS. CONTRACTOR SHALL FIELD VERIFY PRIOR TO STARTING WORK.
 5. REMOVE AND/OR MODIFY EXISTING PAVEMENT MARKINGS

I-29 OVER 56TH ST.
TRAFFIC CONTROL SHEET
PHASE 3
SHEET 1 OF 4

"THIS MEDIA SHOULD NOT BE CONSIDERED A CERTIFIED DOCUMENT."

DATE PREPARED 7/19/2020	
ROUTE I-29	STATE MO
DISTRICT K-C	SHEET NO. 36
COUNTY PLATTE	
JOB NO. J413291	
CONTRACT ID.	
PROJECT NO.	
BRIDGE NO.	

DESCRIPTION	DATE

MISSOURI HIGHWAYS AND TRANSPORTATION COMMISSION



105 WEST CAPITAL
JEFFERSON CITY, MO 65102
1-888-ASK-MODOT (1-888-275-6636)

Burns & McDonnell Engineering Co., Inc.

9400 Ward Parkway
Kansas City, Missouri 64114
816-333-9400

Certification of Authority
No. : 000165
BMOB Project No. 109387



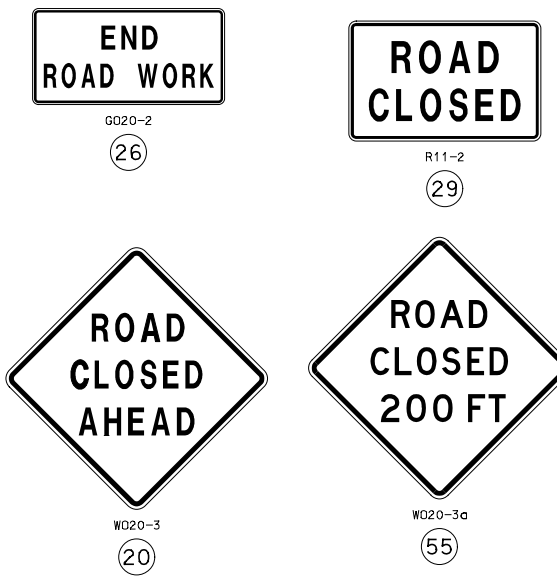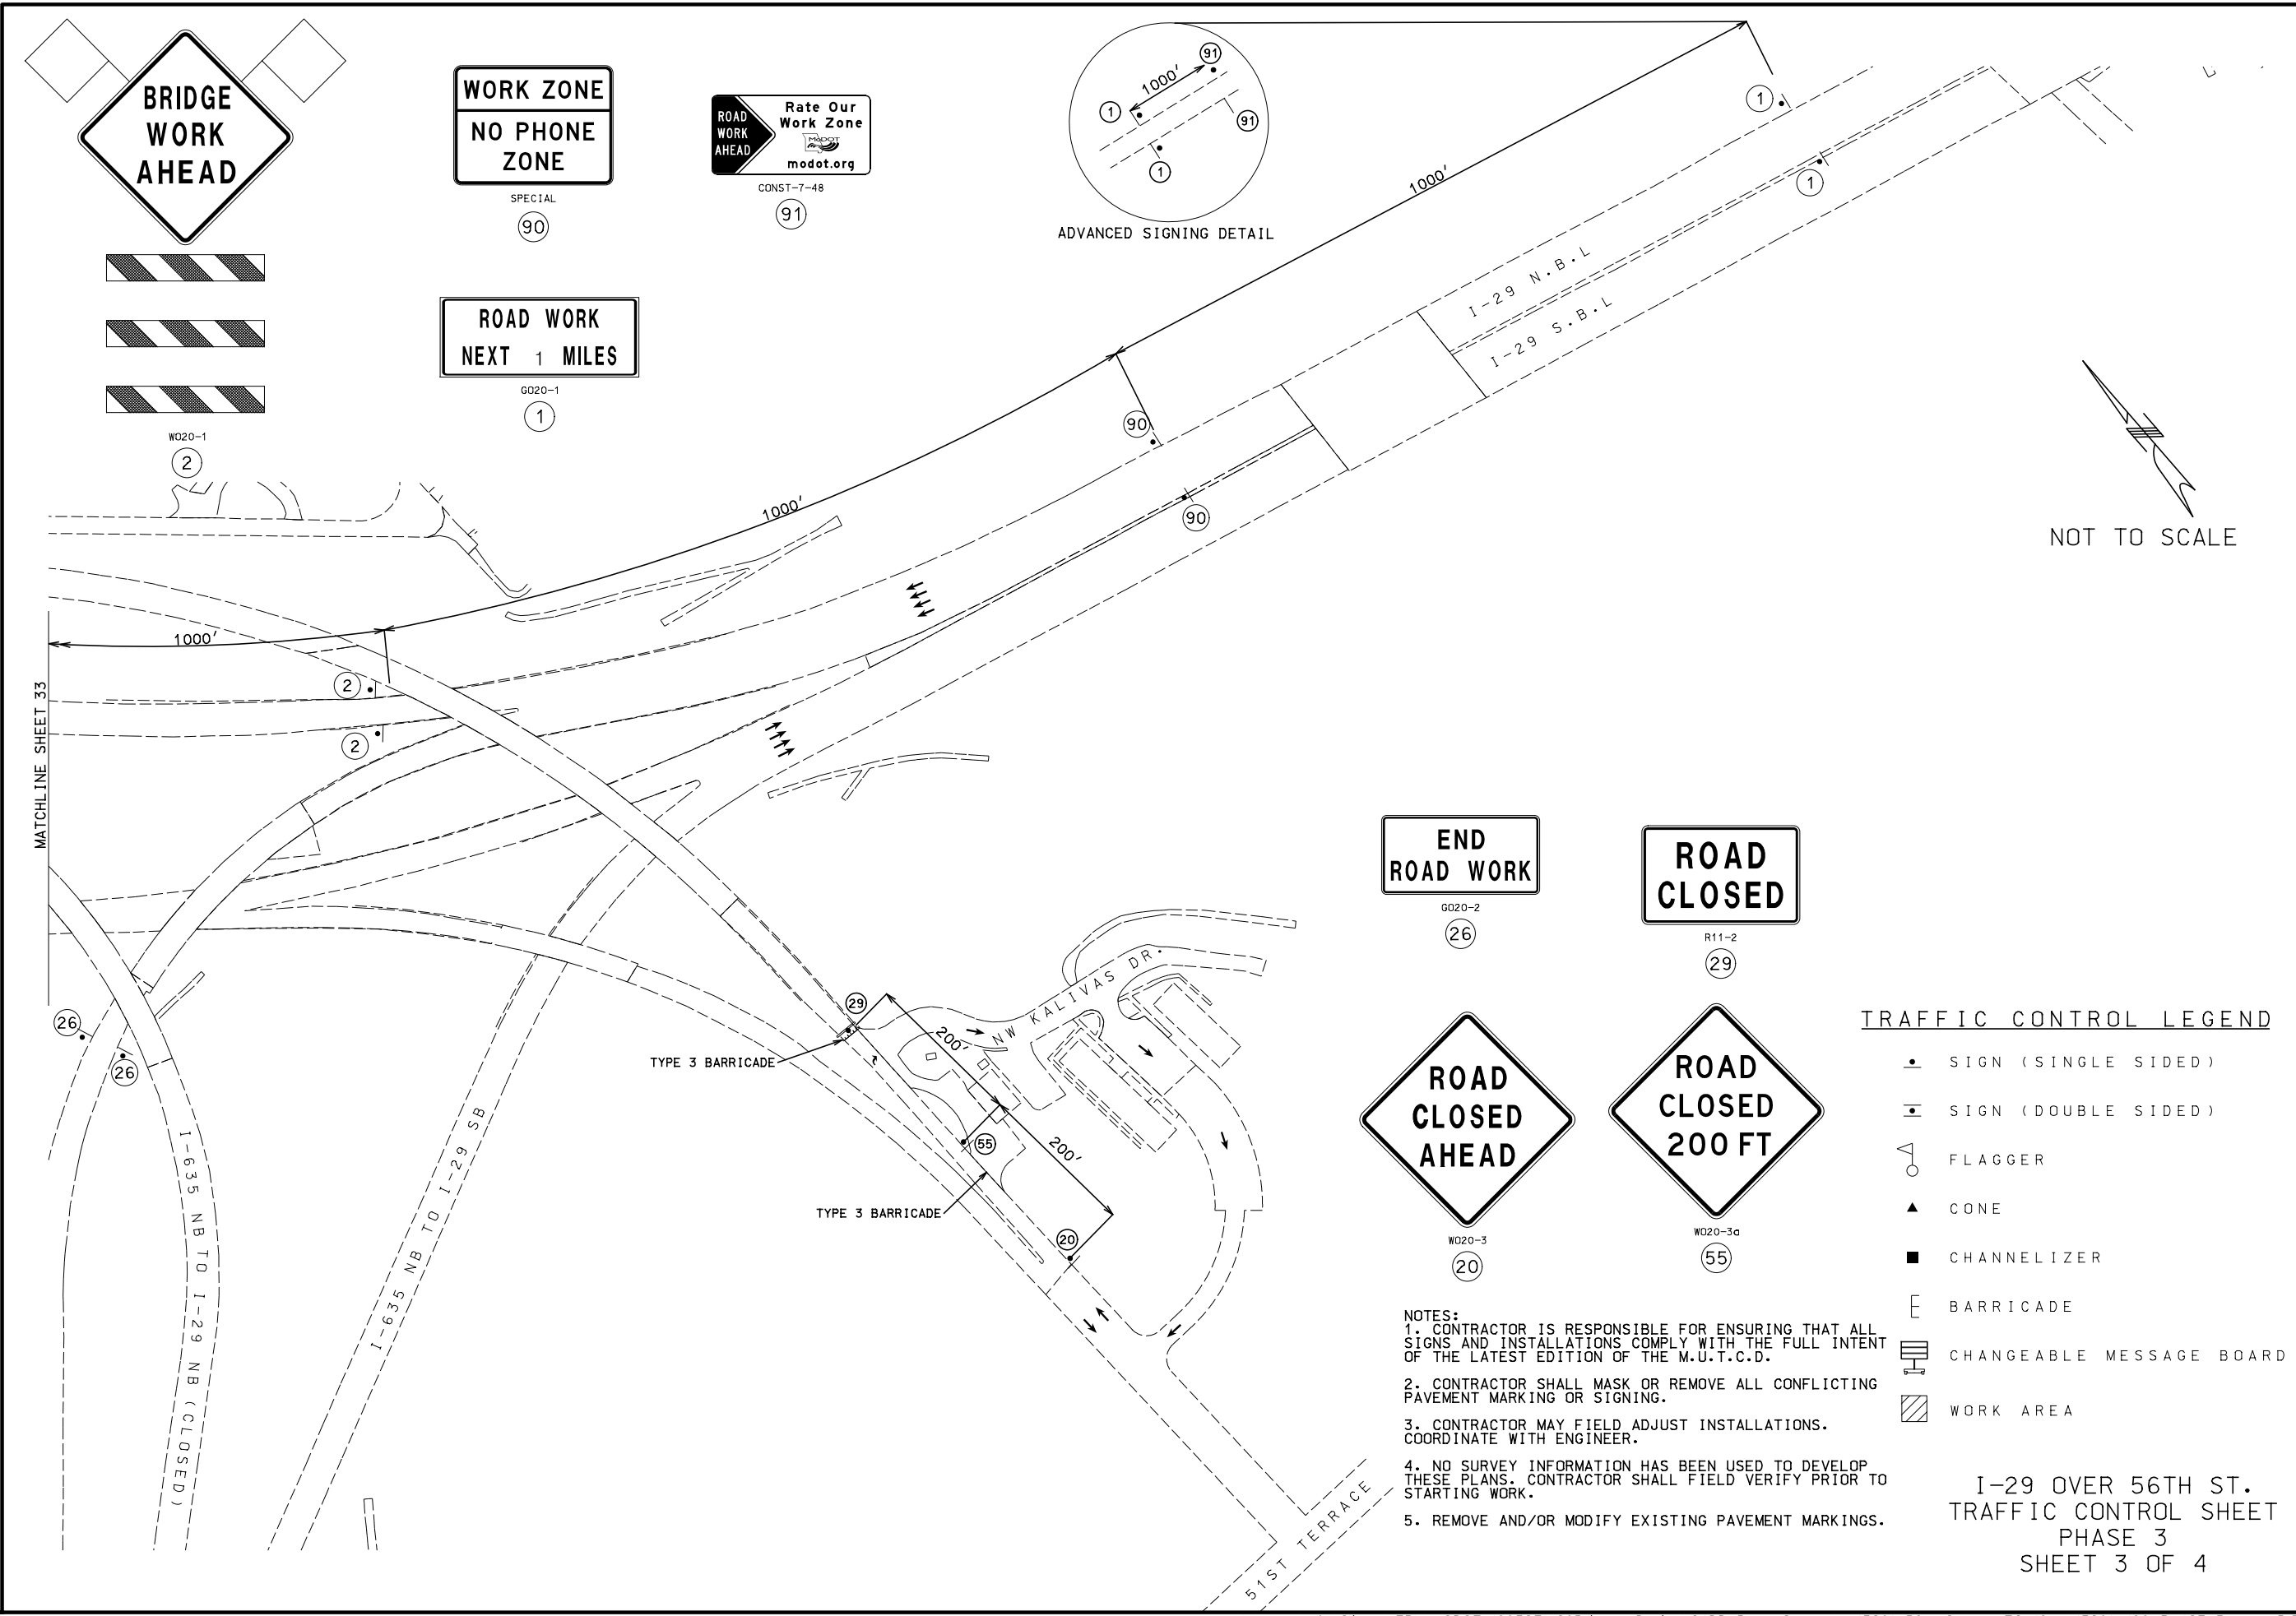

- NOTES:
1. CONTRACTOR IS RESPONSIBLE FOR ENSURING THAT ALL SIGNS AND INSTALLATIONS COMPLY WITH THE FULL INTENT OF THE LATEST EDITION OF THE M.U.T.C.D.
 2. CONTRACTOR SHALL MASK OR REMOVE ALL CONFLICTING PAVEMENT MARKING OR SIGNING.
 3. CONTRACTOR MAY FIELD ADJUST INSTALLATIONS. COORDINATE WITH ENGINEER.
 4. NO SURVEY INFORMATION HAS BEEN USED TO DEVELOP THESE PLANS. CONTRACTOR SHALL FIELD VERIFY PRIOR TO STARTING WORK.
 5. REMOVE AND/OR MODIFY EXISTING PAVEMENT MARKINGS.

TRAFFIC CONTROL LEGEND	
	SIGN (SINGLE SIDED)
	SIGN (DOUBLE SIDED)
	FLAGGER
	CONE
	CHANNELIZER
	BARRICADE
	CHANGEABLE MESSAGE BOARD
	WORK AREA

I-29 OVER 56TH ST.
TRAFFIC CONTROL SHEET
PHASE 3
SHEET 3 OF 4

"THIS MEDIA SHOULD NOT BE CONSIDERED A CERTIFIED DOCUMENT."

DATE PREPARED
7/19/2020

ROUTE I-29	STATE MO
DISTRICT K-C	SHEET NO. 38

COUNTY
PLATTE

JOB NO.
J413291

CONTRACT ID.

PROJECT NO.

BRIDGE NO.

DATE	DESCRIPTION
.	.
.	.
.	.
.	.
.	.
.	.

MISSOURI HIGHWAYS AND TRANSPORTATION COMMISSION

105 WEST CAPITOL
JEFFERSON CITY, MO 65102
1-888-ASK-MODOT (1-888-275-6636)



Burns & McDonnell Engineering Co., Inc.

9400 Ward Parkway
Kansas City, Missouri 64114
816-333-9400

Certificate of Authority
No. : 000165

BMB Project No. 109387

CONSTRUCTION AREA

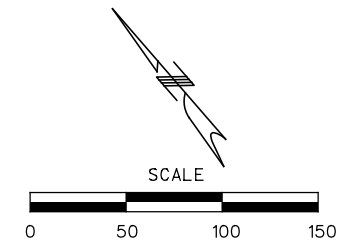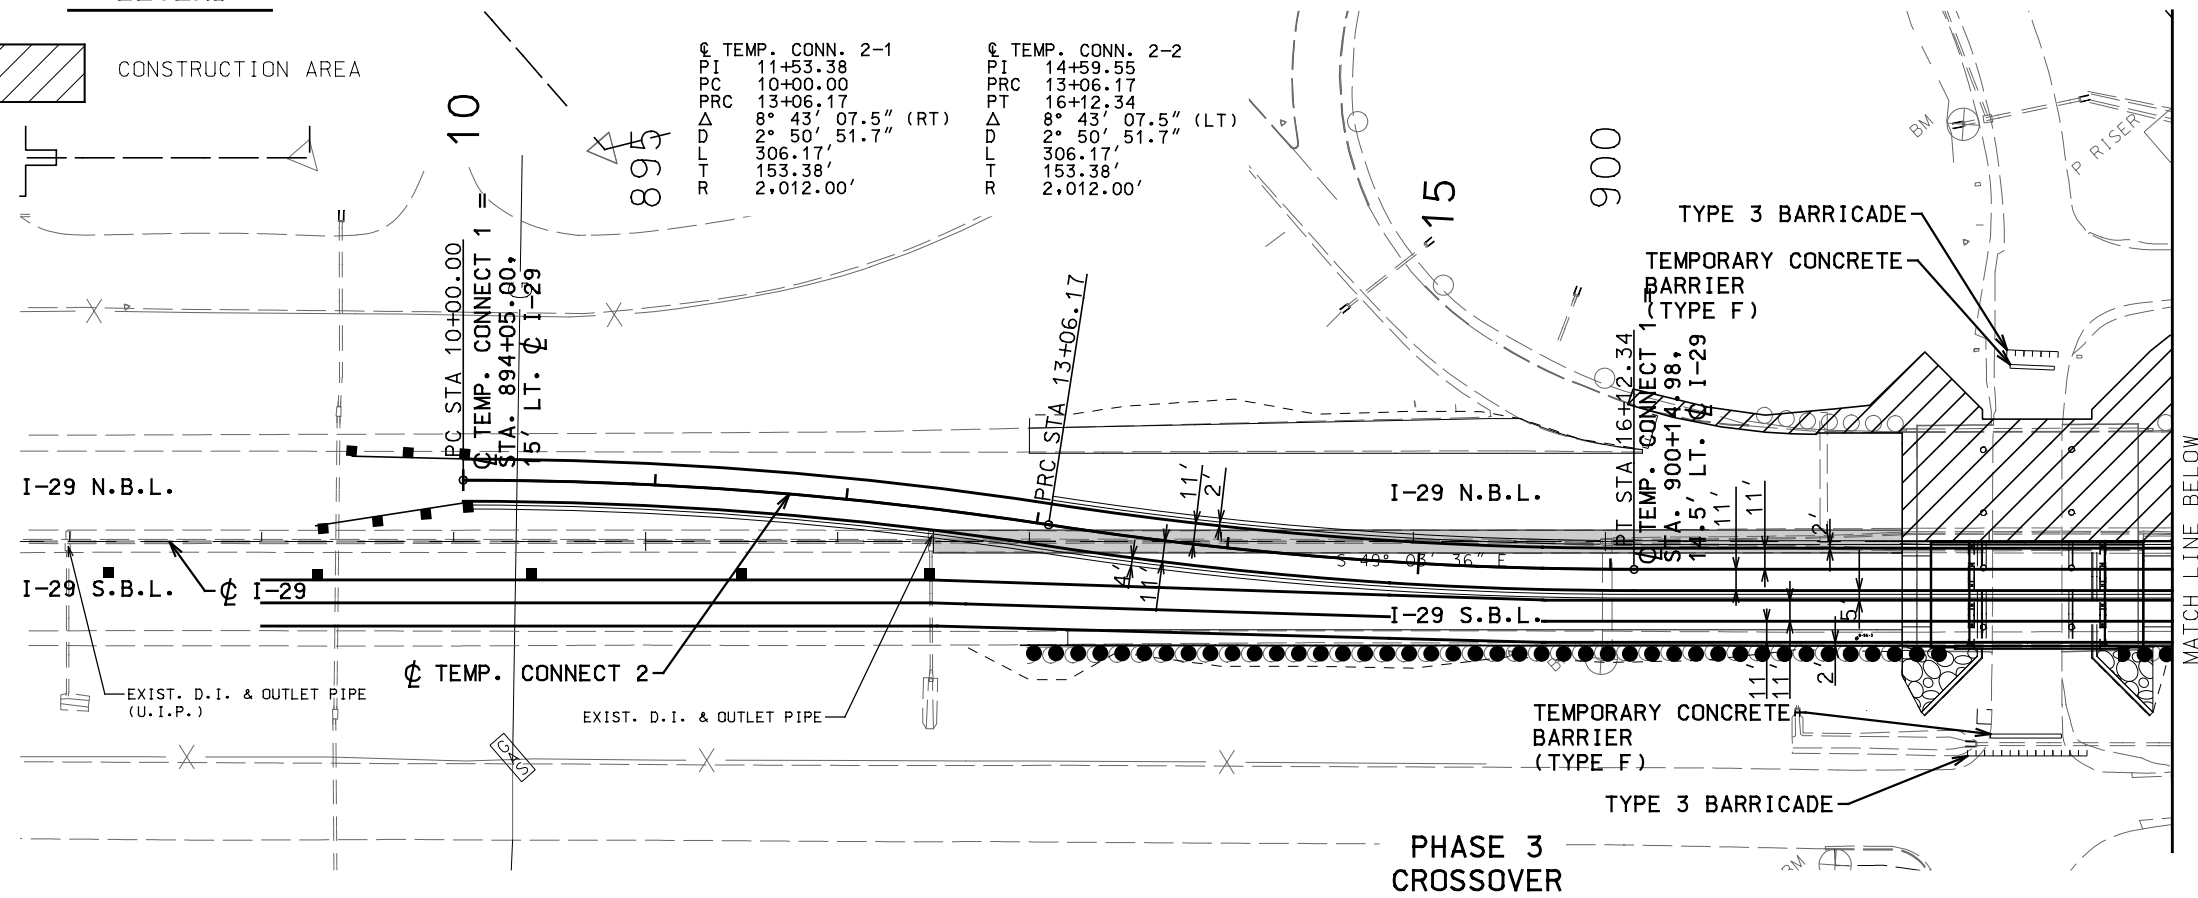

"THIS MEDIA SHOULD
NOT BE CONSIDERED
A CERTIFIED
DOCUMENT."

DATE PREPARED
7/19/2020

ROUTE I-29	STATE MO
DISTRICT K.C.	SHEET NO. 39


COUNTY
PLATTE
JOB NO.
J413291
CONTRACT ID.

PROJECT NO.

BRIDGE NO.

[illegible]

IF A SEAL IS PRESENT ON THIS SHEET IT HAS BEEN ELECTRONICALLY SEALED AND DATED.

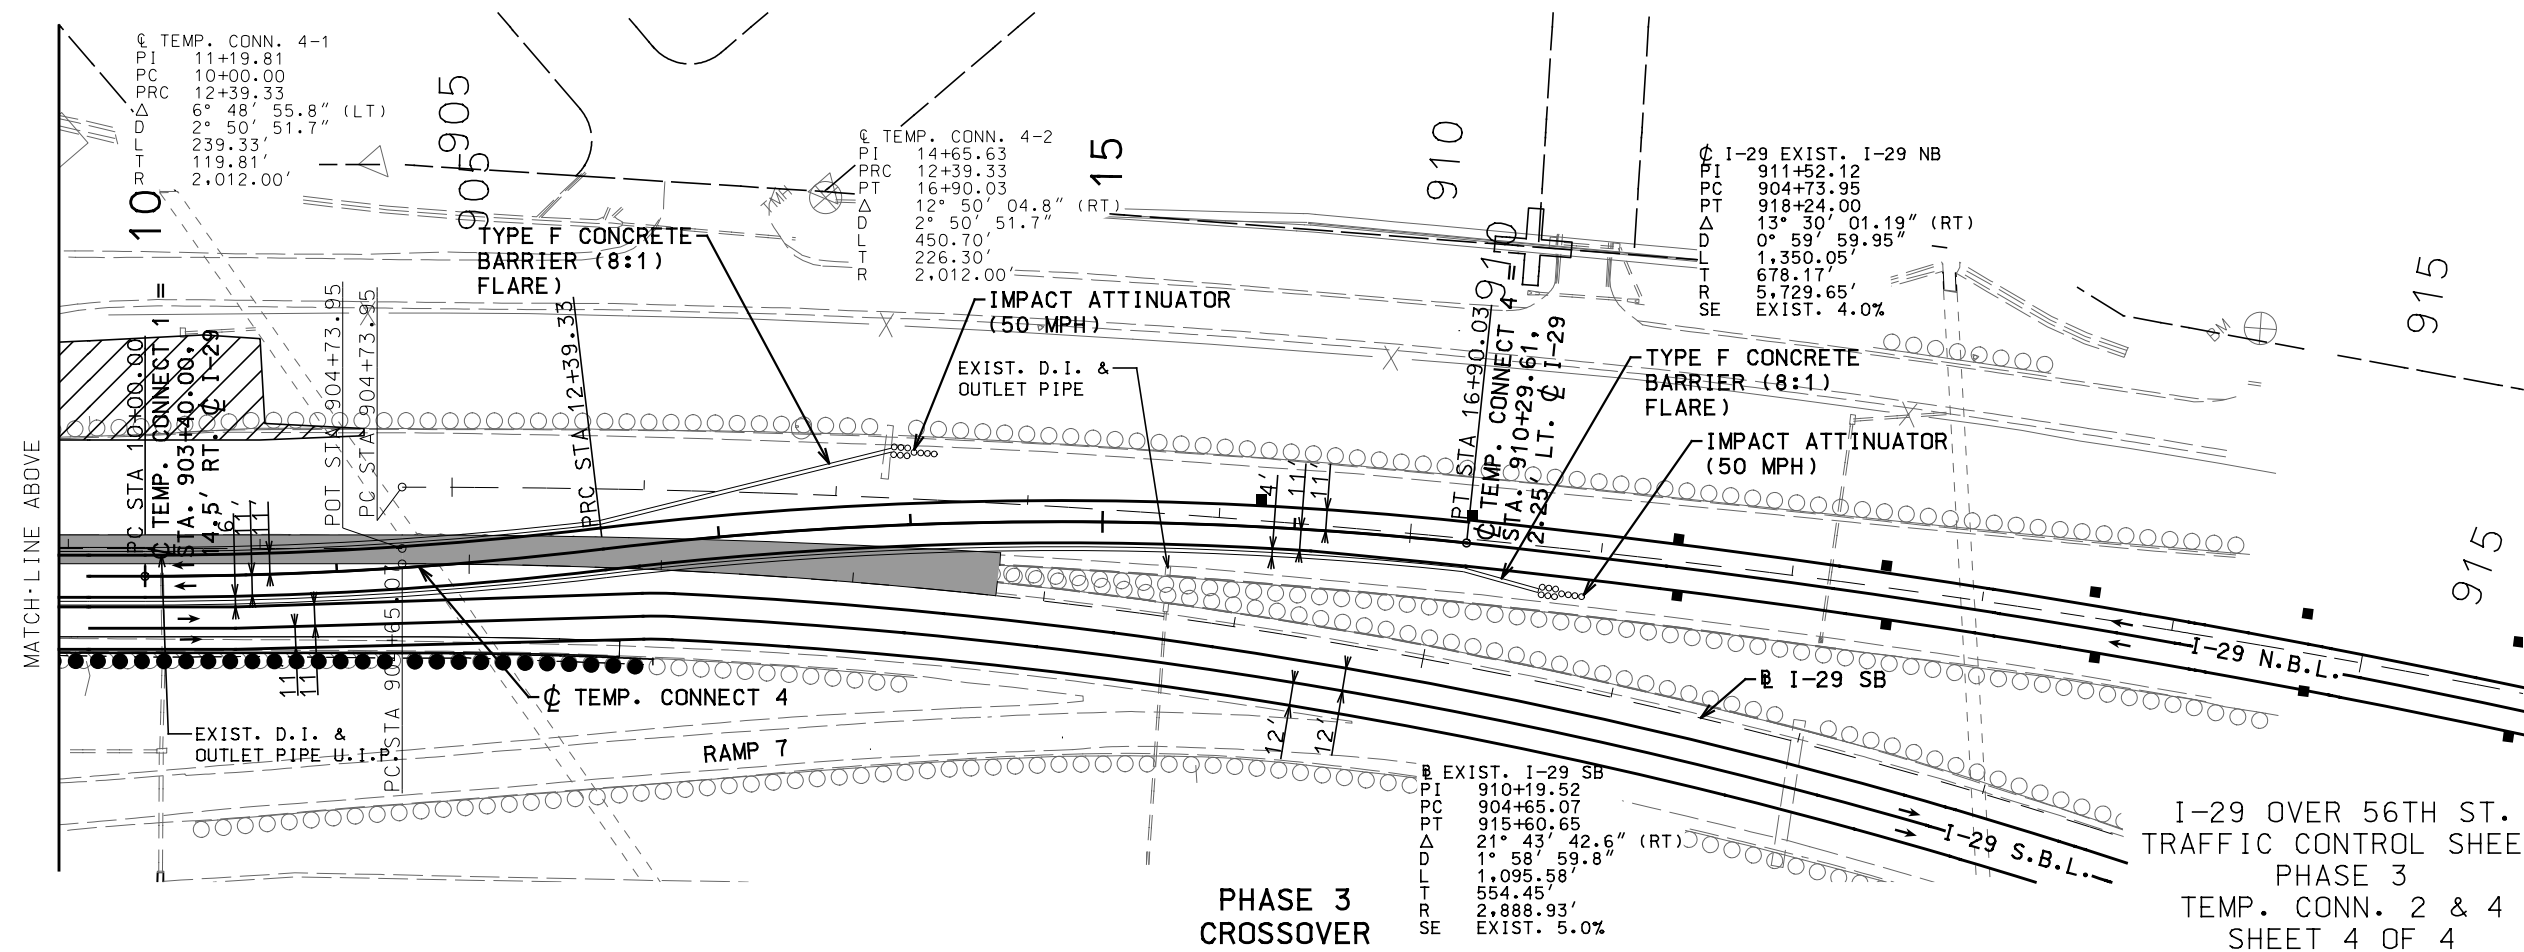


I-29 OVER 56TH ST.
TRAFFIC CONTROL SHEET
PHASE 3
TEMP. CONN. 2 & 4
SHEET 4 OF 4

Burns & McDonnell Engineering Co., Inc.

9400 Ward Parkway
Kansas City, Missouri 64114
816-333-9400

Certificate of Authority
No. : 000165


REV.

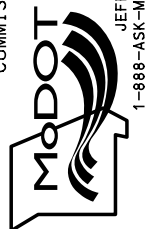MISSOURI HIGHWAYS AND TRANSPORTATION
COMMISSION

105 WEST CAPITOL
JEFFERSON CITY, MO 65102
1-888-ASK-MODOT (1-888-275-6636)

TRAFFIC CONTROL LEGEND

 - SIGN (SINGLE SIDED)
- ◐ SIGN (DOUBLE SIDED)
- 🚧 FLAGGER
- ▲ CONE
- CHANNELIZER
- [] BARRICADE
- 📄 CHANGEABLE MESSAGE BOARD
- ▨ WORK AREA



CONST-7-48
(91)



SPECIAL
(90)




G020-1
(1)



W020-5
(58)




W020-1
(2)

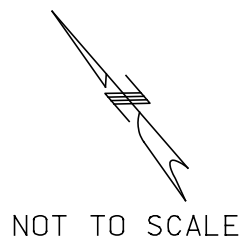

W04-1aR
(59)




W020-6a
(57)

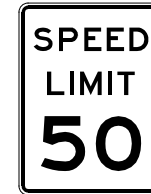

R2-1
(4)





 G020-5aP
(54)



G020-2
(26)

- NOTES:
1. CONTRACTOR IS RESPONSIBLE FOR ENSURING THAT ALL SIGNS AND INSTALLATIONS COMPLY WITH THE FULL INTENT OF THE LATEST EDITION OF THE M.U.T.C.D.
 2. CONTRACTOR SHALL MASK OR REMOVE ALL CONFLICTING PAVEMENT MARKING OR SIGNING.
 3. CONTRACTOR MAY FIELD ADJUST INSTALLATIONS. COORDINATE WITH ENGINEER.
 4. NO SURVEY INFORMATION HAS BEEN USED TO DEVELOP THESE PLANS. CONTRACTOR SHALL FIELD VERIFY PRIOR TO STARTING WORK.
 5. REMOVE AND/OR MODIFY EXISTING PAVEMENT MARKINGS.

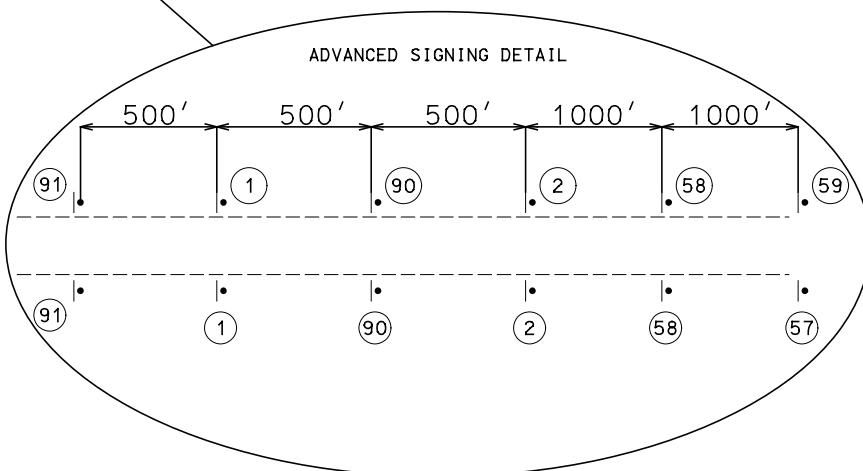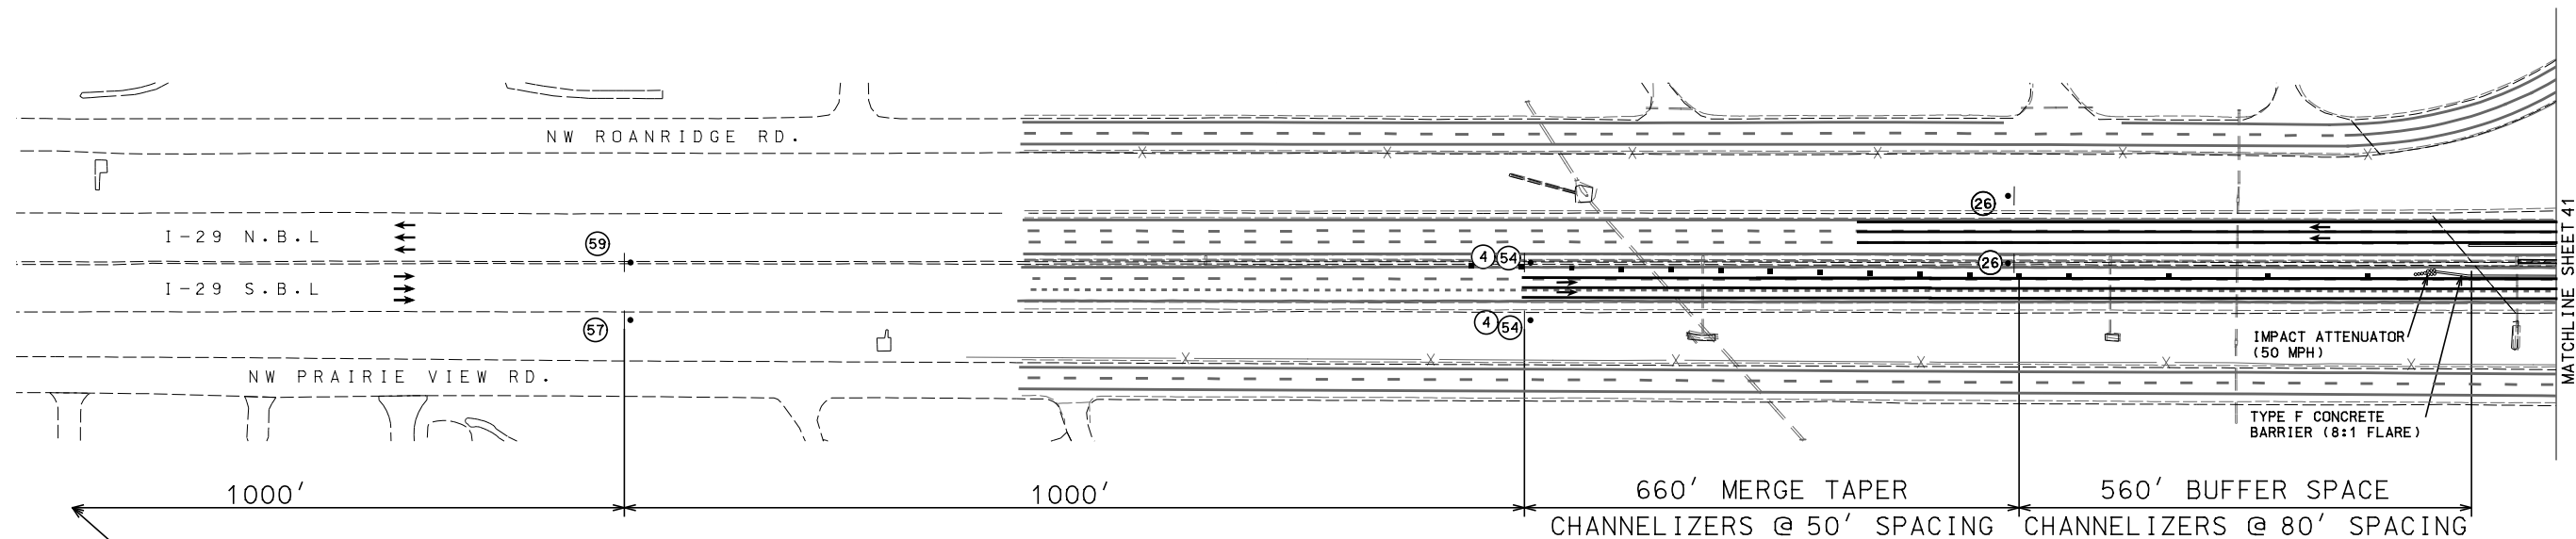

I-29 OVER 56TH ST.
TRAFFIC CONTROL SHEET
PHASE 4
SHEET 1 OF 3

"THIS MEDIA SHOULD
NOT BE CONSIDERED
A CERTIFIED
DOCUMENT."


DATE PREPARED
7/19/2020
ROUTE
I-29
STATE
MO
DISTRICT
K-C
SHEET NO.
40
COUNTY
PLATTE
JOB NO.
J413291
CONTRACT ID.
PROJECT NO.
BRIDGE NO.

DATE	DESCRIPTION

MISSOURI HIGHWAYS AND TRANSPORTATION
COMMISSION
105 WEST CAPITOL
JEFFERSON CITY, MO 65102
1-888-ASK-MODOT (1-888-275-6636)

Burns & McDonnell Engineering Co., Inc.
9400 Ward Parkway
Kansas City, Missouri 64114
816-333-9400
Certificate of Authority
No. : 000165
BMOB Project No. 109387



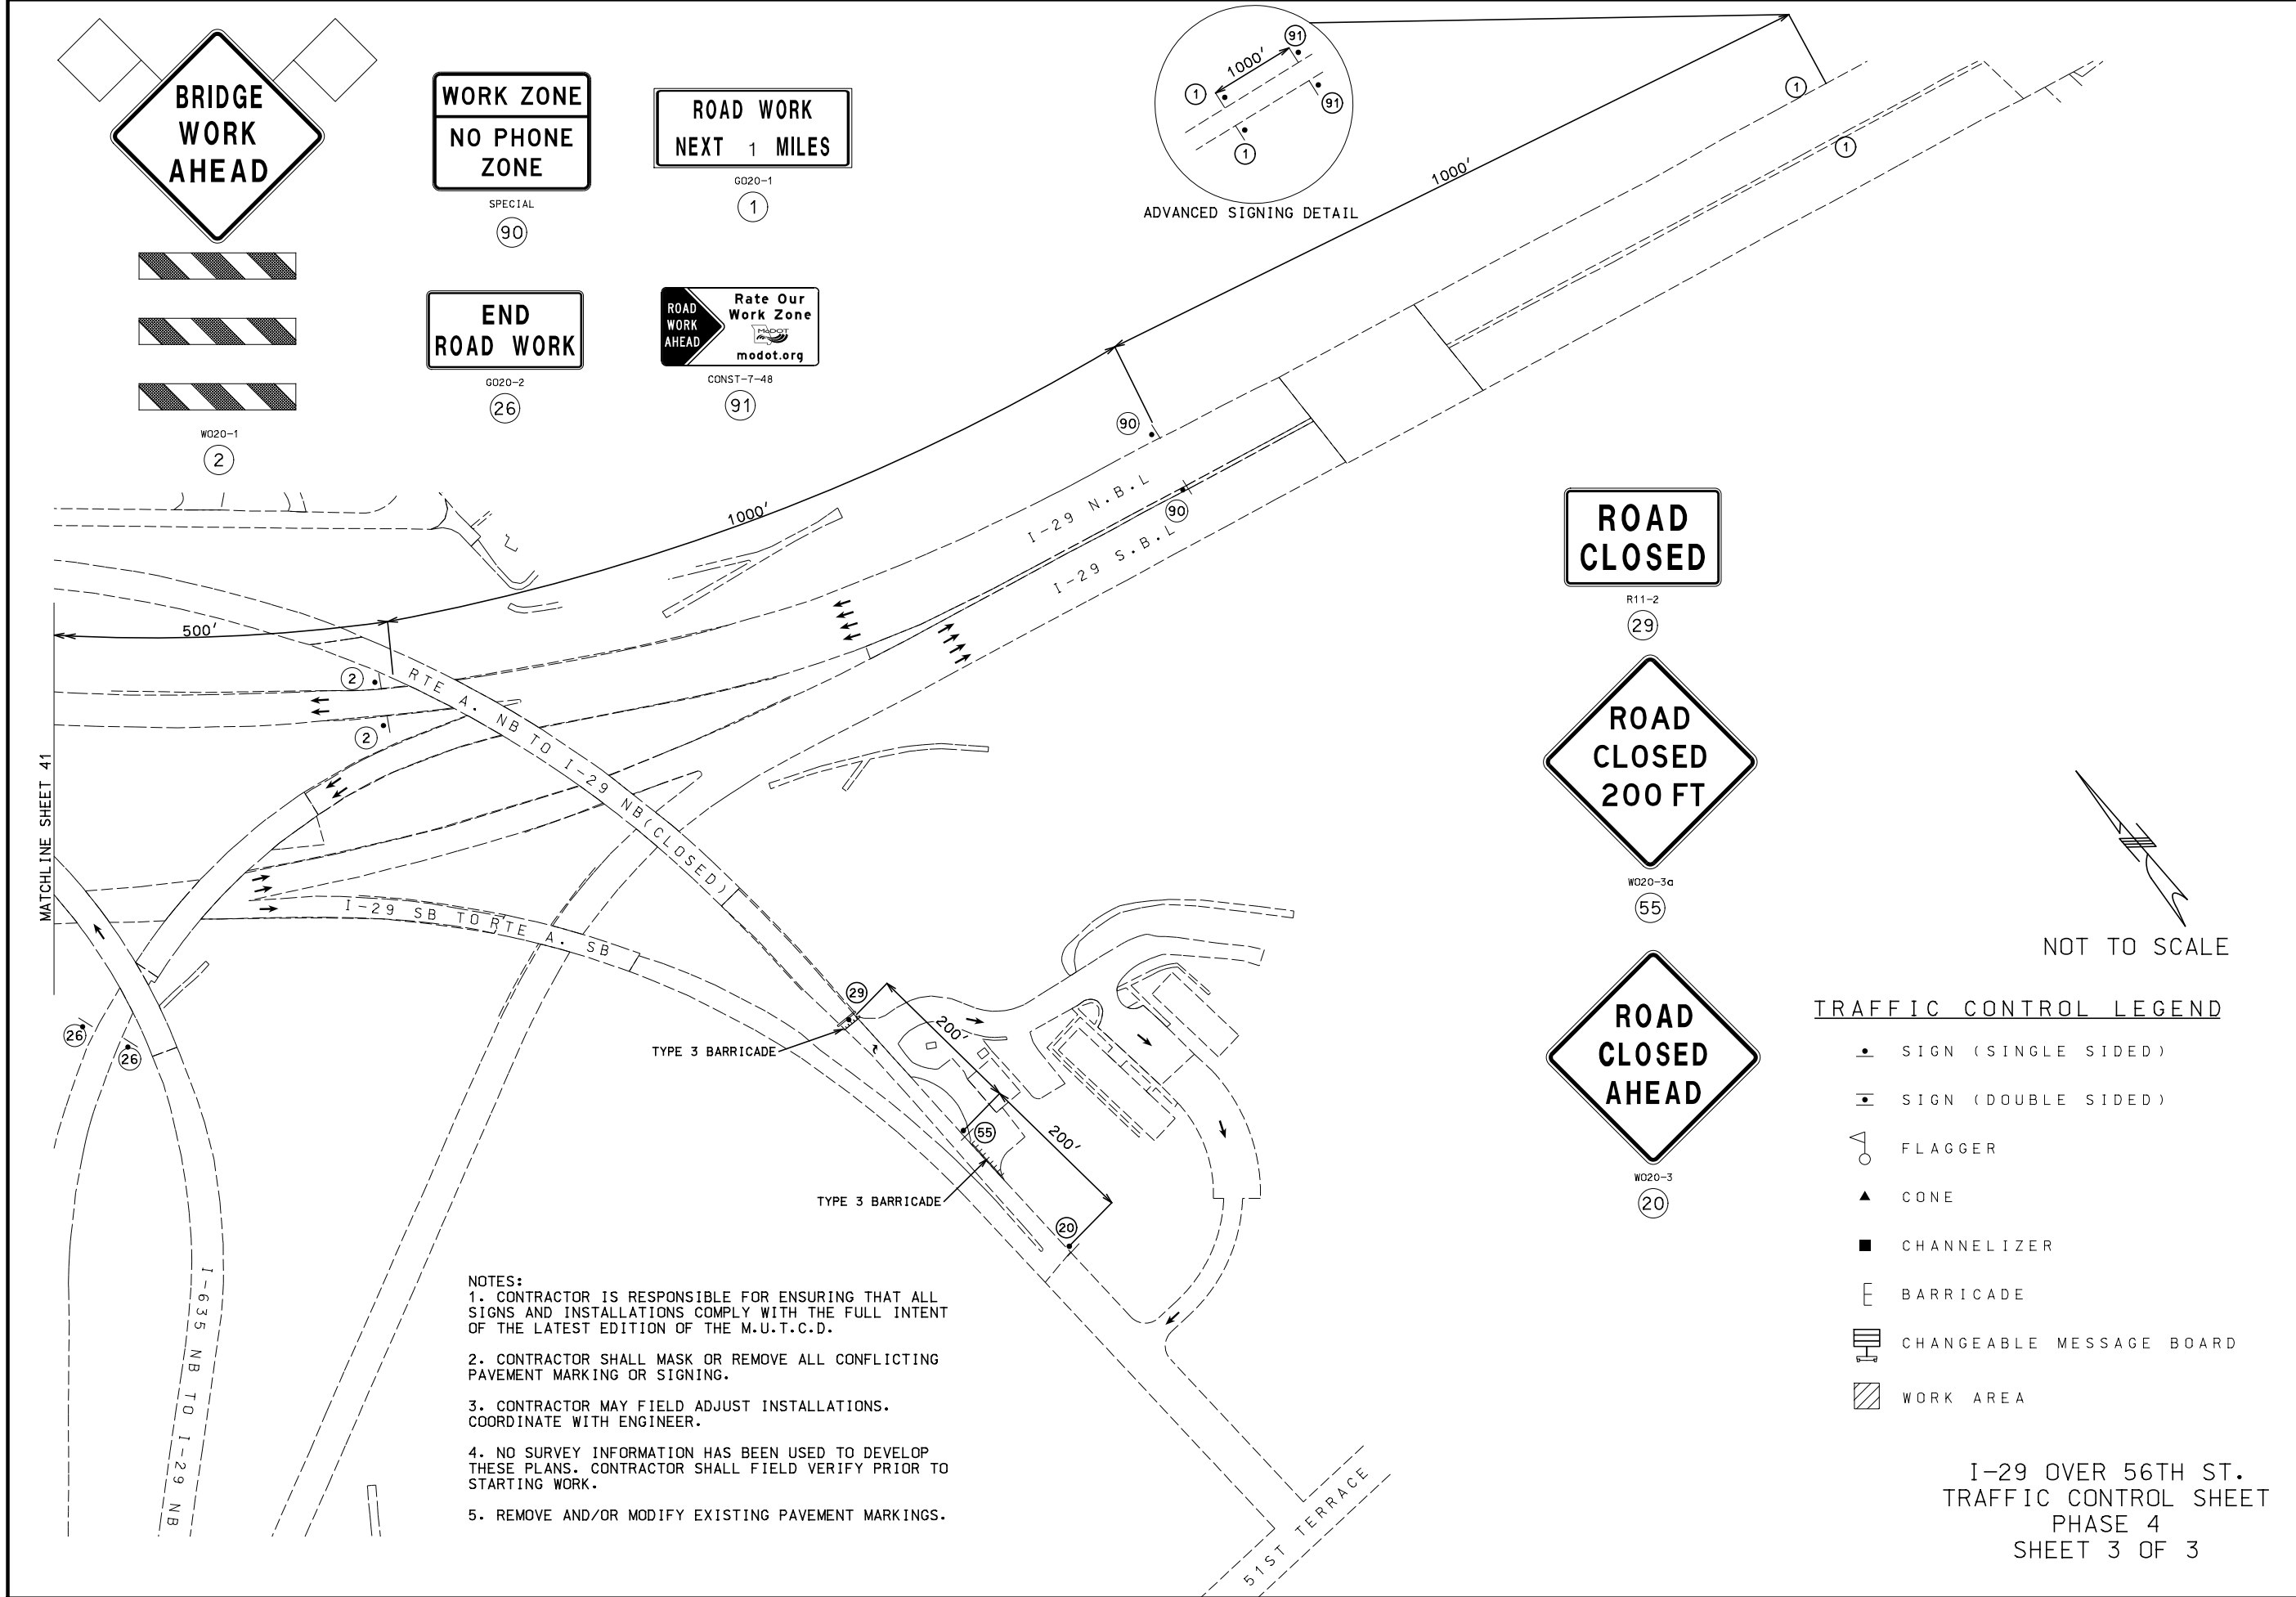

- NOTES:
1. CONTRACTOR IS RESPONSIBLE FOR ENSURING THAT ALL SIGNS AND INSTALLATIONS COMPLY WITH THE FULL INTENT OF THE LATEST EDITION OF THE M.U.T.C.D.
 2. CONTRACTOR SHALL MASK OR REMOVE ALL CONFLICTING PAVEMENT MARKING OR SIGNING.
 3. CONTRACTOR MAY FIELD ADJUST INSTALLATIONS. COORDINATE WITH ENGINEER.
 4. NO SURVEY INFORMATION HAS BEEN USED TO DEVELOP THESE PLANS. CONTRACTOR SHALL FIELD VERIFY PRIOR TO STARTING WORK.
 5. REMOVE AND/OR MODIFY EXISTING PAVEMENT MARKINGS.

- TRAFFIC CONTROL LEGEND
- SIGN (SINGLE SIDED)
 - SIGN (DOUBLE SIDED)
 - ◁ FLAGGER
 - ▲ CONE
 - CHANNELIZER
 - E BARRICADE
 - ▨ CHANGEABLE MESSAGE BOARD
 - ▨ WORK AREA

I-29 OVER 56TH ST.
TRAFFIC CONTROL SHEET
PHASE 4
SHEET 3 OF 3

"THIS MEDIA SHOULD NOT BE CONSIDERED A CERTIFIED DOCUMENT."

DATE PREPARED
7/19/2020

ROUTE I-29	STATE MO
DISTRICT K-C	SHEET NO. 42

COUNTY
PLATTE

JOB NO.
J413291

CONTRACT ID.
.

PROJECT NO.
.

BRIDGE NO.
.

DESCRIPTION	DATE
.	.
.	.
.	.
.	.
.	.
.	.

MISSOURI HIGHWAYS AND TRANSPORTATION COMMISSION

MoDOT

105 WEST CAPITOL
JEFFERSON CITY, MO 65102
1-888-ASK-MODOT (1-888-275-6636)

Burns & McDonnell Engineering Co., Inc.

9400 Ward Parkway
Kansas City, Missouri 64114
816-333-9400

Certificate of Authority
No. : 000165

BMd Project No. 109387

TAPER LENGTHS AND SPACING OF CHANNELIZING DEVICES						
POSTED SPEED PRIOR TO CONSTRUCTION, MPH (P)	MINIMUM TAPER LENGTHS (L) FOR LATERAL SHIFTS (W)			SHOULDER TAPER (T1)	MAX. CHANNELIZER SPACING THROUGH TAPER (X)	MAX. CHANNELIZER SPACING THROUGH WORK AREA (Y)
	10 FT	11 FT	12 FT			
0 TO 35	205 FT	225 FT	245 FT	70 FT	35'	40'
40 TO 45	450 FT	495 FT	540 FT	150 FT	40'	80'
50 TO 55	550 FT	605 FT	660 FT	185 FT	50'	80'
60 TO 70	700 FT	770 FT	840 FT	235 FT	60'	120'

L = W x P FOR 40 MPH OR MORE
L = $\frac{W^2}{60}$ FOR 35 MPH OR LESS
L = TAPER LENGTH IN FEET
W = LATERAL SHIFT IN FEET

SIGN SPACING FOR ADVANCE SIGN SERIES (1) (2)		
POSTED SPEED PRIOR TO CONSTRUCTION, MPH (P)	UNDIVIDED HIGHWAY LENGTH (S), (FT.)	DIVIDED HIGHWAY LENGTH (S), (FT.)
0 TO 35	200' (3)	200' (3)
40 TO 45	350'	500'
50 TO 55	500'	1000'
60 TO 70	1000'	SA - 1000 FT, SB - 1500 FT, SC - 2640 FT

DIMENSIONS IN FEET
(1) SPACING BETWEEN SIGNS, BEGINNING OF TAPER OR SIGNED CONDITION.
(2) SPACING MAY BE ADJUSTED TO MEET FIELD CONDITIONS.
(3) FOR URBAN LOW SPEED, MINIMUM RECOMMENDED SPACING IN MUTCD IS 100 FT.

BUFFER SPACE	
POSTED SPEED PRIOR TO CONSTRUCTION, MPH (P)	RECOMMENDED LENGTH OF LONGITUDINAL BUFFER
0 TO 35	280 FT
40 TO 45	400 FT
50 TO 55	560 FT
60 TO 70	840 FT

TRAFFIC CONTROL GENERAL NOTES:

- TEMPORARY TRAFFIC CONTROL SIGN AND DEVICE LOCATIONS SHALL BE APPROVED BY THE ENGINEER.
- ALL EXISTING SIGNS THAT CONFLICT WITH THE PROPOSED TRAFFIC CONTROL PLAN SHALL BE COVERED. NO DIRECT PAY.
- NO DIRECT PAY FOR RELOCATION OF SIGNS AND DEVICES FOR TEMPORARY TRAFFIC CONTROL.
- ALL TEMPORARY TRAFFIC CONTROL ITEMS NOT INCLUDED IN THE PAY ITEMS SHALL BE CONSIDERED INCIDENTAL.
- CONTRACTOR SHALL MAINTAIN ACCESS TO ALL ENTRANCES AT ALL TIMES.
- DURING FLAGGING OPERATIONS, FLAGGERS SHALL BE USED WHEN WORKERS ARE PRESENT.
- FOR PAVEMENT DROP OFF, REFER TO STANDARD PLAN 619.10 FOR NECESSARY EDGE TREATMENT.
- CHANGEABLE MESSAGE BOARDS SHALL BE CONTRACTOR FURNISHED/CONTRACTOR RETAINED.

PHASE	TYPE	DESCRIPTION
PHASE 5A	NW ROANRIDGE RD RECONSTRUCTION	RECONSTRUCTION OF THE WEST HALF OF THE INTERSECTION OF NW 56TH ST AND NW ROANRIDGE RD.
PHASE 5B	NW ROANRIDGE RD RECONSTRUCTION	RECONSTRUCTION OF THE EAST HALF OF THE INTERSECTION OF NW 56TH ST AND NW ROANRIDGE RD.
PHASE 5C	NW PRAIRIE VIEW RD AND I-29 SB RAMP RECONSTRUCTION	RECONSTRUCTION OF THE INTERSECTION OF NW 56TH ST, NW PRAIRIE VIEW RD AND I-29 SB RAMP.

56TH ST.
TRAFFIC CONTROL SHEET
PHASE 5
SHEET 1 OF 7

DATE PREPARED
6/26/2020

ROUTE
I-29

DISTRICT
KC

STATE
MO

SHEET NO.
43

COUNTY
PLATTE

JOB NO.
J413291

CONTRACT ID.

PROJECT NO.

BRIDGE NO.

DESCRIPTION

DATE

MISSOURI HIGHWAYS AND TRANSPORTATION
COMMISSION

105 WEST CAPITAL
JEFFERSON CITY, MO 65102
1-888-ASK-MODOT (1-888-275-6636)

MoDOT

1411 East 104th St.
Kansas City, MO 64131
Tel (816) 974-4655
Fax (816) 974-4675
www.trekdesigngroup.com


Missouri Cert. of
Authority 202010300

TREK

DESIGN GROUP, LLC

IF A SEAL IS PRESENT ON THIS SHEET IT HAS BEEN ELECTRONICALLY SEALED AND DATED.

037_TC_03_J413291-I1_56THST_PHS5.dgn 1:56:34 PM 6/26/2020

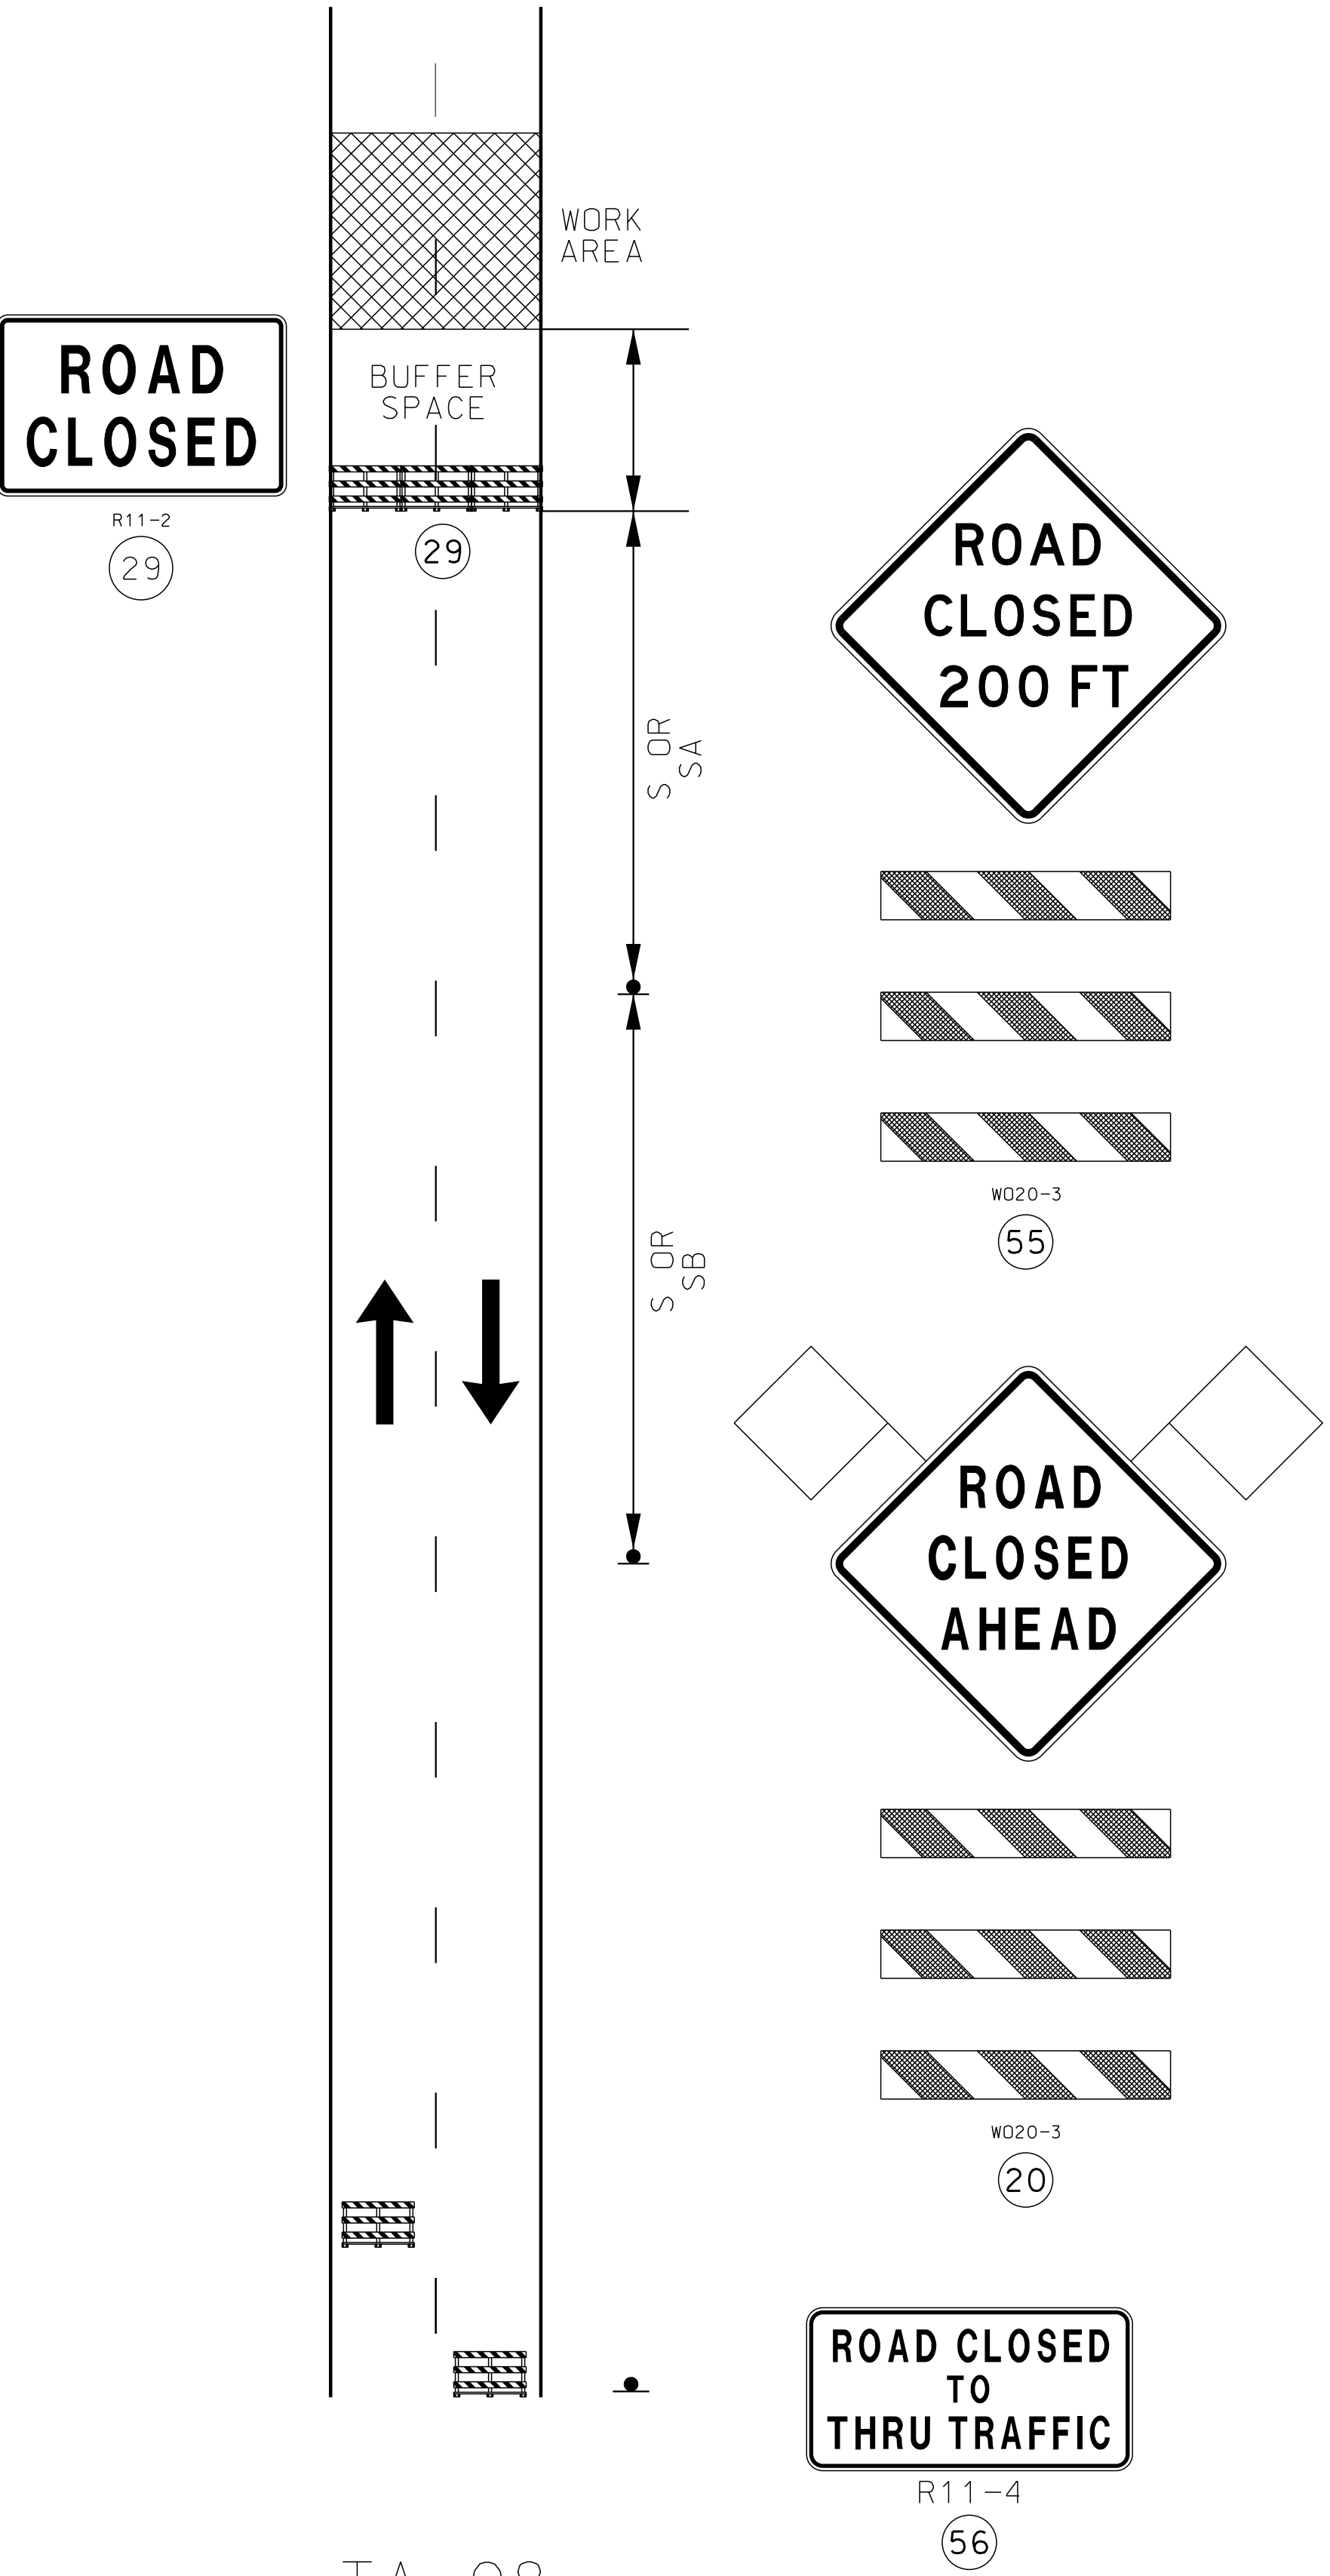

NOTES:


SEE TRAFFIC CONTROL SHEET 43 FOR WORK ZONE SPEED LIMIT GUIDELINES.

SEE TRAFFIC CONTROL SHEET 43 FOR SIGN SPACING, DEVICE SPACING AND CHANNELIZING TAPER LENGTHS.


WHEN A SIDE ROAD INTERSECTS THE HIGHWAY WITHIN THE TTC ZONE ADDITIONAL TTC DEVICES SHALL BE PLACED AS NEEDED.

“ROAD CLOSED” SIGN MAY BE PLACED 7-10 FEET BEHIND THE BARRICADES AND AT A SIGN HEIGHT APPROPRIATE TO THE TYPE OF ROADWAY. ONE BARRICADE SHOULD BE REQUIRED TO COMPLETELY CLOSE EACH 8-FEET OF PAVEMENT. PAVED SHOULDERS SHALL BE INCLUDED IN THE AREA TO BE CLOSED.

IF USED, THE “ROAD CLOSED XX MILES AHEAD LOCAL TRAFFIC ONLY” OR “ROAD CLOSED TO THRU TRAFFIC” SIGN SHOULD BE LOCATED AT THE FIRST STATE ROUTE OR, UPON THE DISCRETION OF THE ENGINEER, ANY OTHER INTERSECTION IN ADVANCE OF THE CLOSURE. ADDITIONAL BARRICADES MAY BE USED AND OFFSETTED TO FACILITATE ACCESS FOR WORK VEHICLES, LOCAL TRAFFIC, ETC.

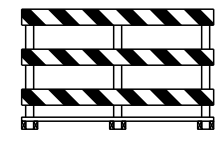


BARRICADE

 

FOR FLAGS AND ADVANCE WARNING RAIL SYSTEMS,



 REFER TO EPG 616.6.2.2



FLAGS AND ADVANCED WARNING RAIL SYSTEM

DATE PREPARED
6/26/2020

ROUTE
I-29

DISTRICT
KC

STATE
MO

SHEET NO.
44

COUNTY
PLATTE

JOB NO.
J413291


CONTRACT ID.

PROJECT NO.

BRIDGE NO.

DESCRIPTION	DATE


MISSOURI HIGHWAYS AND TRANSPORTATION COMMISSION

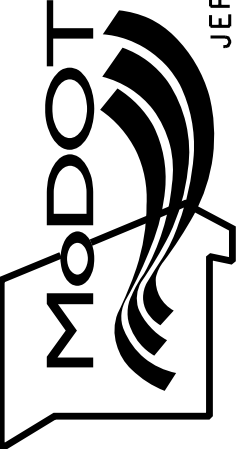

105 WEST CAPITOL
JEFFERSON CITY, MO 65102
1-888-ASK-MODOT (1-888-275-6636)

1411 East 104th St.
Kansas City, MO 64131
Tel (816) 974-4655
Fax (816) 974-4675
www.trekdesigngroup.com

Missouri Cert. of
Authority 202010300

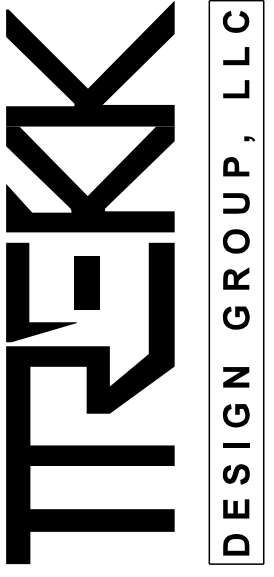

I-29 OVER 56TH ST.
TRAFFIC CONTROL SHEET
PHASE 5
SHEET 2 OF 7



038_TC_04_J413291_I1_56THST_TA-08.dgn 1:56:34 PM 6/26/2020

IF A SEAL IS PRESENT ON THIS SHEET IT HAS BEEN ELECTRONICALLY SEALED AND DATED.

USED WHEN NO WORK
ZONE SPEED LIMIT
IS ESTABLISHED



W03-4
(11)

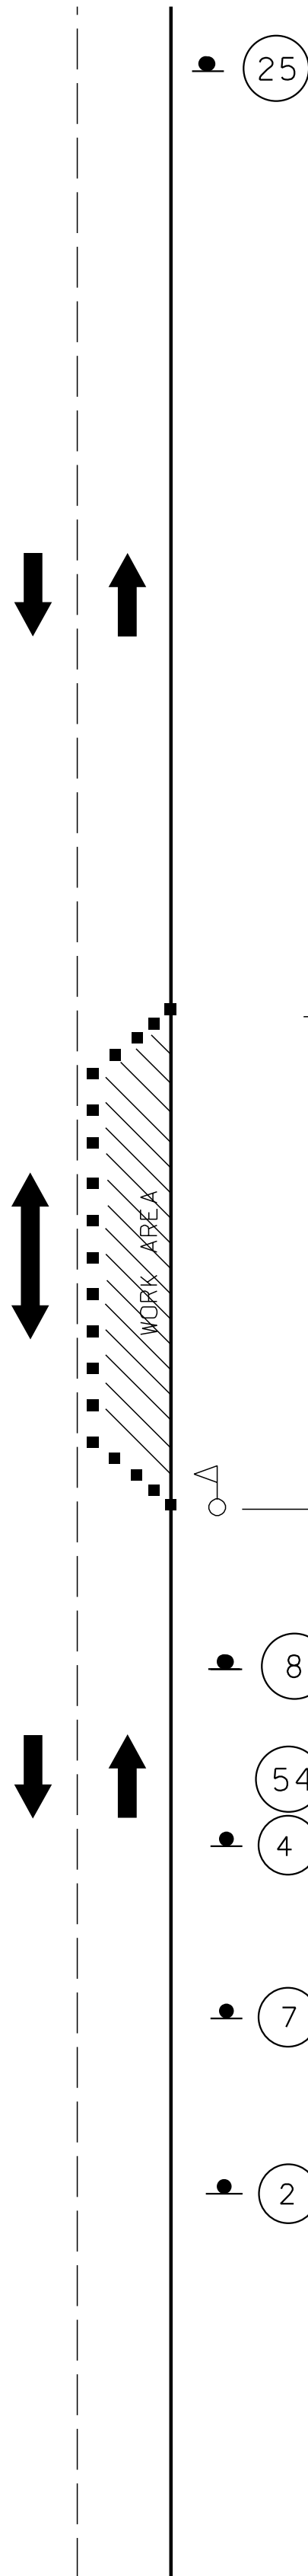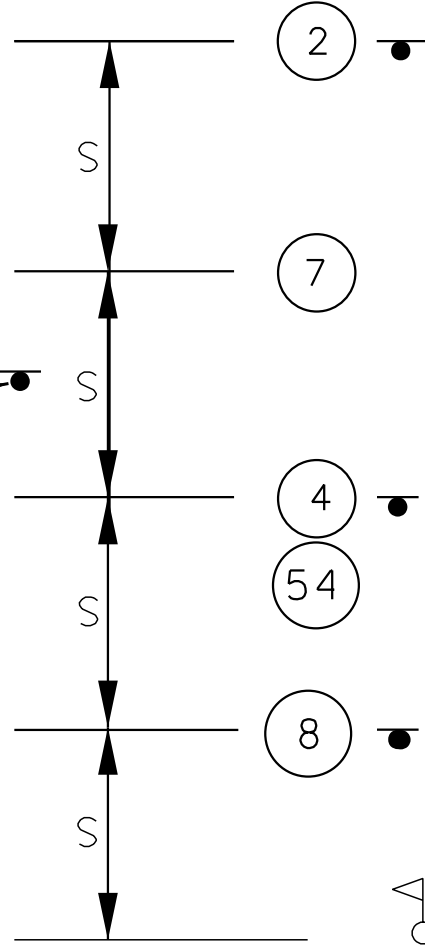

TA-10
LANE CLOSURE
ON TWO-LANE
ROAD USING FLAGGERS

BRIDGE
OR
RAMP
W025-6

ROAD
WORK
AHEAD

W020-1
(2)



R2-1
(4)




R2-1
NORMAL SPEED
(25)



W020-4
(7)



G020-5aP
(54)

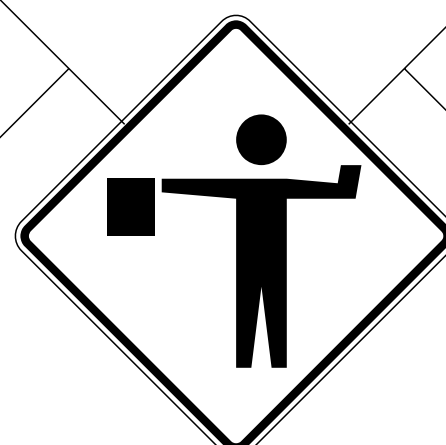

W020-7a
(8)

- FLAGGER



CHANNELIZERS

NOTES: SEE TRAFFIC CONTROL SHEET 43 FOR WORK ZONE SPEED LIMIT GUIDELINES.

SEE TRAFFIC CONTROL SHEET 43 FOR SIGN SPACING, DEVICE SPACING AND CHANNELIZING TAPER LENGTHS.

AUTOMATED FLAGGER ASSISTANCE DEVICES (AFAD) AND PORTABLE SIGNAL FLAGGING DEVICES (PSFD) MAY BE USED AS AN ALTERNATIVE FLAGGING OPERATION.

AFAD AND PSFD TYPICAL APPLICATIONS AND CRITERIA ARE LOCATED AT THE FOLLOWING:
EPG 616.8.10A (TA-10A) LANE CLOSURE ON TWO-LANE HIGHWAYS USING AUTOMATED FLAGGER ASSISTANCE DEVICE WITH RED AND AMBER SIGNAL SYSTEM & EPG 616.8.10 (TA-10C) LANE CLOSURE ON TWO-LANE HIGHWAYS USING PORTABLE SIGNAL FLAGGING DEVICE.

IF RUMBLE STRIPS ARE USED, REVIEW 616.6.87 RUMBLE STRIPS.

IF USED AT NIGHT, THE FLAGGER STATIONS SHALL BE ILLUMINATED WITH AN AVERAGE MAINTAINED INTENSITY OF 0.6 FOOT CANDLES (6.5 LUX).

 


W03-4
(11)


USED WHEN NO WORK
ZONE SPEED LIMIT
IS ESTABLISHED



FOR FLAGS AND ADVANCE
WARNING RAIL SYSTEMS,
REFER TO EPG 616.6.2.2
FLAGS AND ADVANCED
WARNING RAIL SYSTEM



DATE PREPARED 6/26/2020	
ROUTE I-29	STATE MO
DISTRICT KC	SHEET NO. 45
COUNTY PLATTE	
JOB NO. J413291	
CONTRACT ID.	
PROJECT NO.	
BRIDGE NO.	
DESCRIPTION	
DATE	
MISSOURI HIGHWAYS AND TRANSPORTATION COMMISSION	
105 WEST CAPITAL JEFFERSON CITY, MO 65102 1-888-ASK-MODOT (1-888-275-6636)	
1411 East 104th St. Kansas City, MO 64131 Tel (816) 974-4655 Fax (816) 974-4675 www.trekdesigngroup.com	
Missouri Dept. of Transportation Authority 20201030	
TREK DESIGN GROUP, LLC	

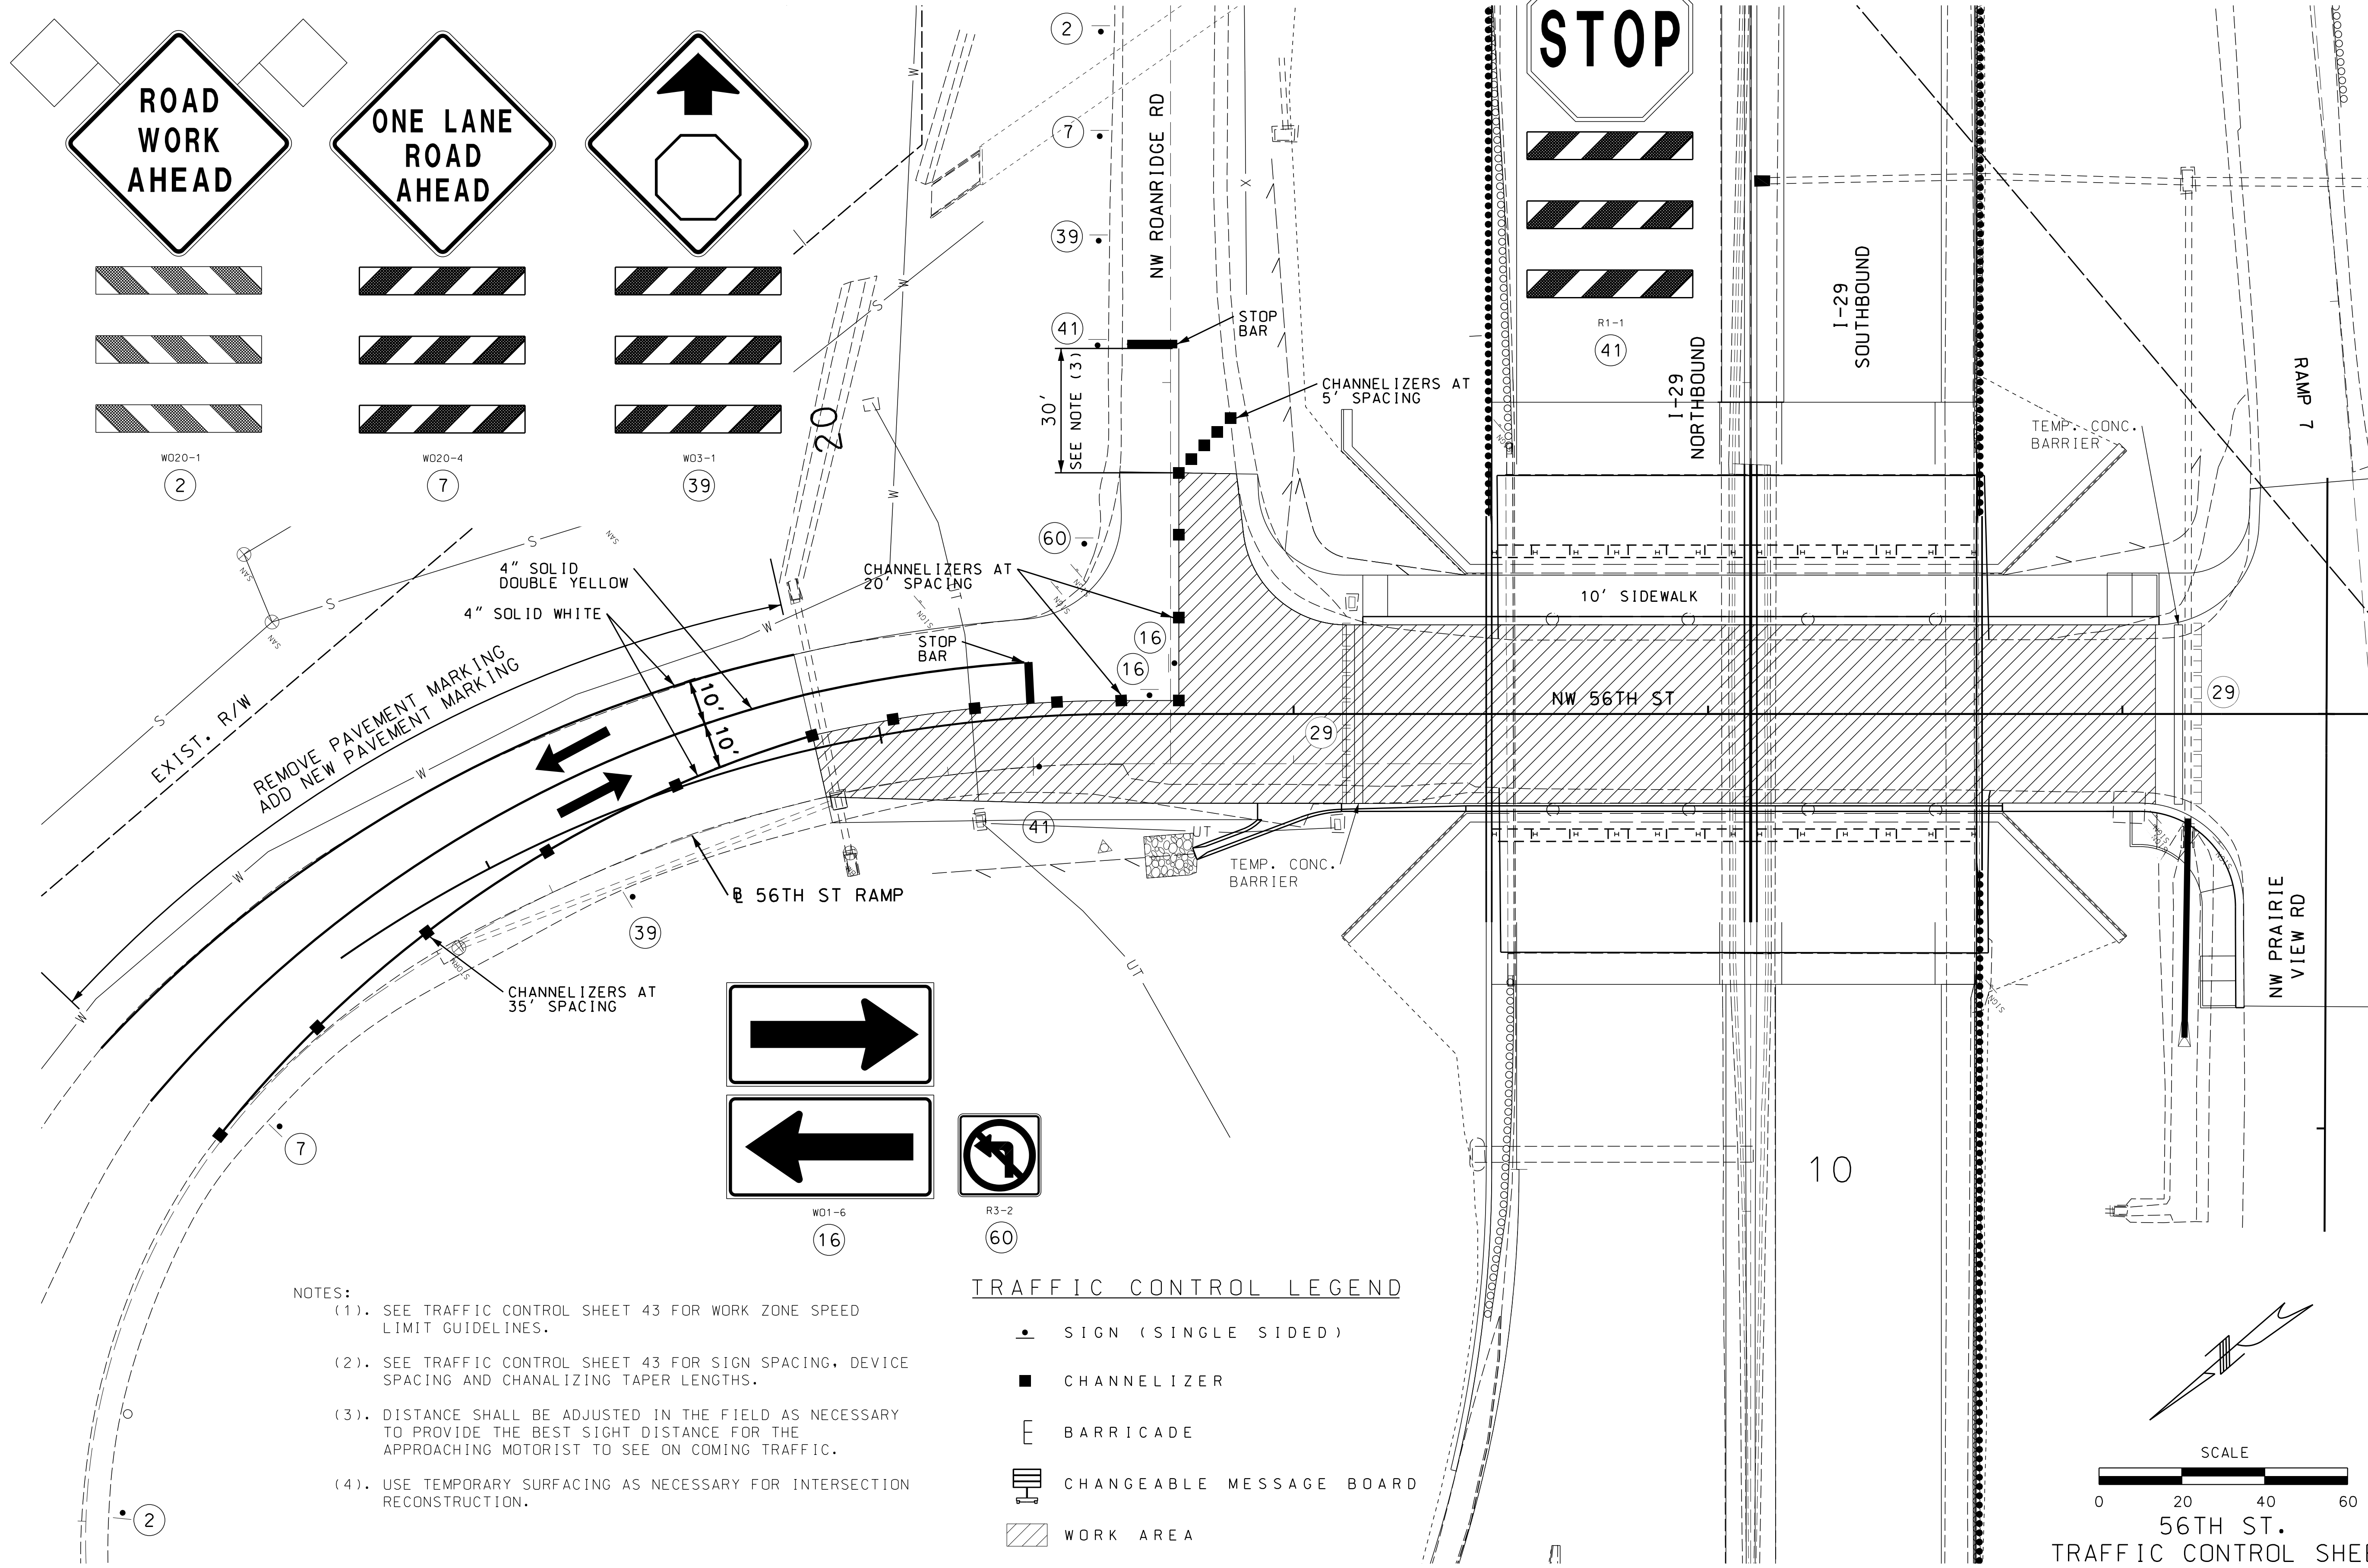

- NOTES:
- (1). SEE TRAFFIC CONTROL SHEET 43 FOR WORK ZONE SPEED LIMIT GUIDELINES.
 - (2). SEE TRAFFIC CONTROL SHEET 43 FOR SIGN SPACING, DEVICE SPACING AND CHANALIZING TAPER LENGTHS.
 - (3). DISTANCE SHALL BE ADJUSTED IN THE FIELD AS NECESSARY TO PROVIDE THE BEST SIGHT DISTANCE FOR THE APPROACHING MOTORIST TO SEE ON COMING TRAFFIC.
 - (4). USE TEMPORARY SURFACING AS NECESSARY FOR INTERSECTION RECONSTRUCTION.

TRAFFIC CONTROL LEGEND

- SIGN (SINGLE SIDED)
- CHANNELIZER
- ⌈ BARRICADE
- ⌈ CHANGEABLE MESSAGE BOARD
- ▨ WORK AREA

SCALE

0 20 40 60


56TH ST.

TRAFFIC CONTROL SHEET

PHASE 5A

SHEET 4 OF 7

DATE PREPARED 6/26/2020	
ROUTE I-29	STATE MO
DISTRICT KC	SHEET NO. 46
COUNTY PLATTE	
JOB NO. J413291	
CONTRACT ID.	
PROJECT NO.	
BRIDGE NO.	
DESCRIPTION	DATE
MISSOURI HIGHWAYS AND TRANSPORTATION COMMISSION	
105 WEST CAPITAL JEFFERSON CITY, MO 65102 1-888-ASK-MODOT (1-888-275-6636) OF SDG	
TREKK DESIGN GROUP, LLC	
1411 East 104th St. Kansas City, MO 64131 Tel (816) 974-4655 Fax (816) 974-4675 www.trekdesigngroup.com Missouri Cert. of Authority 202010300	

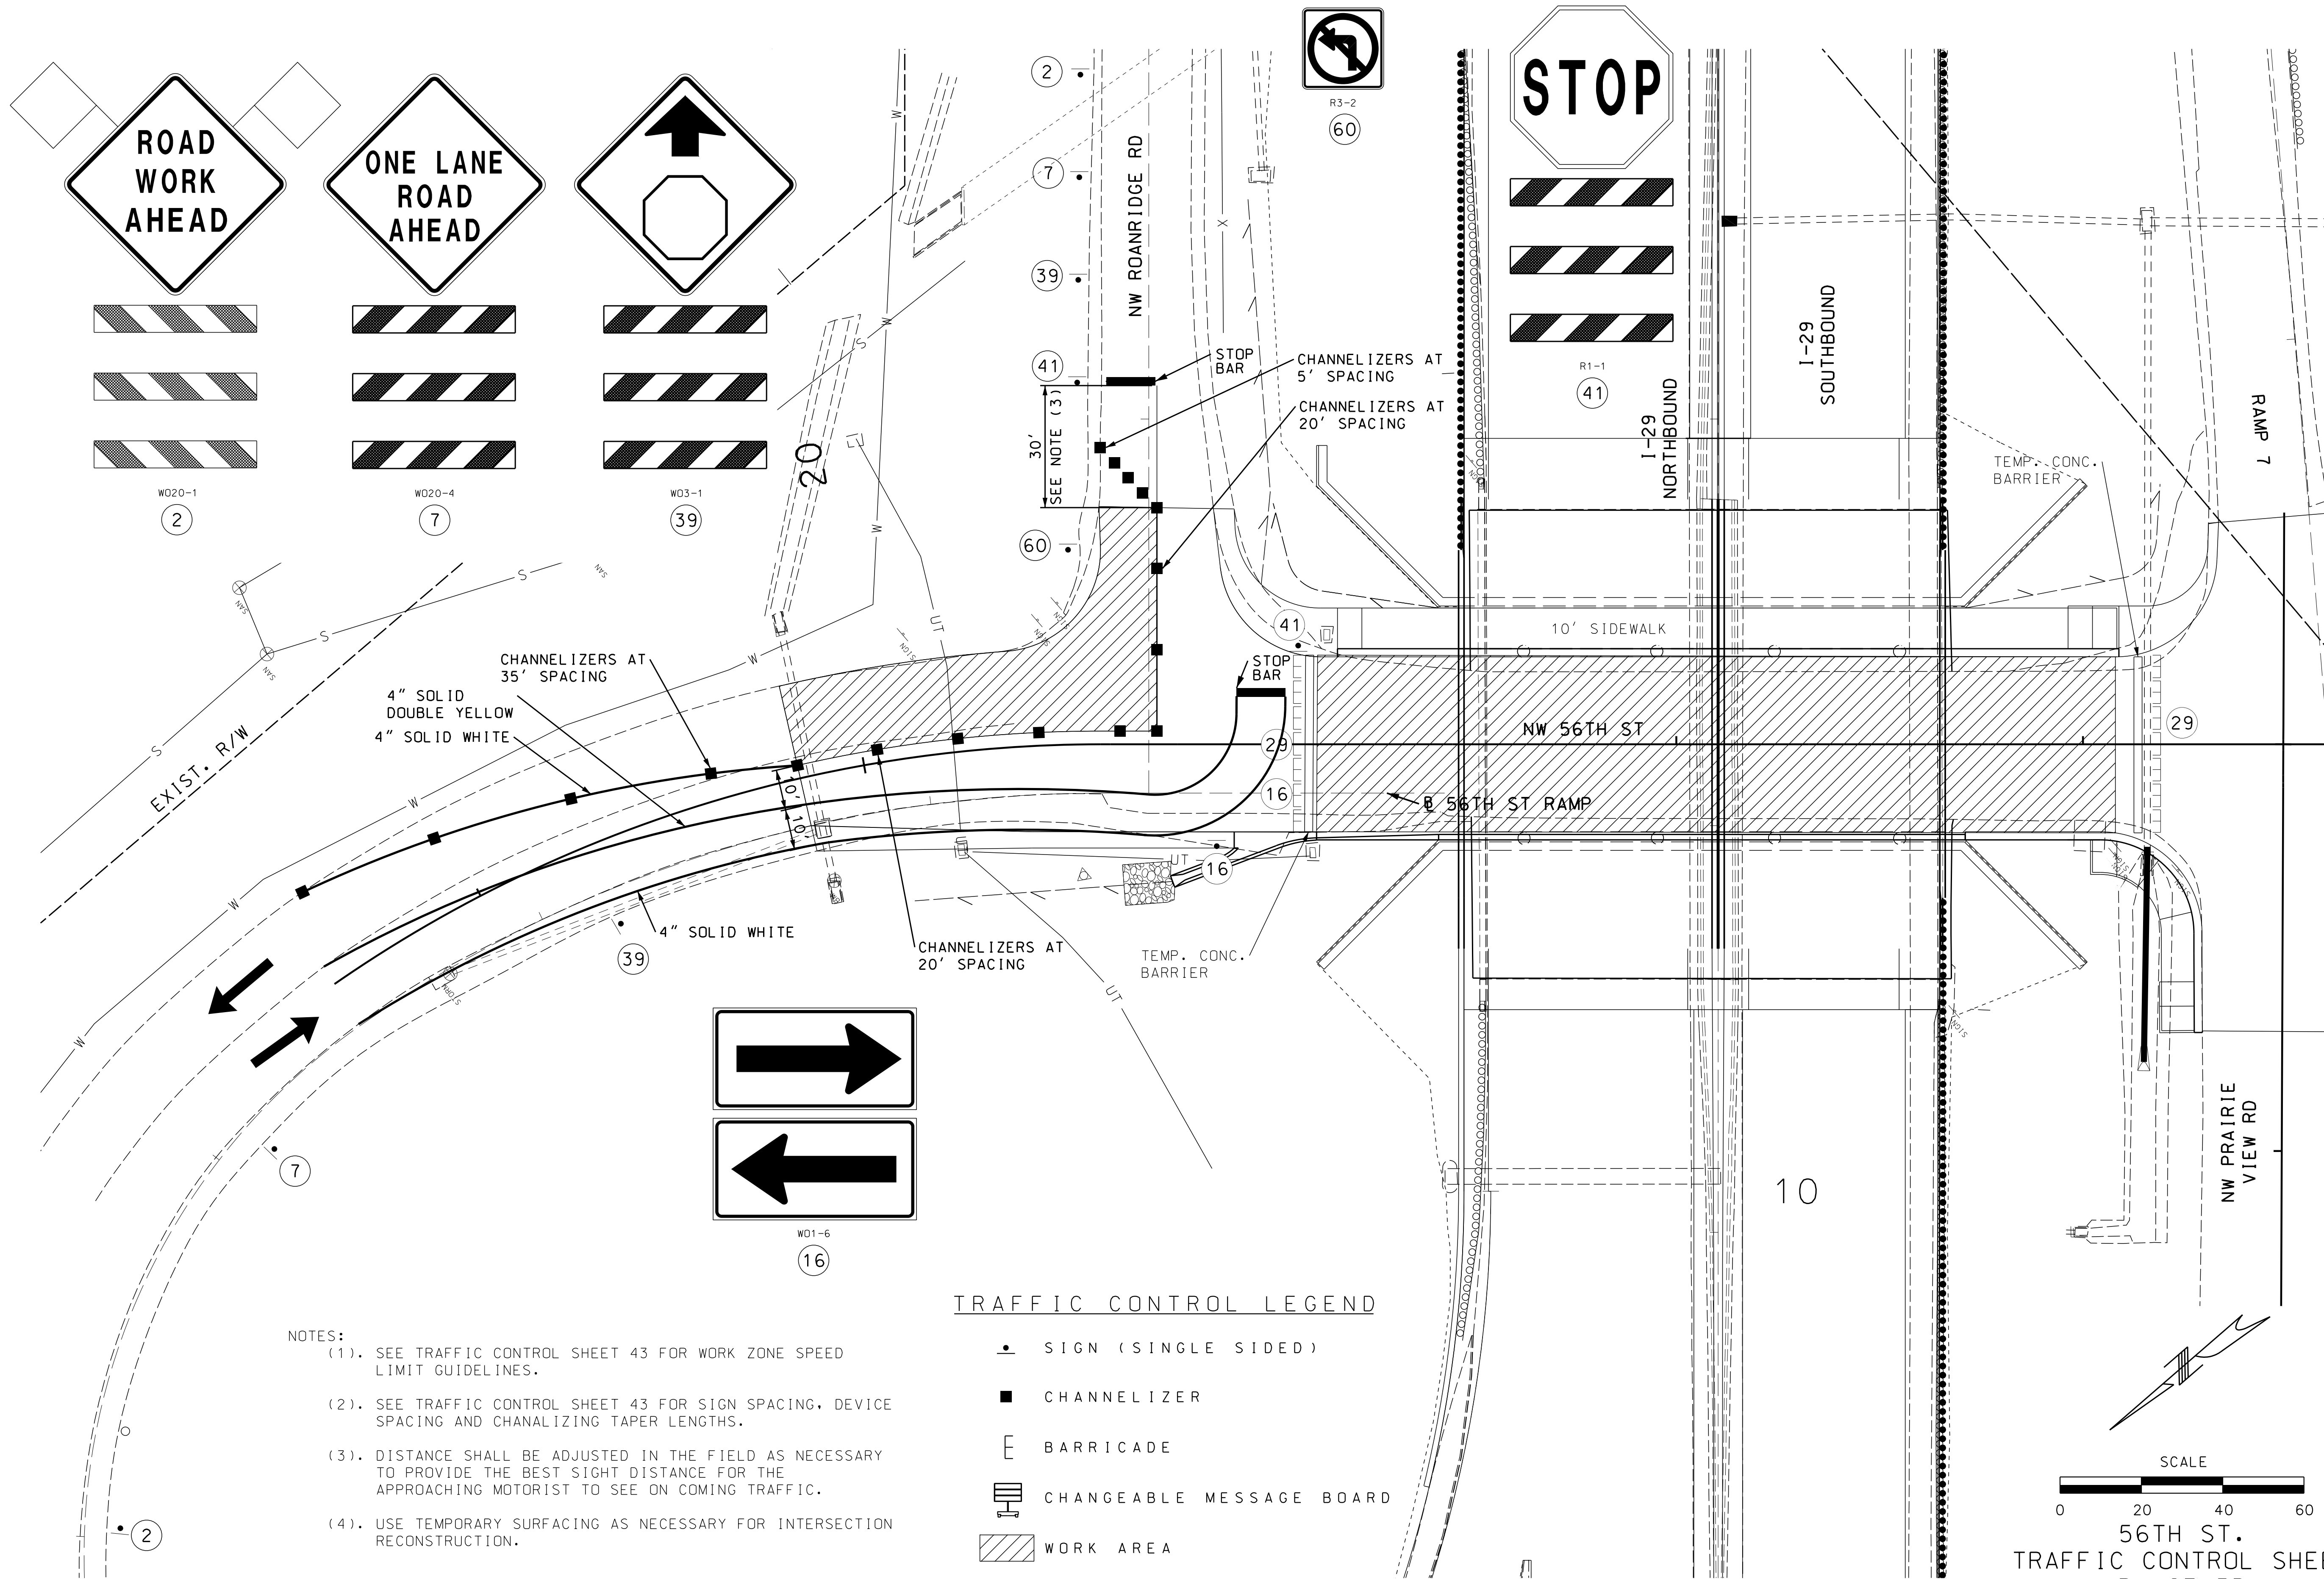

- NOTES:
- (1). SEE TRAFFIC CONTROL SHEET 43 FOR WORK ZONE SPEED LIMIT GUIDELINES.
 - (2). SEE TRAFFIC CONTROL SHEET 43 FOR SIGN SPACING, DEVICE SPACING AND CHANALIZING TAPER LENGTHS.
 - (3). DISTANCE SHALL BE ADJUSTED IN THE FIELD AS NECESSARY TO PROVIDE THE BEST SIGHT DISTANCE FOR THE APPROACHING MOTORIST TO SEE ON COMING TRAFFIC.
 - (4). USE TEMPORARY SURFACING AS NECESSARY FOR INTERSECTION RECONSTRUCTION.

TRAFFIC CONTROL LEGEND

- SIGN (SINGLE SIDED)
- CHANNELIZER
- BARRICADE
- CHANGEABLE MESSAGE BOARD
- ▨ WORK AREA

DATE PREPARED 6/26/2020	
ROUTE I-29	STATE MO
DISTRICT KC	SHEET NO. 47
COUNTY PLATTE	
JOB NO. J413291	
CONTRACT ID.	
PROJECT NO.	
BRIDGE NO.	
DESCRIPTION	
DATE	


MISSOURI HIGHWAYS AND TRANSPORTATION COMMISSION

105 WEST CAPITAL
JEFFERSON CITY, MO 65102
1-888-ASK-MODOT (1-888-275-6636)

1411 East 104th St.
Kansas City, MO 64131
Tel (816) 974-4655
Fax (816) 974-4675
www.trekdesigngroup.com

Missouri Cert. of
Authority 202010300

TREK
DESIGN GROUP, LLC

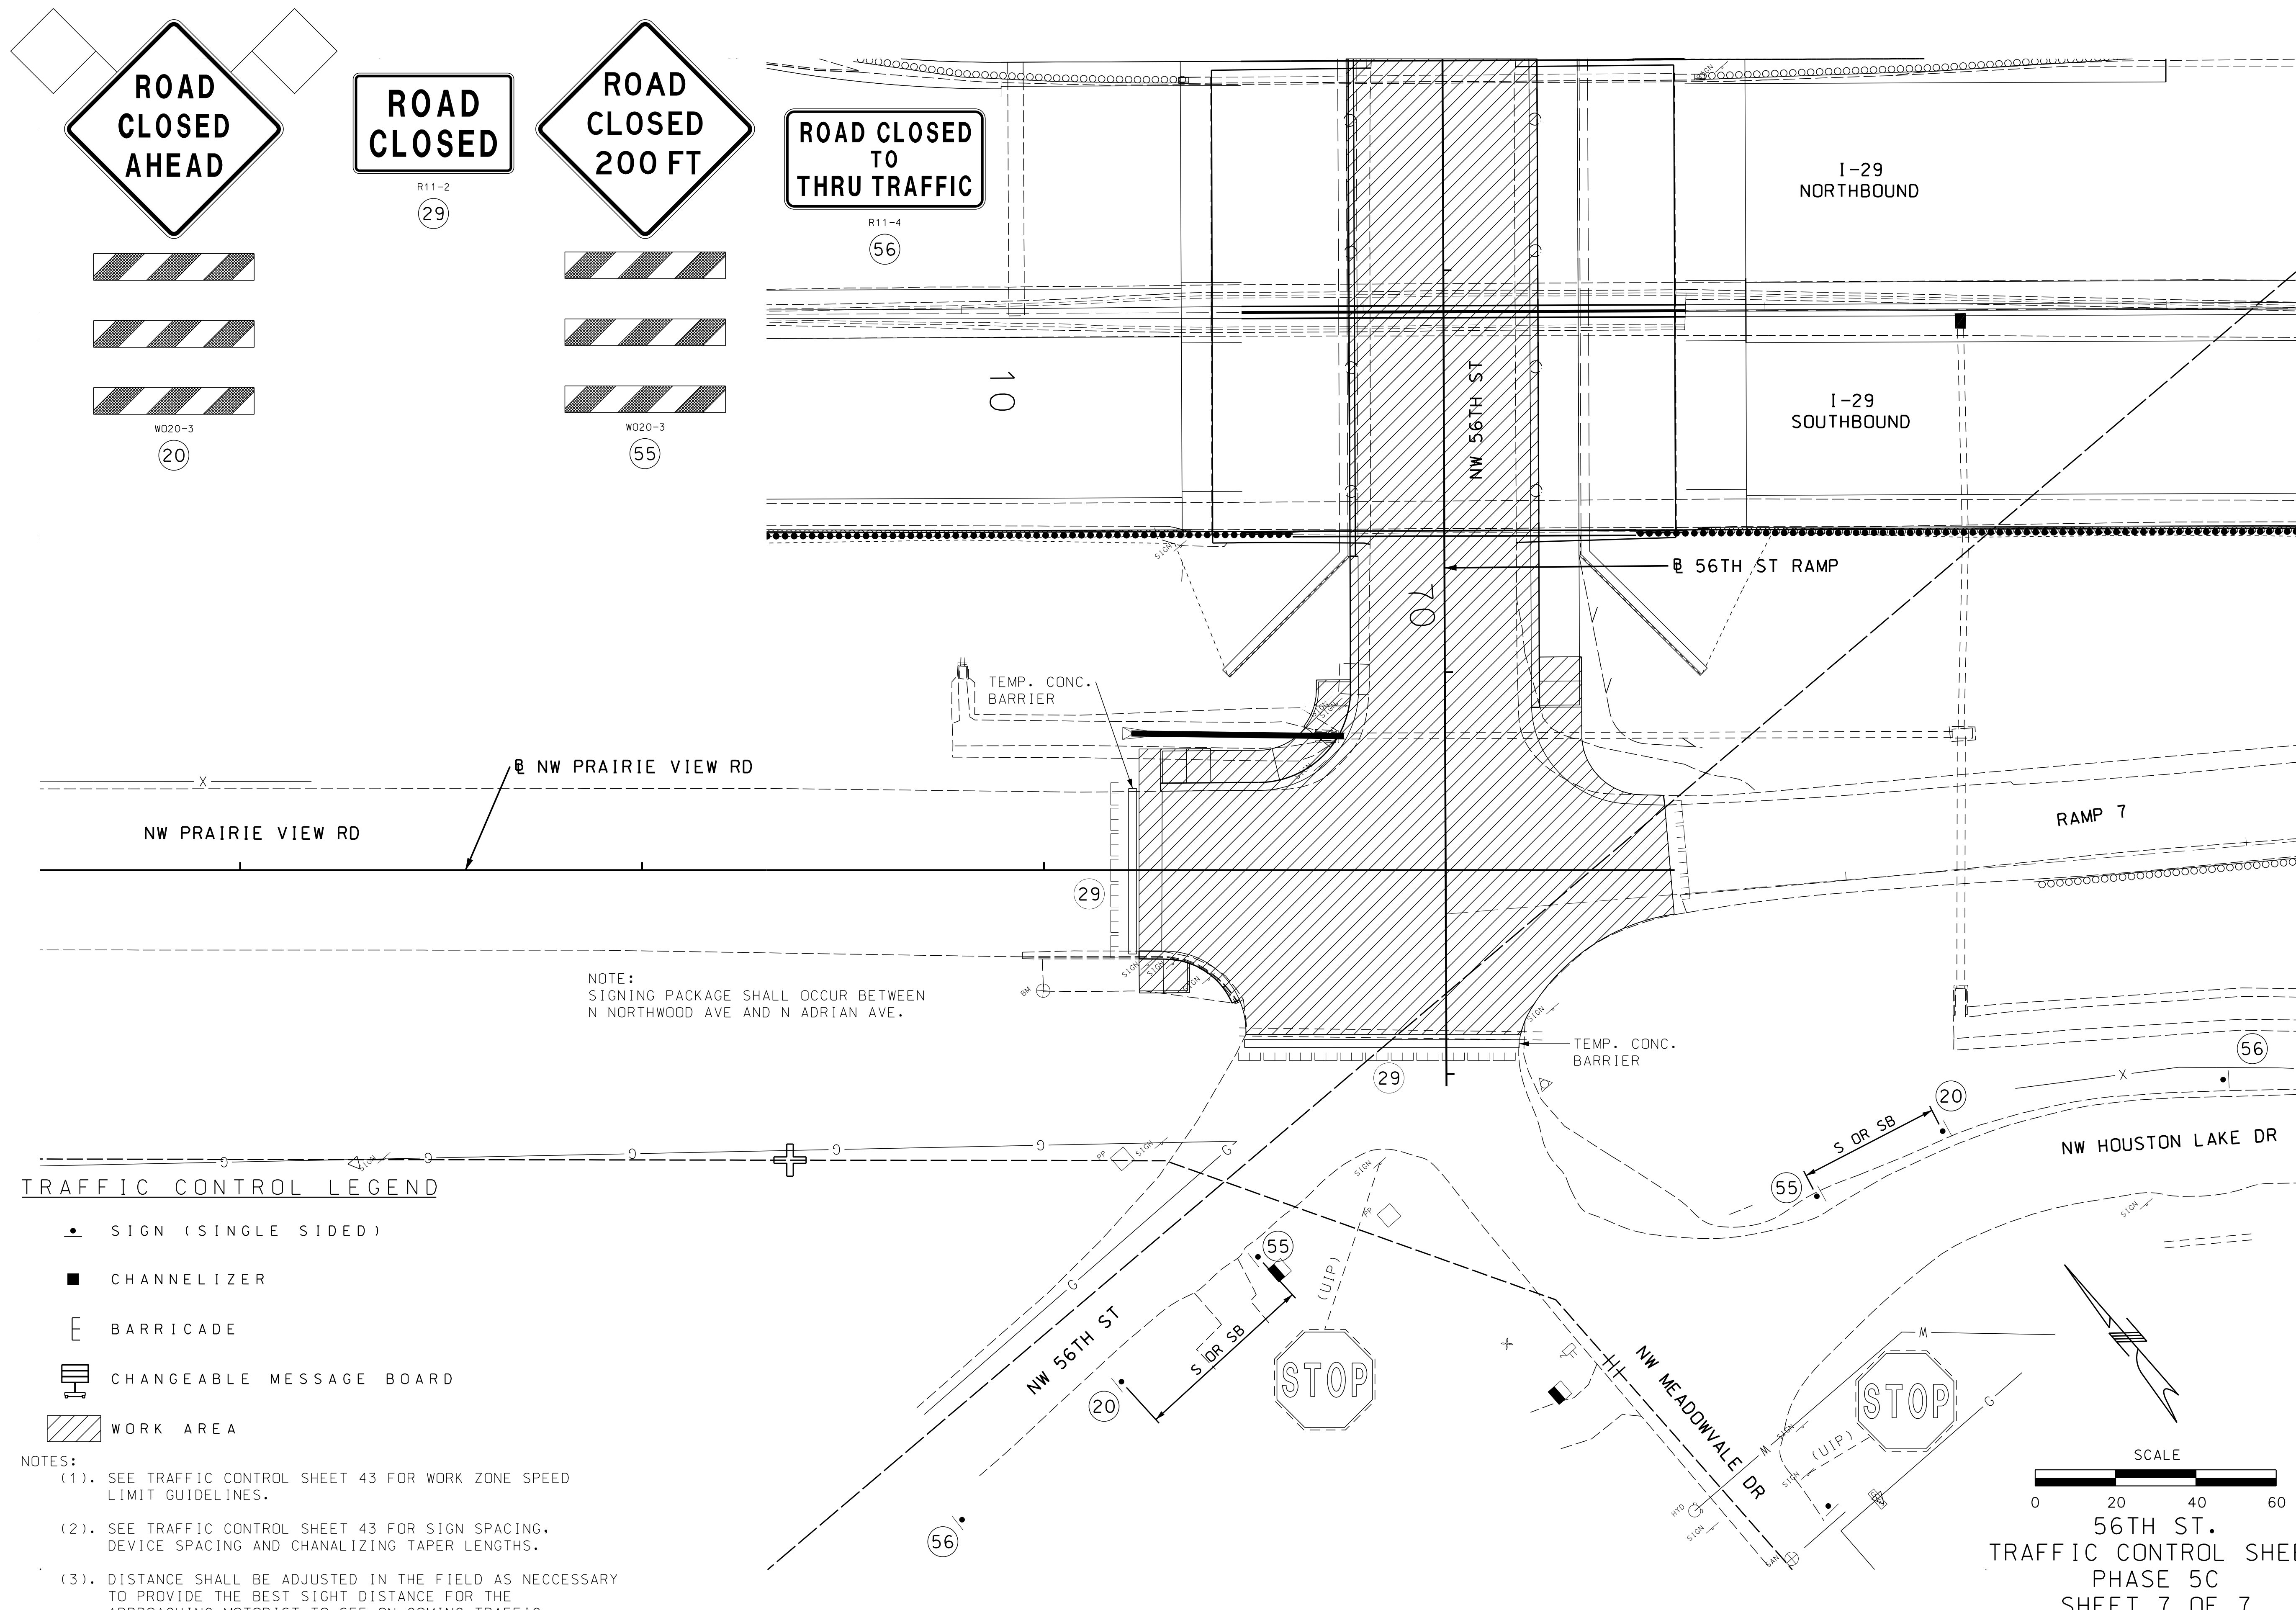

TRAFFIC CONTROL LEGEND


- SIGN (SINGLE SIDED)
- CHANNELIZER
- E BARRICADE
- CHANGEABLE MESSAGE BOARD
- WORK AREA

NOTES:

(1). SEE TRAFFIC CONTROL SHEET 43 FOR WORK ZONE SPEED LIMIT GUIDELINES.

(2). SEE TRAFFIC CONTROL SHEET 43 FOR SIGN SPACING, DEVICE SPACING AND CHANALIZING TAPER LENGTHS.

(3). DISTANCE SHALL BE ADJUSTED IN THE FIELD AS NECESSARY TO PROVIDE THE BEST SIGHT DISTANCE FOR THE APPROACHING MOTORIST TO SEE ON COMING TRAFFIC.

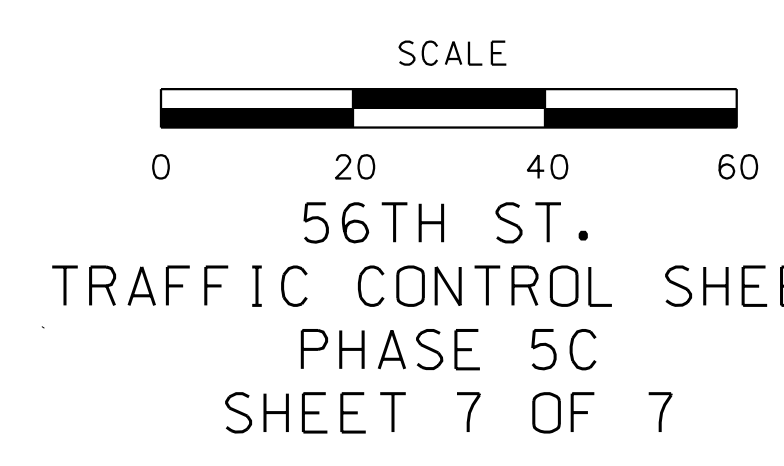

DATE PREPARED 6/26/2020	
ROUTE I-29	STATE MO
DISTRICT KC	SHEET NO. 49
COUNTY PLATTE	
JOB NO. J413291	
CONTRACT ID.	
PROJECT NO.	
BRIDGE NO.	



MISSOURI HIGHWAYS AND TRANSPORTATION COMMISSION

105 WEST CAPITAL
JEFFERSON CITY, MO 65102
1-888-ASK-MODOT (1-888-275-6636)

1411 East 104th St.
Kansas City, MO 64131
Tel (816) 974-4655
Fax (816) 974-4675
www.trekdesigngroup.com

Missouri Cert. of
Authority 202010300

TREK DESIGN GROUP, LLC

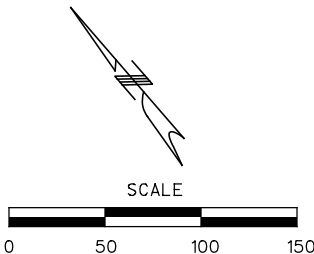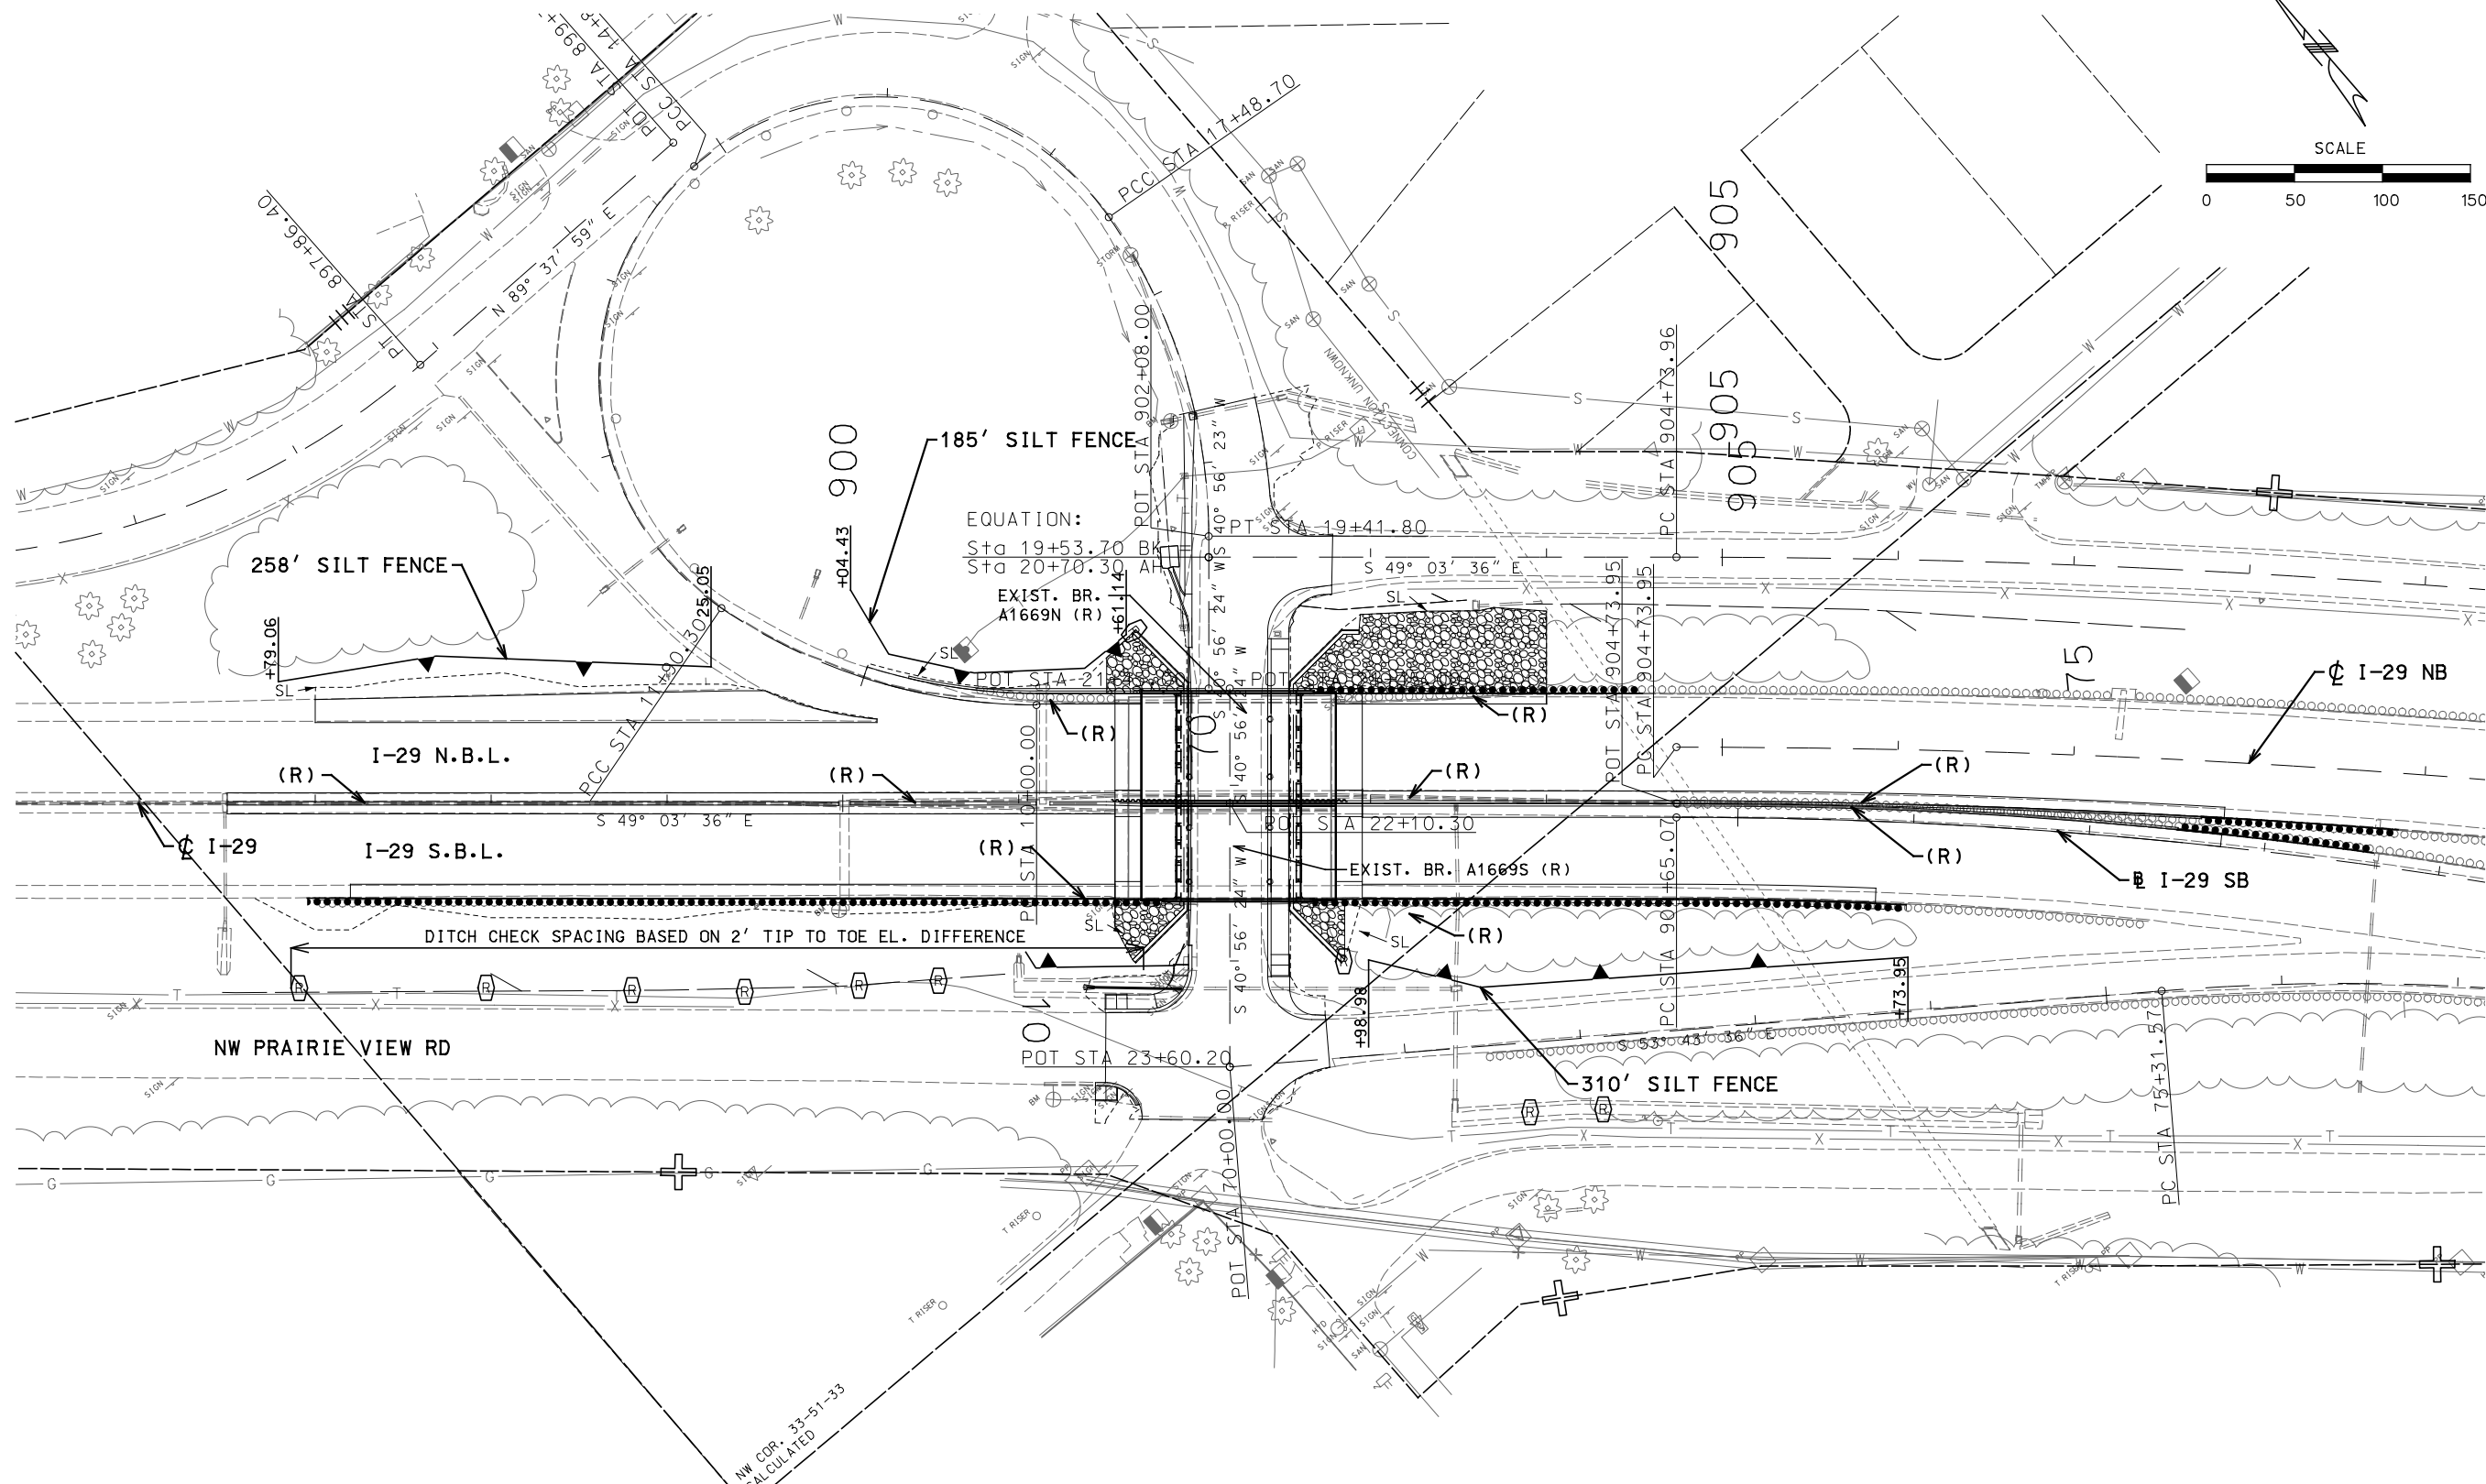

TEMPORARY EROSION CONTROL LEGEND

- (R) TYPE II DITCH CHECK
- (D) DROP INLET CHECK
- DITCH
- SILT FENCE

NOTES:
DITCH CHECK SPACING BASED ON 24" TALL DITCH CHECKS.
TYPE II DITCH CHECKS LOCATED WITHIN CLEAR ZONE AS SHOWN ON TYPICAL SECTIONS SHALL NOT BE OF THE ROCK TYPE.
FOR EROSION CONTROL MEASURES ALONG 56TH ST SEE SHEET NO. 42

I-29 OVER 56TH ST.
EROSION CONTROL
SHEET 1 OF 2

"THIS MEDIA SHOULD NOT BE CONSIDERED A CERTIFIED DOCUMENT."

DATE PREPARED 7/19/2020	
ROUTE I-29	STATE MO
DISTRICT K-C	SHEET NO. 50
COUNTY PLATTE	
JOB NO. J413291	
CONTRACT ID.	
PROJECT NO.	
BRIDGE NO.	

DESCRIPTION	DATE

MISSOURI HIGHWAYS AND TRANSPORTATION COMMISSION



105 WEST CAPITOL
JEFFERSON CITY, MO 65102
1-888-ASK-MODOT (1-888-275-6636)


Burns & McDonnell Engineering Co., Inc.

9400 Ward Parkway
Kansas City, Missouri 64114
816-333-9400

Certification of Authority
No. : 000165

BMD Project No. 109387



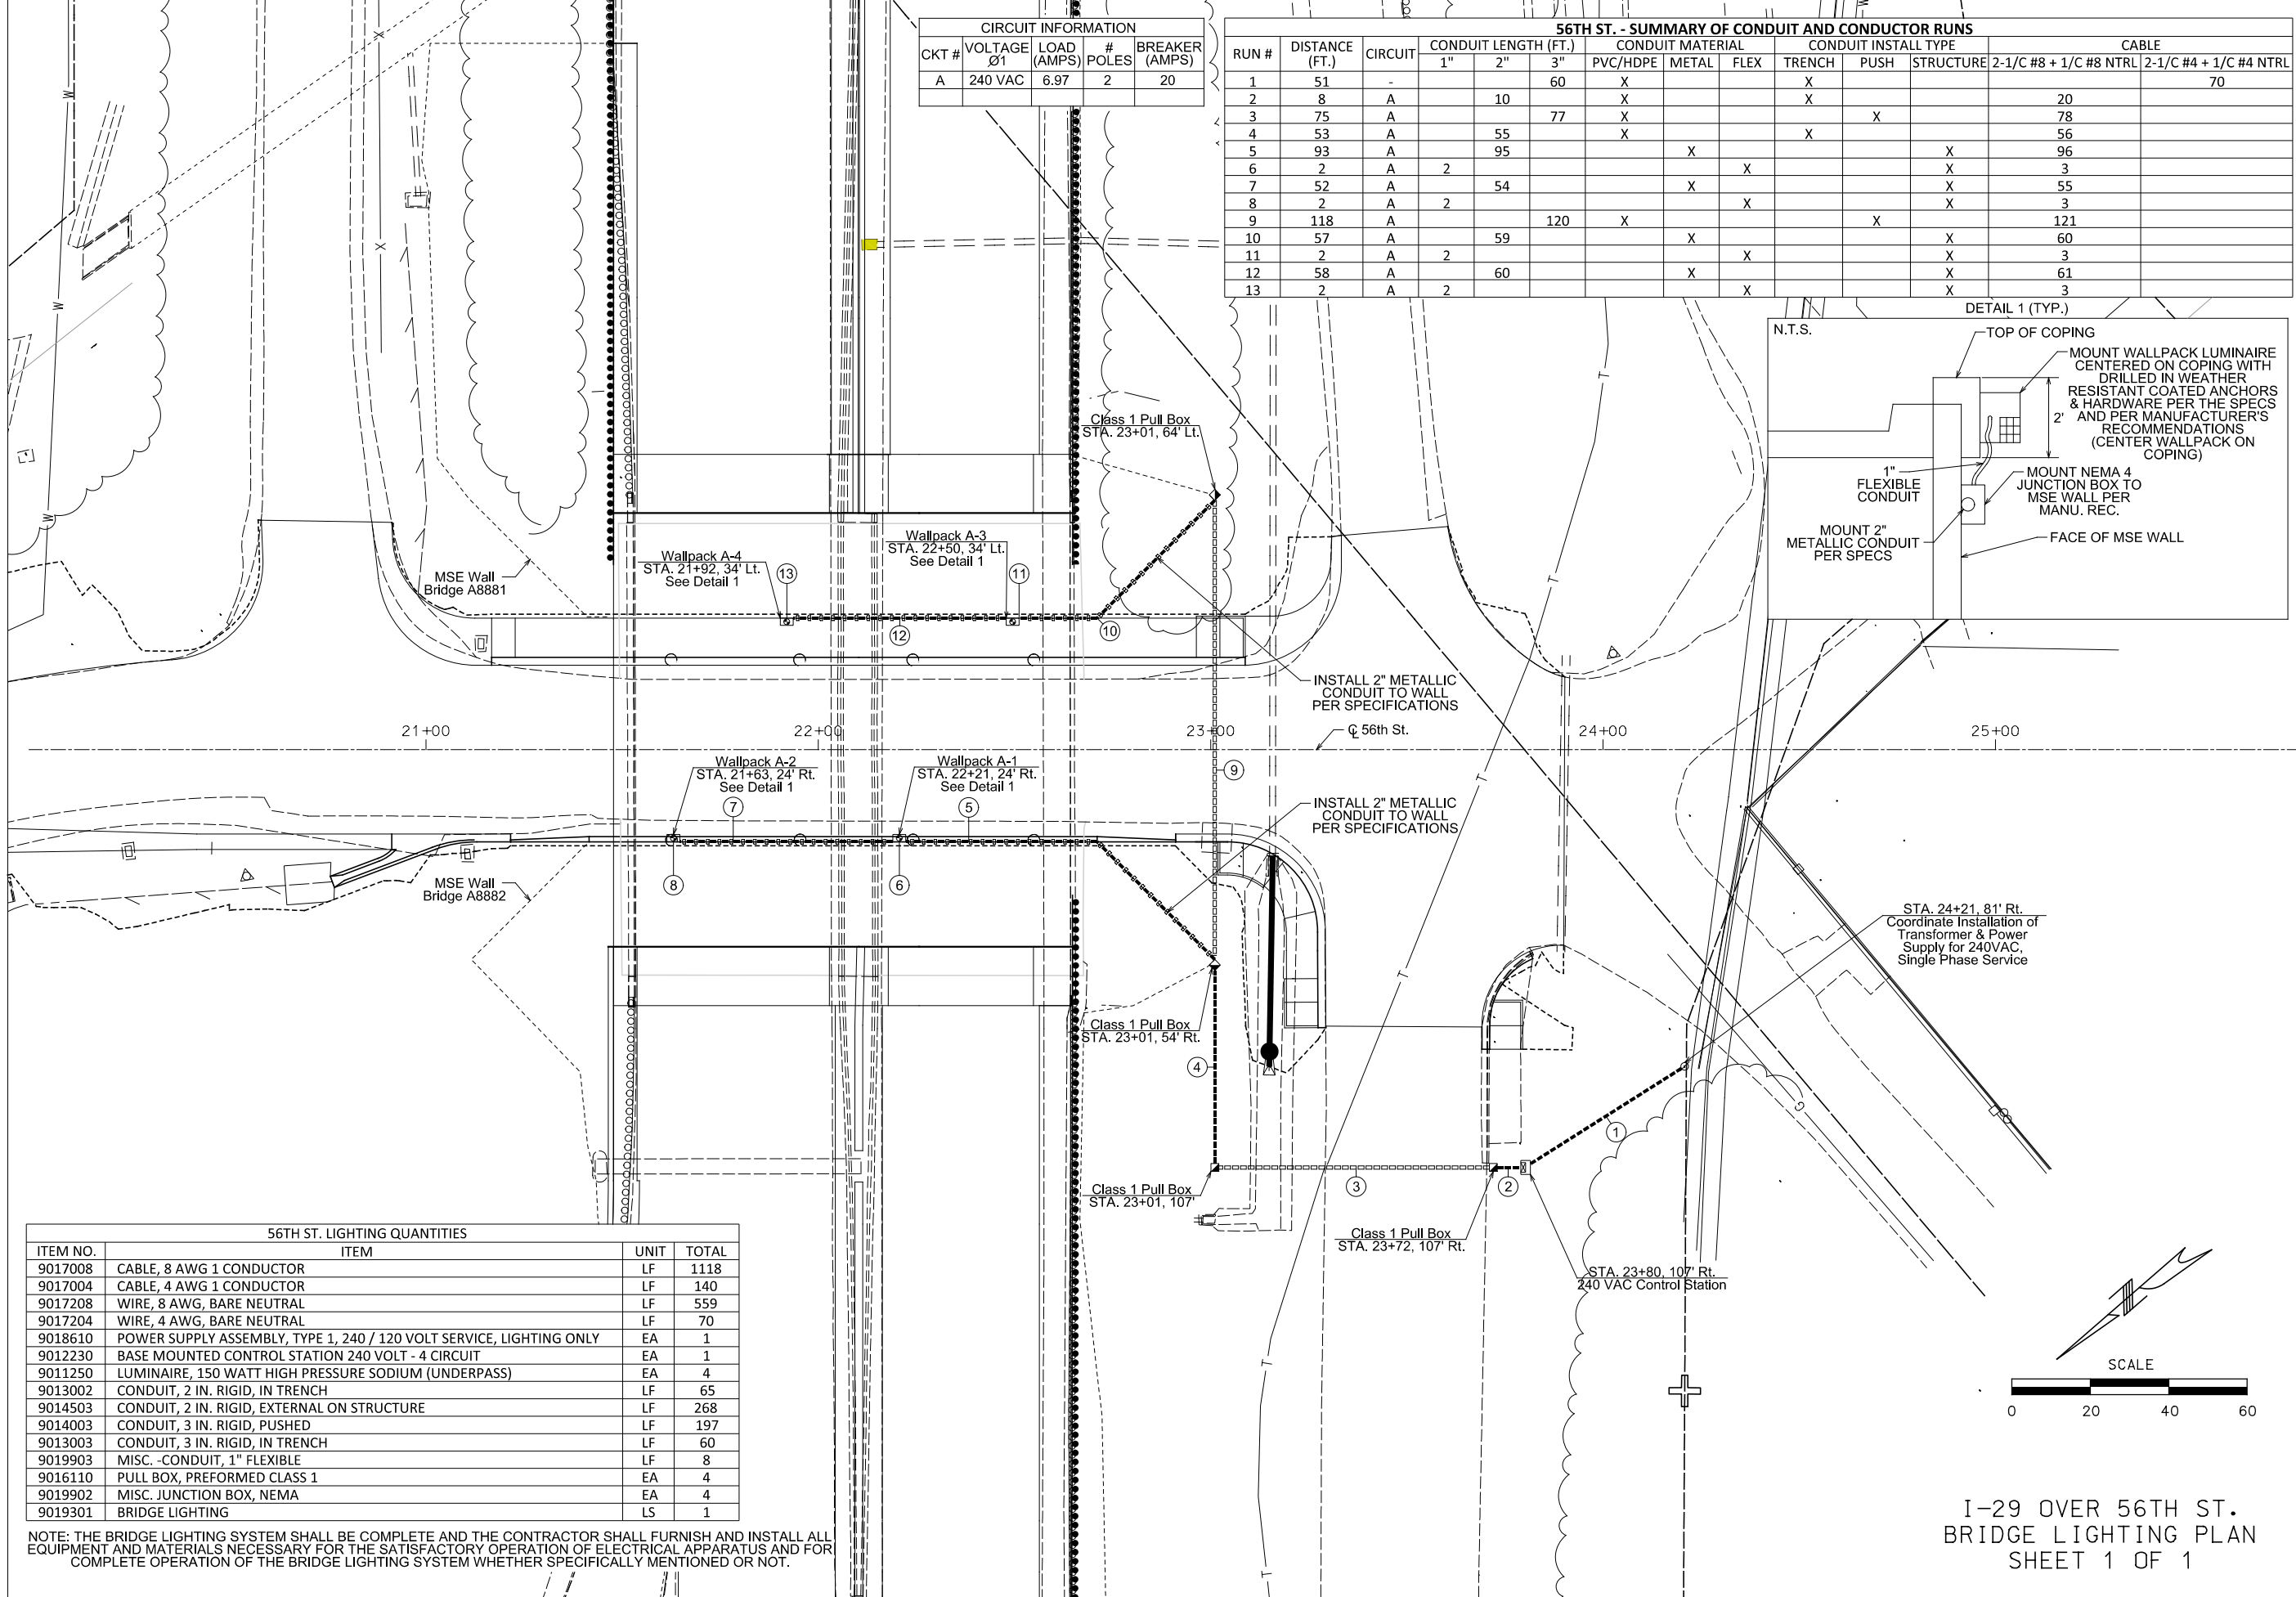

56TH ST. LIGHTING QUANTITIES			
ITEM NO.	ITEM	UNIT	TOTAL
9017008	CABLE, 8 AWG 1 CONDUCTOR	LF	1118
9017004	CABLE, 4 AWG 1 CONDUCTOR	LF	140
9017208	WIRE, 8 AWG, BARE NEUTRAL	LF	559
9017204	WIRE, 4 AWG, BARE NEUTRAL	LF	70
9018610	POWER SUPPLY ASSEMBLY, TYPE 1, 240 / 120 VOLT SERVICE, LIGHTING ONLY	EA	1
9012230	BASE MOUNTED CONTROL STATION 240 VOLT - 4 CIRCUIT	EA	1
9011250	LUMINAIRE, 150 WATT HIGH PRESSURE SODIUM (UNDERPASS)	EA	4
9013002	CONDUIT, 2 IN. RIGID, IN TRENCH	LF	65
9014503	CONDUIT, 2 IN. RIGID, EXTERNAL ON STRUCTURE	LF	268
9014003	CONDUIT, 3 IN. RIGID, PUSHED	LF	197
9013003	CONDUIT, 3 IN. RIGID, IN TRENCH	LF	60
9019903	MISC. -CONDUIT, 1" FLEXIBLE	LF	8
9016110	PULL BOX, PREFORMED CLASS 1	EA	4
9019902	MISC. JUNCTION BOX, NEMA	EA	4
9019301	BRIDGE LIGHTING	LS	1

NOTE: THE BRIDGE LIGHTING SYSTEM SHALL BE COMPLETE AND THE CONTRACTOR SHALL FURNISH AND INSTALL ALL EQUIPMENT AND MATERIALS NECESSARY FOR THE SATISFACTORY OPERATION OF ELECTRICAL APPARATUS AND FOR COMPLETE OPERATION OF THE BRIDGE LIGHTING SYSTEM WHETHER SPECIFICALLY MENTIONED OR NOT.

"THIS MEDIA SHOULD NOT BE CONSIDERED A CERTIFIED DOCUMENT."

DATE PREPARED
7/19/2020

ROUTE
I-29

DISTRICT
KC

STATE
MO

SHEET NO.
52

COUNTY
PLATTE

JOB NO.
J413291

CONTRACT ID.

PROJECT NO.

BRIDGE NO.

DESCRIPTION

DATE

MISSOURI HIGHWAYS AND TRANSPORTATION COMMISSION

MoDOT


105 WEST CAPITOL
JEFFERSON CITY, MO 65102
1-888-ASK-MODOT (1-888-275-6636)

Burns & McDonnell Engineering Co., Inc.

9400 Ward Parkway
Kansas City, Missouri 64114
816-333-9400


Certificate of Authority
No. : 000165

BMcD Project No. 109387

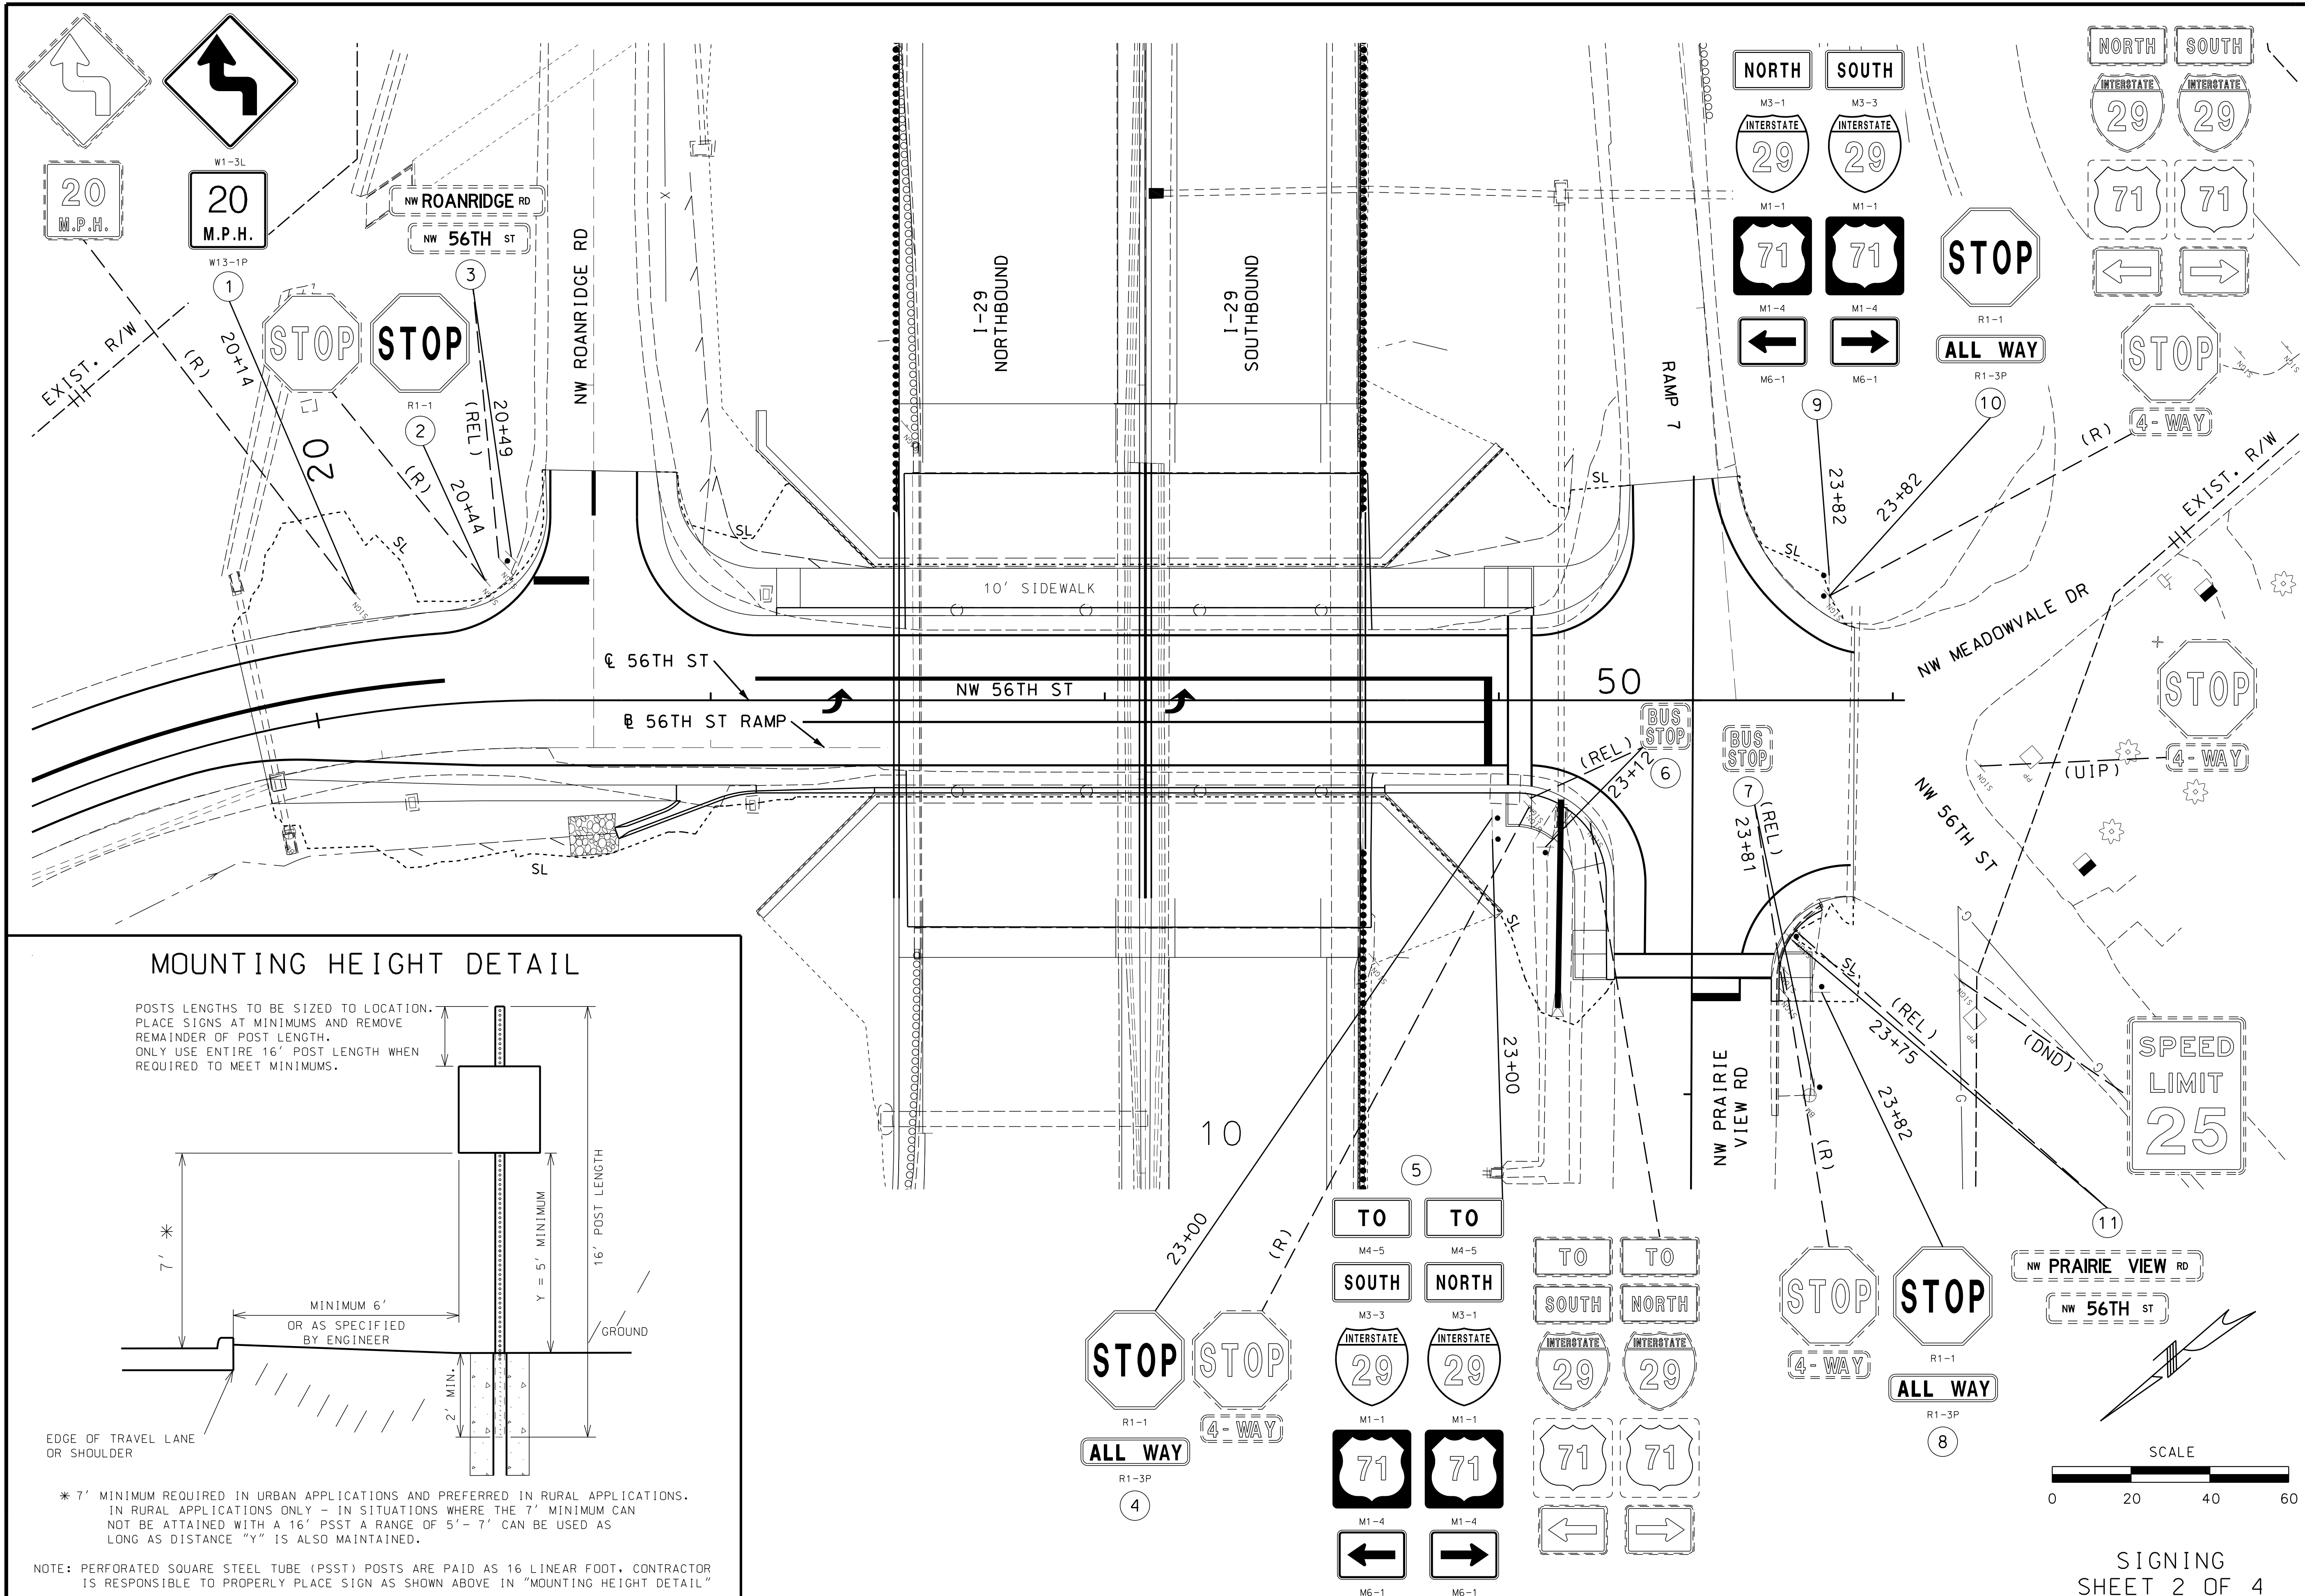

MOUNTING HEIGHT DETAIL

POSTS LENGTHS TO BE SIZED TO LOCATION.
PLACE SIGNS AT MINIMUMS AND REMOVE
REMAINDER OF POST LENGTH.
ONLY USE ENTIRE 16' POST LENGTH WHEN
REQUIRED TO MEET MINIMUMS.

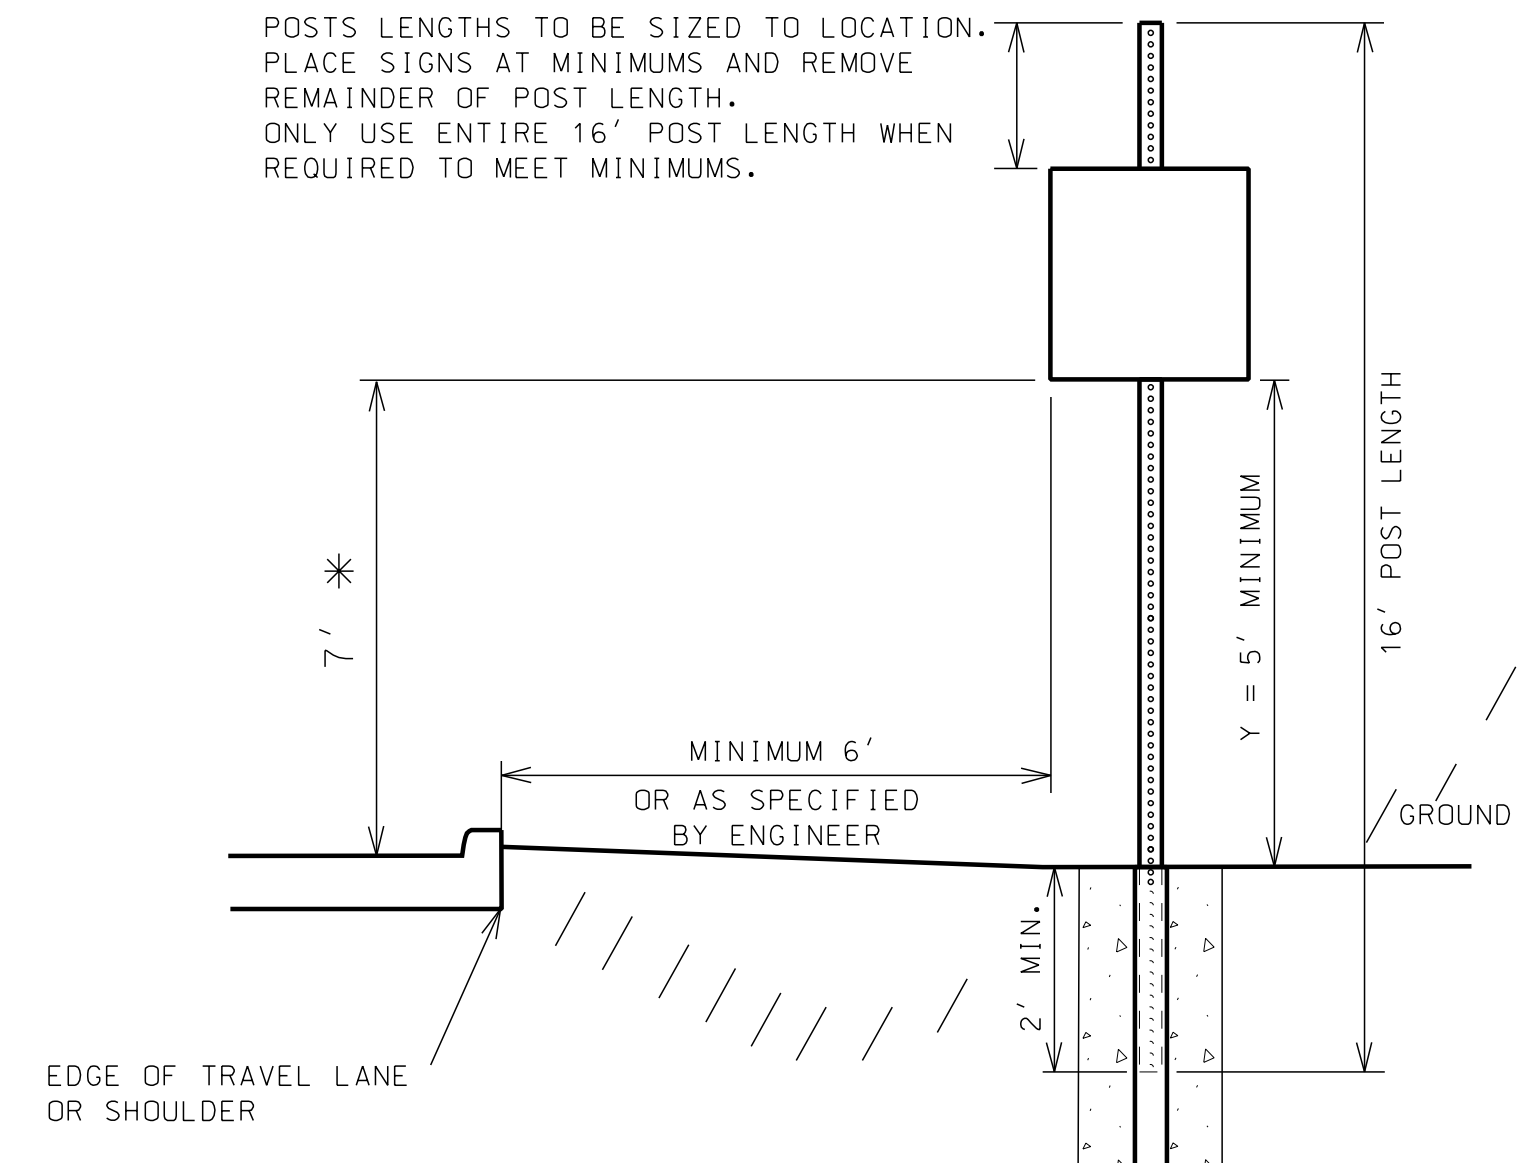

* 7' MINIMUM REQUIRED IN URBAN APPLICATIONS AND PREFERRED IN RURAL APPLICATIONS.
IN RURAL APPLICATIONS ONLY - IN SITUATIONS WHERE THE 7' MINIMUM CAN
NOT BE ATTAINED WITH A 16' PSST A RANGE OF 5' - 7' CAN BE USED AS
LONG AS DISTANCE "Y" IS ALSO MAINTAINED.

NOTE: PERFORATED SQUARE STEEL TUBE (PSST) POSTS ARE PAID AS 16 LINEAR FOOT, CONTRACTOR
IS RESPONSIBLE TO PROPERLY PLACE SIGN AS SHOWN ABOVE IN "MOUNTING HEIGHT DETAIL"

DATE PREPARED 6/26/2020	
ROUTE I-29	STATE MO
DISTRICT KC	SHEET NO. 54
COUNTY PLATTE	
JOB NO. J413291	
CONTRACT ID.	
PROJECT NO.	
BRIDGE NO.	
DESCRIPTION	DATE
MISSOURI HIGHWAYS AND TRANSPORTATION COMMISSION	
105 WEST CAPITAL JEFFERSON CITY, MO 65102 1-888-ASK-MODOT (1-888-275-6636)	
1411 East 104th St. Kansas City, MO 64131 Tel (816) 974-4655 Fax (816) 974-4675 www.trekdesigngroup.com	
Missouri Cert. of Authority 202010300	
TREK DESIGN GROUP, LLC	

EFFECTIVE 12-01-2017																									REMARKS AND OTHER REQUIRED ITEMS.		ITEM NO. 9031010 ITEM NO. 9031020											
SIGNS					PIPE POST *					STRUCTURAL STEEL								U CHANNEL POST	PERFORATED SQUARE STEEL TUBE POST												FOOTINGS							
902 SIGNAL SIGNS TABULATED ON D-37A SHEET					POSTS *					BACKING BARS 2" X 3/8" BARS @ 2.55 LBS PER LIN FT				TOTAL	2 IN														2.5 IN				BREAK- AWAY ASSEMBLY	EMBD	BOLT DOWN			
SIGN NO.	SIGN SIZE	STATION	HORZ CLEAR IF NOT STD	LOCATION	SIGN DTL. SHT. NO.	PIPE SIZE	POST NO.1	POST NO.2	LBS PER FT	TOTAL ITEM NO. 9031220 LBS	POST DES NO.	POST NO.1	POST NO.2	POST NO.3	LBS PER FT	TOTAL	NO. EACH	LGTH IN.	TOTAL LBS	TOTAL	ITEM NO. 9031210 LBS	ITEM NO. 9031250 LF	POST NO.1	POST NO.2	TOTAL ITEM NO. 9031270A LF	ANCHOR 7 GA. ITEM NO. 9031273 LF	OMNI 7 GA. ITEM NO. 9031279 LF	ANCHOR 12 GA. ITEM NO. 9031271 LF	OMNI 12 GA. ITEM NO. 9031278 LF	POST NO.1	POST NO.2	TOTAL ITEM NO. 9031280 LF	2.25" INSERT ITEM NO. 9031272 LF	ANCHOR 7 GA. ITEM NO. 9031281 LF	OMNI 7 GA. ITEM NO. 9031282 LF	ITEM NO. 9031241 EACH	ITEM NO. 9031010 CU YDS	ITEM NO. 9031020 CU YDS
1	ASSEMBLY	20+14	-	LEFT	-	-	-	-	-	-	-	-	-	-	-	-	-	-	-	-	-	-	16	16	16	-	-	3	-	-	-	-	-	-	-	-	0.09	-
2	36"X36"	20+44	-	LEFT	-	-	-	-	-	-	-	-	-	-	-	-	-	-	-	-	-	-	16	16	16	-	-	3	-	-	-	-	-	-	-	-	0.09	-
3	ASSEMBLY	20+49	-	LEFT	-	-	-	-	-	-	-	-	-	-	-	-	-	-	-	-	-	-	16	16	16	-	-	3	-	-	-	-	-	-	-	-	0.09	-
4	ASSEMBLY	23+00	-	RIGHT	-	-	-	-	-	-	-	-	-	-	-	-	-	-	-	-	-	-	16	16	16	-	-	3	-	-	-	-	-	-	-	-	0.09	-
5	ASSEMBLY	23+00	-	RIGHT	-	-	-	-	-	-	-	-	-	-	-	-	10	50	41.7	107	107	-	-	-	-	-	-	-	-	16	16	16	-	-	-	1	0.09	-
6	ASSEMBLY	23+12	-	RIGHT	-	-	-	-	-	-	-	-	-	-	-	-	-	-	-	-	-	-	16	16	16	-	-	3	-	-	-	-	-	-	-	-	0.09	-
7	ASSEMBLY	23+81	-	RIGHT	-	-	-	-	-	-	-	-	-	-	-	-	-	-	-	-	-	-	16	16	16	-	-	3	-	-	-	-	-	-	-	-	0.09	-
8	ASSEMBLY	23+82	-	RIGHT	-	-	-	-	-	-	-	-	-	-	-	-	-	-	-	-	-	-	16	16	16	-	-	3	-	-	-	-	-	-	-	-	0.09	-
9	ASSEMBLY	23+82	-	LEFT	-	-	-	-	-	-	-	-	-	-	-	-	10	50	41.7	107	107	-	-	-	-	-	-	-	-	16	16	16	-	-	-	1	0.09	-
10	ASSEMBLY	23+82	-	LEFT	-	-	-	-	-	-	-	-	-	-	-	-	-	-	-	-	-	-	16	16	16	-	-	3	-	-	-	-	-	-	-	-	0.09	-
11	ASSEMBLY	23+75	-	RIGHT	-	-	-	-	-	-	-	-	-	-	-	-	-	-	-	-	-	-	16	16	16	-	-	3	-	-	-	-	-	-	-	-	0.09	-
12	ASSEMBLY	896+70	-	RIGHT	-	-	-	-	-	-	-	-	-	-	-	-	-	-	-	-	-	-	16	16	16	-	-	3	-	-	-	-	-	-	-	-	0.09	-
13	ASSEMBLY	898+22	-	RIGHT	-	-	-	-	-	-	-	-	-	-	-	-	-	-	-	-	-	-	16	16	32	32	-	-	-	-	-	-	-	-	-	-	0.18	-
14	24"X30"	899+75	-	RIGHT	-	-	-	-	-	-	-	-	-	-	-	-	-	-	-	-	-	-	16	16	-	-	-	3	-	-	-	-	-	-	-	-	0.09	-
15	36"X8"	901+50	-	RIGHT	-	-	-	-	-	-	-	-	-	-	-	-	-	-	-	-	-	-	16	16	16	-	-	3	-	-	-	-	-	-	-	-	0.09	-
16	ASSEMBLY	902+99	-	LEFT	-	-	-	-	-	-	-	-	-	-	-	-	-	-	-	-	-	-	16	16	16	16	-	-	-	-	-	-	-	-	-	0.09	-	
17	ASSEMBLY	899+21	-	LEFT	-	-	-	-	-	-	-	-	-	-	-	-	-	-	-	-	-	-	16	16	32	32	-	-	-	-	-	-	-	2	0.18	-		
18	24"X30"	897+50	-	LEFT	-	-	-	-	-	-	-	-	-	-	-	-	-	-	-	-	-	-	16	16	16	-	-	3	-	-	-	-	-	-	-	0.09	-	

* ORANGE, YELLOW & YELLOW/GREEN

SIGNING
SHEET 4 OF 4

D-30

Engineering Co., Inc.
9400 Ward Parkway
Kansas City, Missouri 64114
816-333-9400

Certificate of Authority
No. : 000165

BMCD Project No. 109387

MISSOURI HIGHWAYS AND TRANSPORTATION
COMMISSION

105 WEST CAPITOL
JEFFERSON CITY, MO 65102
1-888-ASK-MODOT (1-888-275-6636)



DATE PREPARED 7/19/2020	
ROUTE I-29	STATE MO
DISTRICT K/C	SHEET NO. 56
COUNTY PLATTE	
JOB NO. J413291	
CONTRACT ID. .	
PROJECT NO. .	
BRIDGE NO.	

[illegible]

IF A SEAL IS PRESENT ON THIS SHEET IT HAS BEEN ELECTRONICALLY SEALED AND DATED.

NOTES:

1. ALL EXISTING PAVEMENT MARKINGS IN CONFLICT WITH THE PAVEMENT MARKINGS SHOWN ON THIS SHEET ARE TO BE REMOVED.
2. ALL LANE AND EDGE LINES SHALL BE EPOXY. ALL INTERSECTION MARKING SHALL BE PREFORMED THERMOPLASTIC.
3. ALL MARKINGS OTHER THAN DOTTED AND INTERMITTENT LINES SHALL BE HIGH BUILD WATERBONE PAVEMENT MARKING.
4. DOTTED WHITE LINES SHALL BE 2' STRIPE WITH A 3' GAP.
5. INTERMITTENT WHITE LINES SHALL BE 10' STRIPE 30' GAP.

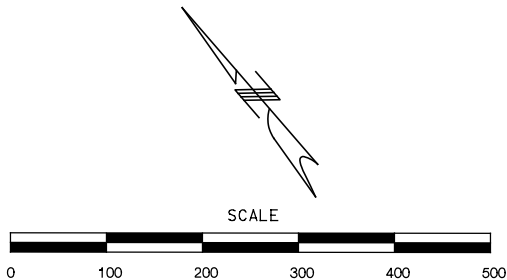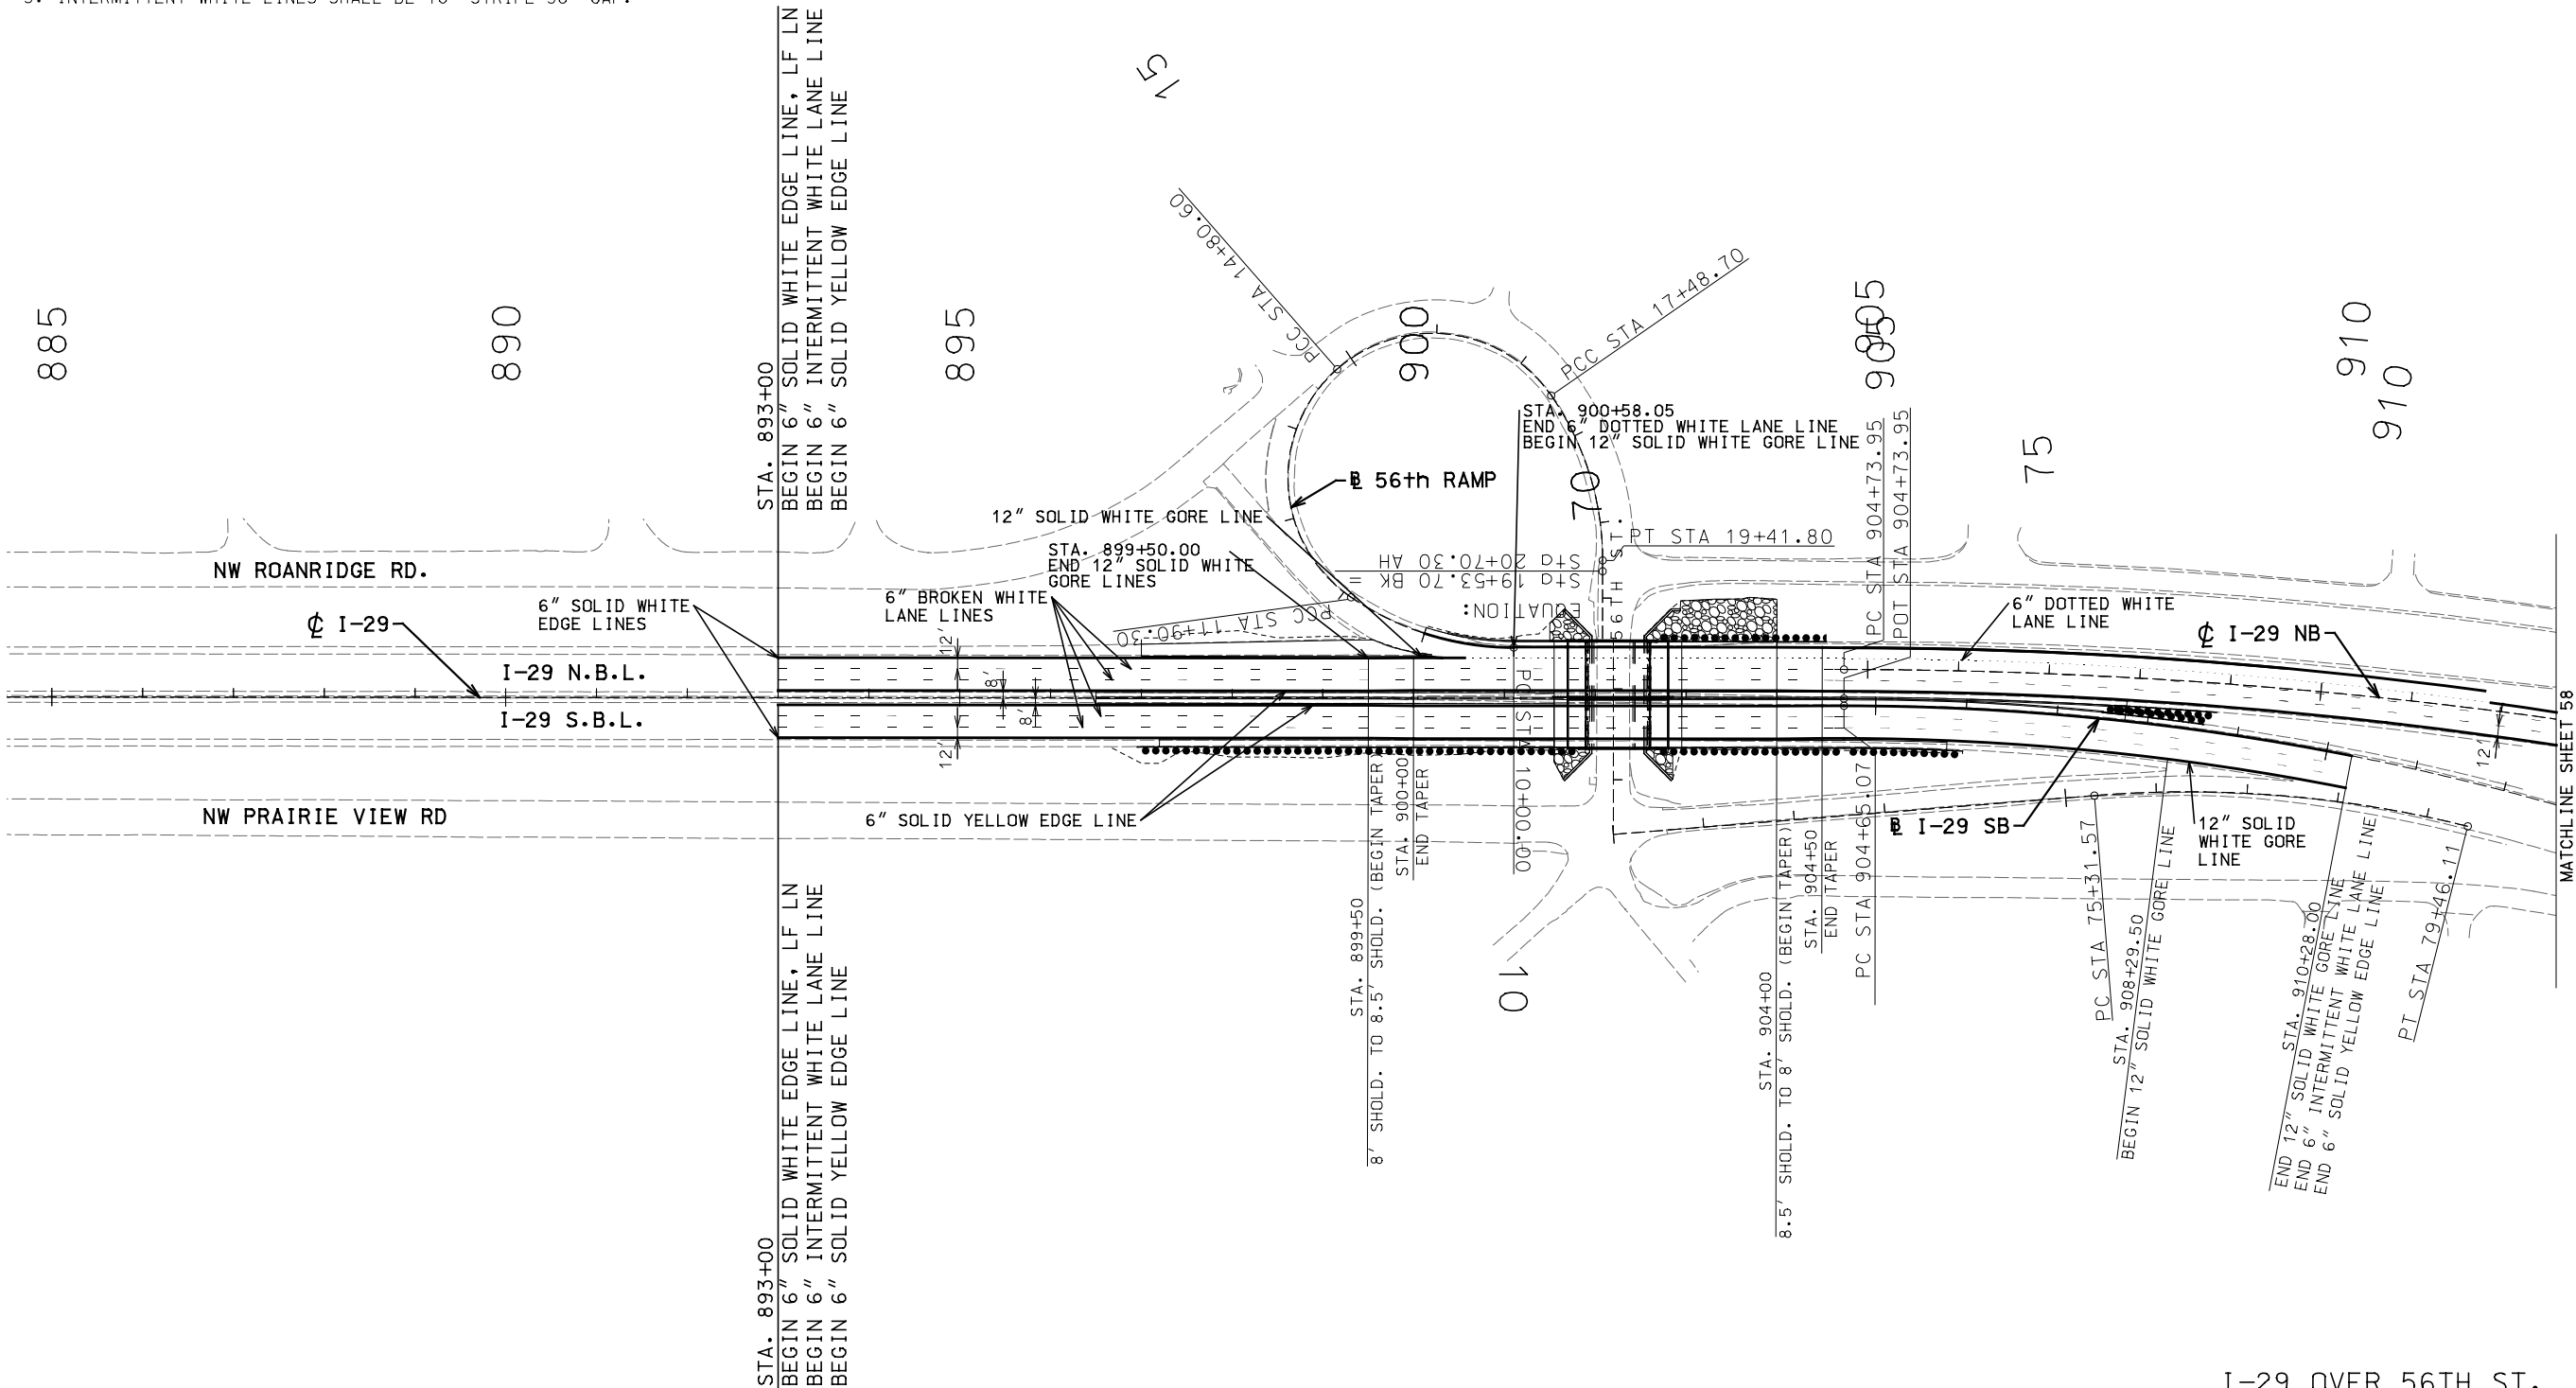

"THIS MEDIA SHOULD NOT BE CONSIDERED A CERTIFIED DOCUMENT."

DATE PREPARED
7/19/2020

ROUTE I-29 STATE MO
DISTRICT K-C SHEET NO. 57

COUNTY
PLATTE

JOB NO.
J413291

CONTRACT ID.

PROJECT NO.

BRIDGE NO.

DATE	DESCRIPTION
.	.
.	.
.	.
.	.
.	.
.	.

MISSOURI HIGHWAYS AND TRANSPORTATION COMMISSION





105 WEST CAPITAL
JEFFERSON CITY, MO 65102
1-888-ASK-MODOT (1-888-275-6636)

Burns & McDonnell Engineering Co., Inc.
9400 Ward Parkway
Kansas City, Missouri 64114
816-333-9400
Certificate of Authority
No. : 000165
BMOB Project No. 109387

IF A SEAL IS PRESENT ON THIS SHEET IT HAS BEEN ELECTRONICALLY SEALED AND DATED.

NOTES:

- 1. ALL EXISTING PAVEMENT MARKINGS IN CONFLICT WITH THE PAVEMENT MARKINGS SHOWN ON THIS SHEET ARE TO BE REMOVED.
- 2. ALL LANE AND EDGE LINES SHALL BE EPOXY. ALL INTERSECTION MARKING SHALL BE PREFORMED THERMOPLASTIC.
- 3. ALL MARKINGS OTHER THAN DOTTED AND INTERMITTENT LINES SHALL BE HIGH BUILD WATERBONE PAVEMENT MARKING.
- 4. DOTTED WHITE LINES SHALL BE 2' STRIPE WITH A 3' GAP.
- 5. INTERMITTENT WHITE LINES SHALL BE 10' STRIPE 30' GAP.

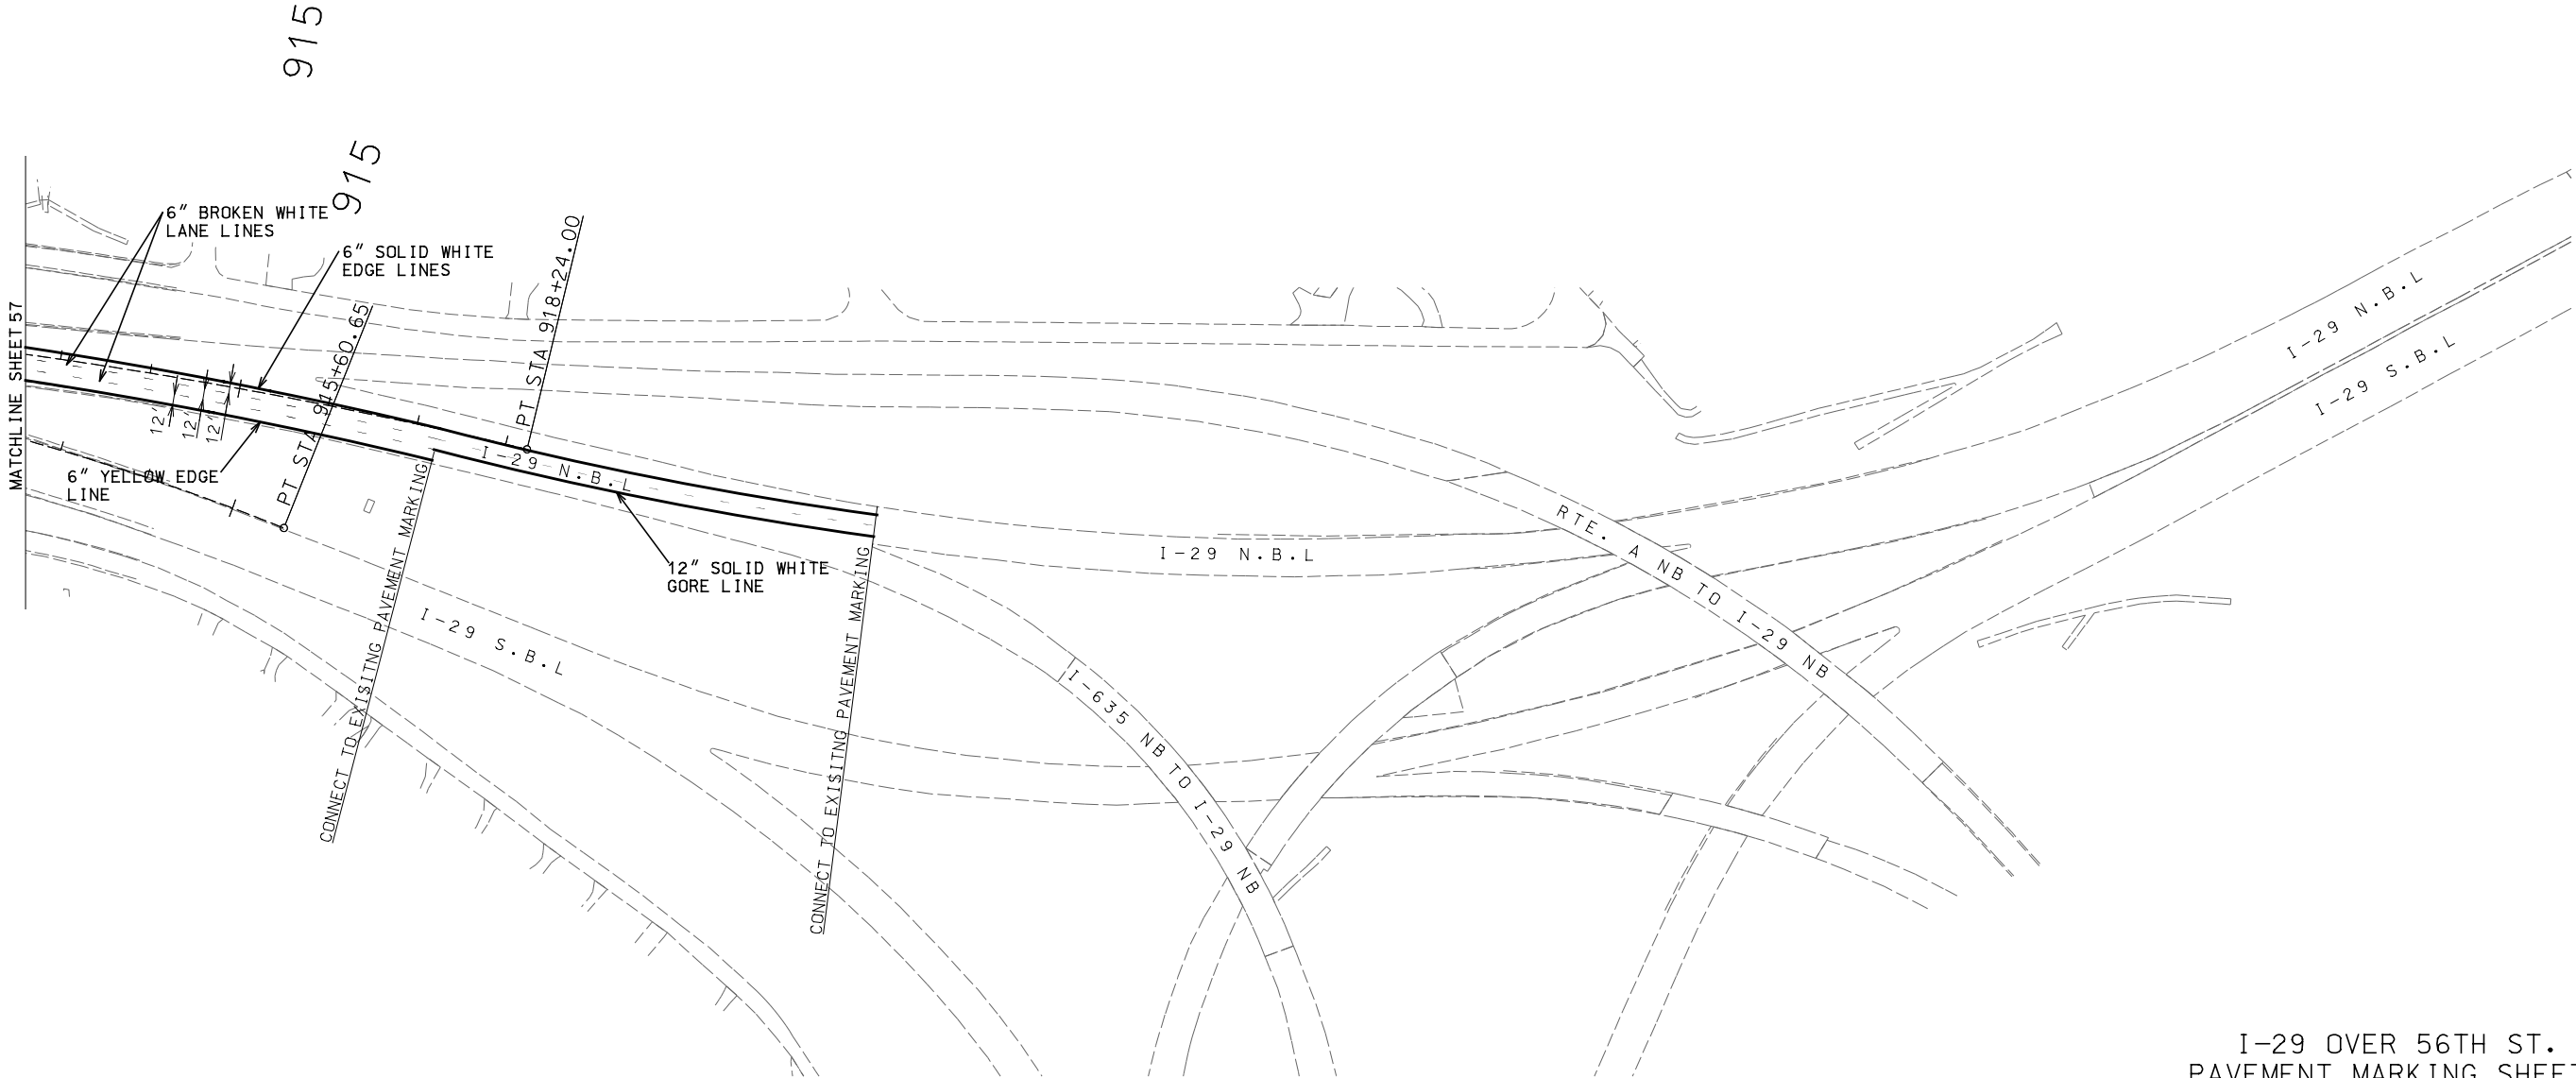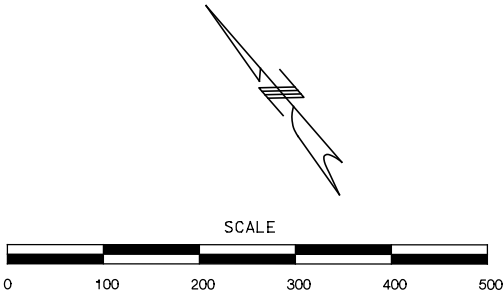

I-29 OVER 56TH ST.
PAVEMENT MARKING SHEETS
SHEET 2 OF 3

"THIS MEDIA SHOULD NOT BE CONSIDERED A CERTIFIED DOCUMENT."

DATE PREPARED 7/19/2020	
ROUTE I-29	STATE MO
DISTRICT K-C	SHEET NO. 58
COUNTY PLATTE	
JOB NO. J413291	
CONTRACT ID. .	
PROJECT NO. .	
BRIDGE NO. .	

DATE	DESCRIPTION
.	.
.	.
.	.
.	.
.	.
.	.

MISSOURI HIGHWAYS AND TRANSPORTATION COMMISSION



105 WEST CAPITAL
JEFFERSON CITY, MO 65102
1-888-ASK-MODOT (1-888-275-6636)

Burns & McDonnell Engineering Co., Inc.

9400 Ward Parkway
Kansas City, Missouri 64114
816-333-9400

Certificate of Authority
No. : 000165

BMd Project No. 109387

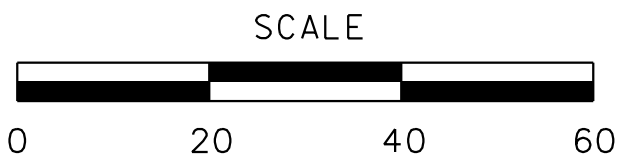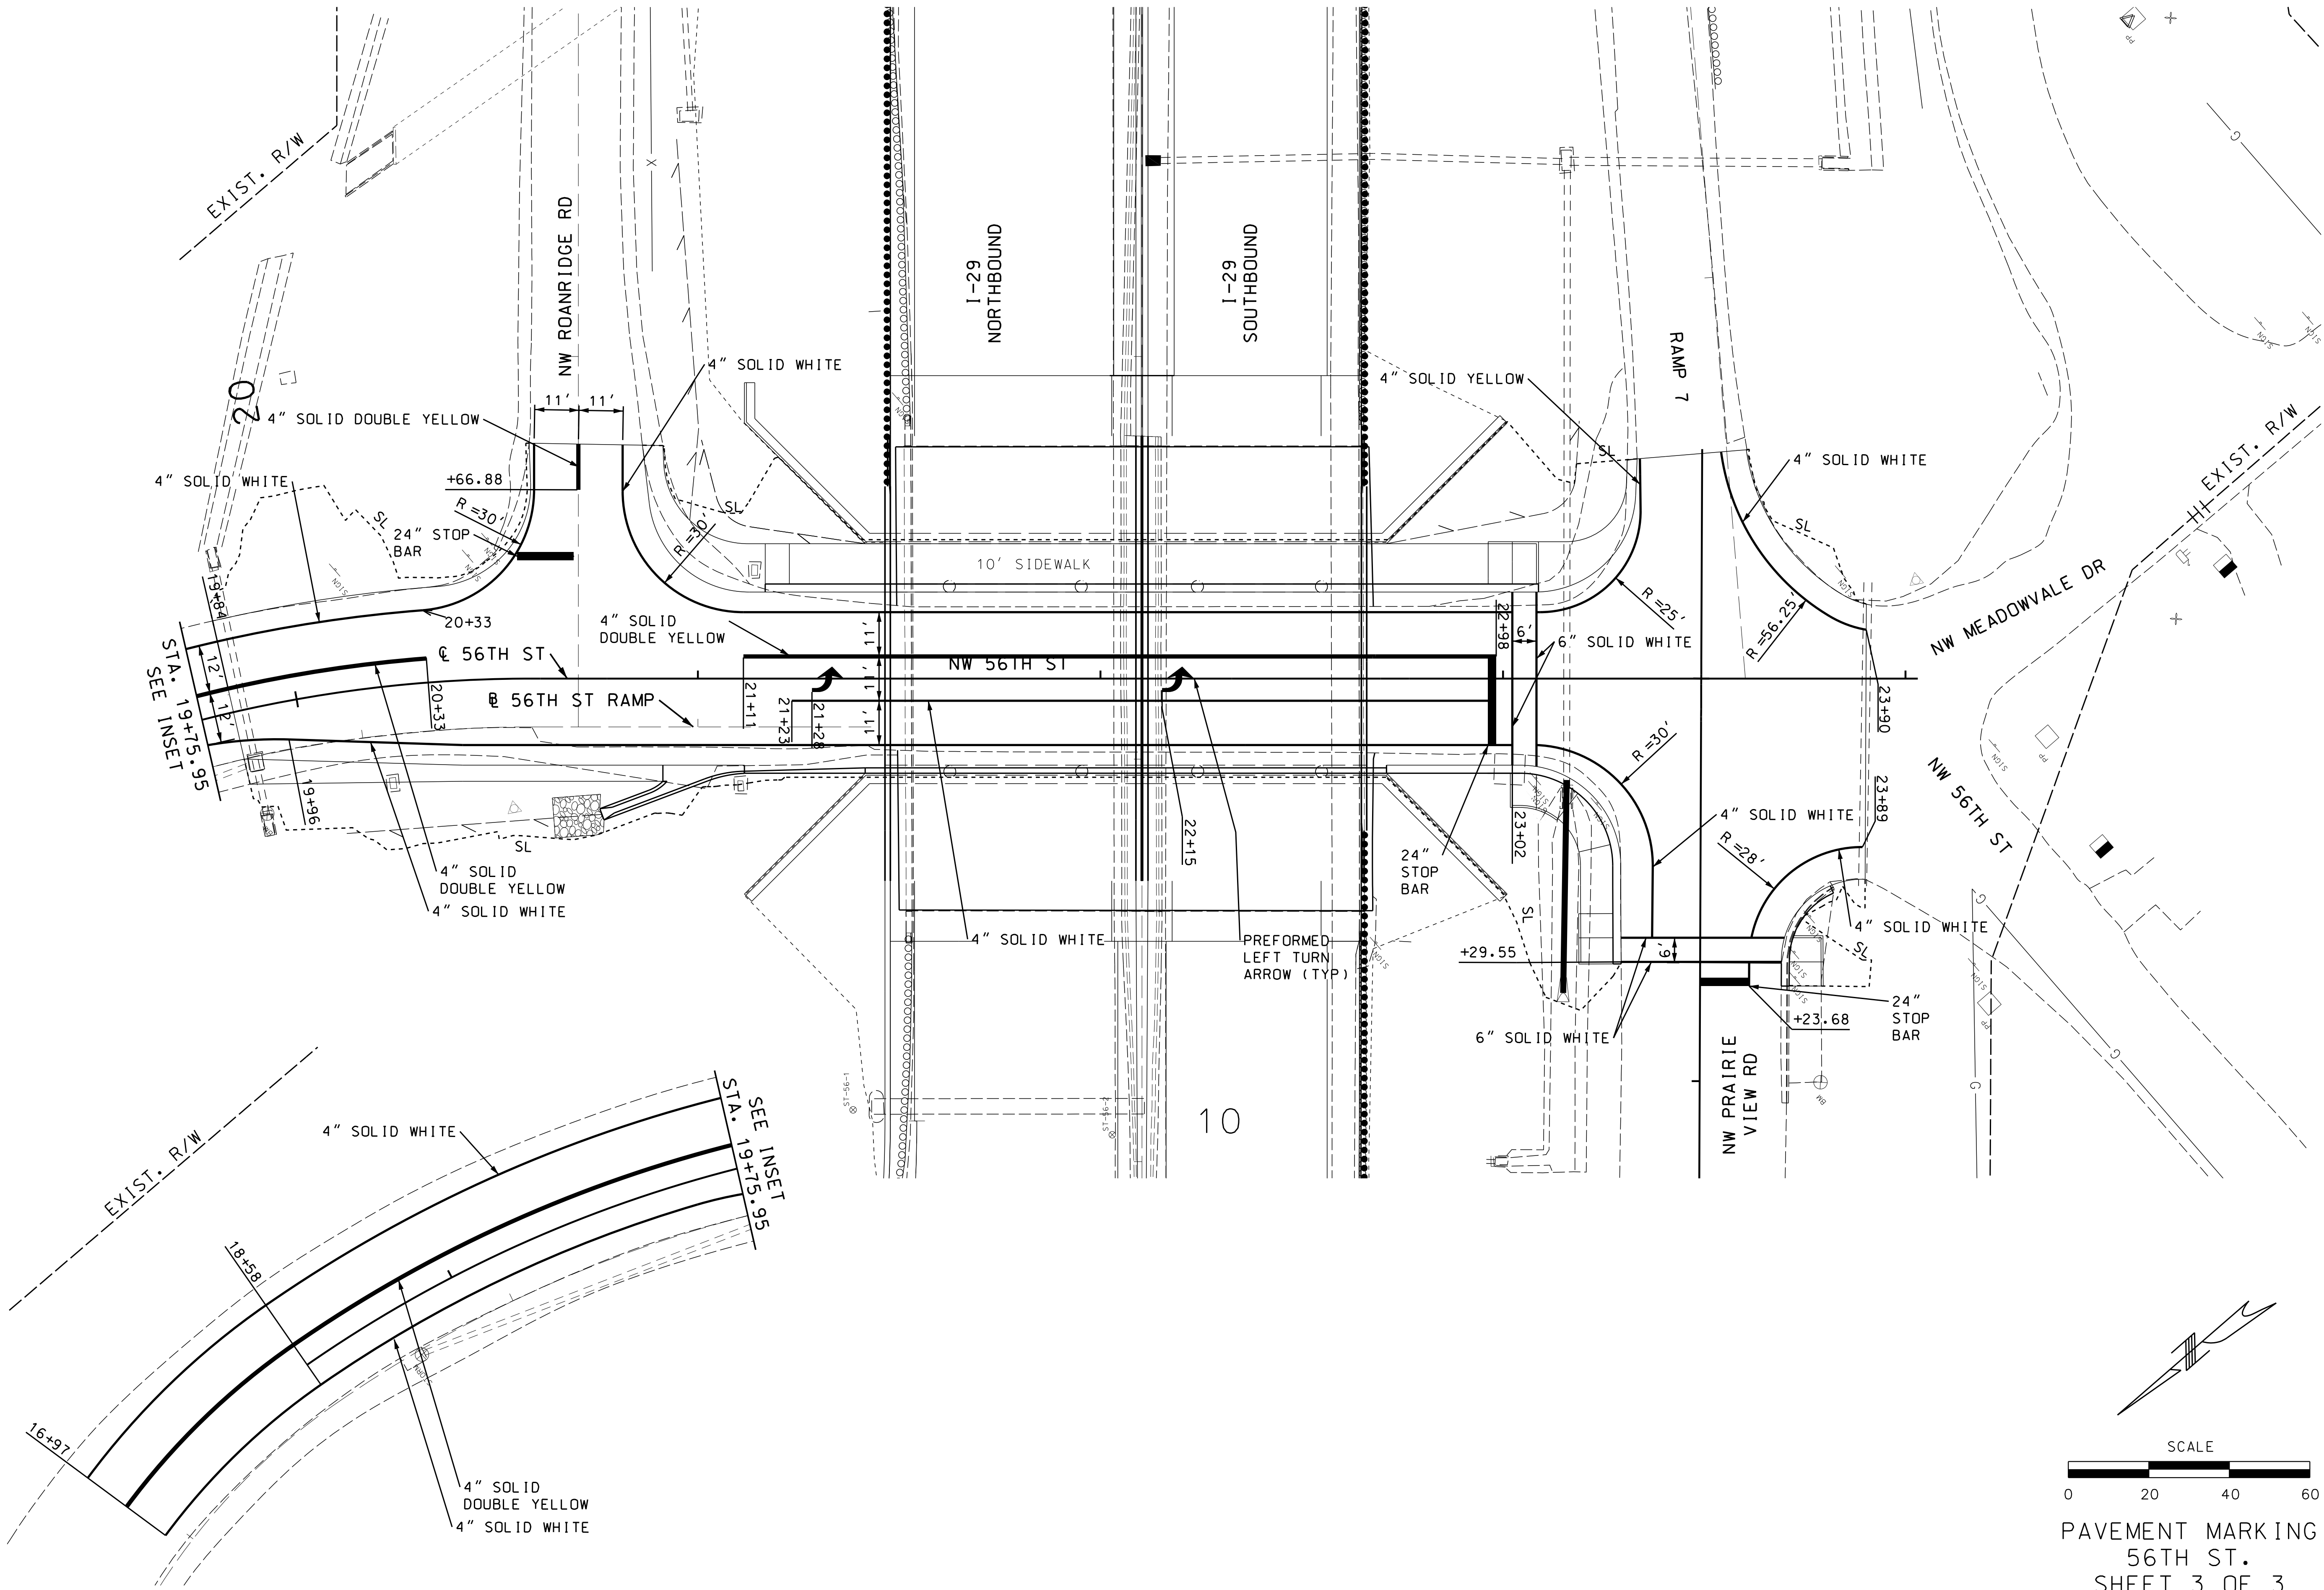

PAVEMENT MARKING
56TH ST.
SHEET 3 OF 3

DATE PREPARED
6/26/2020

ROUTE
I-29

DISTRICT
KC

COUNTY
PLATTE

JOB NO.
J413291

CONTRACT ID.

PROJECT NO.

BRIDGE NO.

STATE
MO

SHEET NO.
59

DESCRIPTION

DATE

MISSOURI HIGHWAYS AND TRANSPORTATION COMMISSION

1411 East 104th St.
Kansas City, MO 64131
Tel (816) 974-4655
Fax (816) 974-4675
www.trekdesigngroup.com

105 WEST CAPITAL
JEFFERSON CITY, MO 65102
1-888-ASK-MODOT (1-888-275-6636)

Missouri Cert. of
Authority 202010300

11

12

13

995



996

997


998

999


053_PM_J413291_I20_56THST.dgn 1:56:39 PM 6/26/2020

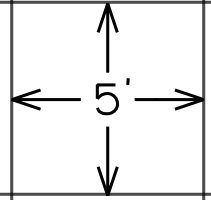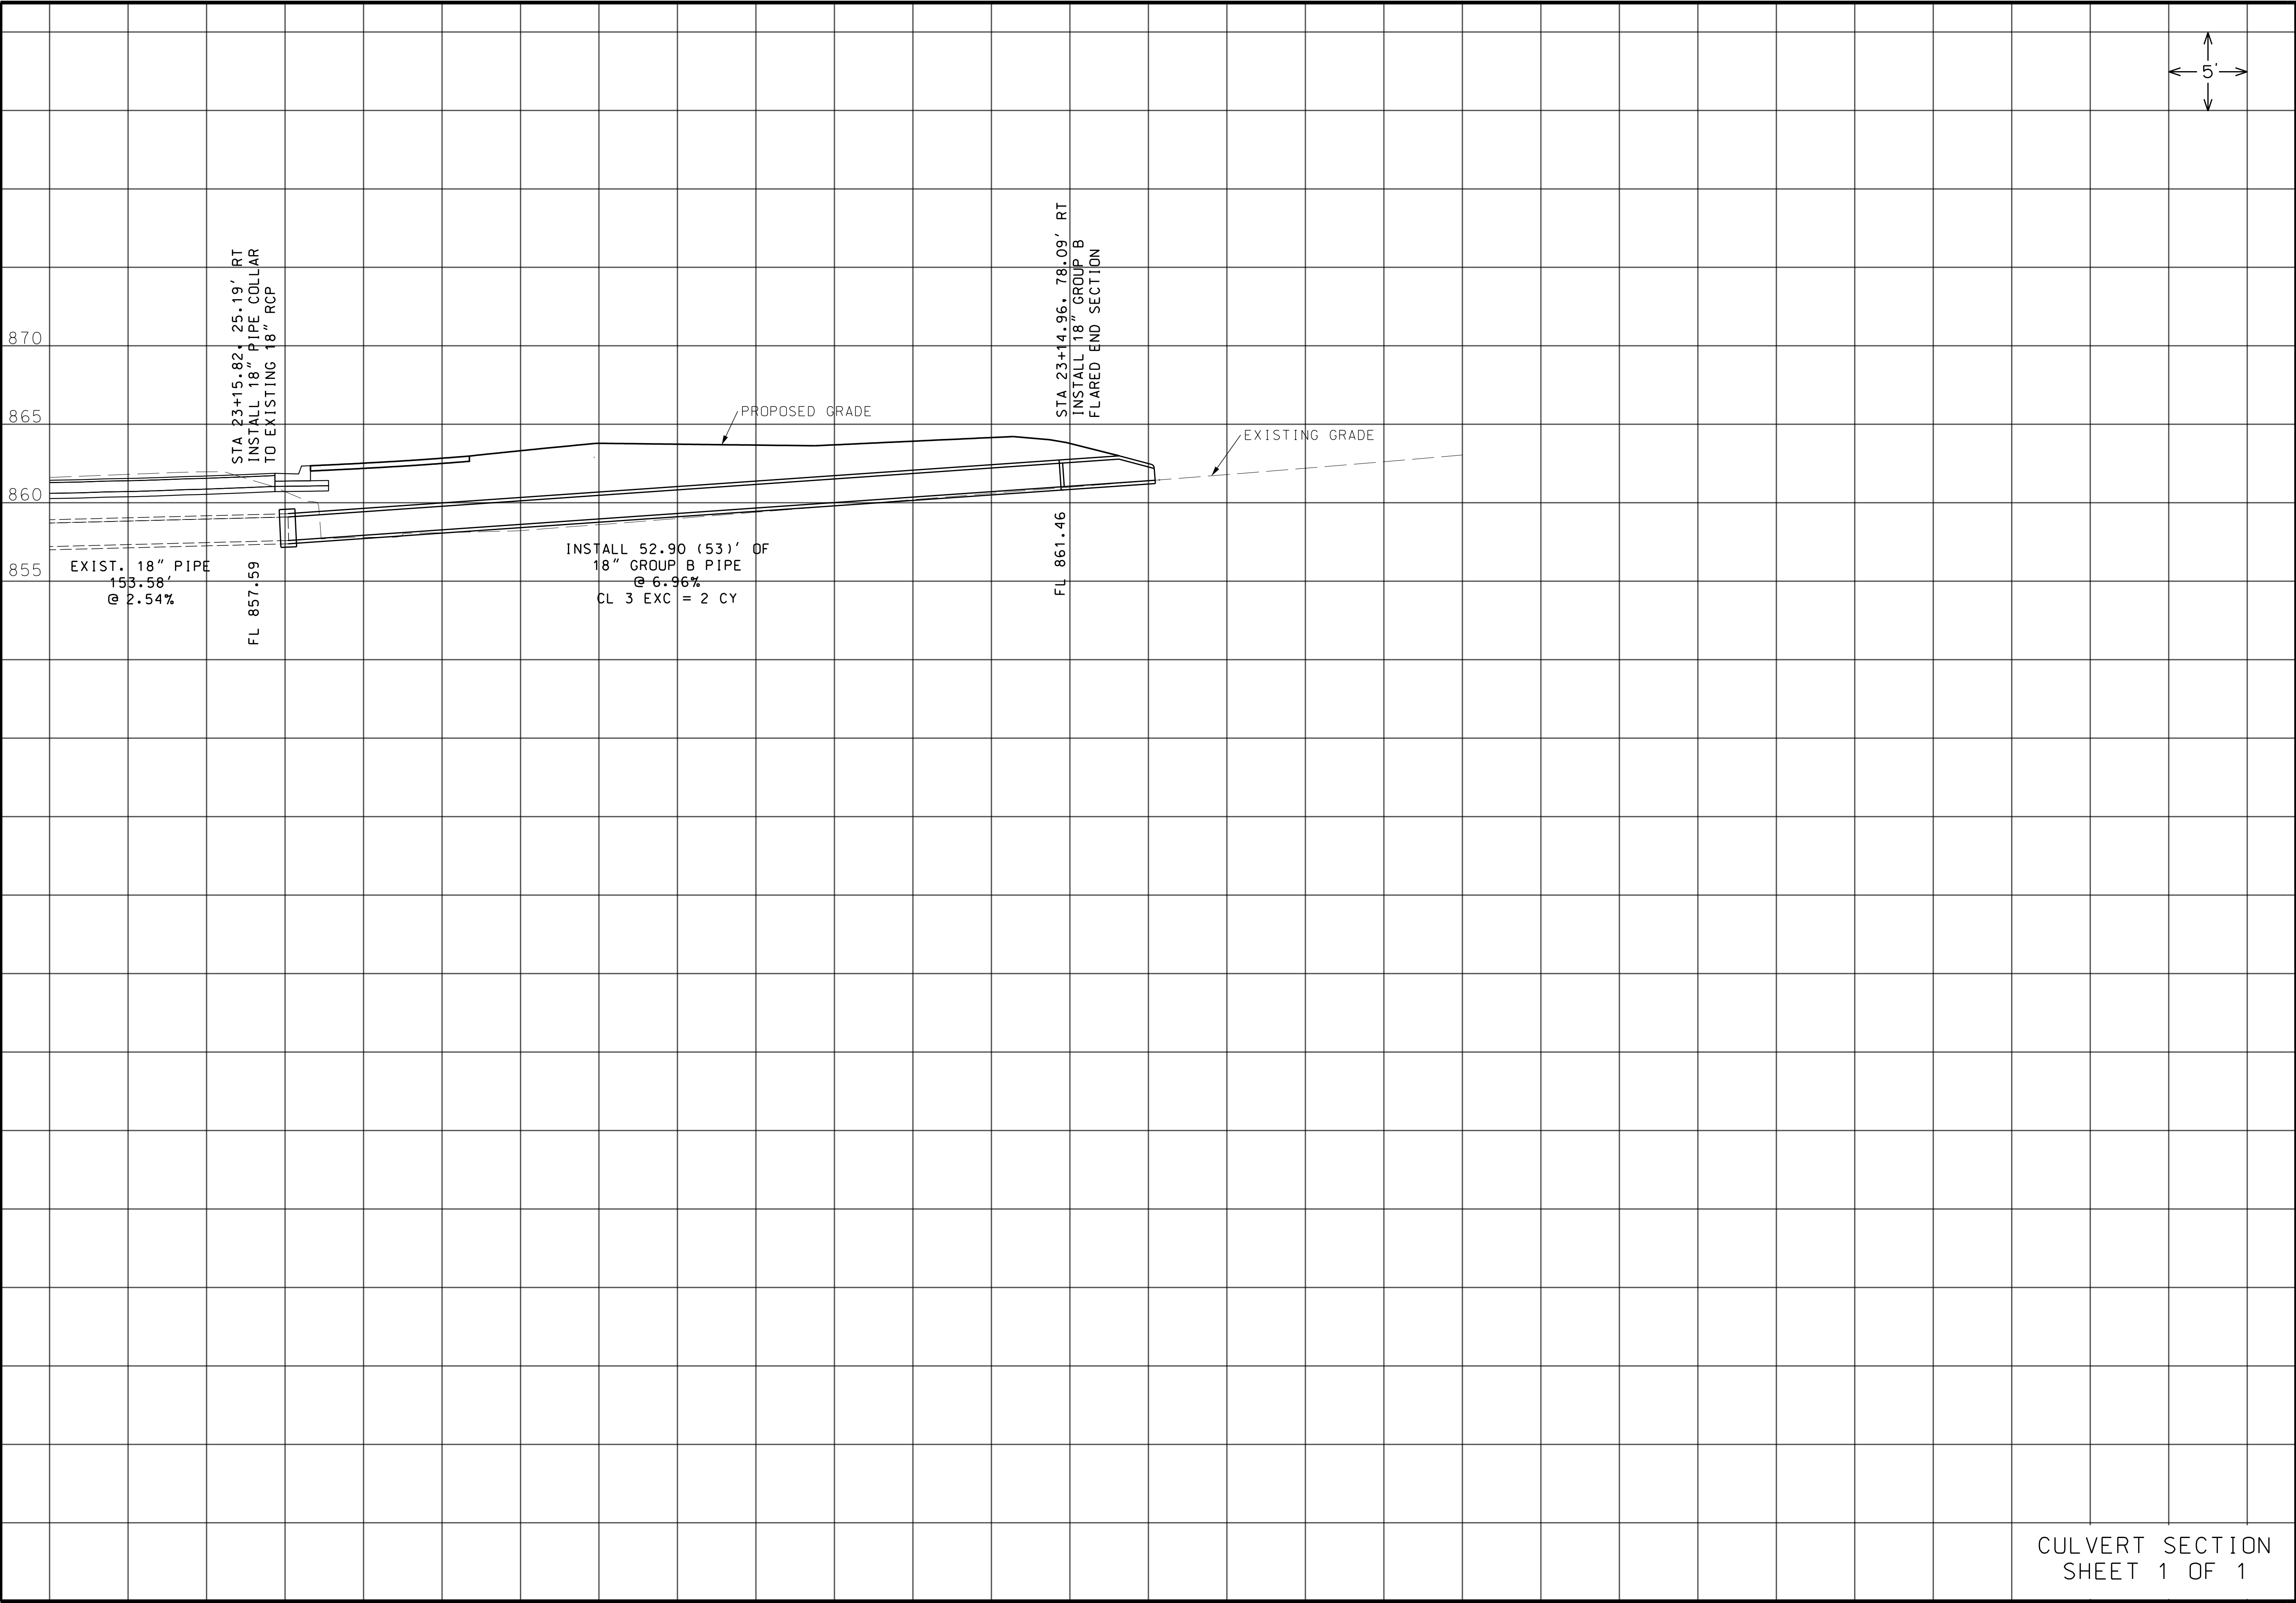

CULVERT SECTION
SHEET 1 OF 1

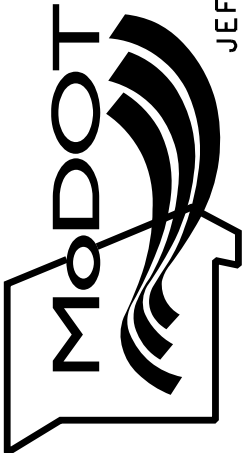DATE PREPARED 6/26/2020	
ROUTE I-29	STATE MO
DISTRICT KC	SHEET NO. 60
COUNTY PLATTE	
JOB NO. J413291	
CONTRACT ID.	
PROJECT NO.	
BRIDGE NO.	
DESCRIPTION	
DATE	
MISSOURI HIGHWAYS AND TRANSPORTATION COMMISSION	
	
105 WEST CAPITAL JEFFERSON CITY, MO 65102 1-888-ASK-MODOT (1-888-275-6636)	
1411 East 104th St. Kansas City, MO 64131 Tel (816) 974-4655 Fax (816) 974-4675 www.trekdesigngroup.com	
Missouri Cert. of Authority 202010300	
TREKK DESIGN GROUP, LLC	

IF A SEAL IS PRESENT ON THIS SHEET IT HAS BEEN ELECTRONICALLY SEALED AND DATED.

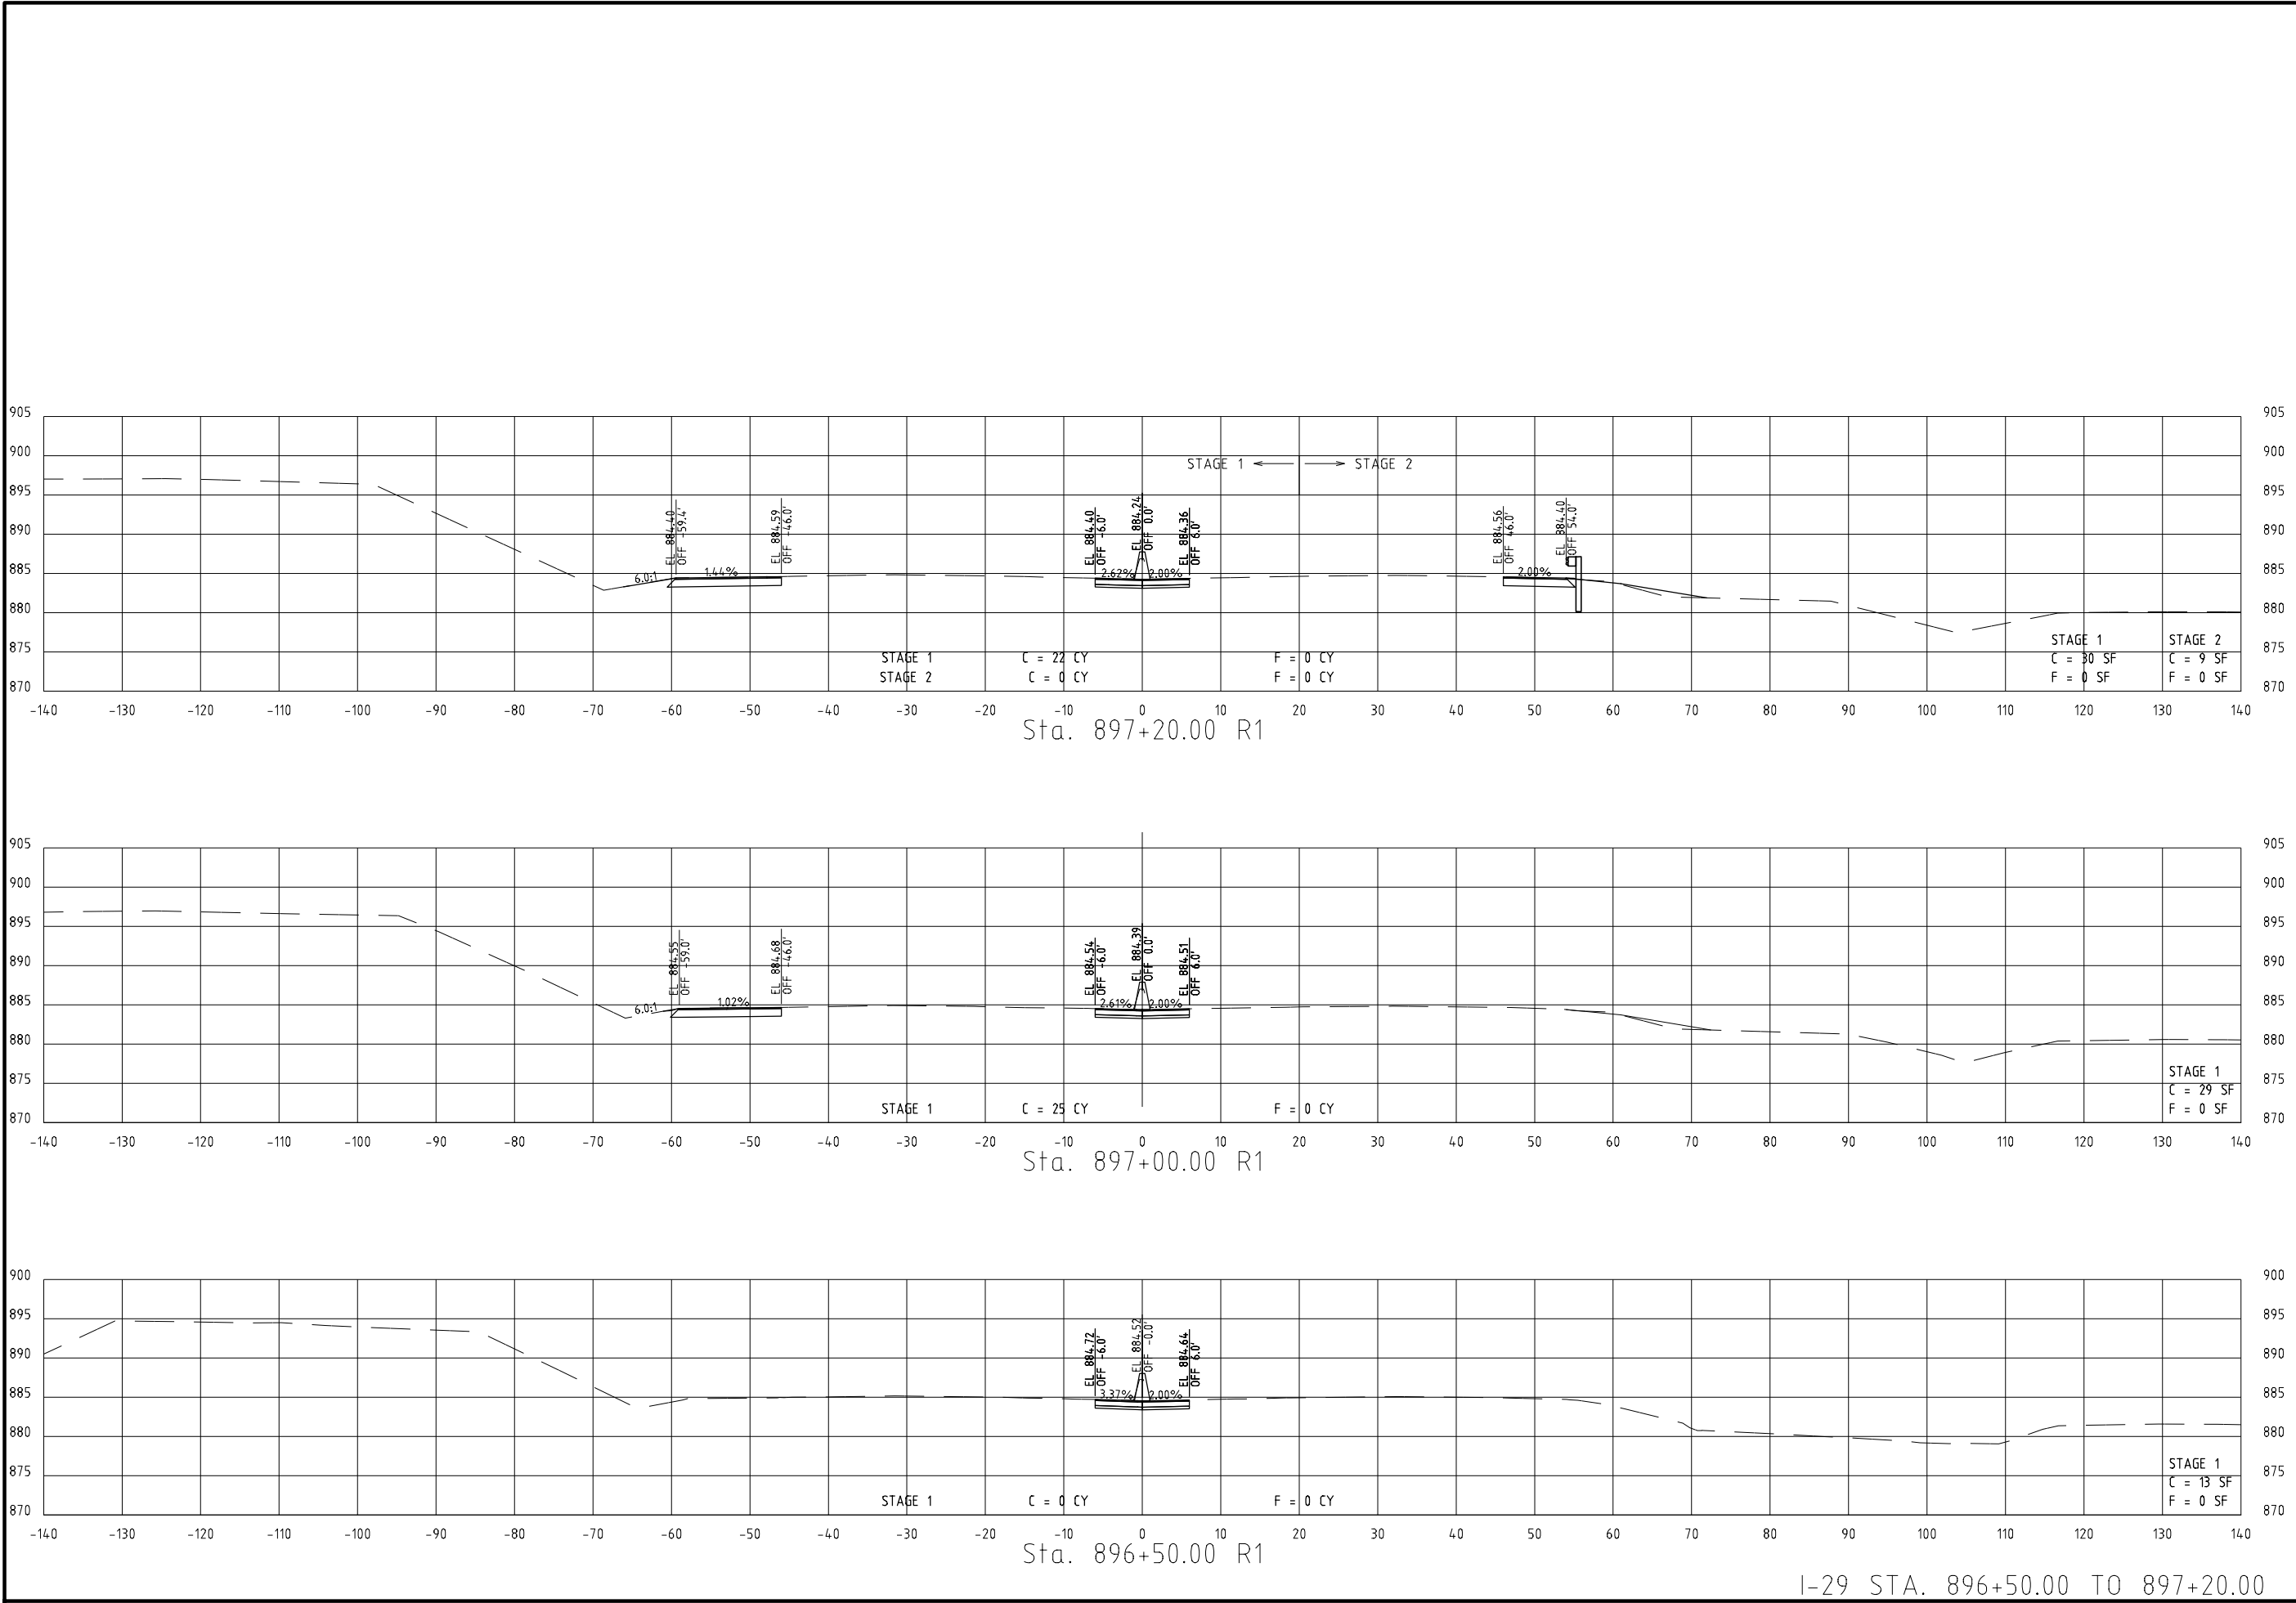

THIS MEDIA SHOULD NOT BE CONSIDERED A CERTIFIED DOCUMENT.

DATE PREPARED 7/19/2020	
ROUTE I-29	STATE MO
DISTRICT K-C	SHEET NO. 1
COUNTY PLATTE	
JOB NO. J413291	
CONTRACT ID.	
PROJECT NO.	
BRIDGE NO.	

DESCRIPTION	DATE

MISSOURI HIGHWAYS AND TRANSPORTATION COMMISSION

MoDOT

105 WEST CAPITAL
JEFFERSON CITY, MO 65102
1-888-ASK-MODOT (1-888-278-6636)





Burns & McDonnell Engineering Co., Inc.

9400 Ward Parkway
Kansas City, Missouri 64114
816-333-9400

Certificate of Authority
No. : 000165
BMOB Project No. 109387

BURNS MEDONNELL

REV.

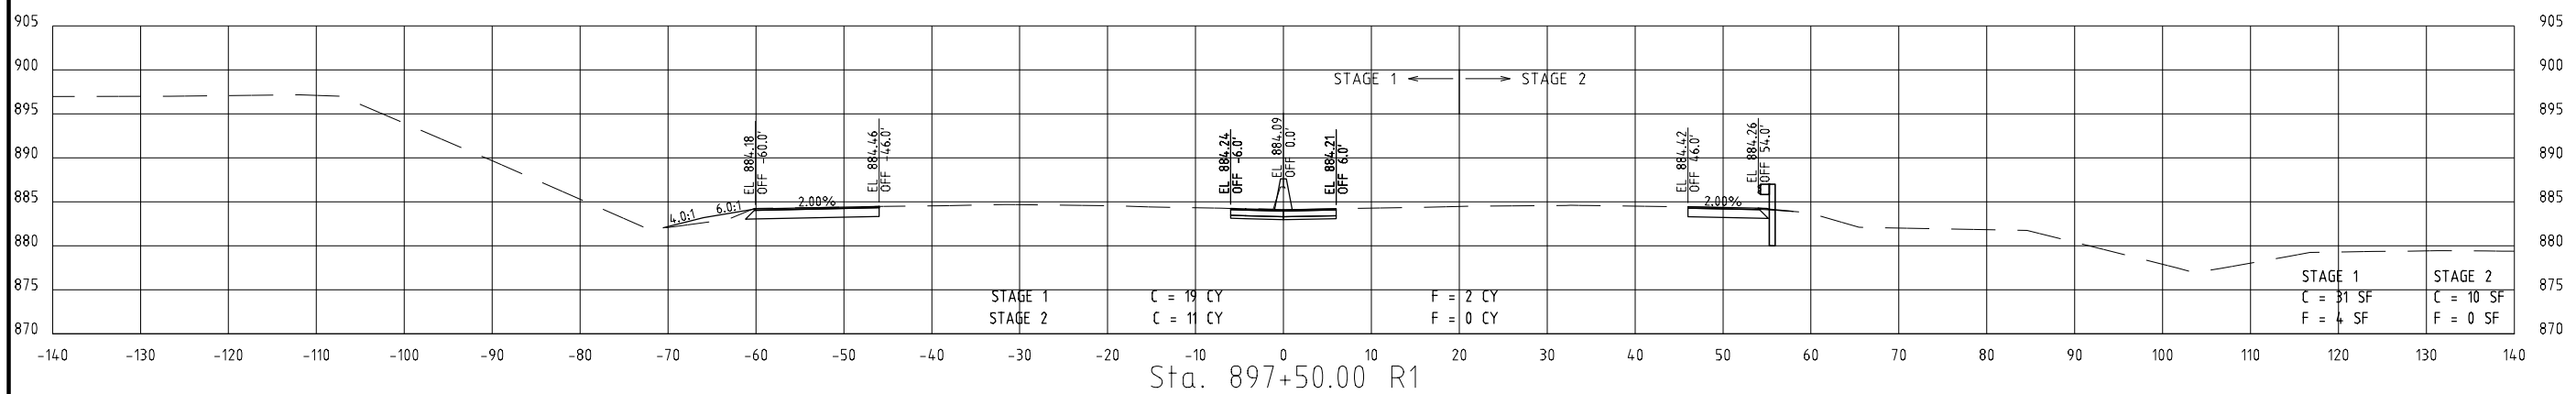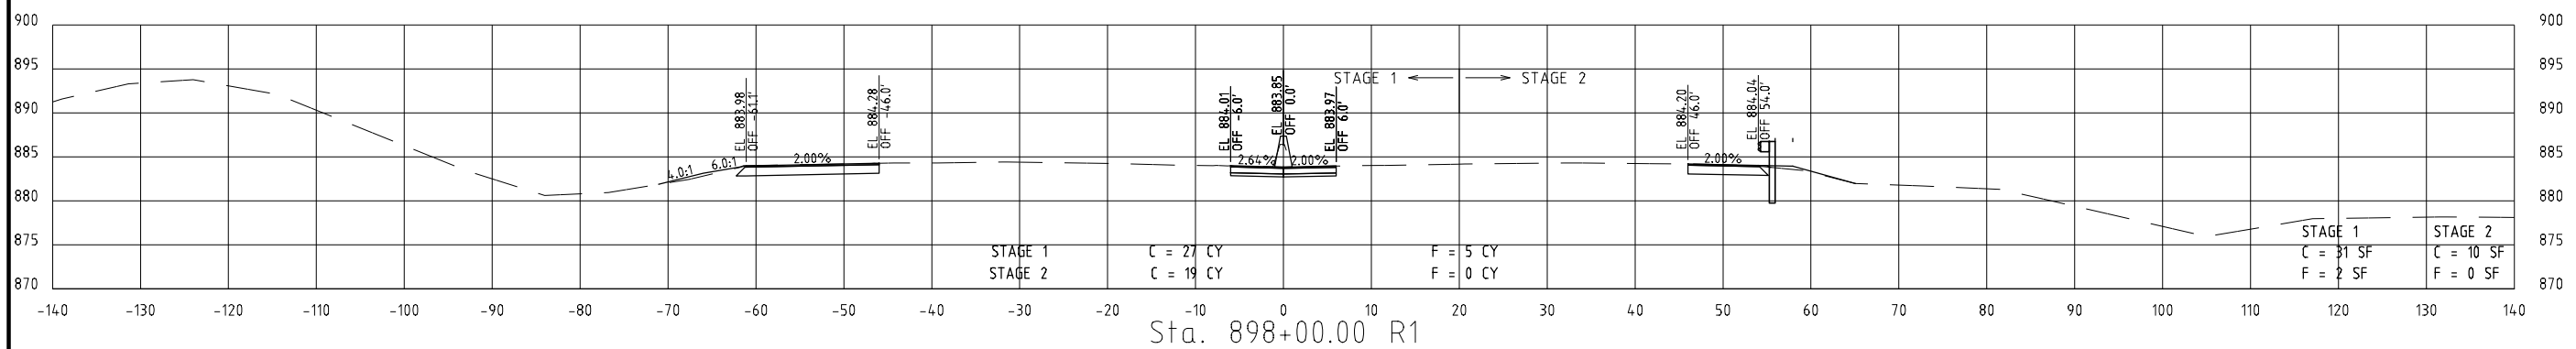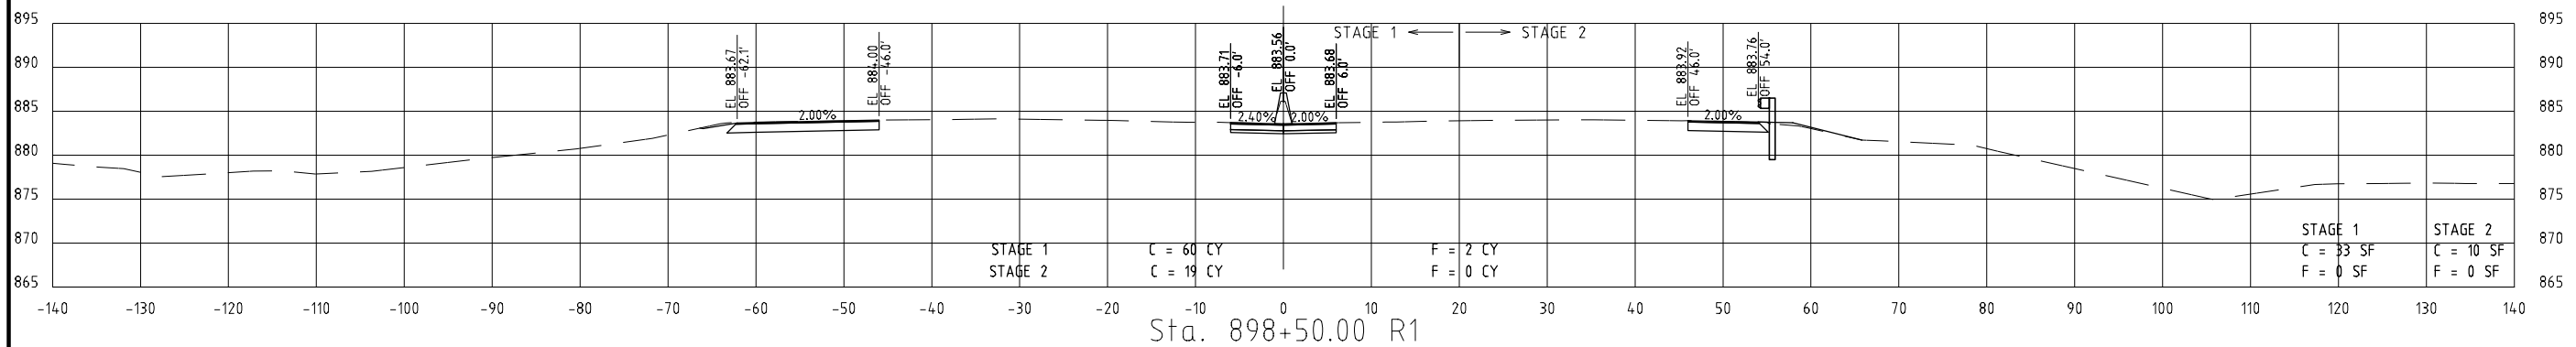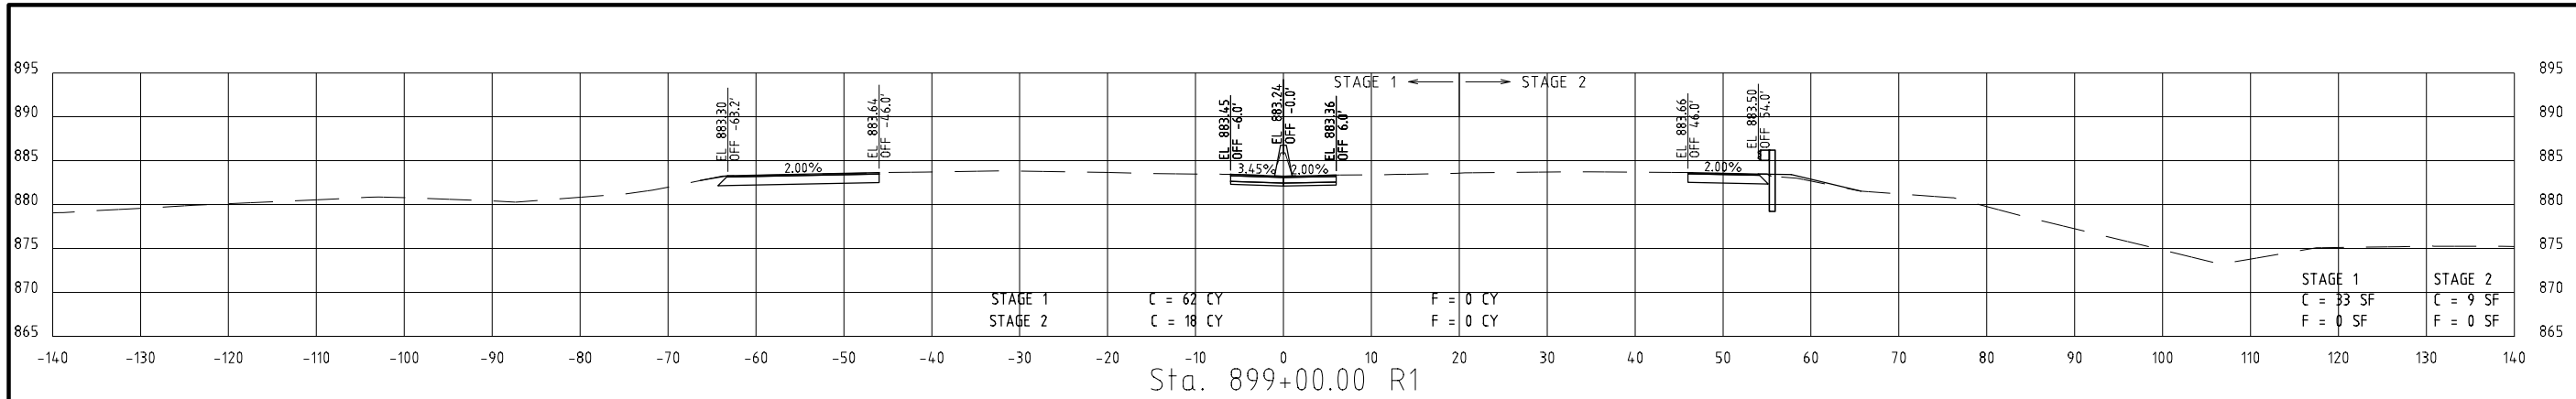

I-29 STA. 897+50.00 TO 899+00.00

"THIS MEDIA SHOULD NOT BE CONSIDERED A CERTIFIED DOCUMENT."

DATE PREPARED
7/19/2020

ROUTE I-29	STATE MO
DISTRICT K-C	SHEET NO. 2

COUNTY
PLATTE

JOB NO.
J413291

CONTRACT ID.
.

PROJECT NO.
.

BRIDGE NO.
.

DATE	DESCRIPTION
.	.
.	.
.	.
.	.
.	.
.	.

MISSOURI HIGHWAYS AND TRANSPORTATION COMMISSION





MoDOT

105 WEST CAPITAL
JEFFERSON CITY, MO 65102
1-888-ASK-MODOT (1-888-275-6636)

Burns & McDonnell Engineering Co., Inc.
9400 Ward Parkway
Kansas City, Missouri 64114
816-333-9400

BURNS MEDONNELL

Certificate of Authority
No. : 000165
BMOB Project No. 109387

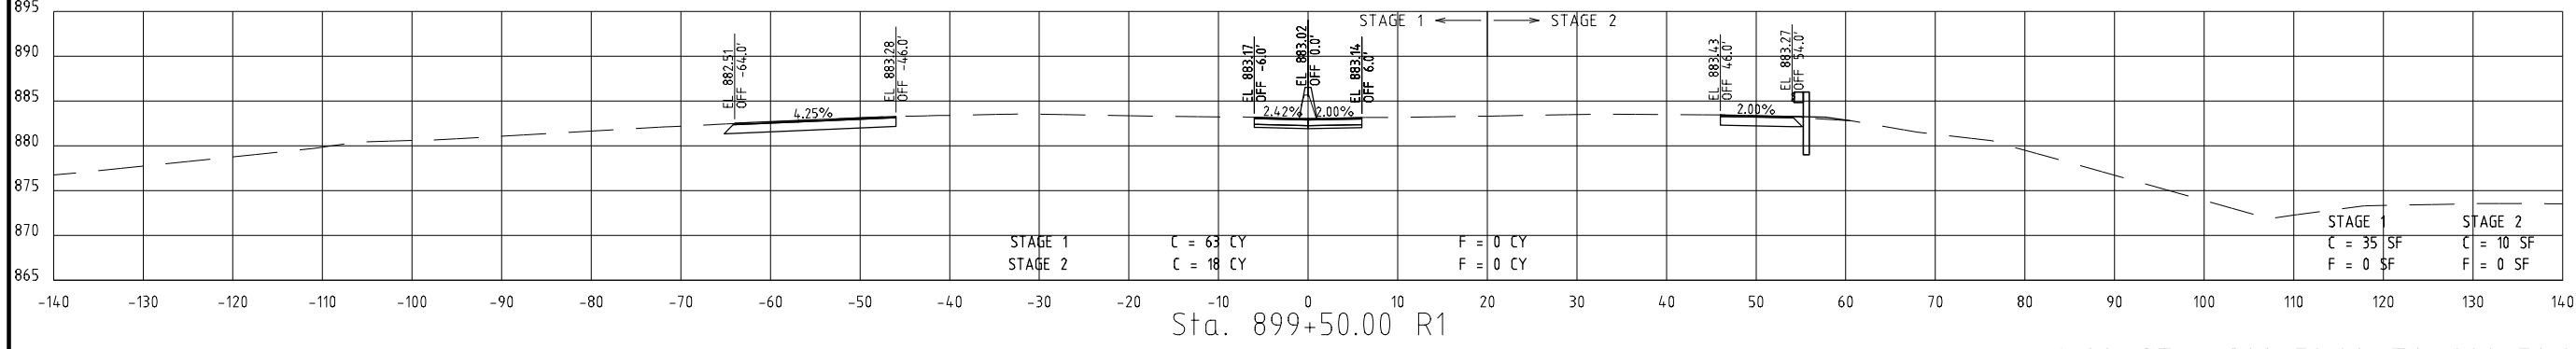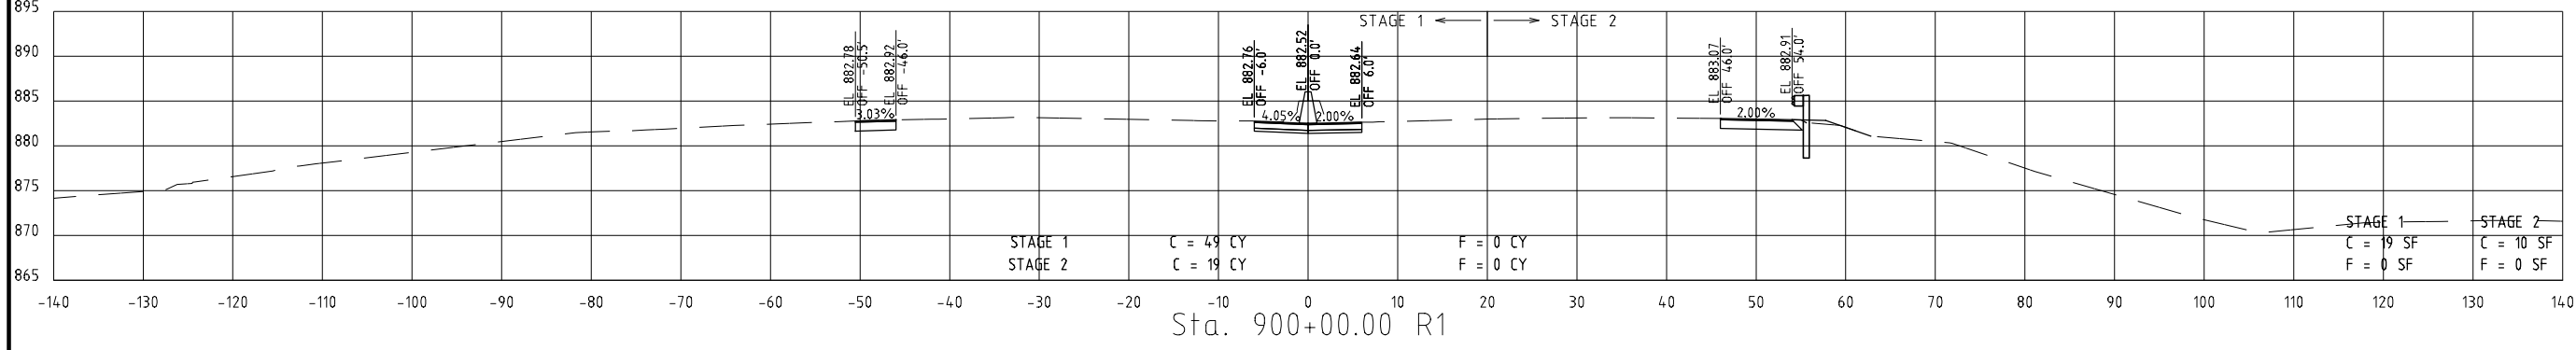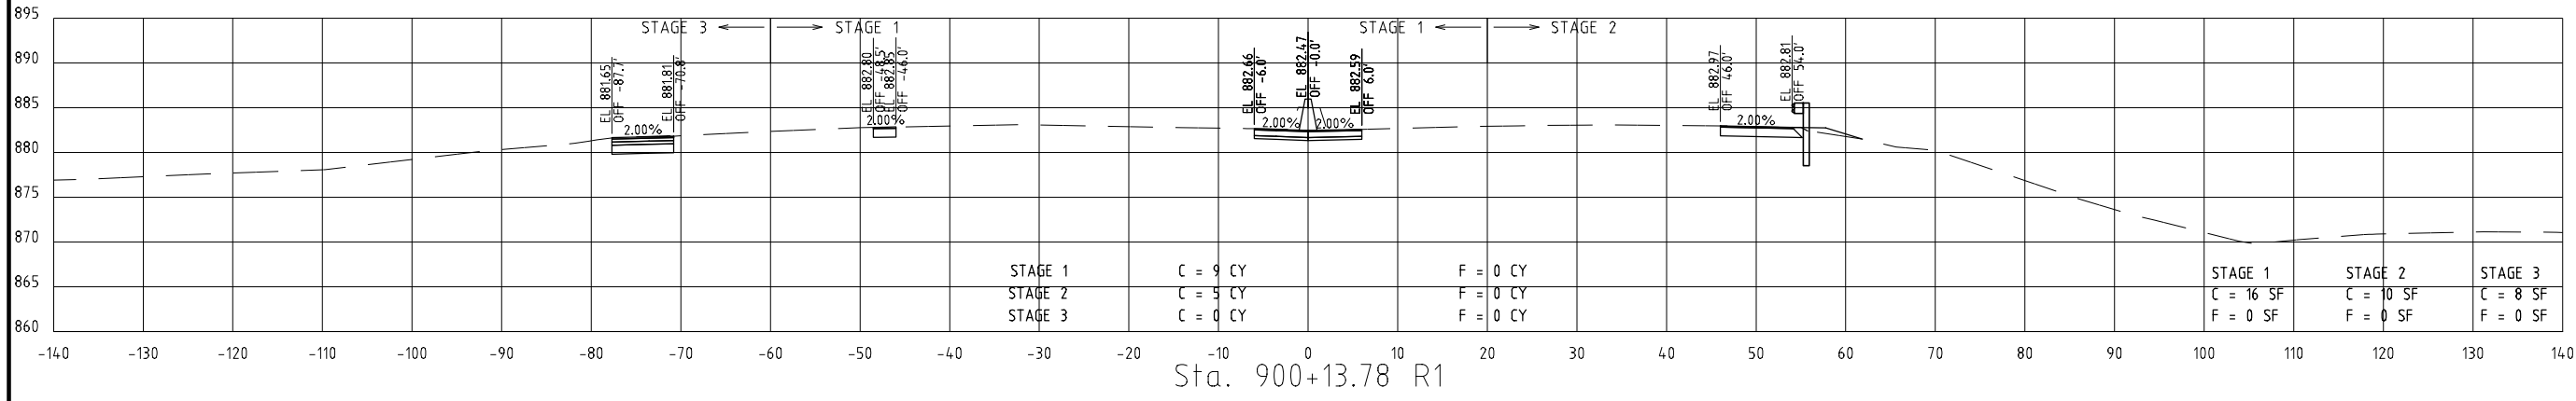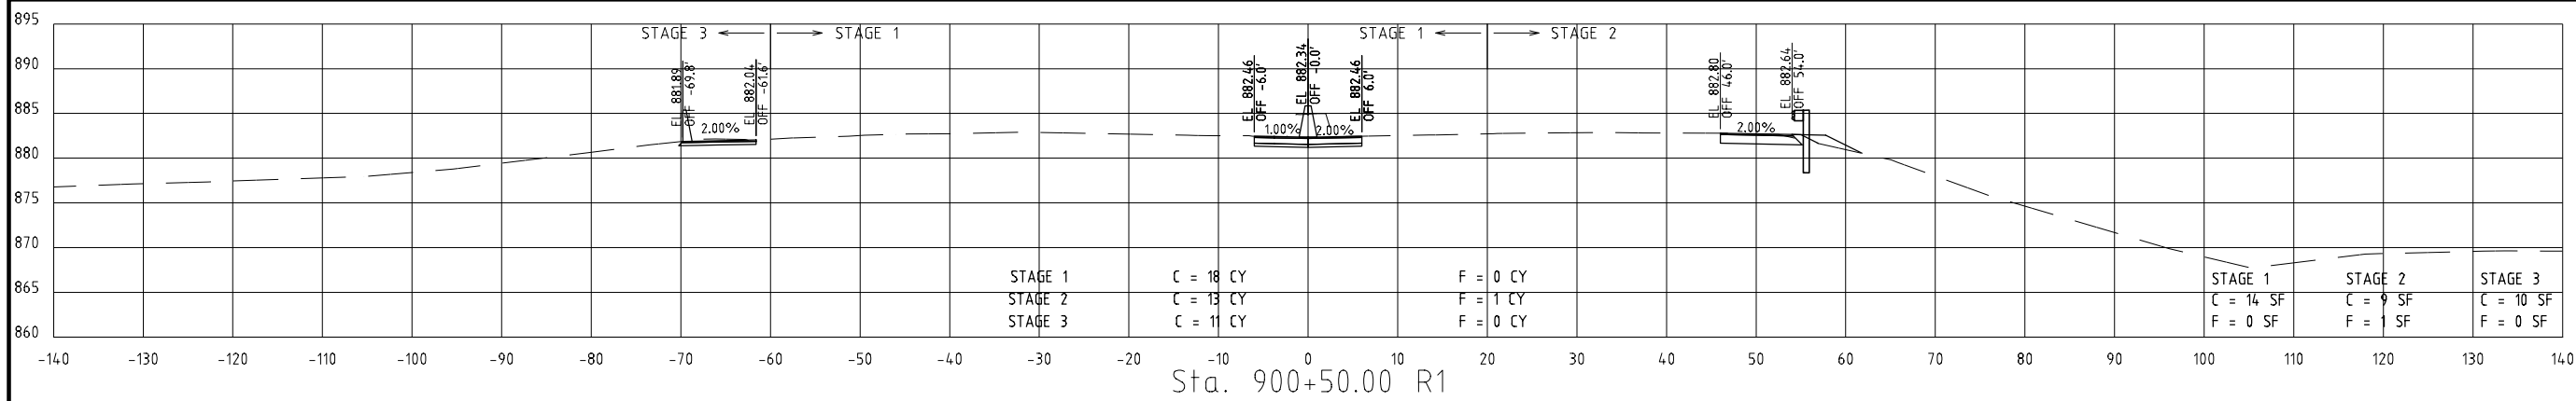

I-29 STA. 899+50.00 TO 900+50.00

"THIS MEDIA SHOULD NOT BE CONSIDERED A CERTIFIED DOCUMENT."

DATE PREPARED
7/19/2020

ROUTE
I-29
DISTRICT
K-C

STATE
MO
SHEET NO.
3

COUNTY
PLATTE

JOB NO.
J413291

CONTRACT ID.

PROJECT NO.

BRIDGE NO.

DATE	DESCRIPTION
.	.
.	.
.	.
.	.
.	.
.	.

MISSOURI HIGHWAYS AND TRANSPORTATION COMMISSION


105 WEST CAPITAL
JEFFERSON CITY, MO 65102
1-888-ASK-MODOT (1-888-278-6636)

Burns & McDonnell Engineering Co., Inc.

9400 Ward Parkway
Kansas City, Missouri 64114
816-333-9400

Certificate of Authority
No. : 000165

BMD Project No. 109387

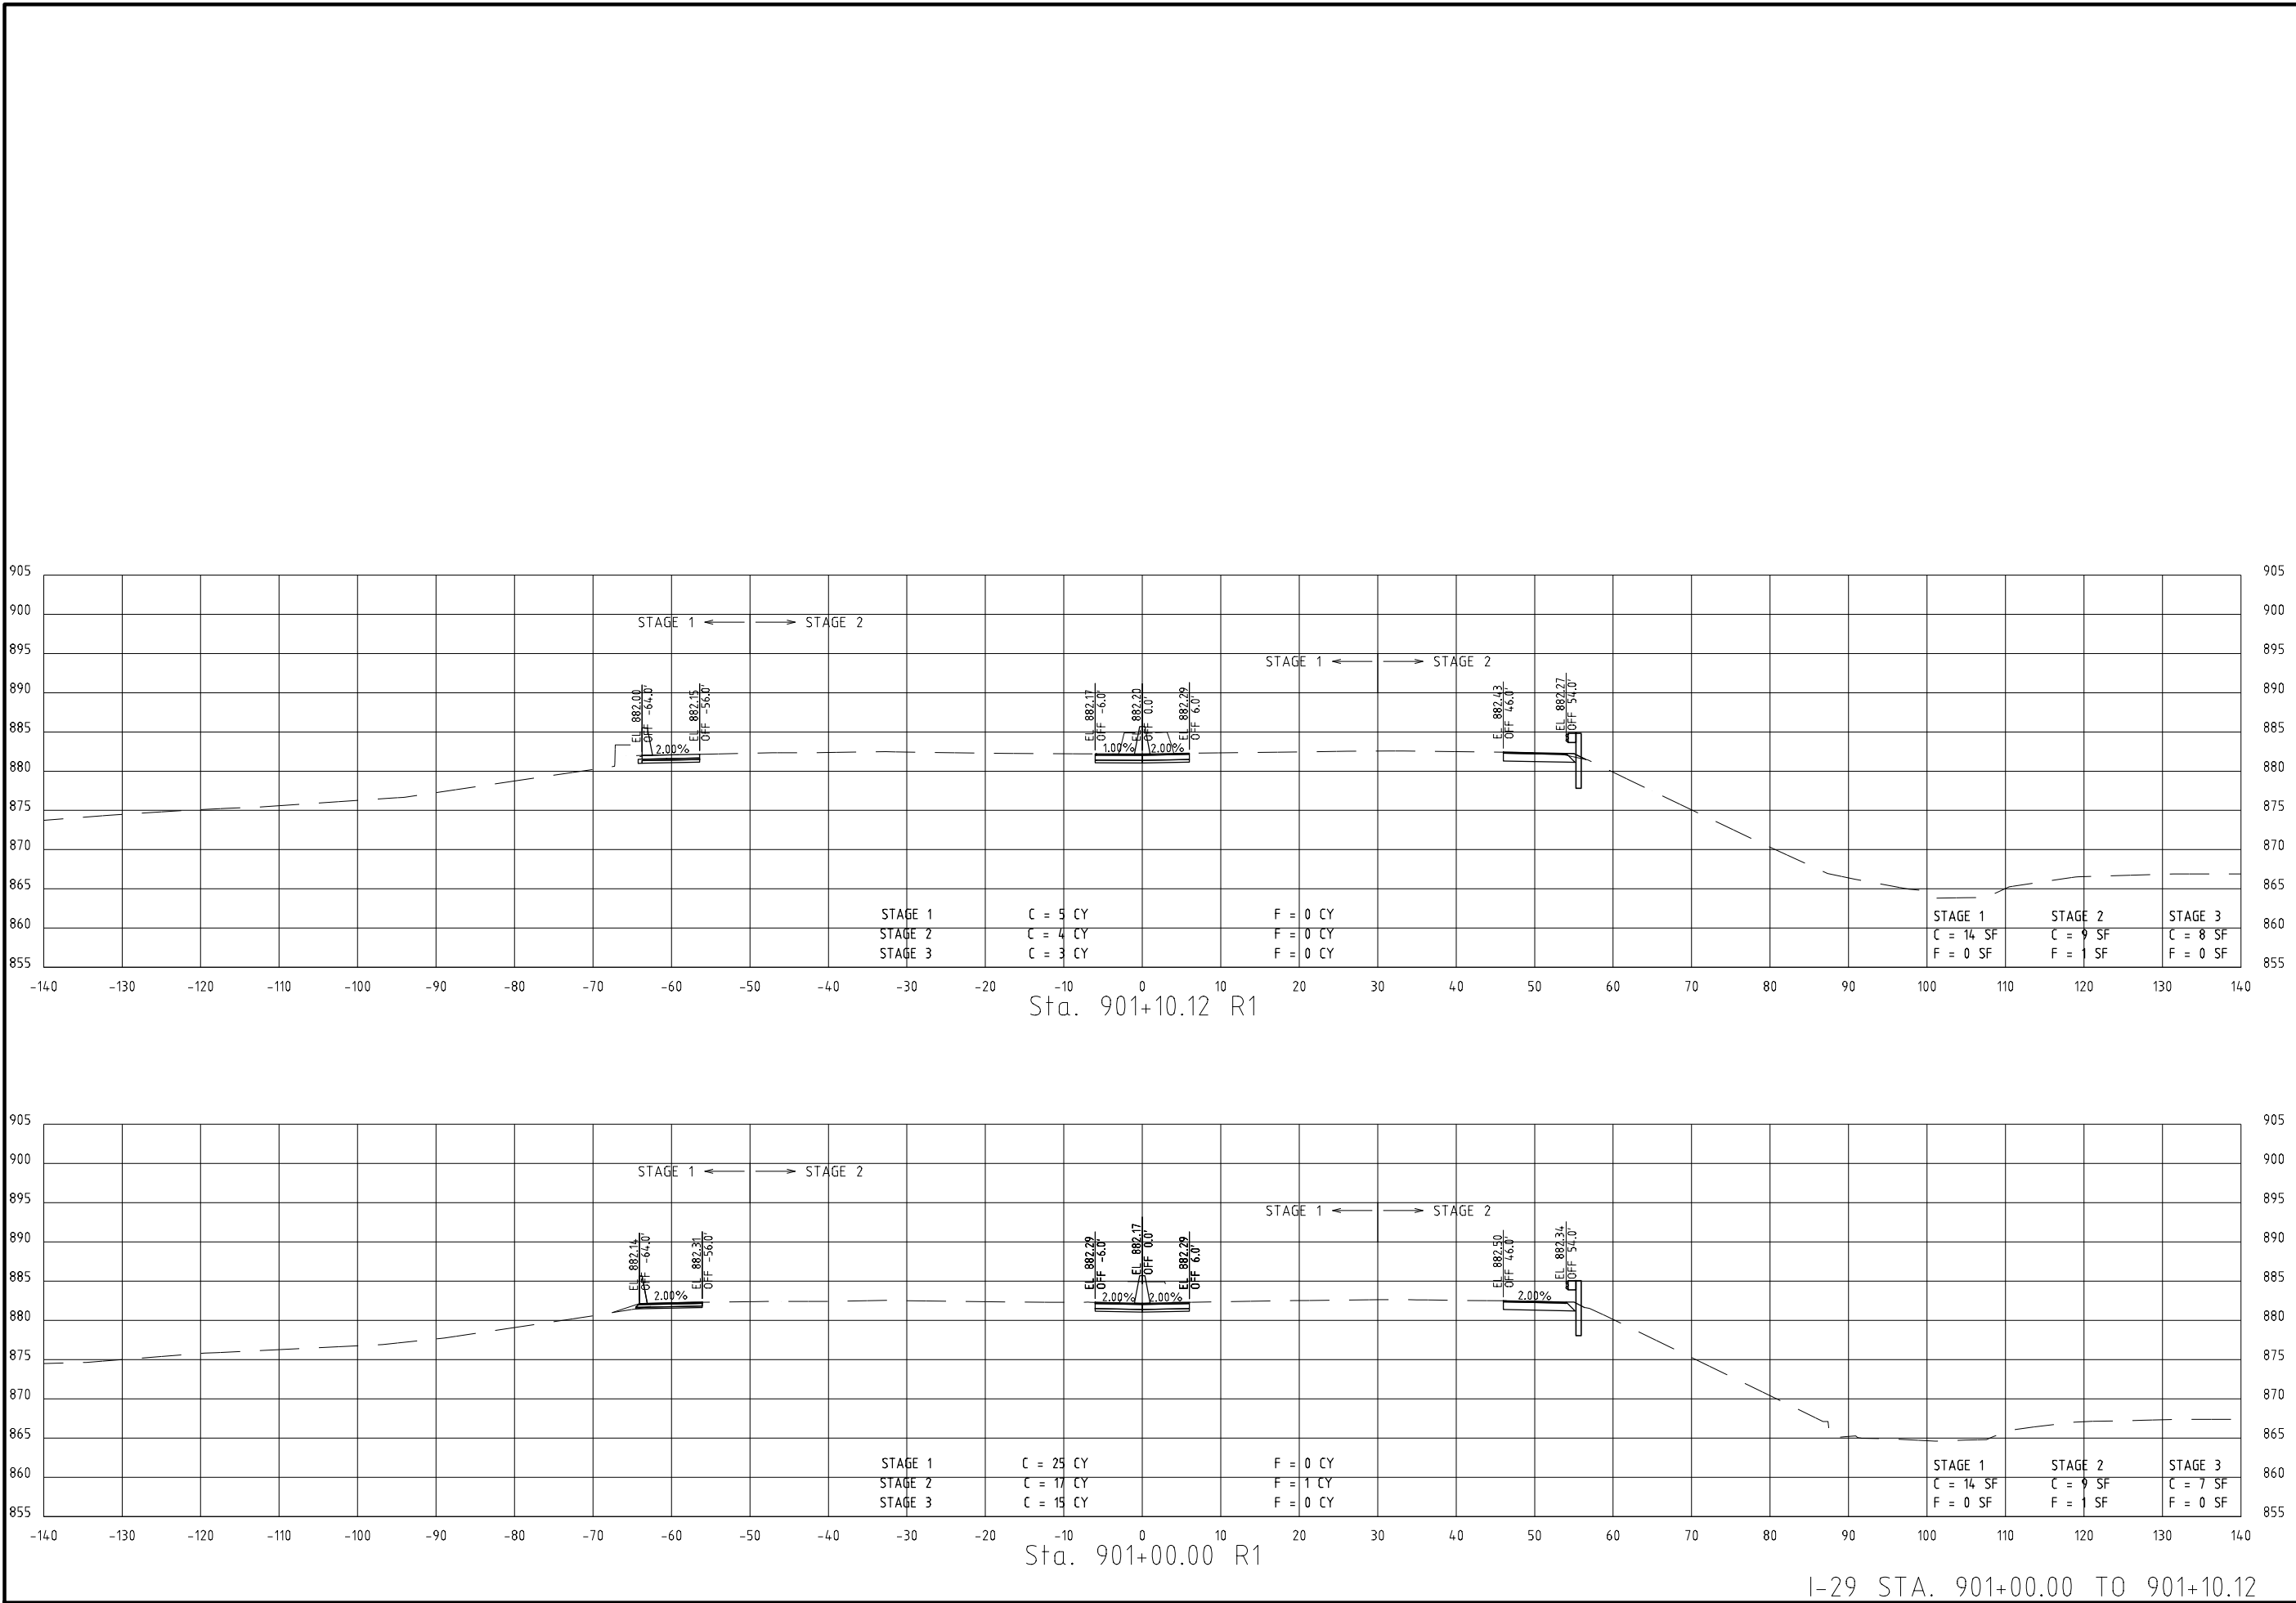

I-29 STA. 901+00.00 TO 901+10.12

\\bmcd\dfs\Clients\TRN\MODOT\109387_129Bridges\Design\CADD\Ref_Files\J413291_56\XS_129.dgn

5:35:24 PM

7/19/2020

"THIS MEDIA SHOULD NOT BE CONSIDERED A CERTIFIED DOCUMENT."

DATE PREPARED
7/19/2020

ROUTE
I-29
DISTRICT
K-C

STATE
MO
SHEET NO.
4

COUNTY
PLATTE

JOB NO.
J413291

CONTRACT ID.
.

PROJECT NO.
.

BRIDGE NO.
.

DATE	DESCRIPTION
.	.
.	.
.	.
.	.
.	.
.	.

MISSOURI HIGHWAYS AND TRANSPORTATION COMMISSION



105 WEST CAPITAL
JEFFERSON CITY, MO 65102
1-888-ASK-MODOT (1-888-275-6636)

Burns & McDonnell Engineering Co., Inc.

9400 Ward Parkway
Kansas City, Missouri 64114
816-333-9400

Certificate of Authority
No. : 000165

BMOB Project No. 109387



REV.

IF A SEAL IS PRESENT ON THIS SHEET IT HAS BEEN ELECTRONICALLY SEALED AND DATED.

ROUTE	STATE
-------	-------

DISTRICT	SHEET NO.
----------	-----------

RS	S
COUNTY	

JOB NO.

CONTRACT ID.

PROJECT NO.

BRIDGE NO.

--	--	--	--	--	--	--	--

7	12.1
---	------




105 WEST CAPITAL
JEFFERSON CITY, MO 65102
TEL: 656-1000 FAX: 656-1070

**BURNS
MCDONNELL**
9400 Ward Parkway
Kansas City, Missouri 64114
816-333-9400
Certificate of Authority
No. : 000165

Certificate of Authority
No. : 000165




REV.

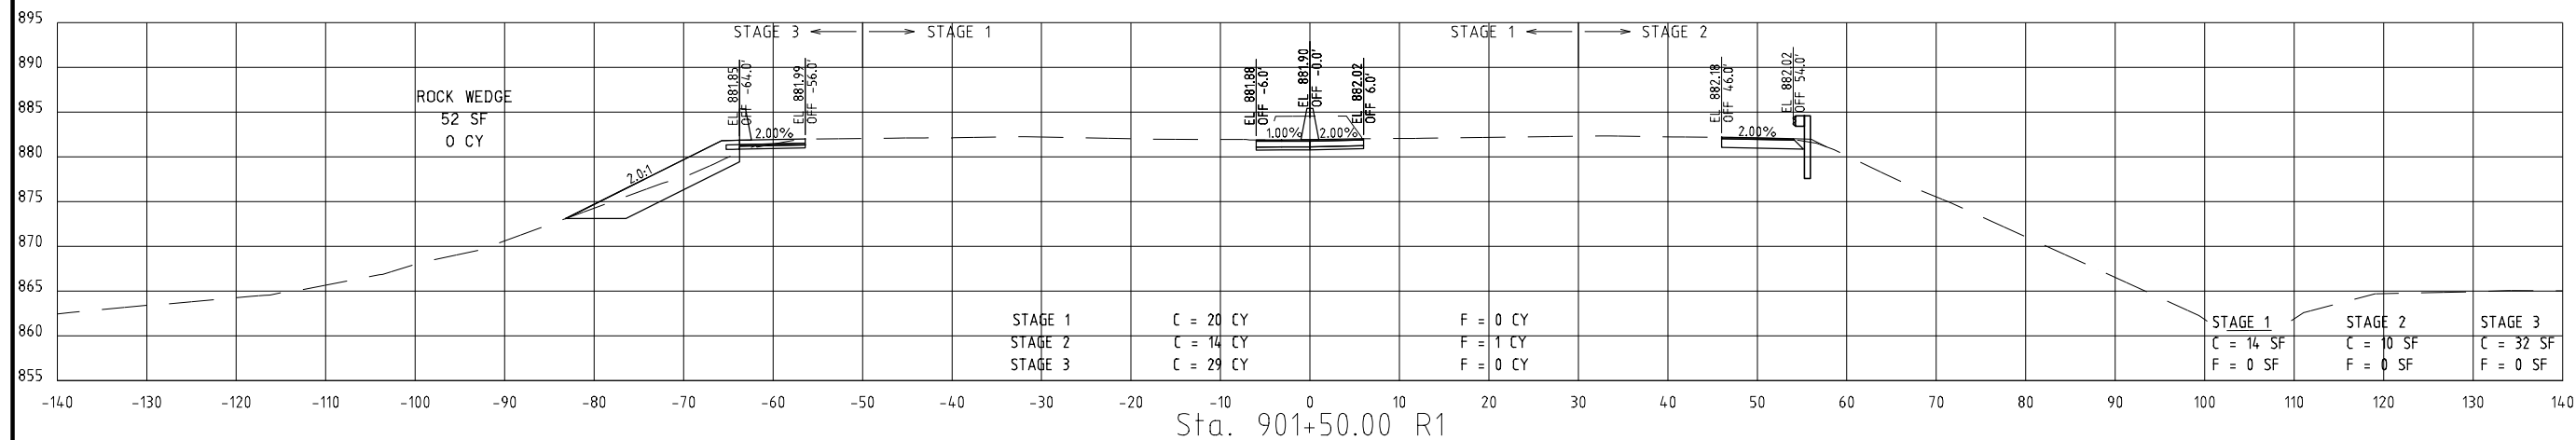


I-29 STA. 901+50.00 TO 901+54.75

STAGE 2	C = 1378 CY
STAGE 3	C = 1281 CY


STAGE 2	C = 972 CY
STAGE 3	C = 914 CY

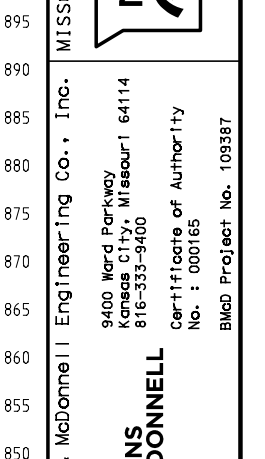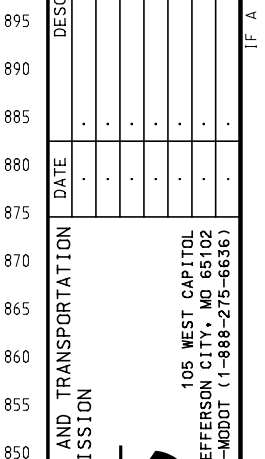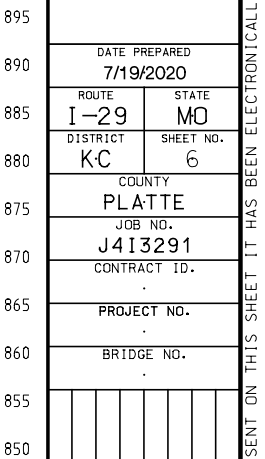


\\bmc\dfs\Clients\TRN\MODOT\109387-129Bridges\Design\CADD\Ref_Files\J413291_56\XS-129.dgn 5:35:24 PM 7/19/2020

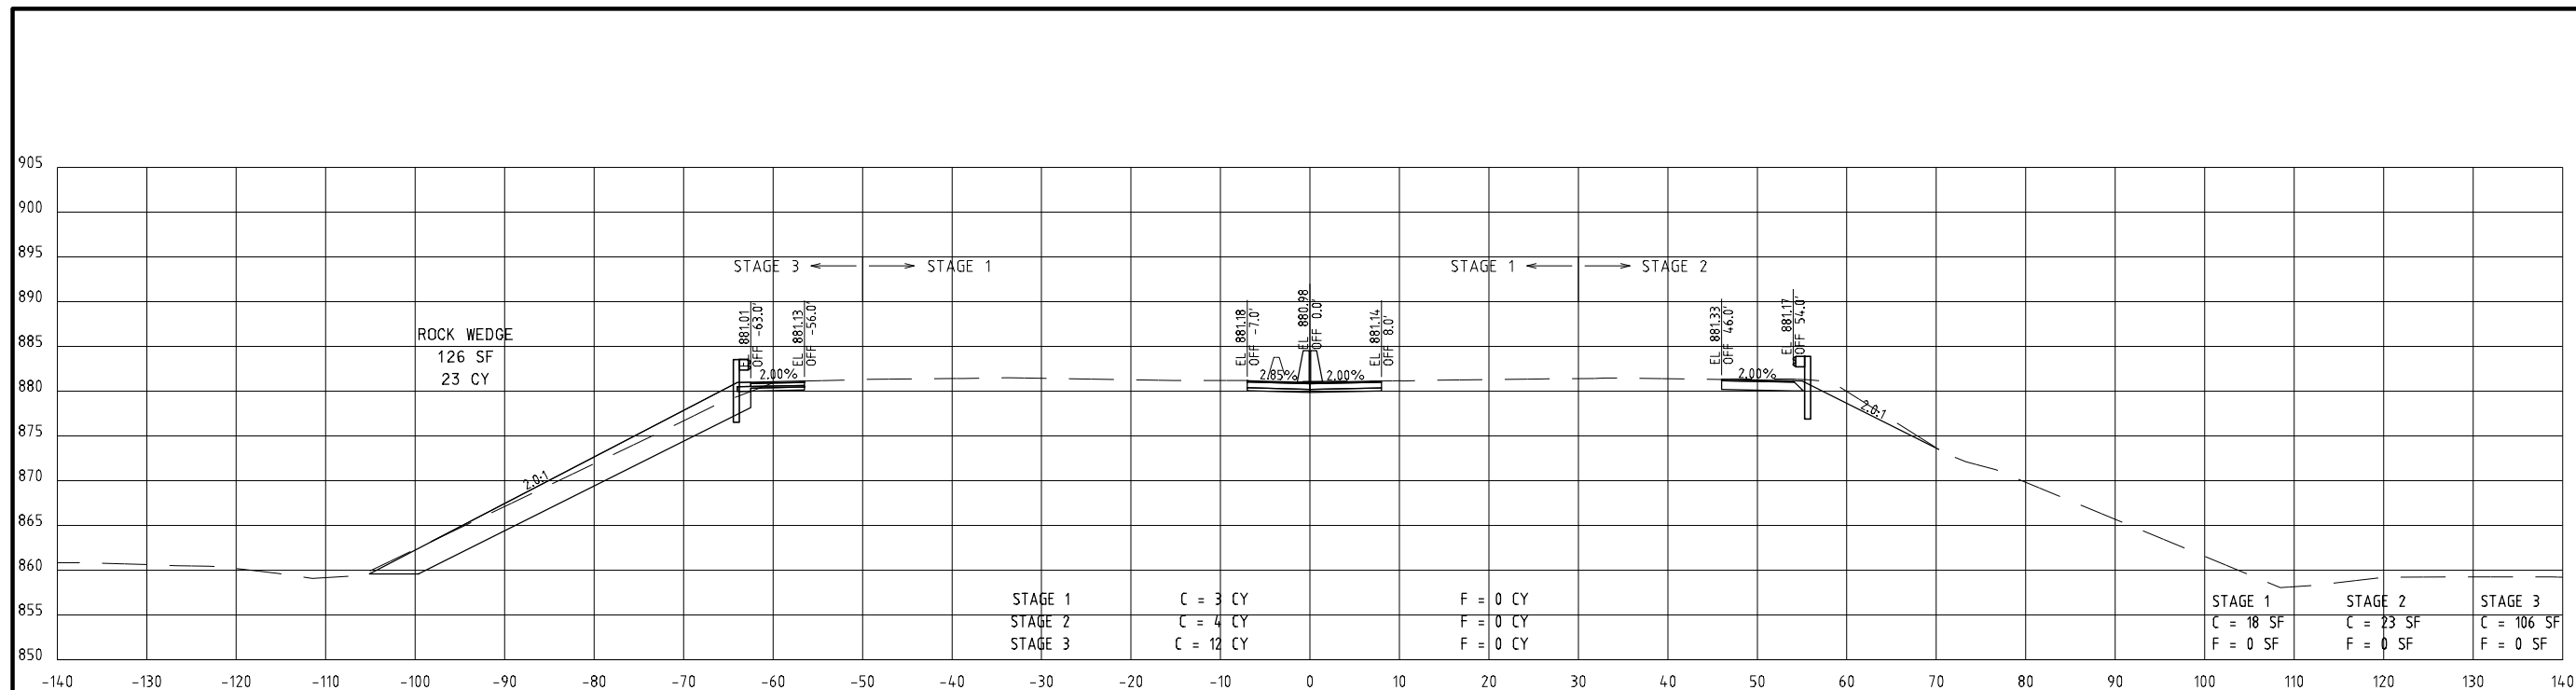

Sta. 903+00.00 R1

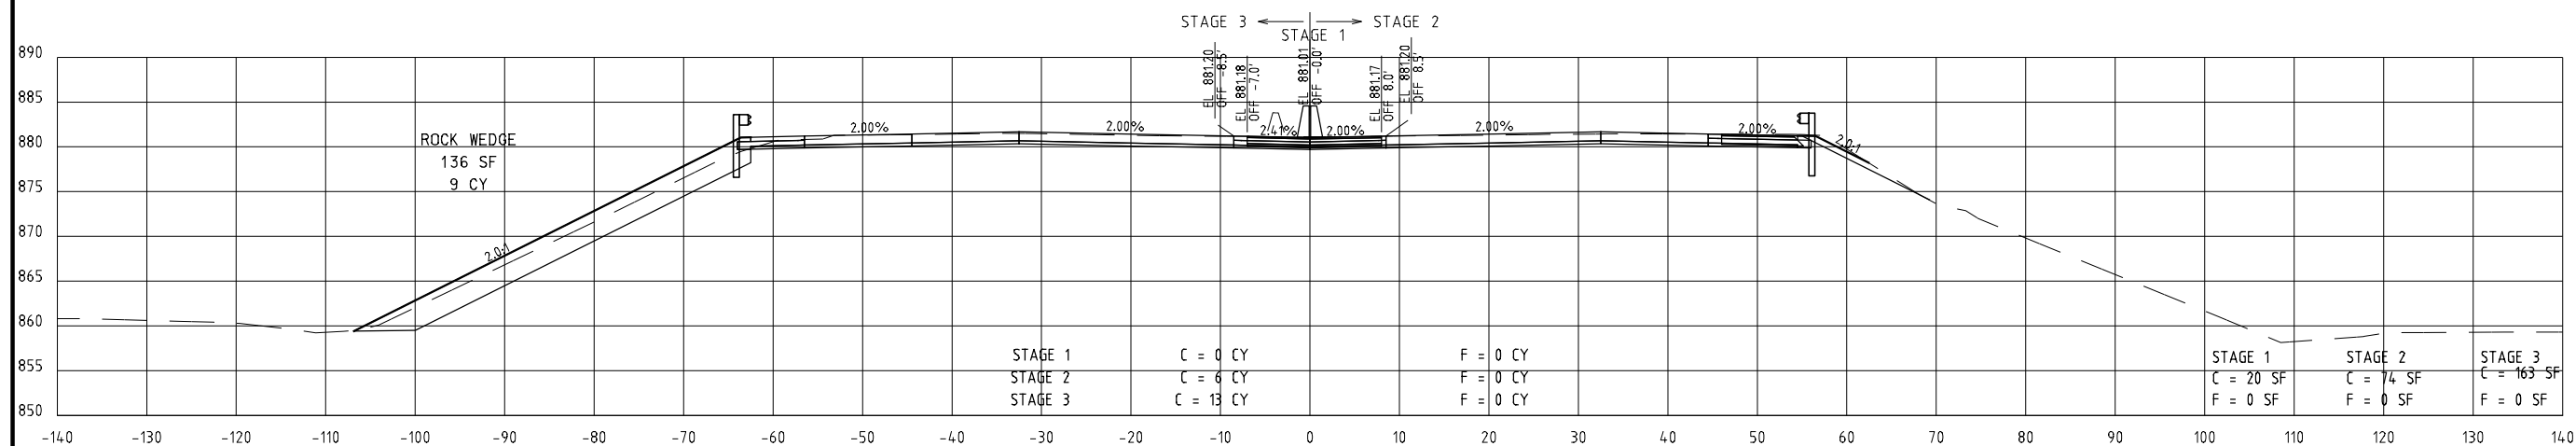

Sta. 902+95.25 R1

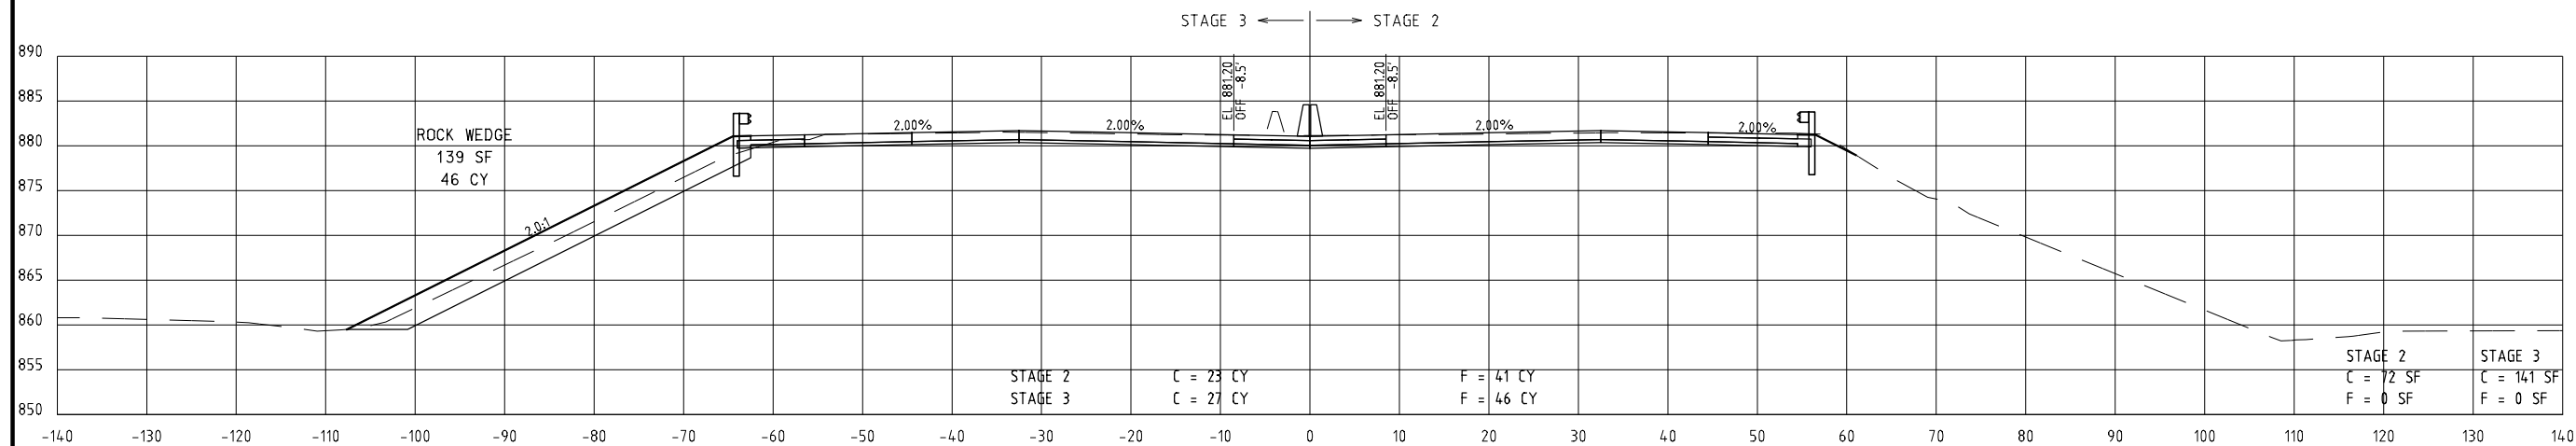

Sta. 902+93.50 R1

I-29 STA. 902+92.93 TO 903+00.00

"THIS MEDIA SHOULD NOT BE CONSIDERED A CERTIFIED DOCUMENT."

DATE PREPARED
7/19/2020

ROUTE
I-29

STATE
MO

DISTRICT
K-C

SHEET NO.
8

COUNTY
PLATTE

JOB NO.
J413291

CONTRACT ID.

PROJECT NO.

BRIDGE NO.

DESCRIPTION	DATE

MISSOURI HIGHWAYS AND TRANSPORTATION COMMISSION



105 WEST CAPITOL
JEFFERSON CITY, MO 65102
1-888-ASK-MODOT (1-888-275-6636)

Burns & McDonnell Engineering Co., Inc.




9400 Ward Parkway
Kansas City, Missouri 64114
816-333-9400

Certificate of Authority
No. : 000165

BMOB Project No. 109387



REV.

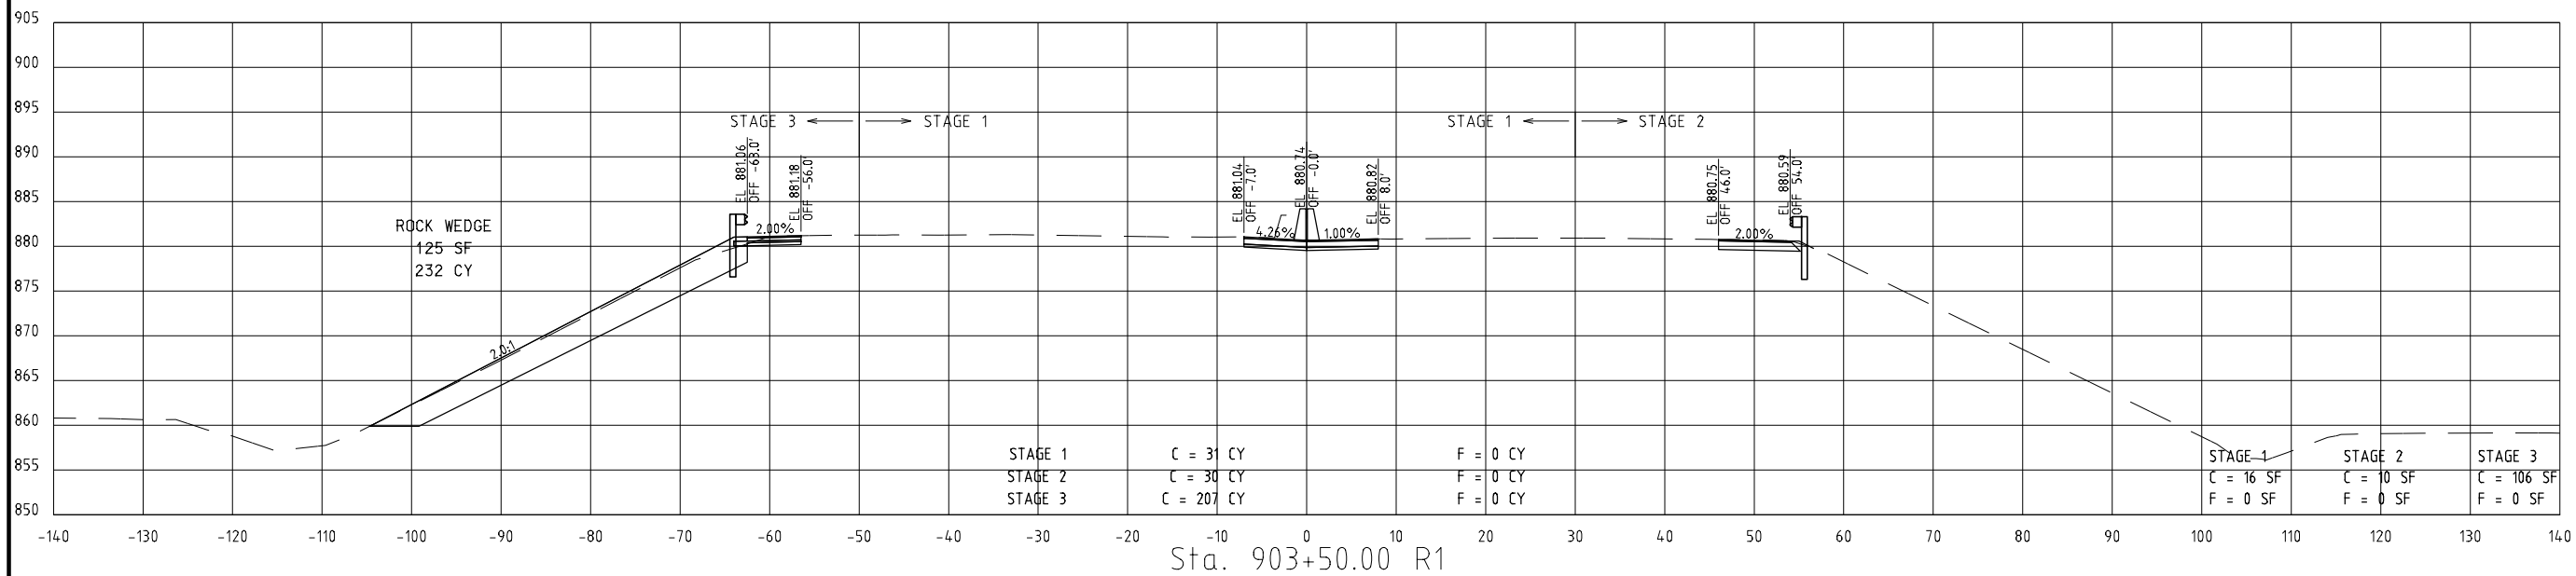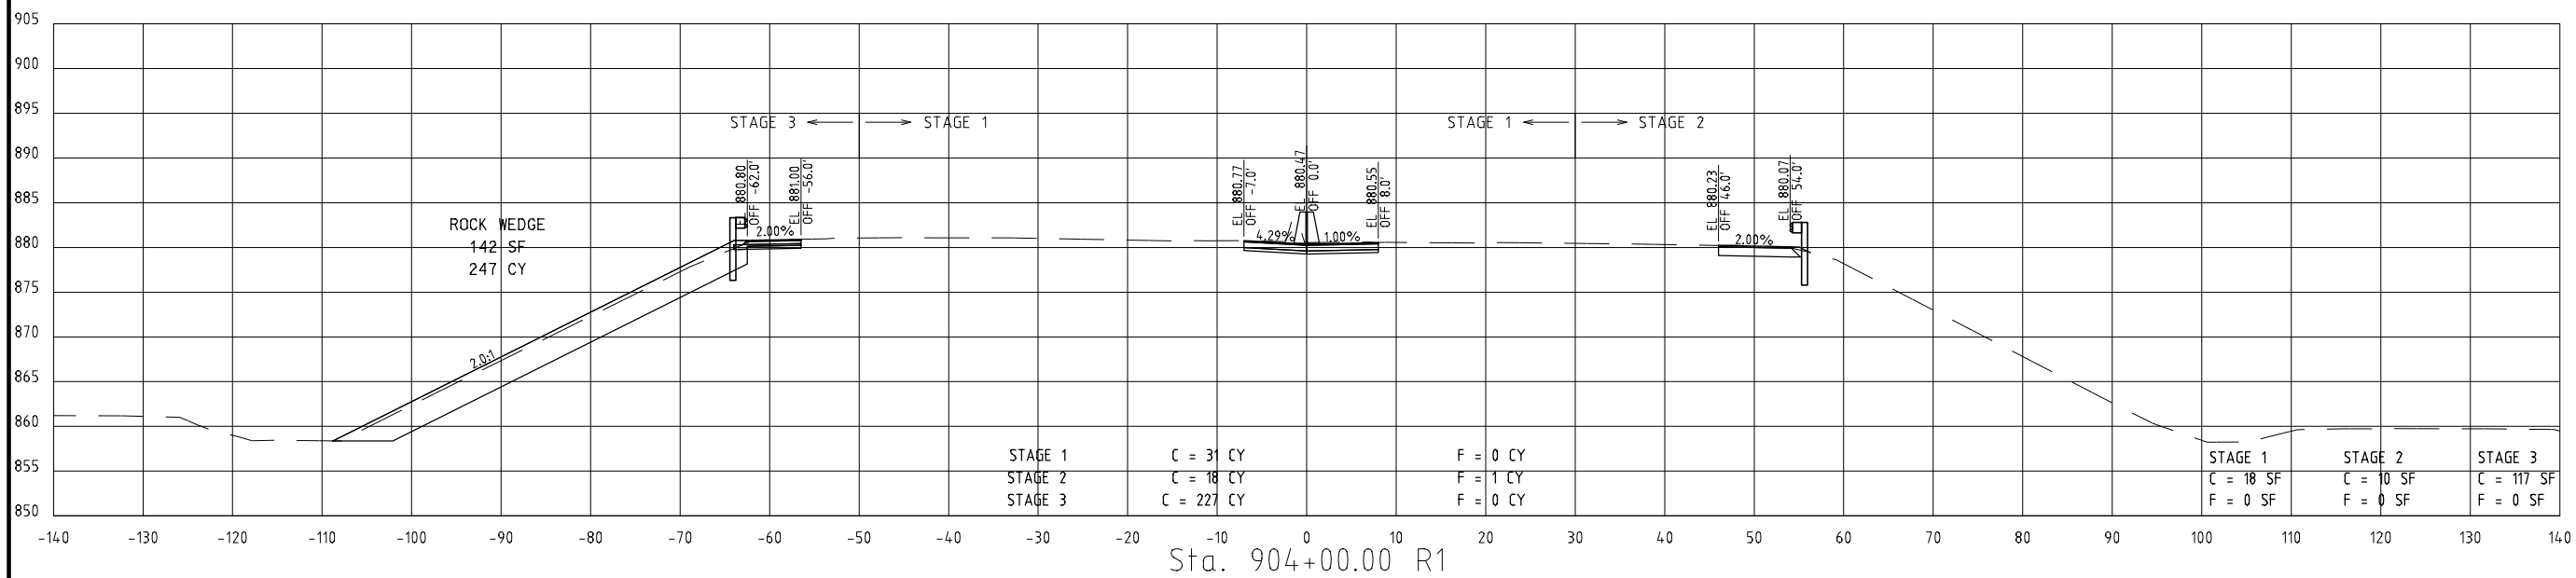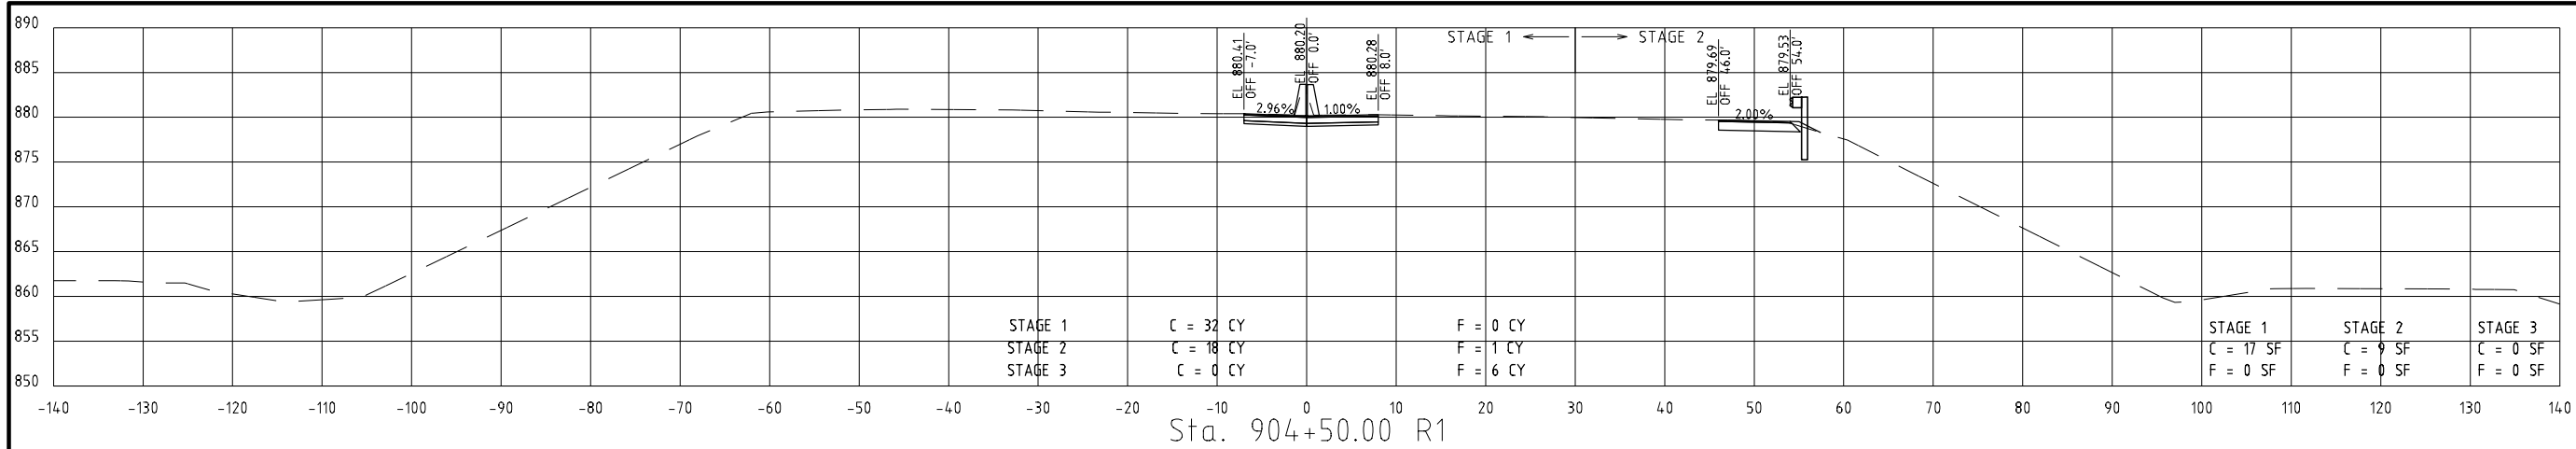

I-29 STA. 903+50.00 TO 904+50.00

\\bmcd\dfs\Clients\TRN\MODOT\109387_129Bridges\Design\CADD\Ref_Files\J413291_56\XS_129.dgn

"THIS MEDIA SHOULD NOT BE CONSIDERED A CERTIFIED DOCUMENT."

DATE PREPARED
7/19/2020

ROUTE I-29	STATE MO
DISTRICT K-C	SHEET NO. 9

COUNTY
PLATTE

JOB NO.
J413291

CONTRACT ID.
.

PROJECT NO.
.

BRIDGE NO.
.

DESCRIPTION	DATE
.	.
.	.
.	.
.	.
.	.
.	.

MISSOURI HIGHWAYS AND TRANSPORTATION COMMISSION

MoDOT

105 WEST CAPITAL
JEFFERSON CITY, MO 65102
1-888-ASK-MODOT (1-888-275-6636)

Burns & McDonnell Engineering Co., Inc.

9400 Ward Parkway
Kansas City, Missouri 64114
816-333-9400

Certificate of Authority
No. : 000165


BMD Project No. 109387

BURNS & MCDONNELL

IF A SEAL IS PRESENT ON THIS SHEET IT HAS BEEN ELECTRONICALLY SEALED AND DATED.

REV.

5:35:25 PM 7/19/2020

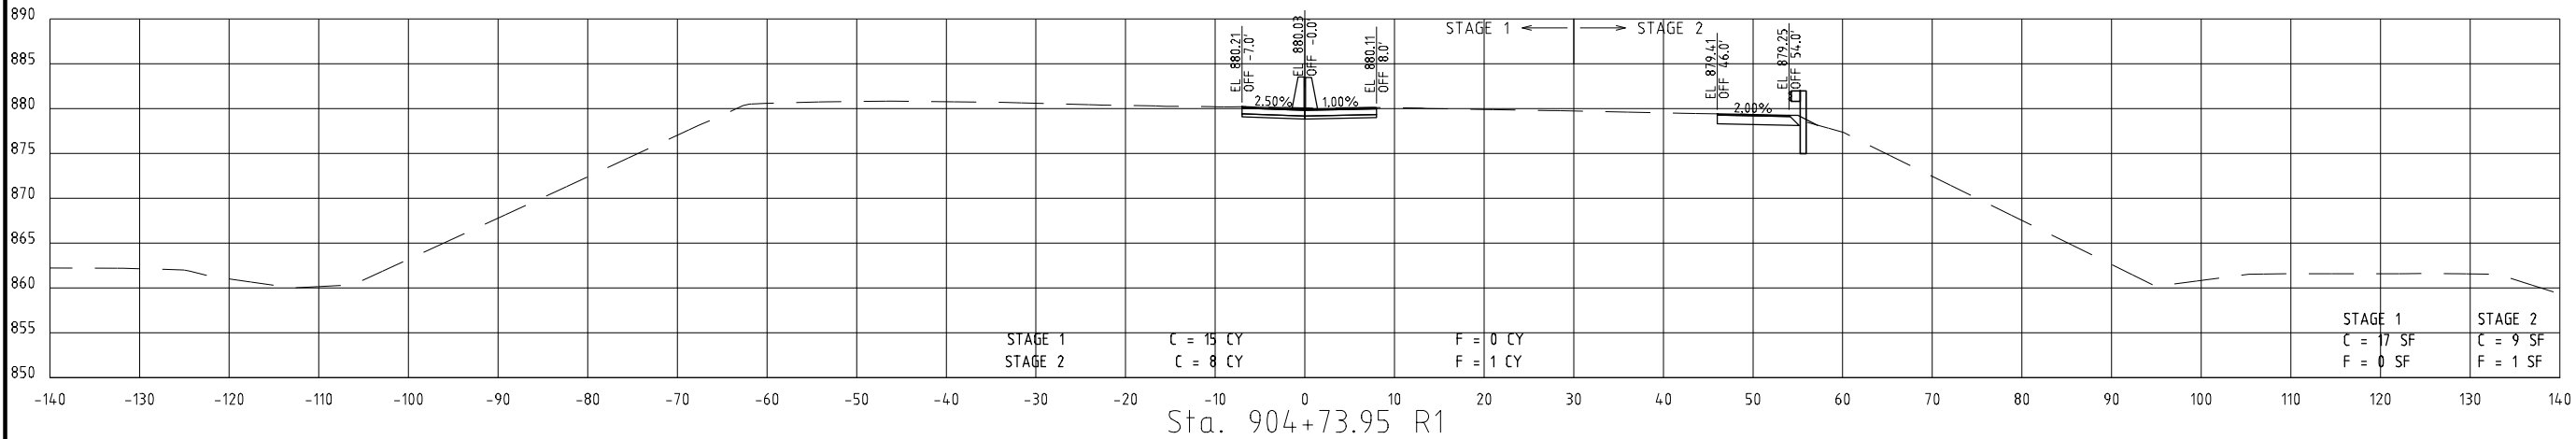

"THIS MEDIA SHOULD NOT BE CONSIDERED A CERTIFIED DOCUMENT."

DATE PREPARED
7/19/2020

ROUTE I-29	STATE MO
DISTRICT K-C	SHEET NO. 1-0

COUNTY
PLATTE

JOB NO.
J413291

CONTRACT ID.
.

PROJECT NO.
.

BRIDGE NO.
.

DATE	DESCRIPTION
.	.
.	.
.	.
.	.
.	.
.	.

MISSOURI HIGHWAYS AND TRANSPORTATION COMMISSION




105 WEST CAPITOL
JEFFERSON CITY, MO 65102
1-888-ASK-MODOT (1-888-278-6636)

Burns & McDonnell Engineering Co., Inc.




9400 Ward Parkway
Kansas City, Missouri 64114
816-333-9400


Certification of Authority
No. : 000165
BMD Project No. 109387

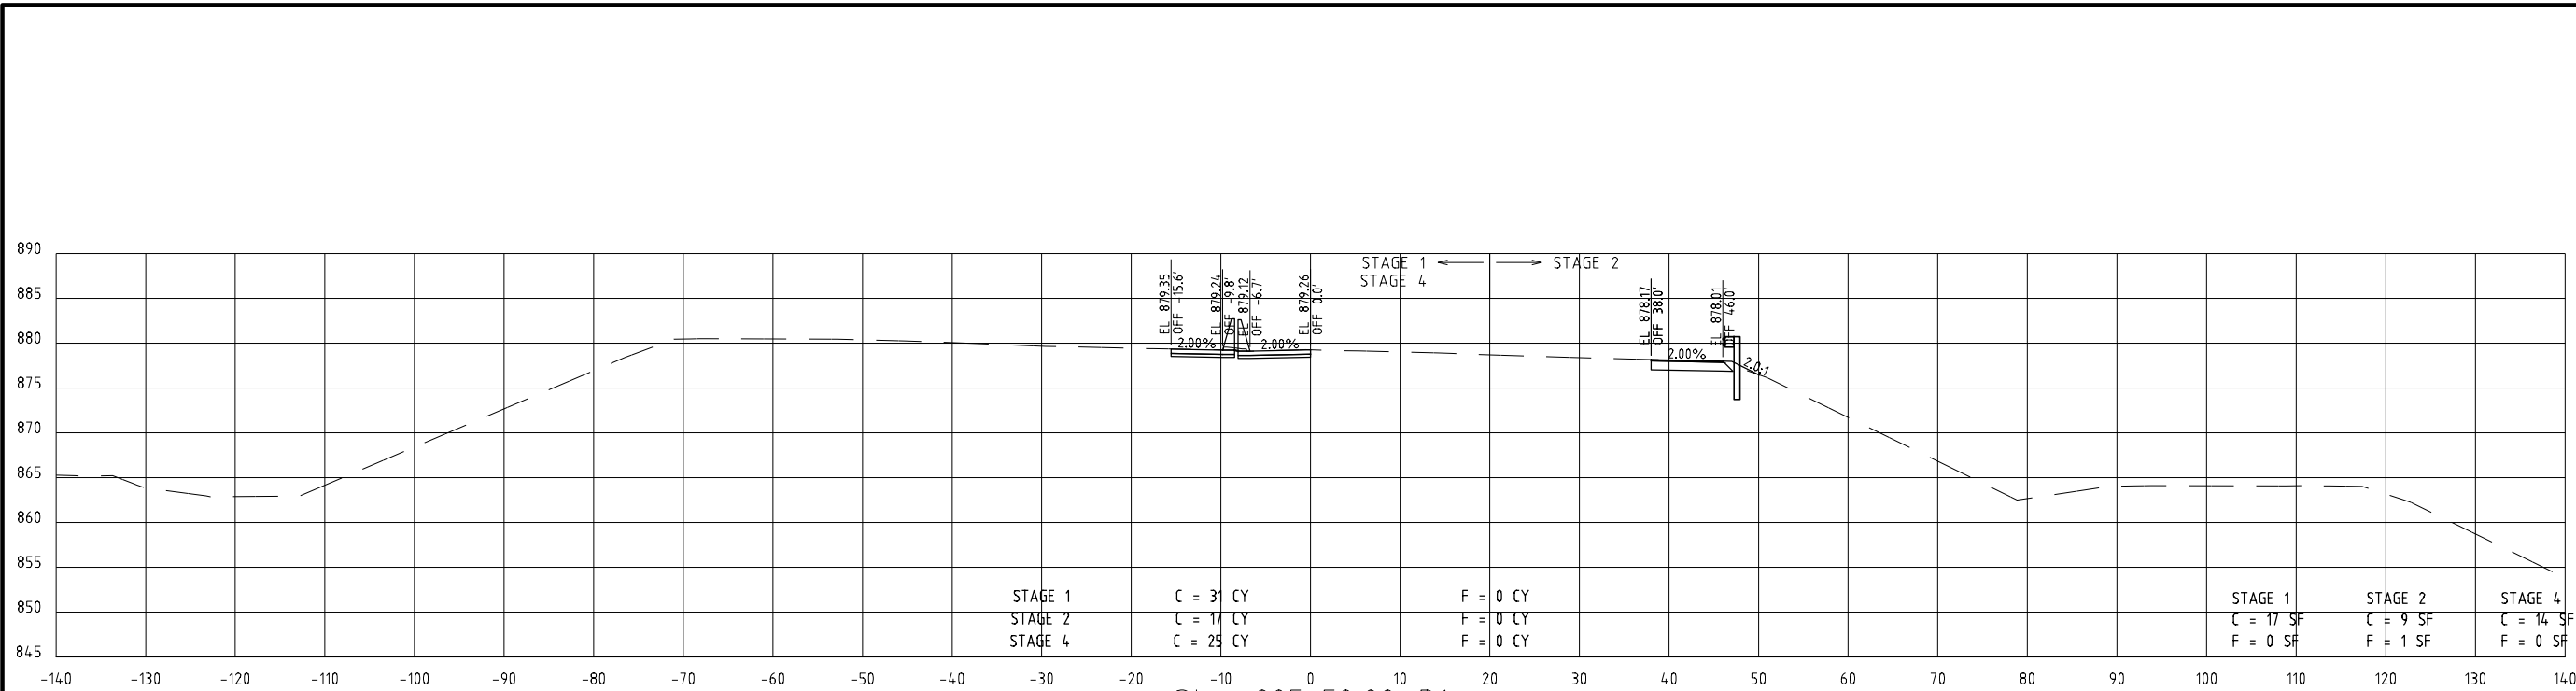

Sta. 905+50.00 R1

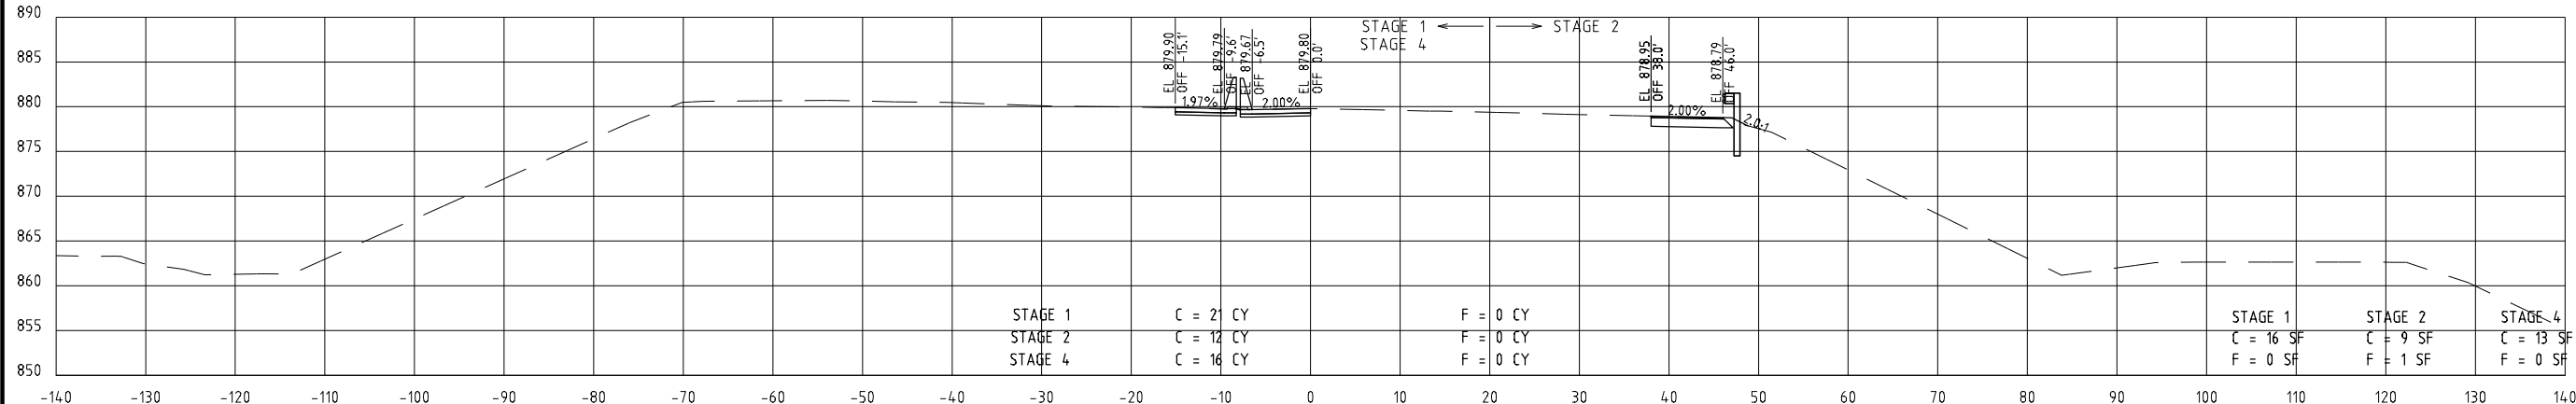

Sta. 905+00.00 R1

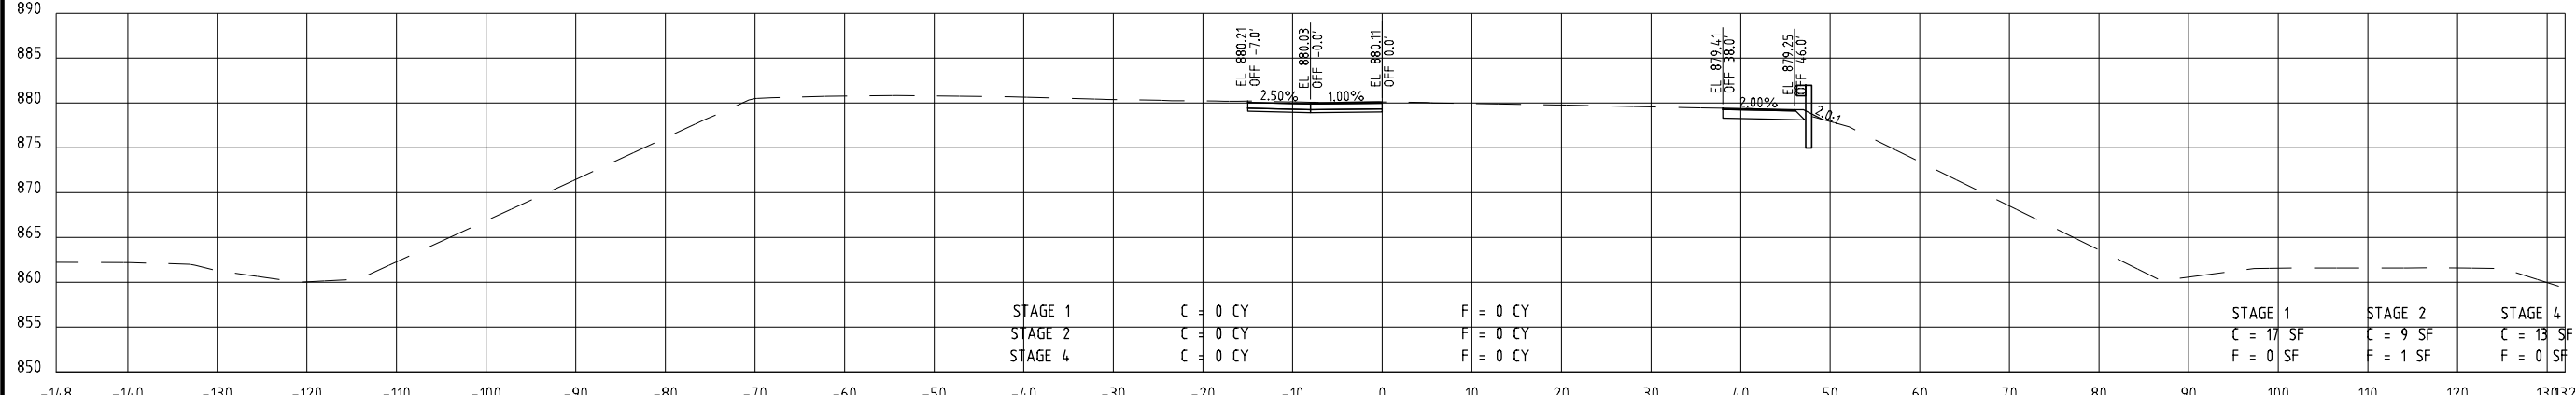

Sta. 904+65.07 R1

I-29 SB STA. 904+65.07 TO 905+50.00

"THIS MEDIA SHOULD NOT BE CONSIDERED A CERTIFIED DOCUMENT."

DATE PREPARED
7/19/2020

ROUTE I-29	STATE MO
DISTRICT K-C	SHEET NO. 1-1
COUNTY PLATTE	
JOB NO. J413291	
CONTRACT ID. .	
PROJECT NO. .	
BRIDGE NO. .	

DESCRIPTION	DATE
.	.
.	.
.	.
.	.
.	.
.	.

MISSOURI HIGHWAYS AND TRANSPORTATION COMMISSION

MoDOT

105 WEST CAPITAL
JEFFERSON CITY, MO 65102
1-888-ASK-MODOT (1-888-275-6636)




Burns & McDonnell Engineering Co., Inc.

9400 Ward Parkway
Kansas City, Missouri 64114
816-333-9400

Certificate of Authority
No. : 000165

BMOB Project No. 109387

BURNS MEDONNELL

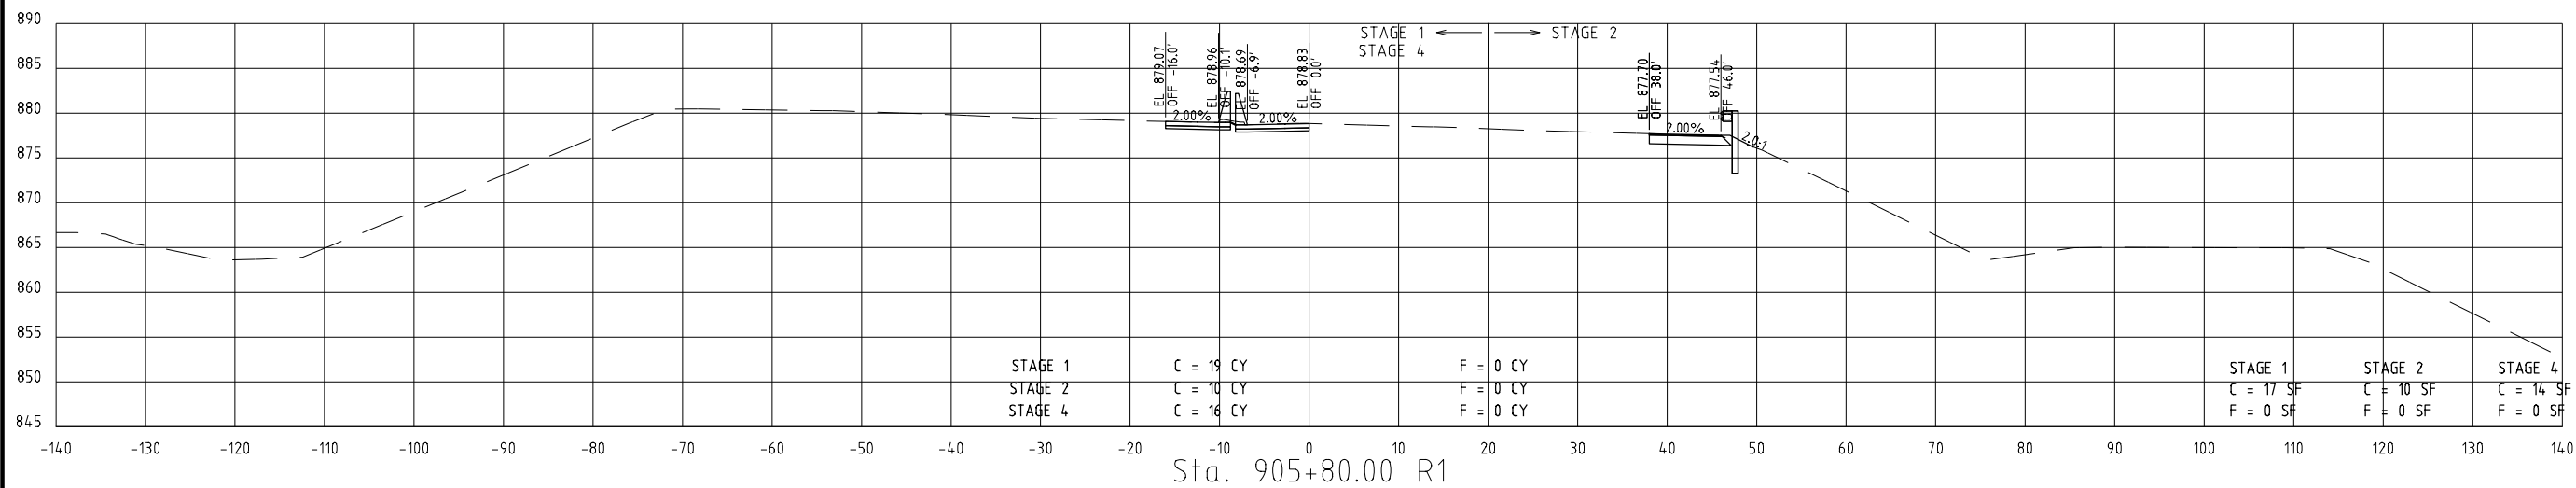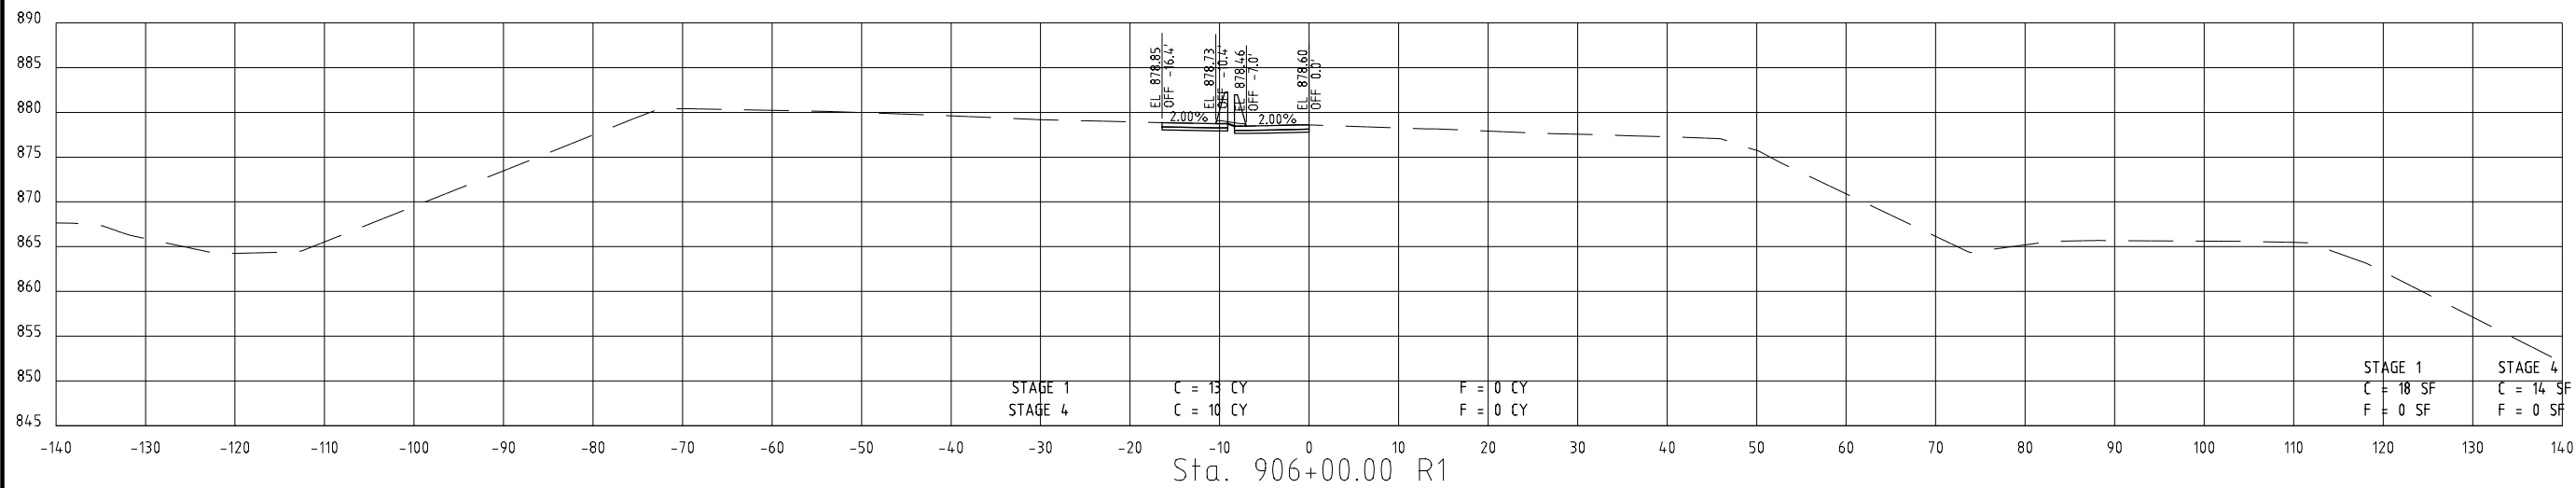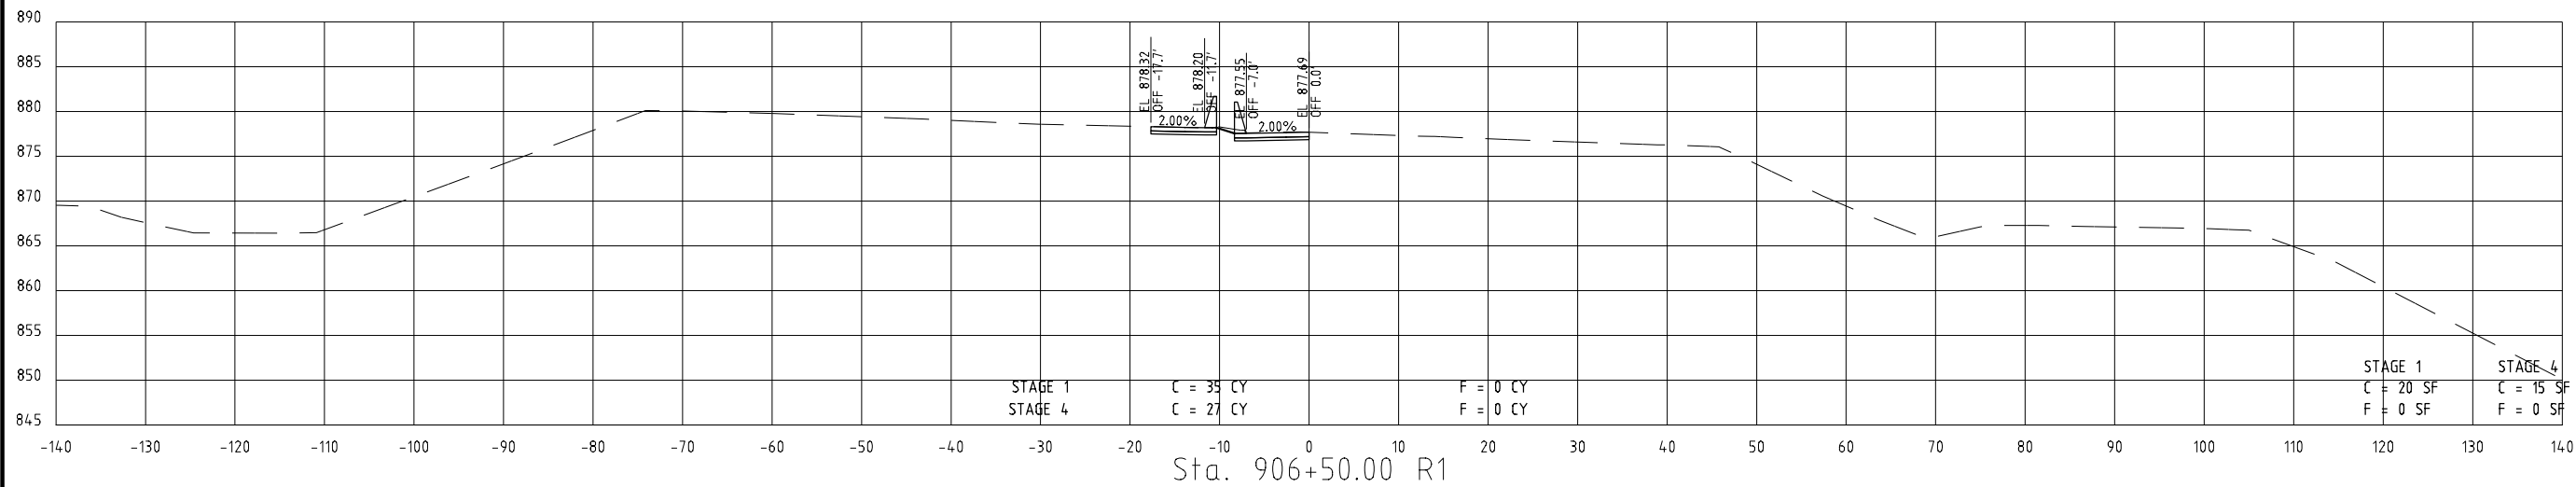

I-29 SB STA. 905+80.00 TO 906+50.00




"THIS MEDIA SHOULD NOT BE CONSIDERED A CERTIFIED DOCUMENT."

DATE PREPARED
7/19/2020
ROUTE
I-29
STATE
MO
DISTRICT
K-C
SHEET NO.
1-2
COUNTY
PLATTE
JOB NO.
J413291
CONTRACT ID.
PROJECT NO.
BRIDGE NO.

DATE	DESCRIPTION
.	.
.	.
.	.
.	.
.	.
.	.

MISSOURI HIGHWAYS AND TRANSPORTATION COMMISSION
MoDOT
105 WEST CAPITAL
JEFFERSON CITY, MO 65102
1-888-ASK-MODOT (1-888-275-6636)

Burns & McDonnell Engineering Co., Inc.
9400 Ward Parkway
Kansas City, Missouri 64114
816-333-9400
Certificate of Authority
No. : 000165
BMOB Project No. 109387
BURNS MEDONNELL

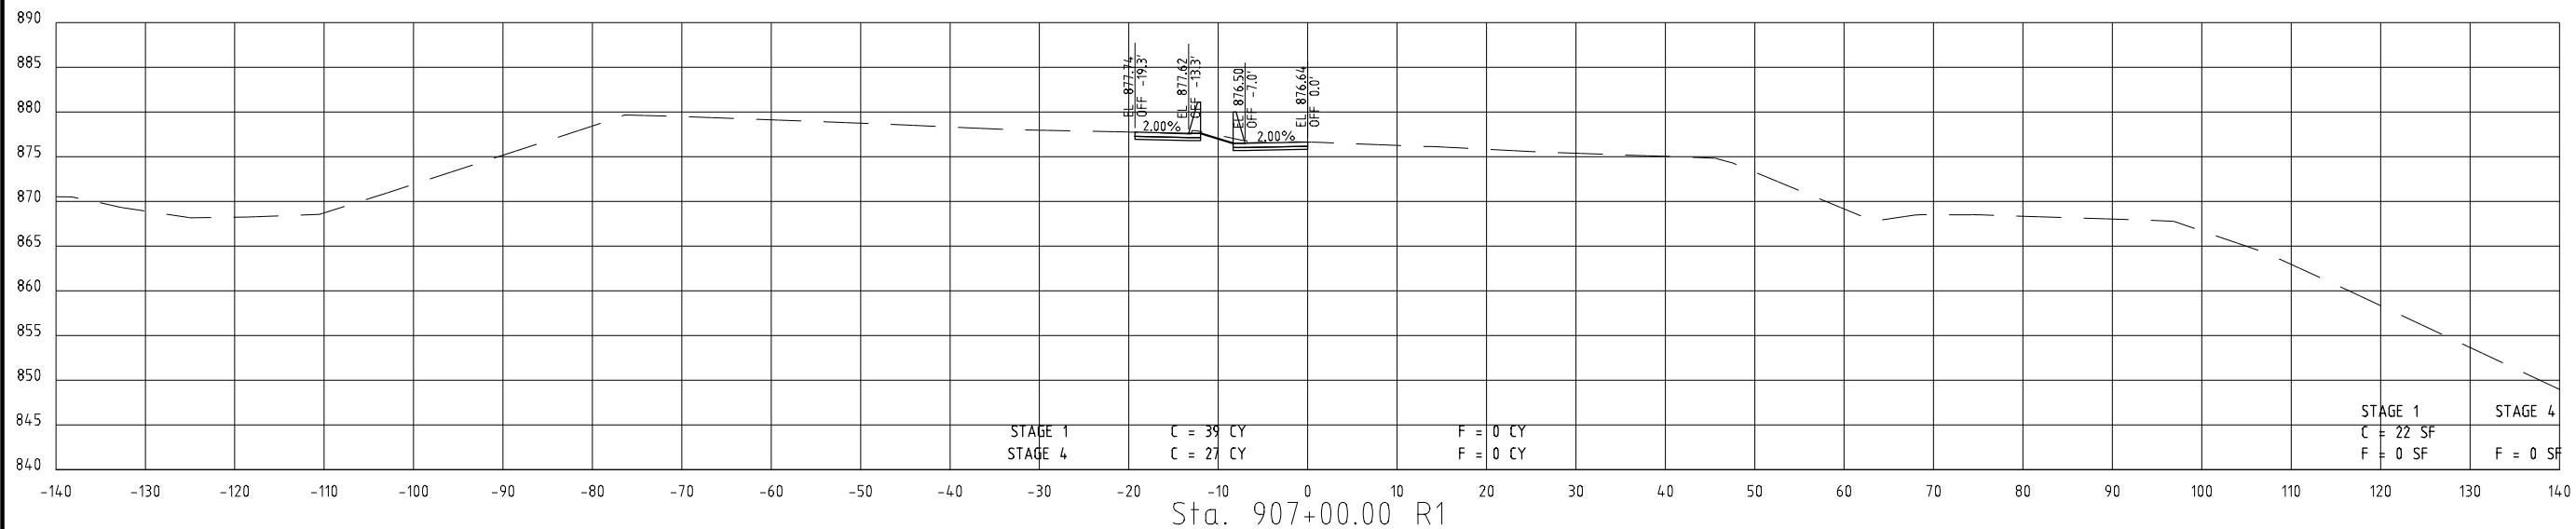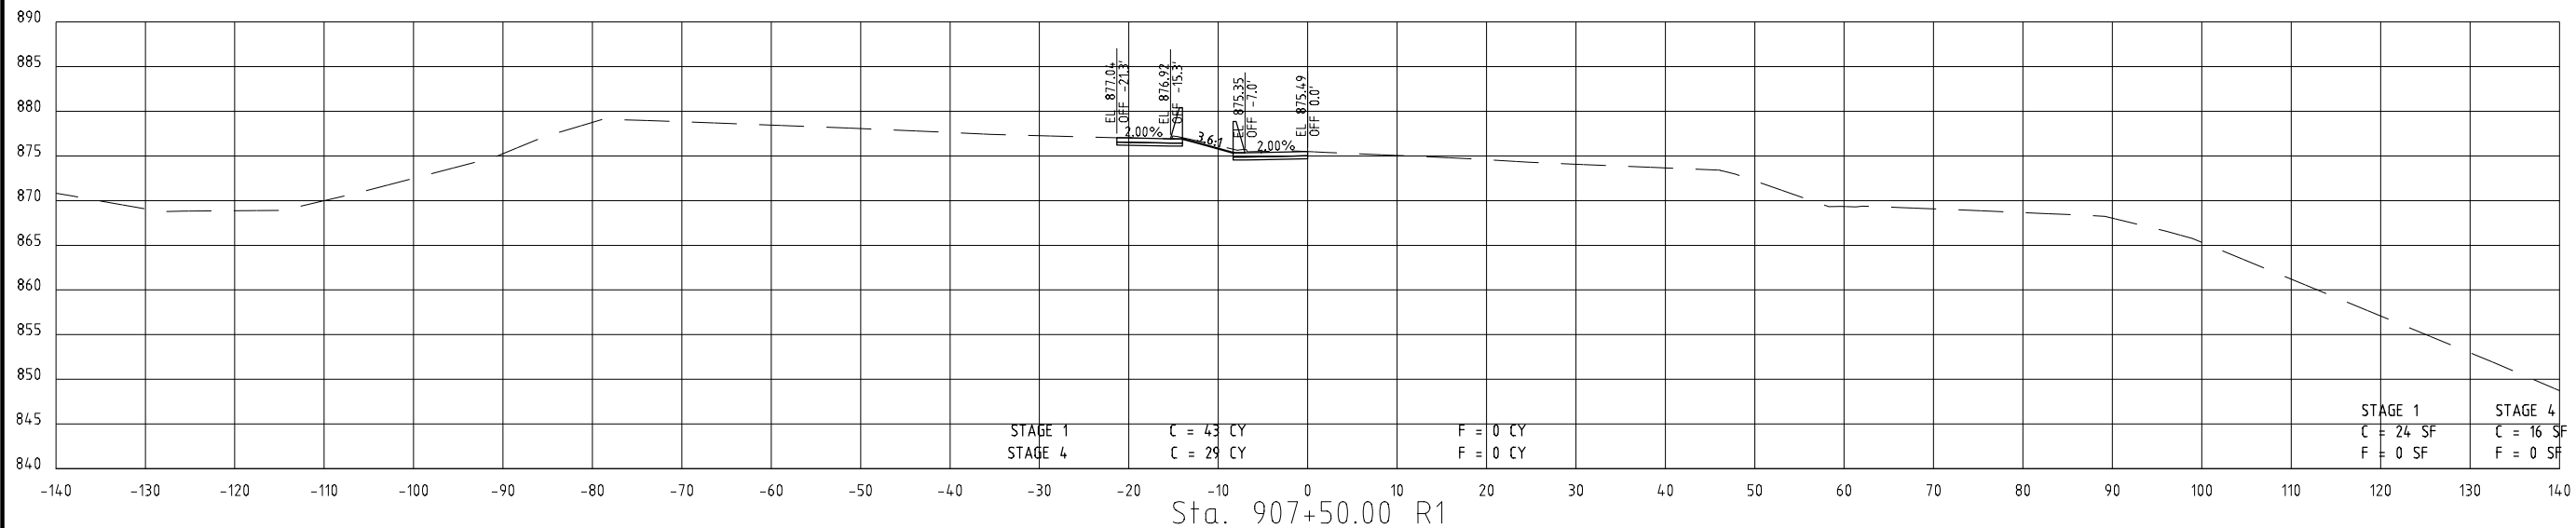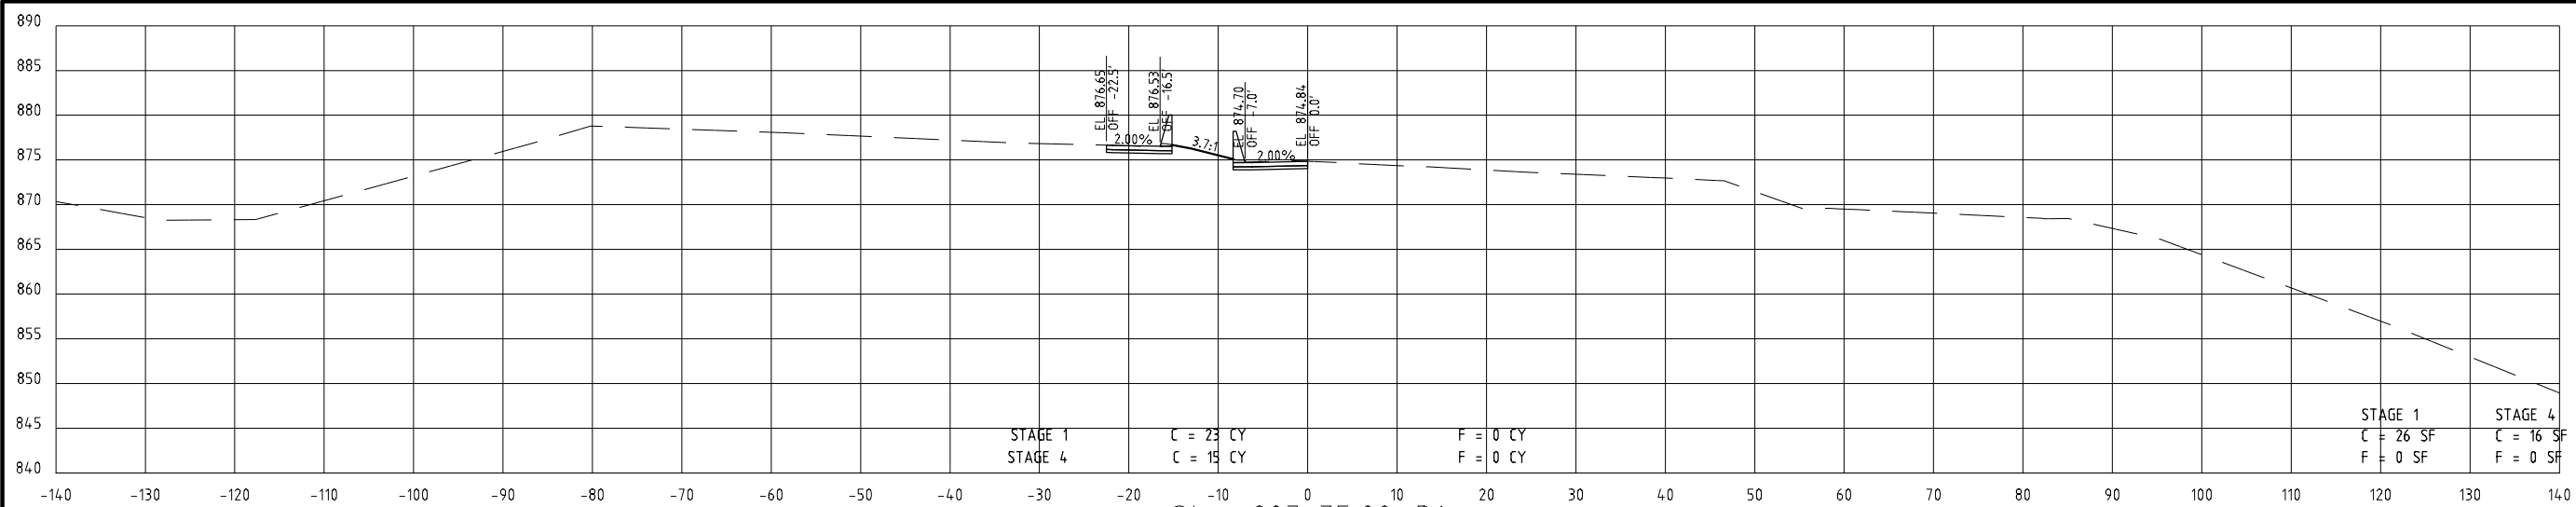

I-29 SB STA. 907+0.00 TO 907+75.00

"THIS MEDIA SHOULD NOT BE CONSIDERED A CERTIFIED DOCUMENT."

DATE PREPARED
7/19/2020

ROUTE I-29 STATE MO
DISTRICT K-C SHEET NO. 1-3

COUNTY
PLATTE

JOB NO.
J413291

CONTRACT ID.
.

PROJECT NO.
.



BRIDGE NO.
.

DATE	DESCRIPTION
.	.
.	.
.	.
.	.
.	.
.	.

MISSOURI HIGHWAYS AND TRANSPORTATION COMMISSION
MoDOT
105 WEST CAPITAL
JEFFERSON CITY, MO 65102
1-888-ASK-MODOT (1-888-275-6636)


Burns & McDonnell Engineering Co., Inc.
9400 Ward Parkway
Kansas City, Missouri 64114
816-333-9400
Certificate of Authority
No. : 000165
BMOB Project No. 109387

BURNS & MCDONNELL

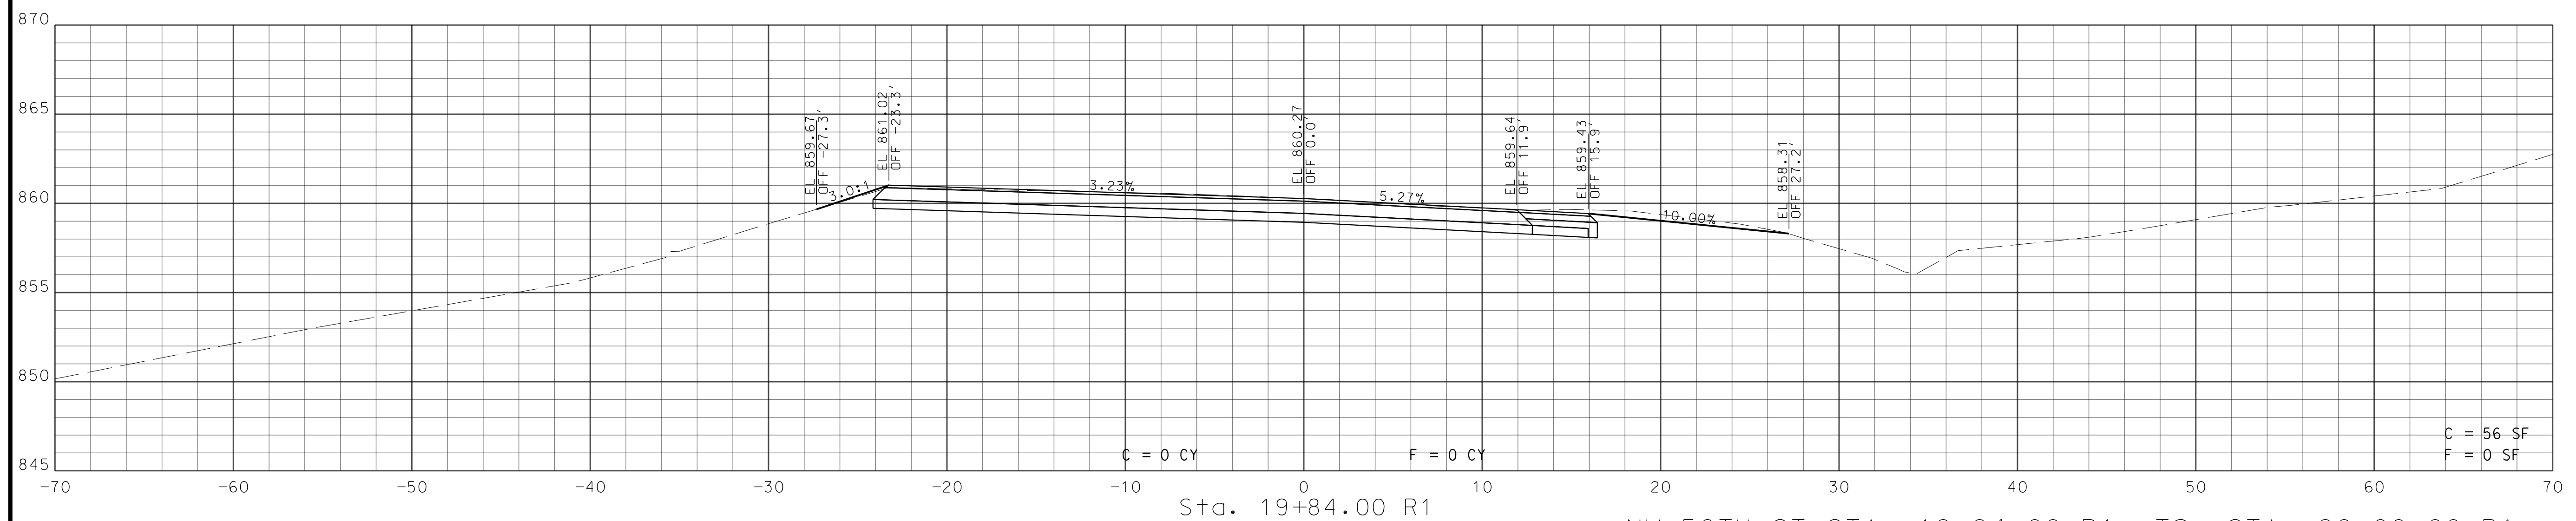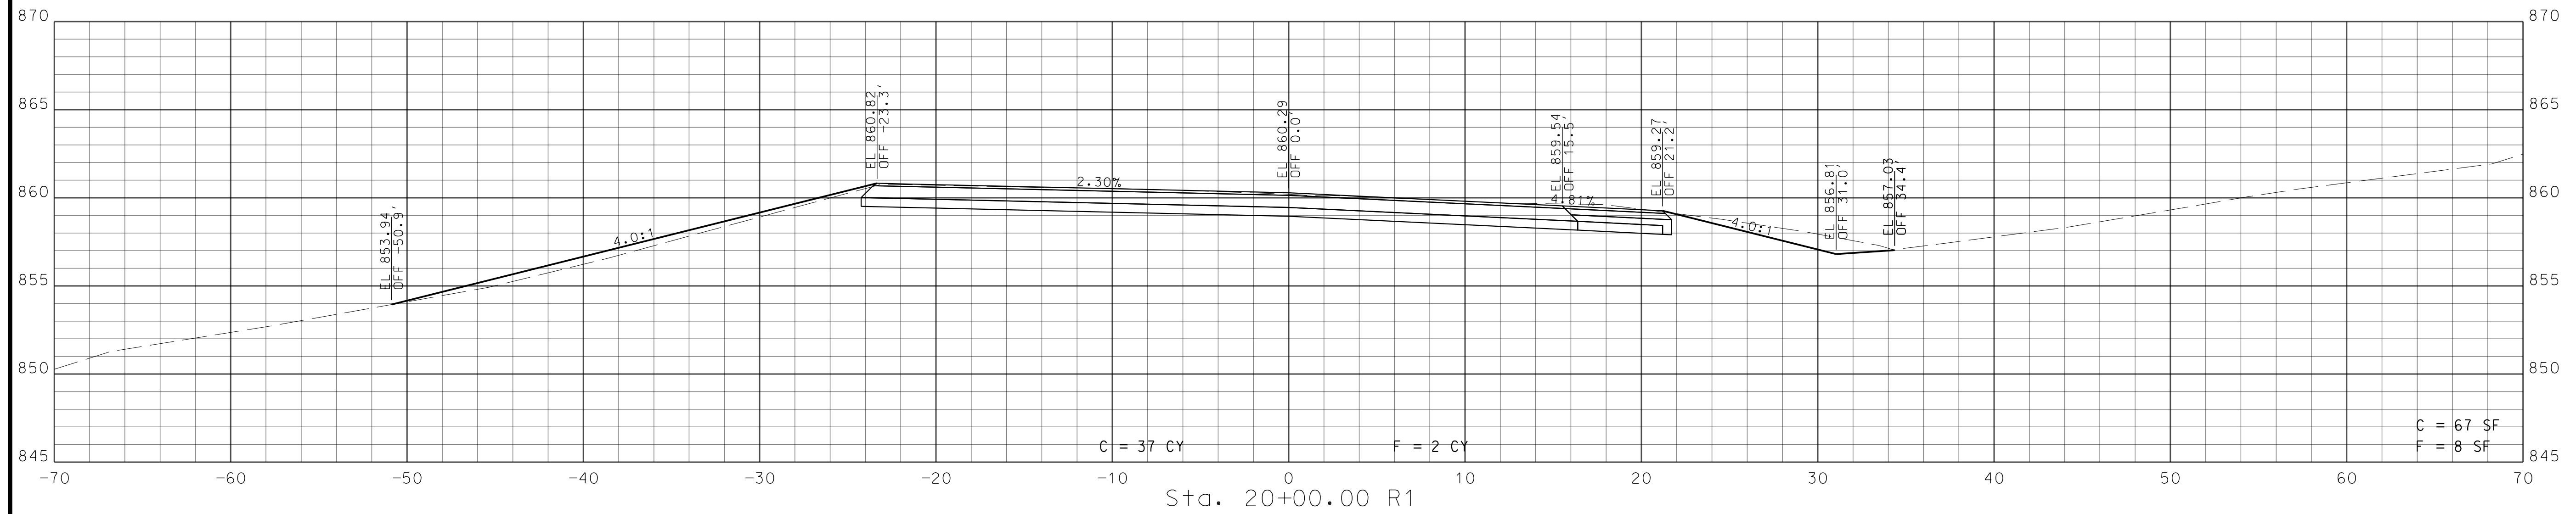

NW 56TH ST STA. 19+84.00 R1 TO STA. 20+00.00 R1

DATE PREPARED	
6/26/2020	
ROUTE	STATE
I-29	MO
DISTRICT	SHEET NO.
KC	14
COUNTY	
PLATTE	
JOB NO.	
J413291	
CONTRACT ID.	
PROJECT NO.	
BRIDGE NO.	



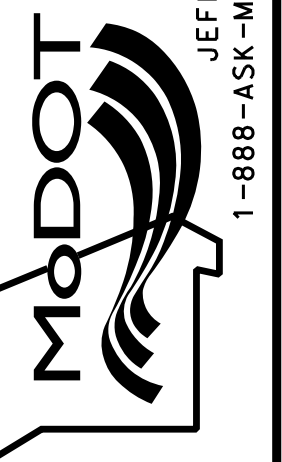
[illegible]MISSOURI HIGHWAYS AND TRANSPORTATION
COMMISSION

105 WEST CAPITOL
JEFFERSON CITY, MO 65102
1-888-ASK-MODOT (1-888-275-6636)



1411 East 104th St.
Kansas City, MO 64131
Tel (816) 874-4655
Fax (816) 874-4675
www.trekdesigngroup.com



Authority 2002010300

TEK
DESIGN GROUP, LLC

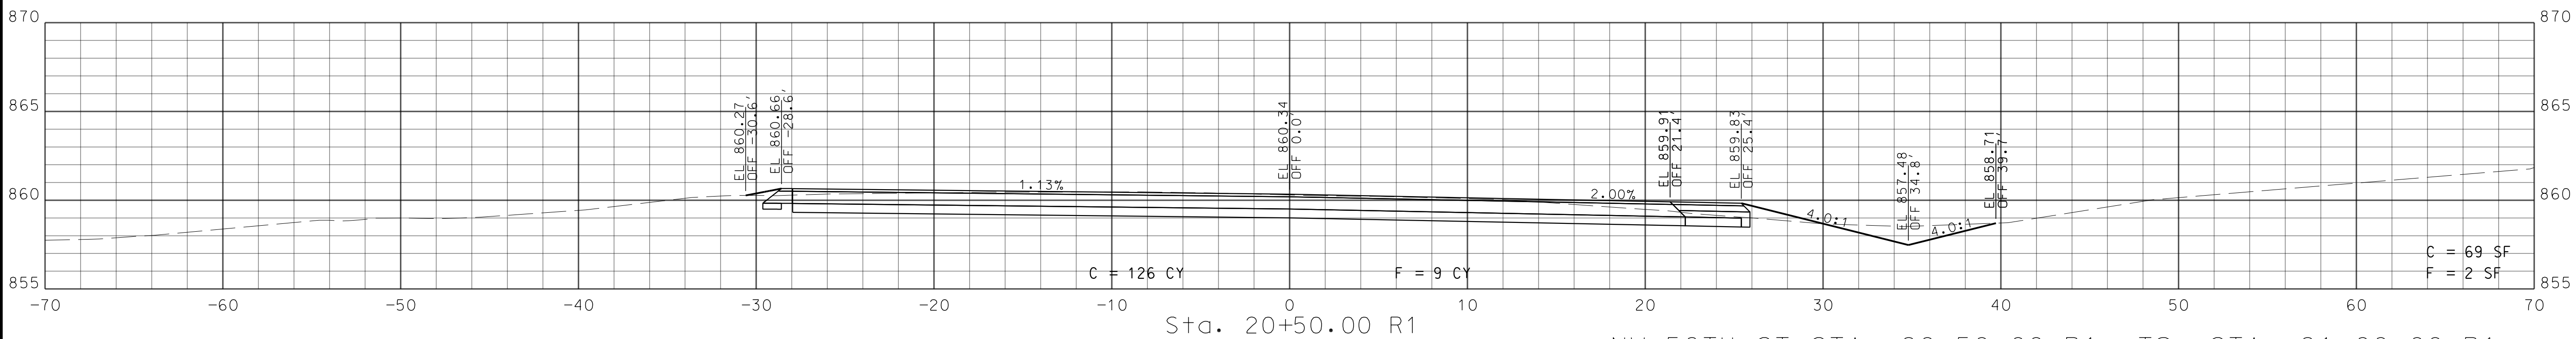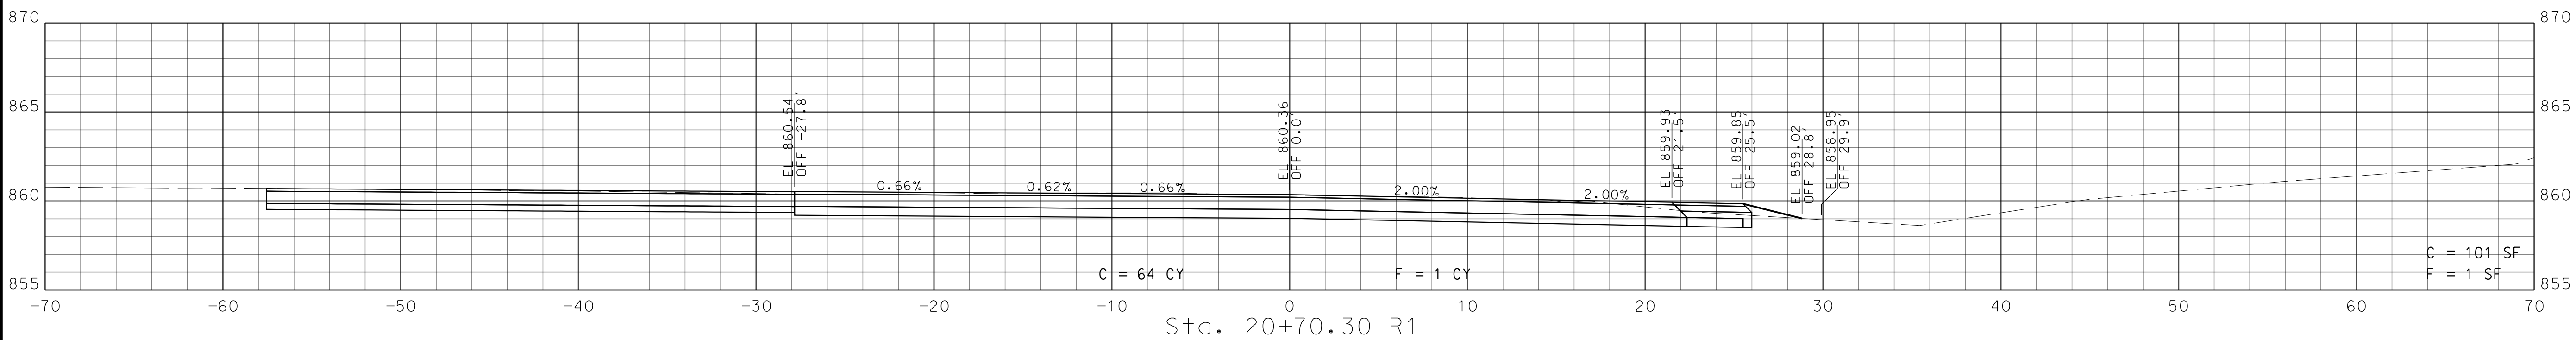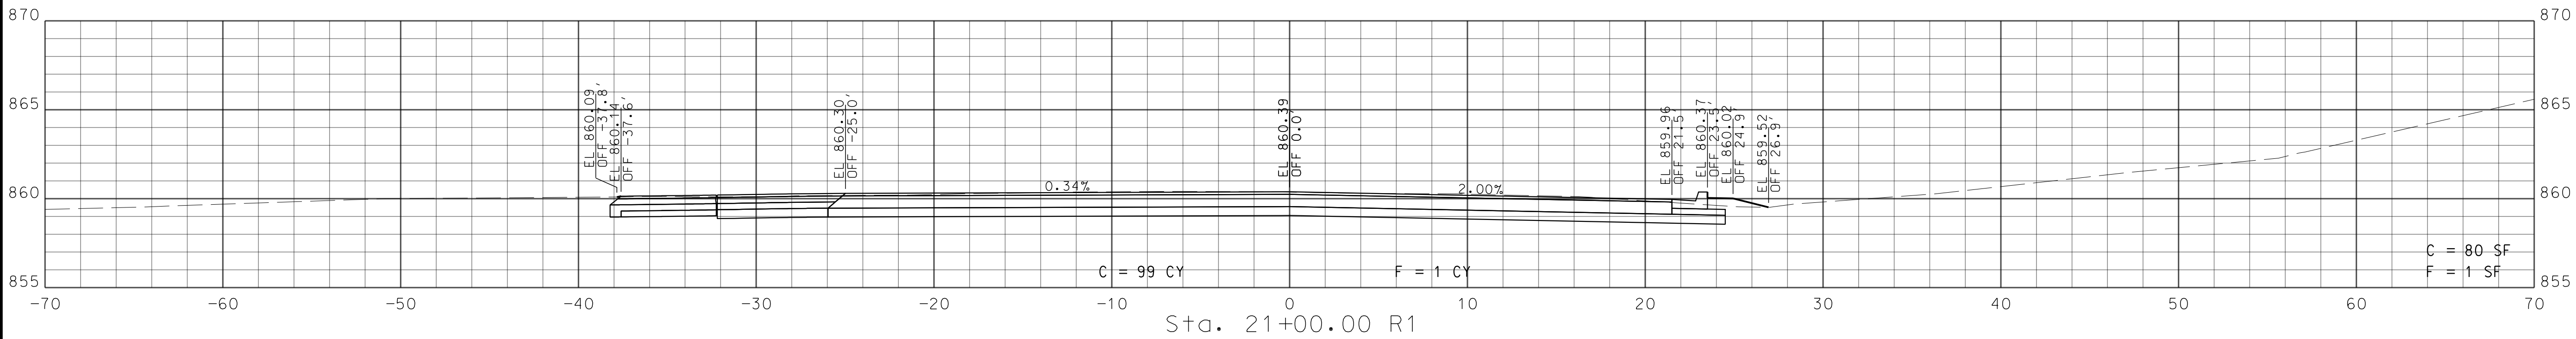

NW 56TH ST STA. 20+50.00 R1 TO STA. 21+00.00 R1

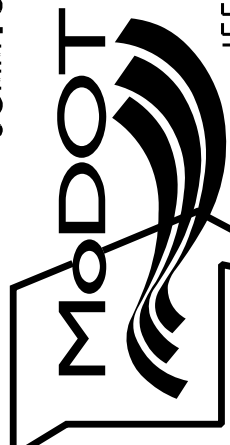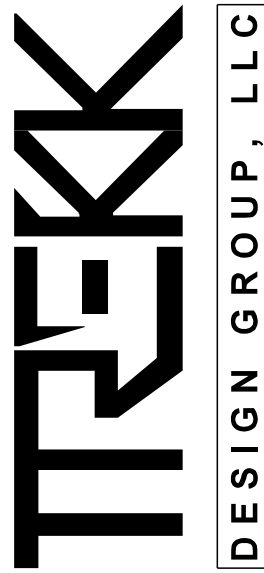DATE PREPARED 6/26/2020	
ROUTE I-29	STATE MO
DISTRICT KC	SHEET NO. 15
COUNTY PLATTE	
JOB NO. J413291	
CONTRACT ID.	
PROJECT NO.	
BRIDGE NO.	
DESCRIPTION	DATE
MISSOURI HIGHWAYS AND TRANSPORTATION COMMISSION	
	
105 WEST CAPITAL JEFFERSON CITY, MO 65102 1-888-ASK-MODOT (1-888-275-6636)	
1411 East 104th St. Kansas City, MO 64131 Tel (816) 974-4655 Fax (816) 974-4675 www.trekdesigngroup.com	
Missouri Cert. of Authority 20201030	
	

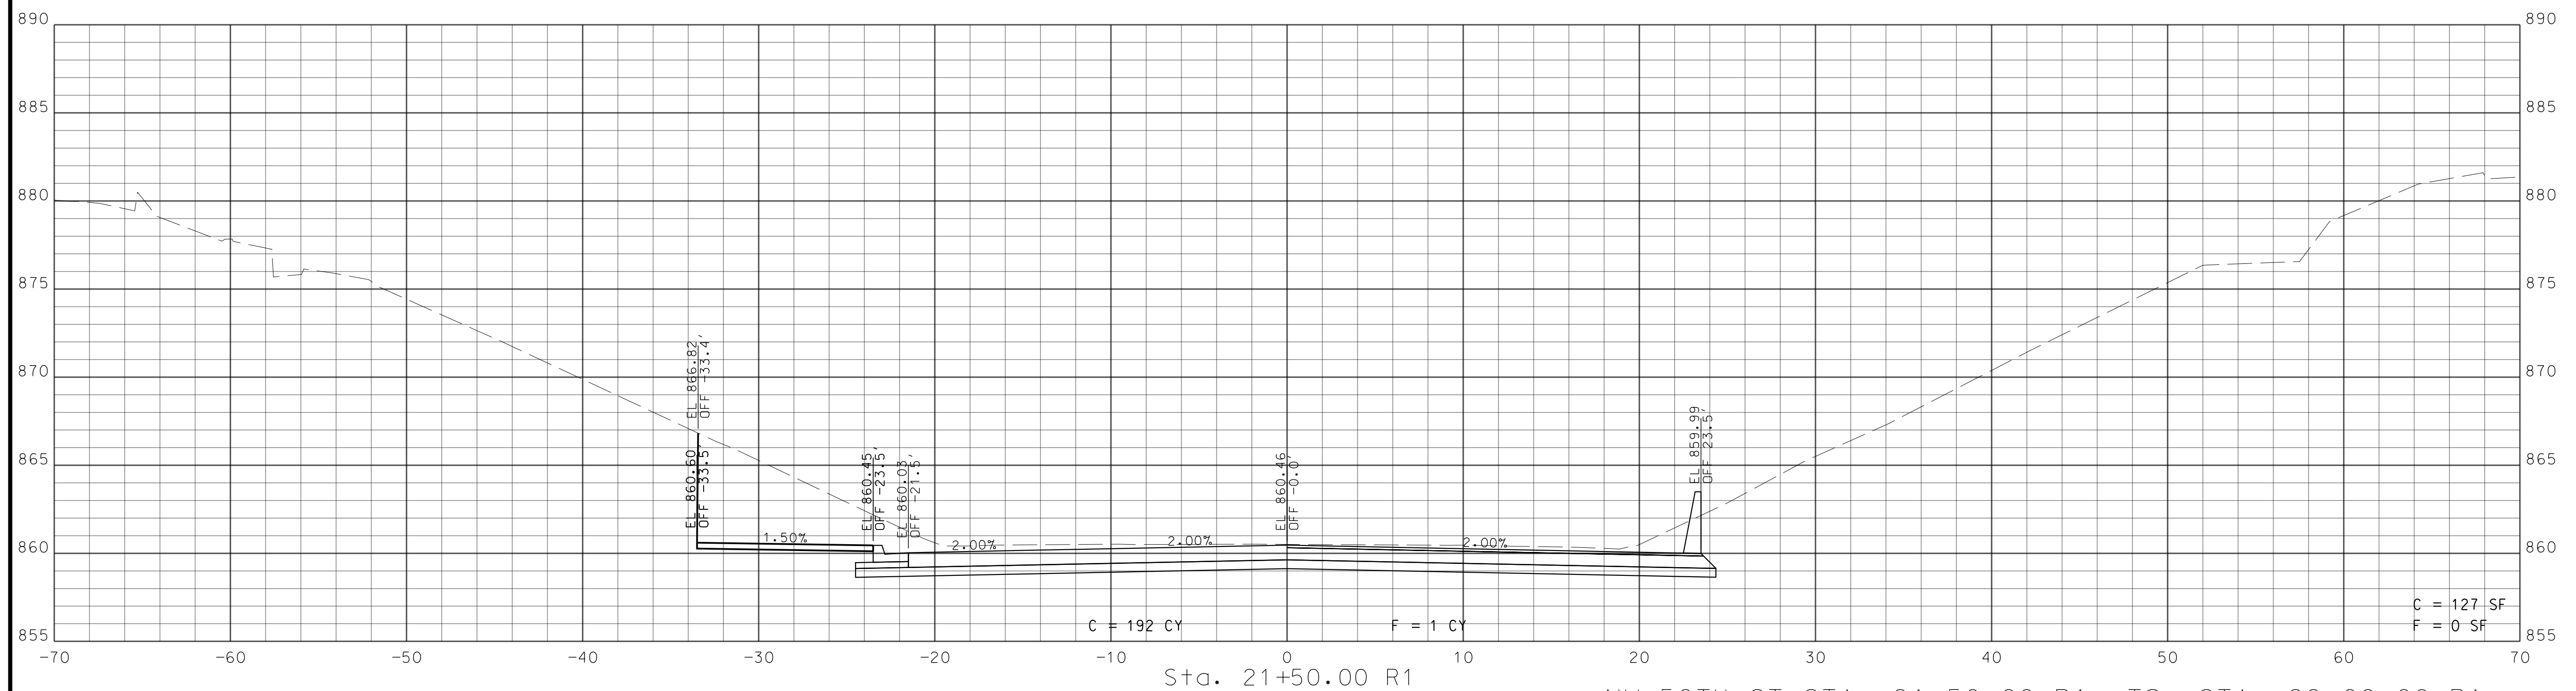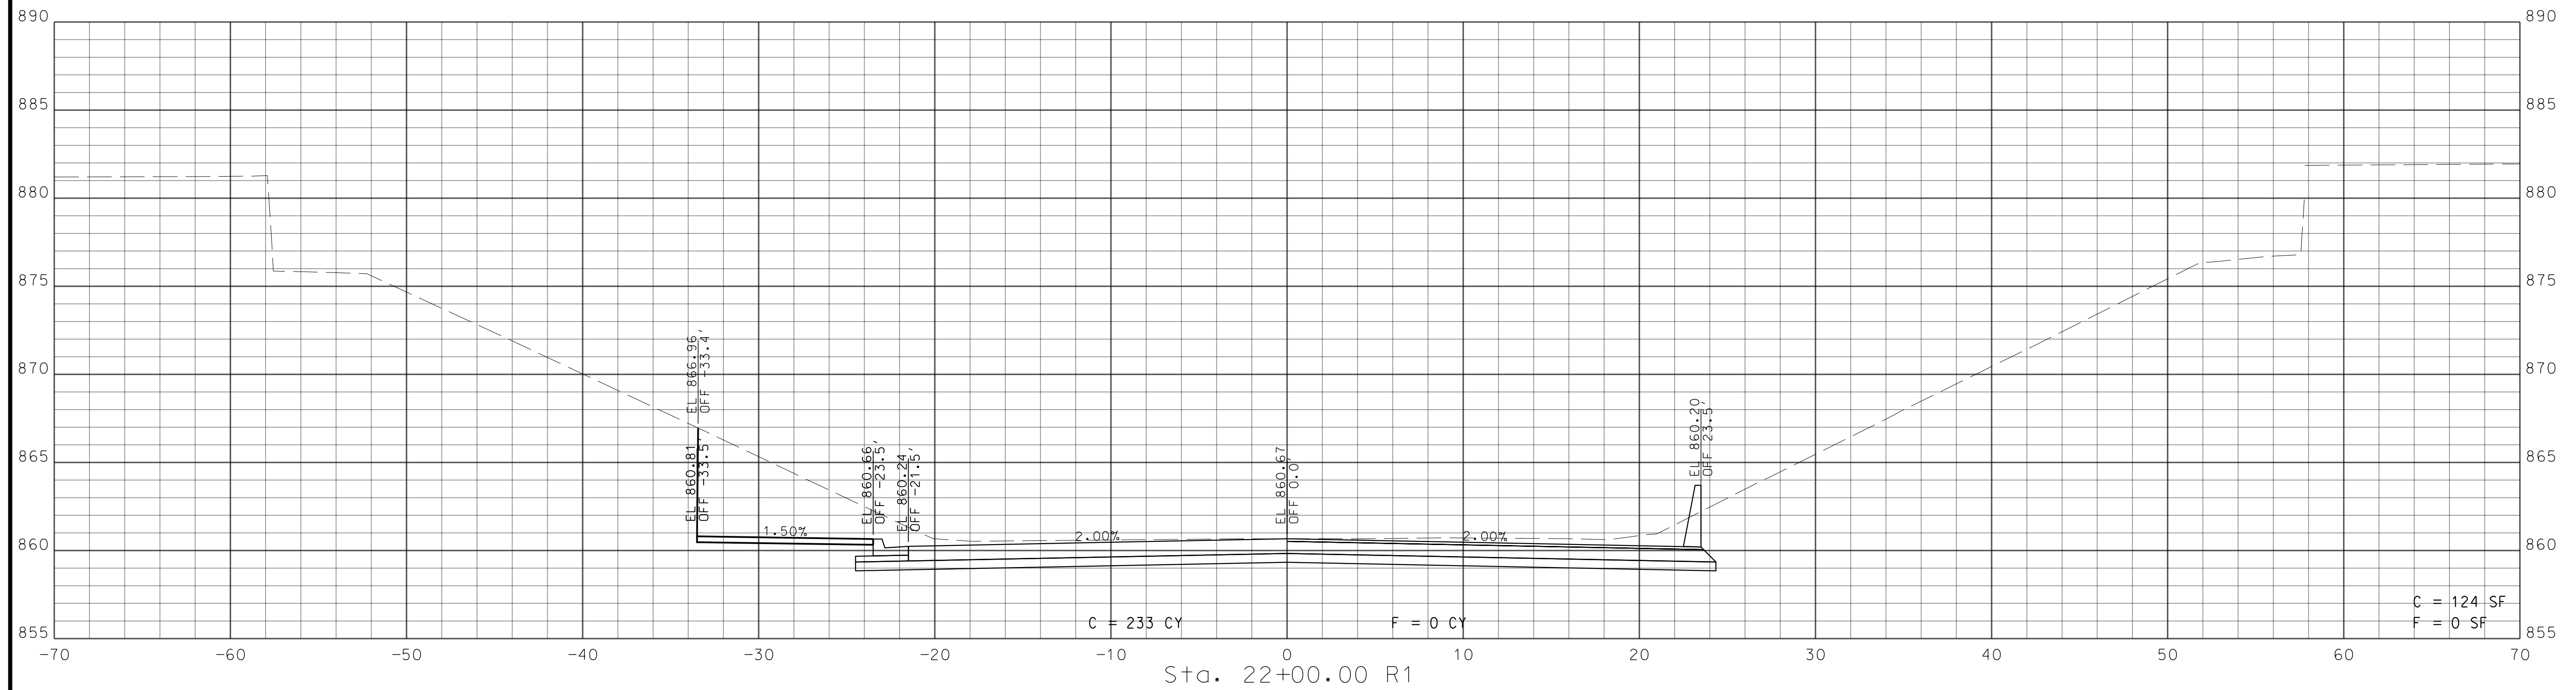


NW 56TH ST STA. 21+50.00 R1 TO STA. 22+00.00 R1

DATE PREPARED	
6/26/2020	
ROUTE	STATE
I-29	MO
DISTRICT	SHEET NO.
KC	16
COUNTY	
PLATTE	
JOB NO.	
J413291	
CONTRACT ID.	

PROJECT NO.

RIDGE NO.


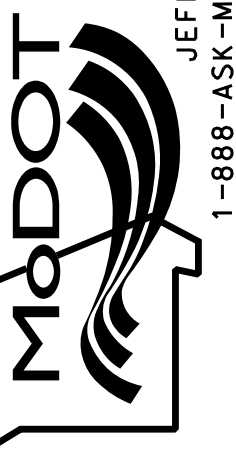
[illegible]MISSOURI HIGHWAYS AND TRANSPORTATION
COMMISSION

JEFFERSON CITY, MO 65102
1-888-ASK-MODOT (1-888-275-6636)

1411 East 104th St.
Kansas City, MO 64131
Tel (816) 874-4655
Fax (816) 874-4675
www.trekdesigngroup.com

Authority 2002010300


THEK
DESIGN GROUP, LLC

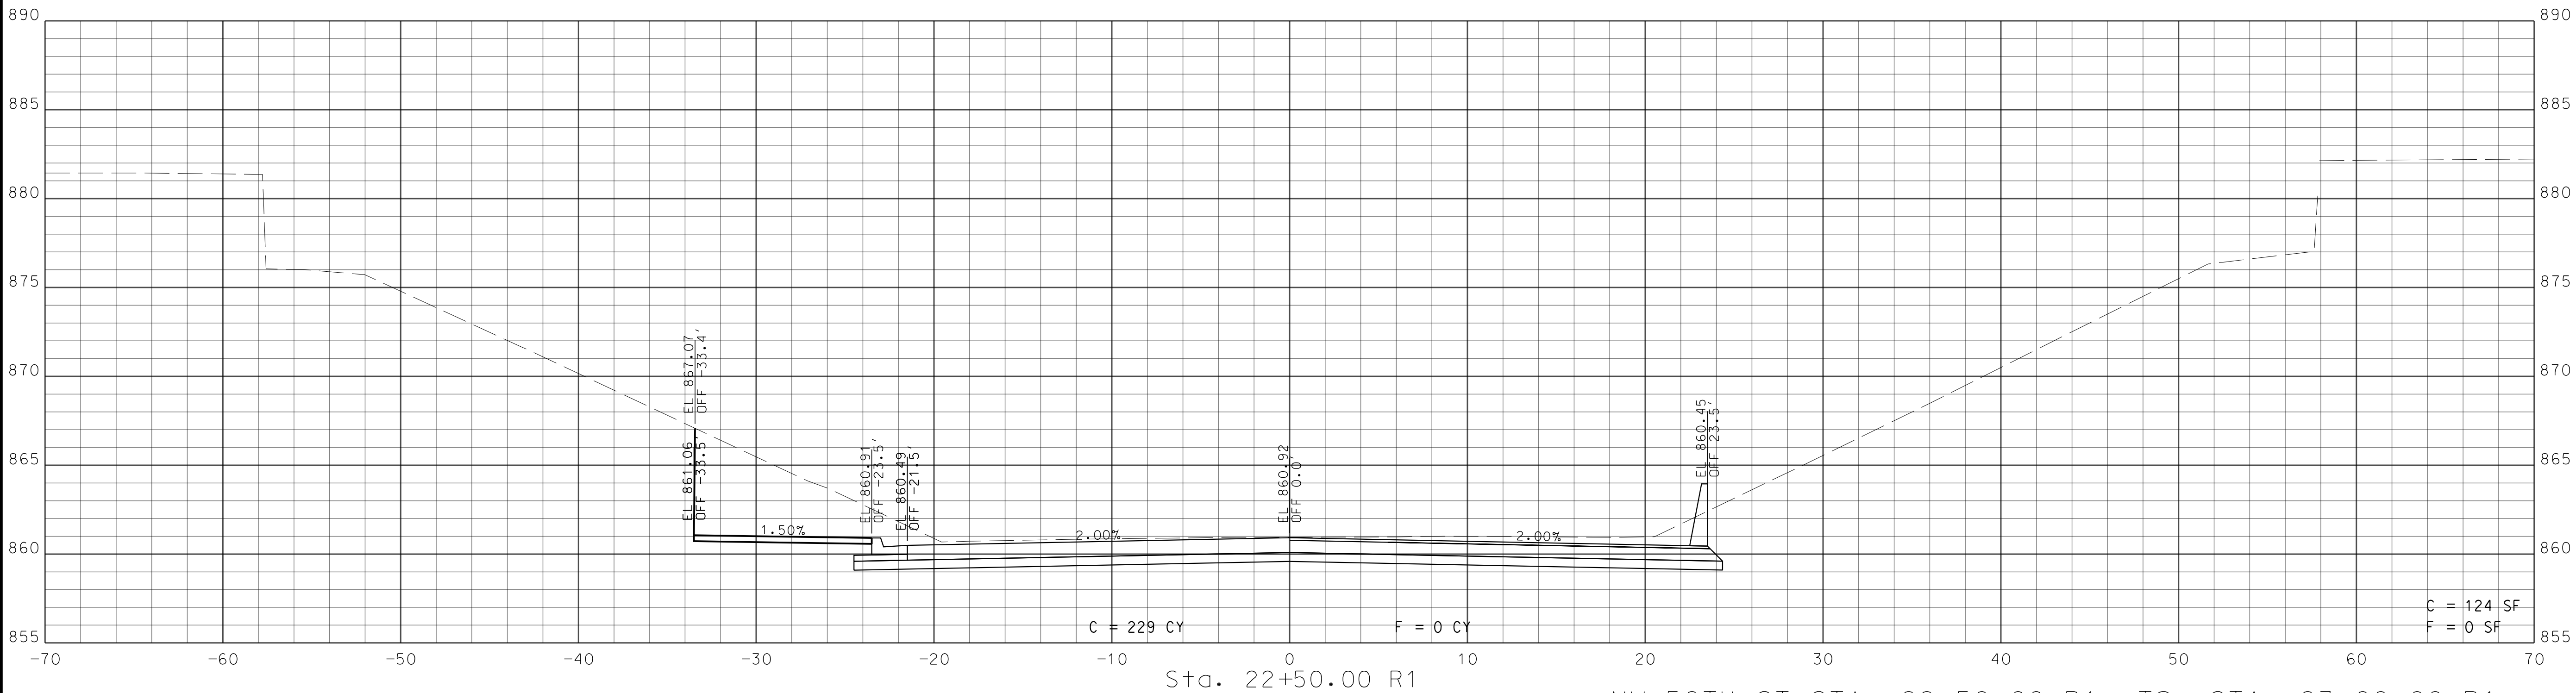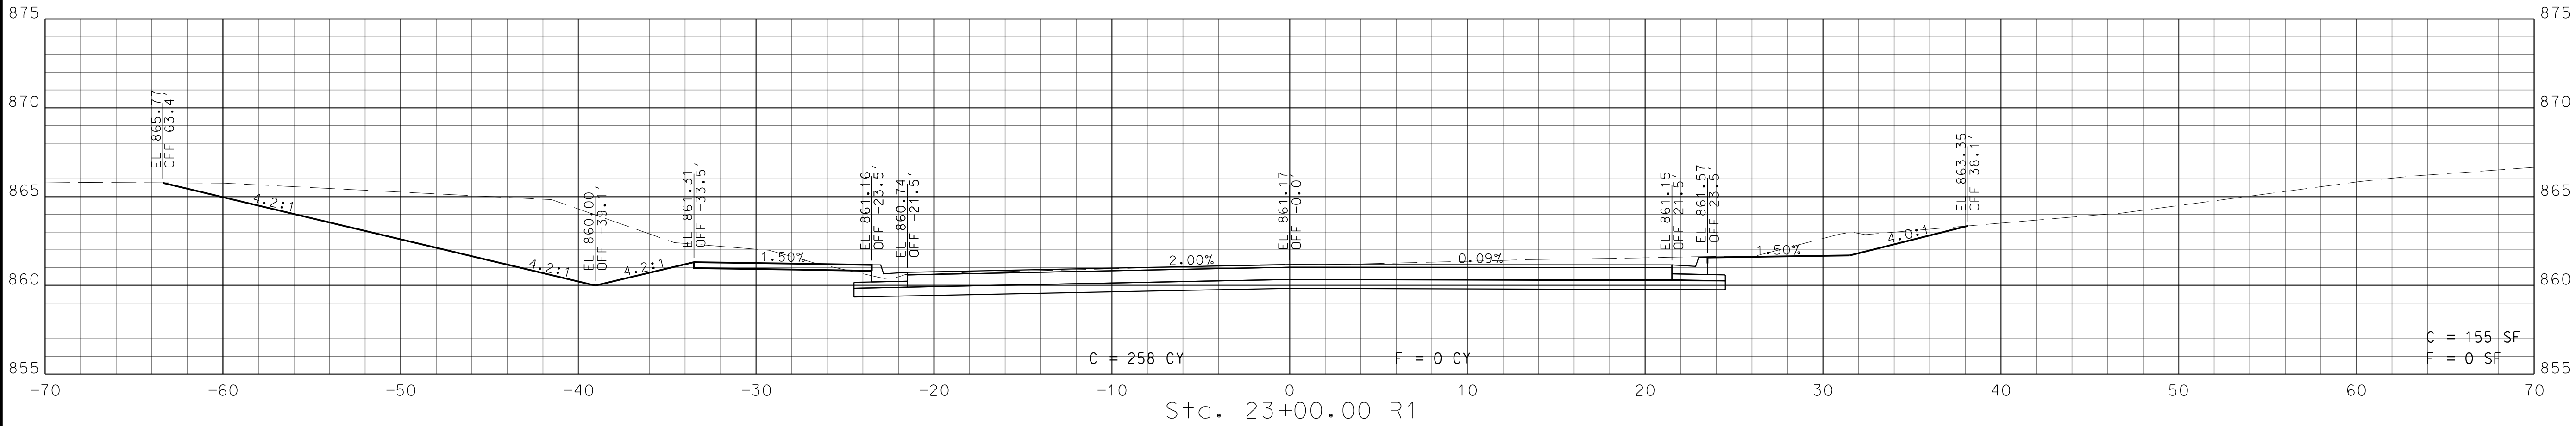


NW 56TH ST STA. 22+50.00 R1 TO STA. 23+00.00 R1

DATE PREPARED 6/26/2020	
ROUTE I-29	STATE MO
DISTRICT KC	SHEET NO. 17
COUNTY PLATTE	
JOB NO. J413291	
CONTRACT ID.	
PROJECT NO.	
BRIDGE NO.	
DATE	DESCRIPTION

MISSOURI HIGHWAYS AND TRANSPORTATION COMMISSION



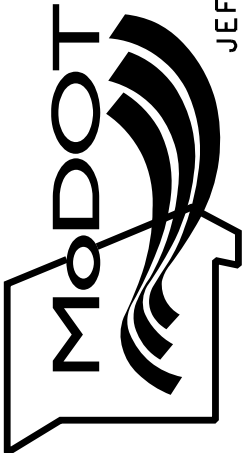


105 WEST CAPITAL
JEFFERSON CITY, MO 65102
1-888-ASK-MODOT (1-888-275-6636)

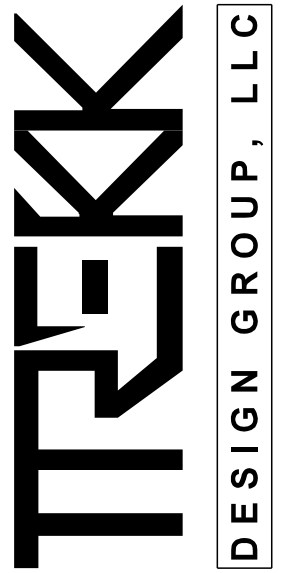

1411 East 104th St.
Kansas City, MO 64131
Tel (816) 974-4655
Fax (816) 974-4675
www.trekdesigngroup.com

Missouri Cert. of
Authority 202010300

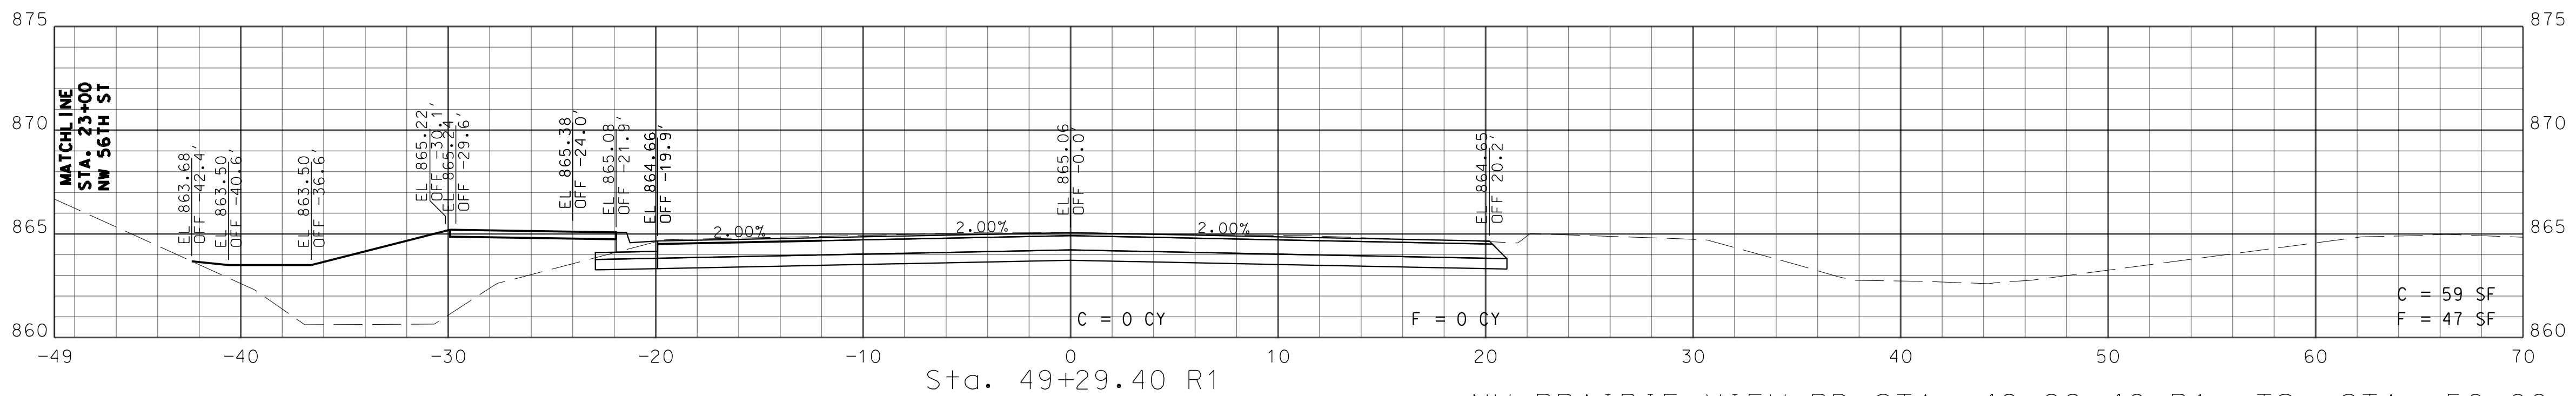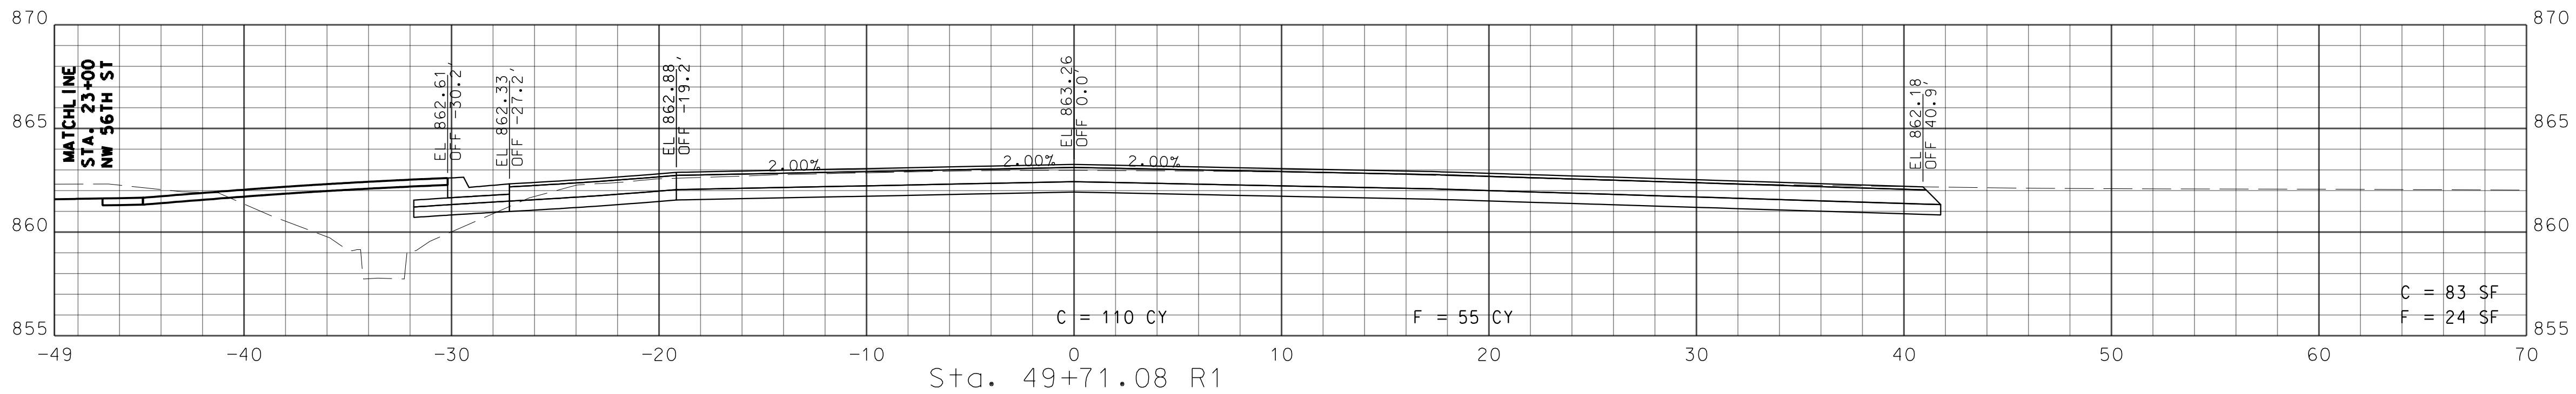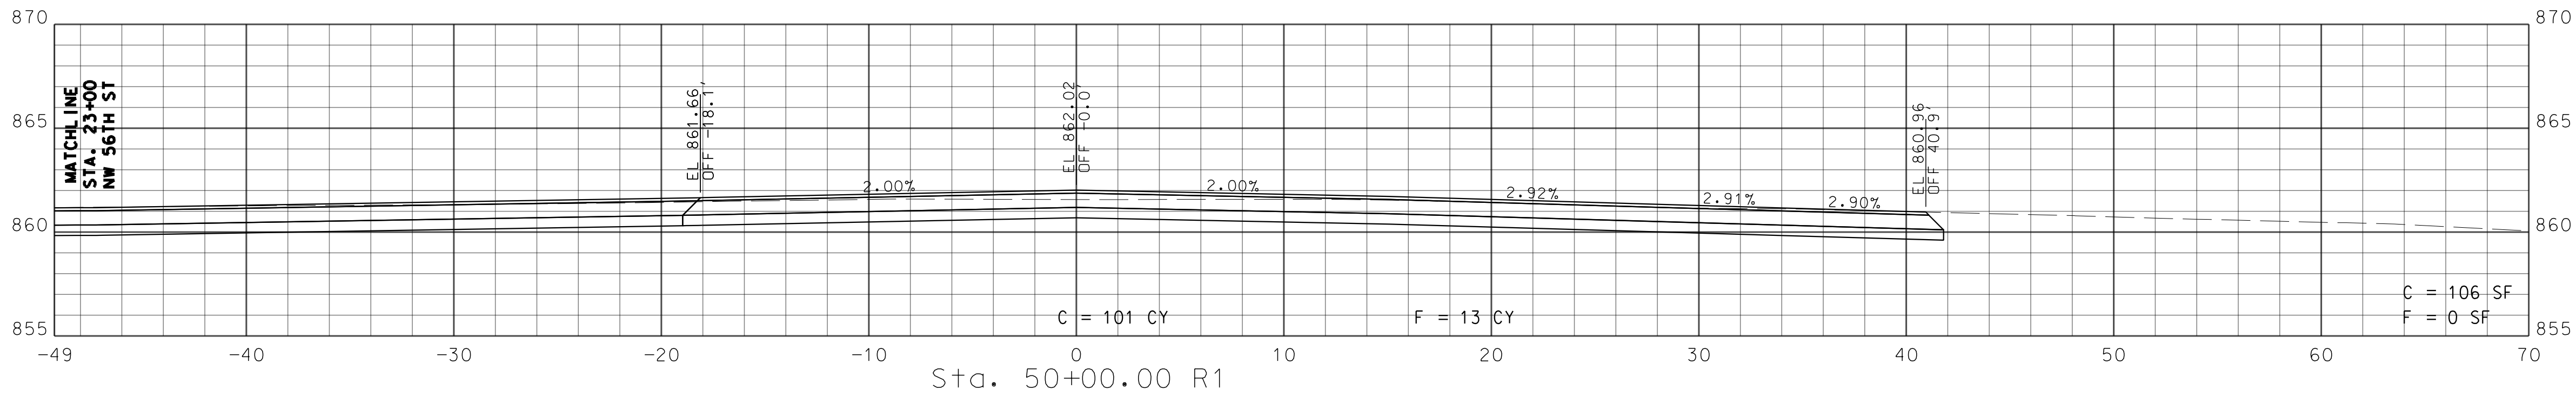

NW PRAIRIE VIEW RD STA. 49+29.40 R1 TO STA. 50+00.00 R1

DATE PREPARED
6/26/2020

ROUTE
I-29

DISTRICT
KC

STATE
MO

SHEET NO.
18

COUNTY
PLATTE

JOB NO.
J413291


CONTRACT ID.

PROJECT NO.

BRIDGE NO.

DESCRIPTION	DATE

MISSOURI HIGHWAYS AND TRANSPORTATION COMMISSION

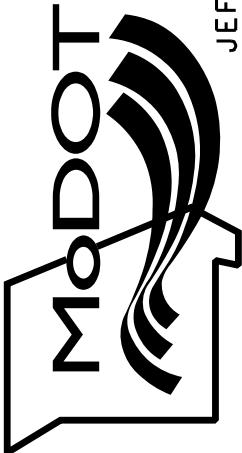

105 WEST CAPITAL
JEFFERSON CITY, MO 65102
1-888-ASK-MODOT (1-888-275-6636)





1411 East 104th St.
Kansas City, MO 64131
Tel (816) 974-4655
Fax (816) 974-4675
www.trekdesigngroup.com

Missouri Cert. of
Authority 20201030

XS_J413291_PrairieView_Ramp7.dgn 1:56:41 PM 6/26/2020

IF A SEAL IS PRESENT ON THIS SHEET IT HAS BEEN ELECTRONICALLY SEALED AND DATED.

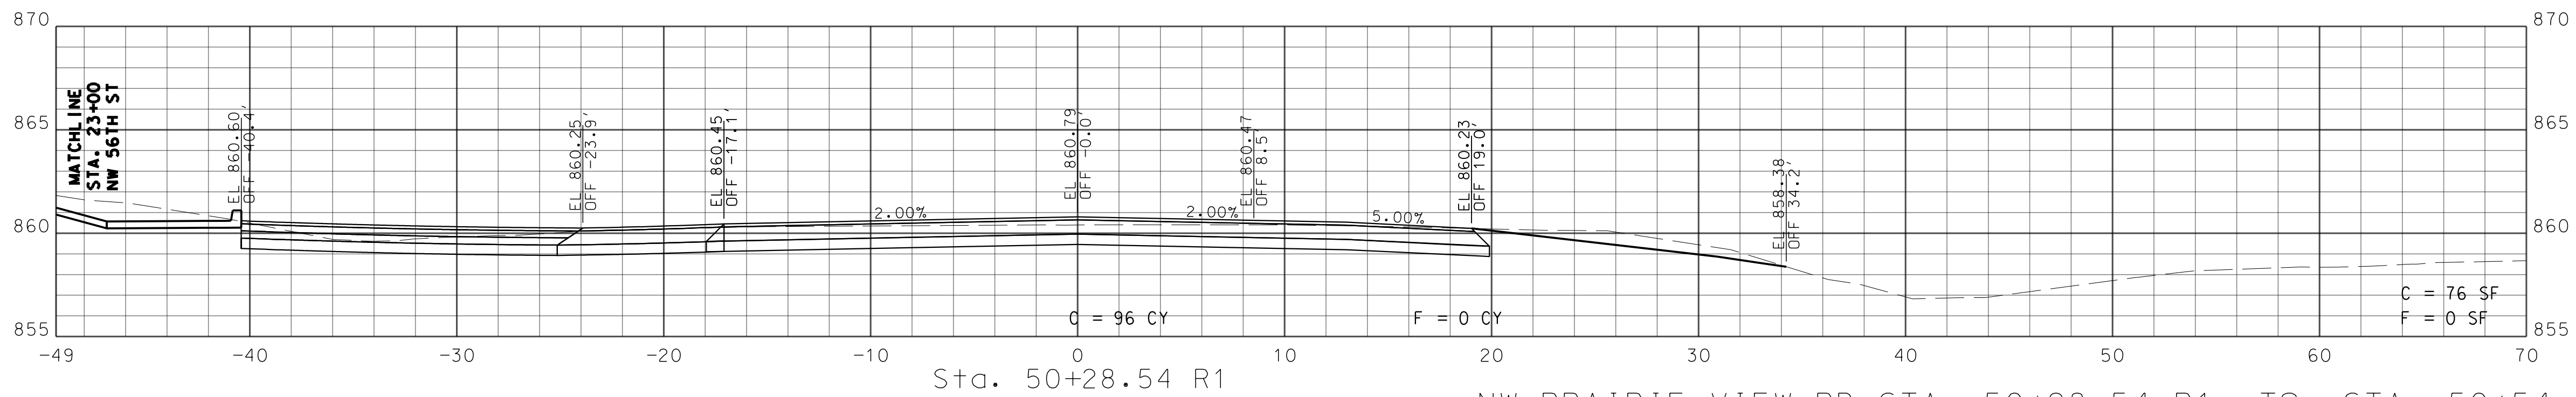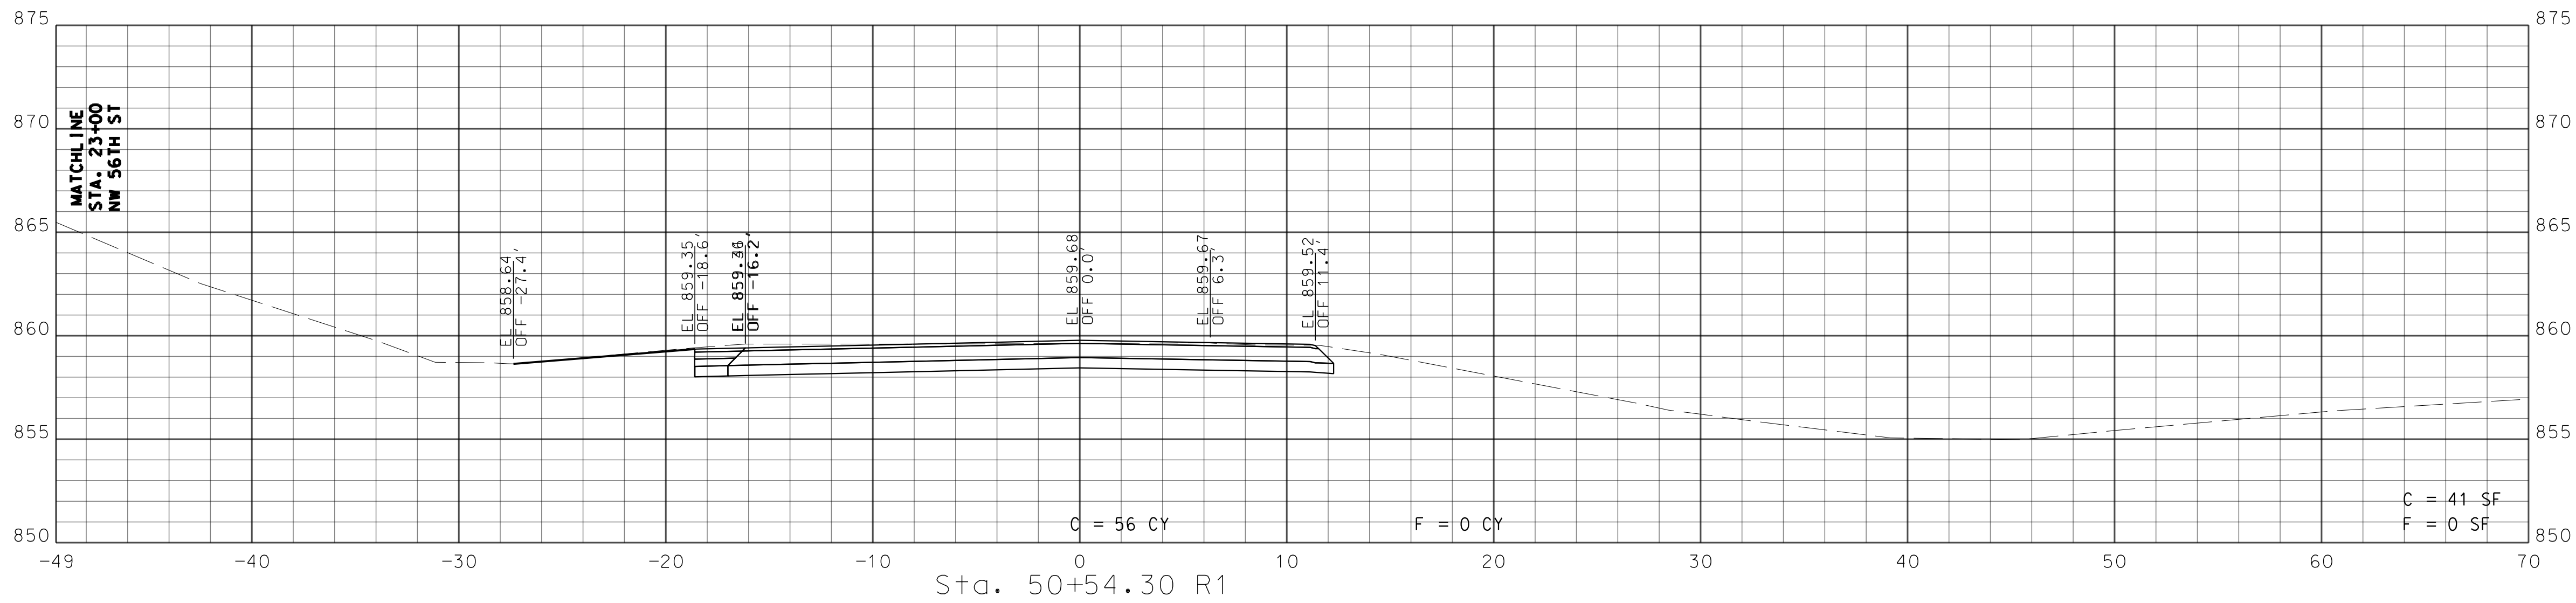

NW PRAIRIE VIEW RD STA. 50+28.54 R1 TO STA. 50+54.30 R1

DATE PREPARED
6/26/2020

ROUTE
I-29

DISTRICT
KC

COUNTY
PLATTE

JOB NO.
J413291

CONTRACT ID.

PROJECT NO.

BRIDGE NO.

STATE
MO

SHEET NO.
19

DESCRIPTION

DATE

MISSOURI HIGHWAYS AND TRANSPORTATION COMMISSION

105 WEST CAPITAL
JEFFERSON CITY, MO 65102
1-888-ASK-MODOT (1-888-275-6636)

MODOT

1411 East 104th St.
Kansas City, MO 64131
Tel (816) 974-4655
Fax (816) 974-4675
www.trekdesigngroup.com

Missouri Cert. of
Authority 202010300

TRKK

DESIGN GROUP, LLC

XS_J413291_PrairieView_Ramp7.dgn 1:56:41 PM 6/26/2020

IF A SEAL IS PRESENT ON THIS SHEET IT HAS BEEN ELECTRONICALLY SEALED AND DATED.