



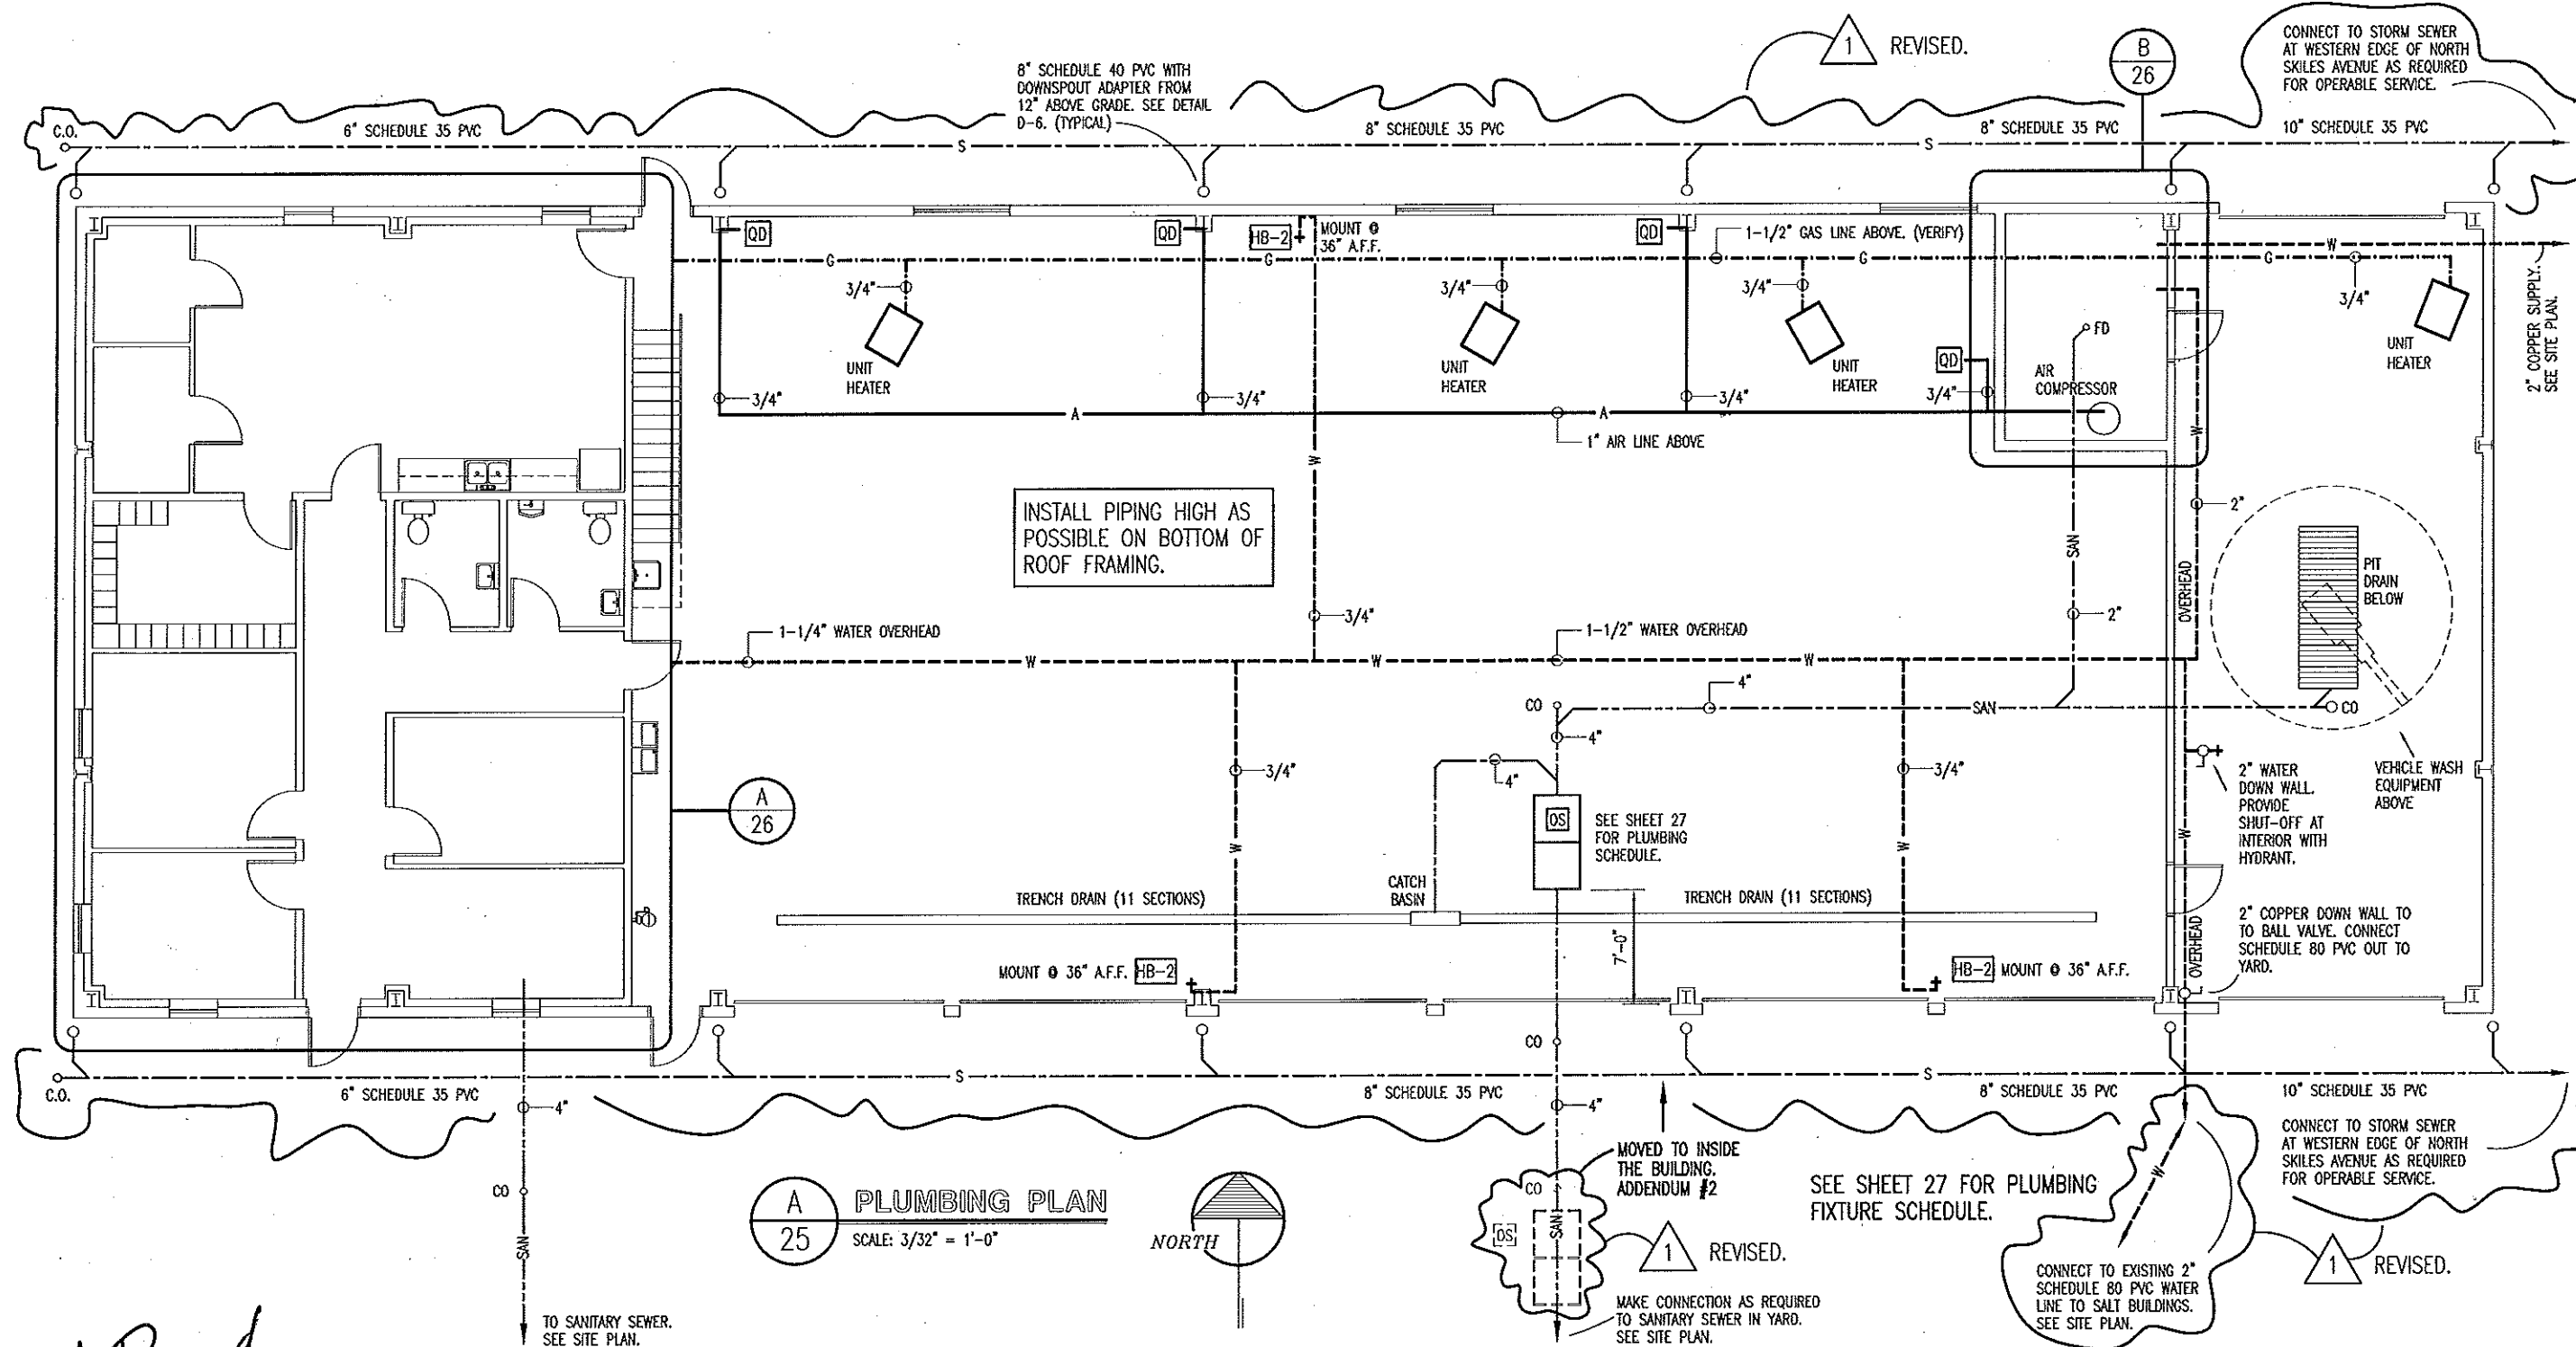

A 25 PLUMBING PLAN
 SCALE: 3/32" = 1'-0"

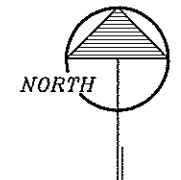

DOUGLAS A. RECORD
 DOUGLAS A. RECORD
 NUMBER
 A-2009002624
 ARCHITECT

3/19/13

PLUMBING PLAN

**MISSOURI DEPARTMENT
 OF TRANSPORTATION**
 DIVISION OF GENERAL SERVICES
 FACILITIES MANAGEMENT

NEW MAINTENANCE COMPLEX
 Kansas City District - Clay County, Kansas City, MO 64161
 3800 North Skiles Avenue

DRAWN BY: LARRY CARNER
 CHECKED BY: DOUG RECORD
 DATE: 3-19-13
 Sheet
 25 of 38