


INDEX OF DRAWINGS

1 -38 COVER SHEET	20-38 HEAD & JAMB DETAILS
2 -38 PLOT PLAN	21-38 HEAD & JAMB DETAILS
3 -38 FOUNDATION PLAN	22-38 WALL SECTIONS
4 -38 FOUNDATION DETAILS	23-38 WALL SECTIONS
5 -38 FOUNDATION DETAILS	24-38 REFLECTED CEILING PLAN
6 -38 FOUNDATION DETAILS	25-38 PLUMBING PLAN
7 -38 FOUNDATION DETAILS	26-38 OFFICE PLUMBING PLAN
8 -38 FOUNDATION DETAILS	27-38 PLUMBING NOTES & SCHEDULES
9 -38 DIMENSIONAL FLOOR PLAN	28-38 MECHANICAL PLAN
10-38 OFFICE DIMENSIONS & MEZZANINE PLAN	29-38 OFFICE MECHANICAL PLAN
11-38 ARCHITECTURAL FLOOR PLAN	30-38 MECHANICAL NOTES & SCHEDULES
12-38 SCHEDULES	31-38 MECHANICAL DETAILS
13-38 ELEVATIONS	32-38 ELECTRICAL LIGHTING PLAN
14-38 BUILDING SECTION	33-38 OFFICE ELECTRICAL LIGHTING PLAN
15-38 BUILDING SECTION	34-38 ELECTRICAL POWER PLAN
16-38 BUILDING SECTION	35-38 OFFICE POWER PLAN
17-38 STAIR & RAILING DETAILS	36-38 POWER DISTRIBUTION PANELS
18-38 INTERIOR ELEVATIONS	37-38 MEZZ. ELECTRIC, NOTES & SCHEDULES
19-38 HEAD & JAMB DETAILS	38-38 ELECTRIC SENSORS

MISSOURI DEPARTMENT
OF TRANSPORTATION
STANDARD MAINTENANCE BUILDING

CODE REQUIREMENTS

- BUILDING CODE -- CURRENT IBC
- PLUMBING CODE -- CURRENT IBC
- MECHANICAL CODE -- CURRENT IBC
- ELECTRICAL CODE -- CURRENT N.E.C.

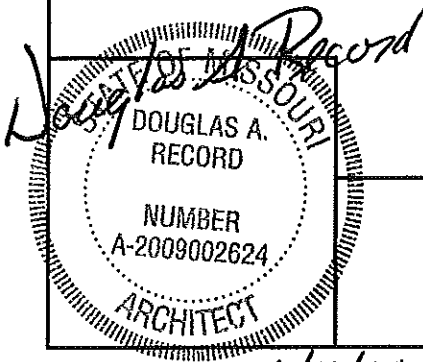


COVER SHEET

MISSOURI DEPARTMENT
OF TRANSPORTATION
DIVISION OF GENERAL SERVICES
FACILITIES MANAGEMENT

STANDARD MAINTENANCE BUILDING

DRAWN BY: LARRY CARVER
CHECKED BY: DOUG RECORD
DATE: 6-11-14
Sheet
1 of 38

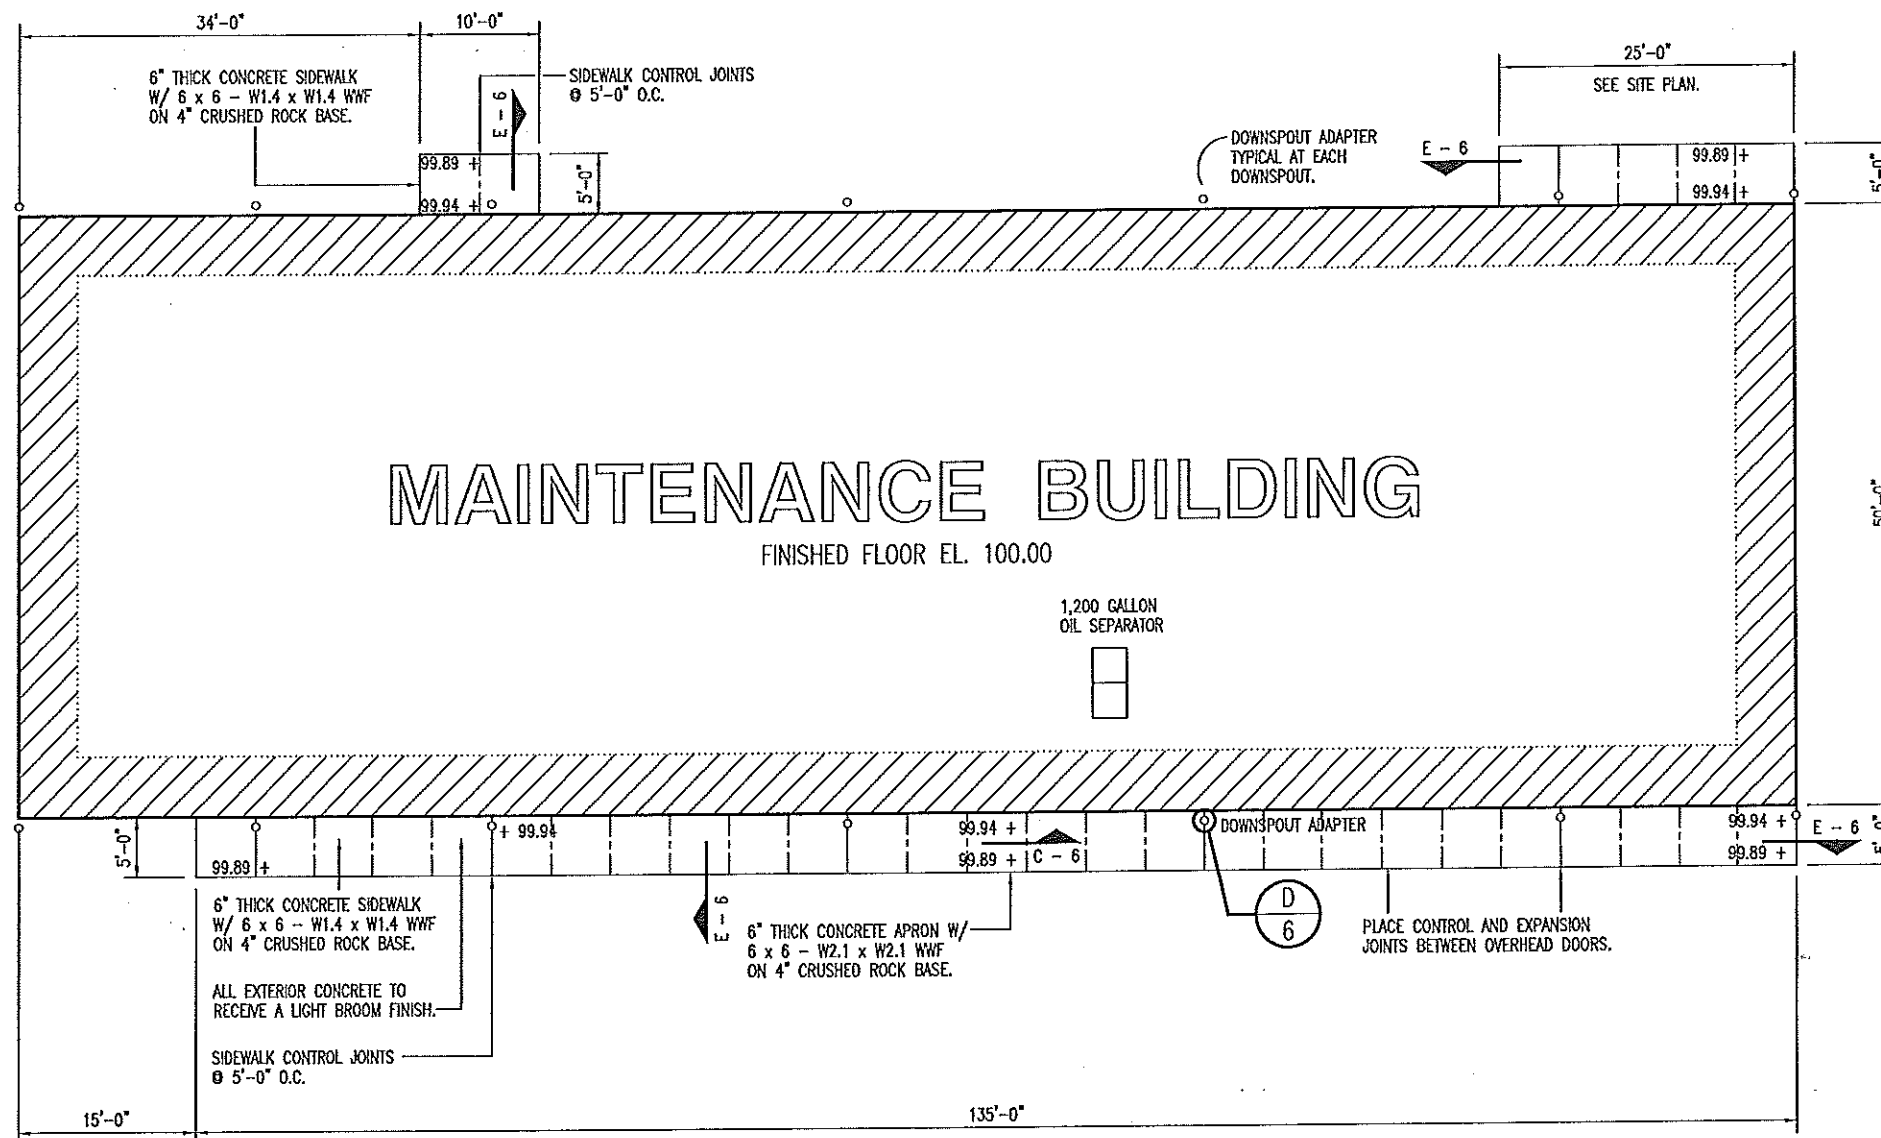


CONTRACTOR NOTE:

CONNECT ALL UTILITIES AS REQUIRED FOR A COMPLETE AND OPERATIONAL SYSTEM FOR THE NEW BUILDING.

ALL UNUSED EXCAVATED MATERIAL CAN BE STOCKPILED ON-SITE. LOCATION BY OWNER.

A
2 **PLOT PLAN**
SCALE: 1/16" = 1'-0"

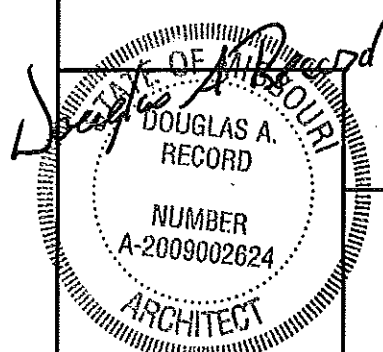

6/11/14

PLOT PLAN

**MISSOURI DEPARTMENT
OF TRANSPORTATION**


DIVISION OF GENERAL SERVICES
FACILITIES MANAGEMENT

STANDARD MAINTENANCE BUILDING


DRAWN BY: LARRY CAYNER
CHECKED BY: DOUG RECORD
DATE: 6-11-14
Sheet
2 of 38

NOTE:

PROVIDE (1) 4" SCHEDULE 40 PVC CONDUIT WITH FIBEROPTIC SWEEPS TO 110 MECHANICAL ROOM. EXTEND 12" ABOVE FINISH FLOOR AND CAP BELOW TELECOMMUNICATION RACK AND 10'-0" FROM THE WEST WALL 24" BELOW GRADE. THE ENTRY AND CONNECTION POINTS WILL BE DETERMINED BY THE SITE LAYOUT.

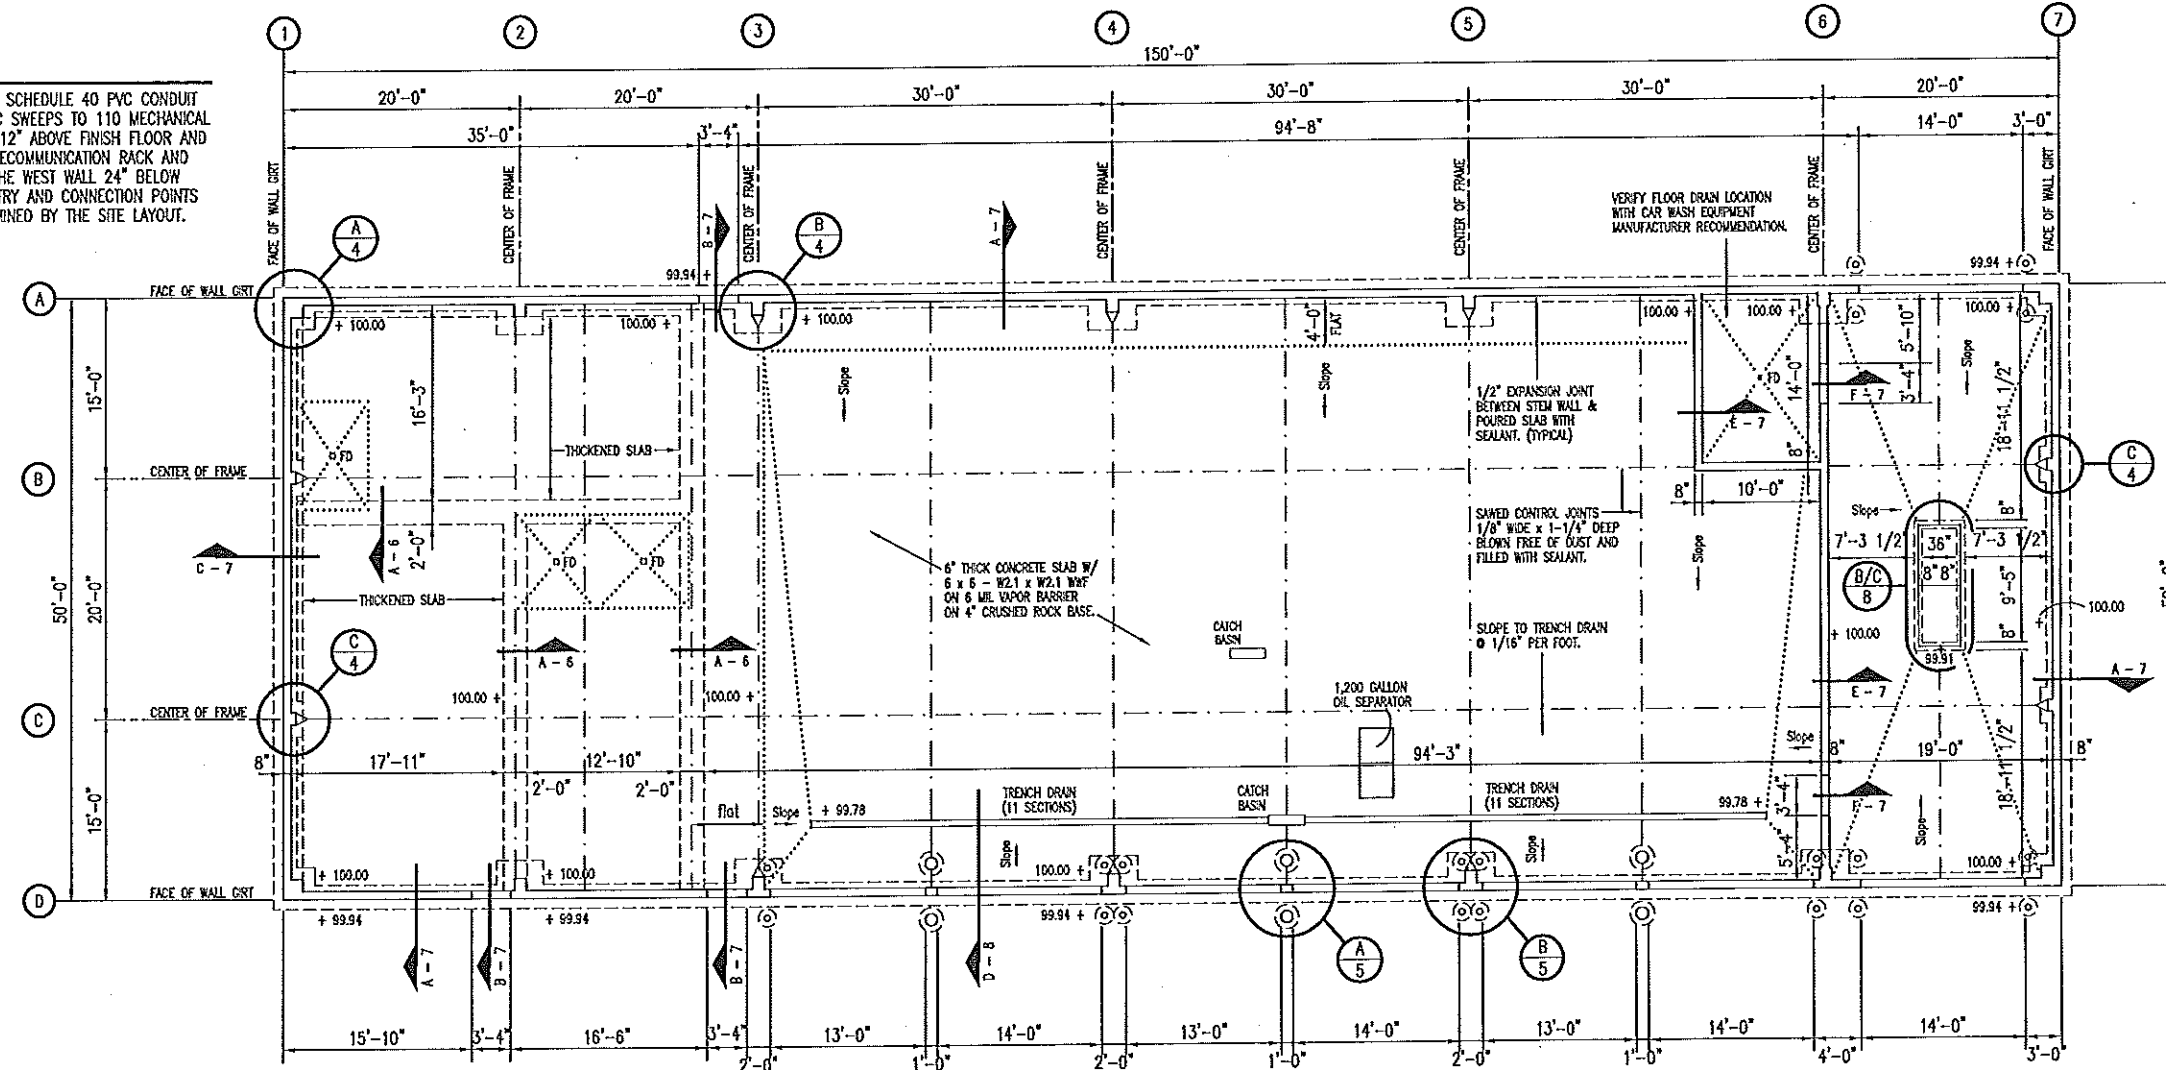

A
3 FOUNDATION PLAN
SCALE: 1/16" = 1'-0"

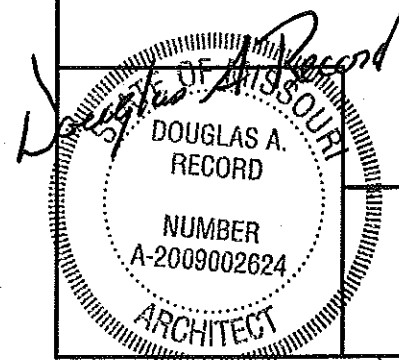


FOUNDATION PLAN


MISSOURI DEPARTMENT
OF TRANSPORTATION
DIVISION OF GENERAL SERVICES
FACILITIES MANAGEMENT

STANDARD MAINTENANCE BUILDING


DRAWN BY: LARRY CARVER
CHECKED BY: DOUG RECORD
DATE: 6-11-14
Sheet
3 of 38

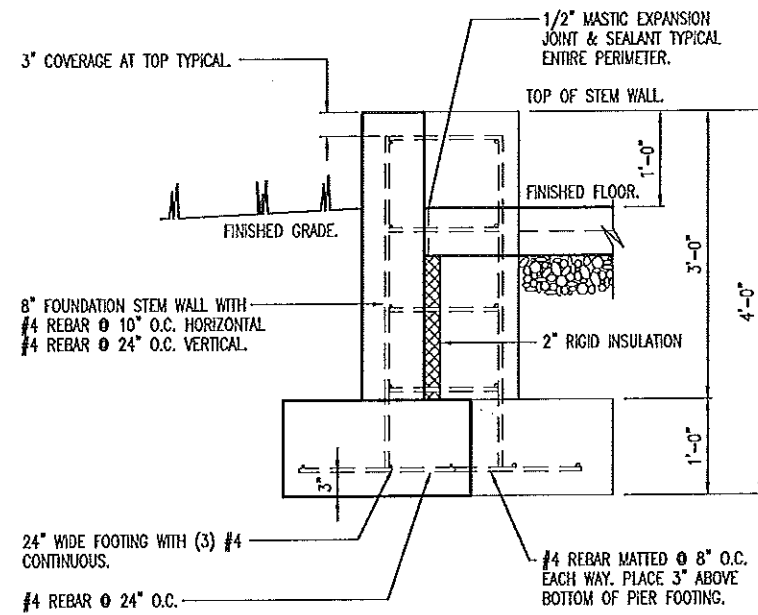


ELEVATION

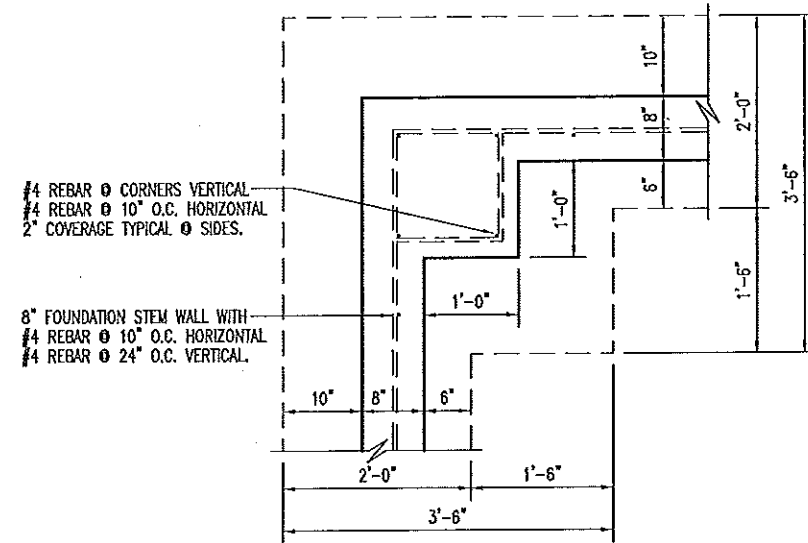


PLAN VIEW

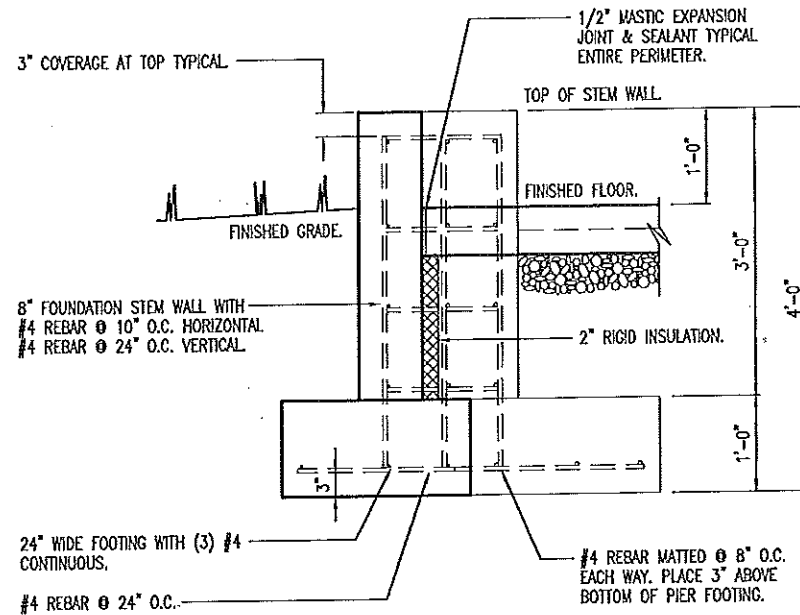


ELEVATION

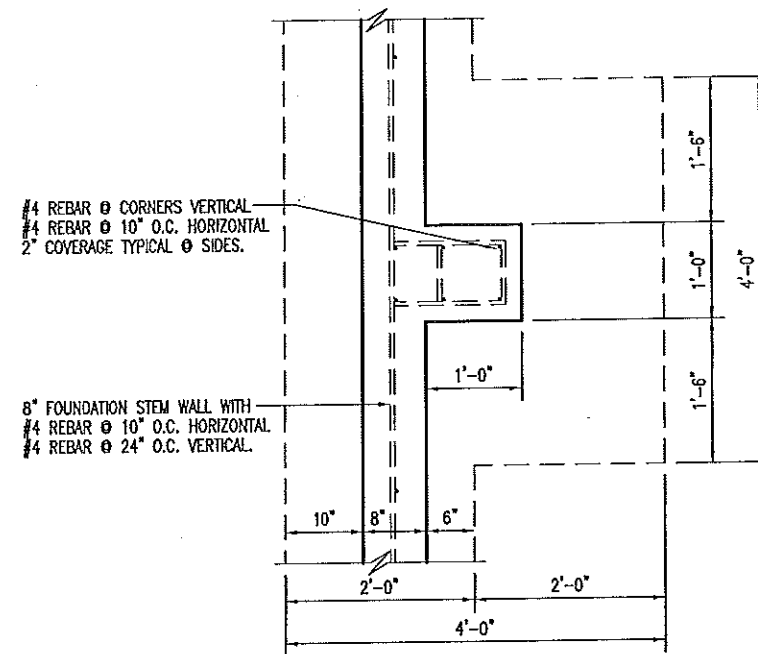

PLAN VIEW

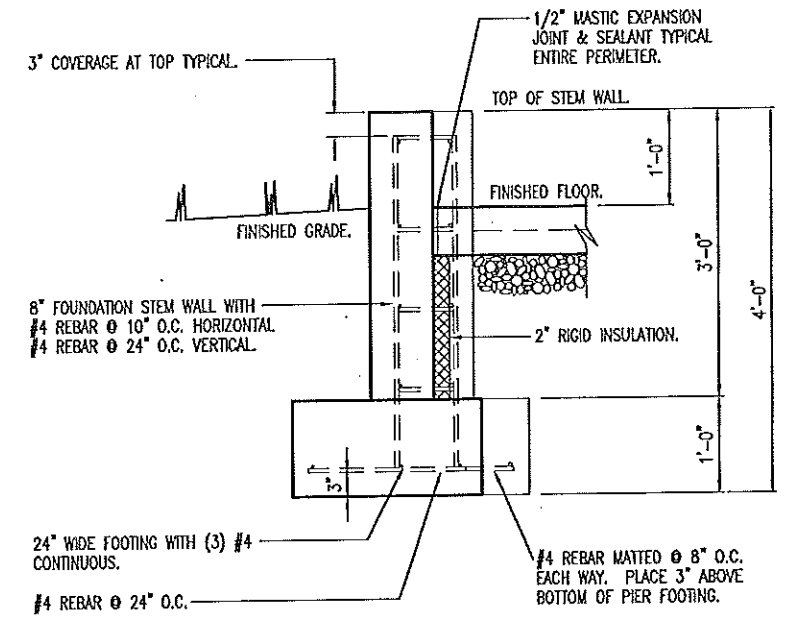

ELEVATION

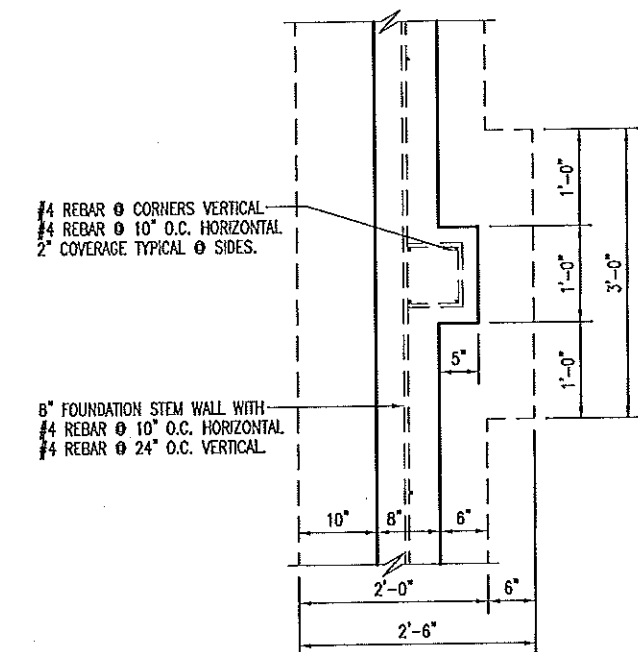


PLAN VIEW

A
4
CORNER COLUMN FOOTING
SCALE: 1/2" = 1'-0"

B
4
SIDEWALL COLUMN FOOTING
SCALE: 1/2" = 1'-0"

C
4
ENDWALL COLUMN FOOTING
SCALE: 1/2" = 1'-0"

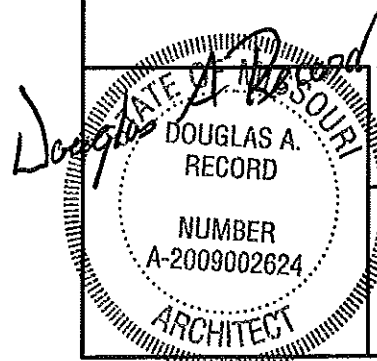



FOUNDATION DETAILS

MISSOURI DEPARTMENT
OF TRANSPORTATION
DIVISION OF GENERAL SERVICES
FACILITIES MANAGEMENT



STANDARD MAINTENANCE BUILDING

DRAWN BY: LARRY CARVER
CHECKED BY: DOUG RECORD
DATE: 6-11-14
Sheet
4 of 38


6/11/14

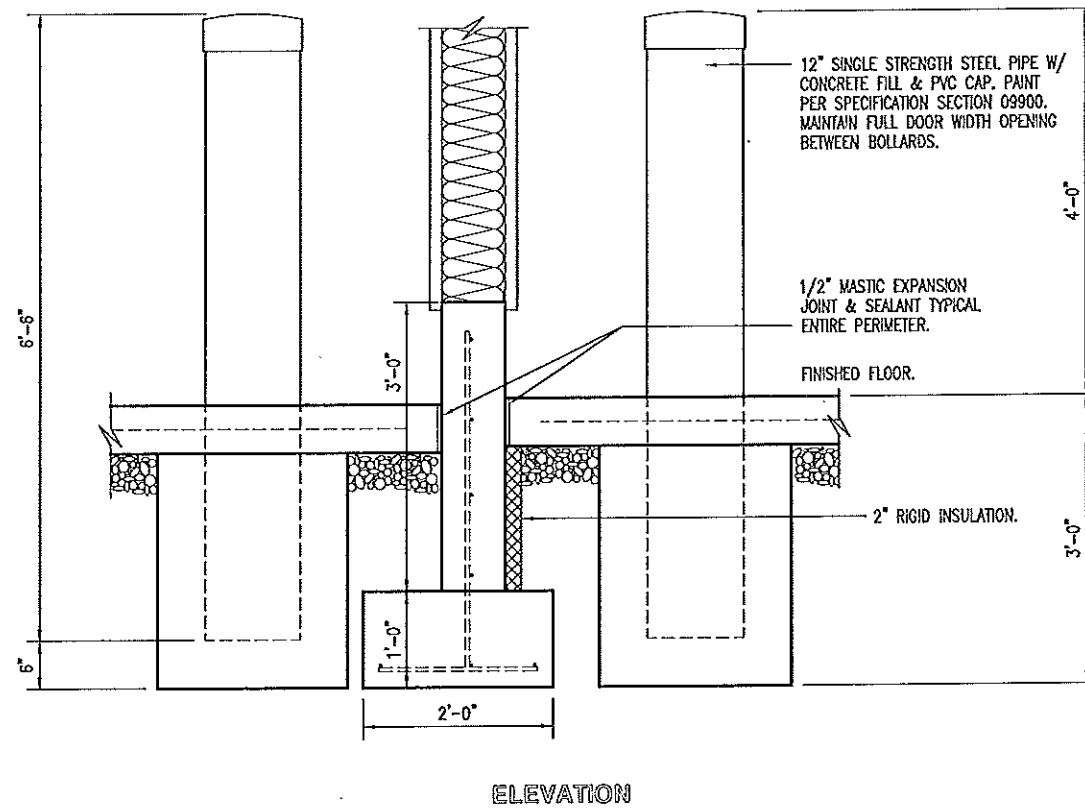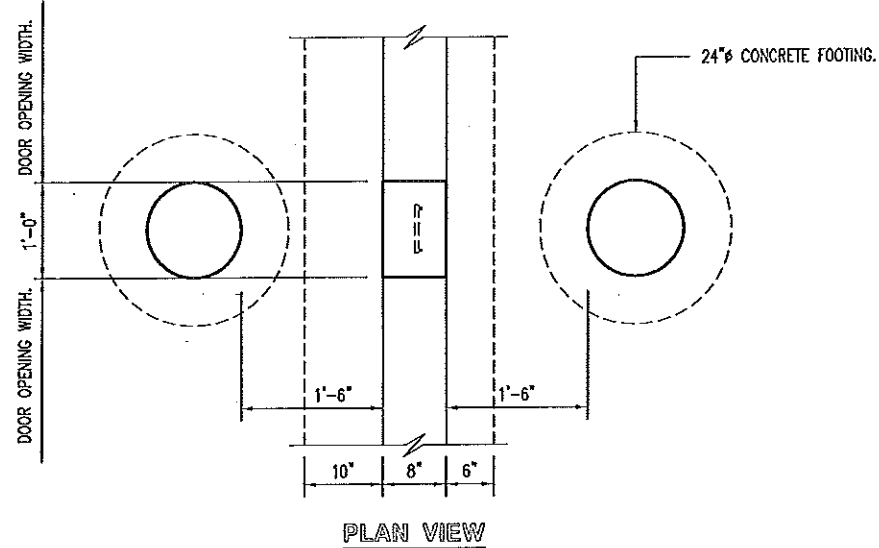

A BOLLARD @ FOOTING DETAIL
5 SCALE: 1/2" = 1'-0"

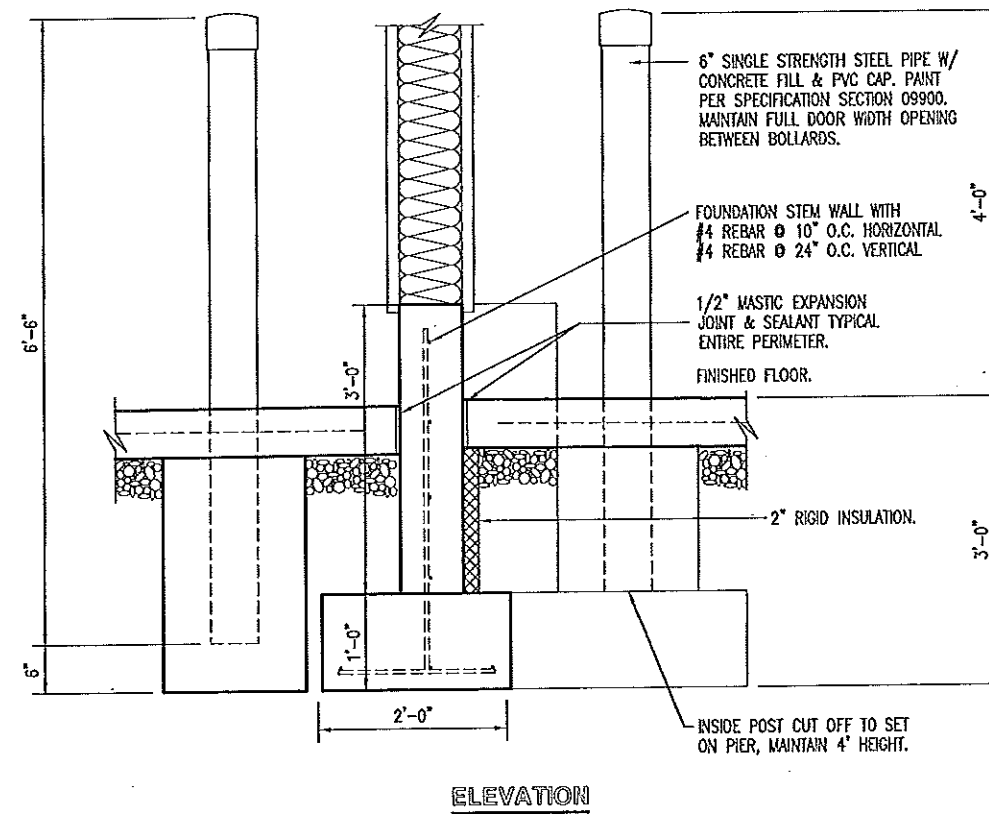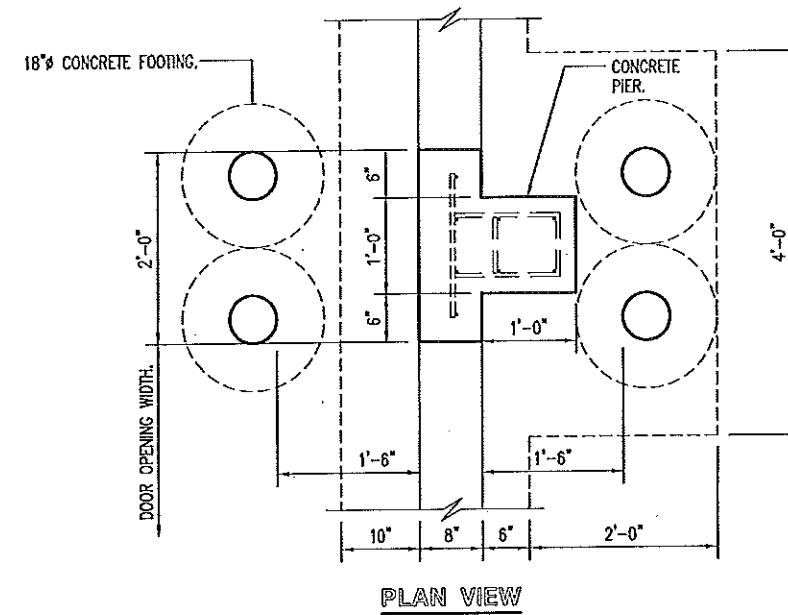

B BOLLARDS @ PIER DETAIL
5 SCALE: 1/2" = 1'-0"

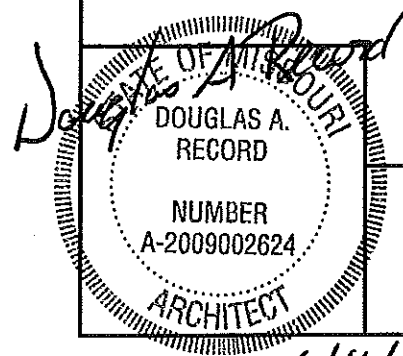


6/11/14

FOUNDATION DETAILS


MISSOURI DEPARTMENT
OF TRANSPORTATION
DIVISION OF GENERAL SERVICES
FACILITIES MANAGEMENT

STANDARD MAINTENANCE BUILDING


DRAWN BY: LARRY CARYN
CHECKED BY: DOUG RECORD
DATE: 6-11-14
Sheet
5 of 38

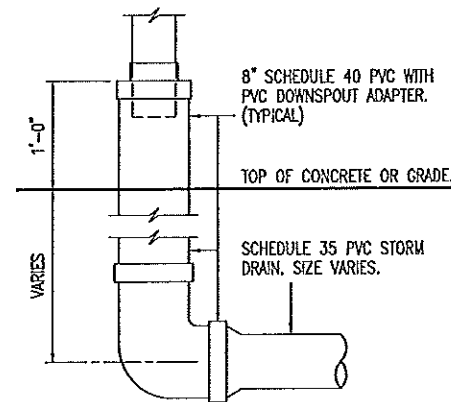


D
6 **DOWNSPOUT ADAPTER**
SCALE: 1/2" = 1'-0"

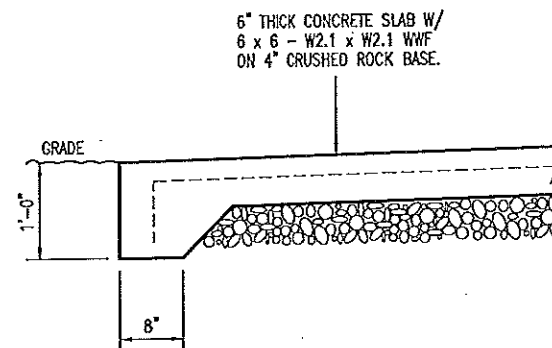

E
6 **SIDEWALK SECTION**
SCALE: 1/2" = 1'-0"

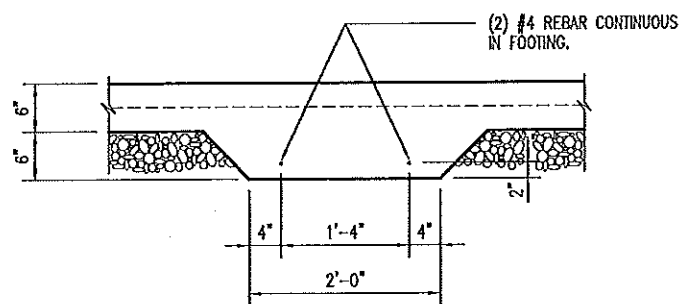

A
6 **INTERIOR BEARING FOOTING**
SCALE: 1/2" = 1'-0"

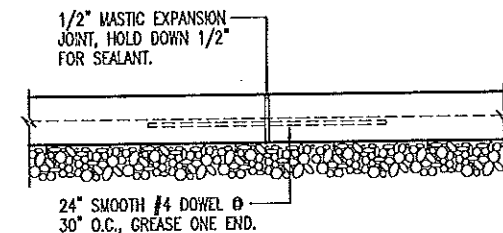

C
6 **EXPANSION JOINT**
SCALE: 1/2" = 1'-0"

CONCRETE NOTES

1. CONCRETE WORK SHALL BE EXECUTED IN STRICT COMPLIANCE WITH THE LATEST EDITION OF THE AMERICAN CONCRETE INSTITUTE (A.C.I.) MANUAL OF CONCRETE PRACTICE.
2. FOUNDATION DESIGN IS BASED UPON AN ASSUMED SOIL BEARING CAPACITY OF 2,000 PSF. IF WET OR UNUSUAL SOIL CONDITIONS ARE ENCOUNTERED, NOTIFY THE DESIGNER AND CONSTRUCTION INSPECTOR BEFORE PROCEEDING WITH THE WORK.
3. IF CONDITIONS REQUIRING ROCK EXCAVATION ARE ENCOUNTERED, NOTIFY THE DESIGNER AND CONSTRUCTION INSPECTOR BEFORE PROCEEDING WITH THE WORK.
4. ALL CONCRETE SHALL BE TYPE 1 CEMENT WITH A COMPRESSIVE STRENGTH OF 4,000 PSI @ 28 DAYS WITH 4" SLUMP.
5. CONCRETE EXPOSED TO THE EXTERIOR SHALL RECEIVE AIR ENTRAINMENT 6% +/- 2%.
6. FOUNDATION BEAMS AND FOOTINGS SHALL BEAR A MINIMUM OF 12 INCHES INTO UNDISTURBED SOIL AND 36 INCHES MINIMUM BELOW FINISH GRADE.
7. DEFORMED STEEL REINFORCING BARS SHALL BE: #4 AND LARGER, ASTM A615 GRADE 60.
8. PROVIDE CORNER REINFORCING BARS WITH 12" MINIMUM LAP EQUAL IN SIZE AND GRADE TO CONNECTING BARS.
9. EXTERIOR CONCRETE FLATWORK SHALL HAVE A LIGHT BROOM FINISH.
10. COORDINATE WORK OF OTHER TRADES REQUIRED TO BE INSTALLED IN, UNDER, OR THROUGH CONCRETE PRIOR TO PLACEMENT OF CONCRETE. INSTALL ALL ANCHORAGES AND SLEEVES REQUIRED FOR THE INSTALLATION OF WORK BY OTHER TRADES.
11. ENTIRE PERIMETER OF BUILDING TO RECEIVE 2" POLYISOCYANURATE RIGID INSULATION BOARD.
12. SAWED CONTROL JOINTS SHALL BE CLEANED FREE OF ALL DEBRIS AND FILLED WITH SEALANT. SEE SECTION 07900.
13. ALL EXPOSED INTERIOR CONCRETE FLOORS SHALL RECEIVE A CURING/SEALING FINISH PER SPECIFICATION SECTION 03346.
14. COPPER PIPING RUN THROUGH CONCRETE WORK SHALL BE RUN THROUGH PVC SLEEVES.
15. CONCRETE COLUMN PIER DIMENSIONS MAY VARY PER BUILDING MANUFACTURER. CONTRACTOR MUST INCLUDE IN HIS BID ALL MATERIALS AND LABOR DUE TO ANY VARIATION FROM DRAWINGS.
16. PROVIDE PRE-CAST TRENCH DRAIN & CATCH BASIN AS SPECIFIED. INSTALL AS RECOMMENDED BY THE MANUFACTURER. ACTUAL CONSTRUCTION AND INSTALLATION MAY REQUIRE SOME FIELD MODIFICATIONS. ANY DEVIATION FROM THE DRAWINGS AND SPECIFICATIONS SHALL HAVE PRIOR APPROVAL FROM THE ARCHITECT OR BUILDING INSPECTOR.
17. SEE SPECIFICATION SECTION 03300 CONCRETE FOR ADDITIONAL INFORMATION.

MISSOURI DEPARTMENT
OF TRANSPORTATION
DIVISION OF GENERAL SERVICES
FACILITIES MANAGEMENT

STANDARD MAINTENANCE BUILDING

DRAWN BY: LARRY CARVER
CHECKED BY: DOUG RECORD
DATE: 6-11-14
Sheet
6 of 38


FOUNDATION DETAILS

DOUGLAS A.
RECORD


NUMBER
A-2009002624

ARCHITECT


6/11/14

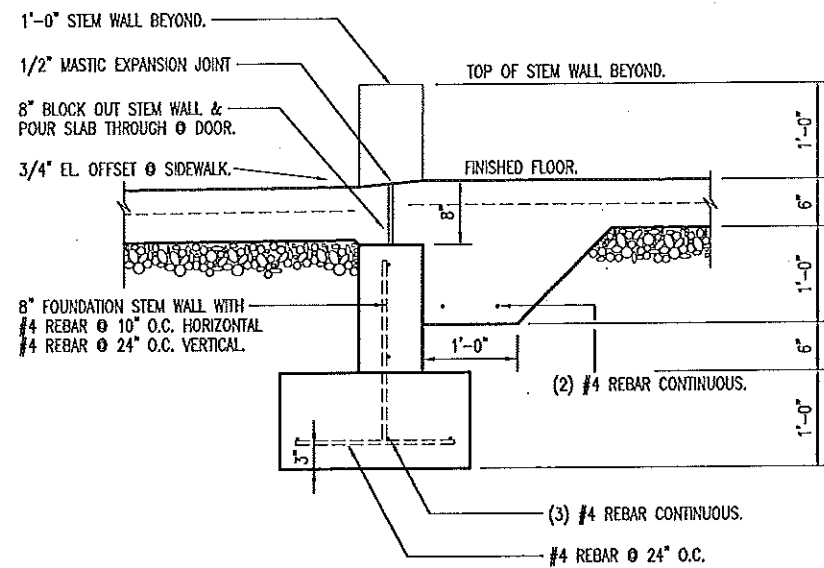


D EXTERIOR STEM WALL
7 SCALE: 1/2" = 1'-0"

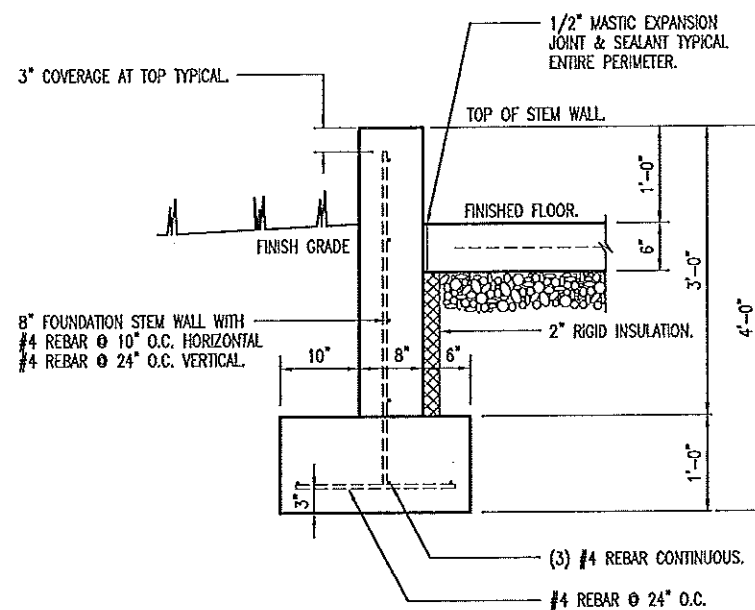


A EXTERIOR STEM WALL
7 SCALE: 1/2" = 1'-0"

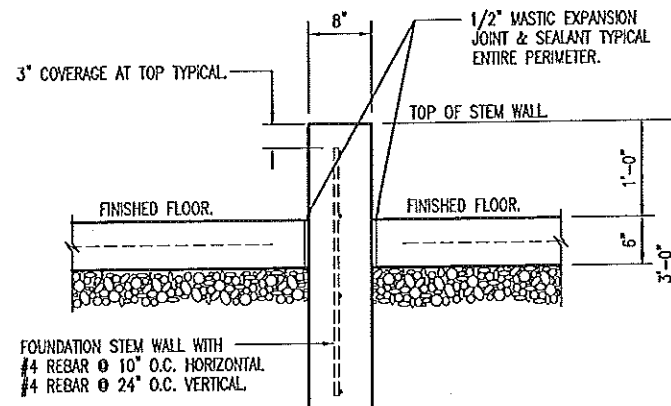


E INTERIOR STEM WALL
7 SCALE: 1/2" = 1'-0"

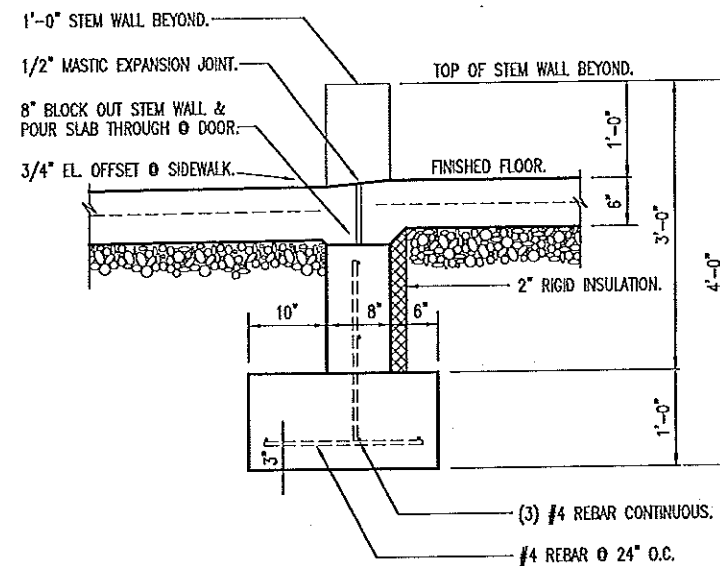


B EXTERIOR STEM WALL @ DOOR
7 SCALE: 1/2" = 1'-0"

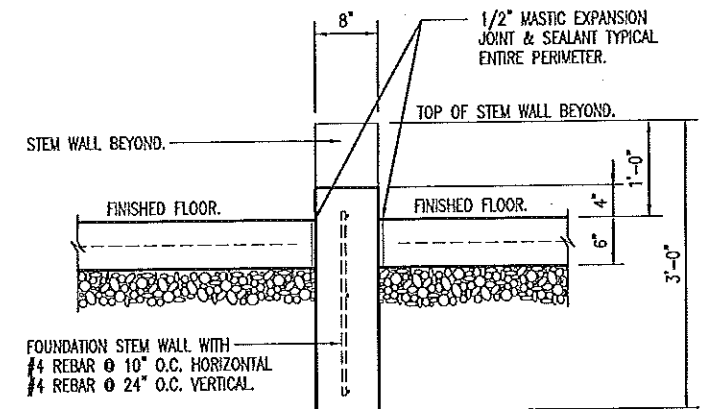

F INTERIOR STEM WALL @ DOOR
7 SCALE: 1/2" = 1'-0"

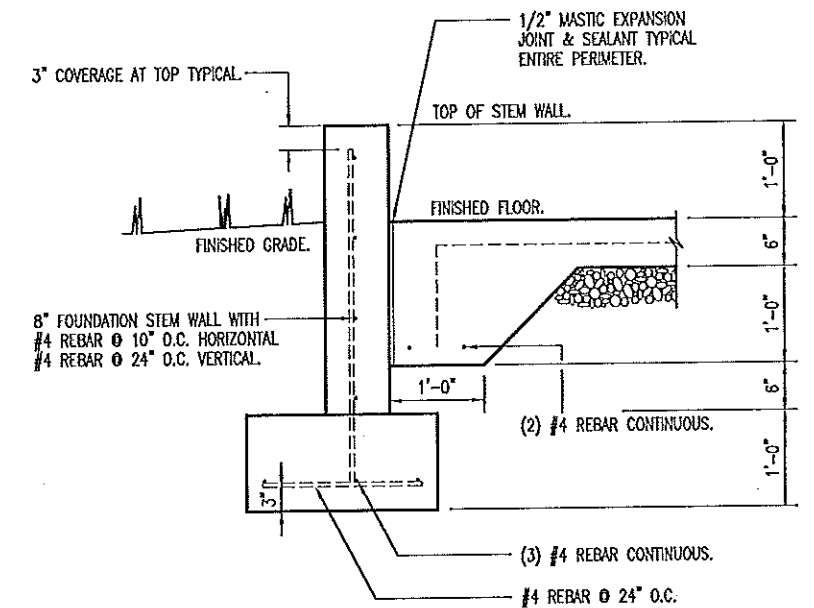

C EXTERIOR STEM WALL
7 SCALE: 1/2" = 1'-0"

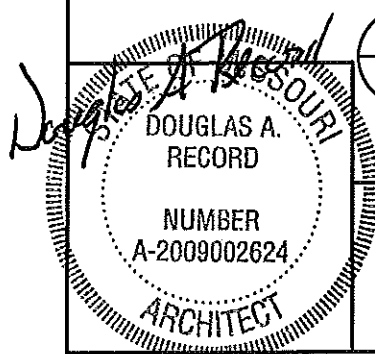


6/11/14

FOUNDATION DETAILS


MISSOURI DEPARTMENT
OF TRANSPORTATION
DIVISION OF GENERAL SERVICES
FACILITIES MANAGEMENT

STANDARD MAINTENANCE BUILDING


DRAWN BY: LARRY CARVER
CHECKED BY: DOUG RECORD
DATE: 6-11-14
Sheet
7 of 38

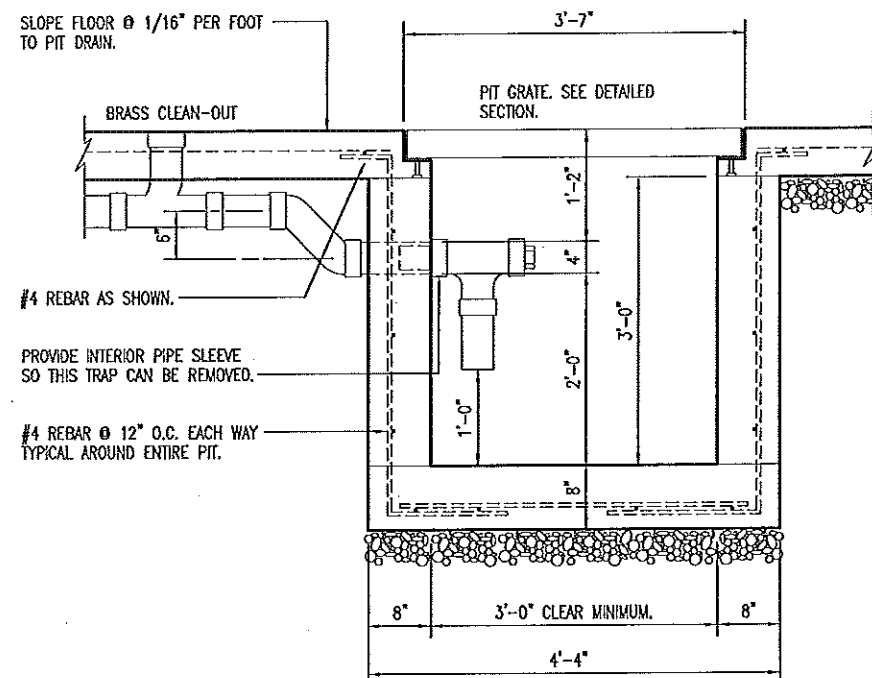


B
8
PIT DRAIN
SCALE: 1/2" = 1'-0"

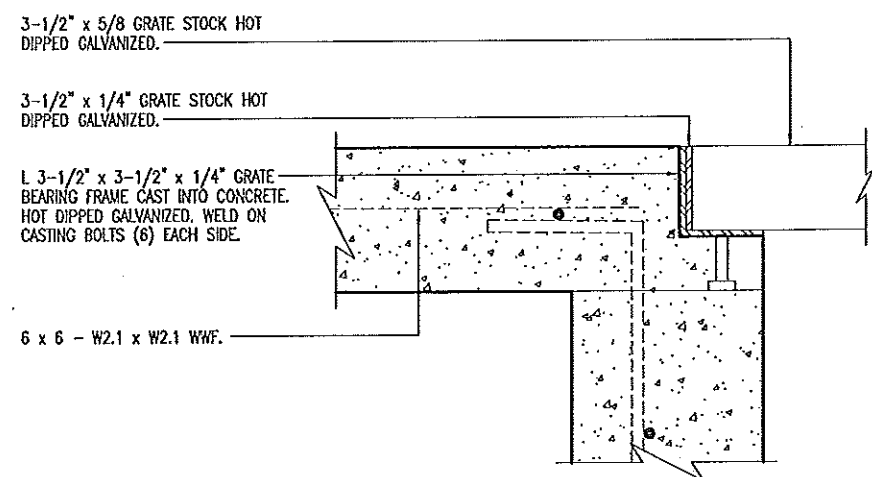

A
8
GRATE SECTION
SCALE: 1-1/2" = 1'-0"

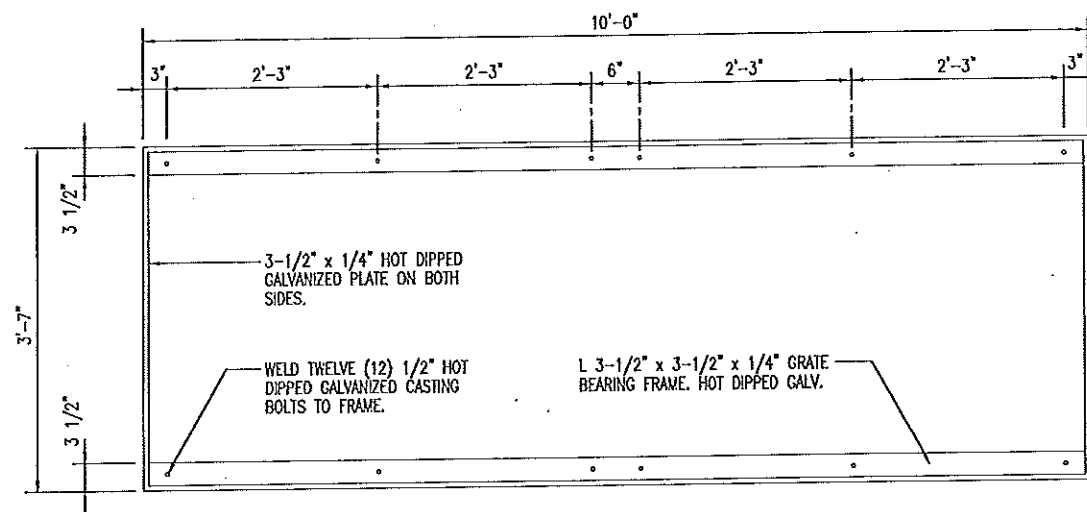


BEARING FRAME PLAN

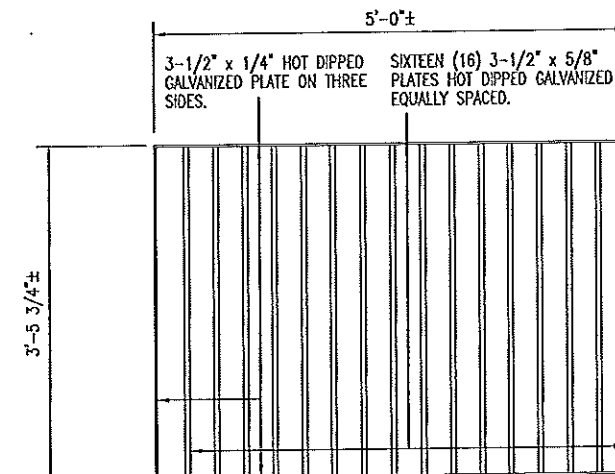


PROVIDE TWO (2) GRATE PLAN

C
8
GRATE AND FRAME DETAIL
SCALE: 1/2" = 1'-0"

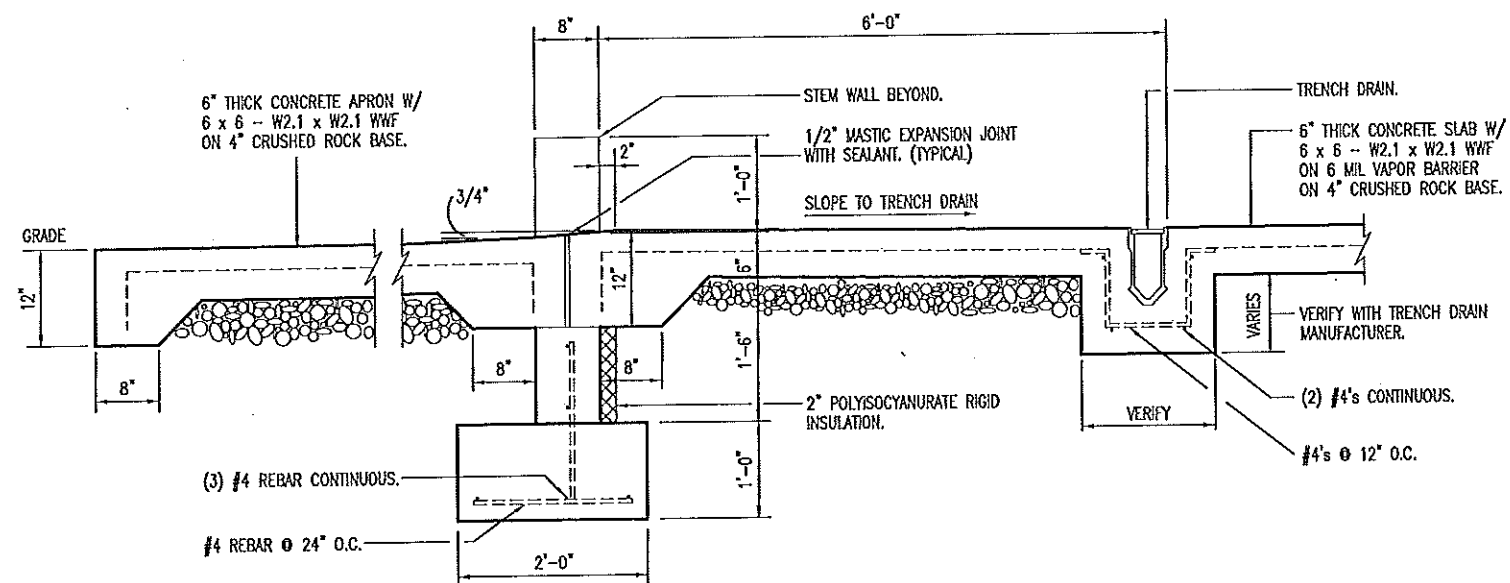

D
8
APPROACH APRON
SCALE: 1/2" = 1'-0"

CONTRACTOR NOTE:
BEGIN CONCRETE SLOPE AWAY FROM
DOOR THRESHOLD 2" FROM INSIDE
BUILDING.

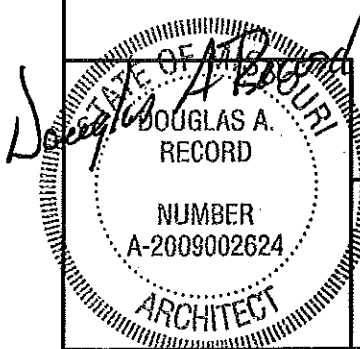


FOUNDATION DETAILS

MISSOURI DEPARTMENT
OF TRANSPORTATION
DIVISION OF GENERAL SERVICES
FACILITIES MANAGEMENT


STANDARD MAINTENANCE BUILDING

DRAWN BY: LARRY CARVER
CHECKED BY: DOUG RECORD
DATE: 6-11-14
Sheet
8 of 38

6/11/14

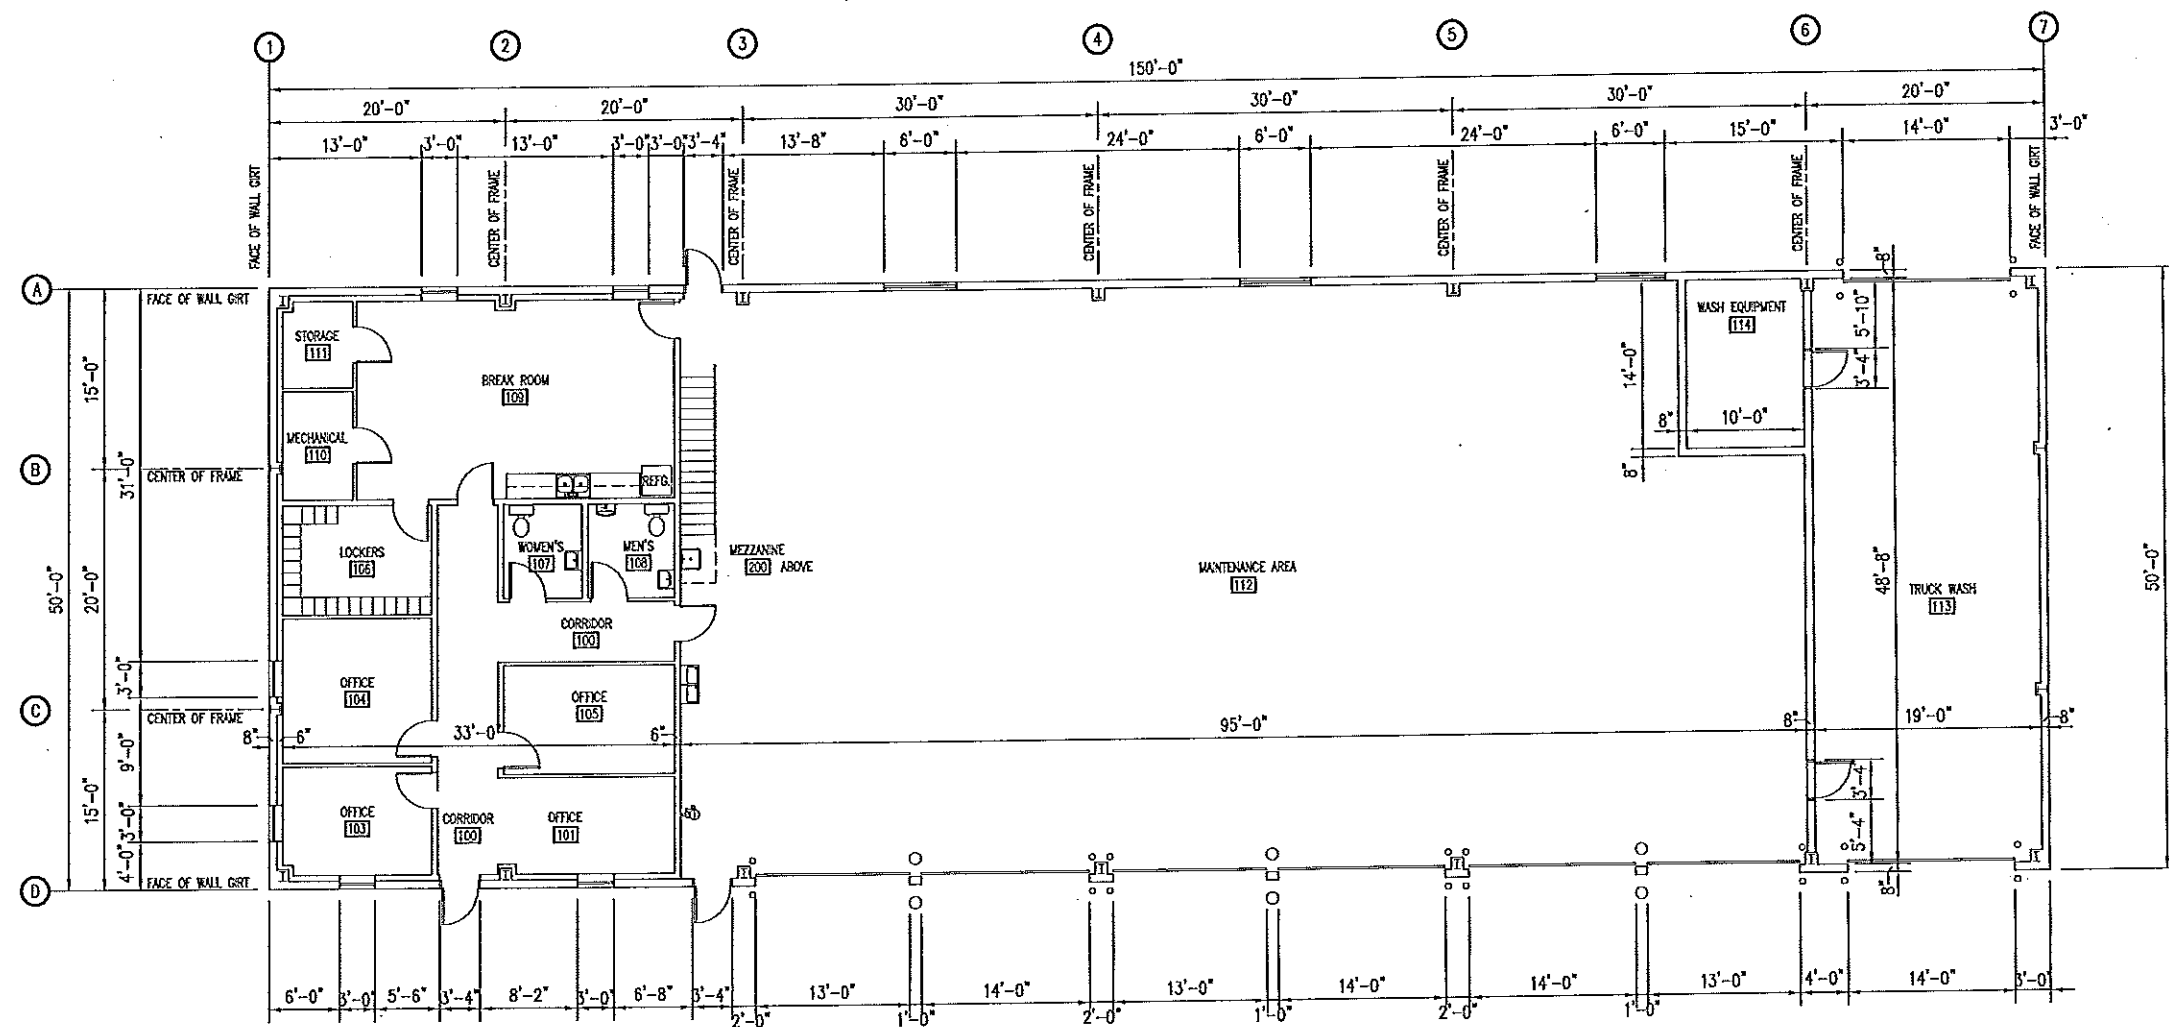

A
9 **DIMENSIONAL FLOOR PLAN**
SCALE: 1/16" = 1'-0"

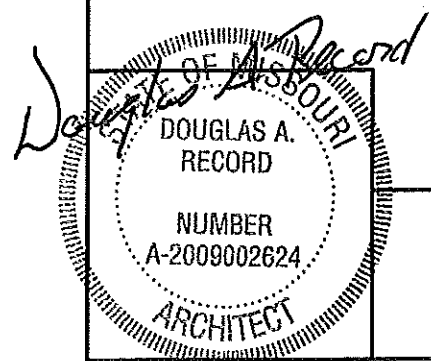


DIMENSIONAL FLOOR PLAN

**MISSOURI DEPARTMENT
OF TRANSPORTATION**
DIVISION OF GENERAL SERVICES
FACILITIES MANAGEMENT

STANDARD MAINTENANCE BUILDING

DRAWN BY: LARRY CARVER
CHECKED BY: DOUG RECORD
DATE: 6-11-14
Sheet
9 of 38

6/11/14

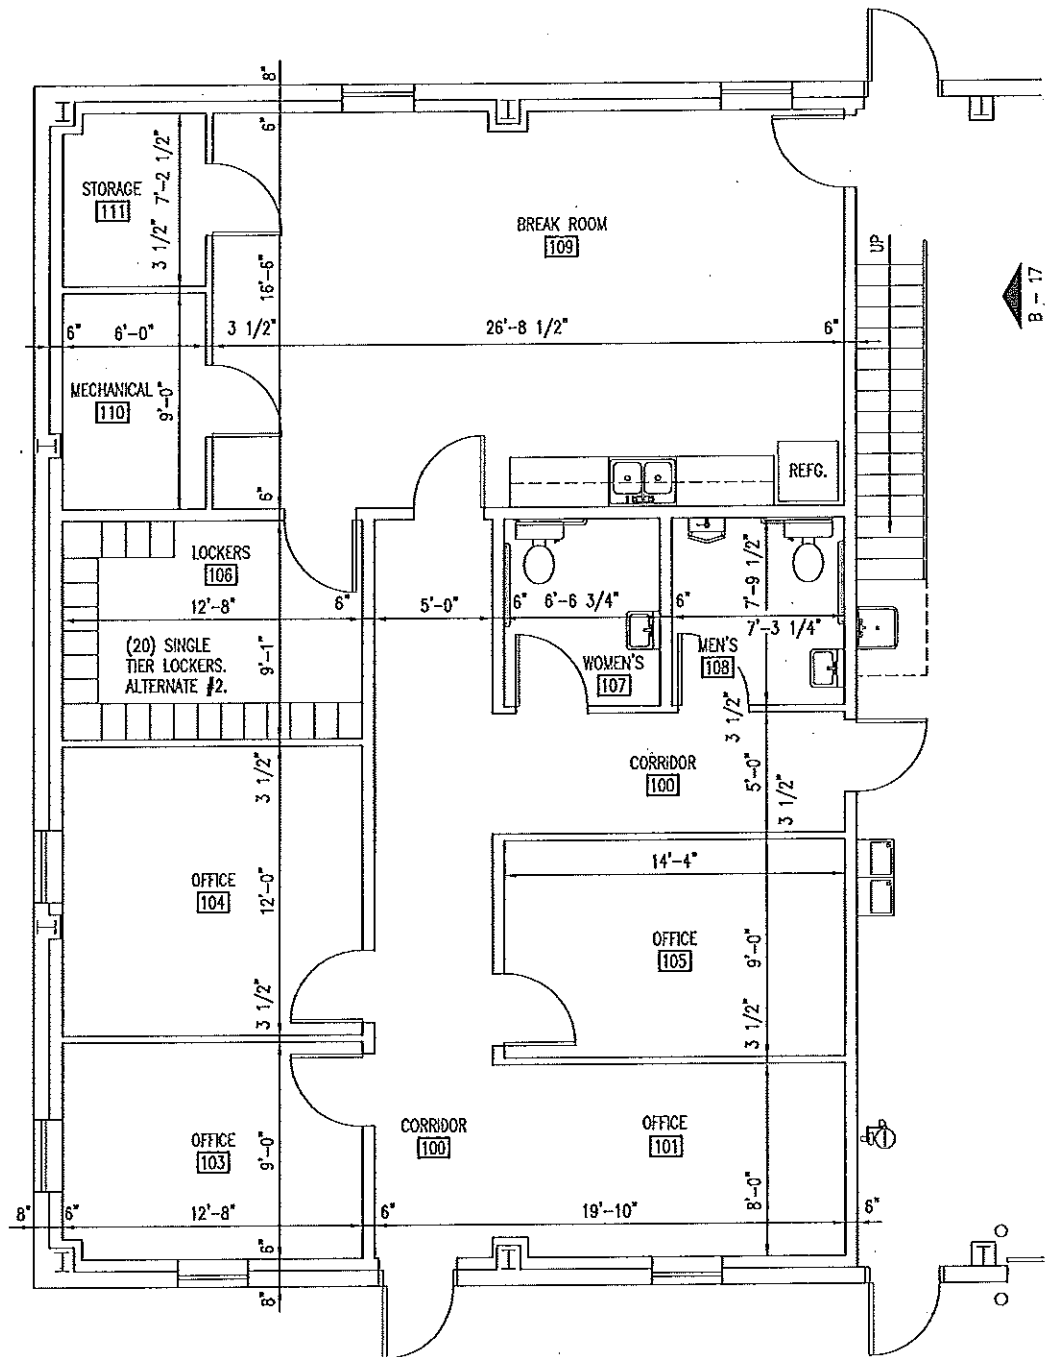

A
10
OFFICE DIMENSIONAL PLAN
SCALE: 1/8" = 1'-0"

NOTE:

CONTRACTOR TO ENSURE ALL LOAD BEARING WALLS BEAR ON THICKENED SLAB. SEE DETAIL A-6, C-7 & D-7.


WRAP ALL COLUMNS ON THE MEZZANINE WITH 2 x 4 WOOD STUDS & 1/2" AC PLYWOOD PAINTED UP TO MEZZANINE CEILING NEATLY AS REQUIRED. FOLLOW CEILING PITCH. ADD 4" VINYL BASE.

PARTITION WALLS BELOW ALL SHOWN DASHED. WALLS TO BE BEARING WALLS AS REQUIRED PER RECOMMENDATIONS OF THE FLOOR TRUSS MANUFACTURER.


3/4" TONGUE AND GROOVE PLYWOOD DECK GLUE AND SCREW. (TYPICAL)

CONTRACTOR TO PROVIDE GUELAN BEAM WITH A MAXIMUM DEPTH EQUAL TO I-JOIST. TIE INTO SIDE OF BEAM USING JOIST ANCHORS, BEARING ON WALLS BELOW AS REQUIRED. MAINTAIN EQUAL PLENUM DEPTH ABOVE FINISHED CEILING FOR HVAC DUCTWORK.

WOOD FLOOR TRUSSES:
WIDE FLANGE I-JOISTS EQUAL TO GEORGIA-PACIFIC 60 SERIES 11-7/8" DEPTH @ 12" O.C. (TYPICAL)

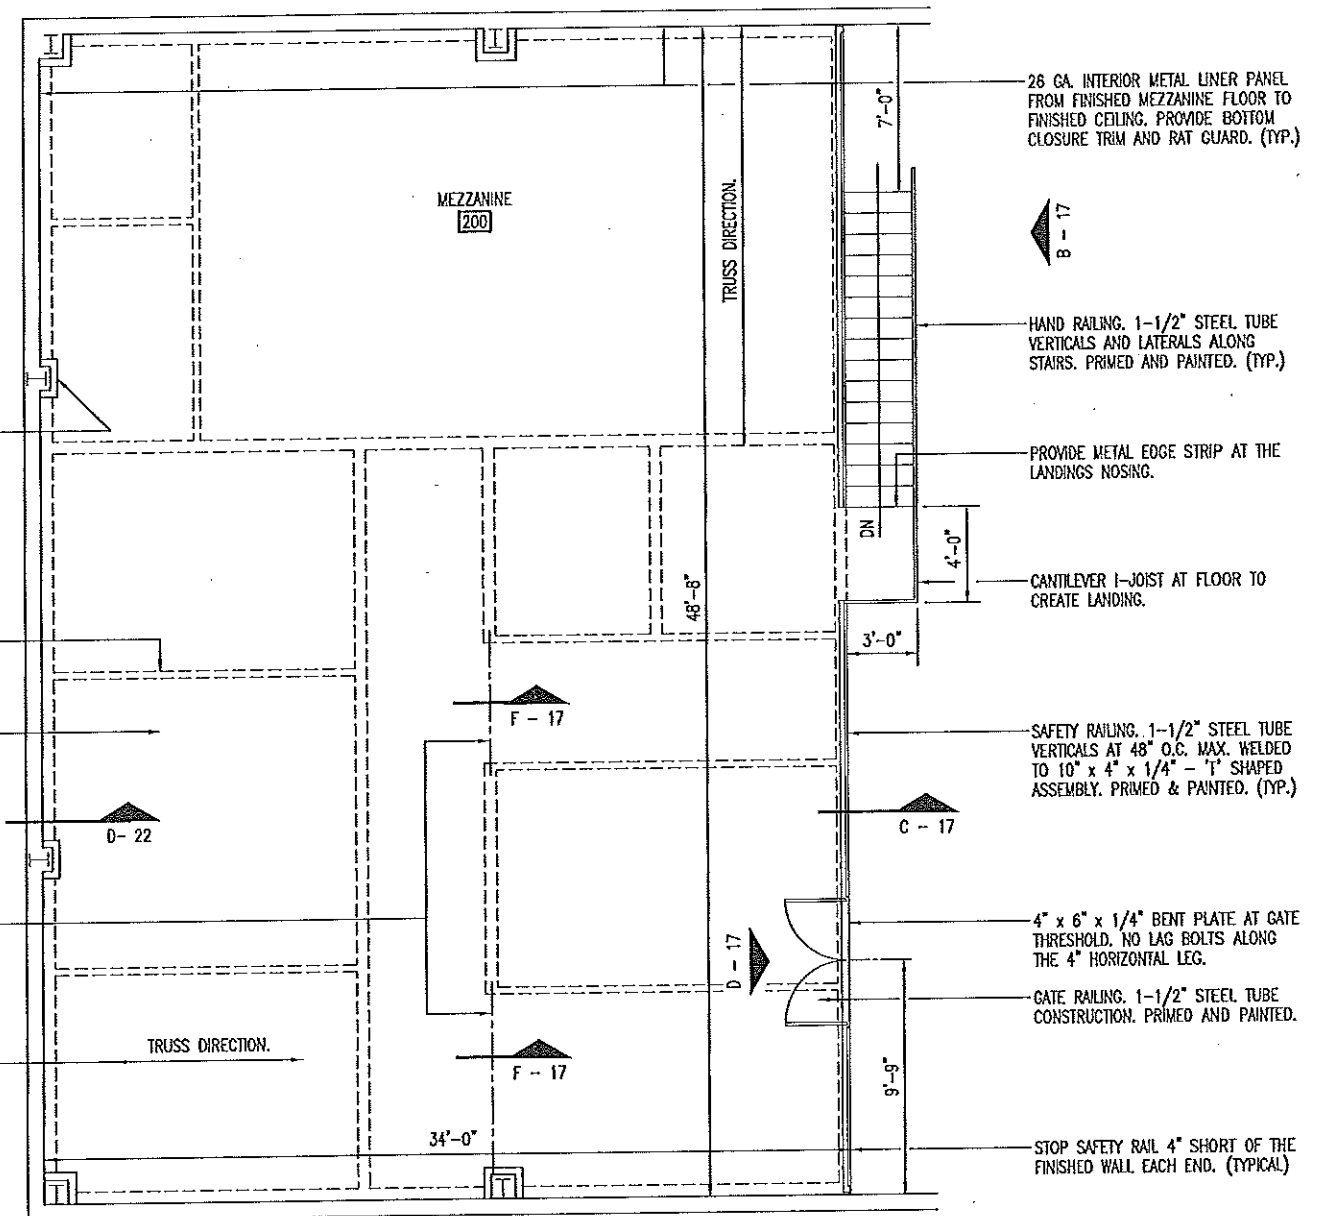

B
10
MEZZANINE PLAN
SCALE: 1/8" = 1'-0"

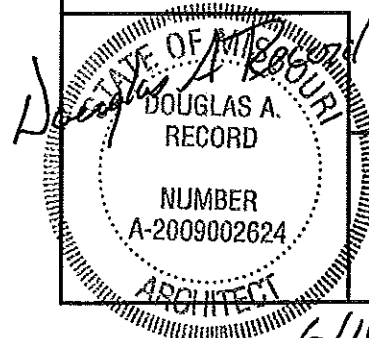


OFFICE DIMENSIONS & MEZZANINE PLAN

**MISSOURI DEPARTMENT
OF TRANSPORTATION**
DIVISION OF GENERAL SERVICES
FACILITIES MANAGEMENT

STANDARD MAINTENANCE BUILDING


DRAWN BY: LARRY CARYER
CHECKED BY: DOUG RECORD
DATE: 6-11-14
Sheet
10 of 38

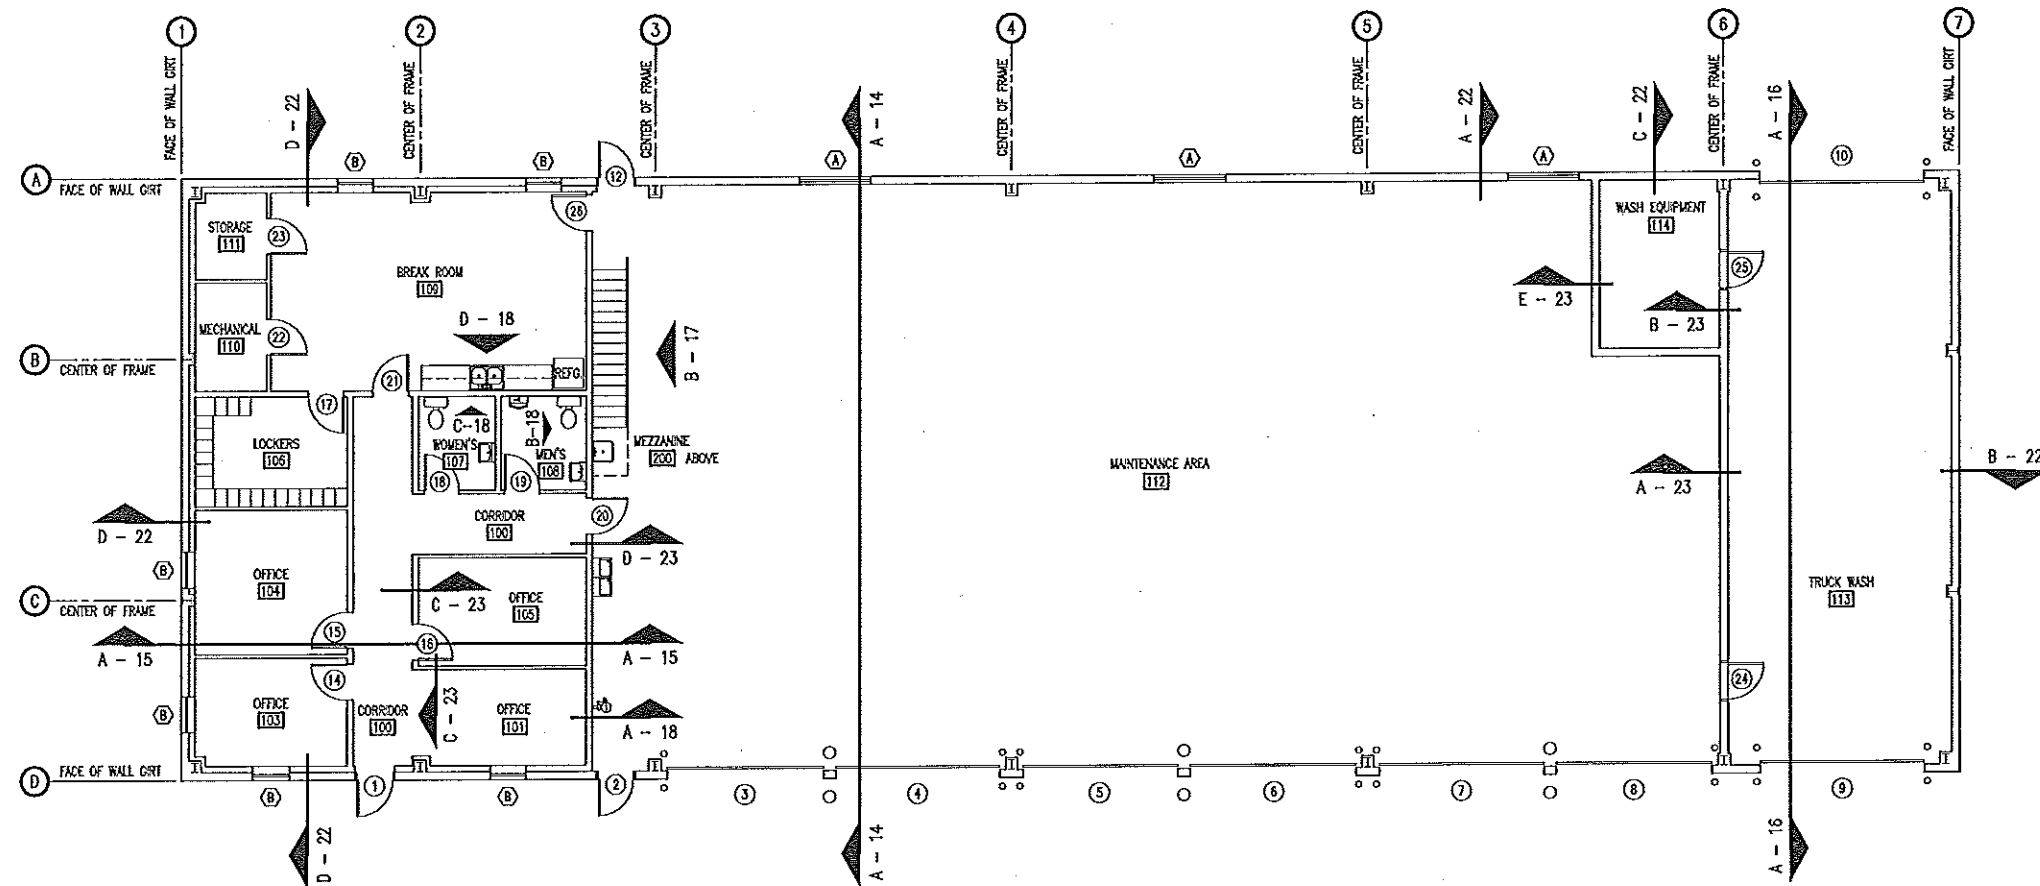

NOTES:

EXTERIOR WALLS @ MAINTENANCE AREA TO BE WALL TYPE A-22.
EXTERIOR WALLS @ OFFICE AREA TO BE WALL TYPE D-22.
EXTERIOR WALLS @ TRUCK WASH AREA TO BE WALL TYPE B-22.
ALL INTERIOR WALLS TO BE WALL TYPE C-23 UNLESS INDICATED ON THE DRAWINGS.

ARCHITECTURAL FLOOR PLAN
11
SCALE: 1/16" = 1'-0"

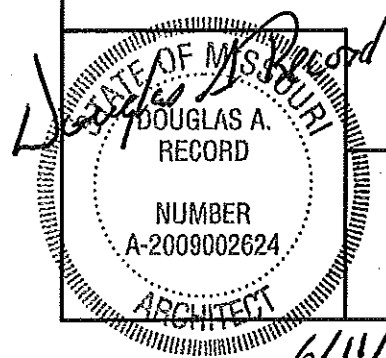



ARCHITECTURAL FLOOR PLAN

**MISSOURI DEPARTMENT
OF TRANSPORTATION**
DIVISION OF GENERAL SERVICES
FACILITIES MANAGEMENT


STANDARD MAINTENANCE BUILDING

DRAWN BY: LARRY CARYER
CHECKED BY: DOUG RECORD
DATE: 6-11-14
Sheet
11 of 38

DOOR SCHEDULE								
MARK	SWING	DOOR SIZE	DOOR MATERIAL	DOOR TYPE	FRAME MATR	FRAME TYPE	HEAD	HARDWARE GROUP
1	LHR	3'-0" x 7'-0" x 1-3/4"	INSUL. MTL.	A	MTL.	I	B-19	1
2	LHR	3'-0" x 7'-0" x 1-3/4"	INSUL. MTL.	A	MTL.	I	A-19	1
3	OH	13'-0" x 14'-0" x 2"	INSUL. MTL.	G	MTL.	-	C-20	-
4	OH	14'-0" x 14'-0" x 2"	INSUL. MTL.	H	MTL.	-	C-20	-
5	OH	13'-0" x 14'-0" x 2"	INSUL. MTL.	G	MTL.	-	C-20	-
6	OH	14'-0" x 14'-0" x 2"	INSUL. MTL.	H	MTL.	-	C-20	-
7	OH	14'-0" x 14'-0" x 2"	INSUL. MTL.	H	MTL.	-	C-20	-
8	OH	13'-0" x 14'-0" x 2"	INSUL. MTL.	G	MTL.	-	C-20	-
9	OH	14'-0" x 14'-0" x 2"	INSUL. MTL.	I	MTL.	-	D-20	-
10	OH	14'-0" x 14'-0" x 2"	INSUL. MTL.	I	MTL.	-	D-20	-
11	-	NOT USED	-	-	-	-	-	-
12	RHR	3'-0" x 7'-0" x 1-3/4"	INSUL. MTL.	A	MTL.	I	B-19	1
13	-	NOT USED	-	-	-	-	-	-
14	LH	3'-0" x 7'-0" x 1-3/4"	HOLLOW MTL.	B	MTL.	I	F-19	5
15	LH	3'-0" x 7'-0" x 1-3/4"	HOLLOW MTL.	B	MTL.	I	F-19	5
16	RH	3'-0" x 7'-0" x 1-3/4"	HOLLOW MTL.	B	MTL.	I	F-19	5
17	LH	3'-0" x 7'-0" x 1-3/4"	HOLLOW MTL.	B	MTL.	I	F-19	5
18	LH	3'-0" x 7'-0" x 1-3/4"	HOLLOW MTL.	B	MTL.	I	B-20	3
19	LH	3'-0" x 7'-0" x 1-3/4"	HOLLOW MTL.	B	MTL.	I	B-20	3
20	LH	3'-0" x 7'-0" x 1-3/4"	HOLLOW MTL.	D	MTL.	I	E-21	2
21	RH	3'-0" x 7'-0" x 1-3/4"	HOLLOW MTL.	B	MTL.	I	F-19	4
22	LHR	3'-0" x 7'-0" x 1-3/4"	HOLLOW MTL.	B	MTL.	I	A-20	5
23	LHR	3'-0" x 7'-0" x 1-3/4"	HOLLOW MTL.	B	MTL.	I	A-20	4
24	LH	3'-0" x 6'-8" x 1-3/4"	STAINLESS STEEL	E	STAINLESS	II	D-19	4
25	LH	3'-0" x 6'-8" x 1-3/4"	STAINLESS STEEL	F	STAINLESS	II	E-19	4
26	RH	3'-0" x 7'-0" x 1-3/4"	HOLLOW MTL.	D	MTL.	I	E-21	2
DOOR 20 TO BE FIRE RATED AND LABELED -- UL90. ALL FRAMES TO BE FIRE RATED AND LABELED -- UL90.								

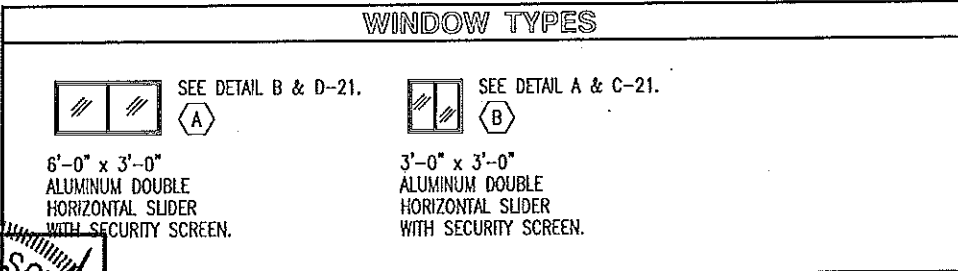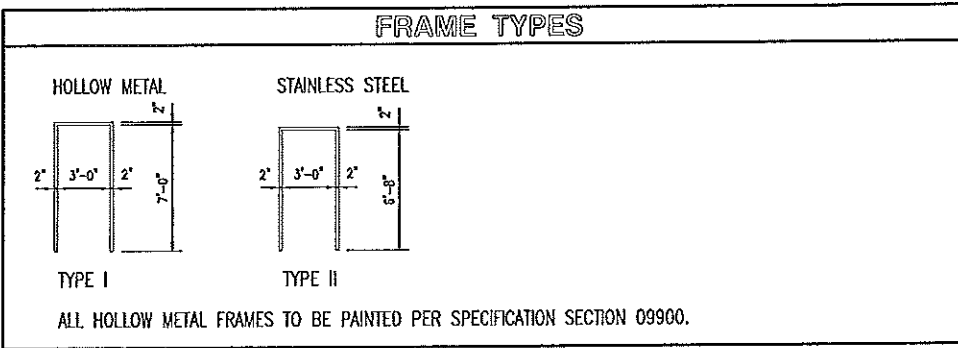

ROOM FINISH SCHEDULE												
NO.	ROOM	FLOORS			BASE		WALLS					CEILING
		EXPOSED CONCRETE	CONCRETE HARDENER/SEALER	3/4" T&G PLYWD	4" VINYL	NONE	INTERIOR METAL LINER PANELS	5/8" TYPE 'X' GYPSUM BOARD	5/8" MOISTURE RESISTANT GYP BD	7/16" FIBERGLASS REINF. PANELS	1/2" AC PLYWOOD	LATEX PAINT
100	CORRIDOR	●	●	●	●			●			●	●
101	CLERK	●	●	●	●			●			●	●
102	-											
103	OFFICE	●	●	●	●			●			●	●
104	OFFICE	●	●	●	●			●			●	●
105	OFFICE	●	●	●	●			●			●	●
106	LOCKERS	●	●	●	●			●			●	●
107	WOMEN'S	●	●	●	●			●			●	●
108	MEN'S	●	●	●	●			●			●	●
109	BREAK ROOM	●	●	●	●			●			●	●
110	MECHANICAL ROOM	●	●	●	●			●			●	●
111	STORAGE	●	●	●	●			●			●	●
112	MAINTENANCE AREA	●	●	●	●	●	●				●	●
113	TRUCK WASH	●	●	●	●				●		●	●
114	WASH EQUIPMENT	●	●	●	●						●	●
200	MEZZANINE			●	●	●	●				●	●

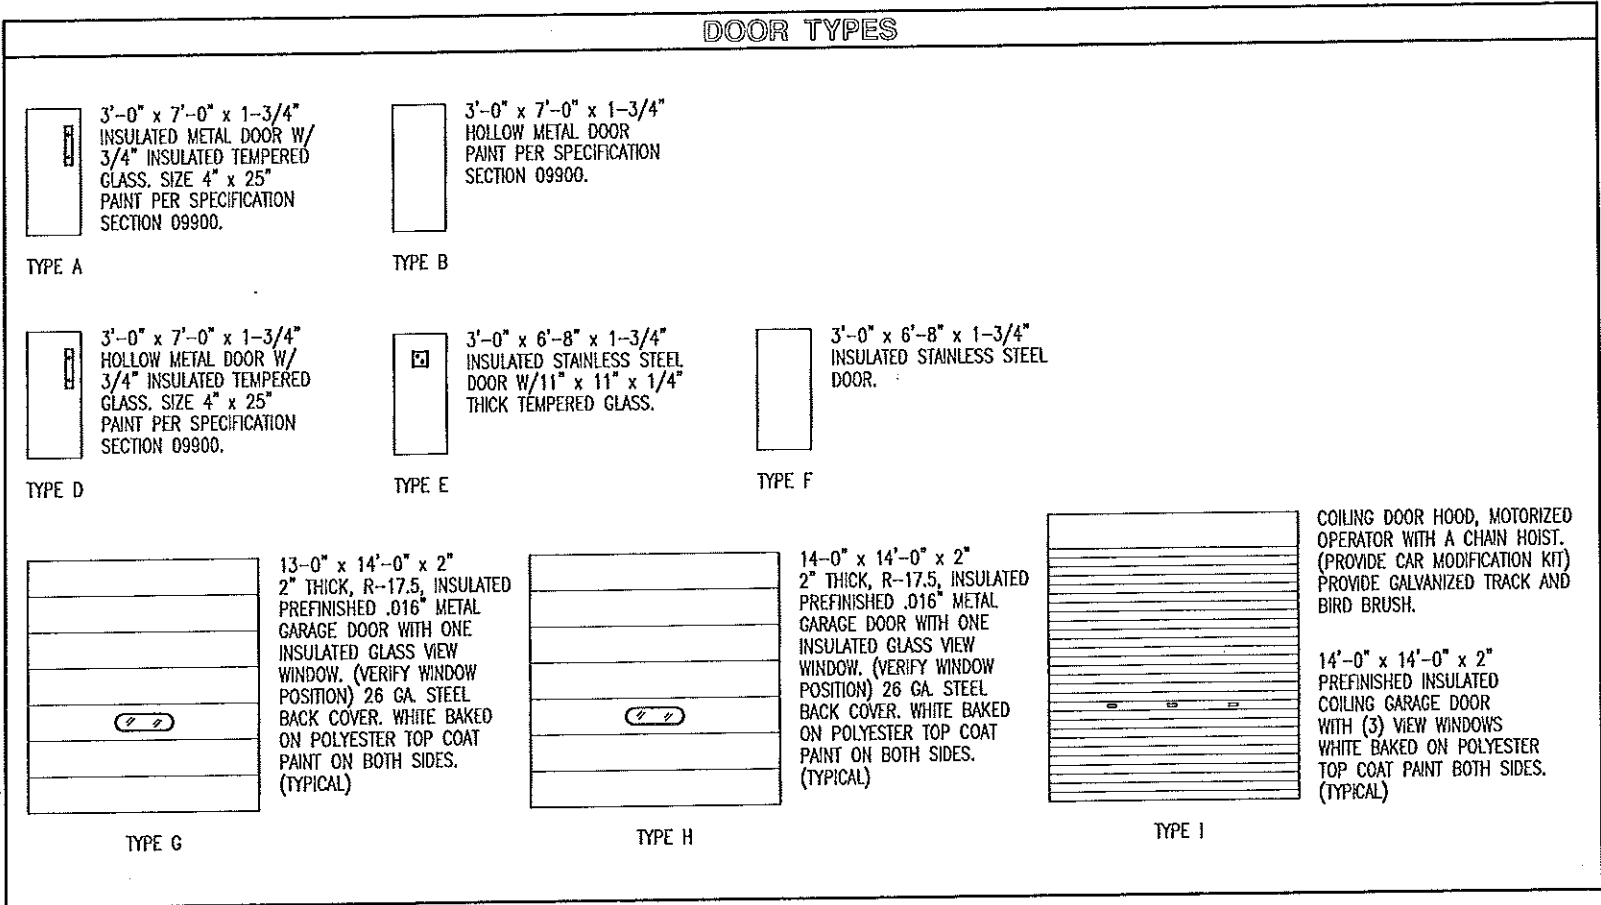

GENERAL NOTES:

BUILDING MANUFACTURER TO FURNISH ALL NECESSARY FLASHING AND TRIM TO PROVIDE A NEAT, WEATHERPROOF APPEARANCE AT ALL DOORS, WINDOWS, COLUMNS AND ANY LOCATION WHERE THE METAL LINER PANELS MAY BE CUT.

ROOM FINISHES TO BE PAINTED PER SPECIFICATION 09900.


FRAMED WALL IN MAINTENANCE AREA TO RECEIVE 1/2" AC PLYWOOD PAINTED PER SPECIFICATION 09900, & 4" VINYL BASE.

PROVIDE FULL THICK SOUND BATT INSULATION (NOT SHOWN) TYPICAL @ ALL INTERIOR STUD WALLS, SEE SPECIFICATION SECTION 07210.

PROVIDE BLOCKING BEHIND ALL ITEMS CONNECTED TO LINER PANELS INCLUDING BUT NOT LIMITED TO MECHANICAL, ELECTRICAL AND PLUMBING LINES, BOXES AND FIXTURES.

ALL EXTERIOR HOLLOW METAL DOOR FRAMES TO HAVE SOLID GROUT FILL @ STEM WALL.

ALL OVERHEAD DOOR JAMBS TO STOP AT FINISHED FLOOR, NOT AT TOP OF STEM WALL.

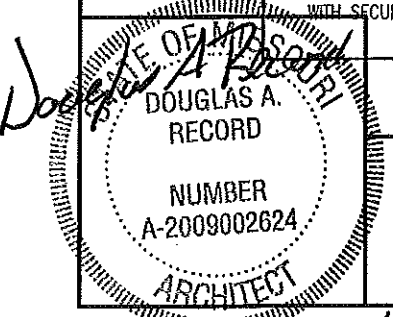


6/11/14

SCHEDULES


MISSOURI DEPARTMENT
OF TRANSPORTATION
DIVISION OF GENERAL SERVICES
FACILITIES MANAGEMENT

STANDARD MAINTENANCE BUILDING


DRAWN BY: LARRY CARVER
CHECKED BY: DOUG RECORD
DATE: 6-11-14
Sheet
12 of 38

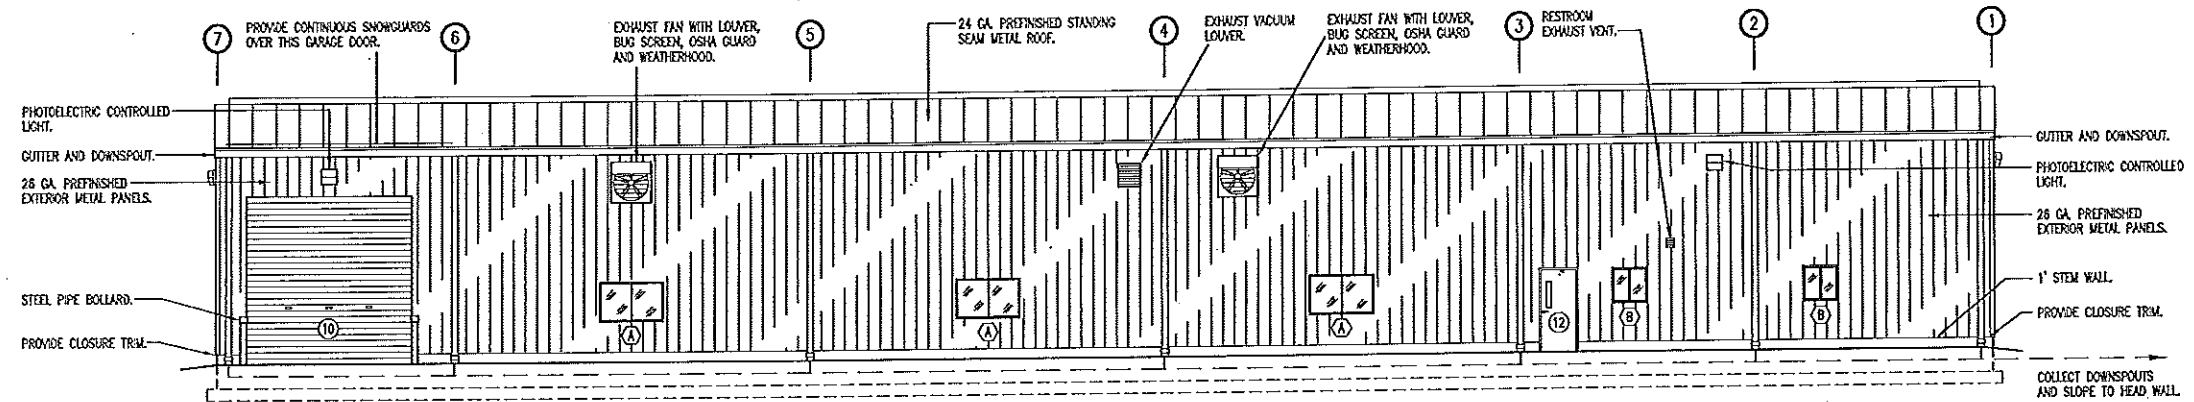


D
13
REAR ELEVATION
SCALE: 1/16" = 1'-0"

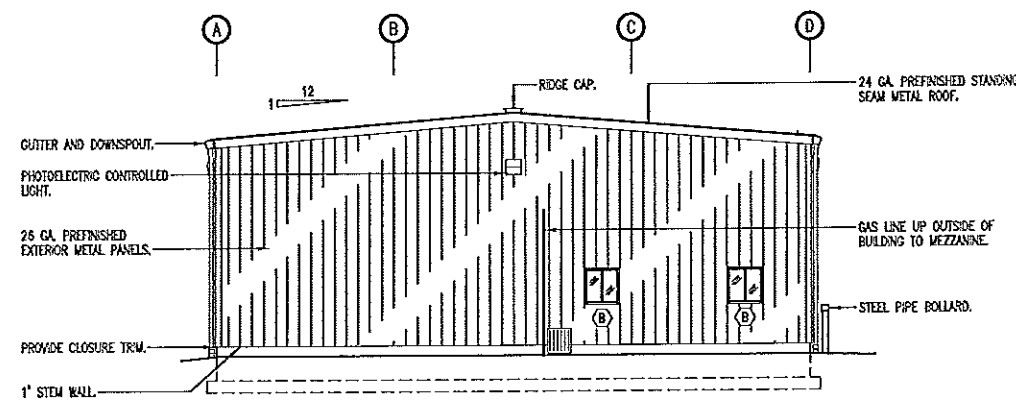

B
13
LEFT ELEVATION
SCALE: 1/16" = 1'-0"

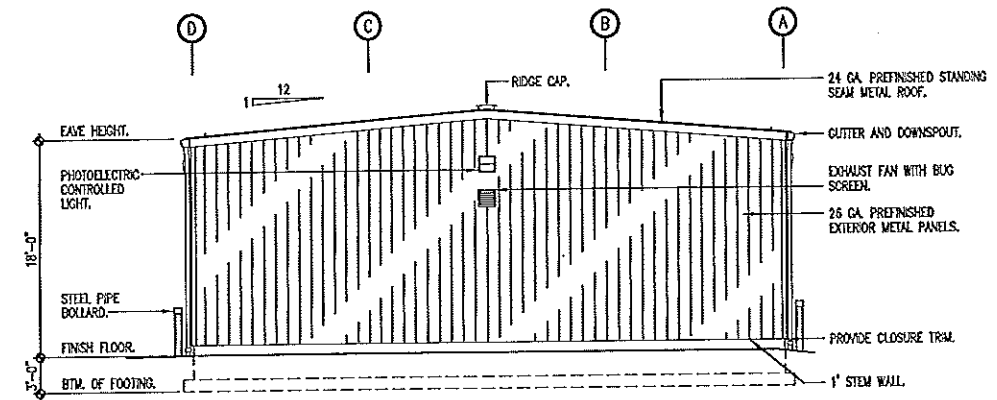

C
13
RIGHT ELEVATION
SCALE: 1/16" = 1'-0"

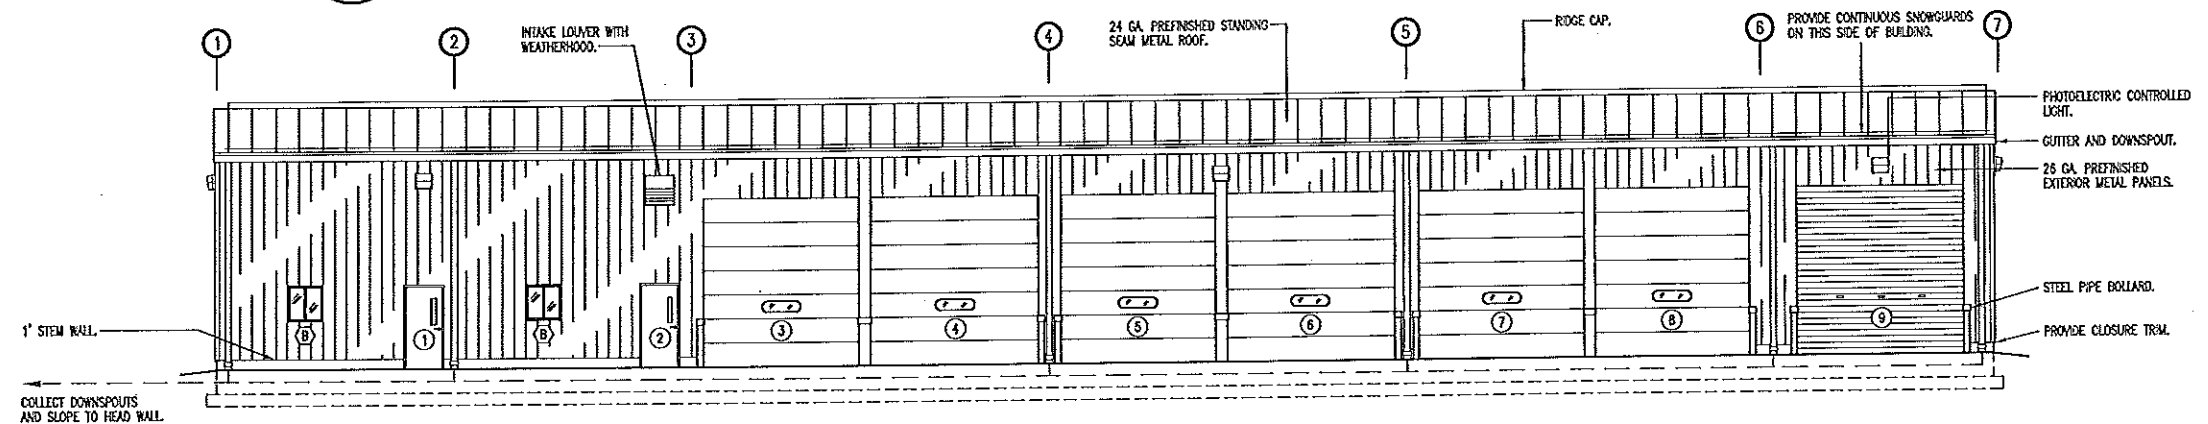


A
13
FRONT ELEVATION
SCALE: 1/16" = 1'-0"


ELEVATIONS

MISSOURI DEPARTMENT
OF TRANSPORTATION
DIVISION OF GENERAL SERVICES
FACILITIES MANAGEMENT


STANDARD MAINTENANCE BUILDING

DRAWN BY: LARRY CARVER
CHECKED BY: DOUG RECORD
DATE: 6-11-14
Sheet
13 of 38

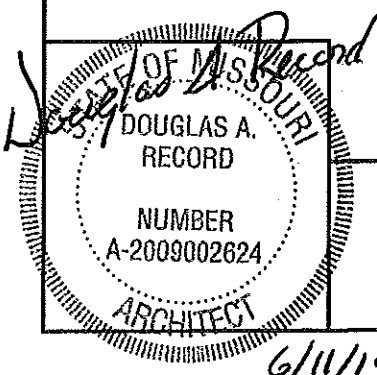

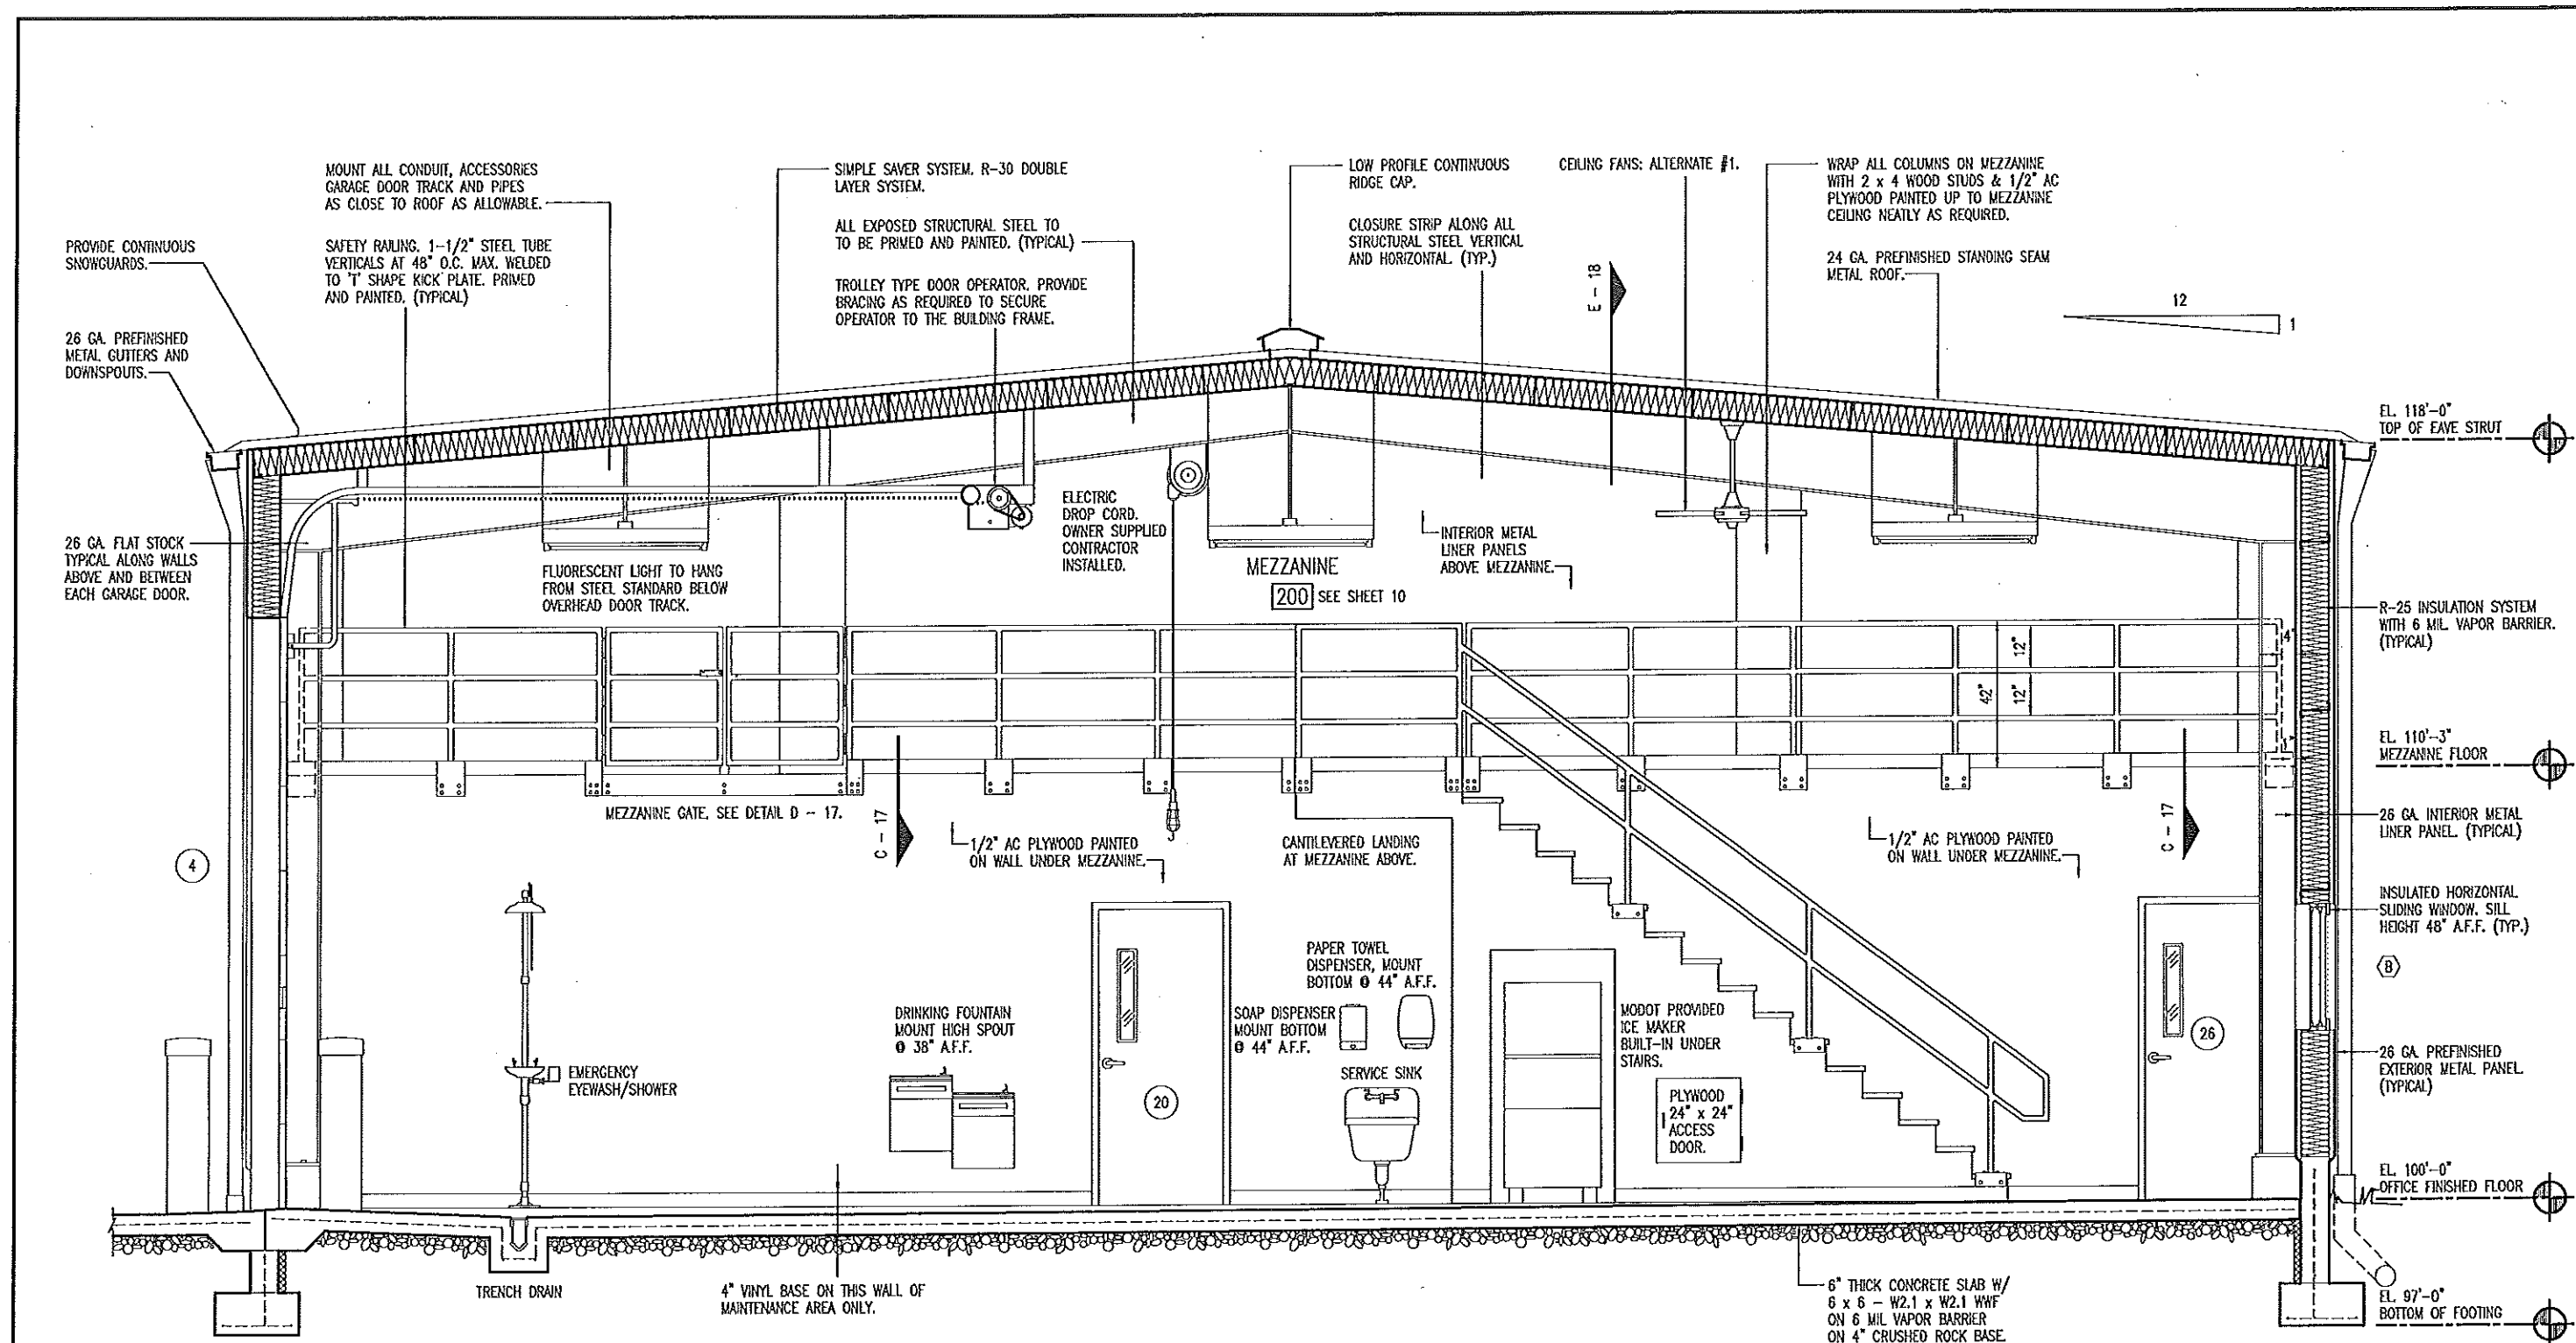

A
14 **BUILDING SECTION**
SCALE: 1/4" = 1'-0"

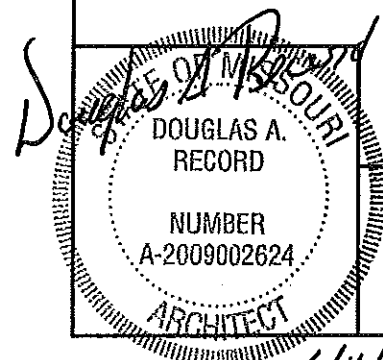


6/11/14

BUILDING SECTION


**MISSOURI DEPARTMENT
OF TRANSPORTATION**
DIVISION OF GENERAL SERVICES
FACILITIES MANAGEMENT

STANDARD MAINTENANCE BUILDING

DRAWN BY: LARRY CARVER
CHECKED BY: DOUG RECORD
DATE: 6-11-14
Sheet
14 of 38

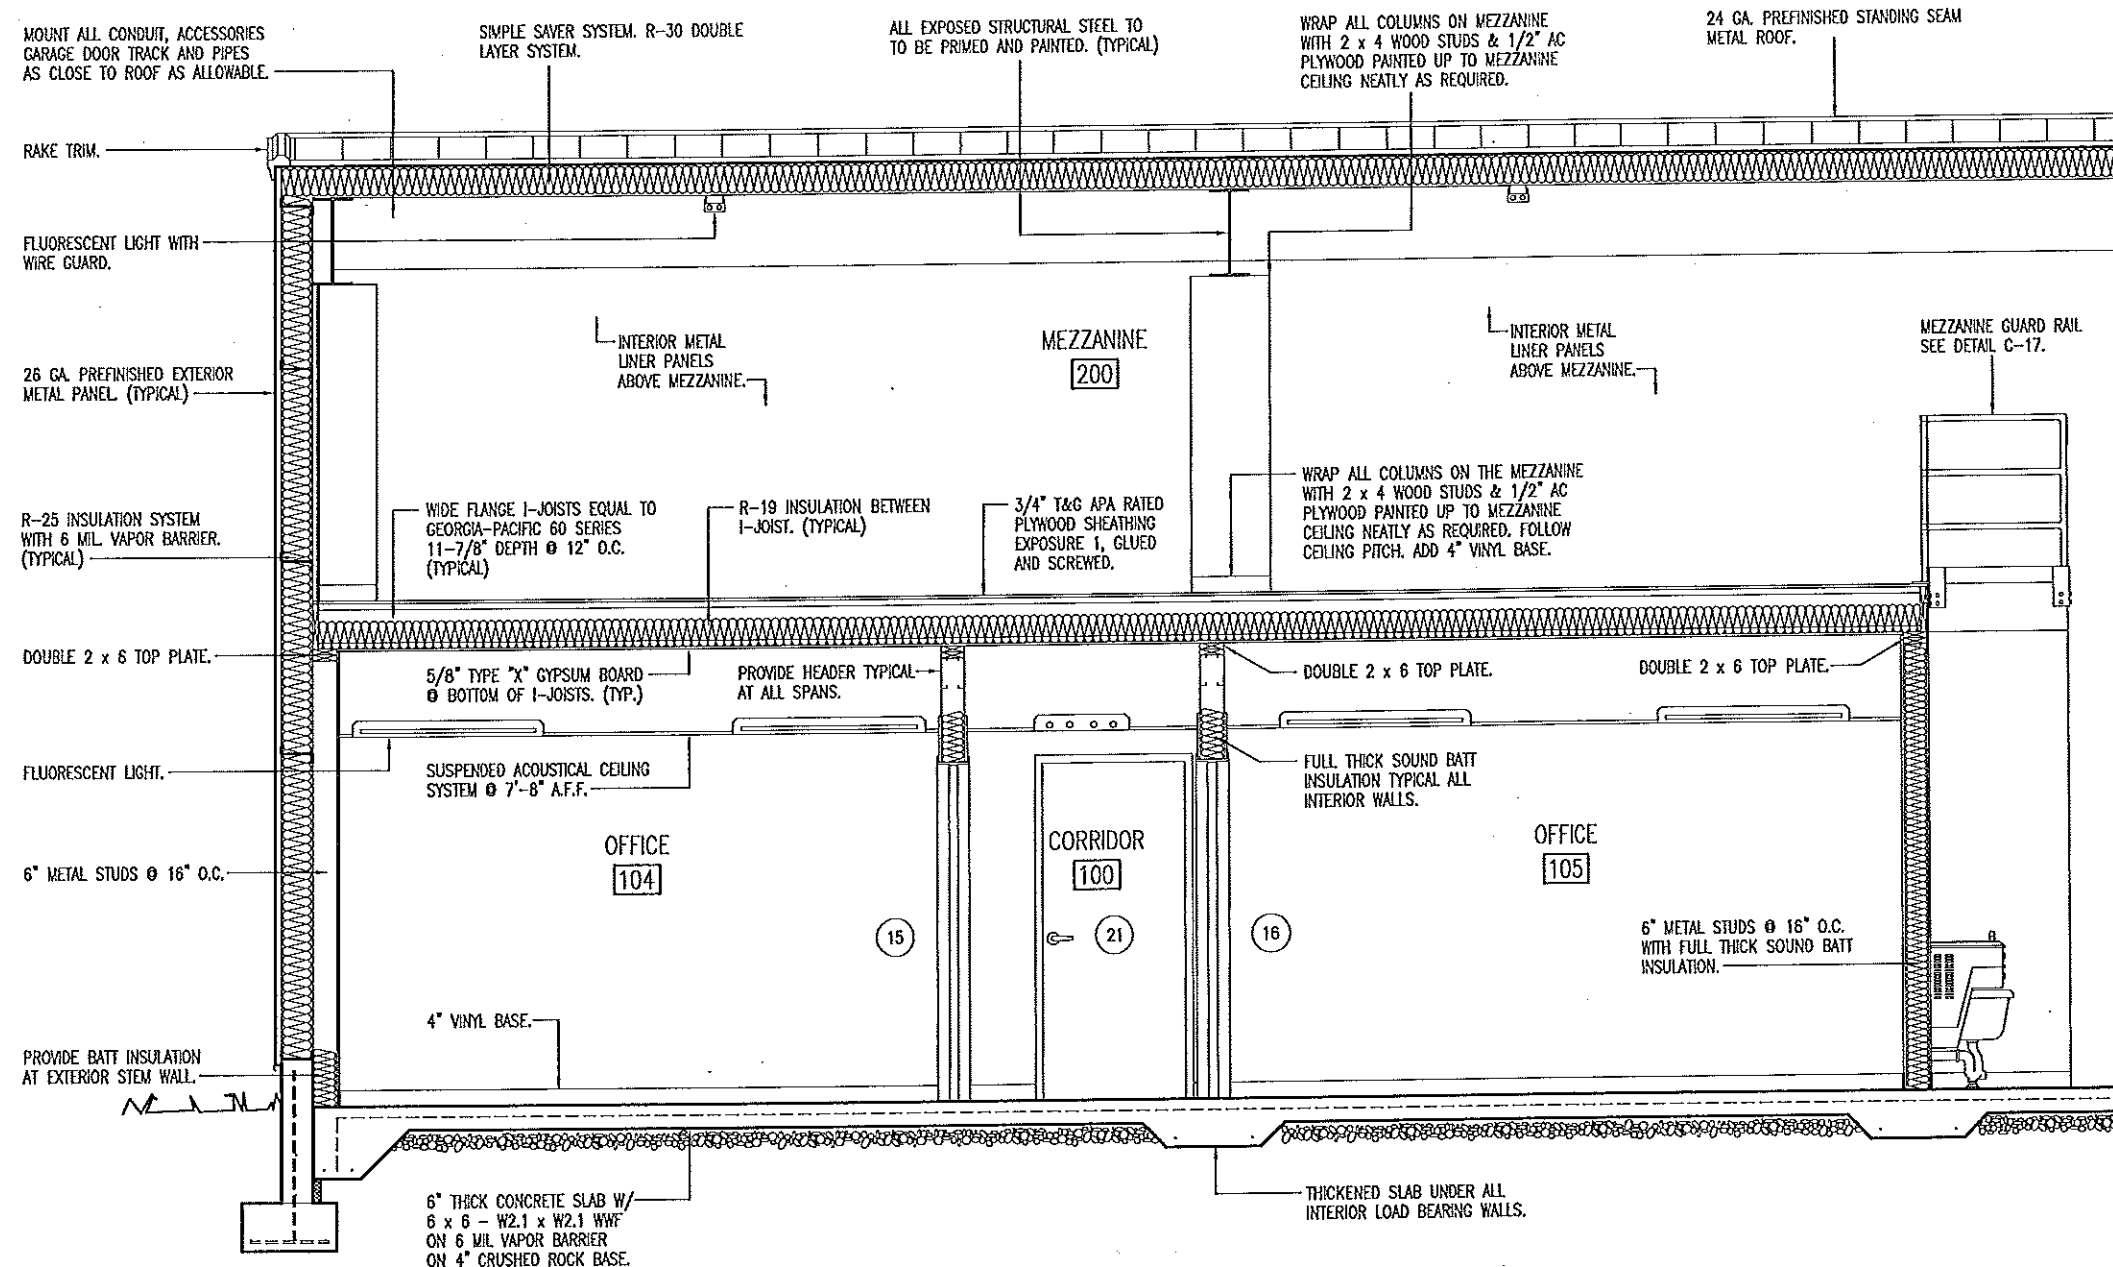

A
15
PARTIAL BUILDING SECTION
SCALE: 1/4" = 1'-0"

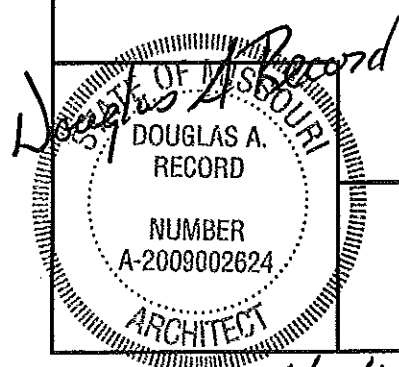


BUILDING SECTION

MISSOURI DEPARTMENT
OF TRANSPORTATION

DIVISION OF GENERAL SERVICES
FACILITIES MANAGEMENT

STANDARD MAINTENANCE BUILDING

DRAWN BY: LARRY CASPER
CHECKED BY: DOUG RECORD
DATE: 6-11-14
Sheet
15 of 38

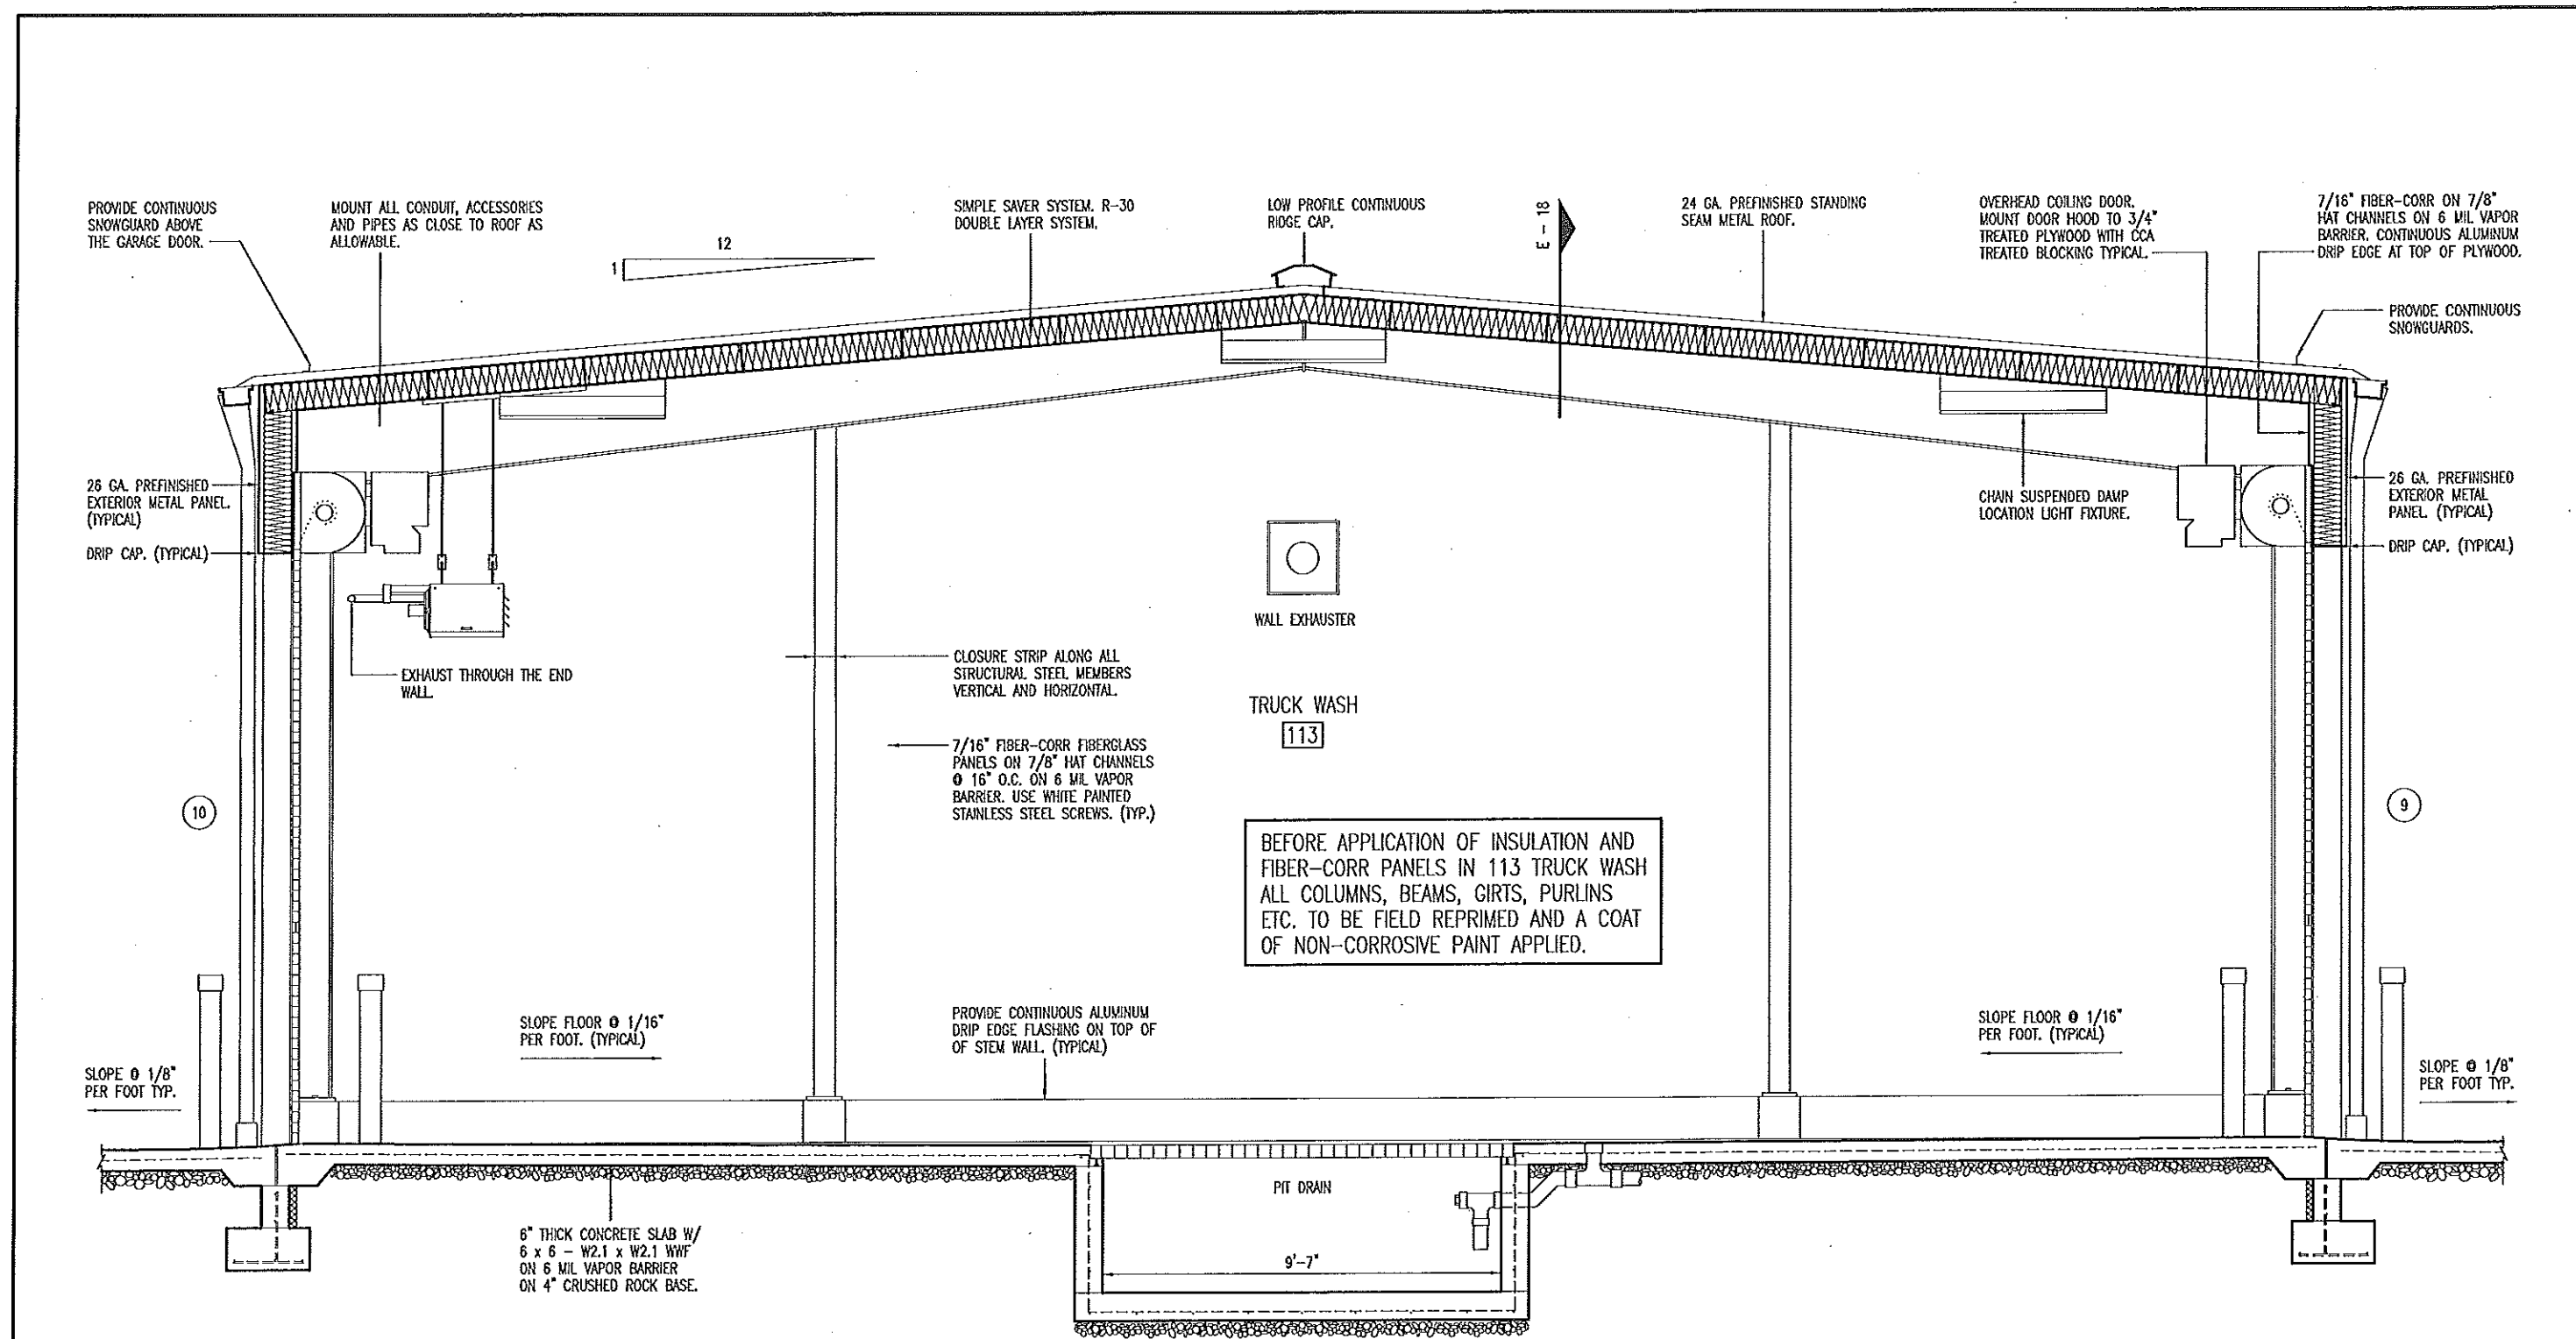

A
16 **BUILDING SECTION**
SCALE: 1/4" = 1'-0"

MISSOURI
DOUGLAS A. RECORD
NUMBER
A-2009002624
ARCHITECT


6/11/14

BUILDING SECTION


**MISSOURI DEPARTMENT
OF TRANSPORTATION**
DIVISION OF GENERAL SERVICES
FACILITIES MANAGEMENT

STANDARD MAINTENANCE BUILDING


DRAWN BY: LARRY CARYER
CHECKED BY: DOUG RECORD
DATE: 6-11-14
Sheet
16 of 38

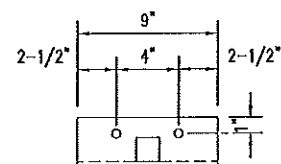


WELD HANDRAIL
TO 1/4" THICK
STEEL ANGLE.

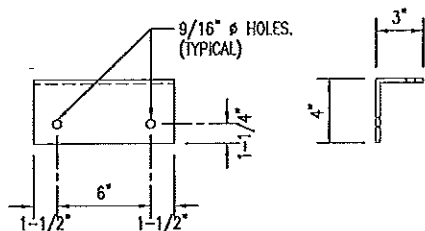


A
17
PRIMED AND PAINTED.
STAIR RAIL CONNECTION
SCALE: 1" = 1'-0"

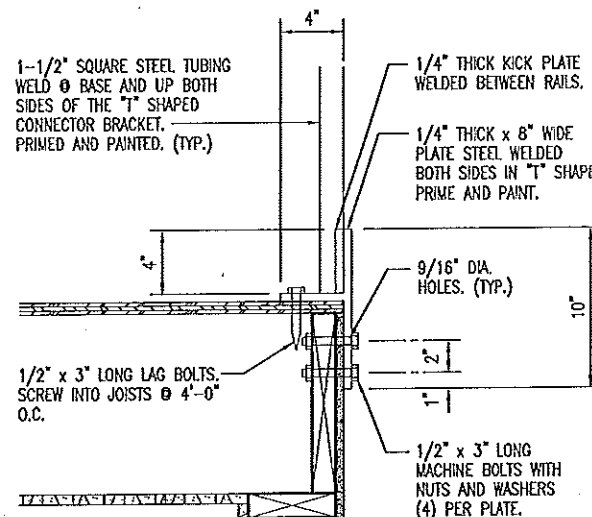


C
17
KICK PLATE DETAIL
SCALE: 1" = 1'-0"

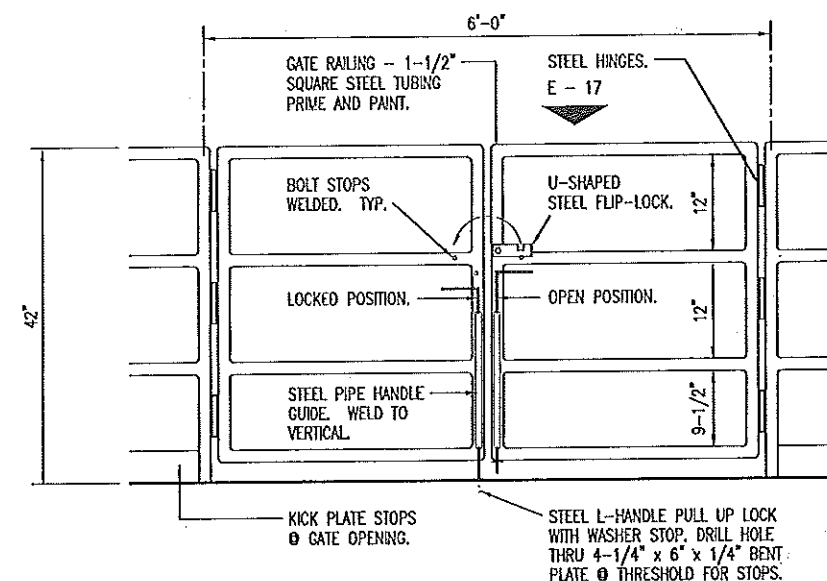


D
17
VIEW FROM MEZZANINE
SWING GATE DETAIL
SCALE: 1" = 1'-0"

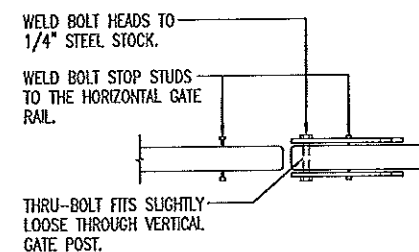


E
17
FLIP LOCK
SCALE: 1" = 1'-0"

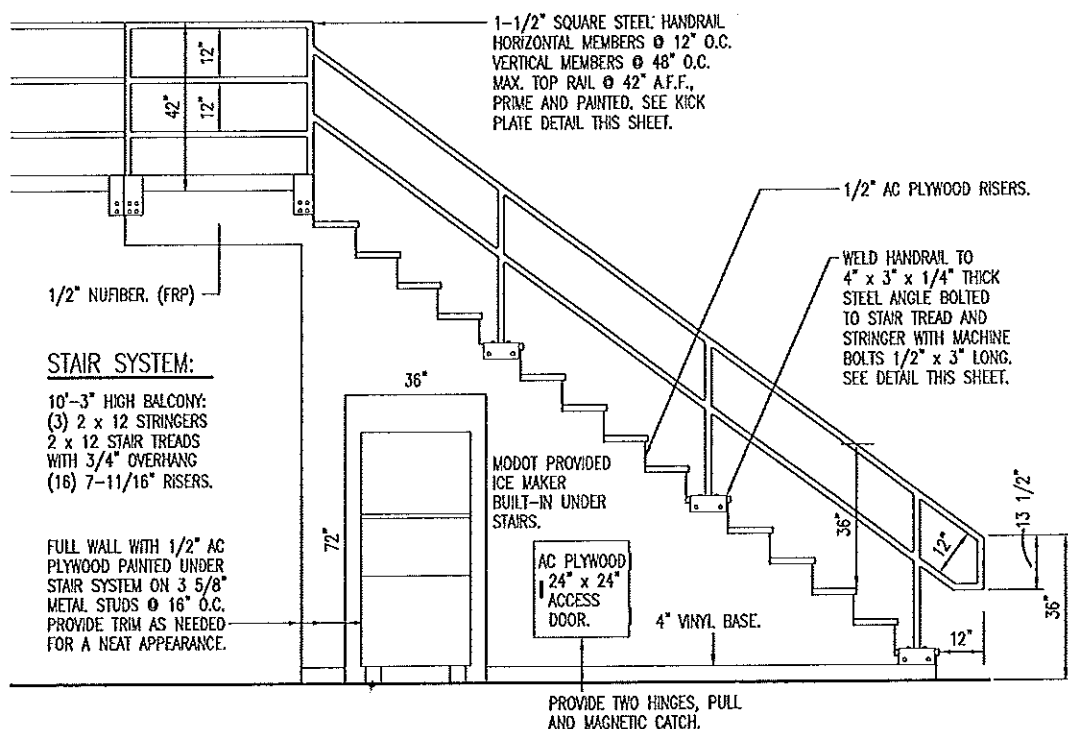

B
17
MEZZANINE STAIR SYSTEM
SCALE: 1/4" = 1'-0"

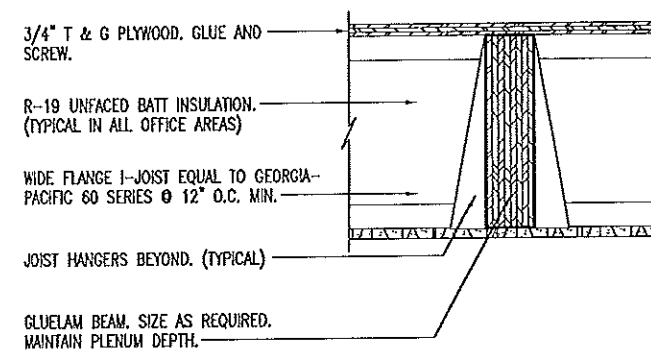

F
17
BEAM DETAIL
SCALE: 1" = 1'-0"

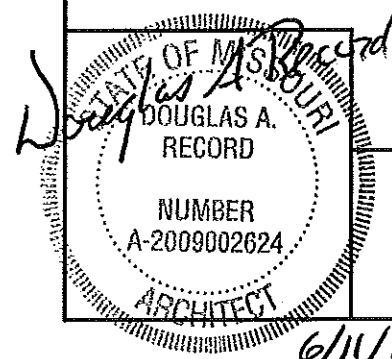


STAIR & RAILING DETAILS


MISSOURI DEPARTMENT
OF TRANSPORTATION
DIVISION OF GENERAL SERVICES
FACILITIES MANAGEMENT

STANDARD MAINTENANCE BUILDING


DRAWN BY: LARRY CARVER
CHECKED BY: DOUG RECORD
DATE: 6-11-14
Sheet
17 of 38

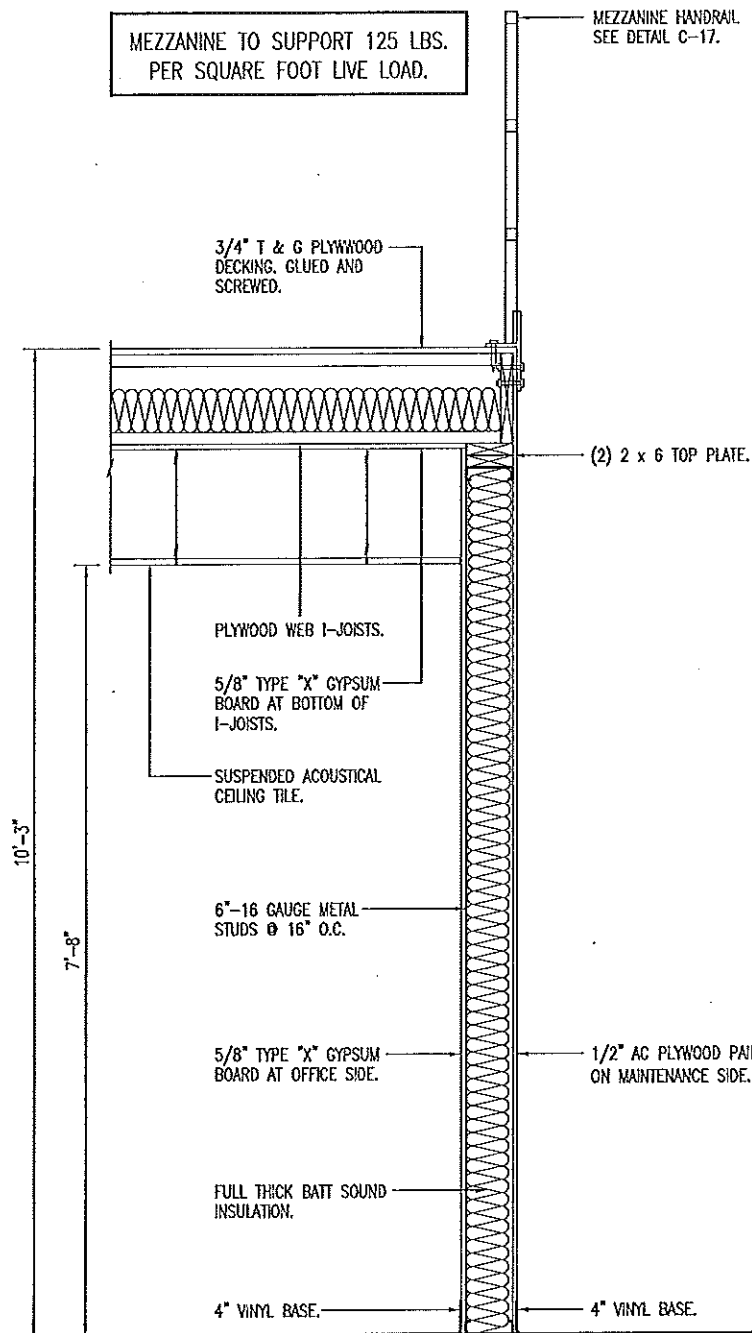


A
18
MEZZANINE WALL SECTION
SCALE: 1/2" = 1'-0"

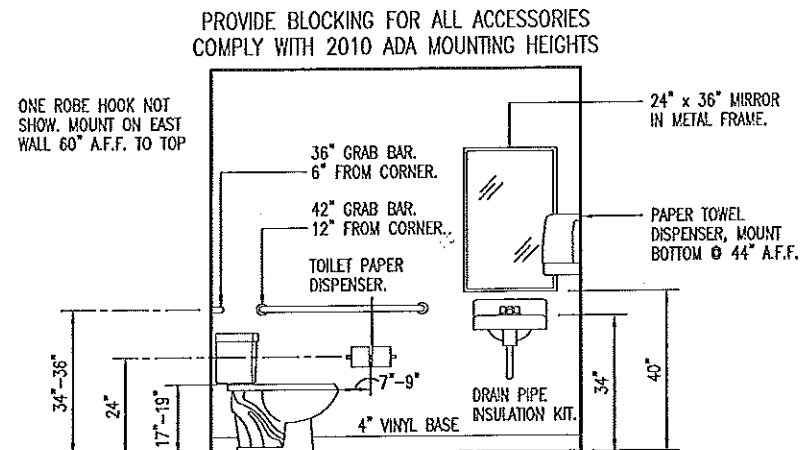

B
18
RESTROOM ELEVATION
SCALE: 1/4" = 1'-0"

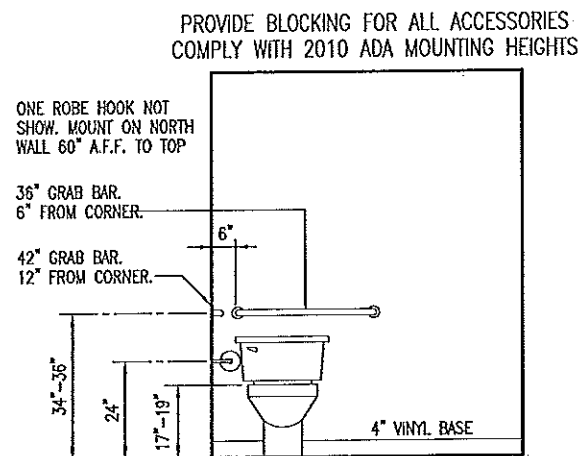

C
18
RESTROOM ELEVATION
SCALE: 1/2" = 1'-0"

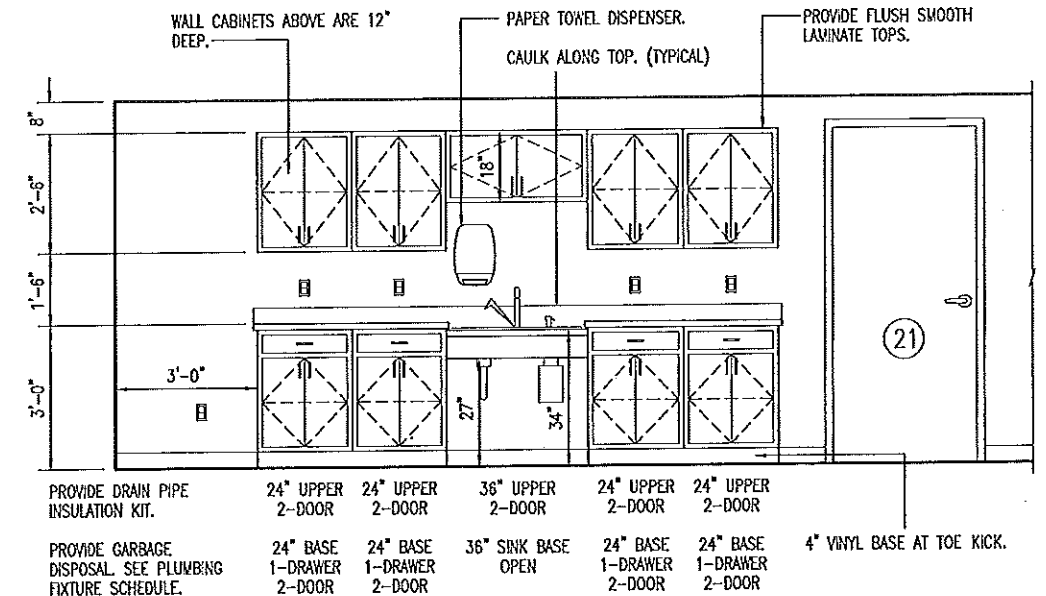


CABINET CONSTRUCTION

CABINETS - PLASTIC LAMINATE ON 3/4" HIGH DENSITY PARTICLE BOARD WITH WHITE MELAMINE INTERIORS, WIRE PULLS AND ADJUSTABLE SHELVES.


ALL DRAWERS TO HAVE METAL GLIDES, WIRE PULLS AND MELAMINE INTERIORS.

1-1/2" COUNTER TOP & 4" BACKSPLASH - PLASTIC LAMINATE ON 3/4" HIGH DENSITY PARTICLEBOARD.

D
18
109 BREAKROOM
CASEWORK ELEVATION
SCALE: 1/4" = 1'-0"

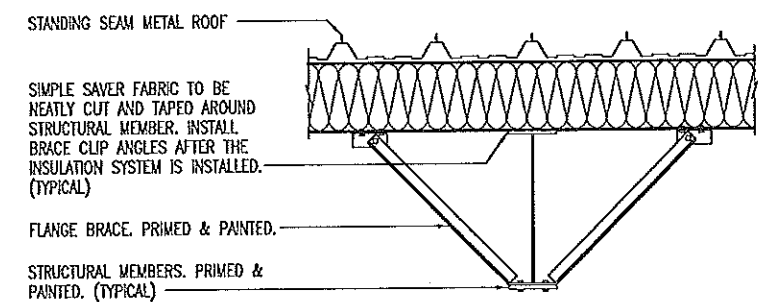

E
18
FLANGE BRACING
SCALE: 1/2" = 1'-0"

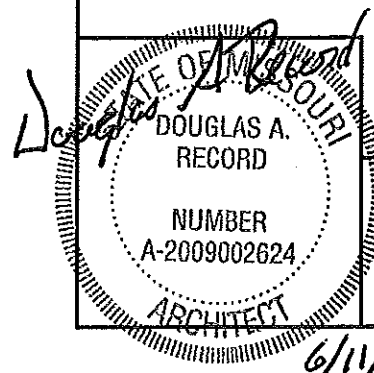


INTERIOR ELEVATIONS


MISSOURI DEPARTMENT
OF TRANSPORTATION
DIVISION OF GENERAL SERVICES
FACILITIES MANAGEMENT

STANDARD MAINTENANCE BUILDING


DRAWN BY: LARRY CARVER
CHECKED BY: DOUG RECORD
DATE: 6-11-14
Sheet
18 of 38

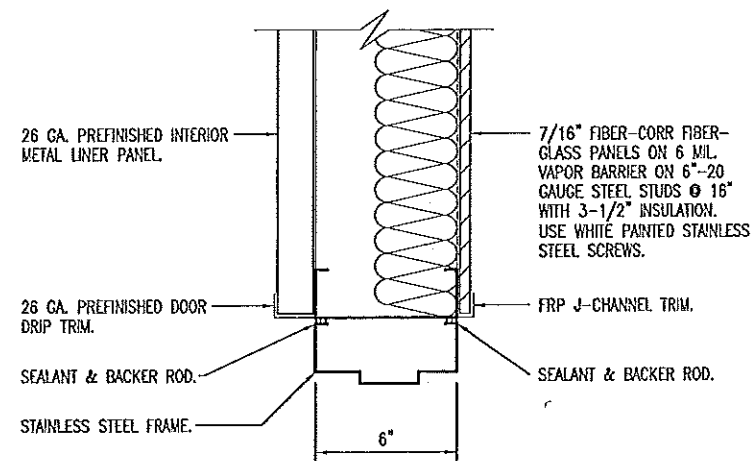


D DOOR HEAD/JAMB
19
SCALE: 1-1/2" = 1'-0"

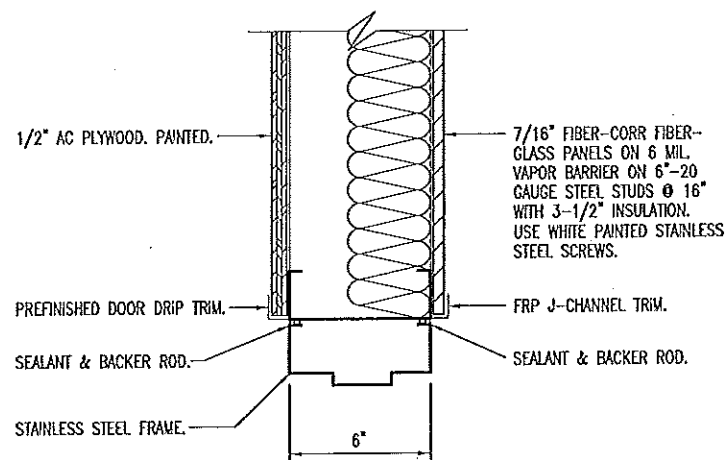


E DOOR HEAD/JAMB
19
SCALE: 1-1/2" = 1'-0"

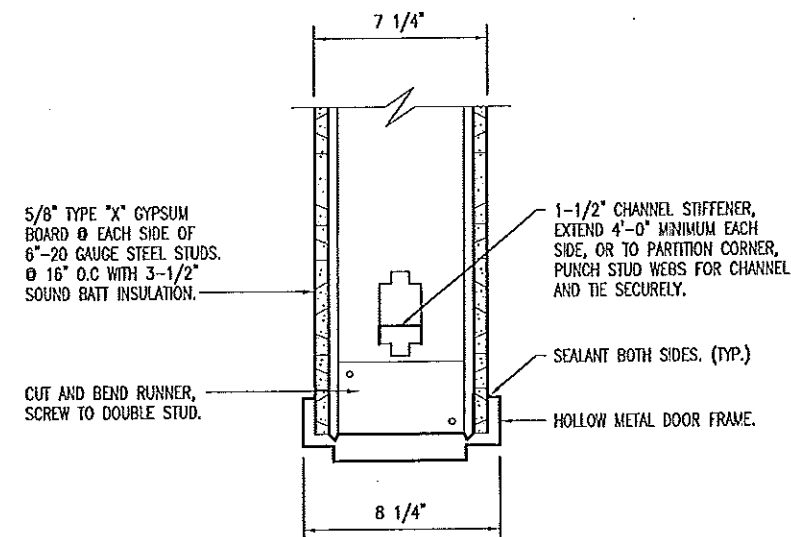


F DOOR HEAD/JAMB
19
SCALE: 1-1/2" = 1'-0"

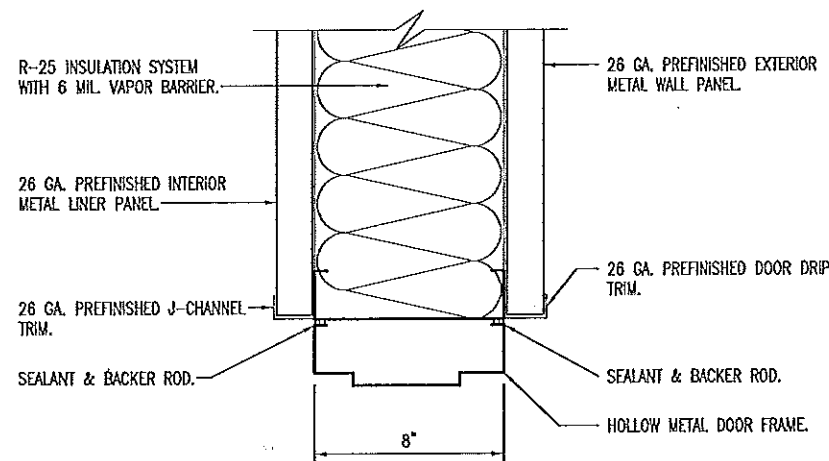


A DOOR HEAD/JAMB
19
SCALE: 1-1/2" = 1'-0"

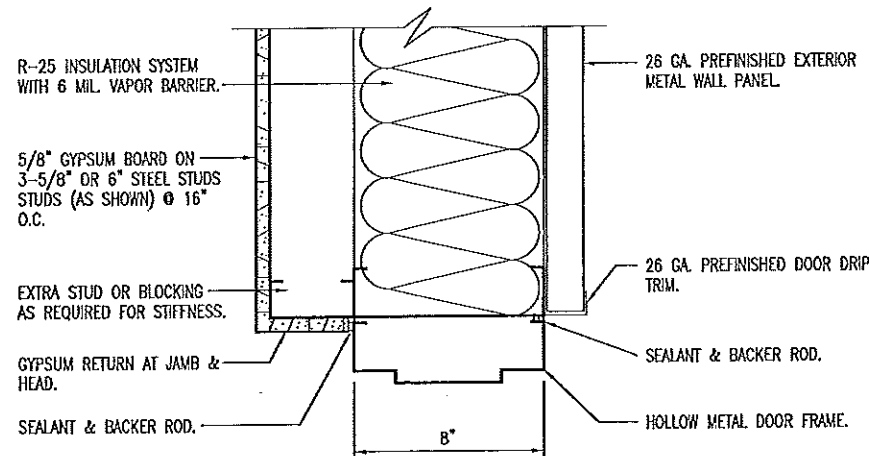

B DOOR HEAD/JAMB
19
SCALE: 1-1/2" = 1'-0"

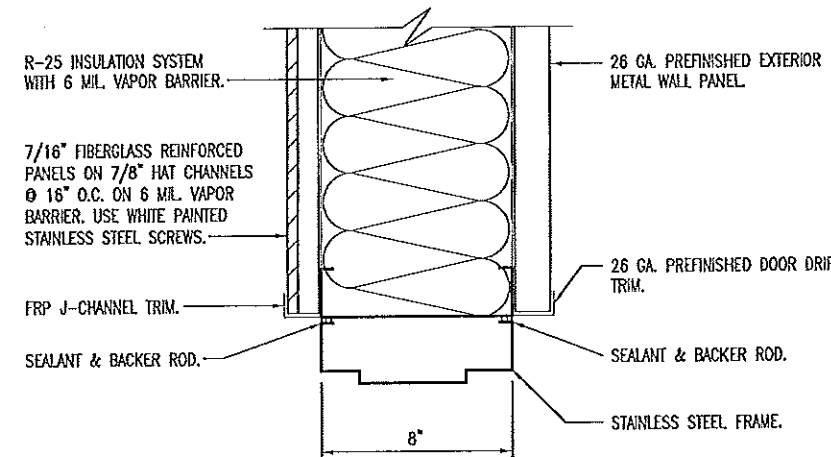

C DOOR HEAD/JAMB
19
SCALE: 1-1/2" = 1'-0"

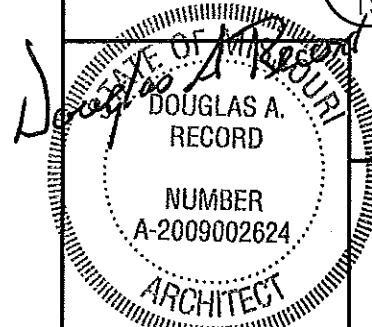


6/11/14

HEAD & JAMB DETAILS


MISSOURI DEPARTMENT
OF TRANSPORTATION
DIVISION OF GENERAL SERVICES
FACILITIES MANAGEMENT

STANDARD MAINTENANCE BUILDING


DRAWN BY: LARRY CARVER
CHECKED BY: DOUG RECORD
DATE: 6-11-14
Sheet
19 of 38

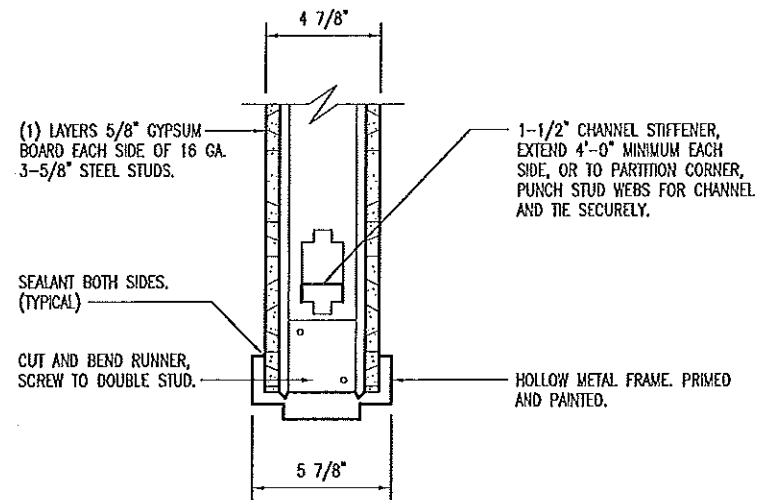


B
20
SOUND BATT INSULATION NOT SHOWN.
DOOR HEAD/JAMB
SCALE: 1-1/2" = 1'-0"

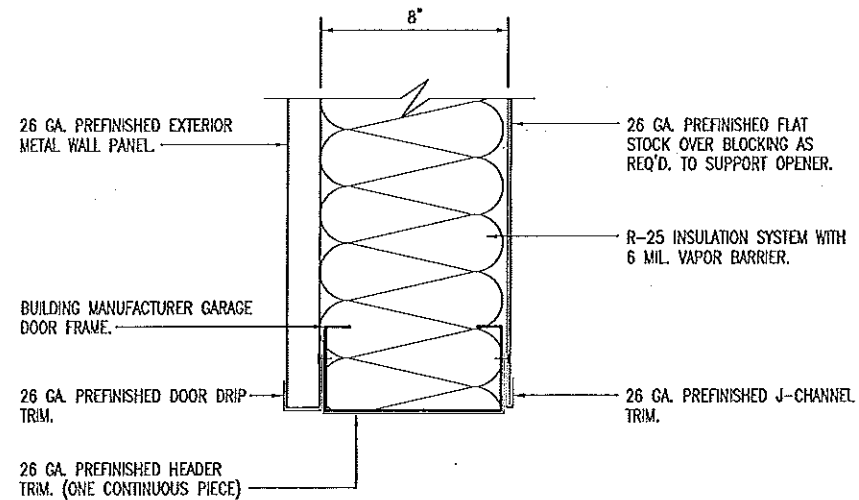


GARAGE DOOR HEAD
SCALE: 1-1/2" = 1'-0"

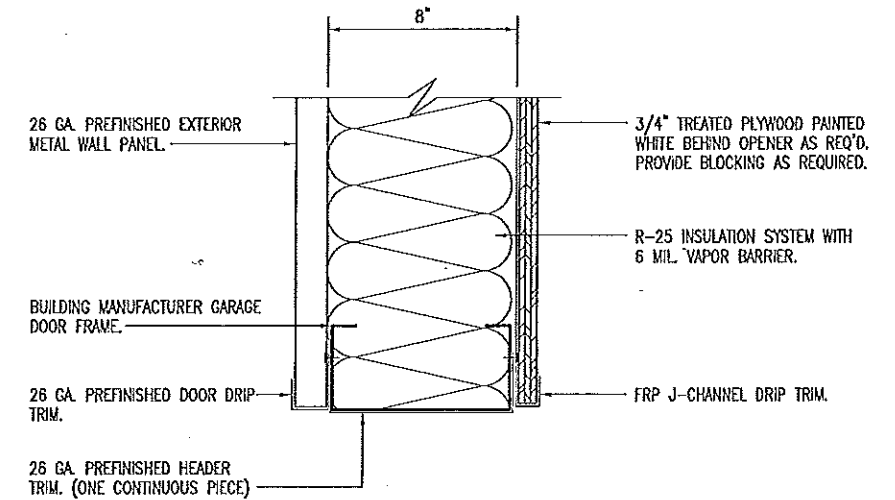


GARAGE DOOR HEAD
SCALE: 1-1/2" = 1'-0"

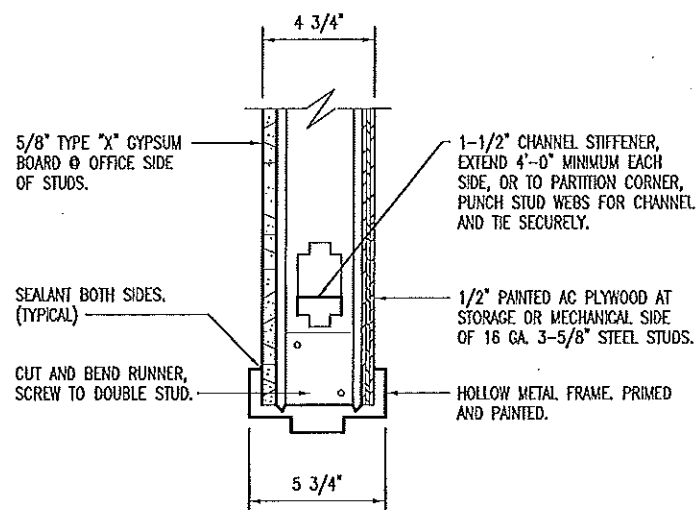


A
20
SOUND BATT INSULATION NOT SHOWN.
DOOR HEAD/JAMB
SCALE: 1-1/2" = 1'-0"

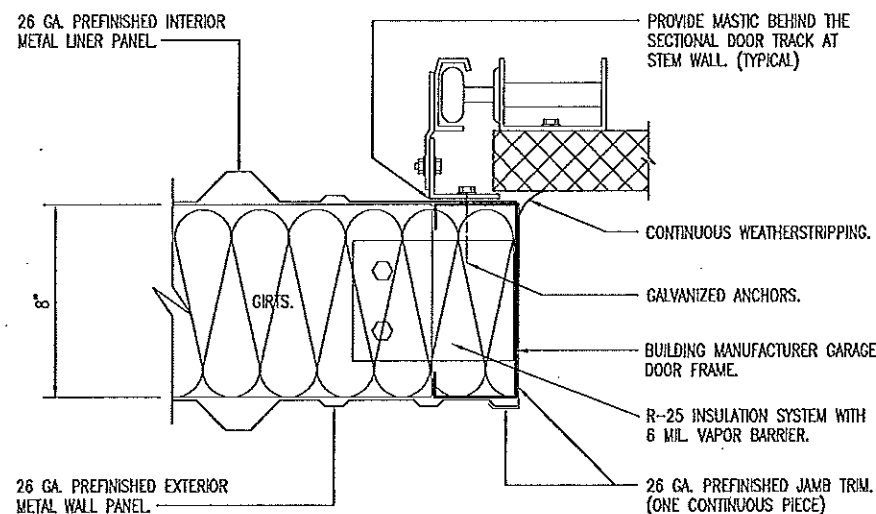

C
20
GARAGE DOOR JAMB
SCALE: 1-1/2" = 1'-0"

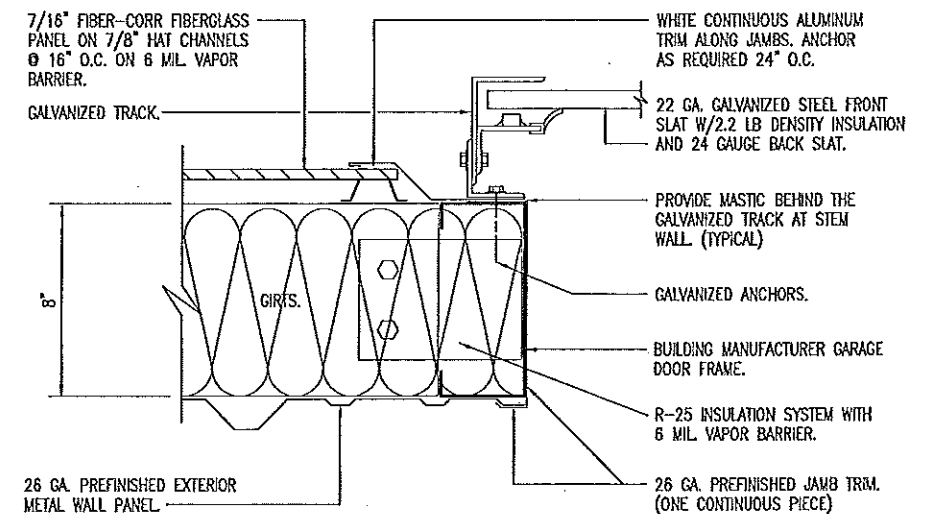

D
20
GARAGE DOOR JAMB
SCALE: 1-1/2" = 1'-0"

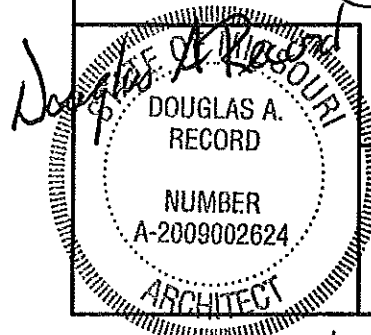


HEAD & JAMB DETAILS


MISSOURI DEPARTMENT
OF TRANSPORTATION
DIVISION OF GENERAL SERVICES
FACILITIES MANAGEMENT

STANDARD MAINTENANCE BUILDING


DRAWN BY: LARRY CARYER
CHECKED BY: DOUG RECORD
DATE: 8-11-14
Sheet
20 of 38

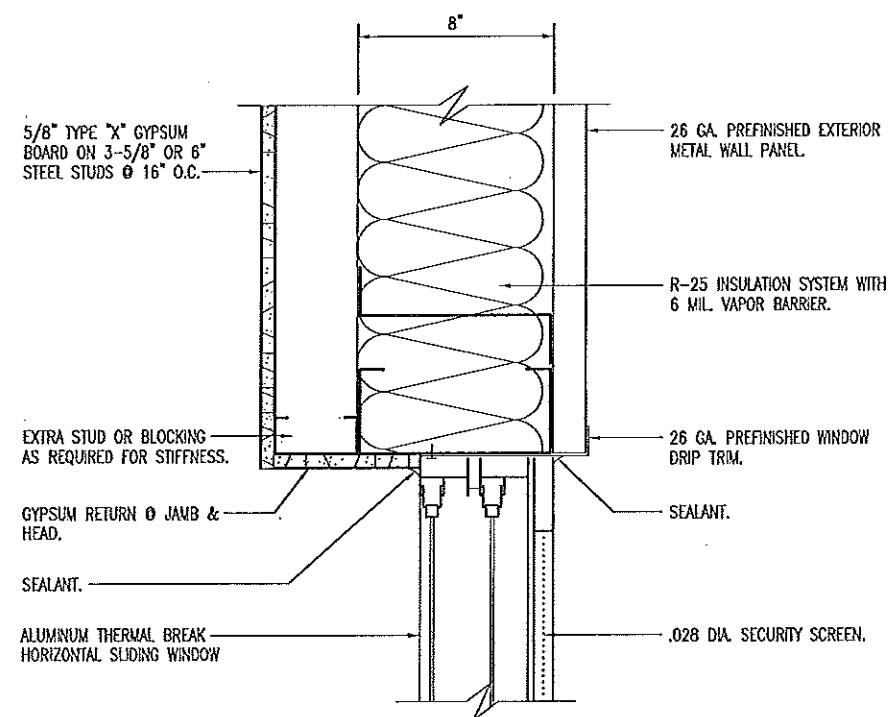


C
21
AT OFFICE AREA
WINDOW HEAD/JAMB
SCALE: 1-1/2" = 1'-0"

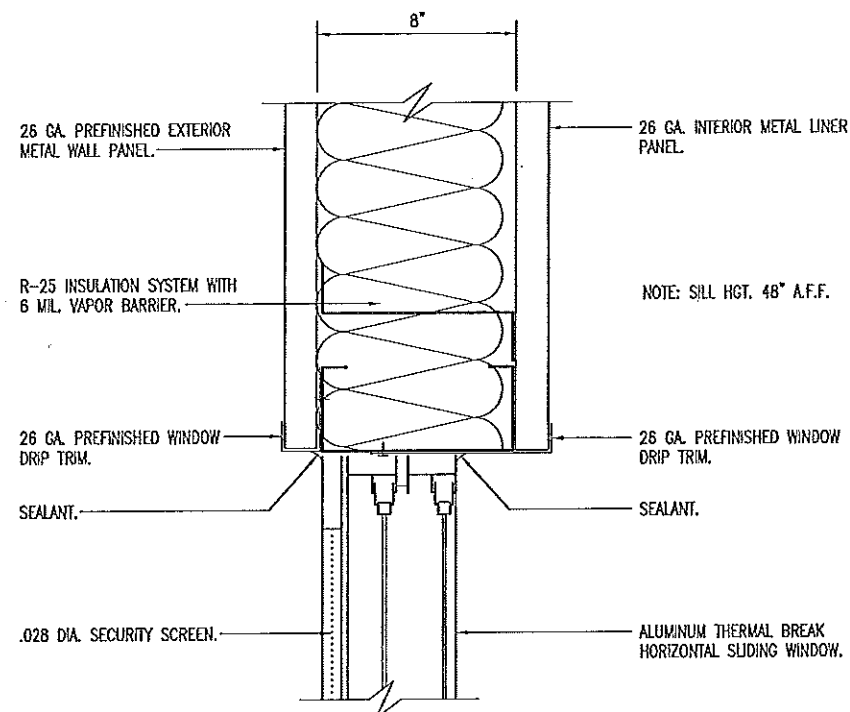


D
21
AT MAINTENANCE AREA
WINDOW HEAD
SCALE: 1-1/2" = 1'-0"

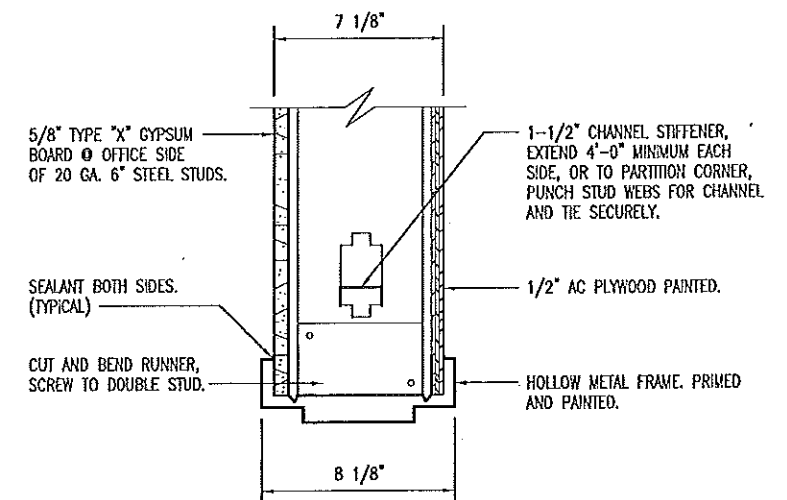


E
21
SOUND BATT INSULATION NOT SHOWN.
DOOR HEAD/JAMB
SCALE: 1-1/2" = 1'-0"

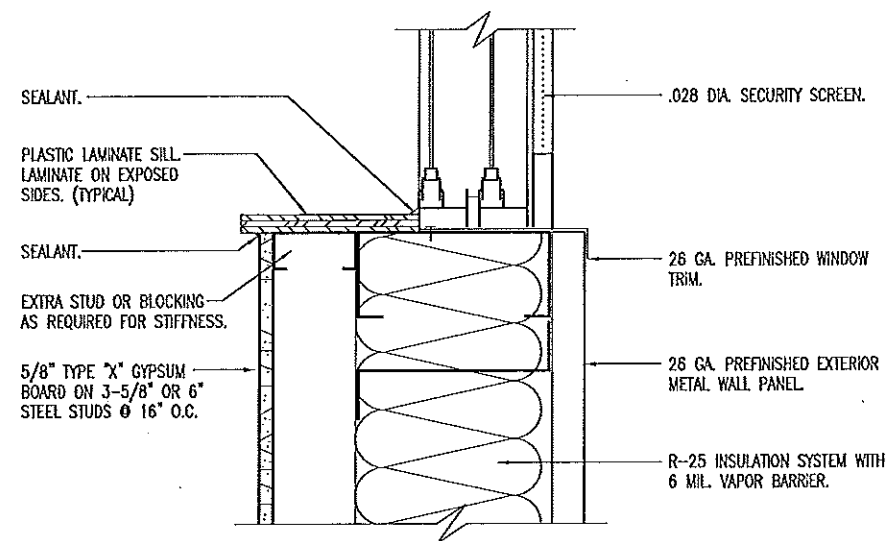

A
21
AT OFFICE AREA
WINDOW SILL
SCALE: 1-1/2" = 1'-0"

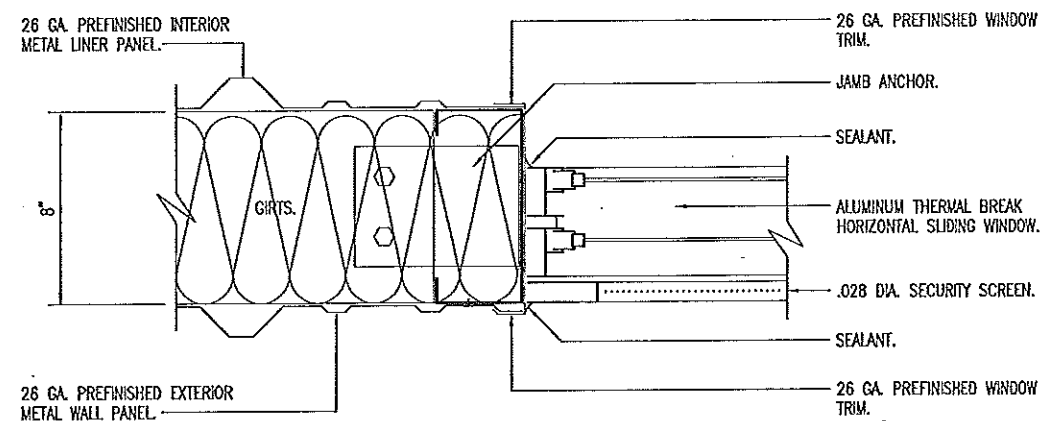

B
21
AT MAINTENANCE AREA
WINDOW JAMB
SCALE: 1-1/2" = 1'-0"

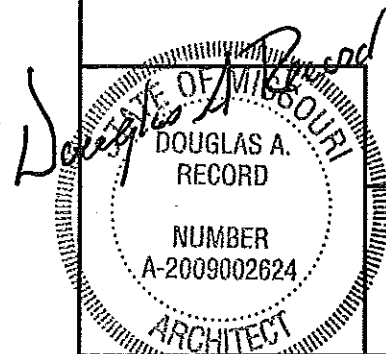


HEAD & JAMB DETAILS


MISSOURI DEPARTMENT
OF TRANSPORTATION
DIVISION OF GENERAL SERVICES
FACILITIES MANAGEMENT

STANDARD MAINTENANCE BUILDING


DRAWN BY: LARRY CARMER
CHECKED BY: DOUG RECORD
DATE: 6-11-14
Sheet
21 of 38

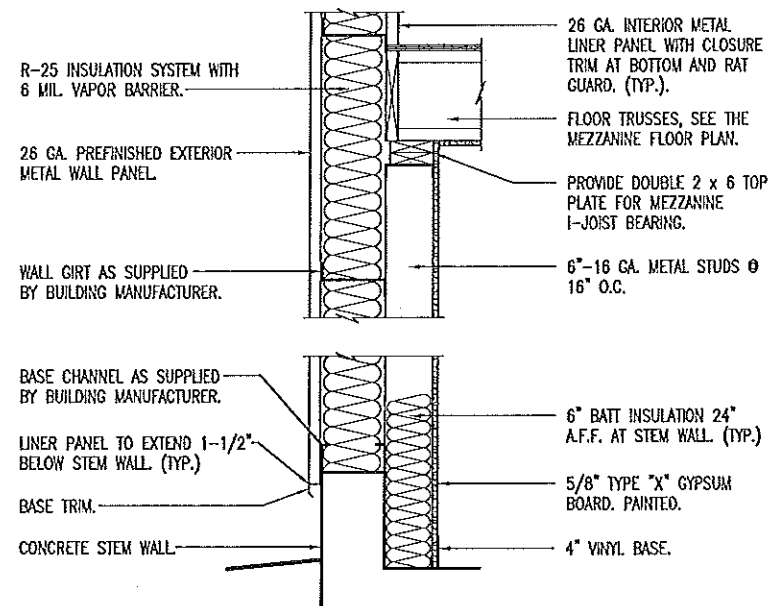


D
22
EXTERIOR WALL SECTION
SCALE: 1/2" = 1'-0"

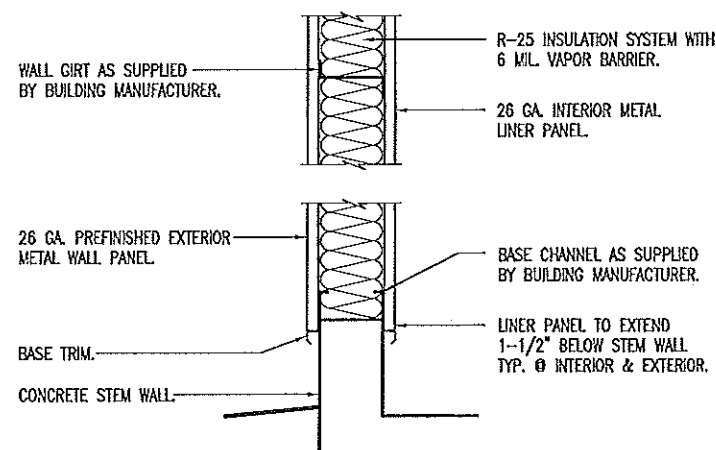


A
22
EXTERIOR WALL SECTION
SCALE: 1/2" = 1'-0"

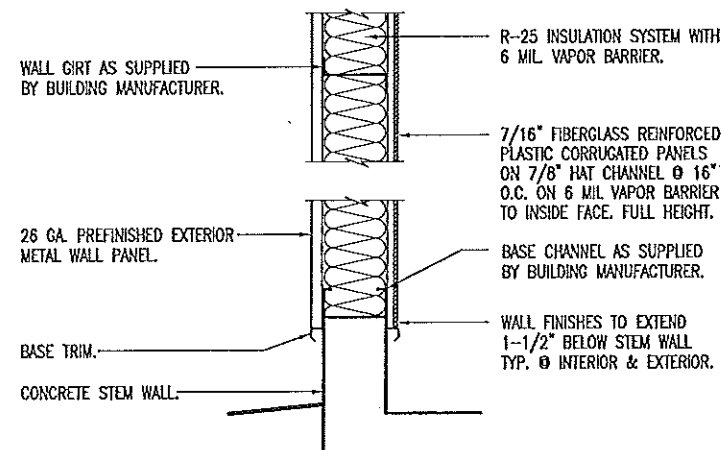

B
22
EXTERIOR WALL SECTION
SCALE: 1/2" = 1'-0"

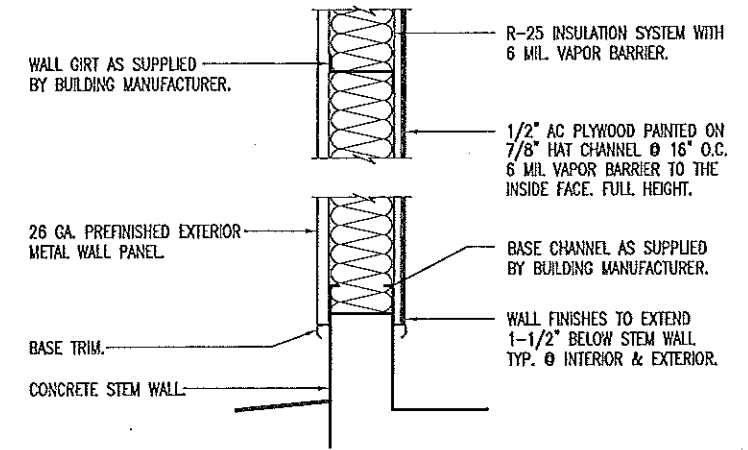

C
22
EXTERIOR WALL SECTION
SCALE: 1/2" = 1'-0"

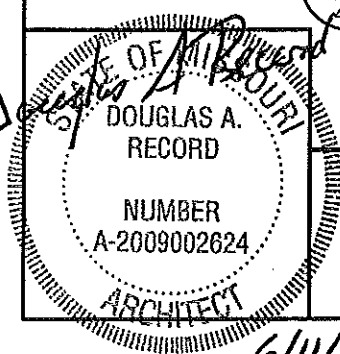


WALL SECTIONS


MISSOURI DEPARTMENT
OF TRANSPORTATION
DIVISION OF GENERAL SERVICES
FACILITIES MANAGEMENT

STANDARD MAINTENANCE BUILDING


DRAWN BY: LARRY CARVER
CHECKED BY: DOUG RECORD
DATE: 6-11-14
Sheet
22 of 38

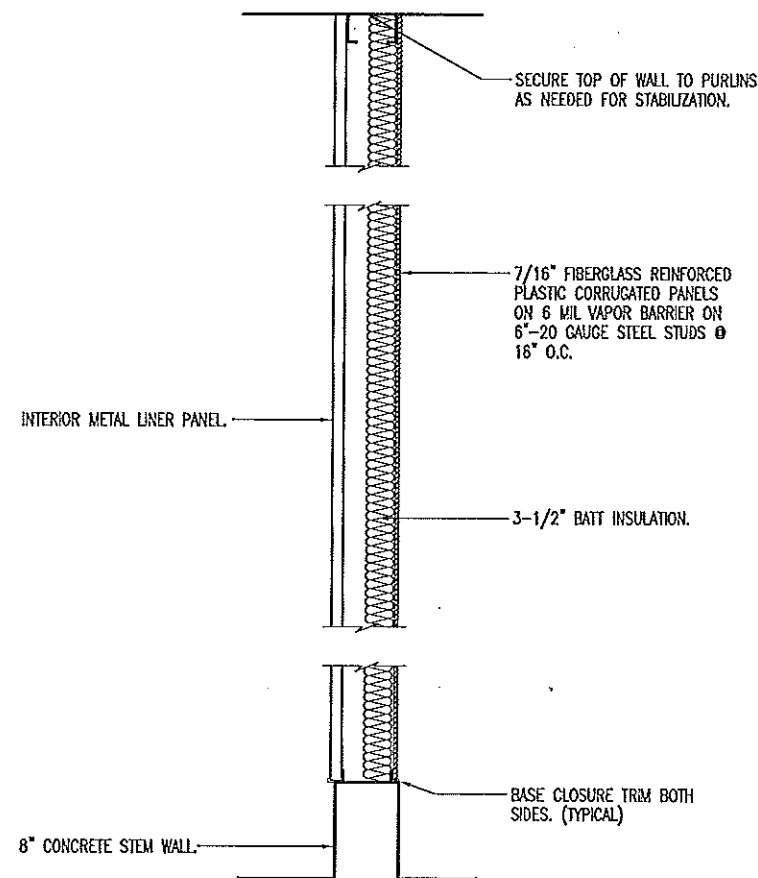


A
23
INTERIOR WALL SECTION
SCALE: 1/2" = 1'-0"

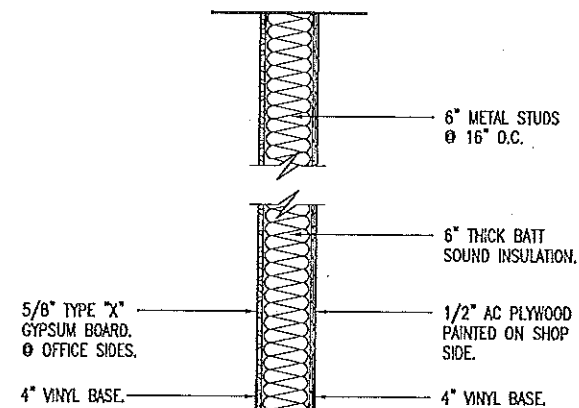


D
23
INTERIOR WALL SECTION
SCALE: 1/2" = 1'-0"

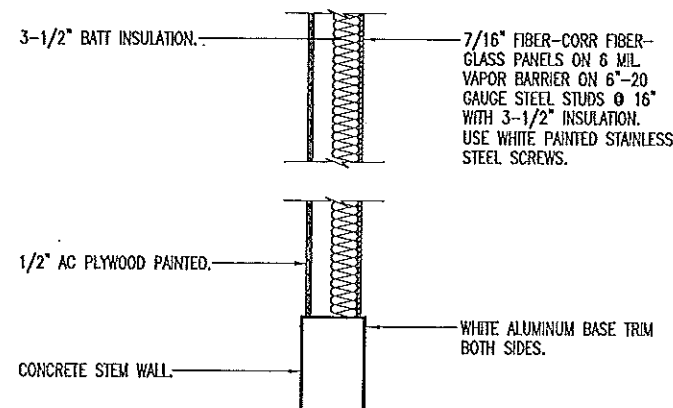


B
23
INTERIOR WALL SECTION
SCALE: 1/2" = 1'-0"

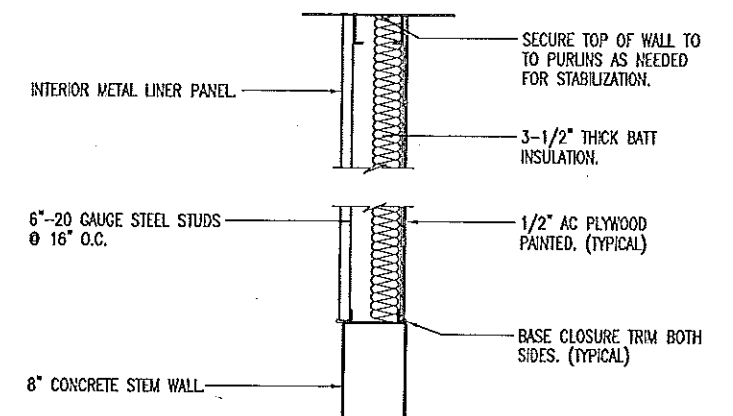

E
23
INTERIOR WALL SECTION
SCALE: 1/2" = 1'-0"

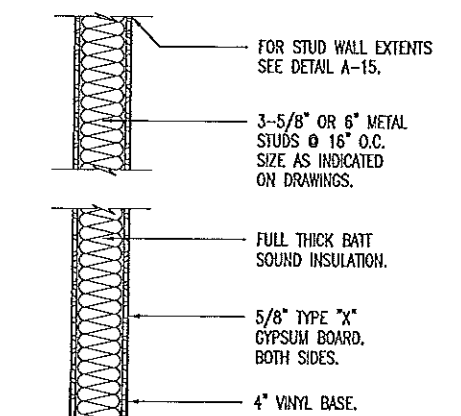

C
23
INTERIOR WALL SECTION
SCALE: 1/2" = 1'-0"

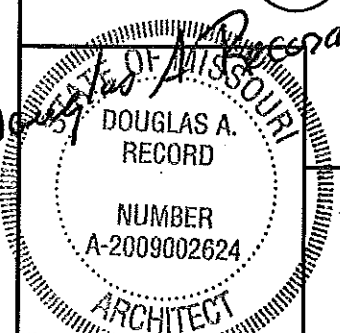


WALL SECTIONS

MISSOURI DEPARTMENT
OF TRANSPORTATION
DIVISION OF GENERAL SERVICES
FACILITIES MANAGEMENT

STANDARD MAINTENANCE BUILDING

DRAWN BY: LARRY CARVER
CHECKED BY: DOUG RECORD
DATE: 6-11-14
Sheet
23 of 38

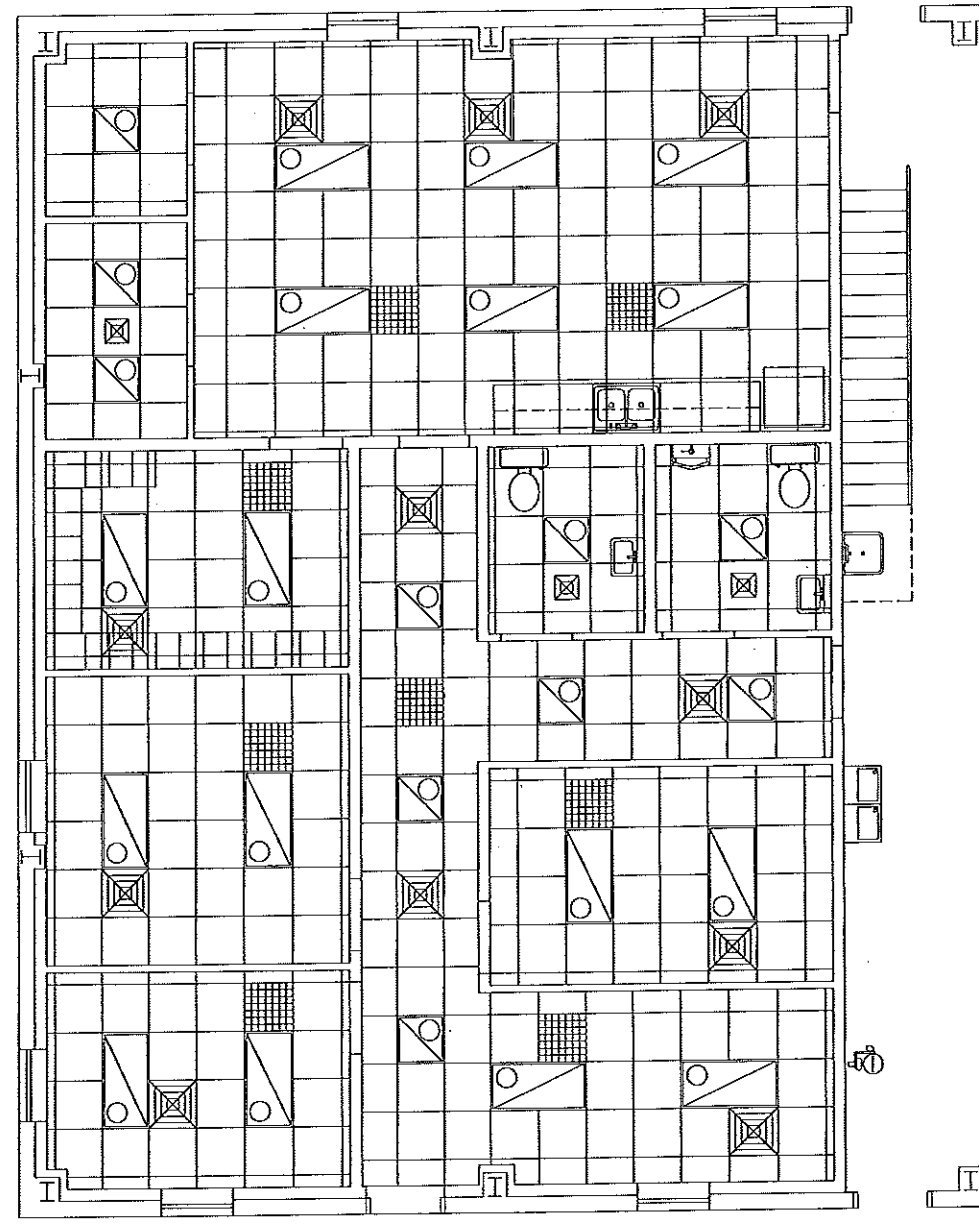

A
24

REFLECTED CEILING PLAN

SCALE: 1/8" = 1'-0"




STATE OF MISSOURI
DOUGLAS A. RECORD
NUMBER
A-2009002624
ARCHITECT
6/11/14

REFLECTED CEILING PLAN

MISSOURI DEPARTMENT
OF TRANSPORTATION
DIVISION OF GENERAL SERVICES
FACILITIES MANAGEMENT

STANDARD MAINTENANCE BUILDING

DRAWN BY: LARRY CARYER
CHECKED BY: DOUG RECORD
DATE: 6-11-14
Sheet
24 of 38

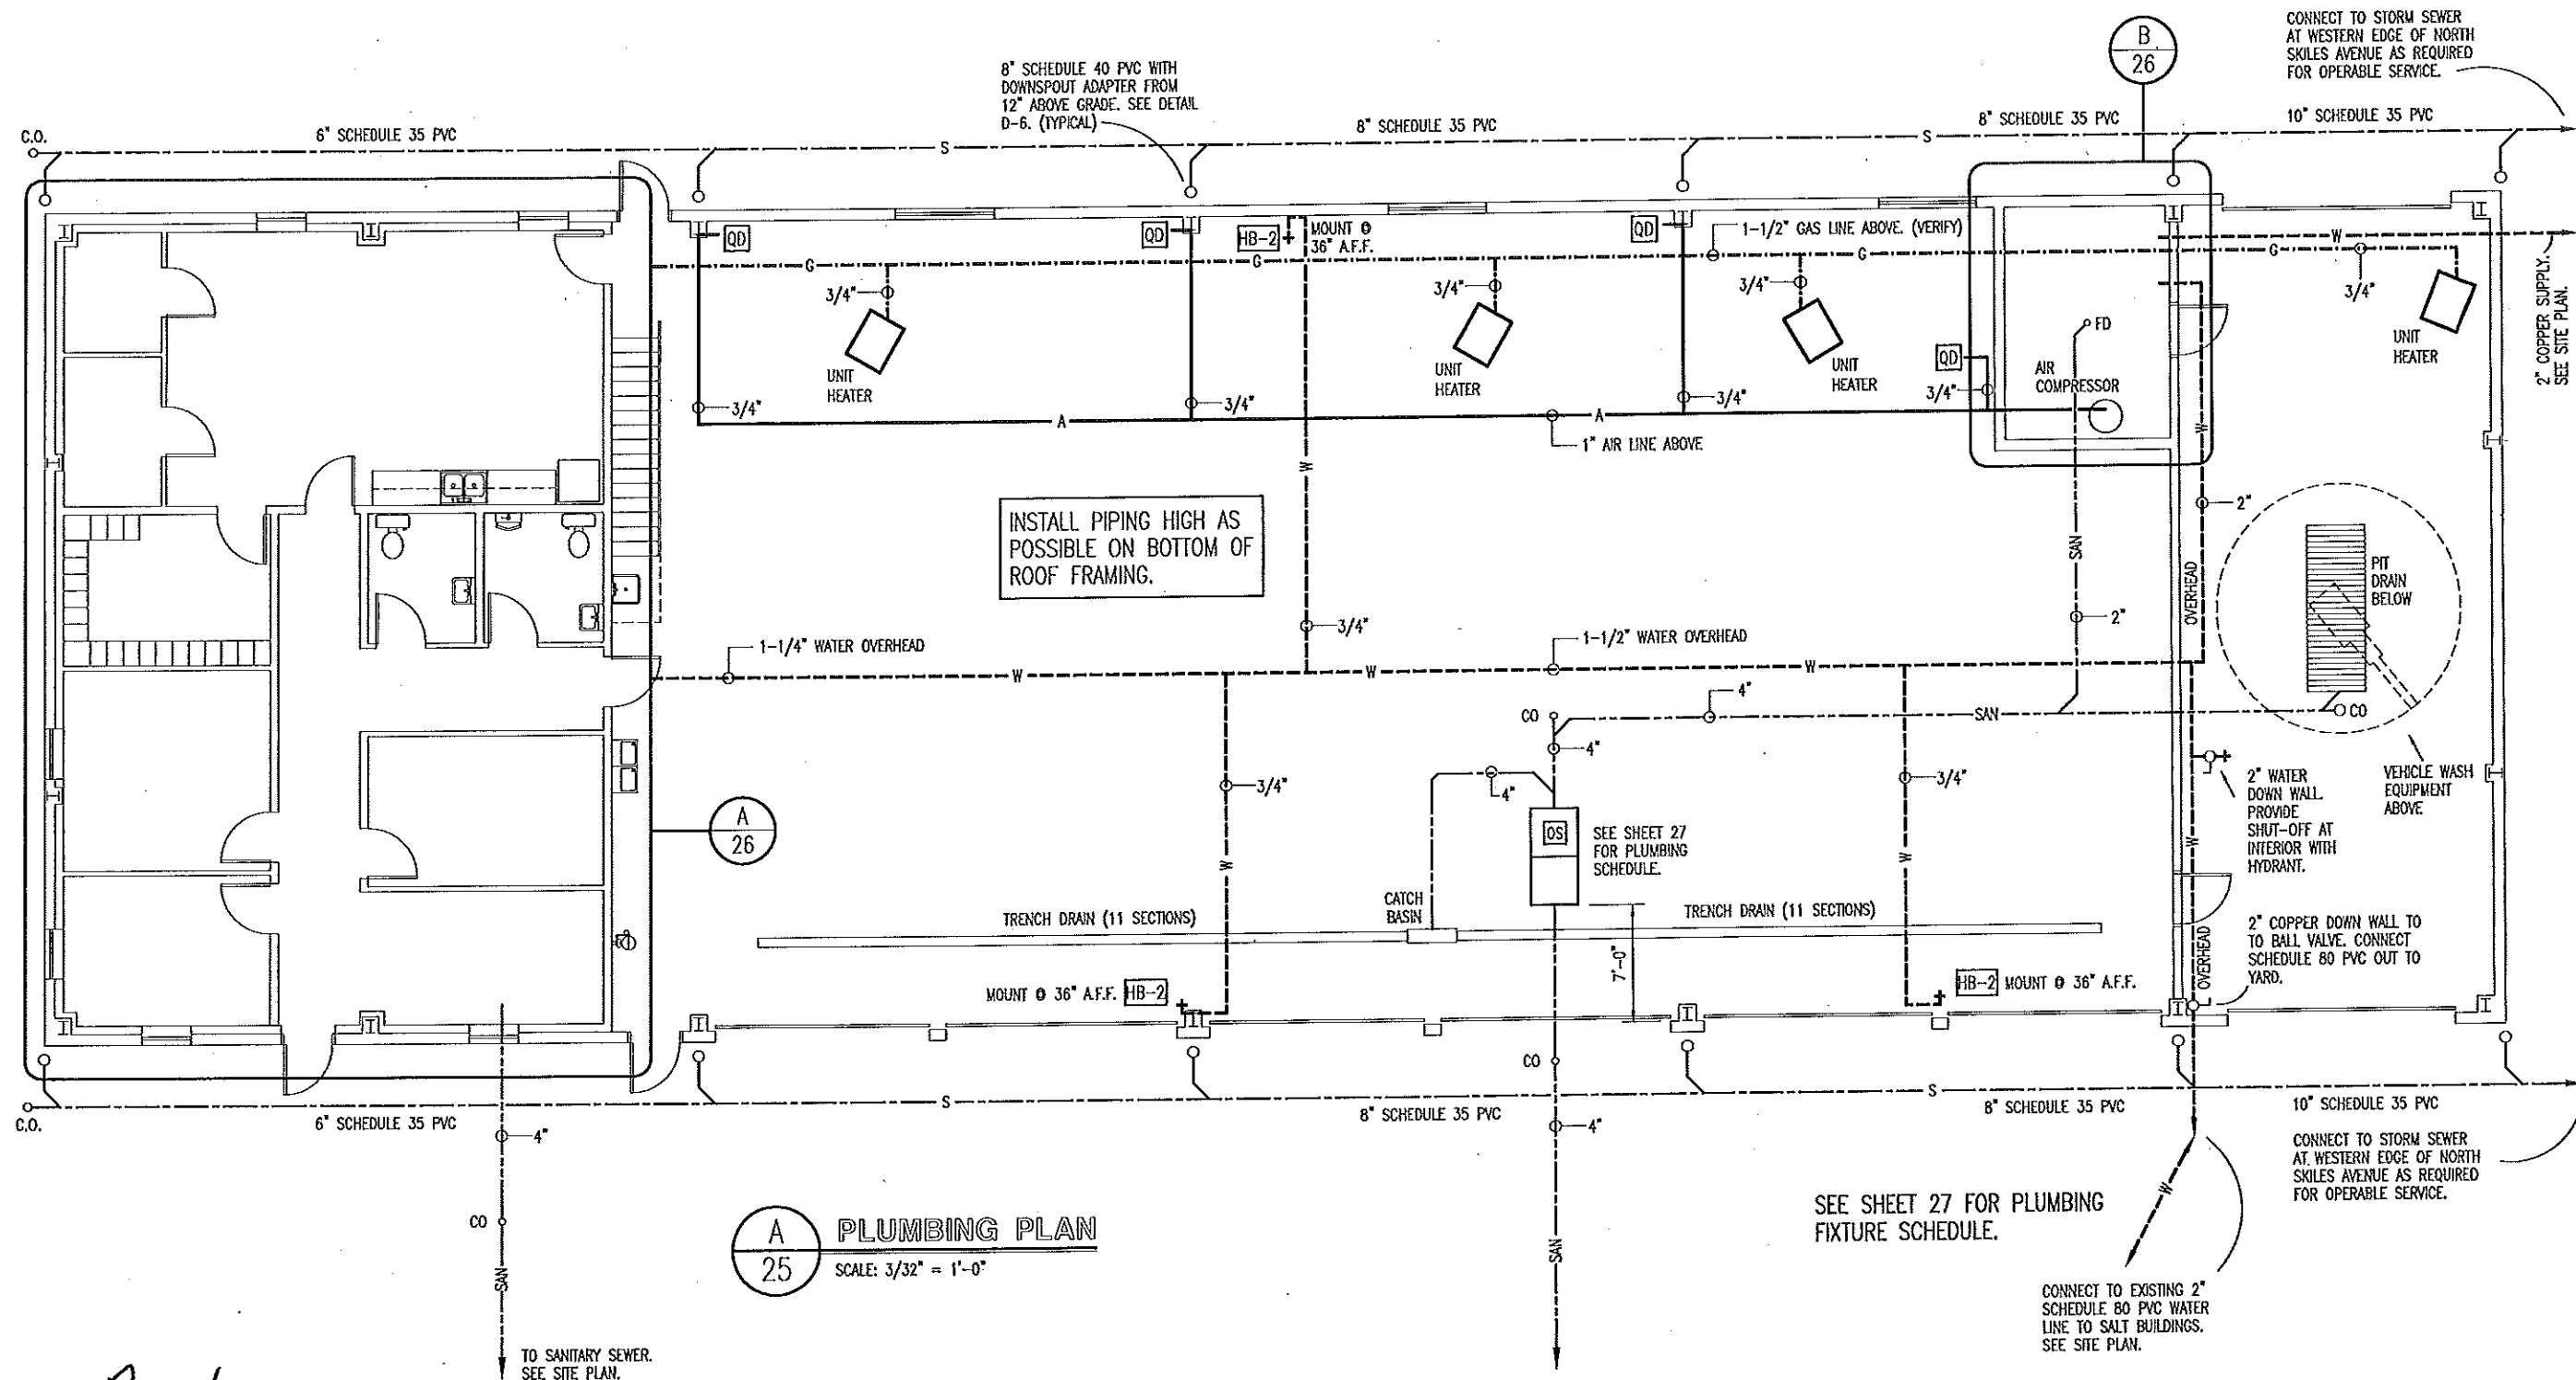

A
25
PLUMBING PLAN
SCALE: 3/32" = 1'-0"

SEE SHEET 27 FOR PLUMBING
FIXTURE SCHEDULE.

CONNECT TO EXISTING 2"
SCHEDULE 80 PVC WATER
LINE TO SALT BUILDINGS.
SEE SITE PLAN.


CONNECT TO STORM SEWER
AT WESTERN EDGE OF NORTH
SKILES AVENUE AS REQUIRED
FOR OPERABLE SERVICE.

MISSOURI DEPARTMENT
OF TRANSPORTATION
DIVISION OF GENERAL SERVICES
FACILITIES MANAGEMENT


STANDARD MAINTENANCE BUILDING

DRAWN BY: LARRY CARVER
CHECKED BY: DOUG RECORD
DATE: 6-11-14
Sheet
25 of 38


PLUMBING PLAN

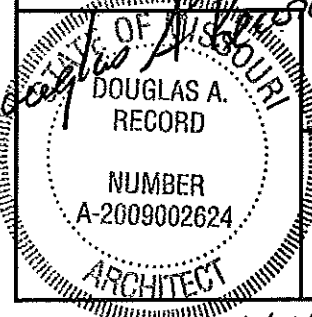


6/11/14

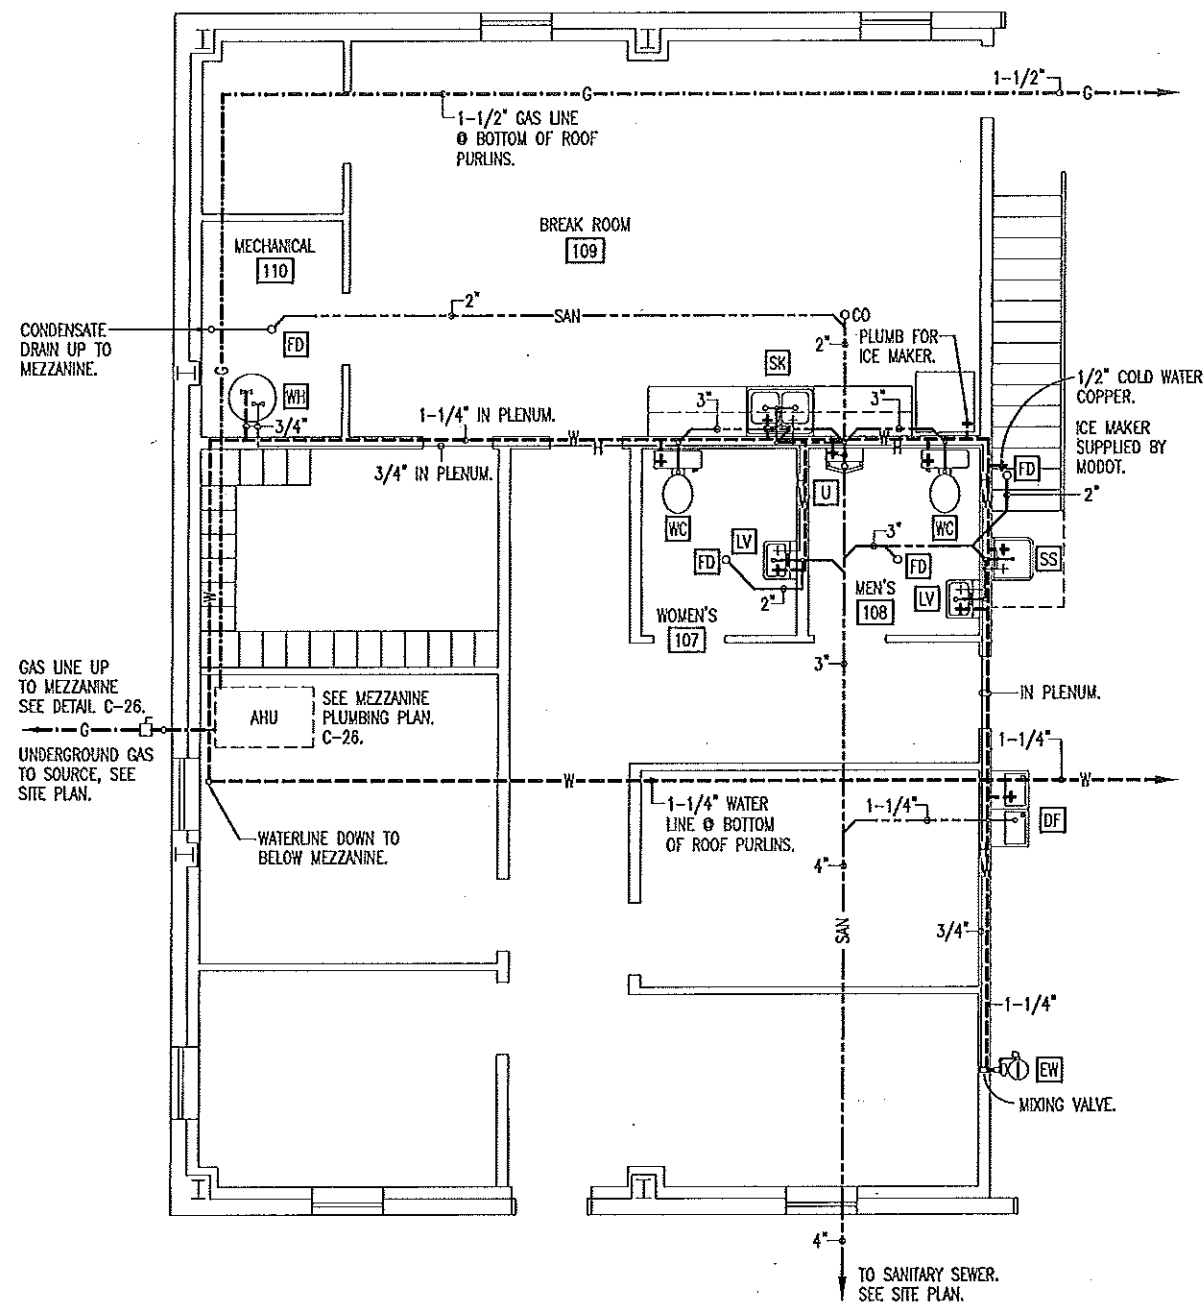

A
26
OFFICE PLUMBING PLAN
SCALE: 1/8" = 1'-0"

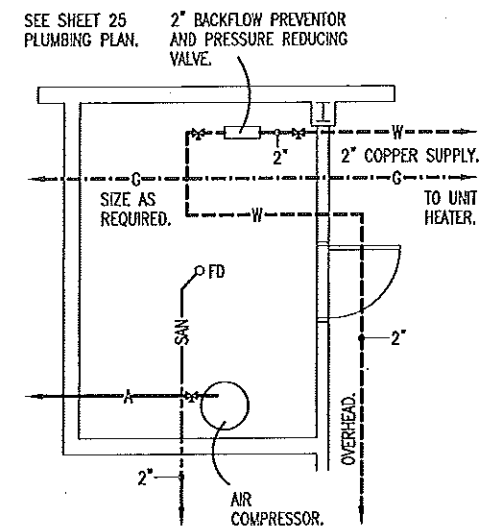


B
26
114 WASH EQUIPMENT PLUMBING
SCALE: 1/8" = 1'-0"

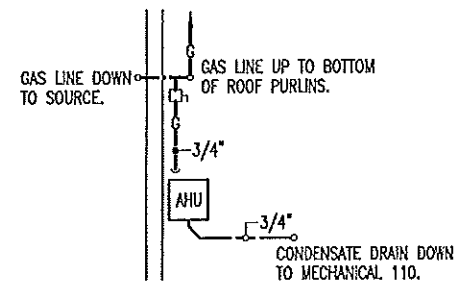

C
26
200 MEZZANINE PLUMBING
SCALE: NONE

SEE SHEET 27 FOR PLUMBING
FIXTURE SCHEDULE.

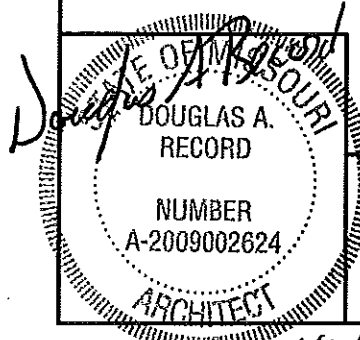

OFFICE PLUMBING PLAN

MISSOURI DEPARTMENT
OF TRANSPORTATION
DIVISION OF GENERAL SERVICES
FACILITIES MANAGEMENT


STANDARD MAINTENANCE BUILDING

DRAWN BY: LARRY CARYER
CHECKED BY: DOUG RECORD
DATE: 8-11-14
Sheet
26 of 38

PLUMBING FIXTURE SCHEDULE						
SYM.	FIXTURE	PIPE CONNECTION				REMARKS
		CW	HW	S&W	VENT	
WC	WATER CLOSET	1/2"		3"	2"	EQUAL TO AMERICAN STANDARD #2377.100 FLOOR MOUNT, PRESSURE ASSISTED, ELONGATED WATER-SAVER "CADET" WATER CLOSET, 16-1/2" HIGH 3109.016 BOWL, 4098.100 TANK, INCLUDE OPEN FRONT SEAT WITH LID. (WHITE)
U	URINAL	3/4"		1-1/2"	1-1/2"	EQUAL TO AMERICAN STANDARD #6601.021 "LYNBROOK" 1.0 GALLON URINAL WITH SLOAN ROYAL 180-1 FLUSH VALVE.
LV	LAVATORY	1/2"	1/2"	2"	2"	EQUAL TO AMERICAN STANDARD #4867.024, 20" x 18" ENAMELED, CAST IRON "REGALYN" WALL MOUNT LAVATORY WITH 4" CENTERSET SYMMONS S-80-2-G-FR-W SINGLE LEVER LAVATORY FAUCET, INCLUDE AN ADA APPROVED INSULATION KIT.
SK	SINK	1/2"	1/2"	2"	2"	EQUAL TO ELKAY MODEL PSR-3321 DOUBLE BOWL SINK WITH STANDARD 4 HOLE PATTERN AND ELKAY MODEL LX-4301-F CHROME FAUCET, SPOUT, SWIVEL AERATOR AND SPRAY. PROVIDE INSINKERATOR EVOLUTION 3/4 HP, 8.1 AMP, GARBAGE DISPOSAL.
SS	SERVICE SINK	1/2"	1/2"	3"	2"	EQUAL TO AMERICAN STANDARD #7692.049, 22" x 18" ENAMELED, CAST IRON "LAKEWELL" SERVICE SINK W/ 8340.242 HERITAGE LEVEL HANDLE FAUCET, AND 7798.176 P-TRAP.
DF	WATER COOLER	3/8"		1-1/4"		ELKAY, TWO STATION WALL MOUNT BARRIER-FREE WALL MOUNT MODEL VRCGRN18C OR EQUAL.
EW	EMERGENCY EYE WASH	1-1/4"	3/4"			EQUAL TO BRADLEY "MODEL S19-310" DRENCH SHOWER/EYE WASH UNIT SAFETY YELLOW, S19-2100 THERMOSTATIC MIXING VALVE.
WH	WATER HEATER	3/4"	3/4"			A.O. SMITH MODEL NUMBER EES-30 (2) 4500 WATT, 240 VOLT ELEMENTS, 30 GALLON ELECTRIC WITH PRESSURE RELIEF VALVE OR EQUAL MOUNT 0 24" ABOVE FINISHED FLOOR AS/WHERE REQUIRED.
HB-1	HOSE BIBB	3/4"				EXTERIOR - EQUAL TO WOODFORD MODEL 67 FREEZELESS WALL HYDRANT WITH 3/4" H.P.T. OUTLET, INTEGRAL VACUUM BREAKER-BACK FLOW PREVENTER, (N.I.C.)
HB-2	HOSE BIBB	3/4"				INTERIOR - EQUAL TO WOODFORD MODEL 26 WALL FAUCET WITH 3/4" H.P.T. OUTLET, INTEGRAL VACUUM BREAKER-BACKFLOW PREVENTER.
YH	YARD HYDRANT	2"				EXTERIOR - EQUAL TO WOODFORD MODEL MK 720 - WHEEL HANDLE HYDRANT WITH 2" FPT INLET, 2" FPT GALVANIZED TEE OUTLET, INTEGRAL VACUUM BREAKER-BACKFLOW PREVENTER.
FD	FLOOR DRAIN			2"		PVC FLOOR DRAIN WITH P-TRAP, 6-1/2" DIA. NICKLE-BRONZE STRAINER, 2" FIP THREADED THROAT-BALL BACKWATER DEVICE. 1-1/2" PRE-INSTALLED FIP CLEAN-OUT THREADS.
TD	TRENCH DRAIN			4"		EQUAL TO ZURN Z886 CHANNEL SLOPE TRENCH DRAIN SYSTEM WITH LOCK DOWN CAST IRON GRATE "CLASS C".
CB	CATCH BASIN			4"		EQUAL TO ZURN Z887-6x20 CATCH BASIN, WITH STAINLESS STEEL TRASH BUCKET AND LOCK DOWN CAST IRON GRATE "CLASS C".
OS	OIL SEPARATOR			4"		EQUAL TO CHAMPION PRECAST INC. 1,200 GALLON OIL & GREASE INTERCEPTOR STOCK STANDARD NO. 140-00218D. HEAVY DUTY PRECAST CONCRETE. PH: (573)384-5855.
QD	QUICK DISCONNECT					VERIFY SIZE WITH MODOT MECHANIC. MOUNT AT 60" A.F.F. ATTACH RIGIDLY TO COLUMNS.
CO	CLEAN OUT					BRASS WITH ADAPTER AND CAP EQUAL TO PIPE SIZE SHOWN.
AC	AIR COMPRESSOR					EQUAL TO INGERSOLL-RAND MODEL #2475N7.5, 7.5 HP, 80 GALLON VERTICAL, 24.0 (ACFM) CAPACITY. MAXIMUM PRESSURE 175 LBS. 230 V 1 PHASE WITH REFRIGERATED DRYER MODEL #DS25 SINGLE PHASE PROVIDE RUBBERIZED WASHERS AT EACH FLOOR MOUNT TO ACT AS A SHOCK ABSORBER. SIZE MOUNT AS REQUIRED. PROVIDE LINE FILTERS AS REQUIRED.

PLUMBING NOTES


- DRAWINGS AND DIAGRAMS ARE DIAGRAMMATIC AND SHALL NOT BE SCALED. REFER TO ARCHITECTURAL DRAWINGS FOR DIMENSIONS.
- PLUMBING SHALL BE INSTALLED IN STRICT COMPLIANCE WITH THE LATEST EDITION OF THE INTERNATIONAL PLUMBING CODE.
- PLUMBING SHALL BE LOCATED AND PLACED UNDER THE SLAB PRIOR TO POURING OF CONCRETE. PIPING SHALL BE RUN IN SAND FILLED TRENCH UNDER THE BASE ROCK AND SLEEVED WITH PVC WHENEVER RUN THROUGH CONCRETE.
- PROVIDE PLUMBING EQUIPMENT AND ACCESSORIES REQUIRED FOR COMPLETE AND OPERATIONAL PLUMBING SYSTEMS AS REQUIRED BY MANUFACTURER'S INSTRUCTIONS AND DIRECTIONS FOR SYSTEMS SPECIFIED.
- PLUMBING VENTS ARE NOT SHOWN ON THE PLANS. ALL FIXTURES SHALL BE PROPERLY VENTED AS PER IBC PLUMBING CODE.
- ROOF VENTS SHALL BE COMBINED WHEREVER IN COMPLIANCE WITH THE NATIONAL PLUMBING CODE TO MINIMIZE ROOF PENETRATIONS.
- EXTERIOR BELOW-GROUND WATER DISTRIBUTION PIPING SHALL RUN A MINIMUM OF 36 INCHES BELOW FINISH GRADE.
- PROVIDE SHUT OFF VALVES AT EACH FIXTURE.
- PROVIDE SHOCK ABSORBERS AS REQUIRED AT EACH FAUCET.
- PROVIDE 2" BACKFLOW PREVENTER AT WATER SUPPLY ENTRANCE.
- SEE HVAC PLANS FOR GAS PIPING REQUIREMENTS.
- CONTRACTOR TO PROVIDE 2" BACKFLOW PREVENTER AND PRESSURE REDUCING VALVE IN 114 WASH EQUIPMENT ROOM AS REQUIRED.
- PROVIDE 3/8" COPPER WATER LINE TO REFRIGERATOR WITH SHUT-OFF AS REQUIRED FOR THE REFRIGERATOR'S ICE MAKER. SHUT-OFF TO BE INSIDE WALL COVERED BY KARP BRAND 8" x 8" HAND-ACCESS PLASTIC ACCESS PANEL. WATER LINE TO BE THROUGH FINISHED WALL WITH CHROME ESCUTCHEON.
- CONTRACTOR TO PROVIDE CAST IRON VENT PIPING IN PLENUM AS REQUIRED BY CODE. SECURE AS REQUIRED.

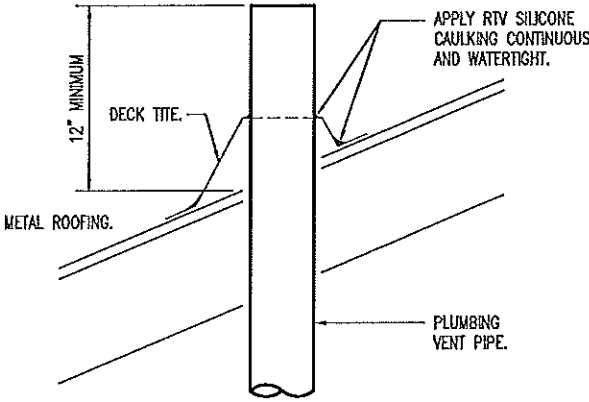


VENT THROUGH ROOF DETAIL
SCALE: NONE

LEGEND


HOT WATER	— H —
WATER	— W —
GAS	— G —
SANITARY SEWER	— SAN —
STORM SEWER	— S —
COMPRESSED AIR	— A —
CLEANOUT	— C.O. —
FLOOR DRAIN	— F.D. —
HOSE BIBB	— HB —
BALL VALVE	— B —
GAS VALVE	— G —

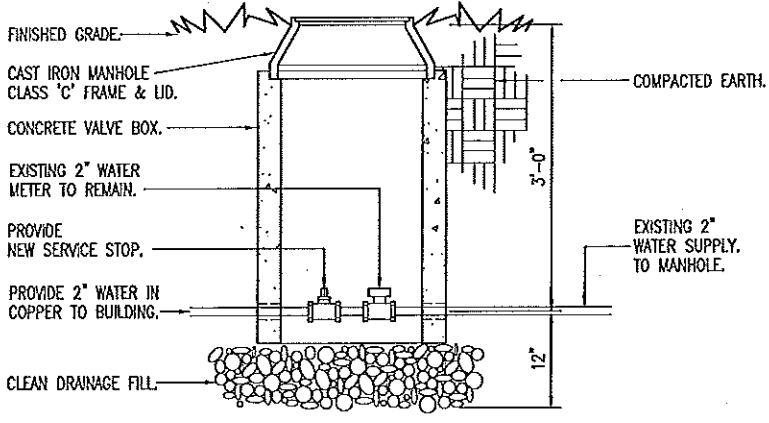


A
27
WATER VALVE & DRAIN
SCALE: NONE

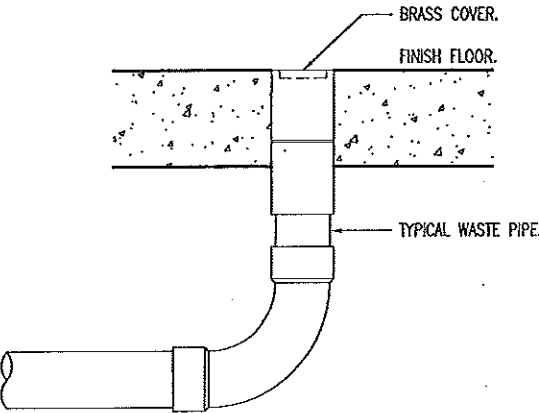

FLOOR CLEANOUT DETAIL
SCALE: NONE

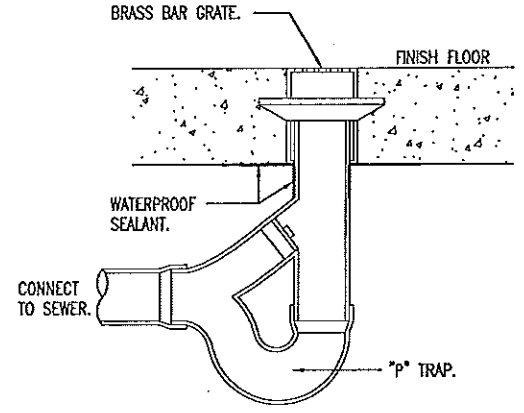

FLOOR DRAIN DETAIL
SCALE: NONE

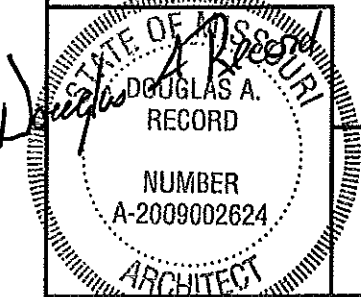


PLUMBING NOTES & SCHEDULES

MISSOURI DEPARTMENT
OF TRANSPORTATION
DIVISION OF GENERAL SERVICES
FACILITIES MANAGEMENT

STANDARD MAINTENANCE BUILDING


DRAWN BY: LARRY CARYER
CHECKED BY: DOUG RECORD
DATE: 6-11-14
Sheet
27 of 38

6/11/14

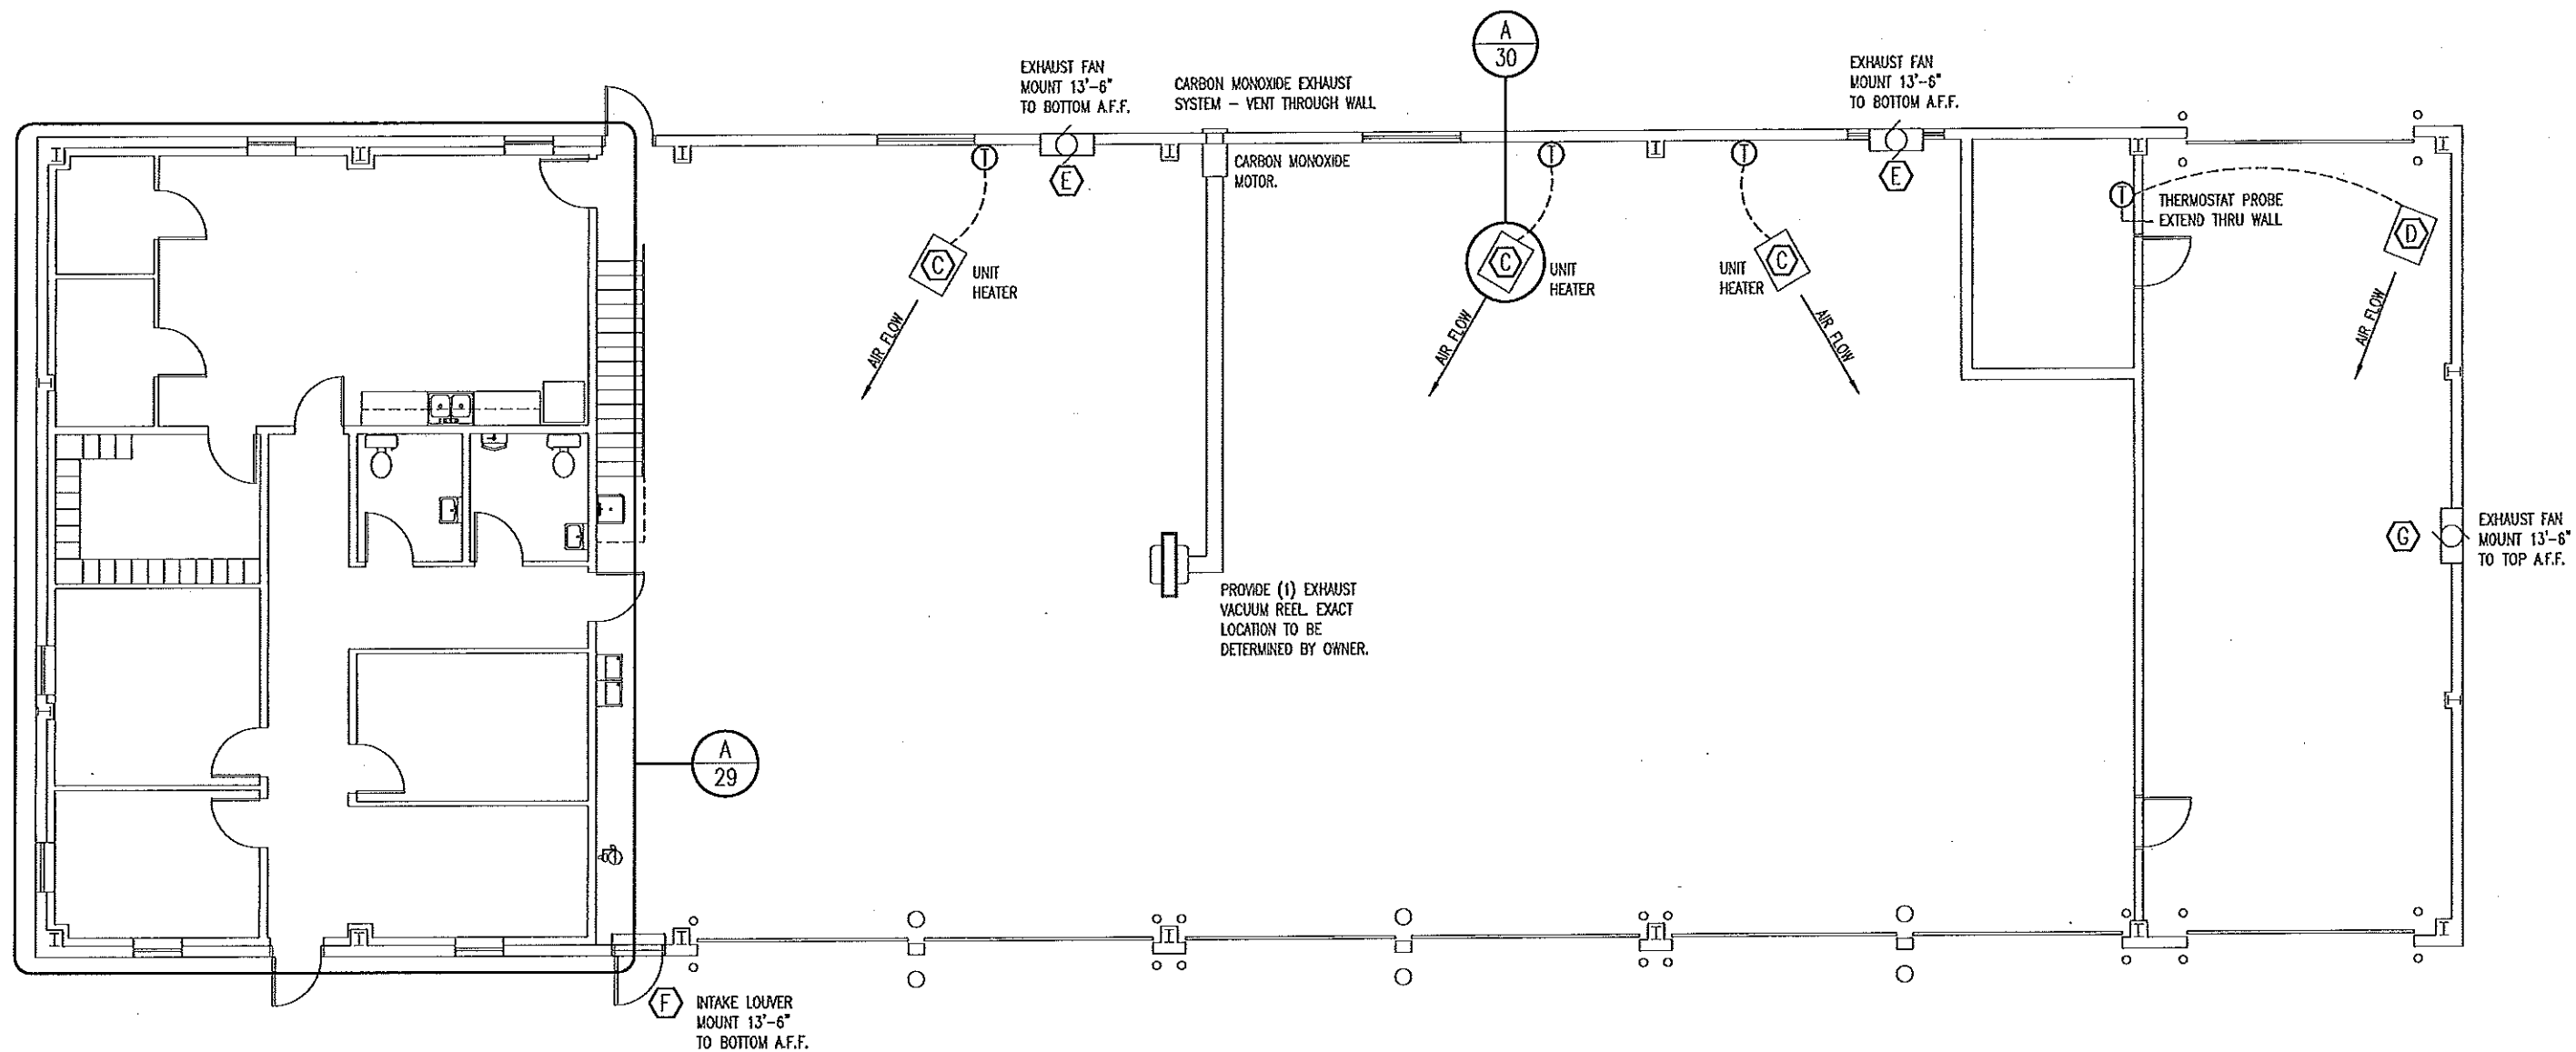

A
28
MECHANICAL PLAN
SCALE: 3/32" = 1'-0"

SEE HVAC SCHEDULE SHEET 30.

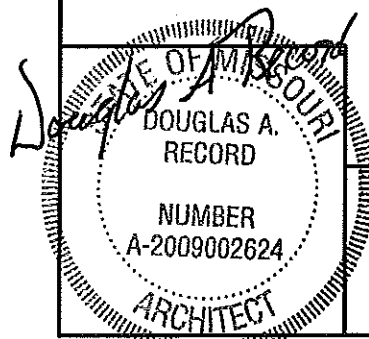


6/11/14

MECHANICAL PLAN

MISSOURI DEPARTMENT
OF TRANSPORTATION
DIVISION OF GENERAL SERVICES
FACILITIES MANAGEMENT


STANDARD MAINTENANCE BUILDING

DRAWN BY: LARRY CARVER
CHECKED BY: DOUG RECORD
DATE: 6-11-14
Sheet
28 of 38

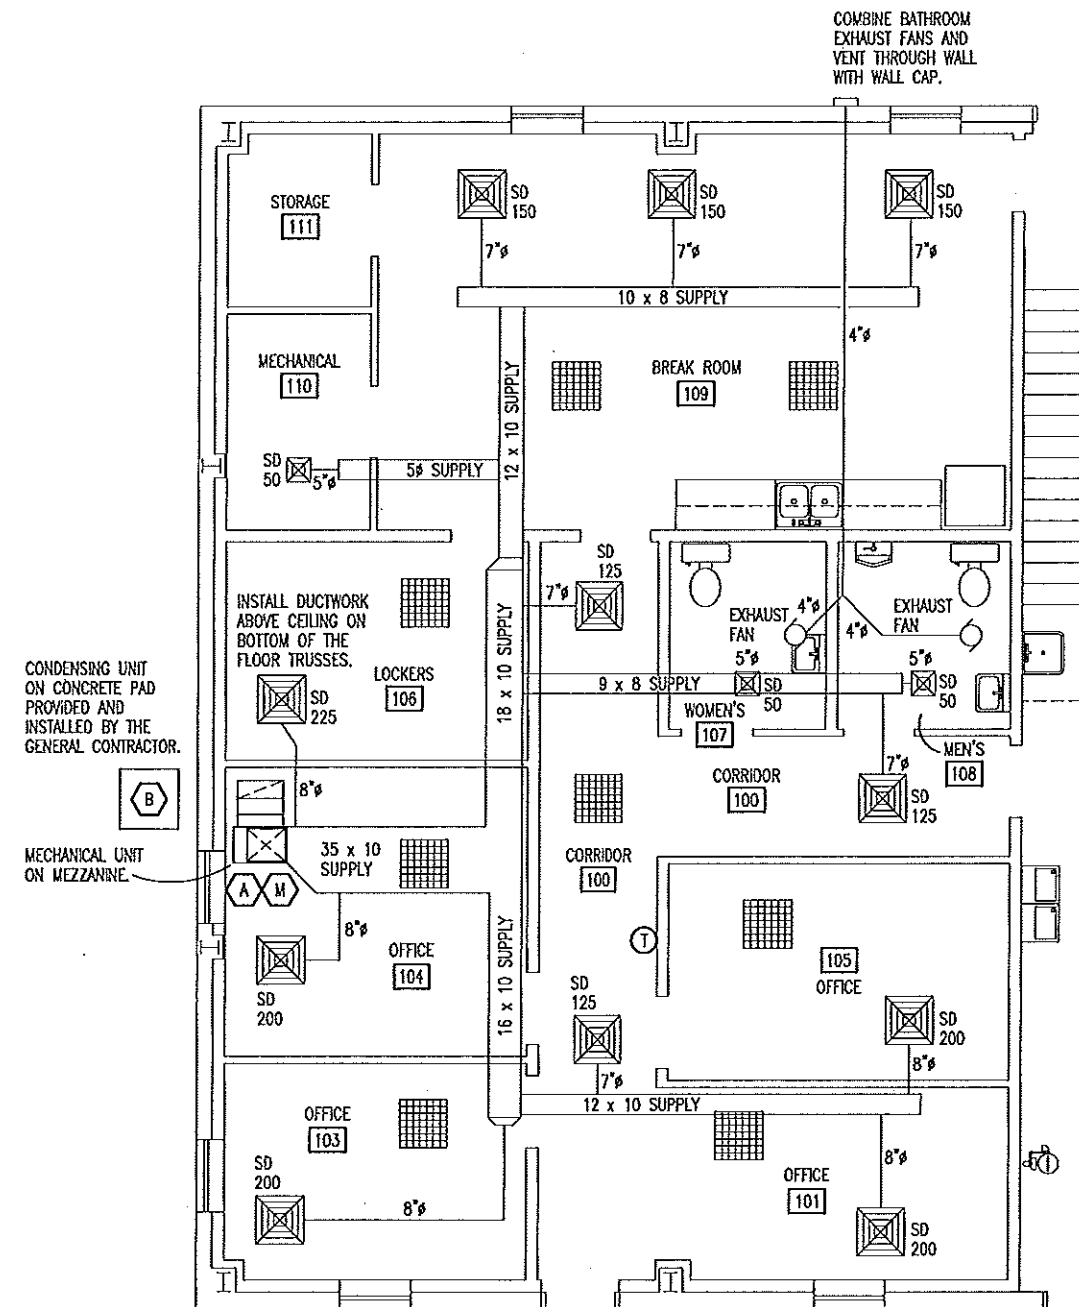

A
29 OFFICE MECHANICAL PLAN
SCALE: 1/8" = 1'-0"

SEE HVAC SCHEDULE SHEET 30.

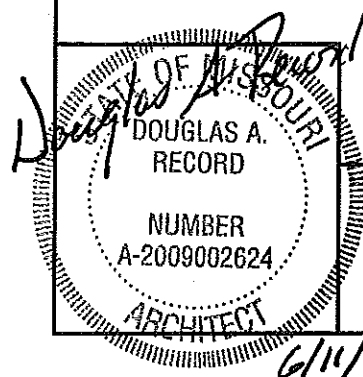


OFFICE MECHANICAL PLAN

MISSOURI DEPARTMENT
OF TRANSPORTATION
DIVISION OF GENERAL SERVICES
FACILITIES MANAGEMENT

STANDARD MAINTENANCE BUILDING

DRAWN BY: LARRY CARYER
CHECKED BY: DOUG RECORD
DATE: 6-11-14
Sheet
29 of 38

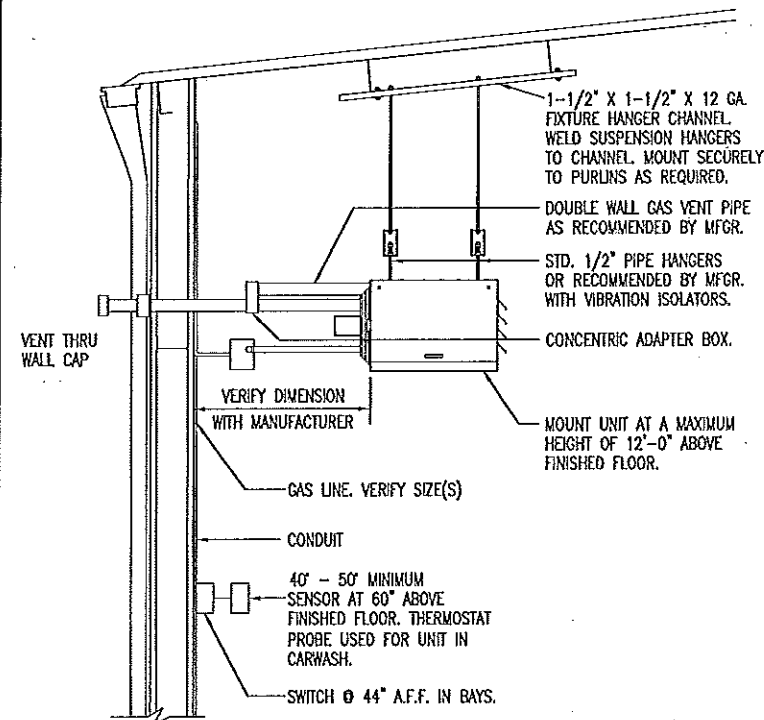

A UNIT HEATER INSTALLATION

30 NOT TO SCALE

MECHANICAL NOTES


- DRAWINGS AND DIAGRAMS ARE DIAGRAMMATIC AND SHALL NOT BE SCALED. REFER TO ARCHITECTURAL DRAWINGS FOR DIMENSIONS.
- MECHANICAL WORK SHALL BE INSTALLED IN STRICT COMPLIANCE WITH THE LATEST EDITION OF THE IBC MECHANICAL CODE.
- PROVIDE EQUIPMENT AND APPURTENANCES NOT NECESSARILY SHOWN OR SPECIFIED BUT NEEDED FOR COMPLETE AND PROPER INSTALLATION.
- ALL EQUIPMENT AND MATERIALS, IN PARTICULAR VALVES, FILTERS, MOTORS, AND CONTROLS SHALL BE ARRANGED TO PROVIDE PROPER CLEARANCE FOR SERVICE, MAINTENANCE AND INSPECTION.
- MECHANICAL SUBCONTRACTOR SHALL FULLY COORDINATE ALL WORK WITH PLUMBING AND ELECTRICAL WORKERS PRIOR TO COMMENCING OF THE MECHANICAL INSTALLATION.
- SEE REFLECTED CEILING PLAN FOR EXACT DIFFUSER LOCATIONS.
- PROVIDE BLOCKING TO HVAC DEVICES AS REQUIRED FOR A SECURE APPLICATION.
- THERMOSTAT CONTROL FOR 113 TRUCK WASH TO BE LOCATED IN 114 WASH EQUIPMENT ROOM WITH PROBE LOCATED AS SHOWN.

MECHANICAL SYMBOLS

- SD 175 CFM 24" x 24" SUPPLY DIFFUSER AND CFM.
- CEILING PLENUM RETURN AIR GRILLE.
- UNIT HEATER THERMOSTAT -- MOUNT @ 46" A.F.F.
- ROUND - DIMENSION SHOWN IS ID.

HVAC SCHEDULE						
SYM.	UNIT	MANUFACTURER	BTU OUTPUT	FUEL	VOLTAGE	REMARKS
A	GAS FURNACE/ FORCED AIR	CARRIER MODEL 59SC2120 OR EQUAL	120,000	GAS/ ELECTRIC	115	90+ AFUE, 2,000 CFM DOWN FLOW. COIL-CNPVP8024ACA 3" COMBINED TERMINATION KIT-KGVAT0601CVT
B	EVAPORATOR COIL	CARRIER MODEL CNPHP6024ACA 24ABC360	60,000	ELECTRIC	115 208	5 TON, 13 SEER, 1-PHASE CONDENSING UNIT.
C	GAS FIRED UNIT HEATER	REZNOR MODEL UDAP 75 OR EQUAL	63,000	NATURAL GAS	115	SINGLE BURNER COMBUSTION, DIRECT SPARK IGNITION, 100% LOCK-OUT & CL-1 STANDARD HEATING ONLY THERMOSTAT.
D	GAS FIRED UNIT HEATER	REZNOR MODEL UDAS 60 OR EQUAL	49,800	NATURAL GAS	115	409 STAINLESS STEEL HEAT EXCHANGERS, TOTALLY ENCLOSED FAN MOTOR, HORIZONTAL COMBUSTION AIR/VENT KIT INCLUDING CONCENTRIC ADAPTER.
E	36" x 36" SHUTTER MOUNT EXHAUST FAN W/WEATHERHOOD	DAYTON 1HLB6 & 1WBW2 OR EQUAL 6.4 AMPS	6,480 CFM	ELECTRIC	115	COMMERCIAL TYPE BELT DRIVE WALL EXHAUST FAN INCLUDING OSHA GUARD AND SHUTTER.
F	MOTORIZED DAMPER WITH WEATHERHOOD	DAYTON MODEL 3C728 & 1WBW1 OR EQUAL .37 AMPS	---	ELECTRIC	115	30" MEDIUM GRADE, MOTORIZED, GALVANIZED STEEL DAMPER WITH 1HP MOTOR. WIRE TO OPEN WHEN EXHAUST FAN IS TURNED ON.
G	16" DIA. CORROSION RESISTANT SHUTTER FAN	DAYTON 1BLJ1 OSHA GUARD OR EQUAL	2,005 CFM	ELECTRIC	115	FIBERGLASS SHUTTER & BLADES. 2.1 AMPS.
H	NOT USED					
I	NOT USED					
T	THERMOSTAT TP-PAC	CARRIER - EDGE OR EQUAL	---	---	---	7 DAY PROGRAMMABLE.
M	MANUALLY OPERATED DAMPER IN RETURN DUCT	---	---	---	---	2 - POSITION 5" Ø DUCT FOR EXTERNAL VENTILATION AIR. 125 CFM. PROVIDE ALUM. LOUVER WITH BUG SCREEN AS REQUIRED.

PROVIDE CONDENSATE TRAP AT ALL COILS AND PIPE TO NEAREST FLOOR DRAIN WITH 3/4" SCHEDULE 40 PVC. MECHANICAL EQUIPMENT IS SCHEDULED BY MANUFACTURER AND MODEL NUMBER FOR DESIGN INTENT ONLY, APPROVED EQUALS MAY BE SUBSTITUTED.

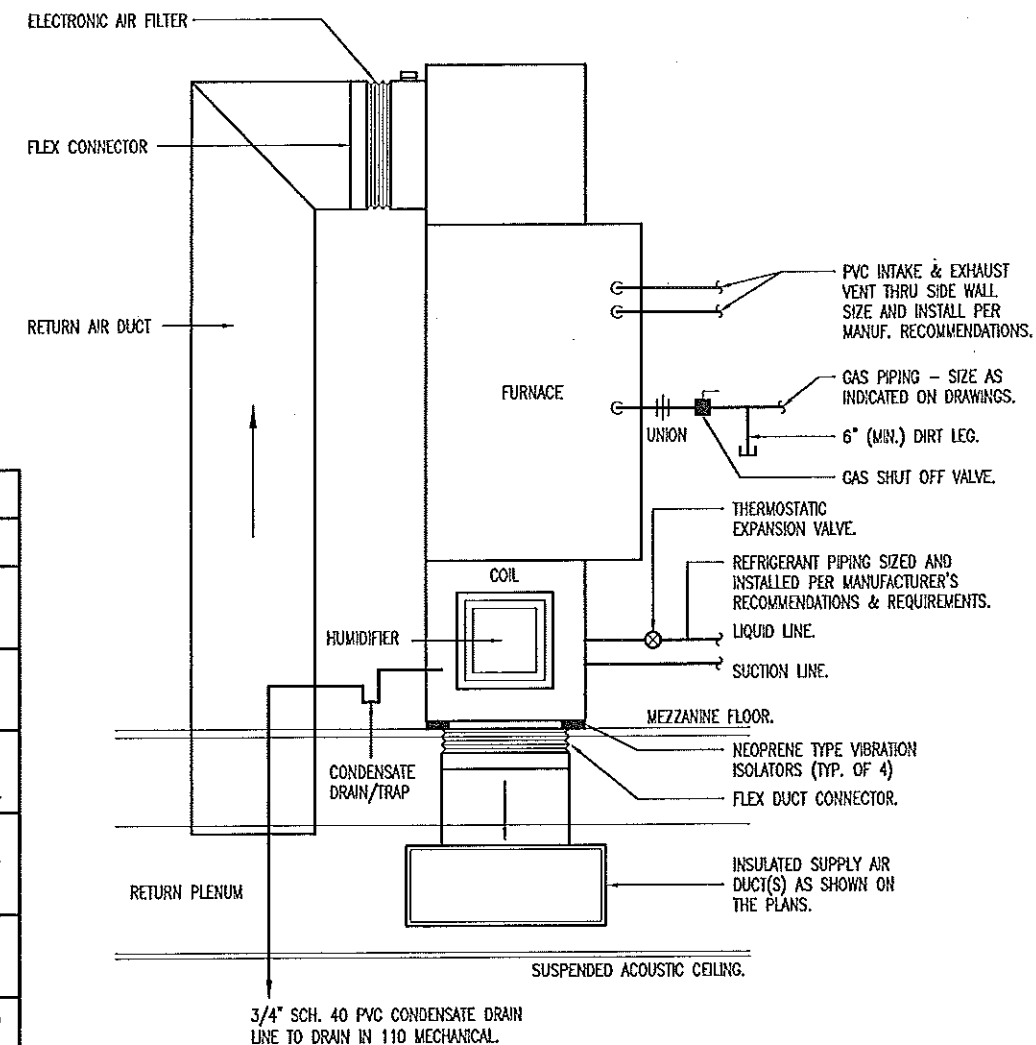

GAS FURNACE INSTALLATION


NOT TO SCALE.

MECHANICAL NOTES & SCHEDULES


MISSOURI DEPARTMENT
OF TRANSPORTATION
DIVISION OF GENERAL SERVICES
FACILITIES MANAGEMENT

STANDARD MAINTENANCE BUILDING

DRAWN BY: LARRY CARYER
CHECKED BY: DOUG RECORD
DATE: 6-11-14
Sheet
30 of 38

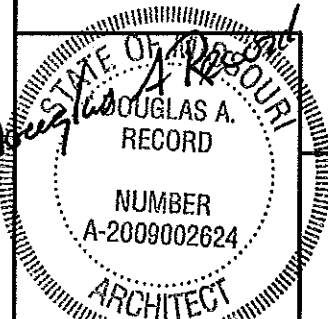


6/11/14

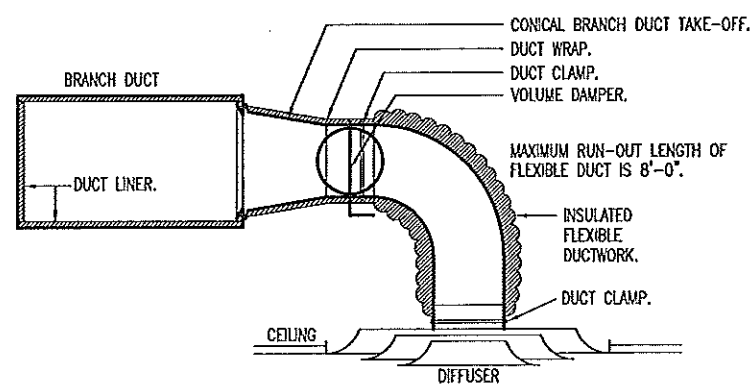

LAY-IN DIFFUSER MOUNTING

NOT TO SCALE

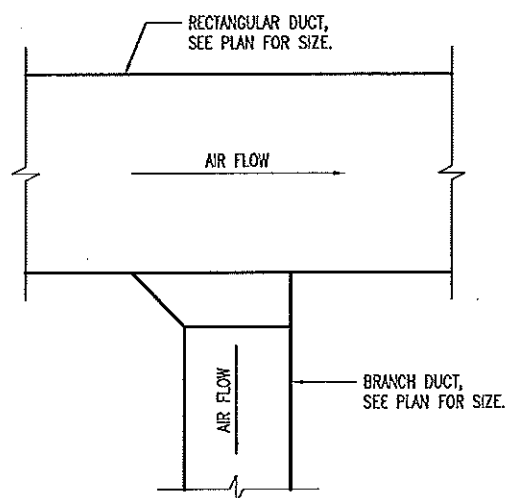


NOTES:

1. TAKEOFF ON SINGLE SIDE OR BOTH SIDES AS REQUIRED BY PLANS.
2. SEE SMACNA MANUAL FOR TAP-IN DETAILS.
3. CINCH LOCK CONNECTION TO DUCT SHALL HAVE CORNER SEALS.

BRANCH DUCT TAKE-OFF

NOT TO SCALE

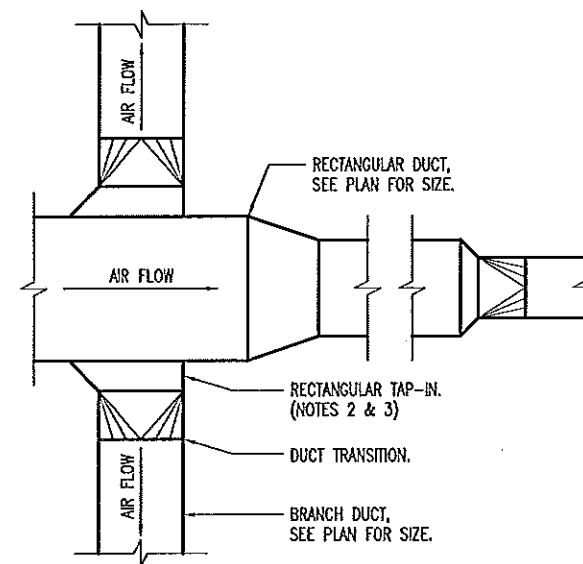

NOTES:


1. TAKEOFF ON SINGLE SIDE OR BOTH SIDES AS REQUIRED BY PLANS.
2. CINCH LOCK CONNECTION TO DUCT SHALL HAVE CORNER SEALS.
3. EXTRACTORS, SCOOPS, OR DEFLECTORS THAT PROTRUDE INTO MAIN DUCT SHALL NOT BE USED.

DIFFUSER TAKE-OFF

NOT TO SCALE

A
31

MECHANICAL DETAILS

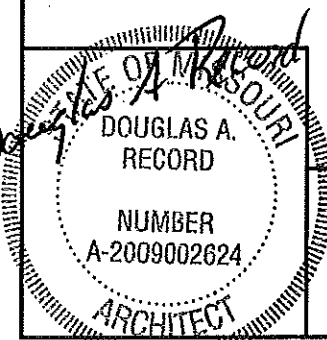


MECHANICAL DETAILS

MISSOURI DEPARTMENT
OF TRANSPORTATION
DIVISION OF GENERAL SERVICES
FACILITIES MANAGEMENT


STANDARD MAINTENANCE BUILDING

DRAWN BY: LARRY CARVER
CHECKED BY: DOUG RECORD
DATE: 6-11-14
Sheet
31 of 38

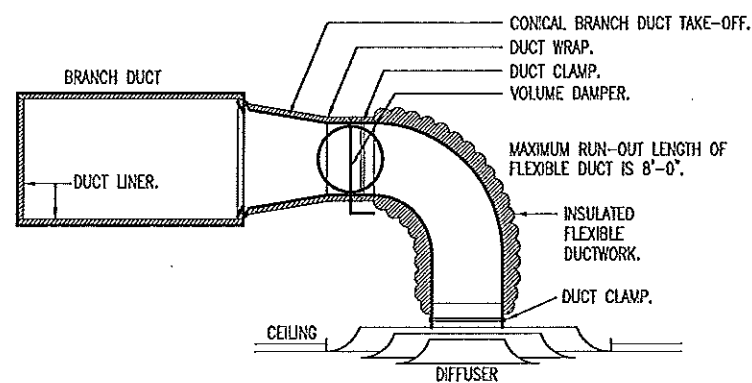

LAY-IN DIFFUSER MOUNTING

NOT TO SCALE

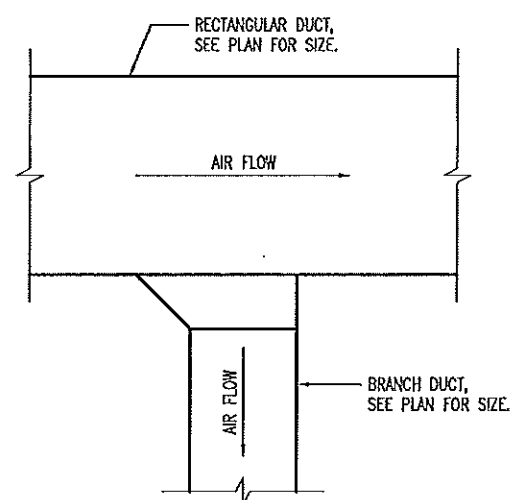


NOTES:

1. TAKEOFF ON SINGLE SIDE OR BOTH SIDES AS REQUIRED BY PLANS.
2. SEE SMACNA MANUAL FOR TAP-IN DETAILS.
3. CINCH LOCK CONNECTION TO DUCT SHALL HAVE CORNER SEALS.

BRANCH DUCT TAKE-OFF

NOT TO SCALE

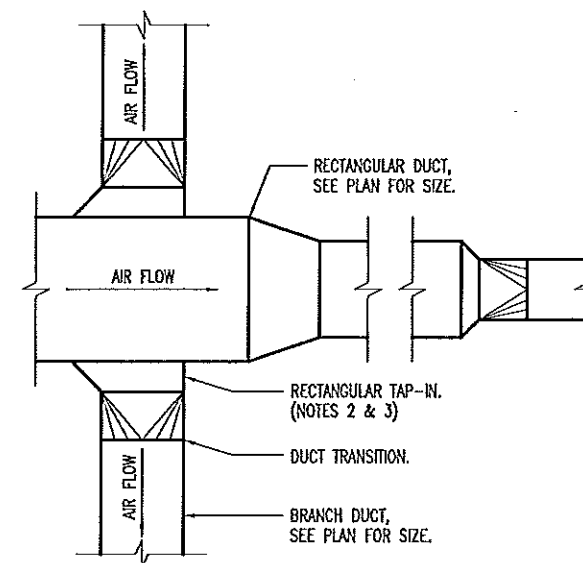


NOTES:

1. TAKEOFF ON SINGLE SIDE OR BOTH SIDES AS REQUIRED BY PLANS.
2. CINCH LOCK CONNECTION TO DUCT SHALL HAVE CORNER SEALS.
3. EXTRACTORS, SCOOPS, OR DEFLECTORS THAT PROTRUDE INTO MAIN DUCT SHALL NOT BE USED.

DIFFUSER TAKE-OFF

NOT TO SCALE

A MECHANICAL DETAILS

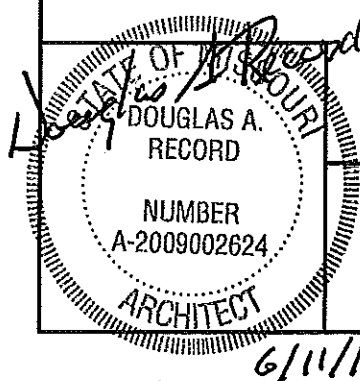


MECHANICAL DETAILS

MISSOURI DEPARTMENT
OF TRANSPORTATION
DIVISION OF GENERAL SERVICES
FACILITIES MANAGEMENT


STANDARD MAINTENANCE BUILDING

DRAWN BY: LARRY CARVER
CHECKED BY: DOUG RECORD
DATE: 6-11-14
Sheet
31 of 38

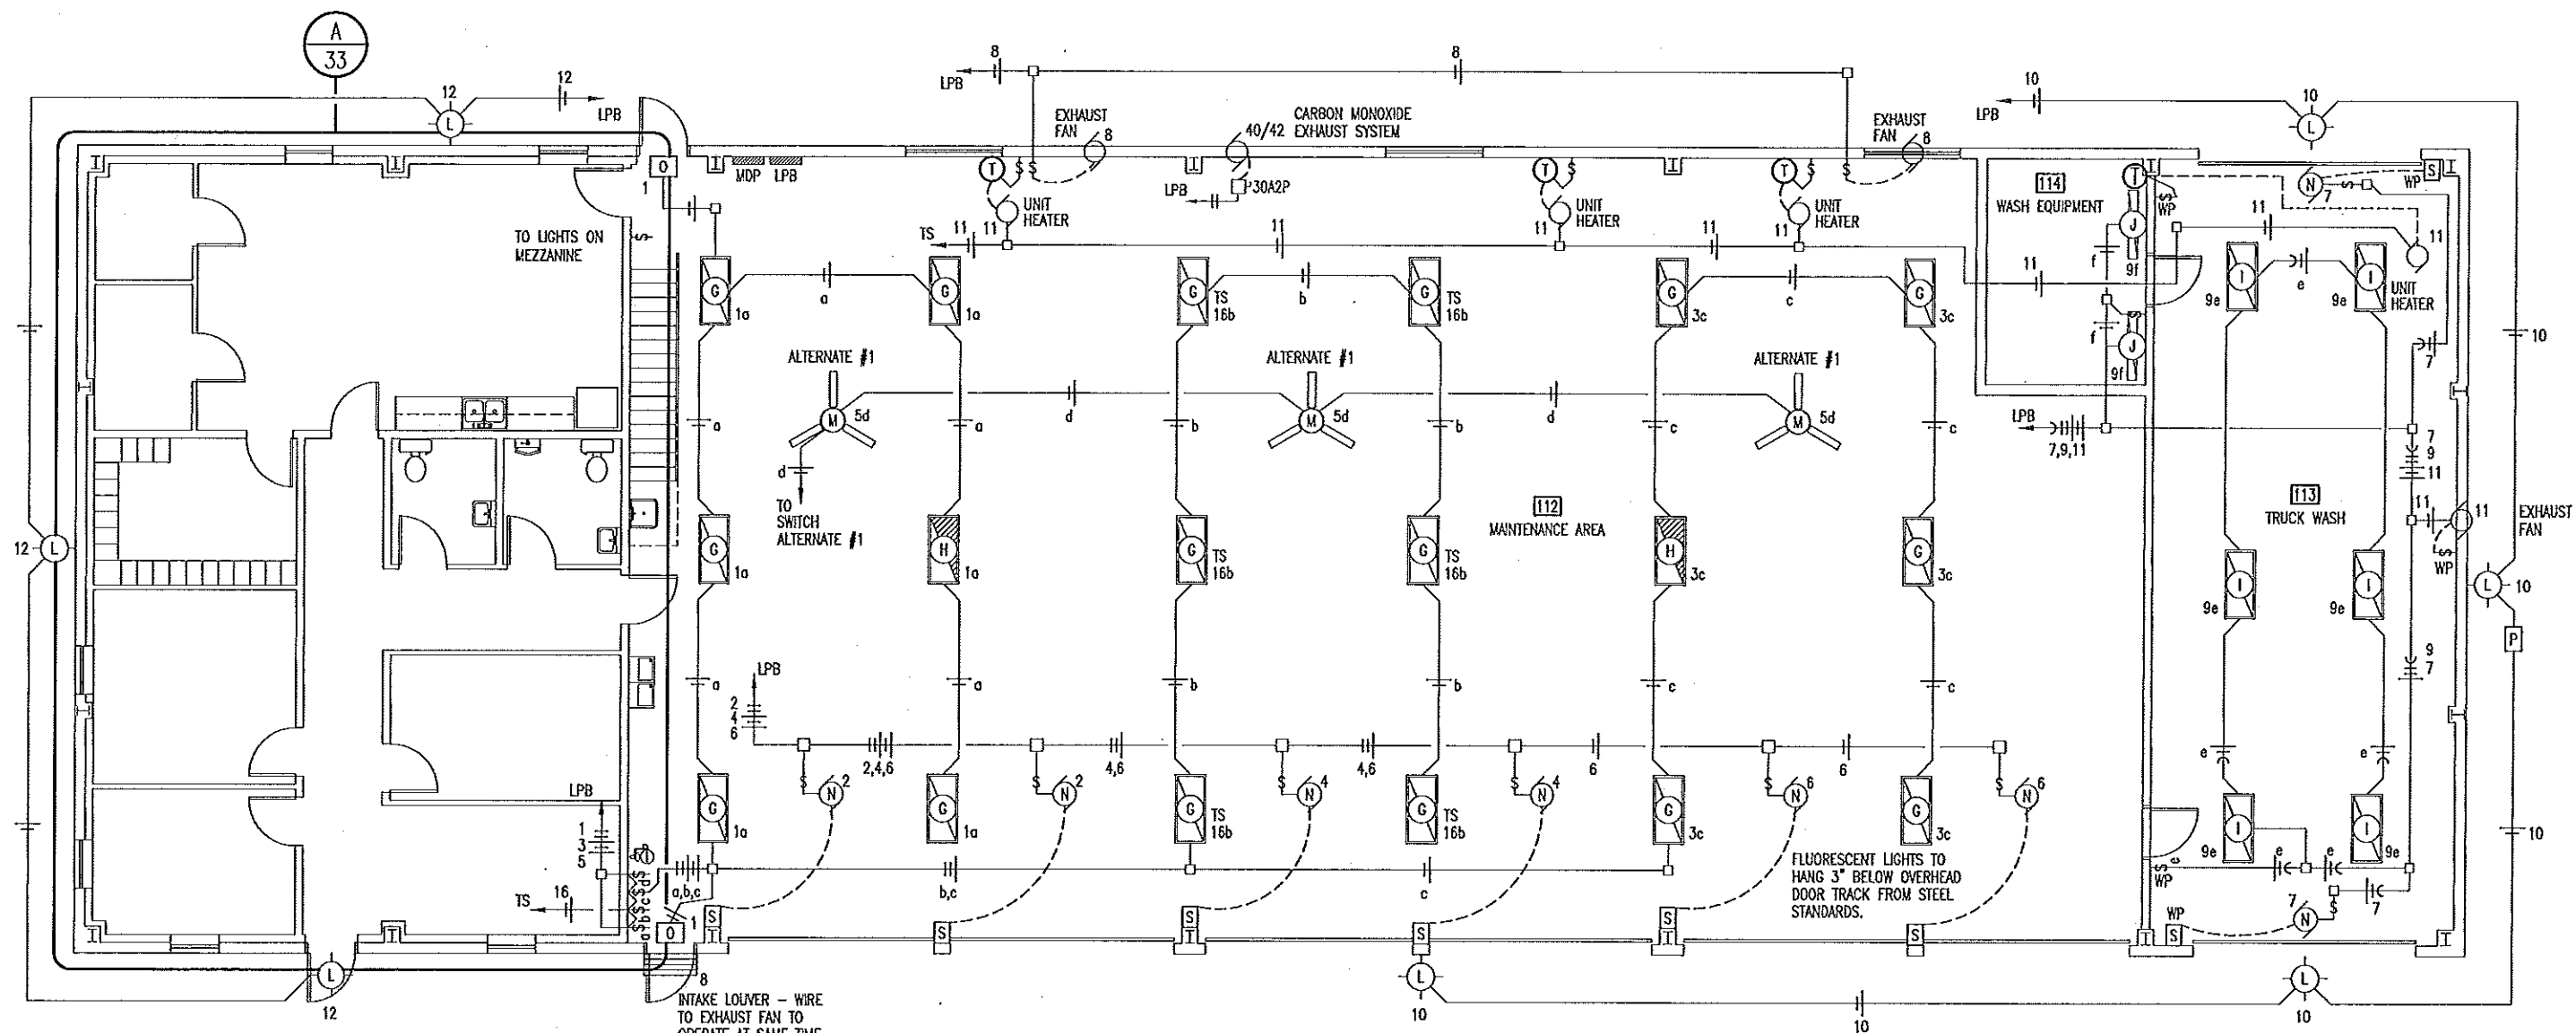

SEE ELECTRICAL SCHEDULE
SHEET 37.

A
32 ELECTRICAL LIGHTING PLAN
SCALE: 3/32" = 1'-0"

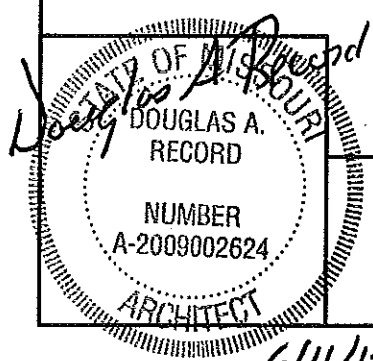


ELECTRICAL LIGHTING PLAN

MISSOURI DEPARTMENT
OF TRANSPORTATION
DIVISION OF GENERAL SERVICES
FACILITIES MANAGEMENT


STANDARD MAINTENANCE BUILDING

DRAWN BY: LARRY CARVER
CHECKED BY: DOUG RECORD
DATE: 6-11-14
Sheet
32 of 38

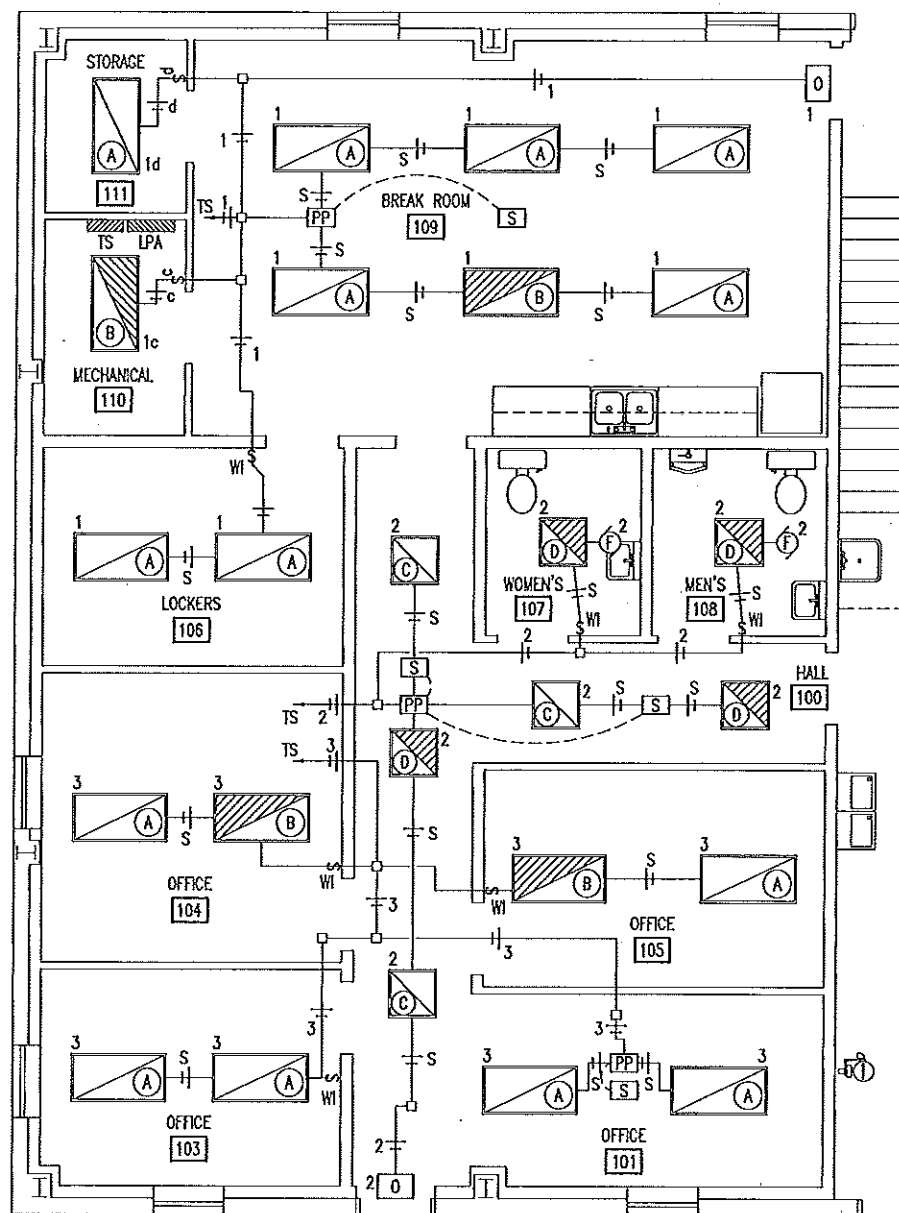

SEE ELECTRICAL SCHEDULE
SHEET 37.

A
33
OFFICE LIGHTING PLAN
SCALE: 1/8" = 1'-0"

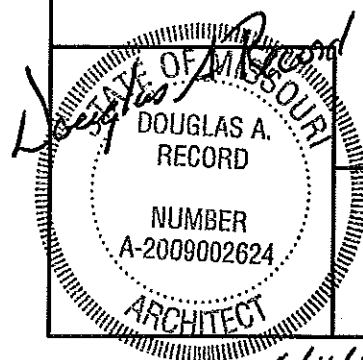


6/11/14

OFFICE LIGHTING PLAN


MISSOURI DEPARTMENT
OF TRANSPORTATION
DIVISION OF GENERAL SERVICES
FACILITIES MANAGEMENT

STANDARD MAINTENANCE BUILDING

DRAWN BY: LARRY CARVER
CHECKED BY: DOUG RECORD
DATE: 6-11-14
Sheet
33 of 38

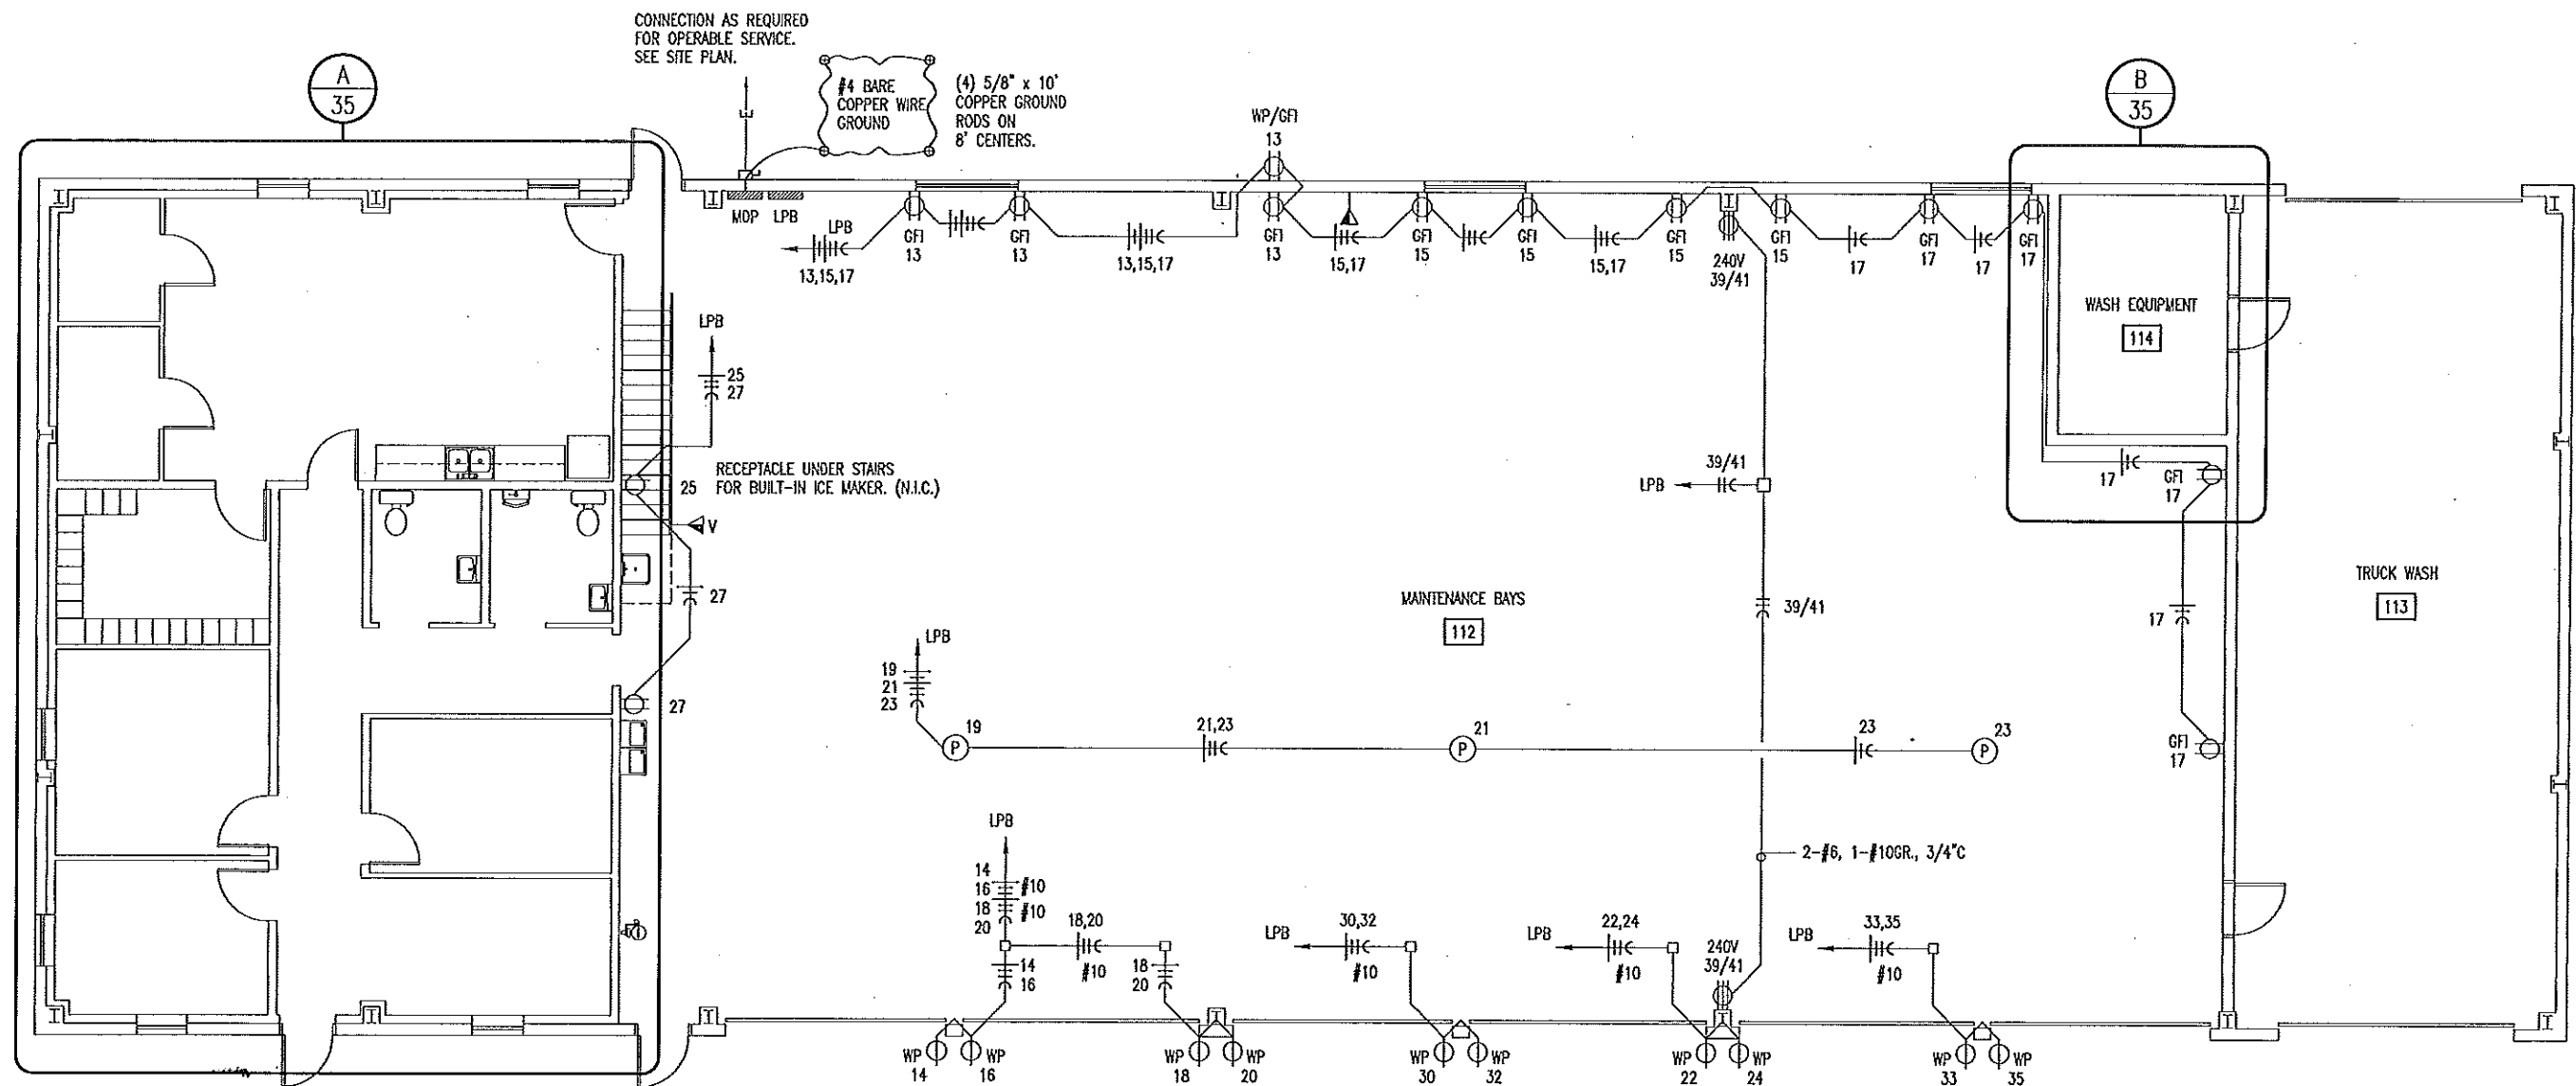

A
34 **ELECTRICAL POWER PLAN**
SCALE: 3/32" = 1'-0"

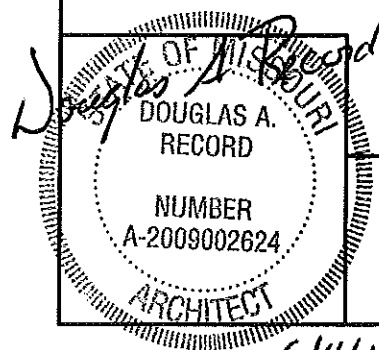


ELECTRICAL POWER PLAN


MISSOURI DEPARTMENT
OF TRANSPORTATION
DIVISION OF GENERAL SERVICES
FACILITIES MANAGEMENT

STANDARD MAINTENANCE BUILDING

DRAWN BY: LARRY CARVER
CHECKED BY: DOUG RECORD
DATE: 6-11-14
Sheet
34 of 38

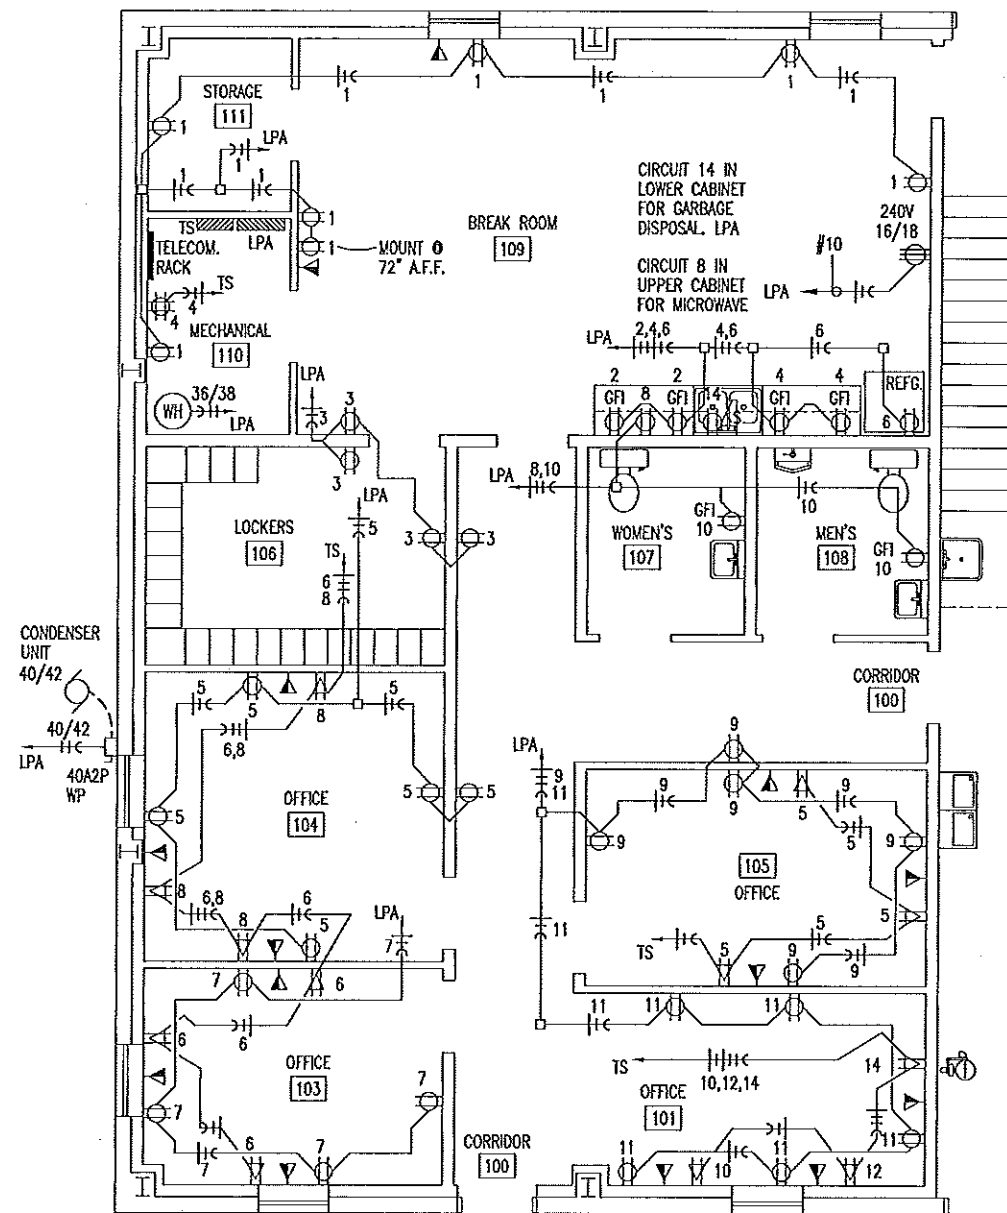


A
35
OFFICE POWER PLAN
SCALE: 1/8" = 1'-0"

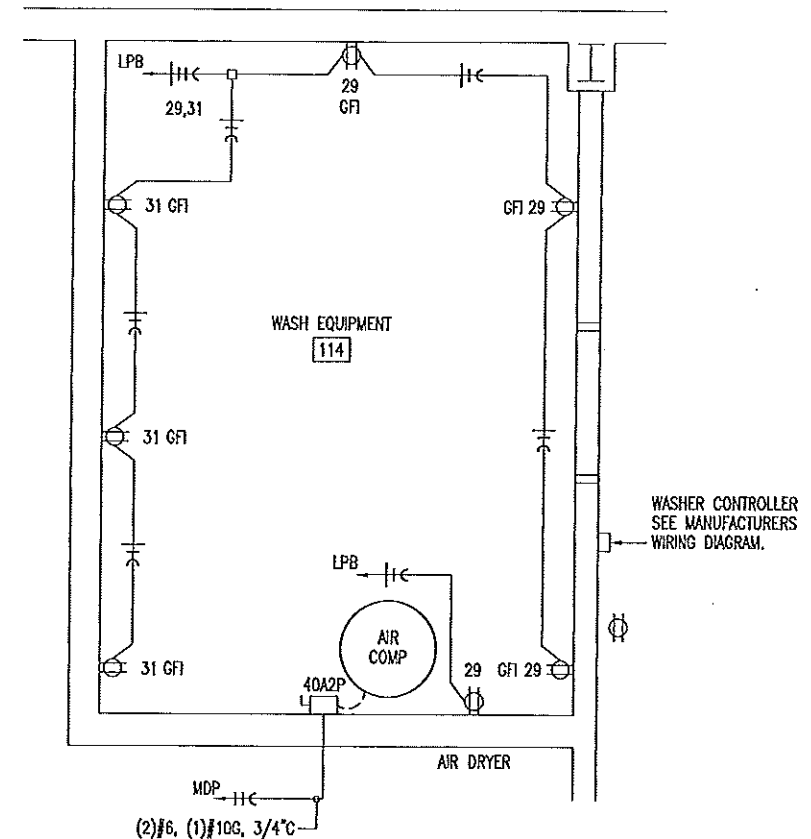

B
35
WASH EQUIPMENT POWER PLAN
SCALE: 1/4" = 1'-0"

SEE ELECTRICAL SCHEDULE SHEET 37.

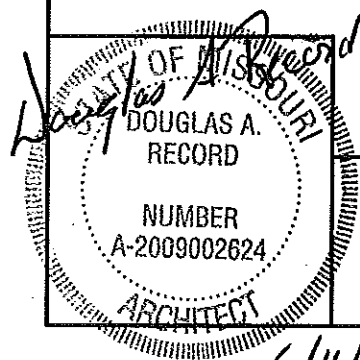


6/11/14

OFFICE POWER PLAN

MISSOURI DEPARTMENT
OF TRANSPORTATION
DIVISION OF GENERAL SERVICES
FACILITIES MANAGEMENT


STANDARD MAINTENANCE BUILDING

DRAWN BY: LARRY CARYER
CHECKED BY: DOUG REDORD
DATE: 6-11-14
Sheet
35 of 38

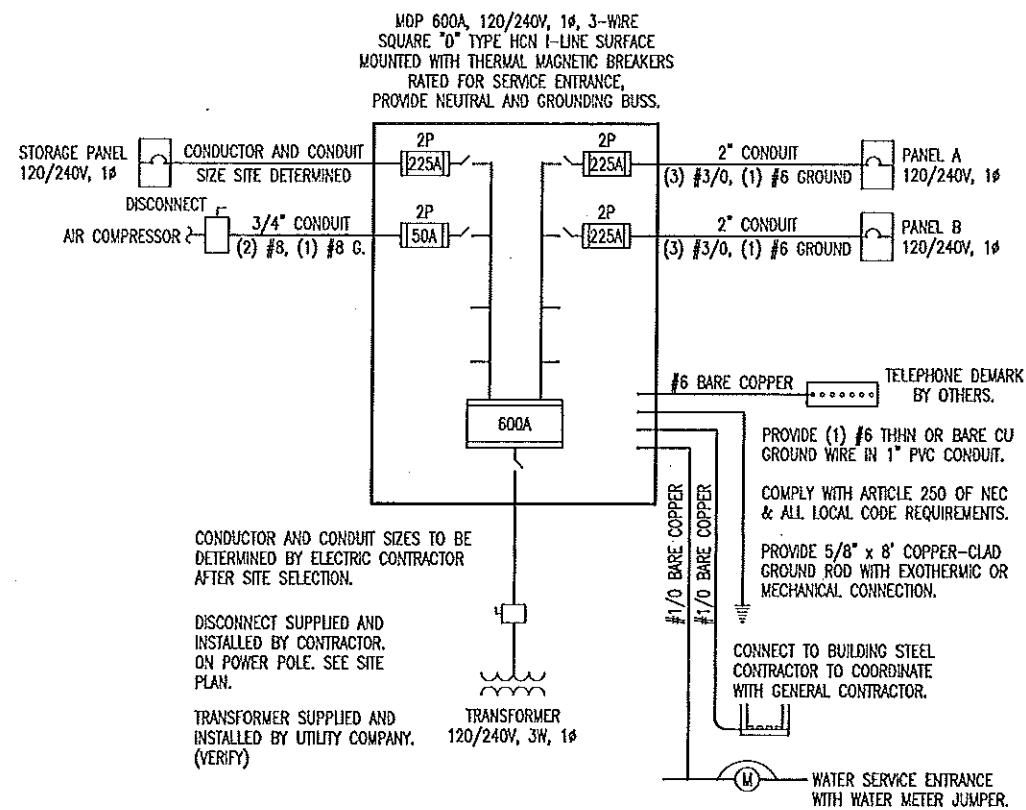

POWER DISTRIBUTION

MTS

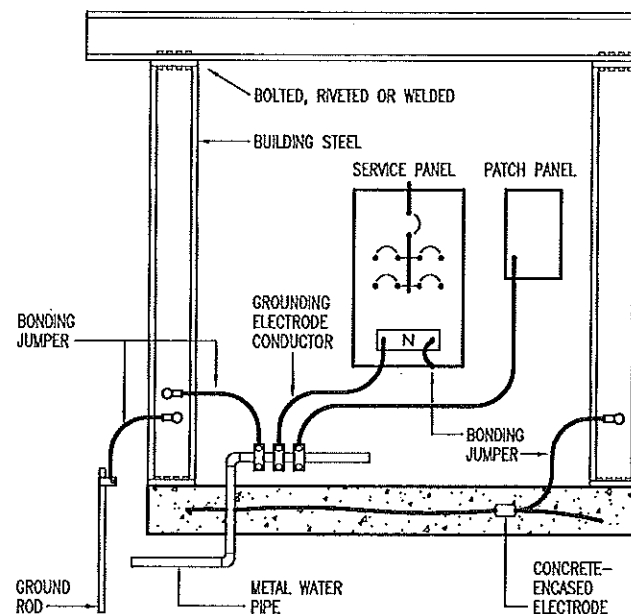

GROUNDING SYSTEM

SERVICE PANEL LPA											
MAIN BUS: 225A MLO VOLTS: 240/120, 1PH, 3-WIRE BUS MATERIAL: COPPER MOUNTING: SURFACE				SQUARE "D" NQOD OR EQUAL W/ NEUTRAL BUS & GROUNDING BUS CIRCUIT BREAKERS BOLT-IN 10000 AIC				CONNECTED LOAD A PHASE 20994 VA B PHASE 20030 VA TOTAL 41024 VA 171 A			
CIR	SERVICE	VA	BKR		BKR	VA	SERVICE				CIR
1	109, 110, 111 -- RECEPTACLES	1260	20A1P	A	20A1P	360	109 -- RECEPTACLES				2
3	100, 106, 109 -- RECEPTACLES	900	20A1P	B	20A1P	360	109 -- RECEPTACLES				4
5	100, 104 -- RECEPTACLES	900	20A1P	A	20A1P	600	109 -- REFRIGERATOR				6
7	103 -- RECEPTACLES	720	20A1P	B	20A1P	800	109 -- MICROWAVE				8
9	100, 105 -- RECEPTACLES	900	20A1P	A	20A1P	360	107, 108 -- GFI RECEPTACLES				10
11	100, 101 -- RECEPTACLES	720	20A1P	B	20A1P	960	EXTERIOR-FUEL ISLAND LIGHTS				12
13	SPARE		20A1P	A	20A1P	972	GARBAGE DISPOSAL				14
15	MEZZANINE LIGHTS	828	20A1P	B	30A2P	2250	RANGE				16
17	MEZZANINE RECEPTACLES	900	20A1P	A		2250					18
19	SPARE		20A1P	B	20A1P		SPARE				20
21				A							22
23				B							24
25				A							26
27				B							28
29				A							30
31				B							32
33				A							34
35				B	30A2P	2600	110 -- WATER HEATER				36
37				A		2600					38
39	110 -- EMERGENCY PANEL & TRANSFER SWITCH	7500	100A 2P	B	30A2P	2392	EXTERIOR -- CONDENSER UNIT				40
41		7500		A		2392					42


EMERGENCY PANEL

TRANSFER SWITCH EQUAL TO GEN/TRAN MODEL 501210 16 CIRCUIT, 15000 WATT											
								CONNECTED LOAD A PH. 6509VA B PH. 6172VA TOTAL 12681VA			
1	SERVICE	VA	BKR		BKR	VA	SERVICE				2
3	106, 109, 110, 111 -- LIGHTS	1128	20A1P	A	20A1P	828	100, 107, 108 -- LIGHTS/FANS				4
5	101, 102, 103, 104, 105 -- LIGHTS	928	20A1P	B	20A1P	360	110 -- TELECOMMUNICATIONS				6
7	105 -- DEDICATED POWER	540	20A1P	A	20A1P	540	103 -- DEDICATED POWER				8
9	SPARE		20A1P	B	20A1P	540	104 -- DEDICATED POWER				10
11	200 -- AHU	1277	20A1P	A	20A1P	1320	101 -- FAX MACHINE				12
13	112, 113 -- UNIT HEATERS	1584	20A1P	B	20A1P	1320	101 -- FAX MACHINE				14
15	EXTERIOR -- FUEL PUMPS	696	20A1P	A	20A1P	180	101 -- DEDICATED POWER				16
	SPARE		20A1P	B	20A1P	1440	112 -- LIGHTS				

SERVICE PANEL LPB

MAIN BUS: 400A MLO VOLTS: 240/120, 1PH, 3-WIRE BUS MATERIAL: COPPER MOUNTING: SURFACE				SQUARE "D" NQOD OR EQUAL W/ NEUTRAL BUS & GROUNDING BUS CIRCUIT BREAKERS BOLT-IN 10000 AIC				CONNECTED LOAD A PHASE 21571 VA B PHASE 20818 VA TOTAL 42389 VA 177 A			
CIR	SERVICE	VA	BKR		BKR	VA	SERVICE				CIR
1	112 -- LIGHTS	1440	30A1P	A	30A1P	2162	112 -- OHD OPENERS				2
3	112 -- LIGHTS	1440	20A1P	B	30A1P	2162	112 -- OHD OPENERS				4
5	112 -- CEILING FANS	468	30A1P	A	30A1P	2162	112 -- OHD OPENERS				6
7	113 -- OHD OPENERS	2162	30A1P	B	20A1P	1199	112 -- EXHAUST FAN/LOUVER				8
9	112, 113, 114 -- LIGHTS	920	20A1P	A	20A1P	868	EXTERIOR -- LIGHTS				10
11	113 -- EXHAUST FAN	1176	20A1P	B	20A1P	651	EXTERIOR -- LIGHTS				12
13	112, EXT -- RECEPTACLE	720	20A1P	A	30A1P	1000	EXTERIOR -- RECEPTACLE				14
15	112 -- RECEPTACLE	720	20A1P	B	30A1P	1000	EXTERIOR -- RECEPTACLE				16
17	112 -- RECEPTACLE	720	20A1P	A	30A1P	1000	EXTERIOR -- RECEPTACLE				18
19	112 -- DROP CORDS	180	20A1P	B	30A1P	1000	EXTERIOR -- RECEPTACLE				20
21	112 -- DROP CORDS	180	20A1P	A	30A1P	1000	EXTERIOR -- RECEPTACLE				22
23	112 -- DROP CORDS	180	20A1P	B	30A1P	1000	EXTERIOR -- RECEPTACLE				24
25	112 -- ICE MACHINE	800	20A1P	A	20A1P	483	COMPRESSOR DRYER				26
27	112 -- DRINKING FOUNTAIN	480	20A1P	B	20A1P		SPARE				28
29	114 -- RECEPTACLE	720	20A1P	A	20A1P	1000	EXTERIOR -- RECEPTACLE				30
31	114 -- RECEPTACLE	540	20A1P	B	20A1P	1000	EXTERIOR -- RECEPTACLE				32
33	EXTERIOR -- RECEPTACLE	1000	30A1P	A	20A1P		SPARE				34
35	EXTERIOR -- RECEPTACLE	1000	30A1P	B	20A1P		SPARE				36
37				A							38
39	100 -- WELDER OUTLET	4100	50A2P	B	20A2P	828	113 -- CARBON MONOXIDE				40
41		4100		A		828					42

⊗ CIRCUIT BREAKER SHALL BE GFI RATED

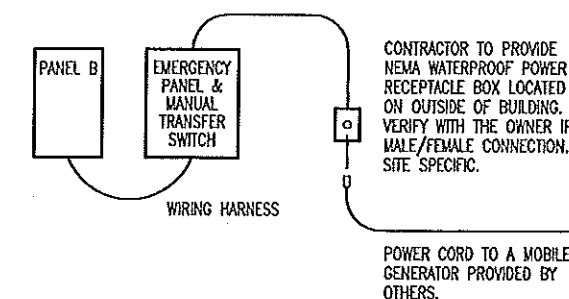

TRANSFER SWITCH INSTALLATION

POWER DISTRIBUTION PANELS


MISSOURI DEPARTMENT OF TRANSPORTATION


DIVISION OF GENERAL SERVICES
FACILITIES MANAGEMENT

STANDARD MAINTENANCE BUILDING

DRAWN BY: LARRY CARVER
CHECKED BY: DOUG RECORD
DATE: 6-11-14

Sheet
36 of 38

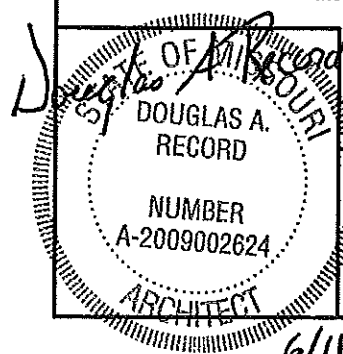

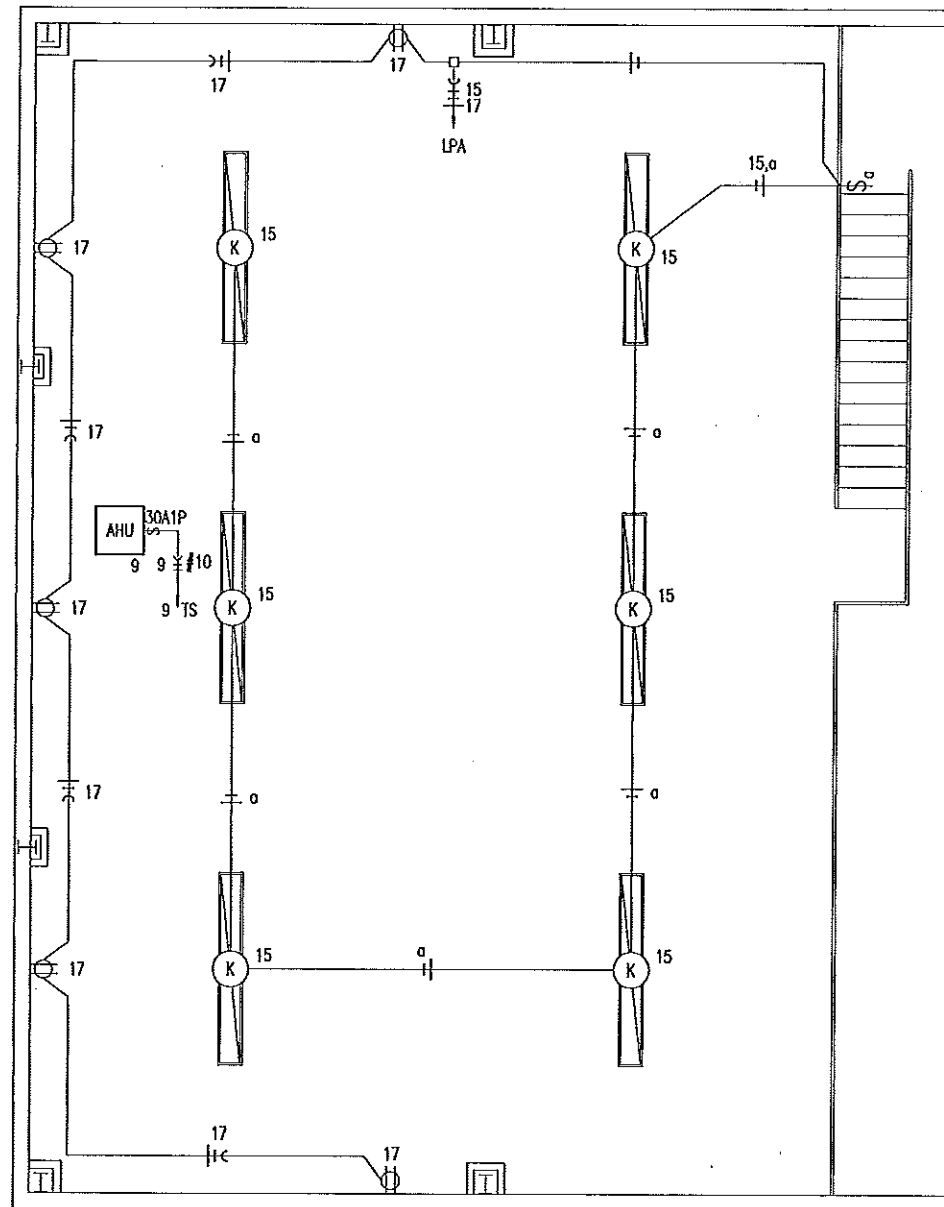

A
37 MEZZANINE ELECTRICAL PLAN
SCALE: 1/8" = 1'-0"

ELECTRIC SCHEDULE					
MANUF.	MODEL	#	LAMPS TYPE W	MNT	REMARKS
WILLIAMS	50G-S24-328-T5S- RPC12125-EB3-UNV	3	FLUORESCENT 28	CLG	24" x 48" STATIC TROFFER FIXTURE, WITH FULL DOOR FRAME, NO REVEAL, WHITE ALUMINUM, AND ELECTRONIC BALLAST.
WILLIAMS	50G-S24-328-T5S- RPC12125-EM/700-EB3- UNV	3	FLUORESCENT 28	CLG	24" x 48" STATIC TROFFER FIXTURE, WITH FULL DOOR FRAME, NO REVEAL, WHITE ALUMINUM, ELECTRONIC BALLAST, EMERGENCY BATTERY PACK.
WILLIAMS	50G-S22-314-T5S- RPC12125-EB2/1-UNV	3	FLUORESCENT 14	CLG	24" x 24" STATIC TROFFER FIXTURE, WITH FULL DOOR FRAME, NO REVEAL, WHITE ALUMINUM, AND ELECTRONIC BALLAST.
WILLIAMS	50G-S22-414-T5S- RPC12125-EM Back Mount EMLP6-EM2/2-UNV	4	FLUORESCENT 14	CLG	24" x 24" STATIC TROFFER FIXTURE, WITH FULL DOOR FRAME, NO REVEAL, WHITE ALUMINUM, ELECTRONIC BALLAST, EMERGENCY BATTERY PACK.
	NOT USED.				
BROAN	BROAN VENTILATOR GRABBER #4C376 OR EQUAL			CLG	VENTED THROUGH WALL AS SHOWN ON THE ELEVATIONS REQUIRED. STEEL SHUTTER TO BE WEATHER STRIPPED. 70 CFM.
WILLIAMS	GL-4-454T5H-HUB3/4* EB4-120	4	FLUORESCENT 54	CLG	14" x 48" LOW PROFILE FIXTURE, WITH WHITE ALUMINUM HOUSING, HIGH SPECULAR ALUMINUM REFLECTOR AND ELECTRONIC BALLAST.
WILLIAMS	GL-4-454T5H-HUB3/4* EM7-EB4-120	4	FLUORESCENT 54	CLG	14" x 48" FIXTURE, WITH WHITE ALUMINUM HOUSING, HIGH SPECULAR ALUMINUM REFLECTOR ELECTRONIC BALLAST AND EMERGENCY BATTERY.
WILLIAMS	GLS-4-454T5H-FCHA118- VBYS-EB4-UNV	4	FLUORESCENT 54	CLG	15" x 48" DAMP LOCATION, CHAIN SUSPENDED FIXTURE, WITH ALUMINUM HOUSING, CLEAR ACRYLIC LENS AND ELECTRONIC BALLAST.
LITHONIA	DMW 2 48HO ARDP 120 ES	2	FLUORESCENT 32	WALL	48" LONG SURFACE MOUNT FLUORESCENT LIGHT FIXTURE, WITH PAINTED STEEL HOUSING, AND ELECTRONIC BALLAST.
LITHONIA	T2UN 4 54T5HO 120 ES (2) WG2UN	4	FLUORESCENT 54	CLG	96" LONG SURFACE MOUNT FLUORESCENT LIGHT FIXTURE, WITH PAINTED STEEL HOUSING, ELECTRONIC BALLAST AND WIRE GUARD.
WILLIAMS	PGM-175H-128-2	1	METAL HALIDE 175	WALL	EXTERIOR, SURFACE MOUNT LIGHT FIXTURE, WITH ALUMINUM HOUSING AND IMPACT RESISTANT ONE-PIECE, WRAP-AROUND LENS.
DAYTON	4C853 ALTERNATE #1.			CLG	SINGLE-SPEED, THREE-BLADE, HEAVY DUTY COMMERCIAL CEILING FAN.
	OVERHEAD DOOR OPERATOR			WALL	230V, 1-PH, JACK SHAFT-TYPE COMMERCIAL OVERHEAD DOOR OPERATOR. SEE SPECIFICATION SECTION 08720.
INFINITY	EXIT-R-EM-WHT-PCI			WALL	EXIT LIGHT, SELF-CONTAINED, COMPACT, LOW PROFILE DESIGN, WHITE THERMOPLASTIC HOUSING, NI-CAD BATTERY PROVIDING 90 MINUTE OPERATION.
HOSE REEL				CLG	OWNER SUPPLIED AND CONTRACTOR INSTALLED.
	NOT USED.				
	OVERHEAD DOOR CONTROL			WALL	THREE BUTTON OVERHEAD DOOR CONTROL AS SUPPLIED BY OVERHEAD DOOR MANUFACTURER. SEE SPECIFICATION SECTION 08720.
TORK	2001			WALL	120V PHOTO ELECTRIC CONTROL OF EXTERIOR LIGHTS.

ELECTRICAL FIXTURES AND EQUIPMENT ARE SCHEDULED BY MANUFACTURER AND MODEL NUMBER FOR DESIGN INTENT ONLY, APPROVED EQUALS MAY BE SUBSTITUTED.

ELECTRICAL NOTES

- DRAWINGS AND DIAGRAMS ARE DIAGNAMATIC AND SHALL NOT BE SCALED. REFER TO ARCHITECTURAL DRAWINGS FOR DIMENSIONS.
- ELECTRICAL WORK SHALL BE INSTALLED IN STRICT COMPLIANCE WITH THE LATEST EDITION OF THE NATIONAL ELECTRIC CODE (N.E.C.).
- PROVIDE ELECTRICAL EQUIPMENT AND ACCESSORIES REQUIRED FOR A COMPLETE AND OPERATIONAL ELECTRICAL SYSTEM AS REQUIRED BY MANUFACTURER'S INSTRUCTIONS AND DIRECTIONS FOR SYSTEMS SPECIFIED.
- SWITCHES AND RECEPTACLES SHALL BE EQUAL TO THE AMPERE RATING SHOWN IN THE PANEL SCHEDULE. RECEPTACLES SHALL BE GROUND-FAULT INTERRUPTION TYPE WHERE SHOWN OR AS REQUIRED BY CODE.
- BATHROOM EXHAUST FANS ARE TO BE PROVIDED AND INSTALLED BY THE ELECTRICAL CONTRACTOR.
- SEE HVAC SCHEDULE FOR EQUIPMENT TO BE HARD WIRED, PROVIDE SERVICE DISCONNECT AT EACH.
- ALL RECEPTACLES IN GARAGE AREA TO BE MOUNTED AT 48" A.F.F.
- COORDINATE WORK WITH OTHER TRADES PRIOR TO COMMENCING WITH ELECTRICAL WORK.
- CONDUCTOR AND BREAKER SIZE MAY VARY PER MANUFACTURER ON THE EQUIPMENT SPECIFIED. ELECTRIC CONTRACTOR TO VERIFY SIZES WITH EXACT EQUIPMENT ORDERED PRIOR TO PURCHASING ELECTRICAL SUPPLIES.
- FIXTURE LOCATIONS ARE APPROXIMATE, EXACT LOCATIONS TO BE DETERMINED AFTER COLLABORATION WITH THE OWNER AND OTHER TRADES.
- CONTRACTOR SHALL PROVIDE SERVICE DISCONNECTS AS REQUIRED AT EXTERIOR OF BUILDING.
- PROVIDE BLOCKING FOR ELECTRICAL DEVICES AS REQUIRED FOR A SECURE APPLICATION.

LEGEND

- § SINGLE POLE SWITCH, FLUSH MOUNTED IN FINISHED AREAS @ 48" A.F.F.
SINGLE POLE SWITCH, SURFACE MOUNTED IN UNFINISHED AREAS @ 48" A.F.F.
- § 3 3-WAY SWITCH, FLUSH MOUNTED IN FINISHED AREAS @ 48" A.F.F.
3-WAY SWITCH, SURFACE MOUNTED IN UNFINISHED AREAS @ 48" A.F.F.
- § WP SINGLE POLE SWITCH, MOUNT IN FS BOX WITH HUBBELL HBL 7420 COVER.
- § QUAD-PLEX RECEPTACLE FLUSH MOUNTED IN FINISHED AREAS @ 42" A.F.F. TO BOTTOM OF OUTLET.
- § DUPLEX RECEPTACLE FLUSH MOUNTED IN FINISHED AREAS @ 18" A.F.F. TO BOTTOM OF OUTLET.
DUPLEX RECEPTACLE SURFACE MOUNTED IN UNFINISHED AREAS @ 42" A.F.F.
- § DEDICATED RECEPTACLE FLUSH MOUNTED IN FINISHED AREAS @ 18" A.F.F. TO BOTTOM OF OUTLET.
DEDICATED RECEPTACLE SURFACE MOUNTED IN UNFINISHED AREAS @ 42" A.F.F.
- § GFI DUPLEX RECEPTACLE WITH GROUND FAULT INTERRUPTER.
- § WP DUPLEX RECEPTACLE MOUNTED IN FS BOX WITH HUBBELL HBL5221 COVER.
- § SINGLE RECEPTACLE FLUSH MOUNTED IN FINISHED AREAS @ 18" A.F.F. TO BOTTOM OF OUTLET.
SINGLE RECEPTACLE SURFACE MOUNTED IN UNFINISHED AREAS @ 42" A.F.F.
- § WP SINGLE RECEPTACLE MOUNTED IN FS BOX WITH HUBBELL HBL7423 COVER.
- § 50A WELDER RECEPTACLE SURFACE MOUNTED 42" A.F.F., MOUNT IN 4" SQUARE BOX WITH RAISED COVER.
- § VOICE AND DATA OUTLET FLUSH MOUNTED IN FINISHED AREAS @ 18" A.F.F. TO BOTTOM OF OUTLET.
VOICE AND DATA OUTLET SURFACE MOUNTED IN UNFINISHED AREAS @ 42" A.F.F.
- § V VOICE OUTLET FLUSH MOUNTED IN FINISHED AREAS @ 18" A.F.F. TO BOTTOM OF OUTLET.
VOICE OUTLET SURFACE MOUNTED IN UNFINISHED AREAS @ 42" A.F.F.
- § NO FUSED DISCONNECT SWITCH.
- § F FUSED DISCONNECT SWITCH.
- CEILING OUTLET BOX, SIZE FOR WIRE, FILL ACCORDING TO ARTICLE 314-16 OF THE N.E.C.
- JUNCTION BOX, SIZE FOR WIRE, FILL ACCORDING TO ARTICLE 314-16 OF THE N.E.C.
- #12 COPPER NEUTRAL CONDUCTOR UNLESS NOTED.
— #12 COPPER PHASE CONDUCTORS UNLESS NOTED.
— 1/2" EMT UNLESS NOTED.
— #12 COPPER GROUNDING CONDUCTOR UNLESS NOTED.

MEZZ. ELECTRICAL, NOTES & SCHEDULES


MISSOURI DEPARTMENT
OF TRANSPORTATION
DIVISION OF GENERAL SERVICES
FACILITIES MANAGEMENT

STANDARD MAINTENANCE BUILDING


DRAWN BY: LARRY CARYER
CHECKED BY: DOUG RECORD
DATE: 6-11-14
Sheet
37 of 38

6/11/14


OCCUPANCY SENSOR SCHEDULE		
ROOM	MODEL	MOUNT
100 - HALL	WT-2250	CEILING
101 - OFFICE	WI-200	WALL
103 - OFFICE	WI-200	WALL
104 - OFFICE	WI-200	WALL
105 - OFFICE	WI-200	WALL
106 - LOCKERS	WI-200	WALL
107 - WOMEN'S	WI-200	WALL
108 - MEN'S	WI-200	WALL
109 - BREAK ROOM	UT-300	CEILING
ALL MODELS BASED ON WATT STOPPER		

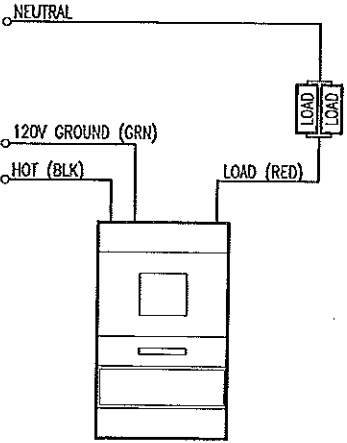

WI-200 WIRING

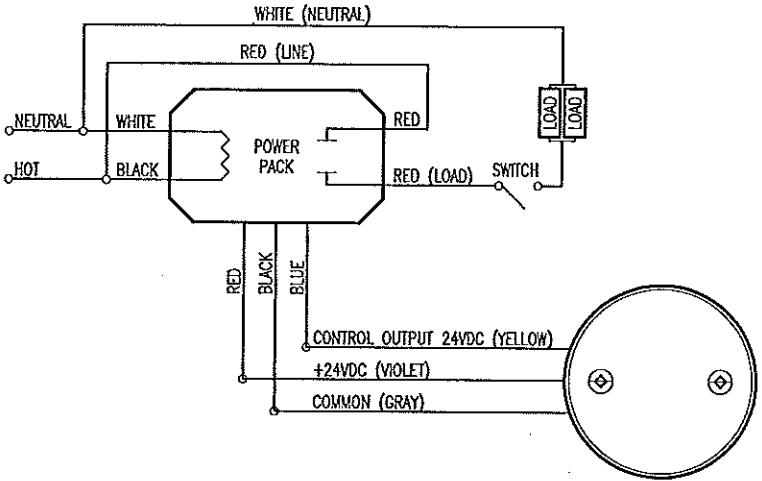

UT-300 WIRING

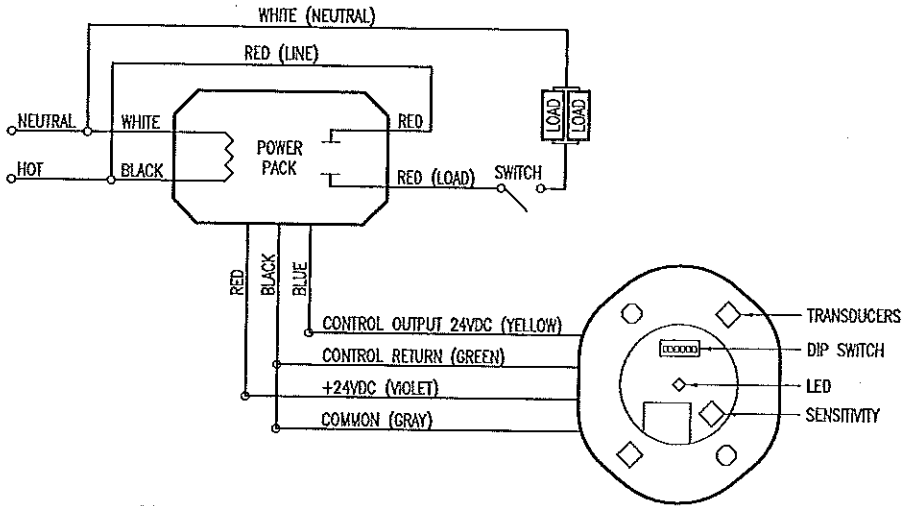

WT-2250 WIRING

A
38
ELECTRIC SENSORS
NOT TO SCALE

ELECTRIC SENSORS

MISSOURI DEPARTMENT
OF TRANSPORTATION
DIVISION OF GENERAL SERVICES
FACILITIES MANAGEMENT

STANDARD MAINTENANCE BUILDING

DRAWN BY: LARRY CARYER
CHECKED BY: DOUG RECORD
DATE: 6-11-14
Sheet
38 of 38

DOUGLAS A. RECORD
ARCHITECT
NUMBER
A-2009002624
6/11/14