



L:\150258-010_CAD\CIVIL\COPY 150258-010 SUR.DWG
LAYOUT: LAYOUT
BY: BEAM
DATE: 10/29/2015
XREF DWG1: NONE
XREF DWG2: NONE
XREF DWG3: NONE
XREF DWG4: NONE

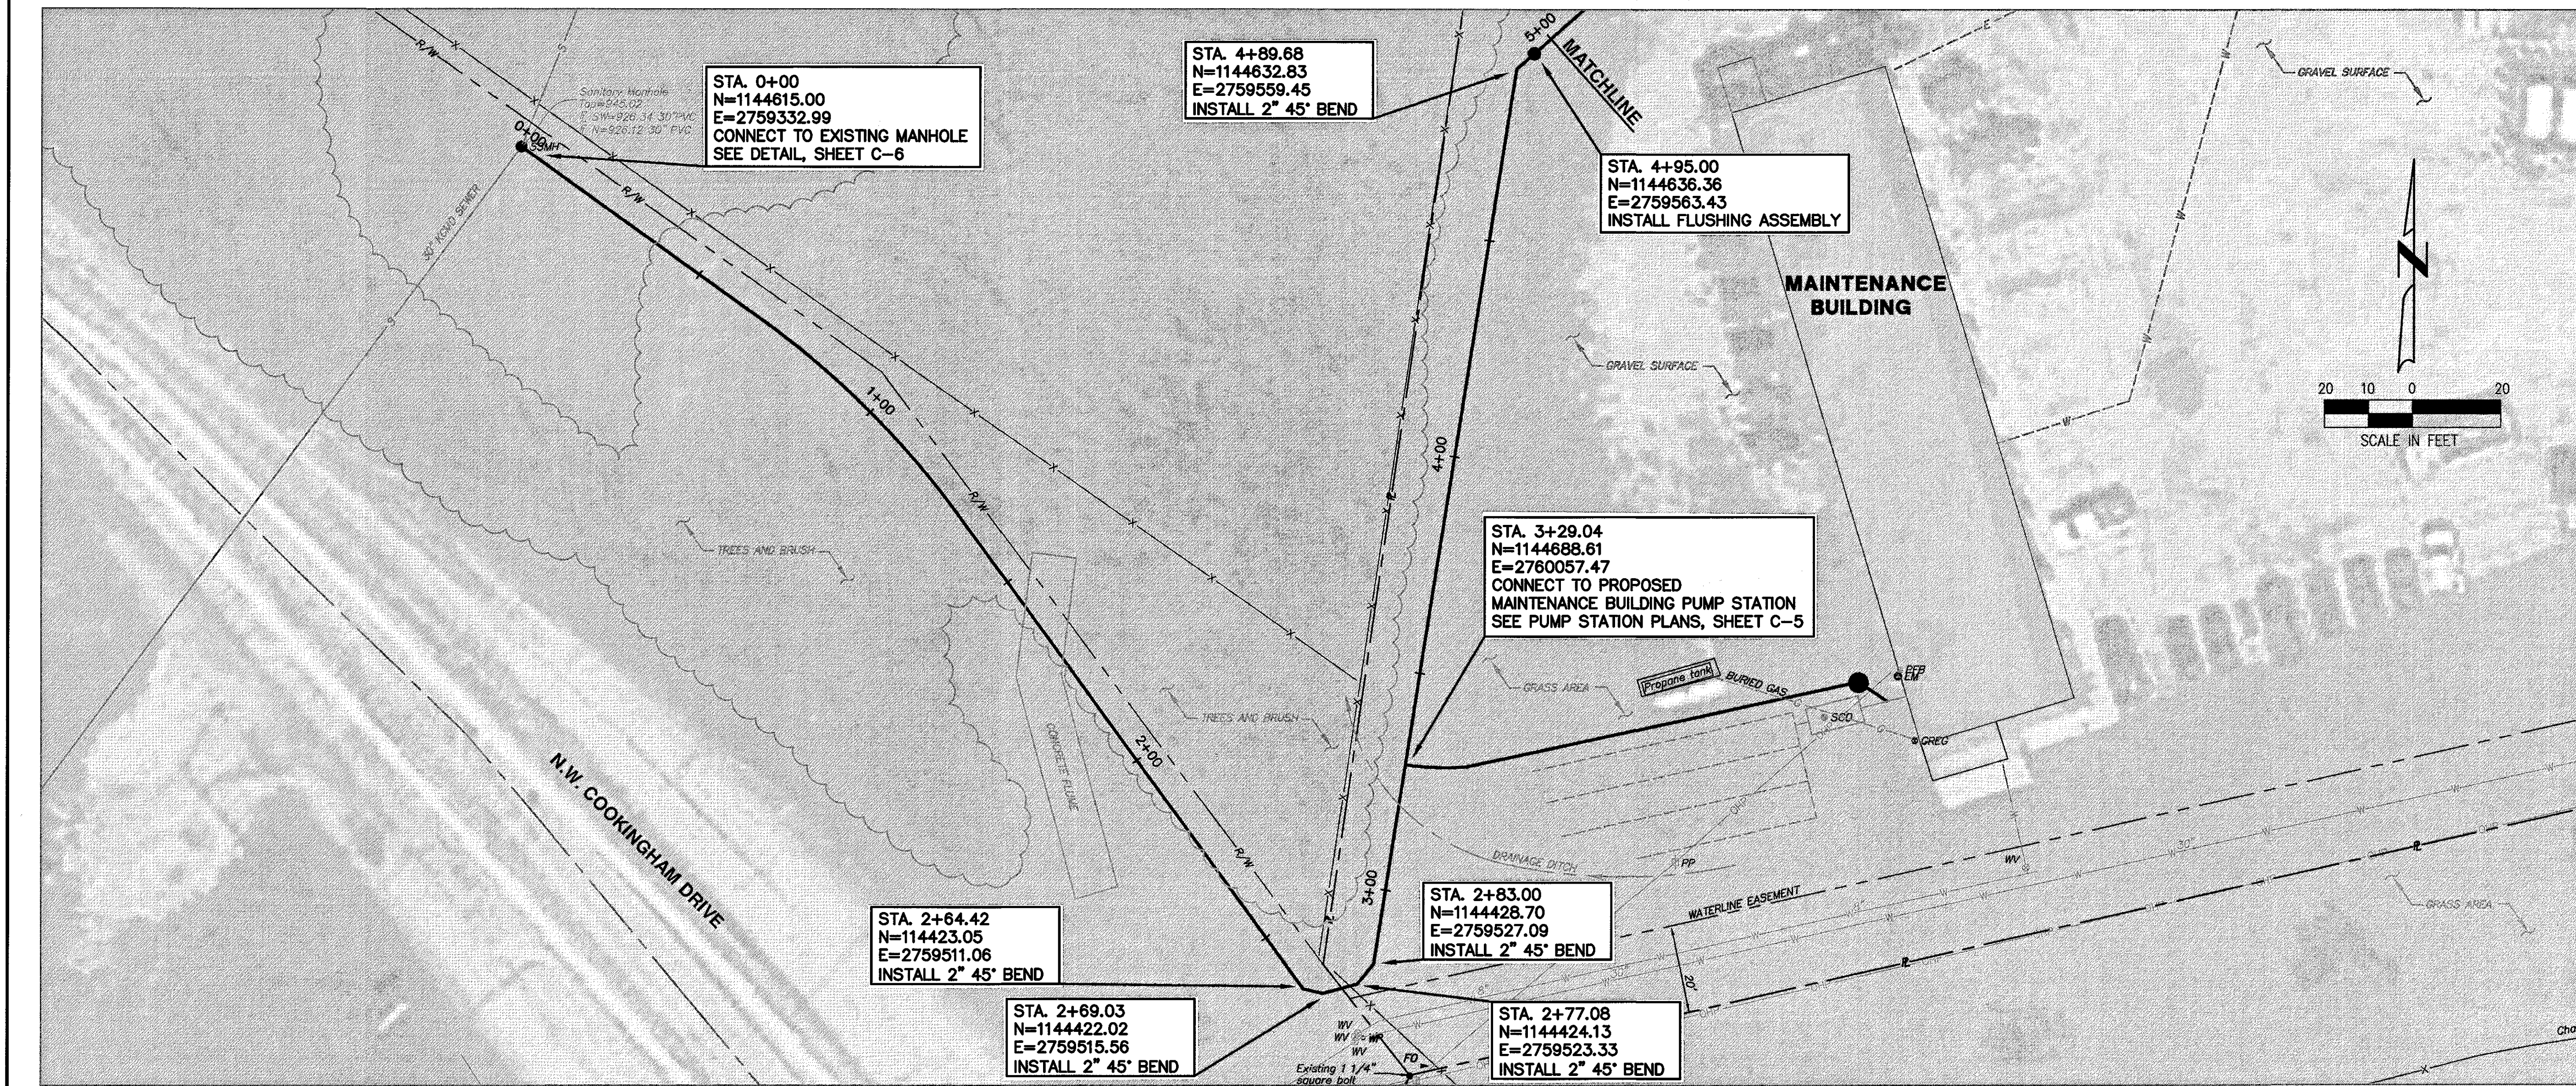


PRESSURE SEWER PLAN

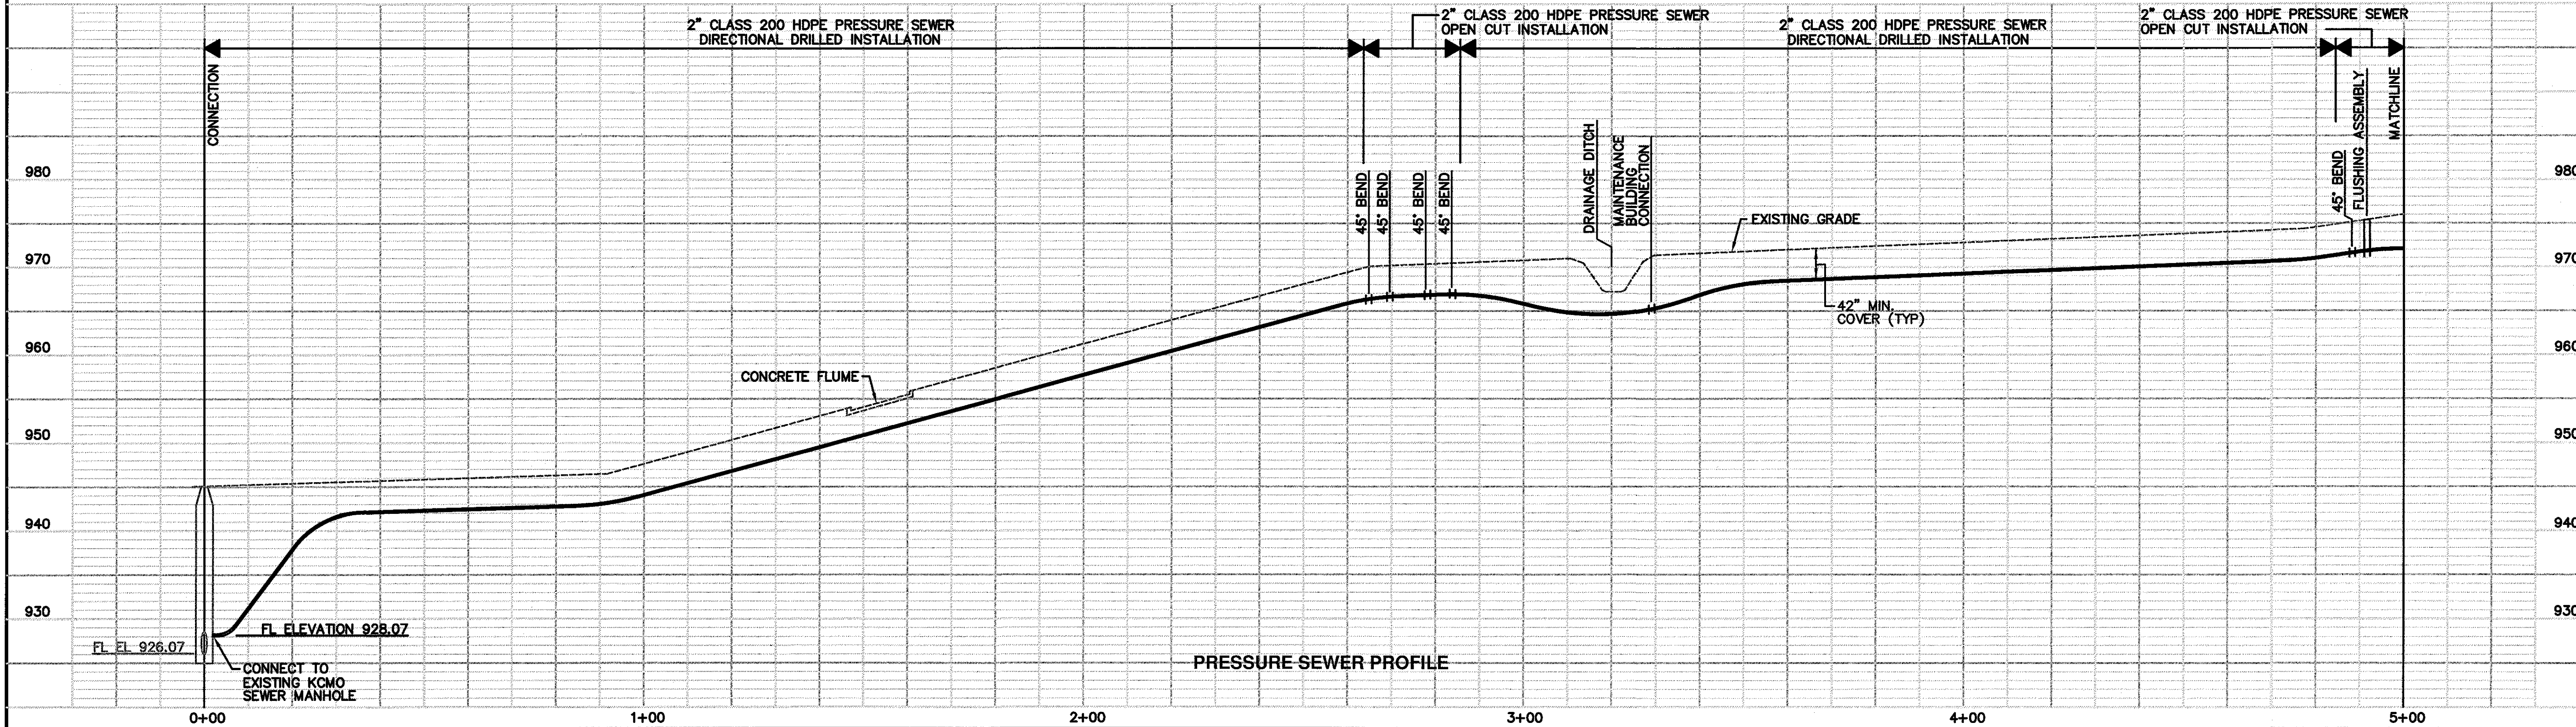


PRESSURE SEWER PROFILE

NASHUA MODOT MAINTENANCE FACILITY KANSAS CITY, MISSOURI		SHAFER, KLINE & WARREN, INC. 11250 Corporate Avenue, Lenexa, KS 66219-1392 913/888-7800 FAX: 913/888-7868		DESIGNED BY: DAB DRAWN BY: DAB CHECKED BY: STB ISSUE DATE: 9/17/15	
SANITARY SEWER SYSTEM SEWER PLAN AND PROFILE		OFFICE LOCATIONS: COLUMBIA, MO HOUSTON, TX LENEXA, KS MACON, MO NORTH KANSAS CITY, MO TULSA, OK		REV. DATE 1 10/29/15 ADDED EXIST. WATER, POWER, GAS BY: STB DAB DAB	
150258-010 SHEET NO. C-3		CIVIL ENGINEERS ELECTRICAL ENGINEERS MECHANICAL ENGINEERS STRUCTURAL ENGINEERS LANDSCAPE ARCHITECTS LAND SURVEYORS LAND PLANNERS		MISSOURI CERTIFICATE OF AUTHORITY: 000143 COPYRIGHT © - 2015 - SHAFER, KLINE & WARREN, INC.	

L:\150258-010\CAD\CIVIL\COPY 150258-010 SUR.DWG
LAYOUT: LAYOUT
BY: BEAM
DATE: 10/29/2015
XREF DWG1: NONE
XREF DWG2: NONE
XREF DWG3: NONE
XREF DWG4: NONE

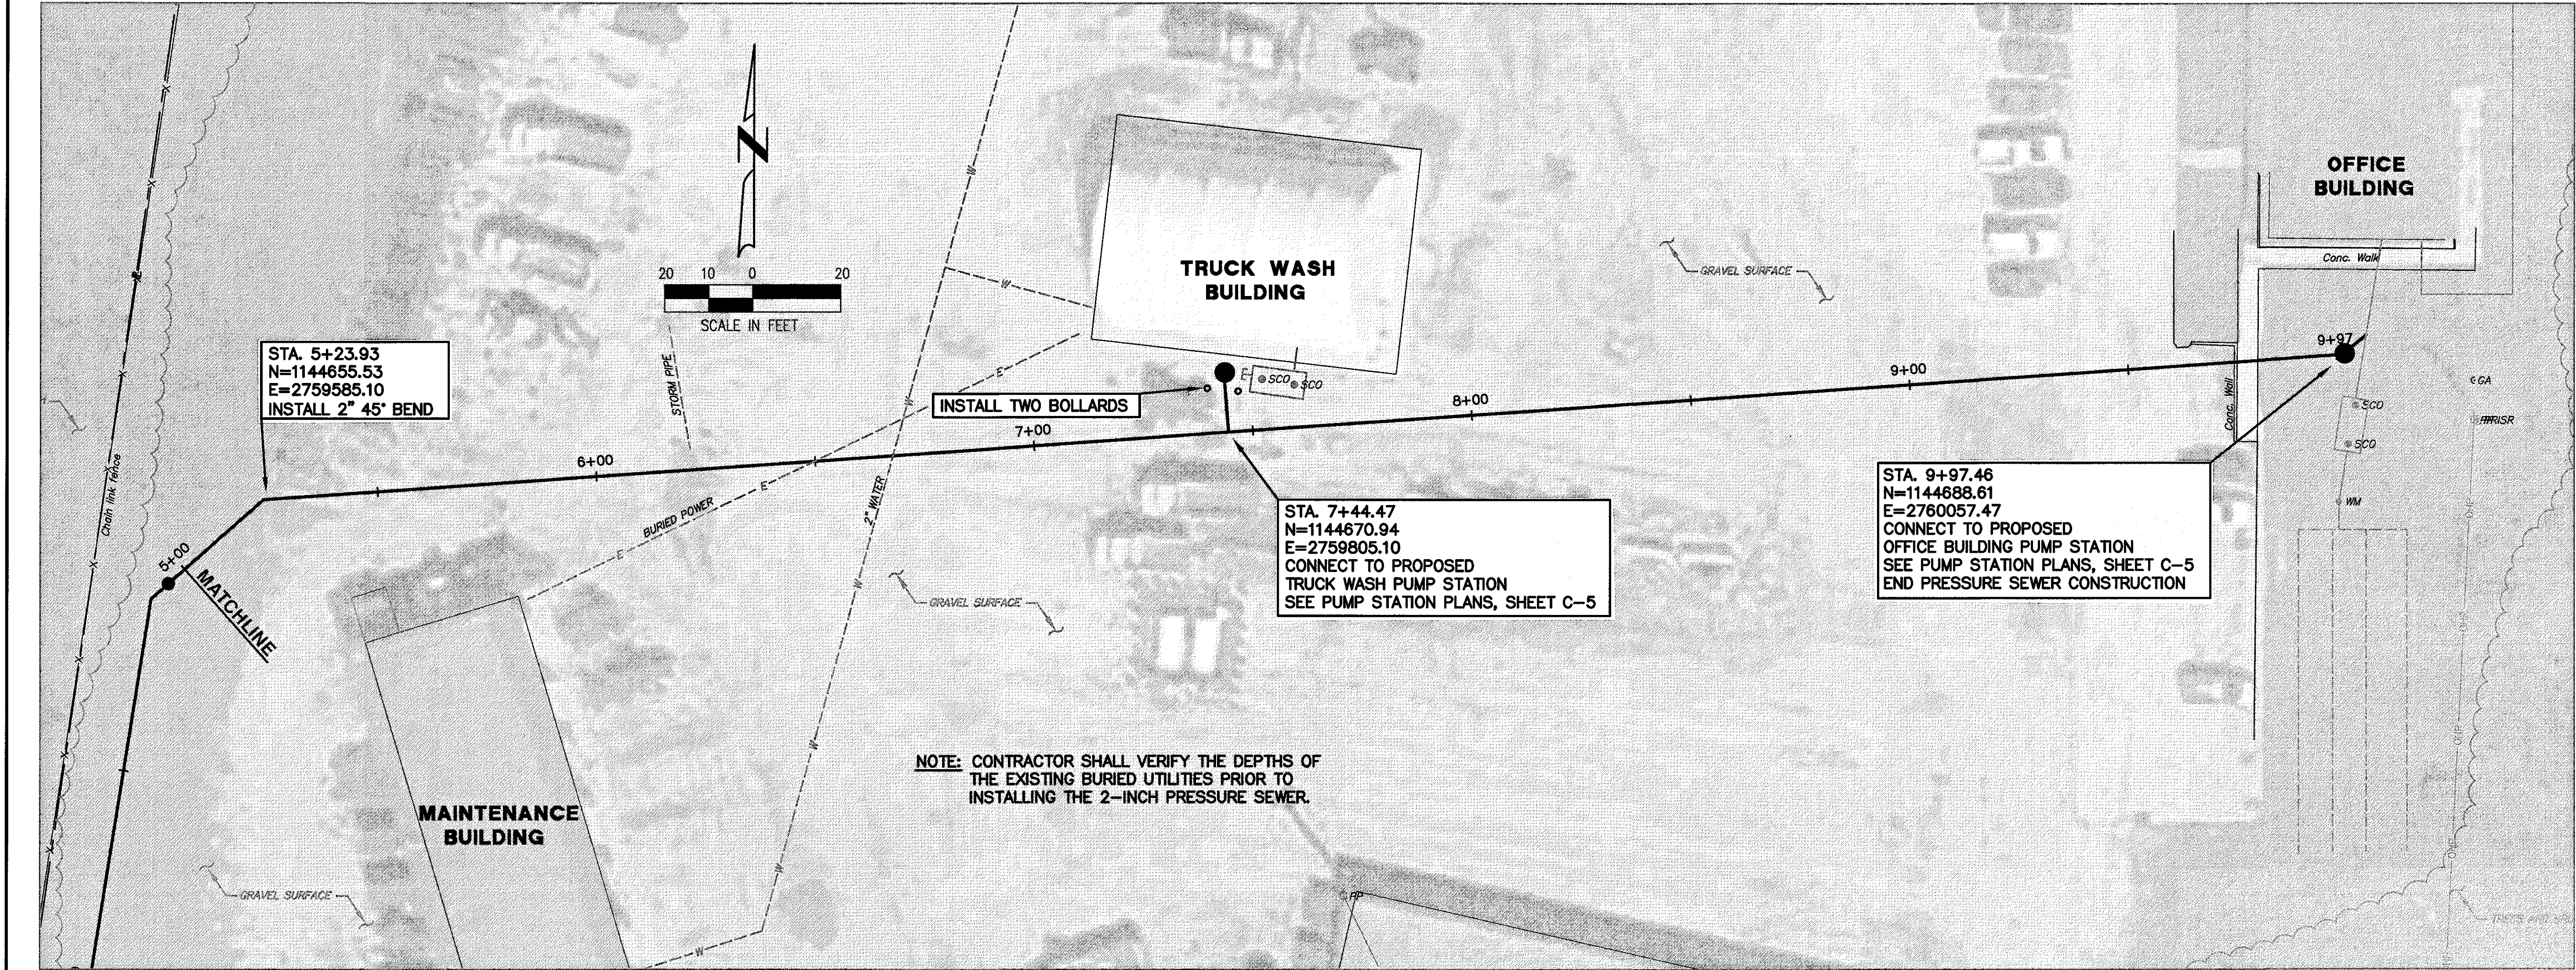

PRESSURE SEWER PLAN

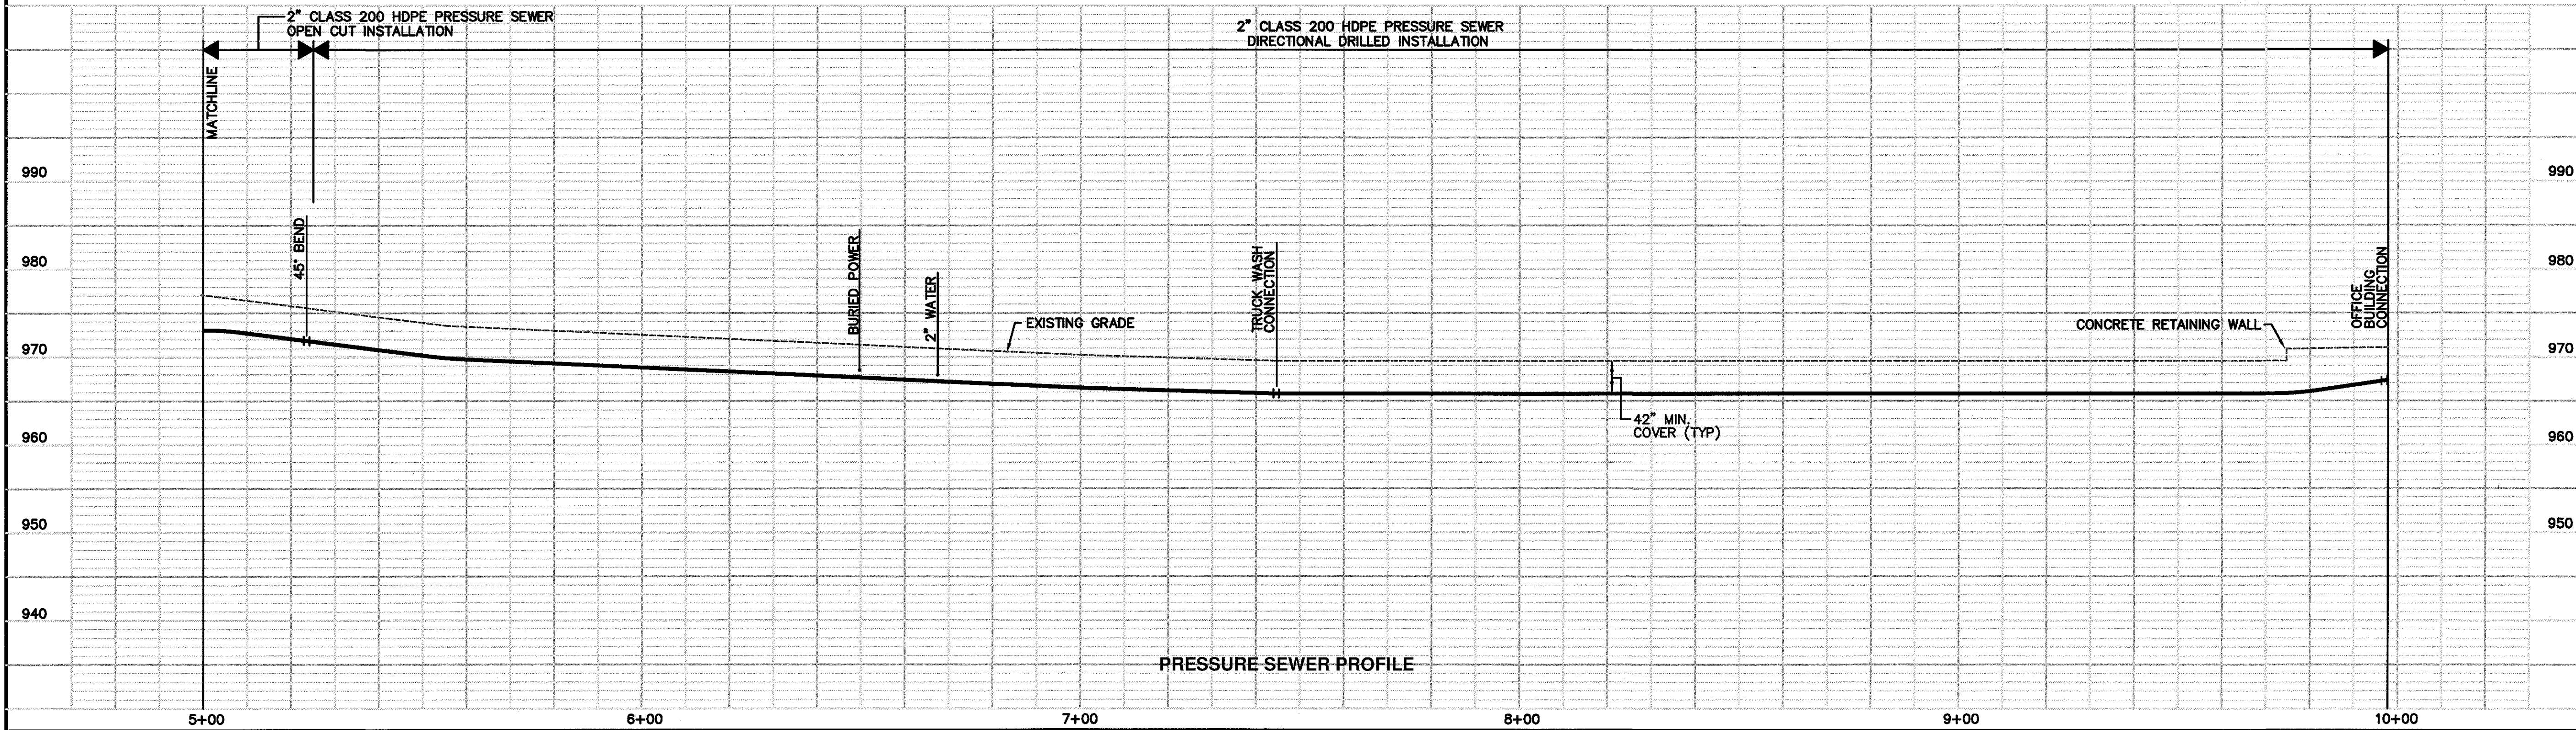

PRESSURE SEWER PROFILE

NASHUA MODOT MAINTENANCE FACILITY KANSAS CITY, MISSOURI		SHAFER, KLINE & WARREN, INC. 11250 Corporate Avenue, Lenexa, KS 66219-1392 913/888-7800 FAX: 913/888-7888		DESIGNED BY: DAB		DRAWN BY: DAB		CHECKED BY: STB		ISSUE DATE: 9/17/15	
SANITARY SEWER SYSTEM SEWER PLAN AND PROFILE		OFFICE LOCATIONS: COLUMBIA, MO HOUSTON, TX LENEXA, KS MACON, MO NORTH KANSAS CITY, MO TULSA, OK		REV. DATE		REV. DATE		REV. DATE		REV. DATE	
150258-010 SHEET NO.		10/29/15		10/29/15		10/29/15		10/29/15		10/29/15	
C-4		COPYRIGHT © - 2015 - SHAFER, KLINE & WARREN INC.		DAB		DAB		STB		DAB	
		MISSOURI CERTIFICATE OF AUTHORITY: 000143									