



L:\160050-010\CAD\CIVIL\160050-010 SITE.DWG
DATE: 5/29/2016
BY: JCARTER
XREF DWG1: 140027 SITE DESIGN.DWG
XREF DWG2: 140027 BASE.DWG
XREF DWG3: NONE
XREF DWG4: NONE

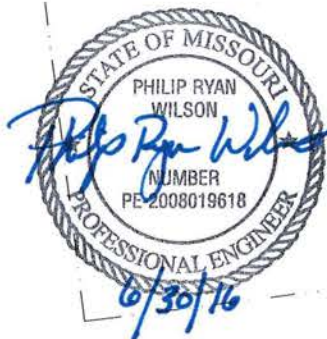

CONNECTION DETAIL

DESIGNED BY: PRW	DRAWN BY: JDC	CHECKED BY: PRW	ISSUE DATE:
COPYRIGHT © 2016 SHAFER, KLINE & WARREN INC. MISSOURI CERTIFICATE OF AUTHORITY: 000143			

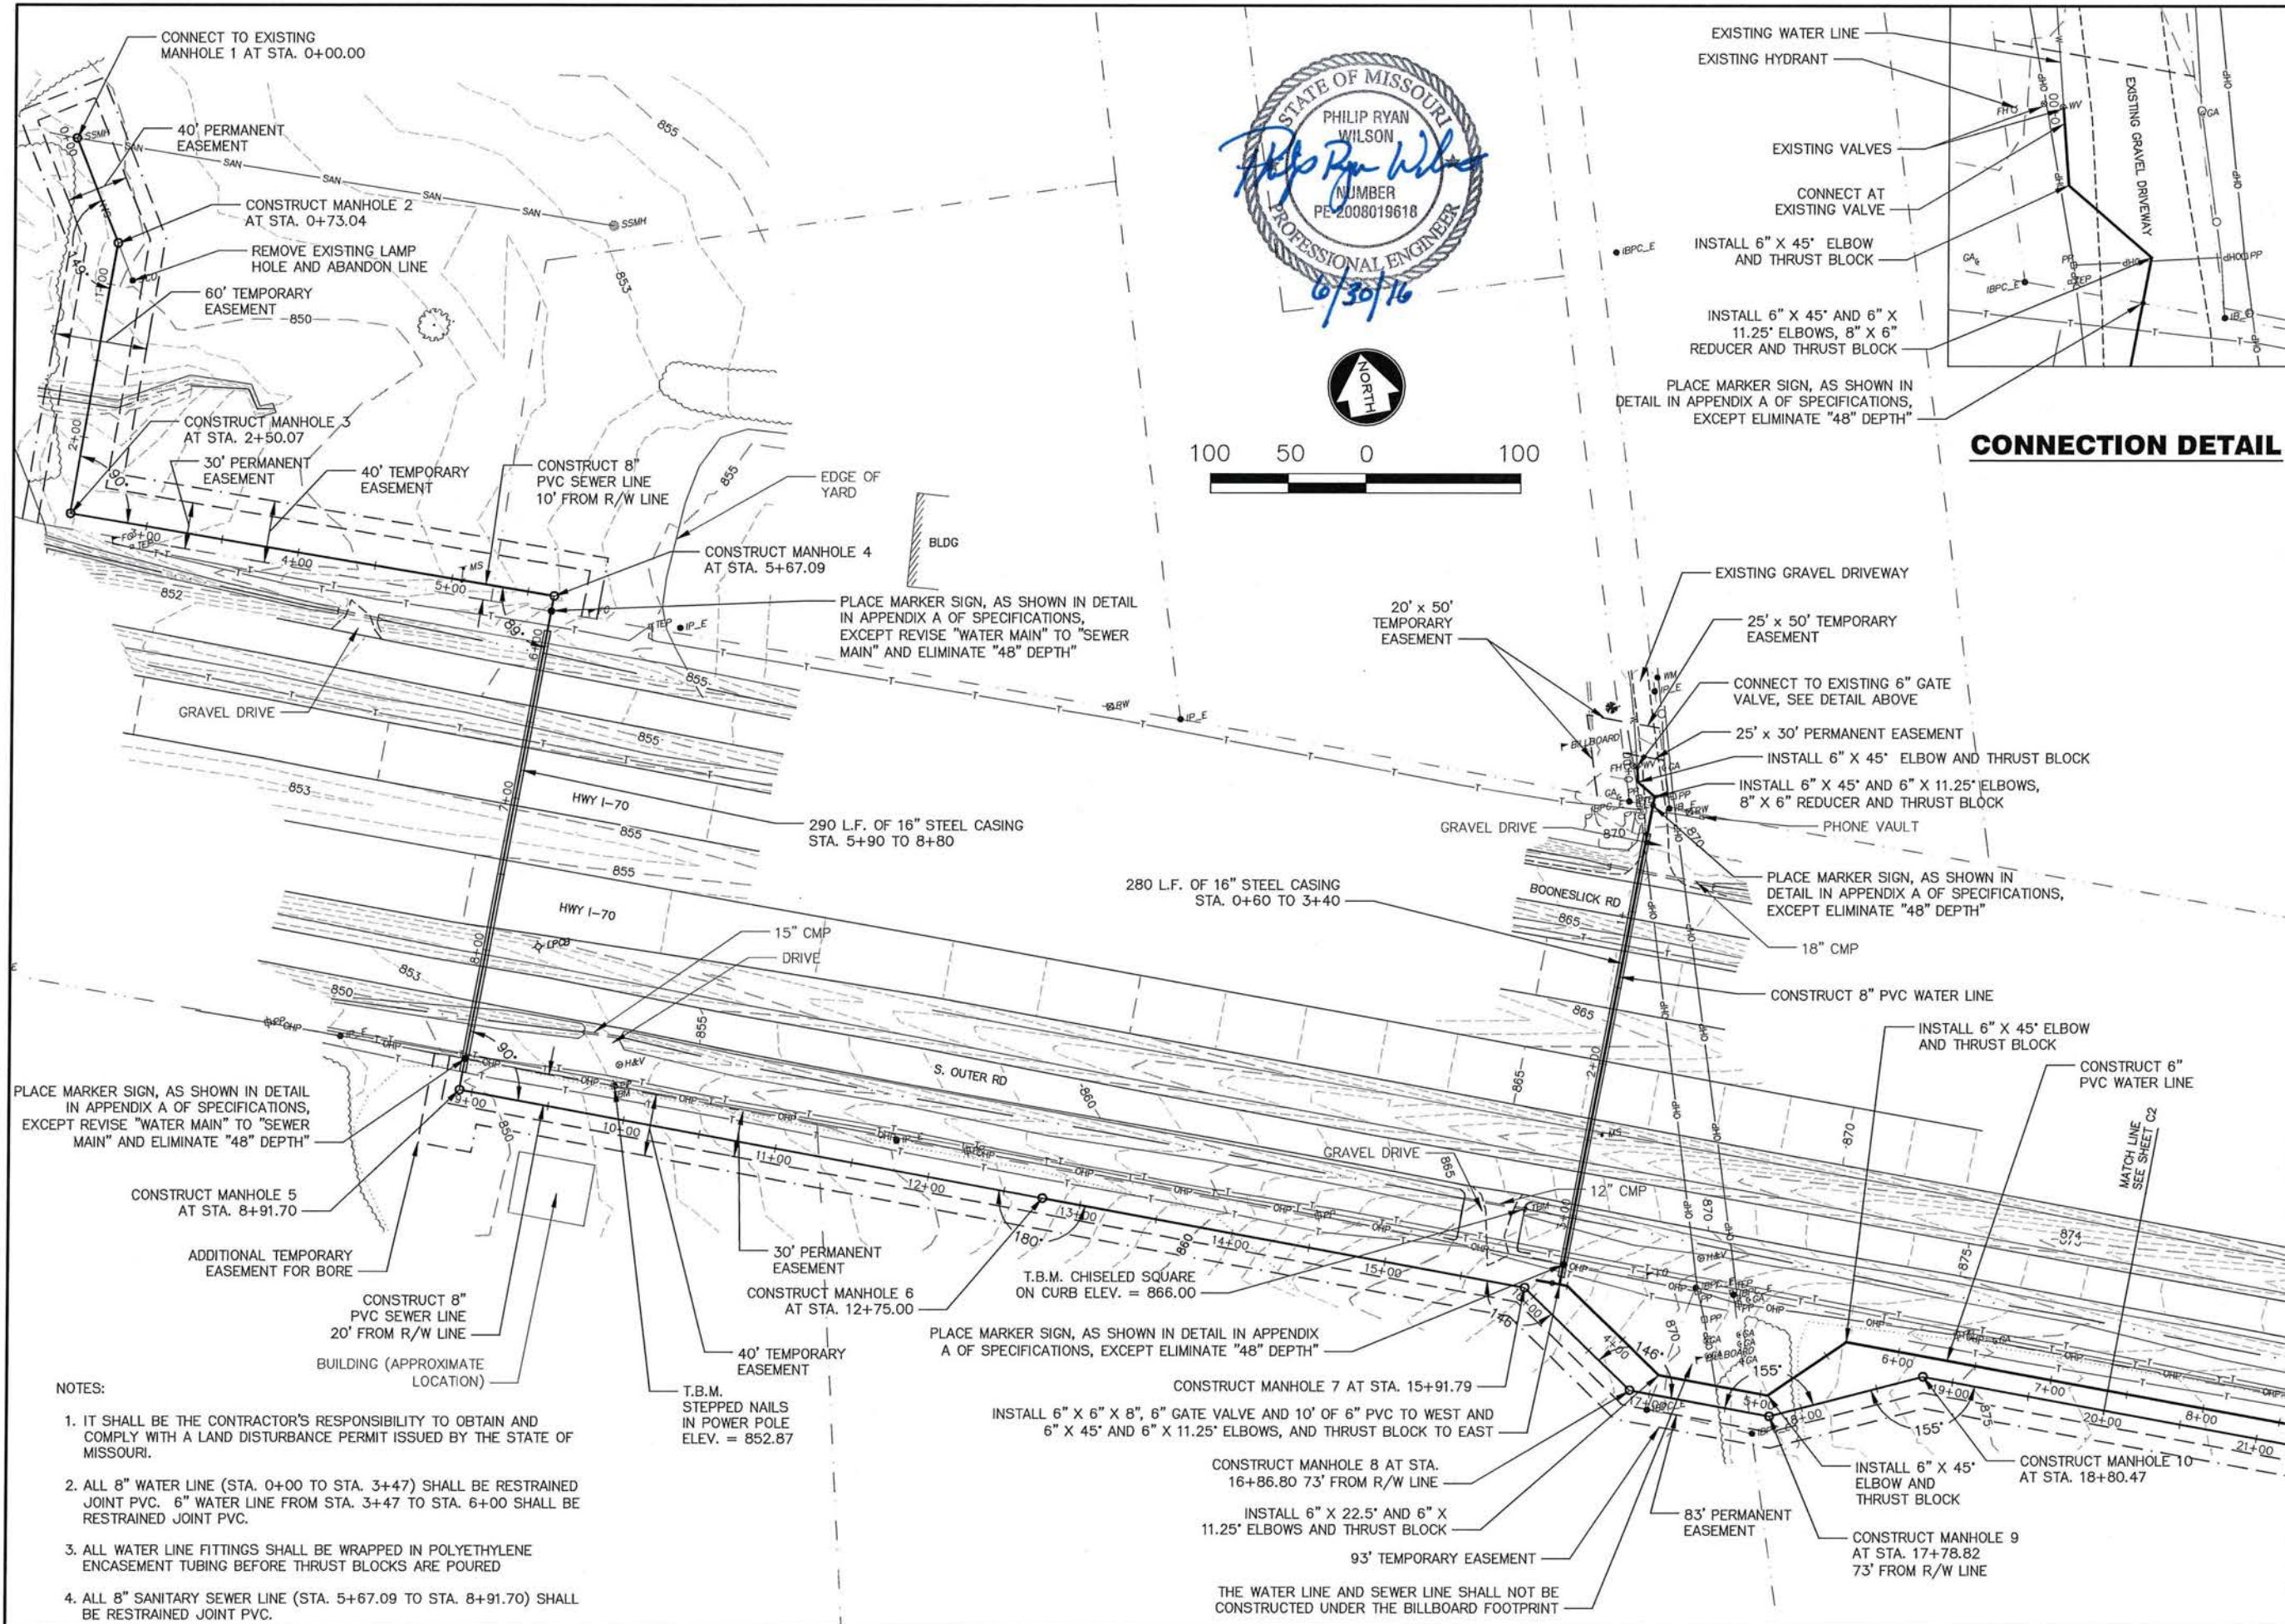

SHAFER, KLINE & WARREN
107 Butler Street
Macon, MO 63552-1628
660.385-6441 FAX: 660.385-6614
SURVEYING | ENGINEERING | CONSTRUCTION

**MODOT MAINTENANCE FACILITY
NEW FLORENCE, MISSOURI**




SITE PLAN

160050-010
SHEET NO.
C1

L: 160050-010_CAD\CIVIL\160050-010 SITE.DWG
DATE: 6/29/2016
XREF DWG1: 140027 SITE DESIGN.DWG
XREF DWG2: 140027 BASE.DWG
XREF DWG3: NONE
XREF DWG4: NONE

TABLE OF COORDINATES		
ITEM	NORTHING	EASTING
MANHOLE 2	1117624.28	549595.51
MANHOLE 3	1117457.57	549535.93
MANHOLE 4	1117350.89	549834.46
MANHOLE 5	1117046.74	549721.04
MANHOLE 6	1116912.81	550080.18
MANHOLE 7	1116802.12	550377.00
MANHOLE 8	1116724.98	550432.47
MANHOLE 9	1116692.70	550518.64
MANHOLE 10	1116700.82	550619.97
MANHOLE 11	1116586.640	550925.960
MANHOLE 12	1116472.46	551231.950
MANHOLE 13	1116243.49	551220.480
MANHOLE 14	1115978.82	551207.220
MANHOLE 15	1115973.17	551319.910

- NOTES:
- IT SHALL BE THE CONTRACTOR'S RESPONSIBILITY TO OBTAIN AND COMPLY WITH A LAND DISTURBANCE PERMIT ISSUED BY THE STATE OF MISSOURI.
 - ALL WATER LINE FITTINGS SHALL BE WRAPPED IN POLYETHYLENE ENCASMENT TUBING BEFORE THRUST BLOCKS ARE POURED.
 - EXISTING LIFT STATION, CAR WASH HOLDING TANK AND SEPTIC TANK SHALL BE BYPASSED AND ABANDONED. TO ABANDON PUMP OUT, PUNCTURE HOLES IN BOTTOM AND FILL WITH SAND. REMOVED MATERIAL SHALL BE DISPOSED OF AT A PERMITTED WASTEWATER FACILITY. DISCONNECT POWER AND REMOVE CONTROL PANEL AND DISPOSE OF PROPERLY. PUMP AND GUIDE RAILS SHALL BE RETAINED BY MODOT.

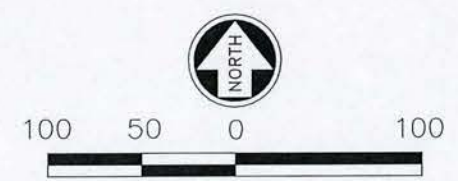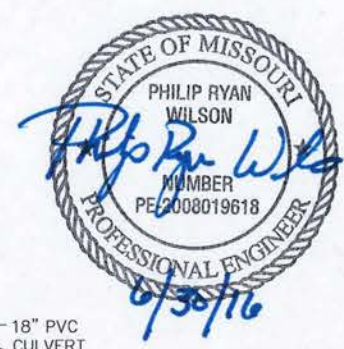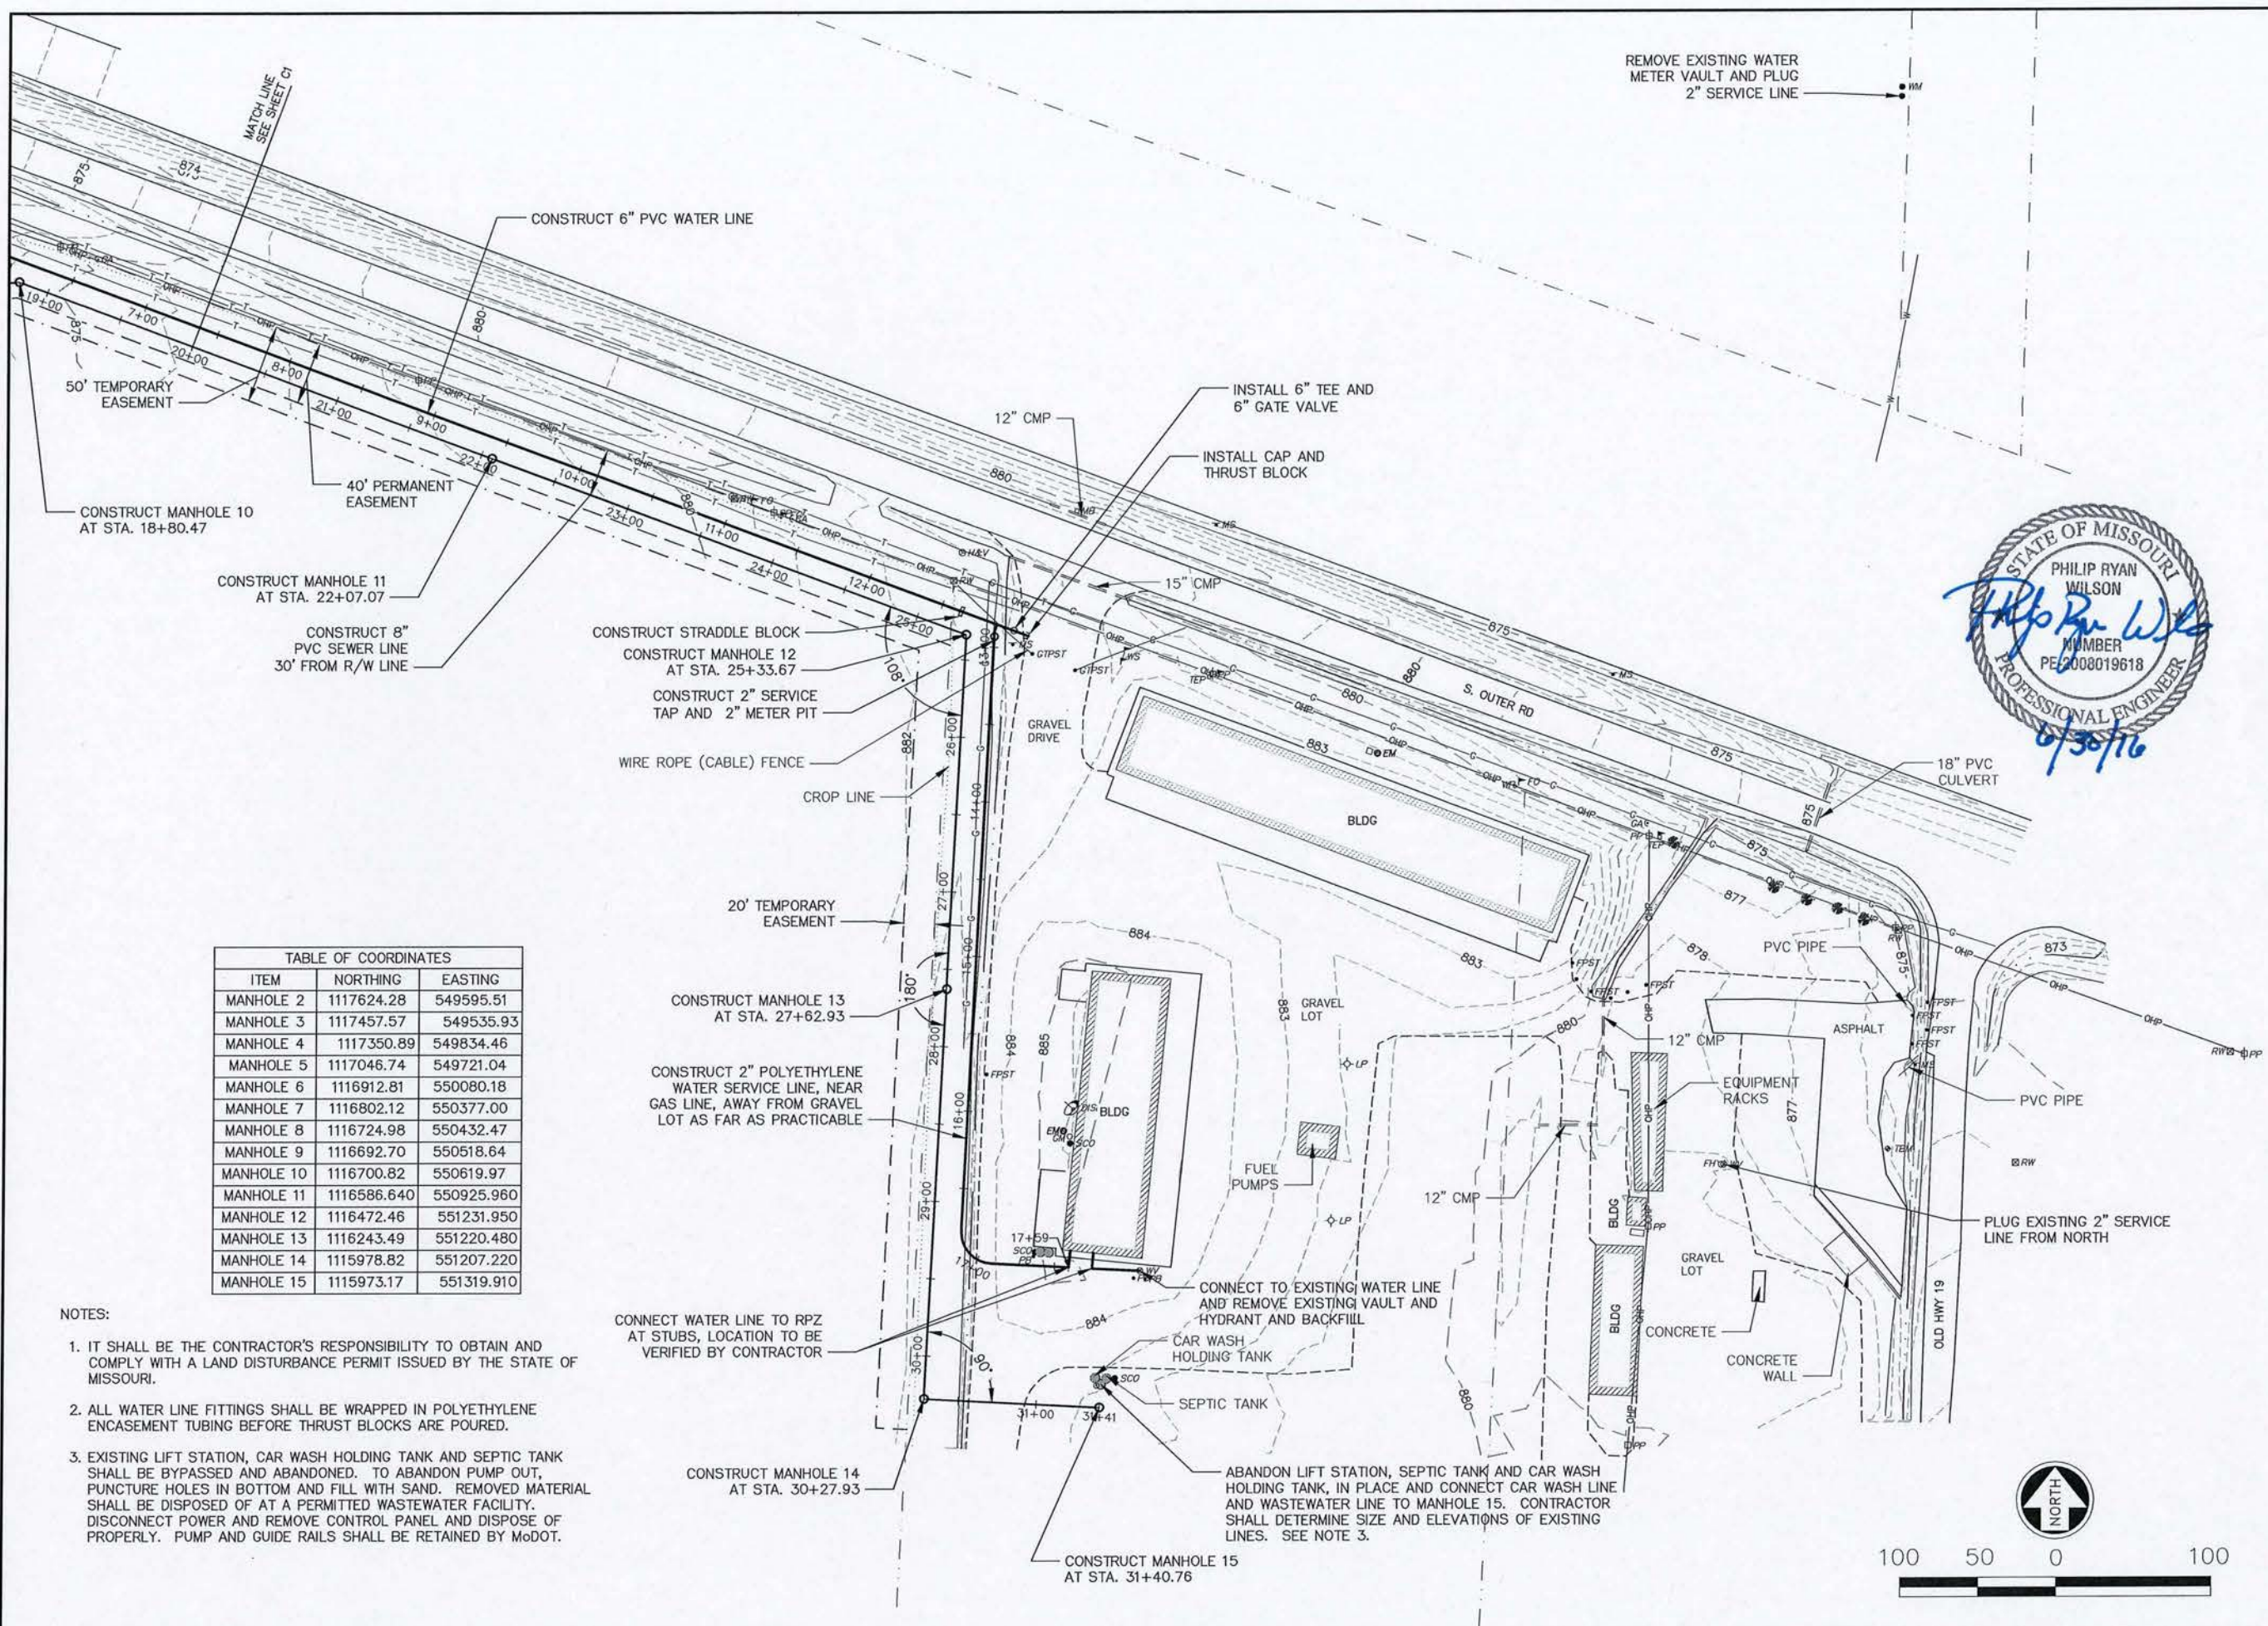

SHAHER, KLINE & WARREN		MODOT MAINTENANCE FACILITY NEW FLORENCE, MISSOURI	
107 Butler Street Macon, MO 63552-1628 660.385-6441 FAX: 660.385-6614 SURVEYING ENGINEERING CONSTRUCTION		SITE PLAN	
160050-010 SHEET NO.		C2	

Designed By: PRW	4	5
Drawn By: JDC	3	
Checked By: PRW	2	
Issue Date:	1	
NO.	DATE	REVISIONS
JDC	06-29-16	REVISED CONNECTION POINT TO STUBS
BY		
APPD		
COPYRIGHT © 2016 - SHAHER, KLINE & WARREN INC.		
MISSOURI CERTIFICATE OF AUTHORITY: 000143		