


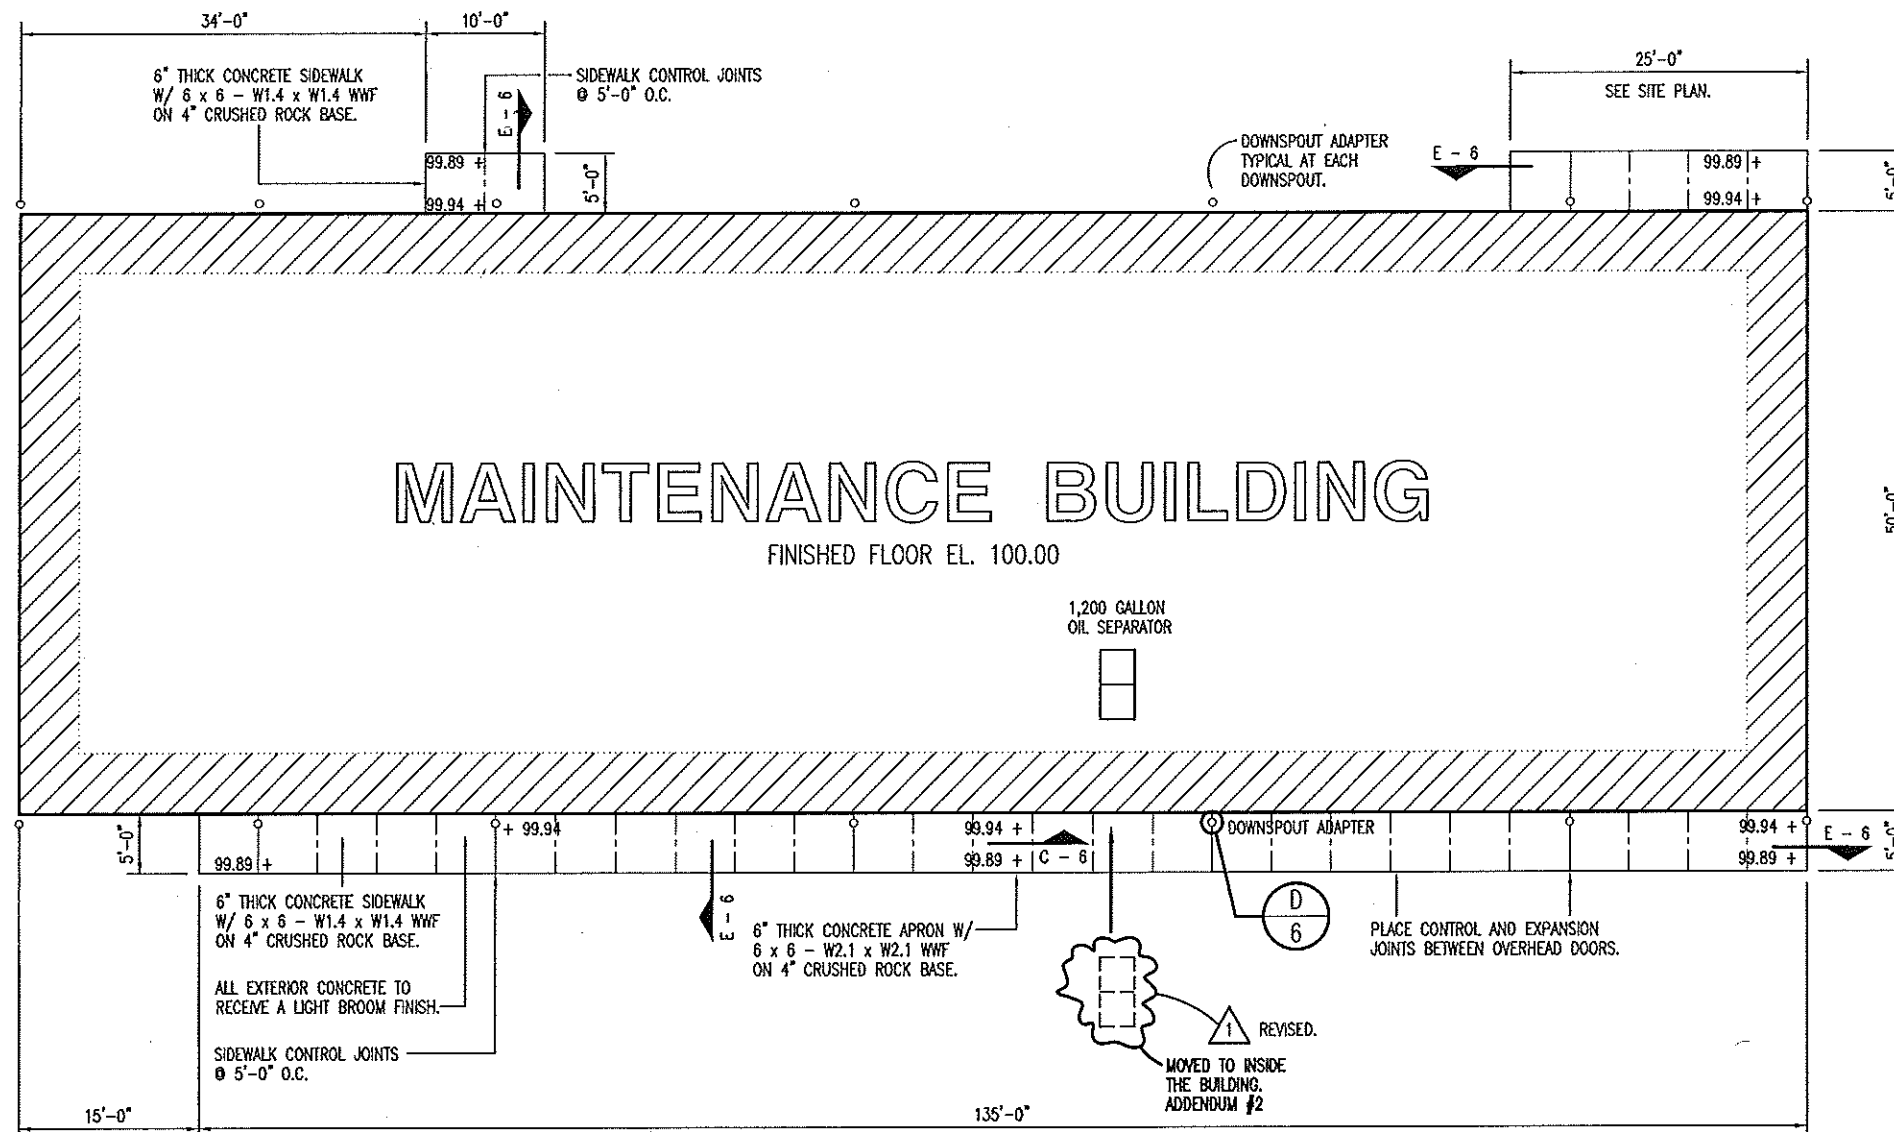


CONTRACTOR NOTE:

CONNECT ALL UTILITIES AS REQUIRED
FOR A COMPLETE AND OPERATIONAL
SYSTEM FOR THE NEW BUILDING.

ALL UNUSED EXCAVATED MATERIAL CAN
BE STOCKPILED ON-SITE. LOCATION BY
OWNER.

A
2 **PLOT PLAN**
SCALE: 1/16" = 1'-0"

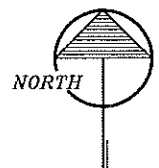


PLOT PLAN

**MISSOURI DEPARTMENT
OF TRANSPORTATION**

DIVISION OF GENERAL SERVICES
FACILITIES MANAGEMENT

NEW MAINTENANCE COMPLEX
Kansas City District - Clay County, Kansas City, MO 64161
3800 North Skiles Avenue

DRAWN BY: LARRY CARYER
CHECKED BY: DOUG RECORD
DATE: 3-11-13
Sheet
2 of 38

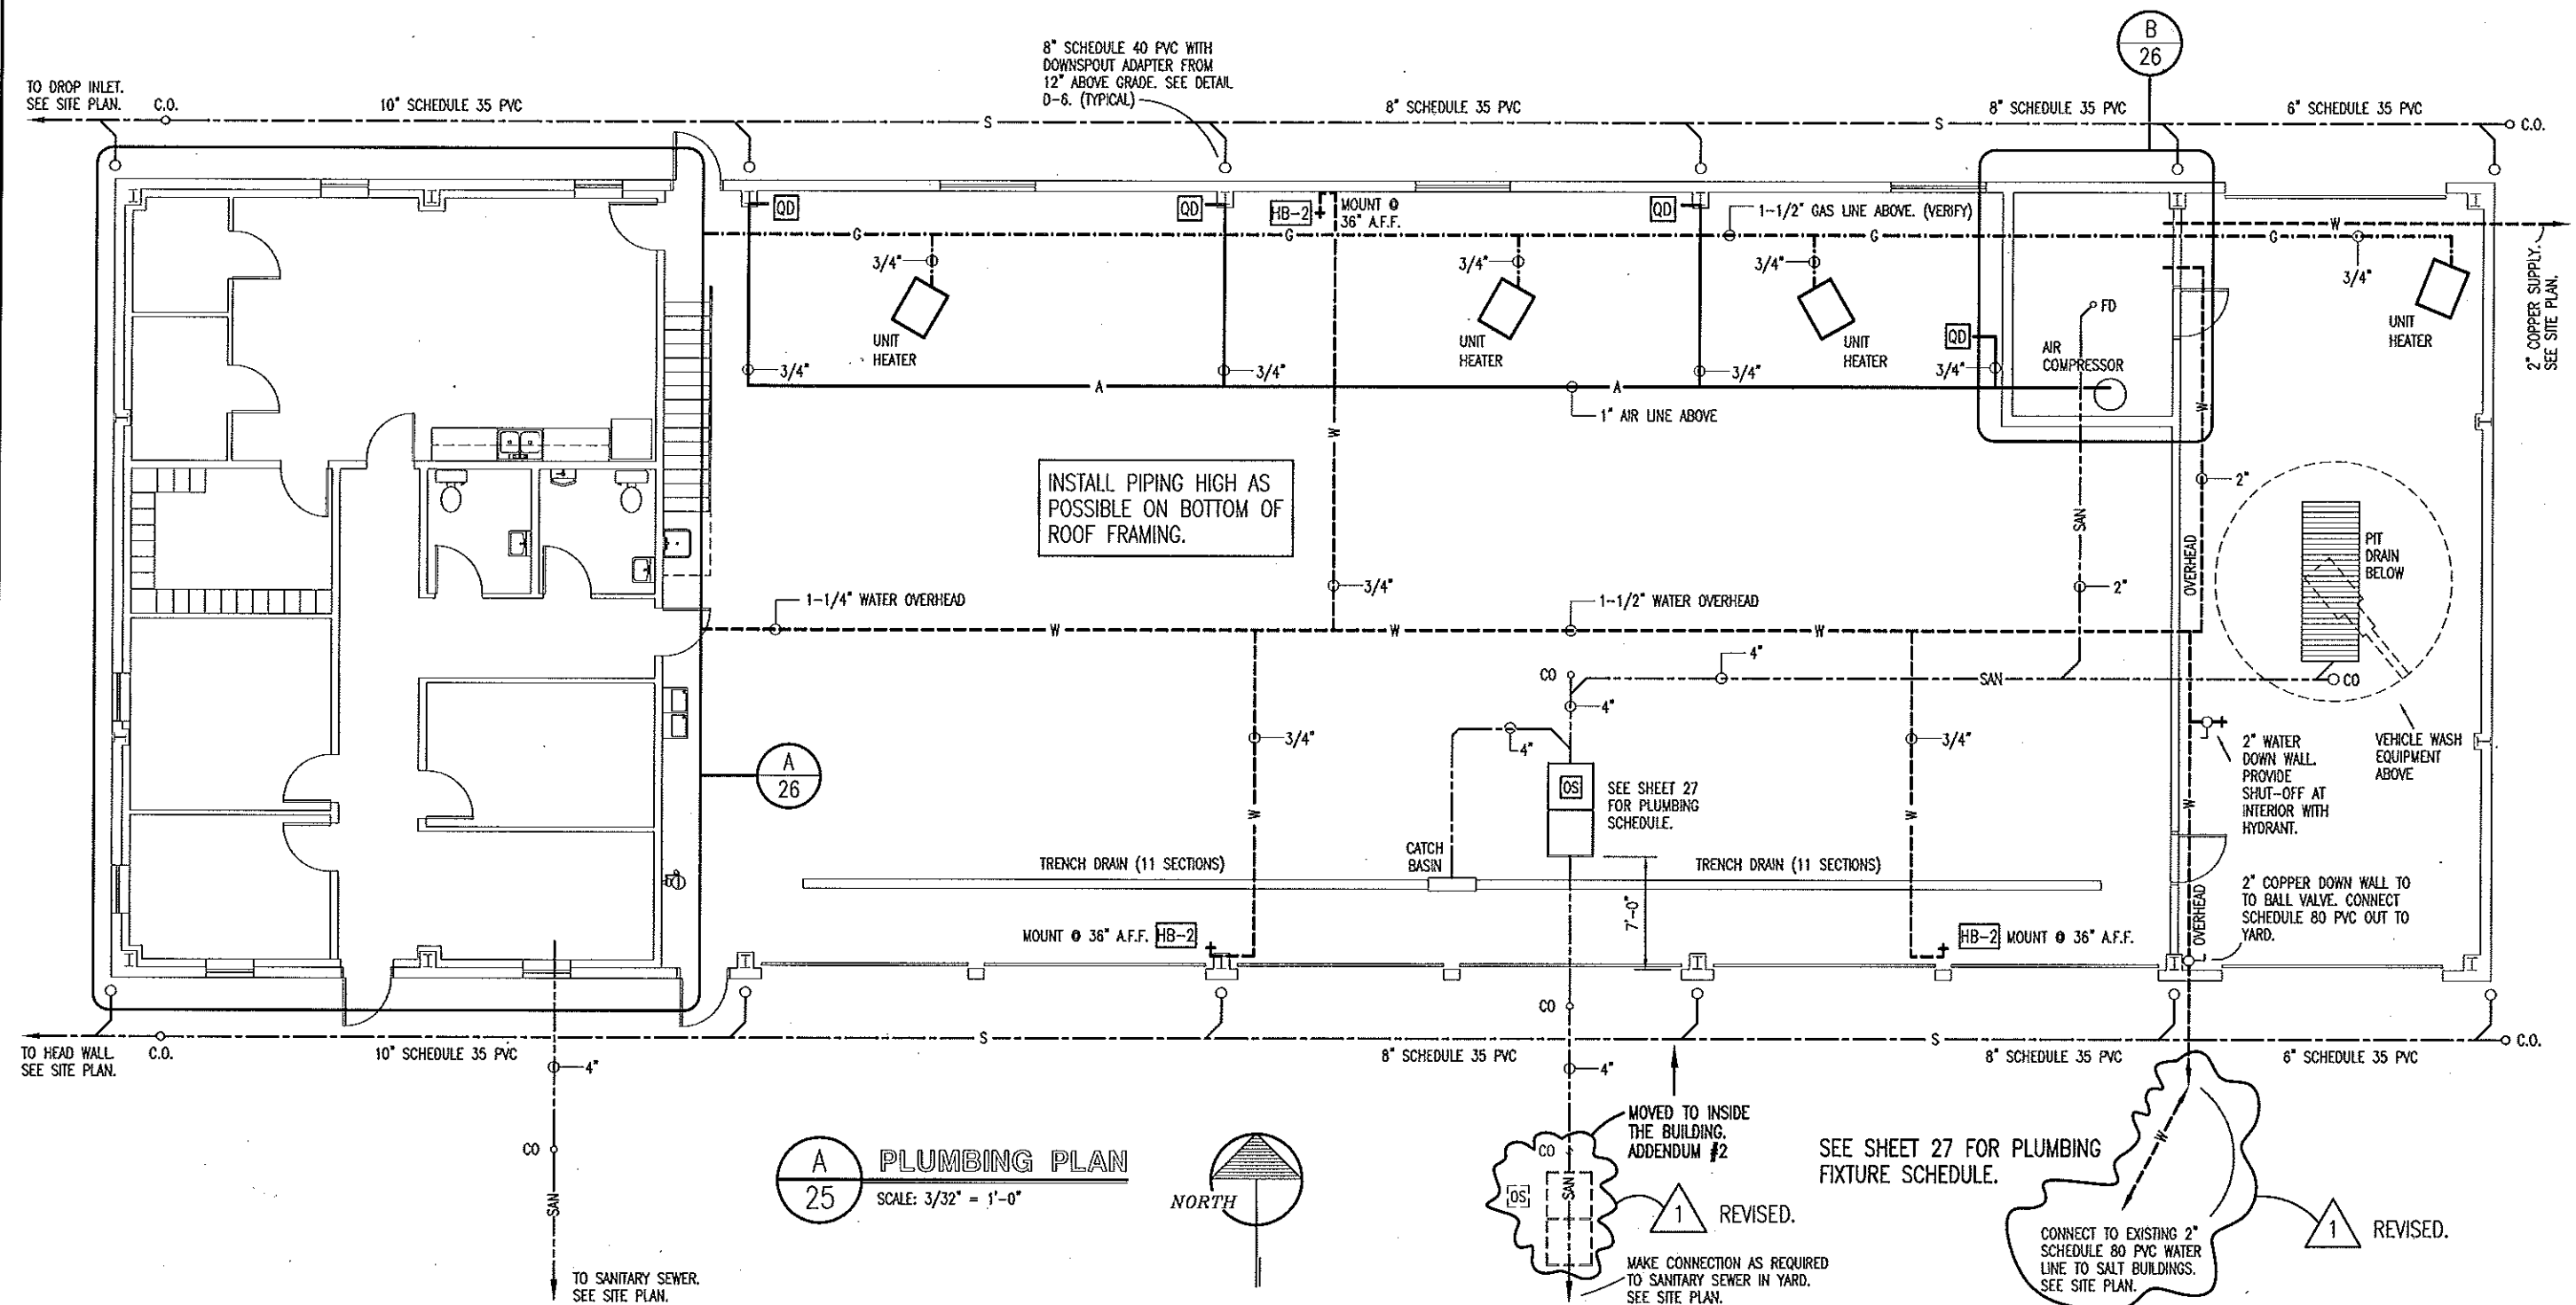

PLUMBING PLAN

MISSOURI DEPARTMENT
OF TRANSPORTATION
DIVISION OF GENERAL SERVICES
FACILITIES MANAGEMENT

NEW MAINTENANCE COMPLEX
Kansas City District - Clay County, Kansas City, MO 64161
3800 North Skiles Avenue

DRAWN BY: LARRY CARVER
CHECKED BY: DOUG RECORD
DATE: 3-11-13
Sheet
25 of 38