

INDEX OF DRAWINGS

- 1 - 13 COVER SHEET
- 2 - 13 FOUNDATION DETAILS
- 3 - 13 CONCRETE SLAB PLAN
- 4 - 13 FLOOR PLAN
- 5 - 13 SCHEDULES
- 6 - 13 FRONT & REAR ELEVATIONS
- 7 - 13 LEFT & RIGHT ELEVATIONS
- 8 - 13 HEAD & JAMB DETAILS
- 9 - 13 WALL SECTIONS
- 10 - 13 WALL SECTIONS
- 11 - 13 ROOF FRAMING PLAN
- 12 - 13 ELECTRICAL PLAN (BY OTHERS)
- 13 - 13 ELECTRICAL PANEL (BY OTHERS)

MISSOURI DEPARTMENT  
OF TRANSPORTATION

Sedalia Pole Barn with Two Enclosed Bays  
Kansas City District  
2200 South Limit, Sedalia, MO 65301  
Pettis County

CODE REQUIREMENTS

BUILDING CODE - 2013 IBC  
ELECTRICAL CODE - 2013 N.E.C.

ALTERNATE CONDITIONS:


THE VARYING MAKEUP OF SOILS AND OCCURRENCE OF ROCK IN MANY MODOT DISTRICTS MAY REQUIRE CONSIDERABLE REDESIGN OF THE POST PLACEMENT BELOW GRADE FROM THAT SHOWN IN THESE DRAWINGS. THE BIDDER WILL BE RESPONSIBLE FOR OBTAINING ACCURATE INFORMATION FROM THE DISTRICTS FACILITIES MANAGER (I.E. DRILLINGS OR BORINGS INFORMATION 5'-0" DEEP AT EACH BUILDING CORNER AND AT LEAST ONE INTERMEDIATE SAMPLE TO THIS DEPTH ON THE LONG SIDES OF THE PROPOSED STRUCTURE) SO THAT THE BID WILL REFLECT ANY FOUNDATION REQUIREMENTS BEYOND THOSE SHOWN HERE. INFORMATION COULD INCLUDE PREVIOUS EXCAVATIONS THAT VERIFY FOOTING CONDITIONS THAT WILL BE ENCOUNTERED BY THIS CONTRACTOR.

REQUIRED BUILDING ELEMENTS:

2 x 4 WALL GIRTS - #2 SYP OR EQUAL.  
POSTS TO BE A MINIMUM OF 4'-0" BELOW GRADE IN COMPACTED SOIL.

FABRICATOR NOTES:

THESE DRAWINGS ARE FURNISHED AS A GUIDE TO BIDDERS IN SUBMITTING THE COMPLETE PACKAGE OF DETAILED DRAWINGS OF THEIR PROPOSED STRUCTURE TO BE SEALED BY AN ARCHITECT/ENGINEER. WHERE "AS REQUIRED" IS USED THE BIDDER MUST FURNISH A DETAILED DESCRIPTION OF THE BUILDING ELEMENT TO BE FURNISHED.

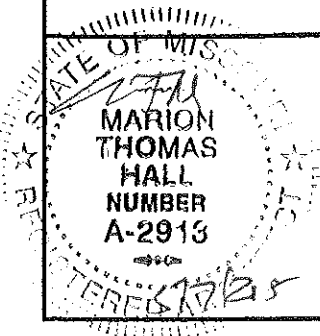

COVER SHEET

MISSOURI DEPARTMENT  
OF TRANSPORTATION  
DIVISION OF GENERAL SERVICES  
FACILITIES MANAGEMENT

Sedalia Pole Barn with Two Enclosed Bays  
Kansas City District - Pettis County  
2200 South Limit, Sedalia, MO 65301

DRAWN BY: LARRY CARRER  
CHECKED BY: GJ  
DATE: 4-17-15  
Sheet  
1 of 13


## GRADING NOTES

CONTRACTOR WILL BE RESPONSIBLE FOR:


- EXCAVATION OF THE SUB GRADE.
- EXCAVATING OF FOOTINGS.
- ALL BACK FILL MATERIAL INSIDE AND OUTSIDE NEW BUILDING.
- CRUSHED ROCK BASE UNDER SLAB & ROCK IN OPEN DAYS.
- ALL FILL, BACK FILL & SUB GRADE MATERIAL AS REQUIRED.
- FINISHED GRADE TO DRAIN AWAY FROM BUILDINGS.
- PROVIDE TOP SOIL, FERTILIZE, SEED AND STRAW AT ALL THE LAWN AREAS DISTURBED DURING CONSTRUCTION.
- PROVIDE FINISHED GRADE MATERIAL DISTURBED DURING CONSTRUCTION TO MATCH EXISTING.
- VERIFY UTILITY LOCATIONS BEFORE CONSTRUCTION.

## CONCRETE NOTES


1. CONCRETE WORK SHALL BE EXECUTED IN STRICT COMPLIANCE WITH THE LATEST EDITION OF THE AMERICAN CONCRETE INSTITUTE (ACI) MANUAL OF CONCRETE PRACTICE.
2. FOUNDATION DESIGN IS BASED UPON AN ASSUMED SOIL BEARING CAPACITY OF 2000 PSF. IF WET OR UNUSUAL SOIL CONDITIONS ARE ENCOUNTERED, NOTIFY THE DESIGNER AND CONSTRUCTION INSPECTOR BEFORE PROCEEDING WITH THE WORK.
3. IF CONDITIONS REQUIRING ROCK EXCAVATION ARE ENCOUNTERED, NOTIFY THE DESIGNER AND CONSTRUCTION INSPECTOR BEFORE PROCEEDING WITH THE WORK.
4. ALL CONCRETE SHALL BE TYPE 1 CEMENT WITH A COMPRESSIVE STRENGTH OF 4,000 PSI @ 28 DAYS AND NOT TO EXCEED 4" SLUMP.
5. CONCRETE EXPOSED TO THE EXTERIOR SHALL RECEIVE AIR ENTRAINMENT 6% +/- 2%.
6. DEFORMED STEEL REINFORCING BARS SHALL BE: #4 AND LARGER ASIM A615 GRADE 60.
7. SEE SPECIFICATION SECTION 03300 CONCRETE FOR ADDITIONAL INFORMATION.
8. SAWED CONTROL JOINTS SHALL BE CLEANED FREE OF ALL DEBRIS AND FILLED WITH SEALANT. SEE SECTION 07900.

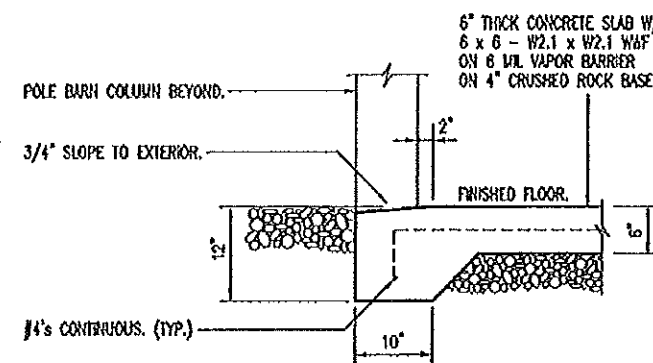

**A**  
2  
GARAGE DOOR  
EXTERIOR SLAB  
SCALE: 1/2" = 1'-0"

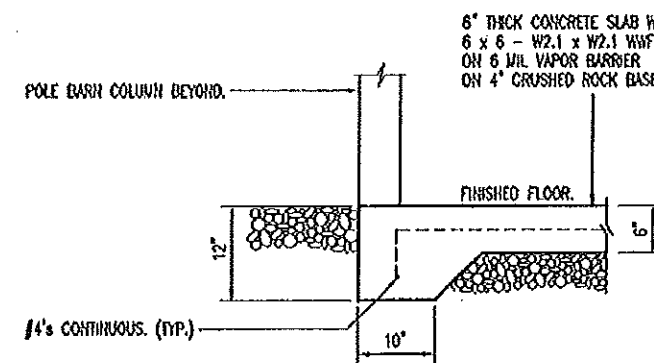

**B**  
2  
FLOOR SLAB EDGE  
SCALE: 1/2" = 1'-0"

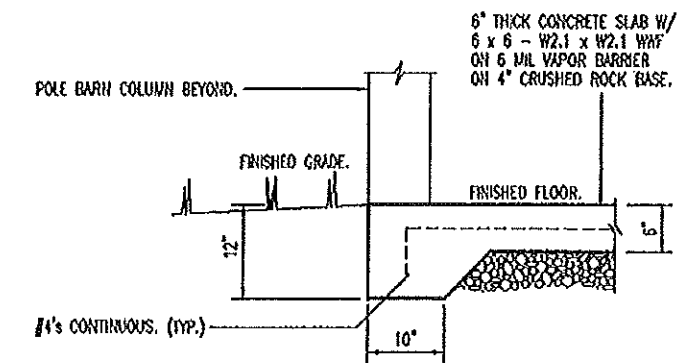

**C**  
2  
FLOOR SLAB EDGE  
SCALE: 1/2" = 1'-0"

## FOUNDATION DETAILS

MISSOURI DEPARTMENT  
OF TRANSPORTATION  
DIVISION OF GENERAL SERVICES  
FACILITIES MANAGEMENT

Sedalia Pole Barn with Two Enclosed Bays  
Kansas City District - Pettis County  
2200 South Limit, Sedalia, MO 65301

DRAWN BY: LARRY CARRER  
CHECKED BY: GB  
DATE: 4-17-15  
Sheet  
2 of 13






| DOOR SCHEDULE |                        |       |          |           |         |        |            |
|---------------|------------------------|-------|----------|-----------|---------|--------|------------|
| NO.           | SIZE                   | SWING | DR. TYPE | FRM. TYPE | DETAIL  | DEPTH  | HUAR. GRP. |
| 1             | 3'-0" x 7'-0" x 1-3/4" | RHR   | A        | I         | C-8     | 6-1/2" | I          |
| 2             | 14'-0" x 14'-0" x 2"   | -     | B        | -         | A & B-8 | -      | -          |
| 3             | 14'-0" x 14'-0" x 2"   | -     | B        | -         | A & B-8 | -      | -          |
| 4             | NOT USED               | -     | -        | -         | -       | -      | -          |

3'-0" x 7'-0" x 1-3/4"  
INSULATED HOLLOW METAL  
DOOR. PAINT PER  
SPECIFICATION.

TYPE A

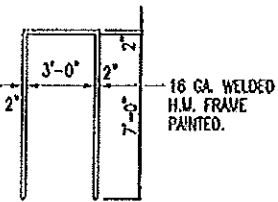

TYPE I

14'-0" x 14'-0" x 2"  
2" THICK, R-17.5, INSULATED  
PREFINISHED .016" METAL  
GARAGE DOOR WITH ONE  
INSULATED GLASS VIEW  
WINDOW. 26 GA. STEEL  
BACK COVER, WHITE BAKED  
ON POLYESTER TOP COAT  
PAINT ON BOTH SIDES.  
(TYPICAL)

TYPE B

26 GAUGE PREFINISHED  
ROOF PANELS ON POLYFOIL  
SINGLE BUBBLE REFLECTIVE  
INSULATION.

DIAGONAL CROSS BRACING  
FOR WALL @ 10'-0" O.C.

2 x 4 GIRTS @ 2'-4"  
O.C. HORIZONTALLY.

1/2" AC PLYWOOD BOTH  
SIDES PAINTED.

(3) 2 x 8 COLUMNS.

CLOSER TRIM WITH RAT  
GUARD. (TYPICAL)

FINISHED GRADE


16'-4"  
FINISHED FLOOR TO TRUSS BEARING

| FINISH SCHEDULE |                              |                                |                             |                           |                                       |
|-----------------|------------------------------|--------------------------------|-----------------------------|---------------------------|---------------------------------------|
| NO.             | ROOM                         | FLOOR                          | WALLS                       | BASE                      | CENTUNG                               |
|                 |                              | CURE AND SEALER<br>ON CONCRETE | 6" COMPACTED TYPE 5<br>ROCK | 26 GA. INTERIOR<br>PANELS | 1/2" AC PLYWOOD,<br>PAINTED. SEE A-5. |
| 101             | CLOSED BAYS                  | •                              | •                           | •                         | •                                     |
| 102             | OPEN BAYS WALL @ CLOSED BAYS | •                              | •                           | •                         | •                                     |

GENERAL NOTES:

BUILDING MANUFACTURER TO FURNISH ALL NECESSARY FLASHING  
AND TRIM TO PROVIDE A TIGHT, WEATHERPROOF FIT AT ALL DOORS,  
COLUMNS AND ANY LOCATION WHERE THE METAL PANELS MAY BE  
CUT.

A  
5 MID-WALL SECTION  
SCALE: 1/4" = 1'-0"

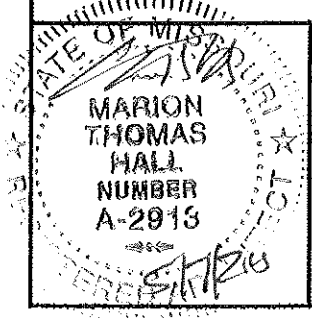


SCHEDULES


MISSOURI DEPARTMENT  
OF TRANSPORTATION  
DIVISION OF GENERAL SERVICES  
FACILITIES MANAGEMENT

Sedalia Pole Barn with Two Enclosed Bays  
Kansas City District - Pettis County  
2200 South Limit, Sedalia, MO 65301


DRAWN BY: LARRY CARER  
CHECKED BY: GS  
DATE: 4-17-15  
Sheet  
5 of 13

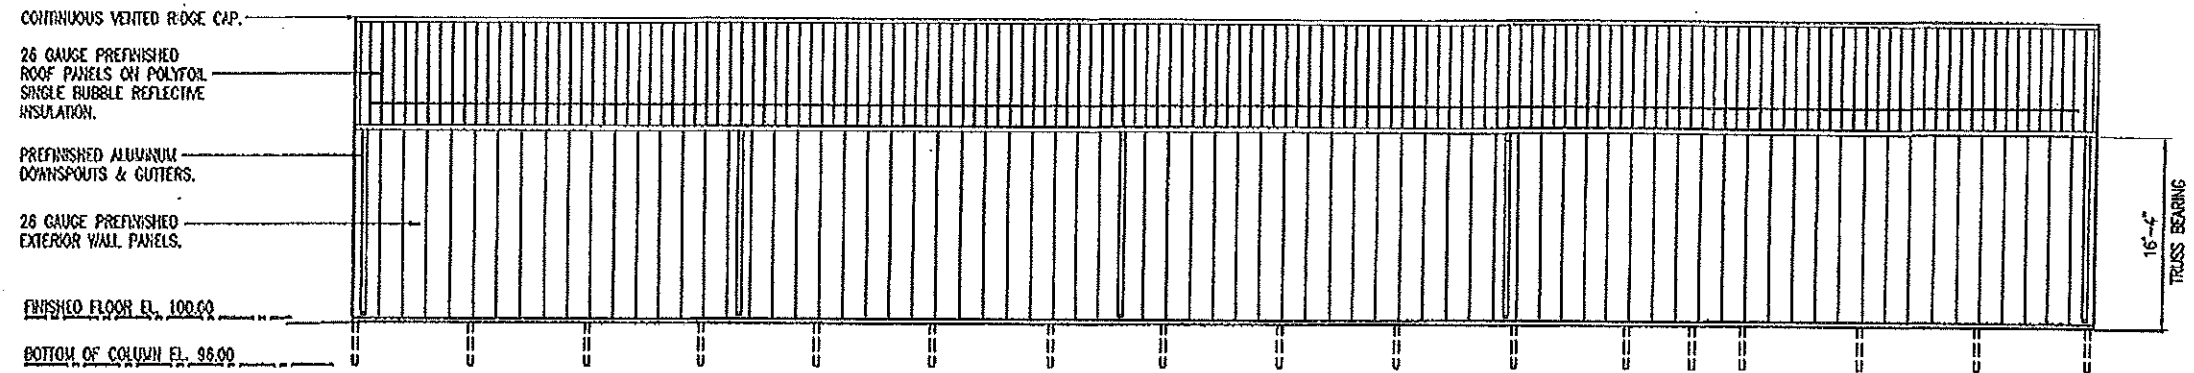

**B**  
**6** **REAR ELEVATION**  
SCALE: 1/16" = 1'-0"

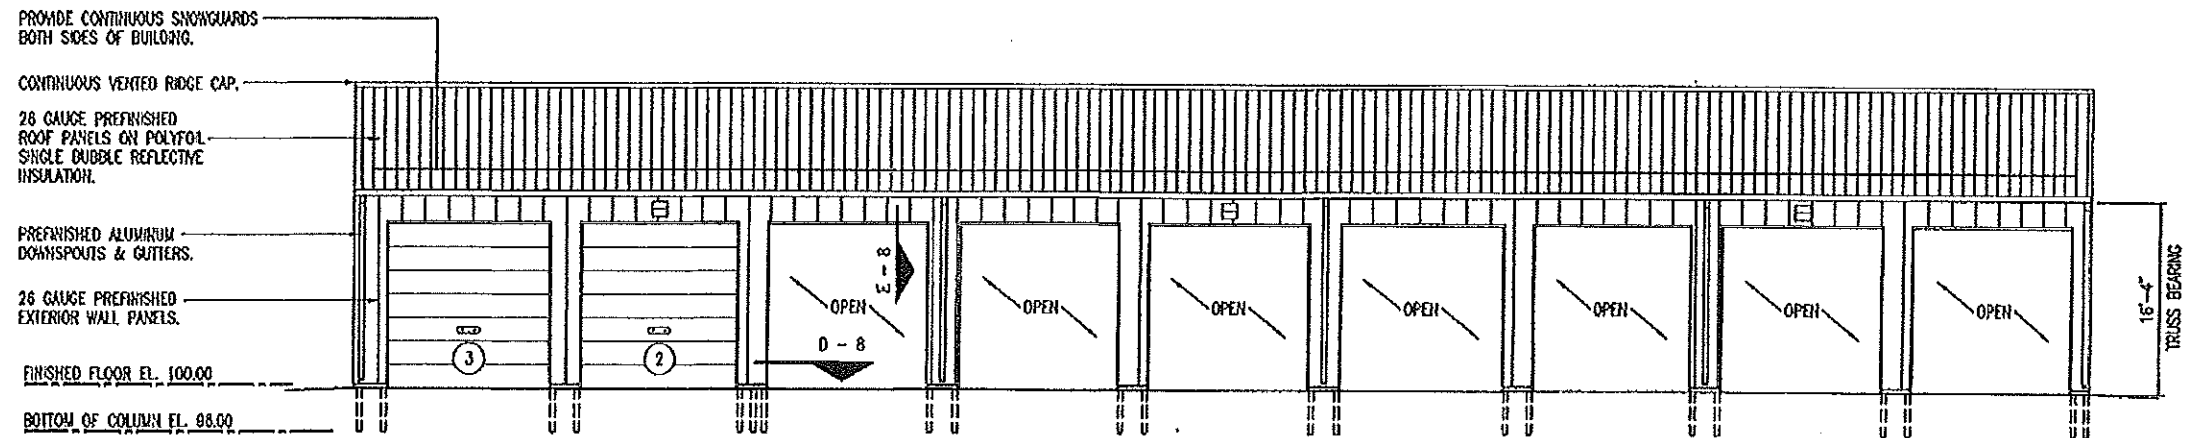

**A**  
**6** **FRONT ELEVATION**  
SCALE: 1/16" = 1'-0"

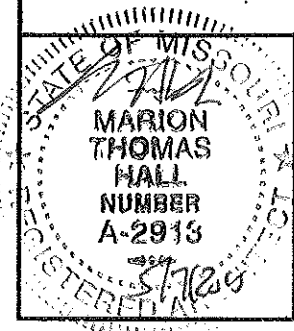


**FRONT & REAR ELEVATIONS**


**MISSOURI DEPARTMENT  
OF TRANSPORTATION**  
DIVISION OF GENERAL SERVICES  
FACILITIES MANAGEMENT

Sedalia Pole Barn with Two Enclosed Bays  
Kansas City District - Pettis County  
2200 South Limit, Sedalia, MO 65301

DRAWN BY: LARRY CARTER  
CHECKED BY: GB  
DATE: 4-17-15  
Sheet  
6 of 13

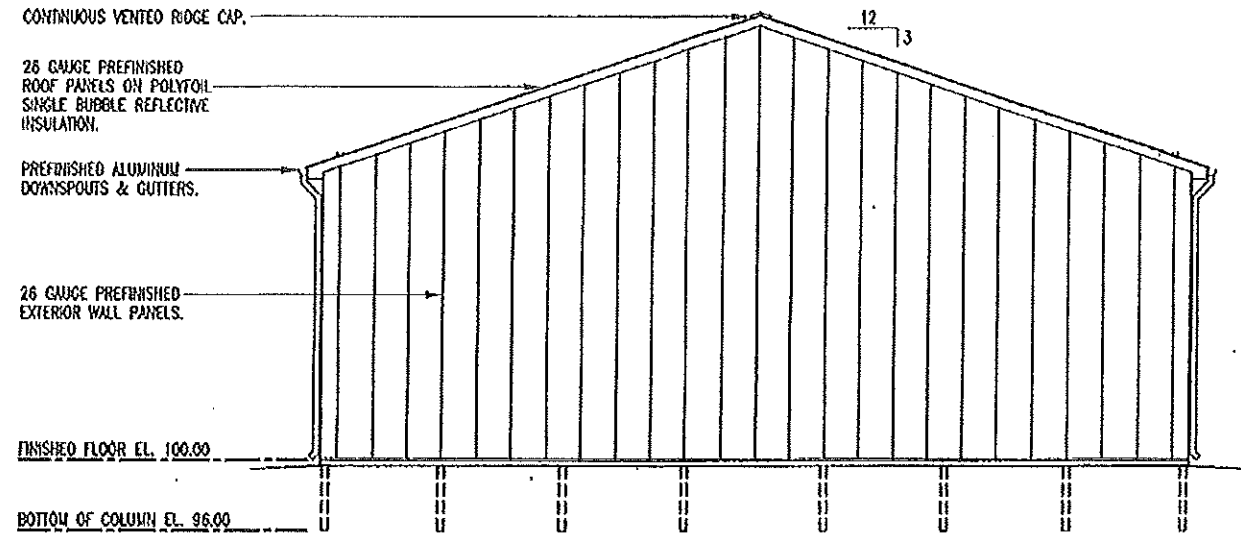

**B**  
7  
**LEFT ELEVATION**  
SCALE: 3/32" = 1'-0"

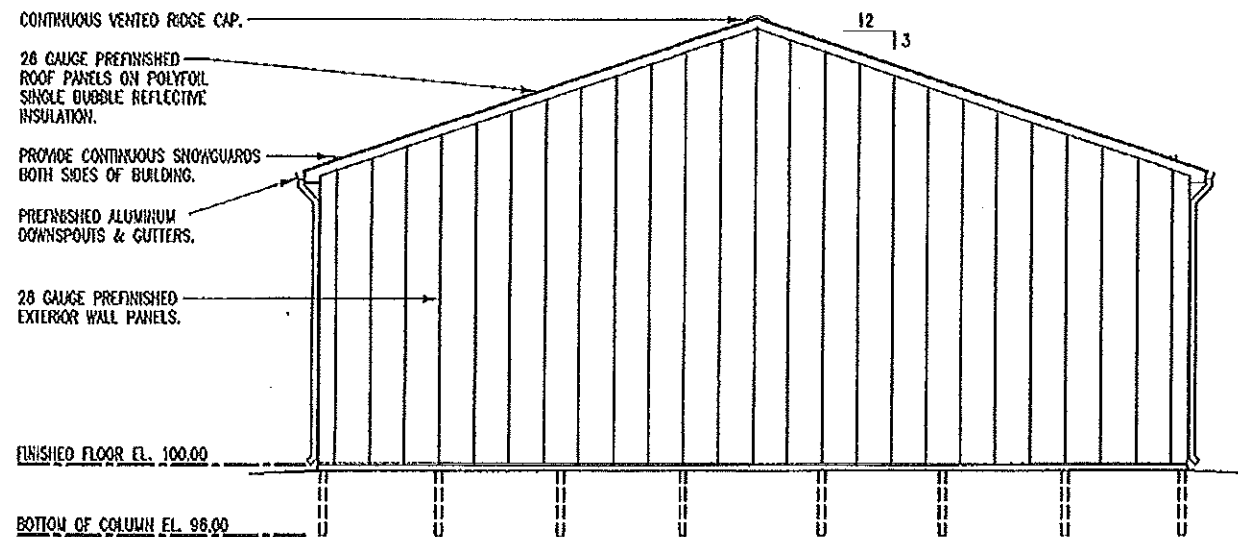


**A**  
7  
**RIGHT ELEVATION**  
SCALE: 3/32" = 1'-0"


**LEFT & RIGHT ELEVATIONS**

**MISSOURI DEPARTMENT  
OF TRANSPORTATION**  
DIVISION OF GENERAL SERVICES  
FACILITIES MANAGEMENT


Sedalia Pole Barn with Two Enclosed Bays  
Kansas City District - Pettis County  
2200 South Limit, Sedalia, MO 65301

DRAWN BY: LARRY CAYLER  
CHECKED BY: CB  
DATE: 1-17-15  
Sheet  
7 of 13

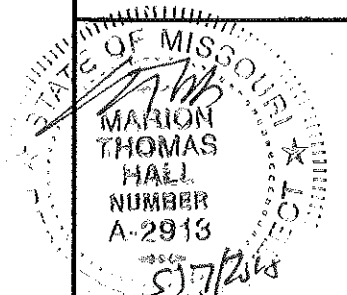


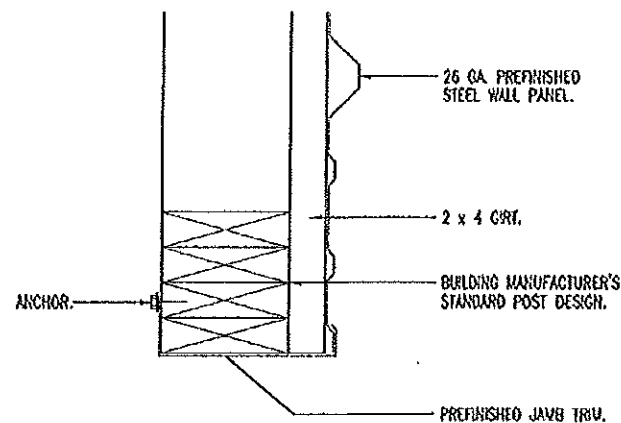


**D** GARAGE DOOR JAMB  
8 SCALE: 1-1/2" = 1'-0"

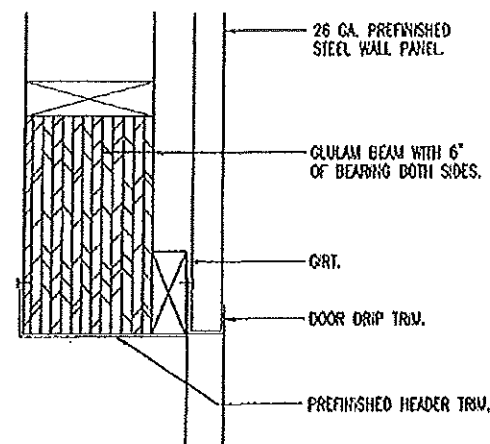


**E** GARAGE DOOR HEAD  
8 SCALE: 1-1/2" = 1'-0"

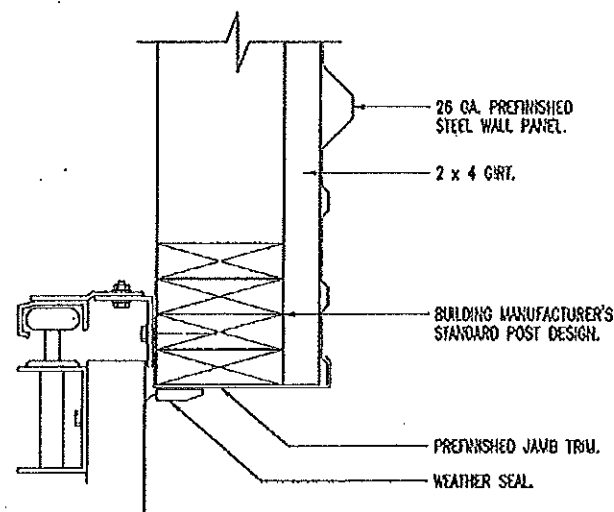


**A** GARAGE DOOR JAMB  
8 SCALE: 1-1/2" = 1'-0"

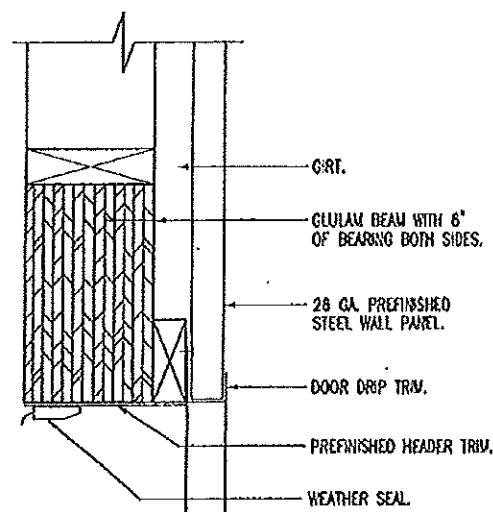

**B** GARAGE DOOR HEAD  
8 SCALE: 1-1/2" = 1'-0"

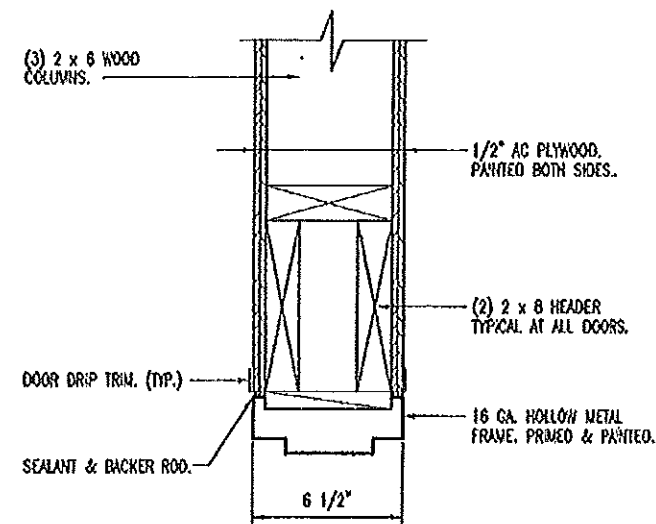

**C** DOOR HEADER/JAMB  
8 SCALE: 1-1/2" = 1'-0"

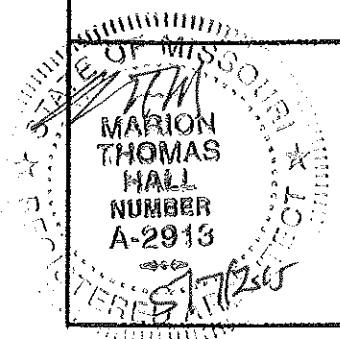


## HEAD & JAMB DETAILS


MISSOURI DEPARTMENT  
OF TRANSPORTATION  
DIVISION OF GENERAL SERVICES  
FACILITIES MANAGEMENT

Sedalia Pole Barn with Two Enclosed Bays  
Kansas City District - Pettis County  
2200 South Limit, Sedalia, MO 65301


BY: LARRY CARER  
CHECKED BY: CB  
DATE: 4-17-15  
Sheet  
8 of 13

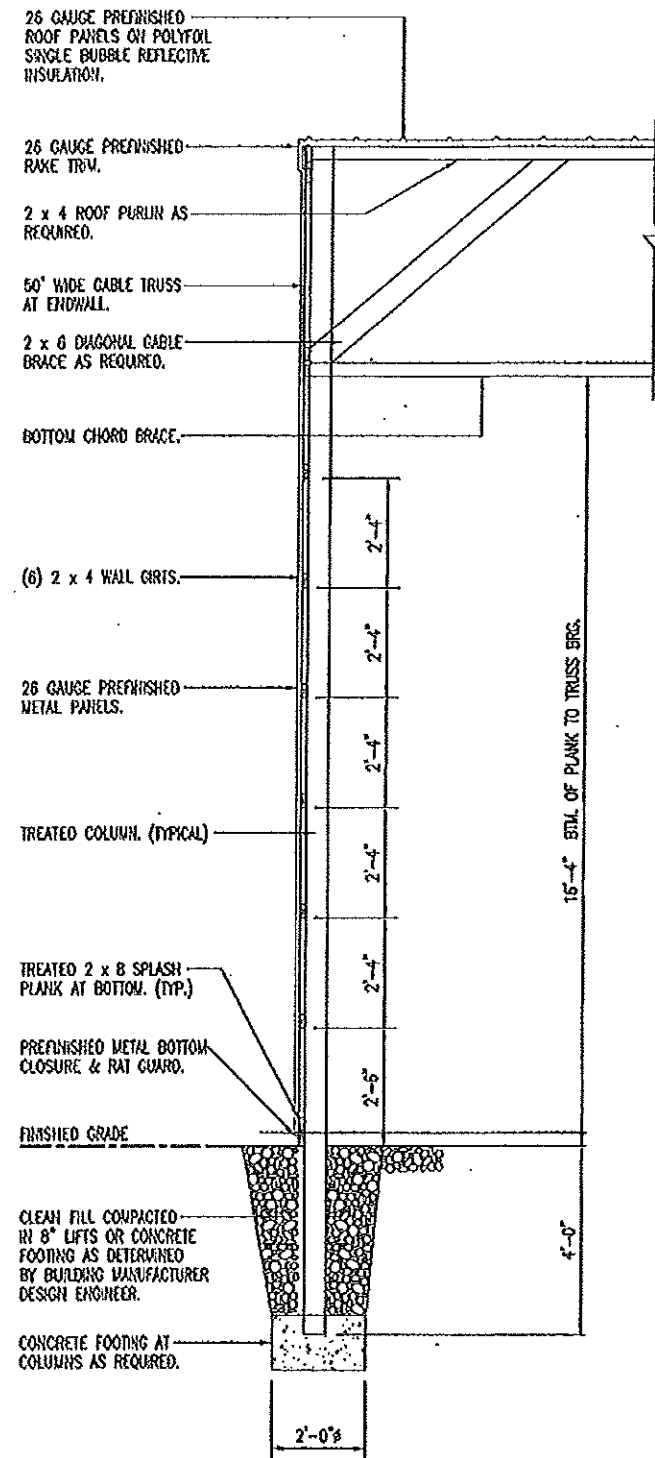


**A** ENDWALL SECTION  
9 SCALE: 1/4" = 1'-0"

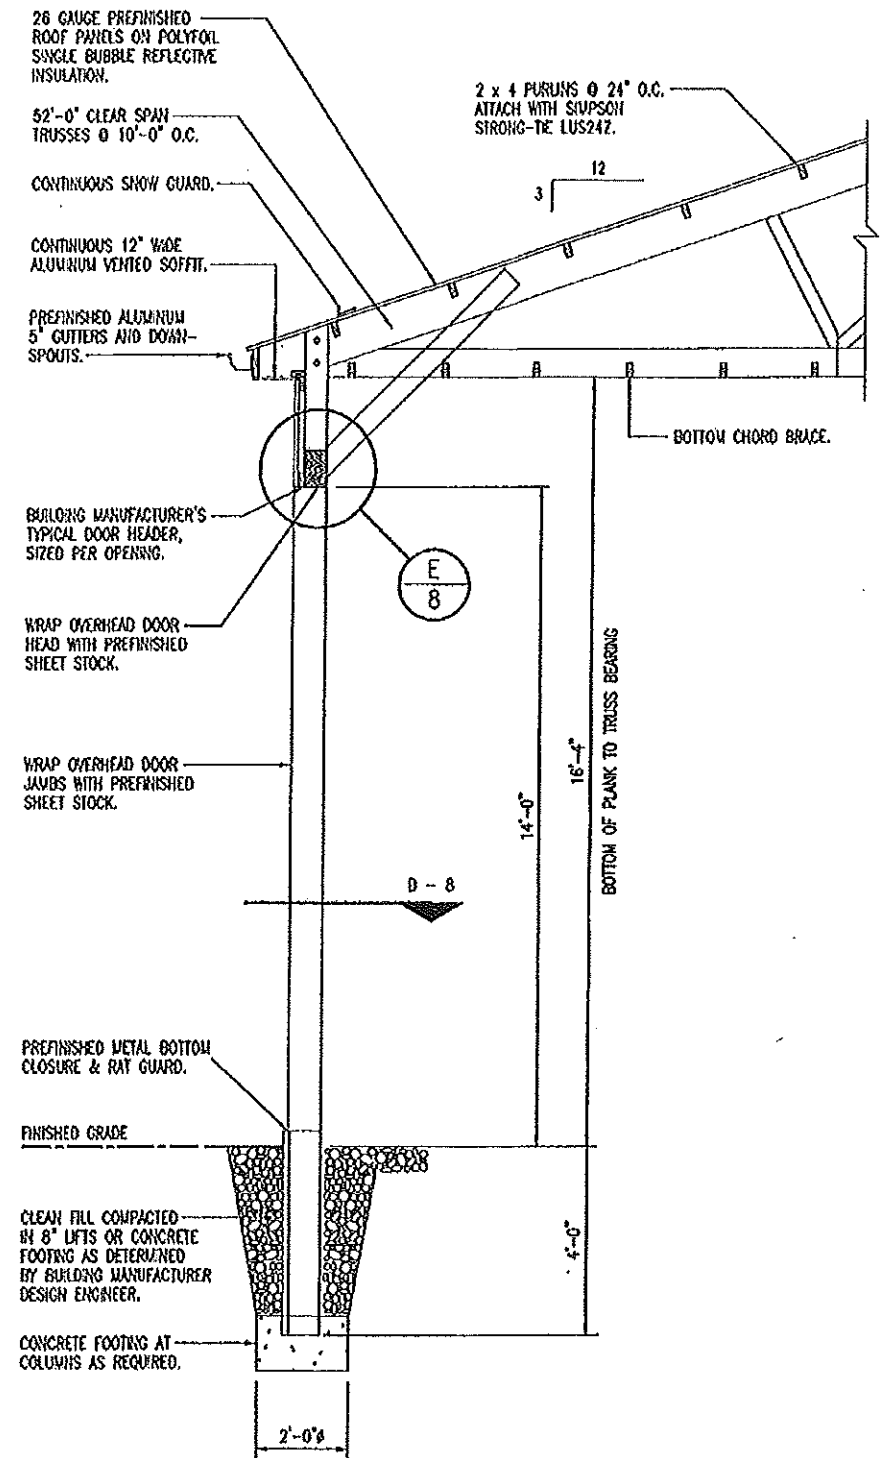

**B** OVERHEAD DOOR SECTION  
9 SCALE: 1/4" = 1'-0"

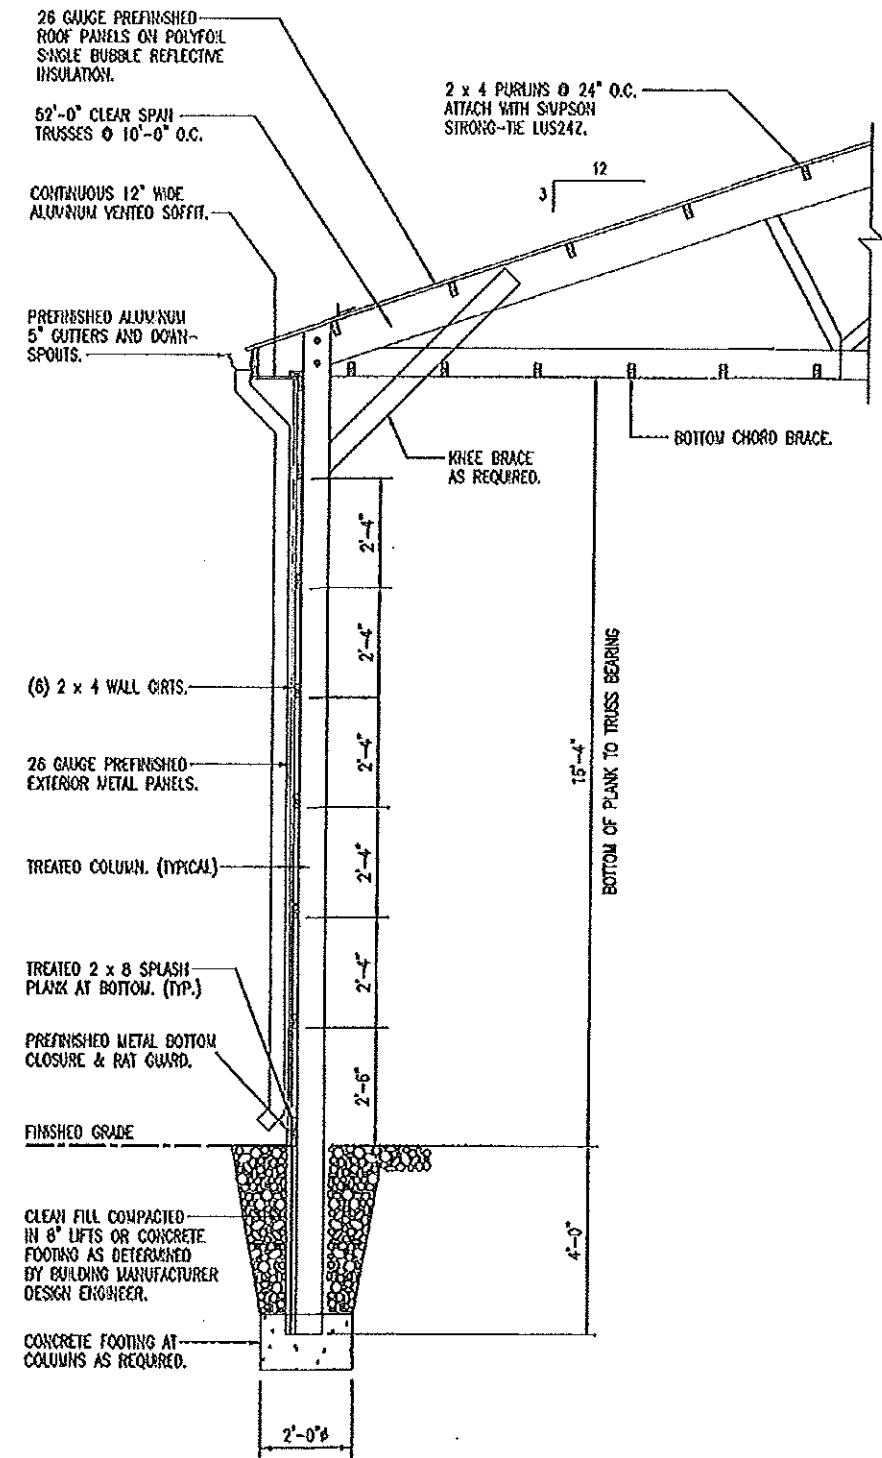


**C** SIDEWALL SECTION  
9 SCALE: 1/4" = 1'-0"

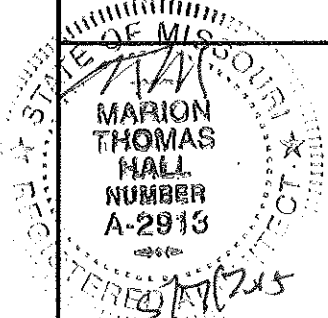


**WALL SECTIONS**

**MISSOURI DEPARTMENT OF TRANSPORTATION**  
DIVISION OF GENERAL SERVICES  
FACILITIES MANAGEMENT


Sedalia Pole Barn with Two Enclosed Boys  
Kansas City District - Pettis County  
2200 South Limit, Sedalia, MO 65301

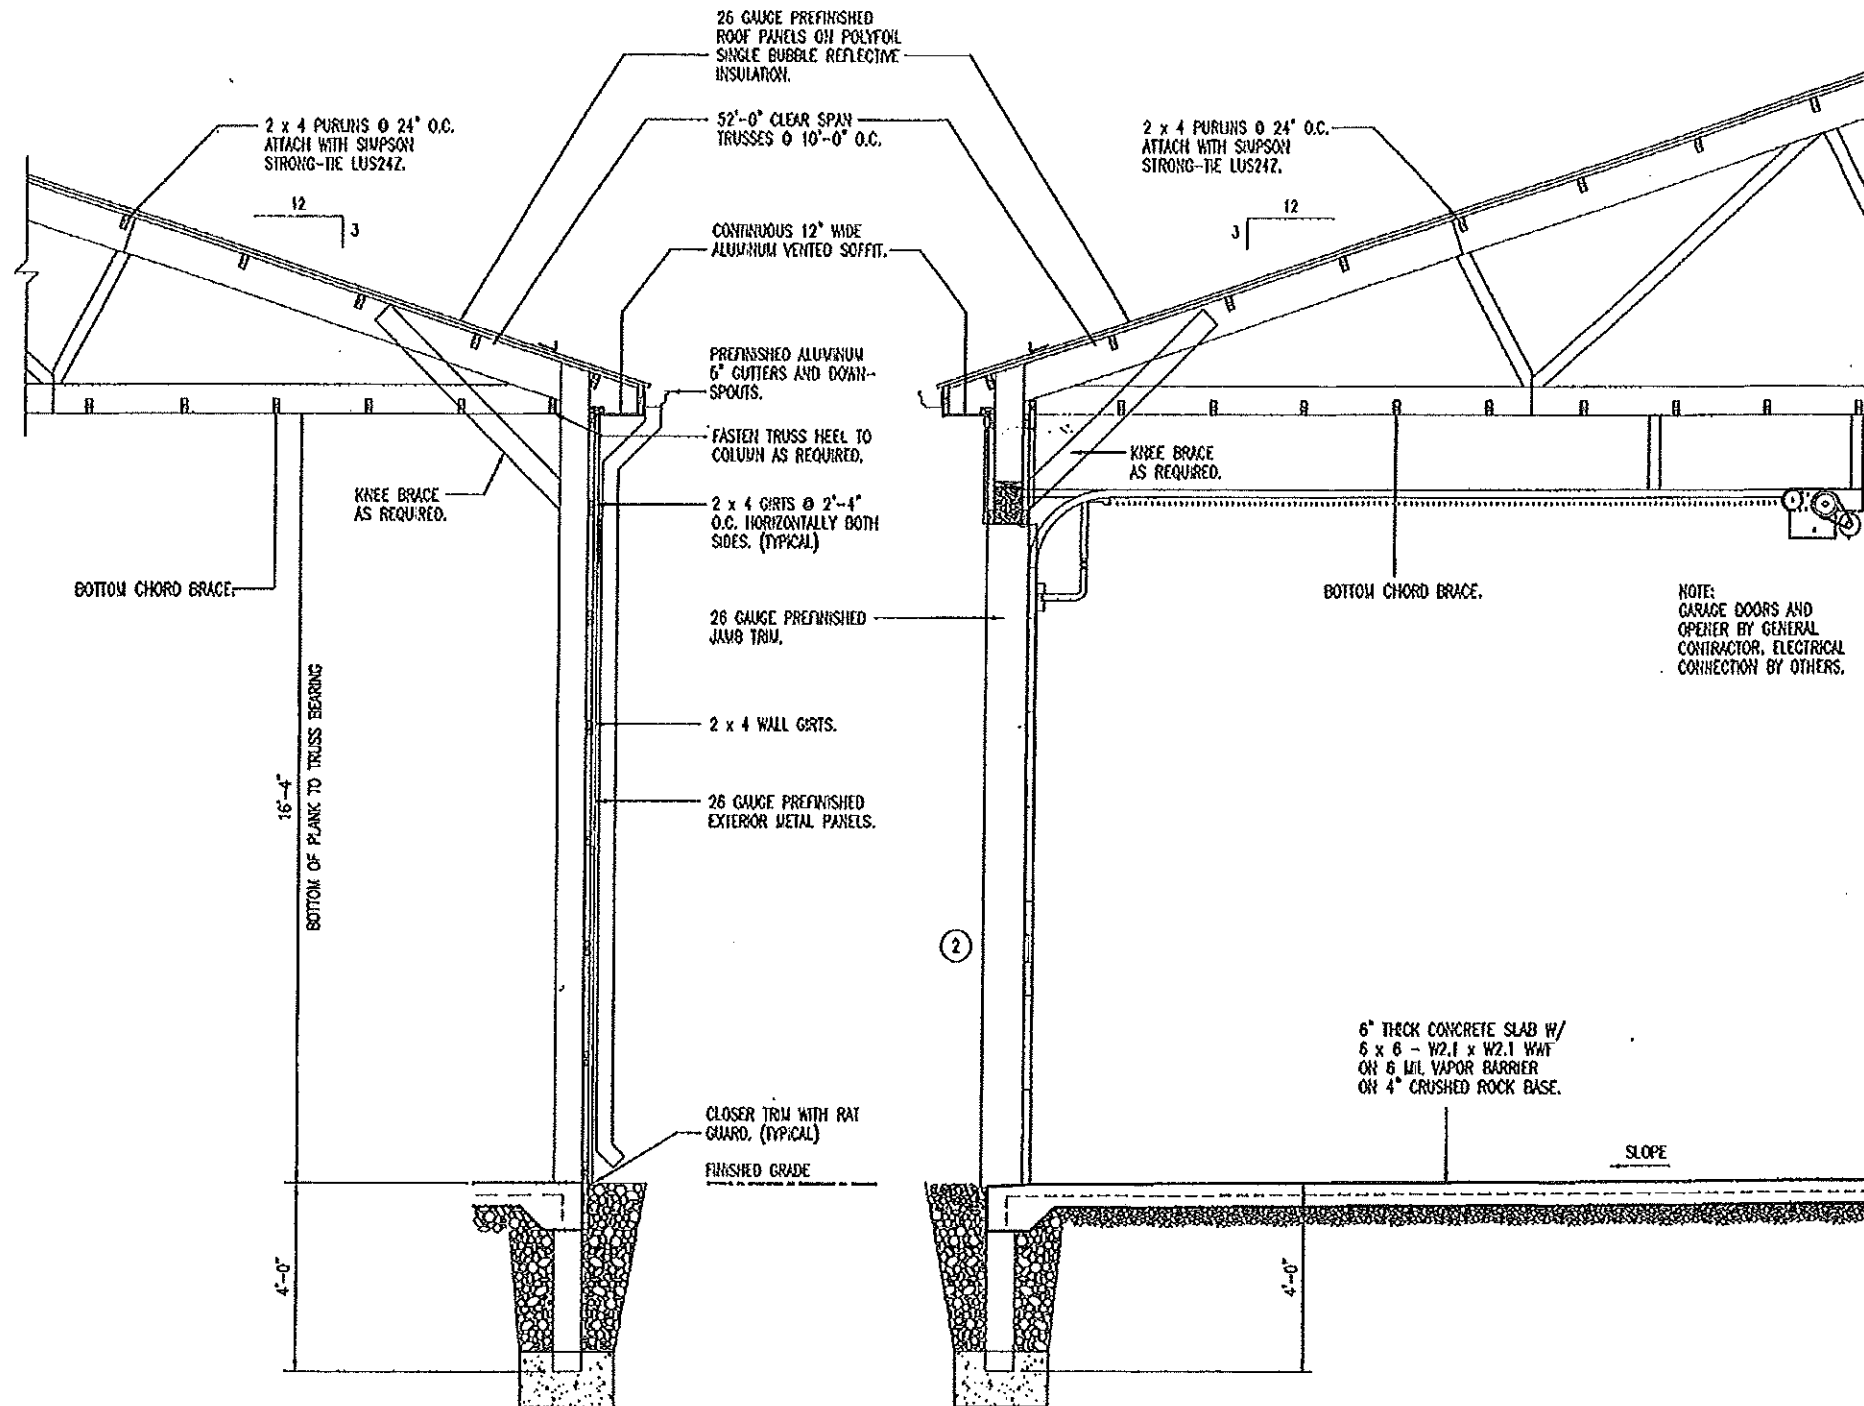


**A**  
**10** **SIDEWALL SECTION**  
SCALE: 1/4" = 1'-0"

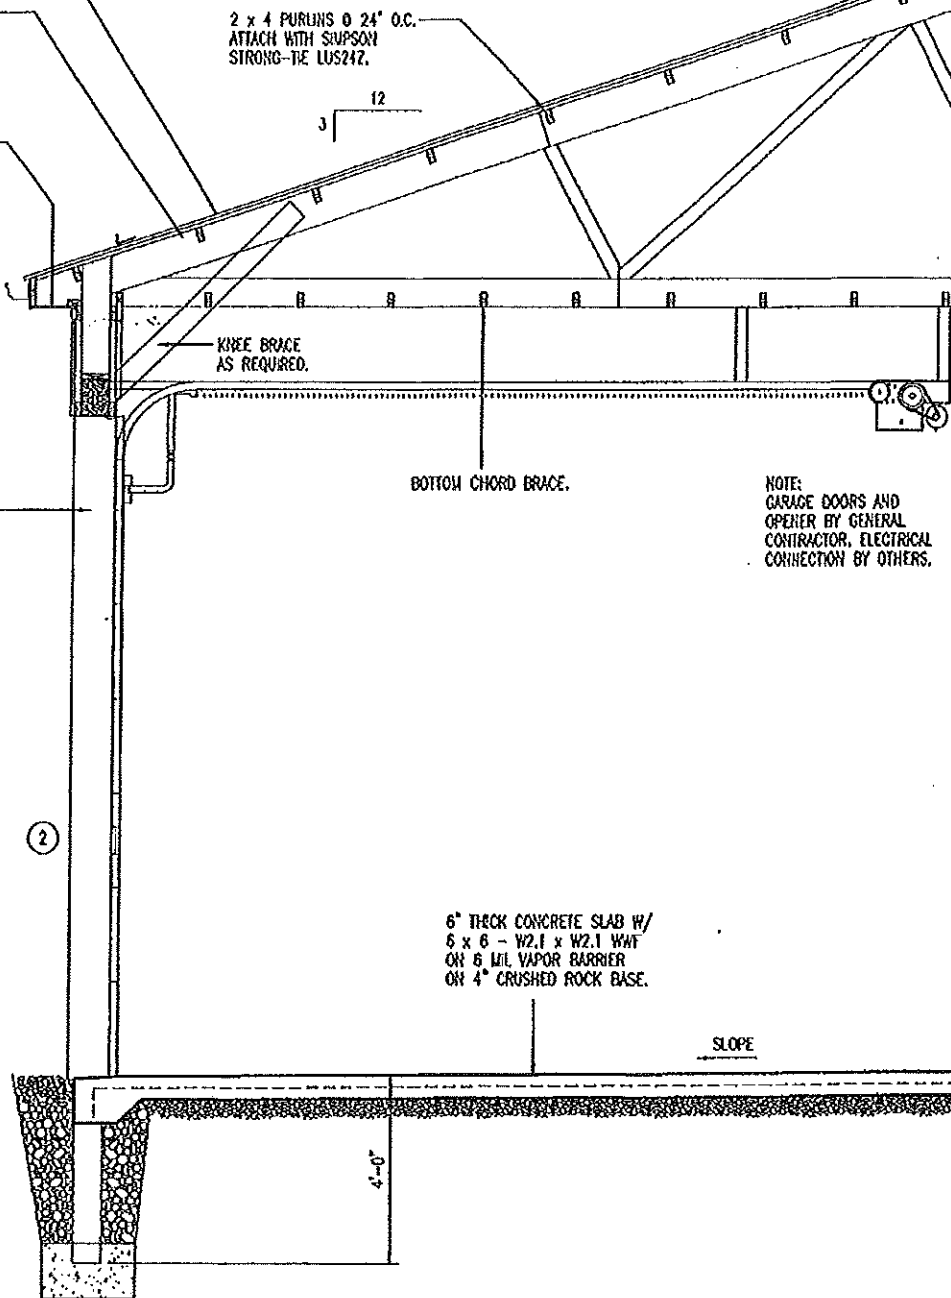

**B**  
**10** **OVERHEAD DOOR SECTION**  
SCALE: 1/4" = 1'-0"

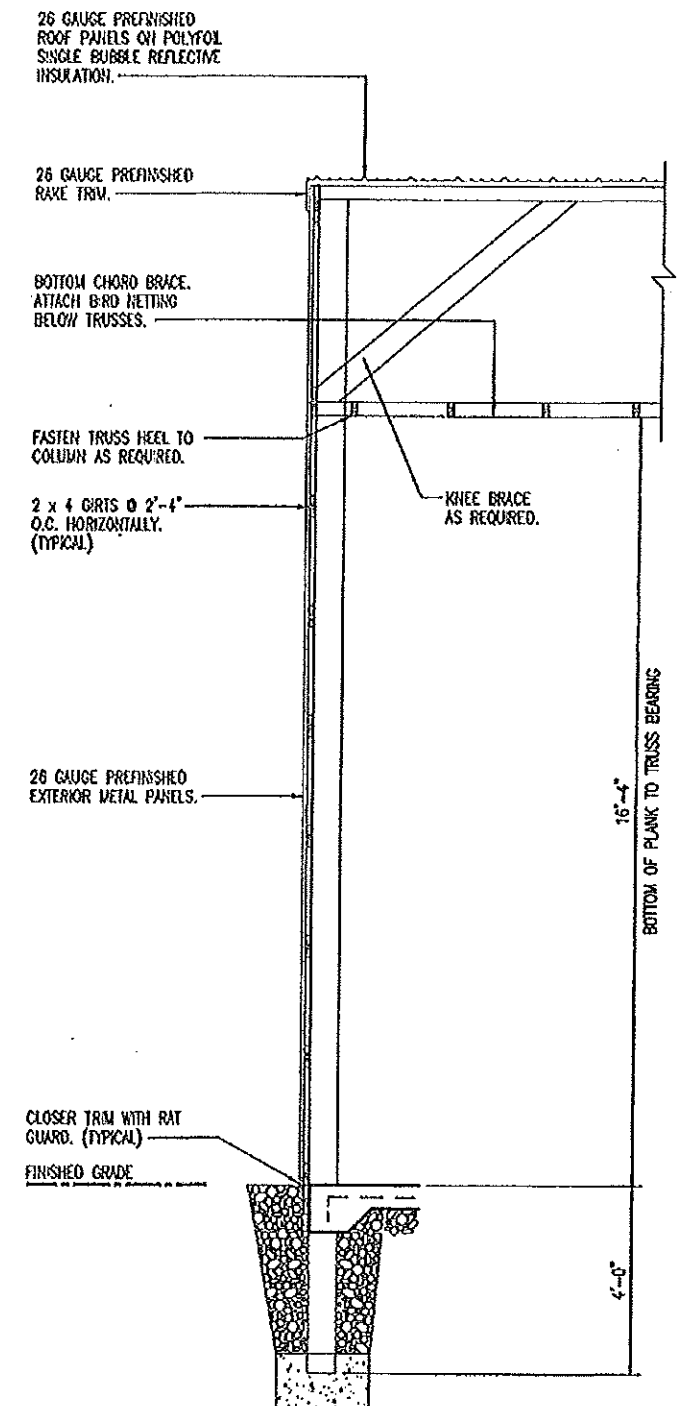

**C**  
**10** **ENDWALL SECTION**  
SCALE: 1/4" = 1'-0"

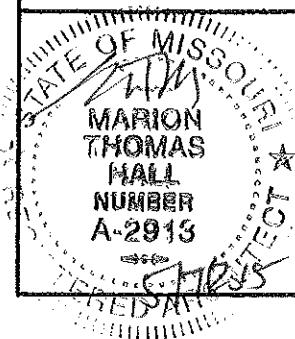

## WALL SECTIONS

MISSOURI DEPARTMENT  
OF TRANSPORTATION  
DIVISION OF GENERAL SERVICES  
FACILITIES MANAGEMENT

Sedalia Pole Barn with Two Enclosed Bays  
Kansas City District - Pettis County  
2200 South Limit, Sedalia, MO 65301

DRAWN BY: LARRY CARVER  
CHECKED BY: DB  
DATE: 4-17-15  
Sheet  
10 of 13

ROOF FRAMING NOTES

1. DESIGN LOADING FOR ROOF TRUSSES SHALL MEET THE FOLLOWING CRITERIA:

ROOF LIVE LOAD 25 PSF  
ROOF DEAD LOAD 4 PSF  
BOTTOM CHORD DEAD LOAD 5 PSF  
EARTHQUAKE ZONE 1, LATEST EDITION IBC  
WIND 90 MPH, EXPOSURE B  
DEFLECTION L/360  
SPACING 10'-0" O.C.

2. TRUSS DESIGN SUBMITTALS SHALL BE SEALED AND SIGNED BY A PROFESSIONAL ENGINEER LICENSED IN THE STATE OF MISSOURI.



3. ROOF TRUSSES AND BOTTOM CHORDS 2x6s SHALL BE ANCHORED TO THE TOP PLATE OF INTERIOR LOAD BEARING WALLS WITH SEISMIC AND HURRICANE ANCHORS EQUAL TO SAMPSON STRONG-TIE #11 ANCHORS WHEN ENCOUNTERED.

4. ROOF TRUSSES TO BE EACH CENTERED IN A POCKET WHICH IS THE DEPTH OF THE BOTTOM CHORD, MINIMUM, ON THE BACK WALL LAMINATED 2x POST(S) THAT ARE 10'-0" O.C. (TYPICAL) SEE DETAIL B-11.


2 x 4 PURLINS @ 24" O.C. ATTACH W/SAMPSON STRONG-TIE LUS24Z. (TYP.)

TRUSS SECURED IN COLUMN POCKET WITH (2) 1/2" x 5-1/2" M BOLTS & (8) 16d THIS NAILS. TRUSS SITS IN CENTER OF (3) LAMINATED 2 x 6s. (8) 16d THIS NAILS. TYPICAL AT BOTH ENDS OF TRUSS.

B TRUSS POCKET  
11 SCALE: 1/2" = 1'-0"

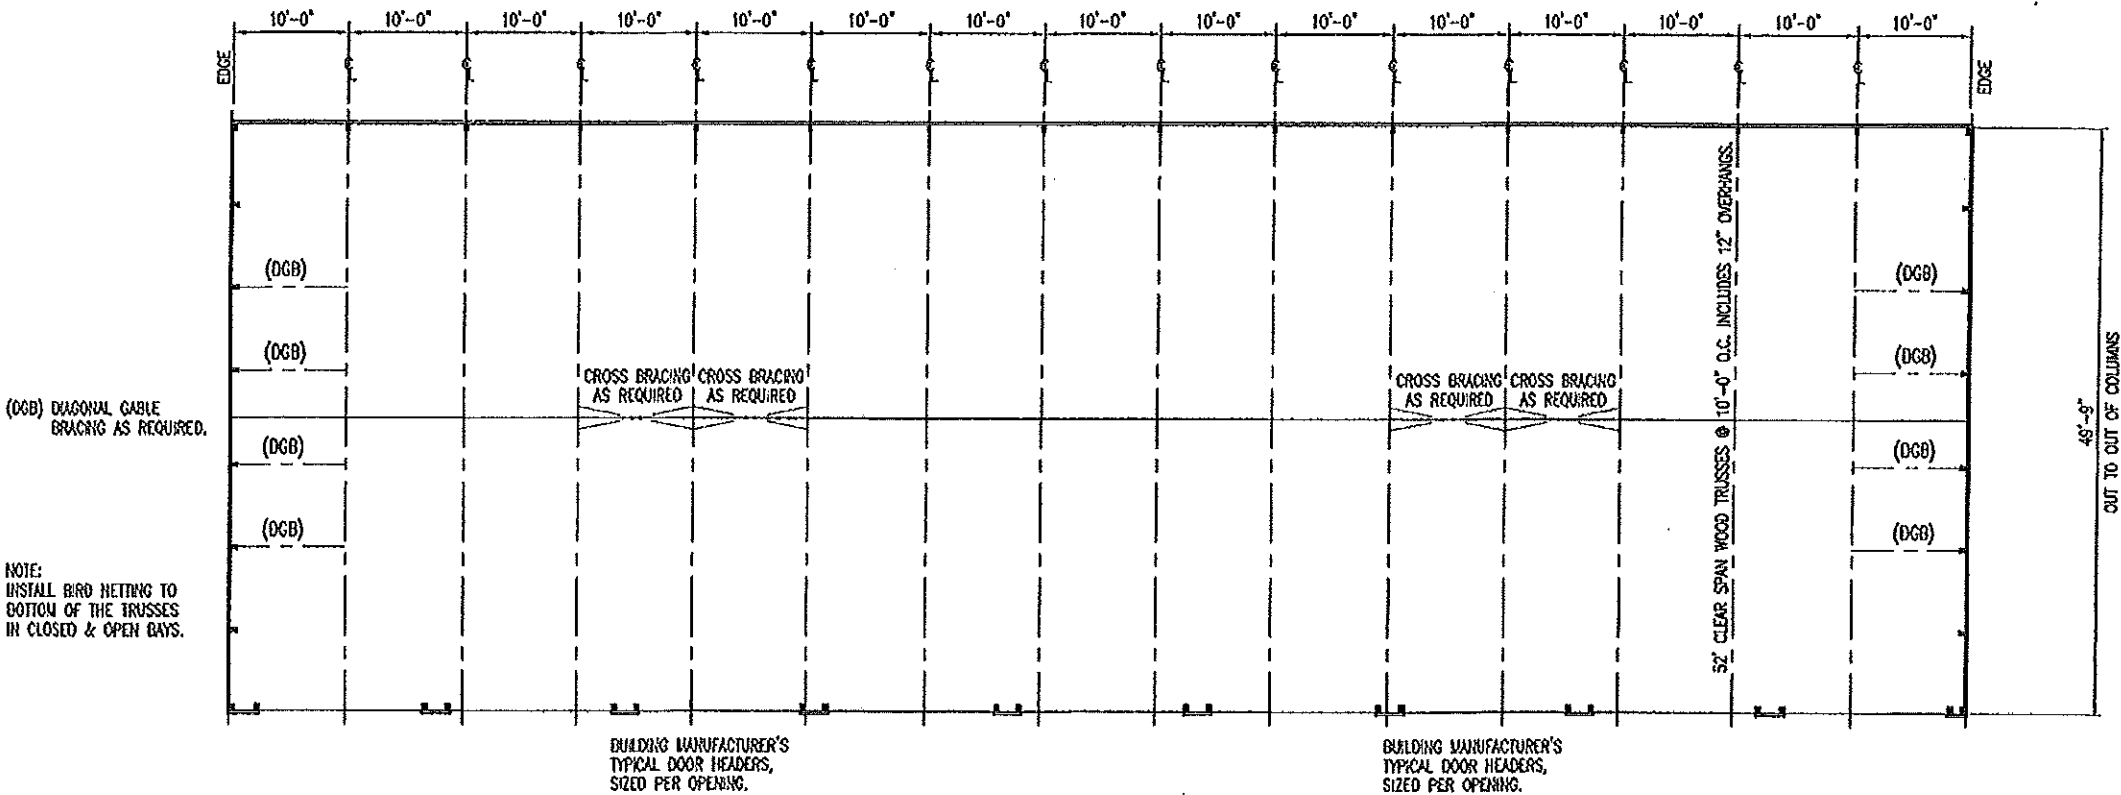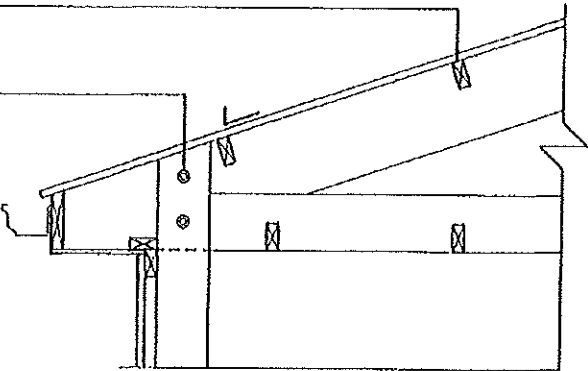

A ROOF FRAMING PLAN  
11 SCALE: 1/16" = 1'-0"

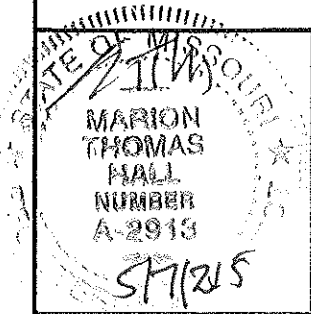

ROOF FRAMING PLAN


MISSOURI DEPARTMENT  
OF TRANSPORTATION  
DIVISION OF GENERAL SERVICES  
FACILITIES MANAGEMENT

Sedalia Pole Barn with Two Enclosed Bays  
Kansas City District - Pettis County  
2200 South Limit, Sedalia, MO 65301

DRAWN BY: LARRY CARRER  
CHECKED BY: CB  
DATE: 4-17-15  
Sheet 11 of 13

\$ WP SINGLE POLE SWITCH, MOUNT IN FS BOX W/ HUBBELL HBL 7420 COVER.  
 \$ WP DUPLEX RECEPTACLE MOUNTED IN FS BOX WITH HUBBELL HBL5221 COVERED.  
 \$ WP SINGLE RECEPTACLE MOUNTED IN FS BOX WITH HUBBELL HBL7423 COVER.

- ☐ WELDER RECEPTACLE SURFACE MOUNTED 42" A.F.F., MOUNT IN 4" SQUARE BOX WITH RAISED COVER.  
☐ NO FUSED DISCONNECT SWITCH.  
☐ JUNCTION BOX, SIZE FOR WIRE, FILL ACCORDING TO ARTICLE 314-16 OF THE N.E.C.
- 

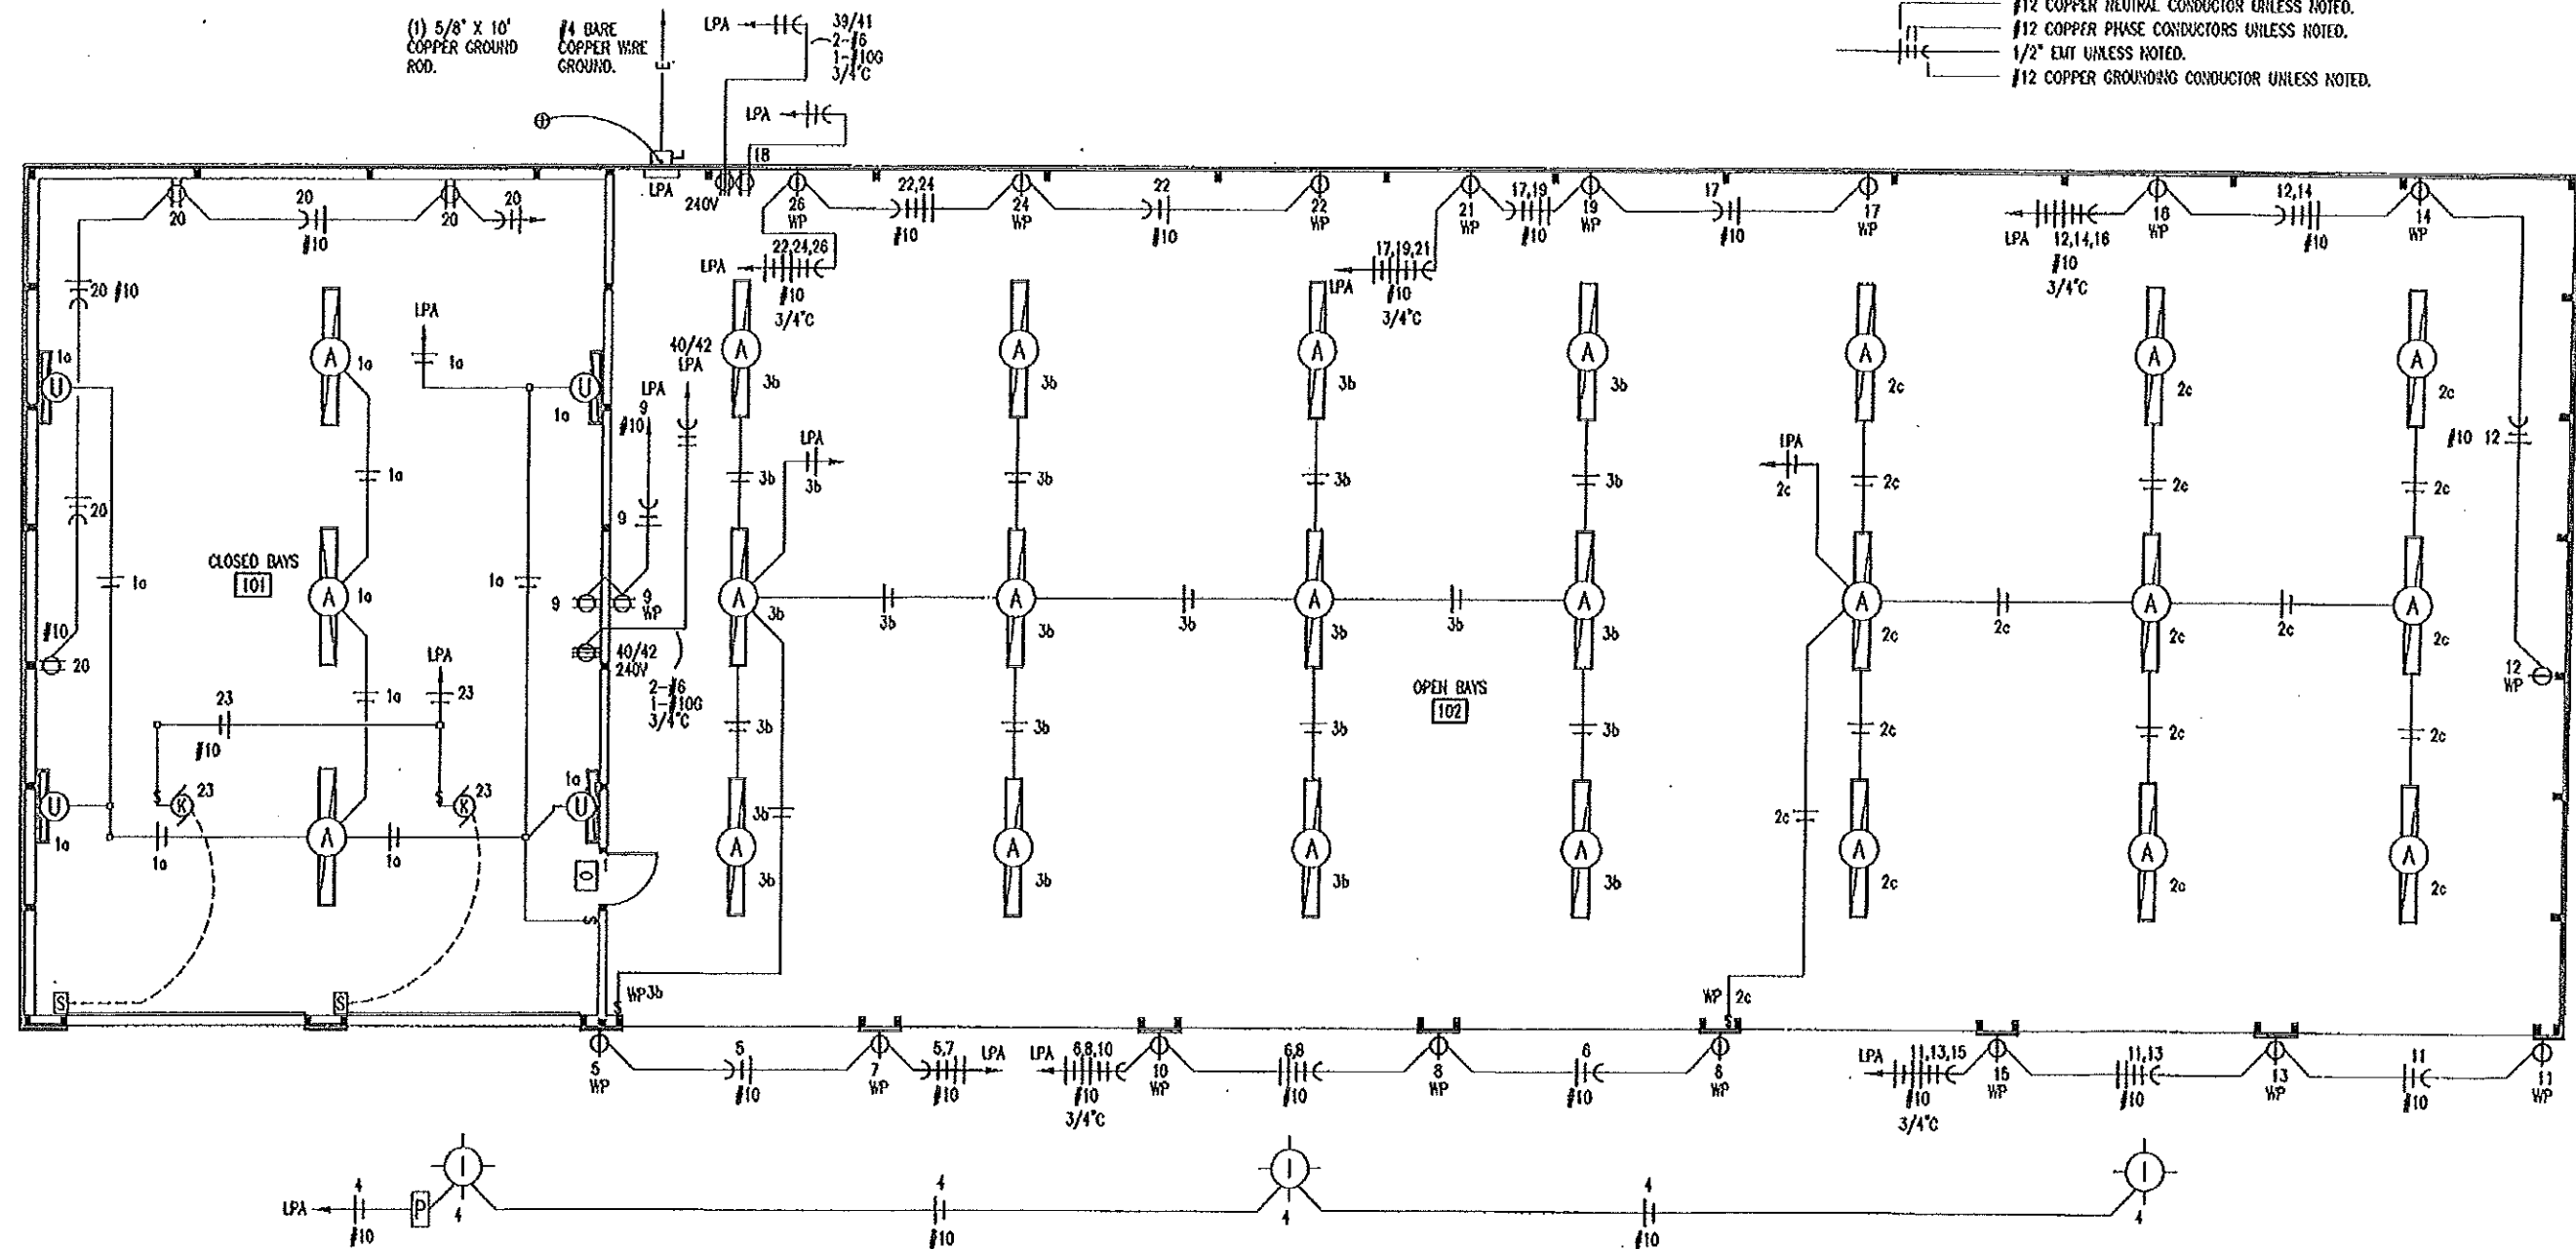

BY OTHERS  
ELECTRICAL PLAN  
SCALE: 3/32" = 1'-0"

SEE ELECTRIC SCHEDULE SHEET 13.

# ELECTRICAL PLAN

MISSOURI DEPARTMENT  
OF TRANSPORTATION  
DIVISION OF GENERAL SERVICES  
FACILITIES MANAGEMENT

Sedalia Pole Barn with Two Enclosed Bays  
Kansas City District - Pettis County  
2200 South Limit, Sedalia, MO 65301

DRAWN BY: LARRY CARVER  
 CHECKED BY: GO  
 DATE: 4-17-15  
 Sheet  
 12 of 13

MARION  
THOMAS  
HALL  
NUMBER  
A-2913


| ELECTRIC SCHEDULE (BY OTHERS *)                                                                                                              |                                                                     |            |     |       |                                                                                                                   |
|----------------------------------------------------------------------------------------------------------------------------------------------|---------------------------------------------------------------------|------------|-----|-------|-------------------------------------------------------------------------------------------------------------------|
| MANUF.                                                                                                                                       | MODEL                                                               | LAMPS TYPE | W   | MOUNT | REMARKS                                                                                                           |
| WILLIAMS                                                                                                                                     | 82-8-L214/840-(1200)-WG-8211-VBY-2-DRY-UNV                          | LED        | 174 | CLG   | 98" LONG CHAIN MOUNT, 20-GAUGE, RIBBED C.R.S. POLYESTER POWDER COAT AND WIRE GUARD.                               |
| LITHONIA                                                                                                                                     | THRI LED 1 50K MVOLT                                                | LED        | 35  | WALL  | RUGGED CAST ALUMINUM WITH BRONZE POWDER PAINT, ONE PIECE GASKET TO INHIBIT THE ENTRANCE OF EXTERNAL CONTAMINATES. |
|                                                                                                                                              | OVERHEAD DOOR OPERATOR                                              |            |     | WALL  | 115V, 1-PH, TROLLEY TYPE, SEE SPECIFICATION SECTION 08720.                                                        |
| LITHONIA                                                                                                                                     | LHQM P W3 R H                                                       |            |     | WALL  | QUANTUM THERMOPLASTIC EXT/UNIT COMBO (2) LED 5.4 KRYPTON LAMPS.                                                   |
| TORK                                                                                                                                         | 2001                                                                |            |     | WALL  | 120V PHOTO ELECTRIC CONTROL OF EXTERIOR LIGHTS.                                                                   |
|                                                                                                                                              | * OVERHEAD DOOR CONTROL PROVIDED AND INSTALL BY GENERAL CONTRACTOR. |            |     | WALL  | THREE BUTTON OVERHEAD DOOR CONTROL AS SUPPLIED BY OVERHEAD DOOR MANUF. SEE SPECIFICATION SECTION 08720.           |
| WILLIAMS                                                                                                                                     | WVAUD-4-LEDPH-32/840U/PH32/8400-AF-EOPHU/EOPHD-120                  | LED        | 79  | WALL  | 48" LENGTH UP/DOWN FIXTURE, FROSTED ACRYLIC SHIELDING, WHITE POLYESTER COATING, MOUNT 7'-0" A.F.F. TO BOTTOM.     |
| ELECTRICAL FIXTURES AND EQUIPMENT ARE SCHEDULED BY MANUFACTURER AND MODEL NUMBER FOR DESIGN INTENT ONLY, APPROVED EQUALS MAY BE SUBSTITUTED. |                                                                     |            |     |       |                                                                                                                   |

#### ELECTRICAL NOTES (BY OTHERS)

- DRAWINGS AND DIAGRAMS ARE DIAGRAMMATIC AND SHALL NOT BE SCALED. REFER TO ARCHITECTURAL DRAWINGS FOR DIMENSIONS.
- ELECTRICAL WORK SHALL BE INSTALLED IN STRICT COMPLIANCE WITH THE LATEST EDITION OF THE NATIONAL ELECTRIC CODE (N.E.C.).
- PROVIDE ELECTRICAL EQUIPMENT AND ACCESSORIES REQUIRED FOR A COMPLETE AND OPERATIONAL ELECTRICAL SYSTEM AS REQUIRED BY MANUFACTURER'S INSTRUCTIONS AND DIRECTIONS FOR SYSTEMS SPECIFIED.
- SWITCHES AND RECEPTACLES SHALL BE EQUAL TO THE AMPERE RATING SHOWN IN THE PANEL SCHEDULE. RECEPTACLES SHALL BE GROUND-FAULT INTERRUPTION TYPE WHERE SHOWN OR AS REQUIRED BY CODE.
- ALL RECEPTACLES IN BAY AREA TO BE MOUNTED AT 48" A.F.F.
- COORDINATE WORK WITH OTHER TRADES PRIOR TO COMMENCING WITH ELECTRICAL WORK.
- CONDUCTOR AND BREAKER SIZE MAY VARY PER MANUFACTURER ON THE EQUIPMENT SPECIFIED. ELECTRIC CONTRACTOR TO VERIFY SIZES WITH EXACT EQUIPMENT ORDERED PRIOR TO PURCHASING ELECTRICAL SUPPLIES.
- FIXTURE LOCATIONS ARE APPROXIMATE, EXACT LOCATIONS TO BE DETERMINED AFTER COLLABORATION WITH THE OWNER AND OTHER TRADES.
- CONTRACTOR SHALL PROVIDE SERVICE DISCONNECTS AS REQUIRED AT EXTERIOR OF BUILDING.
- PROVIDE BLOCKING FOR ELECTRICAL DEVICES AS REQUIRED FOR A SECURE APPLICATION.
- SEE SPECIFICATION SECTION 16100 - ELECTRICAL FOR ADDITIONAL REQUIREMENTS.
- CONTRACTOR TO INSTALL CONDUCTORS IN CONDUIT FROM POWER POLE UP TO SERVICE DISCONNECT AND THEN TO INSIDE FOR A FUNCTIONAL SYSTEM. PROVIDE AND INSTALL METER AS/IF REQUIRED.

| SERVICE PANEL LPA (BY OTHERS)                                                                  |                       |      |                                                                                                 |   |       |                                                                                   |                       |  |     |
|------------------------------------------------------------------------------------------------|-----------------------|------|-------------------------------------------------------------------------------------------------|---|-------|-----------------------------------------------------------------------------------|-----------------------|--|-----|
| MAIN BUS: 225A MLO<br>VOLTS: 240/120, 1PH, 3-WIRE<br>BUS MATERIAL: COPPER<br>MOUNTING: SURFACE |                       |      | SQUARE "D" HOOD OR EQUAL<br>W/ NEUTRAL BUS & GROUNDING BUS<br>CIRCUIT BREAKERS BOLT-IN 10000 AC |   |       | CONNECTED LOAD<br>A PHASE 22342 VA<br>B PHASE 20503 VA<br>TOTAL 42845 VA<br>178 A |                       |  |     |
| CIR                                                                                            | SERVICE               | VA   | BKR                                                                                             |   | BKR   | VA                                                                                | SERVICE               |  | CIR |
| 1                                                                                              | LIGHTS - 101          | 844  | 20A1P                                                                                           | A | 20A1P | 1566                                                                              | LIGHTS - 102          |  | 2   |
| 3                                                                                              | LIGHTS - 102          | 698  | 20A1P                                                                                           | B | 20A1P | 105                                                                               | EXTERIOR LIGHTS       |  | 4   |
| 5                                                                                              | EXTERIOR - RECEPTACLE | 1000 | 20A1P                                                                                           | A | 20A1P | 1000                                                                              | EXTERIOR - RECEPTACLE |  | 6   |
| 7                                                                                              | EXTERIOR - RECEPTACLE | 1000 | 20A1P                                                                                           | B | 20A1P | 1000                                                                              | EXTERIOR - RECEPTACLE |  | 8   |
| 9                                                                                              | RECEPTACLES           | 360  | 20A1P                                                                                           | A | 20A1P | 1000                                                                              | EXTERIOR - RECEPTACLE |  | 10  |
| 11                                                                                             | EXTERIOR - RECEPTACLE | 1000 | 20A1P                                                                                           | B | 20A1P | 1000                                                                              | RECEPTACLE            |  | 12  |
| 13                                                                                             | EXTERIOR - RECEPTACLE | 1000 | 20A1P                                                                                           | A | 20A1P | 1000                                                                              | RECEPTACLE            |  | 14  |
| 15                                                                                             | EXTERIOR - RECEPTACLE | 1000 | 20A1P                                                                                           | B | 20A1P | 1000                                                                              | RECEPTACLE            |  | 16  |
| 17                                                                                             | RECEPTACLES           | 1000 | 20A1P                                                                                           | A | 20A1P | 180                                                                               | RECEPTACLE            |  | 18  |
| 19                                                                                             | RECEPTACLES           | 1000 | 20A1P                                                                                           | B | 20A1P | 540                                                                               | RECEPTACLES           |  | 20  |
| 21                                                                                             | RECEPTACLES           | 1000 | 20A1P                                                                                           | A | 20A1P | 1000                                                                              | RECEPTACLE            |  | 22  |
| 23                                                                                             | GARAGE DOOR OPENERS   | 2162 | 30A1P                                                                                           | B | 20A1P | 1000                                                                              | RECEPTACLE            |  | 24  |
| 25                                                                                             |                       |      |                                                                                                 | A | 20A1P | 1000                                                                              | RECEPTACLE            |  | 26  |
| 27                                                                                             |                       |      |                                                                                                 | B |       |                                                                                   |                       |  | 28  |
| 29                                                                                             |                       |      |                                                                                                 | A |       |                                                                                   |                       |  | 30  |
| 31                                                                                             |                       |      |                                                                                                 | B |       |                                                                                   |                       |  | 32  |
| 33                                                                                             |                       |      |                                                                                                 | A |       |                                                                                   |                       |  | 34  |
| 35                                                                                             |                       |      |                                                                                                 | B |       |                                                                                   |                       |  | 36  |
| 37                                                                                             |                       |      |                                                                                                 | A |       |                                                                                   |                       |  | 38  |
| 39                                                                                             | 102 - WELDER          | 4500 | 50A2P                                                                                           | B | 50A2P | 4500                                                                              | 101 - WELDER          |  | 40  |
| 41                                                                                             |                       | 4500 |                                                                                                 | A |       | 4500                                                                              |                       |  | 42  |

Ⓢ CIRCUIT BREAKER SHALL BE GFI RATED

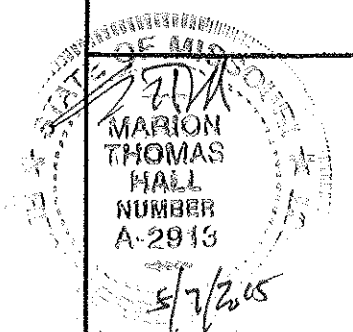

ELECTRICAL PANEL

MISSOURI DEPARTMENT  
OF TRANSPORTATION  
DIVISION OF GENERAL SERVICES  
FACILITIES MANAGEMENT

Sedalia Pole Barn with Two Enclosed Bays  
Kansas City District - Pettis County  
2200 South Limit, Sedalia, MO 65301

DRAWN BY: LARRY CARTER  
CHECKED BY: GB  
DATE: 4-17-15  
Sheet  
13 of 13