



MATCHLINE STA. 10+00.00 (SEE SHEET 5)


 3/4" MICROSURFACING

 4" SIDEWALK

 

 

[illegible]


DISCLAIMER
THE PROFESSIONAL WHOSE SIGNATURE AND PERSONAL SEAL APPEAR HEREON ASSUMES RESPONSIBILITY ONLY FOR WHAT APPEARS ON THIS PAGE, AND DISCLAIMS (PURSUANT TO SECTION 327.411 RSMD) SPECIFICATION, ESTIMATES, REPORTS, OR OTHER DOCUMENTS OR INSTRUMENTS NOT SEALED BY THE UNDERSIGNED PROFESSIONAL RELATING TO OR INTENDED TO BE USED FOR ANY PART OR PARTS OF THE PROJECT TO WHICH THIS PAGE REFERS.

MATCHLINE STA. 10+00.00 (SEE SHEET 4)

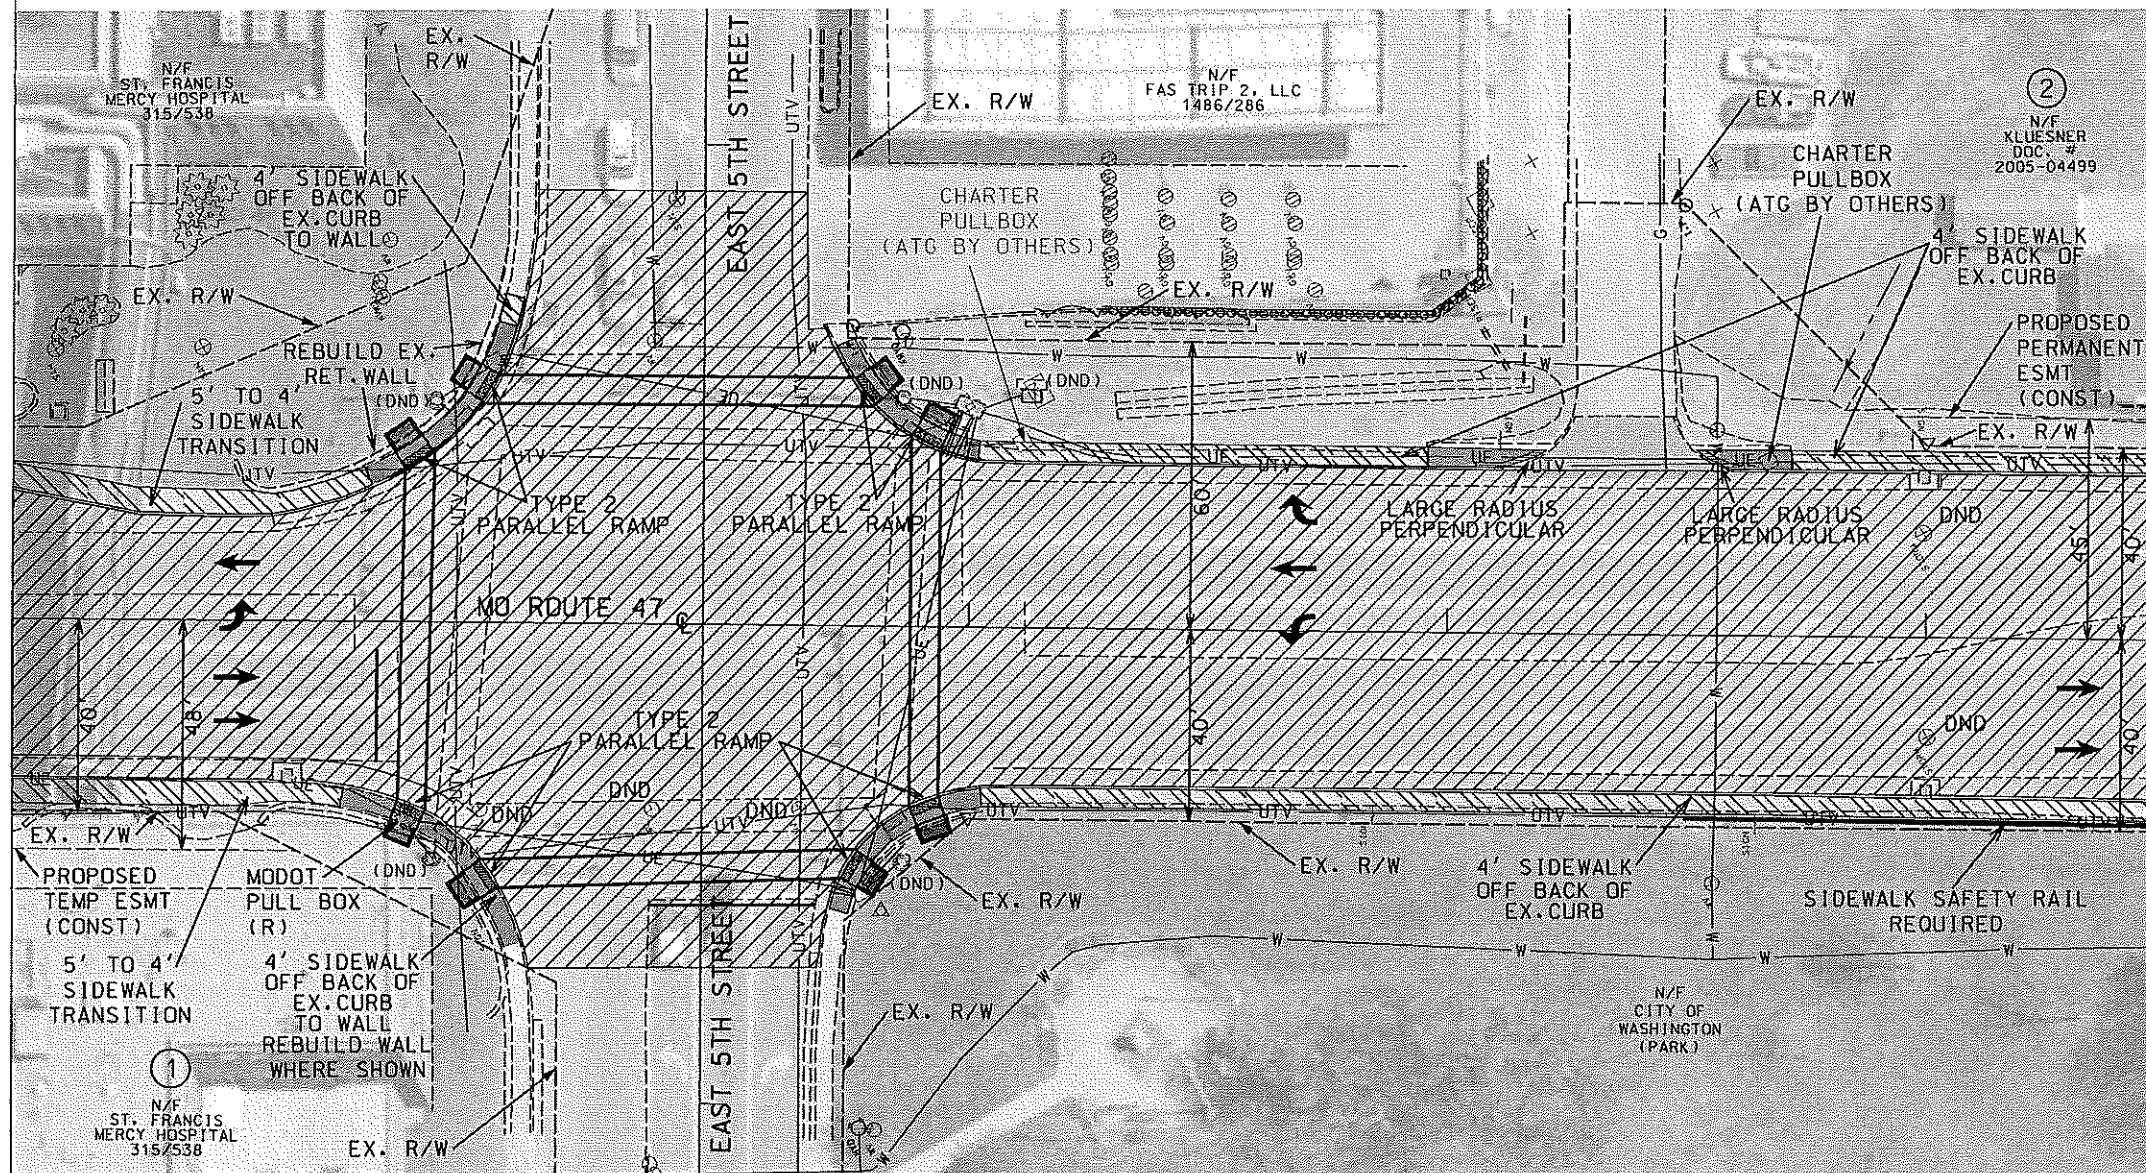

MATCHLINE STA. 14+50.00 (SEE SHEET 6)


-  3/4"MICROSURFACING
-  ADA CURB RAMPS
-  4"SIDEWALK
-  ENTRANCE RECONSTRUCTION

DATE	
DATE PREPARED	
ROUTE 47	STATE MO
DISTRICT SL	SHEET NO. 5
COUNTY FRANKLIN	
JOB NO. J6S3207	
CONTRACT ID.	
PROJECT NO.	
BRIDGE NO.	
DESCRIPTION	DATE
MISSOURI HIGHWAYS AND TRANSPORTATION COMMISSION	
	
105 WEST CAPITOL JEFFERSON CITY, MO 65102 1-888-ASK-MODOT (1-888-275-6636)	
PLAN SHEET SHEET 2 OF 16	

IF A SEAL IS PRESENT ON THIS SHEET IT HAS BEEN ELECTRONICALLY SEALED AND DATED.

DISCLAIMER
THE PROFESSIONAL WHOSE SIGNATURE AND PERSONAL SEAL APPEAR HEREON ASSUMES RESPONSIBILITY ONLY FOR WHAT APPEARS ON THIS PAGE, AND DISCLAIMS (PURSUANT TO SECTION 327.411 RSMO) SPECIFICATION, ESTIMATES, REPORTS, OR OTHER DOCUMENTS OR INSTRUMENTS NOT SEALED BY THE UNDERSIGNED PROFESSIONAL RELATING TO OR INTENDED TO BE USED FOR ANY PART OR PARTS OF THE PROJECT TO WHICH THIS PAGE REFERS.


- 3/4"MICROSURFACING
- 4"SIDEWALK
- ENTRANCE RECONSTRUCTION
- ADA CURB RAMPS

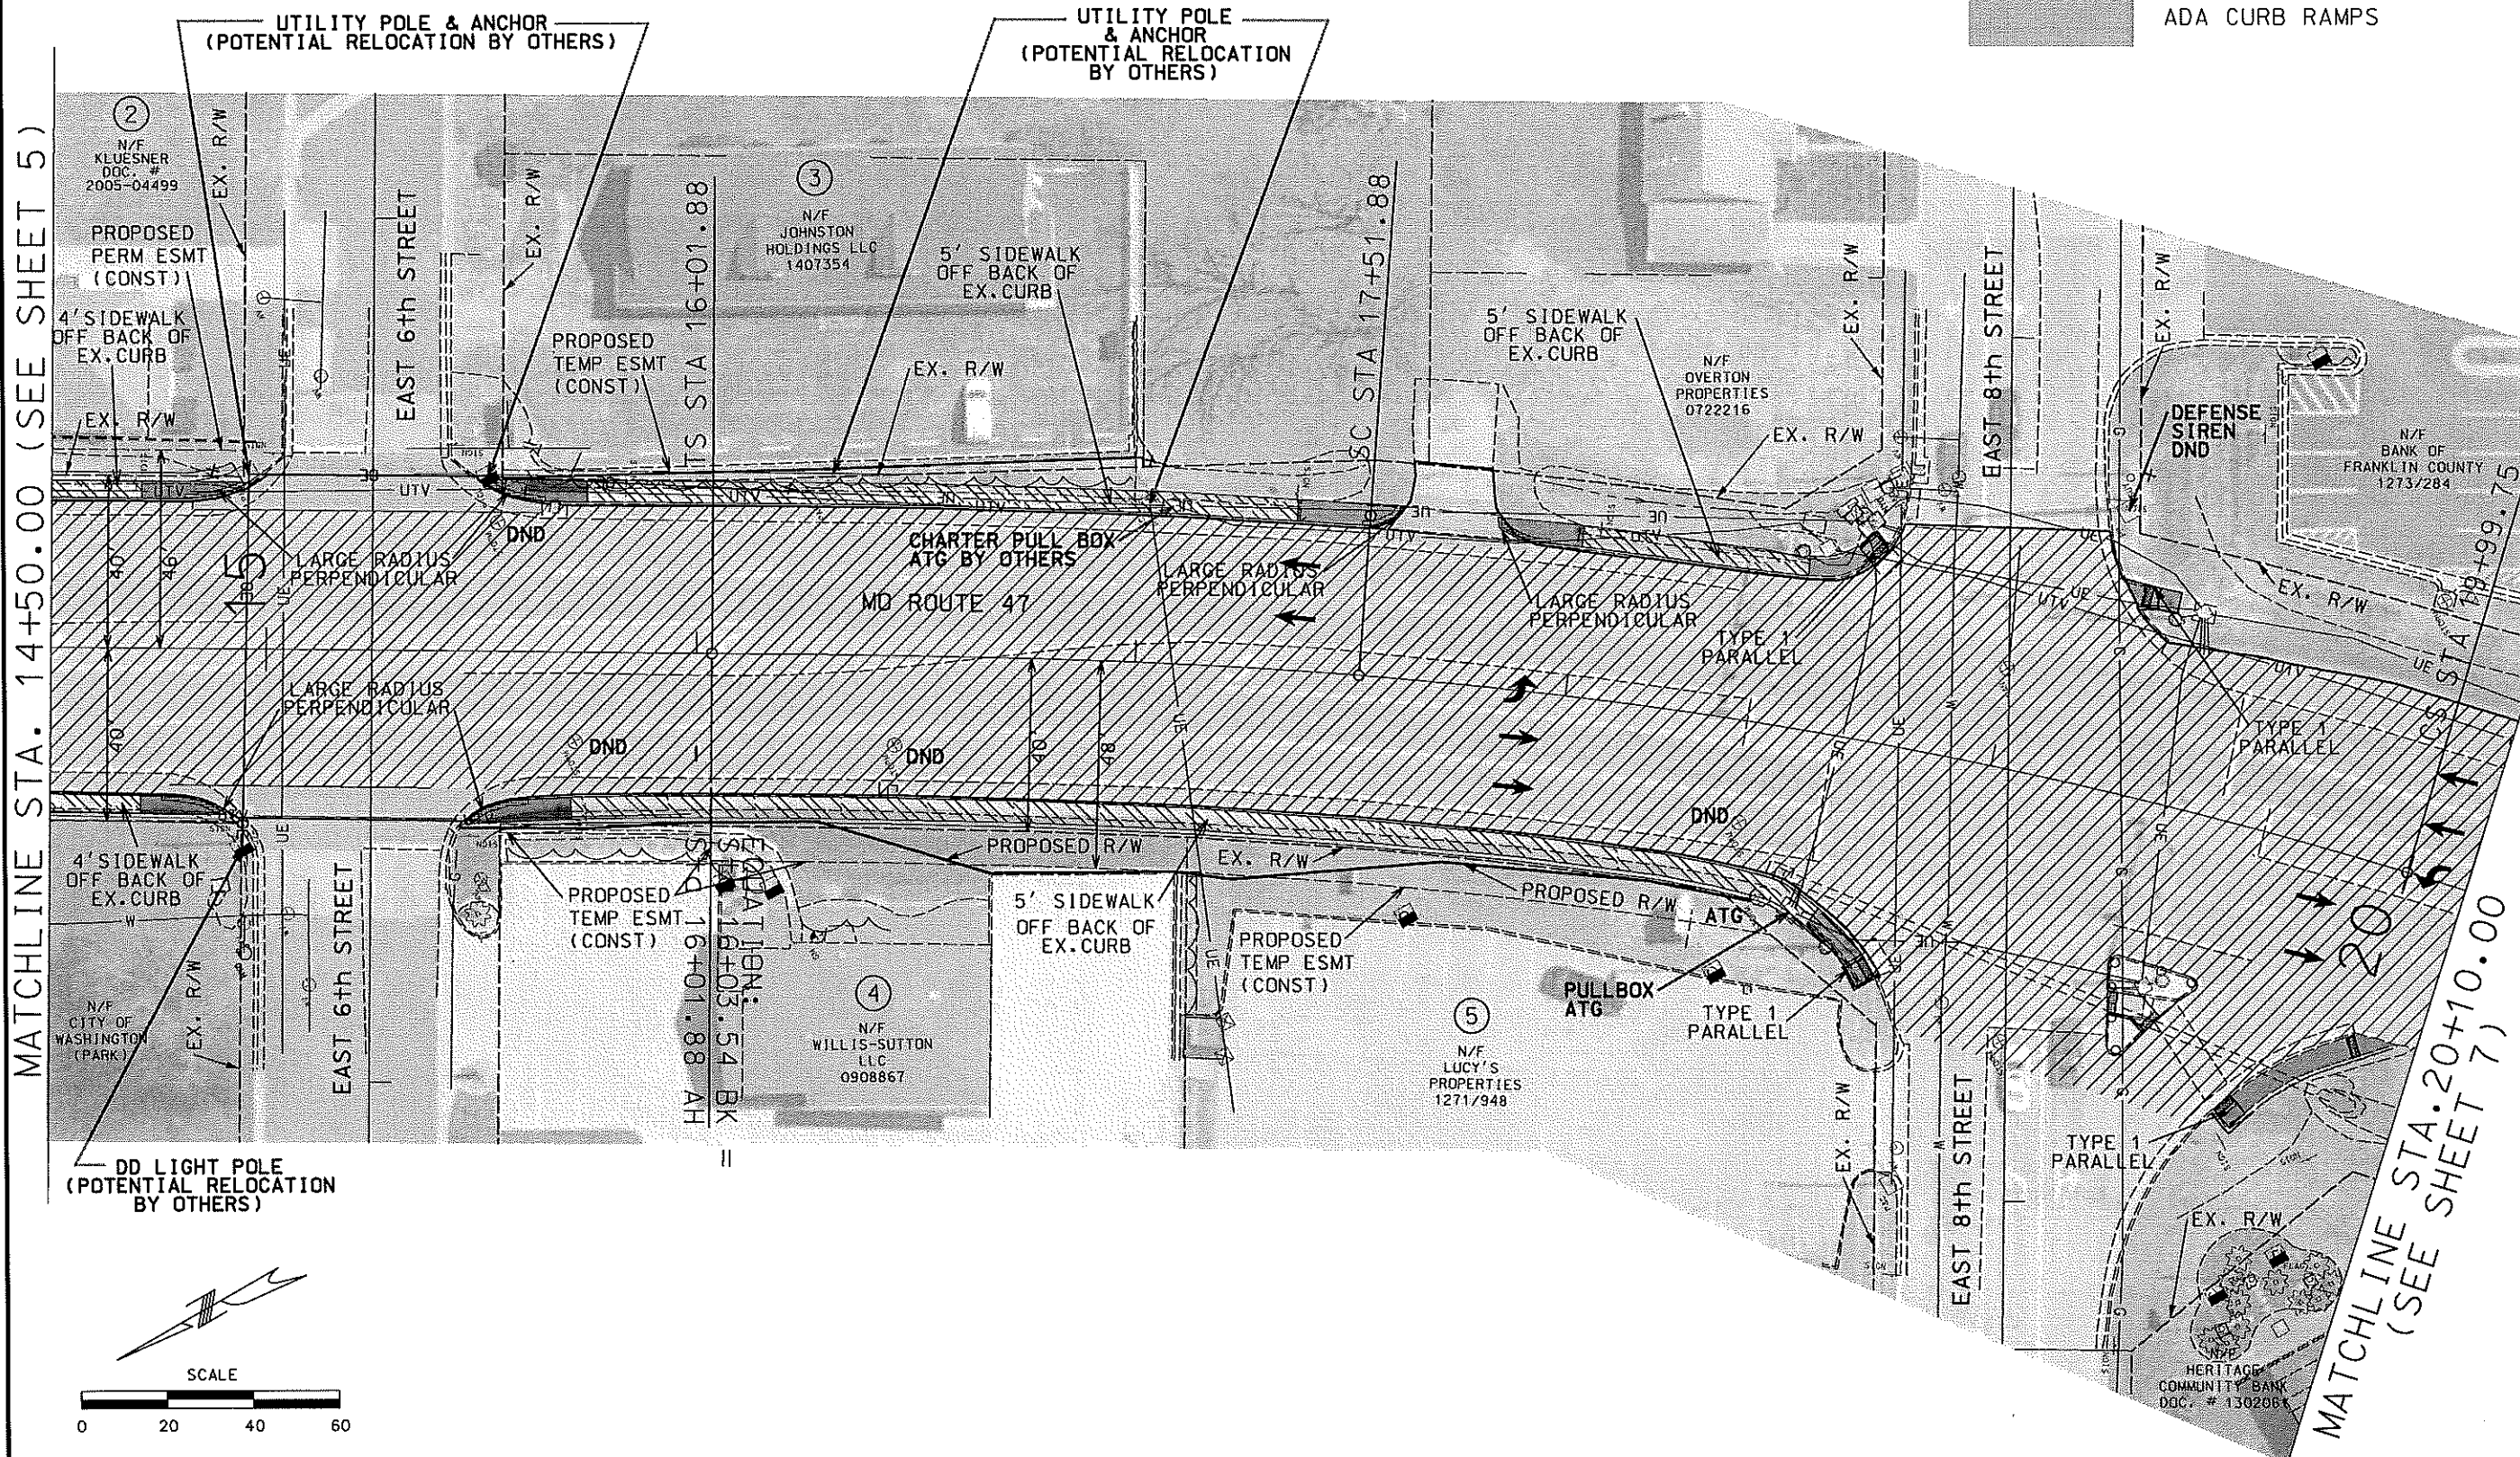


DATE	
DATE PREPARED	
ROUTE 47	STATE MO
DISTRICT SL	SHEET NO. 6
COUNTY FRANKLIN	
JOB NO. J6S3207	
CONTRACT ID.	
PROJECT NO.	
BRIDGE NO.	
DESCRIPTION	DATE
MISSOURI HIGHWAYS AND TRANSPORTATION COMMISSION	
PLAN SHEET SHEET 3 OF 16	
105 WEST CAPITAL JEFFERSON CITY, MO 65102 1-888-ASK-MODOT (1-888-275-6636)	

IF A SEAL IS PRESENT ON THIS SHEET IT HAS BEEN ELECTRONICALLY SEALED AND DATED.


DISCLAIMER
THE PROFESSIONAL WHOSE SIGNATURE AND PERSONAL SEAL APPEAR HEREON ASSUMES RESPONSIBILITY ONLY FOR WHAT APPEARS ON THIS PAGE, AND DISCLAIMS (PURSUANT TO SECTION 327.411 RSMO) SPECIFICATION, ESTIMATES, REPORTS, OR OTHER DOCUMENTS OR INSTRUMENTS NOT SEALED BY THE UNDERSIGNED PROFESSIONAL RELATING TO OR INTENDED TO BE USED FOR ANY PART OR PARTS OF THE PROJECT TO WHICH THIS PAGE REFERS.

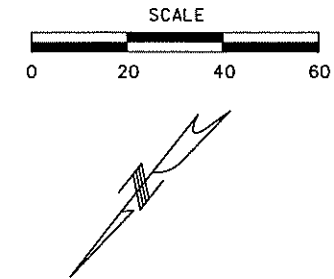


MATCHLINE STA. 20+10.00 (SEE SHEET 6)

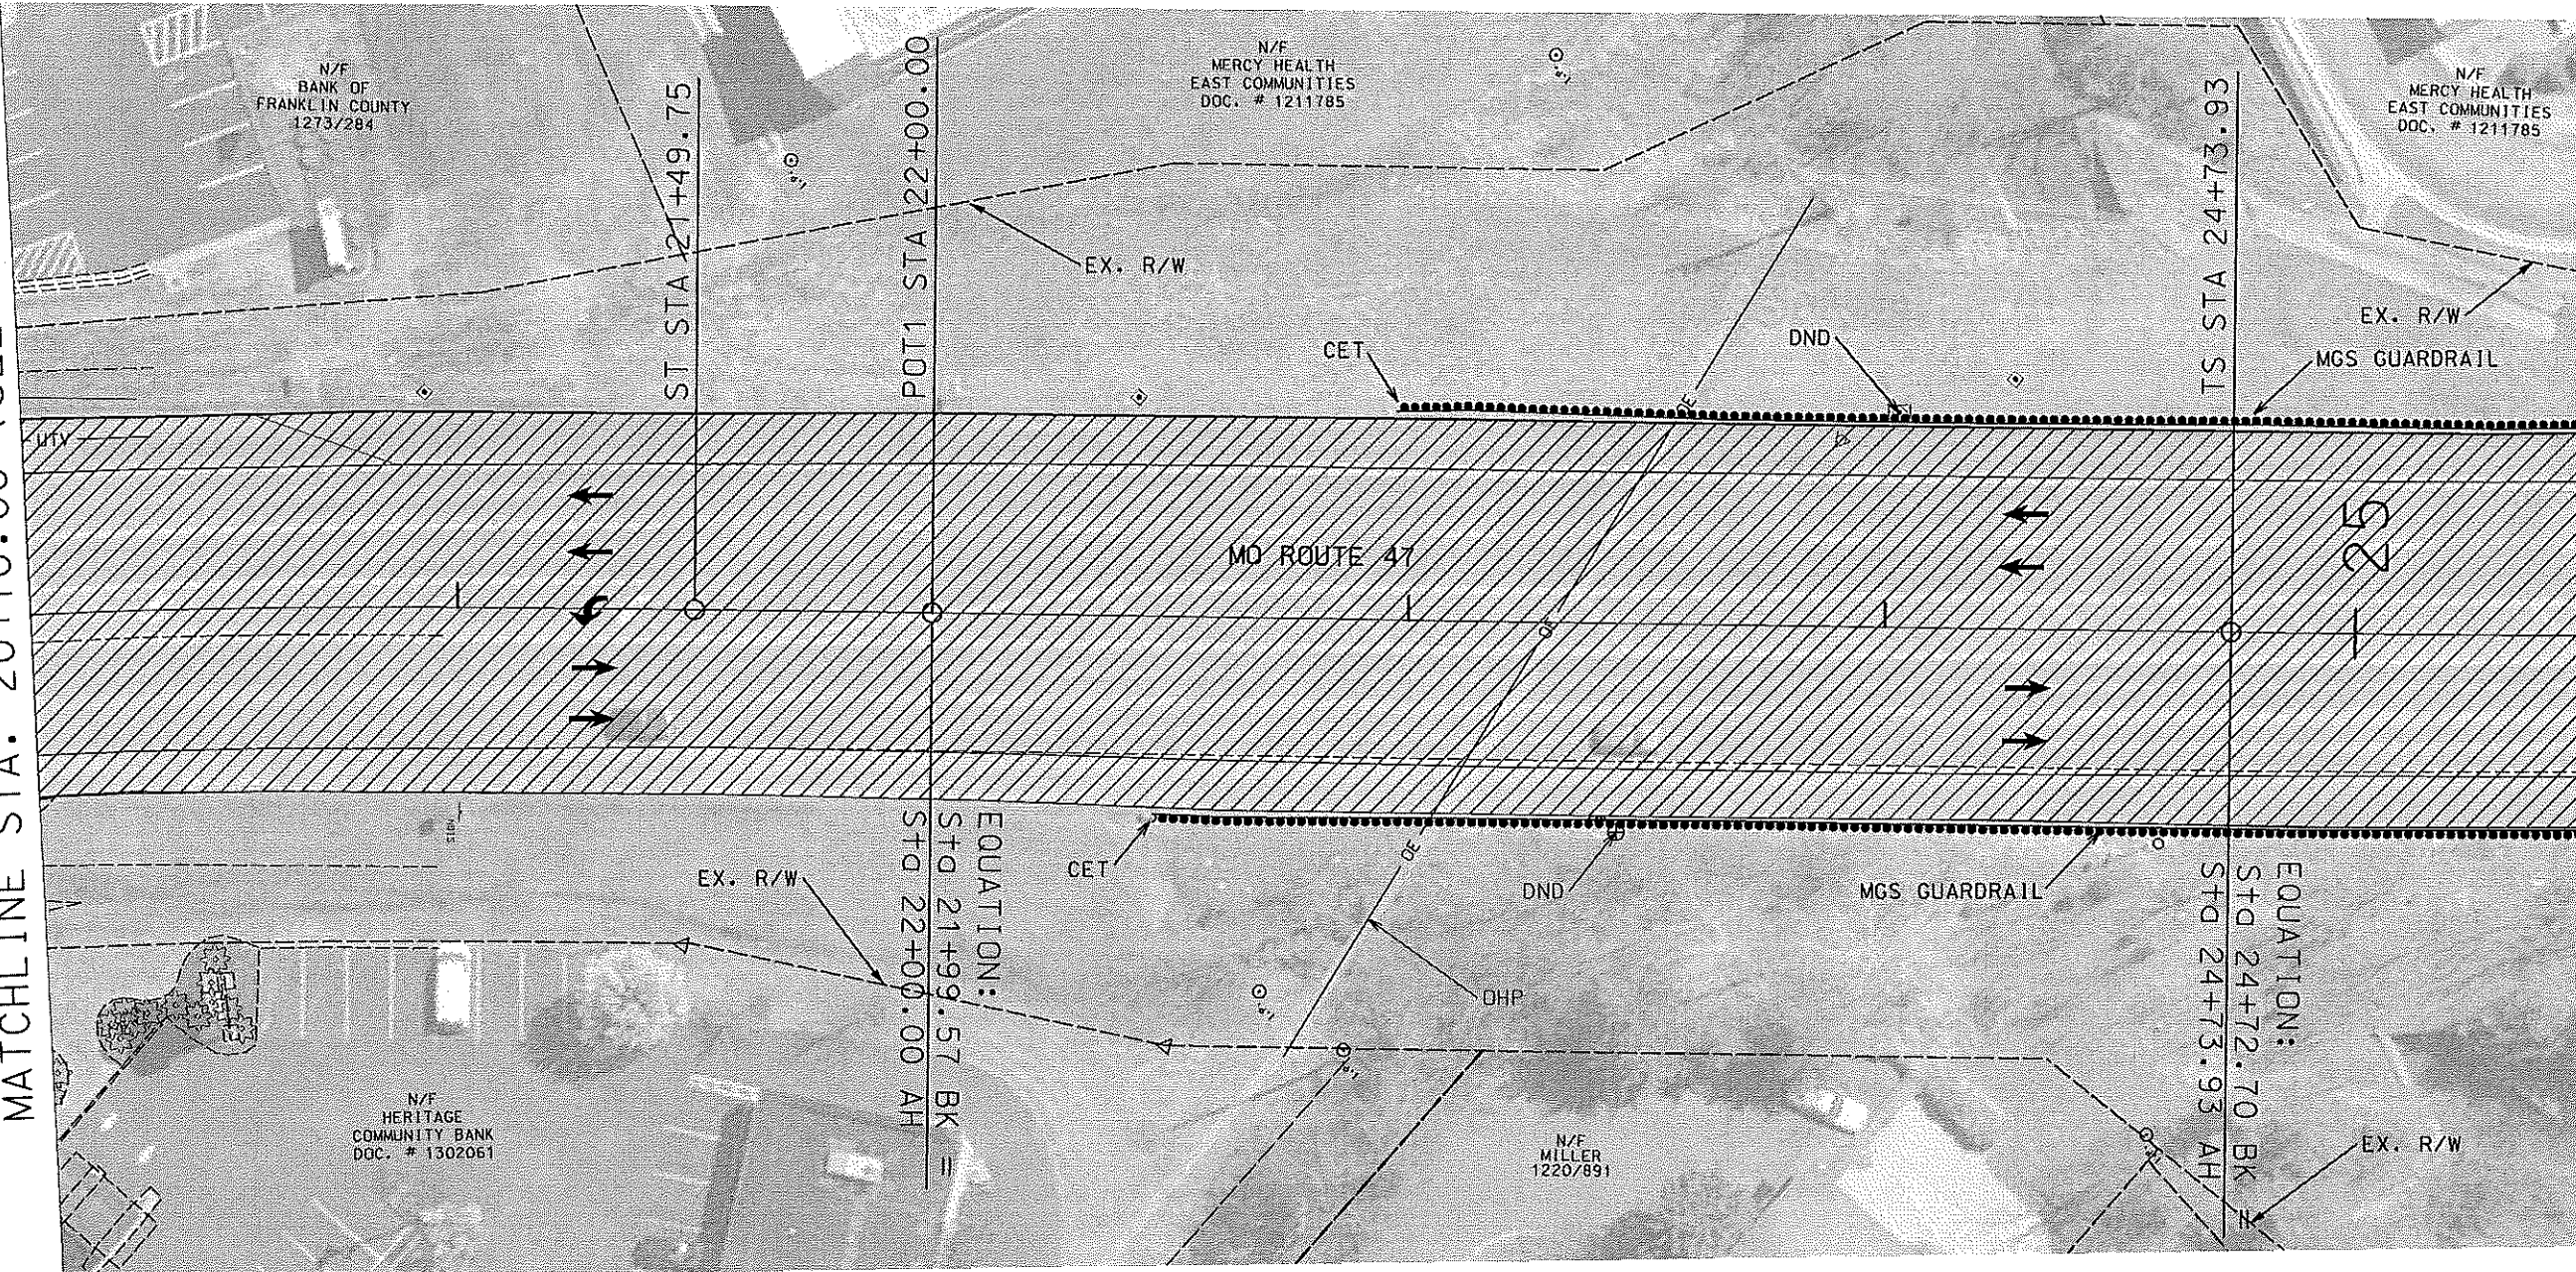



MATCHLINE STA. 25+50.00 (SEE SHEET 8)

 

3/4"MICROSURFACING

DATE PREPARED 11/2/2017	
ROUTE 47	STATE MO
DISTRICT SL	SHEET NO. 7
COUNTY FRANKLIN	
JOB NO. J6S3207	
CONTRACT ID.	
PROJECT NO.	
BRIDGE NO.	
DESCRIPTION	DATE
MISSOURI HIGHWAYS AND TRANSPORTATION COMMISSION	
	
105 WEST CAPITAL JEFFERSON CITY, MO 65102 1-888-ASK-MODOT (1-888-275-6636)	
PLAN SHEET SHEET 4 OF 16	


IF A SEAL IS PRESENT ON THIS SHEET IT HAS BEEN ELECTRONICALLY SEALED AND DATED.

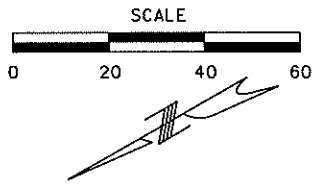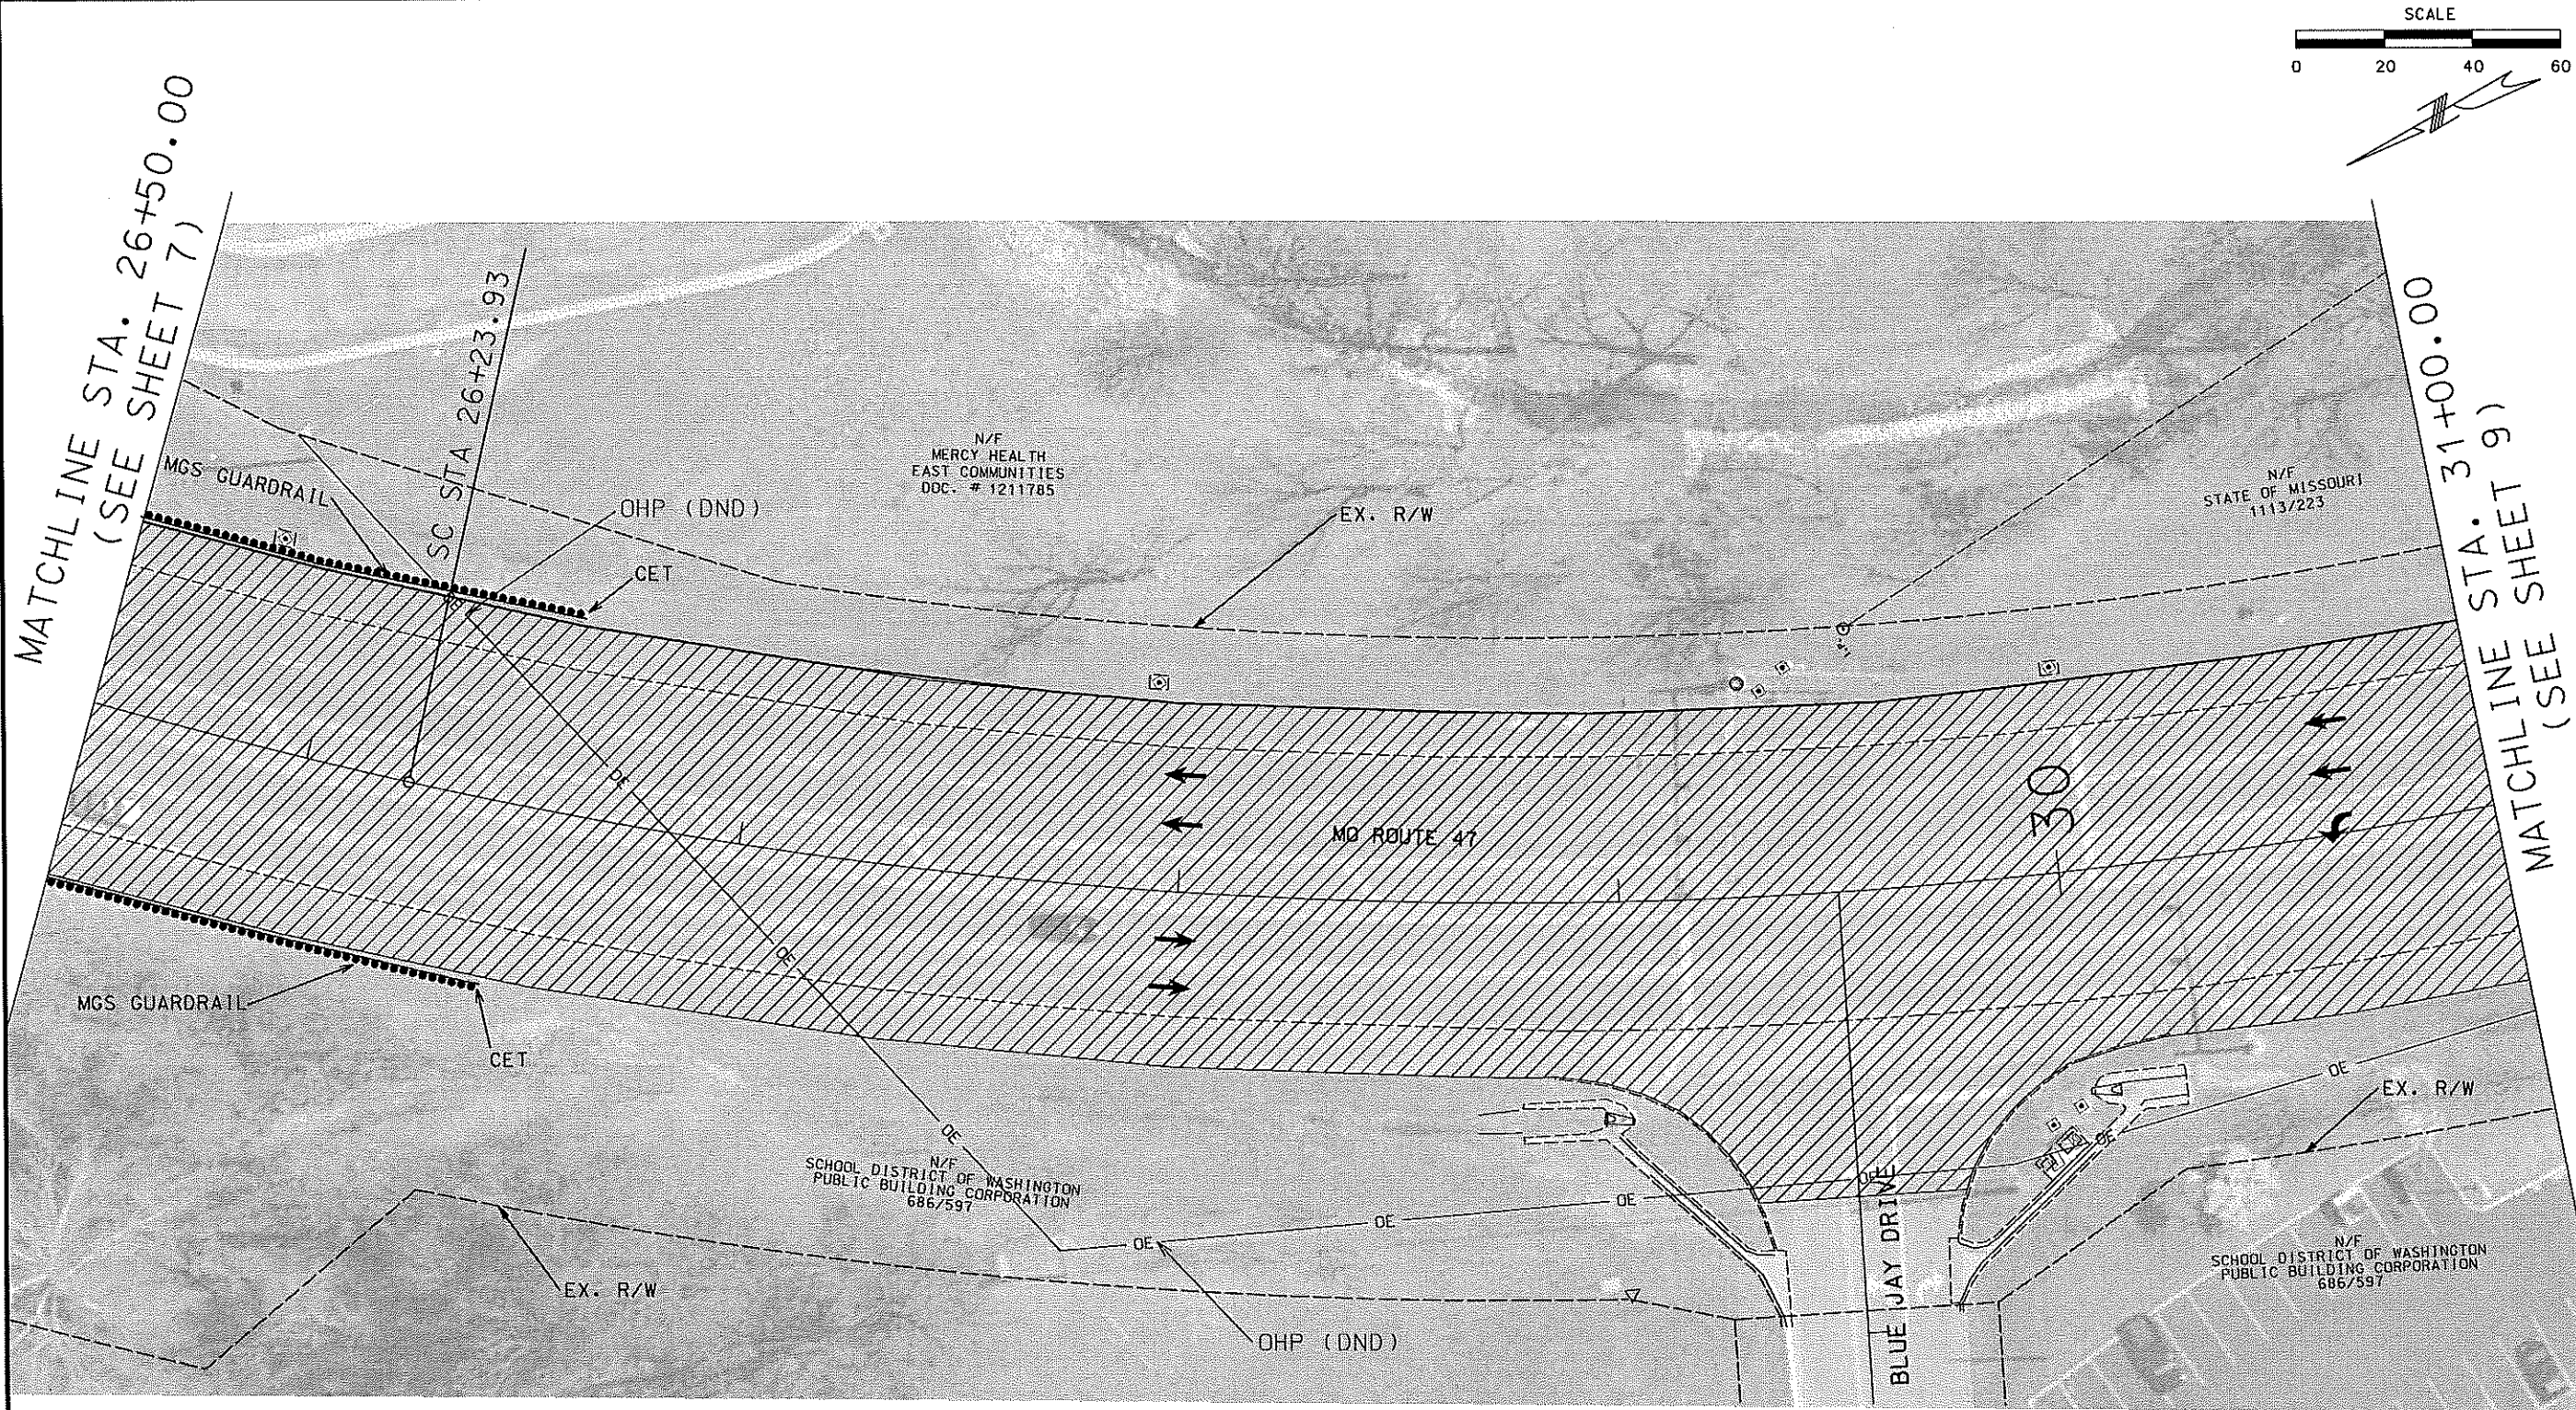


MATCHLINE STA. 26+50.00
(SEE SHEET 7)

MATCHLINE STA. 31+00.00
(SEE SHEET 9)


DISCLAIMER
THE PROFESSIONAL WHOSE SIGNATURE AND PERSONAL SEAL APPEAR HEREON ASSUMES RESPONSIBILITY ONLY FOR WHAT APPEARS ON THIS PAGE, AND DISCLAIMS (PURSUANT TO SECTION 327.411 RSMO) SPECIFICATION, ESTIMATES, REPORTS, OR OTHER DOCUMENTS OR INSTRUMENTS NOT SEALED BY THE UNDERSIGNED PROFESSIONAL RELATING TO OR INTENDED TO BE USED FOR ANY PART OR PARTS OF THE PROJECT TO WHICH THIS PAGE REFERS.

 3/4"MICROSURFACING


DATE PREPARED 11/2/2017	
ROUTE 47	STATE MO
DISTRICT SL	SHEET NO. 8
COUNTY FRANKLIN	
JOB NO. JS63207	
CONTRACT ID.	
PROJECT NO.	
BRIDGE NO.	
DESCRIPTION	DATE
MISSOURI HIGHWAYS AND TRANSPORTATION COMMISSION	
	
105 WEST CAPITAL JEFFERSON CITY, MO 65102 1-888-ASK-MODOT (1-888-275-6636)	
PLAN SHEET SHEET 5 OF 16	

IF A SEAL IS PRESENT ON THIS SHEET IT HAS BEEN ELECTRONICALLY SEALED AND DATED.

DISCLAIMER
THE PROFESSIONAL WHOSE SIGNATURE AND PERSONAL
SEAL APPEAR HEREON ASSUMES RESPONSIBILITY
ONLY FOR WHAT APPEARS ON THIS PAGE, AND
DISCLAIMS (PURSUANT TO SECTION 327.411 RSMO)
SPECIFICATION, ESTIMATES, REPORTS, OR OTHER
DOCUMENTS OR INSTRUMENTS NOT SEALED BY THE
UNDERSIGNED PROFESSIONAL RELATING TO OR
INTENDED TO BE USED FOR ANY PART OR PARTS OF
THE PROJECT TO WHICH THIS PAGE REFERS.

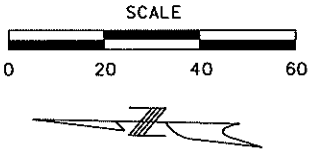

MATCHLINE STA. 36+50.00 (SEE SHEET 8)

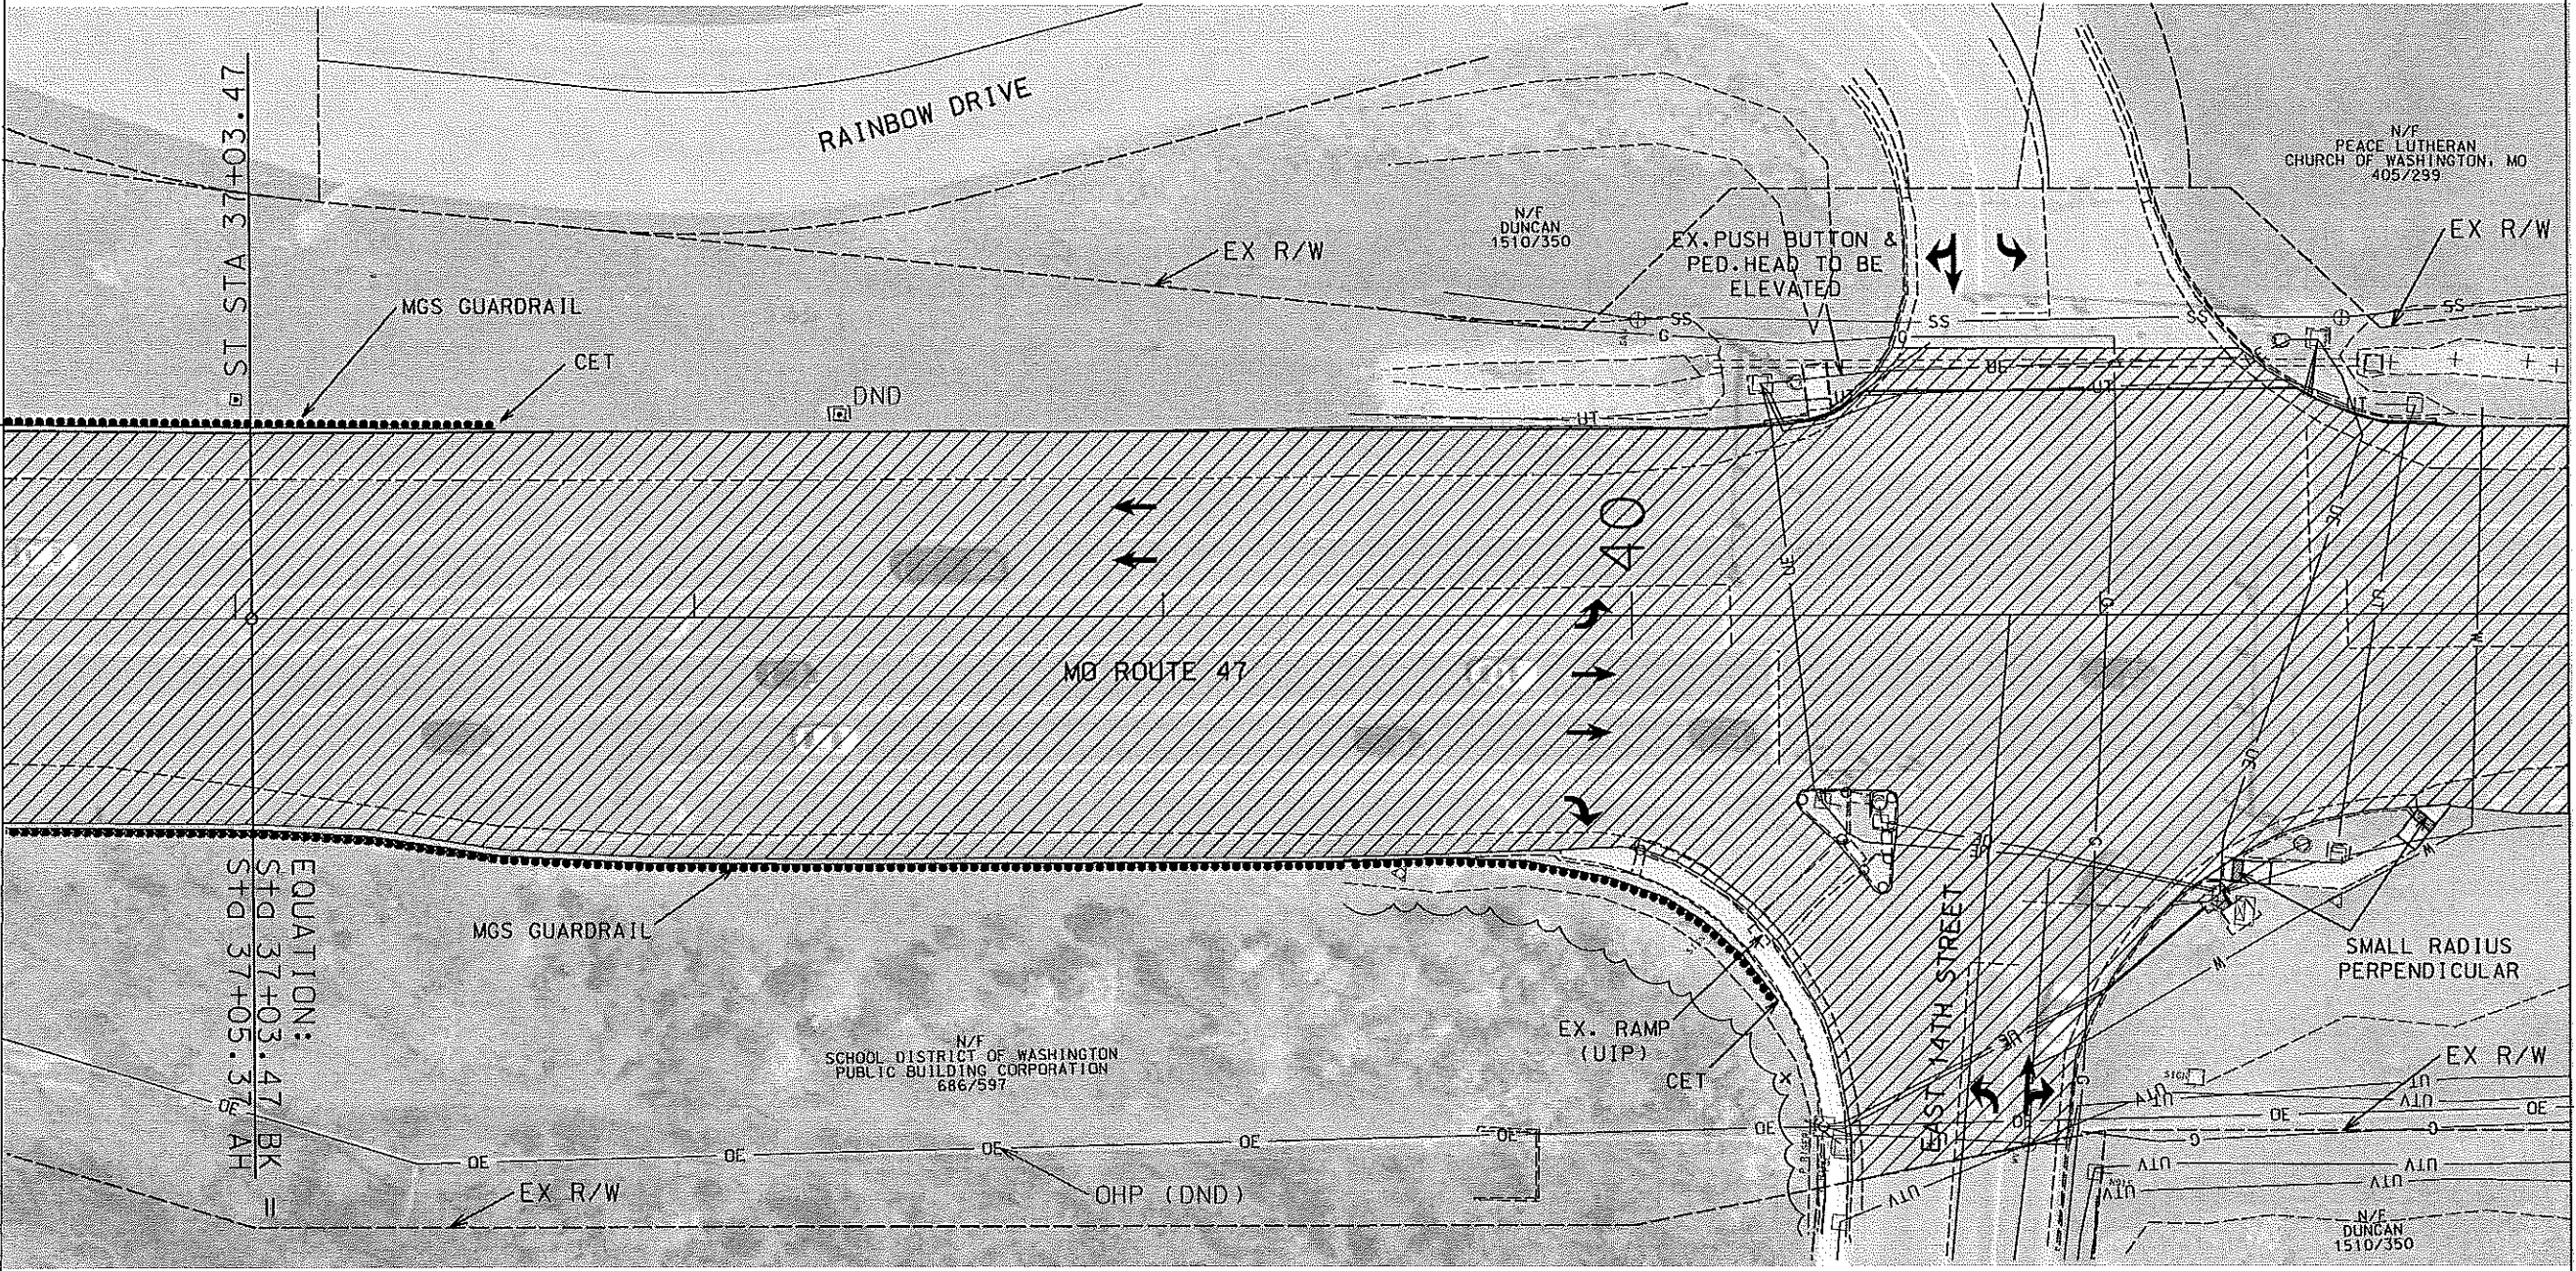

MATCHLINE STA. 42+00.00 (SEE SHEET 11)





3/4"MICROSURFACING

DATE	
DATE PREPARED	
ROUTE 47	STATE MO
DISTRICT SL	SHEET NO. 10
COUNTY FRANKLIN	
JOB NO. J6S3207	
CONTRACT ID.	
PROJECT NO.	
BRIDGE NO.	
DESCRIPTION	DATE
MISSOURI HIGHWAYS AND TRANSPORTATION COMMISSION	105 WEST CAPITAL JEFFERSON CITY, MO 65102 1-888-ASK-MODOT (1-888-275-6636)
PLAN SHEET SHEET 7 OF 16	

IF A SEAL IS PRESENT ON THIS SHEET IT HAS BEEN ELECTRONICALLY SEALED AND DATED.

  THE PROFESSIONAL WHOSE SIGNATURE AND PERSONAL SEAL APPEAR HEREON ASSUMES RESPONSIBILITY ONLY FOR WHAT APPEARS ON THIS PAGE, AND DISCLAIMS (PURSUANT TO SECTION 327.411 RSMO) SPECIFICATION, ESTIMATES, REPORTS, OR OTHER DOCUMENTS OR INSTRUMENTS NOT SEALED BY THE UNDERSIGNED PROFESSIONAL RELATING TO OR INTENDED TO BE USED FOR ANY PART OR PARTS OF THE PROJECT TO WHICH THIS PAGE REFERS.




3/4"MICROSURFACING


IF A SEAL IS PRESENT ON THIS SHEET IT HAS BEEN ELECTRONICALLY SEALED AND DATED.

MATCHLINE STA. 47+50.00 (SEE SHEET 11)


THE PROFESSIONAL WHOSE SIGNATURE AND PERSONAL SEAL APPEAR HEREON ASSUMES RESPONSIBILITY ONLY FOR WHAT APPEARS ON THIS PAGE, AND DISCLAIMS (PURSUANT TO SECTION 327.411 RSMO) SPECIFICATION, ESTIMATES, REPORTS, OR OTHER DOCUMENTS OR INSTRUMENTS NOT SEALED BY THE UNDERSIGNED PROFESSIONAL RELATING TO OR INTENDED TO BE USED FOR ANY PART OR PARTS OF THE PROJECT TO WHICH THIS PAGE REFERS.

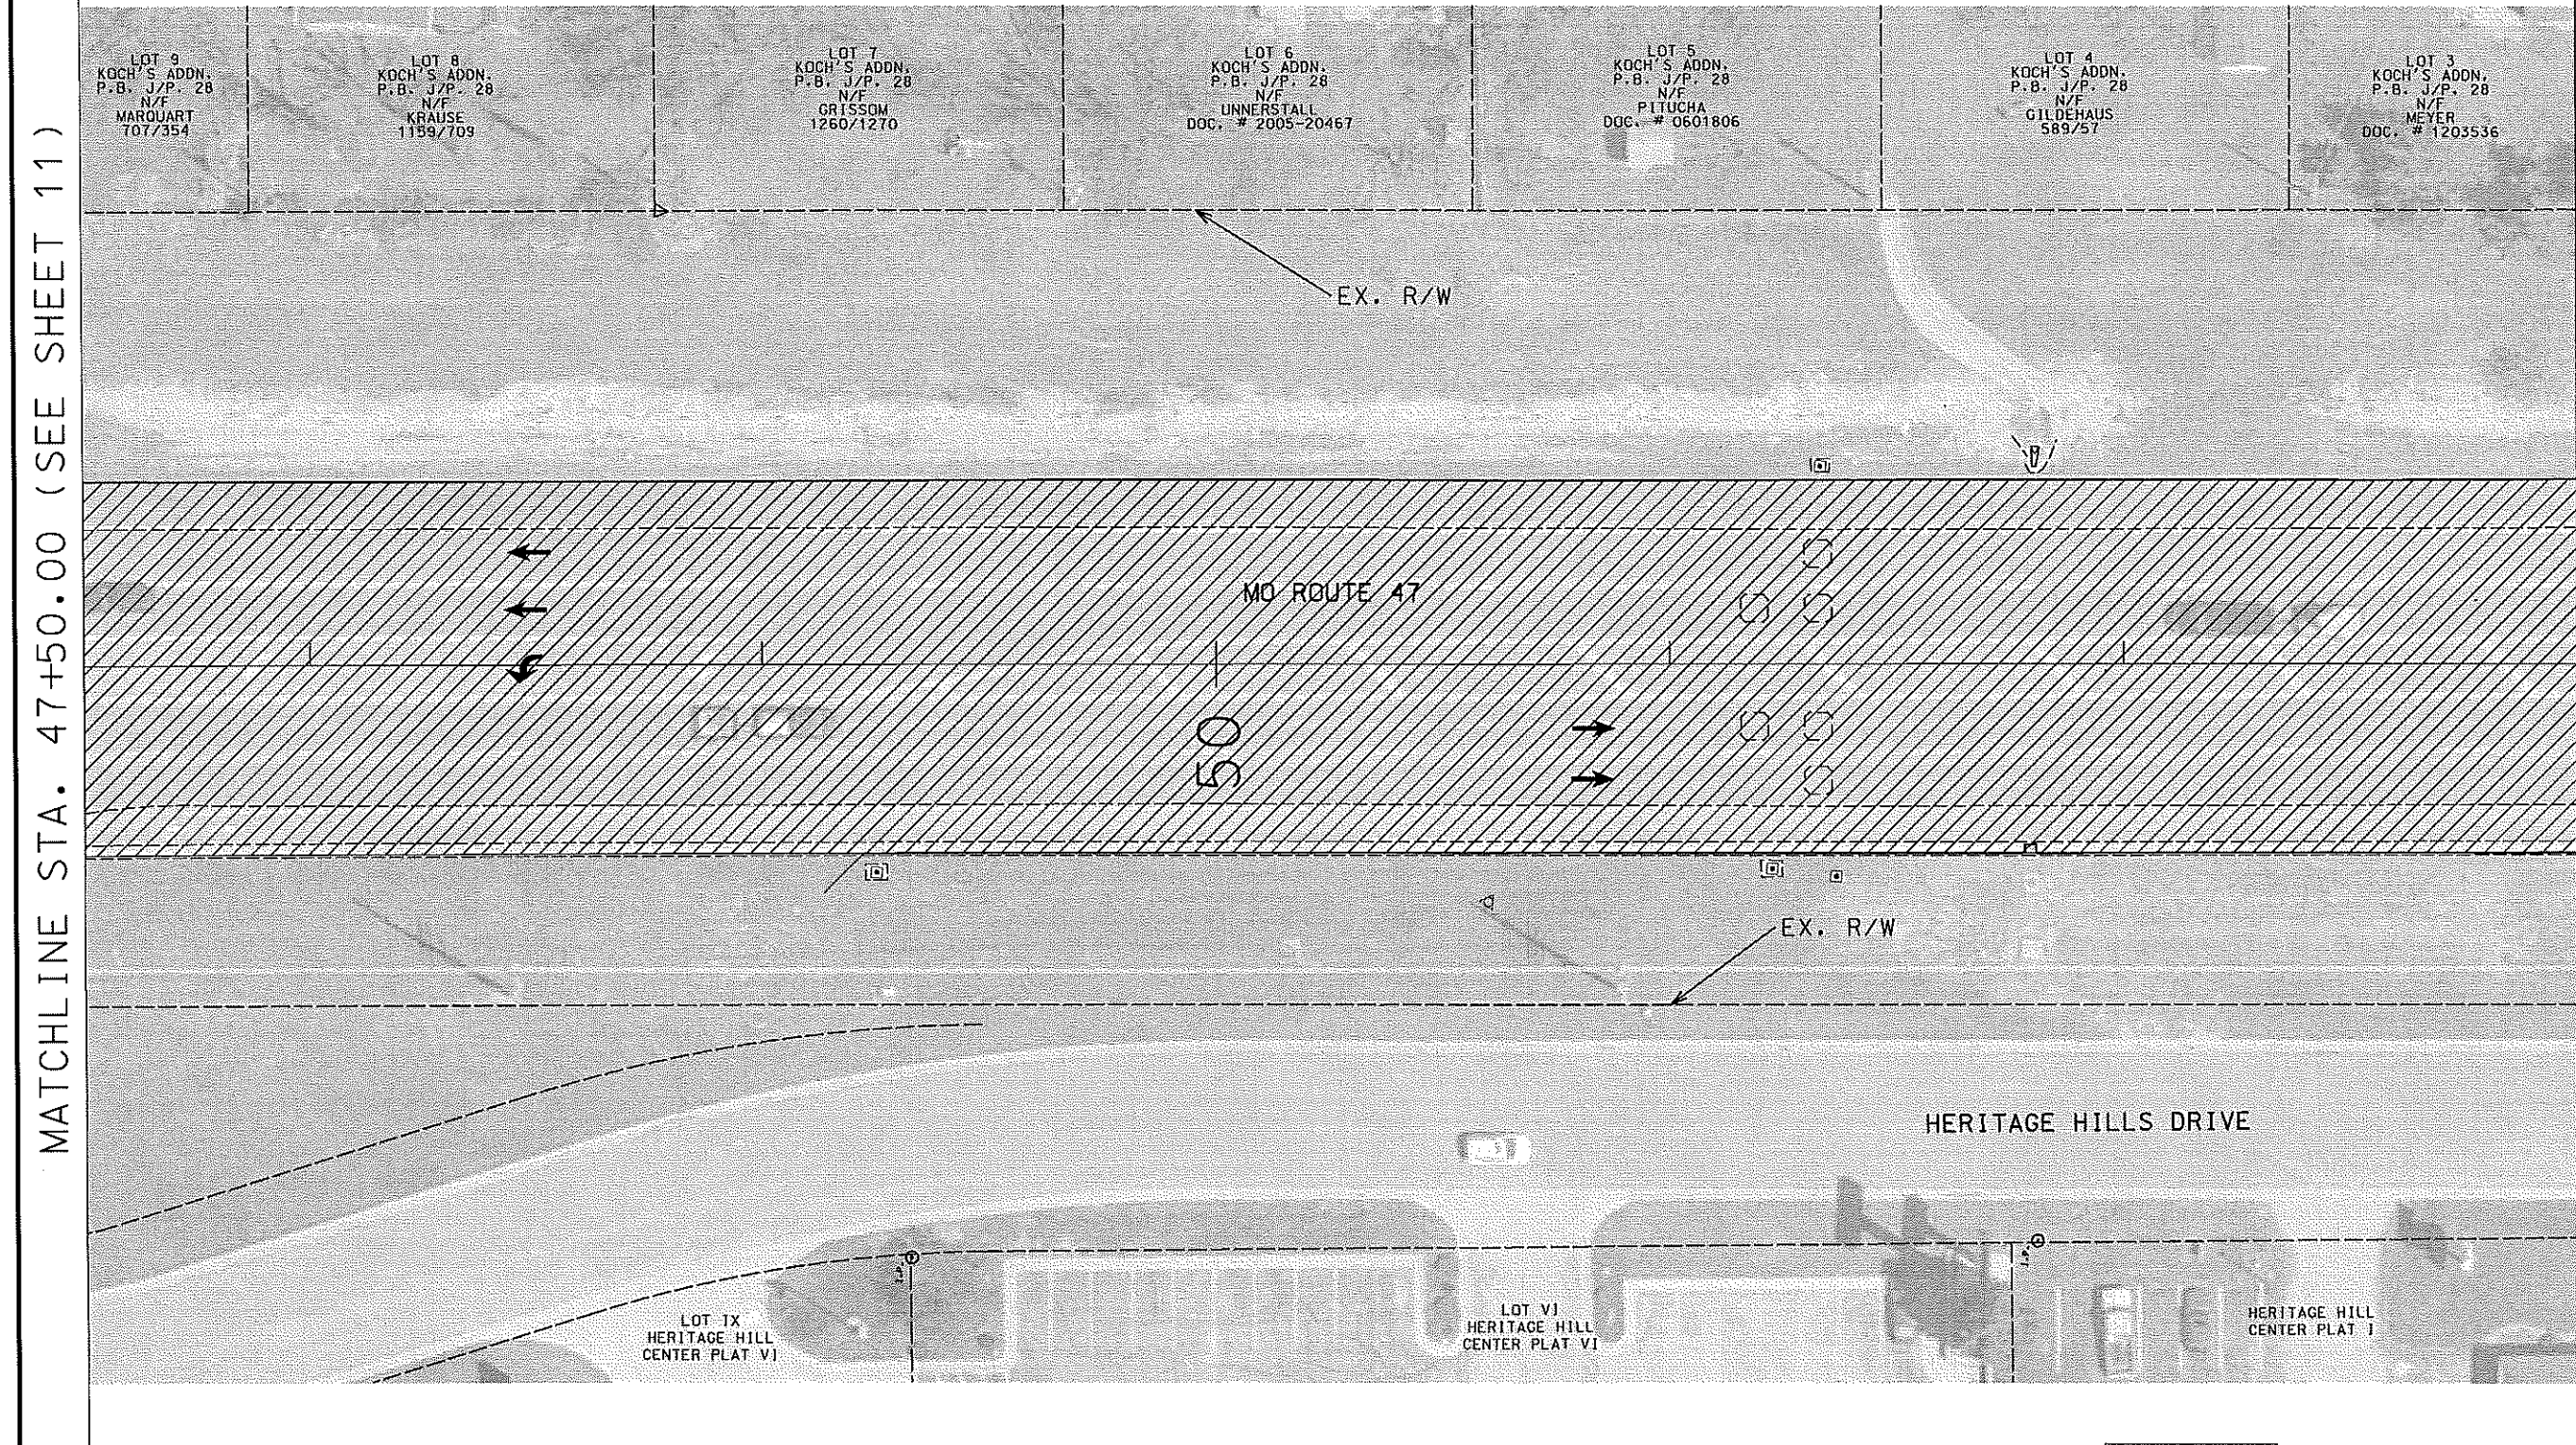

3/4" MICROSURFACING

<div>PLAN SHEET SHEET 9 OF 16</div>		MISSOURI HIGHWAYS AND TRANSPORTATION COMMISSION		<div><p>105 WEST CAPITOL JEFFERSON CITY, MO 65102 1-888-ASK-MODOT (1-888-275-6636)</p></div>
		DATE	DESCRIPTION	
BRIDGE NO.		PROJECT NO.		
CONTRACT ID.		JOB NO.		
COUNTY		STATE		
FRANKLIN		MO		
DISTRICT		SHEET NO.		
SL		12		
ROUTE		47		
DATE PREPARED		DATE		

 IF A SEAL IS PRESENT ON THIS SHEET IT HAS BEEN ELECTRONICALLY SEALED AND DATED.



HERITAGE HILL
CENTER PLAT 11

LO
LO

MO ROUTE 47


EX. R/W

/EX. R/W

LOT 2
KGCH'S ADDN.
P.B. J/P. 28
N/F
SONTAG
DOC. # 1516636

LOT 1,
KOCH'S ADDN.
P.B. J/P. 28
N/F
BOLAND
ODC. # 281672

LOT 10
PARTIAL RESUB.
KDCB'S SUB.
P.B. I/P. 3
N/F
HOTZ
DDC. # 0820660



3/4"MICROSURFACING

MATCHLINE STA: 58+00.00 (SEE SHEET 14)

PLAN SHEET
SHEET 10 OF 16

MISSOURI HIGHWAYS AND TRANSPORTATION
COMMISSION

105 WEST CAPITOL
JEFFERSON CITY, MO 65102
-888-ASK-MO001 (1-888-275-6636)

DESCRIPTION

DATE _____

BRIDGE NO.

CONTRACT ID.

JOB NO.

COUNTY

DISTRICT	SHEET NO
SL	13




ROUTE	STATE
47	MO

DATE PREPARED


DATE _____

 [illegible]


DISCLAIMER
THE PROFESSIONAL WHOSE SIGNATURE AND PERSONAL
SEAL APPEAR HEREON ASSUMES RESPONSIBILITY
ONLY FOR WHAT APPEARS ON THIS PAGE, AND
DISCLAIMS (PURSUANT TO SECTION 327.411 RSMO)
SPECIFICATION, ESTIMATES, REPORTS, OR OTHER
DOCUMENTS OR INSTRUMENTS NOT SEALED BY THE
UNDERSIGNED PROFESSIONAL RELATING TO OR
INTENDED TO BE USED FOR ANY PART OR PARTS OF
THE PROJECT TO WHICH THIS PAGE REFERS.


-  3/4"MICROSURFACING
-  ADA CURB RAMPS
-  4"SIDEWALK

MATCHLINE STA. 58+00.00 (SEE SHEET 13)

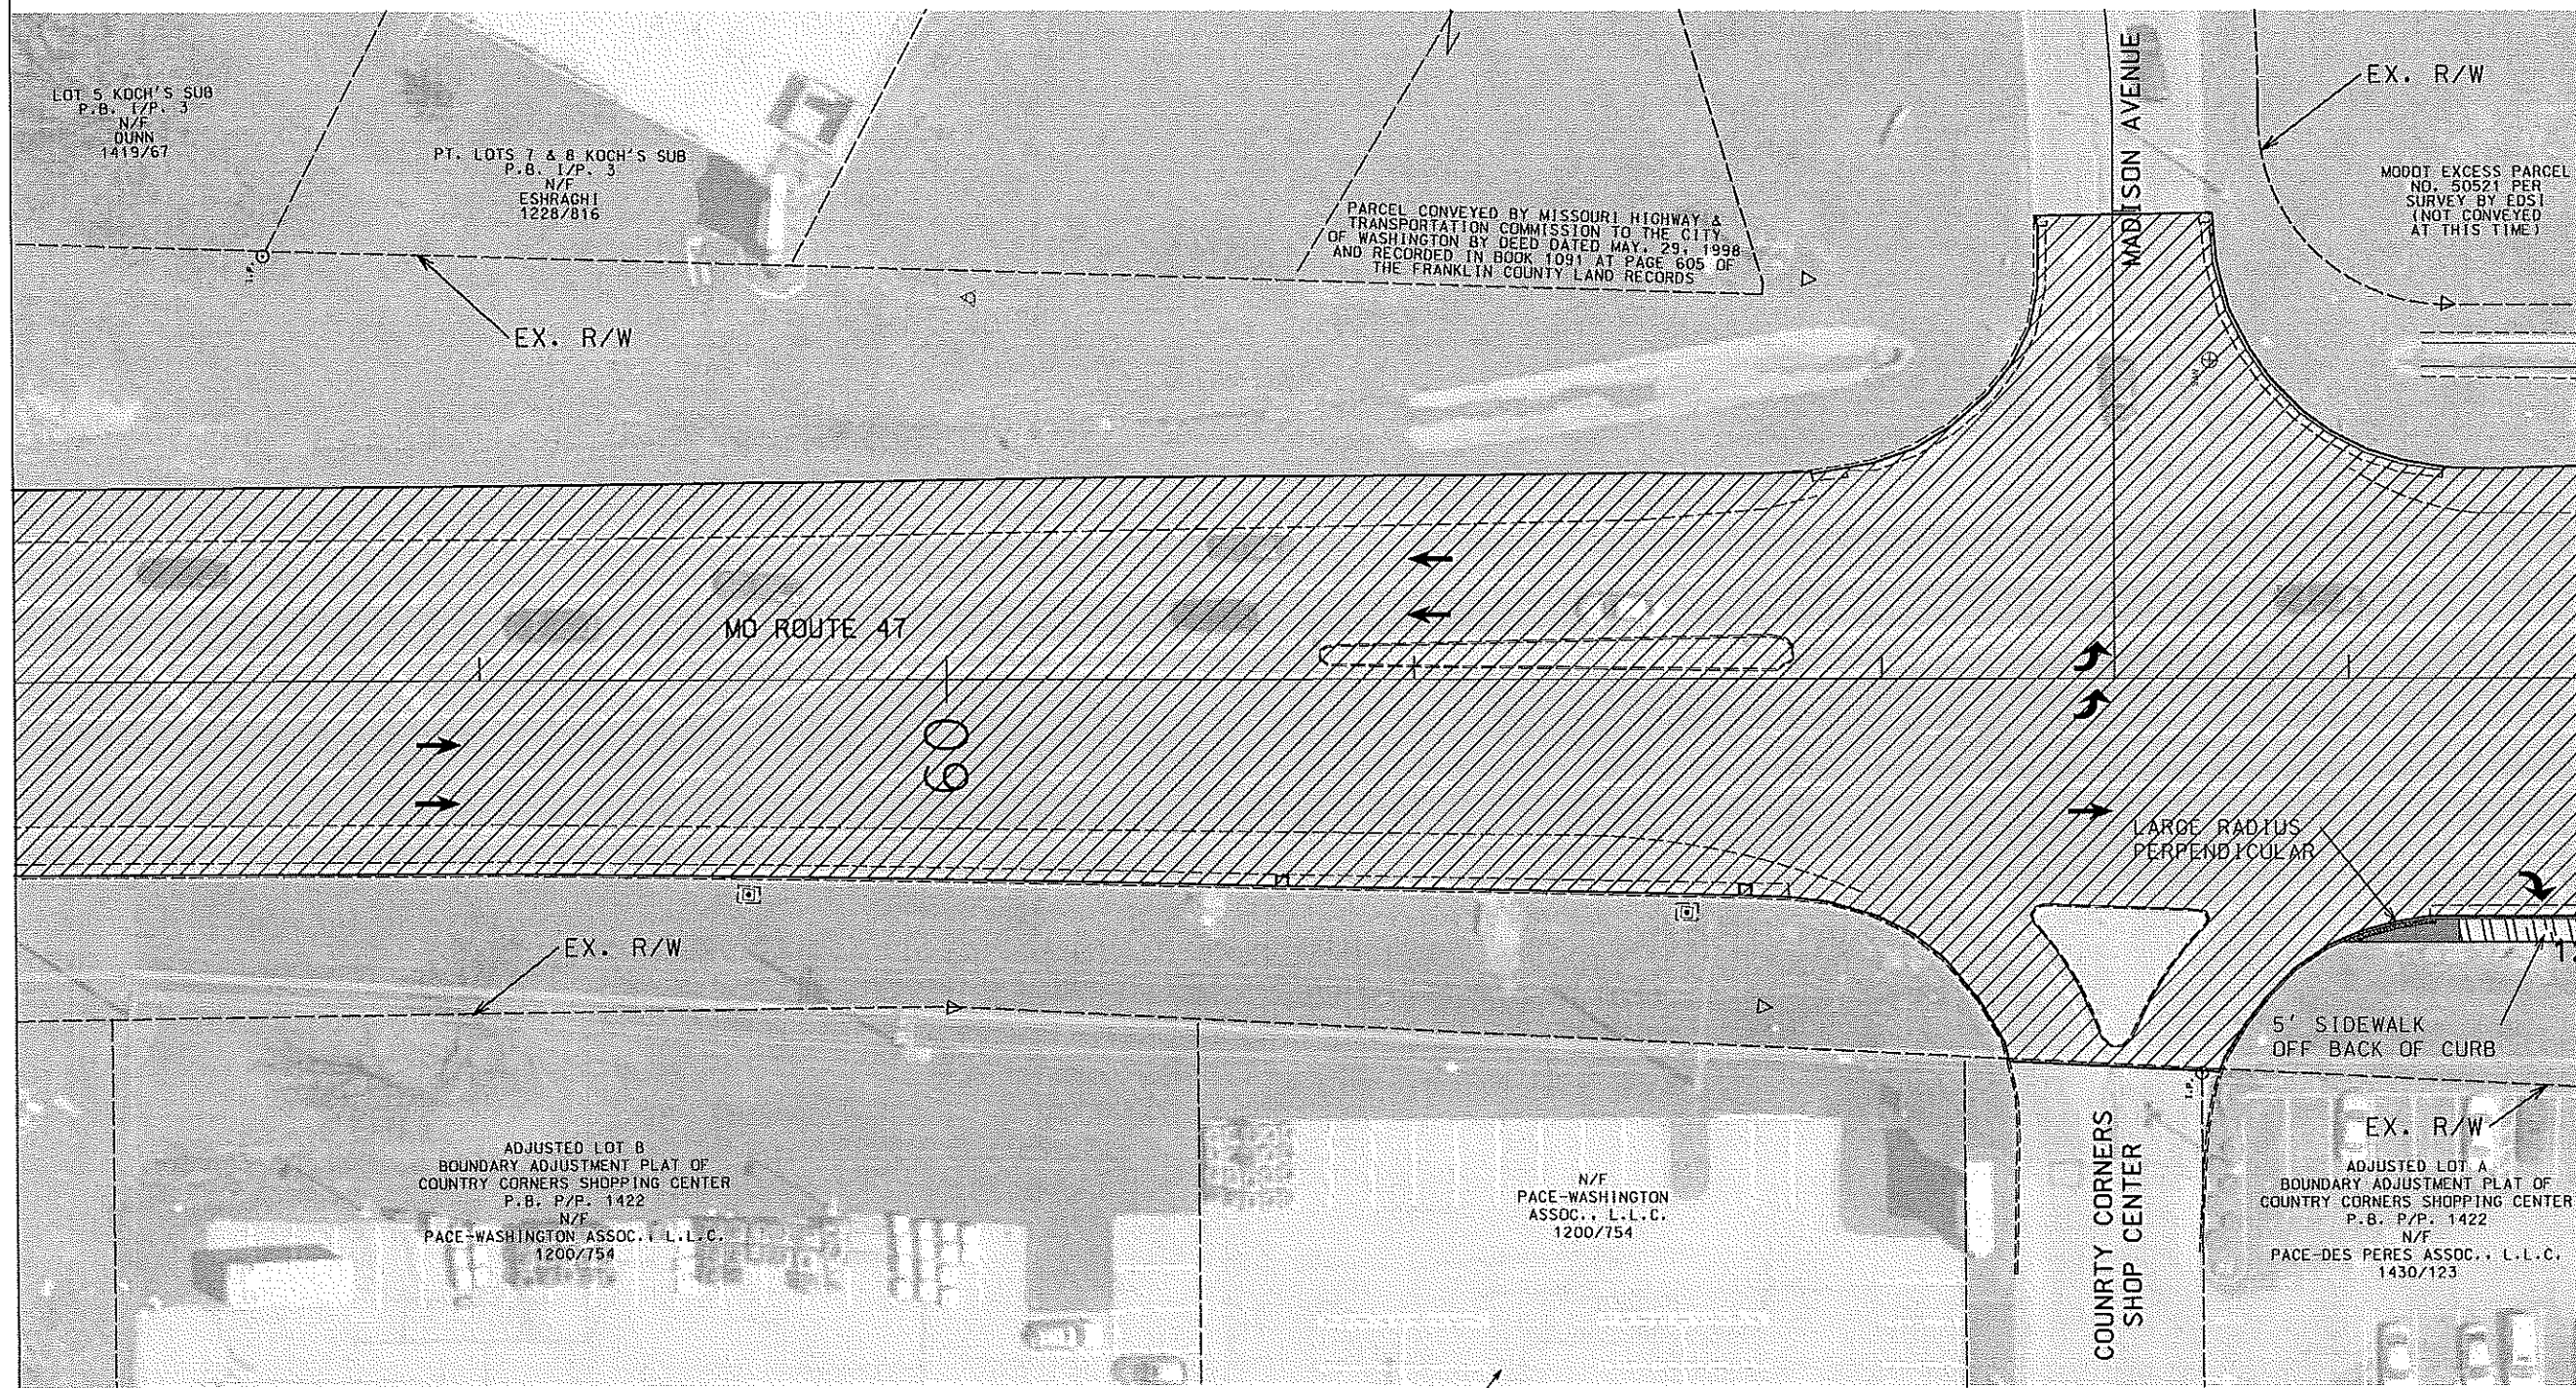



MATCHLINE STA. 63+50.00 (SEE SHEET 15)

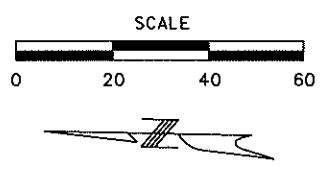

DATE	
DATE PREPARED	
ROUTE 47	STATE MO
DISTRICT SL	SHEET NO. 14
COUNTY FRANKLIN	
JOB NO. J6S3207	
CONTRACT ID.	
PROJECT NO.	
BRIDGE NO.	
DESCRIPTION	DATE
MISSOURI HIGHWAYS AND TRANSPORTATION COMMISSION	
	
105 WEST CAPITOL JEFFERSON CITY, MO 65102 1-888-ASK-MODOT (1-888-275-6636)	
PLAN SHEET SHEET 11 OF 16	

IF A SEAL IS PRESENT ON THIS SHEET IT HAS BEEN ELECTRONICALLY SEALED AND DATED.

MATCHLINE STA. 63+50.00 (SEE SHEET 14)

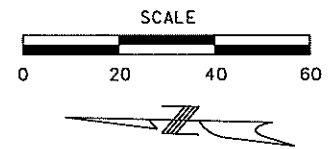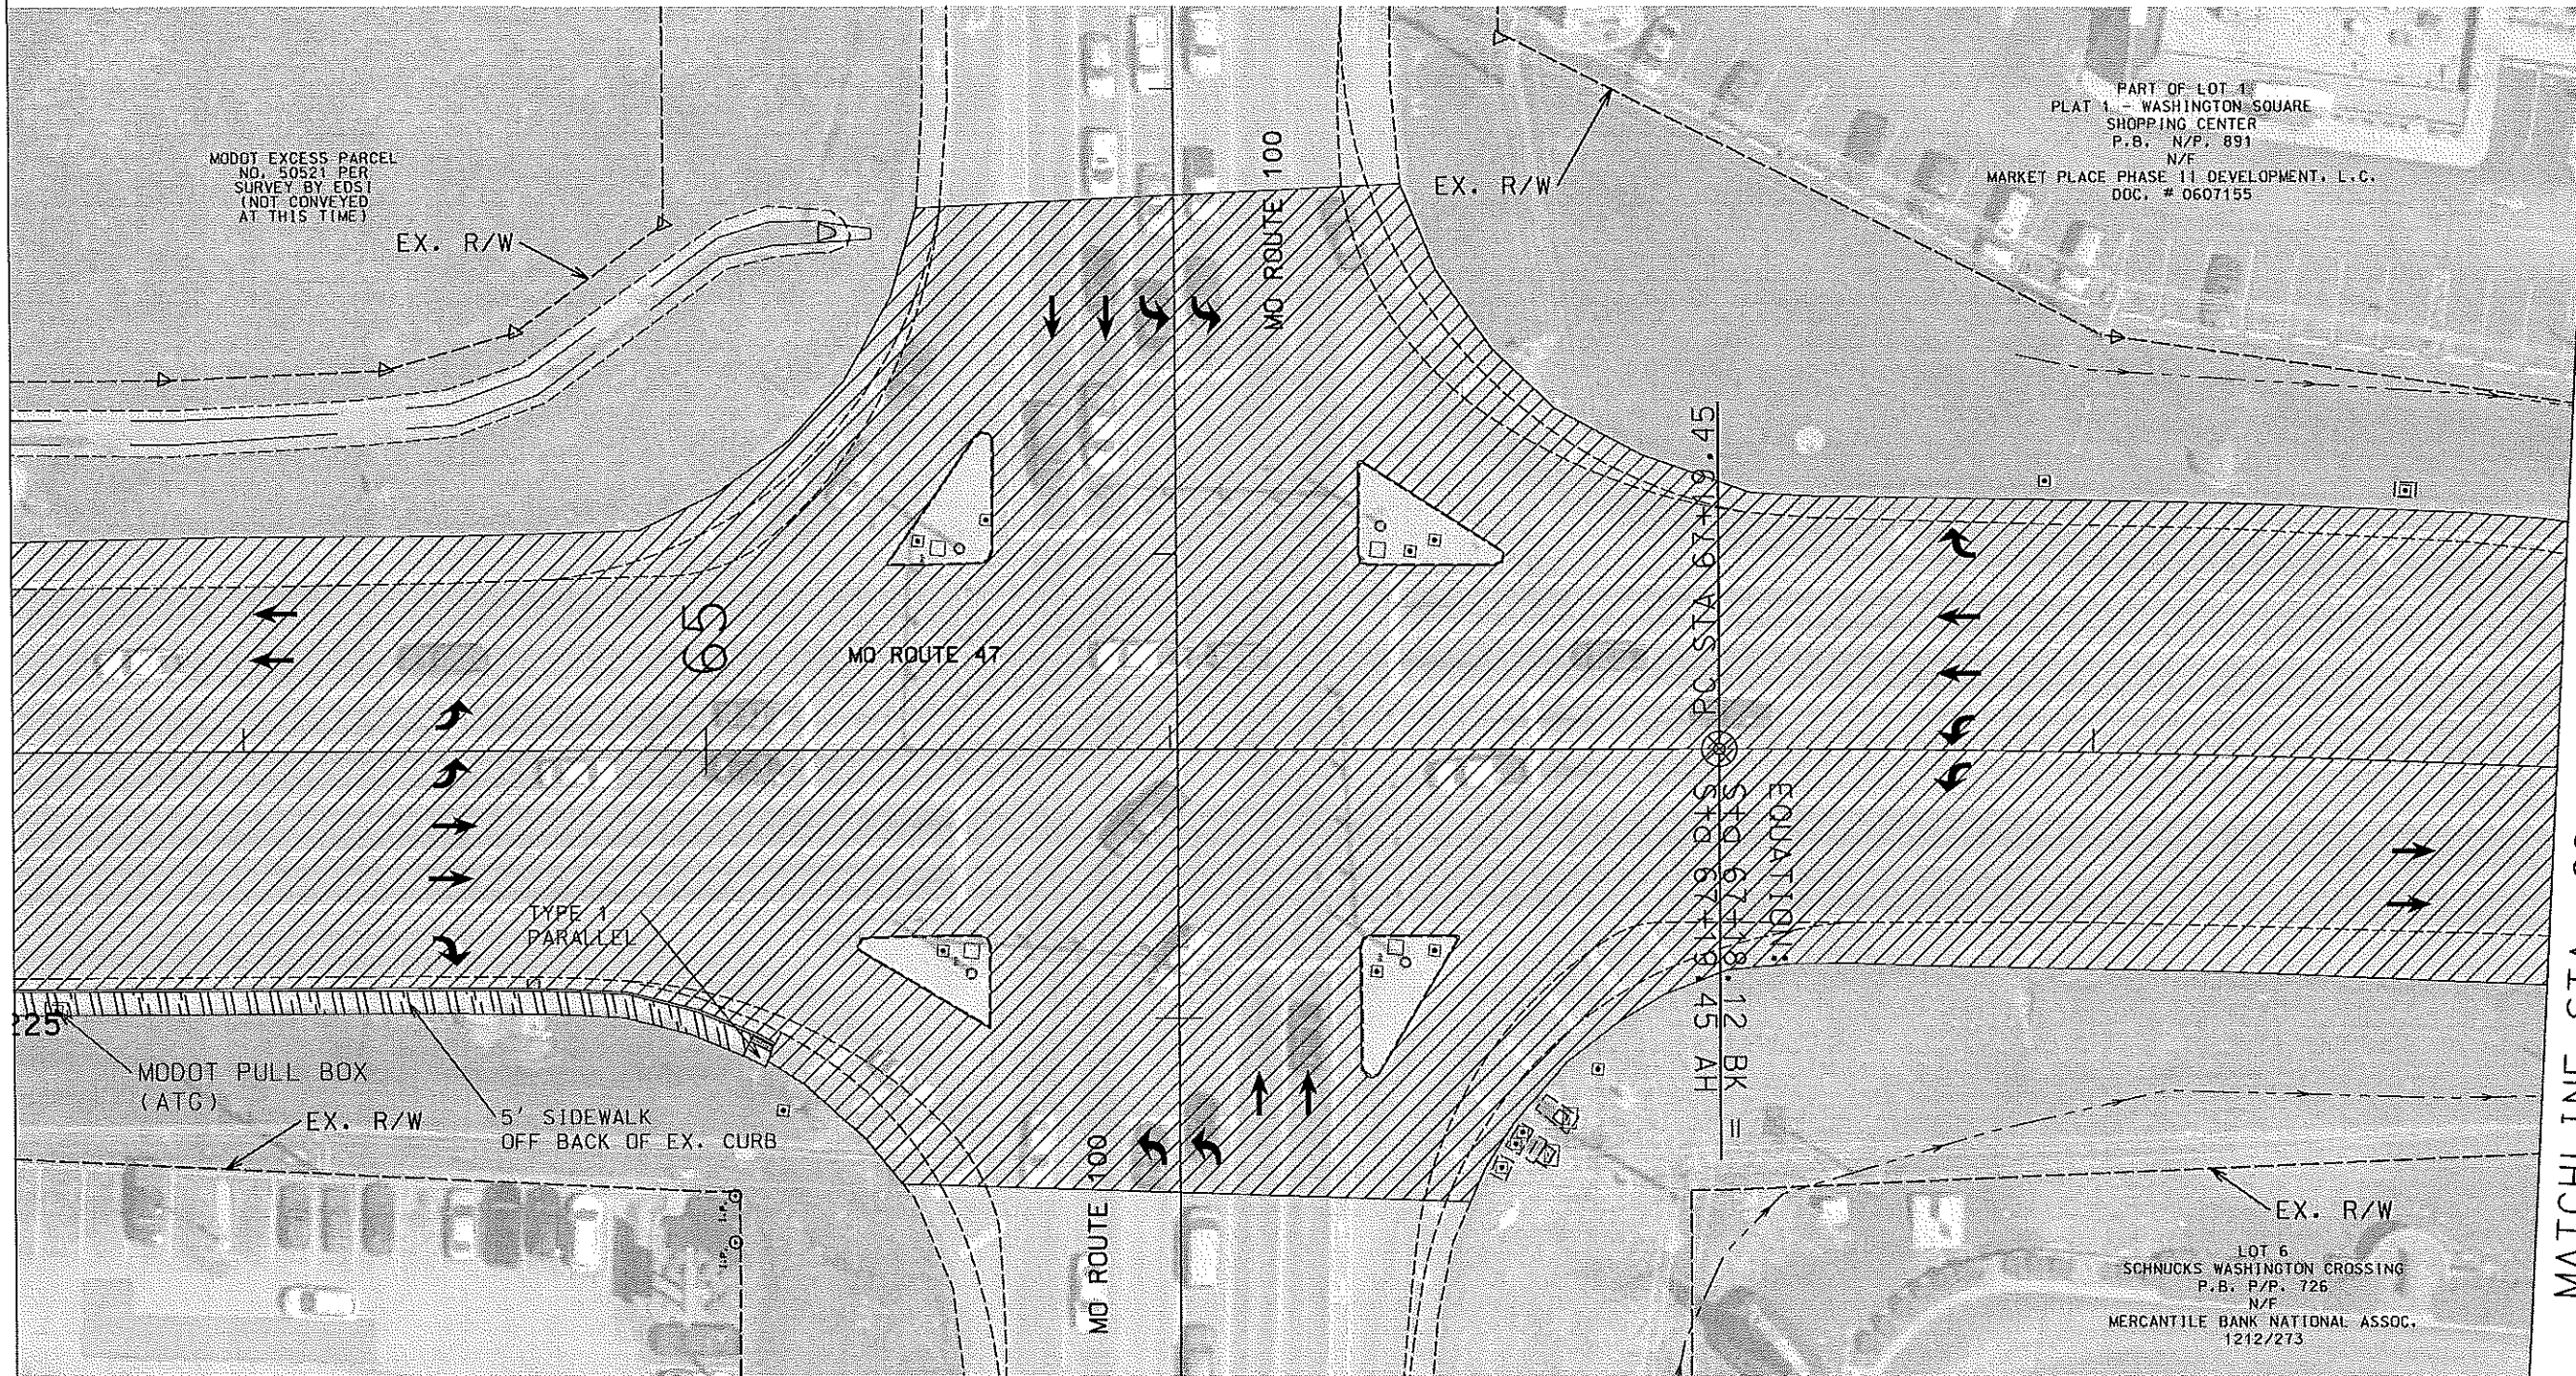


MATCHLINE STA. 69+00.00 (SEE SHEET 16)

DISCLAIMER
THE PROFESSIONAL WHOSE SIGNATURE AND PERSONAL SEAL APPEAR HEREON ASSUMES RESPONSIBILITY ONLY FOR WHAT APPEARS ON THIS PAGE, AND DISCLAIMS (PURSUANT TO SECTION 327.411 RSMO) SPECIFICATION, ESTIMATES, REPORTS, OR OTHER DOCUMENTS OR INSTRUMENTS NOT SEALED BY THE UNDERSIGNED PROFESSIONAL RELATING TO OR INTENDED TO BE USED FOR ANY PART OR PARTS OF THE PROJECT TO WHICH THIS PAGE REFERS.

- 3/4"MICROSURFACING
- 4"SIDEWALK

DATE	
DATE PREPARED	
ROUTE 47	STATE MO
DISTRICT SL	SHEET NO. 15
COUNTY FRANKLIN	
JOB NO. JS63207	
CONTRACT ID.	
PROJECT NO.	
BRIDGE NO.	
DESCRIPTION	DATE
MISSOURI HIGHWAYS AND TRANSPORTATION COMMISSION	
105 WEST CAPITOL JEFFERSON CITY, MO 65102 1-888-ASK-MODOT (1-888-275-6636)	
PLAN SHEET SHEET 12 OF 16	

IF A SEAL IS PRESENT ON THIS SHEET IT HAS BEEN ELECTRONICALLY SEALED AND DATED.

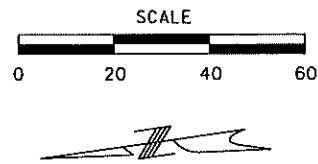

DISCLAIMER
THE PROFESSIONAL WHOSE SIGNATURE AND PERSONAL SEAL APPEAR HEREON ASSUMES RESPONSIBILITY ONLY FOR WHAT APPEARS ON THIS PAGE, AND DISCLAIMS (PURSUANT TO SECTION 327.411 RSMO) SPECIFICATION, ESTIMATES, REPORTS, OR OTHER DOCUMENTS OR INSTRUMENTS NOT SEALED BY THE UNDERSIGNED PROFESSIONAL RELATING TO OR INTENDED TO BE USED FOR ANY PART OR PARTS OF THE PROJECT TO WHICH THIS PAGE REFERS.

PART OF LOT 1
PLAT 1 - WASHINGTON SQUARE
SHOPPING CENTER
P.B. N/P. 891
N/F
MARKET PLACE PHASE II DEVELOPMENT, L.C.
DOC. # 0607155

PT. LOT 12 GLEN
VIEW EST. 3RD ADDN.
P.B. J/P. 48
N/F
D & C ECKELKAMP
PROPERTIES, LLC
DOC. # 1223053

MATCHLINE STA. 69+00.00 (SEE SHEET 15)

MATCHLINE STA. 74+50.00 (SEE SHEET 17)

MO ROUTE 47

WASHINGTON SQUARE
CENTER


WASHINGTON CROSSING

LOT 6
SCHNUCK'S WASHINGTON CROSSING
P.B. P/P. 726
N/F
MERCANTILE BANK NATIONAL ASSOC.
1212/273

LOT 7
SCHNUCK'S WASHINGTON CROSSING
P.B. P/P. 726
N/F
RAVING FAN INVESTMENTS II, LLC
1299/802

LOT 8
SCHNUCK'S WASHINGTON
CROSSING
P.B. P/P. 726
N/F
JACK IN THE
BOX INC.
DOC. # 181063

 LOT 9
SCHNUCK'S WASHINGTON
CROSSING
P.B. P/P. 726
N/F
BURGER KING
CORPORATION
1251/796



3/4"MICROSURFACING

DESCRIPTION

DATE

MISSOURI HIGHWAYS AND TRANSPORTATION
COMMISSION



 
PLAN SHEET
SHEET 13 OF 16

105 WEST CAPITOL
JEFFERSON CITY, MO 65102
1-888-ASK-MODOT (1-888-275-6636)

IF A SEAL IS PRESENT ON THIS SHEET IT HAS BEEN ELECTRONICALLY SEALED AND DATED.

DISCLAIMER

THE PROFESSIONAL WHOSE SIGNATURE AND PERSONAL SEAL APPEAR HEREON ASSUMES RESPONSIBILITY ONLY FOR WHAT APPEARS ON THIS PAGE, AND DISCLAIMS (PURSUANT TO SECTION 327.411 RSMO) SPECIFICATION, ESTIMATES, REPORTS, OR OTHER DOCUMENTS OR INSTRUMENTS NOT SEALED BY THE UNDERSIGNED PROFESSIONAL RELATING TO OR INTENDED TO BE USED FOR ANY PART OR PARTS OF THE PROJECT TO WHICH THIS PAGE REFERS.




MATCHLINE STA: 80+00.00 (SEE SHEET 18)


[illegible]

IF A SEAL IS PRESENT ON THIS SHEET IT HAS BEEN ELECTRONICALLY SEALED AND DATED.


* NOTE:
CURB RAMP TYPE TO BE DETERMINED UPON REVIEW OF
CITY OF WASHINGTON'S SIDEWALK DEVELOPMENT PLAN FOR THIS LOCATION

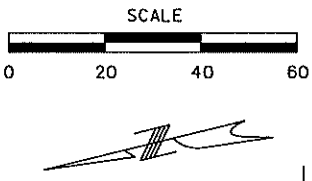


MATCHLINE STA. 80+00.00 (SEE SHEET 17)

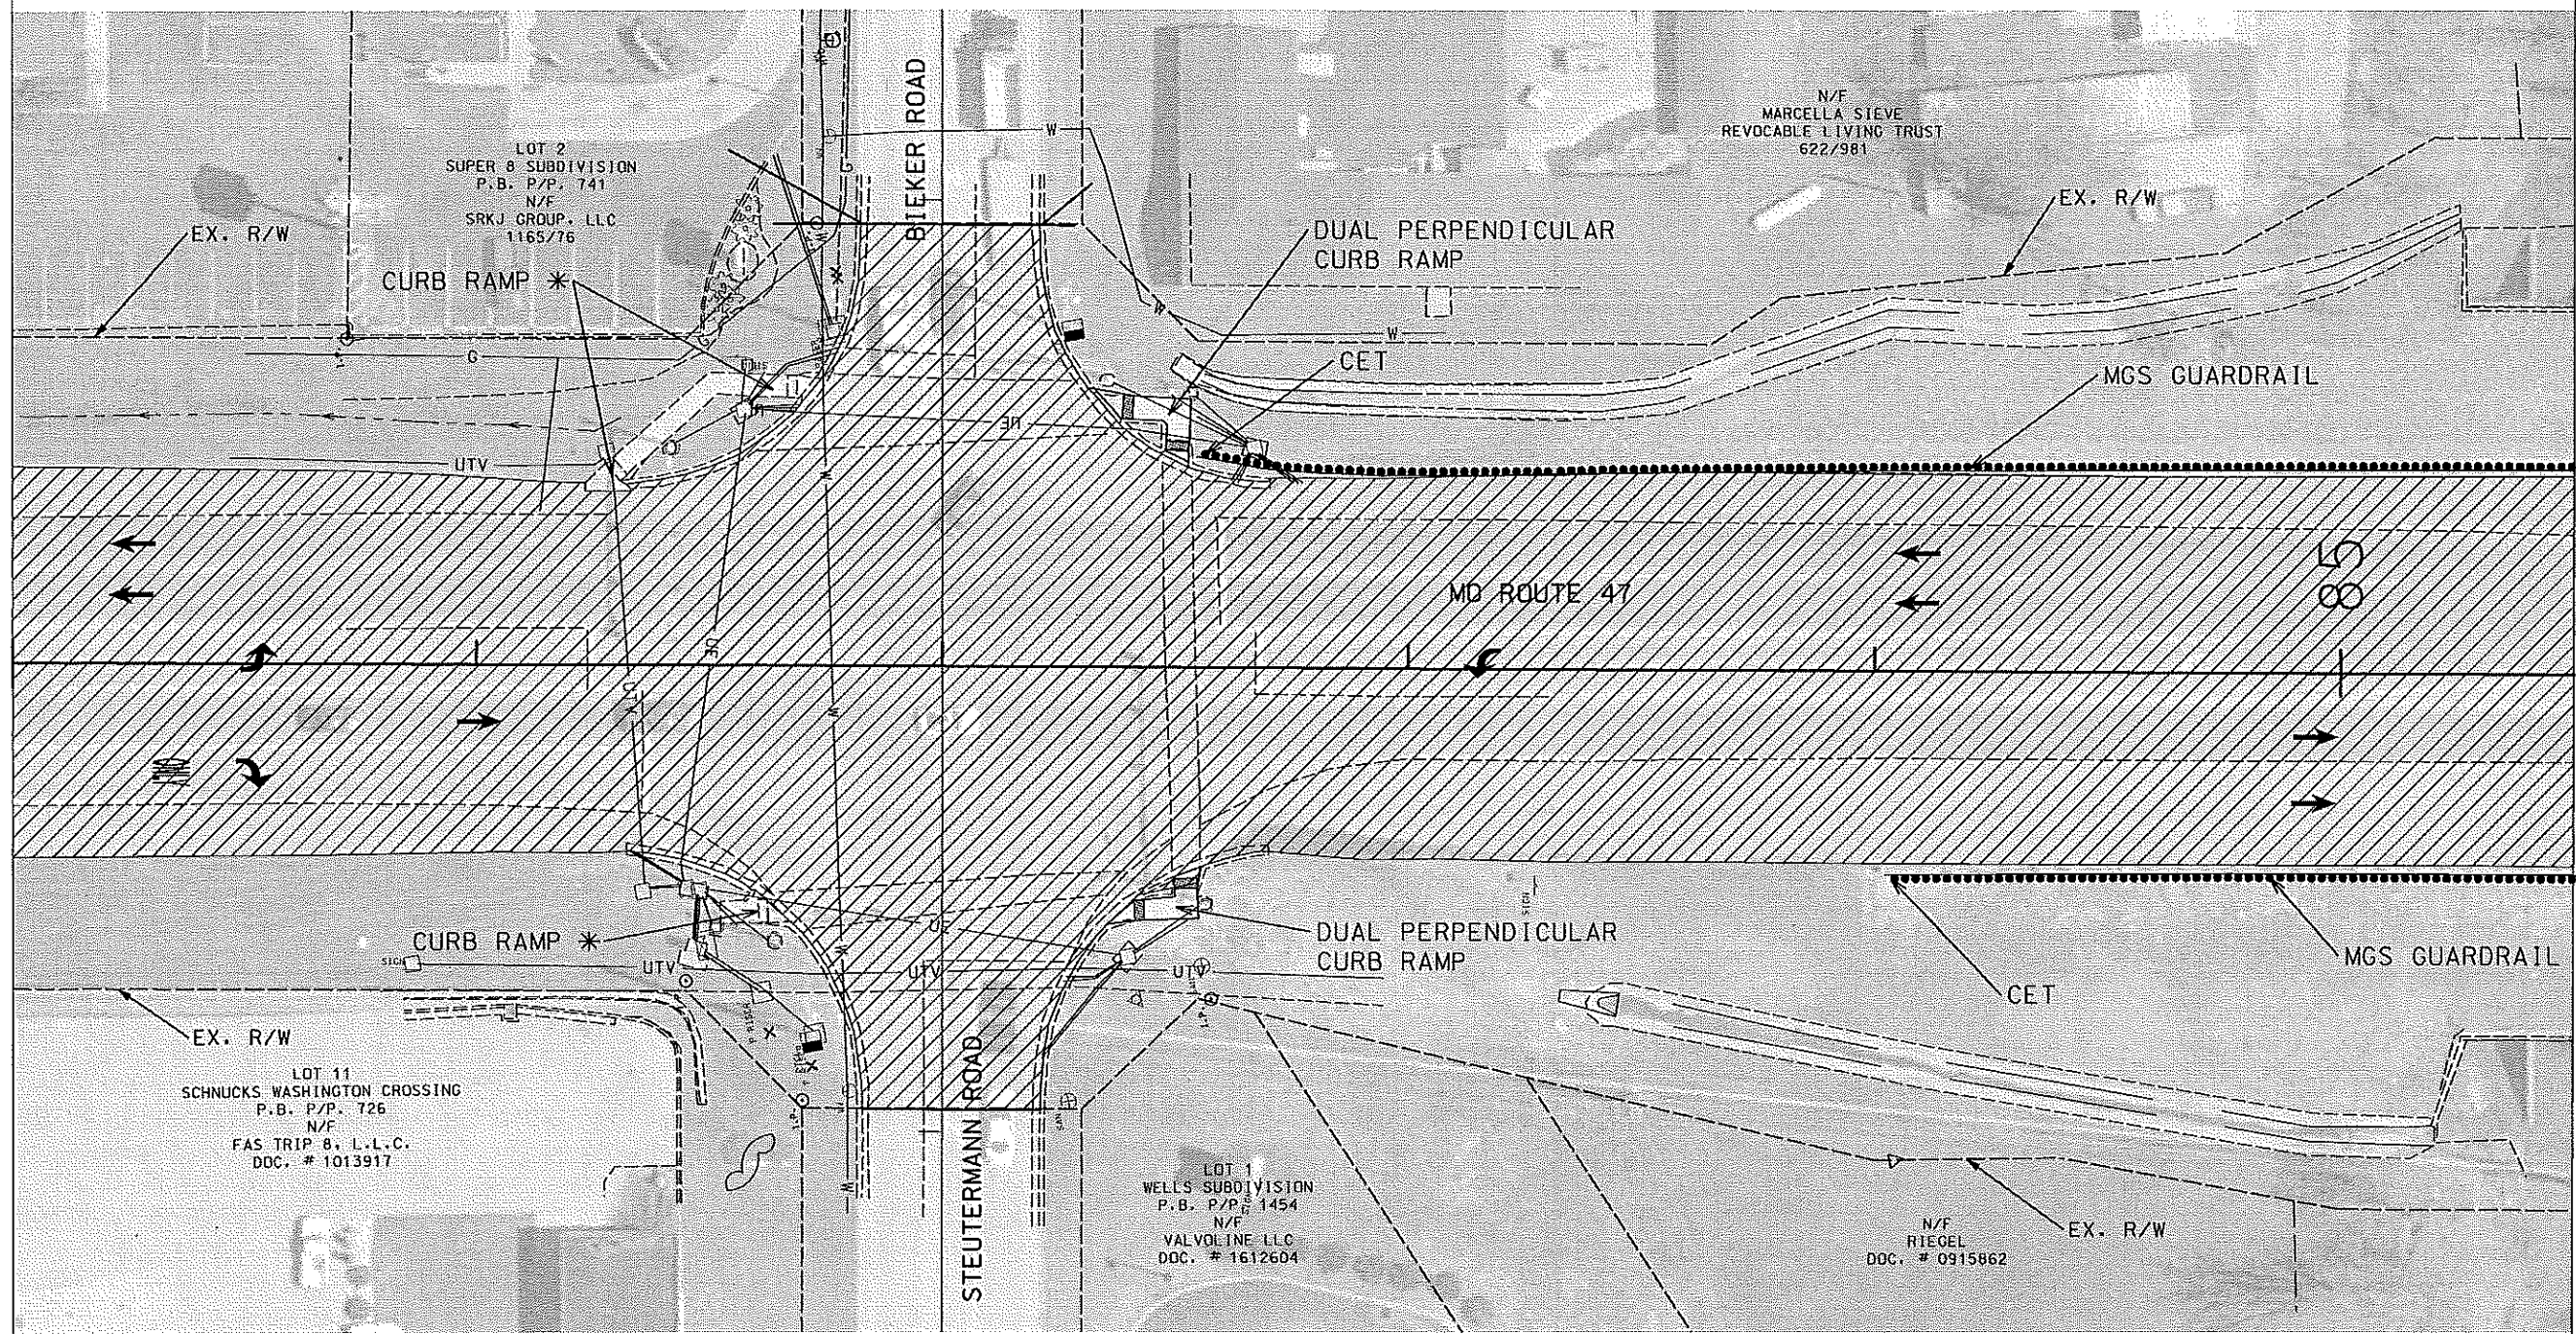

MATCHLINE STA. 85+50.00 (SEE SHEET 19)

 
 3/4"MICROSURFACING

DISCLAIMER
THE PROFESSIONAL WHOSE SIGNATURE AND PERSONAL
SEAL APPEAR HEREON ASSUMES RESPONSIBILITY
ONLY FOR WHAT APPEARS ON THIS PAGE, AND
DISCLAIMS (PURSUANT TO SECTION 327.411 RSMO)
SPECIFICATION, ESTIMATES, REPORTS, OR OTHER
DOCUMENTS OR INSTRUMENTS NOT SEALED BY THE
UNDERSIGNED PROFESSIONAL RELATING TO OR
INTENDED TO BE USED FOR ANY PART OR PARTS OF
THE PROJECT TO WHICH THIS PAGE REFERS.

DATE	
DATE PREPARED	
ROUTE 47	STATE MO
DISTRICT SL	SHEET NO. 18
COUNTY FRANKLIN	
JOB NO. J6S3207	
CONTRACT ID.	
PROJECT NO.	
BRIDGE NO.	
DESCRIPTION	DATE
MISSOURI HIGHWAYS AND TRANSPORTATION COMMISSION	
 105 WEST CAPITOL JEFFERSON CITY, MO 65102 1-888-ASK-MODOT (1-888-275-6636)	
PLAN SHEET SHEET 15 OF 16	

IF A SEAL IS PRESENT ON THIS SHEET IT HAS BEEN ELECTRONICALLY SEALED AND DATED.

MATCHLINE STA. 85+50.00 (SEE SHEET 19)

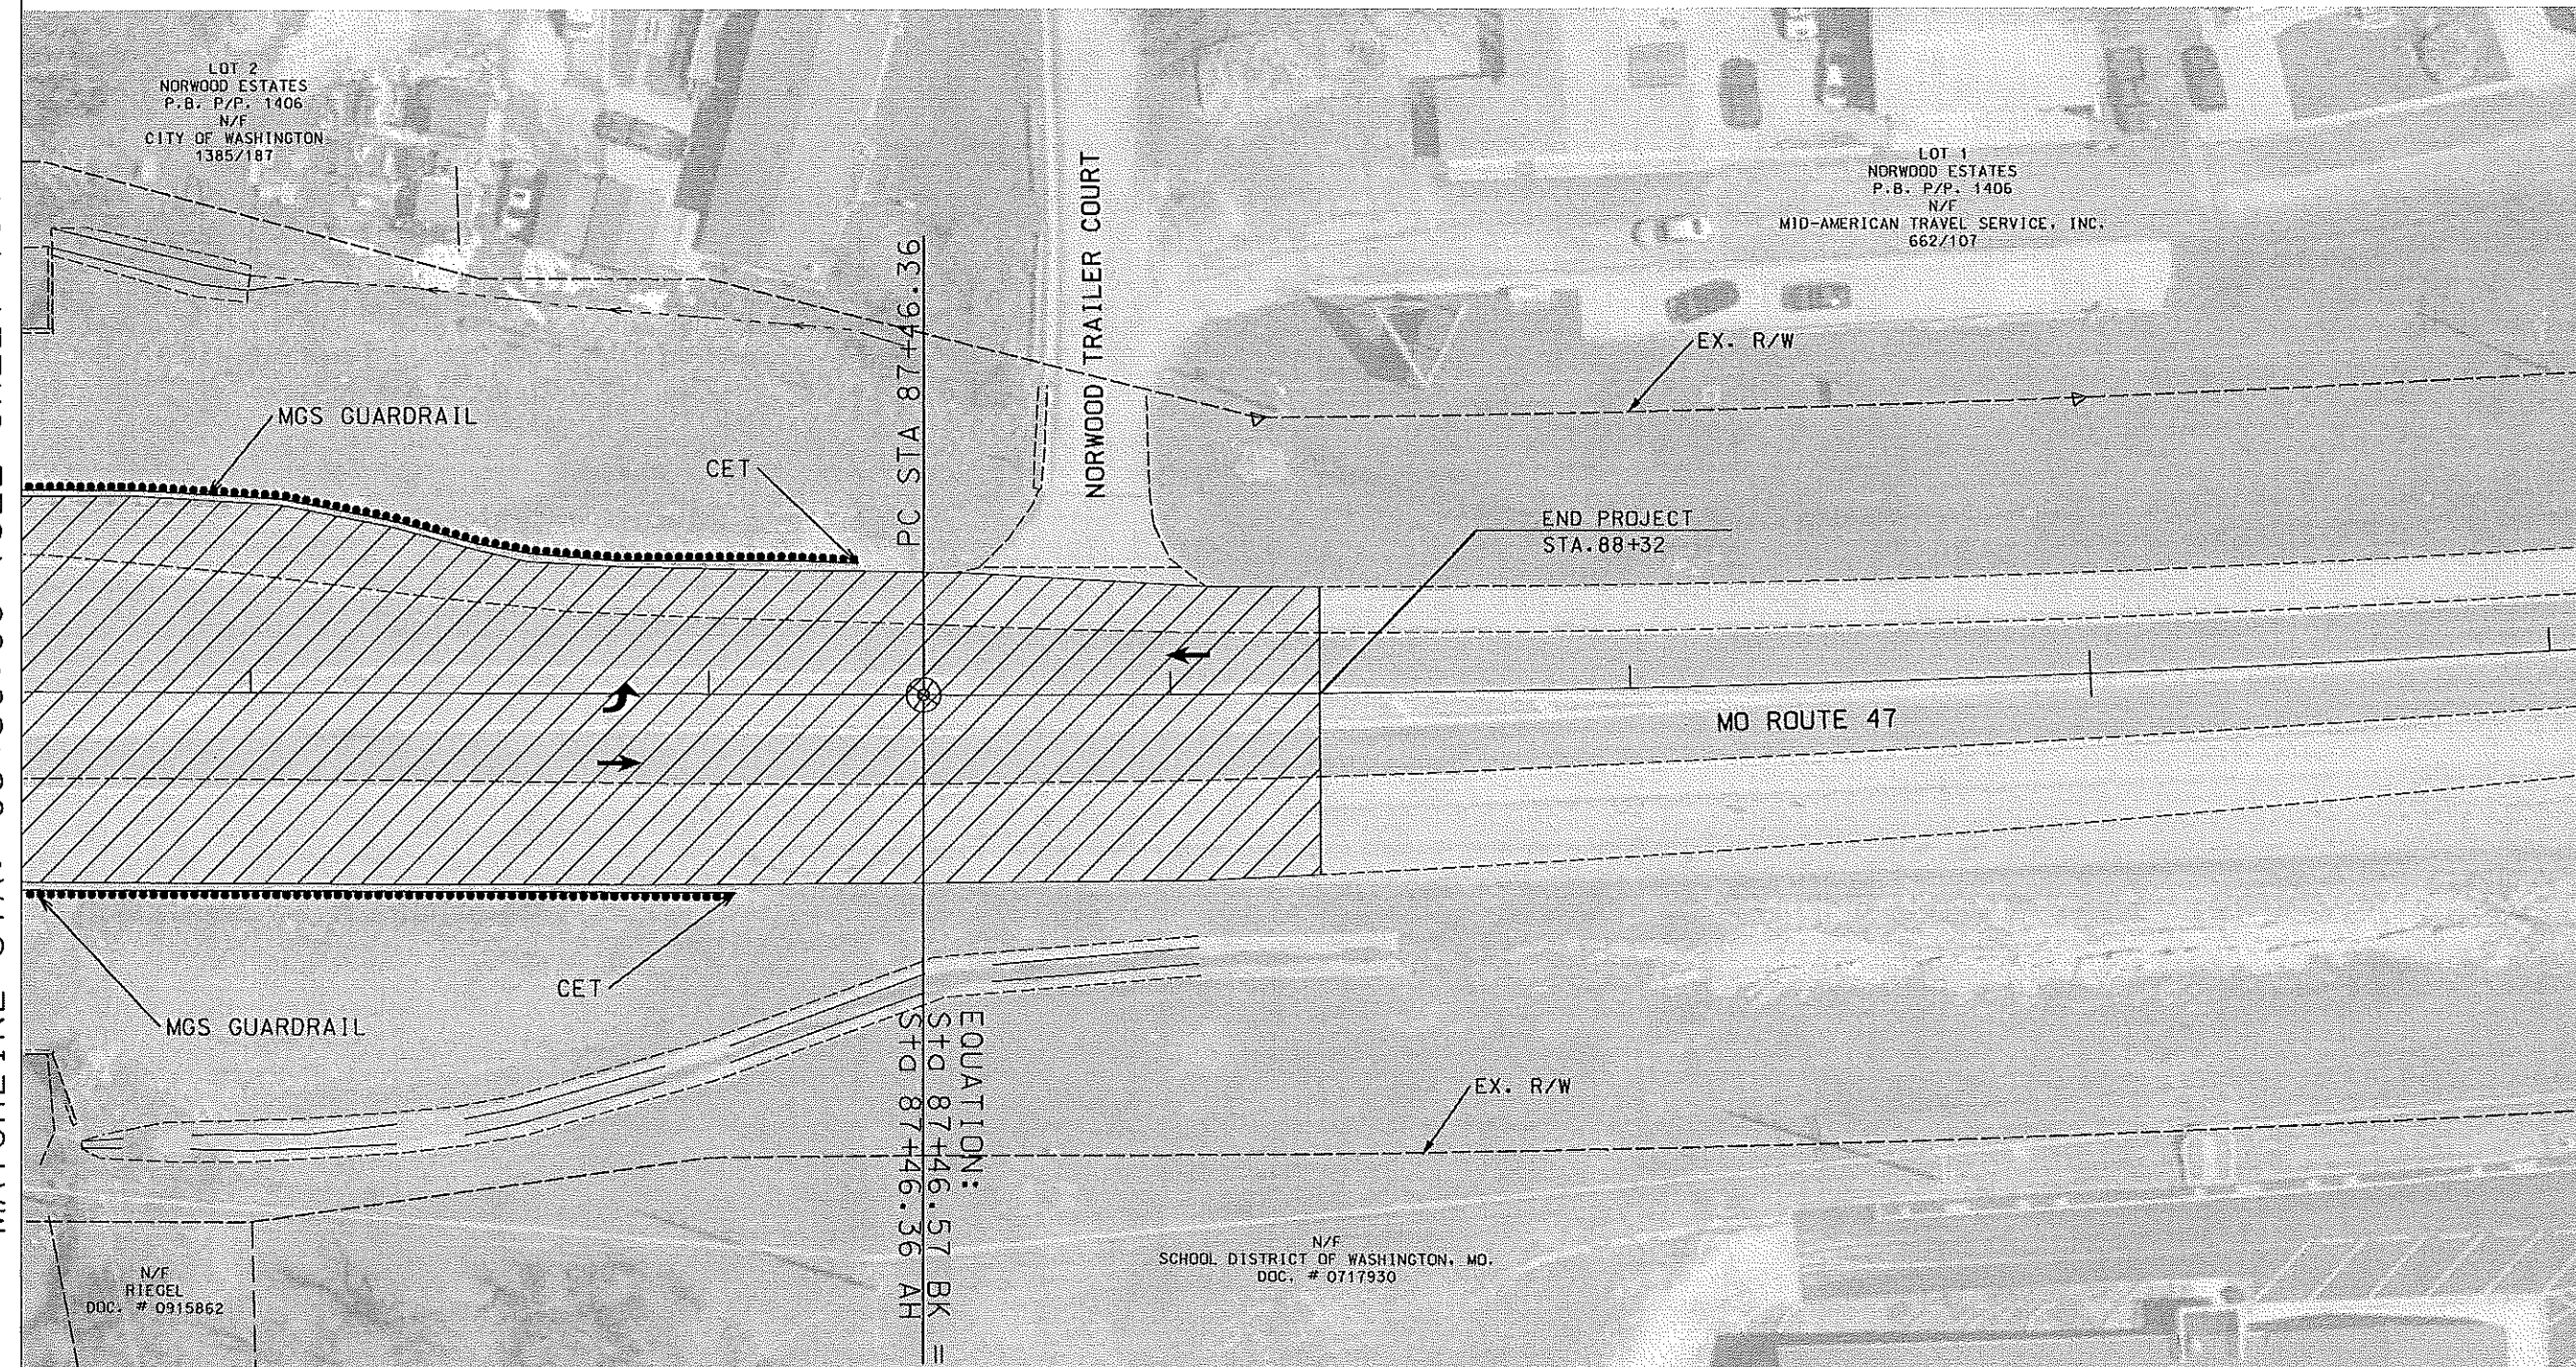

3/4"MICROSURFACING

DISCLAIMER

THE PROFESSIONAL WHOSE SIGNATURE AND PERSONAL SEAL APPEAR HEREON ASSUMES RESPONSIBILITY ONLY FOR WHAT APPEARS ON THIS PAGE, AND DISCLAIMS (PURSUANT TO SECTION 327.411 RSMO) SPECIFICATION, ESTIMATES, REPORTS, OR OTHER DOCUMENTS OR INSTRUMENTS NOT SEALED BY THE UNDERSIGNED PROFESSIONAL RELATING TO OR INTENDED TO BE USED FOR ANY PART OR PARTS OF THE PROJECT TO WHICH THIS PAGE REFERS.

PLAN SHEET
SHEET 16 OF 16



MISSOURI HIGHWAYS AND TRANSPORTATION
COMMISSION

105 WEST CAPITOL
JEFFERSON CITY, MO 65102
1-888-ASK-MODOT (1-888-275-6636)

[illegible]

PROJECT NO.	
-------------	--

BRIDGE NO.

0055201
CONTRACT ID

JOB NO.
16S3207

FRANKLIN

COUNTY

SI	1
----	---

47	M
DISTRICT	SHEET

ROUTE	ST.
17	1

DATE PREPARED

DATE _____

IF A SEAL IS PRESENT ON THIS SHEET IT HAS BEEN ELECTRONICALLY SEALED AND DATED: